


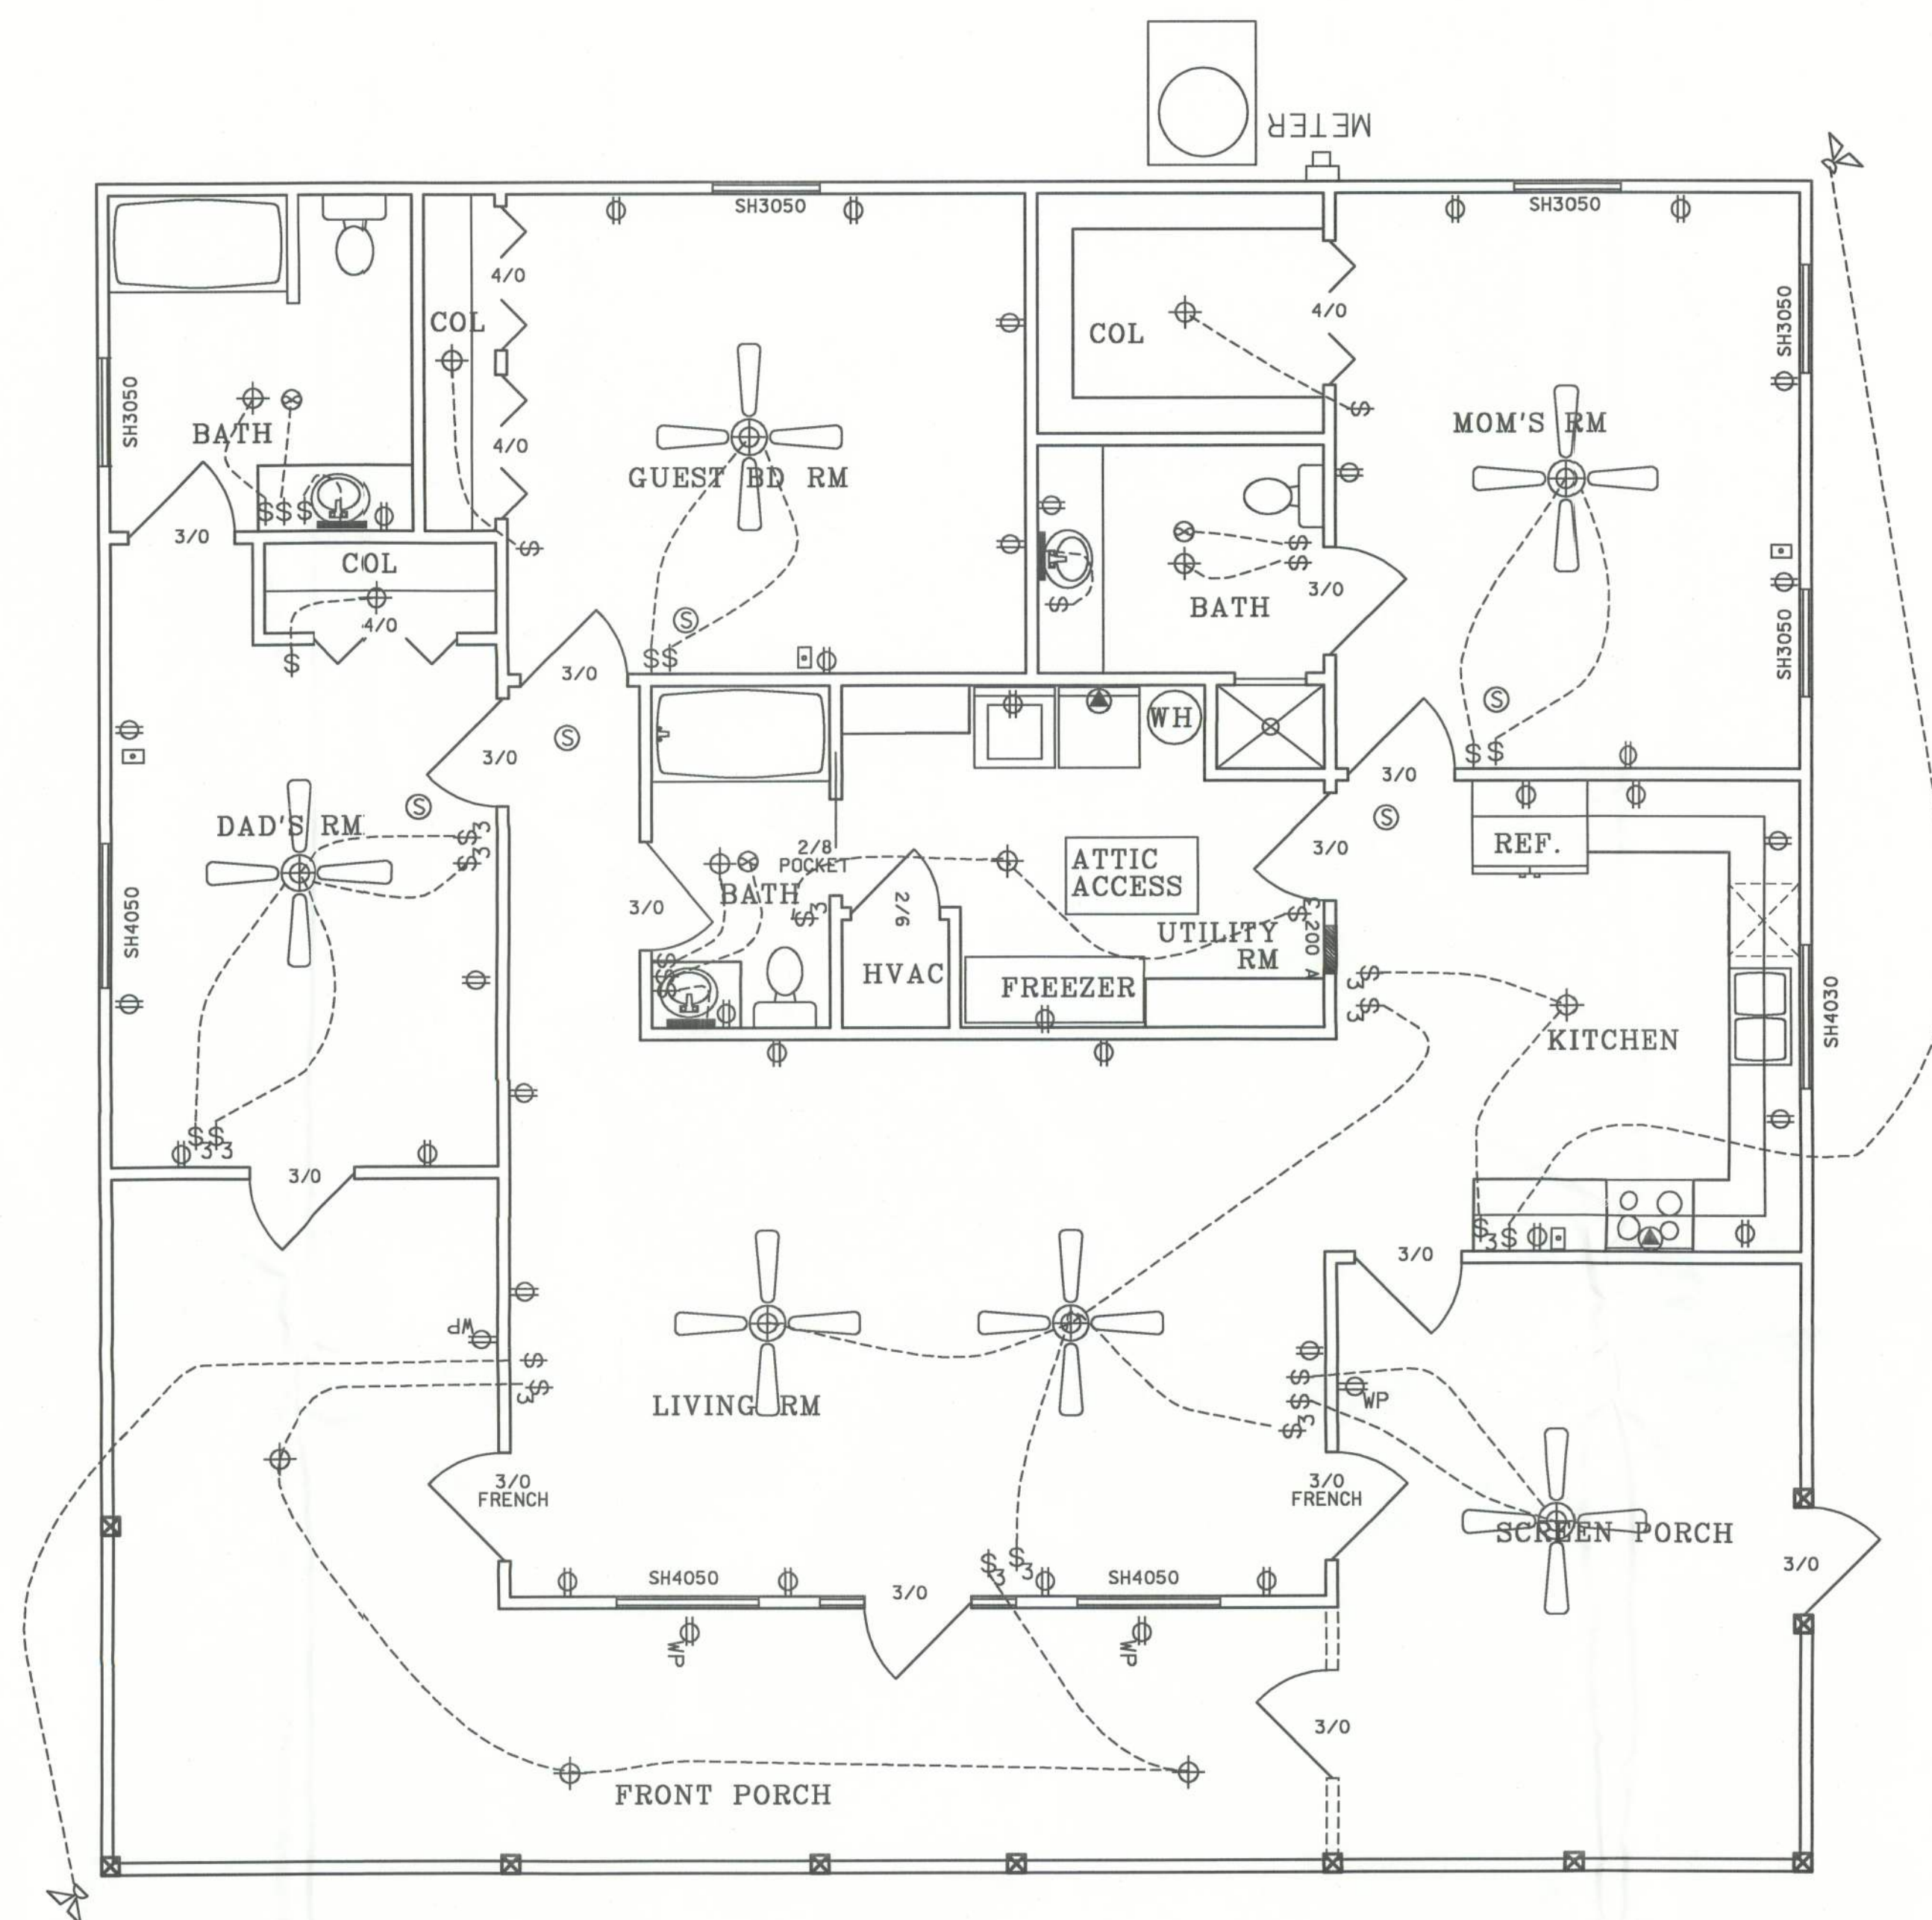

- ☐ - METER BASE
- - VANITY LIGHT AS SPECIFIED
- ⊕ - LIGHT FIXTURE
- \$ - SINGLE POLE SWITCH
- \$⊕ - THREE-WAY SWITCH
- ⊕ - RECEPT.
- ☼ - SECURITY LIGHT
- ⊗ - EXHAUST
- Ⓢ - 220 V.
- Ⓢ - SMOKE DETECTOR (AC/DC and interconnected)
- ☎ - TELEPHONE
- 200 A - 200 AMP SERVICE PANEL

NOTES:

- 1.) PULL HOMERUNS OF TELEPHONE CABLE AND COAX CABLE TO COMMUNICATION PANEL (NO JUNCTIONS ALLOWED IN ATTIC)
- 2.) ALL EXTERIOR RECEPTACLES SHALL EITHER BE GFI RECEPTACLES OR PART OF A GFI CIRCUIT. ALL EXTERIOR RECEPTACLES SHALL BE WEATHERPROOF.
- 3.) ALL BATHROOM, KITCHEN, AND GARAGE RECEPTACLES SHALL BE PART OF A GFI CIRCUIT.
- 4.) ALL BEDROOM RECEPTACLES SHALL BE PART OF AN AFI CIRCUIT.
- 5.) ALL BATHROOM RECEPTACLES SHALL BE A SEPARATE DEDICATED 20amp GFI CIRCUIT.

NOTE:

THE ELECTRICAL PLAN IS INTENDED TO SHOW SCHEMATICALLY THE LAYOUT OF THE ELECTRICAL COMPONENTS. FINAL LOCATIONS AND SIZING OF THE COMPONENTS SHALL BE THE RESPONSIBILITY OF A LICENSED ELECTRICAL CONTRACTOR. ALL WORK SHALL BE PERFORMED IN ACCORDANCE WITH ALL APPLICABLE CODES.



HAYGOOD HOMES INC.

12592 So. U.S. HWY 441
LAKE CITY FL. 32025
OFFICE (386) 752-3496
MOBILE (386) 303-1981
CR-C1326715

MIKE THOMAS

LAKE CITY FL.

ELECTRICAL

PLAN No.	SCALE	DATE	SHEET NO.
P 0507	1/4" = 1'	10/13/05	3