
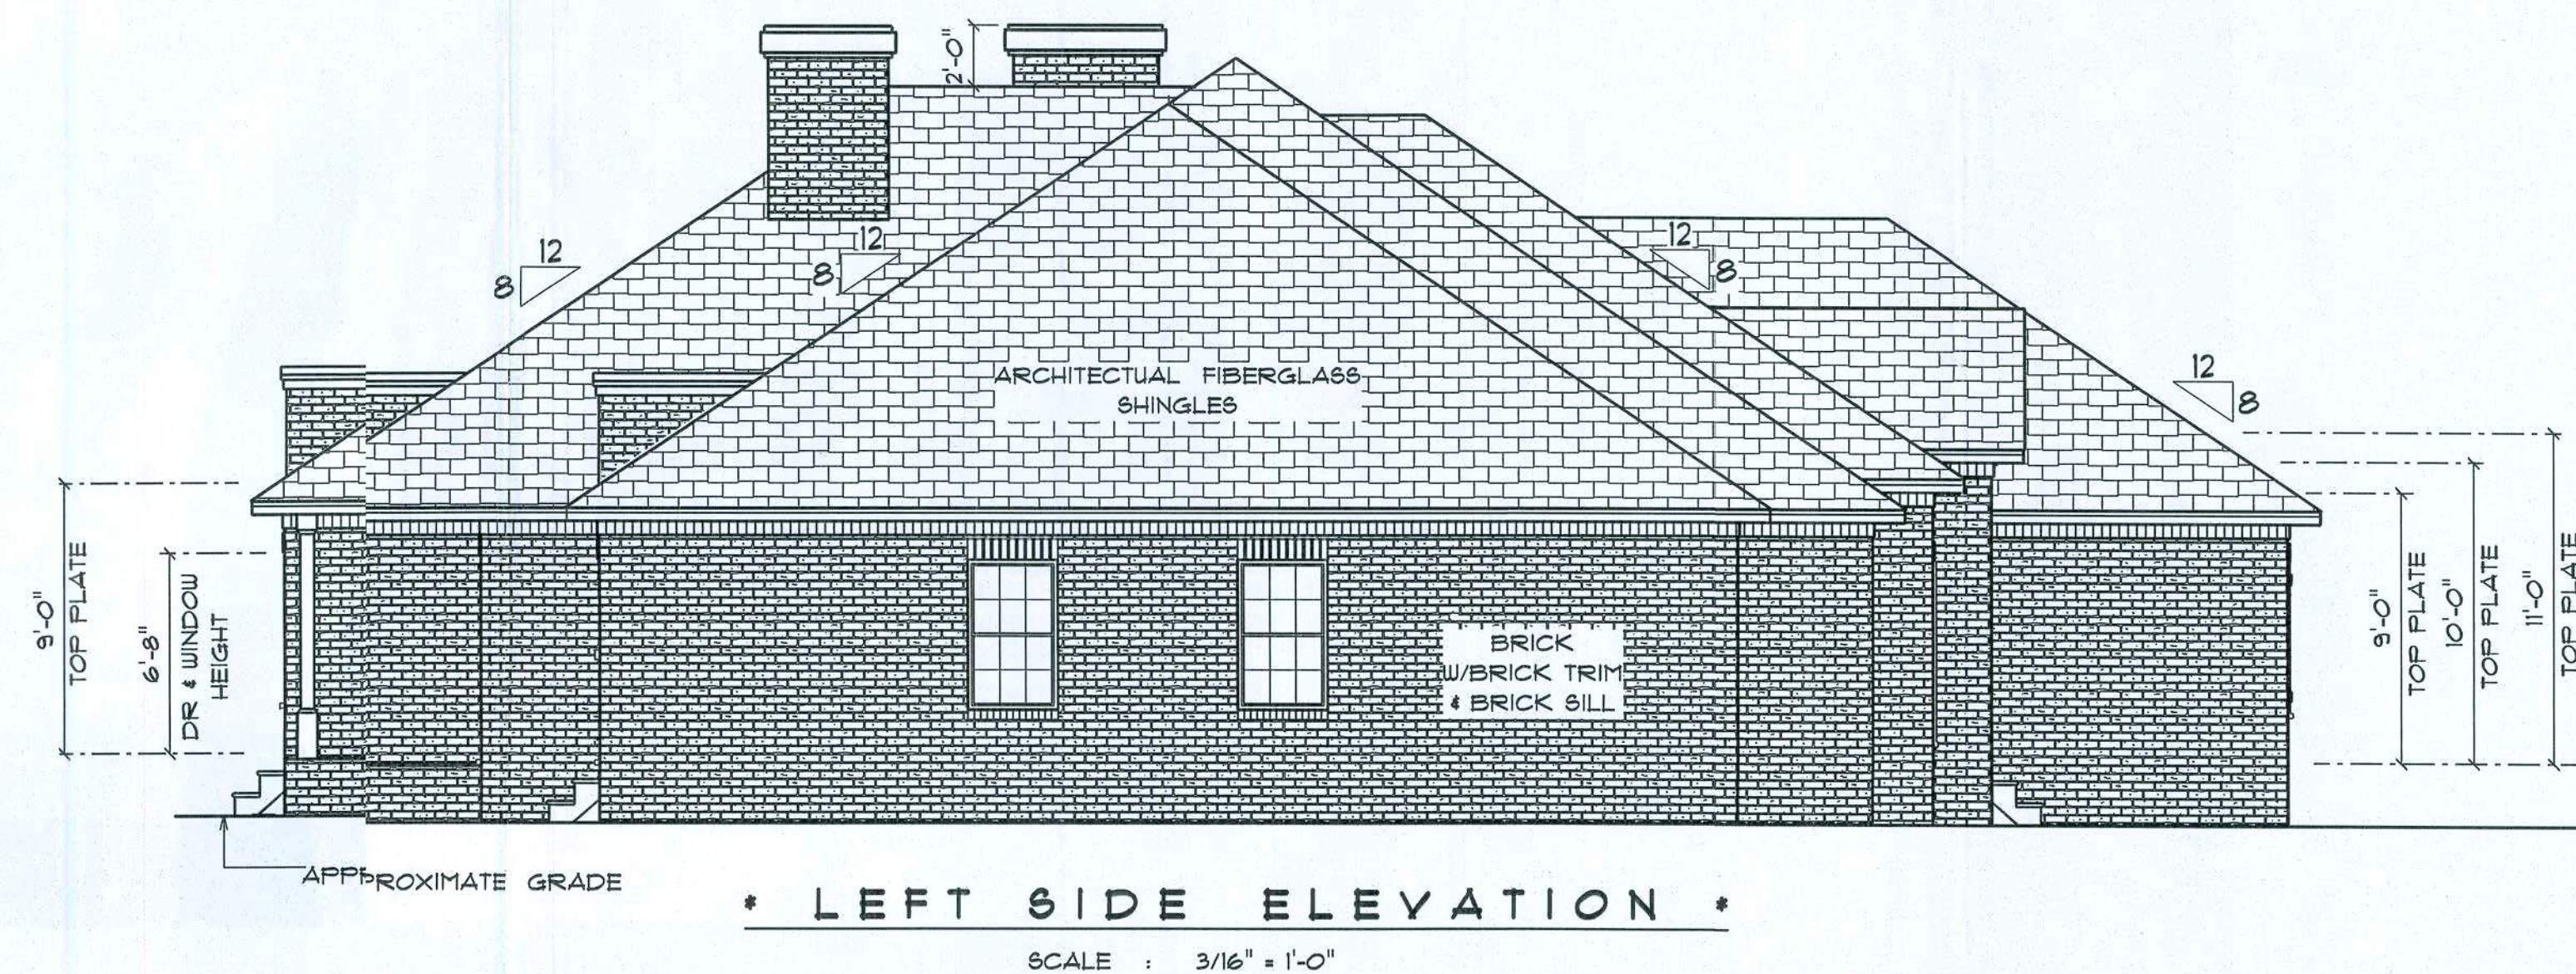
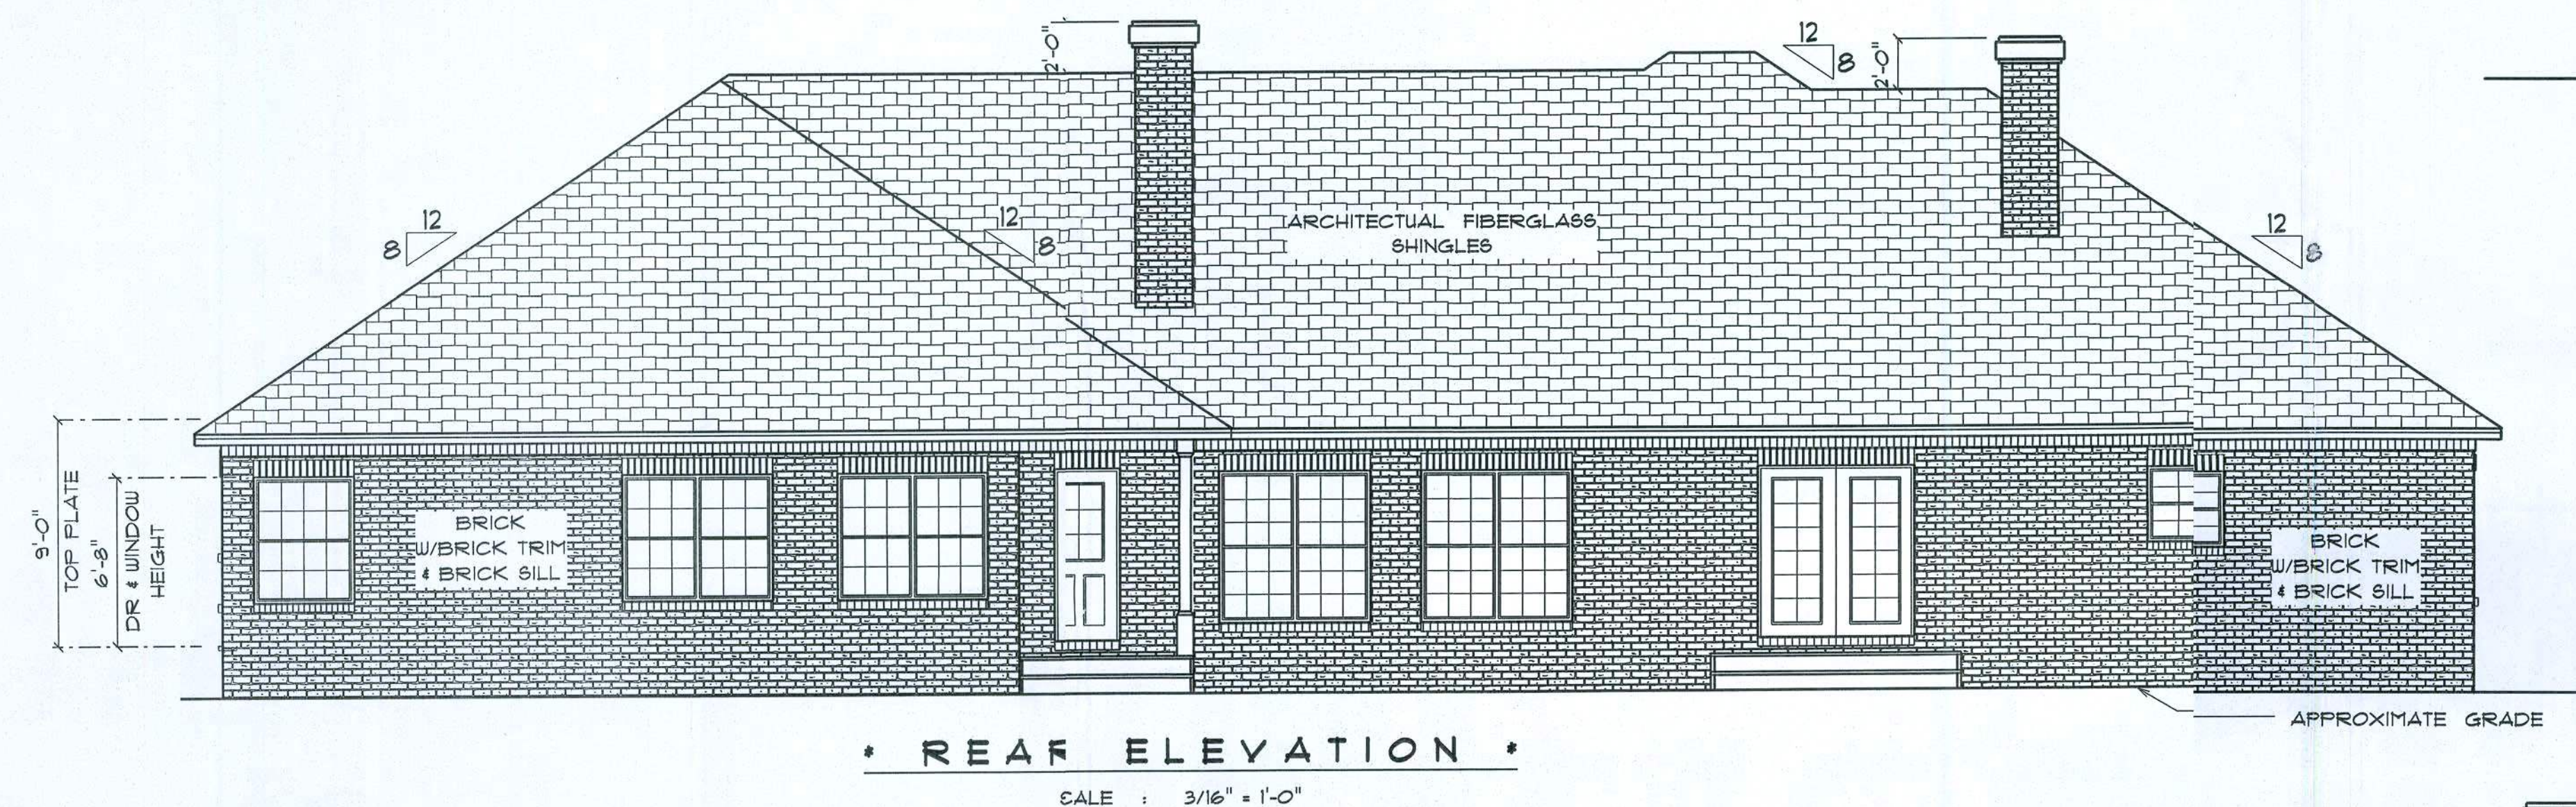
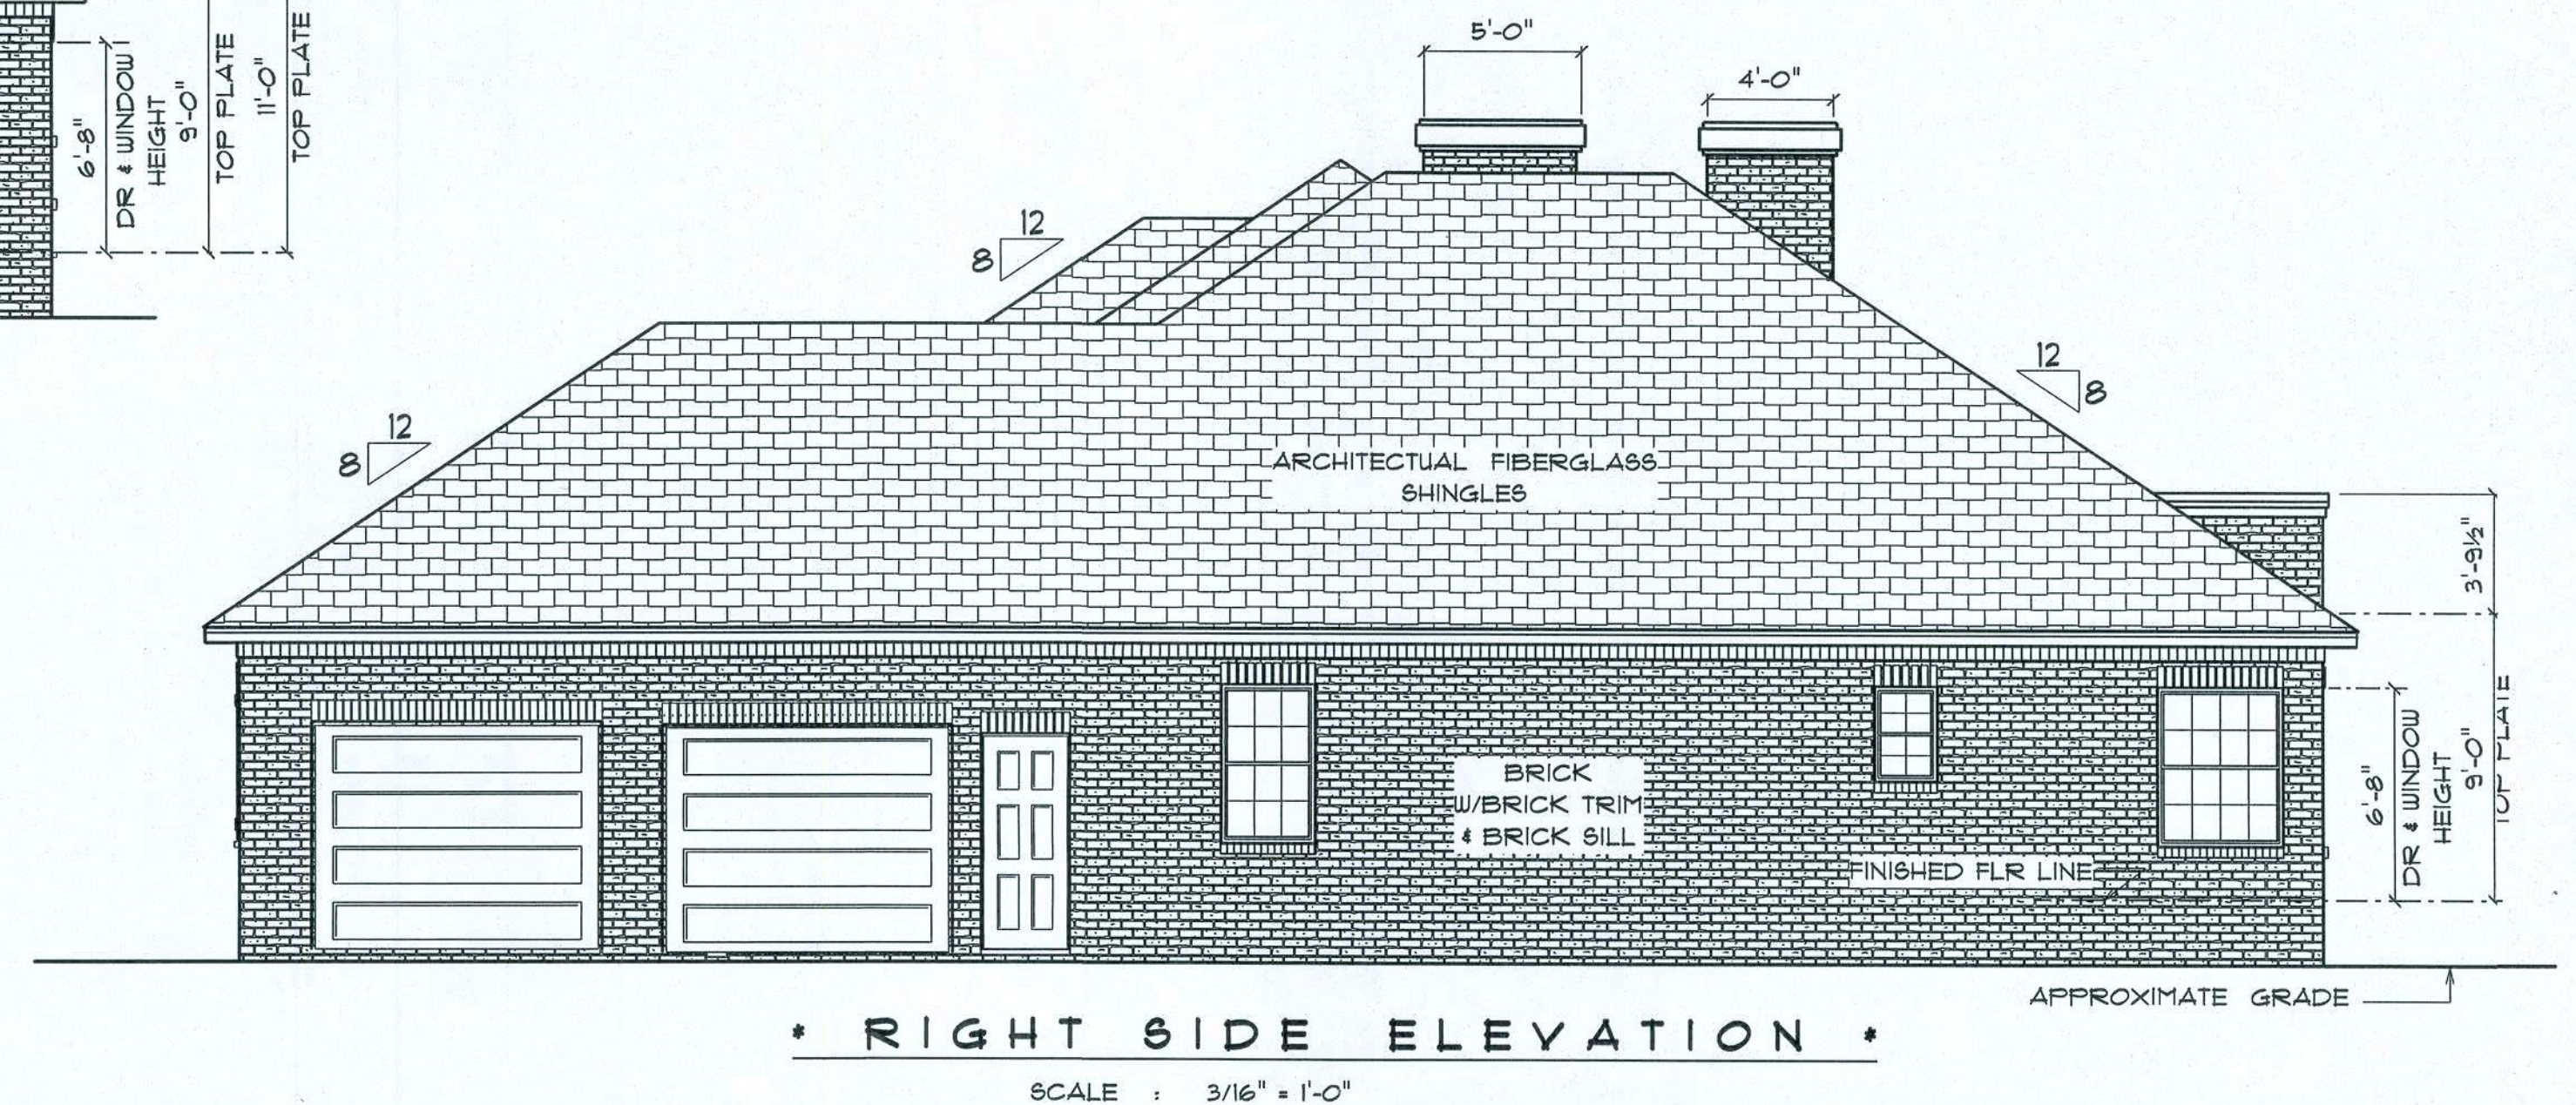


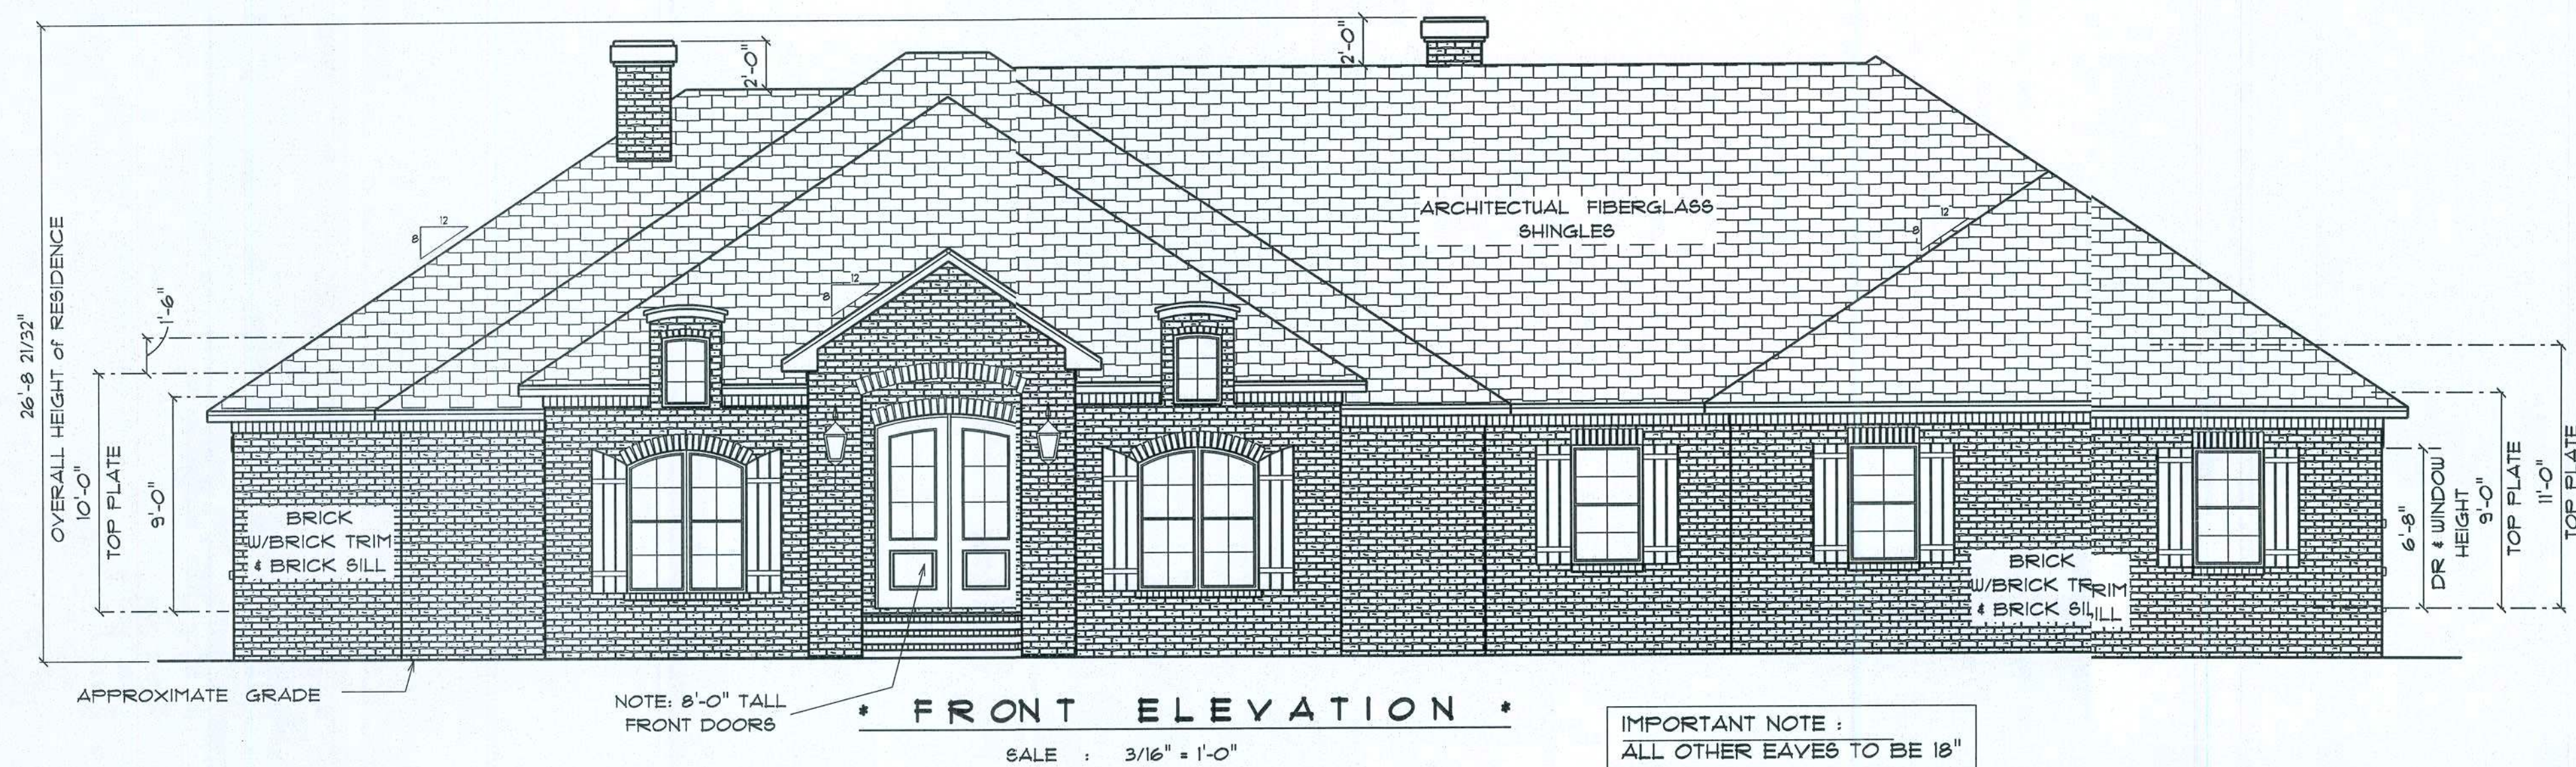

RESIDENCE
for
PETE & KYALA
JOHNSON

LAKE CITY, FLORIDA

Tesna M. Ruffo
2025 SW 5th Ave
Lake City, Florida 32025
Cell: (386) 861-1191
Email: tesnaruffo@gmail.com

PRINTED DATE:
Wednesday, January 31, 201

DRAWN BY: TESNA M. RUFFO
CHECKED BY:

BUILDING CONTRACTOR


FINALS DATE:

JOB NUMBER:

DRAWING NUMBER

A-3

OF 4 SHEETS

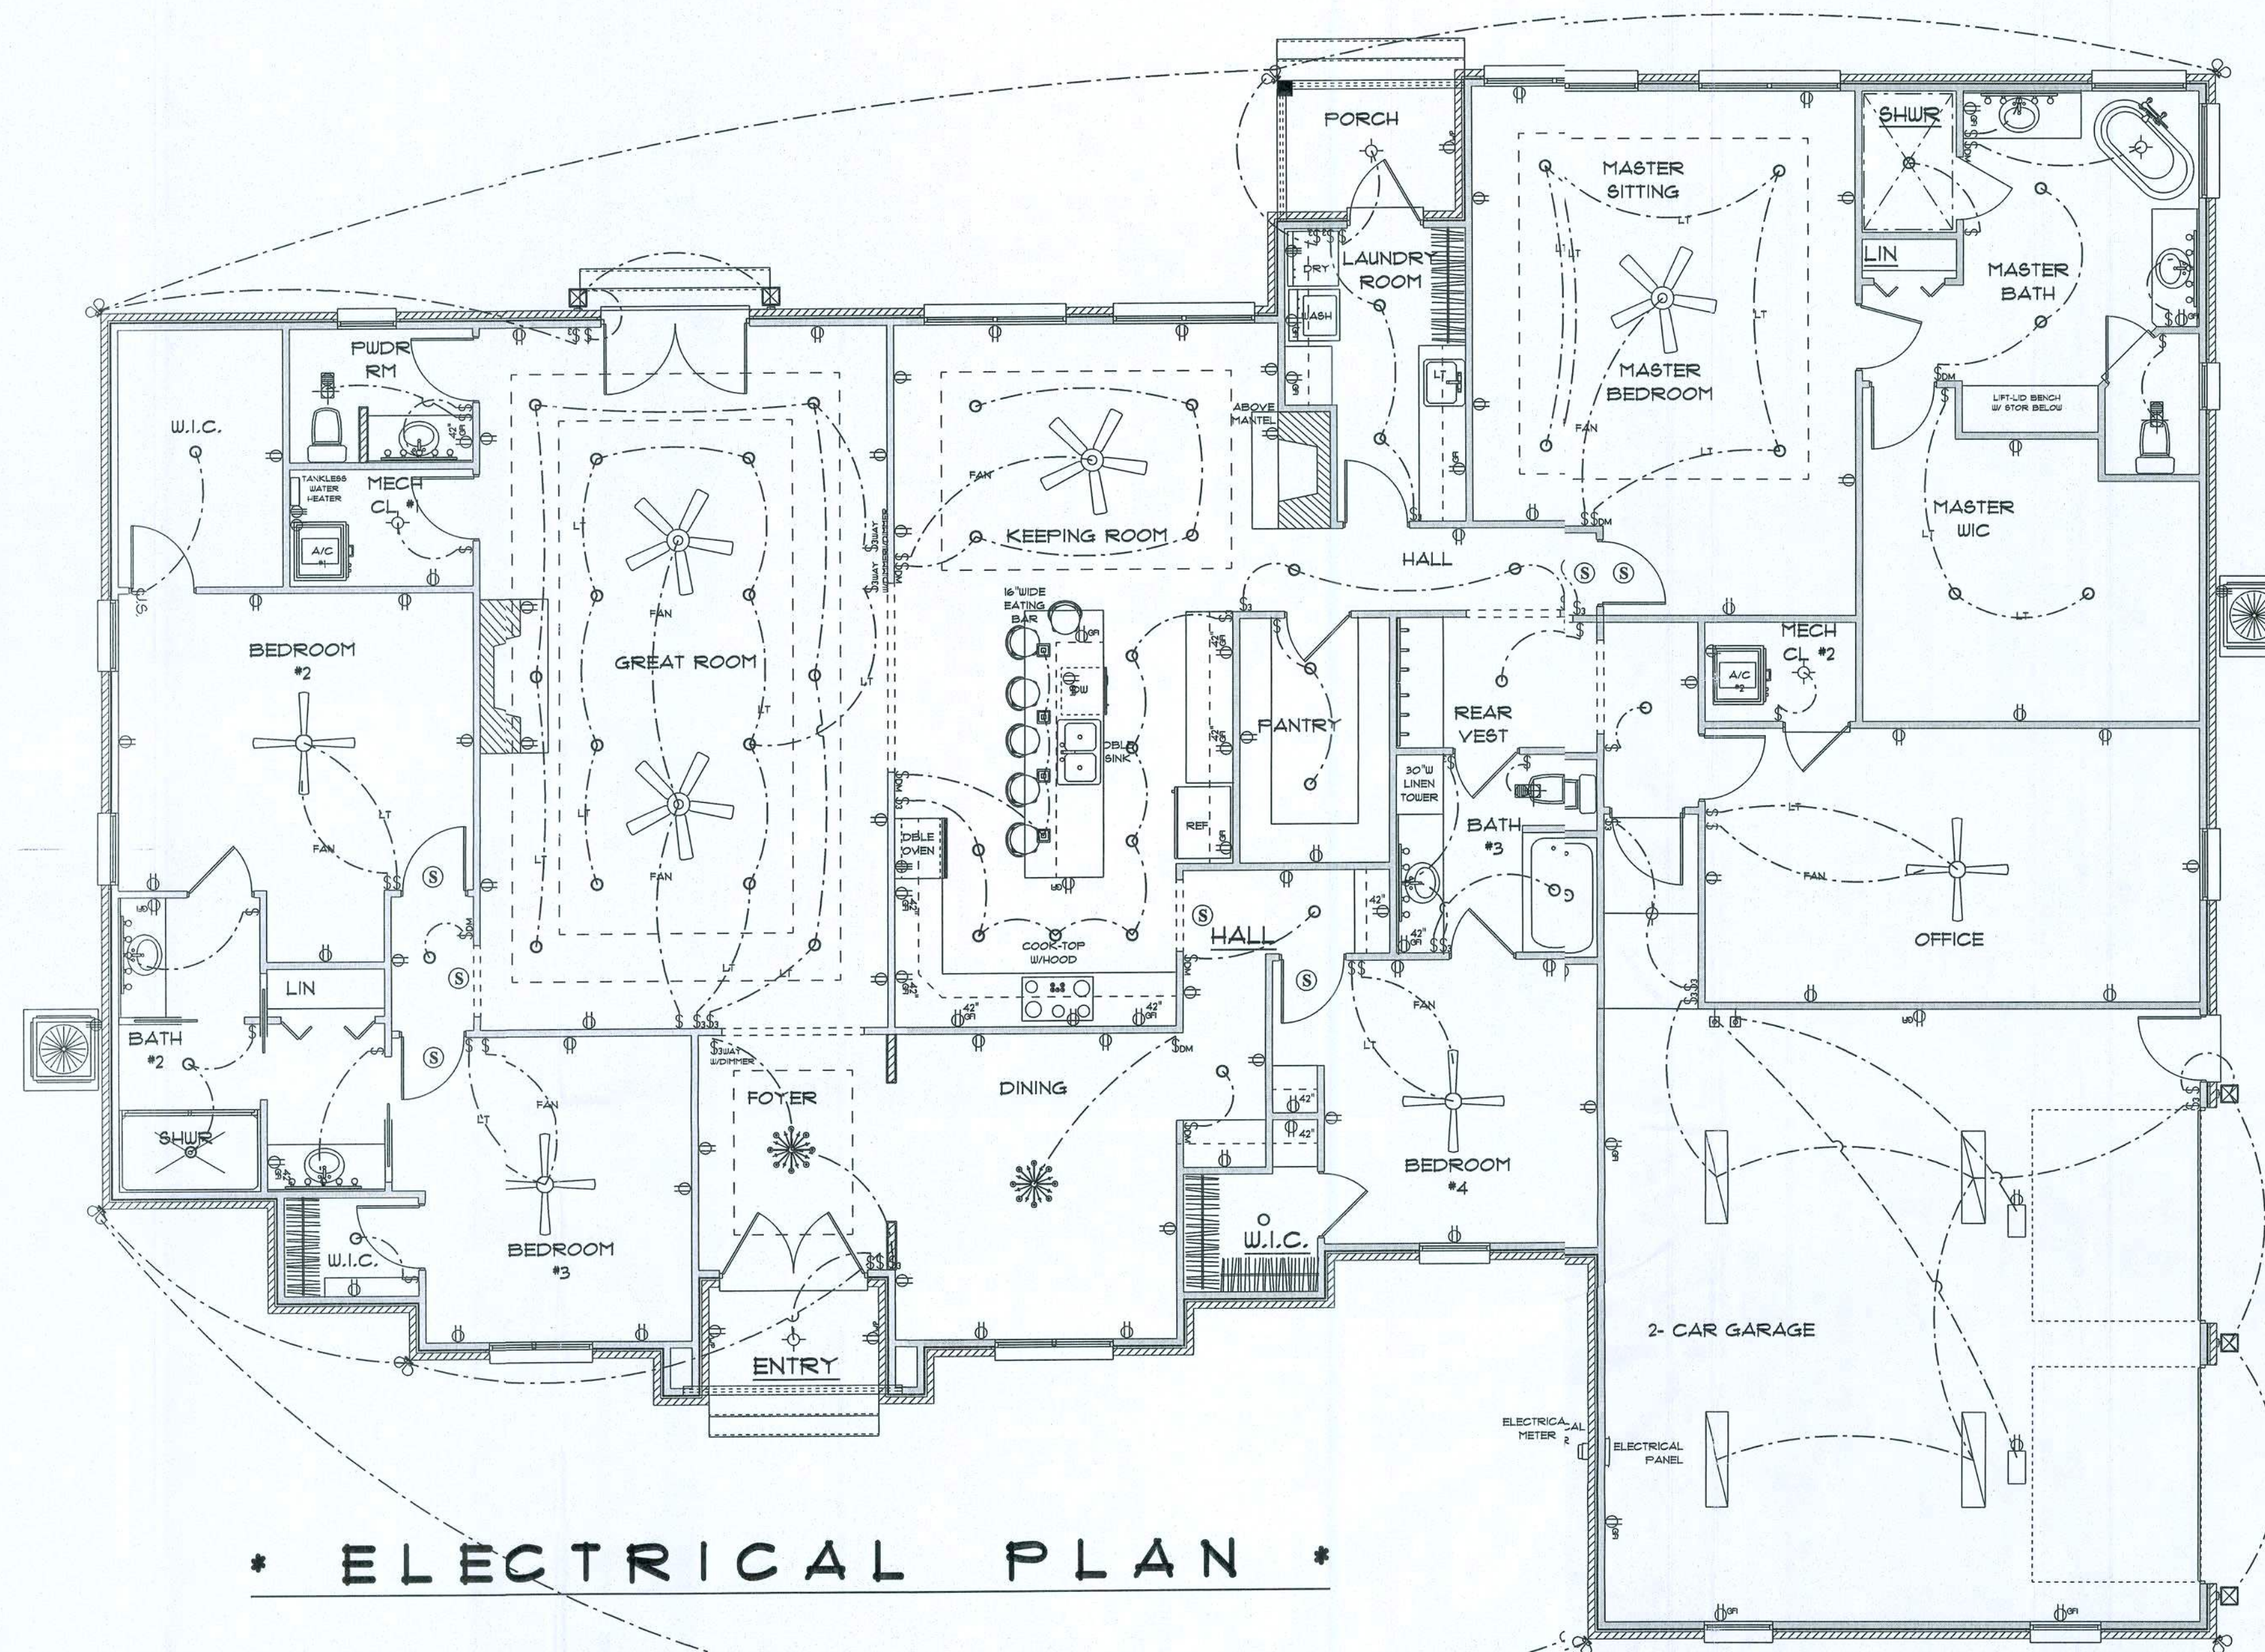

* ELECTRICAL PLAN *

SCALE: 3/16" = 1'-0"

ELECTRICAL PLAN NOTES

- E-1 WIRE ALL APPLIANCES, HVAC UNITS AND OTHER EQUIPMENT PER MANUFACTURER'S SPECIFICATIONS.
- E-2 CONSULT THE OWNER FOR THE NUMBER OF SEPERATE TELEPHONE LINES TO BE INSTALLED.
- E-4 ALL INSTALLATIONS SHALL BE PER NATIONAL ELECTRIC CODE.
- E-3 ALL SMOKE DETECTORS SHALL BE 120V W/BATTERY BACKUP OF THE PHOTOELECTRIC TYPE AND SHALL BE INTERLOCKED TOGETHER. INSTALL INSIDE AND NEAR ALL BEDROOMS.
- E-5 TELEPHONE, TELEVISION AND OTHER LOW VOLTAGE DEVICES OR OUTLETS SHALL BE AS PER THE OWNERS DIRECTION AND IN ACCORDANCE WITH APPLICABLE SECTIONS OF NATIONAL ELCT. CODE LATEST EDITION.
- E-6 ELECTRICAL CONTRACTOR SHALL BE RESPONSIBLE FOR THE DESIGN AND SIZING OF ELECTRICAL SERVICE AND CIRCUITS.
- E-7 ENTRY OF SERVICE UNDERGROUND OR OVERHEAD IS TO BE DETERMINED BY THE POWER COMPANY.
- E-8 ALL BEDROOM RECEPTALS ARE TO BE AFCI (ARC FAULT CIRCUIT INTERRUPT)

ELECTRICAL LEGEND		
ELECTRICAL	COUNT	SYMBOL
ceiling fan 5 bladed 01	4	
ceiling fan globe 01	4	
ceiling classic	2	
fluorescent light 1 x 4	4	
pendant large	4	
pot light	51	
exterior light 03	5	
spotlight double	7	
Smoke Detector	7	
vanity bar light	6	
electrical meter	1	
electrical panel	1	
3 way switch with dimmer	3	
automatic garage dr opener	2	
dimmer switch	9	
garage dr opener	2	
jamb switch	1	
light	6	
outlet	72	
outlet 220v	5	
outlet gfi	24	
outlet wp	3	
switch	34	
switch 3 way	17	
vent light combo	3	

RESIDENCE
for
PETE & KYALA
JOHNSON

LAKE CITY, FLORIDA

Teena M. Ruffo
2825 SW 41
Lake City, Florida 32025
Cell: (386) 671-1191
Email: teena.ruffo@gmail.com

PRINTED DATE:
Wednesday, January 31, 2012

DRAWN BY: Teena M. Ruffo
CHECKED BY:

BUILDING CONTRACTOR

FINALS DATE:

JOB NUMBER

DRAWING NUMBER

A-4

OF 4 SHEETS