

ADDITION PLANS FOR GRANGER RESIDENCE COLUMBIA COUNTY, FL


Plan Sheet Index:

Sheet No.	Description
1	title/index sheet
2	floor plan
3	front and right elevations
4	rear and left elevations
5	wall typical
6	roof plan
7	foundation & plumbing plan
8	electrical plan bottom floor

PLANS PREPARED BY:
CHRISTOPHER Q. DICKS
4035 SE CR 252, LAKE CITY, FL 32025

GRANGER RESIDENCE
COLUMBIA COUNTY, FLORIDA

SHEET
1
OF
8

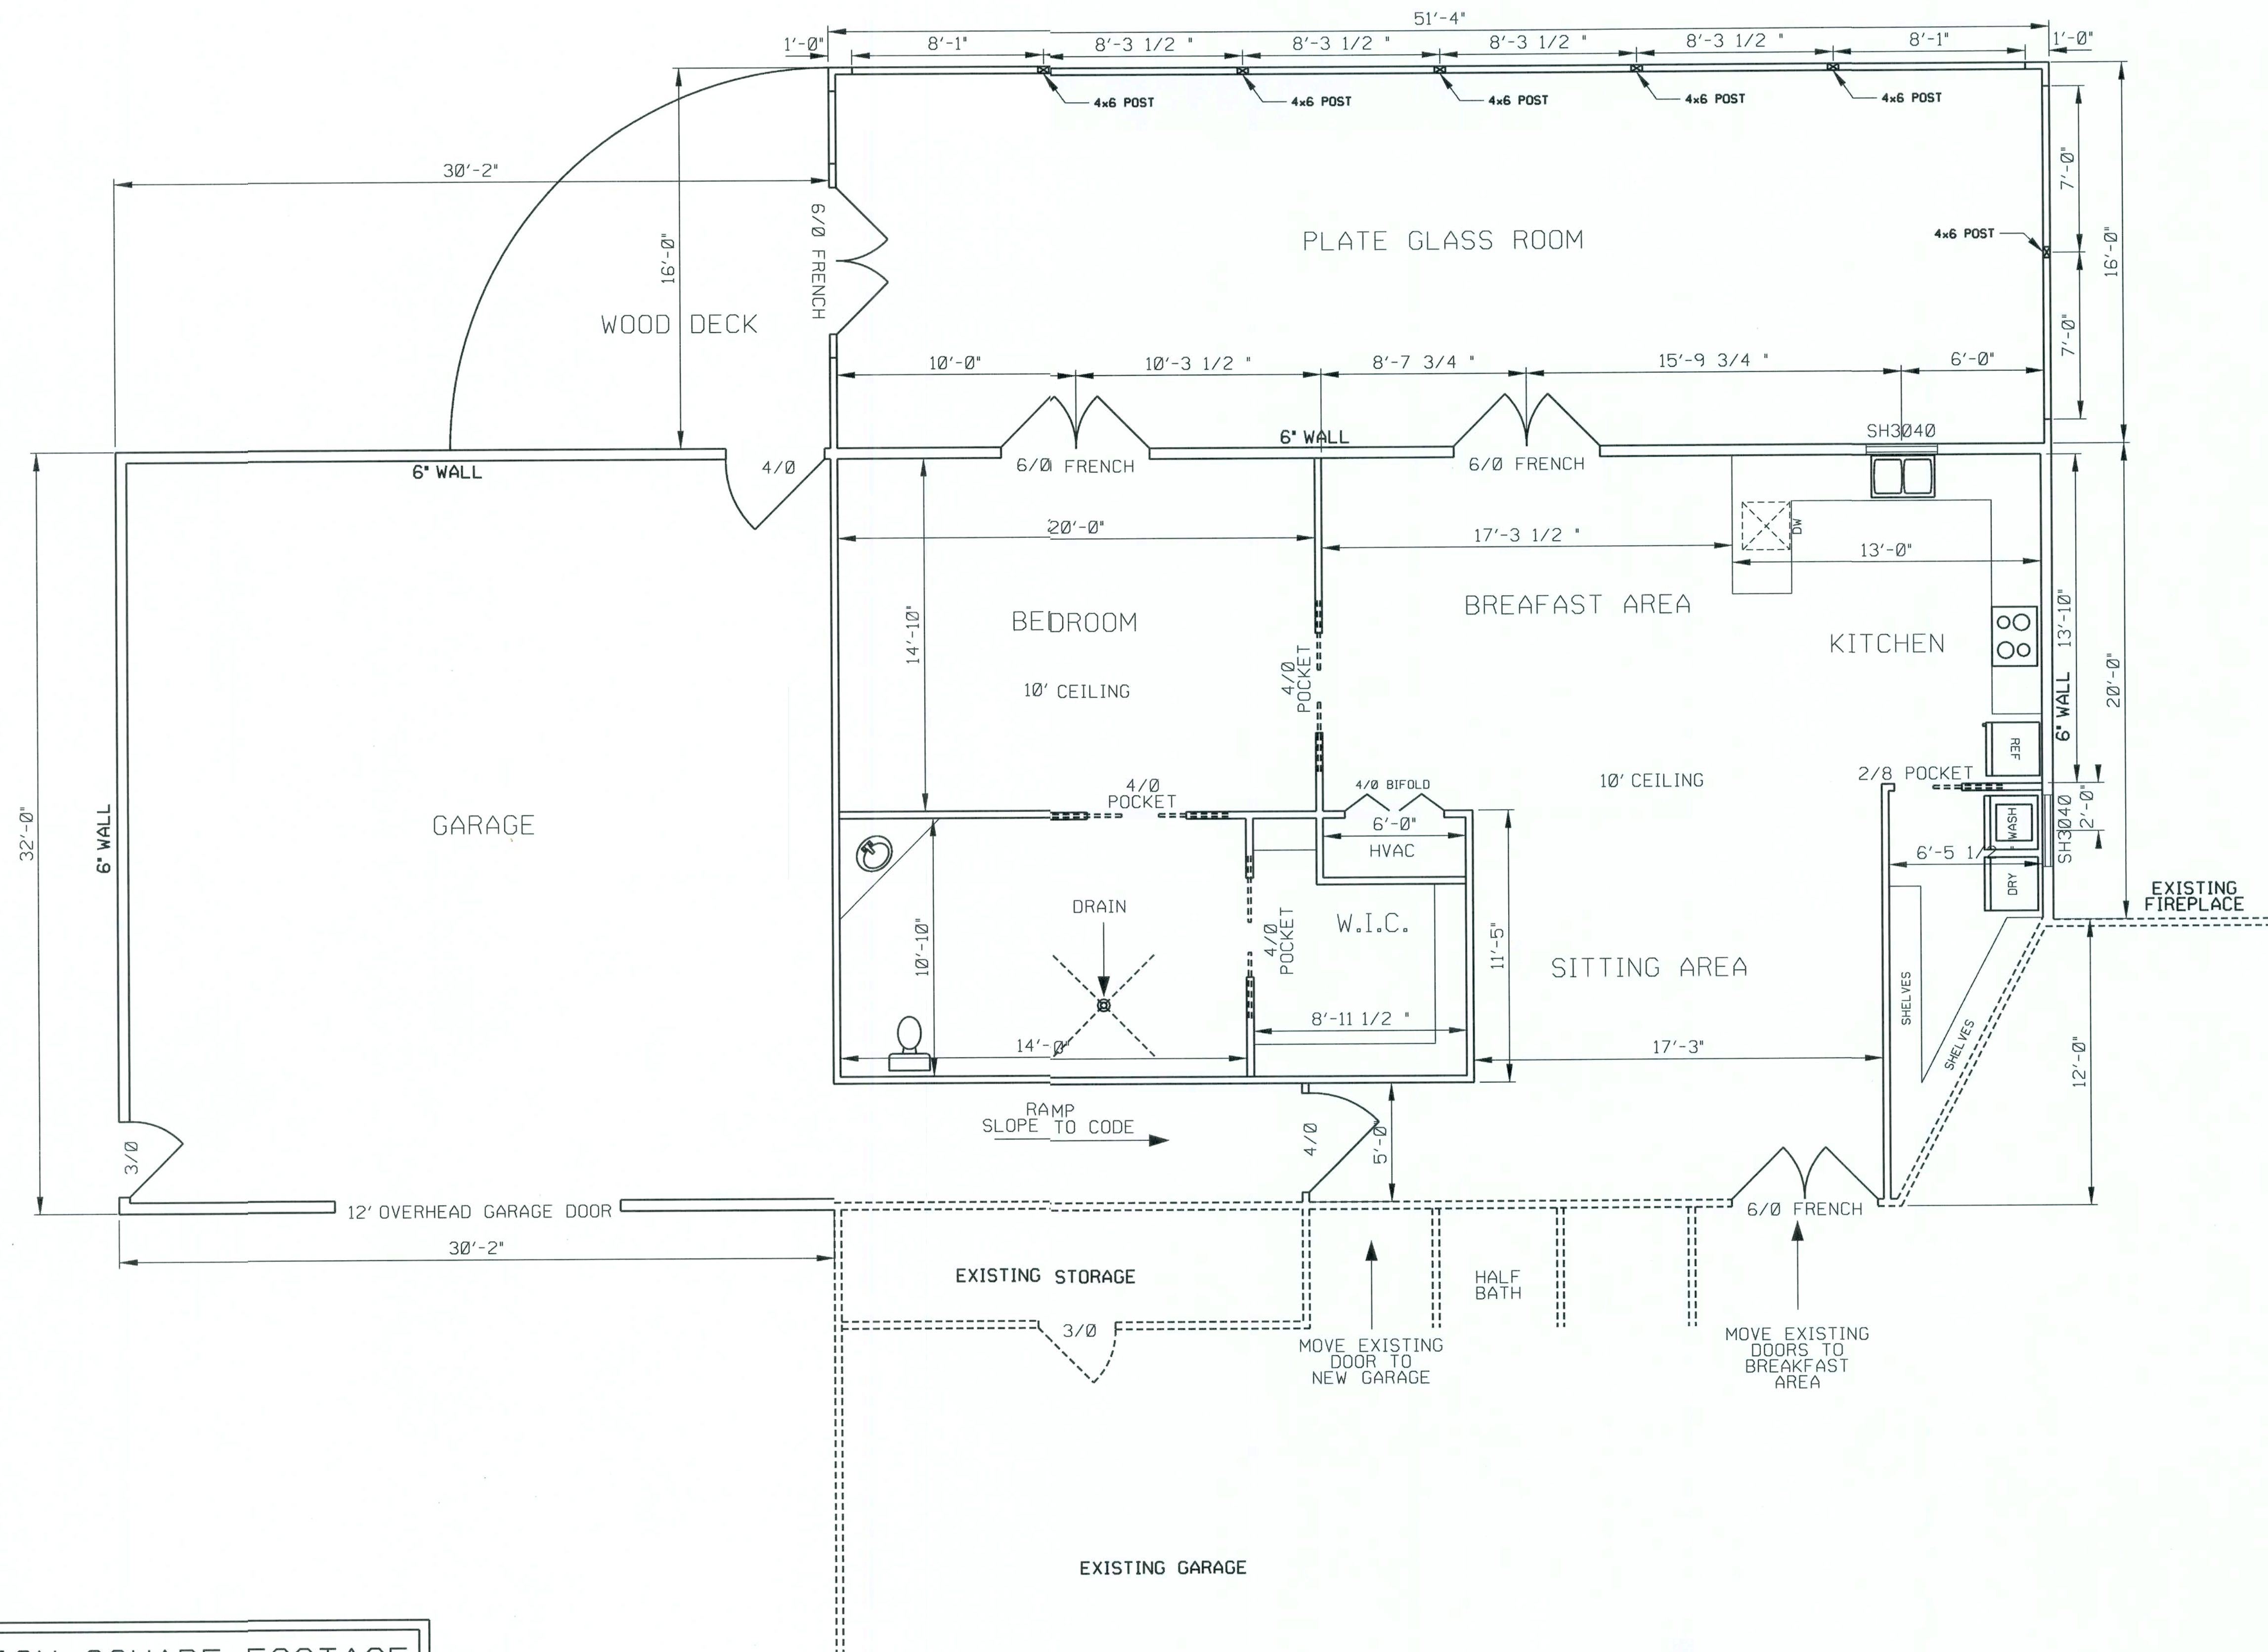

ADDITION SQUARE FOOTAGE	
HEATED AREA	1603 SF
GARAGE	965 SF
GLASS PORCH	845 SF
DECK	201 SF
TOTAL	3614 SF


FLOOR PLAN

0 4' 8'
scale


PLANS PREPARED BY:
CHRISTOPHER Q. DICKS
4035 SE CR 252, LAKE CITY, FL 32025

GRANGER RESIDENCE
COLUMBIA COUNTY, FLORIDA

SHEET
2
OF
8

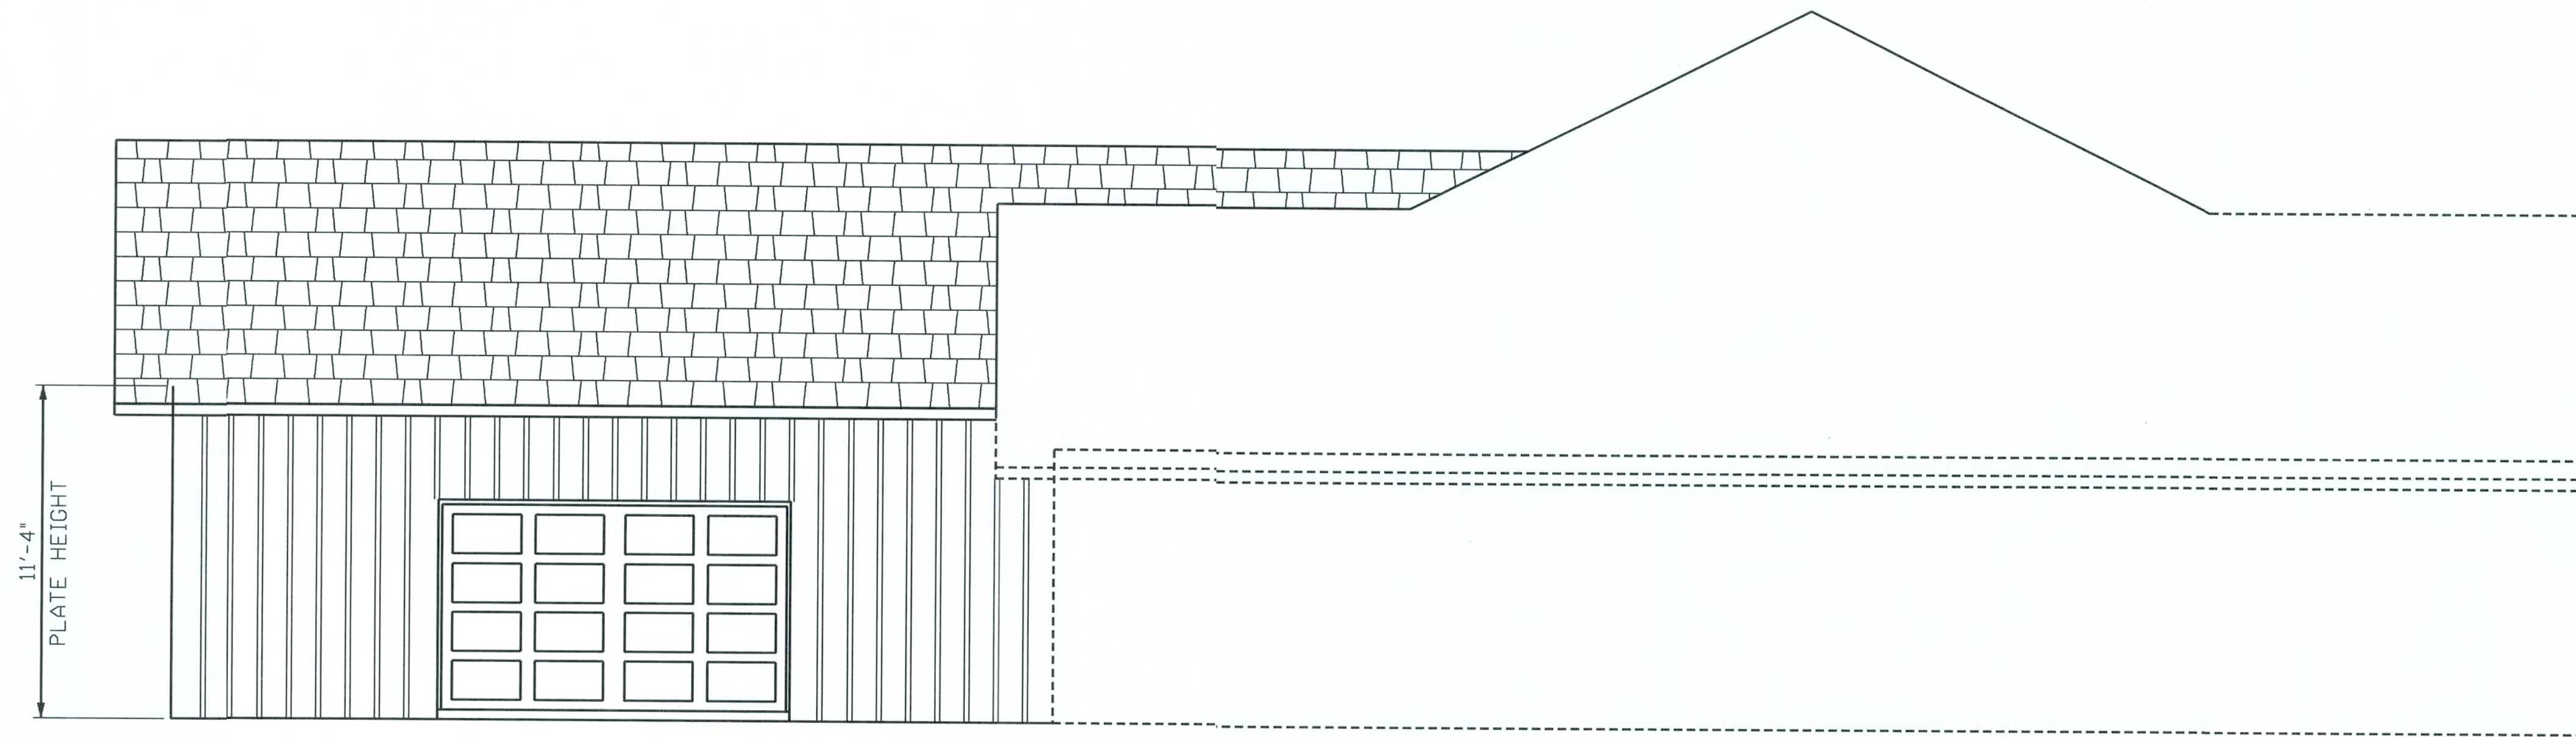

FRONT ELEVATION

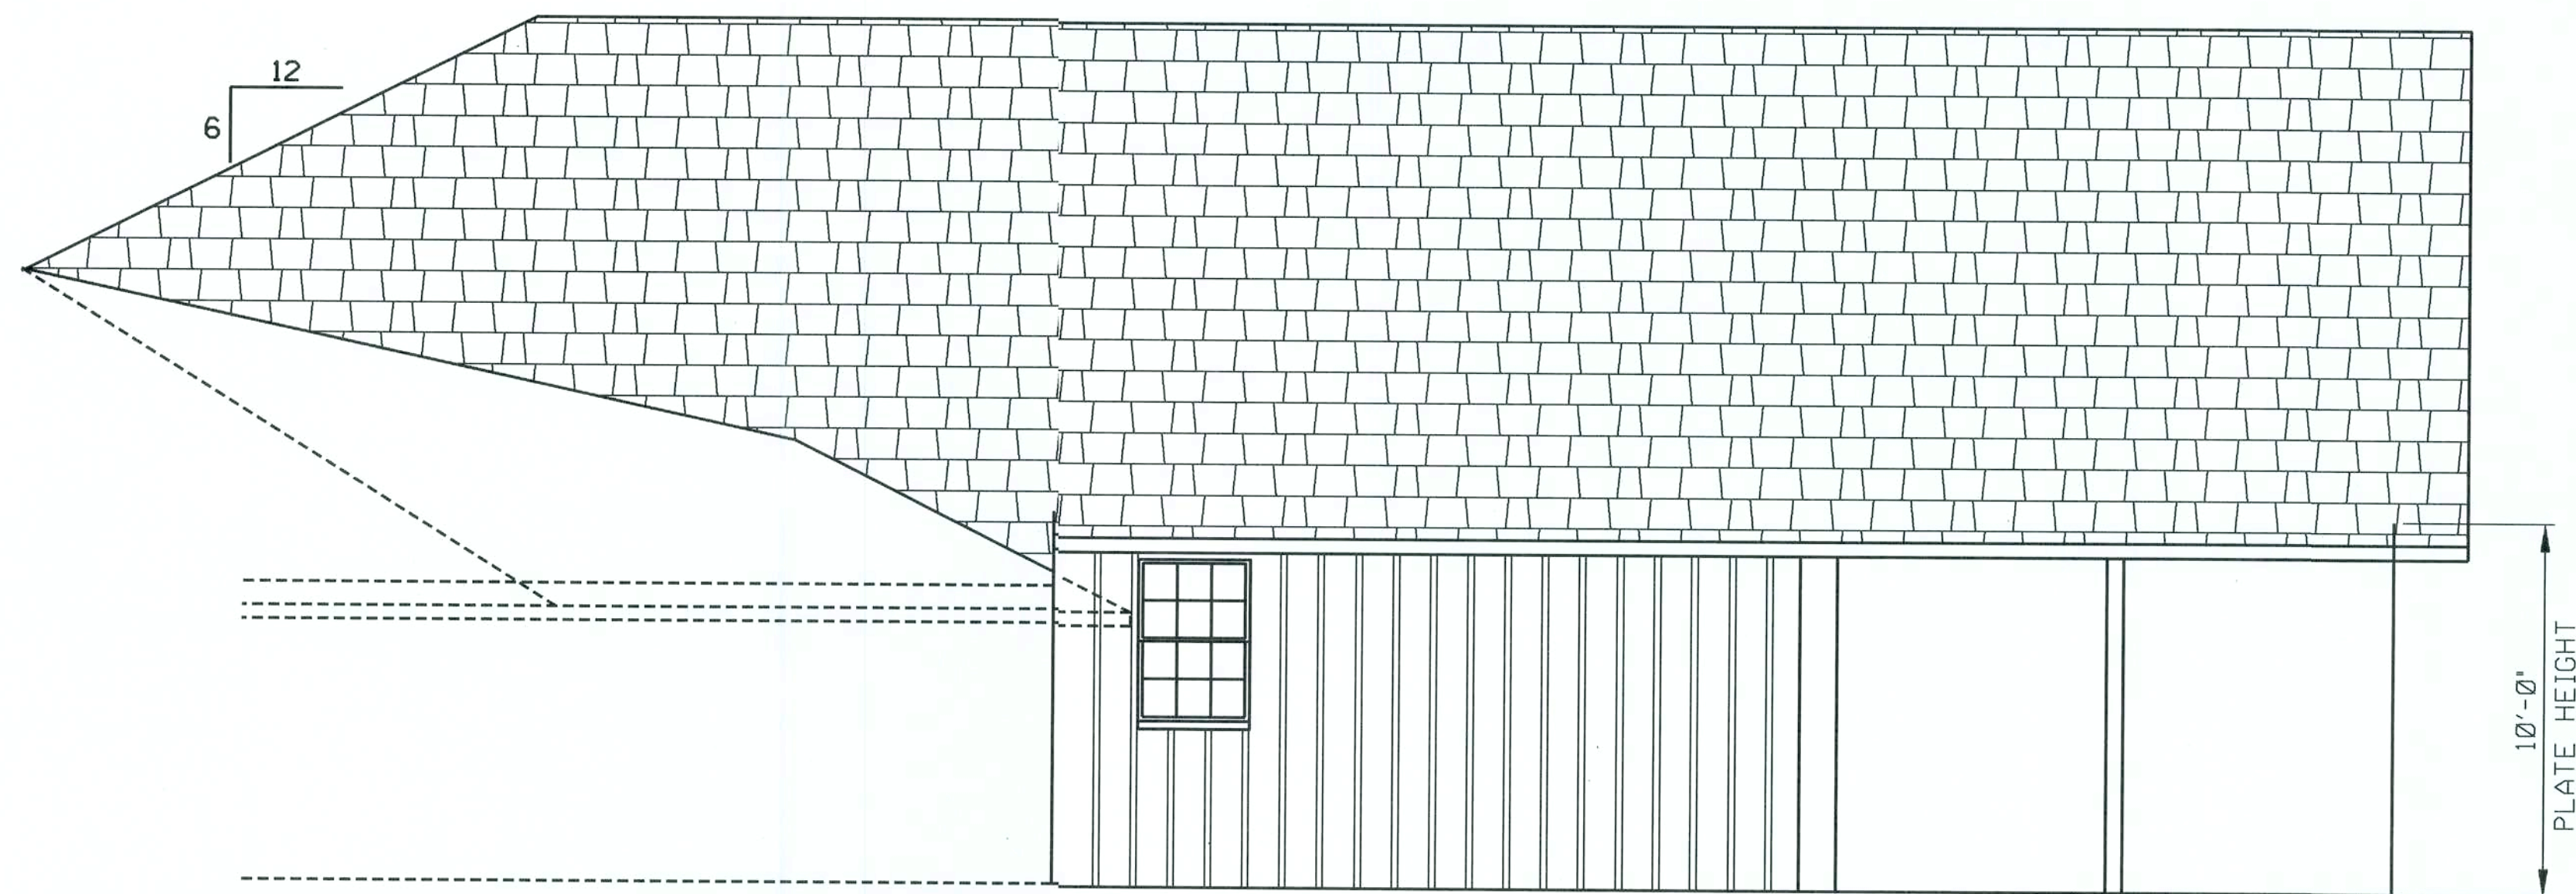


RIGHT ELEVATION

4' 8'
scale


SHEET
3
OF
8

GRANGER RESIDENCE
COLUMBIA COUNTY, FLORIDA

PLANS PREPARED BY:
CHRISTOPHER O. DICKS
4035 SE CR 252, LAKE CITY, FL 32025

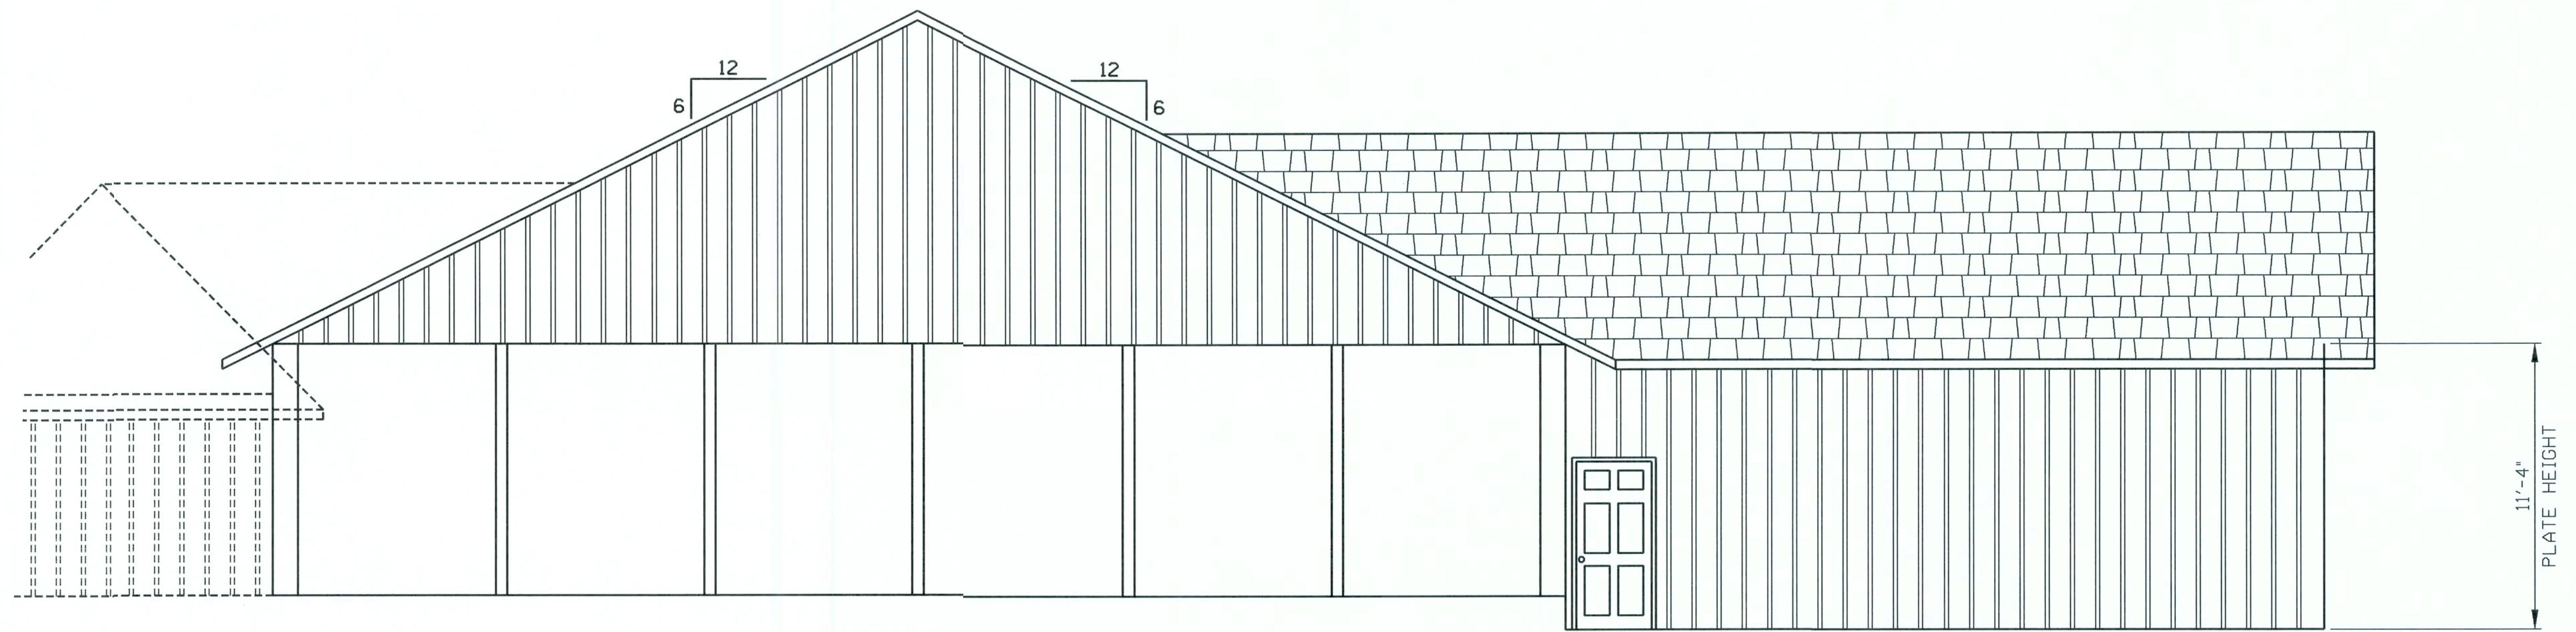

REAR ELEVATION

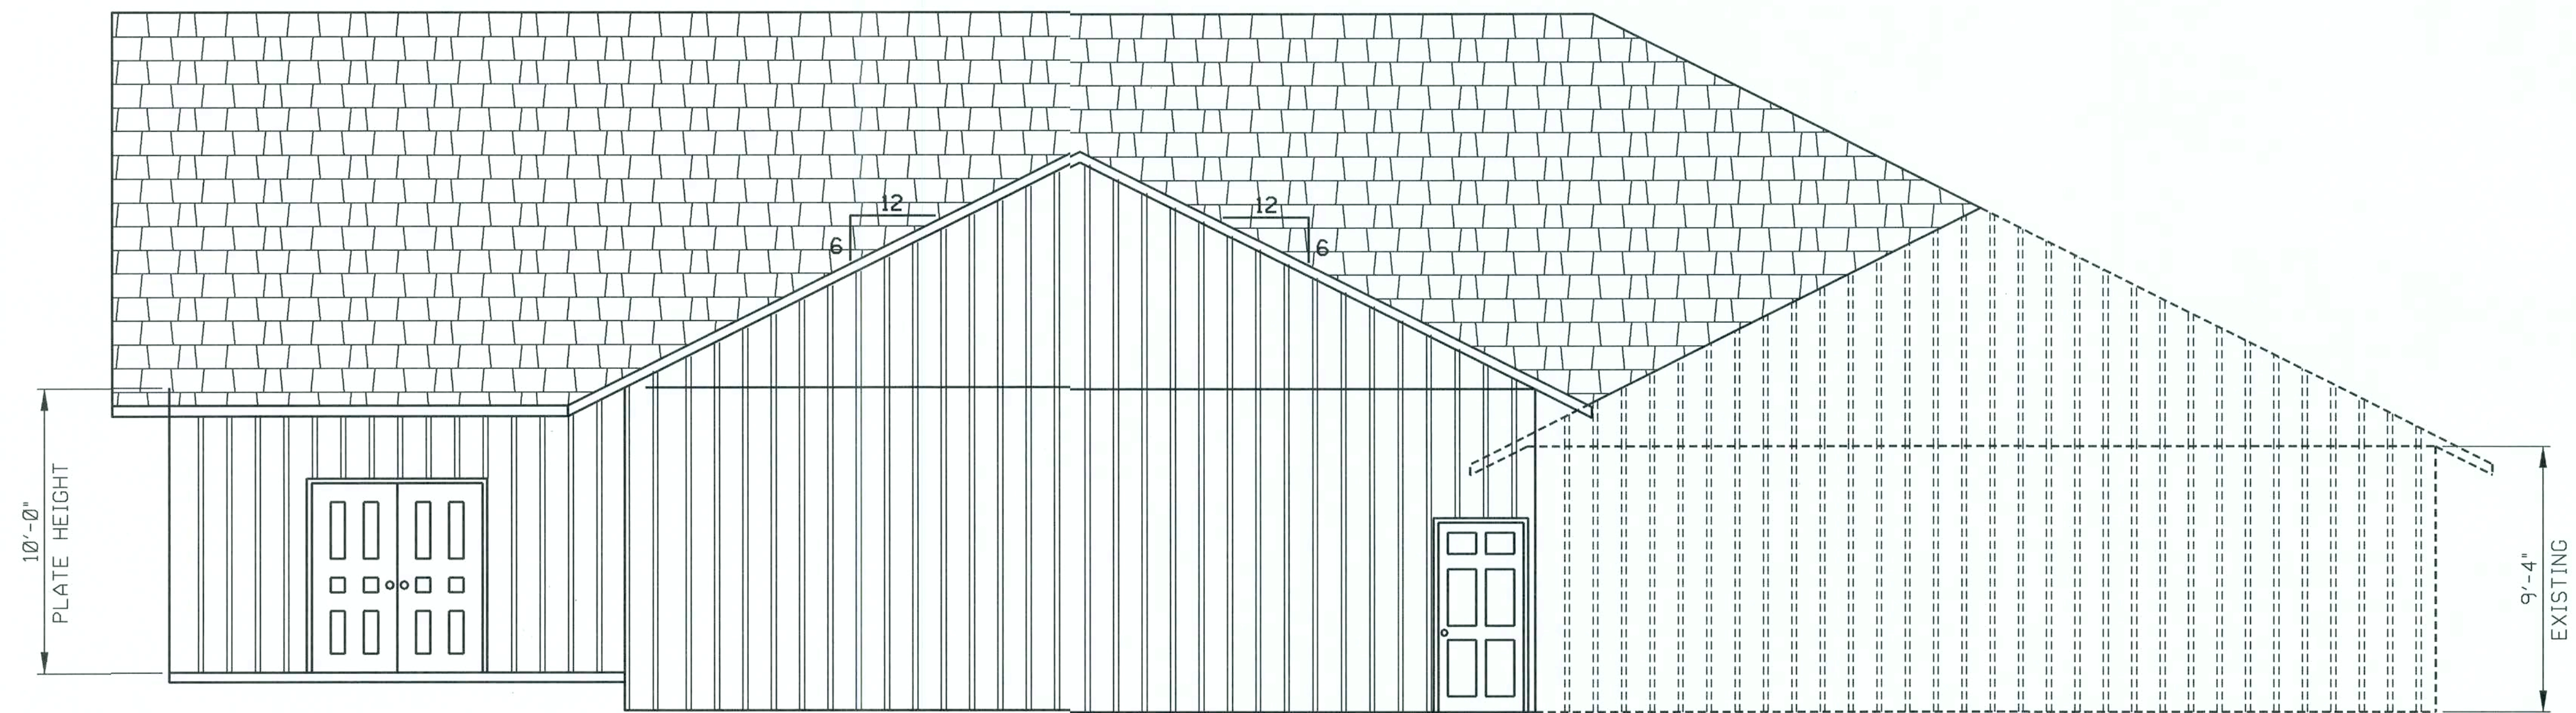


LEFT ELEVATION

0 4' 8'
scale

PLANS PREPARED BY:
CHRISTOPHER O. DICKS
4035 SE CR 252, LAKE CITY, FL 32025

GRANGER RESIDENCE
COLUMBIA COUNTY, FLORIDA

SHEET
4
OF
8

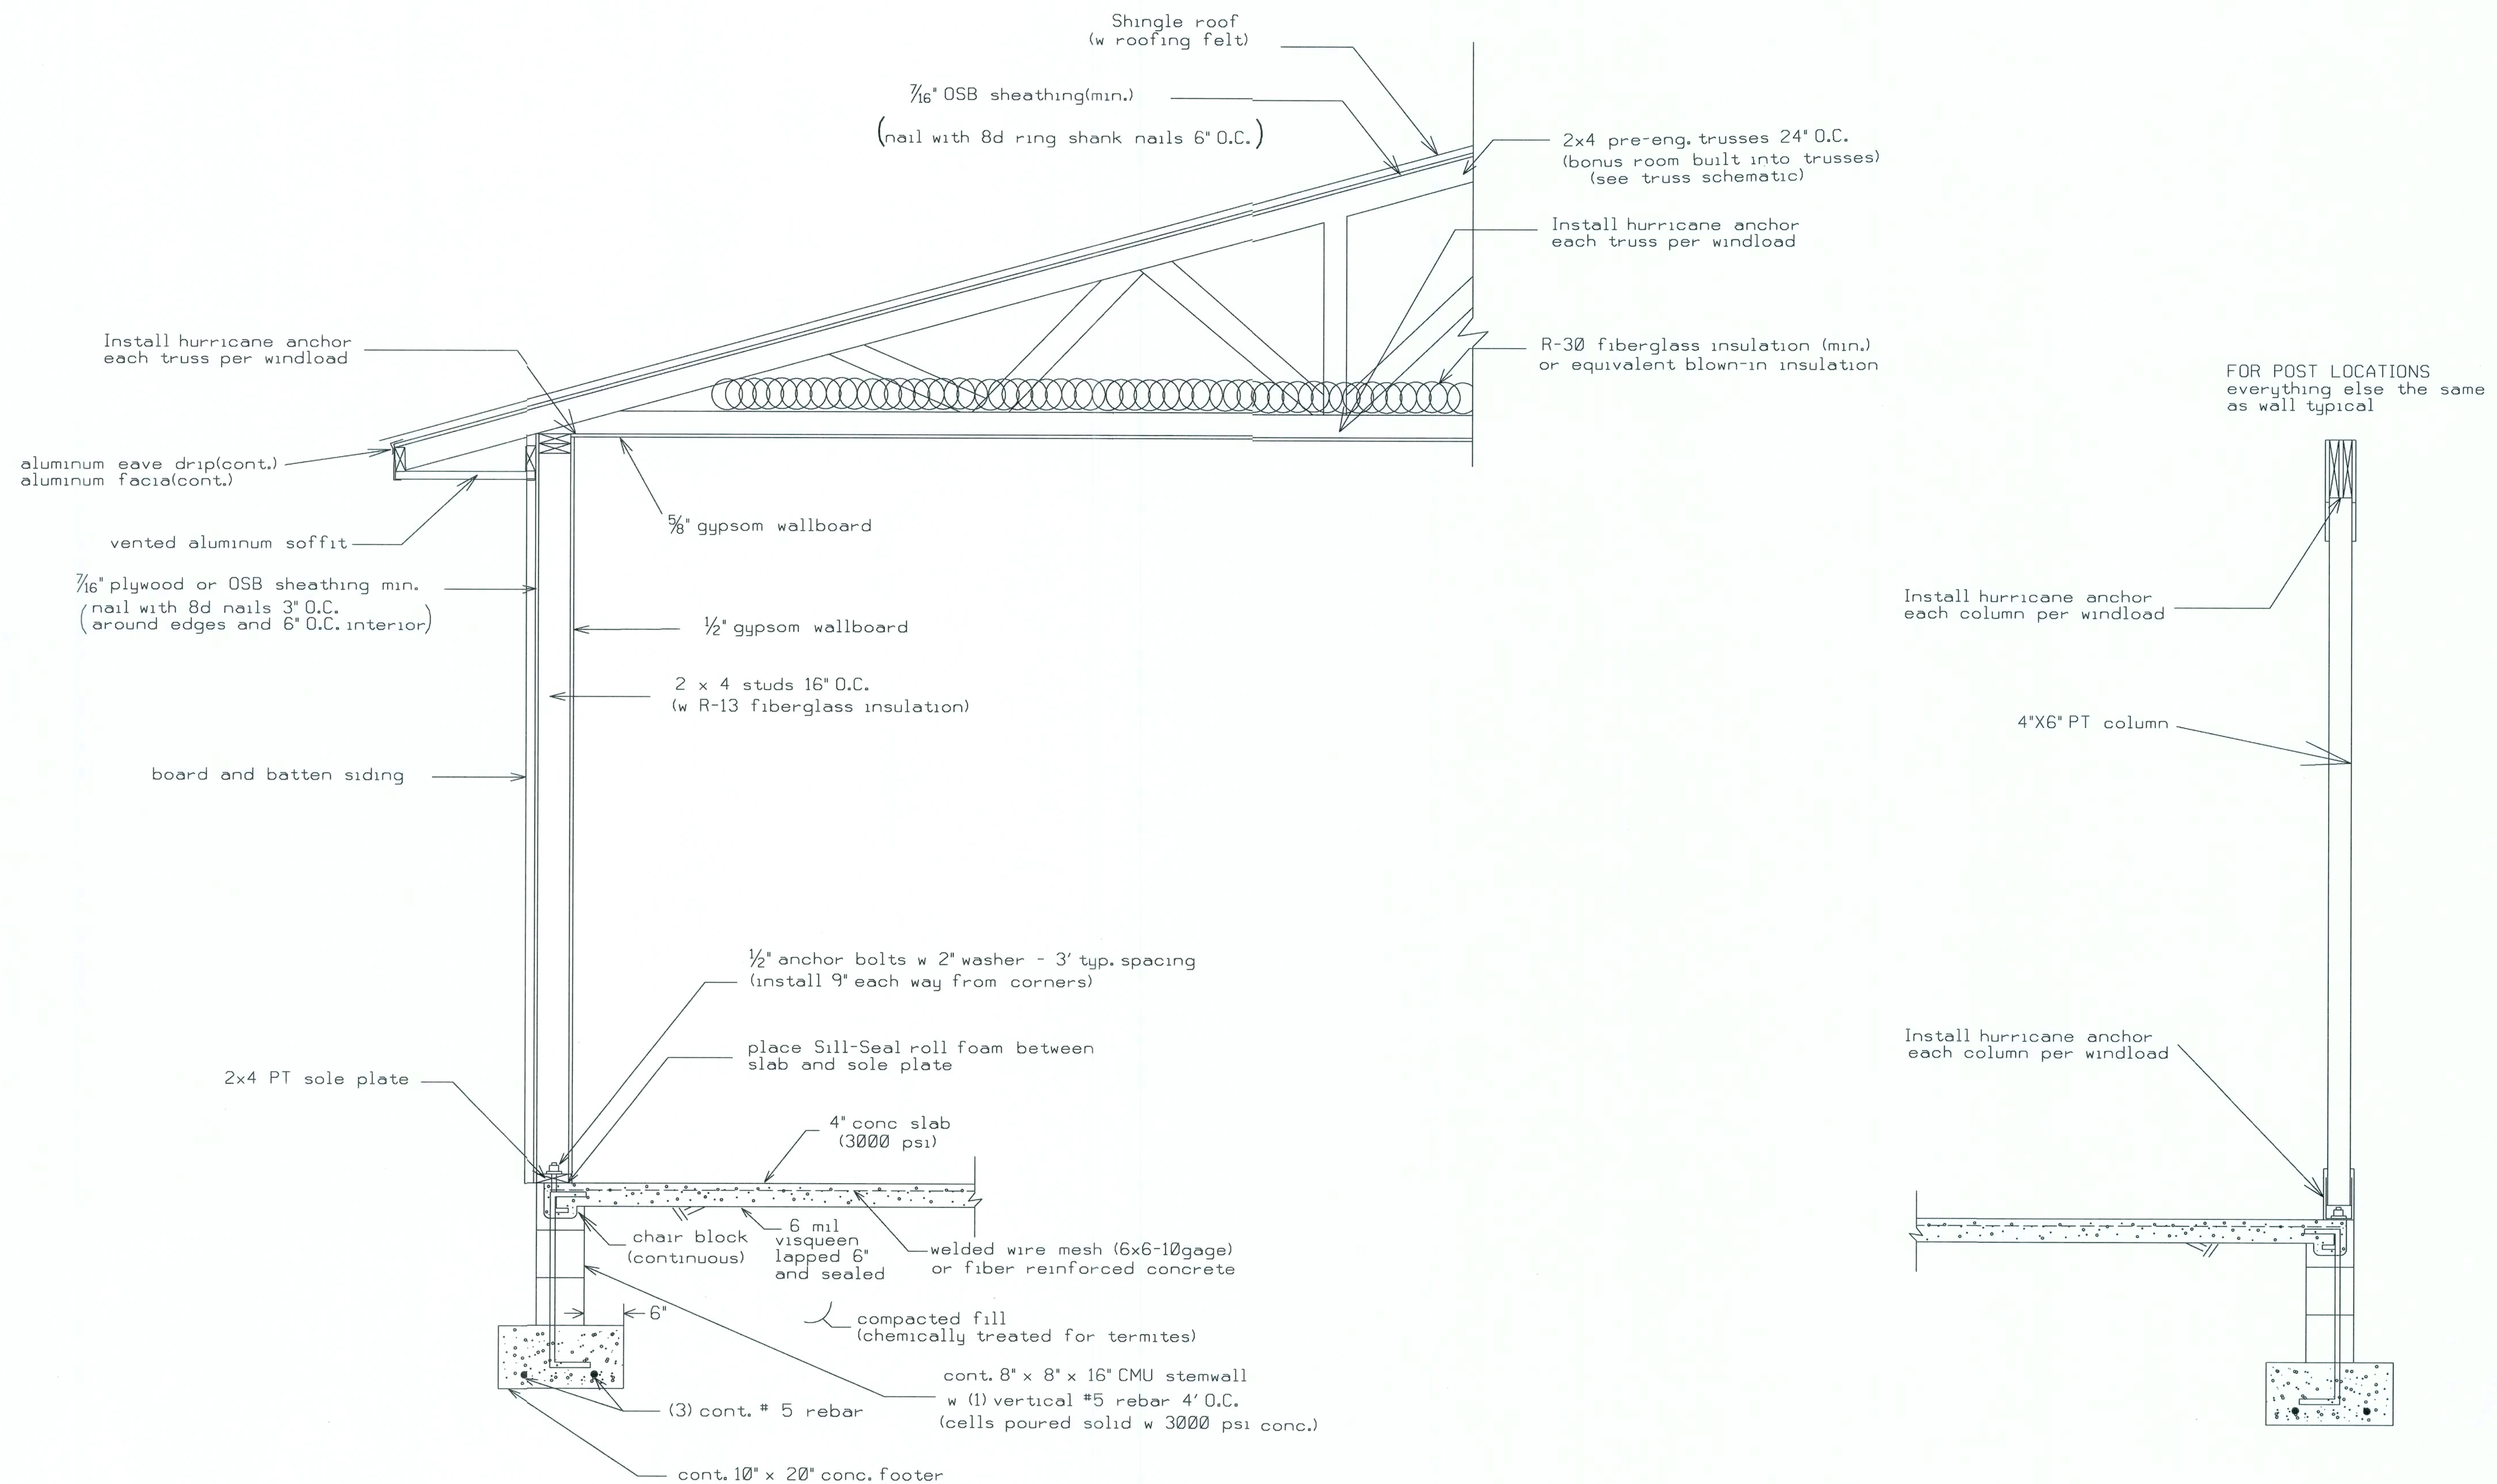


Note: Headers for windows and doors
shall be 2-2x12's(#2 SYP) with $\frac{1}{2}$ "
plywood between. Porch beam
shall be 2 -2x10's(#2 SYP) with $\frac{1}{2}$ "
plywood between.

TYPICAL WALL SECTION N.T.S.

PLANS PREPARED BY:
CHRISTOPHER O. DICKS
4035 SE CR 252, LAKE CITY, FL 32025

GRANGER RESIDENCE
COLUMBIA COUNTY, FLORIDA

SHEET
5
OF
8

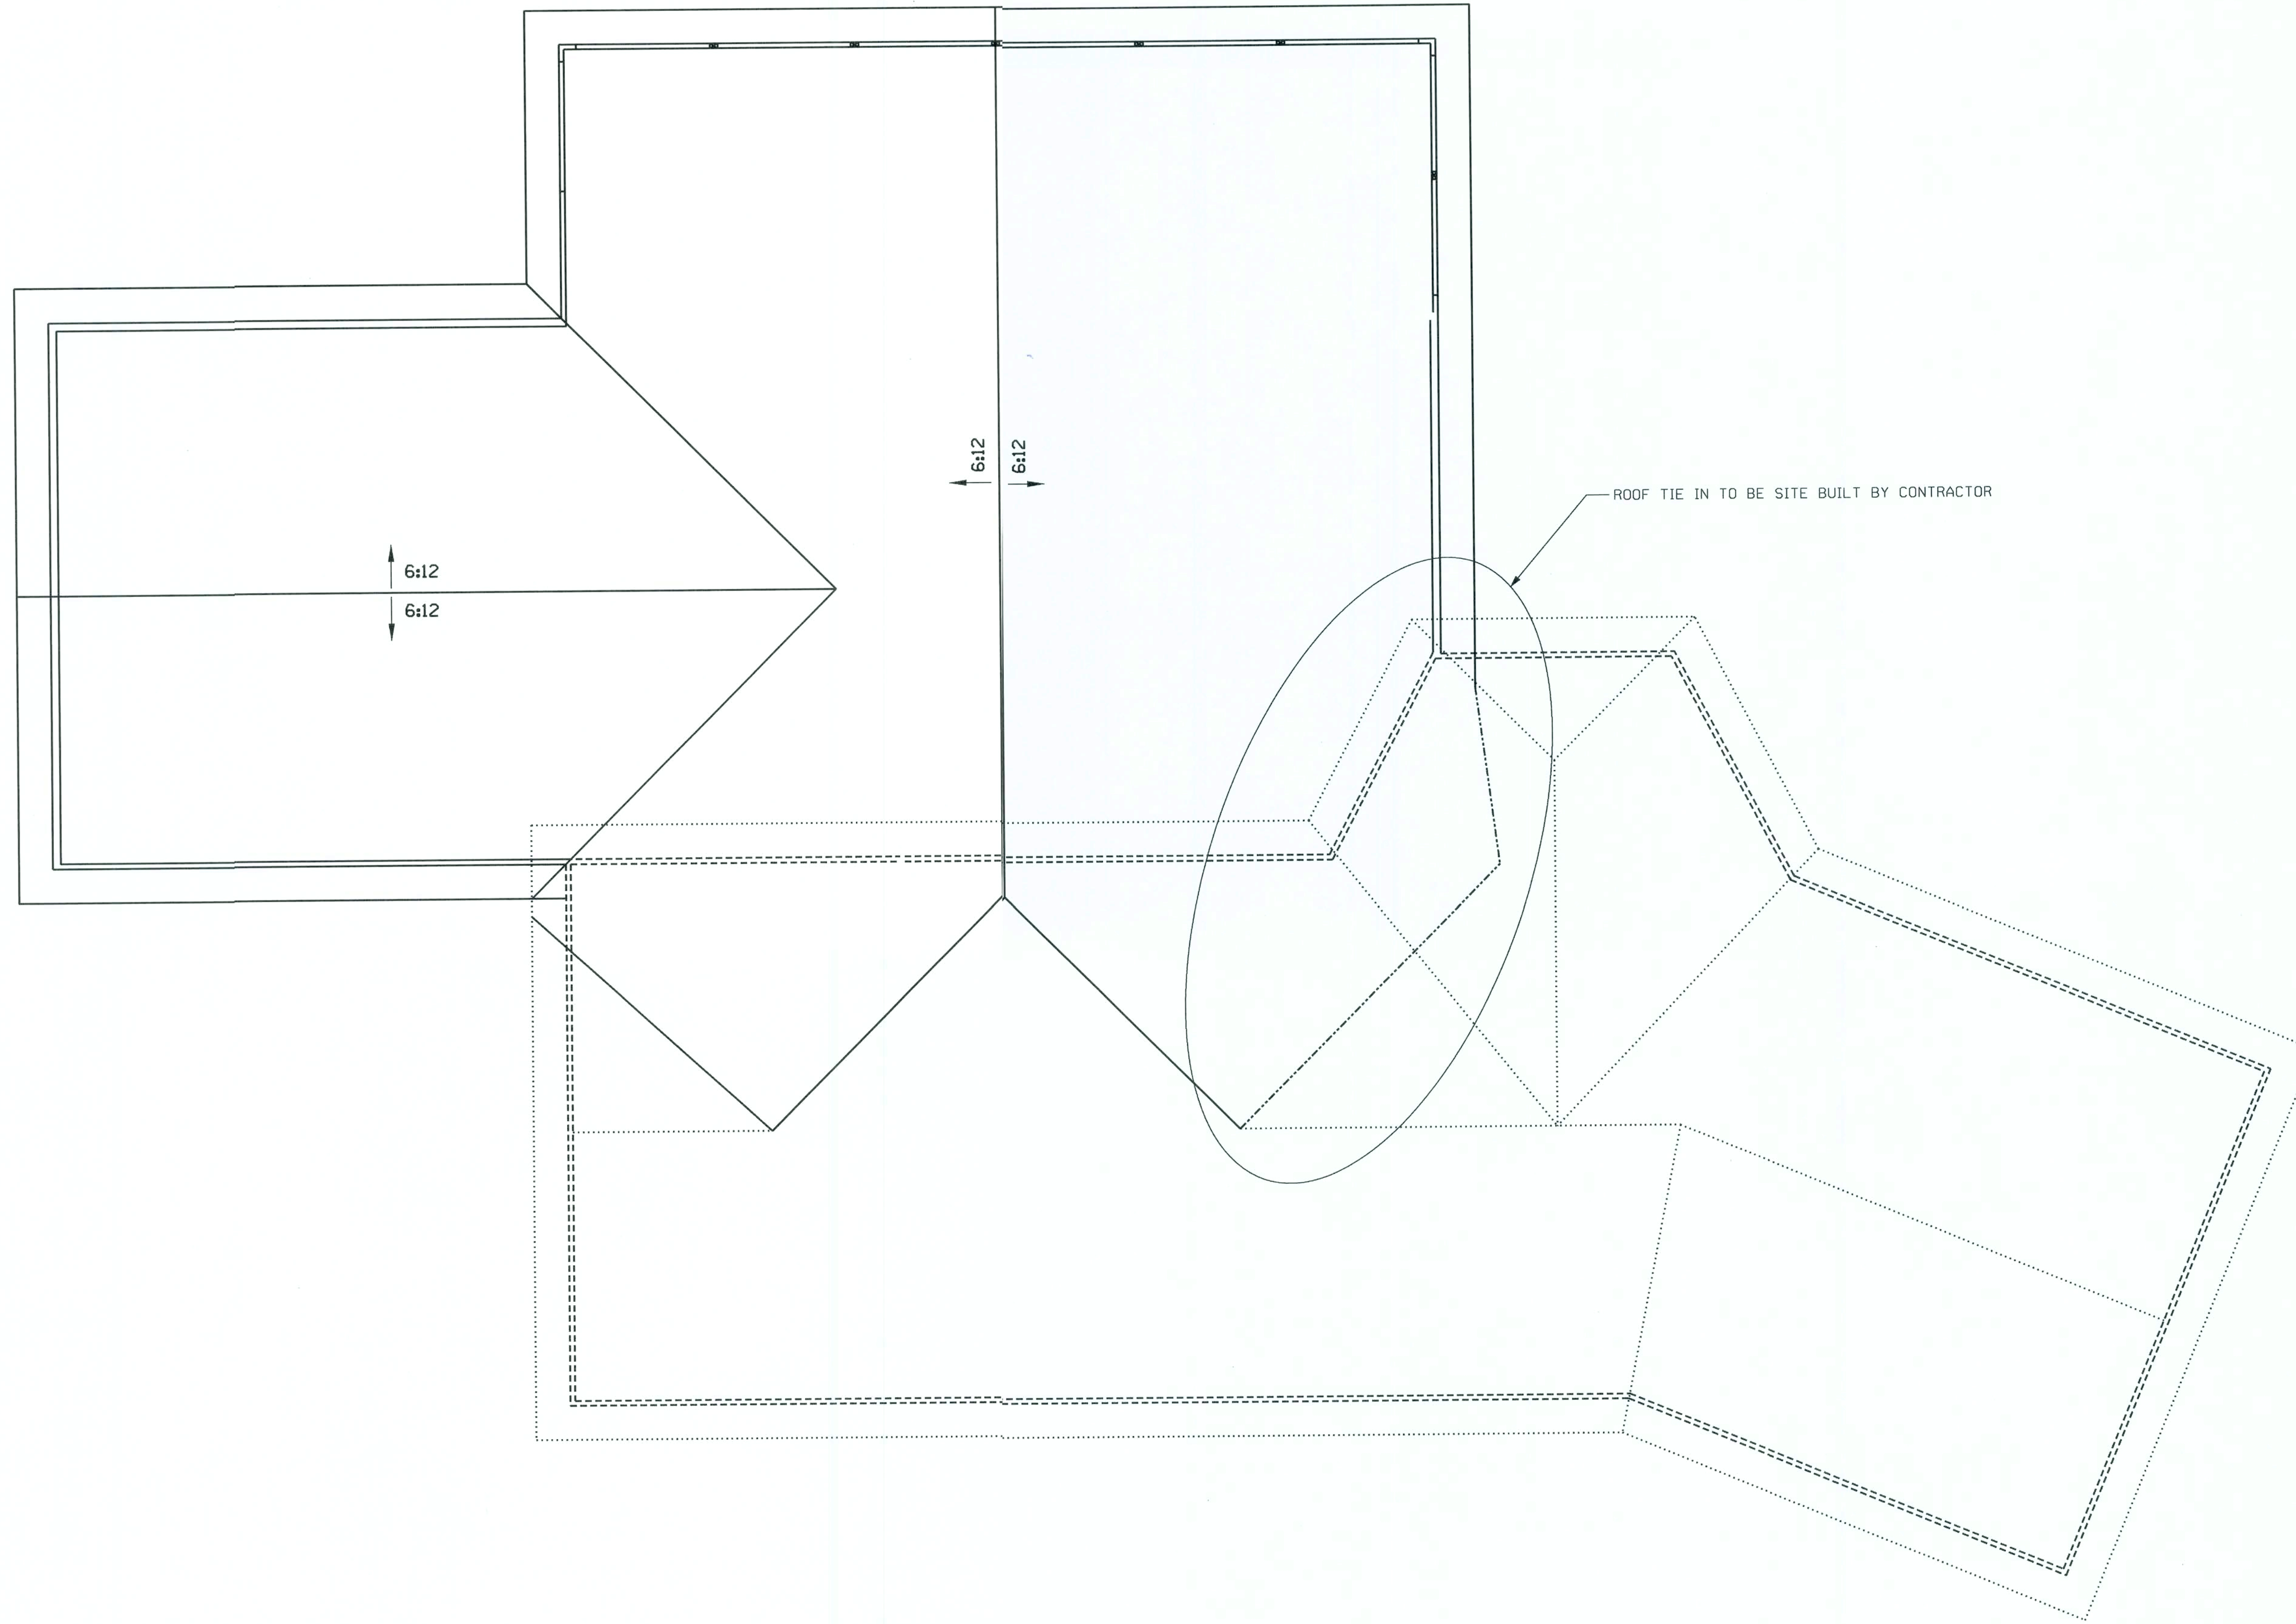


ROOF PLAN

SHEET
6
OF
8

GRANGER RESIDENCE
COLUMBIA COUNTY, FLORIDA

PLANS PREPARED BY:
CHRISTOPHER Q. DICKS
4035 SE CR 252, LAKE CITY, FL 32025

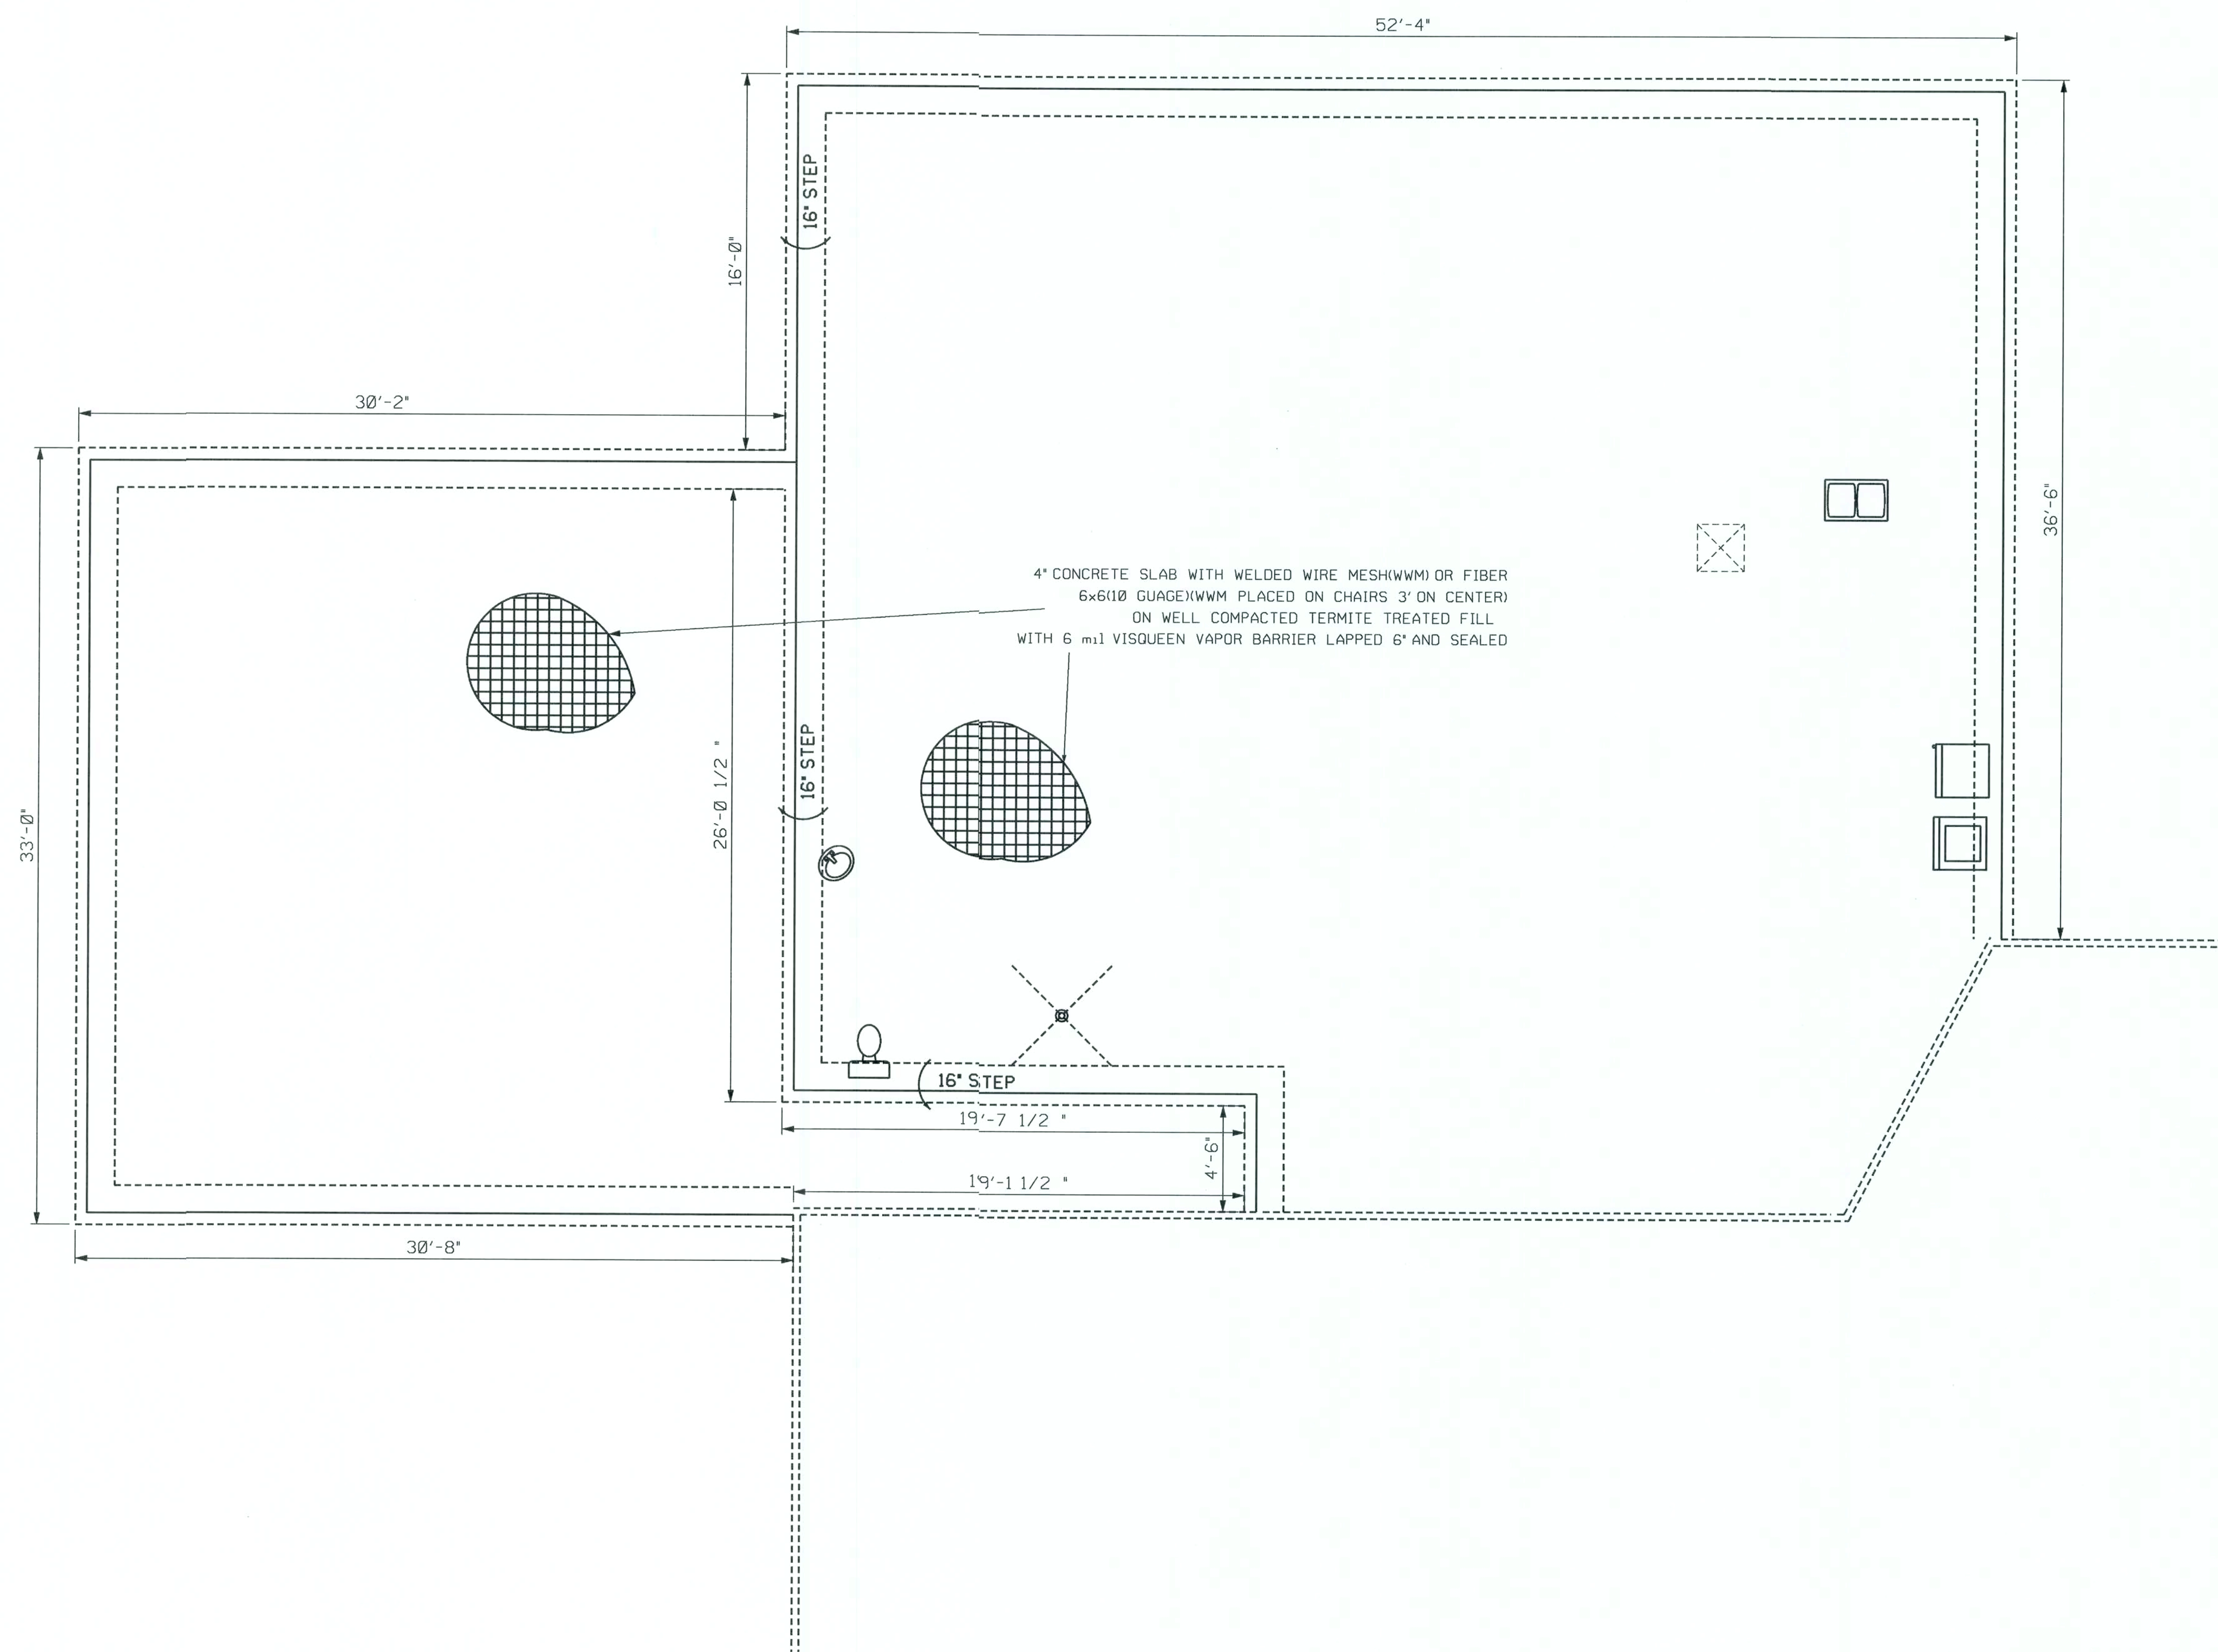


FOUNDATION & PLUMBING PLAN

PLANS PREPARED BY:
CHRISTOPHER O. DICKS
4035 SE CR 252, LAKE CITY, FL 32025

GRANGER RESIDENCE
COLUMBIA COUNTY, FLORIDA


SHEET
7
OF
8

ELECTRICAL LEGEND

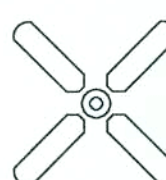-  - CEILING FAN w LIGHTS
-  - LIGHT FIXTURE
-  - SINGLE POLE SWITCH
-  - THREE-WAY SWITCH
-  - FOUR-WAY SWITCH
-  - RECEPT.
-  - RECEPT OR PART OF A GFI CIRCUIT.
-  - FLOOR RECEPT.
-  - SECURITY LIGHT
-  - EXHAUST WITH LIGHT
-  - 220 V.
-  - SMOKE DETECTOR (AC/DC and interconnected)
-  - TELEPHONE AND RG6 COAX
-  - ELECTRICAL SERVICE METER CAN

NOTES:

- 1.) ALL EXTERIOR RECEPTACLES SHALL BE WEATHERPROOF.
- 2.) ALL BEDROOM RECPTS SHALL BE PART OF AN AFCI CIRCUIT. EACH BEDROOM SHALL BE ON AN INDIVIDUAL AFC CIRCUIT.

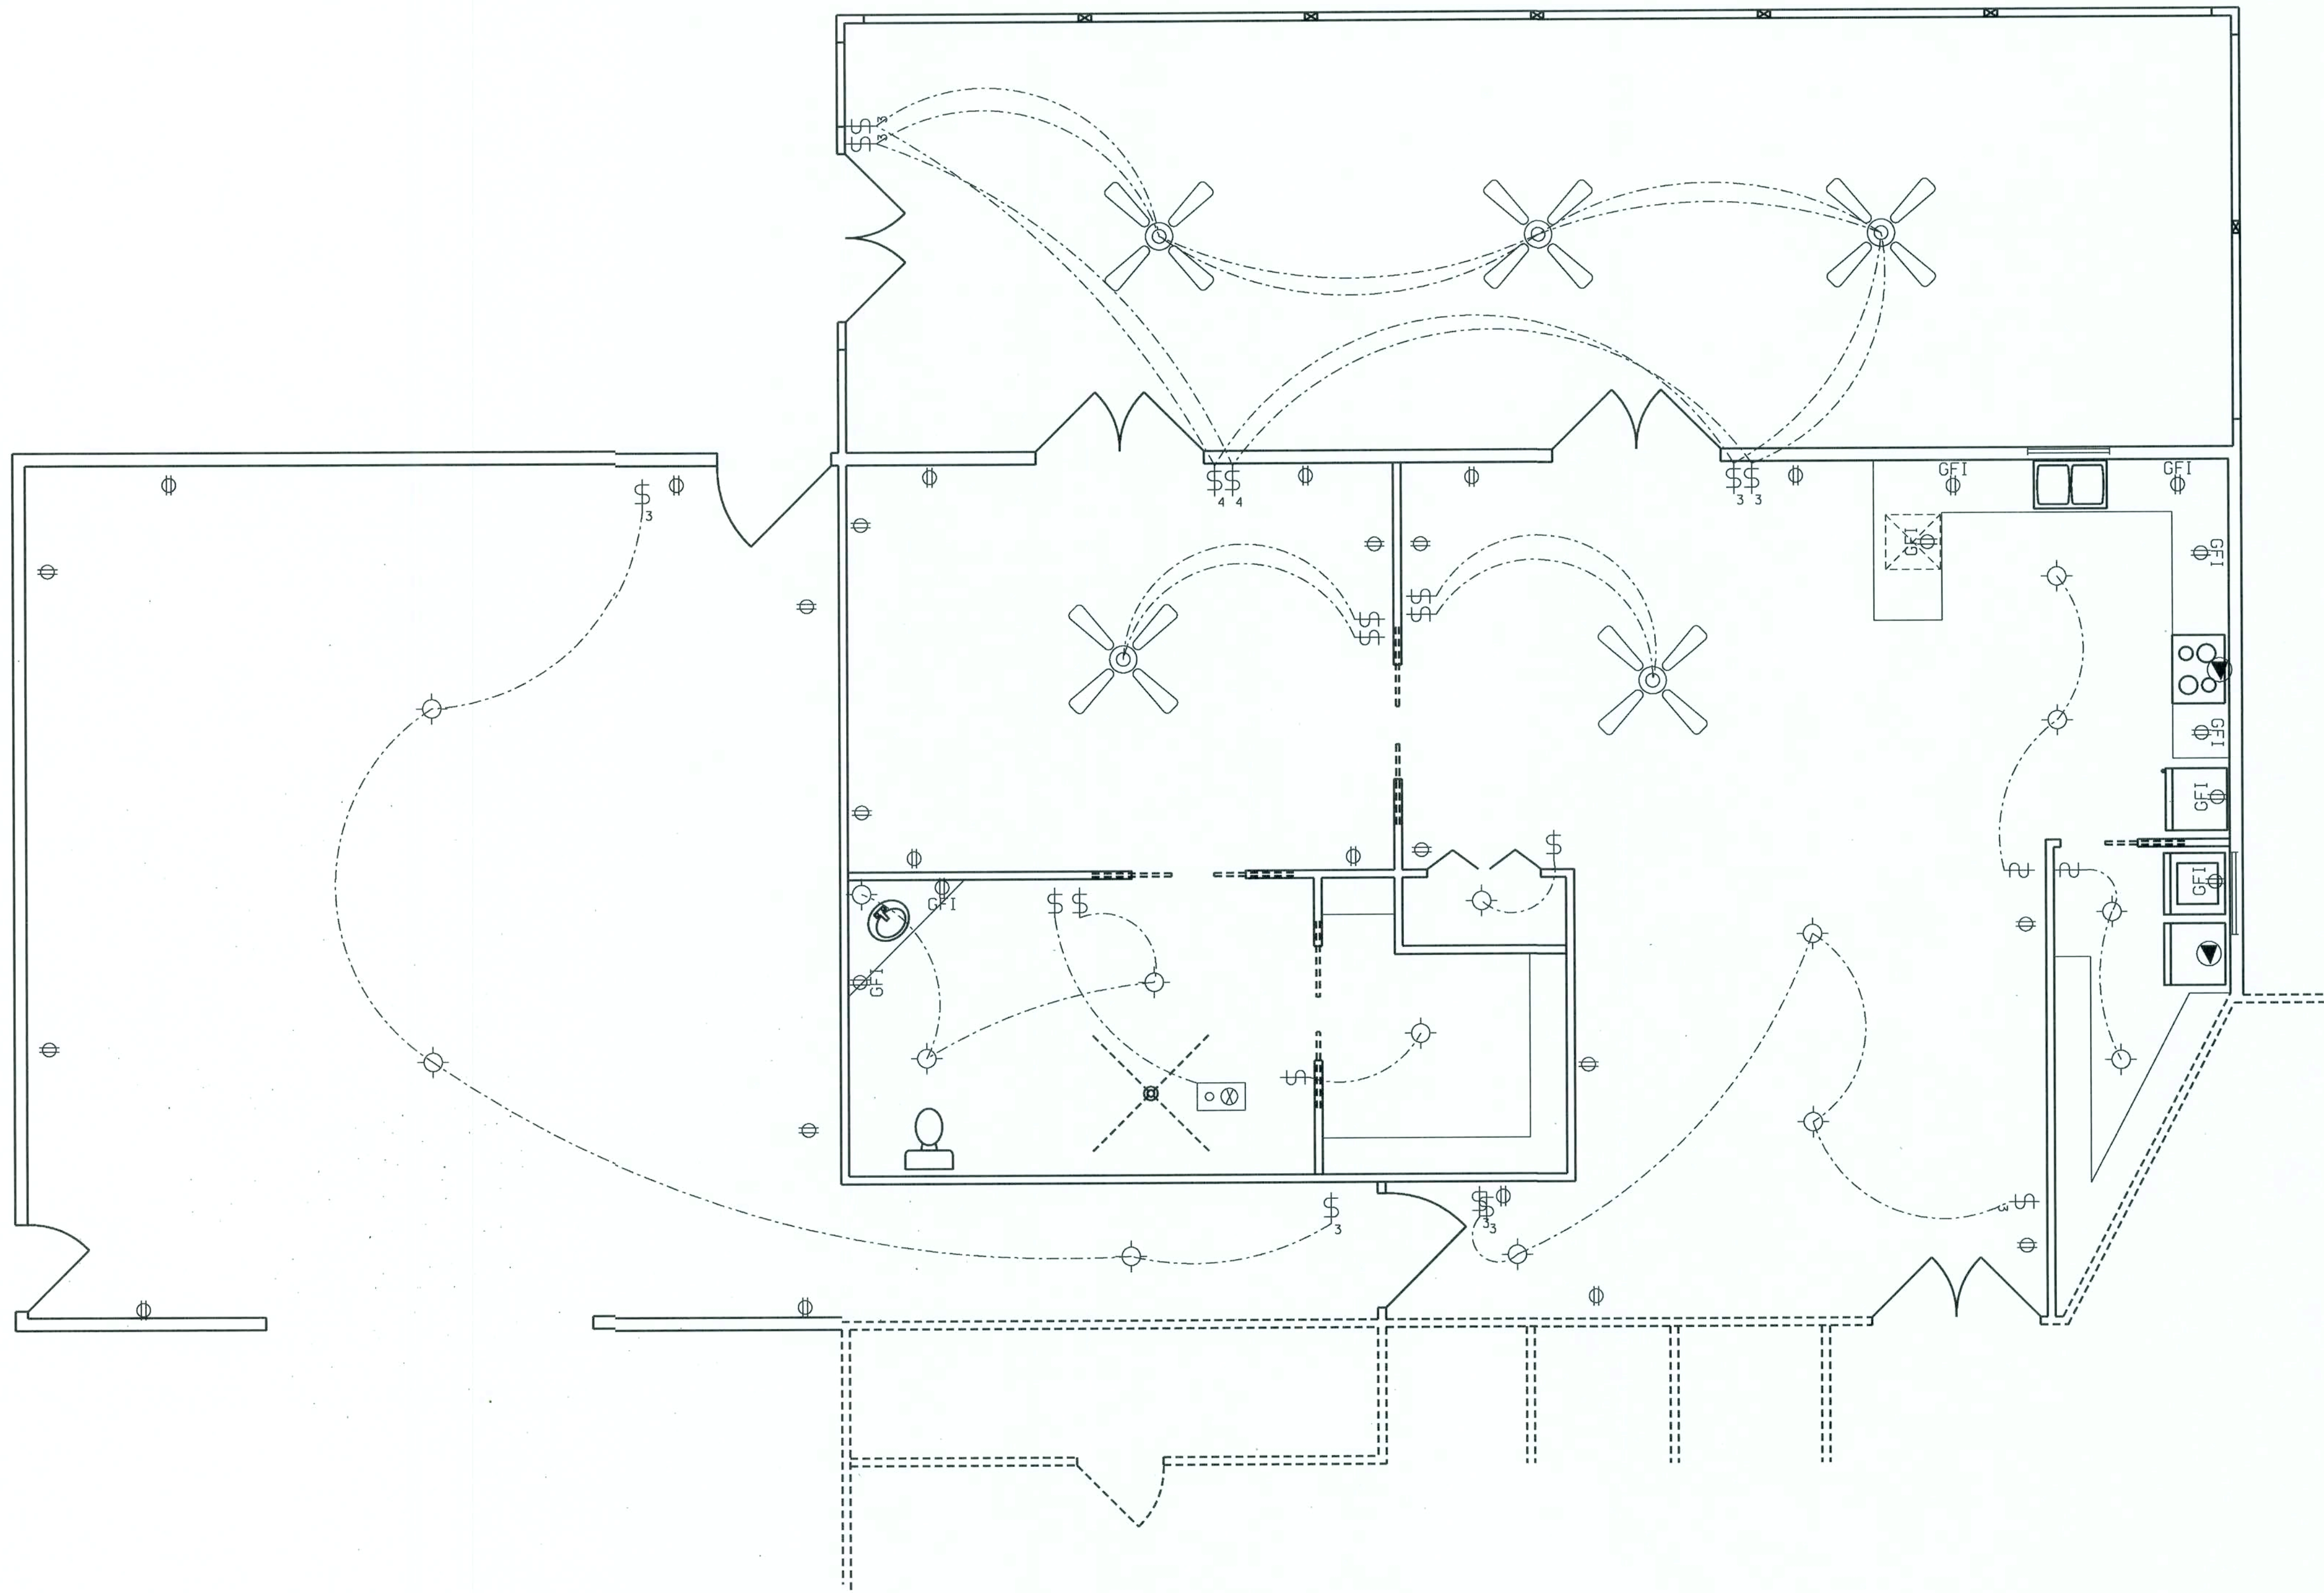

ELECTRICAL PLAN
BOTTOM FLOOR

0 4' 8'
scale

PLANS PREPARED BY:
CHRISTOPHER Q. DICKS
4035 SE CR 252, LAKE CITY, FL 32025

GRANGER RESIDENCE
COLUMBIA COUNTY, FLORIDA

SHEET
8
OF
8