



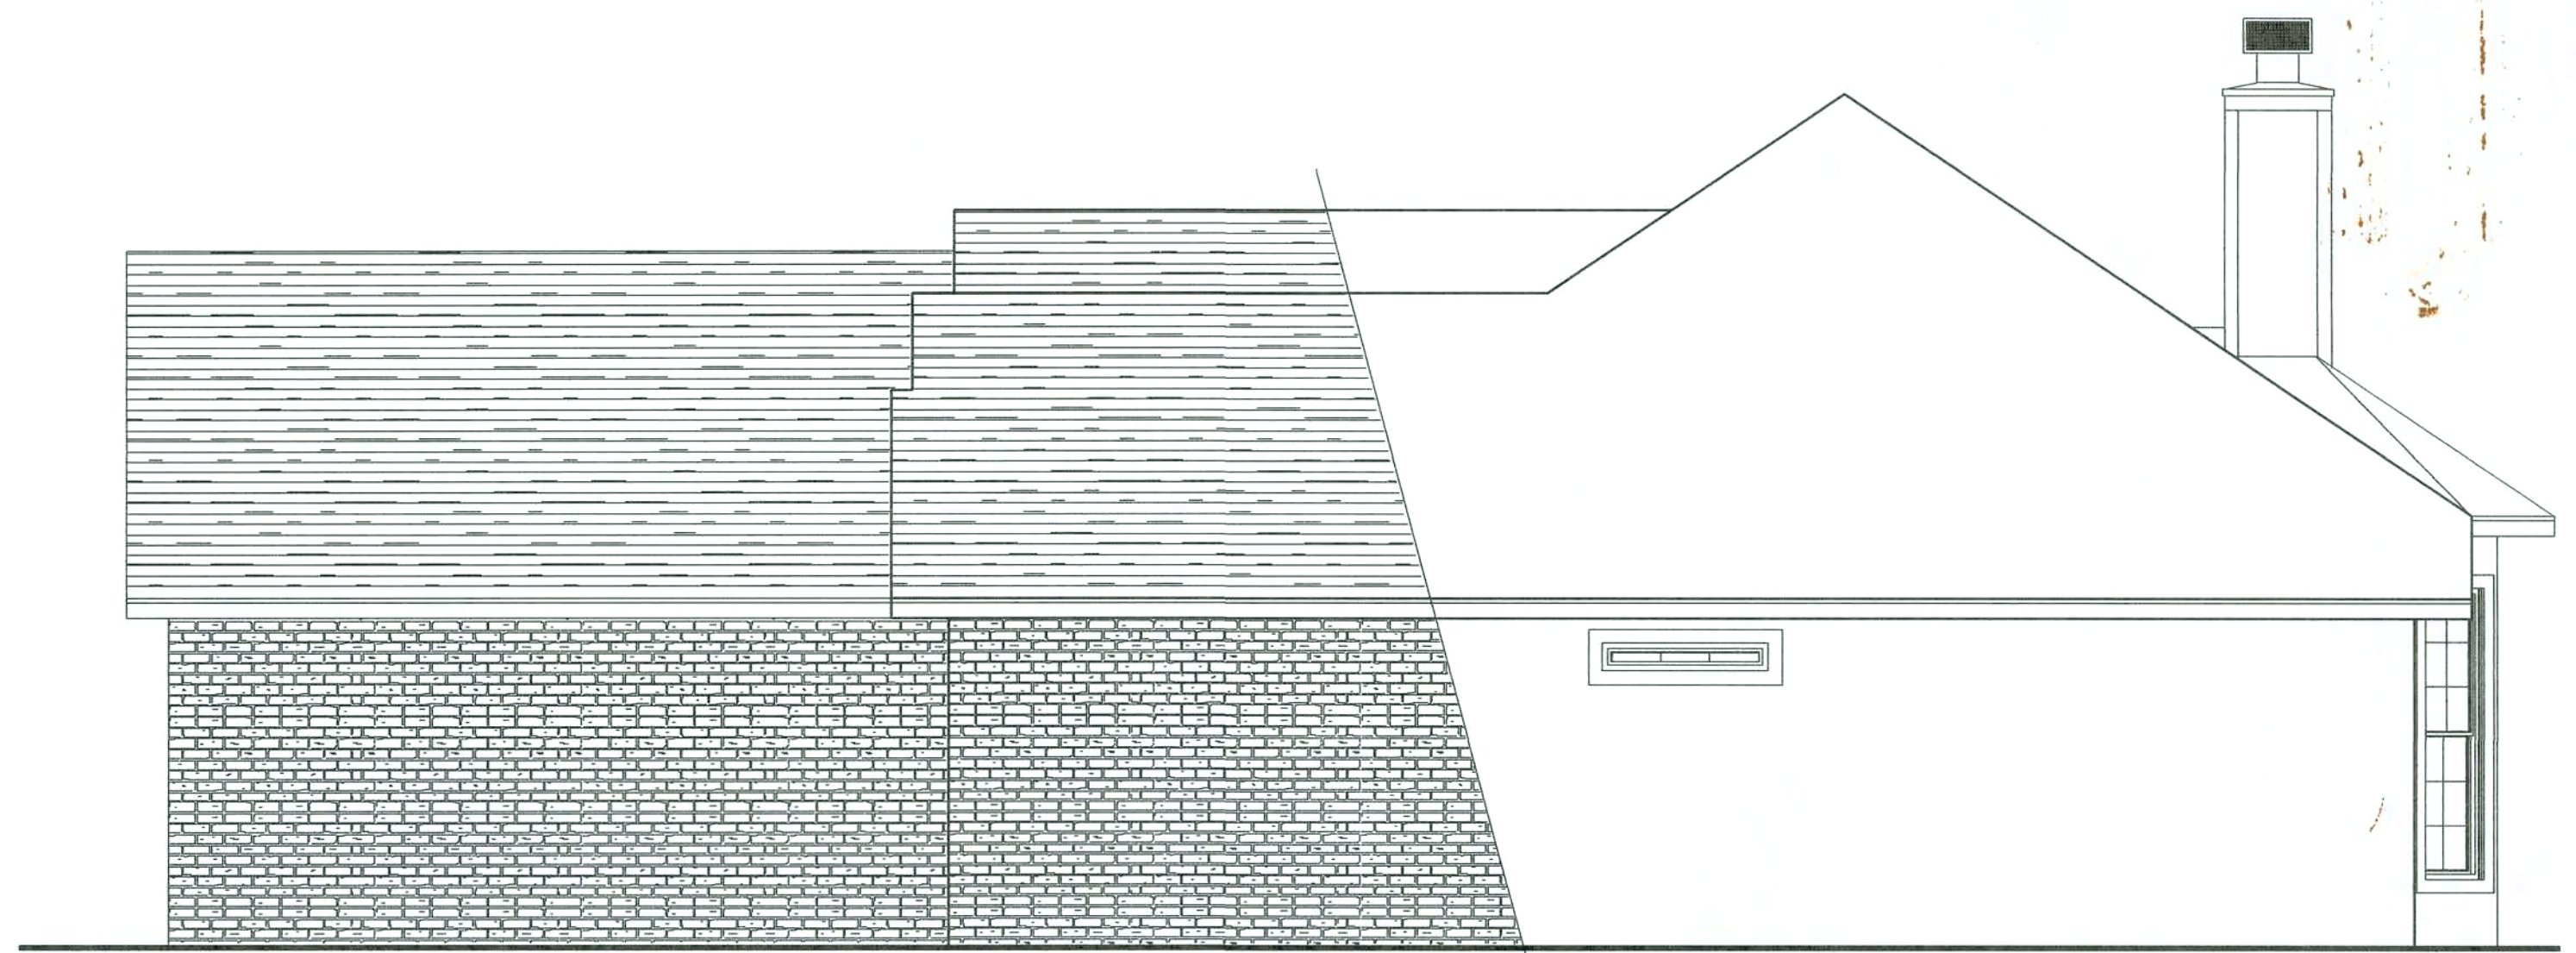


LEFT ELEVATION
SCALE: 1/4" = 1'-0"




RIGHT ELEVATION
SCALE: 1/4" = 1'-0"

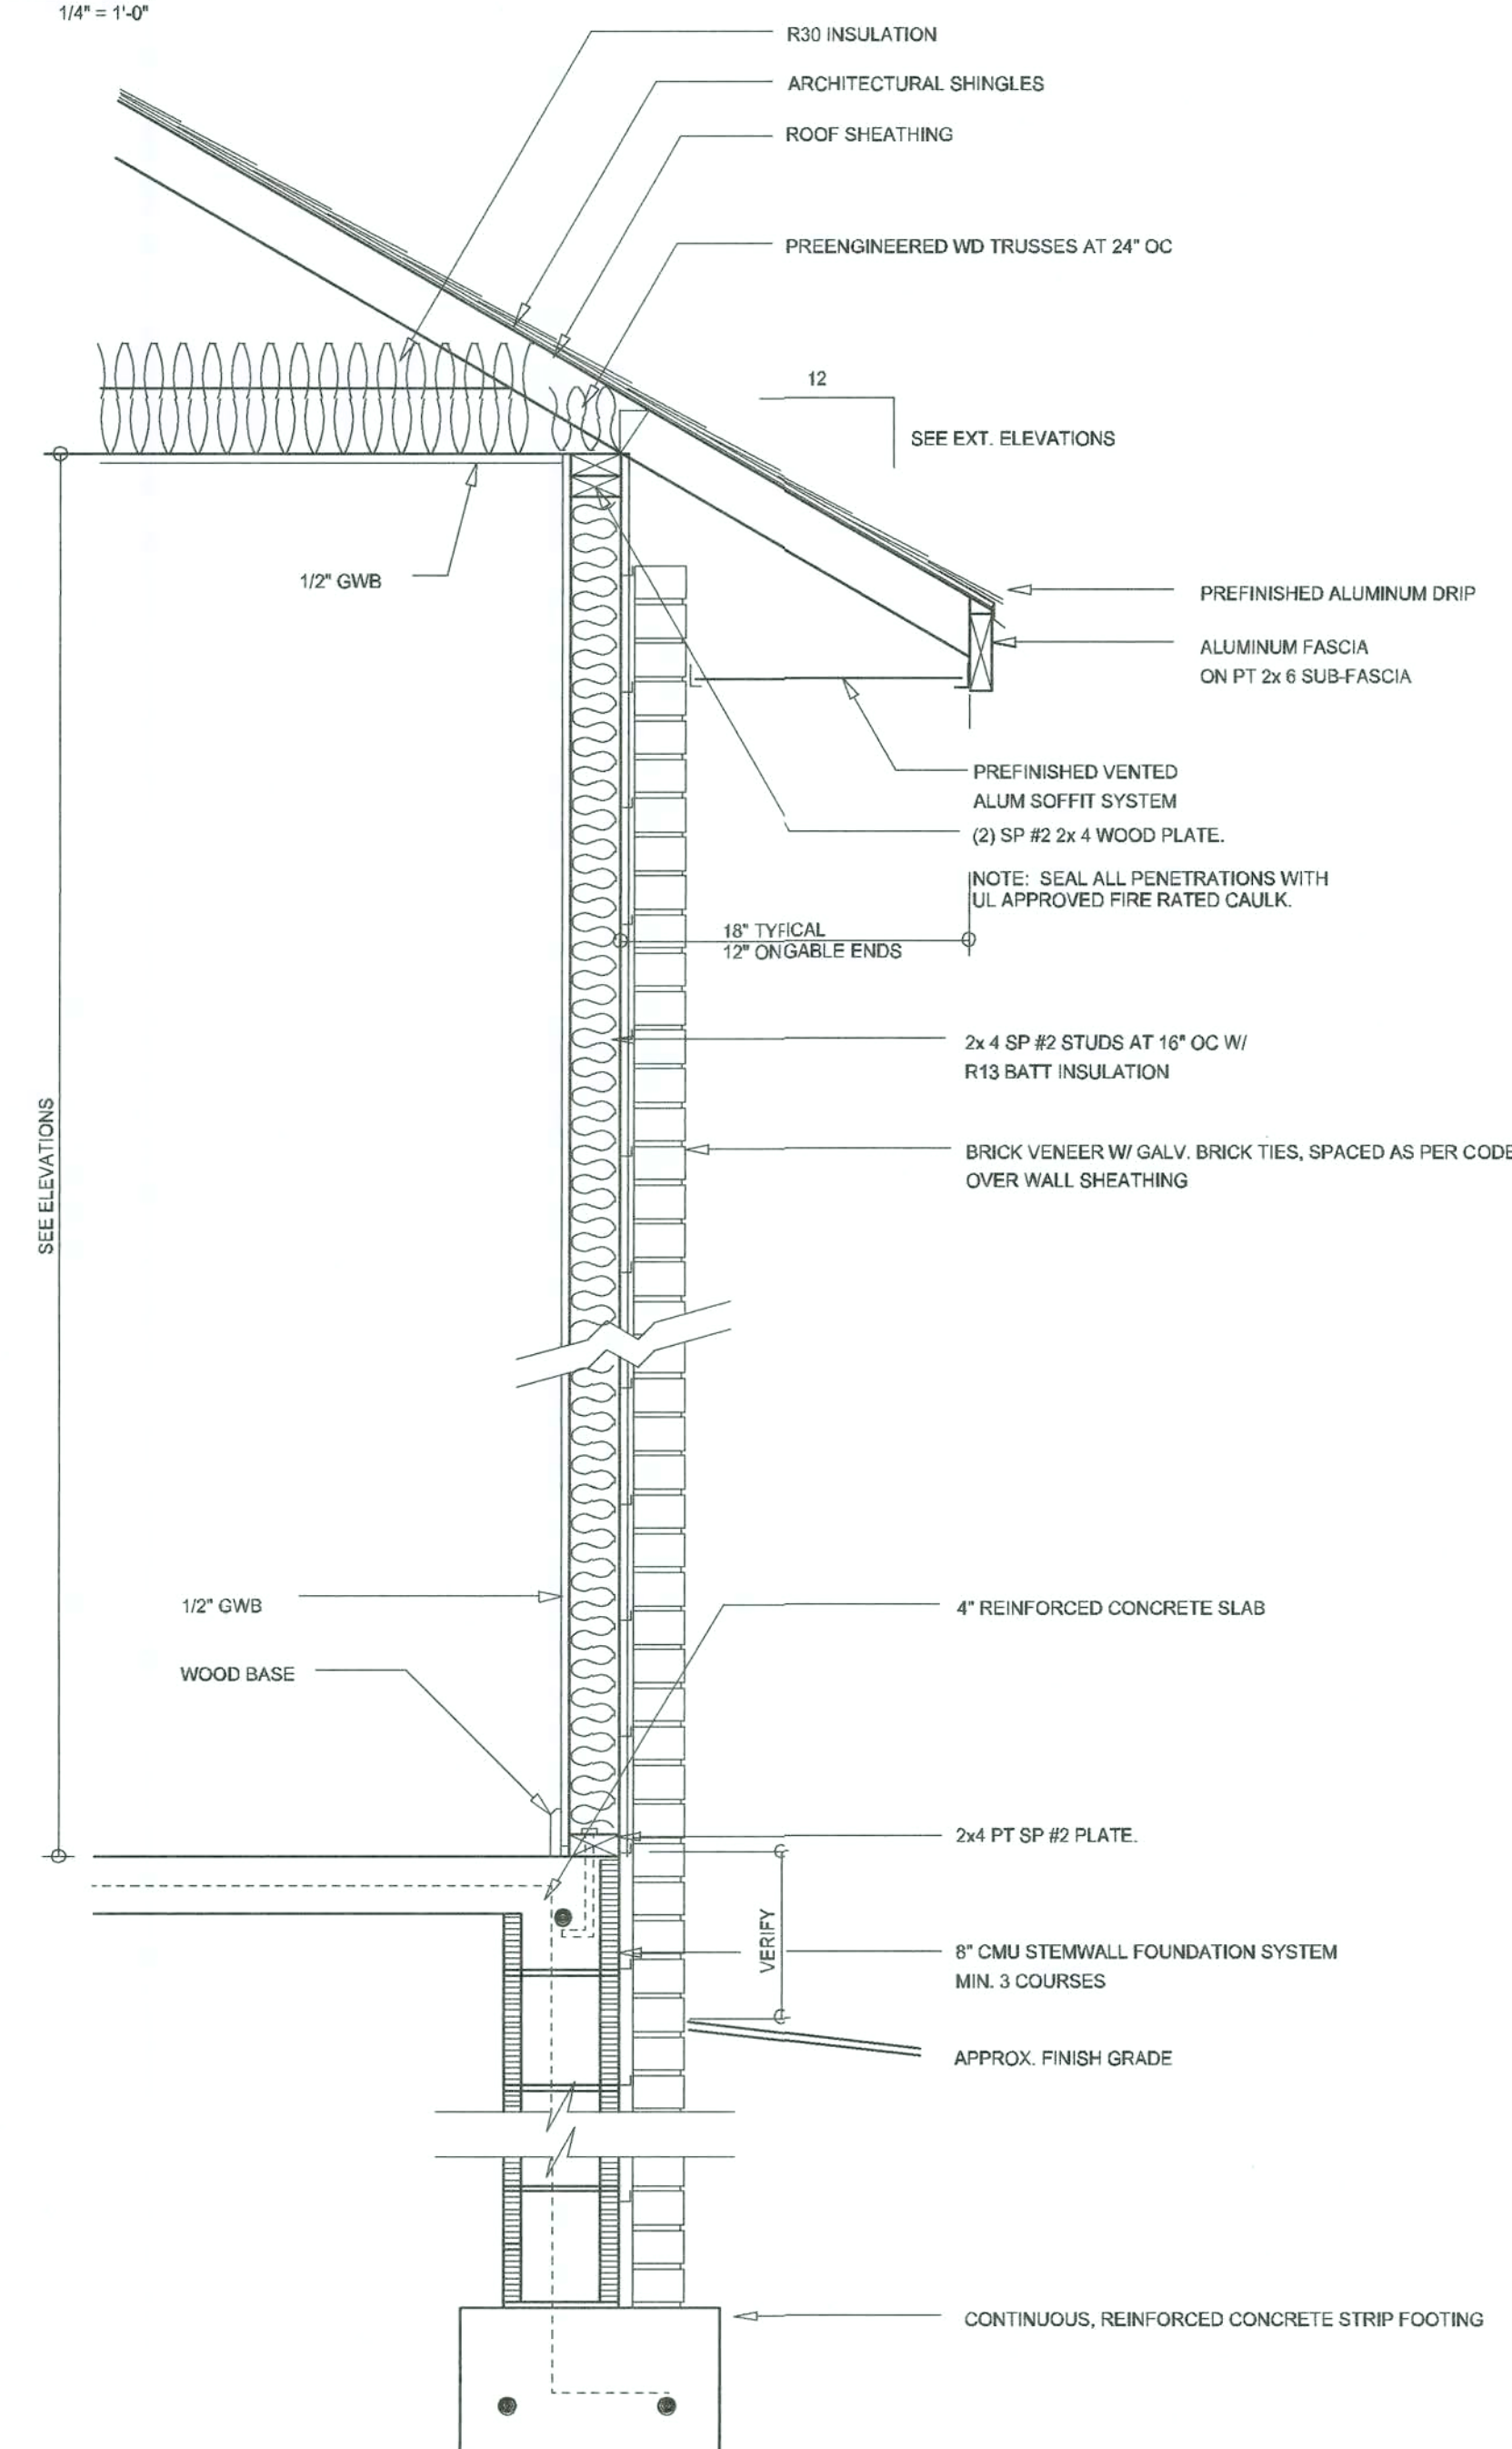

TYPICAL WALL SECTION
SCALE: 1" = 1'-0"

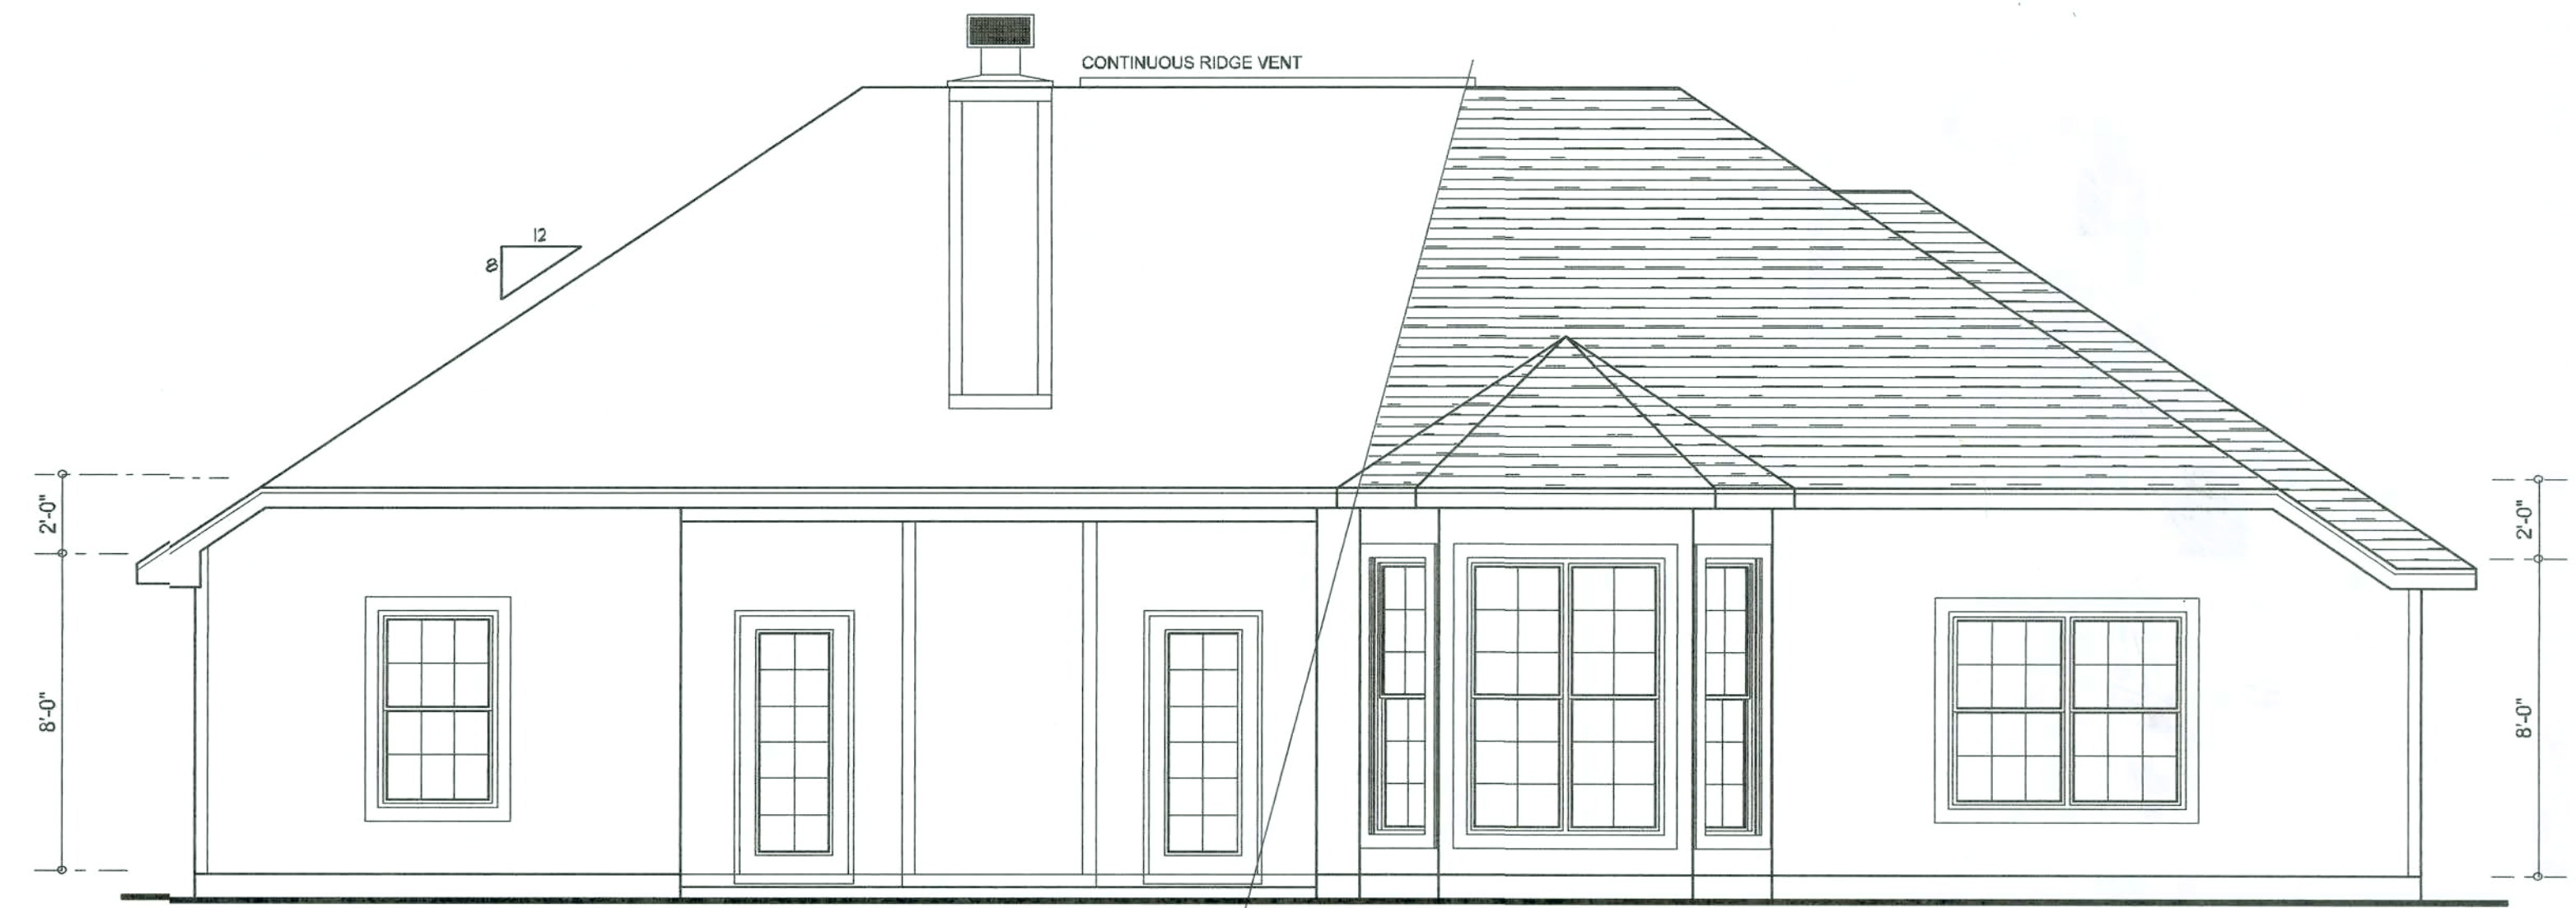

REAR ELEVATION
SCALE: 1/4" = 1'-0"

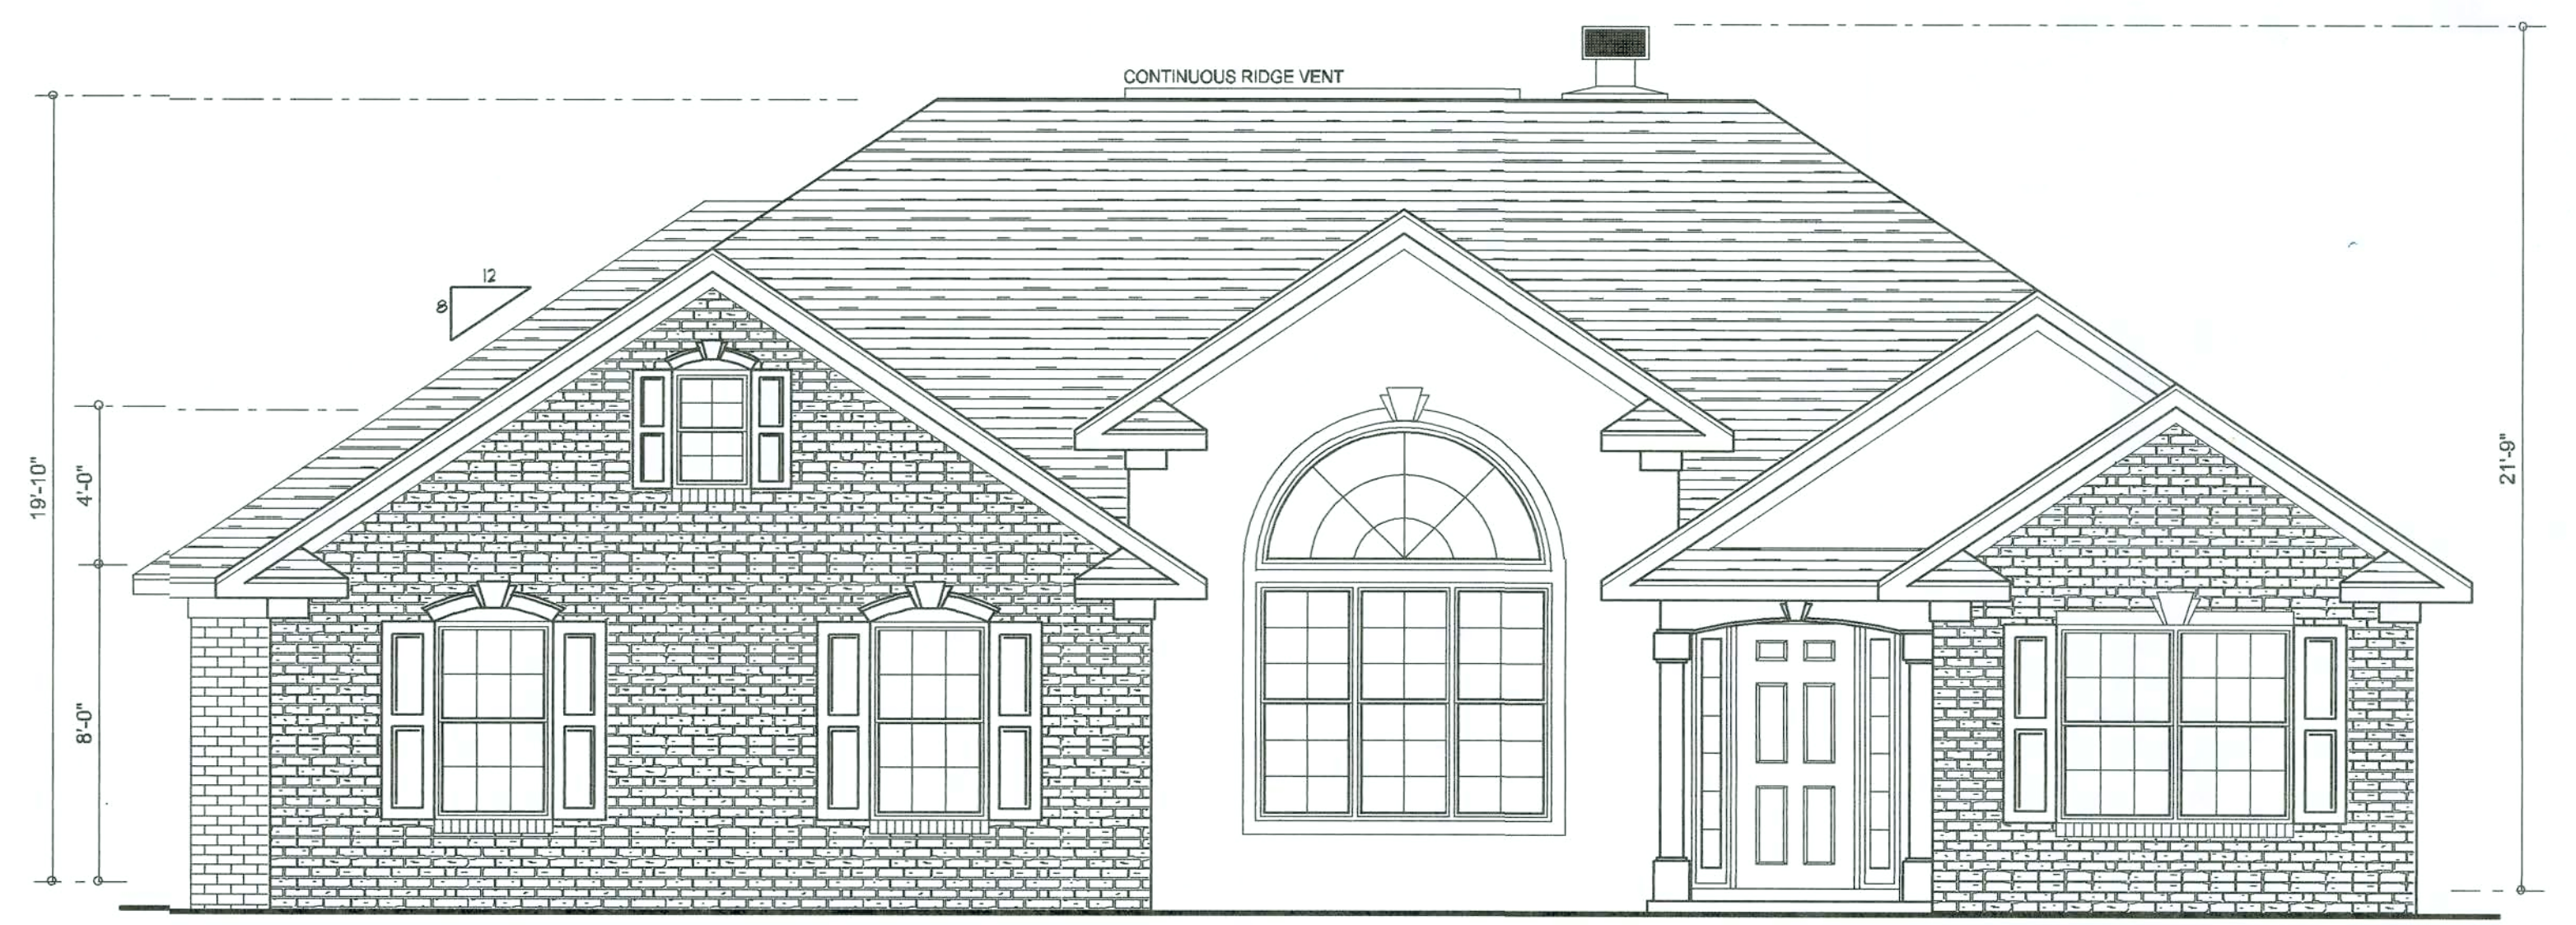

FRONT ELEVATION
SCALE: 1/4" = 1'-0"


REVISIONS
January 27, 2004

EXTERIOR ELEVATIONS
SCALE: 1/4" = 1'-0"

TYPICAL WALL SECTION
SCALE: 1" = 1'-0"

A CUSTOM RESIDENCE FOR:
SEAN & KRISTI SKOWRON
PROJECT ADDRESS: SMITH LANE, COLUMBIA COUNTY, FLORIDA

©WILLIAM MYERS
DESIGN
P.O. BOX 1513
LAKE CITY, FL 32866
(386) 867-1394
lmyers@bellsouth.net

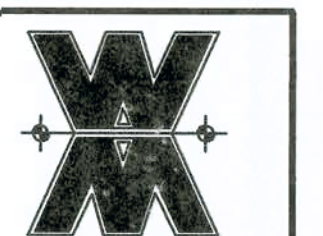


JOB NUMBER
040110

SHEET NUMBER
A1
OF 4 SHEETS

21432

Wm Myers

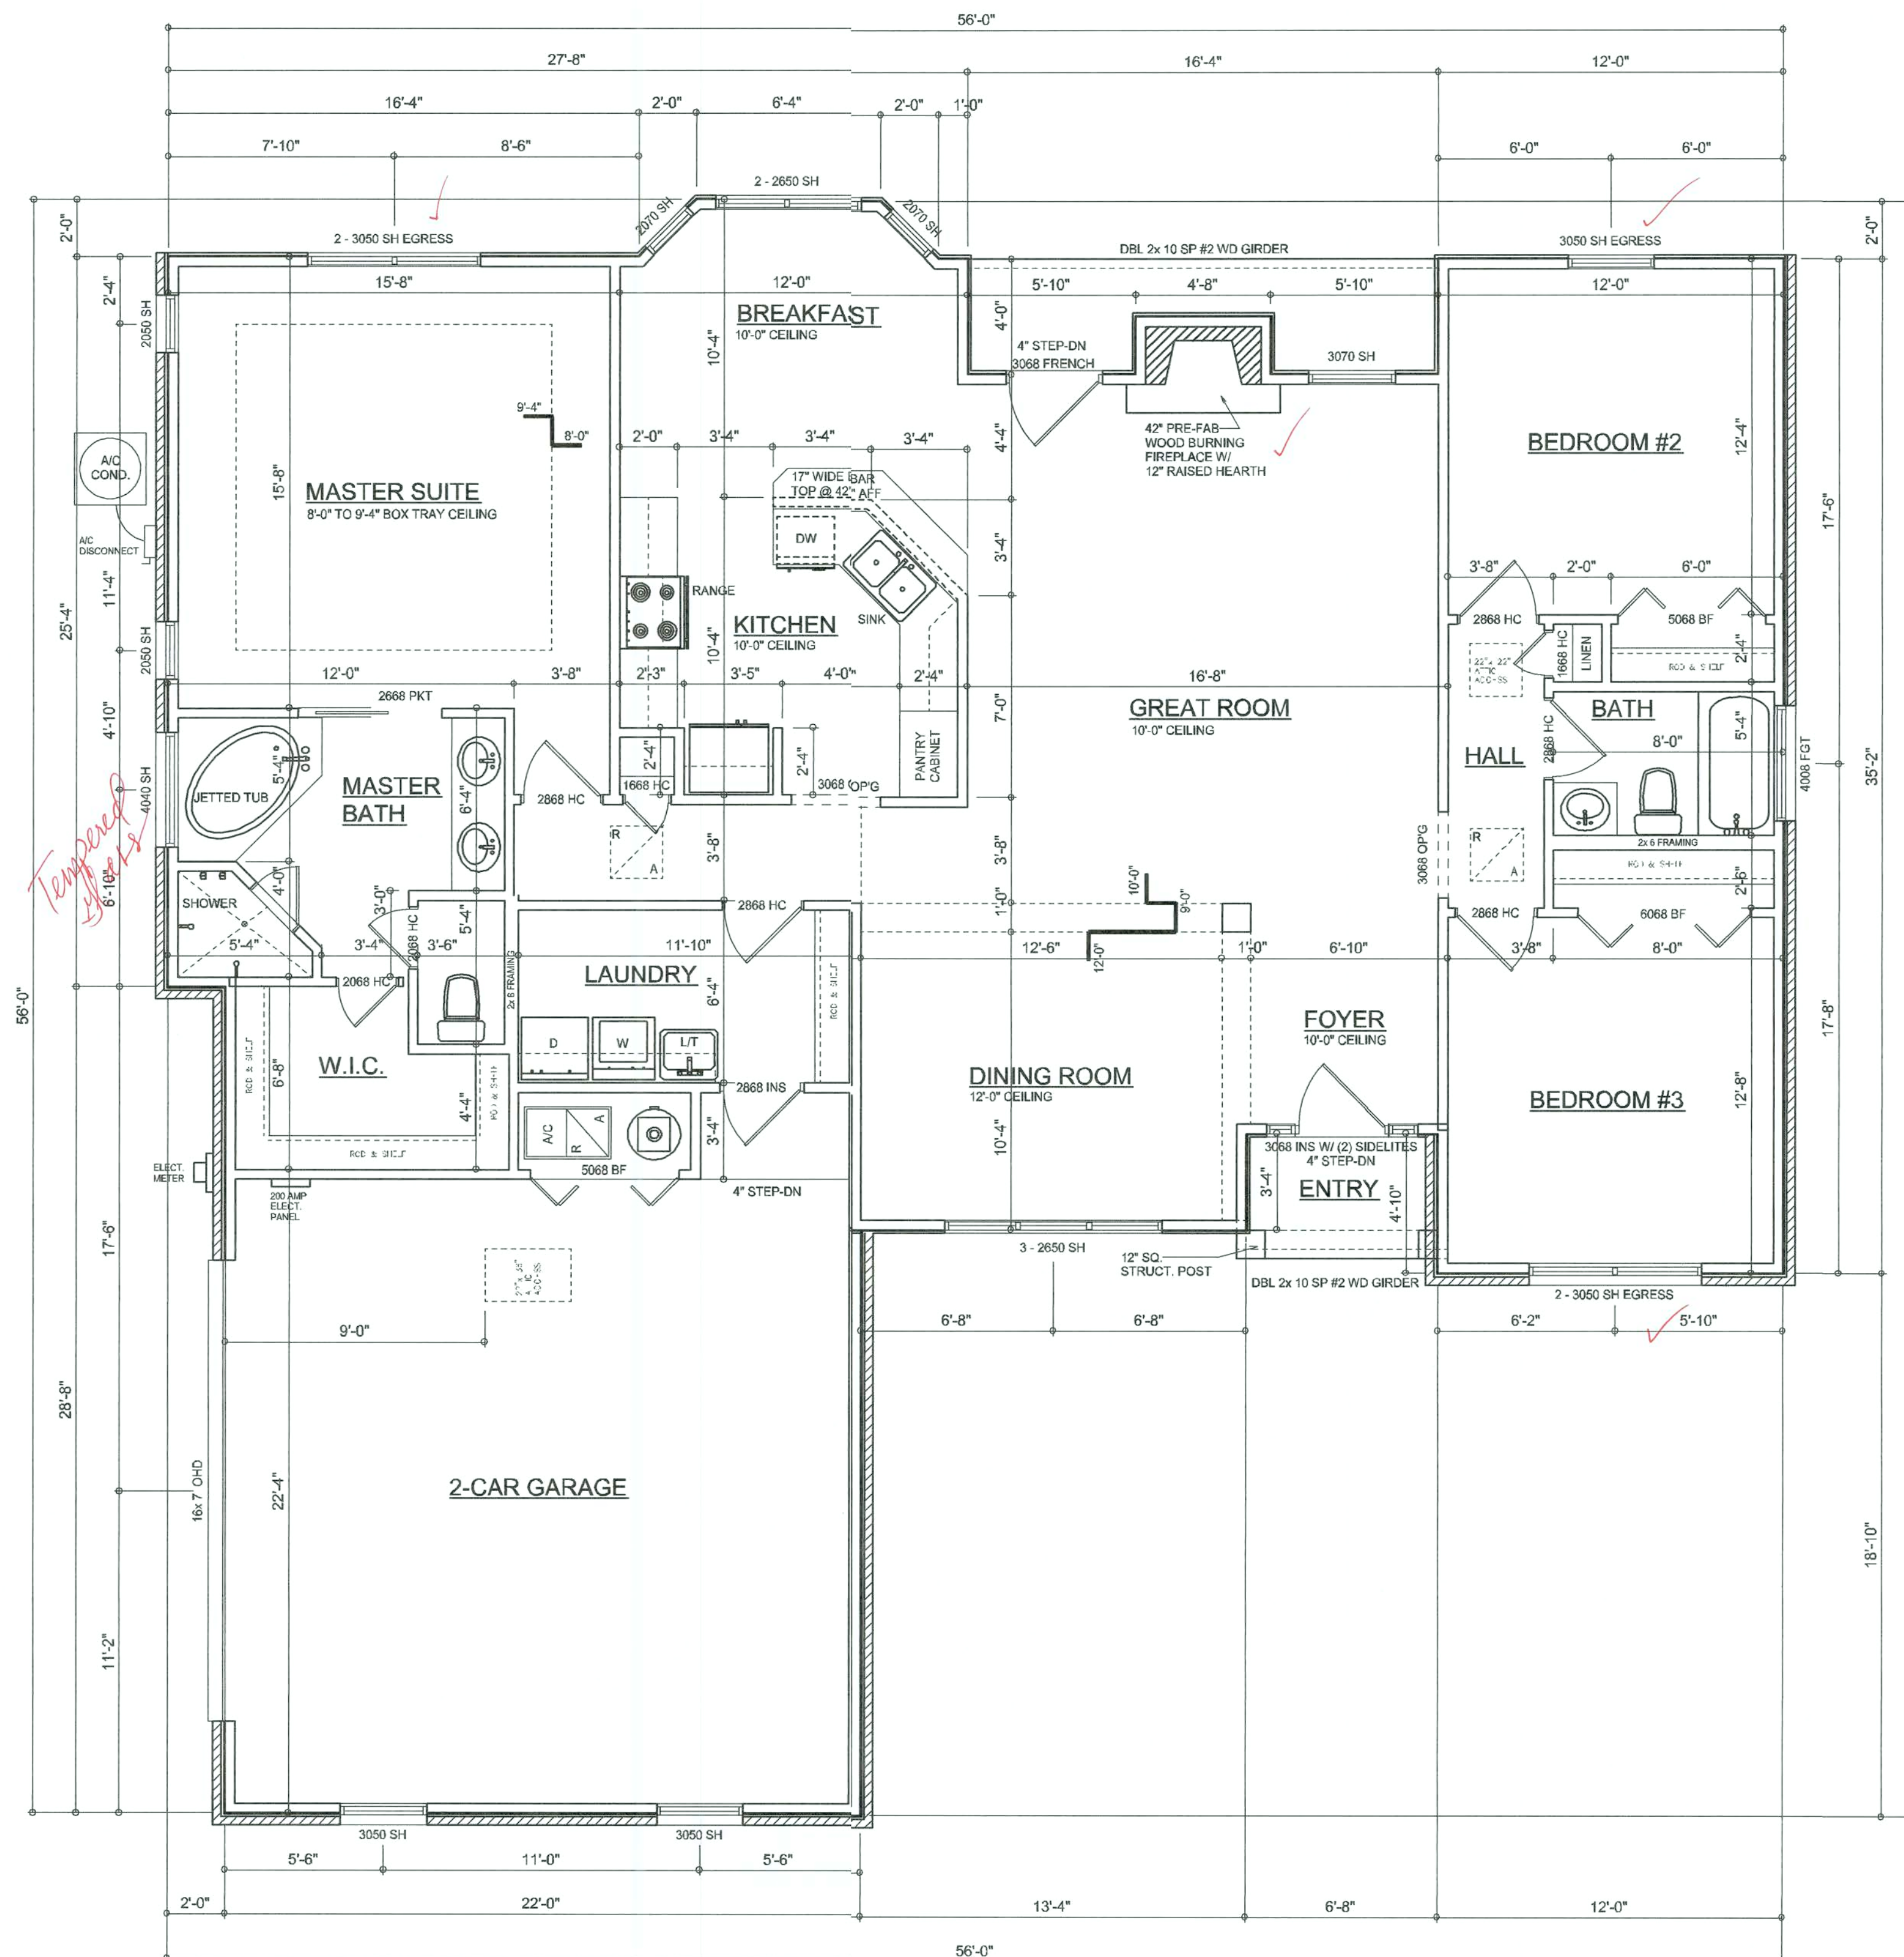

FLOOR PLAN

SCALE: 1/4" = 1'-0"
NOTE: ALL CEILING HEIGHTS SHALL BE 8'-0" UNLESS OTHERWISE NOTED

AREA SUMMARY


LIVING AREA	1726	✓	S.F.
GARAGE AREA	518	✓	S.F.
COVERED PORCH AREA	66	✓	S.F.
ENTRY PORCH AREA	29	✓	S.F.
TOTAL AREA	2339		S.F.

REVISIONS
January 27, 2004

FLOOR PLAN
SCALE: 1/4" = 1'-0"

A CUSTOM RESIDENCE FOR:
SEAN & KRISTI SKOWRON
PROJECT ADDRESS: SMITH LANE, COLUMBIA COUNTY, FLORIDA


©WILLIAM MYERS
DESIGN
P.O. BOX 1513
LAKE CITY, FL 32056
(386) 867-1394
t@yours@bellsouth.net

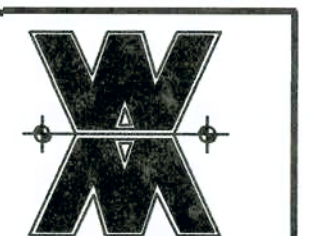


JOB NUMBER
040110

SHEET NUMBER
A3
OF 4 SHEETS

Wm Myers

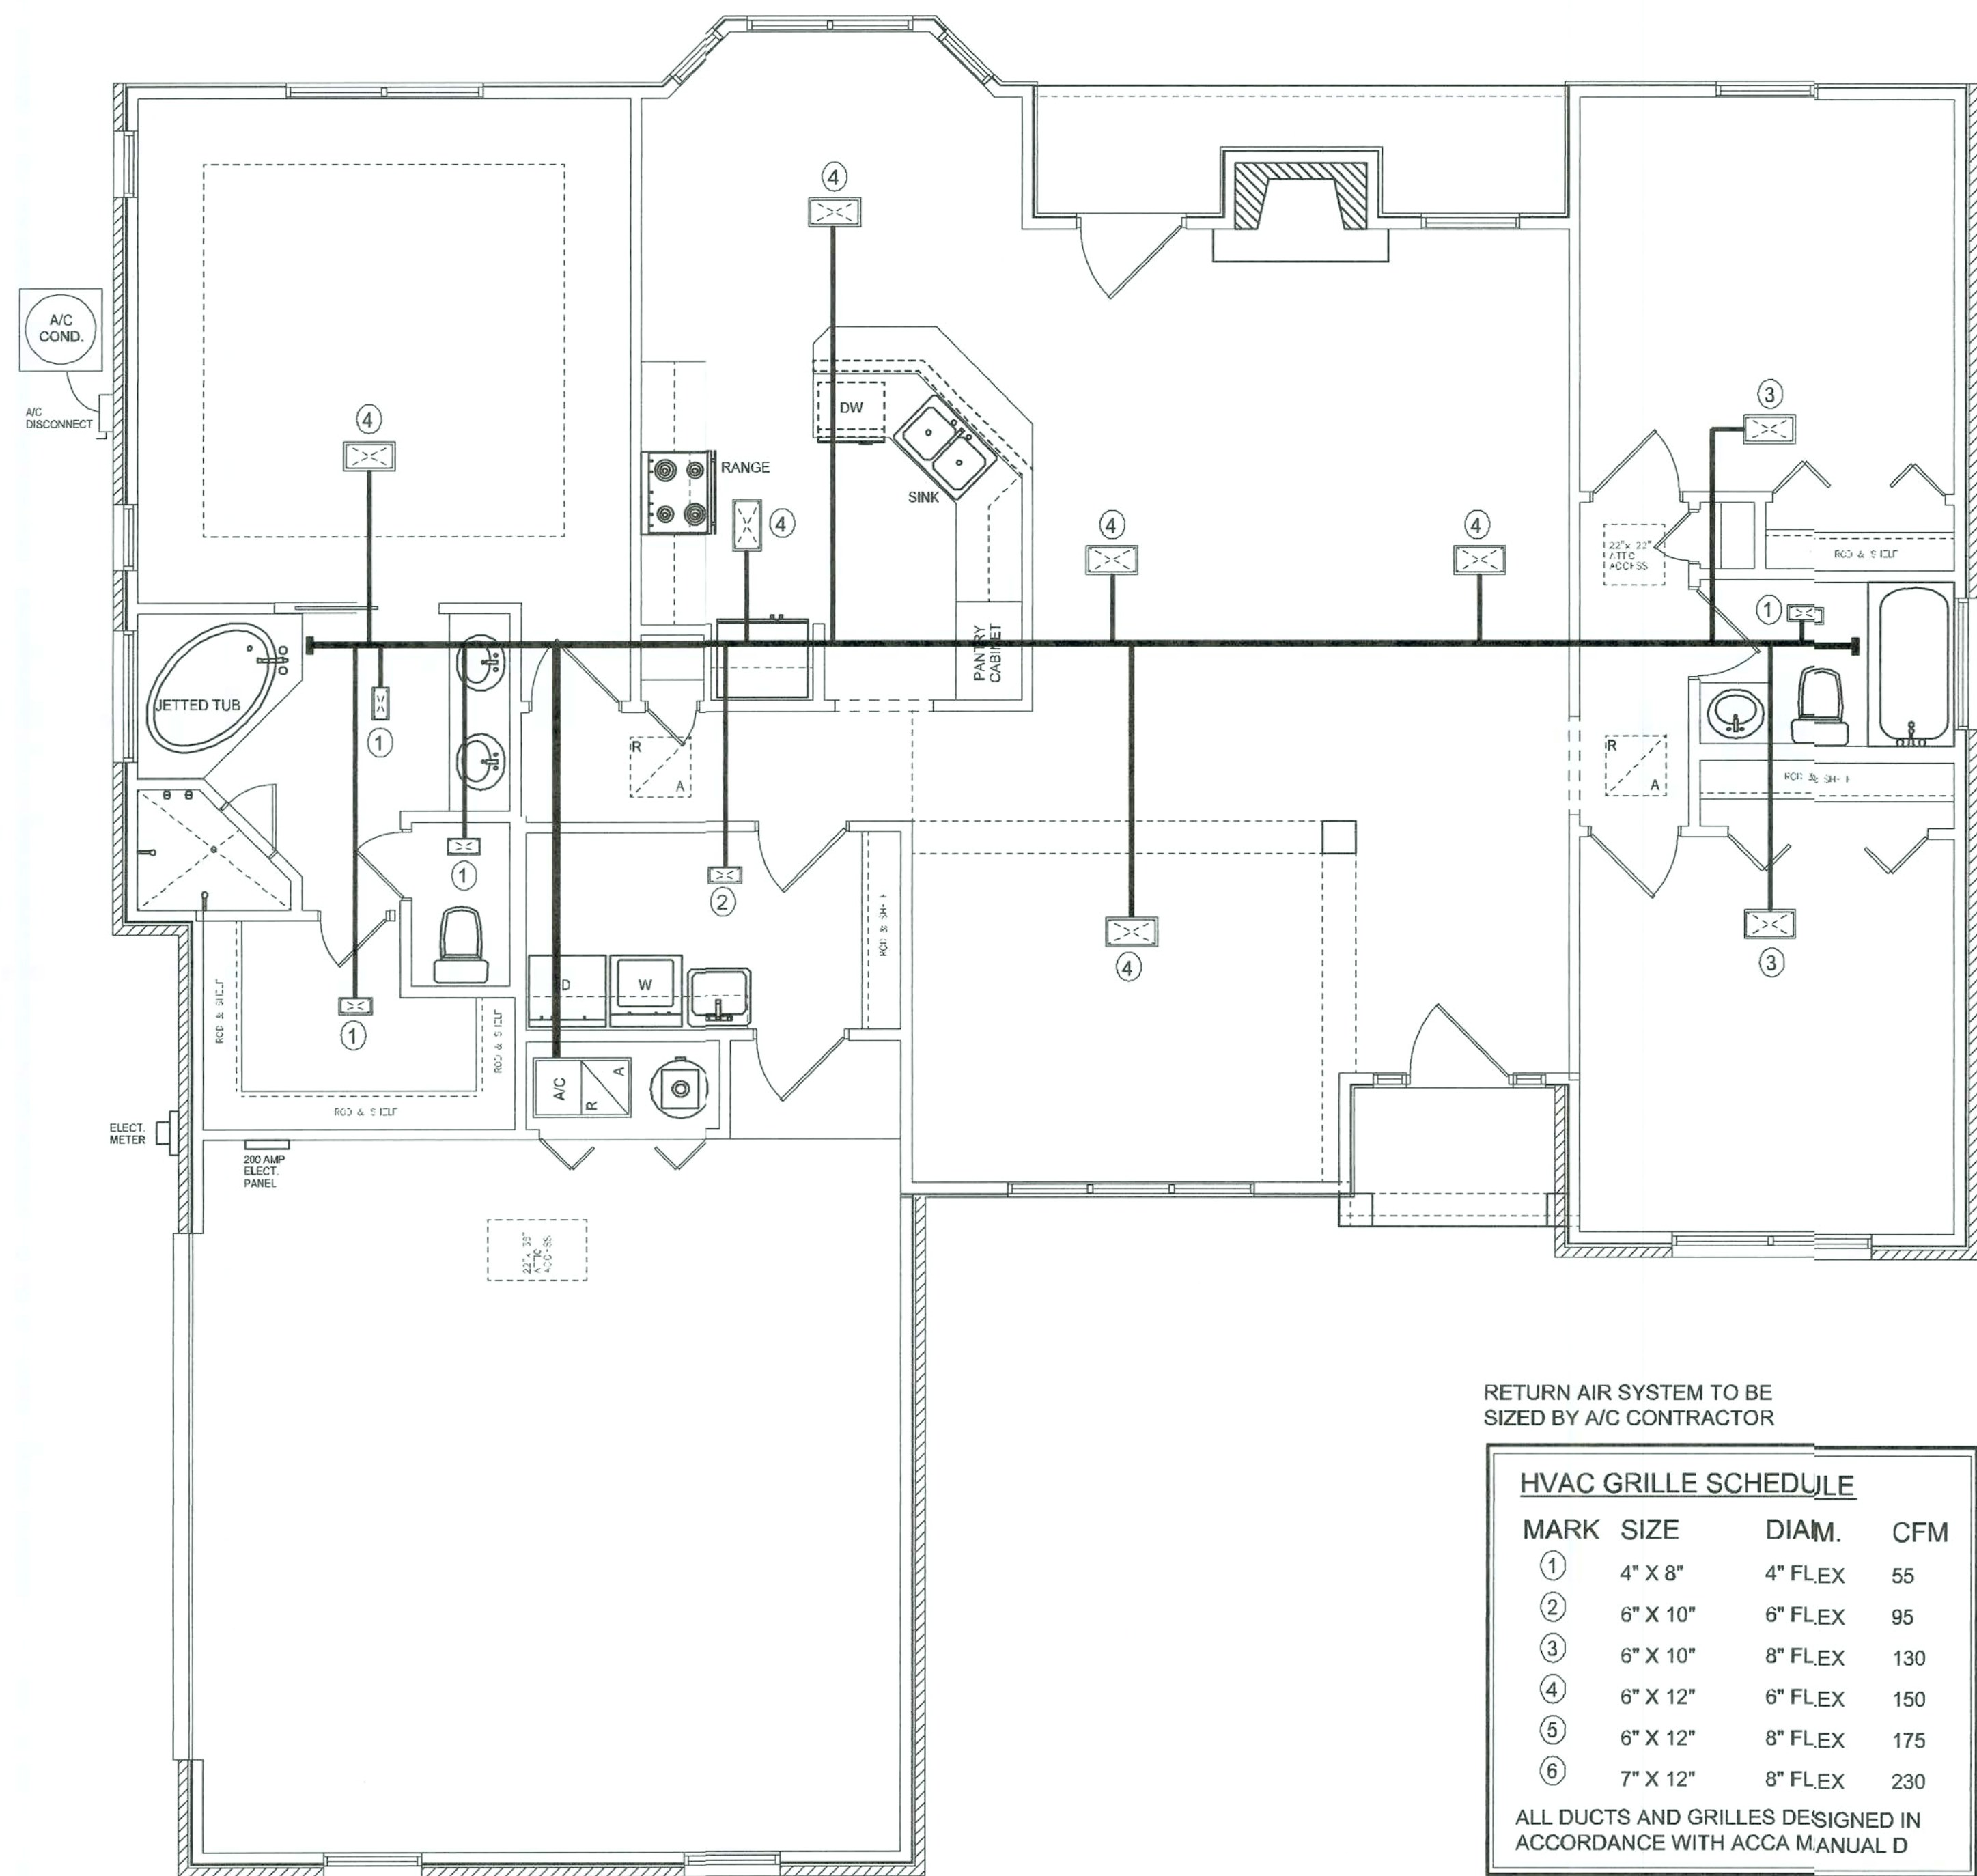

HVAC PLAN
SCALE: 1/4" = 1'-0"

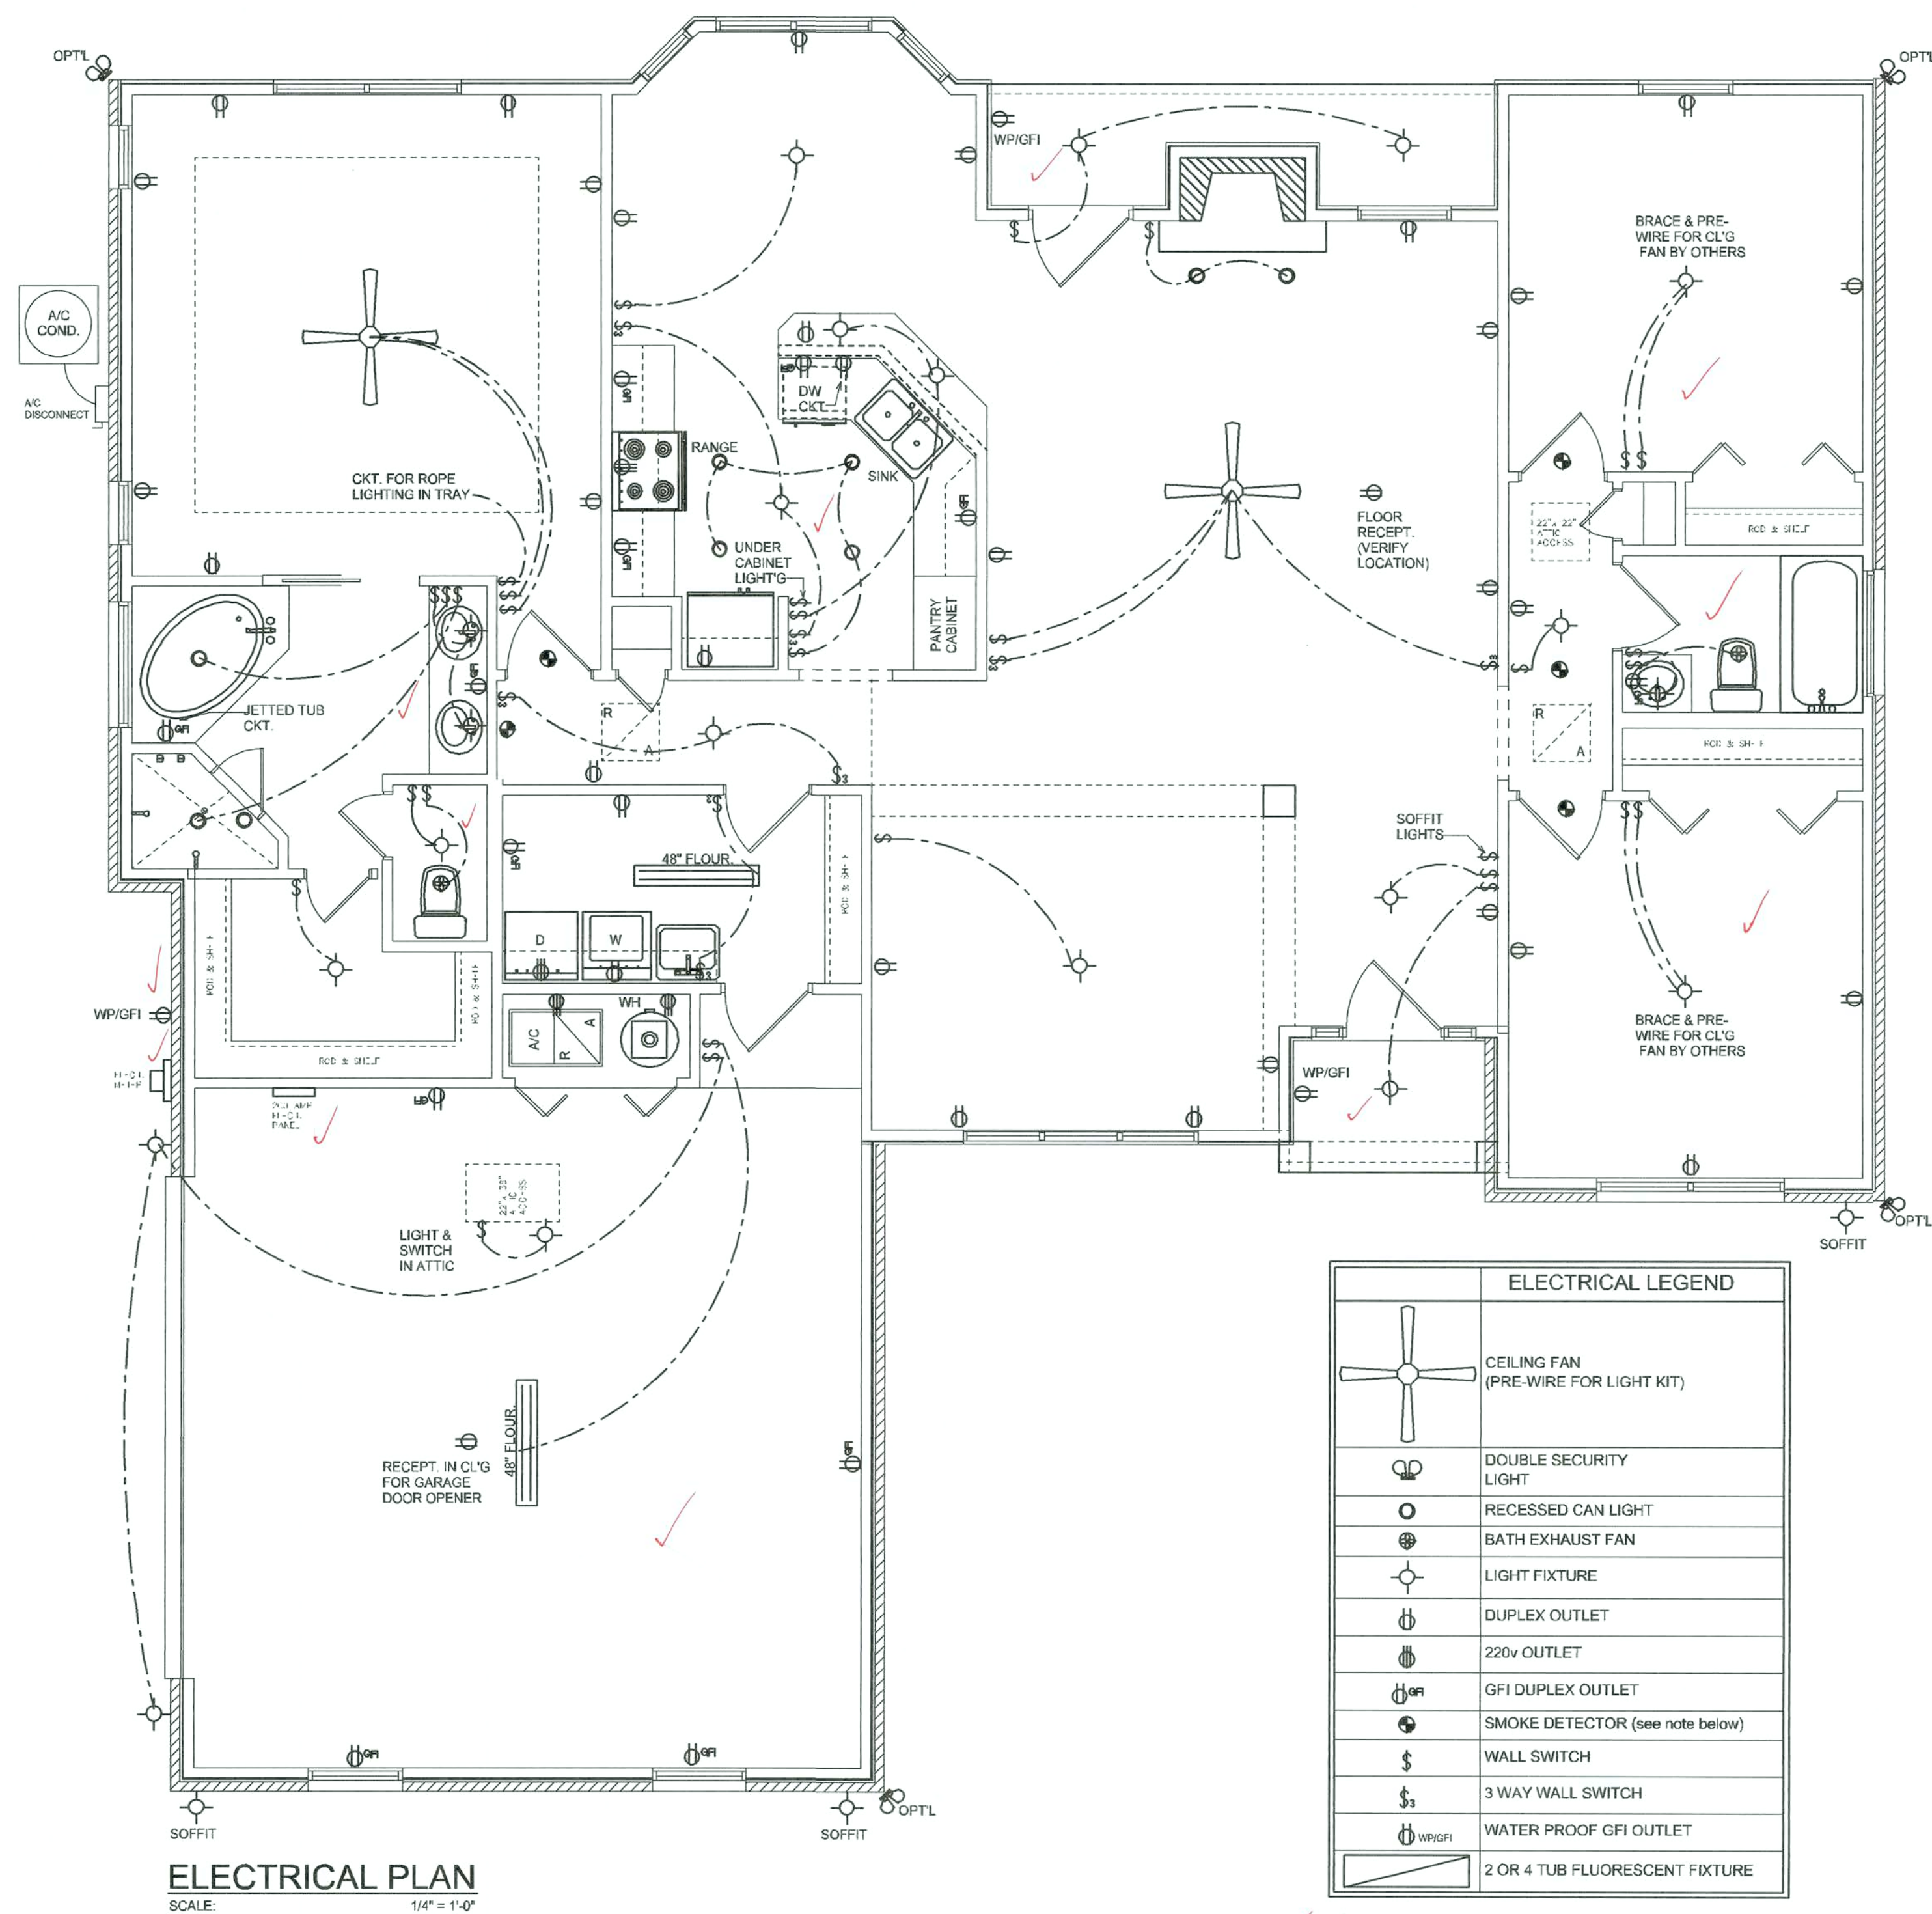

ELECTRICAL LEGEND	
	CEILING FAN (PRE-WIRE FOR LIGHT KIT)
	DOUBLE SECURITY LIGHT
	RECESSED CAN LIGHT
	BATH EXHAUST FAN
	LIGHT FIXTURE
	DUPLEX OUTLET
	220v OUTLET
	GFI DUPLEX OUTLET
	SMOKE DETECTOR (see notes below)
	WALL SWITCH
	3 WAY WALL SWITCH
	WATER PROOF GFI OUTLET
	2 OR 4 TUB FLUORESCENT FIXTURE

NOTE:
ALL BEDROOM RECEPTACLES SHALL BE AFCI (ARC FAULT CIRCUIT INTERRUPT)
ALL SMOKE DETECTORS SHALL HAVE BATTERY BACKUP POWER AND ALL WIRED TOGETHER SO IF ANY ONE UNIT IS ACTUATED THEY ALL ACTIVATE.

REVISIONS
January 27, 2004

ELECTRICAL PLAN
SCALE: 1/4" = 1'-0"
HVAC PLAN
SCALE: 1/4" = 1'-0"

A CUSTOM RESIDENCE FOR:
SEAN & KRISTI SKOWRON
PROJECT ADDRESS: SMITH LANE, COLUMBIA COUNTY, FLORIDA

©WILLIAM MYERS DESIGN
P.O. BOX 1513
LAKE CITY, FL 33056
(386) 867-1394
tmyers@bellsouth.net



JOB NUMBER
040110

SHEET NUMBER
A4
OF 4 SHEETS

Wm Myers

