



REVISIONS	

SOFTPLAN
ARCHITECTURAL DESIGN SOFTWARE

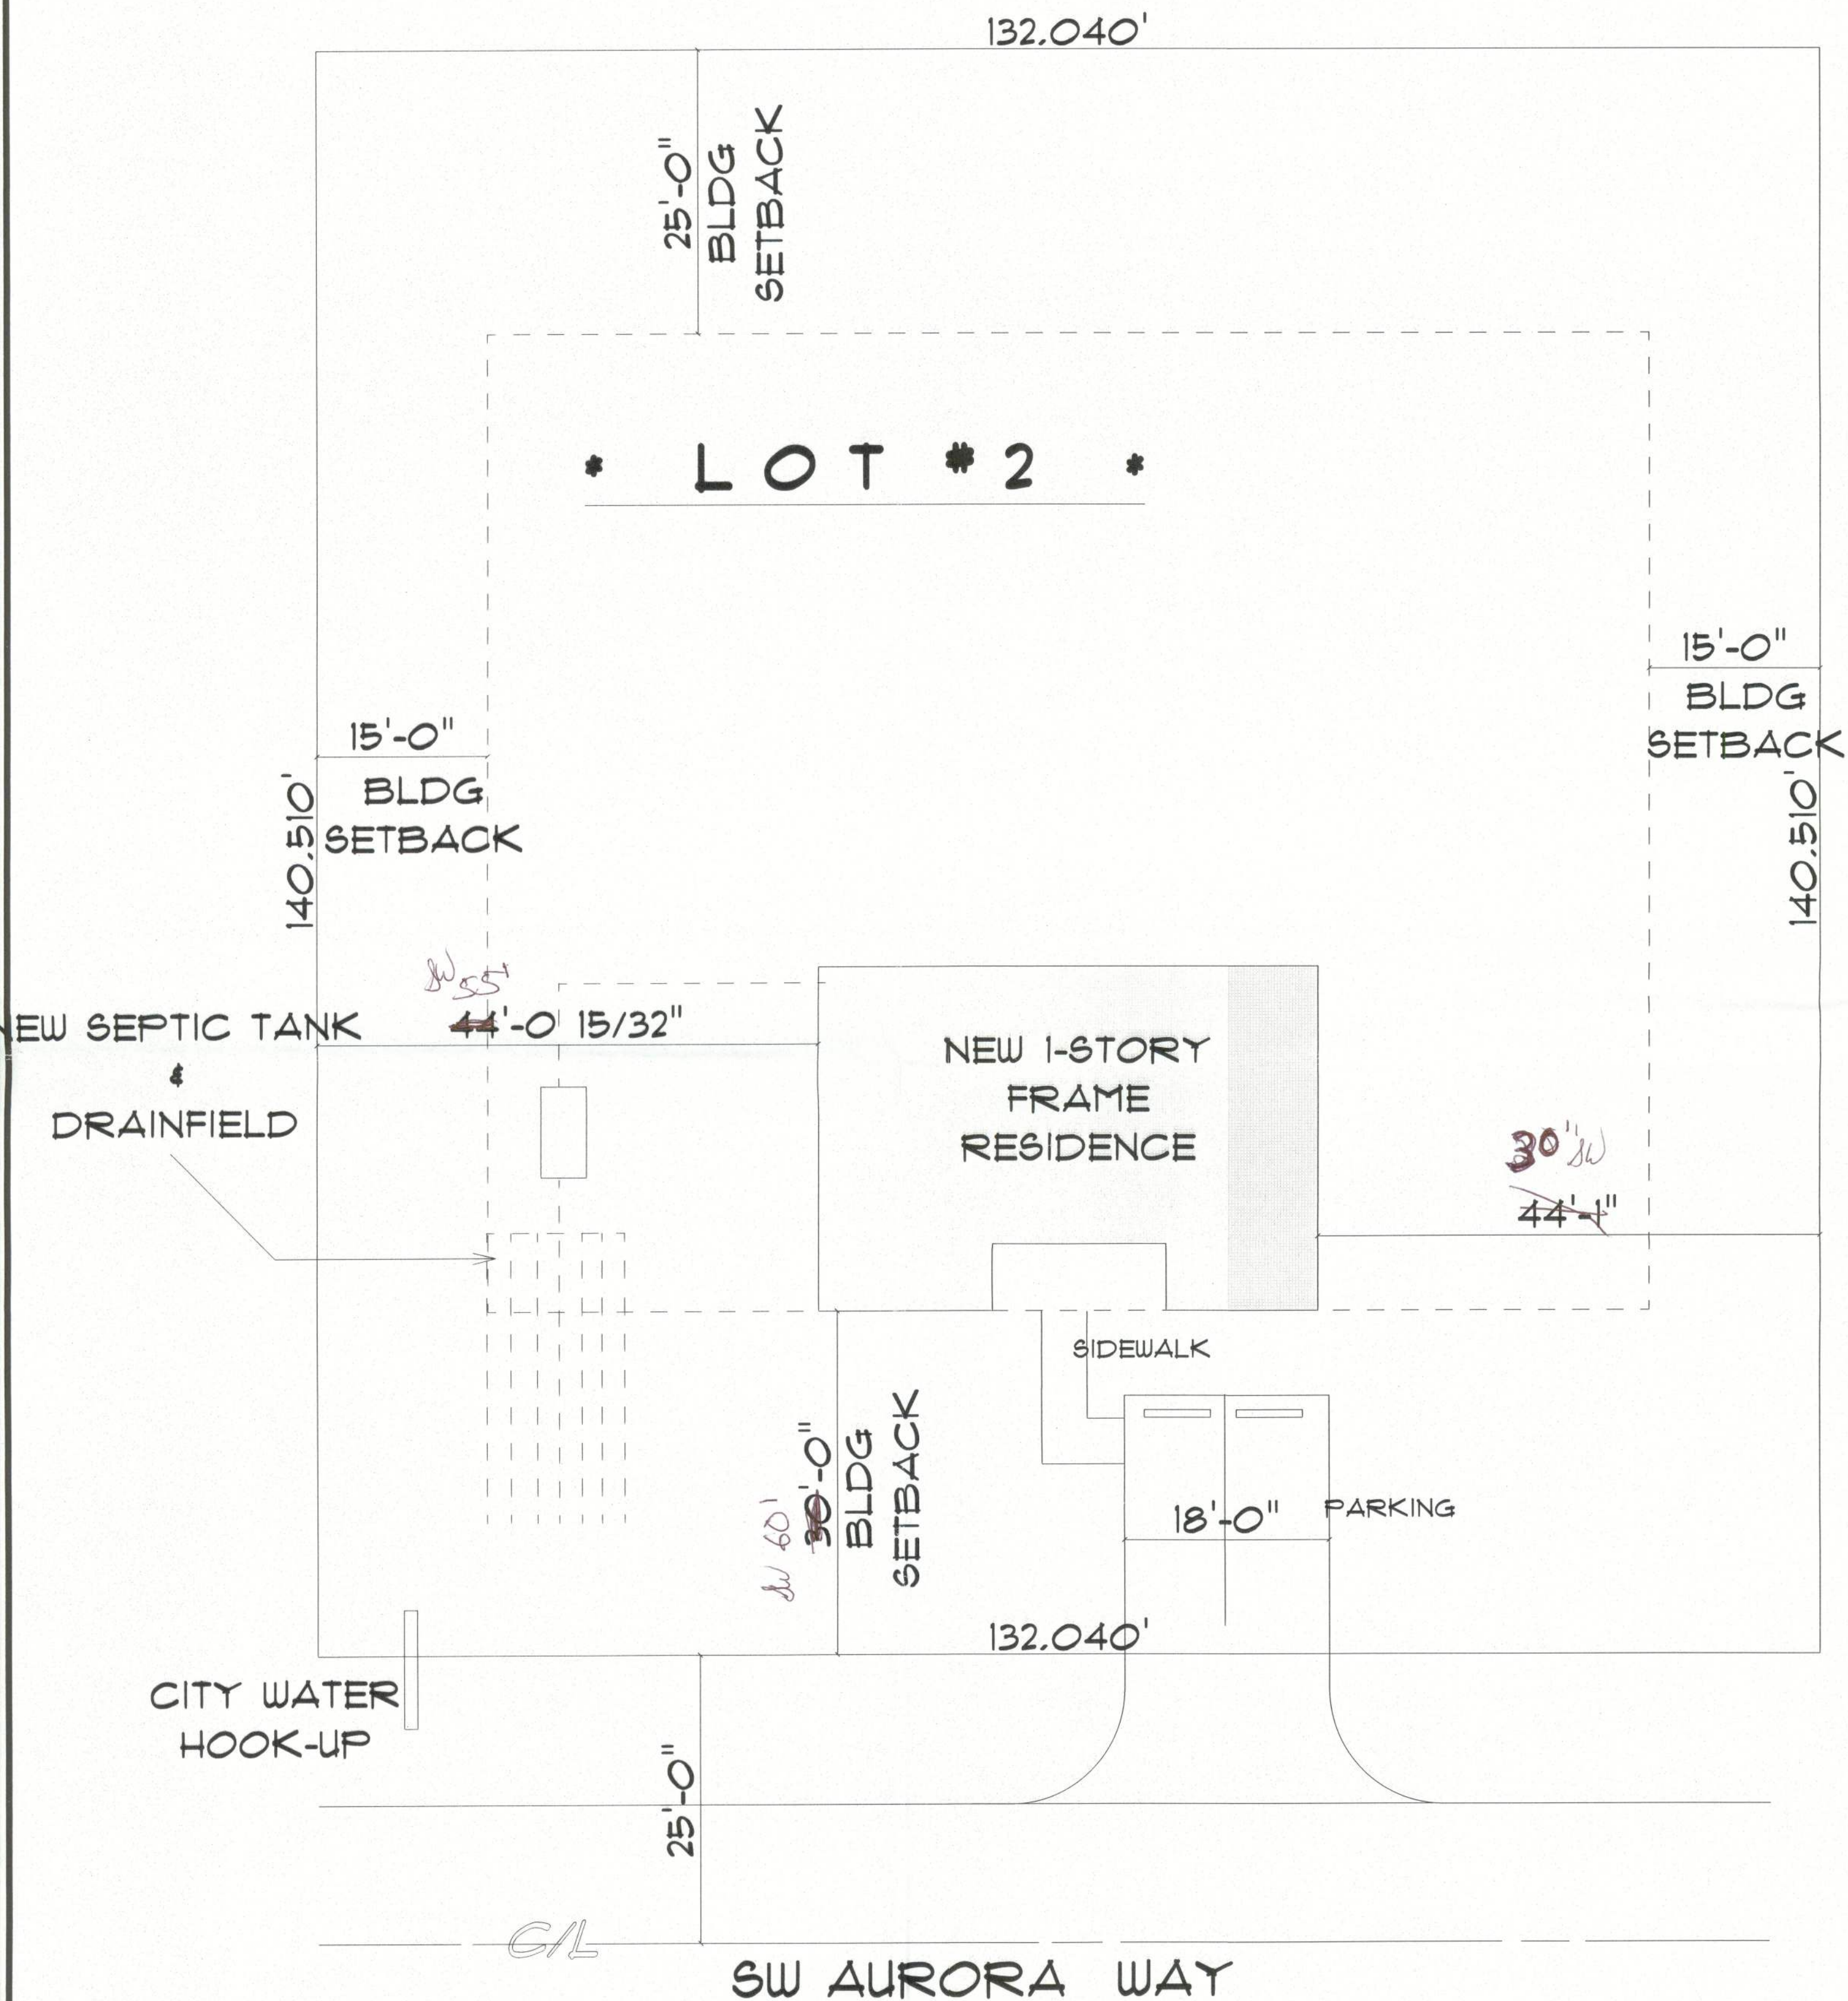

* SITE PLAN *

SCALE : 1"=10'

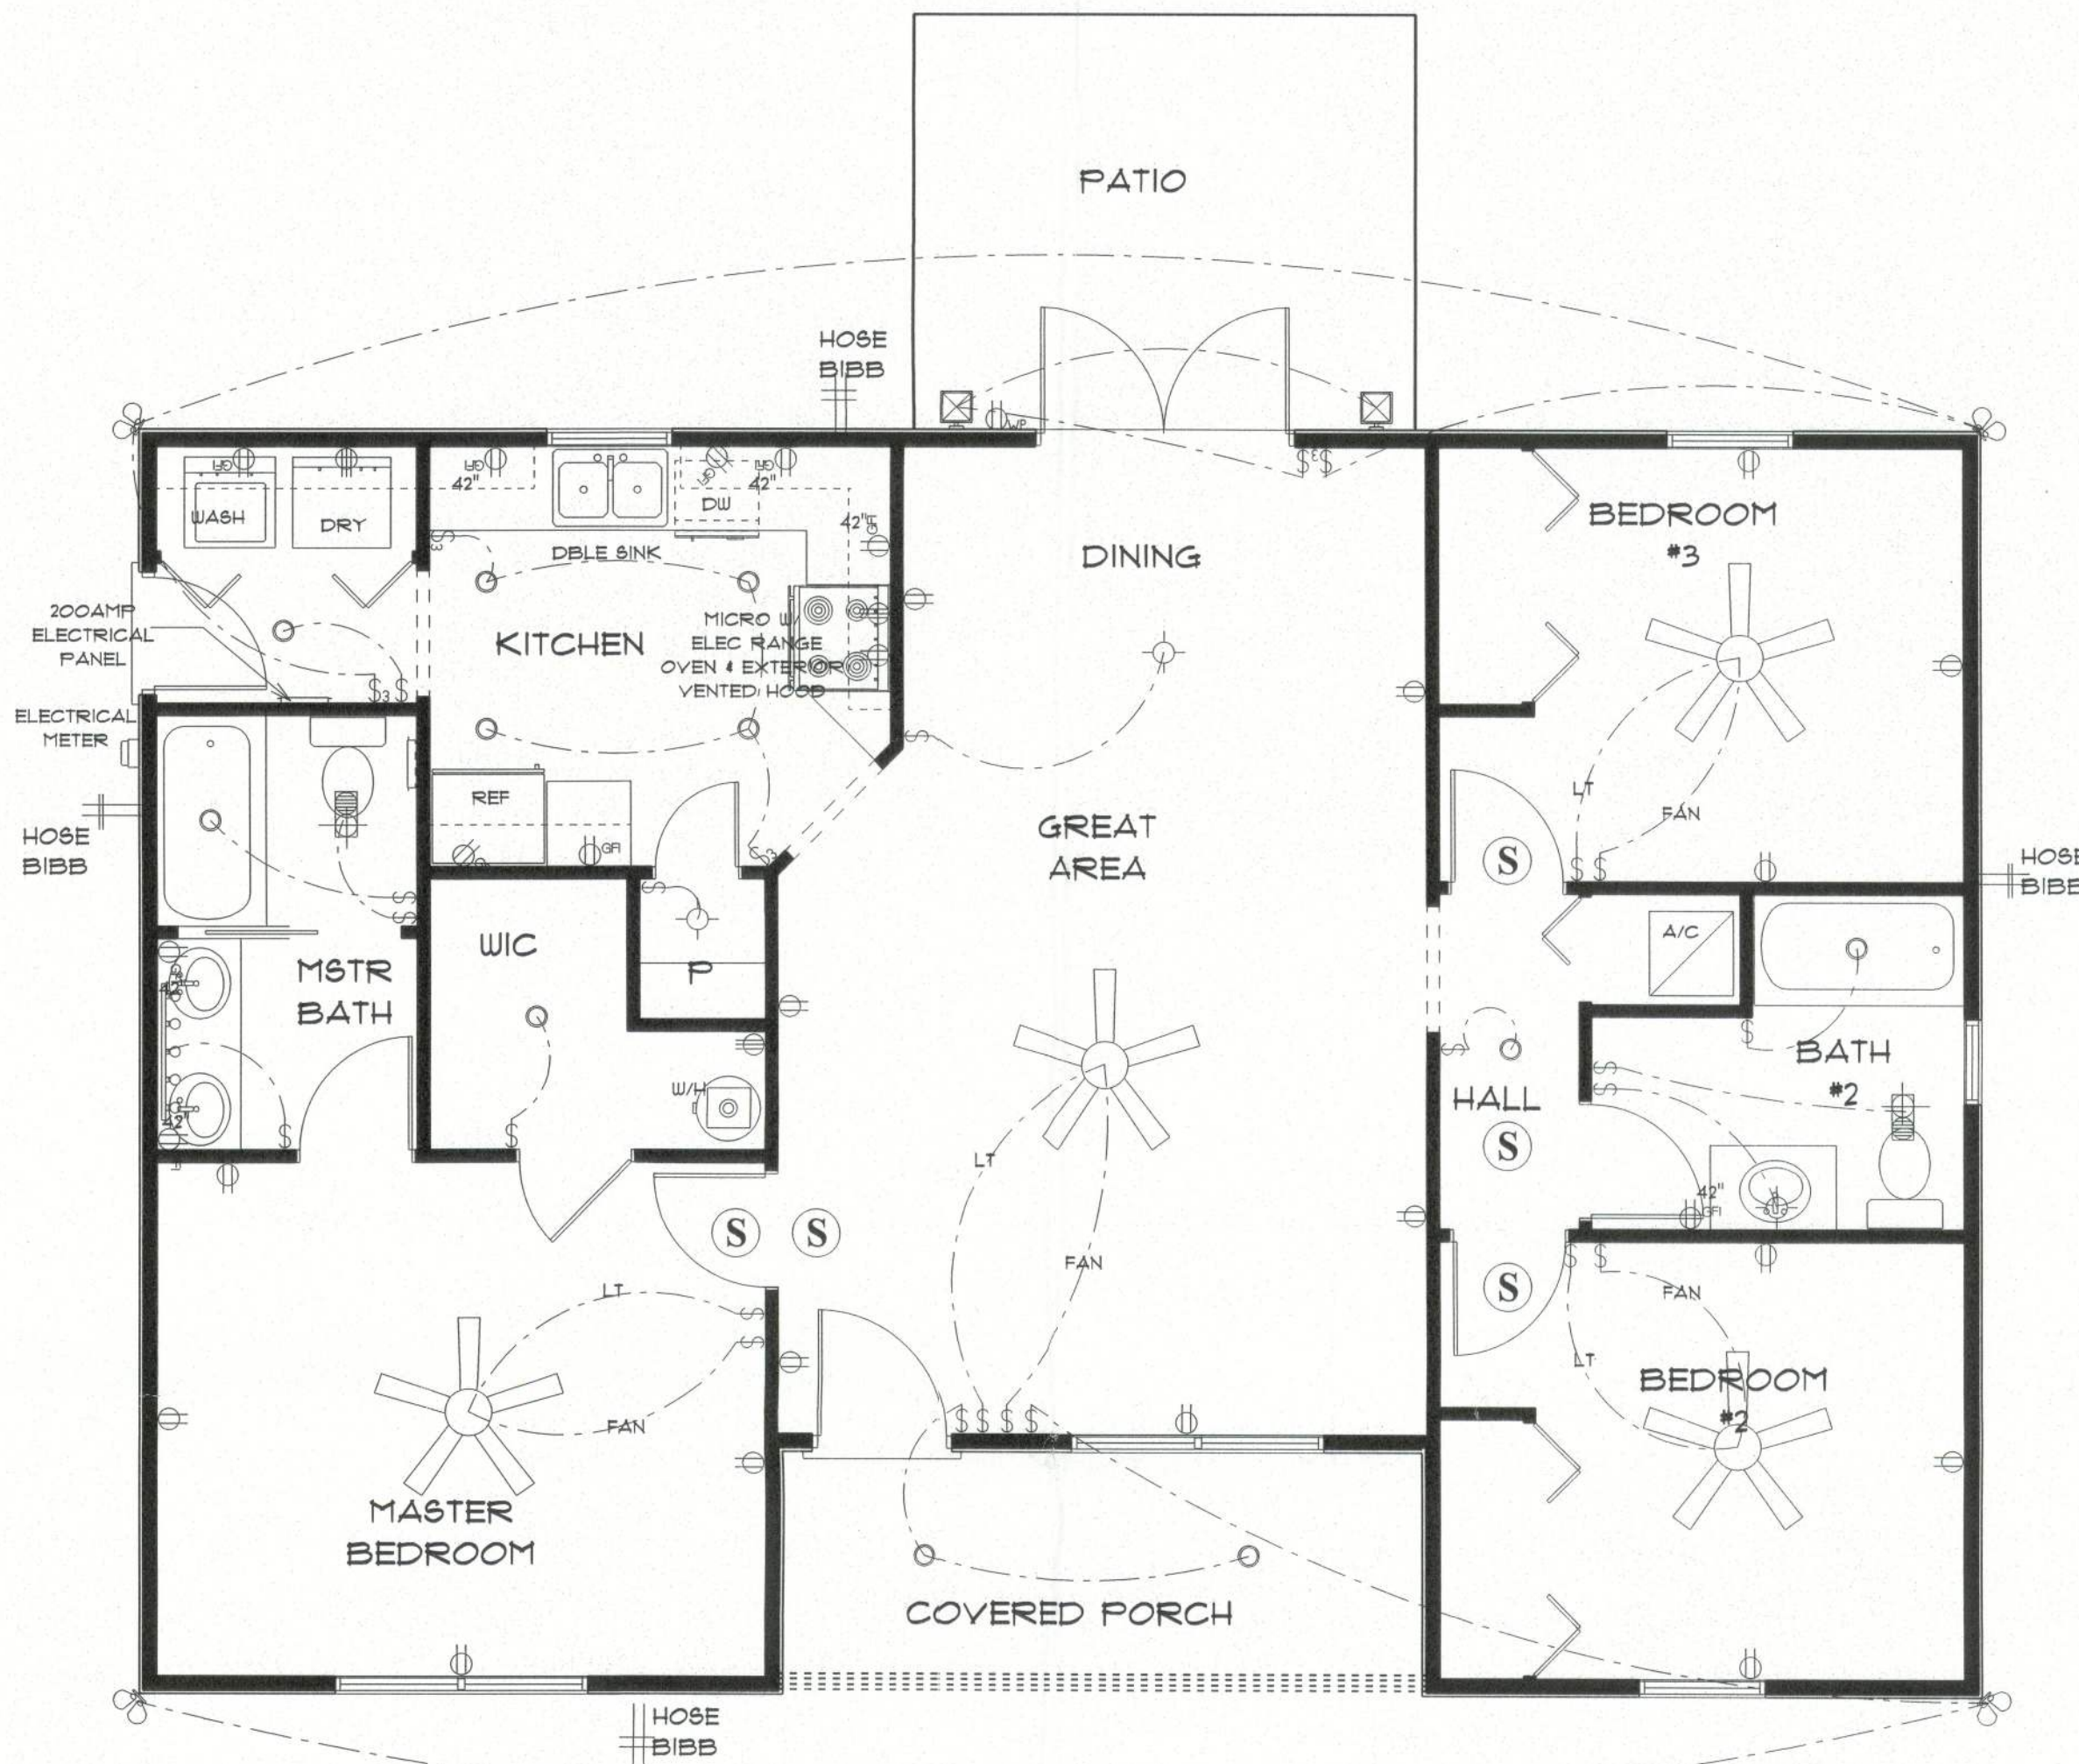

* ELECTRICAL PLAN *

SCALE : 1/4" = 1'-0"

ELECTRICAL PLAN NOTES

- E-1 WIRE ALL APPLIANCES, HVAC UNITS AND OTHER EQUIPMENT PER MANUFACTURER'S SPECIFICATIONS.
- E-2 CONSULT THE OWNER FOR THE NUMBER OF SEPARATE TELEPHONE LINES TO BE INSTALLED.
- E-3 ALL INSTALLATIONS SHALL BE PER NATIONAL ELECTRIC CODE.
- E-4 ALL SMOKE DETECTORS SHALL BE 120V W/BATTERY BACKUP OF THE PHOTOELECTRIC TYPE, AND SHALL BE INTERLOCKED TOGETHER. INSTALL INSIDE AND NEAR ALL BEDROOMS.
- E-5 TELEPHONE, TELEVISION AND OTHER LOW VOLTAGE DEVICES OR OUTLETS SHALL BE AS PER THE OWNER'S DIRECTION AND IN ACCORDANCE WITH APPLICABLE SECTIONS OF NATIONAL ELECT. CODE LATEST EDITION.
- E-6 ELECTRICAL CONTRACTOR SHALL BE RESPONSIBLE FOR THE DESIGN AND SIZING OF ELECTRICAL SERVICE AND CIRCUITS.
- E-7 ENTRY OF SERVICE UNDERGROUND OR OVERHEAD) IS TO BE DETERMINED BY THE OWNER.
- E-8 ALL BEDROOM RECEPTALS ARE TO BE AFCI (ARC FAULT CIRCUIT INTERRUPT).

ELECTRICAL LEGEND		
ELECTRICAL	COUNT	SYMBOL
ceiling fan 5 bladed 04	4	
pot light	11	
exterior light 03	2	
spotlight double	4	
Smoke Detector	5	
vanity bar light	1	
electrical meter	1	
electrical panel	2	
light	3	
outlet	11	
outlet 220v	3	
outlet gfi	10	
outlet wp	1	
switch	22	
switch 3 way	4	
vent light combo	2	

MODEL A for LOT #2

LAKE CITY FLORIDA

Teena M. Ruffo
2325 SW 8th St
Lake City, Florida 32025
Cell: (386) 861-1191
Email: teenaruffo@gmail.com

PRINTED DATE:
Friday, May 19, 2017

DRAWN BY: Teena M. Ruffo
CHECKED BY: BUILDING CONTRACTOR

FINALS DATE:

JOB NUMBER:

DRAWING NUMBER

A-2

OF 2 SHEETS