


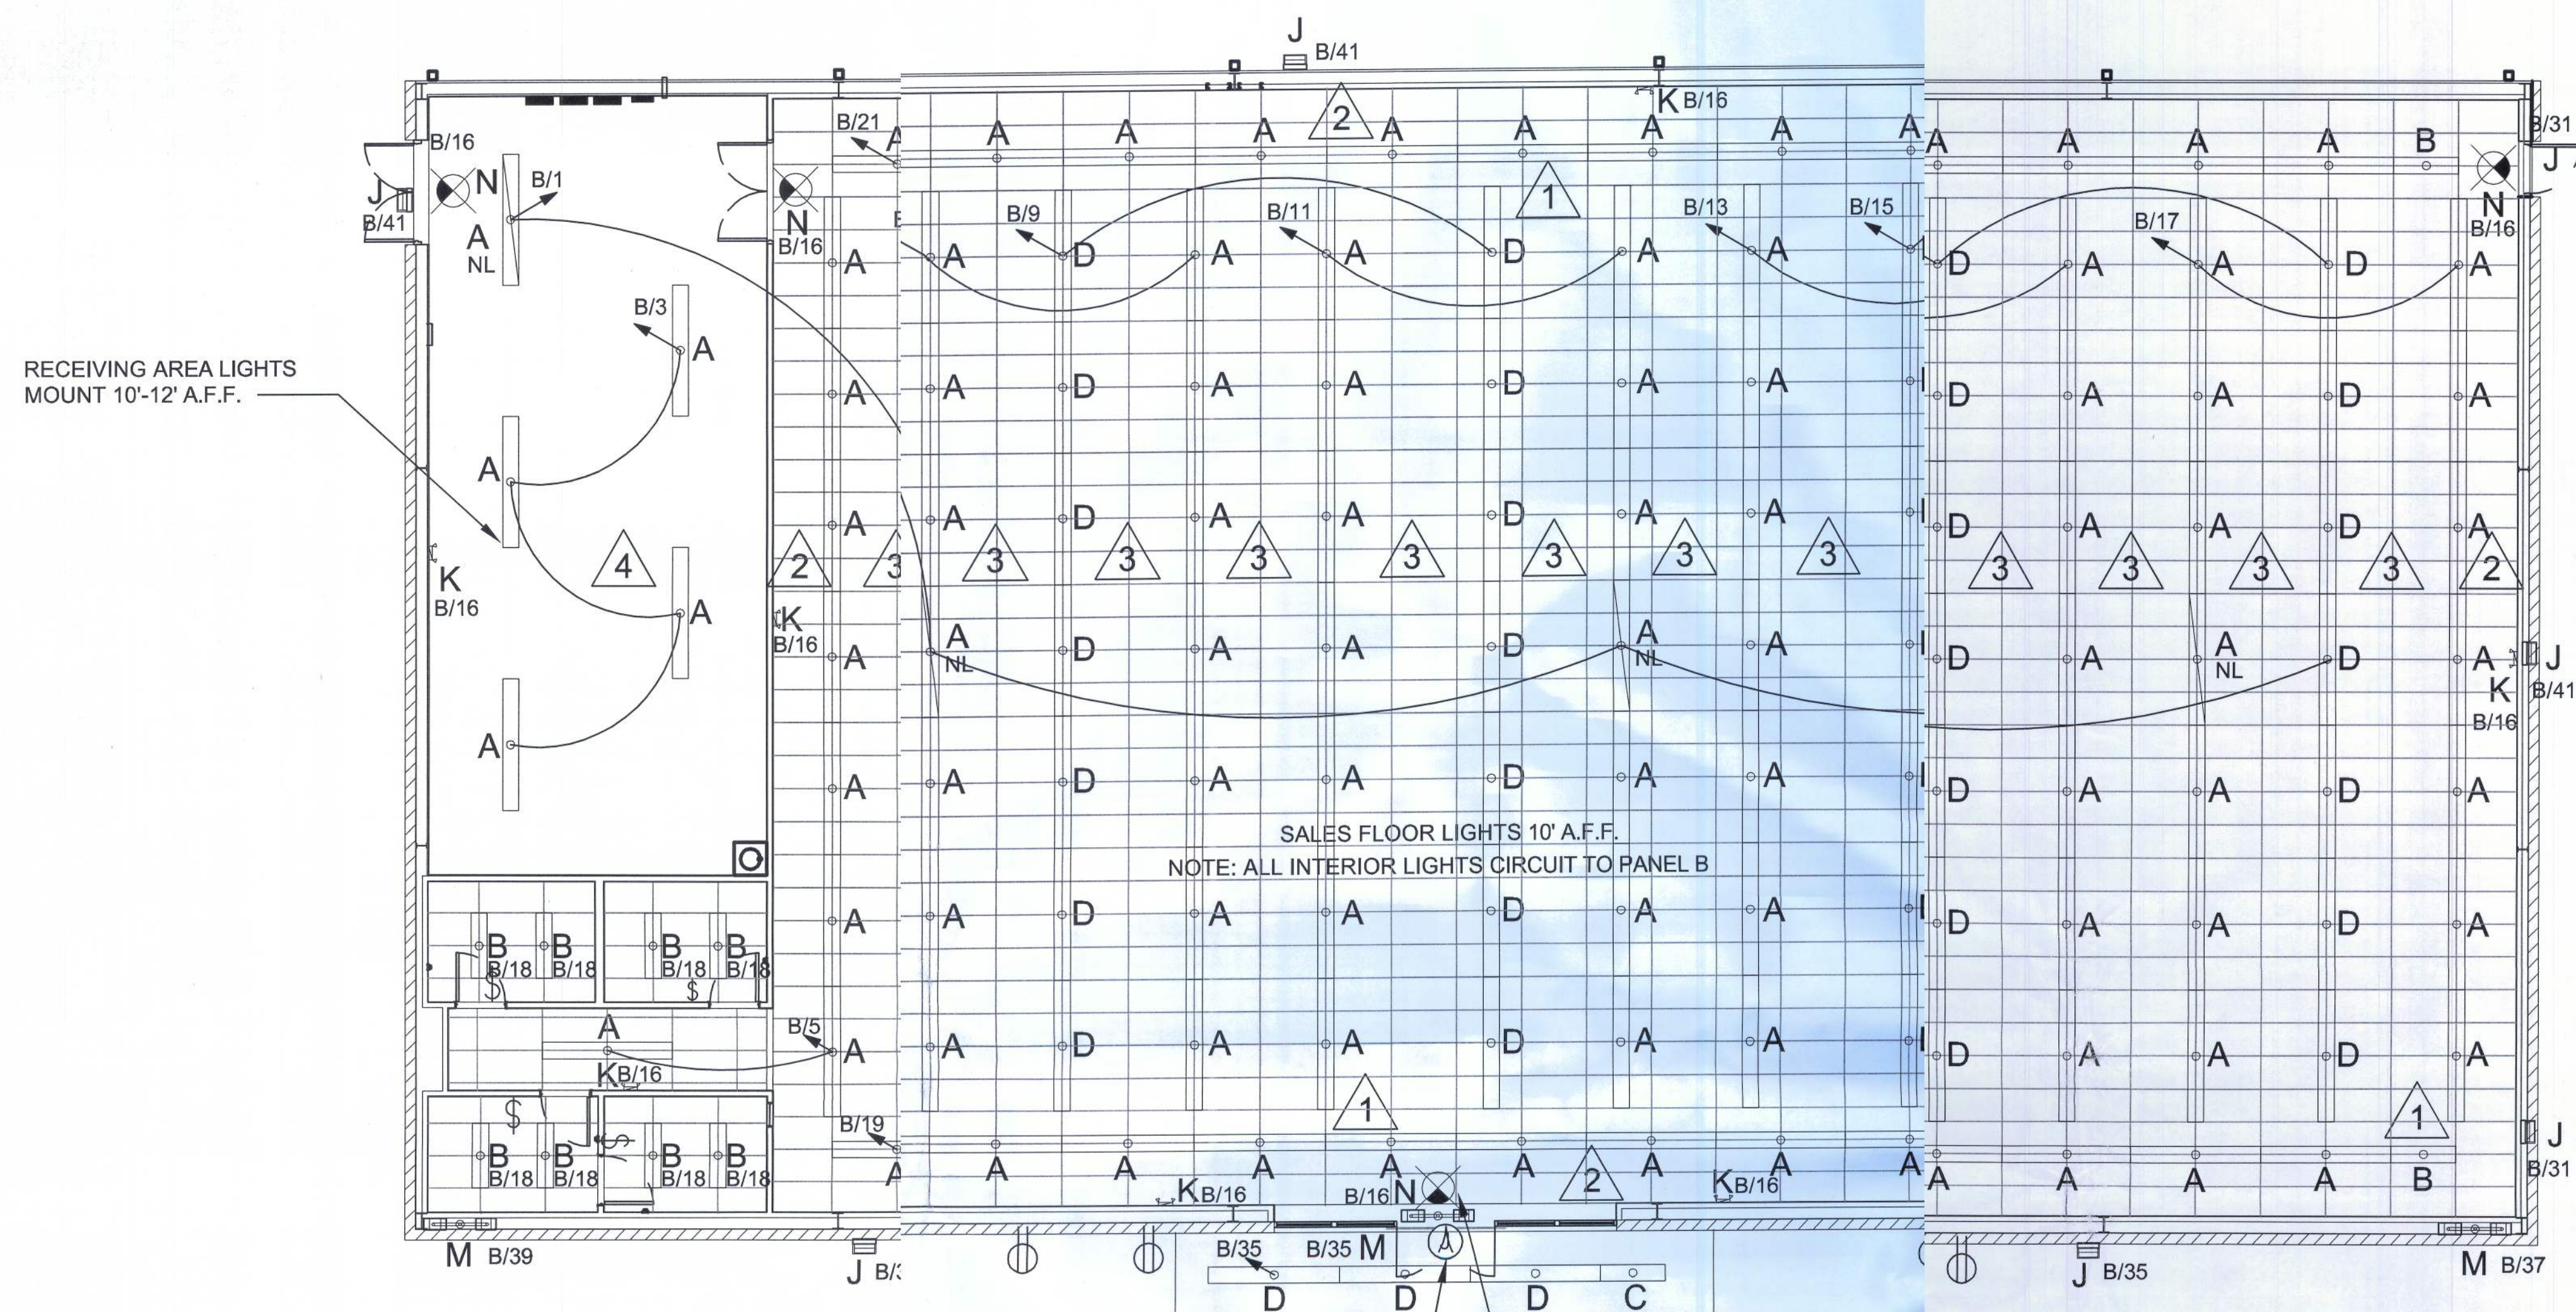

1 LIGHTING PLAN
E2.C 1/16" = 1'-0"

REQUIRED NATIONAL ACCOUNT VENDORS

COMPANY	CONTACTS	PHONE #	REQUIRED ITEMS
HARRIS LIGHTING	SHENNEL JOHNSON	904-1220 EXT. 262 sjo@harrislights.com	ELECTRICAL LIGHTING SUPPLIES
CED - CONSOLIDATED ELECTRICAL DISTRIBUTORS	ROBERT DECKER	270-1-2229 rob@cedbgky.com	ELECTRICAL SWITCH GEAR

LEGEND	
PANEL/CIRCUIT NO. A/12	WALL PACK J
LIGHT FIXTURE TYPE A	EMERGENCY LIGHT K
NIGHT LIGHT CIRCUIT A NL	BI-DIRECTIONAL SECURITY LIGHTING M
LIGHT FIXTURE TYPE B	EMERGENCY LIGHT AND EXIT COMBO N
LIGHT FIXTURE TYPE C	OCCUPANCY LIGHT SENSOR -LEVITON - ODS10-IDW
LIGHT FIXTURE TYPE D	

LIGHT SPACING NOTES	
1	DISTANCE BETWEEN PERIMETER ROW OF LIGHTS TO BE NO MORE THAN 2'-0" AT ANY POINT FROM AN ADJACENT LIGHT FIXTURE.
2	PERIMETER ROWS OF LIGHTS TO BE 4'-0" FROM THE ADJACENT SIDE WALLS.
3	DISTANCE BETWEEN PARALLEL ROWS OF LIGHTS TO BE NO MORE THAN 8'-0"
4	RECEIVING AREA LIGHTS TO BE SPACED EVENLY BETWEEN FRONT AND REAR WALL OF THE RECEIVING AREA.

LIGHT FIXTURE DESCRIPTION		
TYPE	DESCRIPTION	Count
A	8' LIGHT FIXTURE W/TWO (2) LAMPS: HARRIS LIGHTING #MFSBC8424T8HI-120 WITH ELECTRONIC BALLAST & TWO (2) T8/32W LAMPS.	93
B	4' LIGHT FIXTURE W/ONE (1) LAMP: HARRIS LIGHTING #MFSBC4414T8HI-120 WITH ELECTRONIC BALLAST & ONE (1) T8/32W LAMP.	10
C	4' LIGHT FIXTURE W/TWO (2) LAMPS: HARRIS LIGHTING #PFSBC4424T8HI-120 WITH ELECTRONIC BALLAST & TWO (2) T8/32W LAMPS.	1
D	8' LIGHT FIXTURE W/FOUR (4) LAMPS: HARRIS LIGHTING #MFSBC8444T8HI-120 WITH ELECTRONIC BALLAST & FOUR (4) T8/32W LAMPS.	31
J	WALLPACK LIGHT FIXTURE: HARRIS LIGHTING #MFHID-WP-400MH WITH #HPS400W/MH400W MAX LAMP.	VERIFY
K	EMERGENCY LIGHT FIXTURE: HARRIS LIGHTING #MFEF-2L WITH TWO (2) #6V, MR16 LAMPS.	7
N	EMERGENCY LIGHT/EXIT LIGHT COMBO FIXTURE: HARRIS LIGHTING #MFEXIT2LPDUAL WITH TWO (2) #6V, 5.4W MR16 LAMPS.	4
N.1	EXIT LIGHT FIXTURE: HARRIS LIGHTING #MFEXITRED WITH LED EXIT SIGN, RED.	0
M	BI-DIRECTIONAL SECURITY BULL HORN LIGHT FIXTURE: HARRIS LIGHTING #MFHID-BH-400MH WITH #HPS400W/MH400W MAX LAMP & #HW-HID-BH-MB MOUNT.	3

LIGHTING PLAN

NE
NICHOLAS PAUL
GEISLER
ARCHITECT
N.C.A.R.B. Certified
11300 NW Brown Road
Lake City, FL 32055
386/755-9021

CASCO
10077 WATSON ROAD
LAKE CITY, FL 32055
PHONE: 314-821-1100

DATE: 3/16/2010
CDWG: AR0007005



CONCEPT
CONSTRUCTION

License#: CC1515491
ph: 386-755-3887
fx: 386-755-919

295 NW Commons Loop
Suite 115-32
Lake City, FL 32055

www.conceptconstruction.net

DOLLAR GENERAL

LAKE CITY, FLORIDA
COUNTY RD 247, LAKE CITY, FL
STORE # 12851

2010 PROTOTYPE - PLAN "C" 9,100

DATE 30 MAR 2010
Design FB 06/10/10
Revisions JB 10/20/10

SHEET NUMBER

E2.C