

HOUSE CRAFT HOMES, L.L.C.

12523 U.S. Highway 441 - Alachua, FL 32615 Phone: (904) 462-5323/FAX: (904) 2-1509

Client Name: CANNON Model: CUSTOM SUWANEE

BANK: LOAN TYPE: ( ) Cash (X) Conventional ( ) F.H.A. ( ) V.A.

#### CABINET COLOR SELECTIONS:

Kitchen: Countertop SANTA CECILIA Cabinet Base WHEAT ARC Master Bath: Countertop X-891 Cabinet Base WHEAT Hall Bath: Countertop X-891 Cabinet Base WHEAT

Toilets or Master WH Hall WH Other WH

NOTES: WHITE SINK

#### BATHROOM TILE SELECTION:

Master Bath: Shower 9X12 WIND DRIFT BEIGE Shower Floor SL81 MURAL 2X2 Grout #180 SANDSTONE Hall Bath: Tub Surround Tile Selection Grout

Color WHITE WHITE Tub Choices Style PP YES

#### VAULTS:

CARPET 00200 GOLDEN TINT

VINYL/TILE

#### PAINT SELECTIONS:

Interior Wall Color STD Interior Trim STD

Window Sills: ( ) Wood (X) Flatcut Marble ( ) Hardiplank Siding od Sill

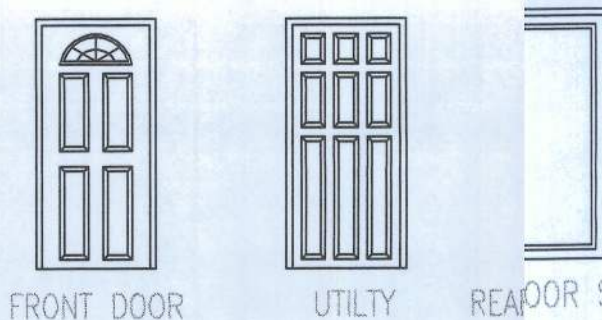
#### RANGE SELECTIONS:

Range/Color WHITE FLAT TOP GLASS Hood/Color MICRO HOOD

#### OPTIONAL APPLIANCES:

#### EXTERIOR FEATURE SELECTIONS:

Acrocrete/Main House SANDBAR AC-228 Trim Package COLUMNS Trim Color NEW CREAM AC-201 Exterior Door Colors WHITE Siding N/A Soffit SANDLEWOOD Shingles RUSTIC CEDAR Style/Color ARCH Window Color WHITE



Trim Type Colonial w/Classique Doors Std. Colonial Grills Front Windows Standard

#### BATH WINDOWS:

Master (X) Obscure ( ) Clear Glass Hall ( ) Obscure ( ) Clear Glass

SUPER Energy Pac: Yes ( ) No ( )

Well Allowance Yes (X) No ( ) Septic Allowance Yes (X) No ( )

Extras:

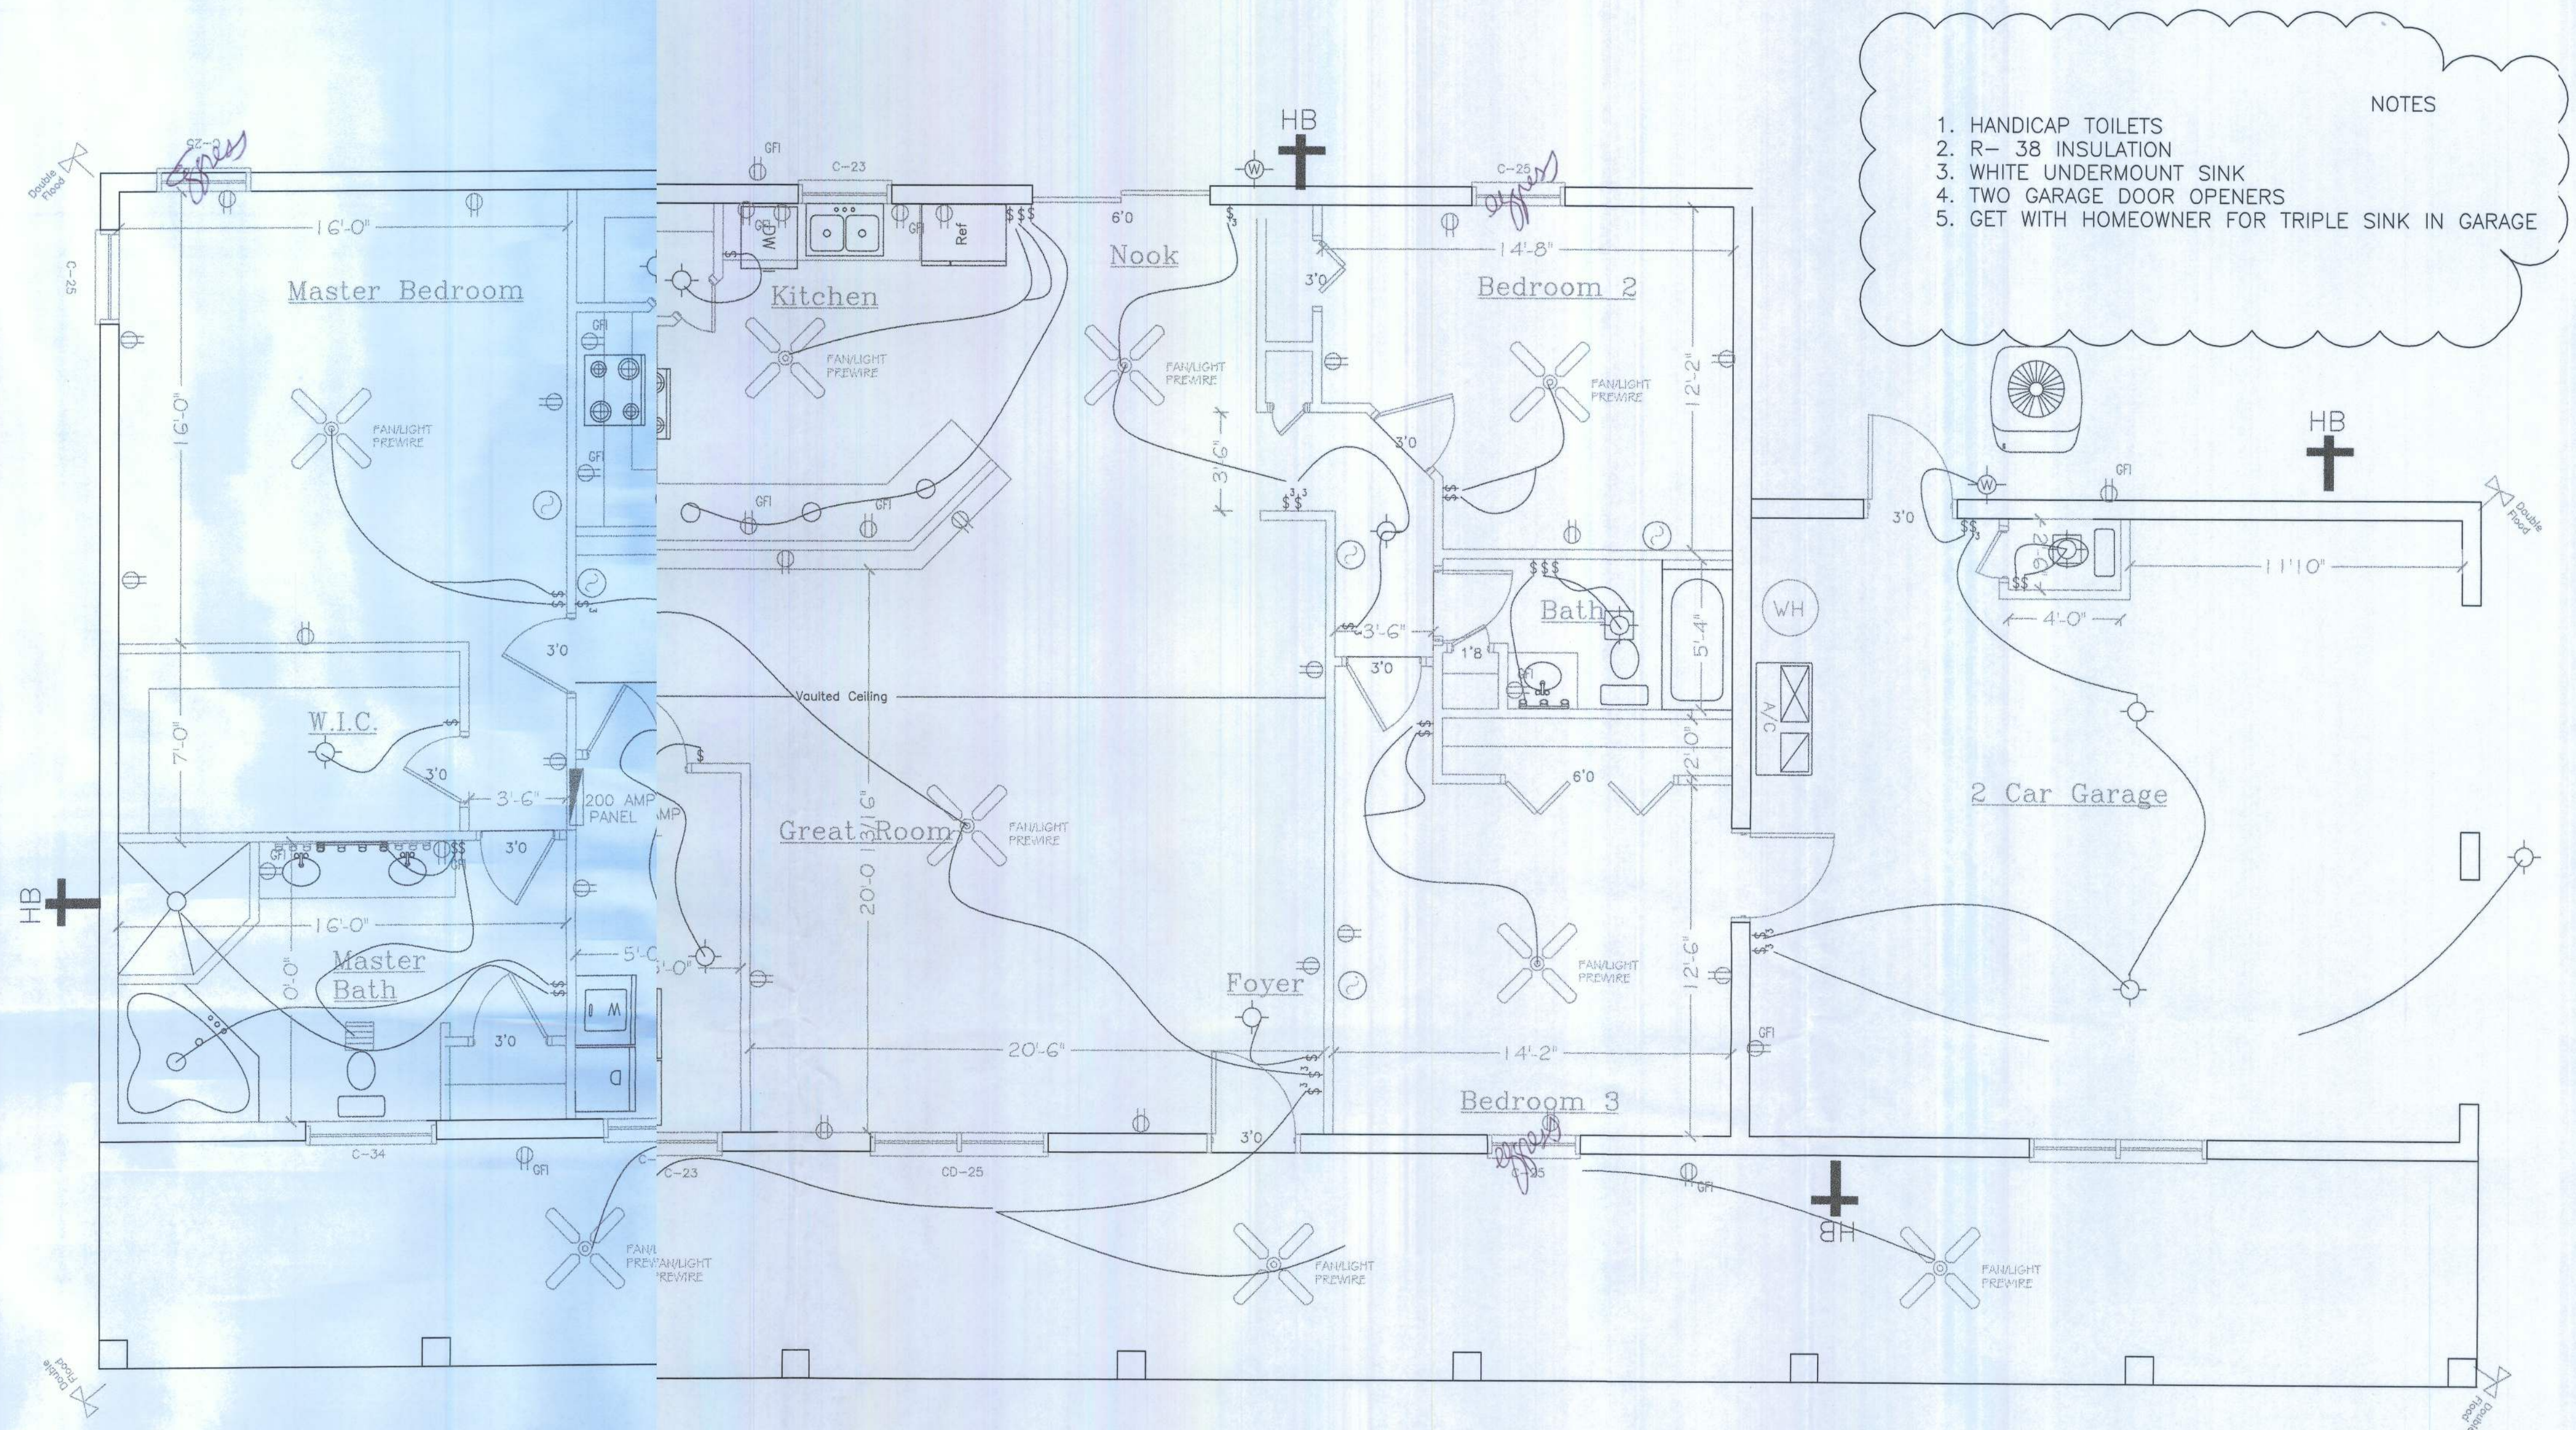
Power Company: CLAY ELECTRIC (X) Overhead ( ) Underground

Fireplace Screenroom Color

We have reviewed this plan and all notes on it. All items we have discussed with House Craft and its representatives are indicated on this "Master Copy". We understand that any additional items that are not on this print can be done for a \$250.00 plan change fee plus the cost of the change.

Purchaser: \* Date: \*

| REV. | DESCRIPTION | DATE |
|------|-------------|------|
|      |             |      |
|      |             |      |
- NOTES
1. HANDICAP TOILETS
  2. R- 38 INSULATION
  3. WHITE UNDERMOUNT SINK
  4. TWO GARAGE DOOR OPENERS
  5. GET WITH HOMEOWNER FOR TRIPLE SINK IN GARAGE

## FLOOR PLAN

SCALE: 1/4"=1'-0"

ELECTRIC SCHEDULE  
Designed in compliance with the requirements of the 2008 Electrical Code.

#### CODE COMPLIANCE.

This building is designed in compliance with the requirements of the Florida Building Code, 2007. Structural members, cladding, fasteners and systems providing for the structural integrity of the building are designed to resist gravity loads as prescribed Chapter 16 and wind loads prescribed in Section 1606.2 Simplified Provisions for Low Rise Building

| LIGHTING FIXTURE SCHEDULE |                                      |
|---------------------------|--------------------------------------|
| FIXTURE                   | DESCRIPTION                          |
|                           | SURFACE MOUNTED INCANDESCENT FIXTURE |
|                           | PRE-WIRED CEILING FAN                |
|                           | DOUBLE FLOOD LIGHT FIXTURE           |
|                           | FAN LIGHT VENTED TO EXTERIOR         |
|                           | SURFACE MOUNTED INCANDESCENT FIXTURE |

#### ELECTRICAL LEGEND

- 44" DUPLEX CONVENIENCE RECEPTACLE WITH GROUND (44" DENOTES HEIGHT A.F.F., IF OTHER THAN STD.) (GFI/GFCI DENOTES GROUND FAULT CIRCUIT INTERRUPTER) (WP DENOTES WEATHER PROOF)
- SPECIAL RECEPTACLE WITH GROUND, SEE SPECIFICATIONS
- SINGLE POLE SWITCH AT STANDARD HEIGHT
- THREE WAY SWITCH AT STANDARD HEIGHT
- TELEPHONE OUTLET
- CEILING MOUNTED EXHAUST FAN VENTED TO EXTERIOR
- CABLE TV OUTLET
- ELECTRICAL DISTRIBUTION PANEL
- SMOKE DETECTOR
- THERMOSTAT

#### Square Footage

|           |       |
|-----------|-------|
| Living... | 1991  |
| Garage... | 607   |
| Entry...  | 672   |
| Porch...  | 000   |
| Total...  | 3,270 |



HOUSE CRAFT HOMES, LLC

12523 NW U.S. Hwy. 441 - Alachua, FL 32615 Phone: (386) 462-5323/FAX: (888) 719-0105

Job name:

CANNON

Model: SUWANNEE Type: PLAN

Location: COLUMBIA COUNTY Drawn By: J.D.H.

Designer: J.D.H. Checked By: J.D.H.

Scale: 1/4"=1' Date: 8/19/2011 Sheet: 4 of 4