

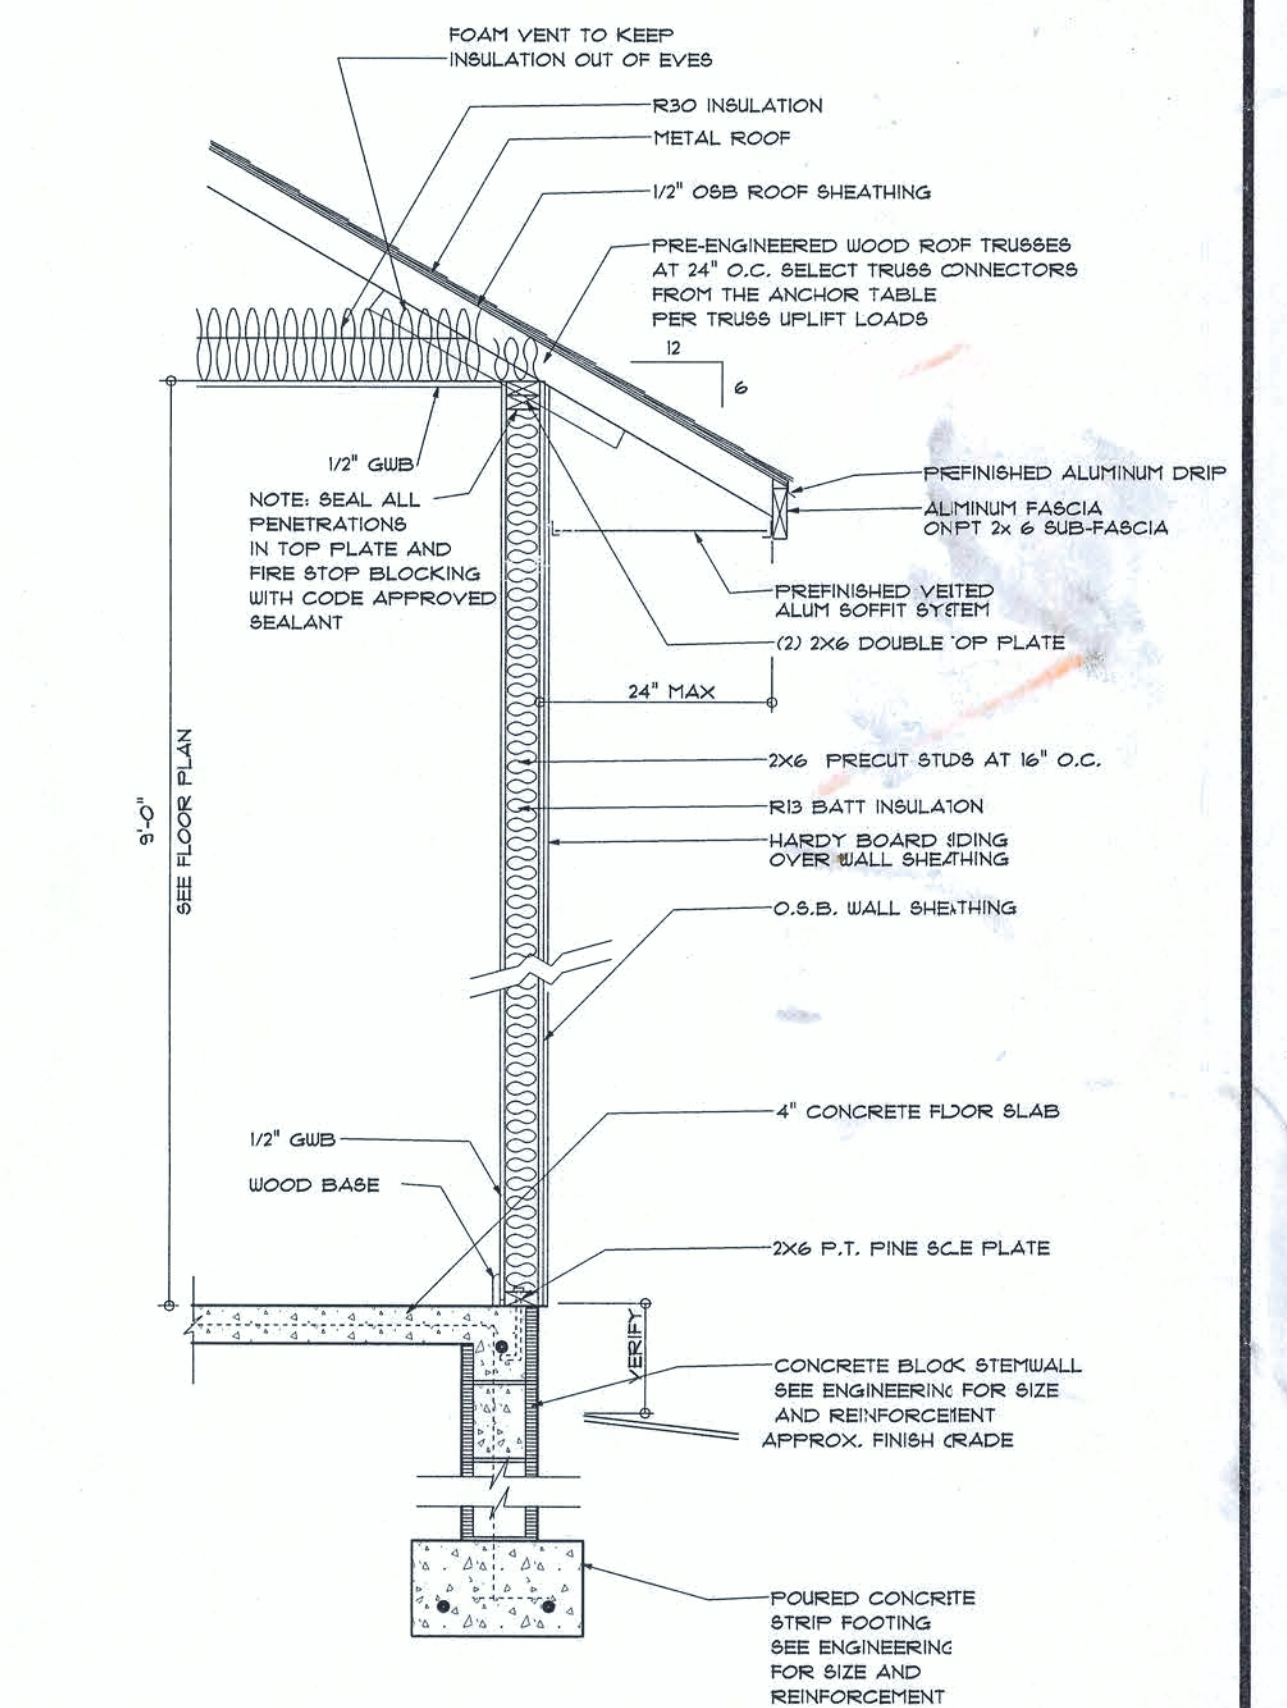


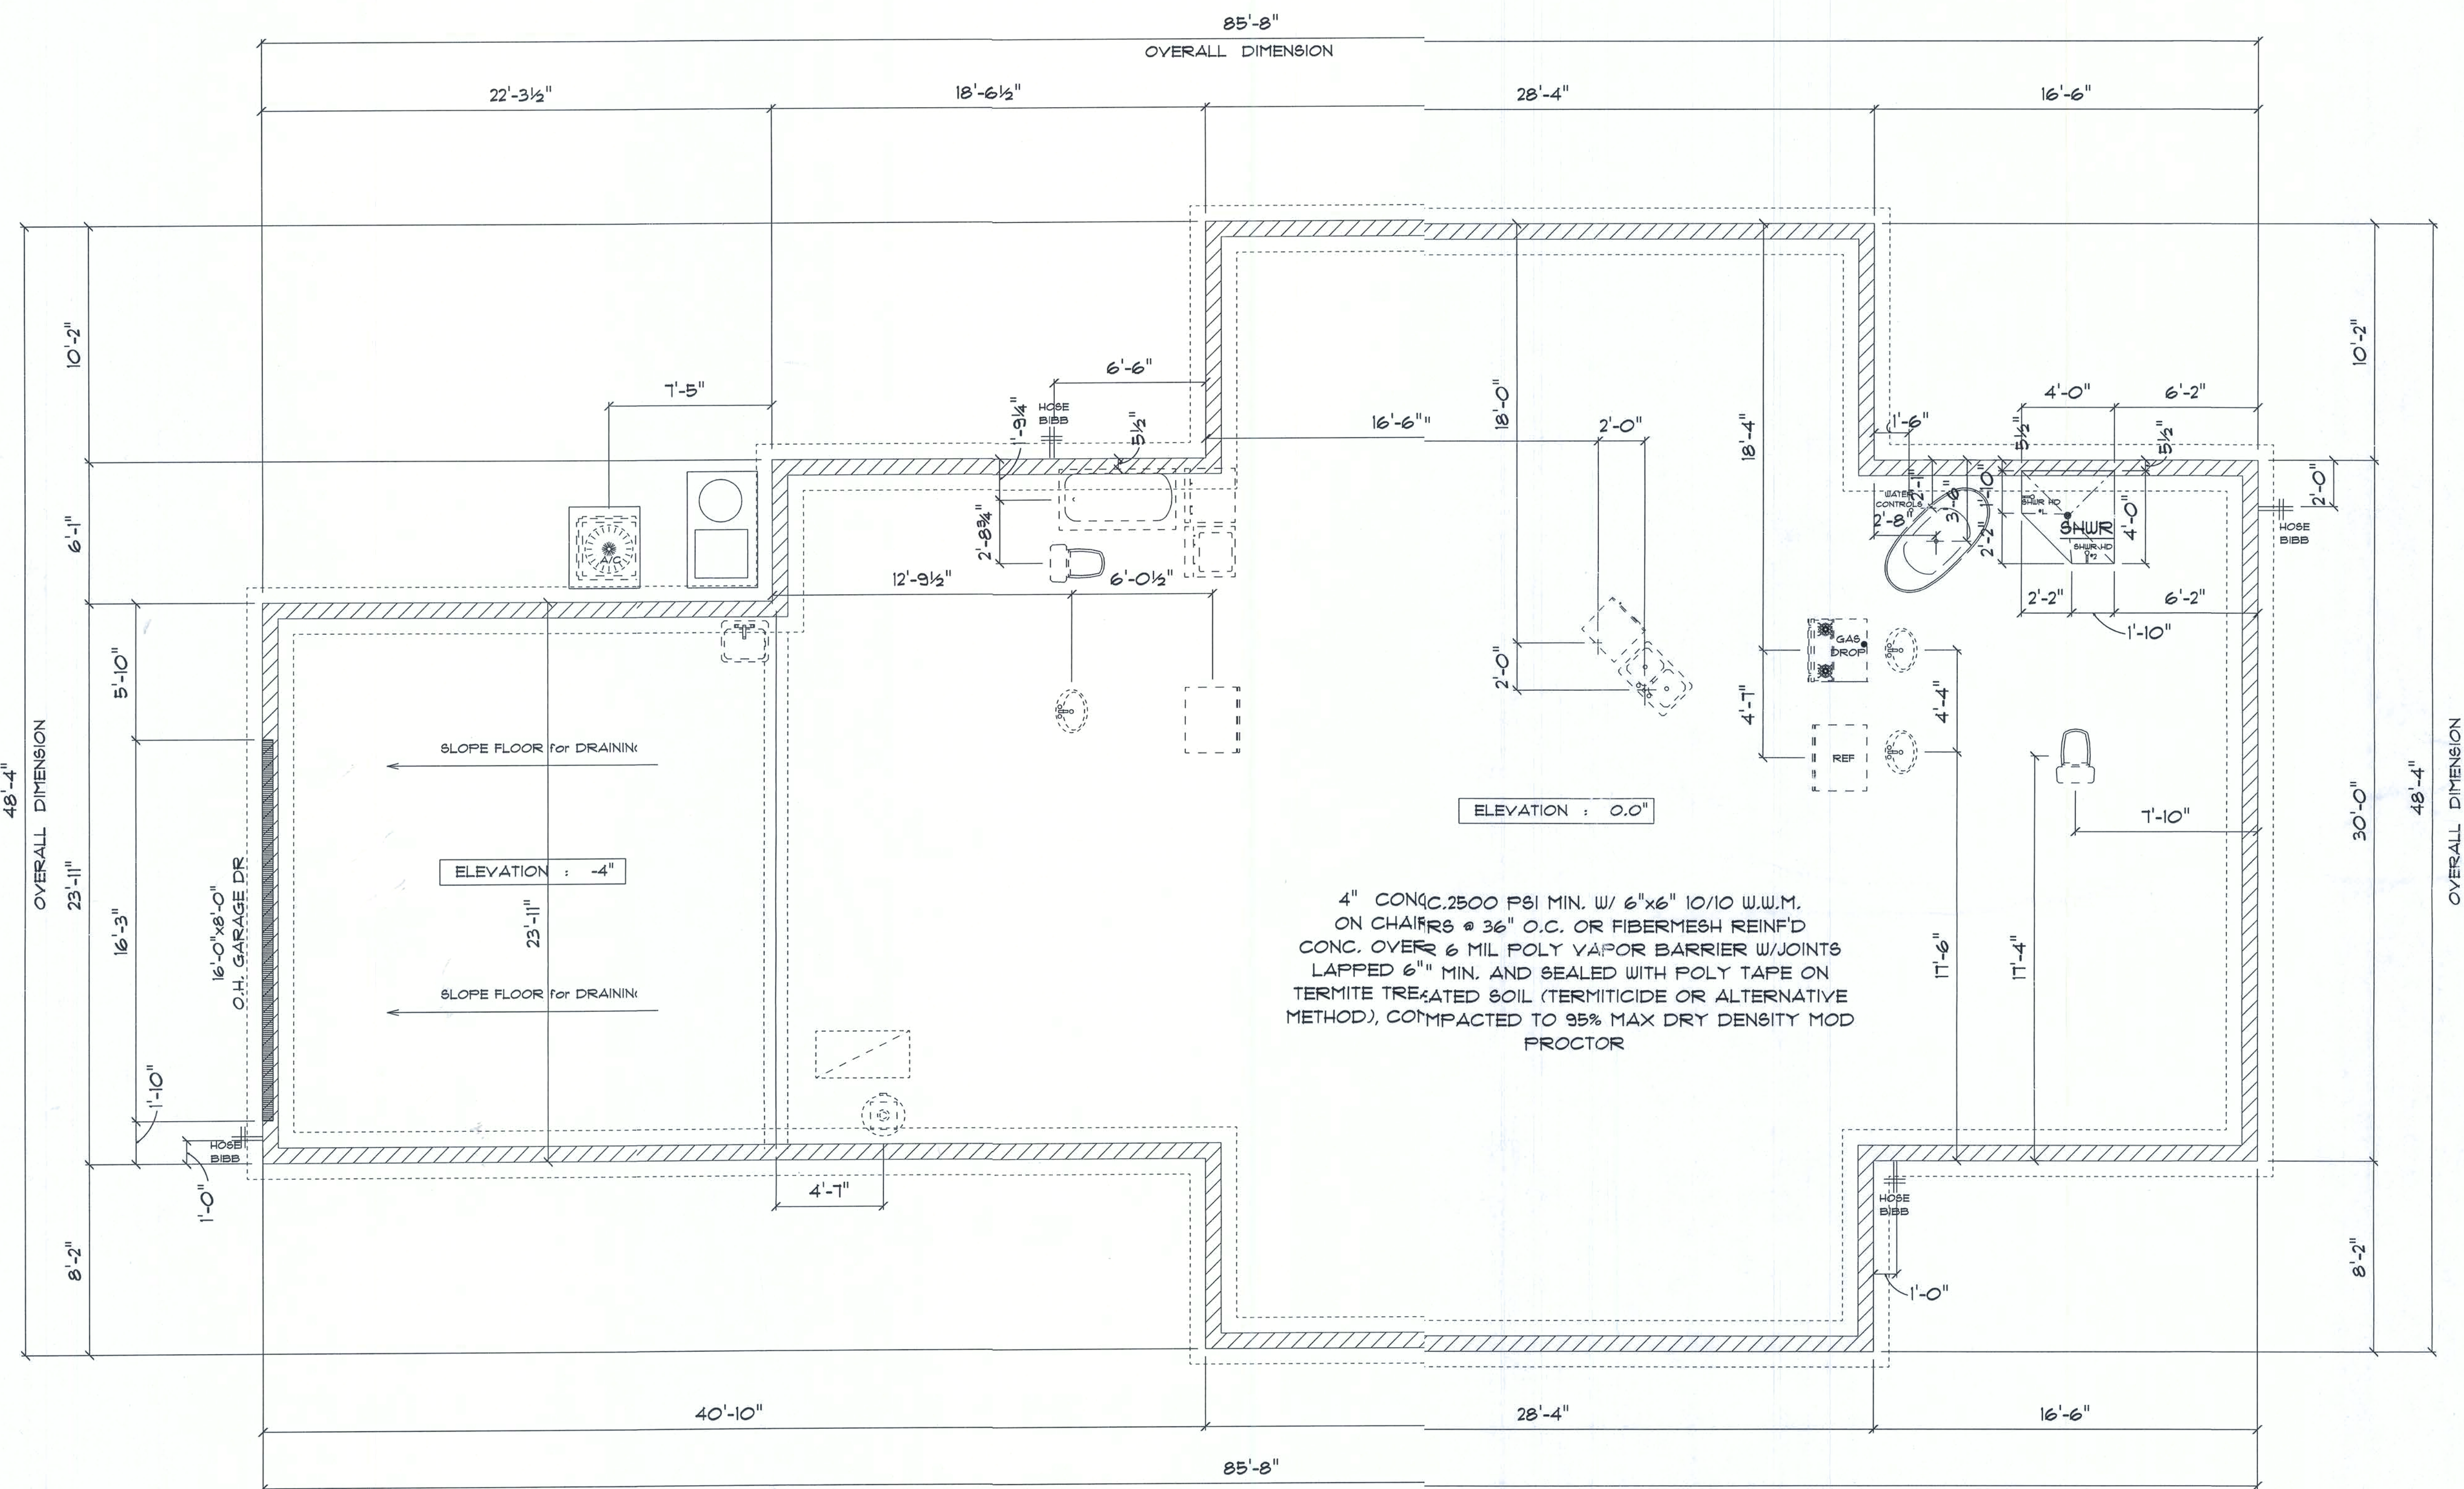

- IMPORTANT NOTE:
1. IT IS THE BUILDER'S RESPONSIBILITY TO VERIFY ALL GEOMETRY AND DIMENSIONS BEFORE ORDERING ANY MATERIALS OR BEGINNING CONSTRUCTION.
 2. THESE PLANS ARE FOR LAYOUT AND DESIGN PURPOSES ONLY ALL STRUCTURAL NOTES AND DETAILS TO BE PROVIDED BY AN ENGINEER.
 3. ALL EXTERIOR WALLS TO BE 2X6.

* FOUNDATION PLAN *

SCALE : 1/4" = 1'-0"

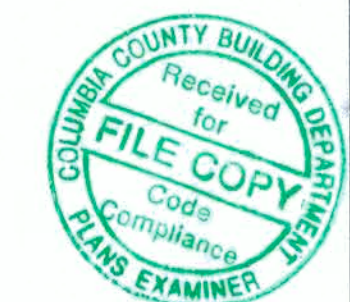

RESIDENCE
for
MARCO & BECKY
MATTHEWS

Trena M. Ruffo
2125 SW 8R 47
Lake City Florida, 32025
Cell: (386) 861-1181
Email: trena.ruffo@gmail.com

PRINTED DATE:
Tuesday, June 16, 2020


DRAWN BY: Trena M. Ruffo
CHECKED BY:
BUILDING CONTRACTOR

FINAL DATE:

JOE NUMBER:

DRAWING NUMBER

A-1
OF 5 SHEETS

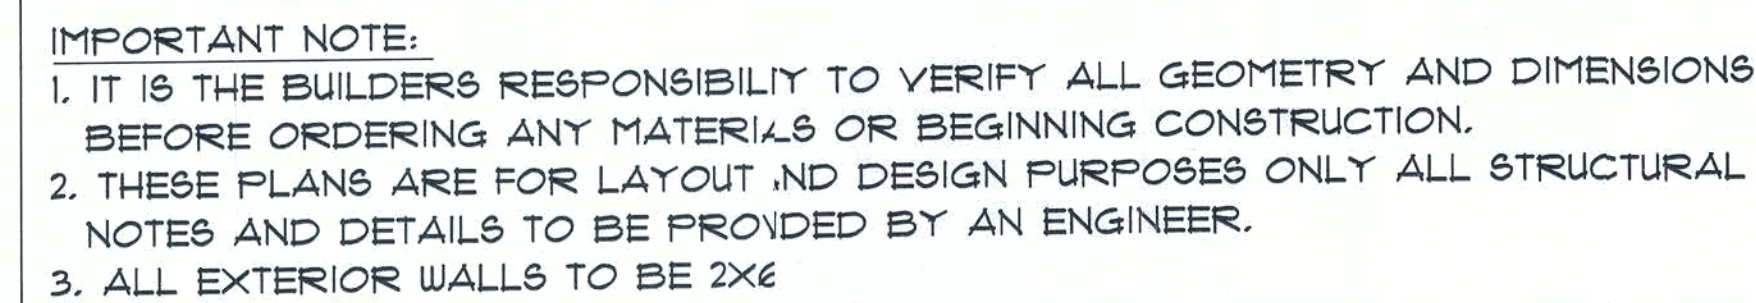

SCALE : 1/4" = 1'-0"

RESIDENCE
for
MARCUS & BECKY
MATTHEWS

Teena M. Ruffo
2925 SW SR 47
Lake City Florida, 32025
Cell: (386) 867 - 1191
Email: teenaruffo@gmail.com

PRINTED DATE:
Tuesday, June 16, 2020

DRAIN BY:	CHECKED:
-----------	----------

Tesna M. Ruffo

	BUILDING CONTRACTOR
--	---------------------

100

FINALS DATE:	
--------------	--

1000

JOB NUMBER:

1000

DRAWING NUMBER

A-2

A-2


OF 5 SHEETS



NOTE :
 1/ OVERHANG ON ALL GABLE EAVES
 1/ OVERHANG ON ALL OTHER EAVES
 6/12 PITCH MAIN ROOF
 8/12 PITCH ON FRONT FALSE GABLE ROOF

*** FRONT ELEVATION ***

SCALE : 1/4" = 1'-0"

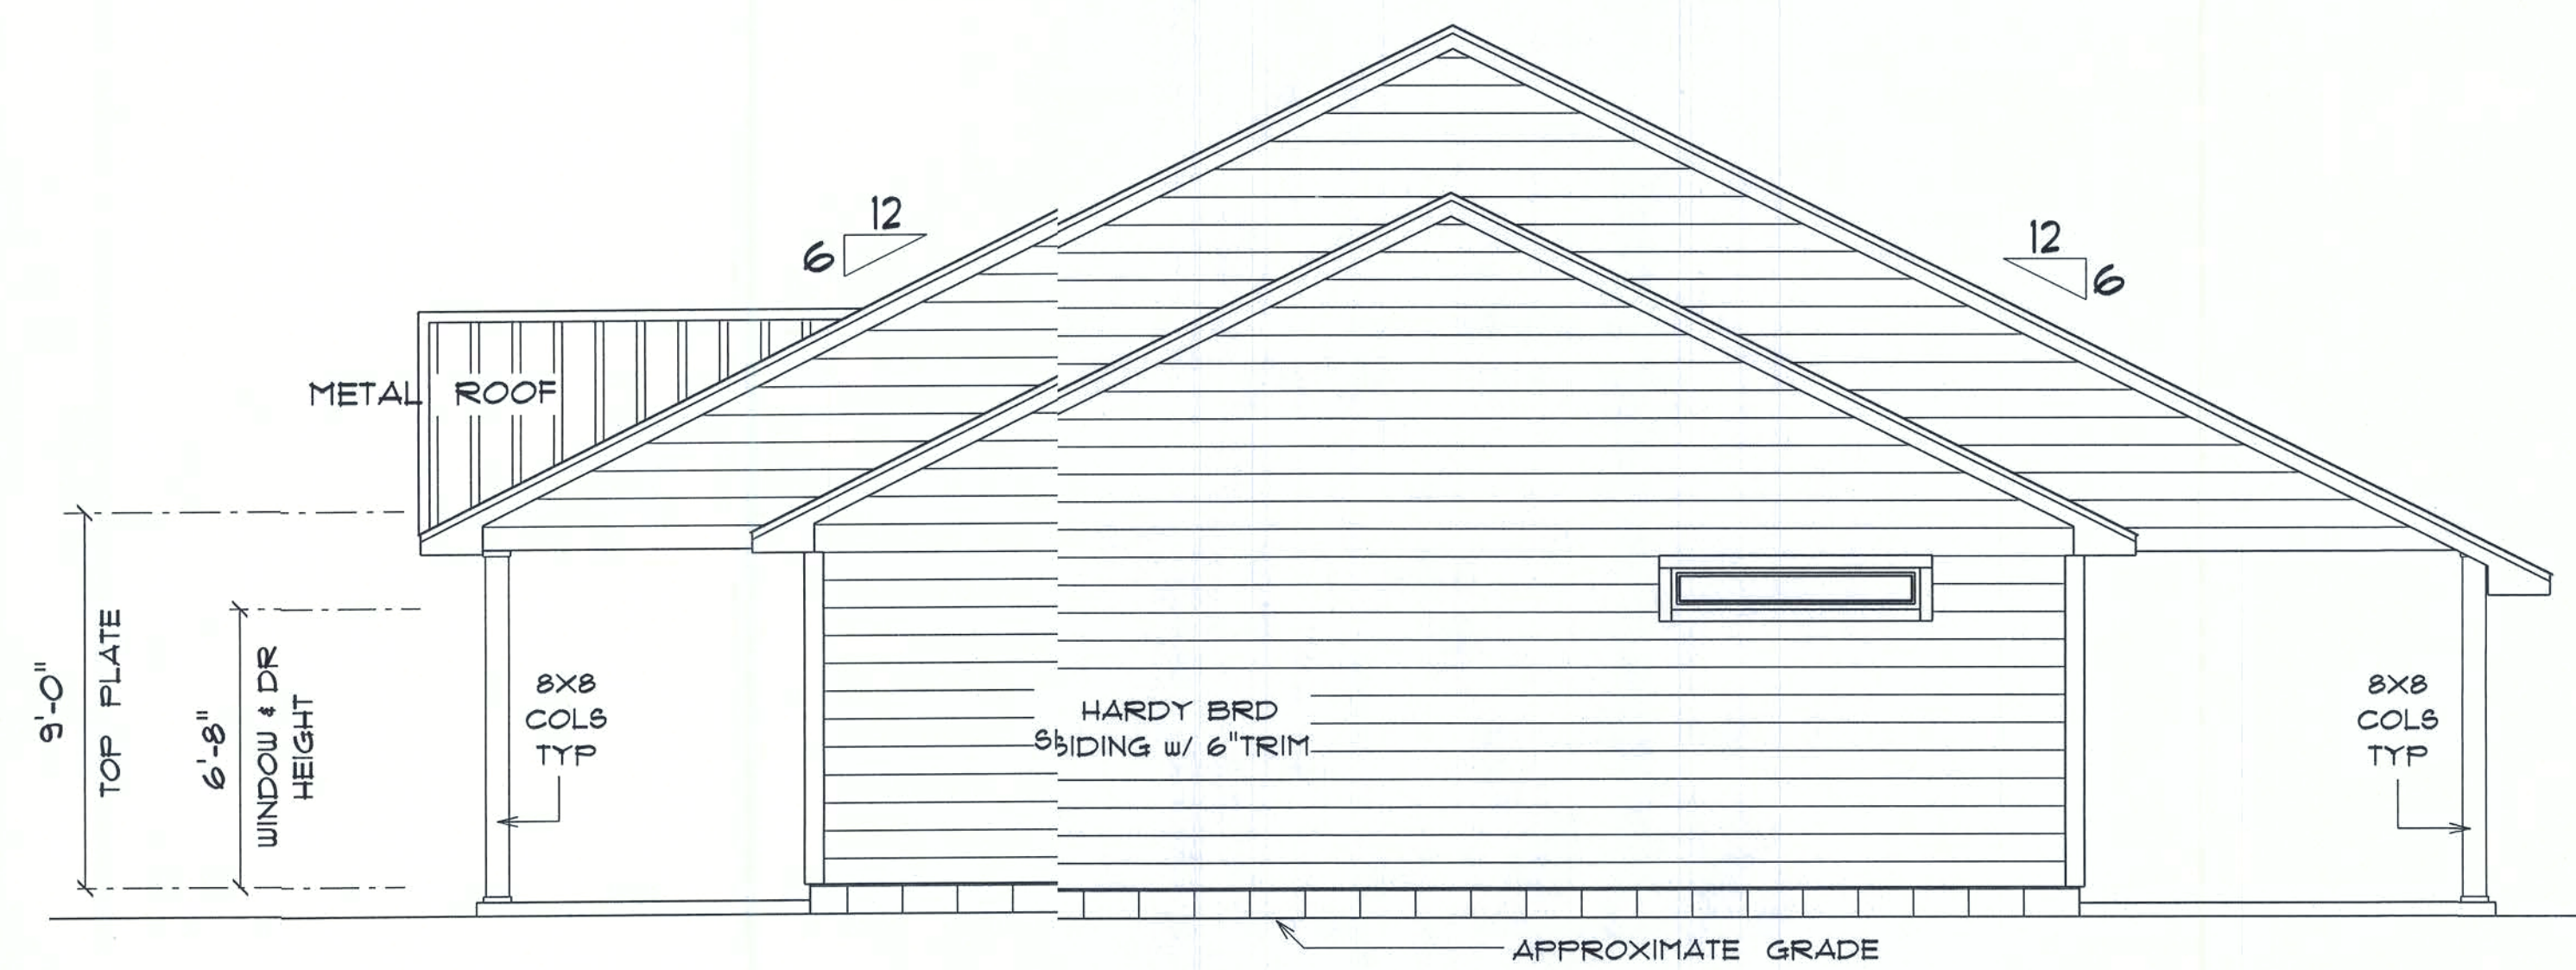

*** RIGHT SIDE ELEVATION ***

SCALE : 1/4" = 1'-0"

RESIDENCE
 for
MARCUS & BECKY
MATTHEWS

Tenna M. Ruffo
 255 SW SR 41
 Lake City Florida 32025
 Cell: (386) 861-1191
 Email: tennaruffo@gmail.com

PRINTED DATE:
 Tuesday, June 16, 2020

DRAWN BY: Tenna M. Ruffo CHECKED BY:

BUILDING CONTRACTOR

FINALS DATE:

JOB NUMBER:

DRAWING NUMBER


A-3

OF 5 SHEETS



*** REAR ELEVATION ***

SCALE : 1/4" = 1'-0"

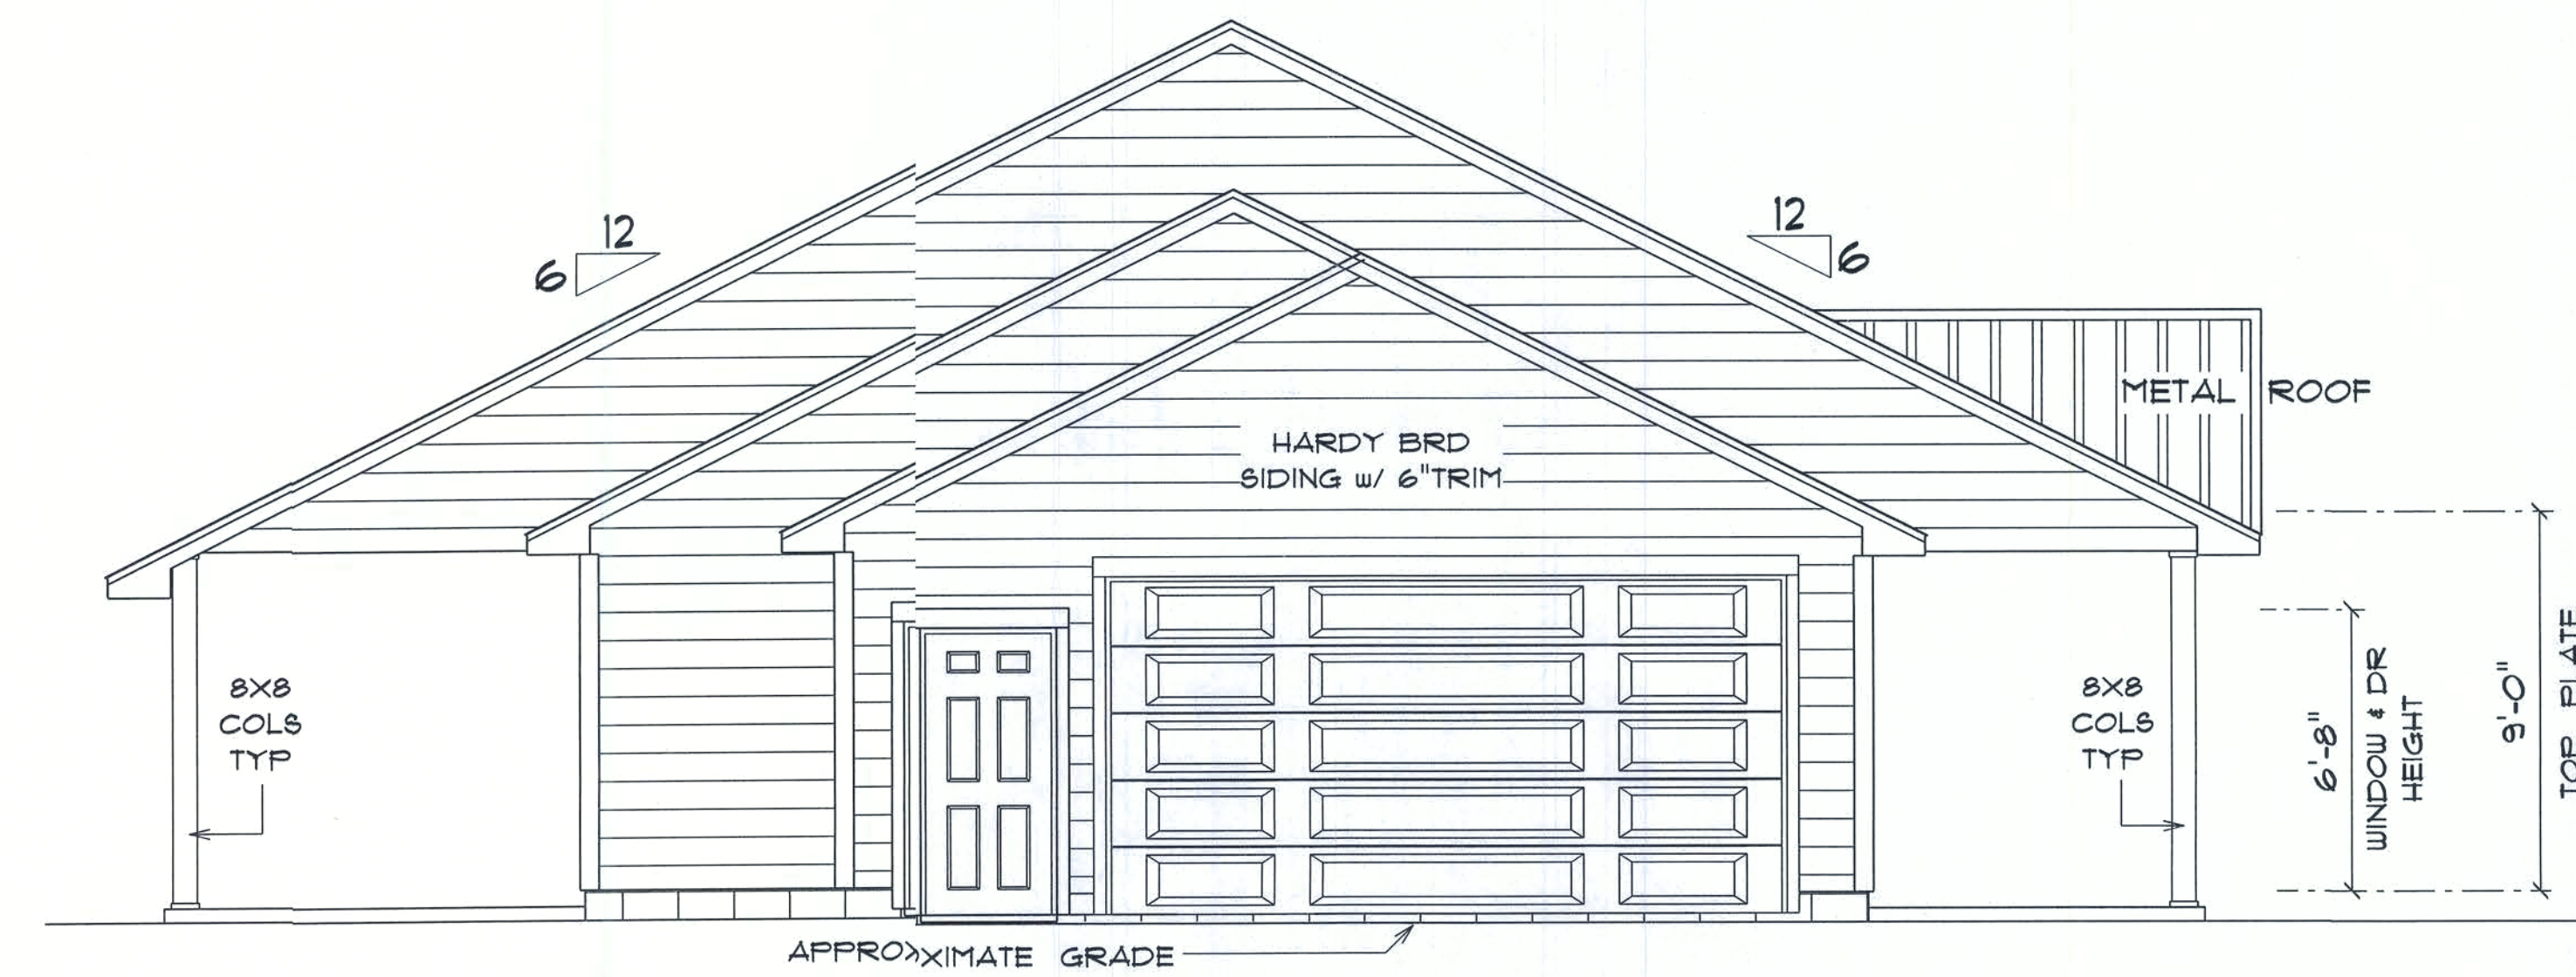

*** LEFT SIDE ELEVATION ***

SCALE : 1/4" = 1'-0"

RESIDENCE
for
MARCUS & BECKY
MATTHEWS

Teane M. Ruffo
2325 SW 5th St
Lake City, Florida, 32025
Cell: (386) 861-1181
Email: teanaruffo@gmail.com

PRINTED DATE:
Tuesday, June 16, 2020


DRAWN BY: Teane M. Ruffo
CHECKED BY:
BUILDING CONTRACTOR

FINAL DATE:

JOB NUMBER:

DRAWING NUMBER

A-4
OF 5 SHEETS

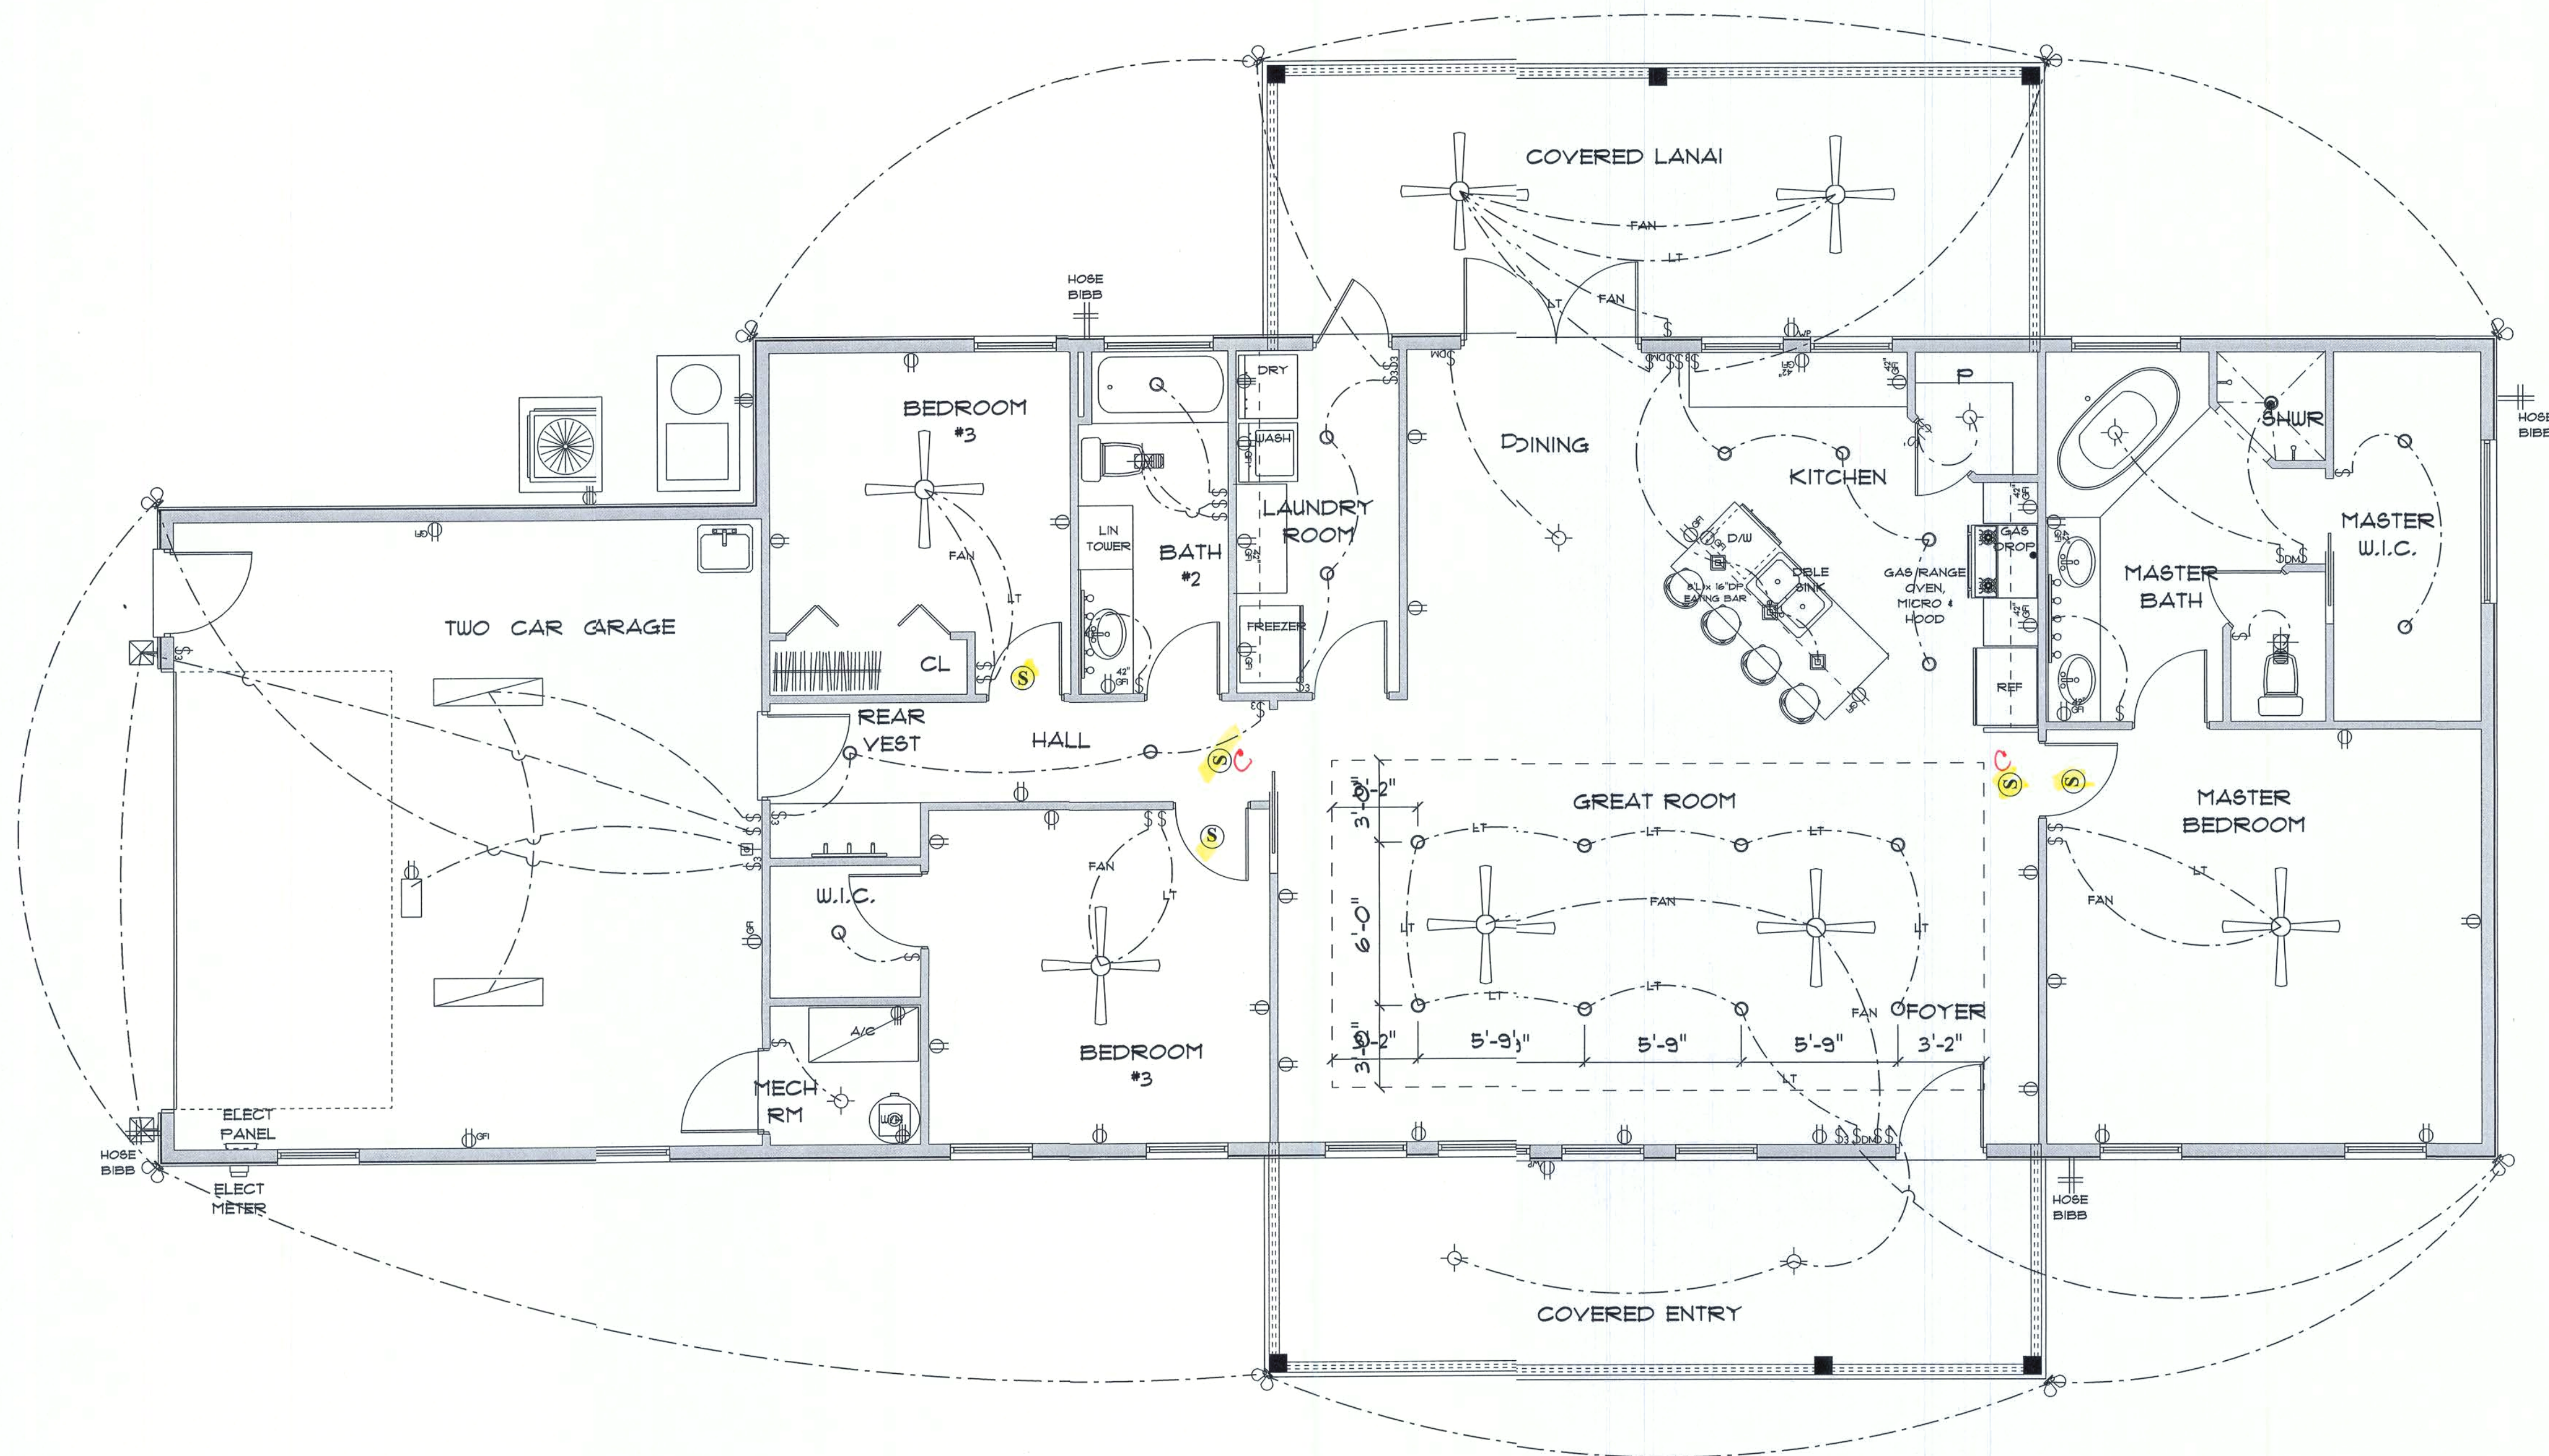

ELECTRICAL LEGEND		
ELECTRICAL	COUNT	SYMBOL
ceiling fan globe 01	7	
pendant large	3	
pot light	21	
exterior craftsman light fixture	2	
spotlight double	9	
Smoke Detector	5	
vanity bar light	2	
electrical meter	1	
electrical panel	1	
automatic garage dr opener	1	
dimmer switch	4	
garage dr opener	1	
jamb switch	1	
light	6	
outlet	23	
outlet 220v	5	
outlet gfi	16	
outlet wp	2	
switch	23	
switch 3 way	9	
vent light combo	2	
fluorescent light 1 x 4	2	

ELECTRICAL PLAN NOTE

- E-1 WIRE ALL APPLIANCES, HVAC UNITS AND OTHER EQUIPMENT PER MANUFACTURER'S SPECIFICATIONS.
- E-2 ALL INSTALLATIONS SHALL BE PER NATIONAL ELECTRIC CODE.
- E-3 ALL SMOKE /CARBON MONOXIDE DETECTORS SHALL BE 120V W/BATTERY BACKUP OF THE PHOTOELECTRIC TYPE, AND SHALL BE INTERLOCKED TOGETHER, INSTALL INSIDE AND NEAR ALL BEDROOMS AS PER CODE.
- E-4 TELEPHONE, TELEVISION AND OTHER LOW VOLTAGE DEVICES OR OUTLETS SHALL BE AS PER THE OWNER'S DIRECTION AND IN ACCORDANCE WITH APPLICABLE SECTIONS OF NATIONAL ELCT. CODE LATEST EDITION.
- E-5 ELECTRICAL CONTRACTOR SHALL BE RESPONSIBLE FOR THE DESIGN AND SIZING OF ELECTRICAL SERVICE AND CIRCUITS.
- E-6 ENTRY OF SERVICE UNDERGROUND OR OVERHEAD IS TO BE DETERMINED BY THE POWER COMPANY.
- E-7 ALL BEDROOM RECEPTALS ARE TO BE AFCI (ARC FAULT CIRCUIT INTERRUPT)
- E-8 15% OF ALL PERMANENT LIGHTS TO BE ENERGY EFFICIENT.

* ELECTRICAL PLAN *

SCALE : 1/4" = 1'-0"

RESIDENCE
for
MARCUS & BECKY
MATTHEWS

Teresa M. Ruffo
2925 SW 8th St
Lake City, Florida, 32025
Cell: (386) 861-1181
Email: teresaruffo@gmail.com

PRINTED DATE:
Tuesday, June 16, 2020

DRAWN BY: Teresa M. Ruffo

CHECKED BY:

BUILDING CONTRACTOR:

FINALS DATE:

JOB NUMBER:

DRAWING NUMBER

A-5

OF 5 SHEETS