




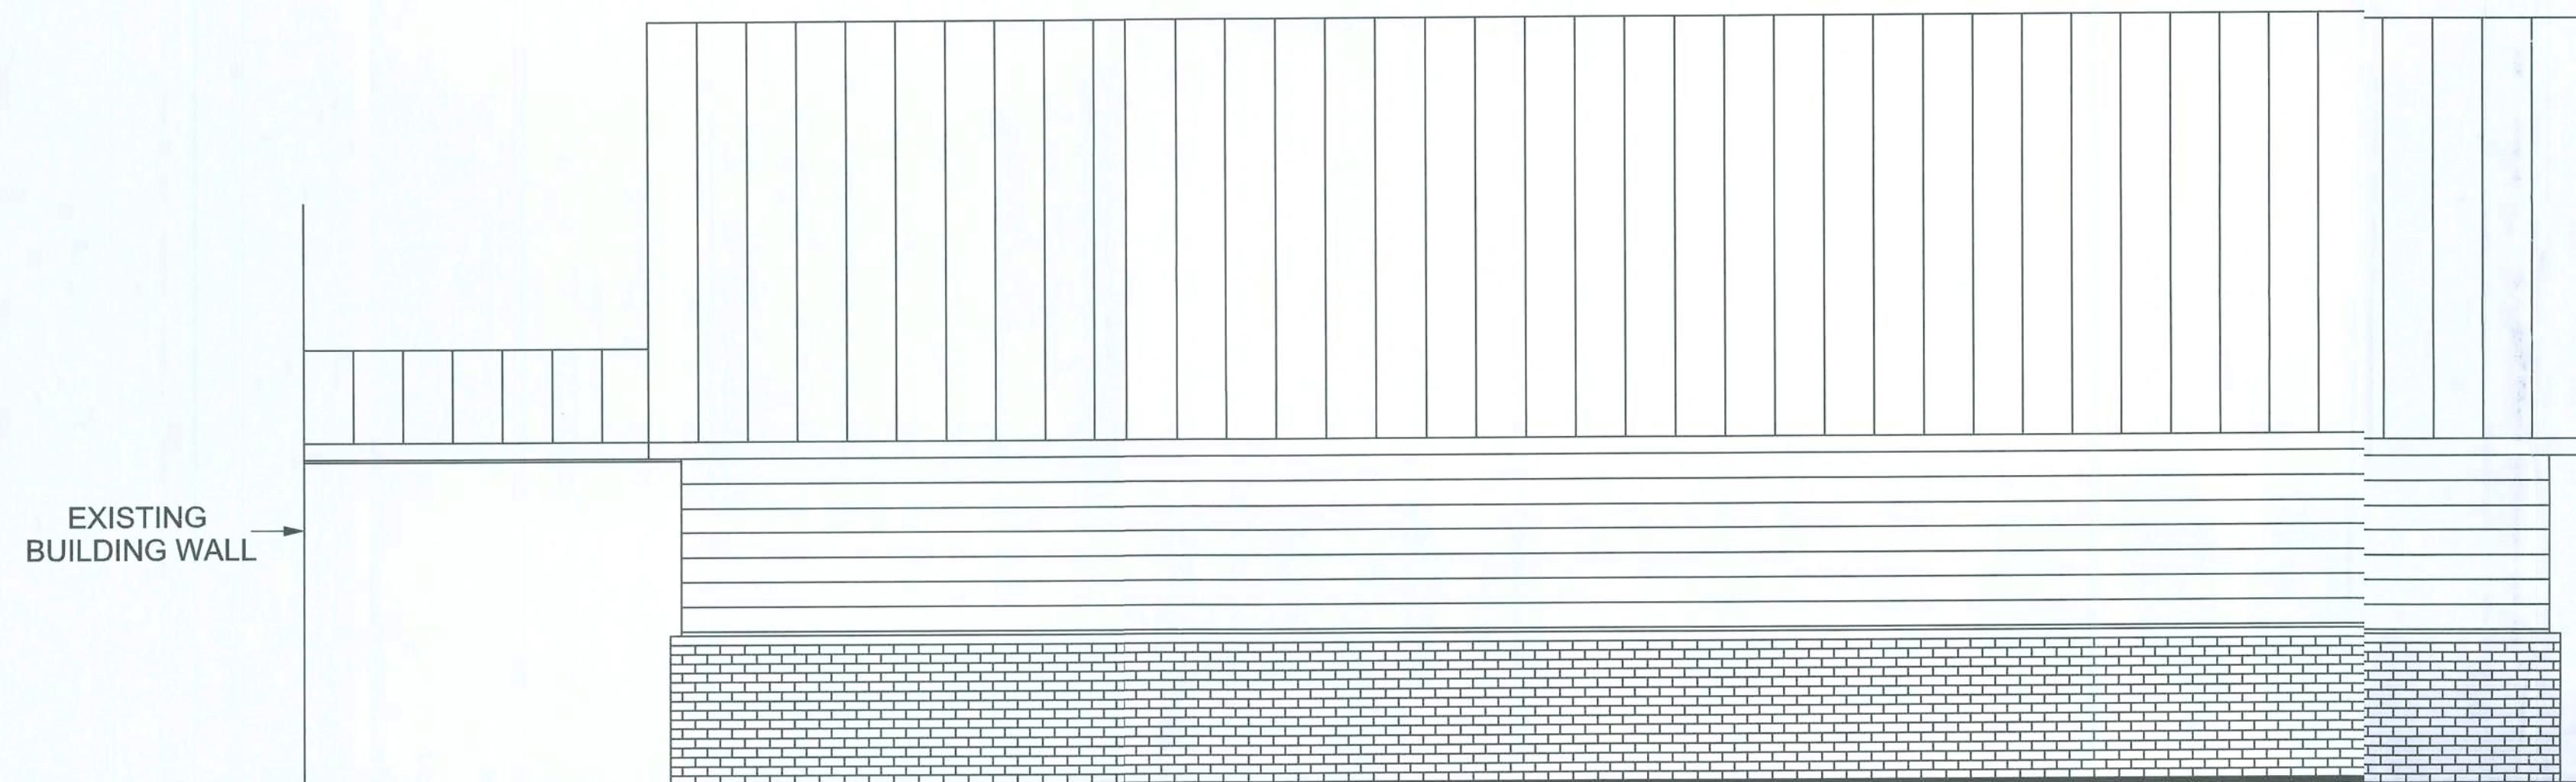


RIGHT ELEVATION

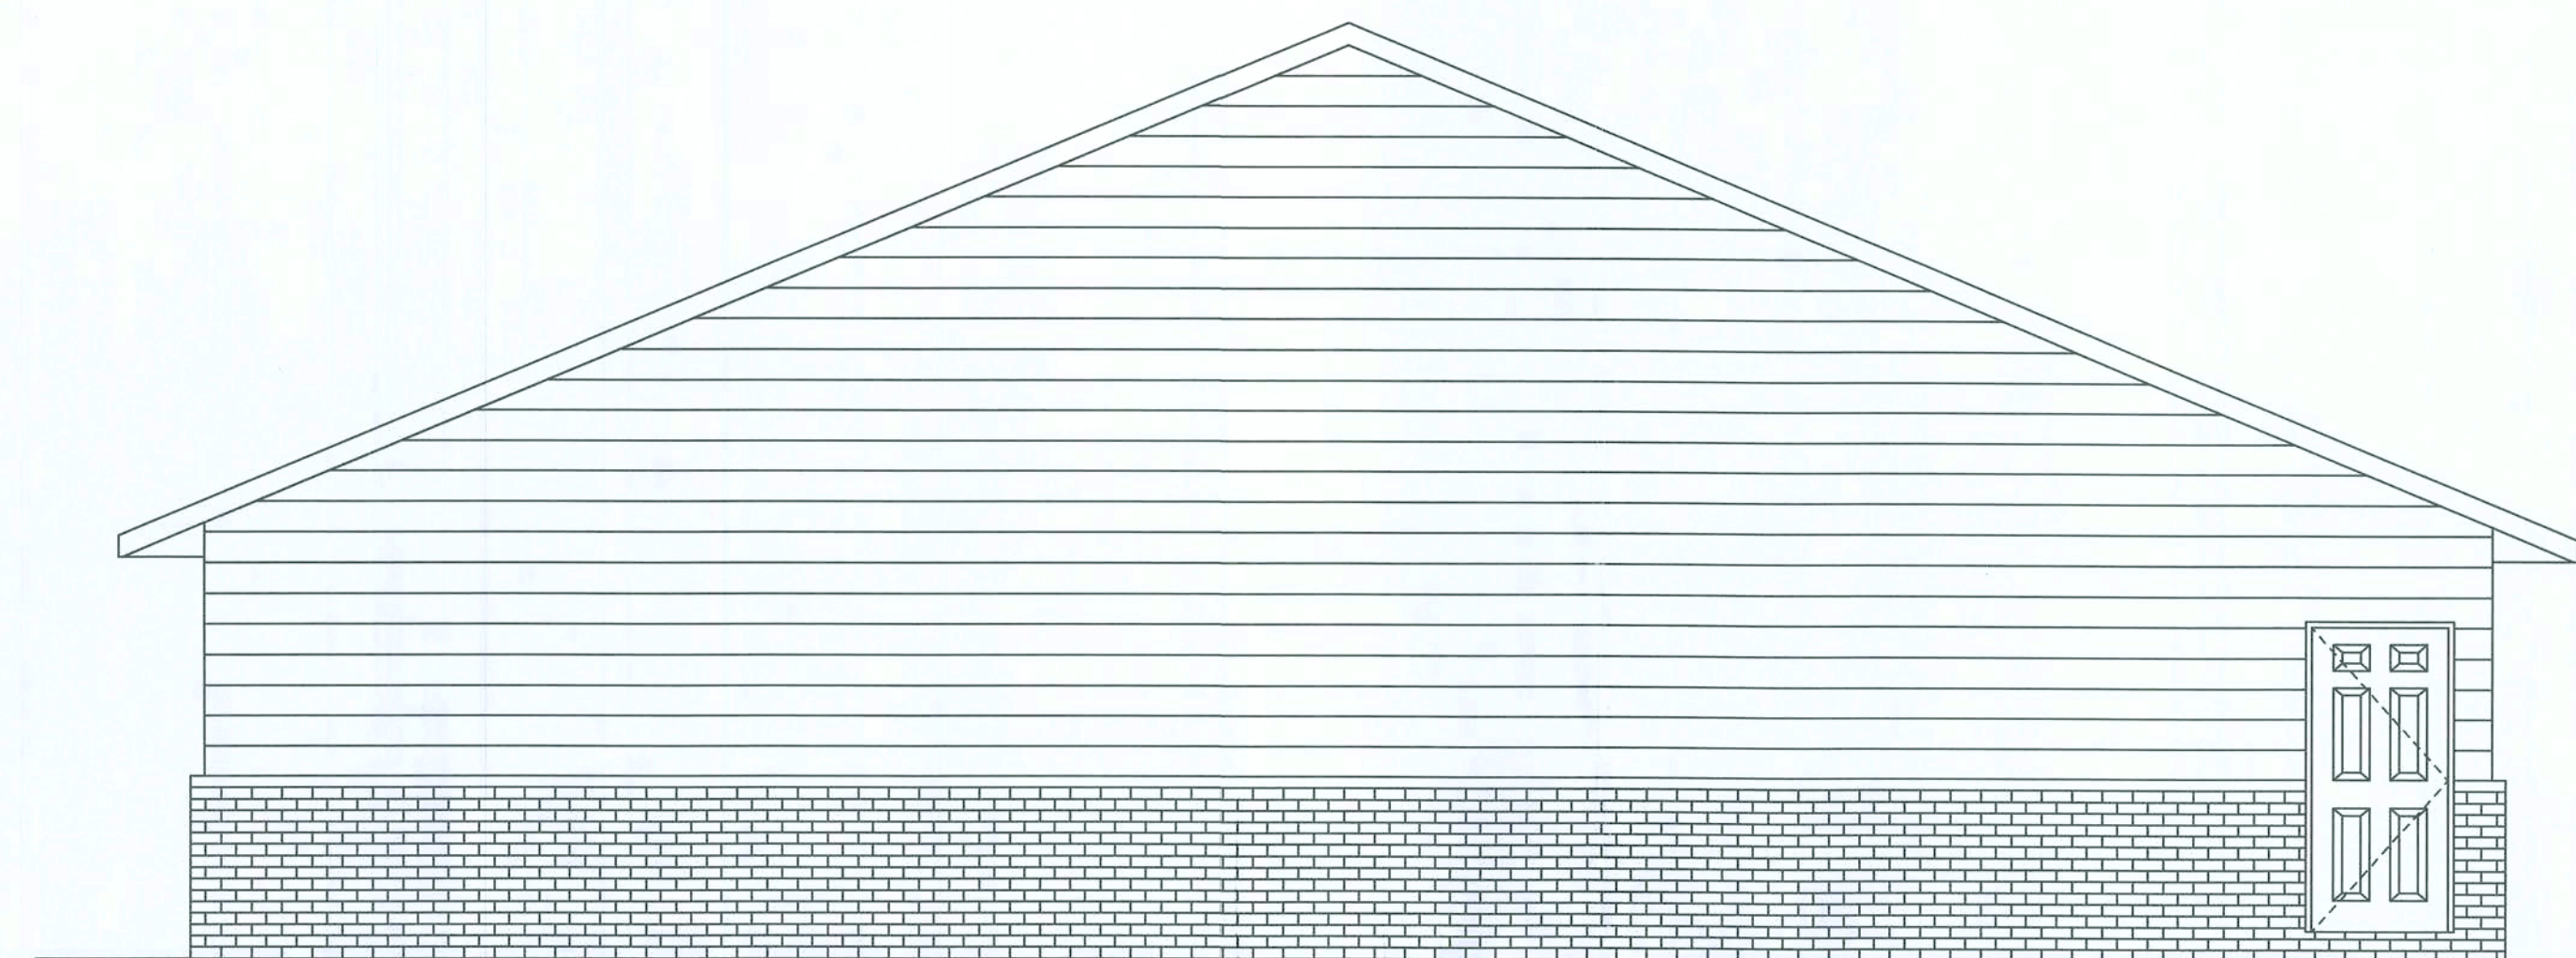



REAR ELEVATION

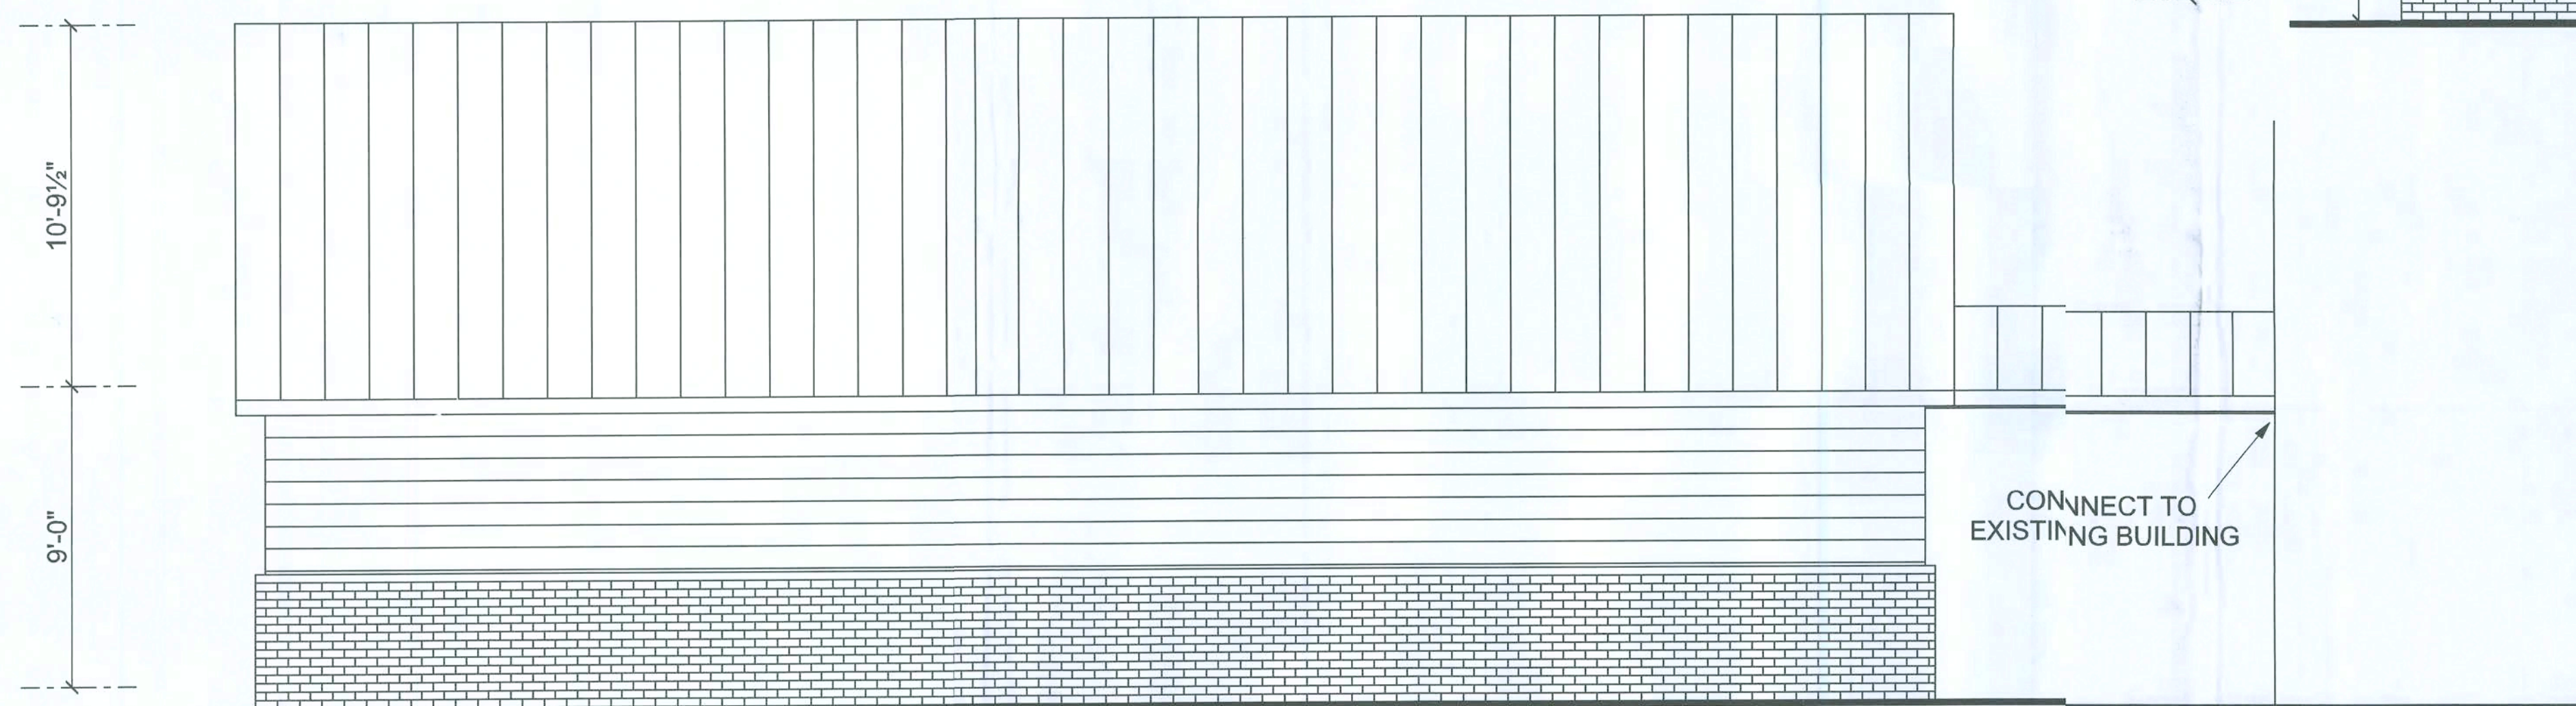

LEFT ELEVATION

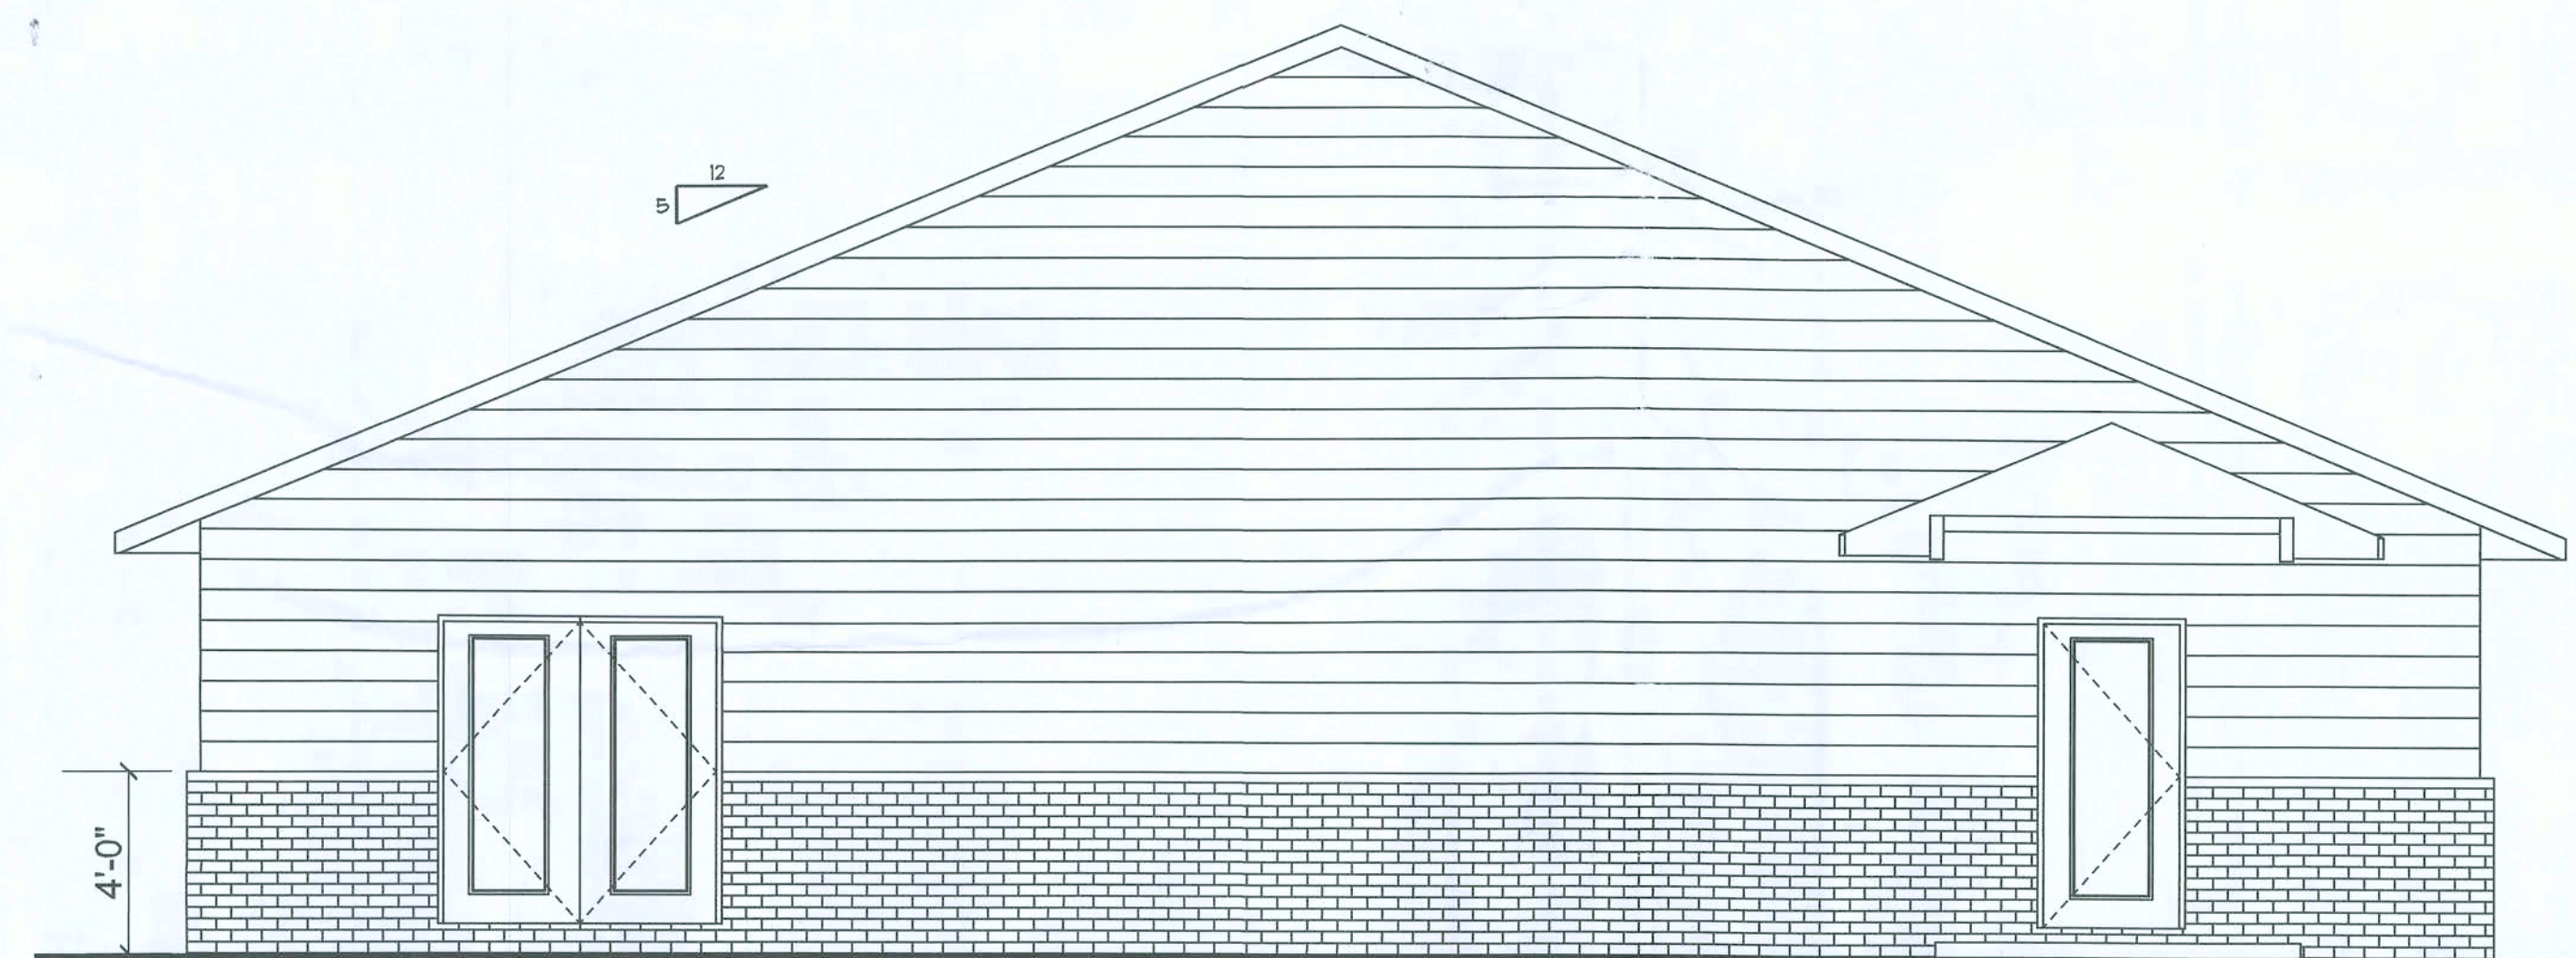

FRONT ELEVATION

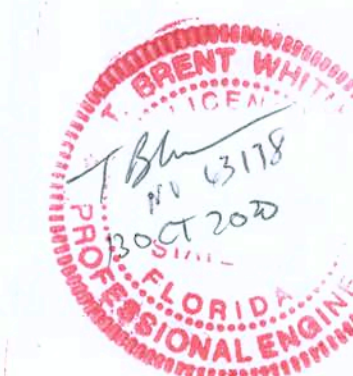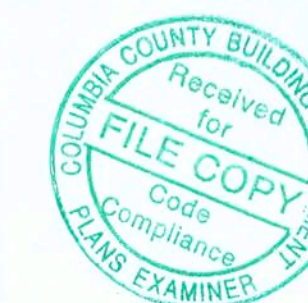

DRAWN BY:
JASON ELIXSON CONSTRUCTION, LLC
7490 WEST CR. 18
LAKE BUTLER, FL. 32054
(386) 623-1741

CONNECT CHURCH


COLUMBIA CO.

ELEVATIONS
1/4" = 1 FOOT

A1

SOFTPLAN
ARCHITECTURAL DESIGN SOFTWARE

It is important that the Client and Contractor examine the drawings and documentation in detail. It shall be the final responsibility of the Contractor to review and double check the plans for accuracy and compliance with regulatory agencies. It is customary and ordinary not to include details well within the knowledge of licensed Contractor. If necessary, further clarification of these plans should be achieved before signing the construction contract and obtaining a building permit, otherwise the Contractor assumes responsibility for the construction in question. Methods of construction shall be determined by the Contractor.

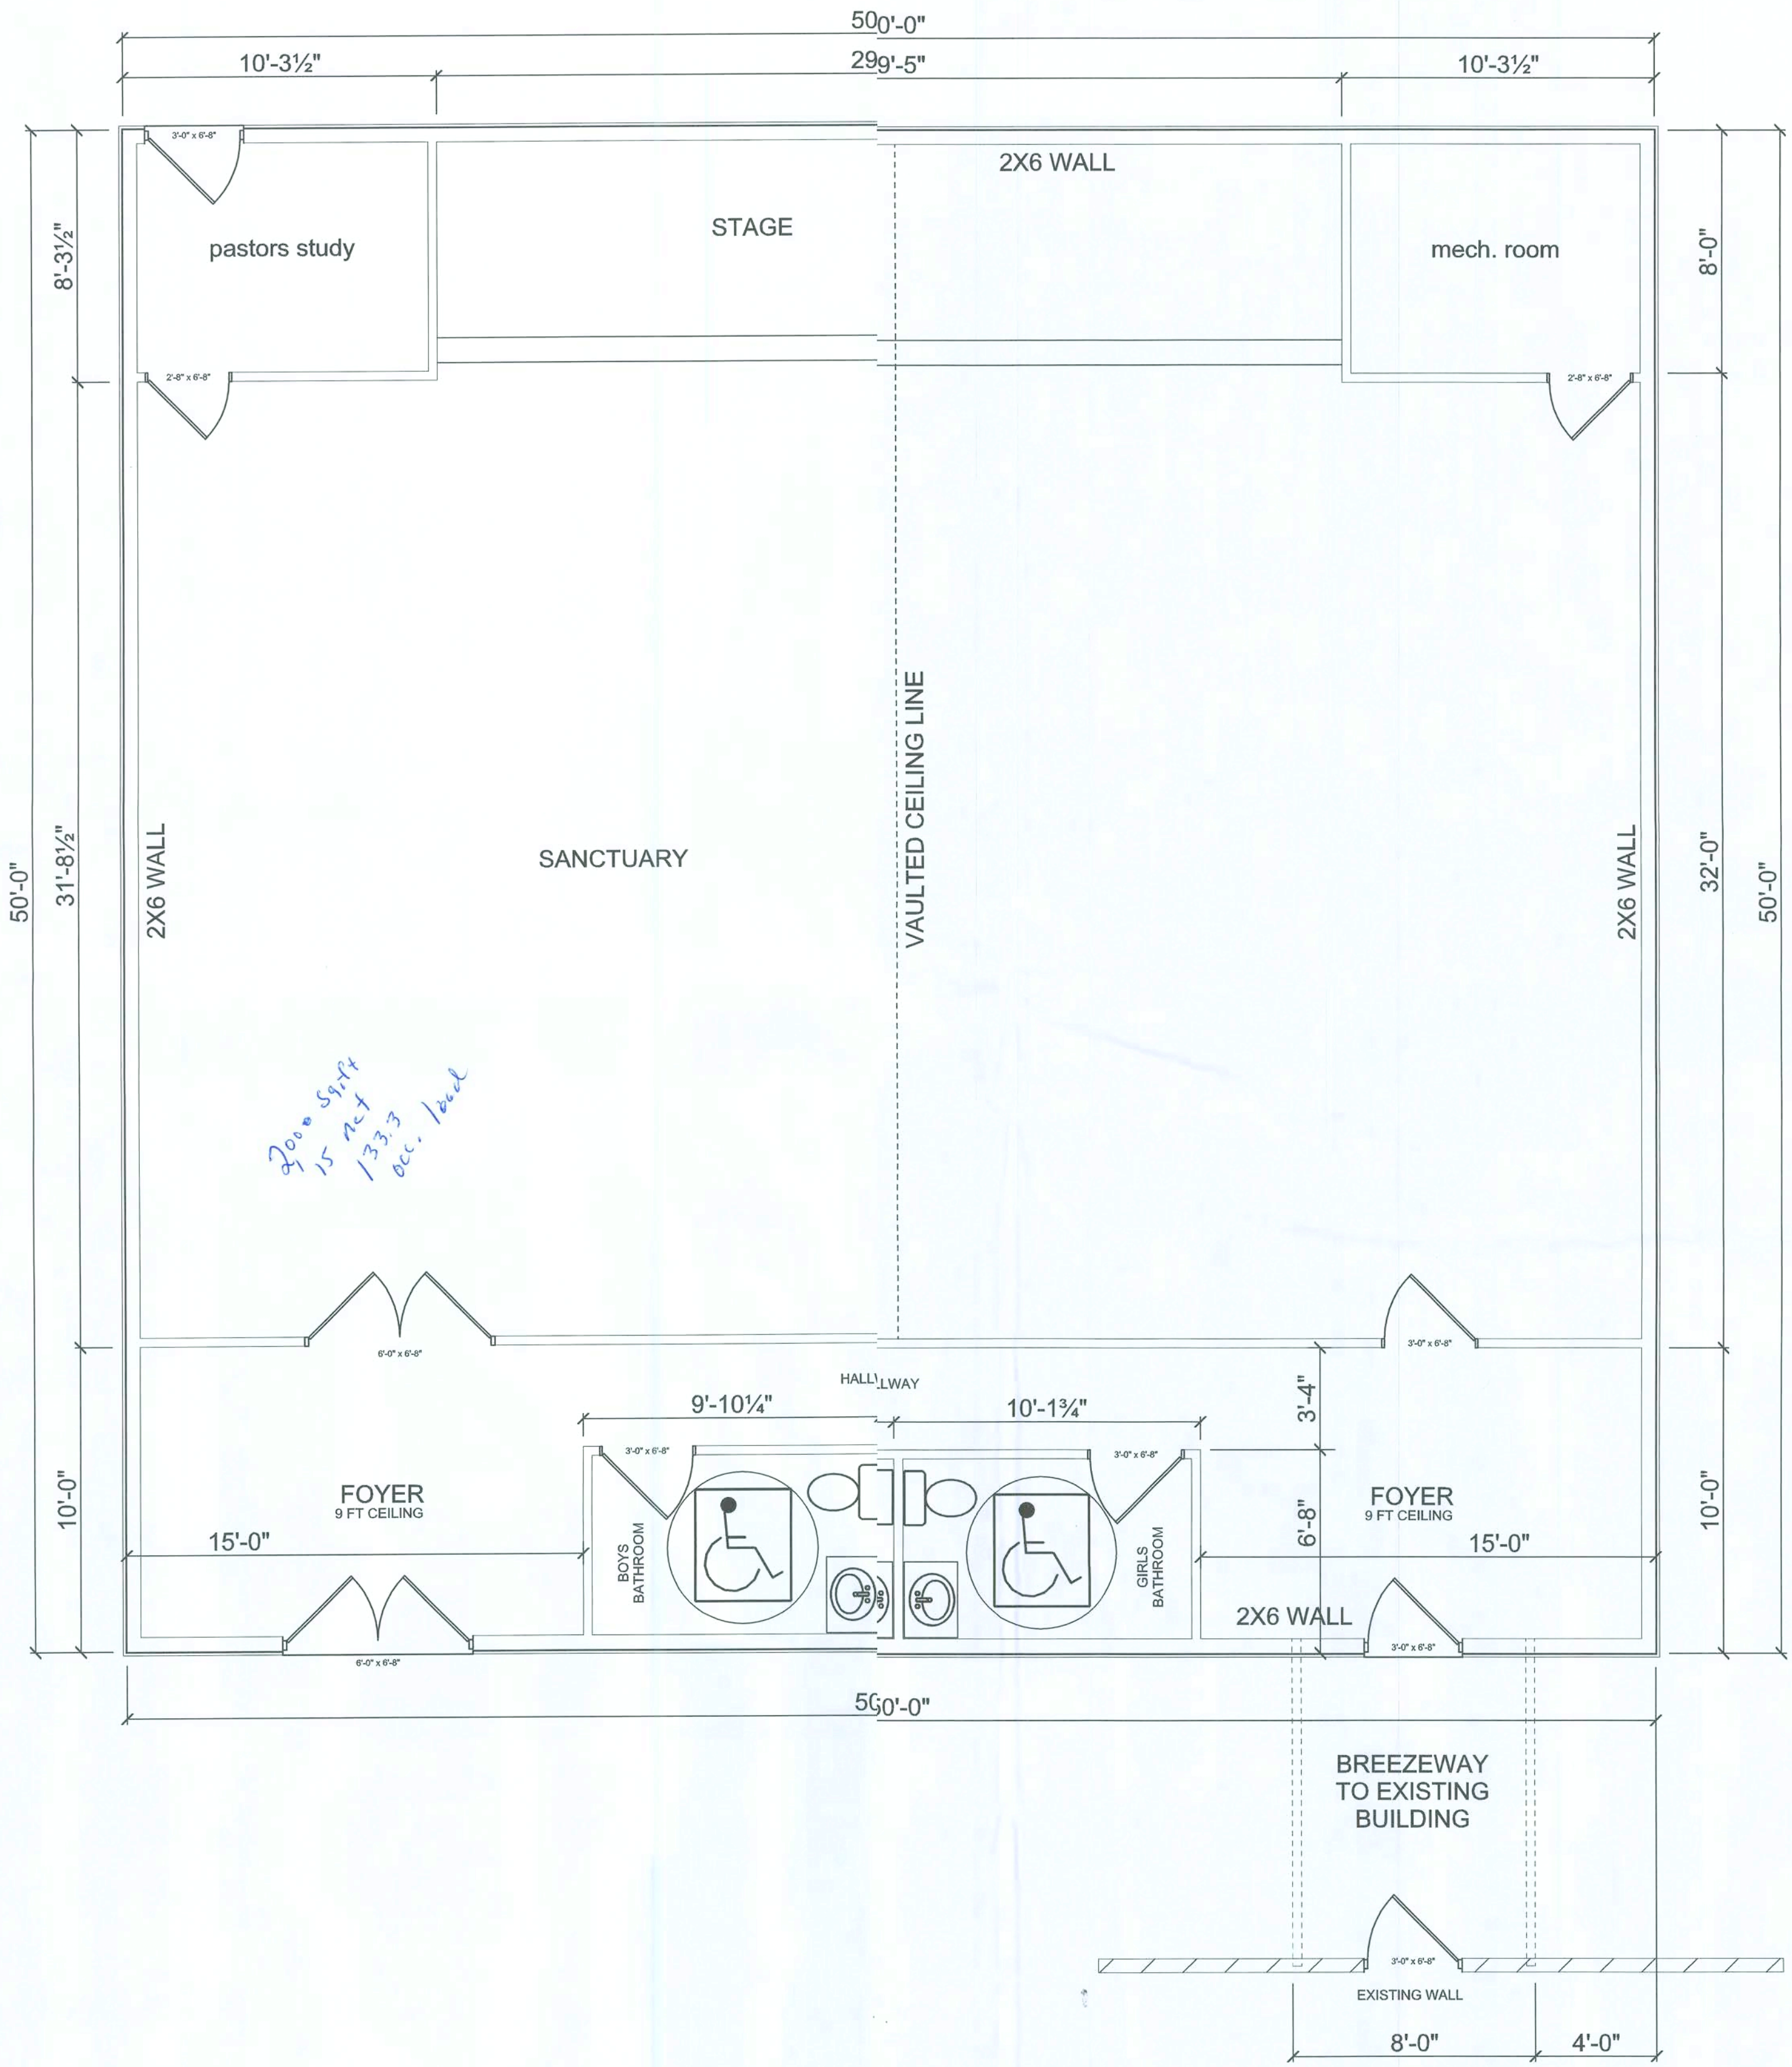


AREA SCHEDULE	
NAME	AREA
SANCTUARY	2500 sq ft.
BREEZEWAY	80 sq ft.
TOTAL	2580 sq ft.

FLOOR PLAN



DRAWN BY: JASON ELIXSON CONSTRUCTION, LLC 7490 WEST CR. 18 LAKE BUTLER, FL. 32054 (386) 623-1741	CONNECT CHURCH	FLOOR PLAN 1/4" = 1 FOOT	A2
	COLUMBIA CO.		

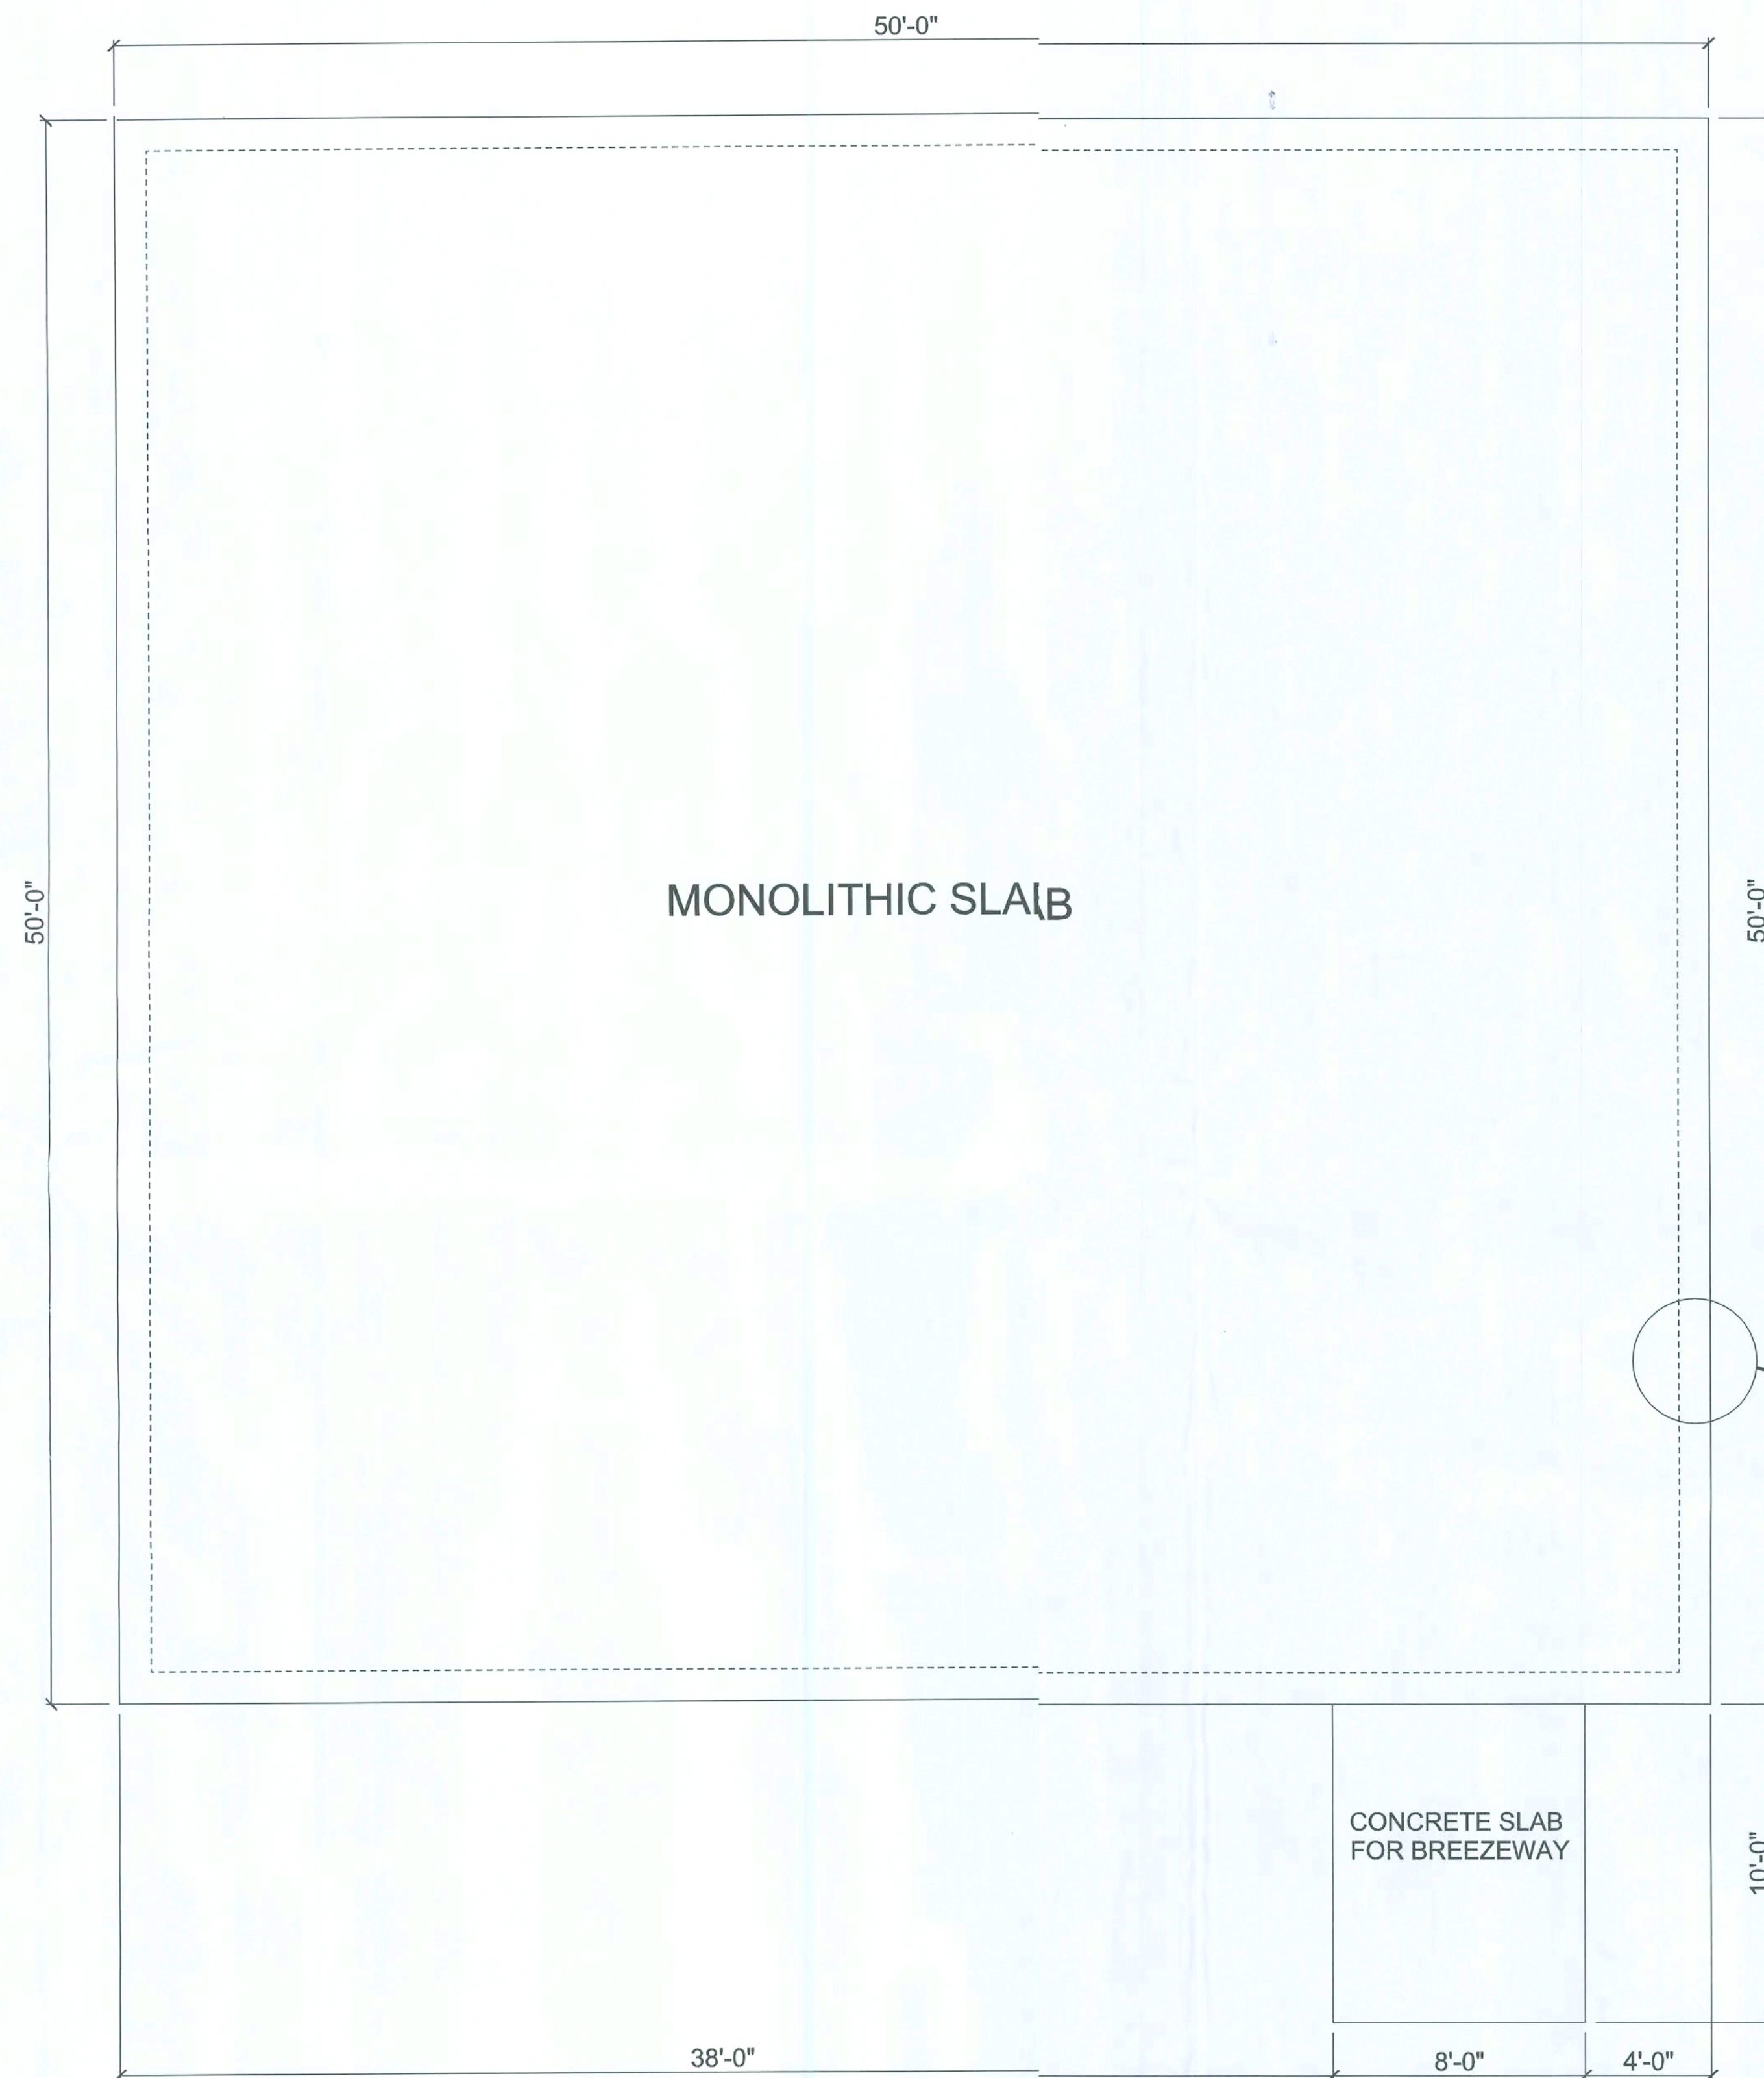



FOUNDATION PLAN

FOUNDATION NOTES

1. Footing trenches and the area within the foundation walls shall be free of all deleterious material.
2. All reinforcing rods shall be Grade 40 (40,000 p.s.i.) #5 deformed bars with a 25" min. lap and placed on support chairs @ 6" o.c.
3. All concrete for slabs, pads, and walkways shall be 2500 p.s.i. minimum at 28 days. Concrete for downpours and bond beams shall be 3000 p.s.i. (pea gravel mix).
4. Provide 6 mil vapor barrier under all concrete slabs with joints lapped 6" and taped.
5. Slab reinforcing shall be 6 X 6 #10/10 welded wire fabric (steel), edge lap 6" and tied.
6. All fill dirt shall be clean sand, free of deleterious material and laid in 12" lifts. Each lift to be wetted and compacted prior to next lift.
7. All fill dirt within the foundation walls shall be termite treated and according to the standards of the National Pest Control Association with a minimum one year warranty.
8. Slope all exterior slabs and garage floor slab for proper drainage.

TYPICAL FOUNDATION WALL
8" CONCRETE BLOCK STEM WALL ON 20"X10"
POURED CONCRETE FOOTING REINFORCED WITH
SHOP BENT ELBOWS ON CORNERS
TO PROVIDE MIN. 25" LAP

TYPICAL FLOOR SLAB
4" CONCRETE FLOOR SLAB REINFORCED WITH
6X6-10/10 WELDED WIRE MESH PLACED OVER
6-MIL POLYETHYLENE VAPOR BARRIER
OVER COMPACTED AND TERMITE-TREATED
CLEAN FILL

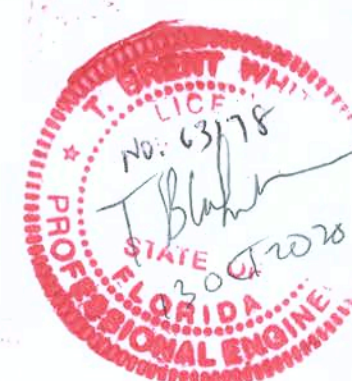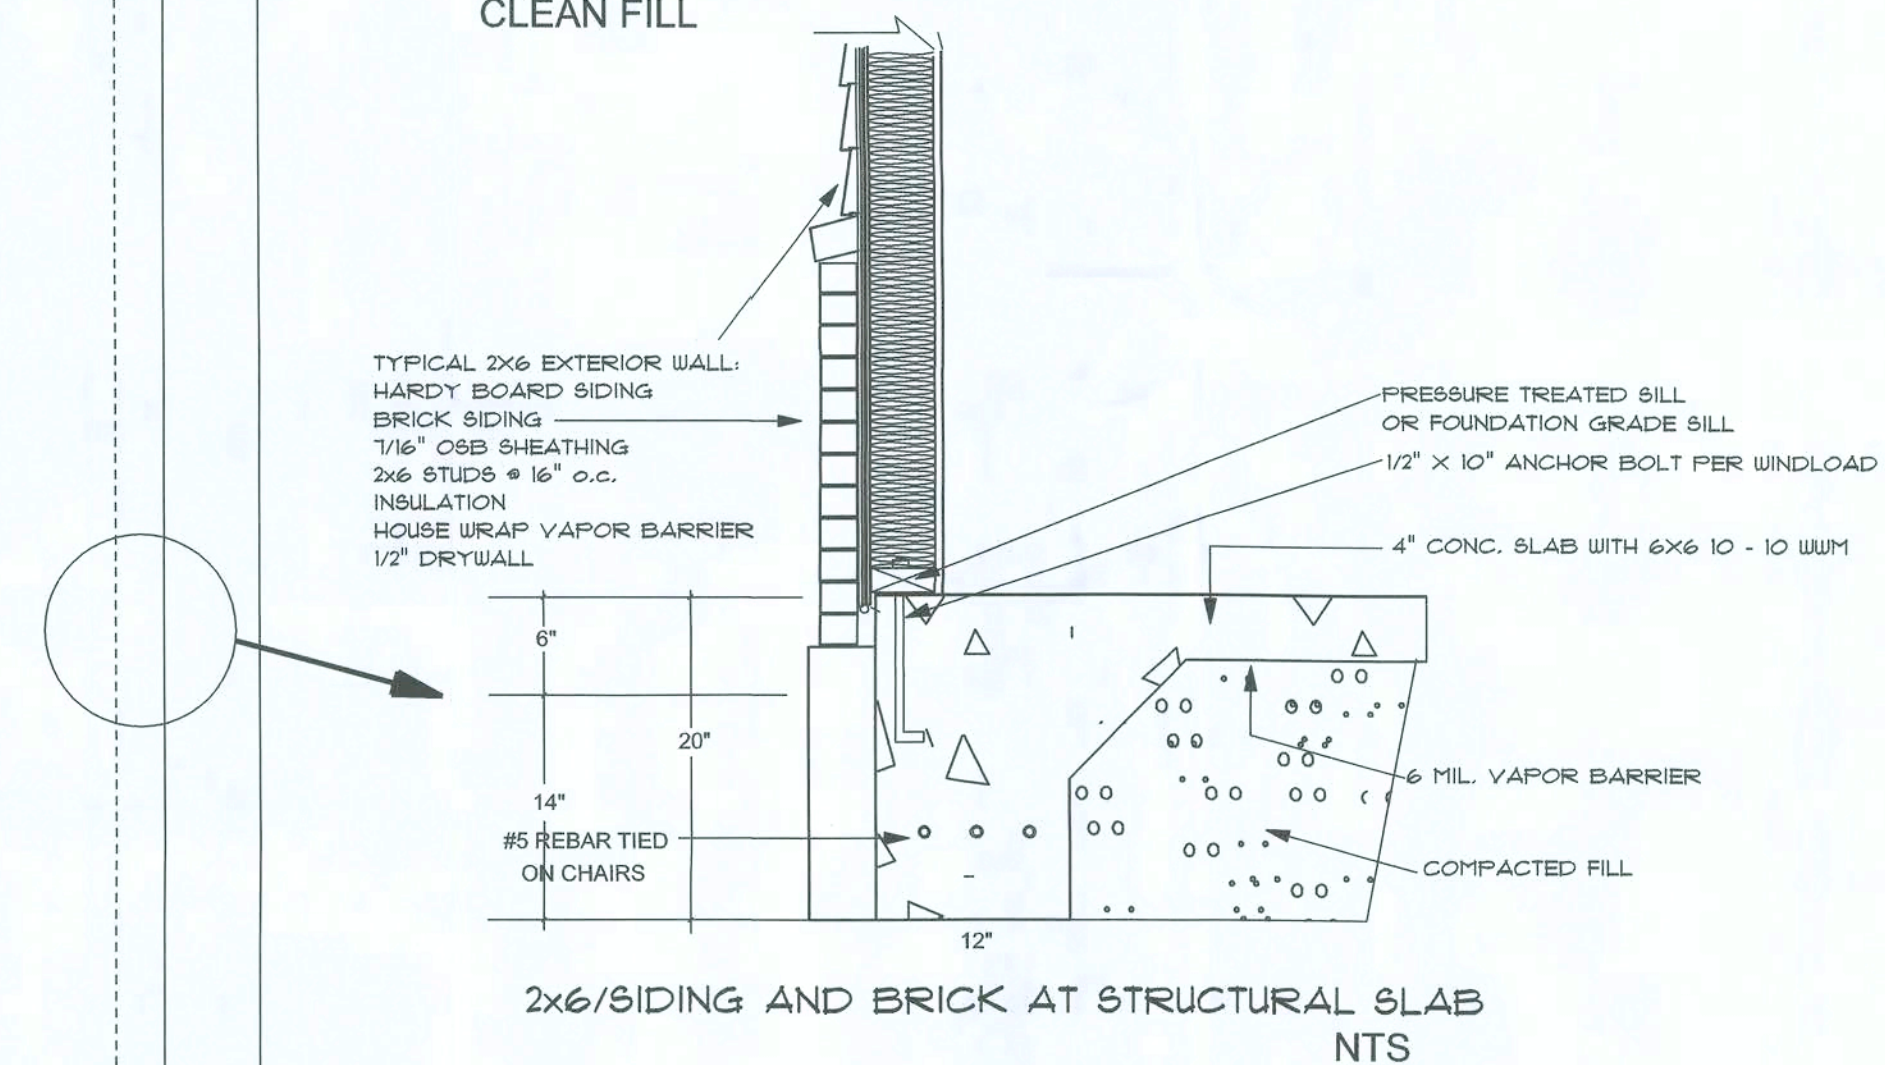

CONNECT CHURCH

FOUNDATION

1/4" = 1 FOOT


A3

DRAWN BY:

JASON ELIXSON CONSTRUCTION, LLC
7490 WEST CR. 18
LAKE BUTLER, FL. 32054
(386) 623-1741


COLUMBIA CO.

SOFTPLAN
ARCHITECTURAL DESIGN SOFTWARE

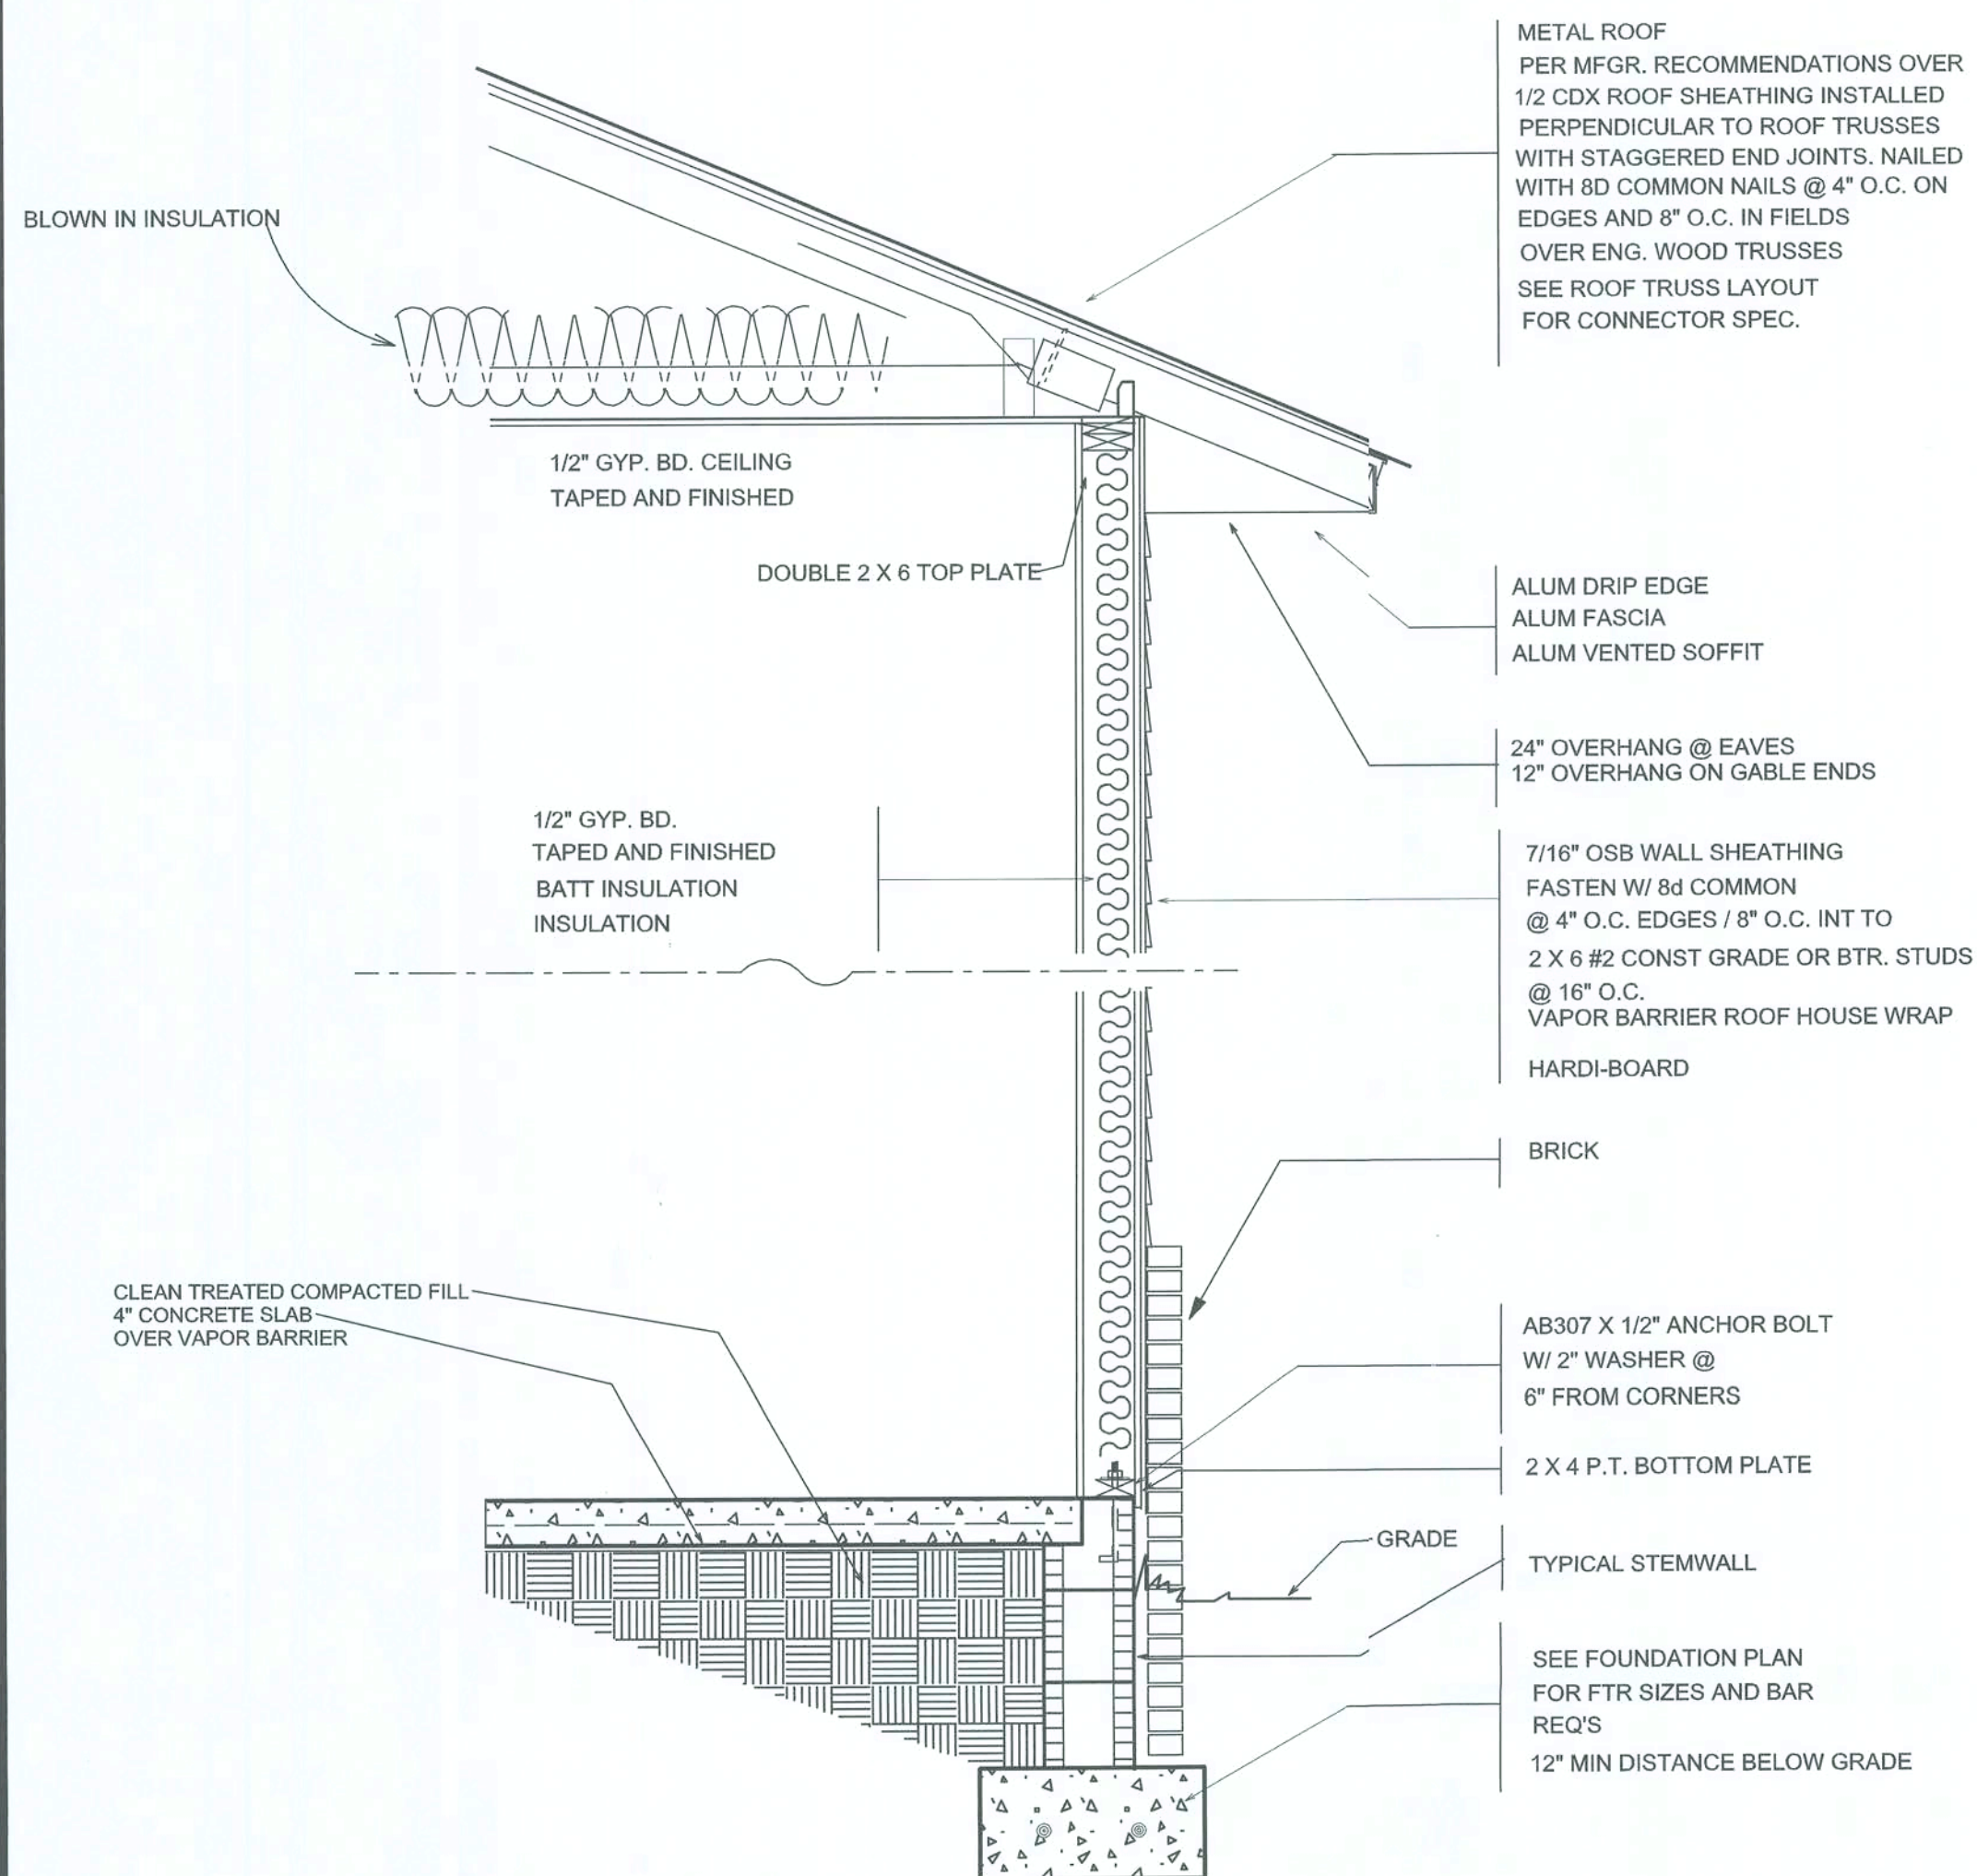

TYPICAL WALL SECTION

NT:

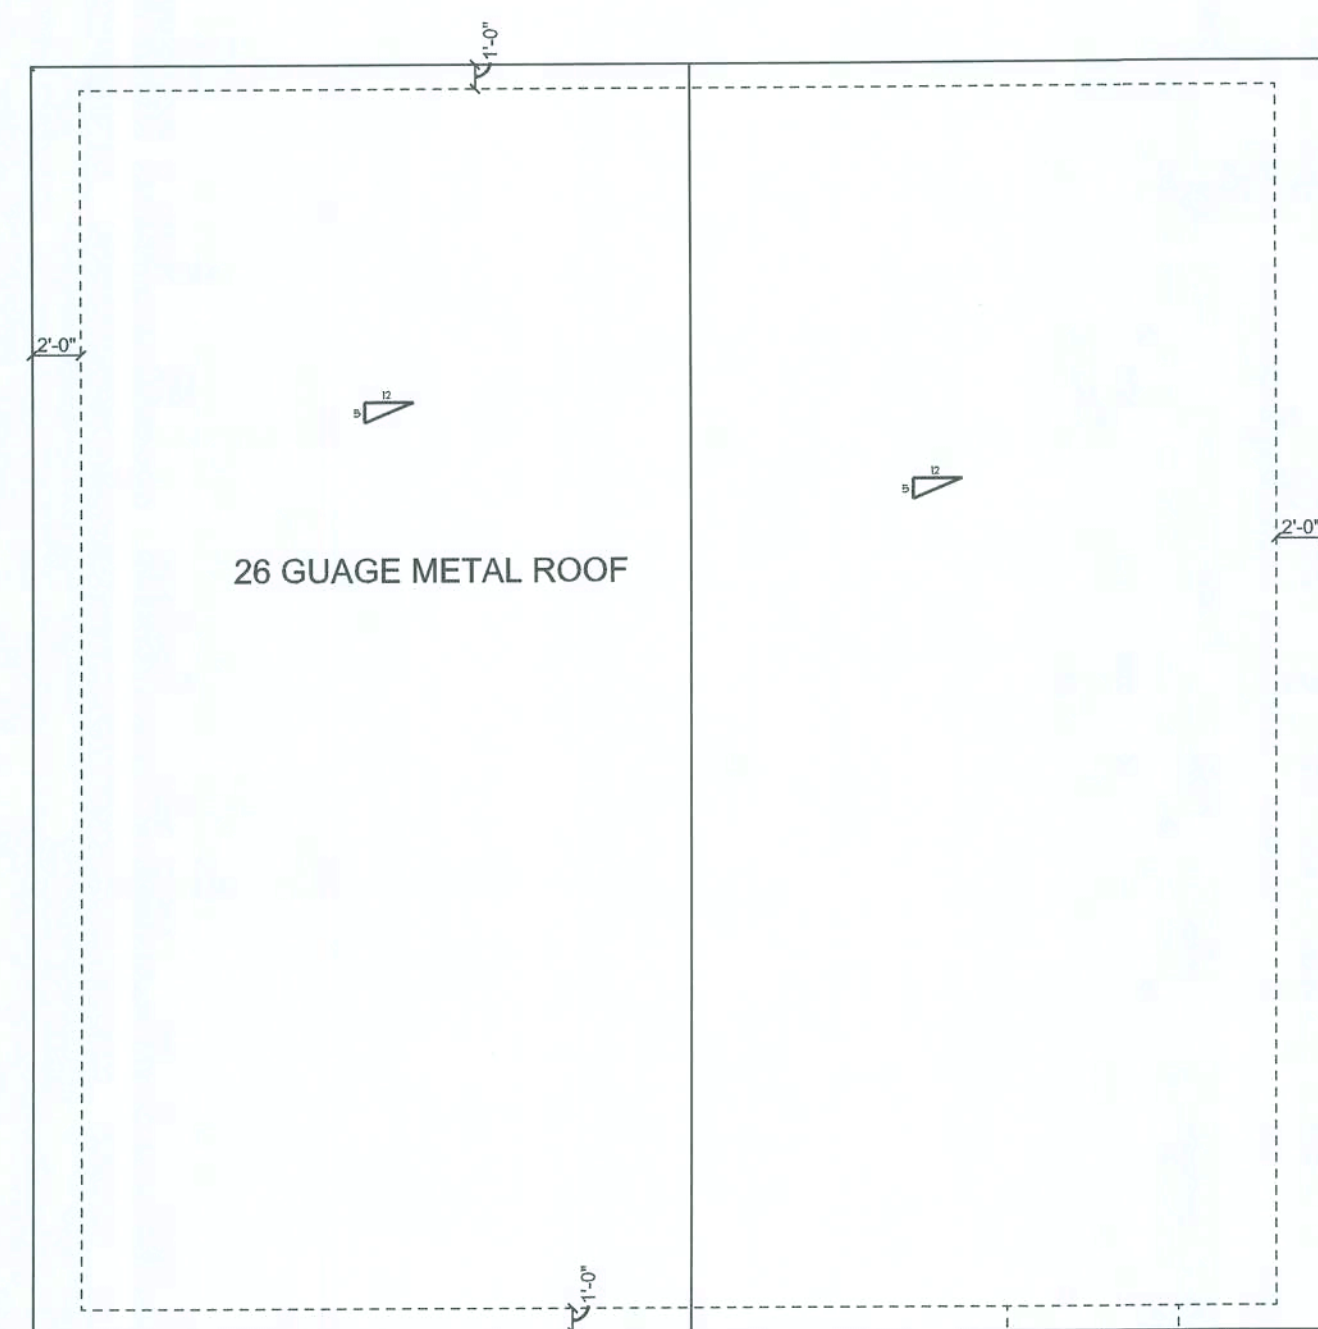

ROOF PLAN

1/8"=1 FOOT

ELECTRICAL LEGEND	
ELECTRICAL	SYMBOL
fluorescent light 2 x 4	
pot light	
flood light	
fan	
light	
outlet	
outlet 220v	
outlet gfi	
outlet wp	
switch	
switch 3 way	
switch 4 way	

WIRE ALL APPLIANCES, HVAC UNIT AND OTHER
EQUIPMENT PER MANUFACTURER SPECS ;


INSTALLATION SHALL BE PER NATIONAL ELECTRIC CODE

TELEPHONE, T.V. AND OTHER LOW VOLTAGE
DEVICES OR OUTLETS SHALL BE AS PER THE OWNERS
DIRECTIONS AND IN ACCORDANCE WITH APPLICABLE
SECTIONS OF NEC-LATEST EDITIONS

ALL SMOKE DETECTORS SHALL BE 120V WITH BATTERY
BACKUP OF THE PHOTOELECTRIC TYPE, AND SHALL BE
INTERLOCKED TOGETHER

ALL MATERIAL SHALL HAVE A UL LABEL OFR LISTING

ALL BEDROOM OUTLETS TO BE ARC-FAULT BREAKERS
OR GFI OUTLETS

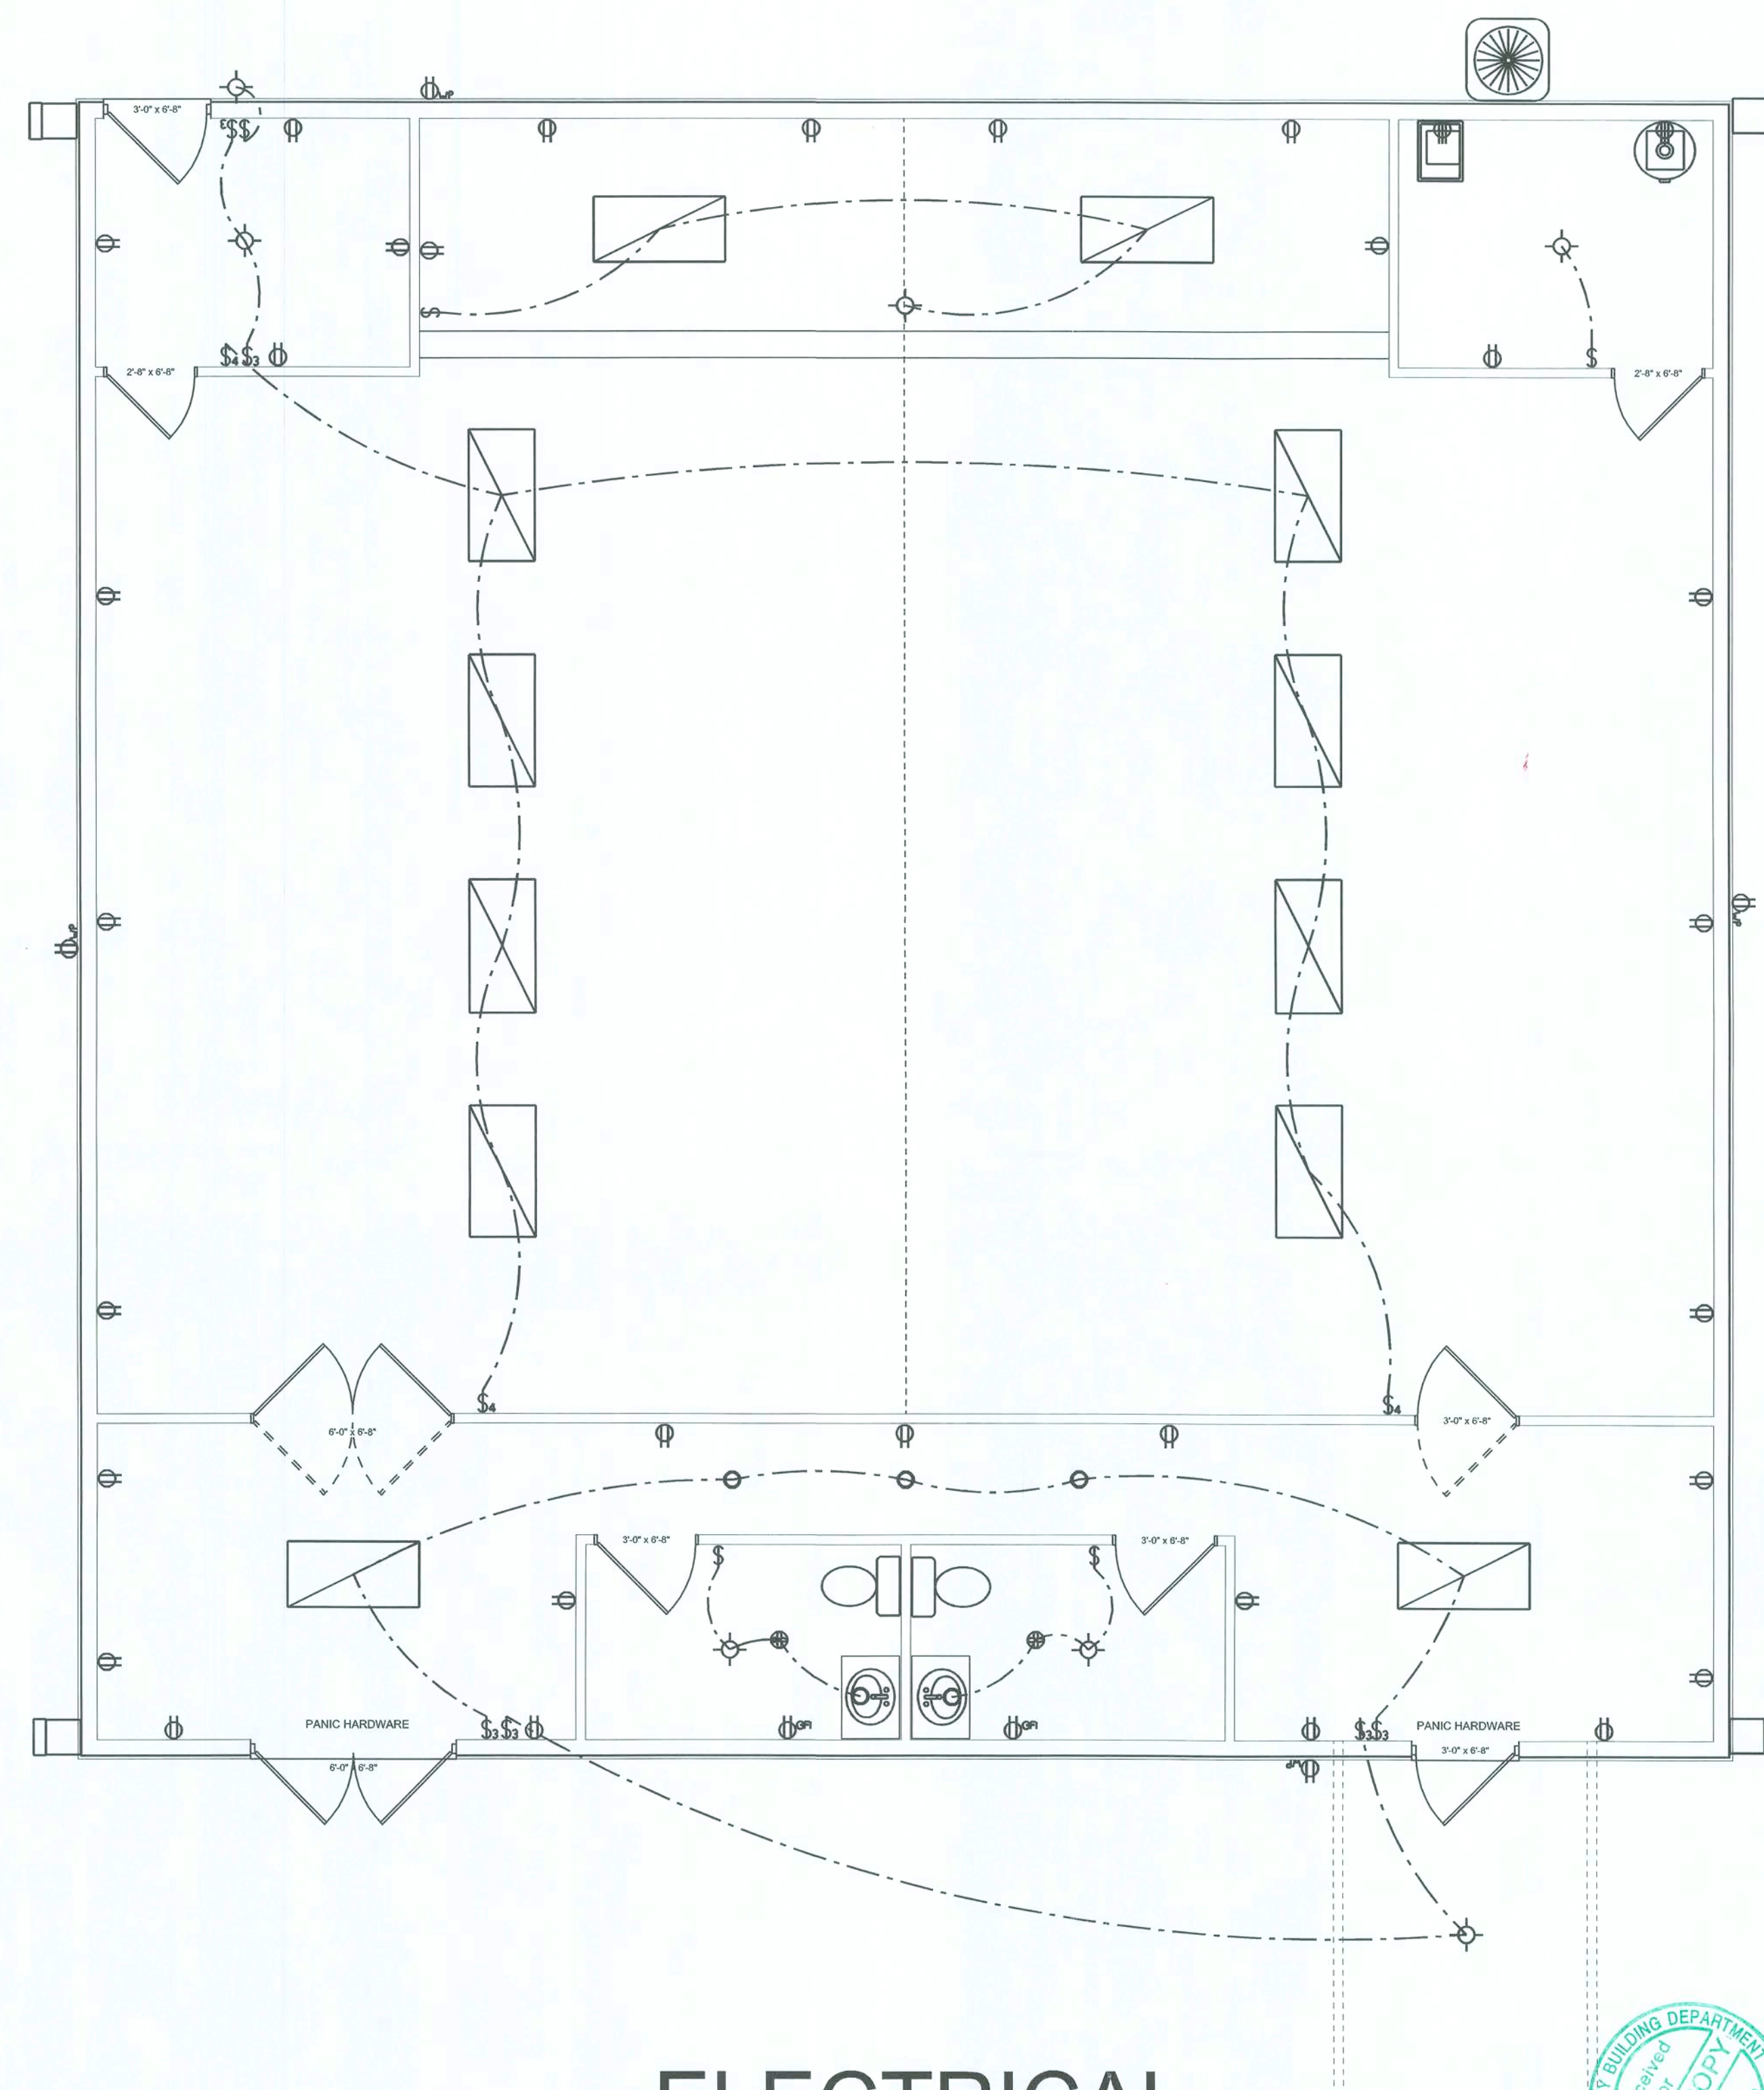

ELECTRICAL



CONNECT CHURCH

ELECTRICAL
WALL SECTION/ROOF


1/4" = 1 FOOT

DRAWN BY:
JASON ELIXSON CONSTRUCTION, LLC
7490 WEST CR. 18
LAKE BUTLER, FL. 32054
(386) 623-1741


COLUMBIA CO.

SOFTPLAN
ARCHITECTURAL DESIGN SOFTWARE

A4

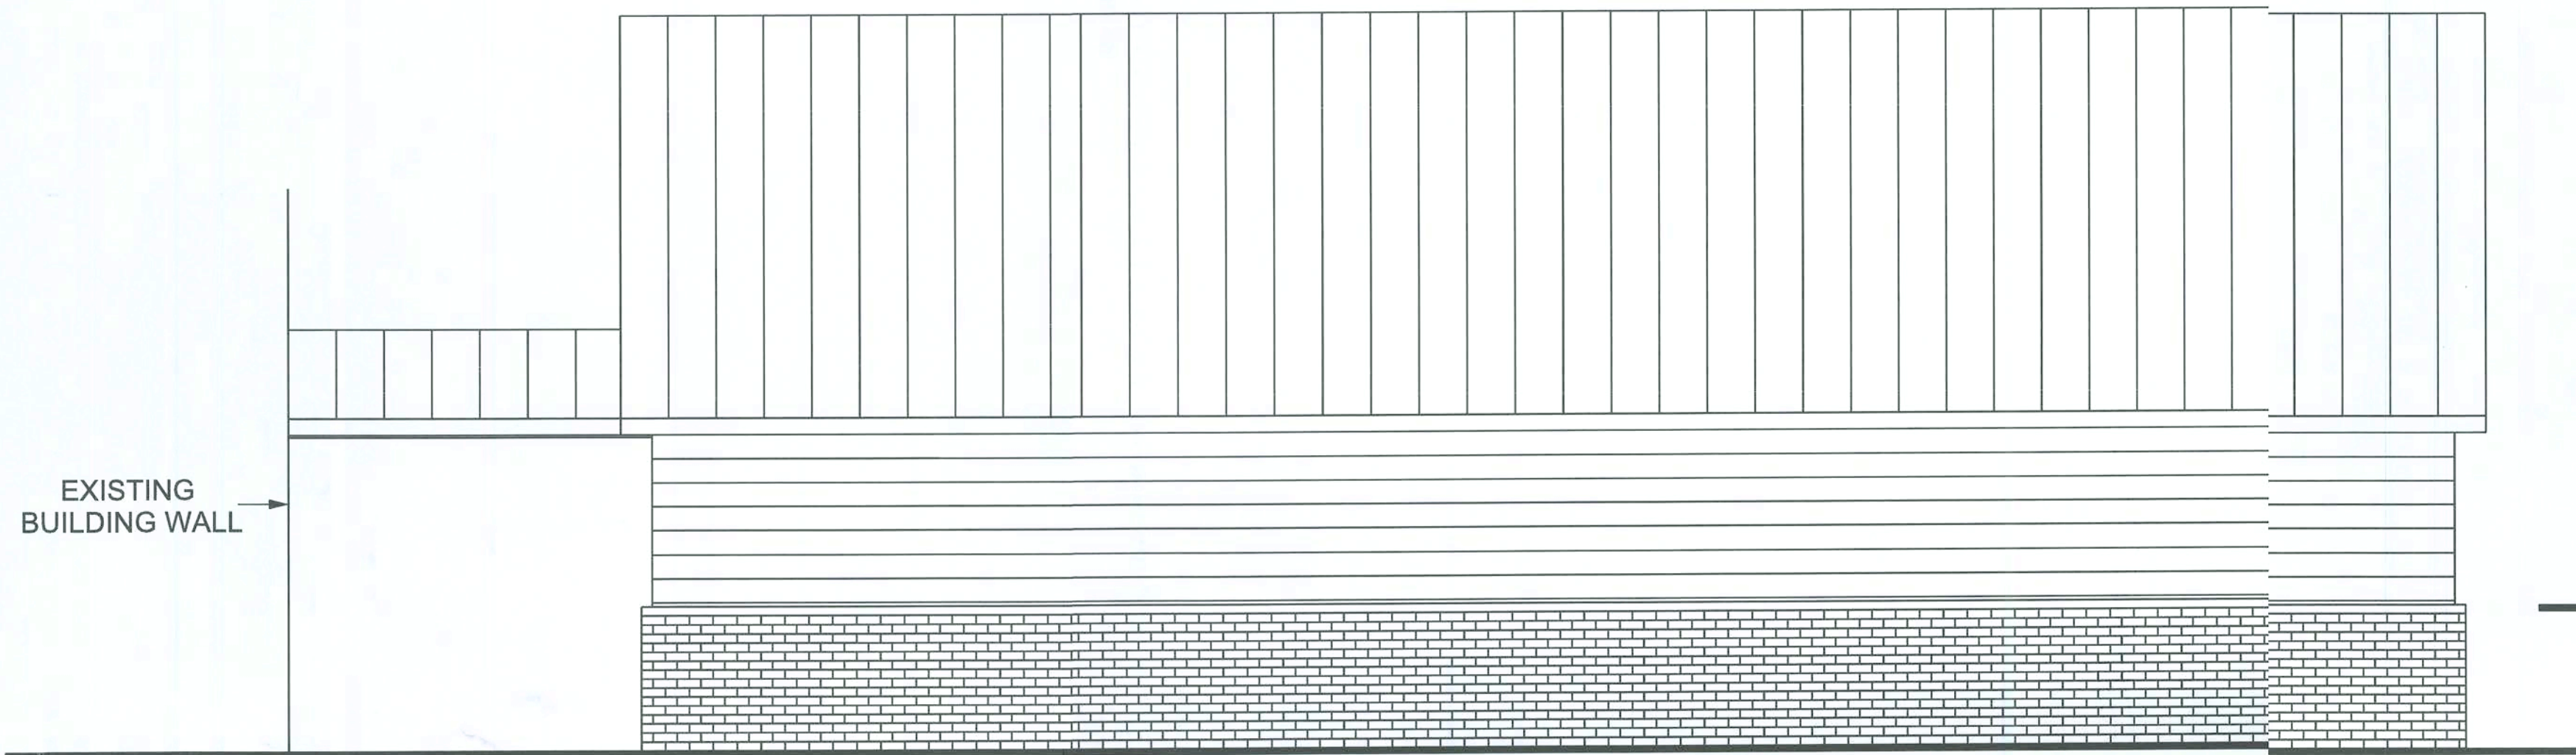


RIGHT ELEVATION

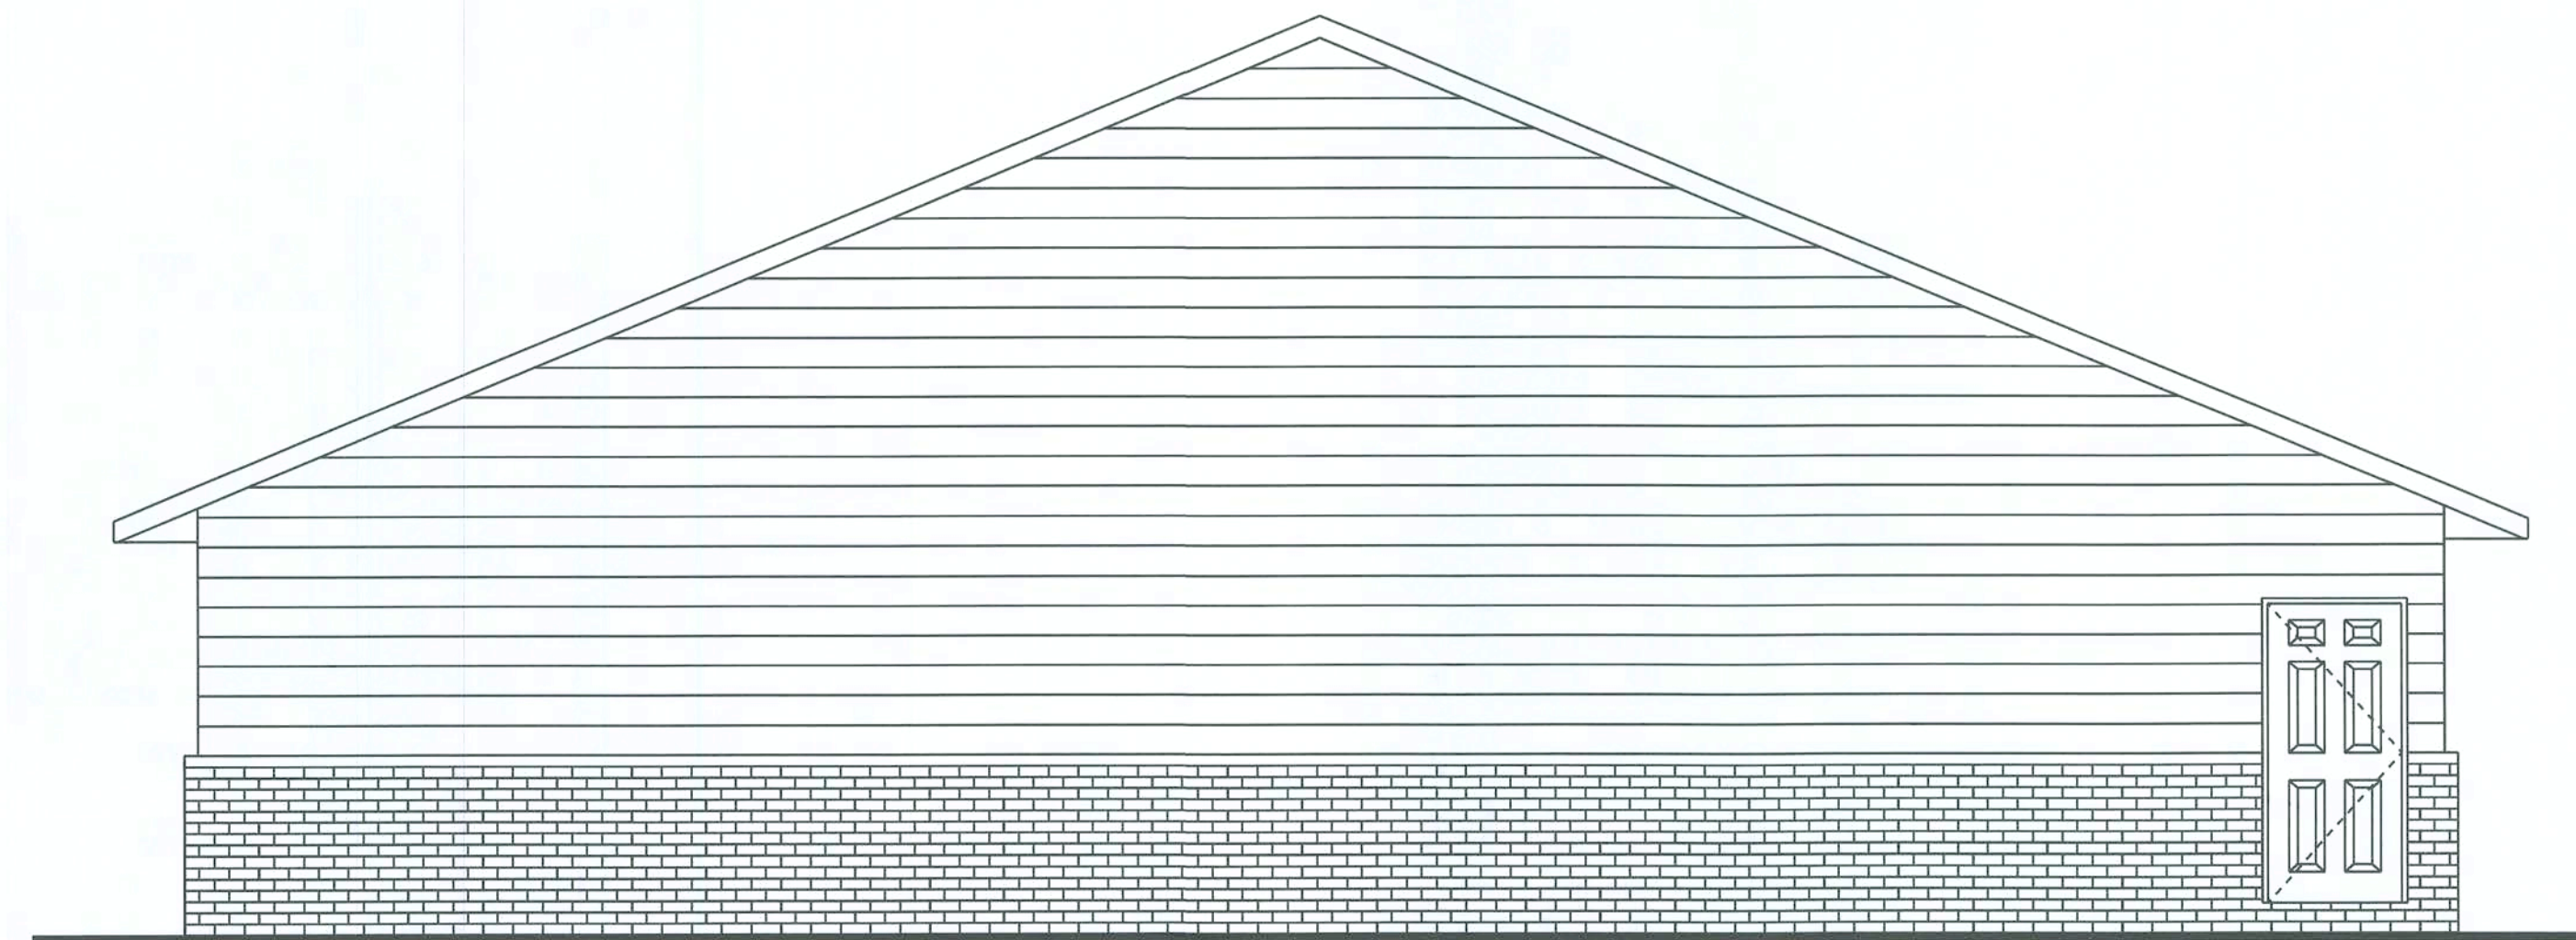

REAR ELEVATION



LEFT ELEVATION

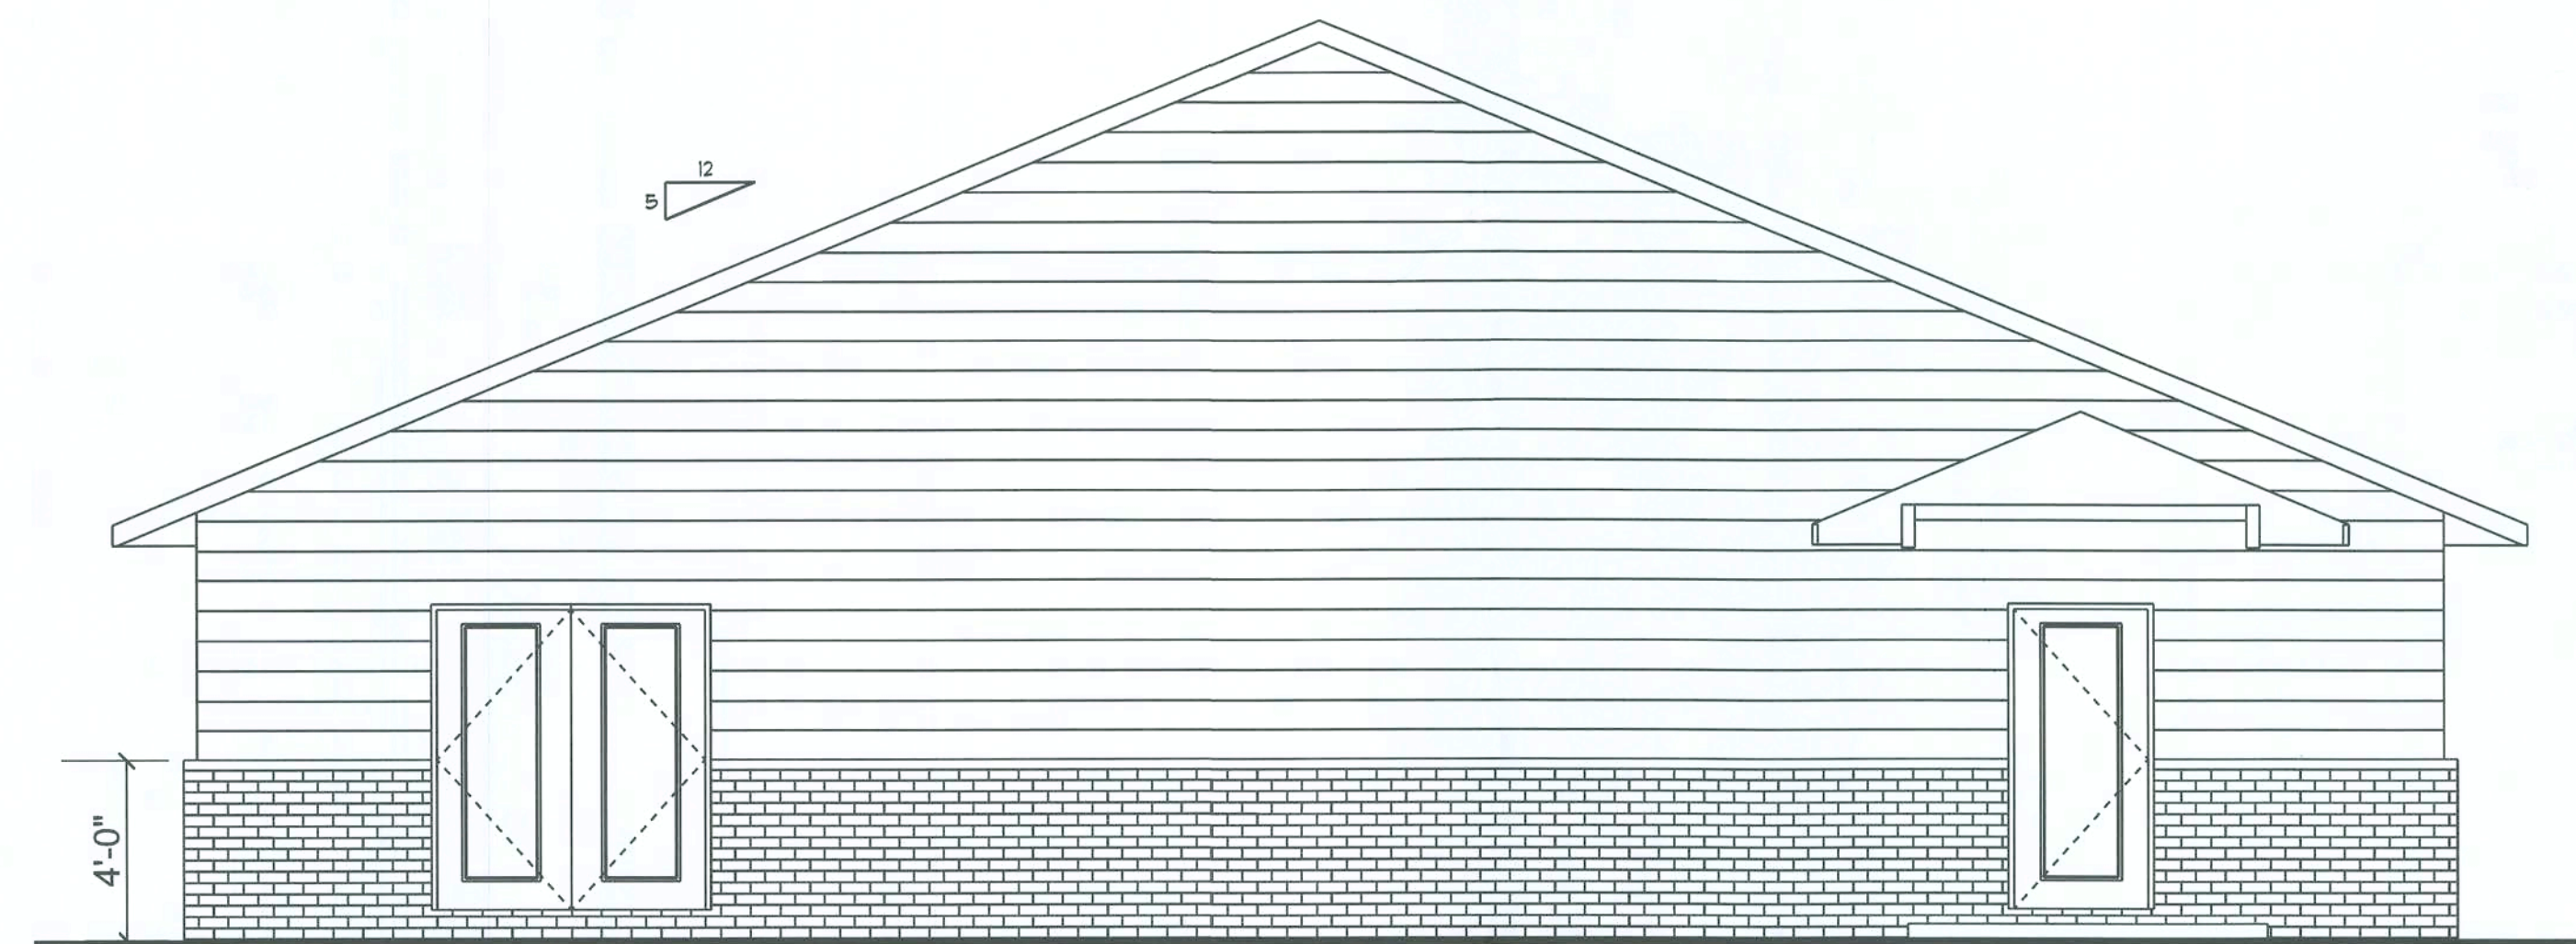

FRONT ELEVATION

#47631
APP.



T. Blum
12/10/2020
STATE OF FLORIDA

DRAWN BY:
JASON ELIXSON CONSTRUCTION, LLC
7490 WEST CR. 18
LAKE BUTLER, FL. 32054
(386) 623-1741

CONNECT CHURCH

COLUMBIA CO.


SOFTPLAN
ARCHITECTURAL DESIGN SOFTWARE

ELEVATIONS

1/4" = 1 FOOT

A1

It is important that the Client and Contractor examine the drawings and documentation in detail. It shall be the final responsibility of the Contractor to review and double check the plans for accuracy and compliance with regulatory agencies. It is customary and ordinary not to include details well within the knowledge of licensed Contractor. If necessary, further clarification of these plans should be achieved before signing the construction contract and obtaining a building permit, otherwise the Contractor assume responsibility for the construction in question. Methods of construction shall be determined by the Contractor.

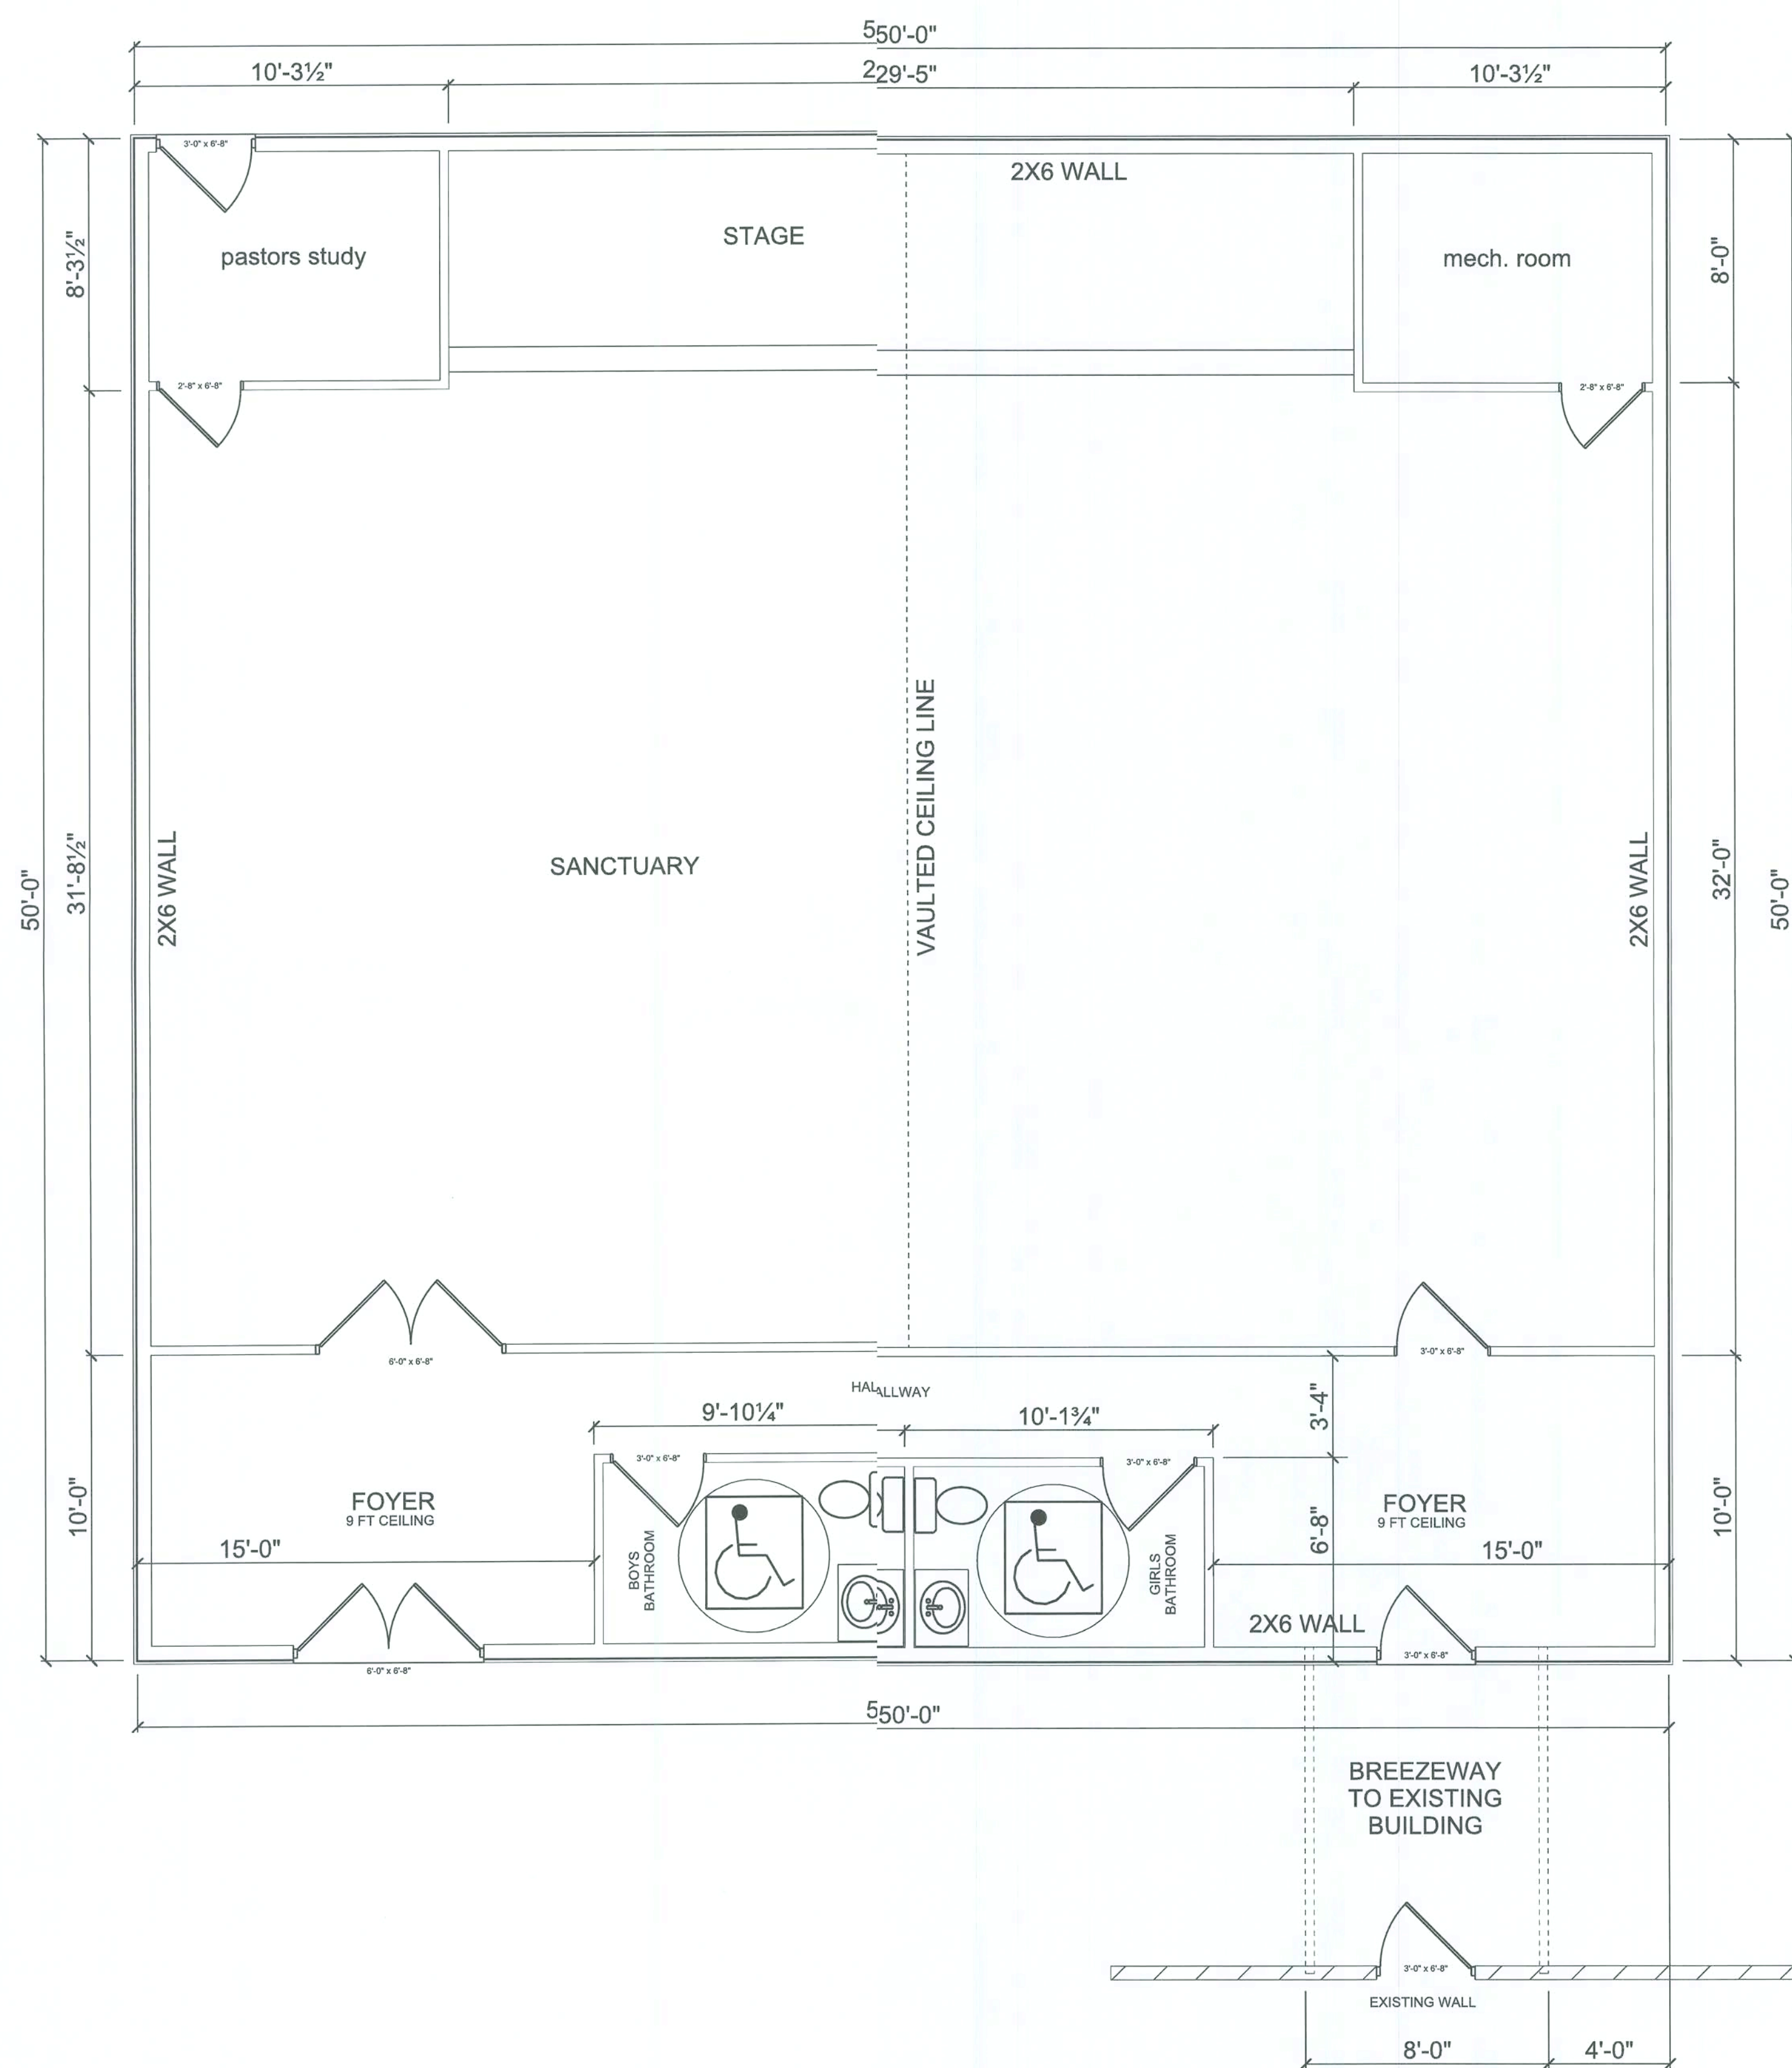

AREA SCHEDULE	
NAME	AREA
SANCTUARY	2500 sq ft.
BREEZEWAY	80 sq ft.
TOTAL	2580 sq ft.


FLOOR PLAN




Handwritten signature and date: 12/10/2020

DRAWN BY: JASON ELIXSON CONSTRUCTION, LLC 7490 WEST CR. 18 LAKE BUTLER, FL. 32054 (386) 623-1741	CONNECT CHURCH	FLOOR PLAN	A2
	COLUMBIA CO.	1/4" = 1 FOOT	



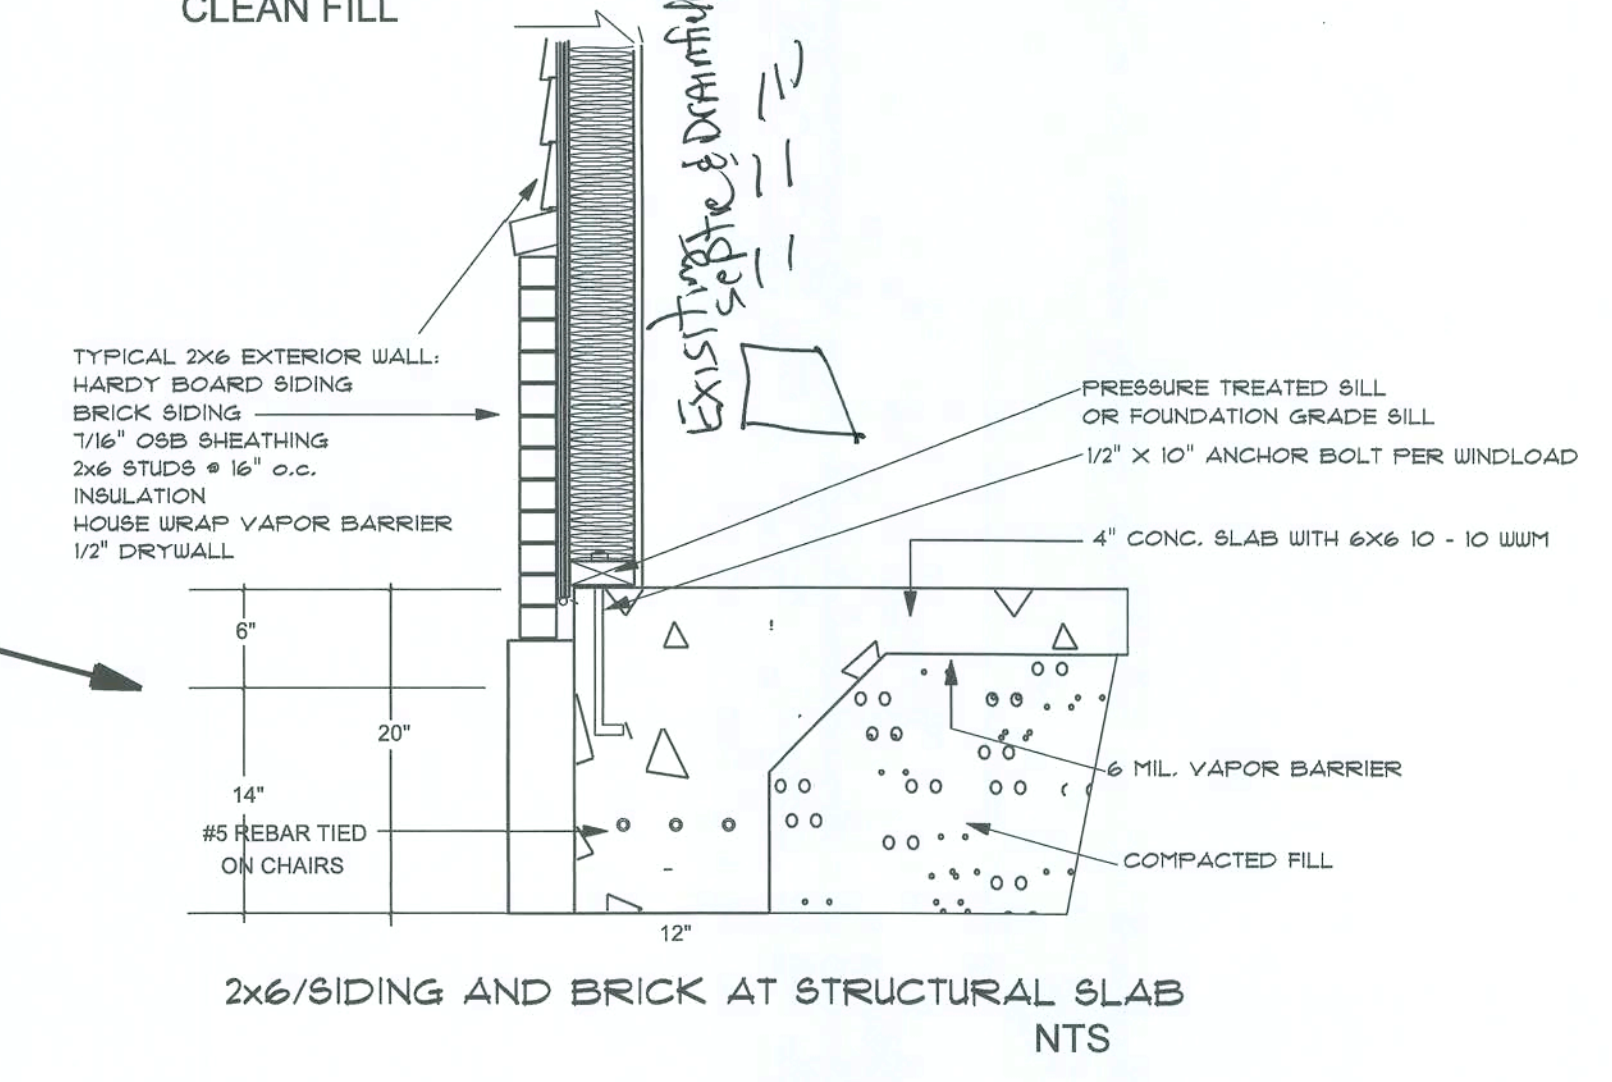


A3

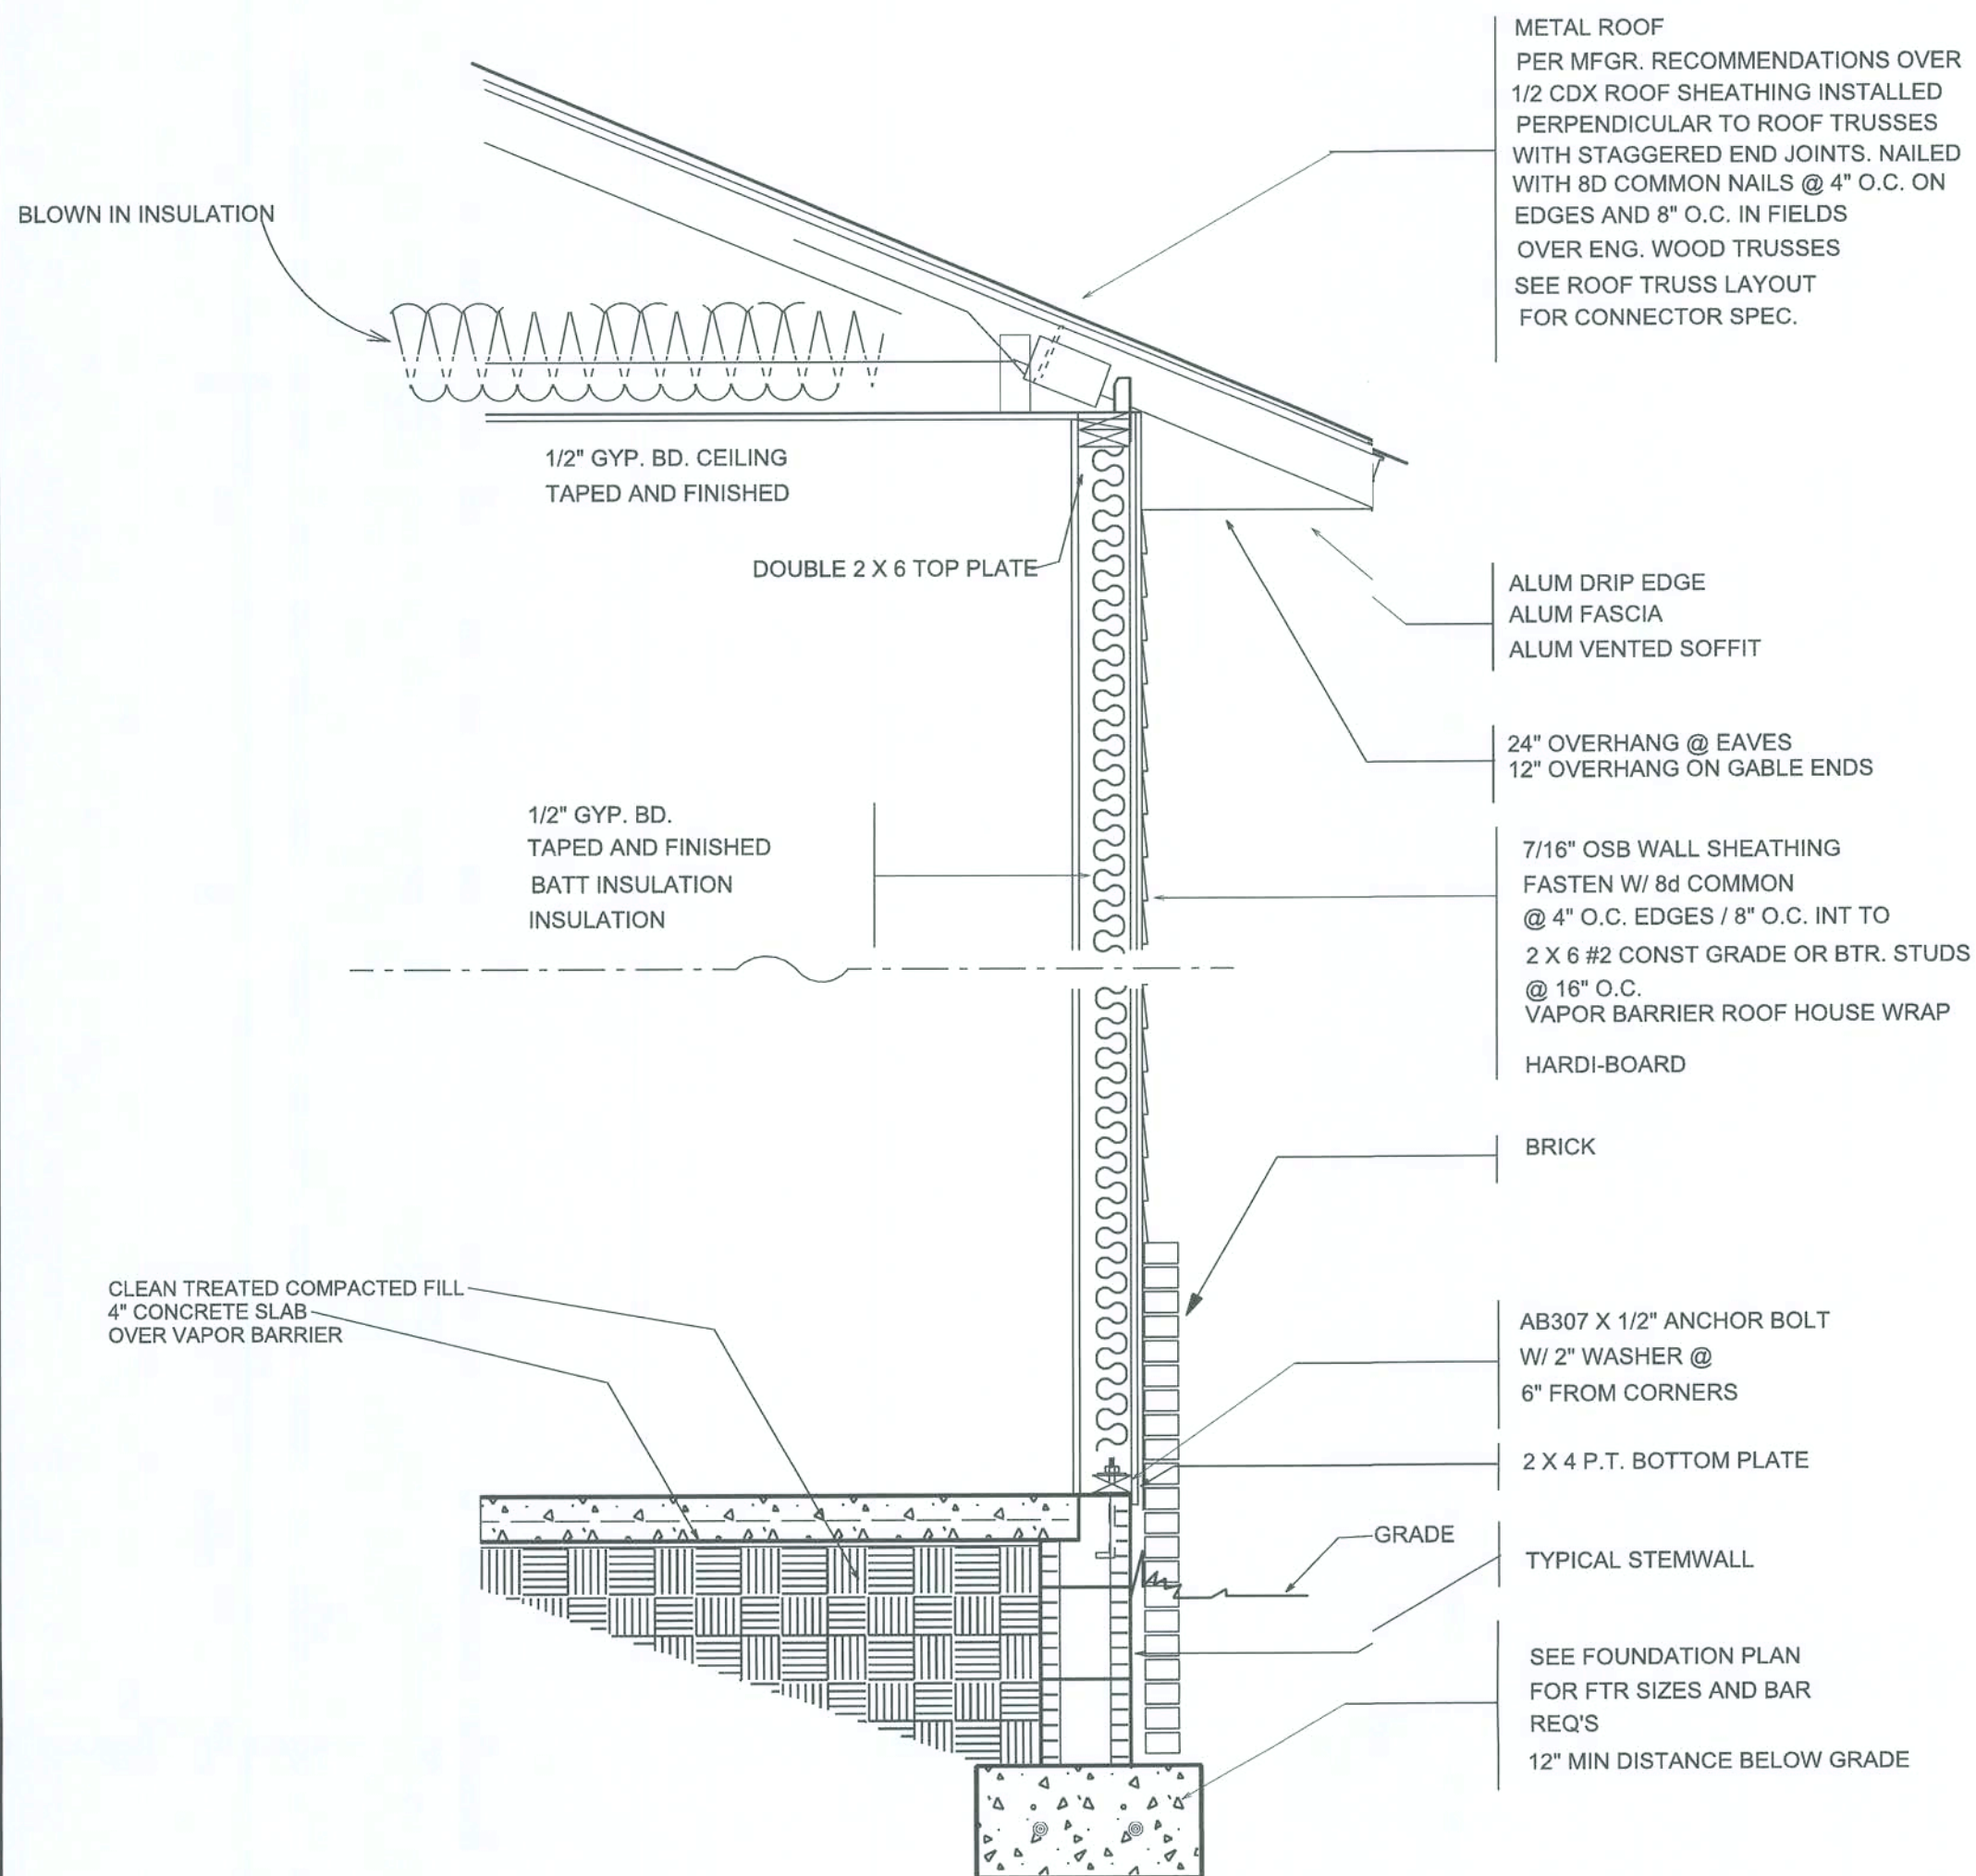

ELECTRICAL LEGEND	
ELECTRICAL	SYMBOL
fluorescent light 2 x 4	
pot light	
flood light	
fan	
light	
outlet	
outlet 220v	
outlet gfi	
outlet wp	
switch	
switch 3 way	
switch 4 way	

TYPICAL WALL SECTION

NTS

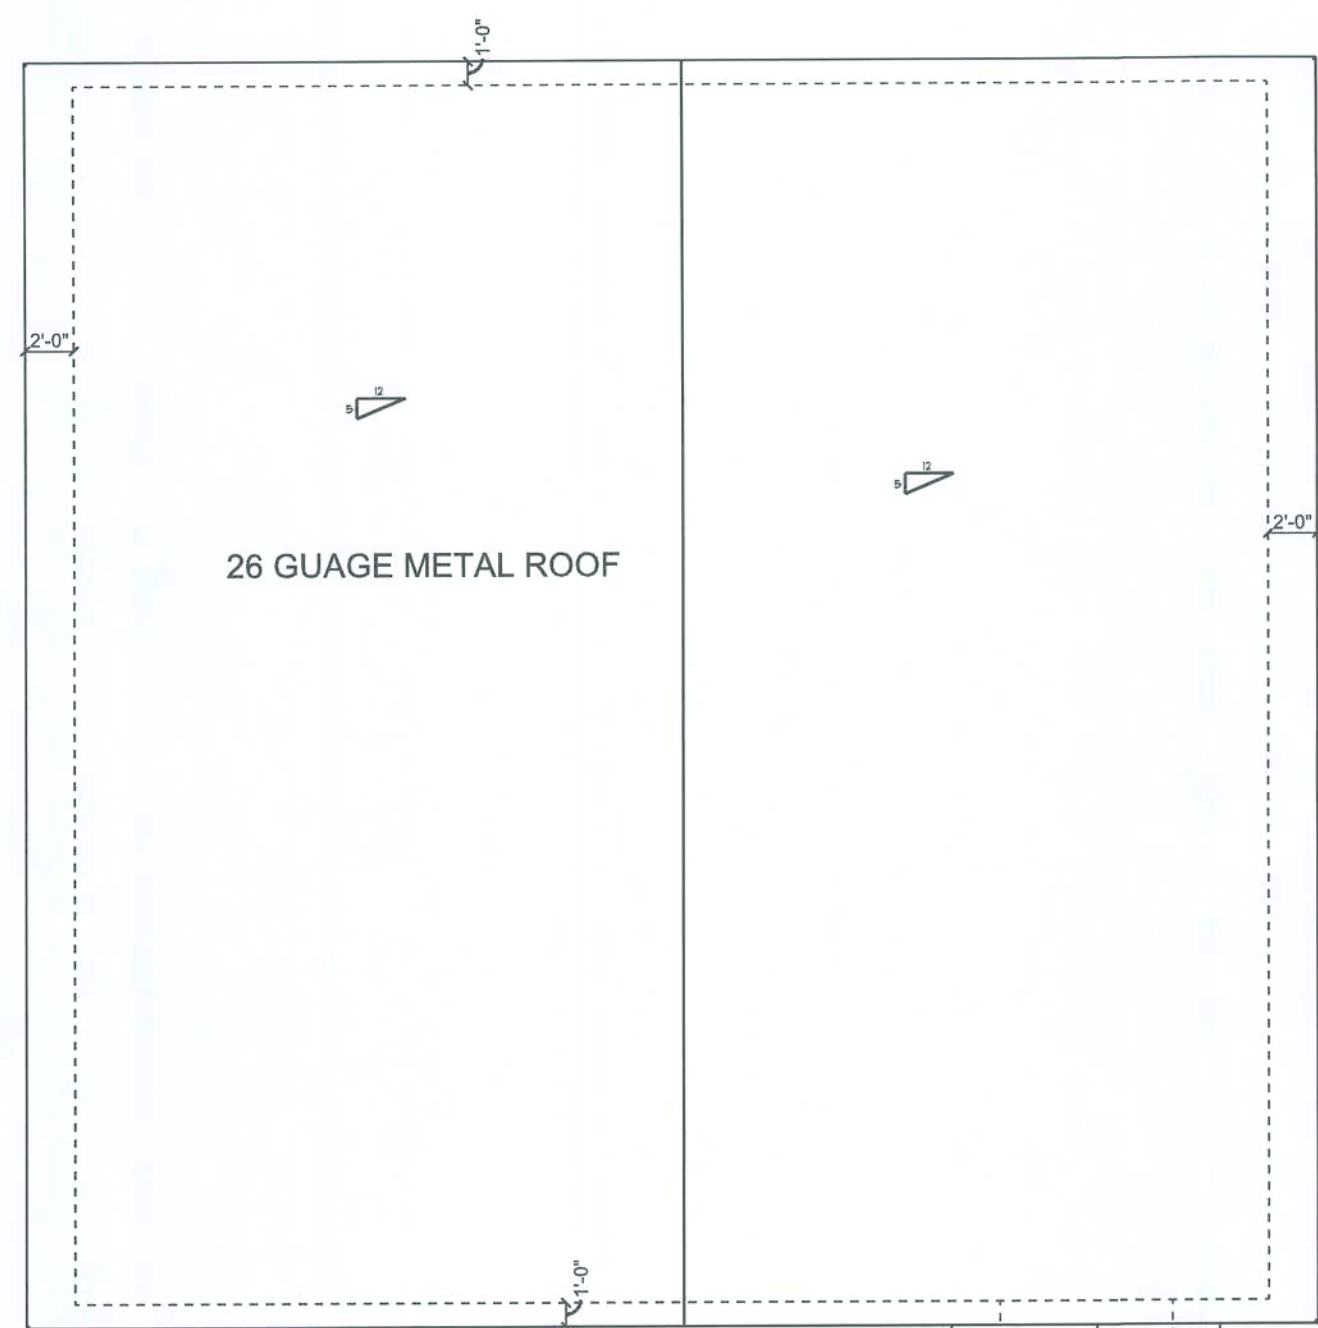

ROOF PLAN
1/8"=1 FOOT

WIRE ALL APPLIANCES, HVAC UNIT AND OTHER EQUIPMENT PER MANUFACTURER SPECS


INSTALLATION SHALL BE PER NATIONAL ELECTRIC CODE

TELEPHONE, T.V. AND OTHER LOW VOLTAGE DEVICES OR OUTLETS SHALL BE AS PER THE OWNERS DIRECTIONS AND IN ACCORDANCE WITH APPLICABLE SECTIONS OF NEC-LATEST EDITIONS

ALL SMOKE DETECTORS SHALL BE 120V WITH BATTERY BACKUP OF THE PHOTOELECTRIC TYPE, AND SHALL BE INTERLOCKED TOGETHER

ALL MATERIAL SHALL HAVE A UL LABEL OR LISTING

ALL BEDROOM OUTLETS TO BE ARC-FAULT BREAKERS OR GFI OUTLETS

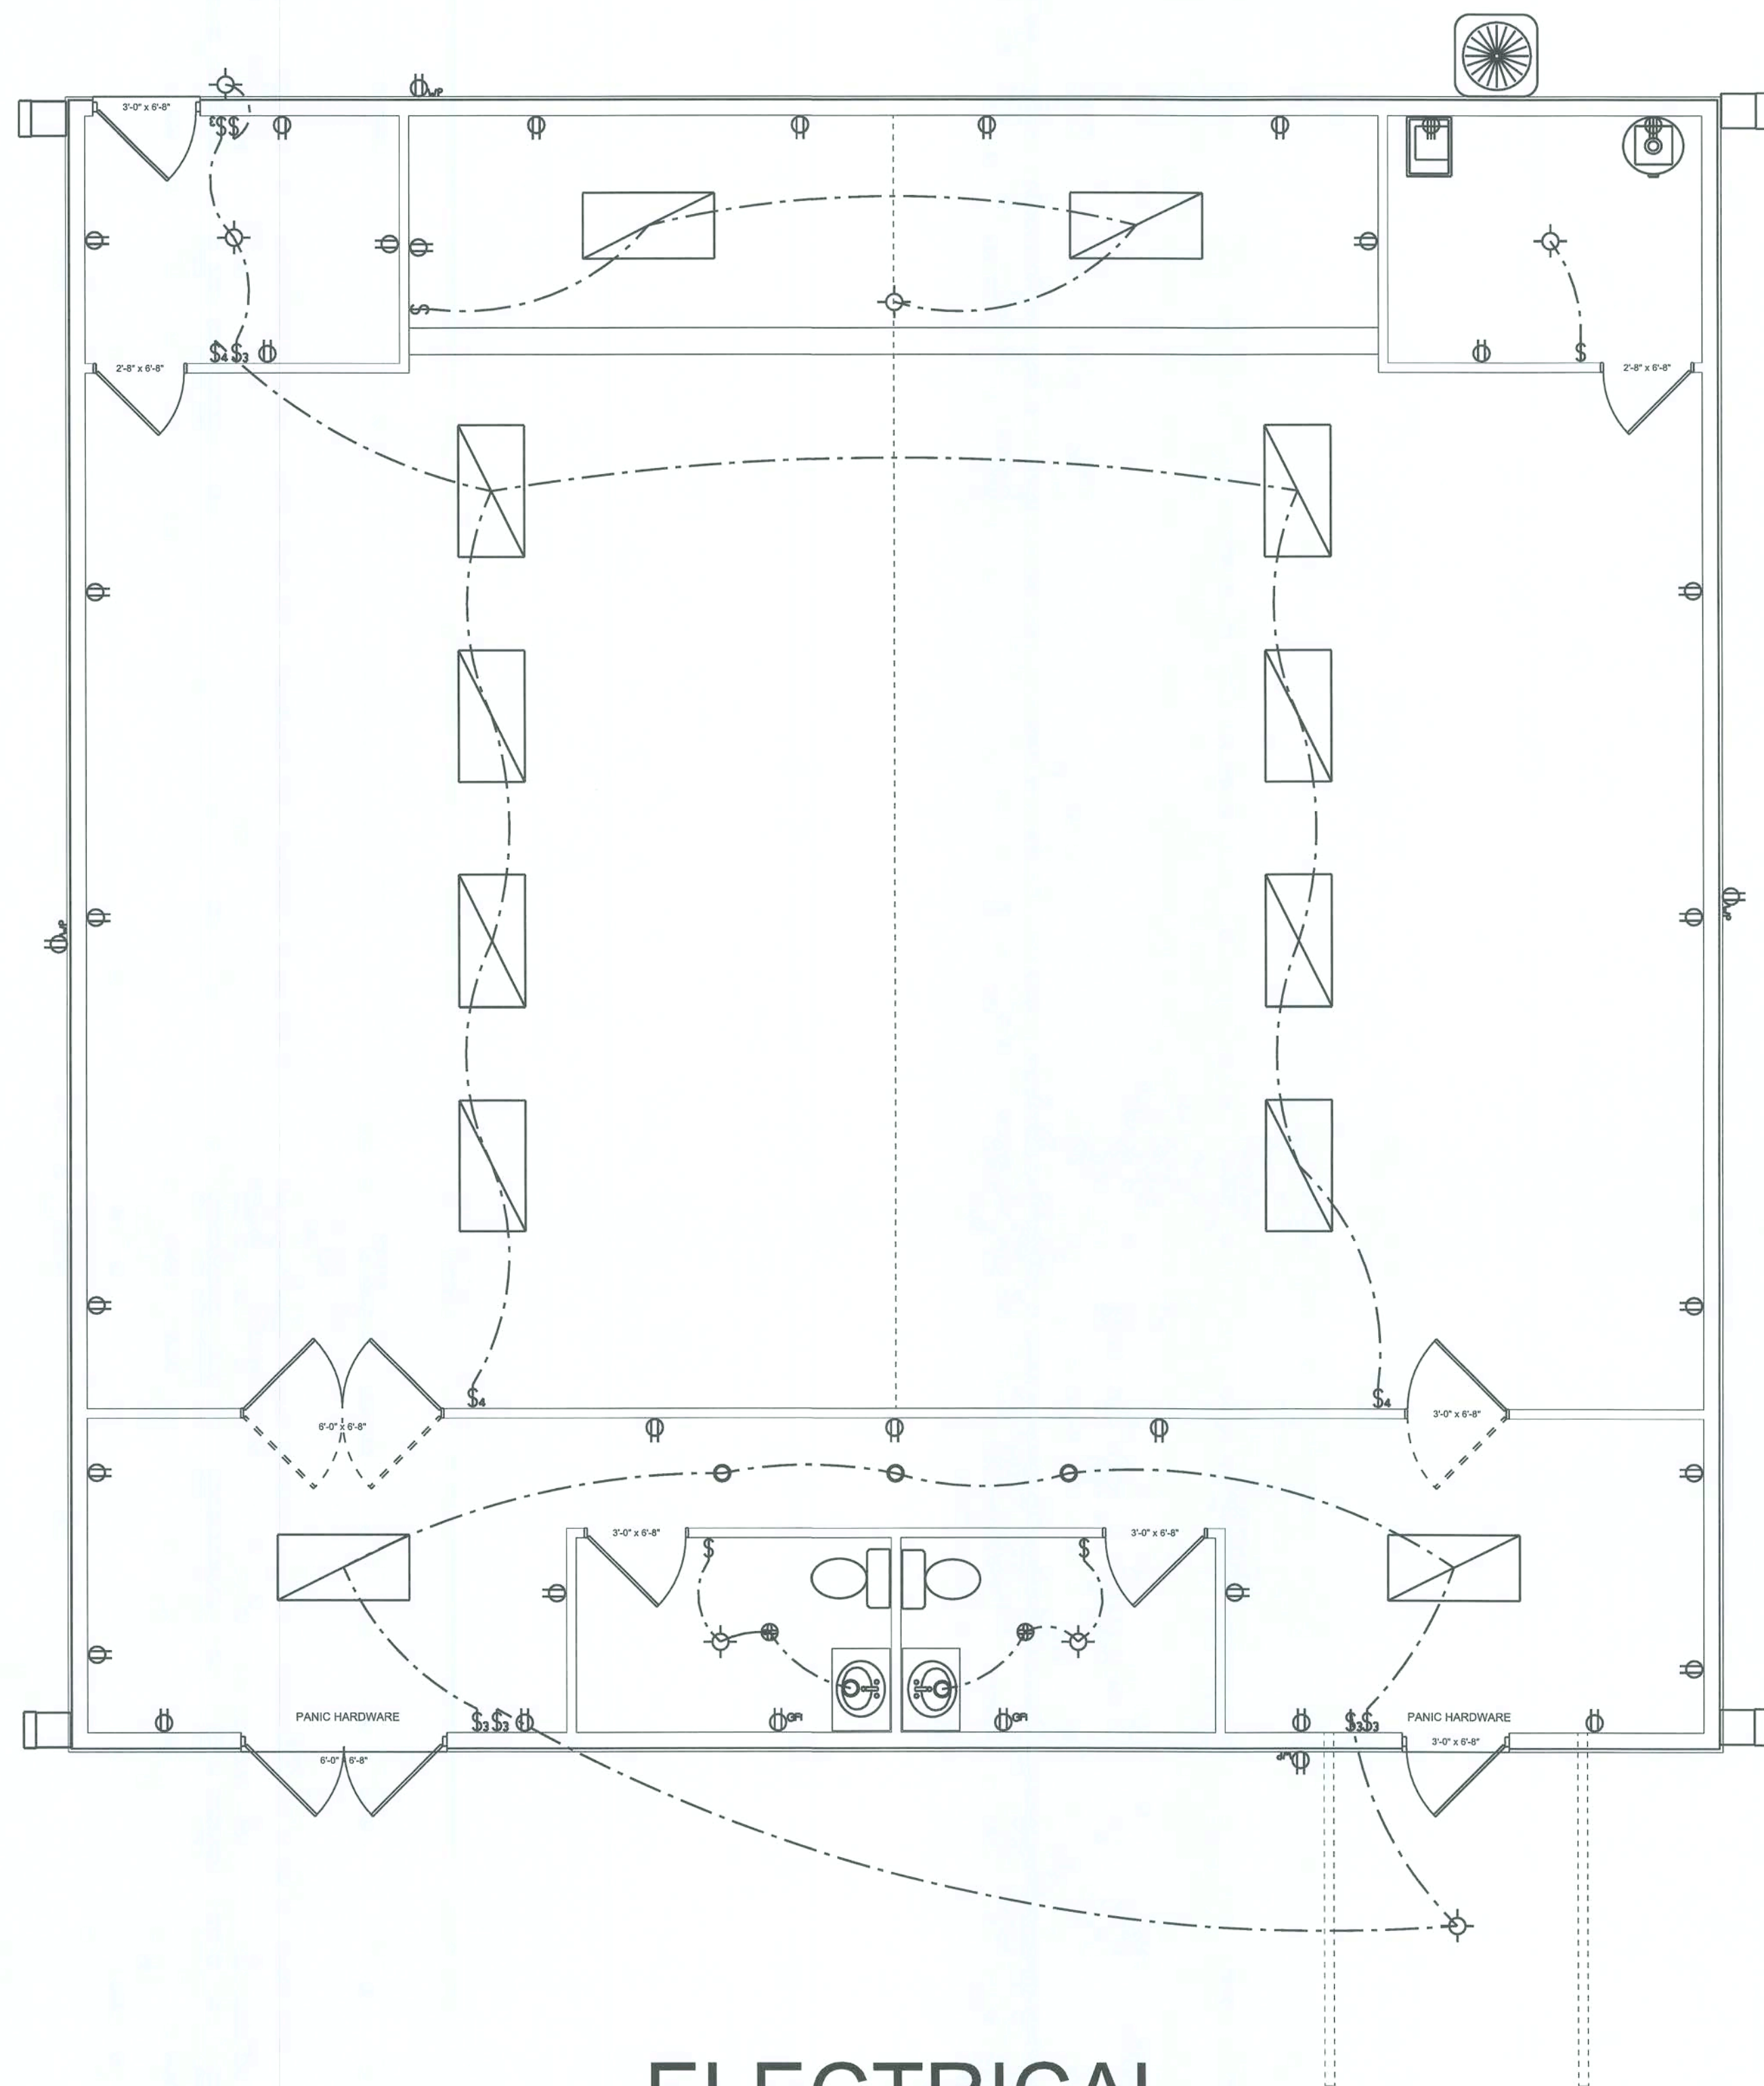

ELECTRICAL



[Signature]
12/15/2024

DRAWN BY:
JASON ELIXSON CONSTRUCTION, LLC
7490 WEST CR. 18
LAKE BUTLER, FL. 32054
(386) 623-1741

CONNECT CHURCH

COLUMBIA CO.

ELECTRICAL
WALL SECTION/ROOF

1/4" = 1 FOOT

A4

SOFTPLAN
ARCHITECTURAL DESIGN SOFTWARE