


ONE 9 # 1401
FUEL NETWORK
14170 US 441
LAKE CITY, FL 32024

Owner: Southwest Georgia Oil
Designer: Texas Republic Signs, LLC
Zoning: CHI Highway Interchange
Parcel # 03-6S-17-09594-000

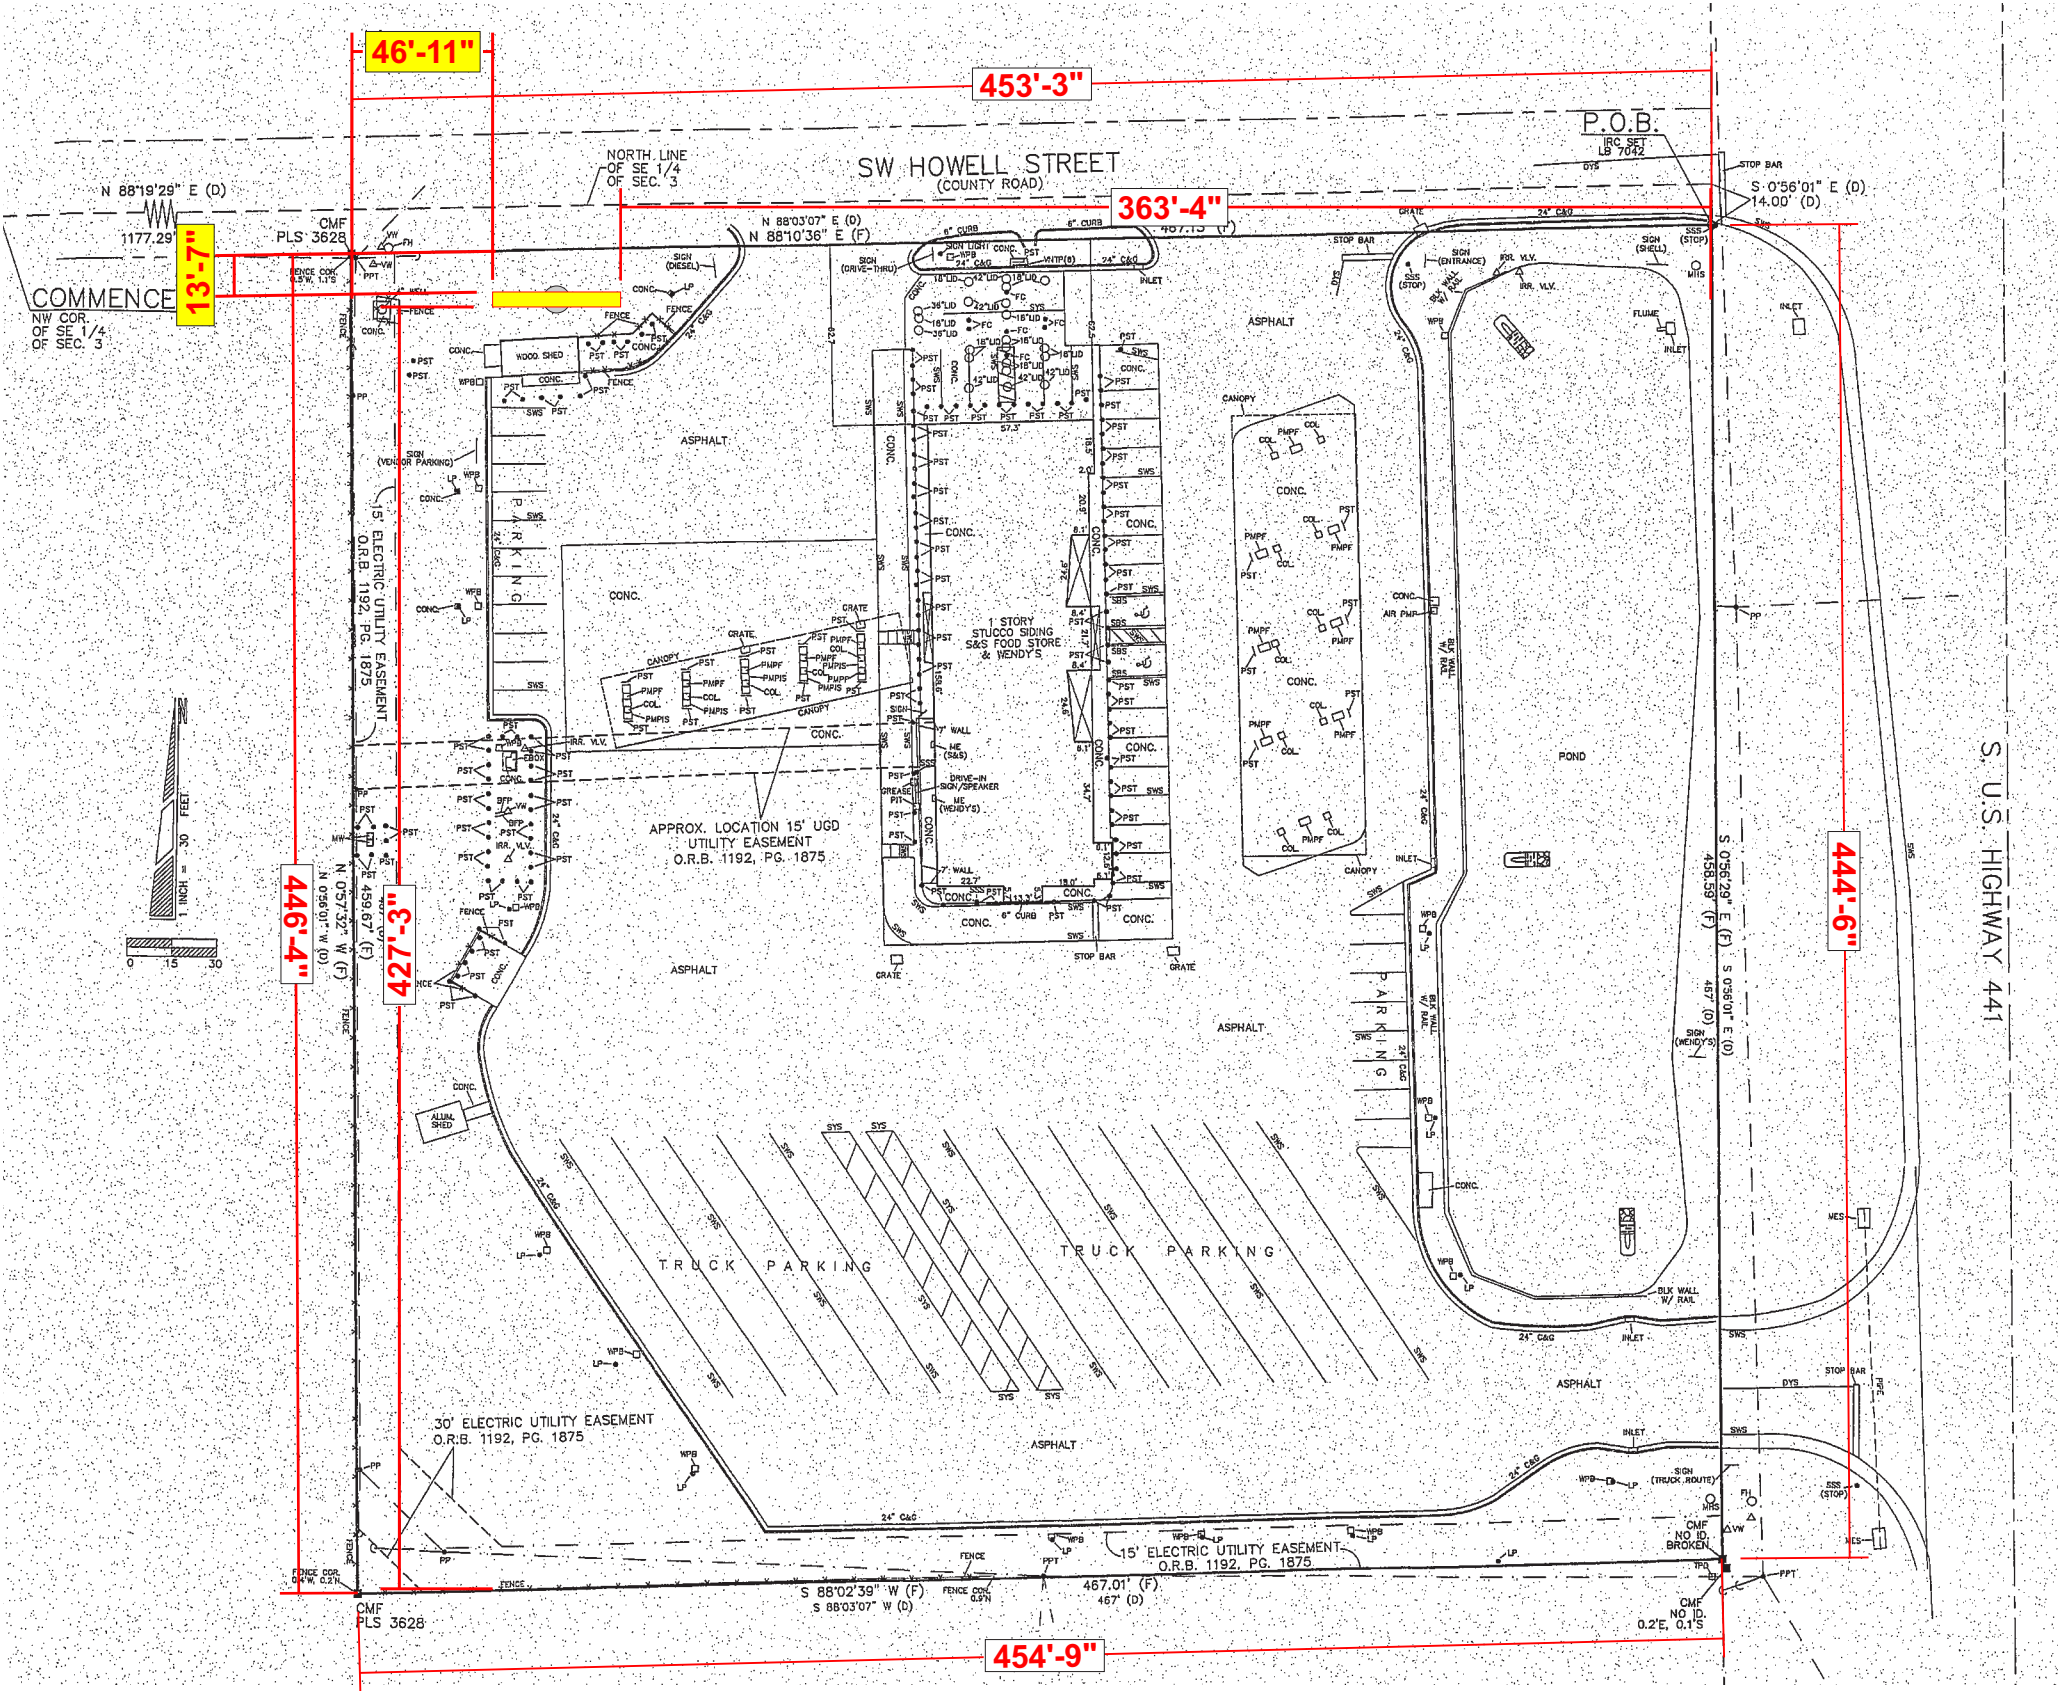

SITE PLAN



SCALE: 1/64" = 1'-0"

TEXAS REPUBLIC
SIGNS

2211 PECH RD HOUSTON TX 77055
832-727-5415
TEXASREPUBLICSIGNS.COM

Customer:

ONE 9 #1401

Address:

14170 US 441
LAKE CITY, FL 32024

City of Jurisdiction:

COLUMBIA COUNTY

Designer:

AVIMAE

Date Created:

3-22-23

W.O. #:

TBD

File Path:P:\2023 JOBS\I\One 9\One 9

1401 - Lake City, FL\PRELIM DRAWINGS

REVISIONS

Rev 8: MOVE HR PER TODD BE
4-14-2023

Rev 4:ADD BRANDING &
REARRANGE COPY

Rev 5: Added dimensions
per survey provided. - AR

Rev 6: 3-3-23Updated Diesel prices
with Sunshine LEDs. - AR

Rev 7: 3-22-23 Added HI-Rise per
client request. - AR

CUSTOMER APPROVAL

Todd Signature:

Date:

THIS SIGN IS INTENDED TO BE INSTALLED IN
ACCORDANCE WITH THE REQUIREMENTS OF
ARTICLE 600 OF THE NEC AND/OR OTHER
APPLICABLE LOCAL CODE. THIS INCLUDES
PROPER GROUNDING AND BONDING OF SIGN.

ELECTRICAL REQUIREMENTS

AMPS: VOLTS: CIRCUITS:

SIGN TYPE A1 QUANTITY: 1

SCOPE OF WORK: HI-RISE
PROVIDE AND INSTALL NEW HI-RISE
WITH NEW STEEL STRUCTURE.

SPECIFICATIONS: ONE 9 SIGN
• CABINET FILLER AND 5” RETAINERS
PAINTED, P1
• WHITE FLEX FACES WITH APPLIED
V1 VINYL

SPECIFICATIONS: LED PRICER
• TWO (2) PRODUCT PRICER PROVIDED
BY CLIENT AND INSTALLED BY TRS

SPECIFICATIONS: STEEL PIPE
• PROVIDE NEW STEEL PIPE
STRUCTURE; PAINT BLACK; P1


SPECIFICATIONS: WENDY’S/SUN STOP
• CABINET FILLER AND 5” RETAINERS
PAINTED, P1
• WHITE FLEX FACES WITH APPLIED
VINYL



Electric Signs
UL 48
#114898

ALL ELECTRICAL COMPONENTS TO BE U.L. LISTED,
APPROVED AND MARKED PER N.E.C. 600-4.
ALL TO BE ELECTRICALLY GROUNDED PER N.E.C. 250.
ALL POWER SUPPLIES TO BE FUSED PER U. L. 48, 28.2.1
GROUNDING AND BONDING PER N.E.C. 250-90, -92,-94,-96.
SIGN TO MEET N.E.C. AND U. L. 48
STANDARDS FOR ELECTRICAL SIGNS.
GROUNDING & BONDING
AS PER N.E.C. 250-90 & NEC 600-7

PRIMARIES AND FINAL CONNECTION TO SIGN BY:
CERTIFIED ELECTRICIAN

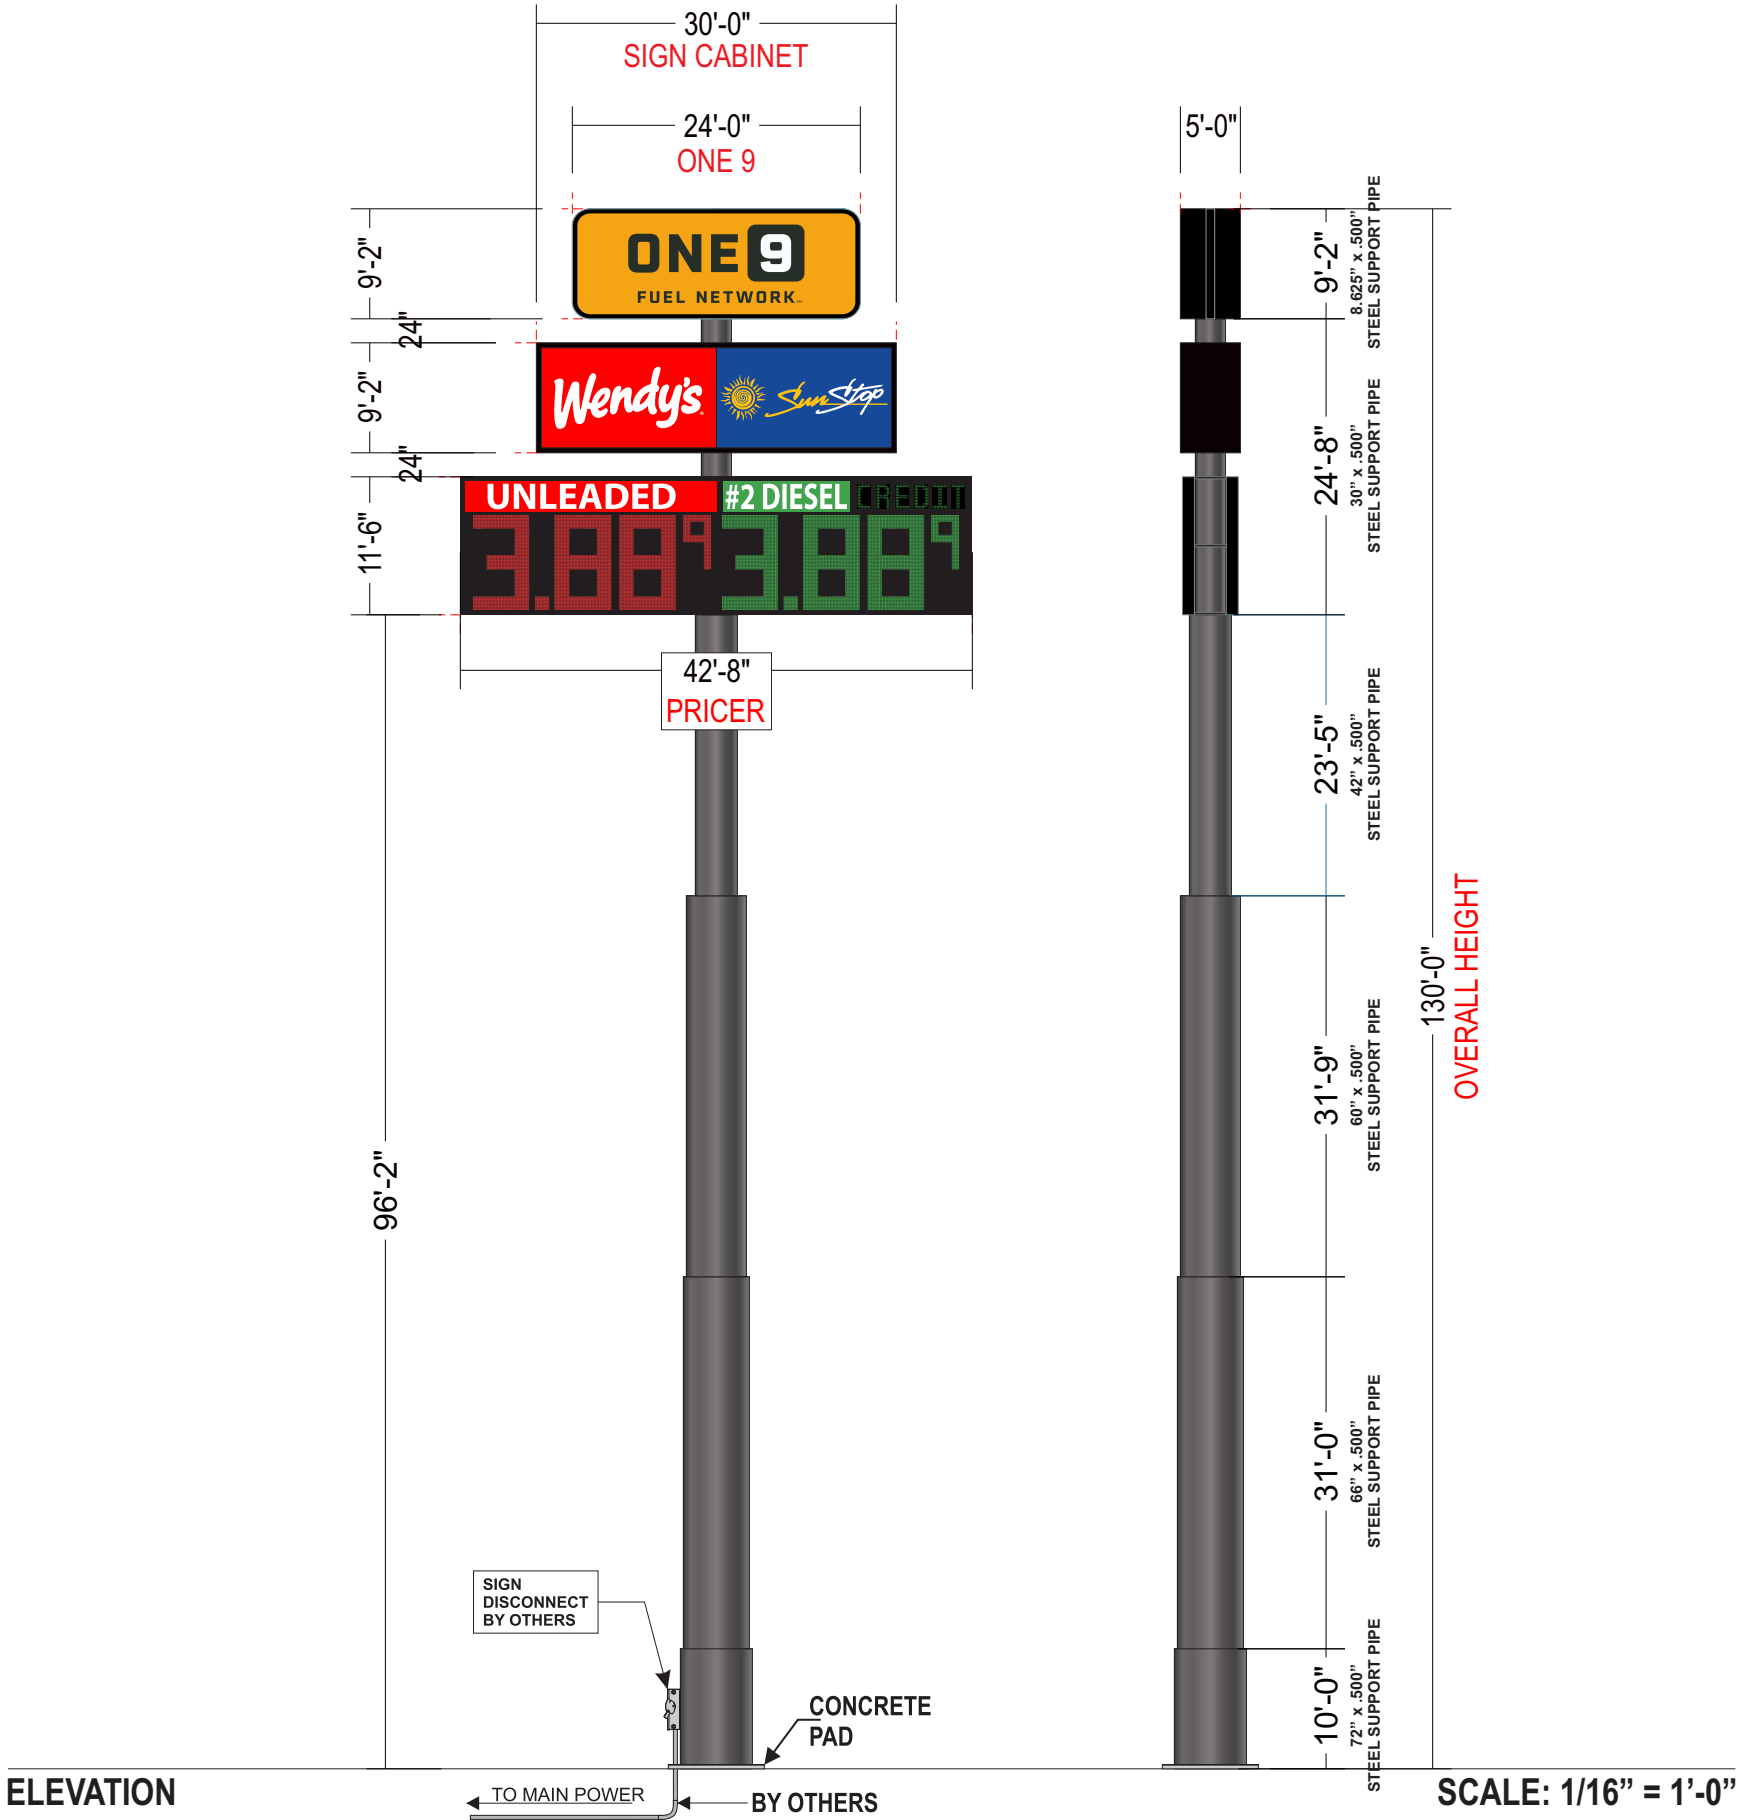

TEXAS REPUBLIC
SIGNS

2211 PECH RD HOUSTON TX 77055
832-727-5415
TEXASREPUBLICSIGNS.COM

Customer:

ONE 9 #1401

Address:

14170 US 441
LAKE CITY, FL 32024

City of Jurisdiction:

COLUMBIA COUNTY

Designer:

AVIMAEI

Date Created:

3-22-23

W.O. #:

TBD

File Path:P:\2023 JOBS\I\One 9\One 9
#1401 - Lake City, FL\PRELIM DRAWINGS

REVISIONS

Rev 8: MOVE HR PER TODD BE
4-14-2023

Rev 4:ADD BRANDING &
REARRANGE COPY

Rev 5: Added dimensions
per survey provided. - AR

Rev 6: 3-3-23Updated Diesel pricer
with Sunshine LEDs. - AR

Rev 7: 3-22-23 Added HI-Rise per
client request. - AR

CUSTOMER APPROVAL

Todd Signature:

Date:


THIS SIGN IS INTENDED TO BE INSTALLED IN
ACCORDANCE WITH THE REQUIREMENTS OF
ARTICLE 600 OF THE NEC AND/OR OTHER
APPLICABLE LOCAL CODE. THIS INCLUDES
PROPER GROUNDING AND BONDING OF SIGN

ELECTRICAL REQUIREMENTS

AMPS: VOLTS: CIRCUITS:


ONE 9 - HI-RISE D/F CABINET 24'-0" x 9'-2"

THE ELECTRICAL SPECS IN THIS DOCUMENT REPRESENT ONE SIDE OF THIS D/F CABINET.

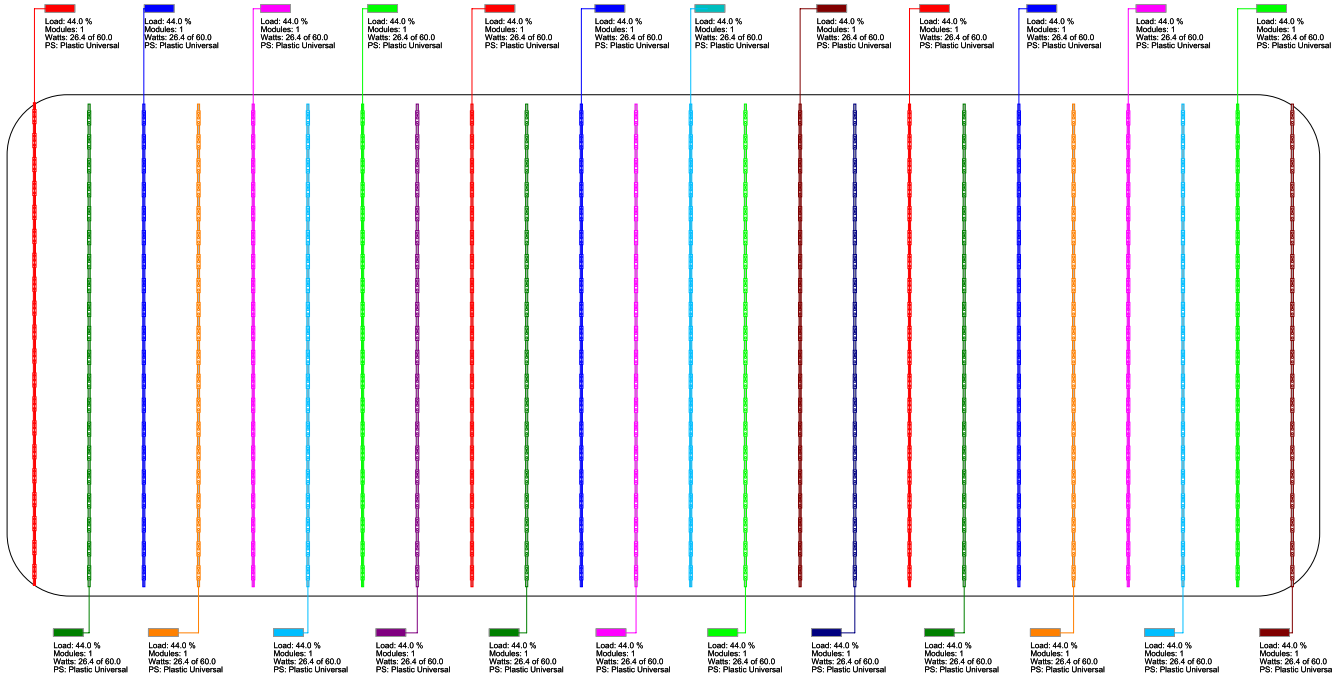


Tap Out Stik SS
24 Tap Out Stik Single Sided 108
(PL-OP2-TO3-P/ST-SS-108-TW)

POWER SUPPLIES
24 Plastic Universal (PL-60-12-PCM-U)
AMP DRAW: 26.40 A
WATTS: 633.60
(4) 120V CIRCUITS REQUIRED

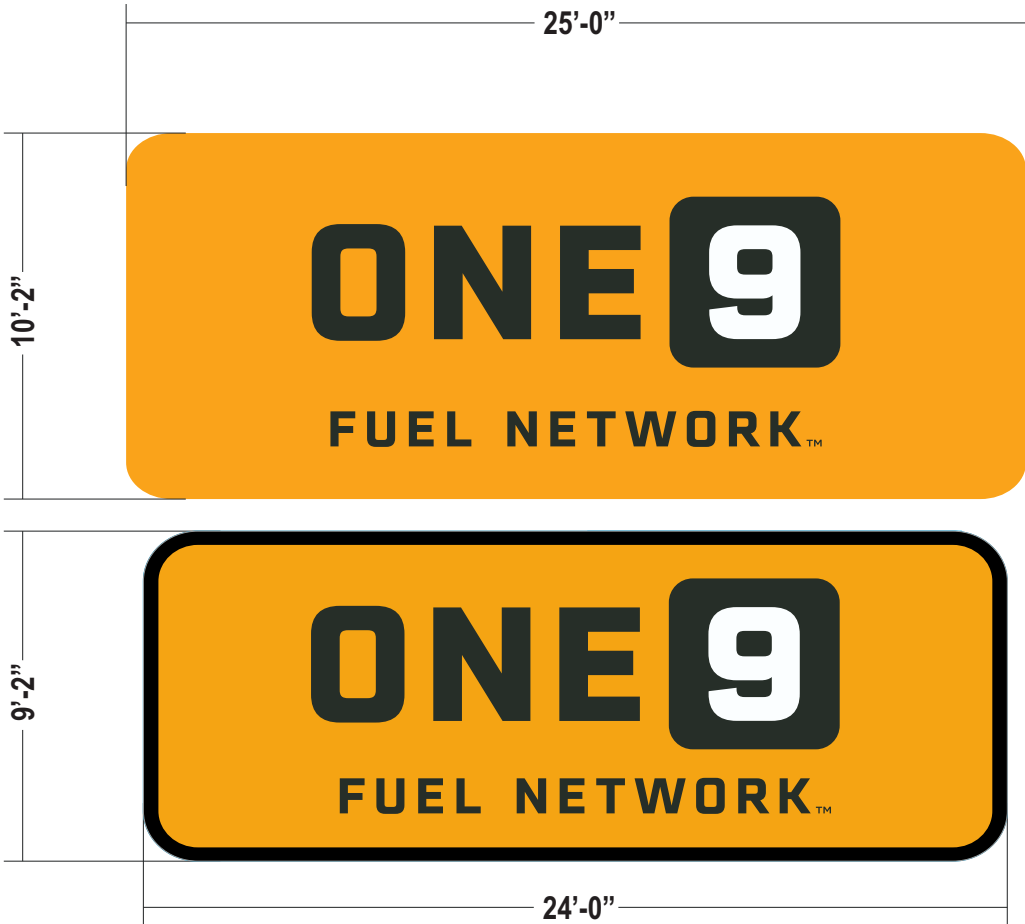


ELEVATION UPDATED CONDITIONS SCALE: 3/16" = 1'-0"

WENDY'S / SUNSTOP - HI-RISE D/F CABINET 30'-0" x 9'-2"

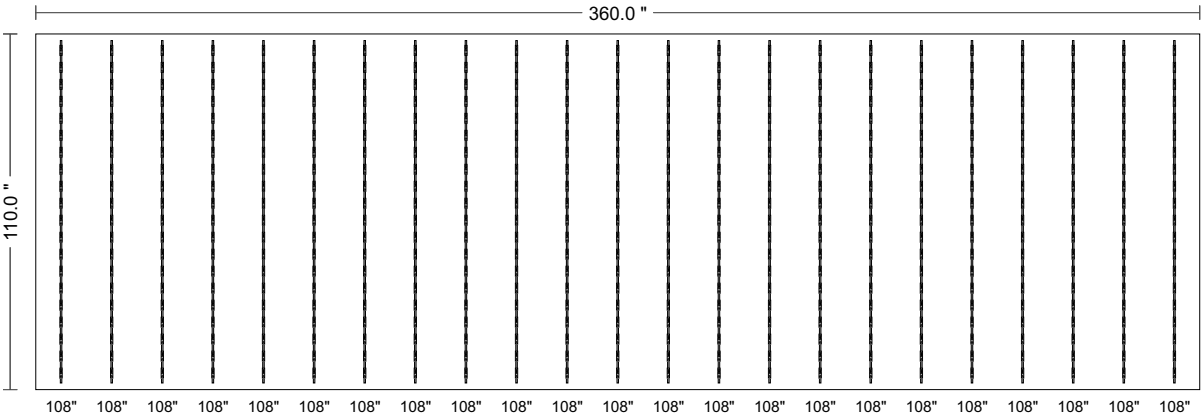

Date	Module	Power Supply	Total Watts	Area
February 19, 2023 09:52 AM PST	(23) Tap Out Stik Single Sided 108	(12) Universal 60W	607.20 watts	275.00 sq ft
Lighting	Module Part Number	Power Supply Part Number	Row Spacing	Perimeter
LED Module	PL-OP2-TO3-P/ST-SS-108-TW	PL-60-12-U	15.7 in	78.33 feet
Layout Type	Module SKU	Power Supply SKU	Can Depth	Max Modules per PS
Face Lit	B-TO-S20-10870	P-OH060-12-PL	8.00 in	2

(2) 120V CIRCUITS REQUIRED

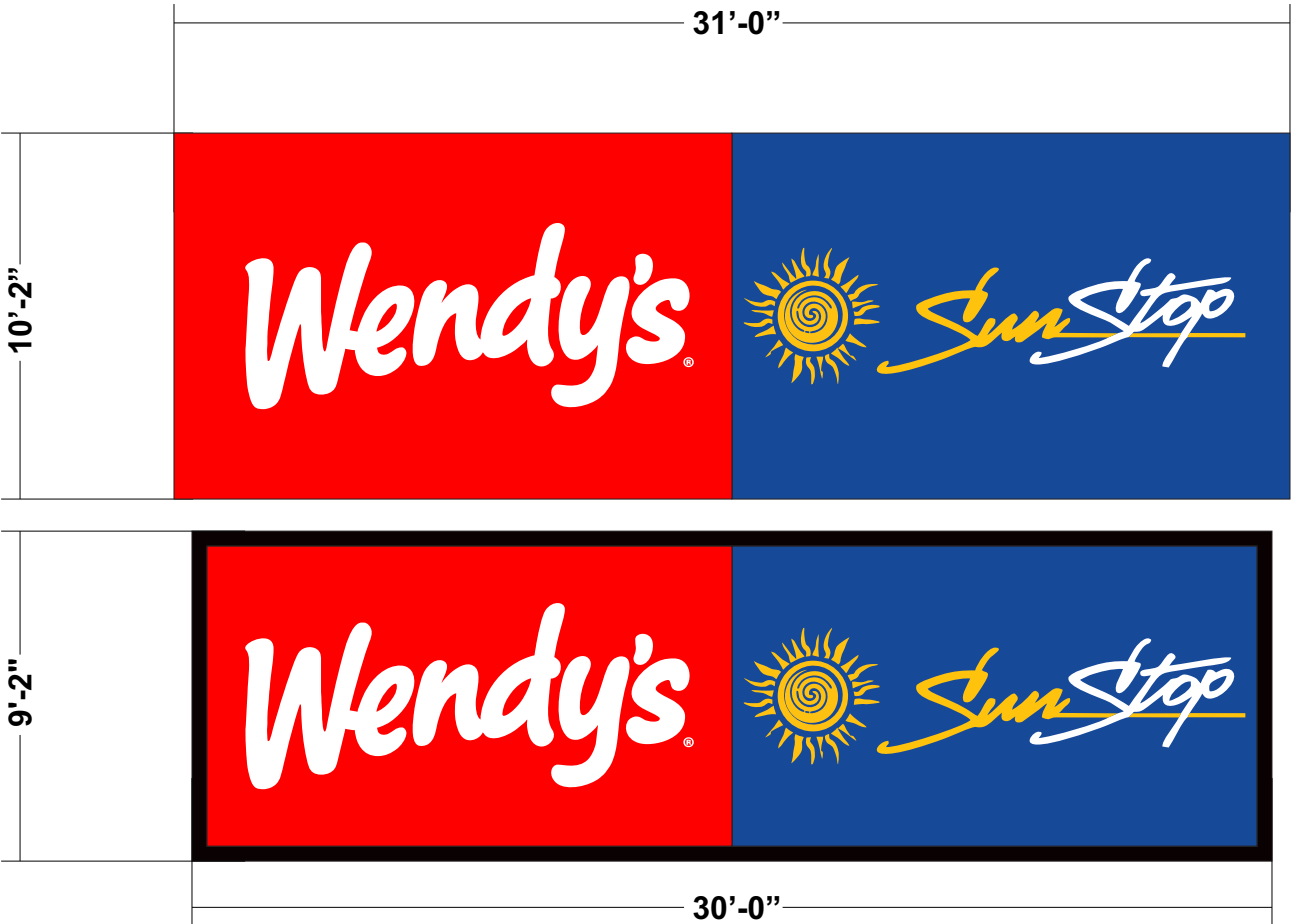

ELEVATION UPDATED CONDITIONS SCALE: 3/16" = 1'-0"

TEXAS REPUBLIC SIGNS

2211 PECH RD HOUSTON TX 77055
832-727-5415
TEXASREPUBLICSIGNS.COM

Customer:

ONE 9 #1401

Address:

14170 US 441
LAKE CITY, FL 32024

City of Jurisdiction:

COLUMBIA COUNTY

Designer:

AVIMAEI

Date Created:

3-22-23

W.O. #:

TBD

File Path:P:\2023 JOBS\One 9\One 9
1401 - Lake City, FL\PRELIM DRAWINGS

REVISIONS

Rev 8: MOVE HR PER TODD BE
4-14-2023

Rev 4:ADD BRANDING &
REARRANGE COPY

Rev 5: Added dimensions
per survey provided. - AR

Rev 6: 3-3-23Updated Diesel prices
with Sunshine LEDs. - AR

Rev 7: 3-22-23 Added HI-Rise per
client request. - AR

CUSTOMER APPROVAL

Todd Signature:

Date:

THIS SIGN IS INTENDED TO BE INSTALLED IN
ACCORDANCE WITH THE REQUIREMENTS OF
ARTICLE 600 OF THE NEC AND/OR OTHER
APPLICABLE LOCAL CODE. THIS INCLUDES
PROPER GROUNDING AND BONDING OF SIGN.

ELECTRICAL REQUIREMENTS

AMPS: VOLTS: CIRCUITS:

