




ALL DRAWINGS NOT TO BE SCALED, WRITTEN DIMENSIONS TAKE PRECEDENCE OVER SCALED DIMENSIONS

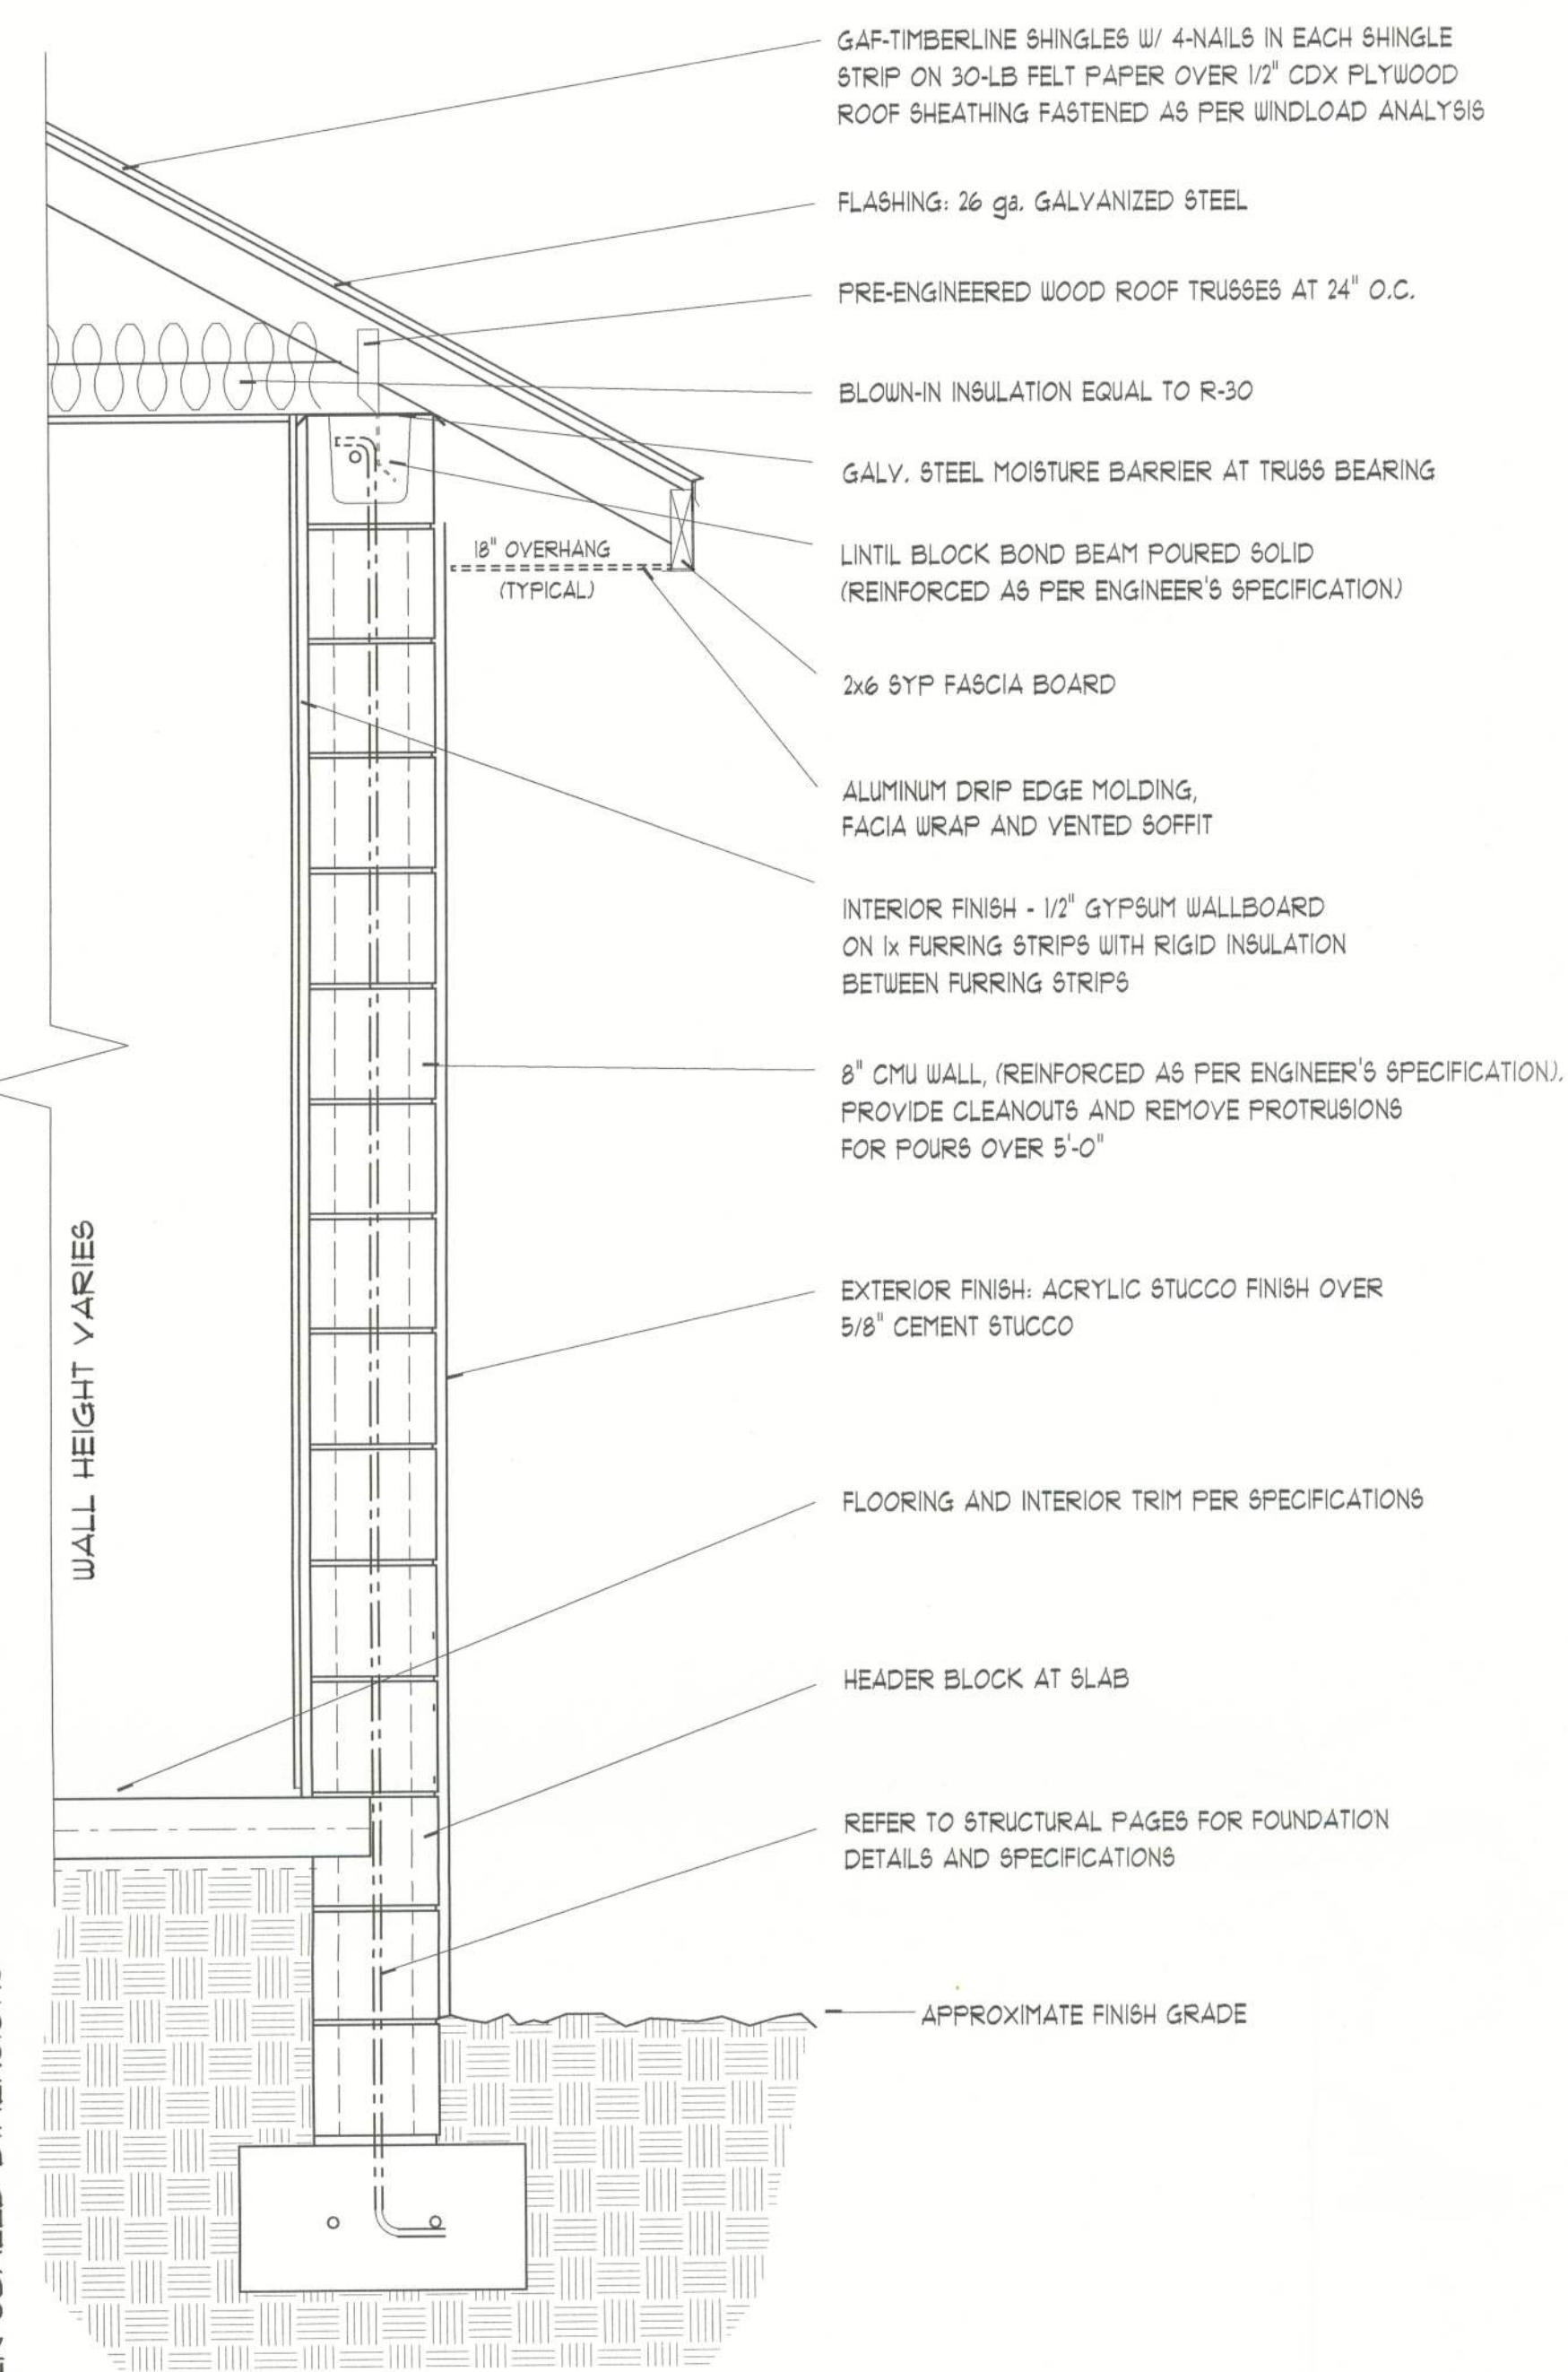

TYPICAL WALL SECTION
SCALE: 1" = 1'

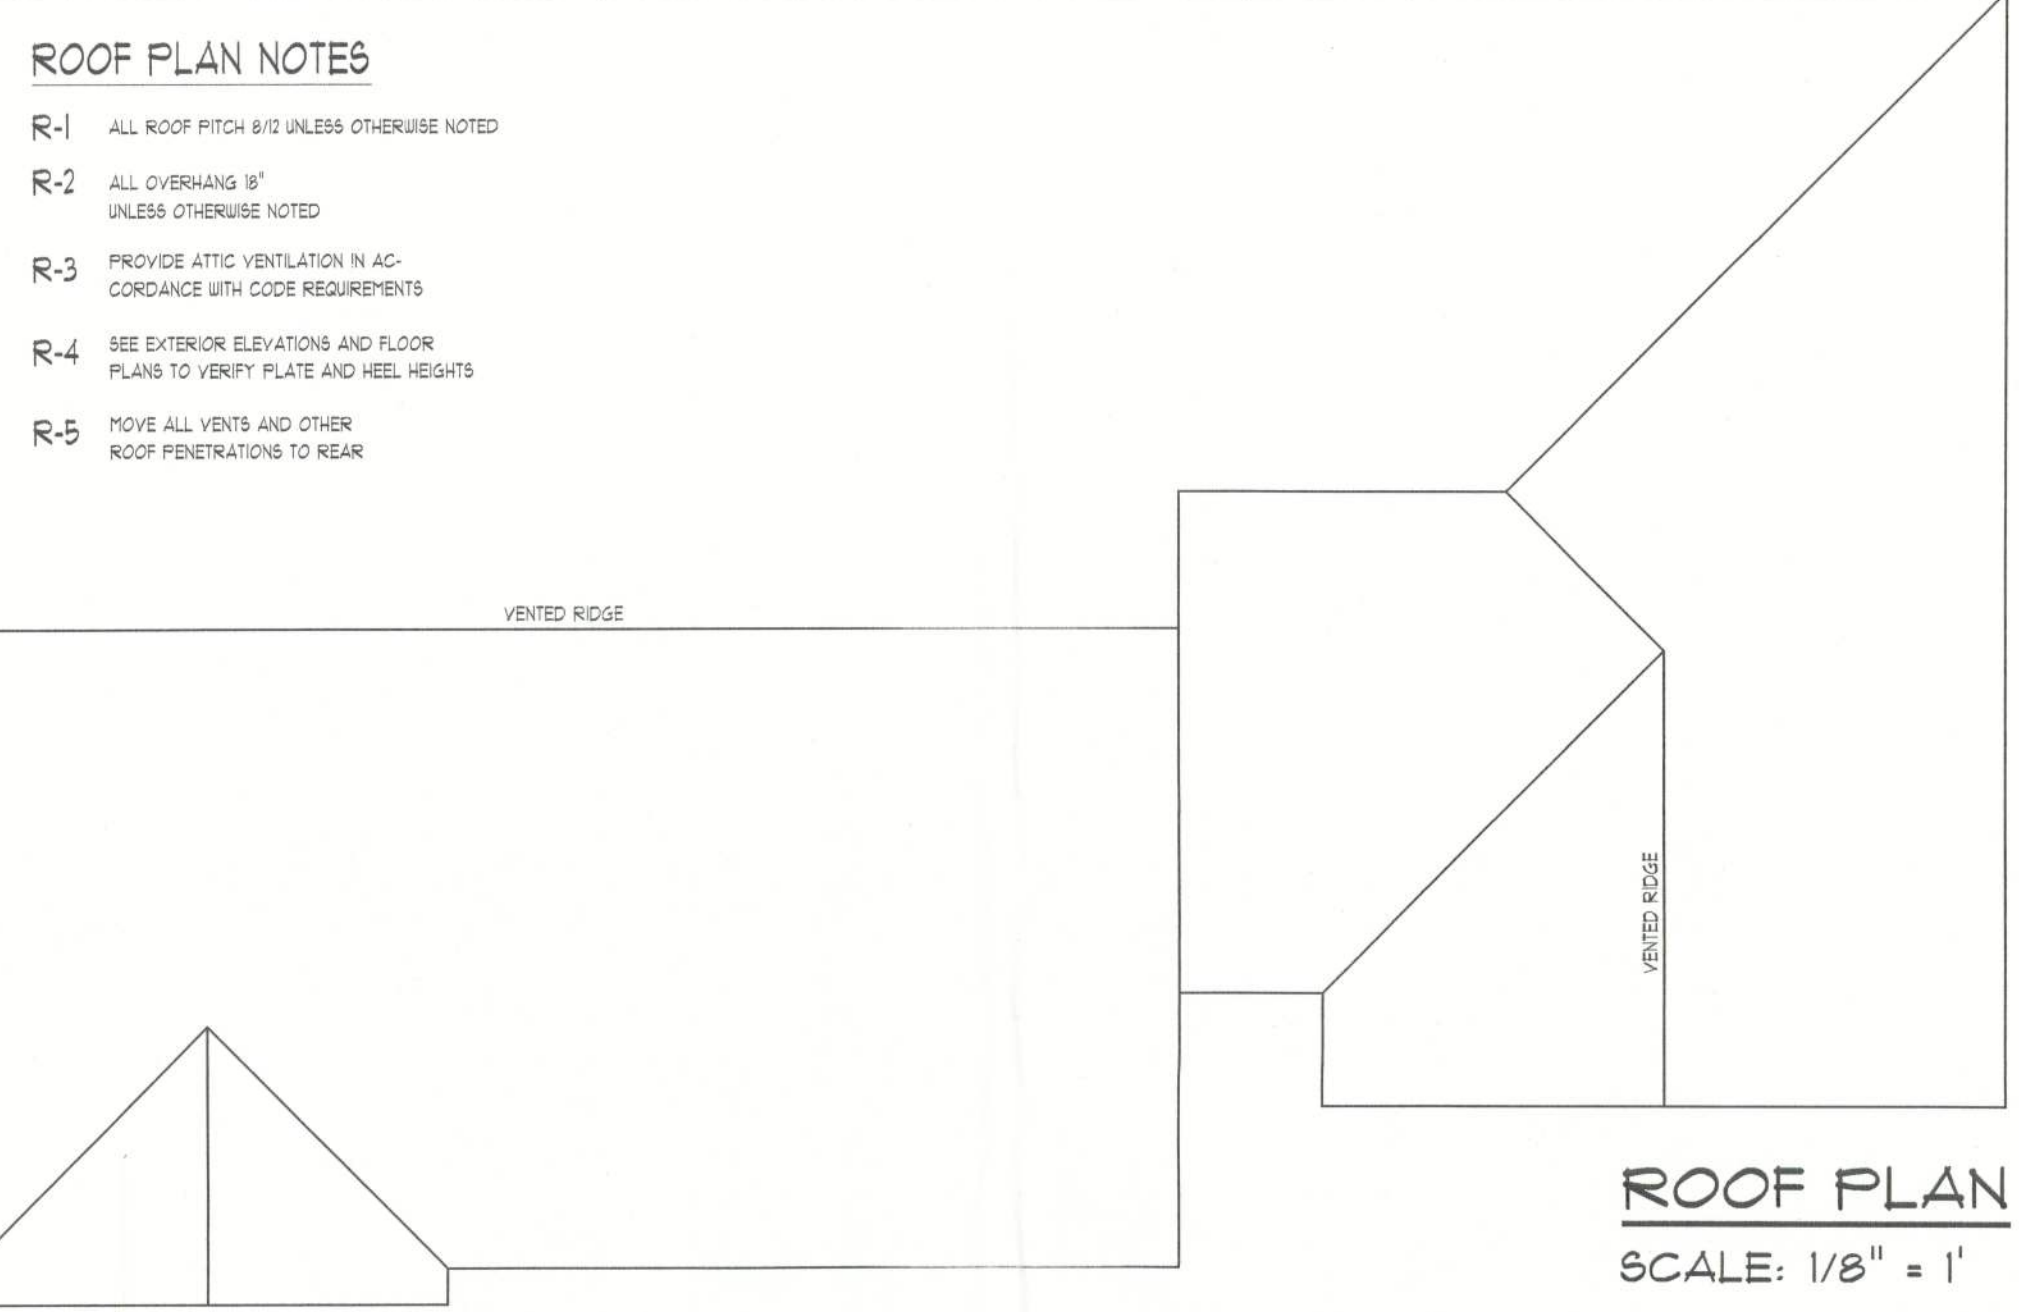

ROOF PLAN
SCALE: 1/8" = 1'

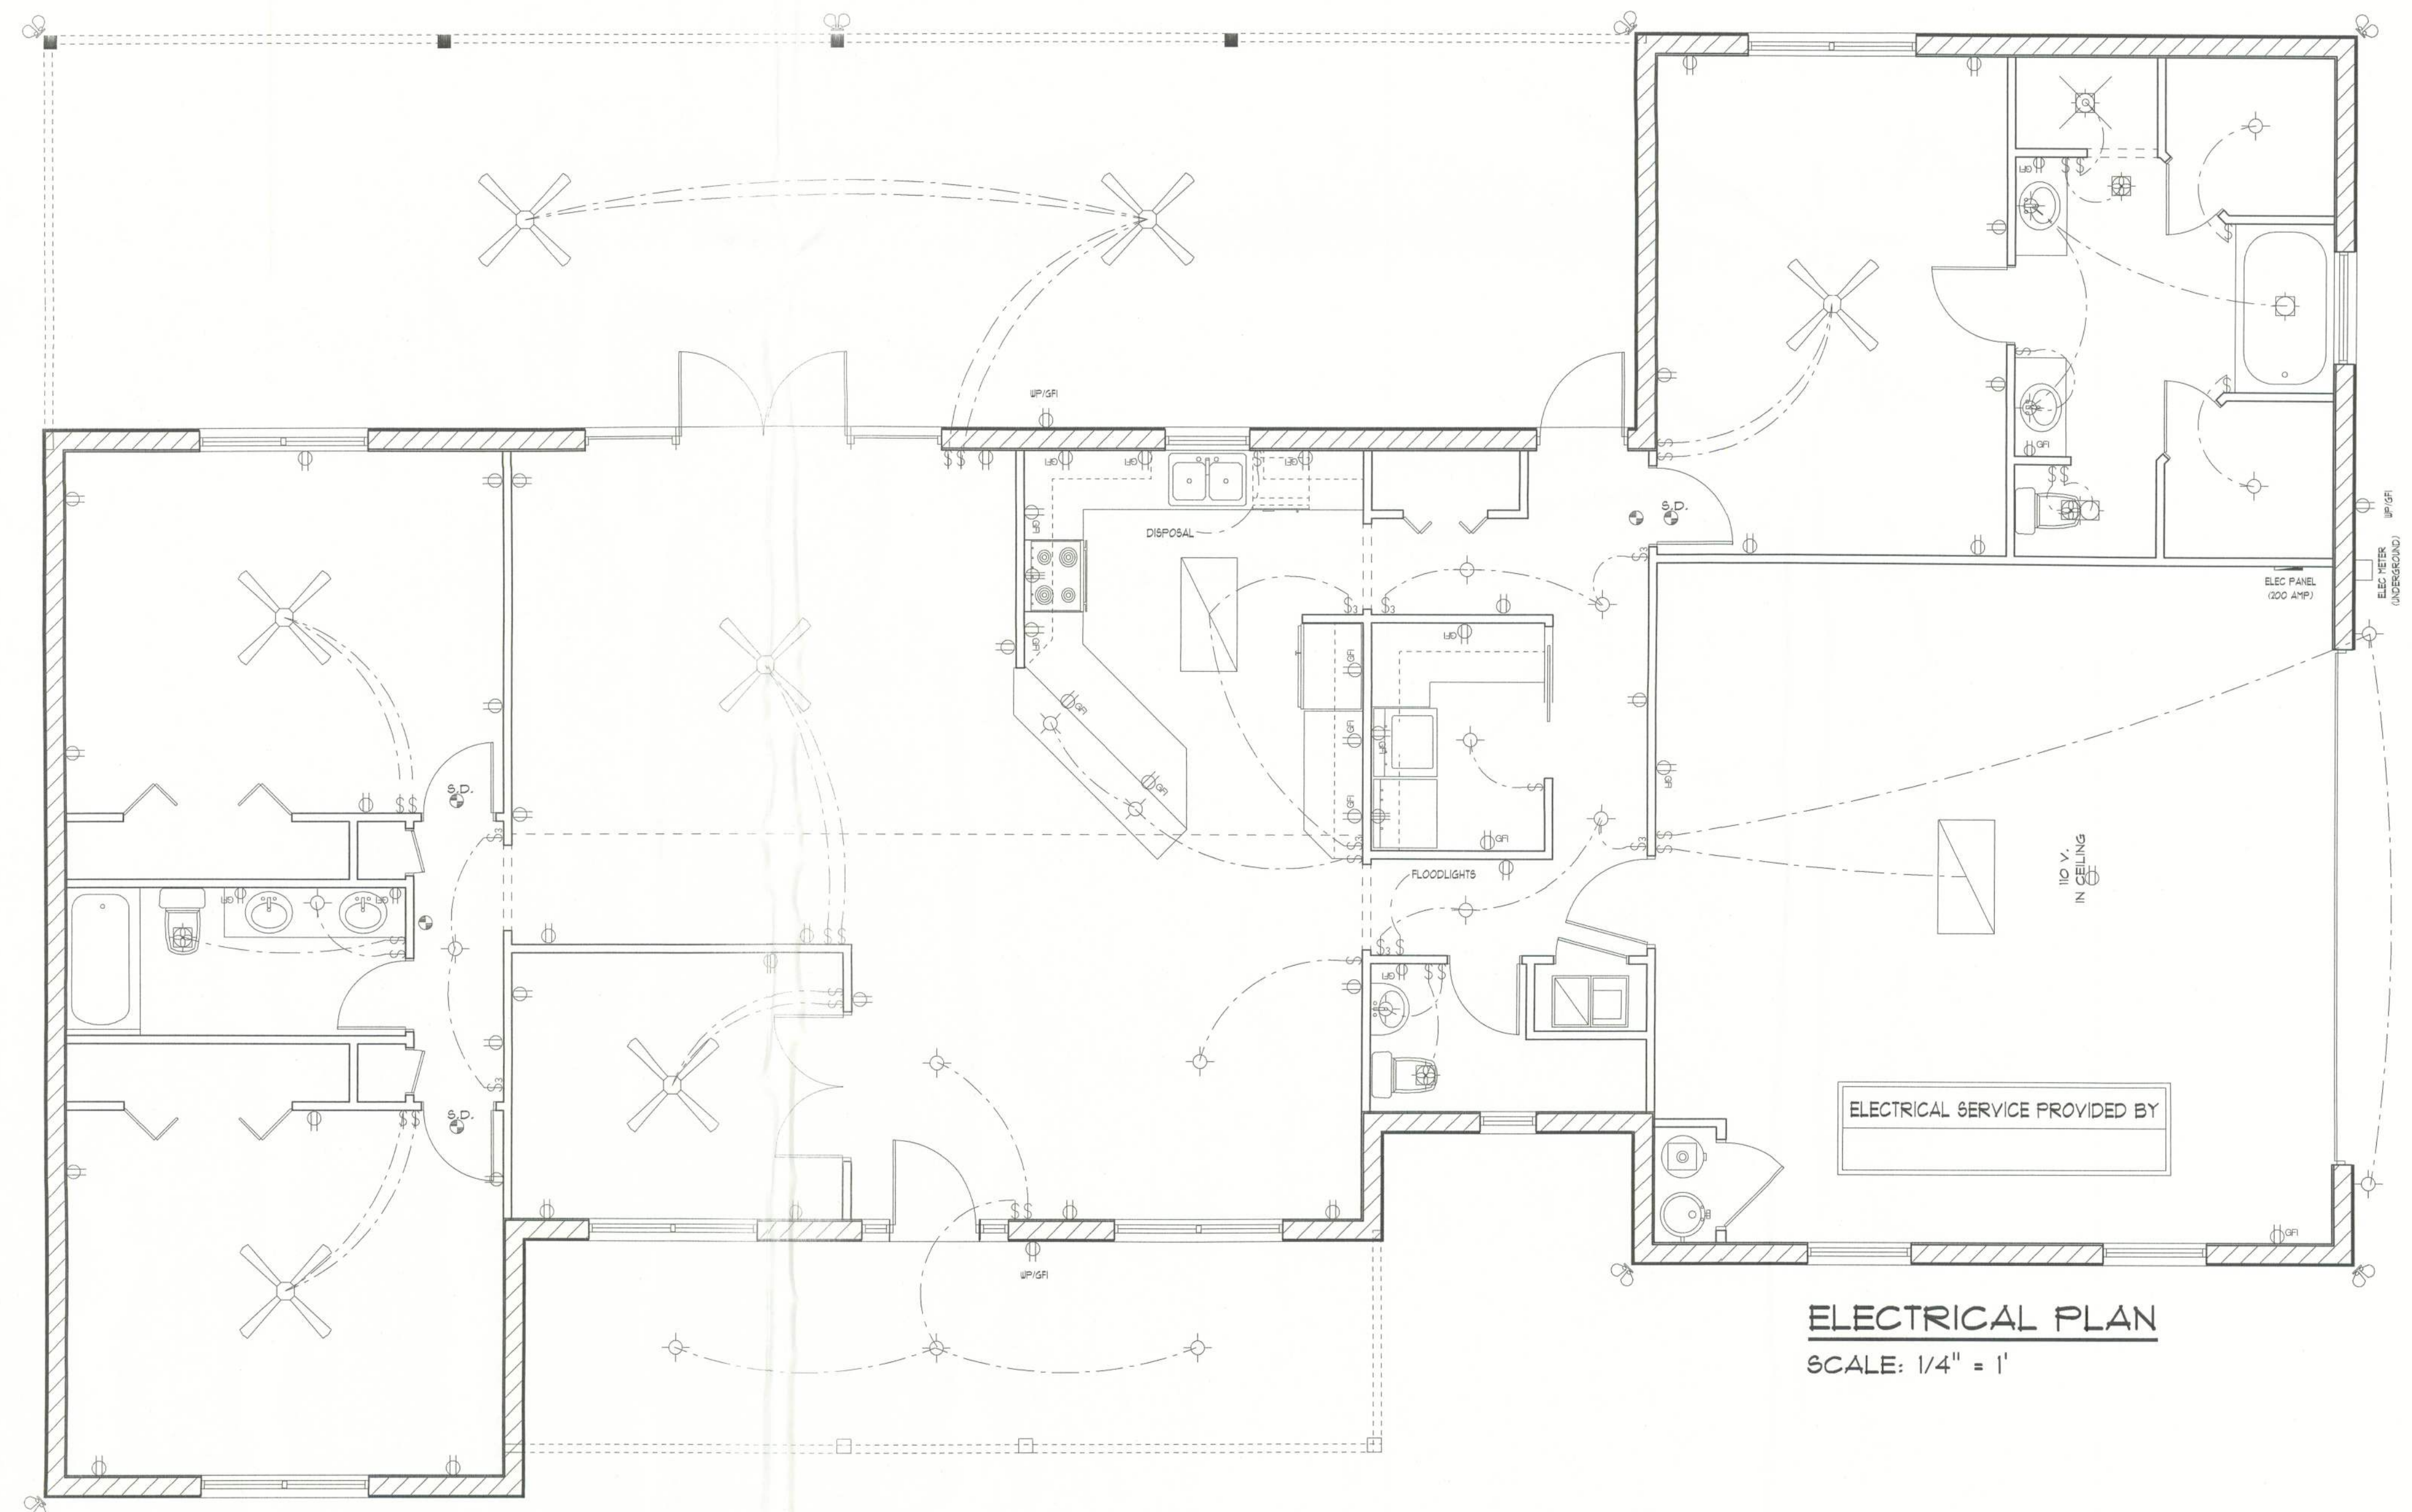

ELECTRICAL PLAN
SCALE: 1/4" = 1'

Daniel Shaheen
Daniel Shaheen

ELECTRICAL PLAN NOTES

- E-1 ALL WORK SHALL COMPLY WITH THE NATIONAL ELECTRICAL CODE, LATEST EDITION, AND ALL OTHER APPLICABLE LOCAL CODES AND ORDINANCES.
- E-2 NOTE: ALL SMOKE DETECTORS TO BE WIRED TOGETHER TO ACTUATE ALL ALARMS IF ANY ONE UNIT IS ACTUATED.
- E-3 PROVIDE WIRING AS REQUIRED FOR APPLIANCES, AIR CONDITIONING, HEATING AND WATER HEATING EQUIPMENT.
- E-4 ALL BEDROOM RECEPTACLES SHALL BE AFCI. (ARC FAULT CIRCUIT INTERRUPT)

NOTE:
THIS ELECTRICAL PLAN IS A SCHEMATIC WITH SUGGESTED SWITCH, RECEPTACLE AND LIGHT FIXTURE LOCATIONS. DUE TO VARYING LOCAL AND STATE CODES, REGULATIONS, AND STATUTES, IT IS THE RESPONSIBILITY OF THE OWNER AND/OR CONTRACTOR TO COMPLY WITH ALL LOCAL AND STATE CODES, REGULATIONS AND STATUTES.

2-06-03



ARCHITECTURAL
DESIGN
P.O. BOX 273
LAKE CITY FL. 32056
(386) 754-0181

COPYRIGHTED BY:

MARK DISOSWAY, P.E.
POB 866, LAKE CITY, FL 32056
PH: (804) 754-5419
PH: (804) 754-6749
FLORIDA P.E. 53915

ENGINEERED BY:

DAVID & JUDITH
ONORATI

DESIGNED FOR:

ELECTRICAL PLAN
ROOF PLAN
TYPICAL WALL SECTION

SHEET NUMBER
3 of 3

All work shall comply with the standard building code, and all applicable local codes and ordinances.
Contractor shall verify all dimensions prior to commencing construction.