


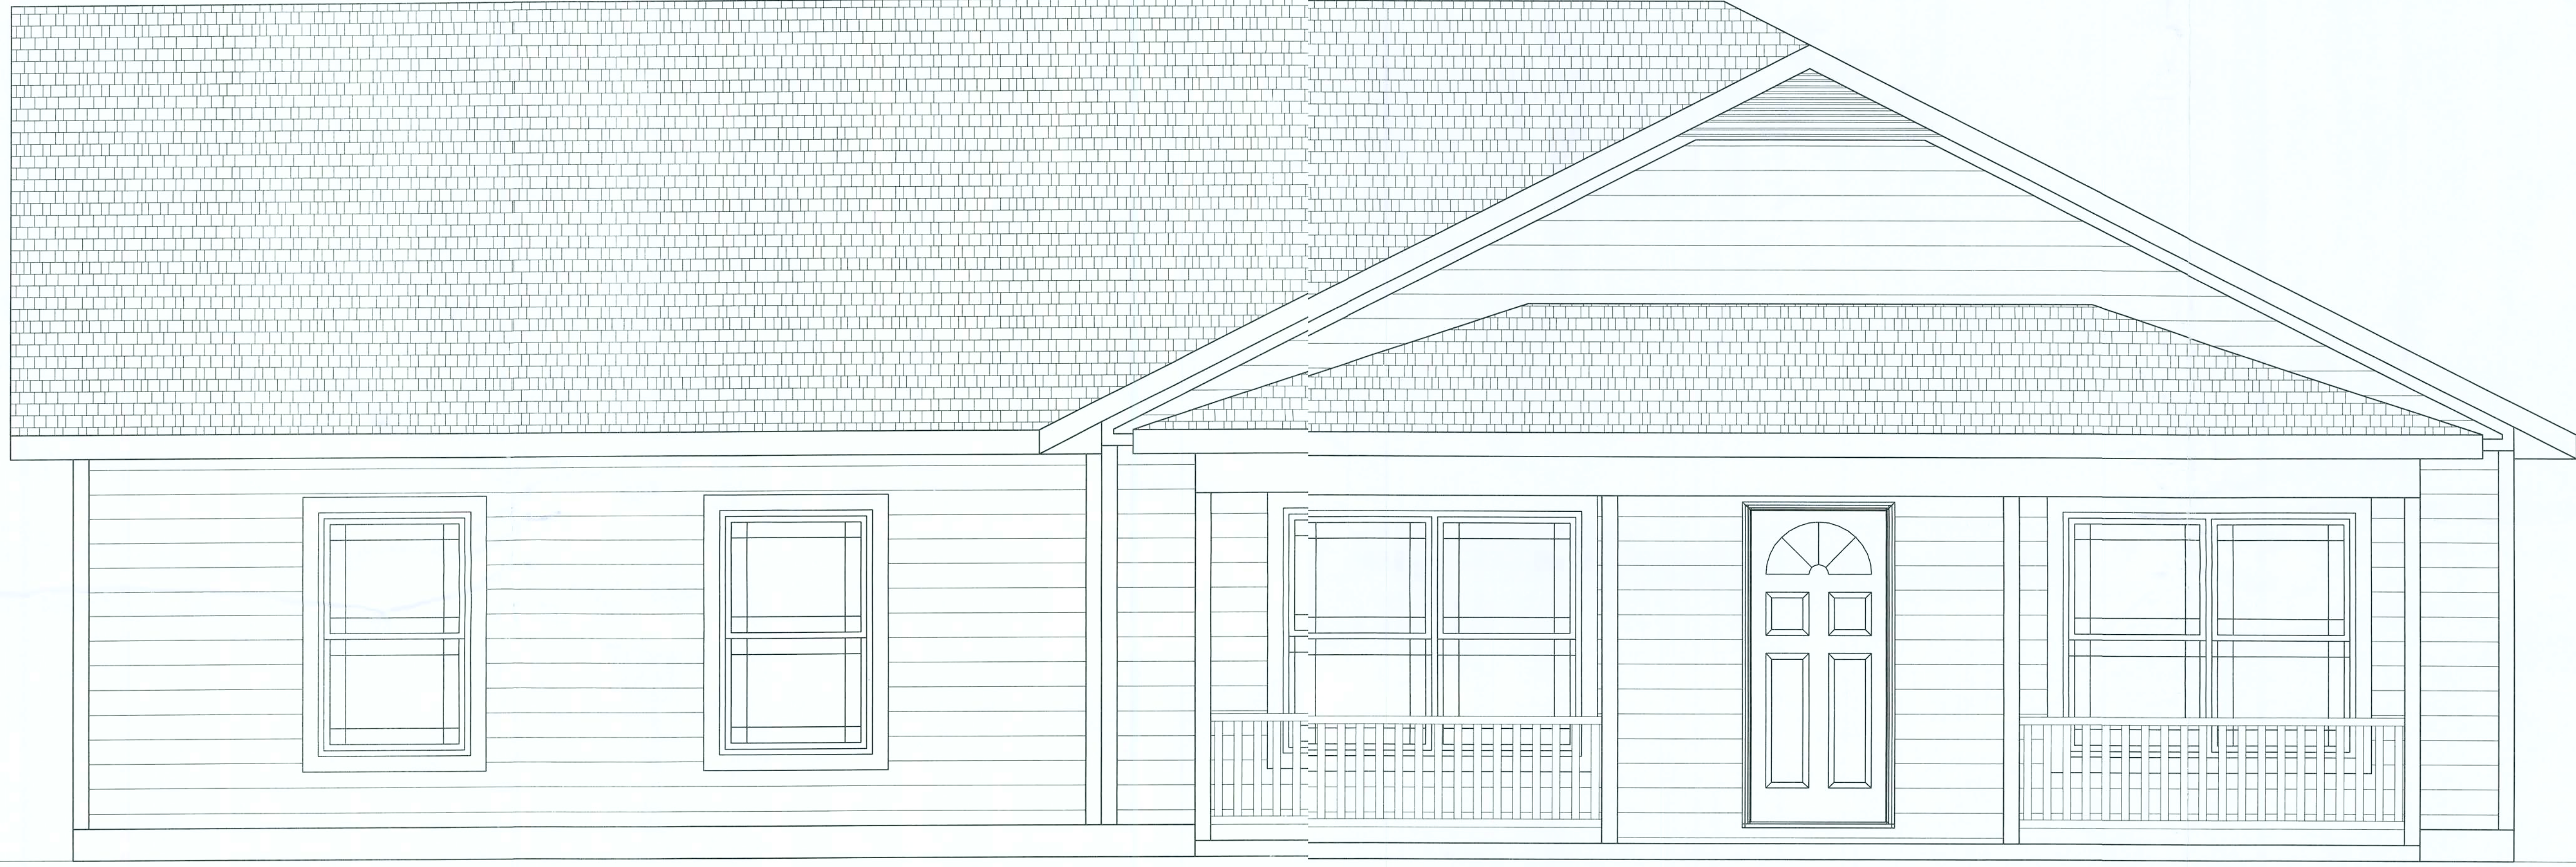

COVER SHEET

JOB #: SF-1

REVISION
STERLING SE LEFT HAND


DATE

SANTA FE RIVER PLANTATIONS


LOT 45

G C Construction CC-C052925
P.O. Box 5893 Phone 386-418-2114
Gainesville, FL 32627 gclennan@att.net

Drawn by: Steve Ryall Architectural Drafting
16794 NW 212th Terrace
Miami Springs, Florida 33064
305-377-1825

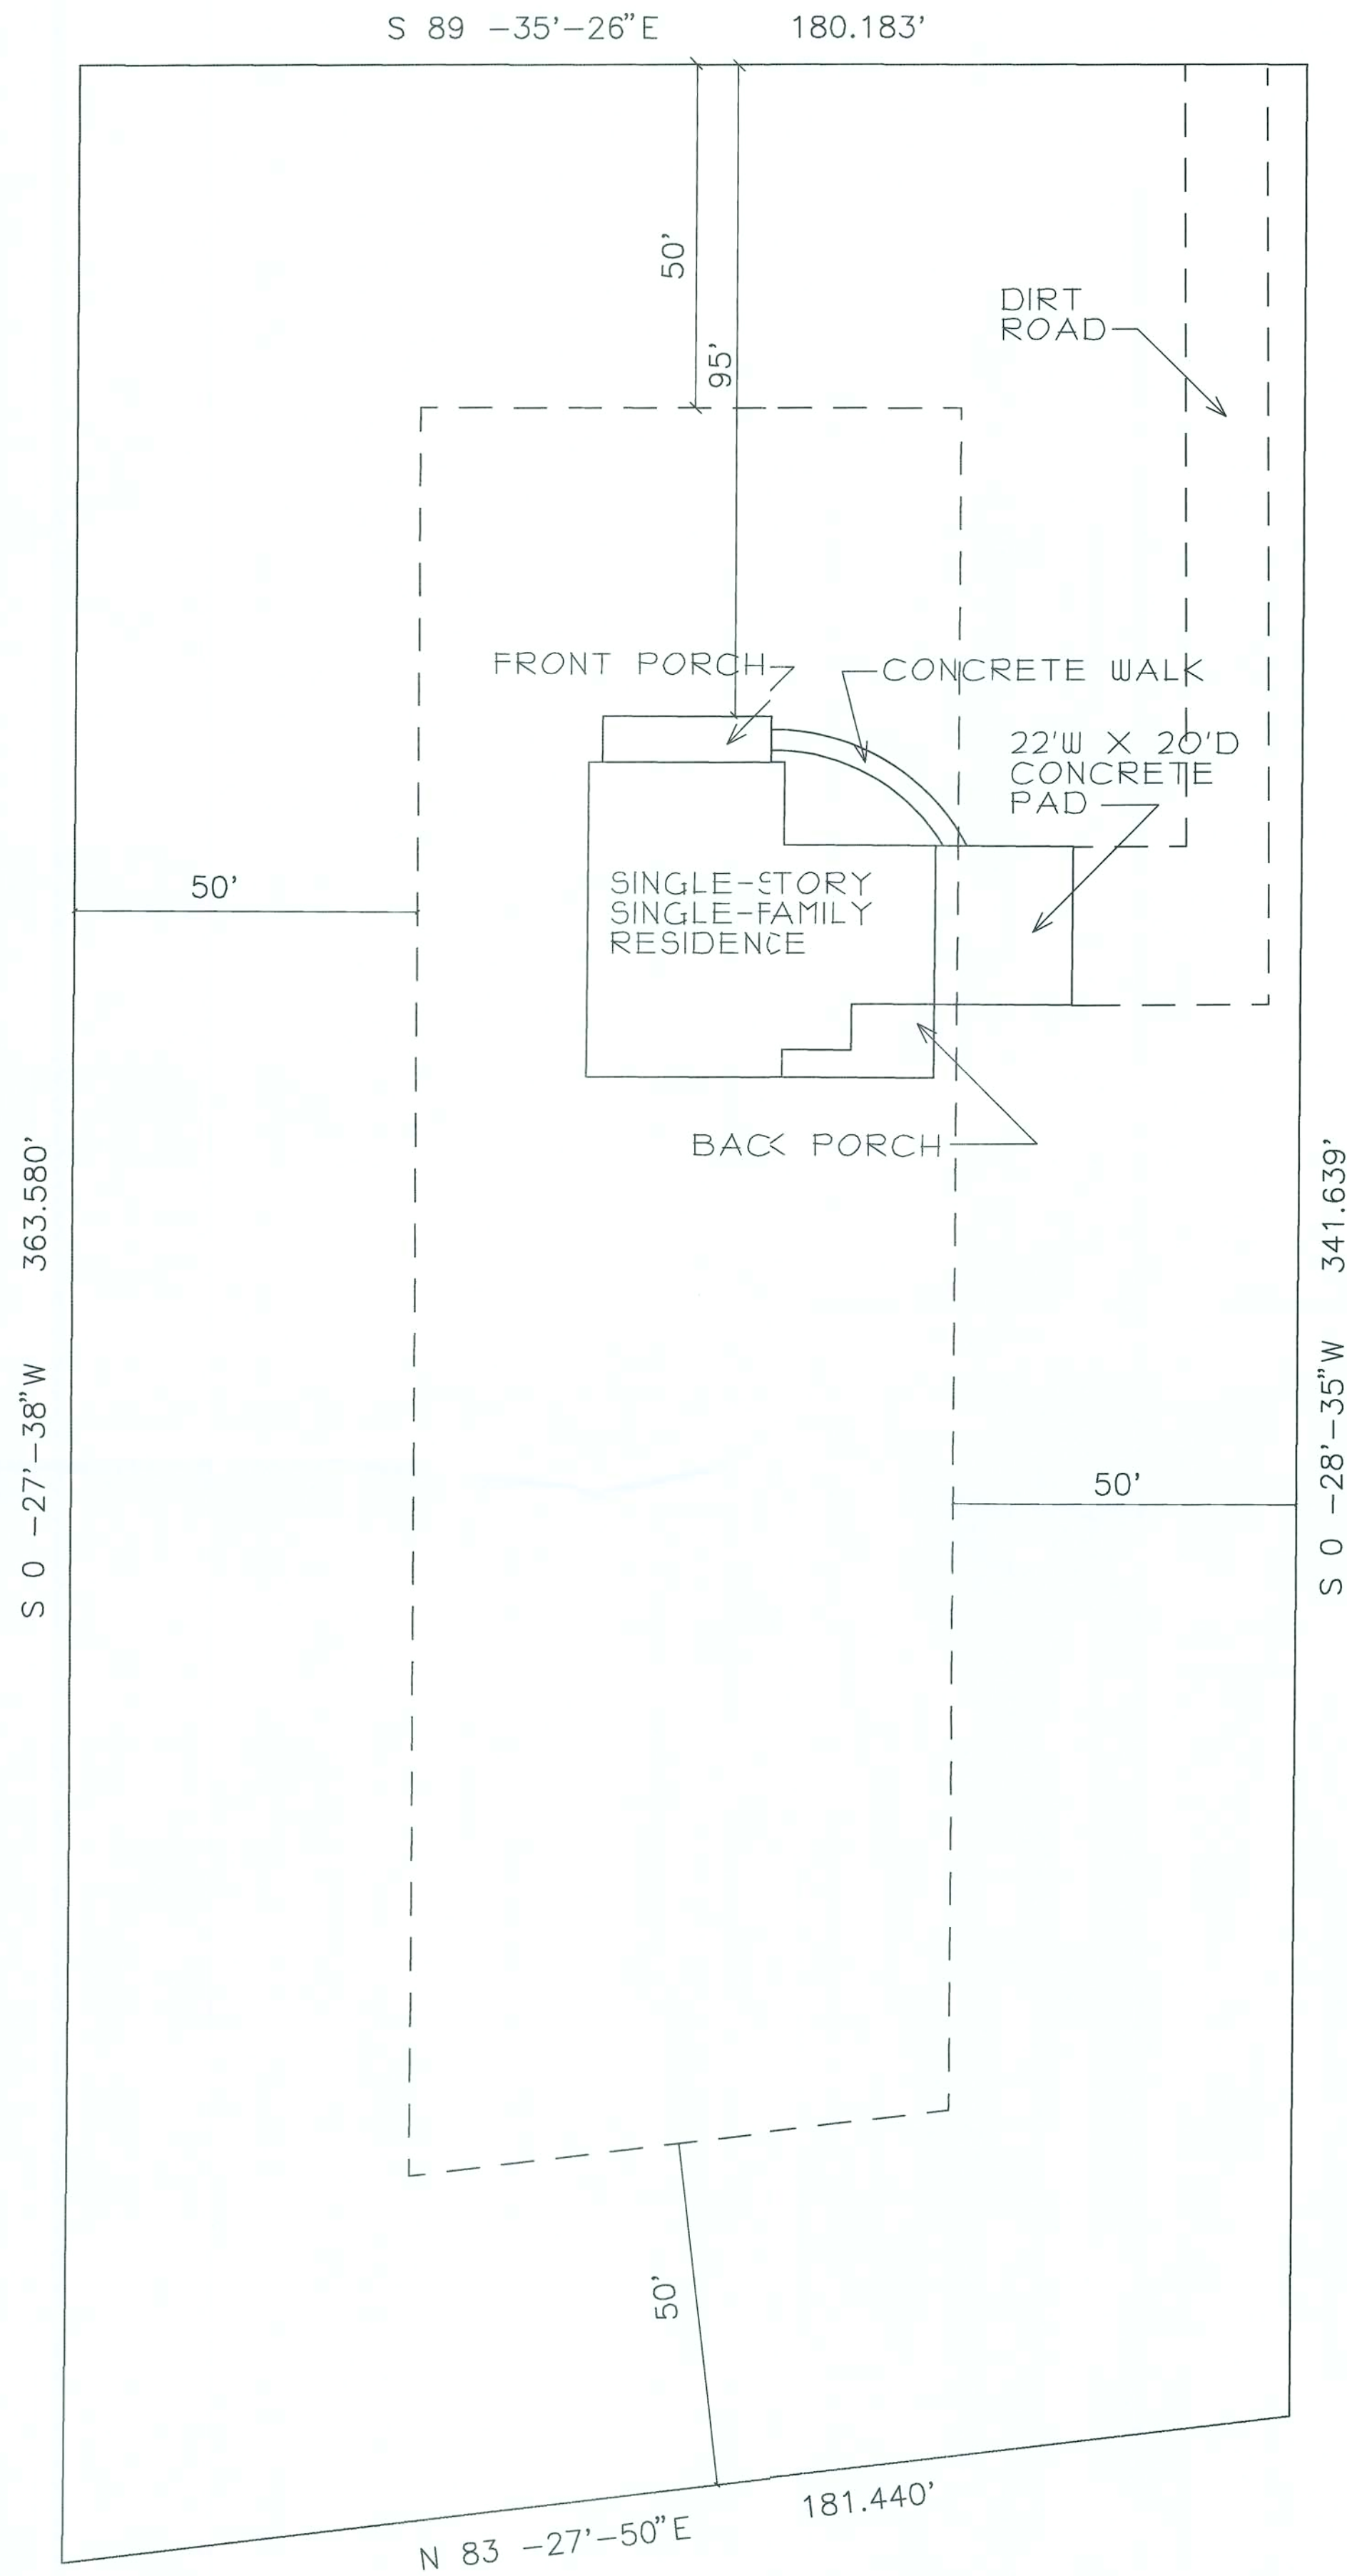

SITE PLAN
SCALE: 1" = 20'-0"

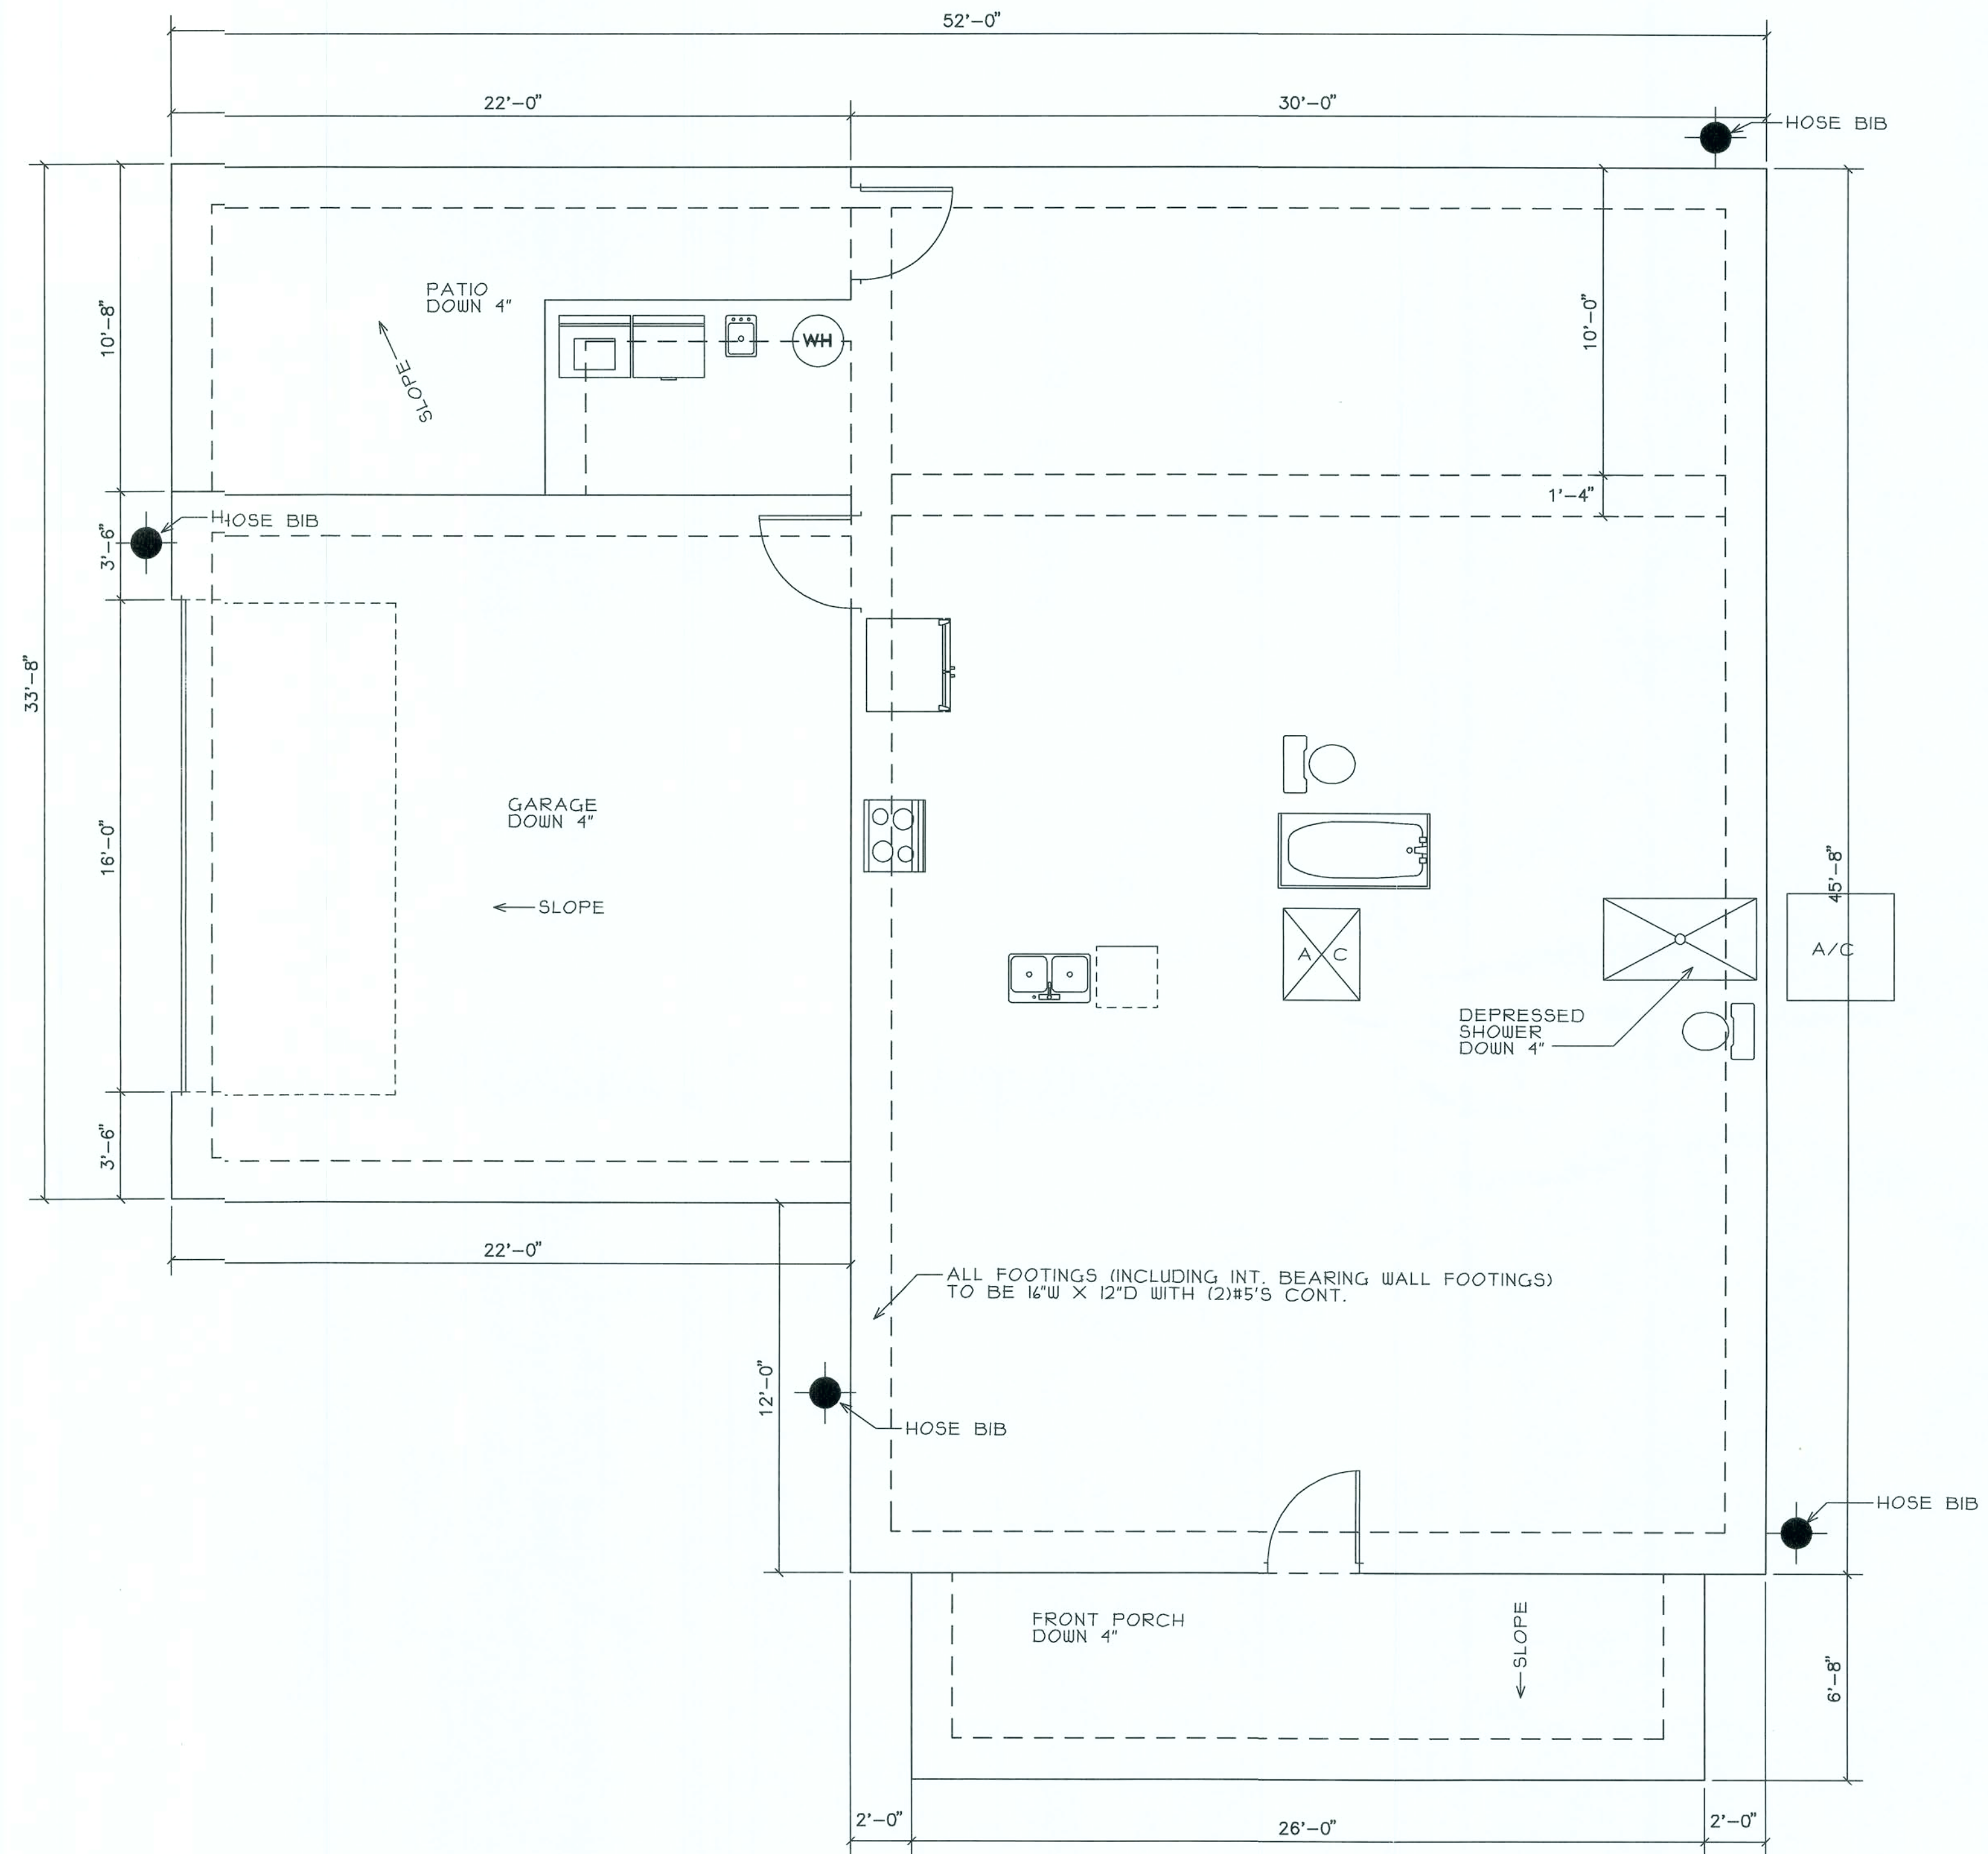

FOUNDATION PLAN
SCALE: 1/4" = 1'-0"

FOUNDATION PLAN

SCALE: 1/4" = 1'-0"
JOD #: SF 1


REVISION
DATE

SANTA FE RIVER PLANTATIONS


LOT 45

G C Construction
P.O. Box 5993
Gainesville, FL 32627
Phone: 386-418-2114
gclennan@att.net
Steve Ryal Architectural Drafting
16794 NW 212th Terrace
Fort Meade, FL 32843
352-871-6251


1

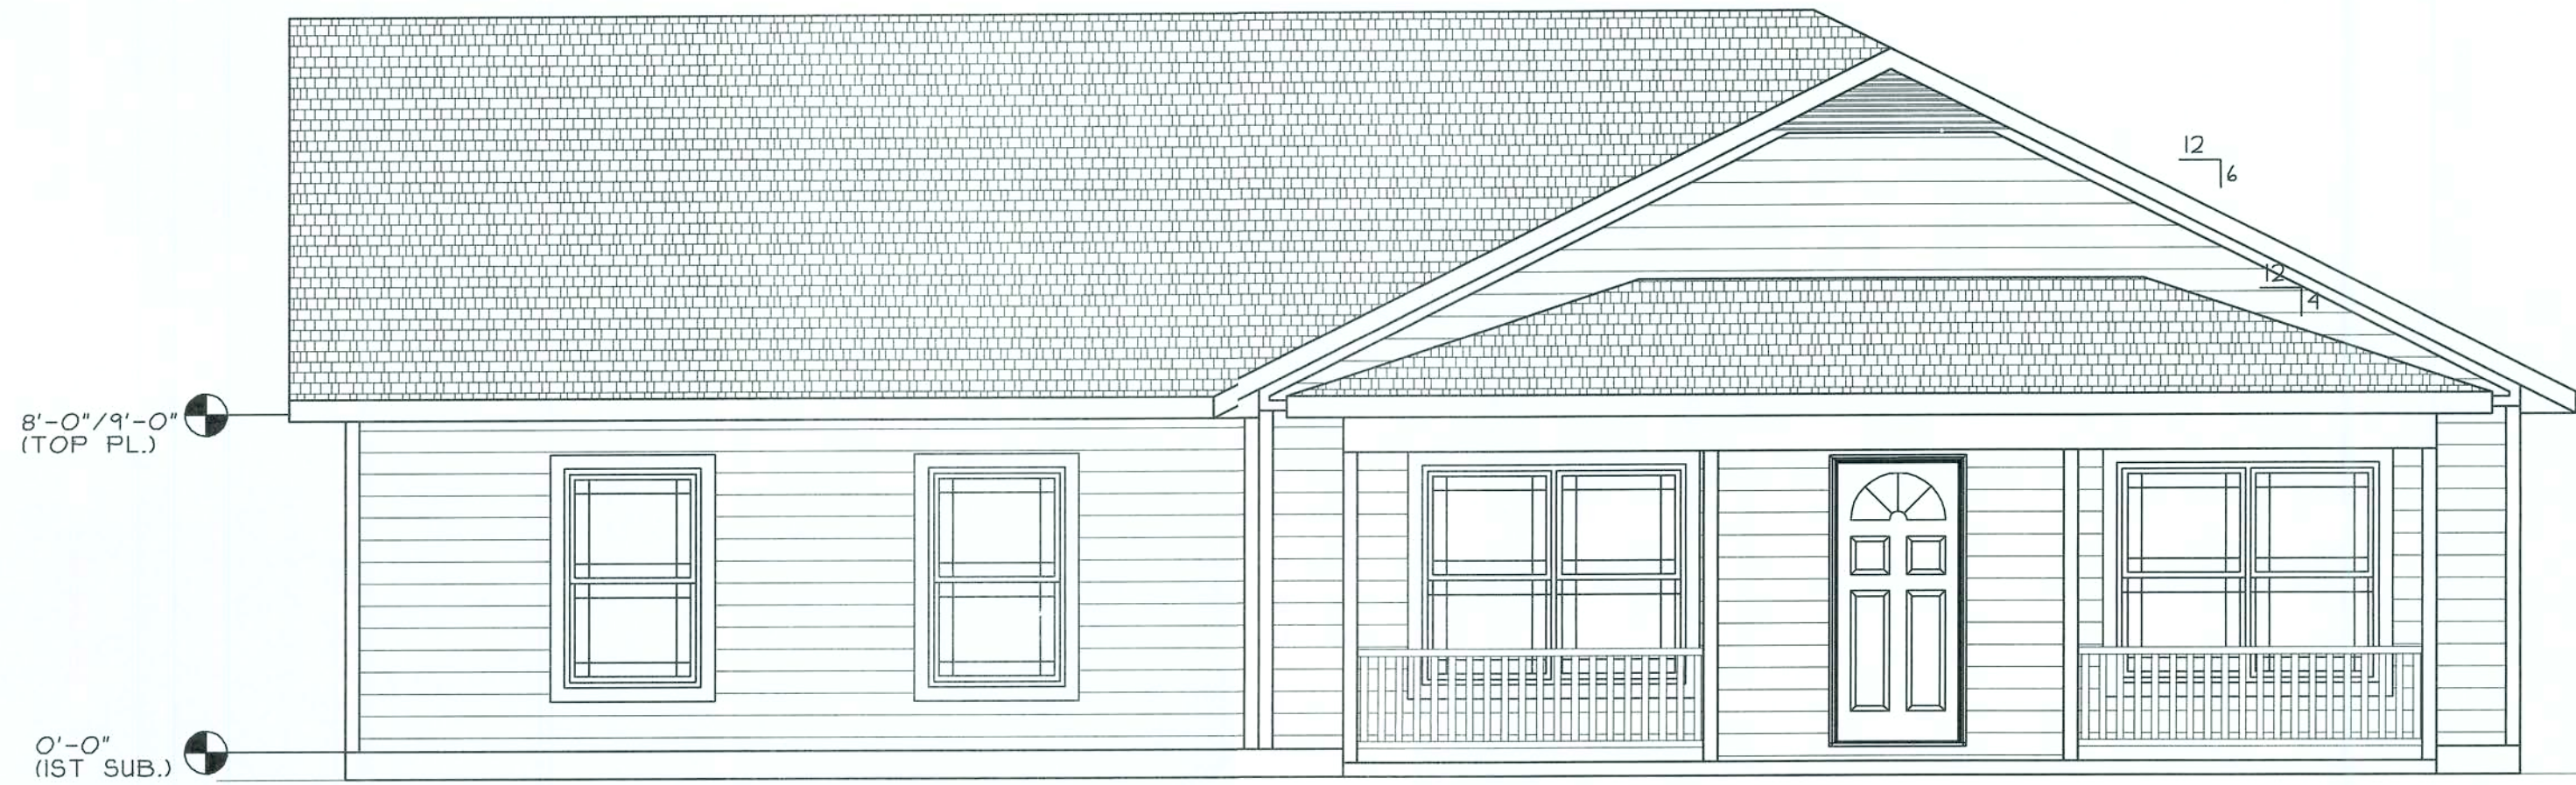


FRONT ELEVATION
SCALE: 1/4" = 1'-0"

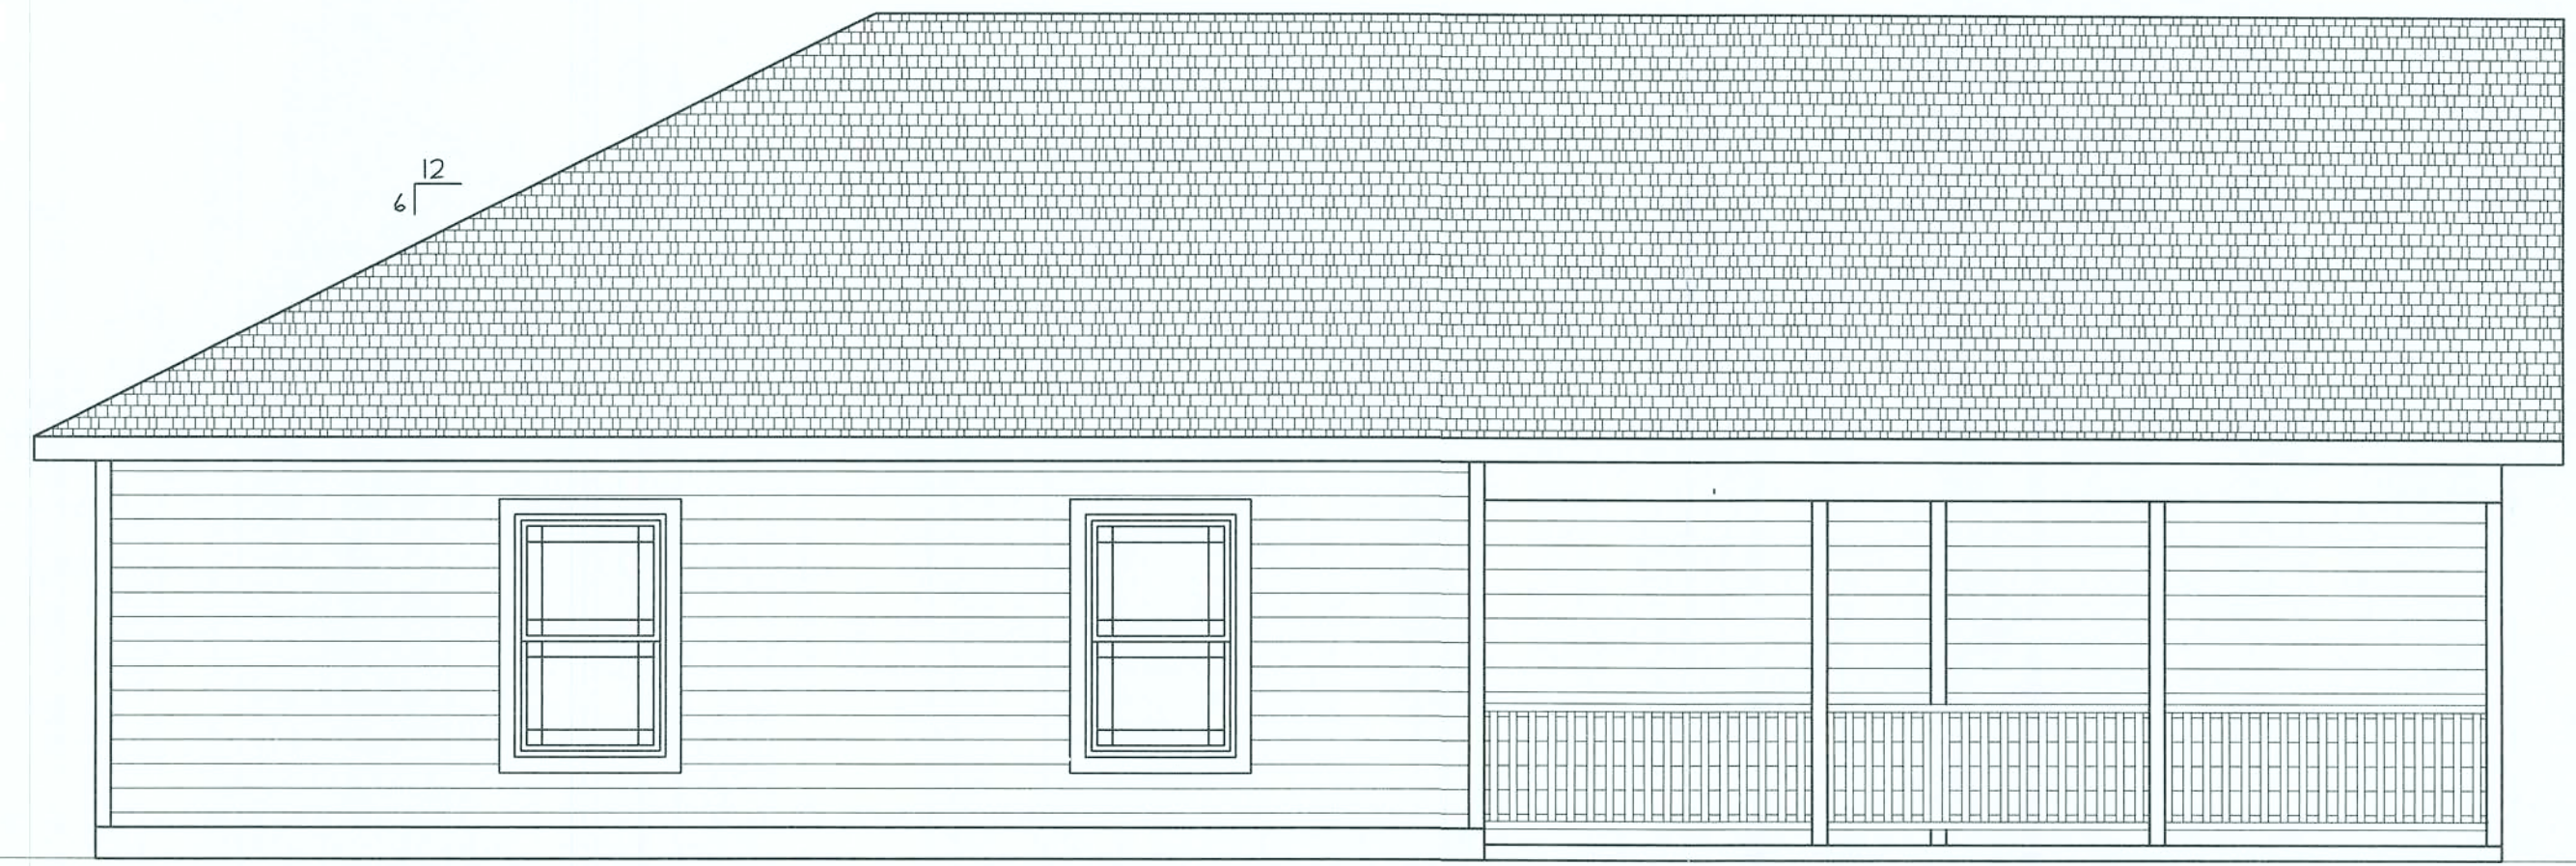

REAR ELEVATION
SCALE: 1/4" = 1'-0"

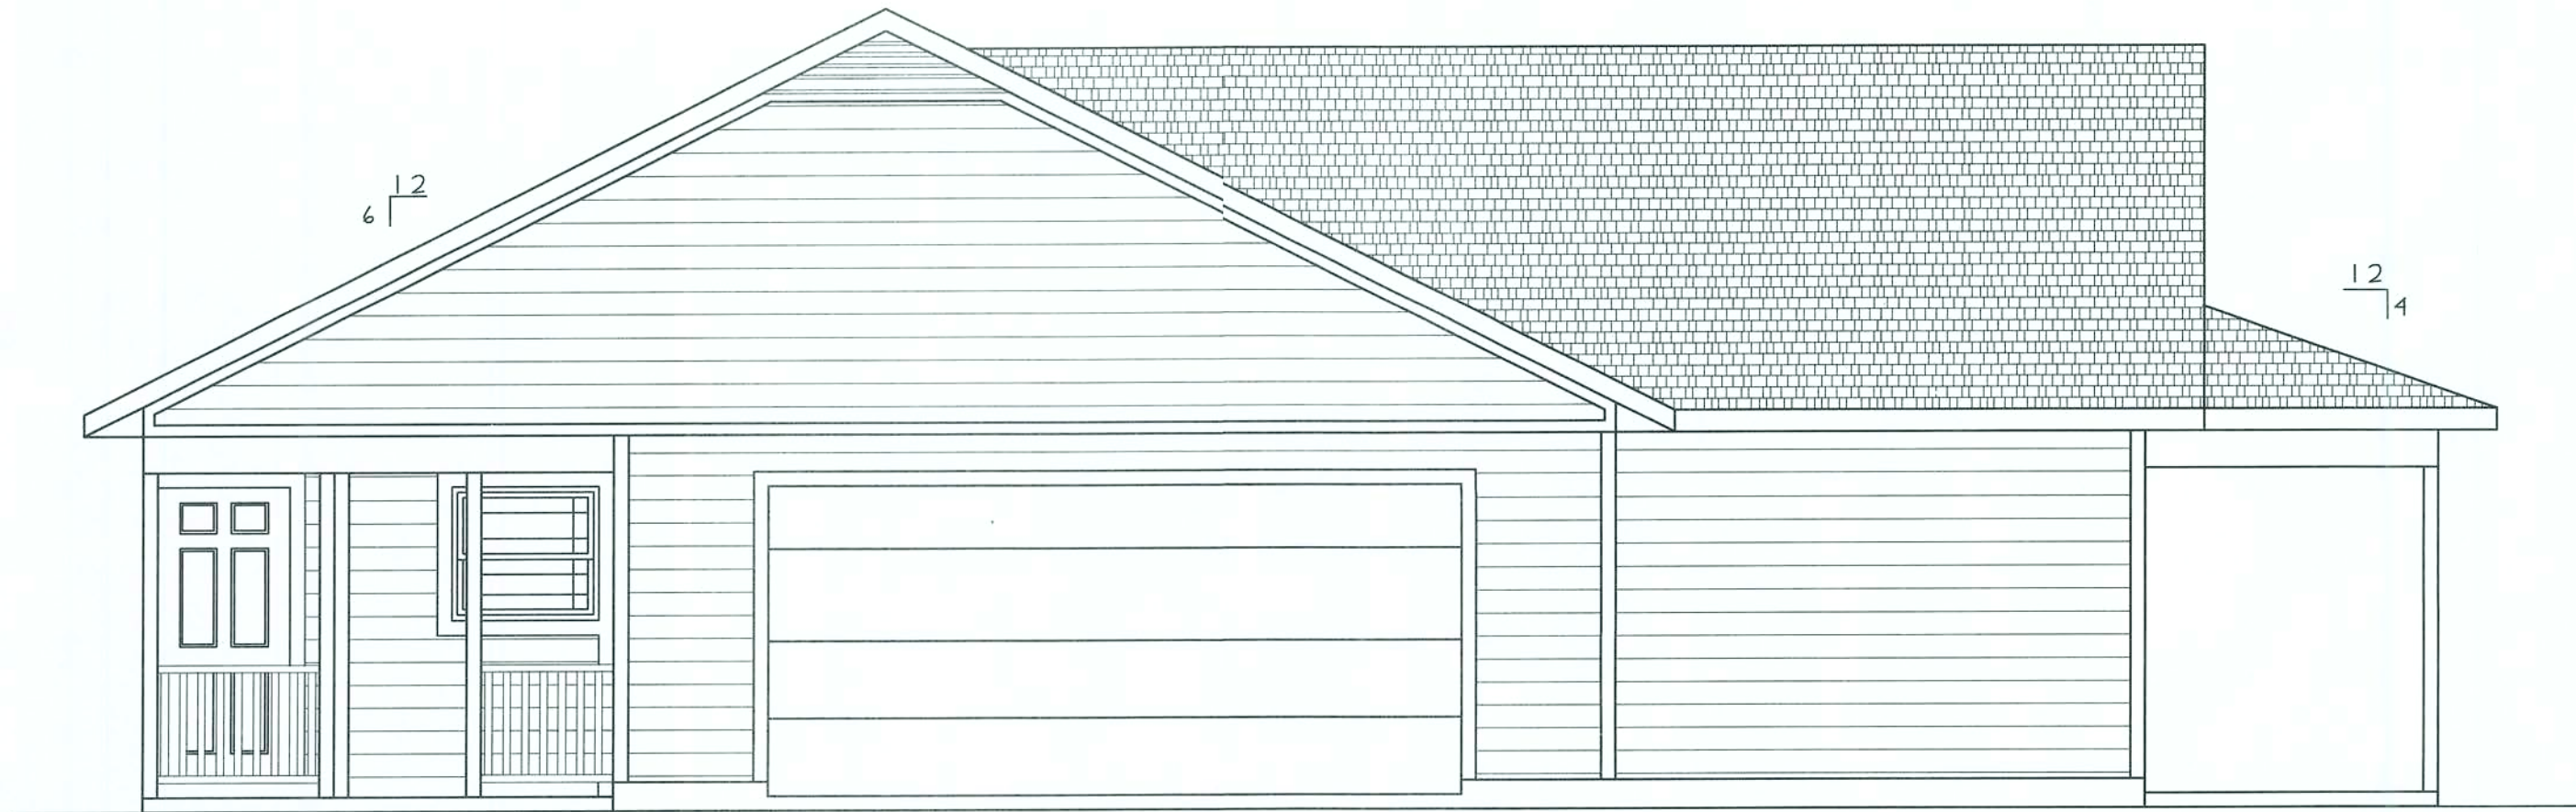

LEFT ELEVATION
SCALE: 1/4" = 1'-0"

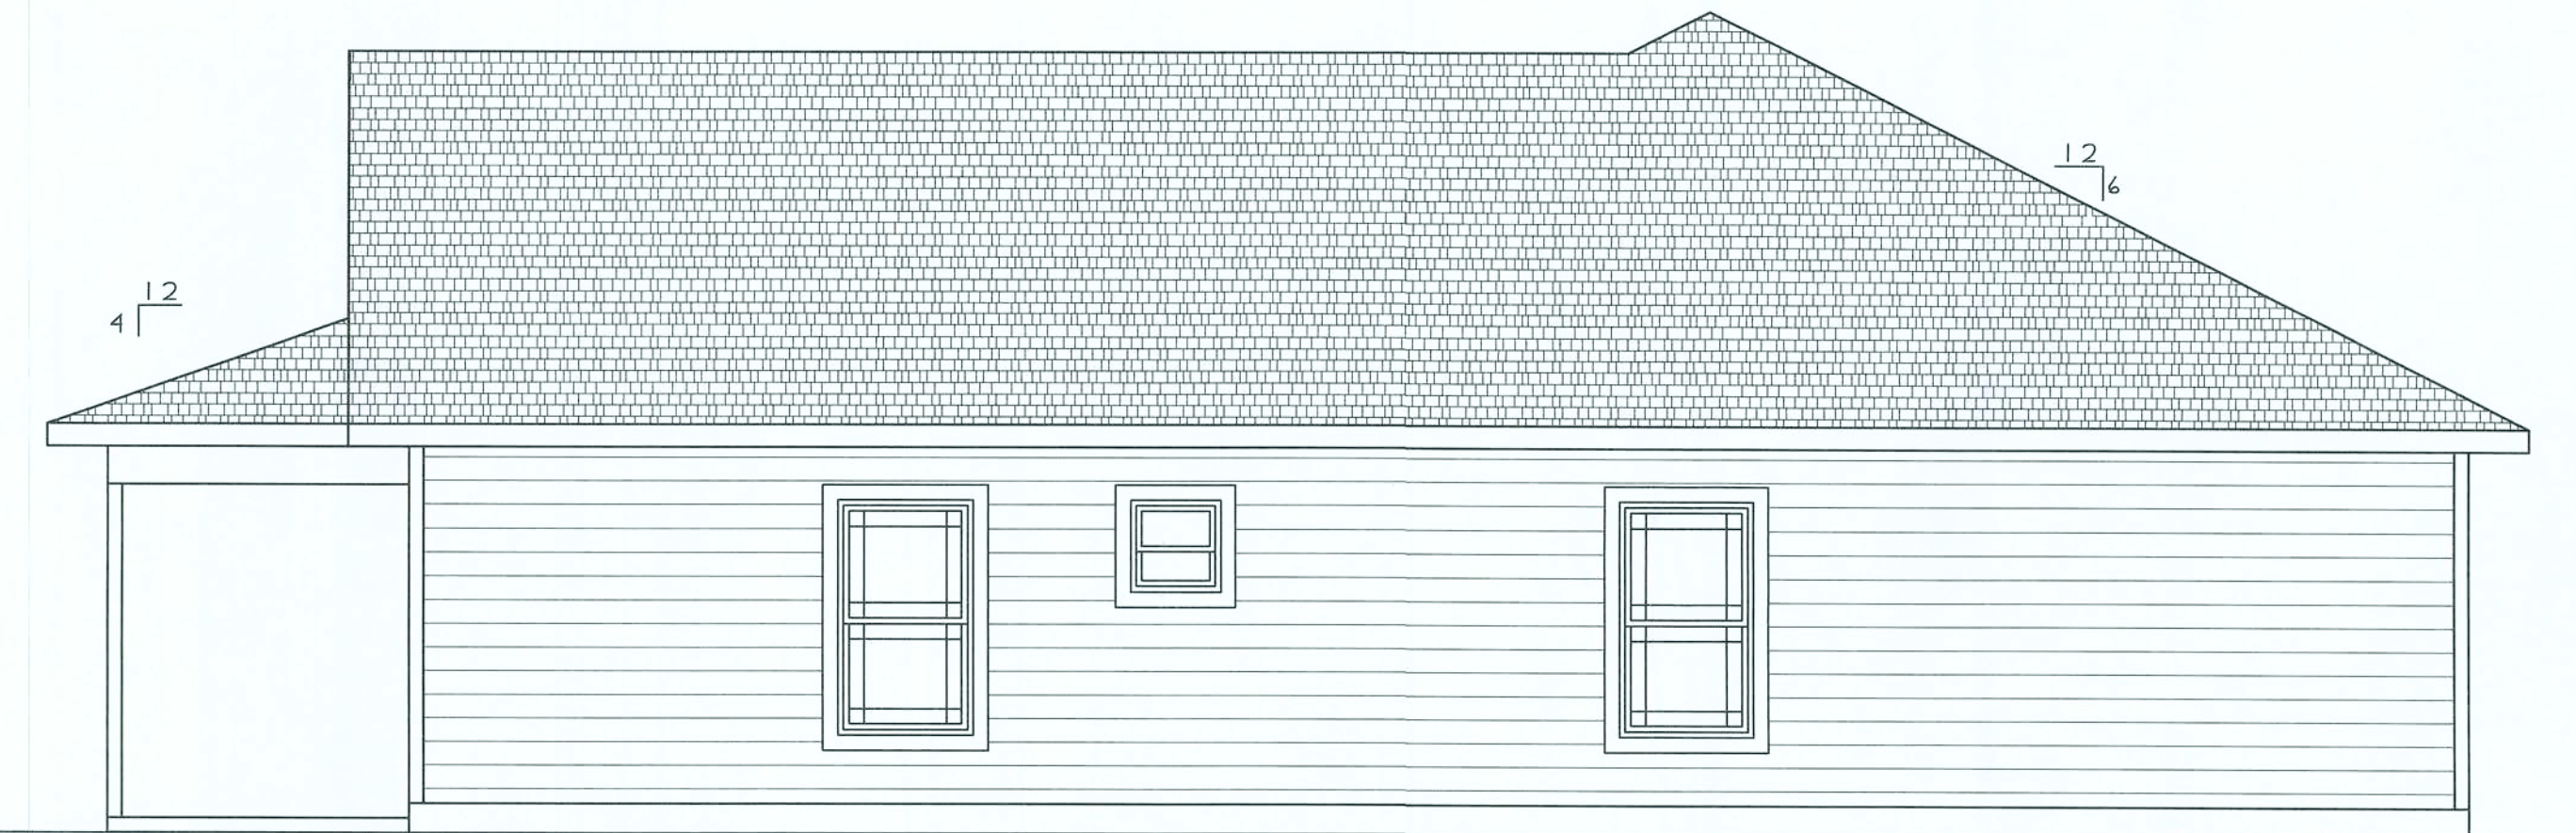

RIGHT ELEVATION
SCALE: 1/4" = 1'-0"

G C Construction CC-C052925
P.O. Box 5893 Phone 386-418-2114
Gainesville, FL 32627 gclenmon@alltel.net
Drawn by: Steve Ryall Architectural Drafting
16794 NW 212th Terrace
High Springs, Florida 32643
352-371-1821

SANTA FE RIVER PLANTATIONS


LOT 45

ELEVATIONS

SCALE: 1/4" = 1'-0"
JOB #: SF-1
REVISION
DATE

3

ELECTRICAL KEY	
	CEILING FAN WITH LIGHT FIXT.
	SMOKE DETECTOR
	RECESSED LIGHT
	SINGLE SWITCH
	2-WAY SWITCH
	DUPLEX OUTLET
	DUPLEX GFI OUTLET
	220 OUTLET
	RANGE OUTLET
	SECURITY LIGHT
	TV/CABLE OUTLET
	PHONE/ETHERNET
	EXHAUST FAN
	2X4 FLOR. FIXTURE
	COACH LT/BALL FIXT
	HANGING LIGHT FIXT.

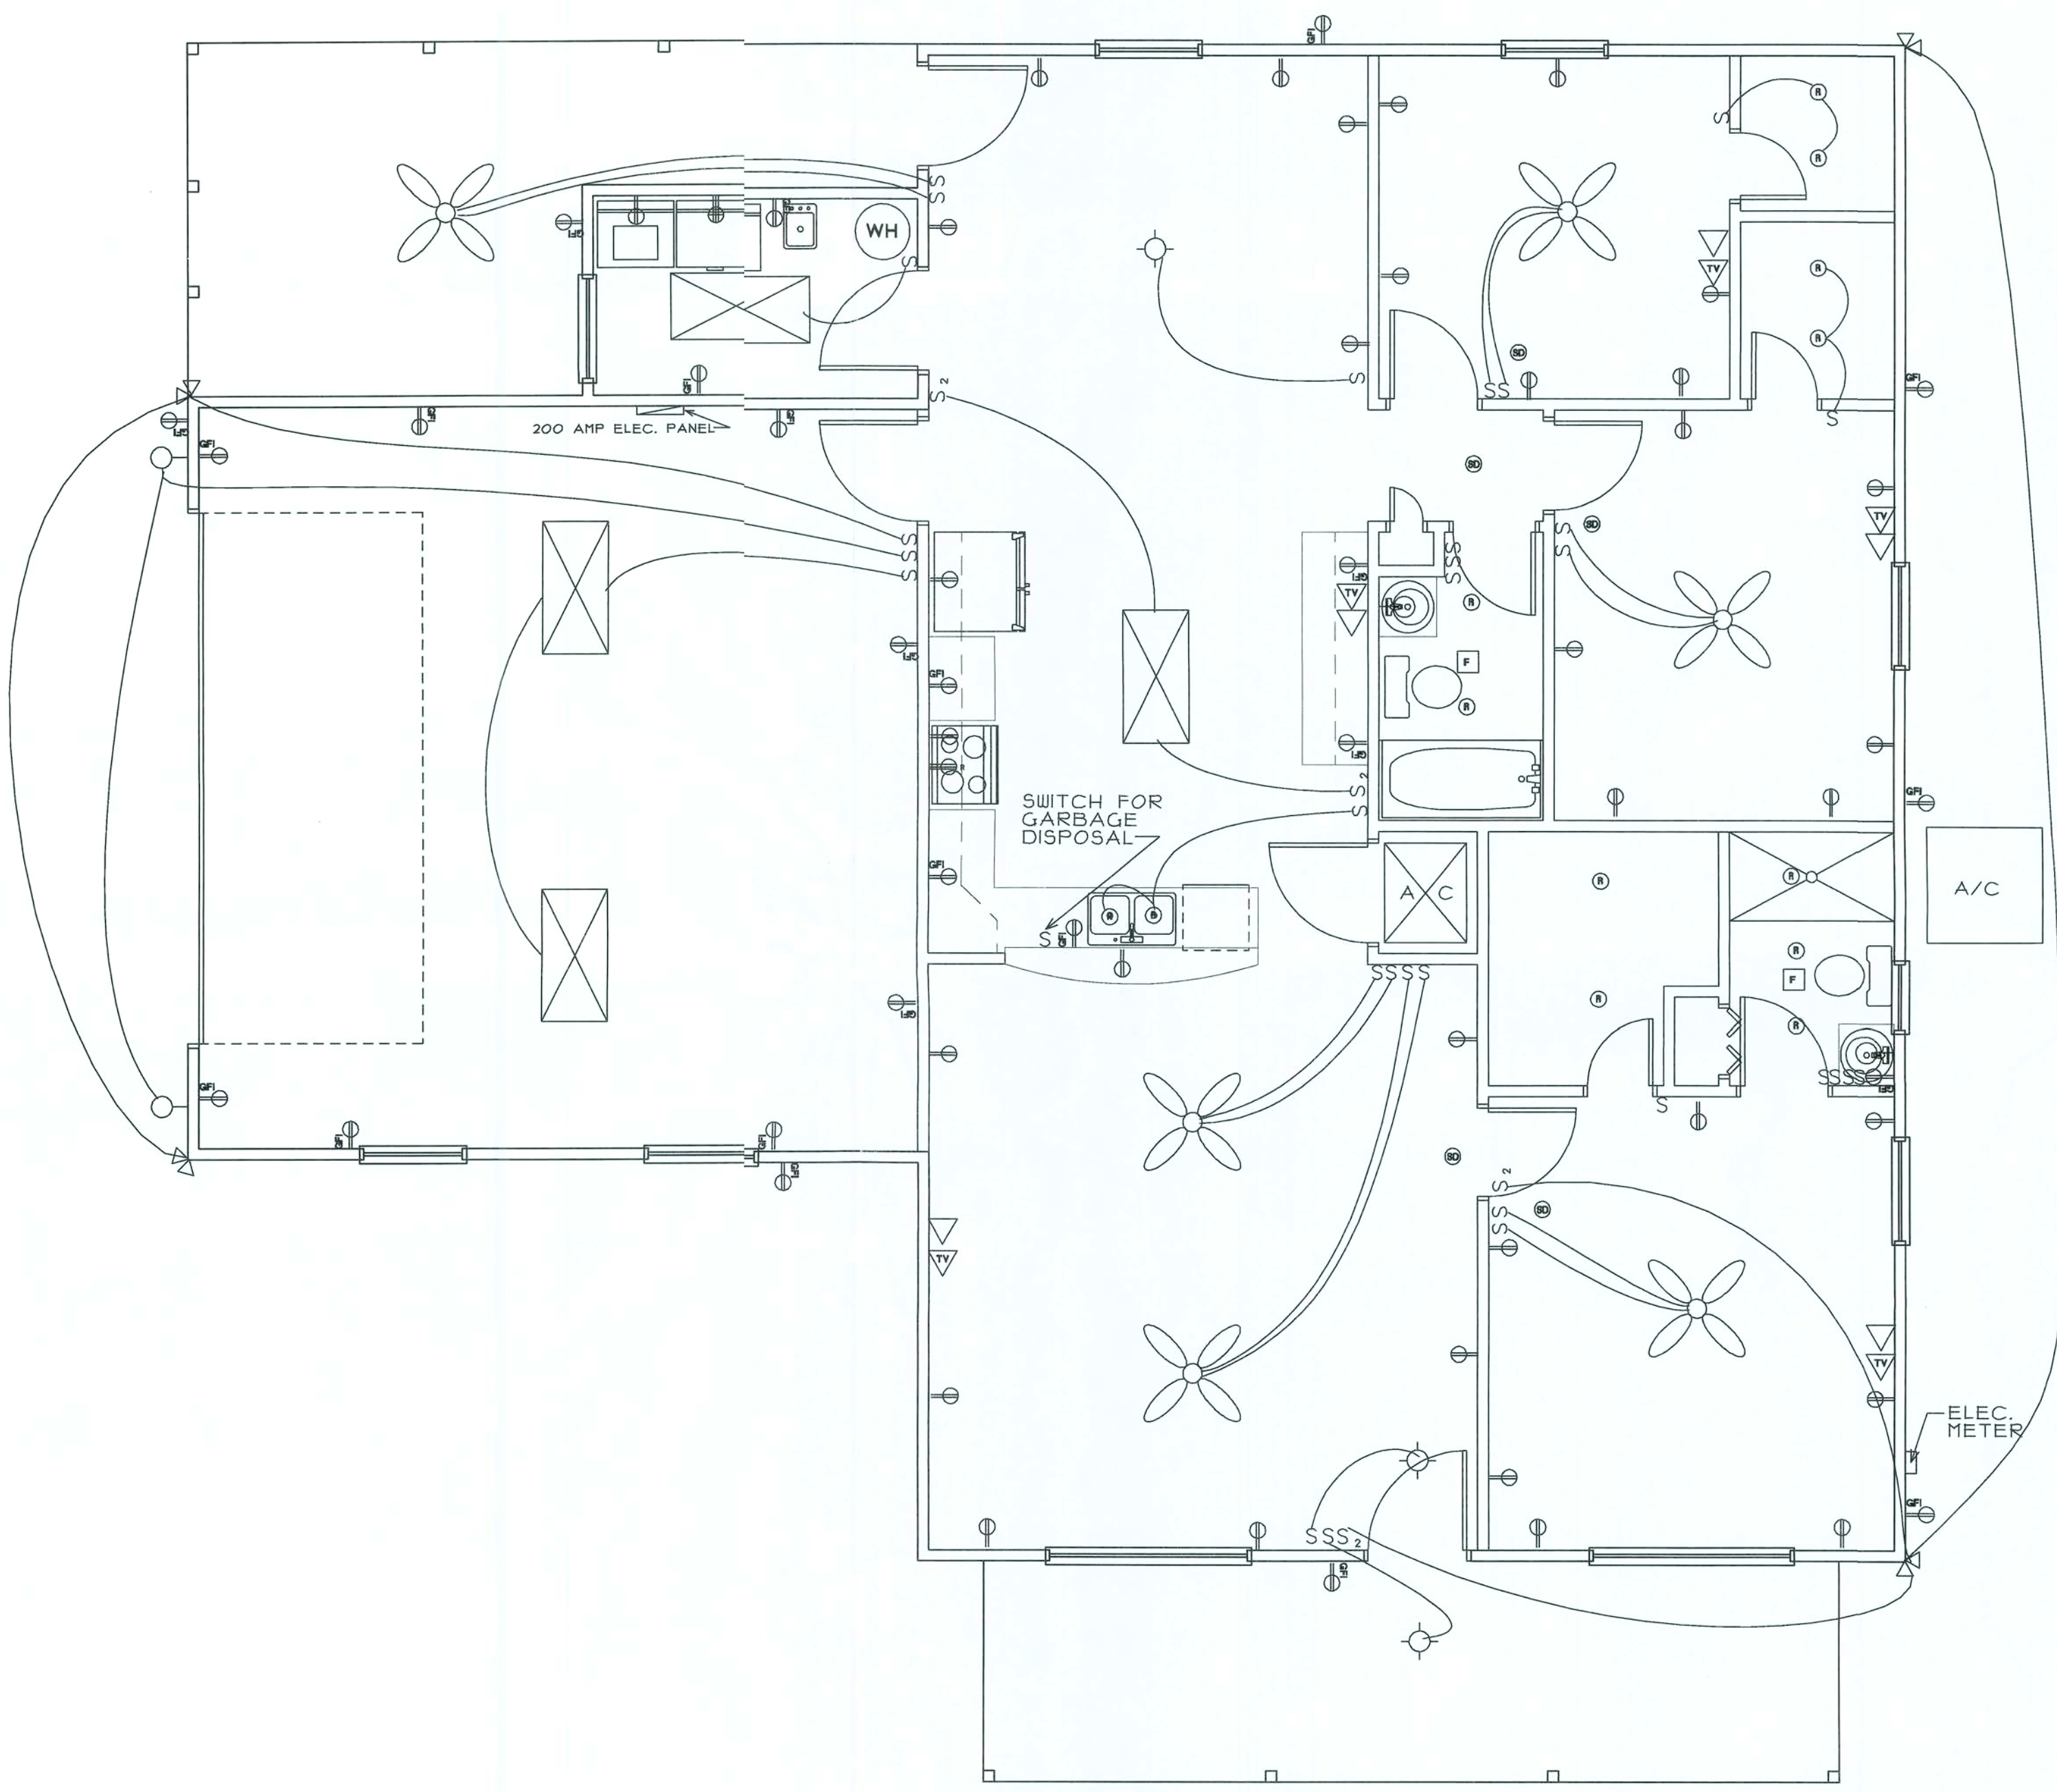

ELECTRICAL PLAN
 SCALE: 1/4" = 1'-0"

Overcurrent protection device shall be installed on the exterior of structures to serve as a disconnecting means. Conductors used from the exterior disconnecting means to a panel or sub panel shall have four-wire conductors, of which one conductor shall be used as an equipment ground.

ELECTRICAL PLAN	
SCALE: 1/4" = 1'-0"	REVISION
JOB #:	DATE
ST-1	

SANTA FE RIVER PLANTATIONS

LOT 45


G C Construction CG-C052925
 P.O. Box 5803 Phone 386-418-2114
 Gainesville, FL 32627 gclenmon@att.net
 Drawn by: Steve Ryall Architectural Drafting
 16794 NW 212th Terr
 Palm Springs, FL 33525
 352-871-8251

TRUSS NOTES:

1. ALL TRUSSES SHALL CARRY MANUFACTURERS STAMP.
2. ALL TRUSSES SHALL BE INSTALLED & BRACED TO MANUFACTURERS SPECIFICATIONS.
3. DESIGN DETAILS AND DRAWINGS FOR ALL TRUSSES SHALL BE ON-SITE FOR FRAMING INSPECTION.
4. TRUSSES SHALL NOT BE FIELD ALTERED WITHOUT PRIOR BUILDING DEPT. APPROVAL OF ENG. CALCULATIONS.
5. NON-BEARING WALLS SHOULD BE HELD DOWN FROM THE TRUSS BOTTOM CHORD W/SIMPSON STC TO INSURE THE TRUSS BOTTOM CHORD WILL NOT BEAR ON THE WALL.
6. ALL CONNECTIONS OF FALTERS, JACK OR HIP TRUSSES TO MAIN GIRDER TO BE PROVIDED BY TRUSS MANUFACTURER.
7. ALL ROOF FRAMING 24" O. C.
8. ALL ROOF PITCHES 4: 2, UNLESS OTHERWISE NOTED
9. ALL OVERHANGS 16".

ATTIC VENT NOTES:

- AREA/300
1. PROVIDE 1" MIN. AIR GAP AT EAVES WITH INSULATION BAFFLES TYP. AT ALL TRUSS BAYS.
 2. PROVIDE GABLE VENTS AT ALL GABLE ENDS.
 3. PROVIDE GALV. ROOF VENTS ON BACK SIDE OF ROOFLINE ABOVE CONDITIONED AREAS.
 4. 2278 SQ. /FT. OF ATTIC SPACE/300=7.59
 5. 7.59/.72=10.54
 6. USE 11 4' OFF-RIDGE VENTS.

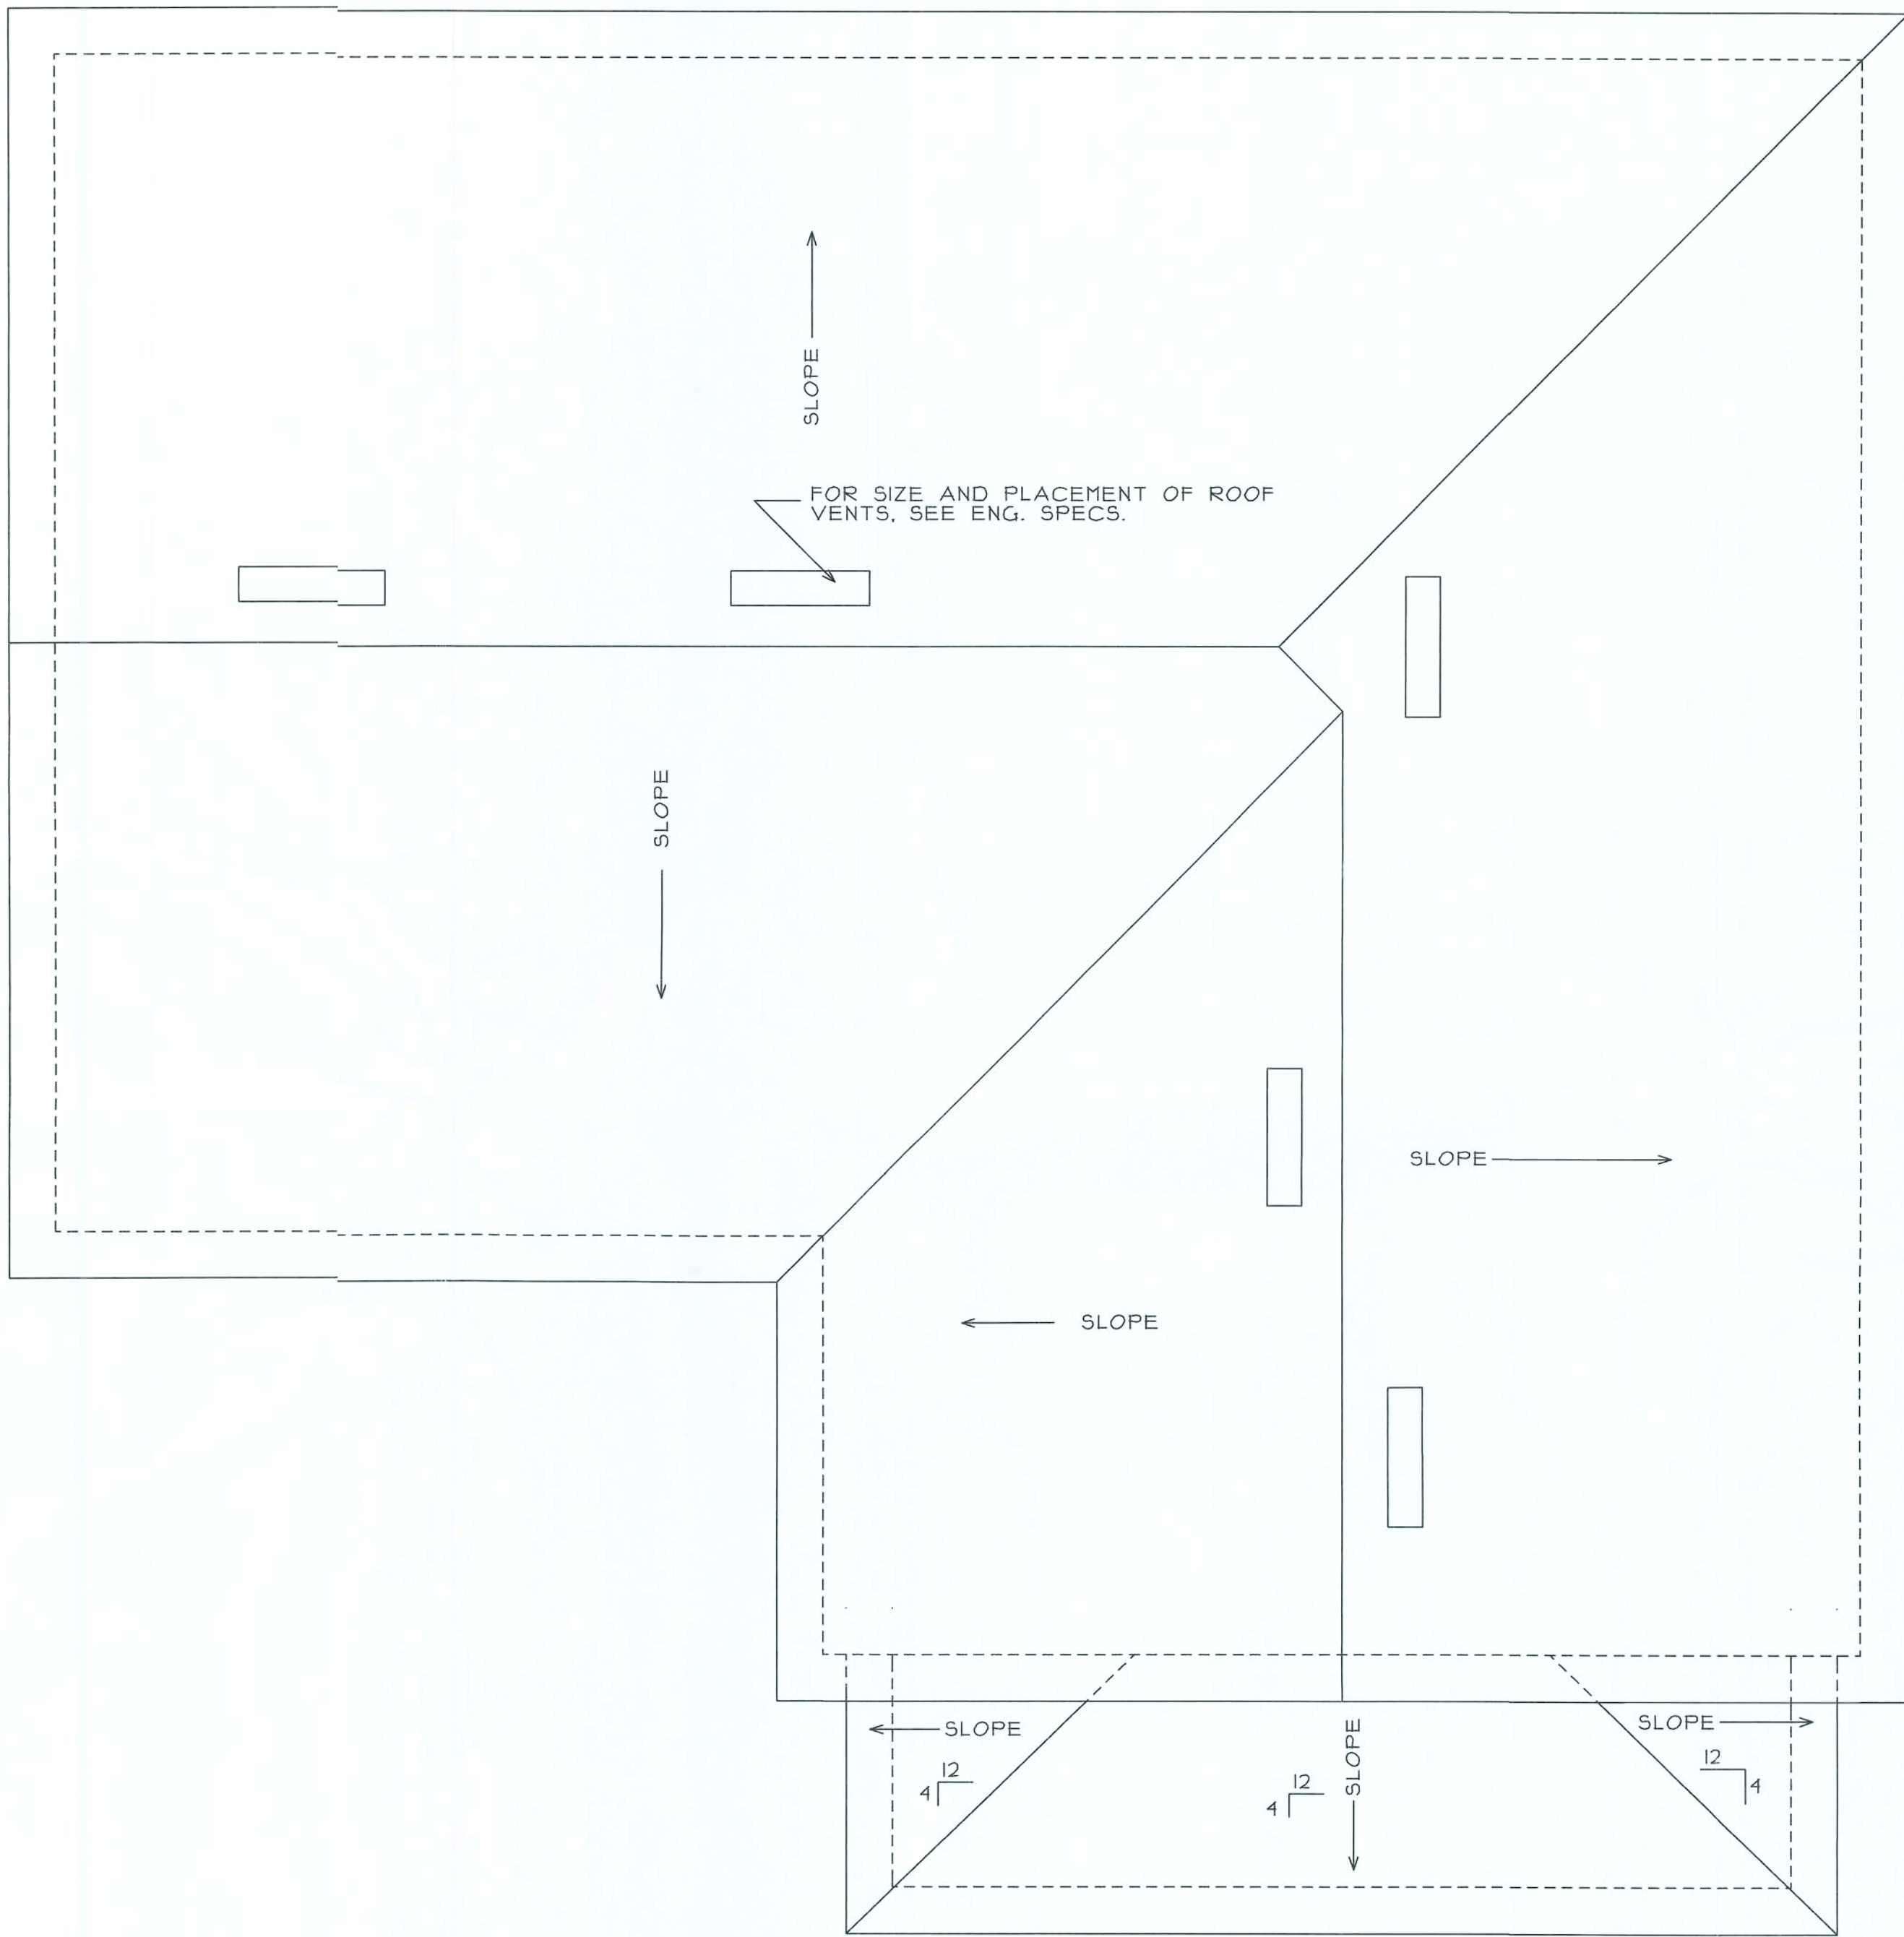

ROOF PLAN
SCALE: 1/4" = 1'-0"

ROOF PLAN

SCALE: 1/4" = 1'-0"

JOB #: SF-1

REVISION

DATE


SANTA FE RIVER PLANTATIONS

LOT 45


G C Construction CG-C052925
P.O. Box 5583 Gainesville, FL 32627
Phone 386-418-2114
gclemmon@alltel.net

Drawn by: Steve Ryall Architectural Drafting
11000 Highway 100, Suite 100
High Springs, Florida 32643
352-871-8251


Open: 2nd floor
 1st floor
 2nd floor
 3rd floor
 4th floor
 5th floor
 6th floor
 7th floor
 8th floor
 9th floor
 10th floor
 11th floor
 12th floor
 13th floor
 14th floor
 15th floor
 16th floor
 17th floor
 18th floor
 19th floor
 20th floor
 21st floor
 22nd floor
 23rd floor
 24th floor
 25th floor
 26th floor
 27th floor
 28th floor
 29th floor
 30th floor
 31st floor
 32nd floor
 33rd floor
 34th floor
 35th floor
 36th floor
 37th floor
 38th floor
 39th floor
 40th floor
 41st floor
 42nd floor
 43rd floor
 44th floor
 45th floor
 46th floor
 47th floor
 48th floor
 49th floor
 50th floor
 51st floor
 52nd floor
 53rd floor
 54th floor
 55th floor
 56th floor
 57th floor
 58th floor
 59th floor
 60th floor
 61st floor
 62nd floor
 63rd floor
 64th floor
 65th floor
 66th floor
 67th floor
 68th floor
 69th floor
 70th floor
 71st floor
 72nd floor
 73rd floor
 74th floor
 75th floor
 76th floor
 77th floor
 78th floor
 79th floor
 80th floor
 81st floor
 82nd floor
 83rd floor
 84th floor
 85th floor
 86th floor
 87th floor
 88th floor
 89th floor
 90th floor
 91st floor
 92nd floor
 93rd floor
 94th floor
 95th floor
 96th floor
 97th floor
 98th floor
 99th floor
 100th floor

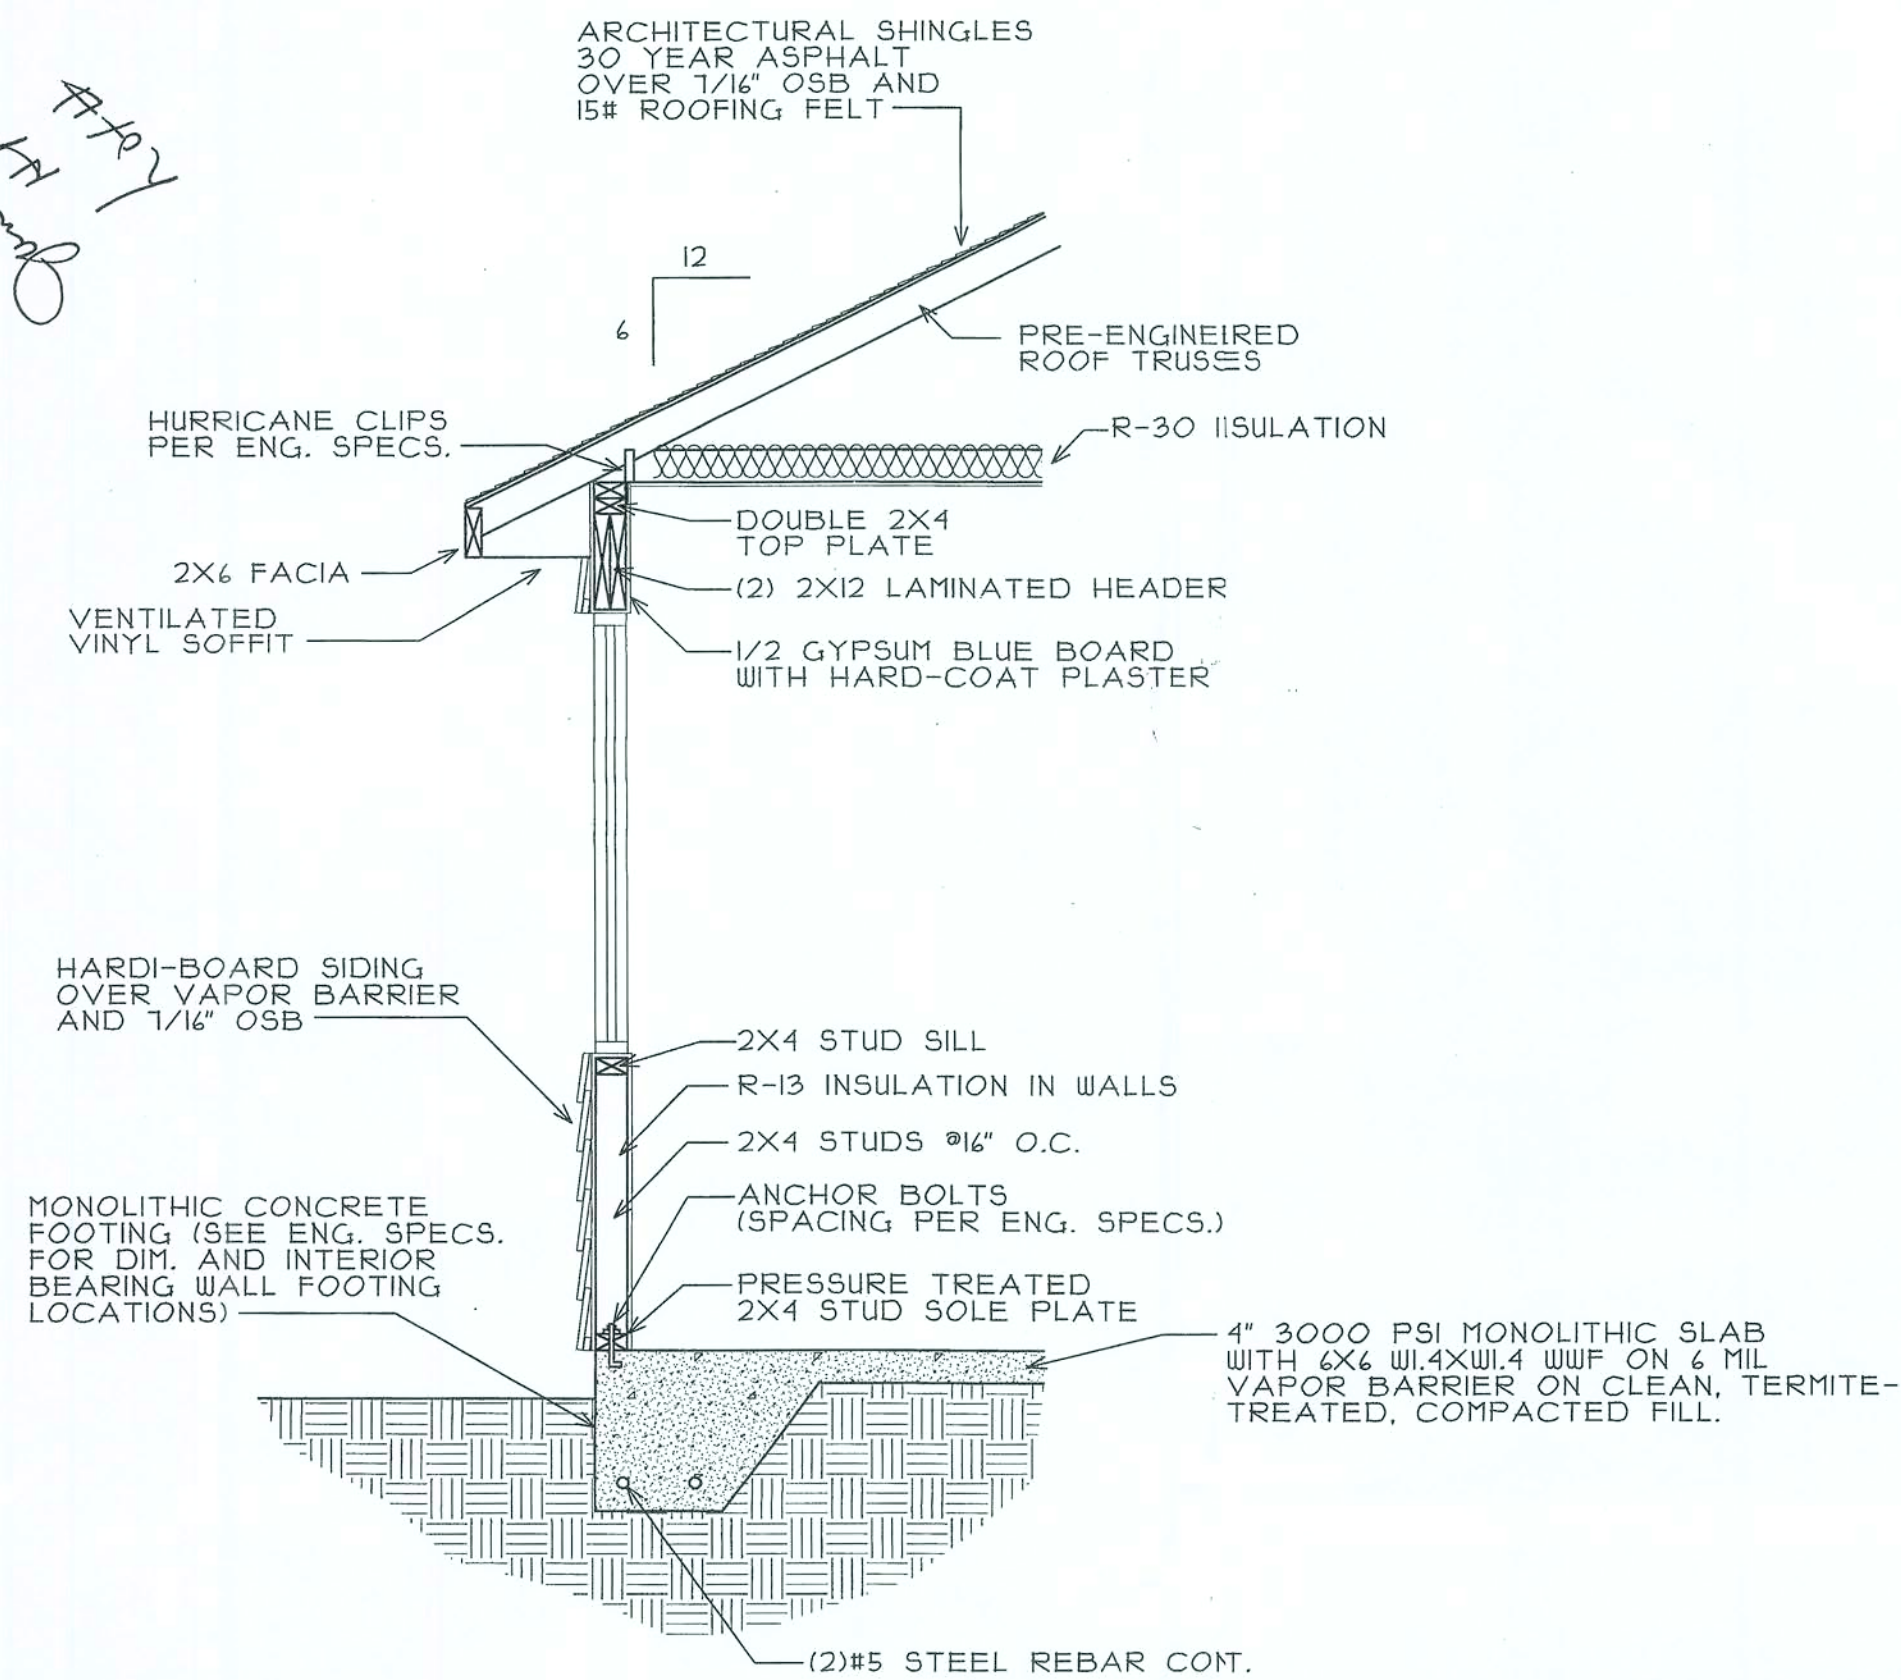

TYPICAL WALL/FOUNDATION SECTION
 SCALE: 1/2" = 1'-0"

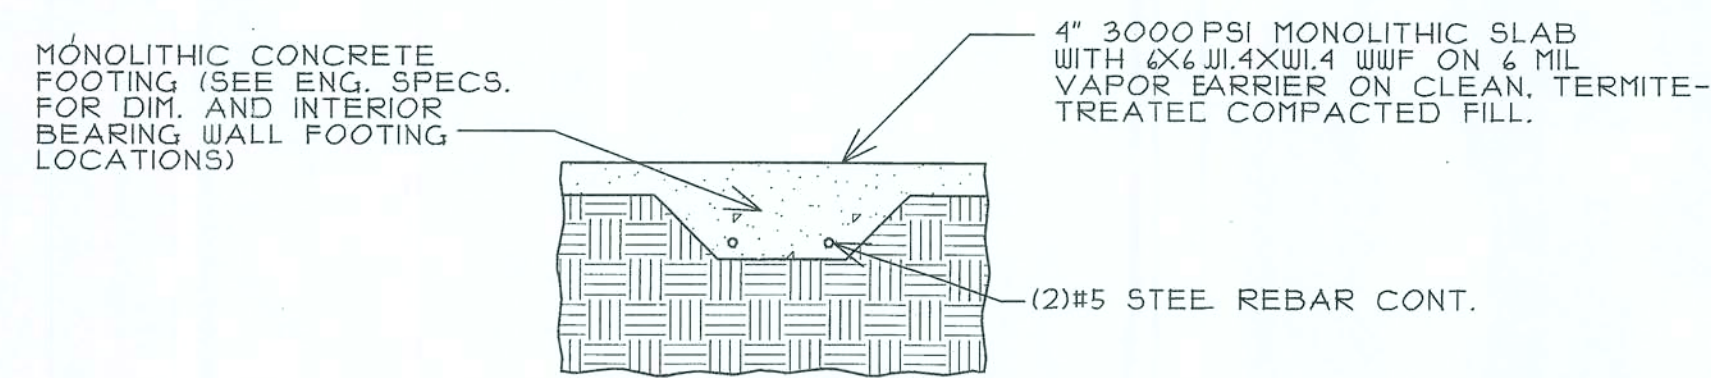

TYPICAL INTERIOR LOAD-BEARING FOOTING
 SCALE: 1/2" = 1'-0"

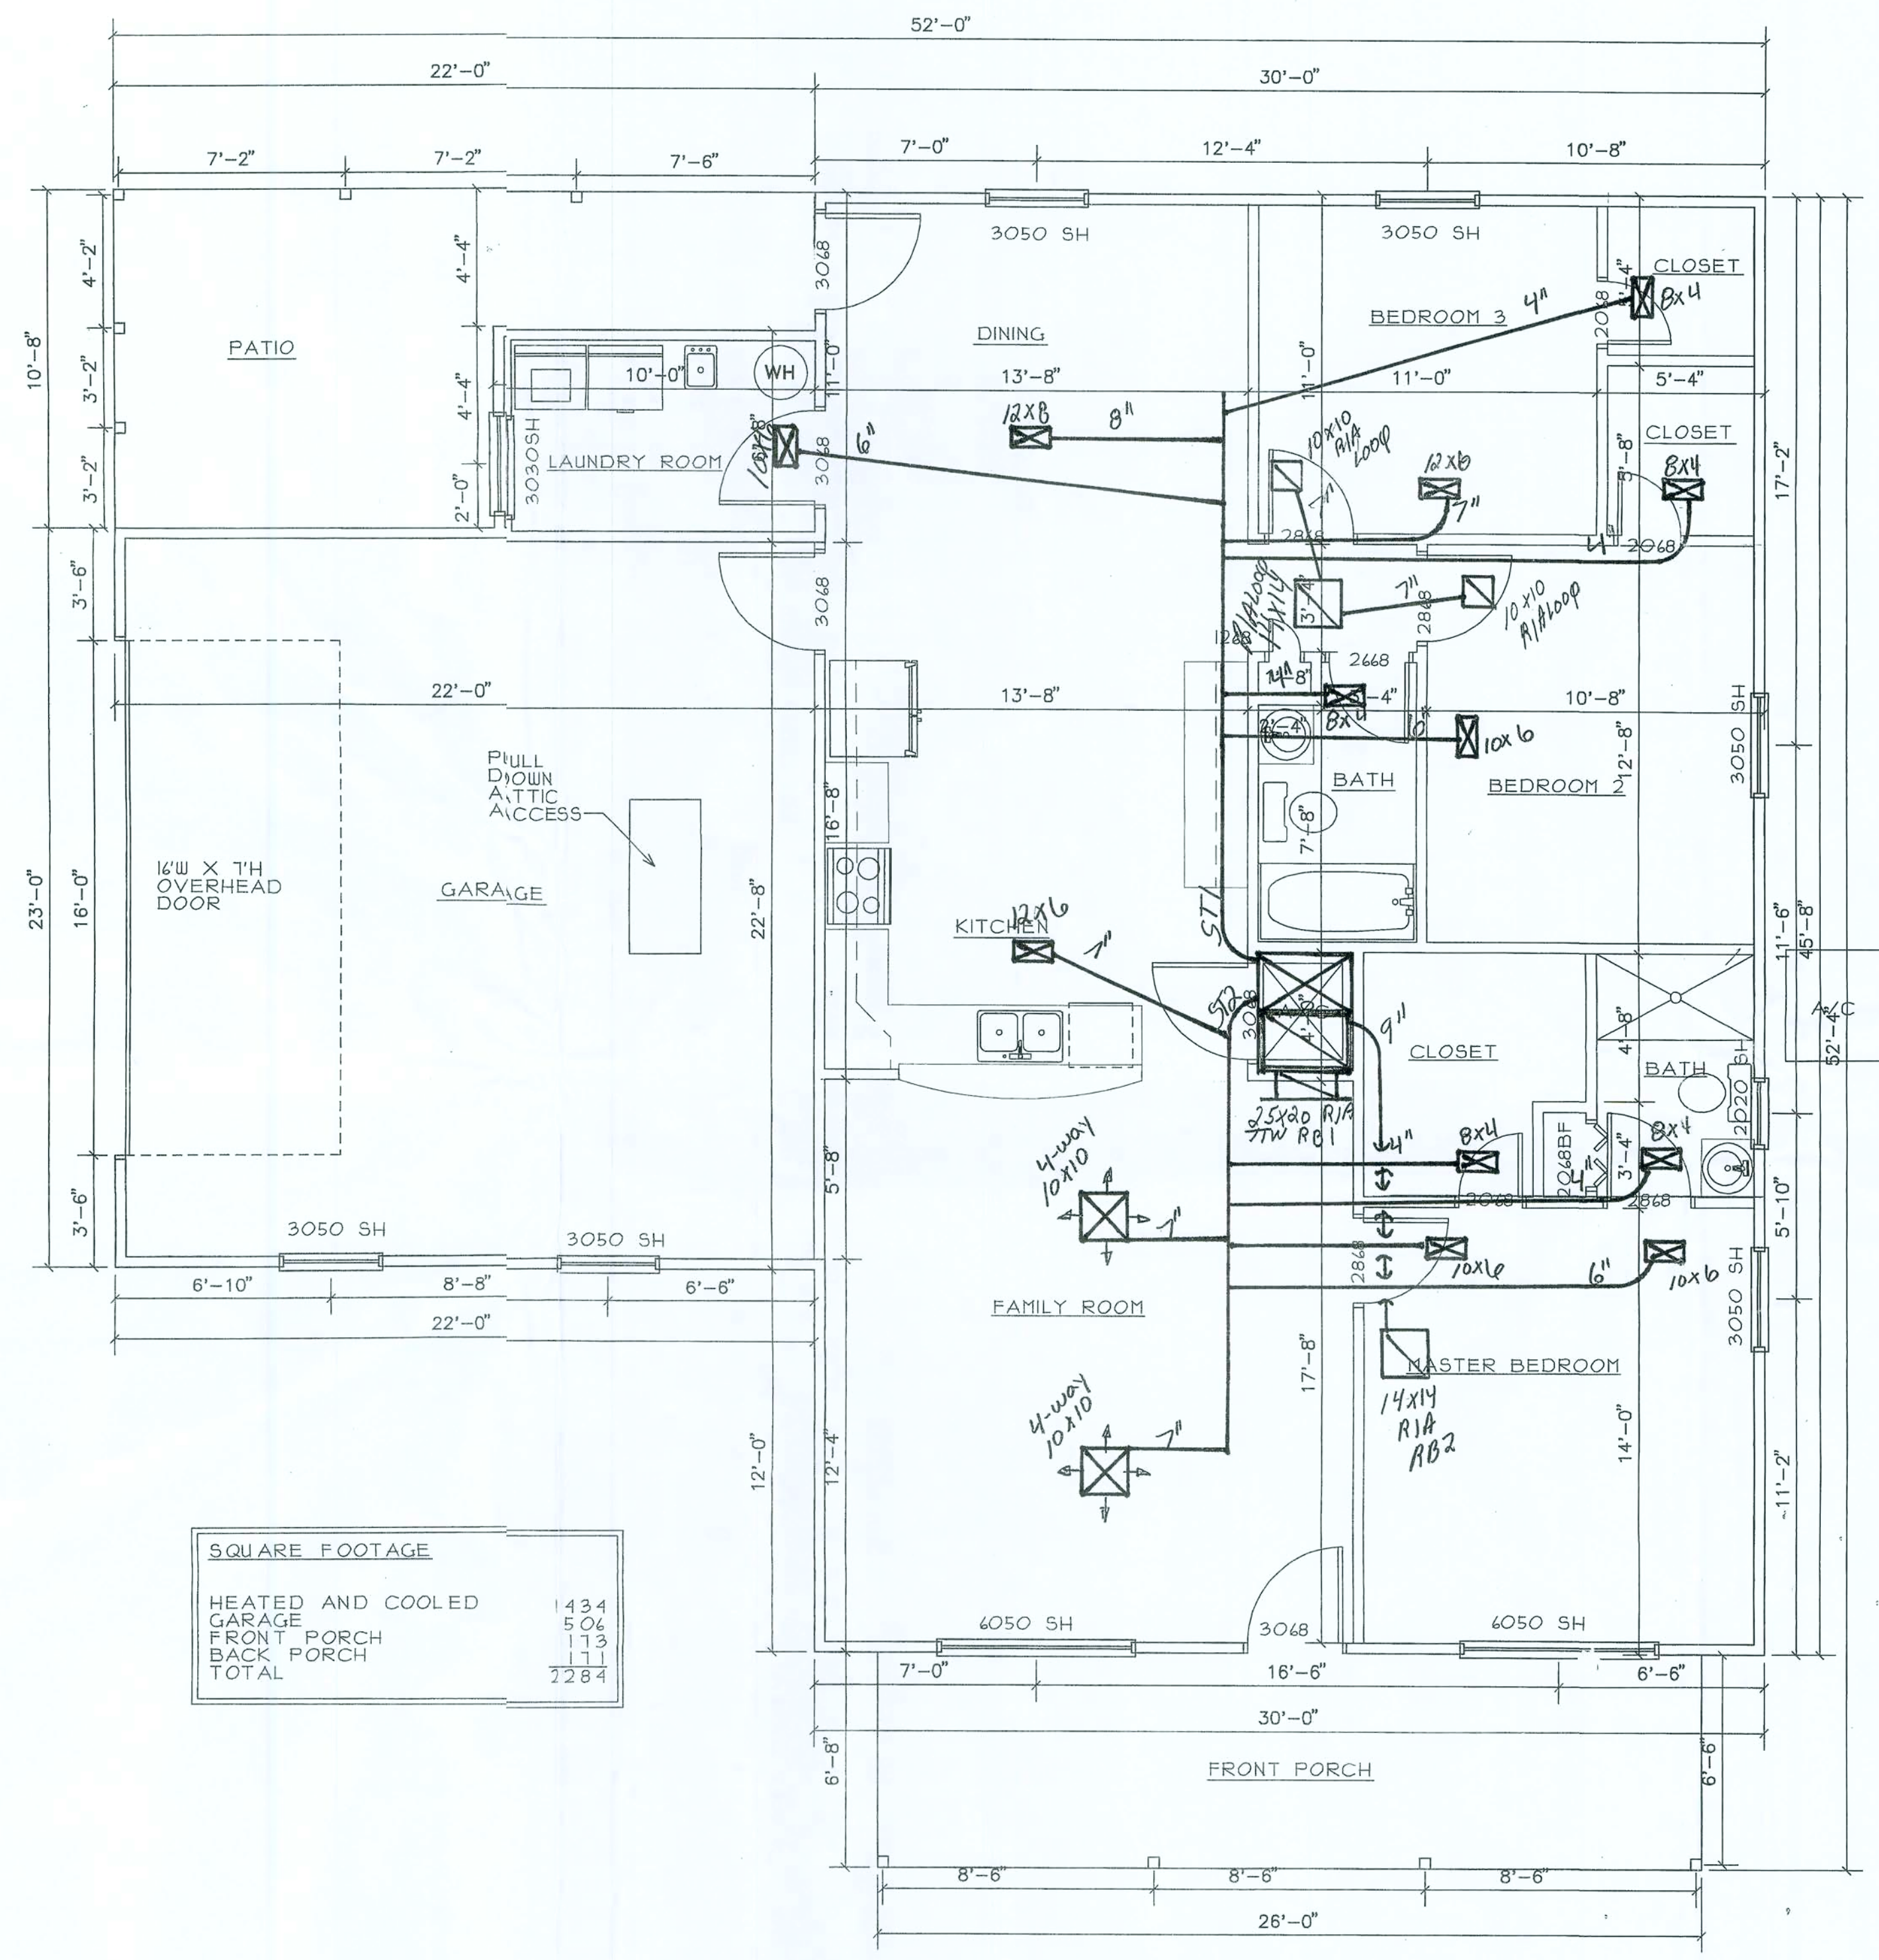

FLOOR PLAN
 SCALE: 1/4" = 1'-0"

G C Construction CG-C052925
 P.O. Box 5893 Phone 386-418-2114
 Gainesville, FL 32627 gclenmon@att.net
 Drawn by: Steve Ryall Architectural Drafting
 16794 NW 212th Terrace
 High Springs, Florida 32643
 352-871-6251

SANTA FE RIVER PLANTATIONS

LOT 45

FLOOR PLAN

SCALE: 1/4" = 1'-0"
 JOB #: SF-1
 DATE: _____
 REVISION: _____

2