

NOTE:
REFER TO SHEET F&Z FOR EXACT KITCHEN EQUIPMENT
ROUGH-IN DIMENSIONS, SIZES AND PLACEMENT. COORDINATE
WITH THE EQUIPMENT SUPPLIER ON ANY AVAILABLE UPDATES
PRIOR TO COMMENCEMENT OF WORK.

PLUMBING LEGEND

SANITARY	_____
GREASE WASTE	_____
WASTE OIL	_____
SODA SLEEVE	_____


GREASE INTERCEPTOR SIZING

(6) x (64) x (48) 1/2" x (15) = CAPACITY
100 x 10" x 10" x 15" = 600 GALLON
PROVIDED, ONE 1000 GALLON
GREASE TRAP - IN COMPLIANCE
WITH THE 2020 FPC -
LUMS STANDARDS AND ORDINANCES.


GREASE INTERCEPTORS
GREASE RETENTION
CAPACITY WITH FPC-
PLUMBING SECTION
1003351 AND TABLE
1003351.

PLUMBING GENERAL NOTES:


1. THE PLUMBING CONTRACTOR SHALL VERIFY SITE PRIOR TO BID SUBMISSION TO VERIFY ALL EXISTING LOCATIONS, SLOPES AND INVERTS OF SANITARY PIPING INCLUDING CONNECTION POINTS. ALSO VERIFY LOCATIONS AND CONNECTION POINT TO THE EXISTING SEWER MAIN.
2. WASTE AND VENT PIPING SHALL BE SCHEDULE 40 PVC WITH DRAINAGE PATTERN FITTINGS.
3. DOMESTIC WATER PIPING SHALL BE CPVC WITH SOLVENT JOINED FITTINGS. PROVIDE WATER HAMMER ARRESTORS EQUAL TO 1/4" R 90° AT EACH FIXTURE GROUP. IN ACCORDANCE WITH THE FPC, 4. SLOPE WASTE LINES 3" AND LARGER AT 1/4" PER FOOT. LINES SMALLER THAN 3" SHALL BE SLOPED AT 1/4" PER FOOT.
5. INSULATE ALL DOMESTIC HOT WATER PIPING WITH 1" WALL POLYISOCYANURATE INSULATION.
6. PROVIDE 1" POLYISOCYANURATE INSULATION NEW INSTALLATION VENTS SHALL BE CROWNED FINISH EQUAL TO BRASS/BRASS.
7. PROVIDE WALL CARRIERS AT ALL WALL-HUNG FIXTURES.
8. INSTALLATION OF ALL PLUMBING FIXTURES, PIPING COMPONENTS AND PERIPHERALS SHALL COMPLY WITH THE 2020 FPC - PLUMBING 1st EDITION AND ALL OTHER APPLICABLE CODES, LUMS STANDARDS AND ORDINANCES.
9. PLUMBING CONTRACTOR SHALL COORDINATE ALL ROUTING AND PIPING CONNECTIONS PRIOR TO COMMENCEMENT OF WORK.
10. ALTERNATE FIXTURE MANUFACTURERS ARE ACCEPTABLE PROVIDED THEY ARE EQUIVALENT AND MEET THE KIND AND QUALITY OF THE MANUFACTURER'S SPECIFICATIONS.
11. PIPE HANGERS SHALL BE SPACED 7' PER GALVANIZED WITH THREADED ROD SUPPORT FROM STRUCTURE ABOVE EQUAL TO GRINNELL. DISTANCE BETWEEN SUPPORTS SHALL BE PER FPC.
12. TESTING OF THE PLUMBING SYSTEMS SHALL BE PERFORMED BY THE PLUMBING SUBCONTRACTOR AND WITNESSED BY THE BUILDING DEPARTMENT INSPECTOR FOR POTABLE HOT AND COLD WATER SYSTEMS. TESTING SHALL BE IN ACCORDANCE WITH THE 2020 FPC-PLUMBING 1st EDITION.
13. CLEANOUTS SHALL BE PROVIDED PER PLAN AND/OR AS REQUIRED TO PROVIDE A COMPLETE SERVICEABLE SYSTEM. CLEANOUTS SHALL BE SAME SIZE AS PIPE FLOOR CLEANOUTS. SHALL BE EQUAL TO 2" MIN 2" 1/4" 1/2" 3/4" 1" 1 1/4" 1 1/2" 2" 2 1/4" 3" 3 1/4" 4" 4 1/4" 5" 5 1/4" 6" 6 1/4" 8" 8 1/4" 10" 10 1/4" 12" 12 1/4" 14" 14 1/4" 16" 16 1/4" 18" 18 1/4" 20" 20 1/4" 24" 24 1/4" 30" 30 1/4" 36" 36 1/4" 42" 42 1/4" 48" 48 1/4" 60" 60 1/4" 72" 72 1/4" 84" 84 1/4" 96" 96 1/4" 108" 108 1/4" 120" 120 1/4" 144" 144 1/4" 168" 168 1/4" 9984" 9984 1/4" 10000" 10000 1/4" 10024" 10024 1/4" 10048" 10048 1/4" 10072" 10072 1/4" 10096" 10096 1/4" 10120" 10120 1/4" 10144" 10144 1/4" 10168" 10168 1/4" 10192" 10192 1/4" 10216" 10216 1/4" 10240" 10240 1/4" 10264" 10264 1/4" 10288" 10288 1/4" 10312" 10312 1/4" 10336" 10336 1/4" 10360" 10360 1/4" 10384" 10384 1/4" 10408" 10408 1/4" 10432" 10432 1/4" 10456" 10456 1/4" 10480" 10480 1/4" 10504" 10504 1/4" 10528" 10528 1/4" 10552" 10552 1/4" 10576" 10576 1/4" 10600" 10600 1/4" 10624" 10624 1/4" 10648" 10648 1/4" 10672" 10672 1/4" 10696" 10696 1/4" 10720" 10720 1/4" 10744" 10744 1/4" 10768" 10768 1/4" 10792" 10792 1/4" 10816" 10816 1/4" 10840" 10840 1/4" 10864" 10864 1/4" 10888" 10888 1/4" 10912" 10912 1/4" 10936" 10936 1/4" 10960" 10960 1/4" 10984" 10984 1/4" 11000" 11000 1/4" 11024" 11024 1/4" 11048" 11048 1/4" 11072" 11072 1/4" 11096" 11096 1/4" 11120" 11120 1/4" 11144" 11144 1/4" 11168" 11168 1/4" 11192" 11192 1/4" 11216" 11216 1/4" 11240" 11240 1/4" 11264" 11264 1/4" 11288" 11288 1/4" 11312" 11312 1/4" 11336" 11336 1/4" 11360" 11360 1/4" 11384" 11384 1/4" 11408" 11408 1/4" 11432" 11432 1/4" 11456" 11456 1/4" 11480" 11480 1/4" 11504" 11504 1/4" 11528" 11528 1/4" 11552" 11552 1/4" 11576" 11576 1/4" 11600" 11600 1/4" 11624" 11624 1/4" 11648" 11648 1/4" 11672" 11672 1/4" 11696" 11696 1/4" 11720" 11720 1/4" 11744" 11744 1/4" 11768" 11768 1/4" 11792" 11792 1/4" 11816" 11816 1/4" 11840" 11840 1/4" 11864" 11864 1/4" 11888" 11888 1/4" 11912" 11912 1/4" 11936" 11936 1/4" 11960" 11960 1/4" 11984" 11984 1/4" 12000" 12000 1/4" 12024" 12024 1/4" 12048" 12048 1/4" 12072" 12072 1/4" 12096" 12096 1/4" 12120" 12120 1/4" 12144" 12144 1/4" 12168" 12168 1/4" 12192" 12192 1/4" 12216" 12216 1/4" 12240" 12240 1/4" 12264" 12264 1/4" 12288" 12288 1/4" 12312" 12312 1/4" 12336" 12336 1/4" 12360" 12360 1/4" 12384" 12384 1/4" 12408" 12408 1/4" 12432" 12432 1/4" 12456" 12456 1/4" 12480" 12480 1/4" 12504" 12504 1/4" 12528" 12528 1/4" 12552" 12552 1/4" 12576" 12576 1/4" 12600" 12600 1/4" 12624" 12624 1/4" 12648" 12648 1/4" 12672" 12672 1/4" 12696" 12696 1/4" 12720" 12720 1/4" 12744" 12744 1/4" 12768" 12768 1/4" 12792" 12792 1/4" 12816" 12816 1/4" 12840" 12840 1/4" 12864" 12864 1/4" 12888" 12888 1/4" 12912" 12912 1/4" 12936" 12936 1/4" 12960" 12960 1/4" 12984" 12984 1/4" 13000" 13000 1/4" 13024" 13024 1/4" 13048" 13048 1/4" 13072" 13072 1/4" 13096" 13096 1/4" 13120" 13120 1/4" 13144" 13144 1/4" 13168" 13168 1/4" 13192" 13192 1/4" 13216" 13216 1/4" 13240" 13240 1/4" 13264" 13264 1/4" 13288" 13288 1/4" 13312" 13312 1/4" 13336" 13336 1/4" 13360" 13360 1/4" 13384" 13384 1/4" 13408" 13408 1/4" 13432" 13432 1/4" 13456" 13456 1/4" 13480" 13480 1/4" 13504" 13504 1/4" 13528" 13528 1/4" 13552" 13552 1/4" 13576" 13576 1/4" 13600" 13600 1/4" 13624" 13624 1/4" 13648" 13648 1/4" 13672" 13672 1/4" 13696" 13696 1/4" 13720" 13720 1/4" 13744" 13744 1/4" 13768" 13768 1/4" 13792" 13792 1/4" 13816" 13816 1/4" 13840" 13840 1/4" 13864" 13864 1/4" 13888" 13888 1/4" 13912" 13912 1/4" 13936" 13936 1/4" 13960" 13960 1/4" 13984" 13984 1/4" 14000" 14000 1/4" 14024" 14024 1/4" 14048" 14048 1/4" 14072" 14072 1/4" 14096" 14096 1/4" 14120" 14120 1/4" 14144" 14144 1/4" 14168" 14168 1/4" 14192" 14192 1/4" 14216" 14216 1/4" 14240" 14240 1/4" 14264" 14264 1/4" 14288" 14288 1/4" 14312" 14312 1/4" 14336" 14336 1/4" 14360" 14360 1/4" 14384" 14384 1/4" 14408" 14408 1/4" 14432" 14432 1/4" 14456" 14456 1/4" 14480" 14480 1/4" 14504" 14504 1/4" 14528" 14528 1/4" 14552" 14552 1/4" 14576" 14576 1/4" 14600" 14600 1/4" 14624" 14624 1/4" 14648" 14648 1/4" 14672" 14672 1/4" 14696" 14696 1/4" 14720" 14720 1/4" 14744" 14744 1/4" 14768" 14768 1/4" 14792" 14792 1/4" 14816" 14816 1/4" 14840" 14840 1/4" 14864" 14864 1/4" 14888" 14888 1/4" 14912" 14912 1/4" 14936" 14936 1/4" 14960" 14960 1/4" 14984" 14984 1/4" 15000" 15000 1/4" 15024" 15024 1/4" 15048" 15048 1/4" 15072" 15072 1/4" 15096" 15096 1/4" 15120" 15120 1/4" 15144" 15144 1/4" 15168" 15168 1/4" 15192" 15192 1/4" 15216" 15216 1/4" 15240" 15240 1/4" 15264" 15264 1/4" 15288" 15288 1/4" 15312" 15312 1/4" 15336" 15336 1/4" 15360" 15360 1/4" 15384" 15384 1/4" 15408" 15408 1/4" 15432" 15432 1/4" 15456" 15456 1/4" 15480" 15480 1/4" 15504" 15504 1/4" 15528" 15528 1/4" 15552" 15552 1/4" 15576" 15576 1/4" 15600" 15600 1/4" 15624" 15624 1/4" 15648" 15648 1/4" 15672" 15672 1/4" 15696" 15696 1/4" 15720" 15720 1/4" 15744" 15744 1/4" 15768" 15768 1/4" 15792" 1579

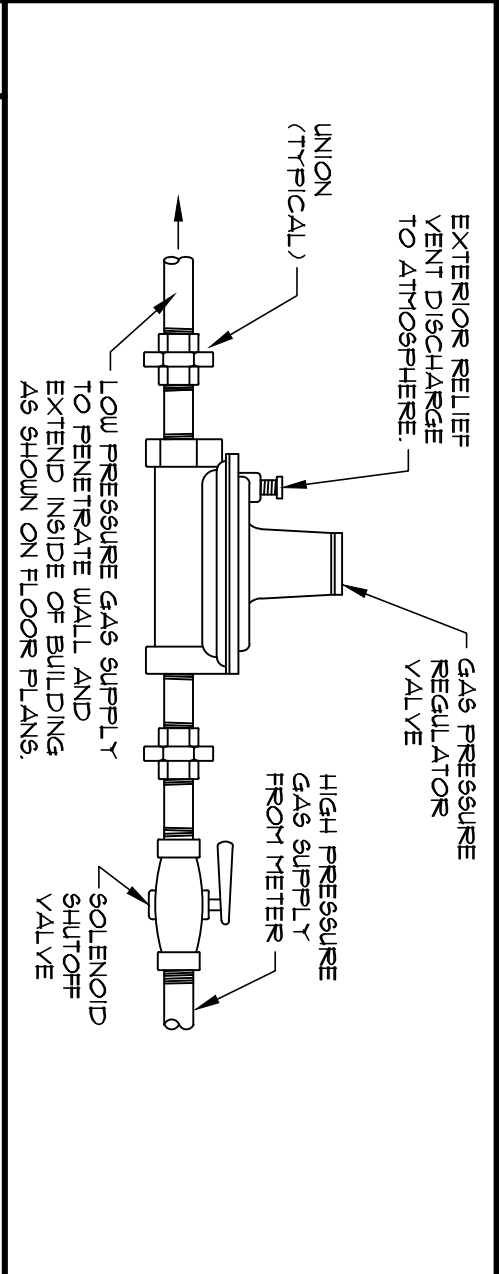


2 GAS PRESSURE REGULATOR DETAIL
SCALE: NONE

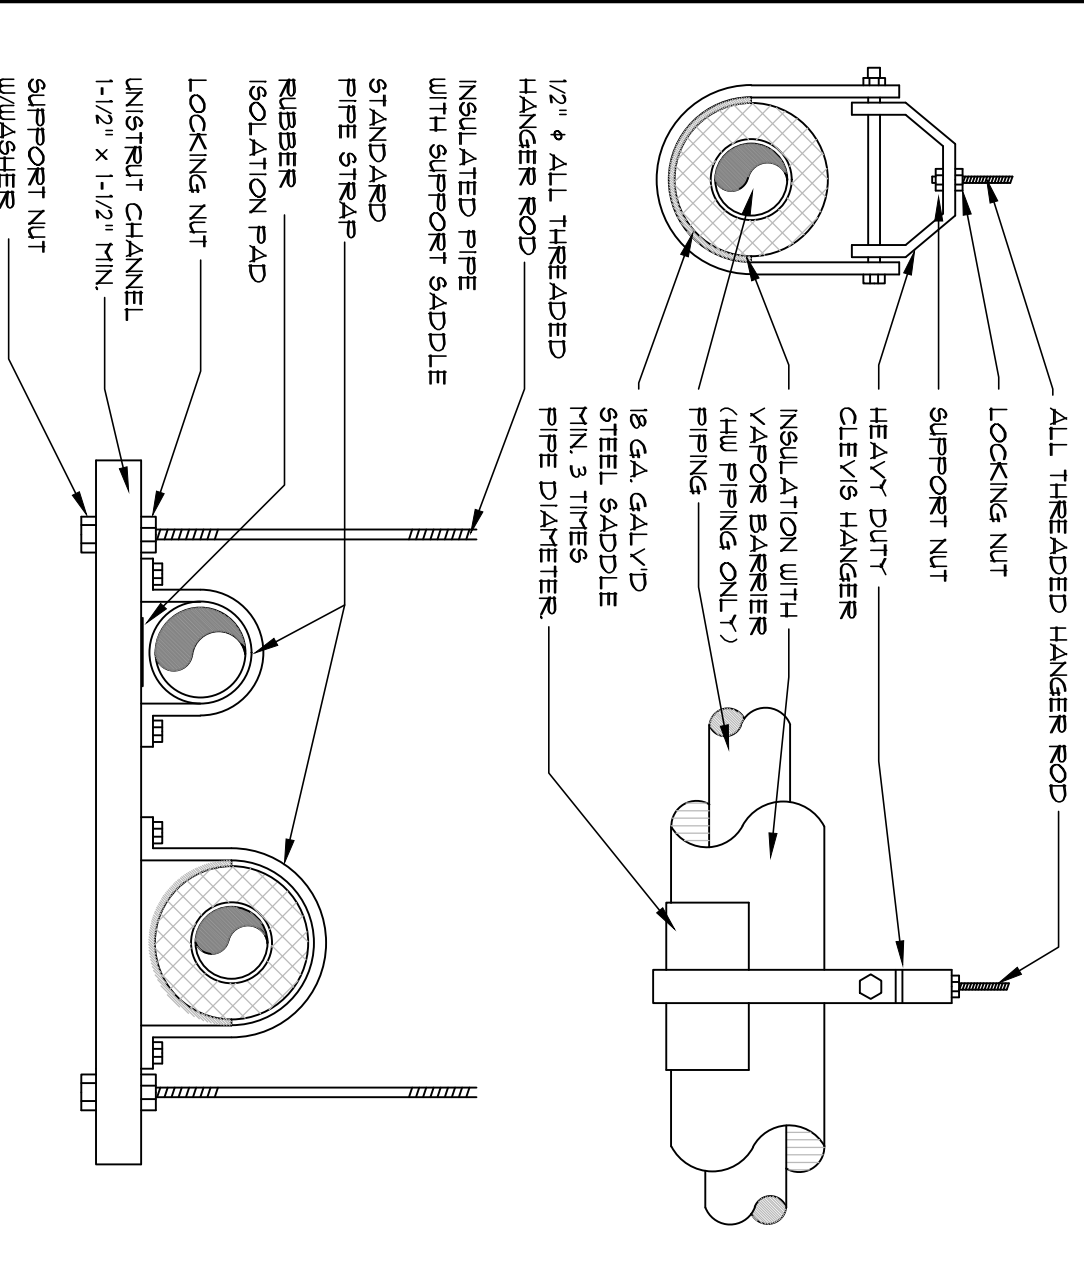


1 PIPE HANGER DETAIL
SCALE: NONE

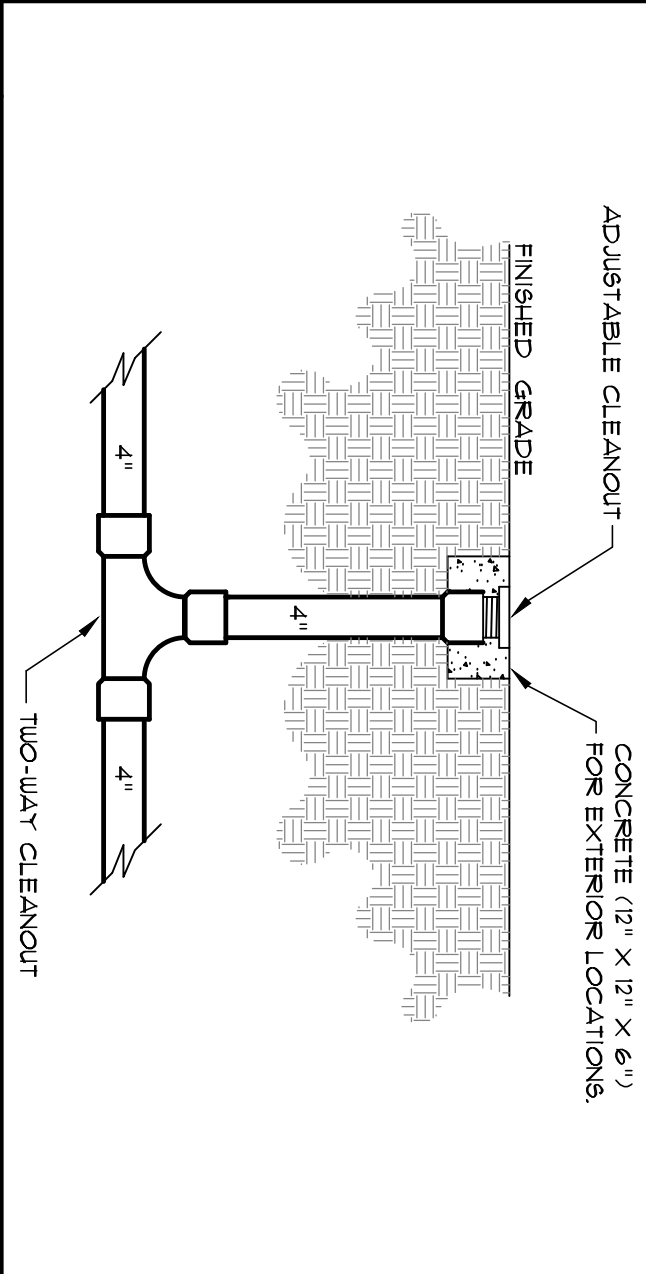


11 TWO-WAY GRADE CLEANOUT DETAIL
SCALE: NONE

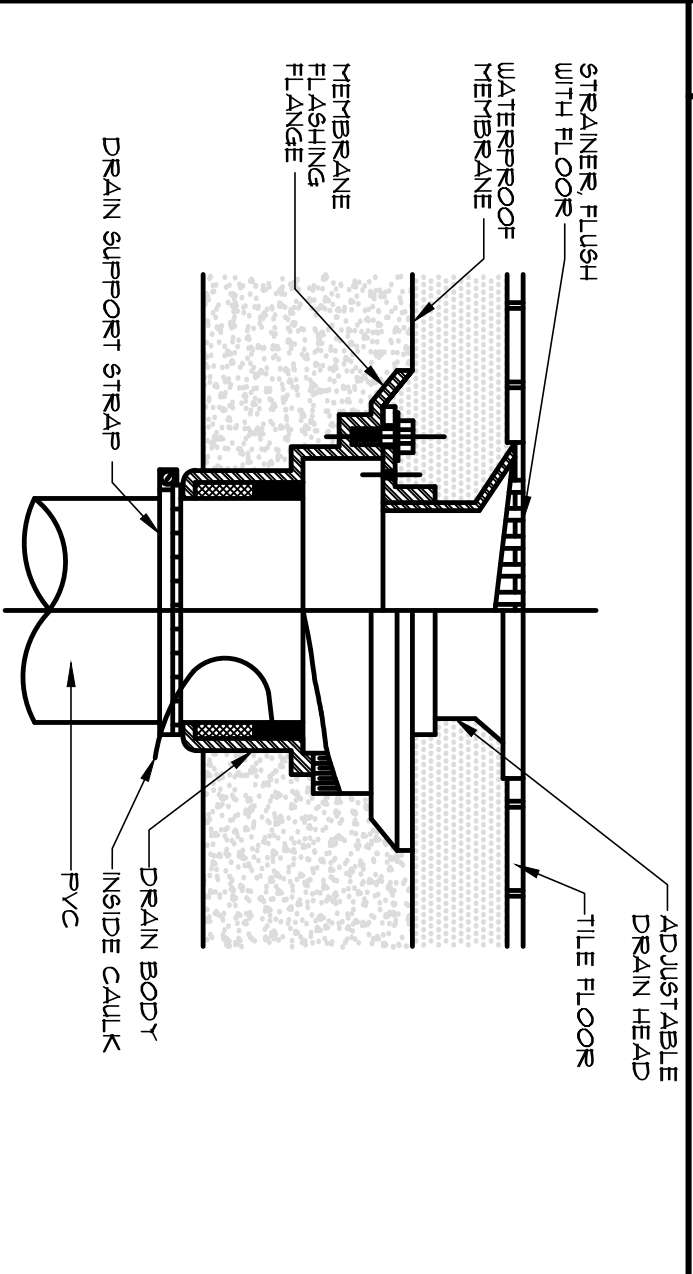


12 FLOOR DRAIN
SCALE: NONE

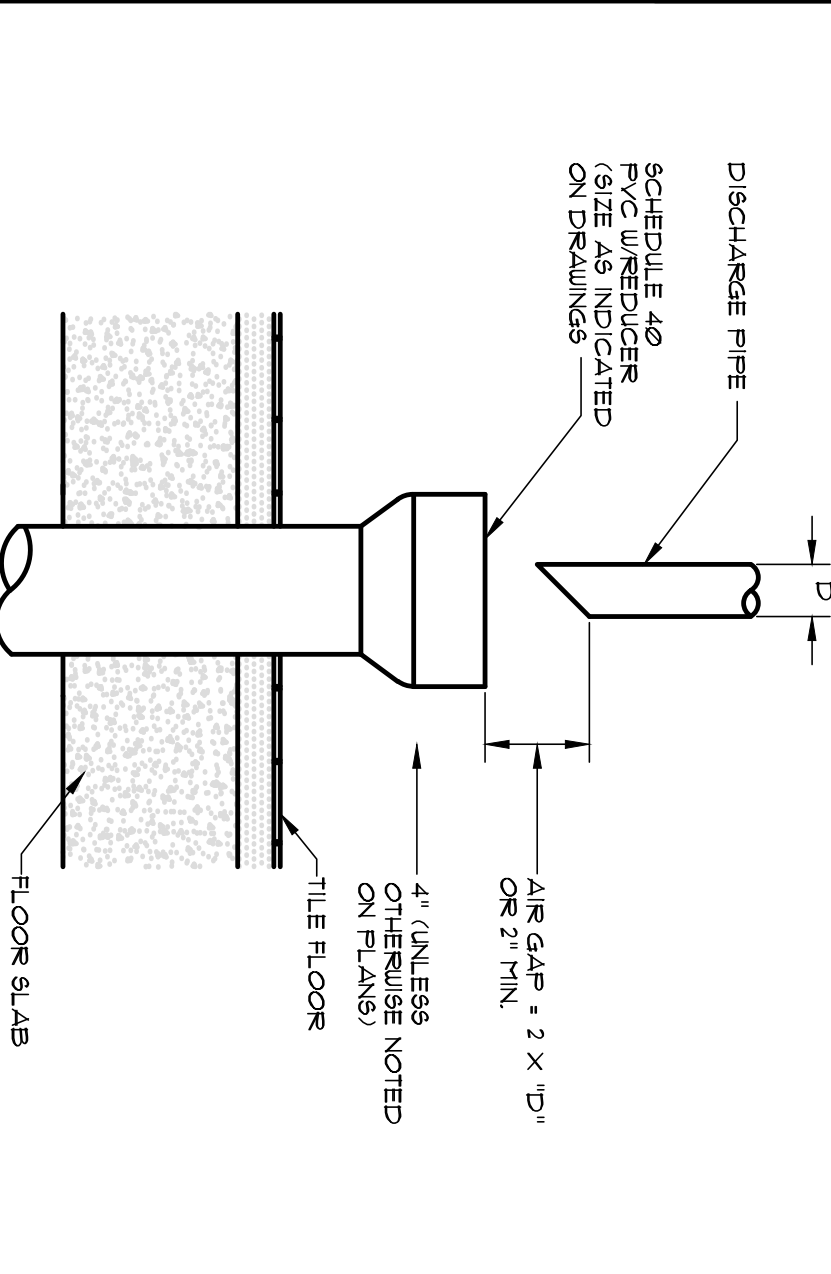


13 HUB DRAIN
SCALE: NONE

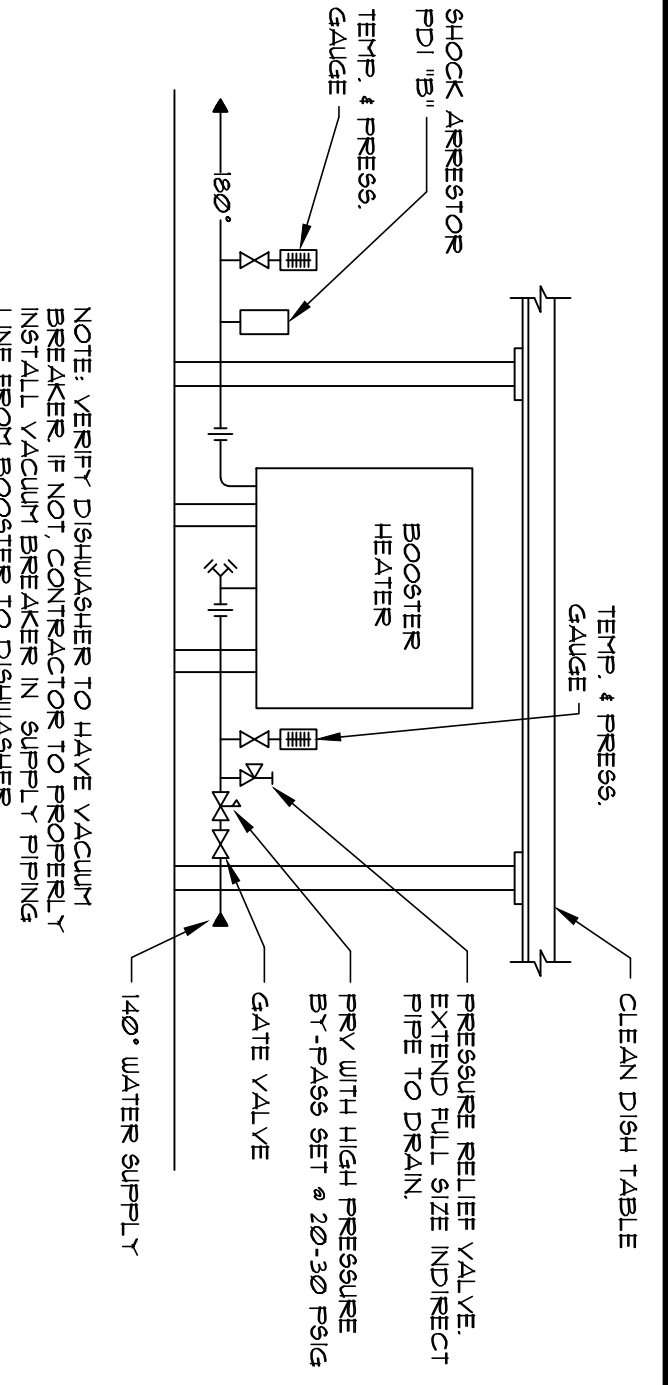


3 BOOSTER HEATER DETAIL
SCALE: NONE

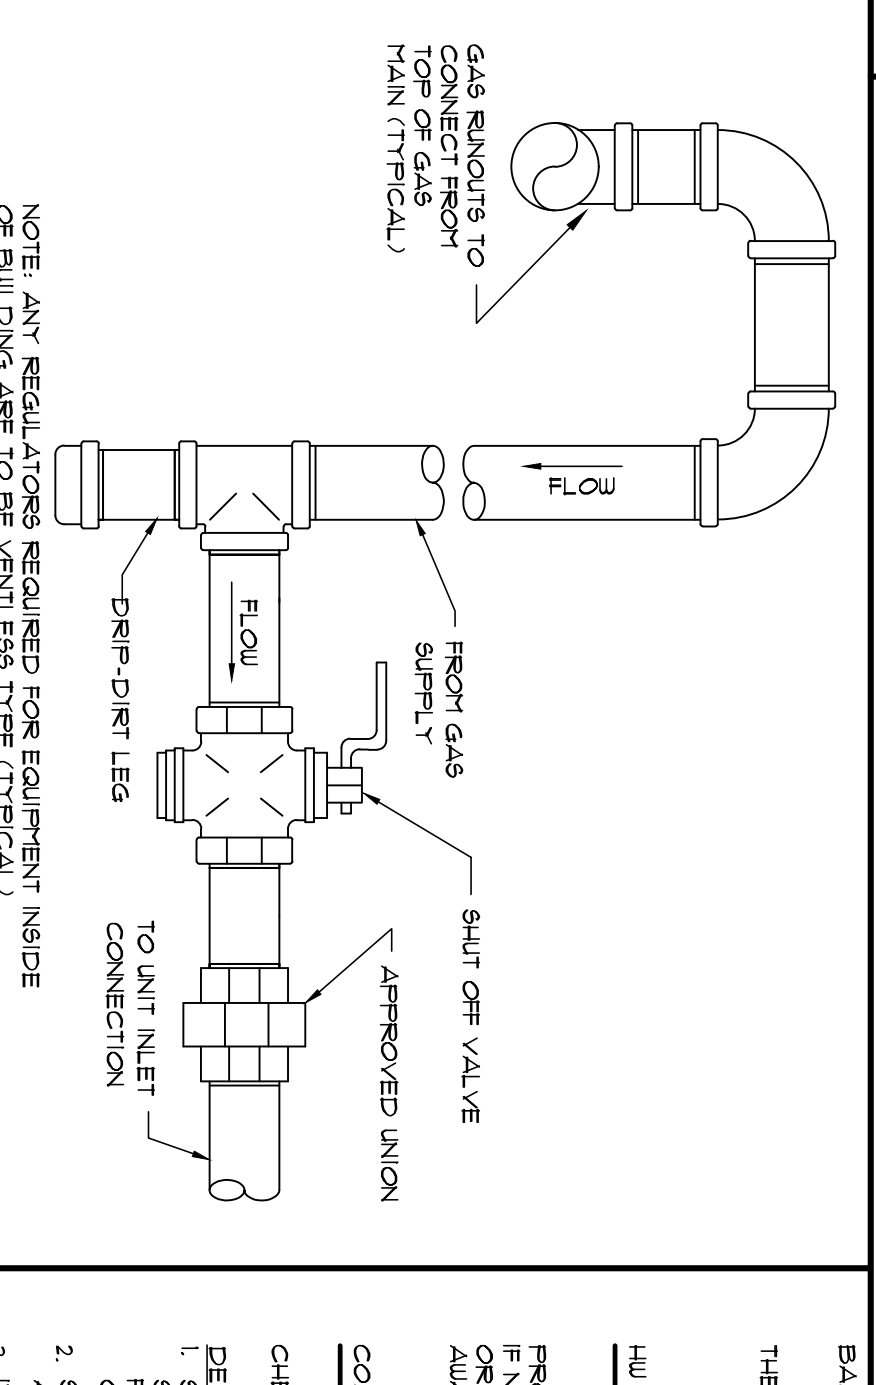


3 GAS CONNECTION DETAIL
SCALE: NONE

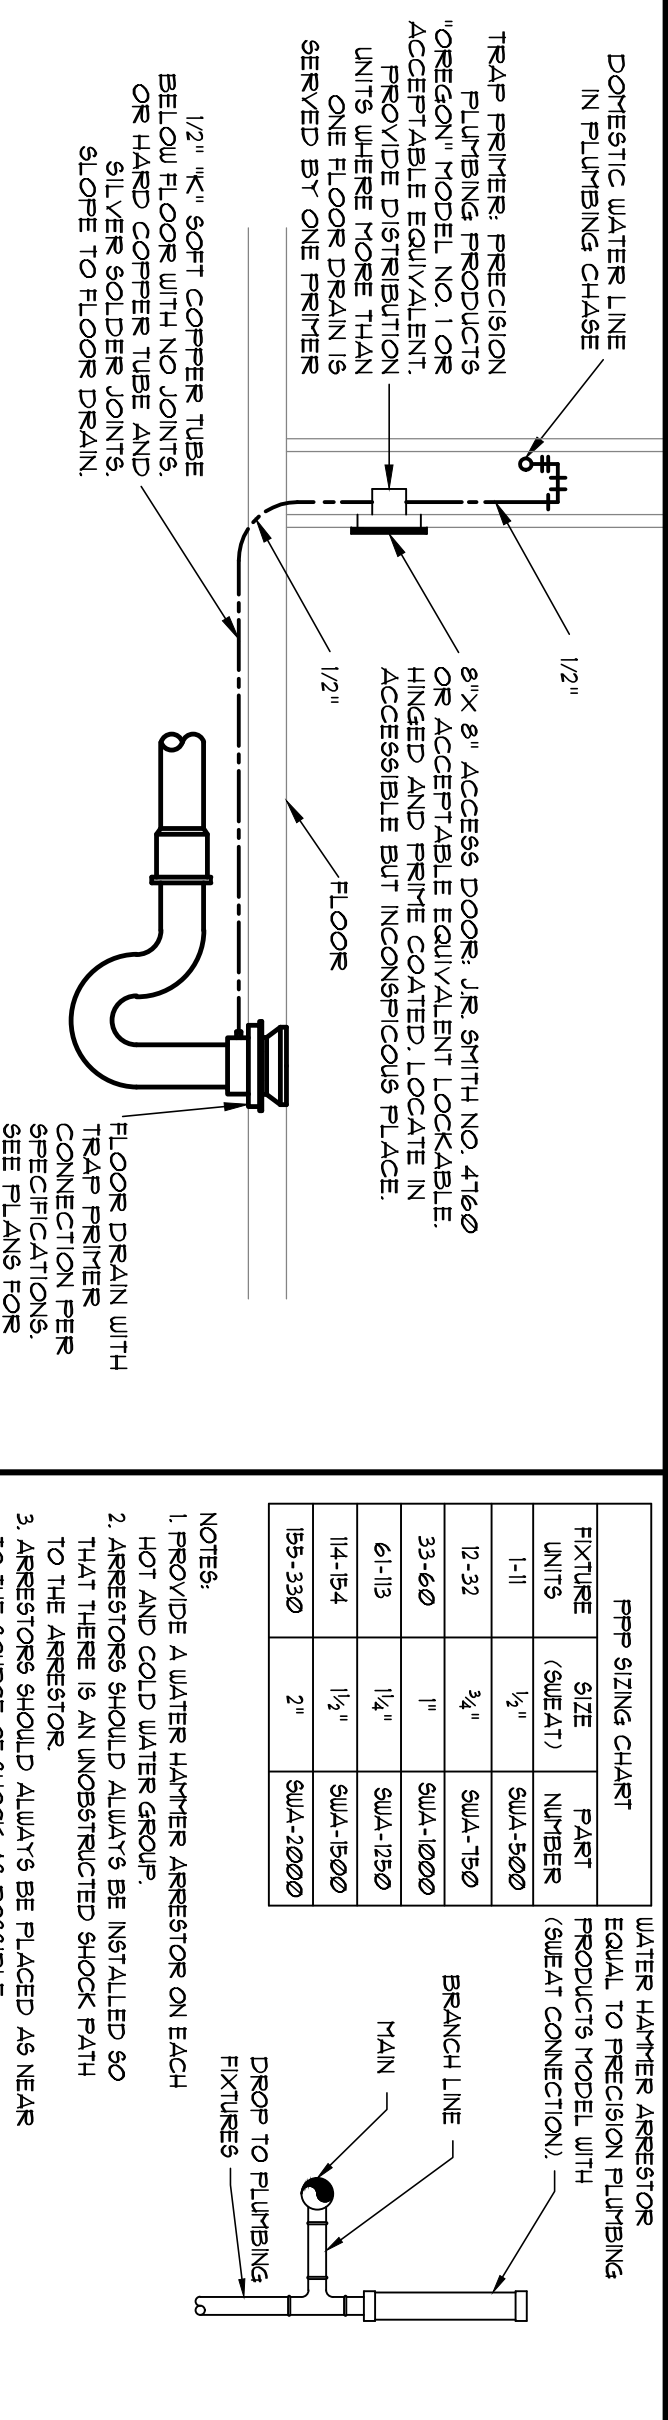


4 TRAP PRIMER DETAIL
SCALE: NONE

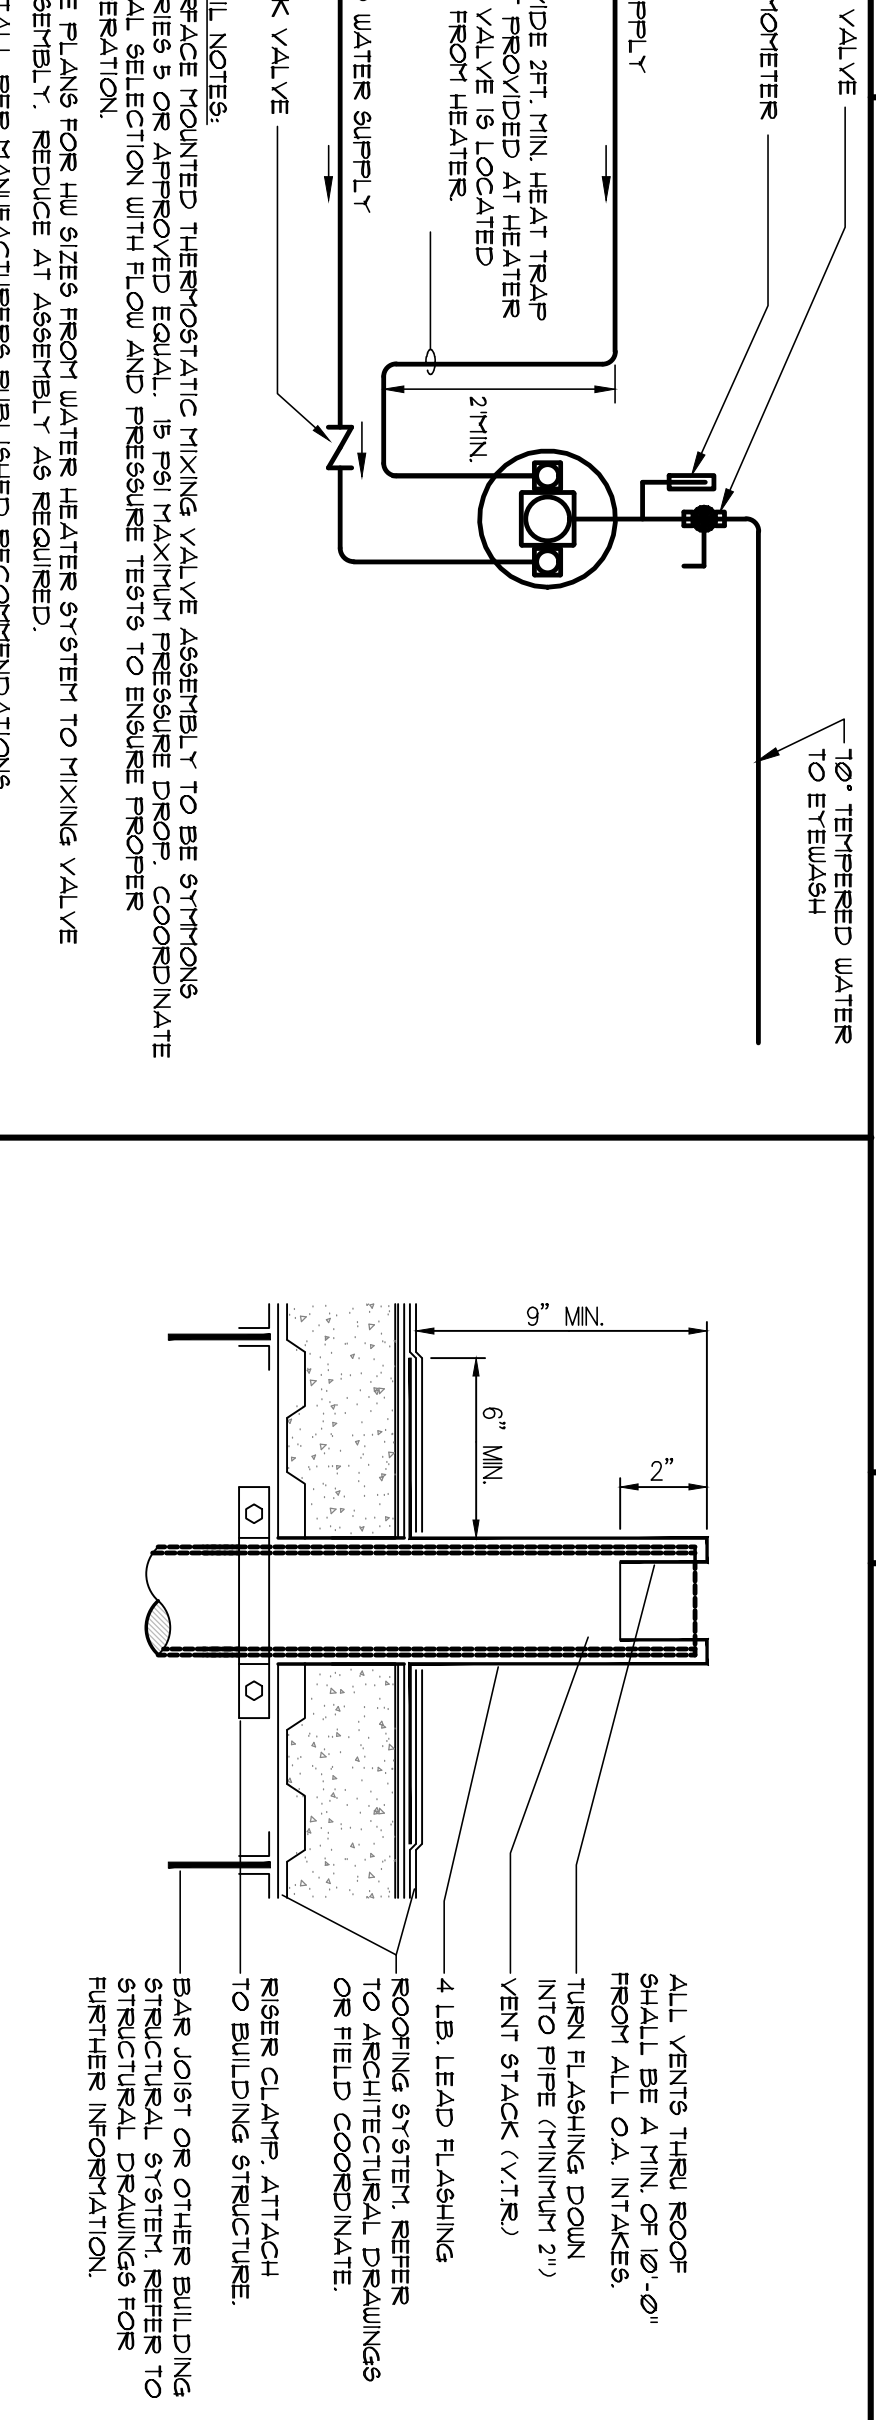


3 THERMOSTATIC MIXING VALVE
SCALE: NONE

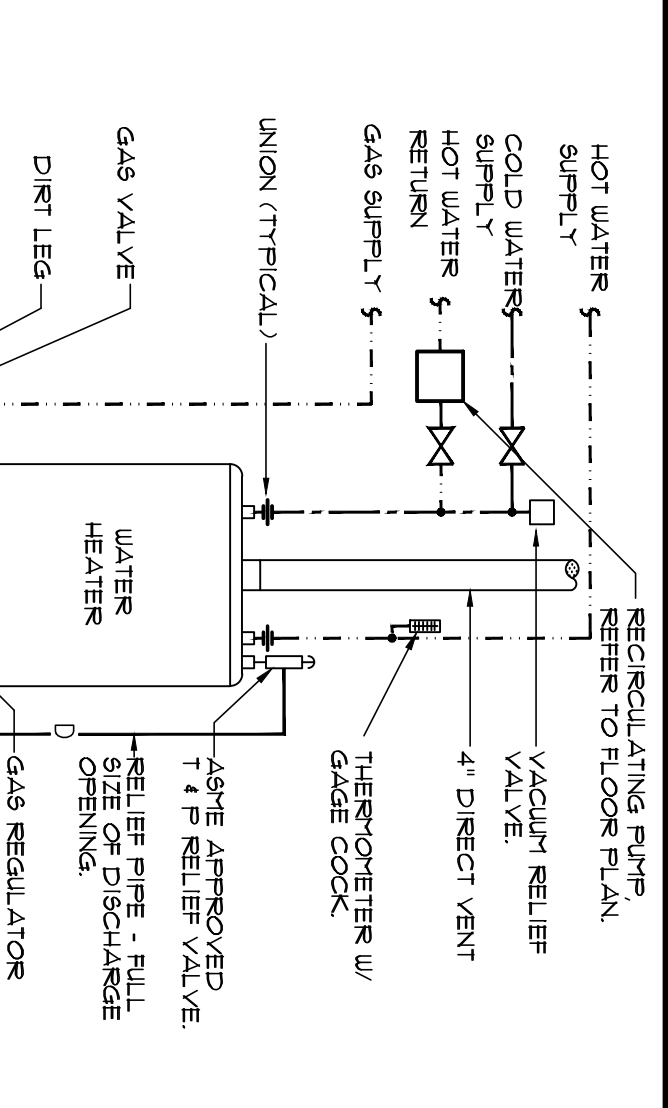


5 WATER HAMMER ARRESTOR DETAIL
SCALE: NONE

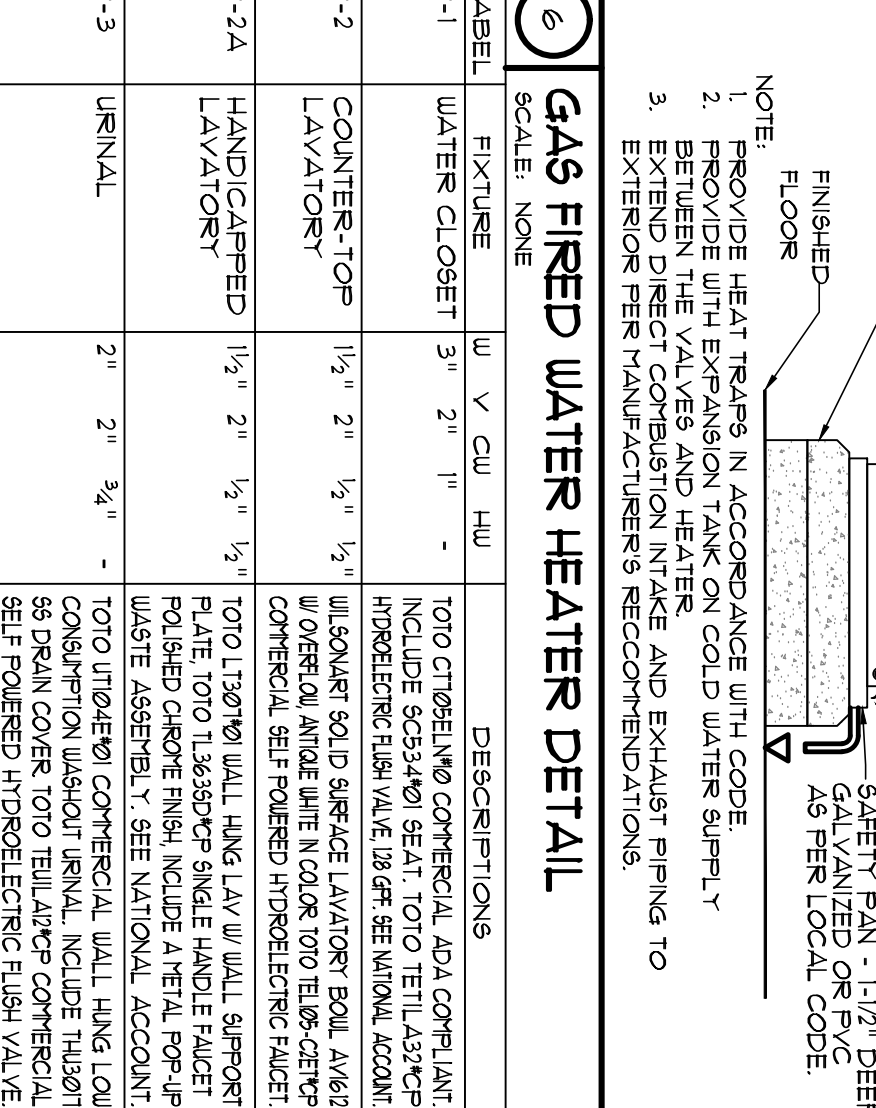

10 VENT THRU ROOF DETAIL
SCALE: NONE

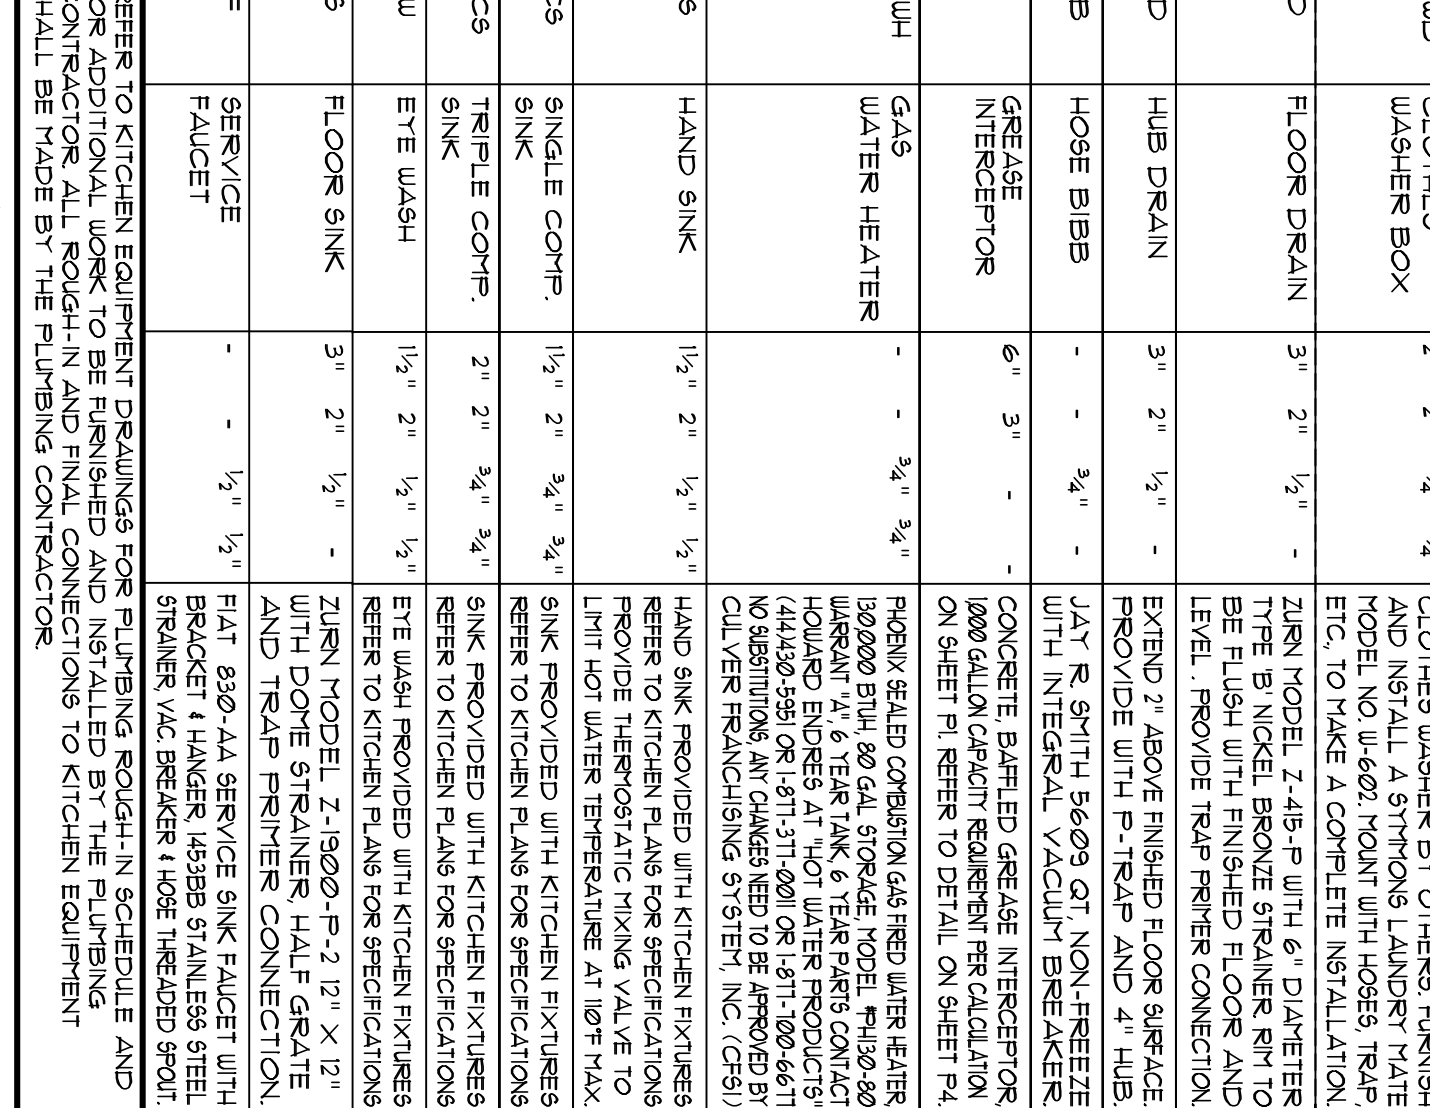

PLUMBING FIXTURE SCHEDULE

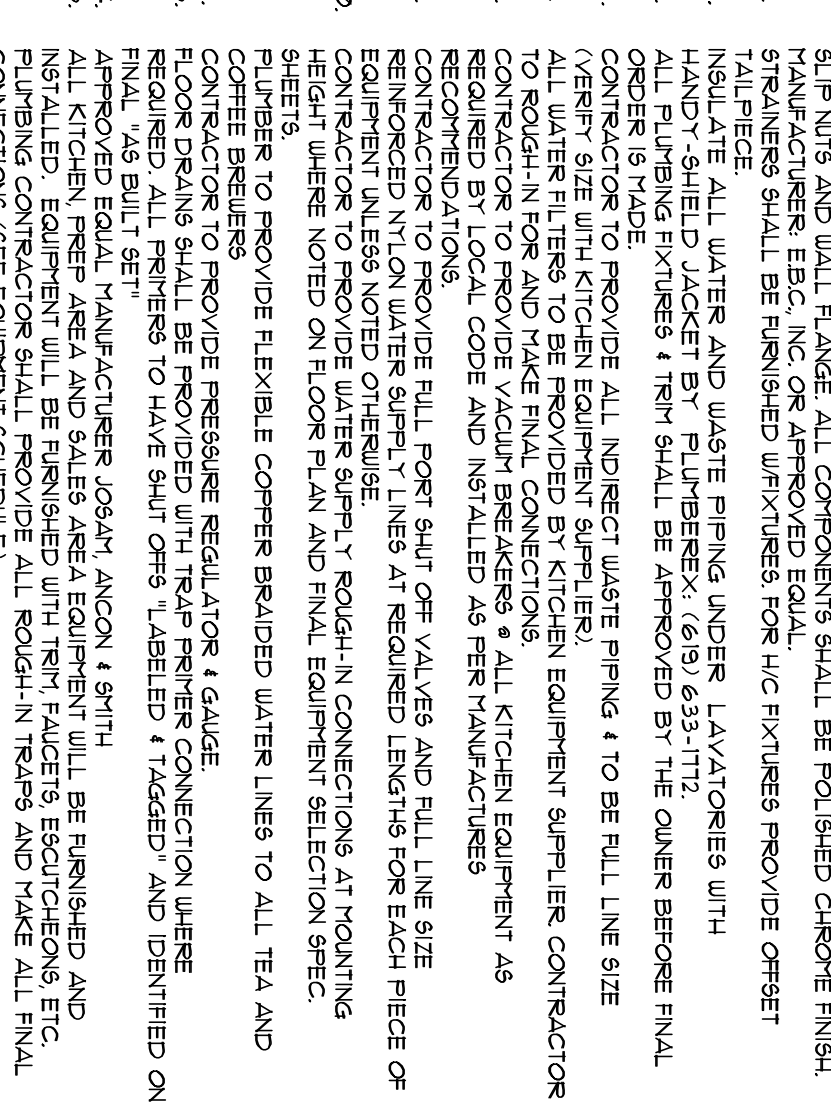

PLUMBING FIXTURE SCHEDULE

REVISIONS	BY
03.31.22	BND

OLIVERI ARCHITECTS
Member of the American Institute of Architects
1004 Indiana Avenue • Palm Harbor, FL 34683
Phone 727. 781. 7325
www.oliveriarchitects.com

© 2022 OLIVERI ARCHITECTS
ALL INFORMATION CONTAINED
IN THIS DRAWING IS THE
SOLE PROPERTY OF
OLIVERI ARCHITECTS.
ALL RIGHTS RESERVED.

MDCI FLORIDA, INC.
405 2nd Street South • Suite B
Safety Harbor, Florida 34686
Engineering Business No. 9204
Tel: 727.698.0398 Fax: 727.797.8225
© Copyright, 2022 • Project No. 2206

New Free Standing
Calver's
US Hwy 90
Lake City, Florida
Columbia County

Date: 04.13.22	Scale: AS NOTED	Project Mgr: DG
Drawn: BND		
Job: 21-244		
Sheet		

