


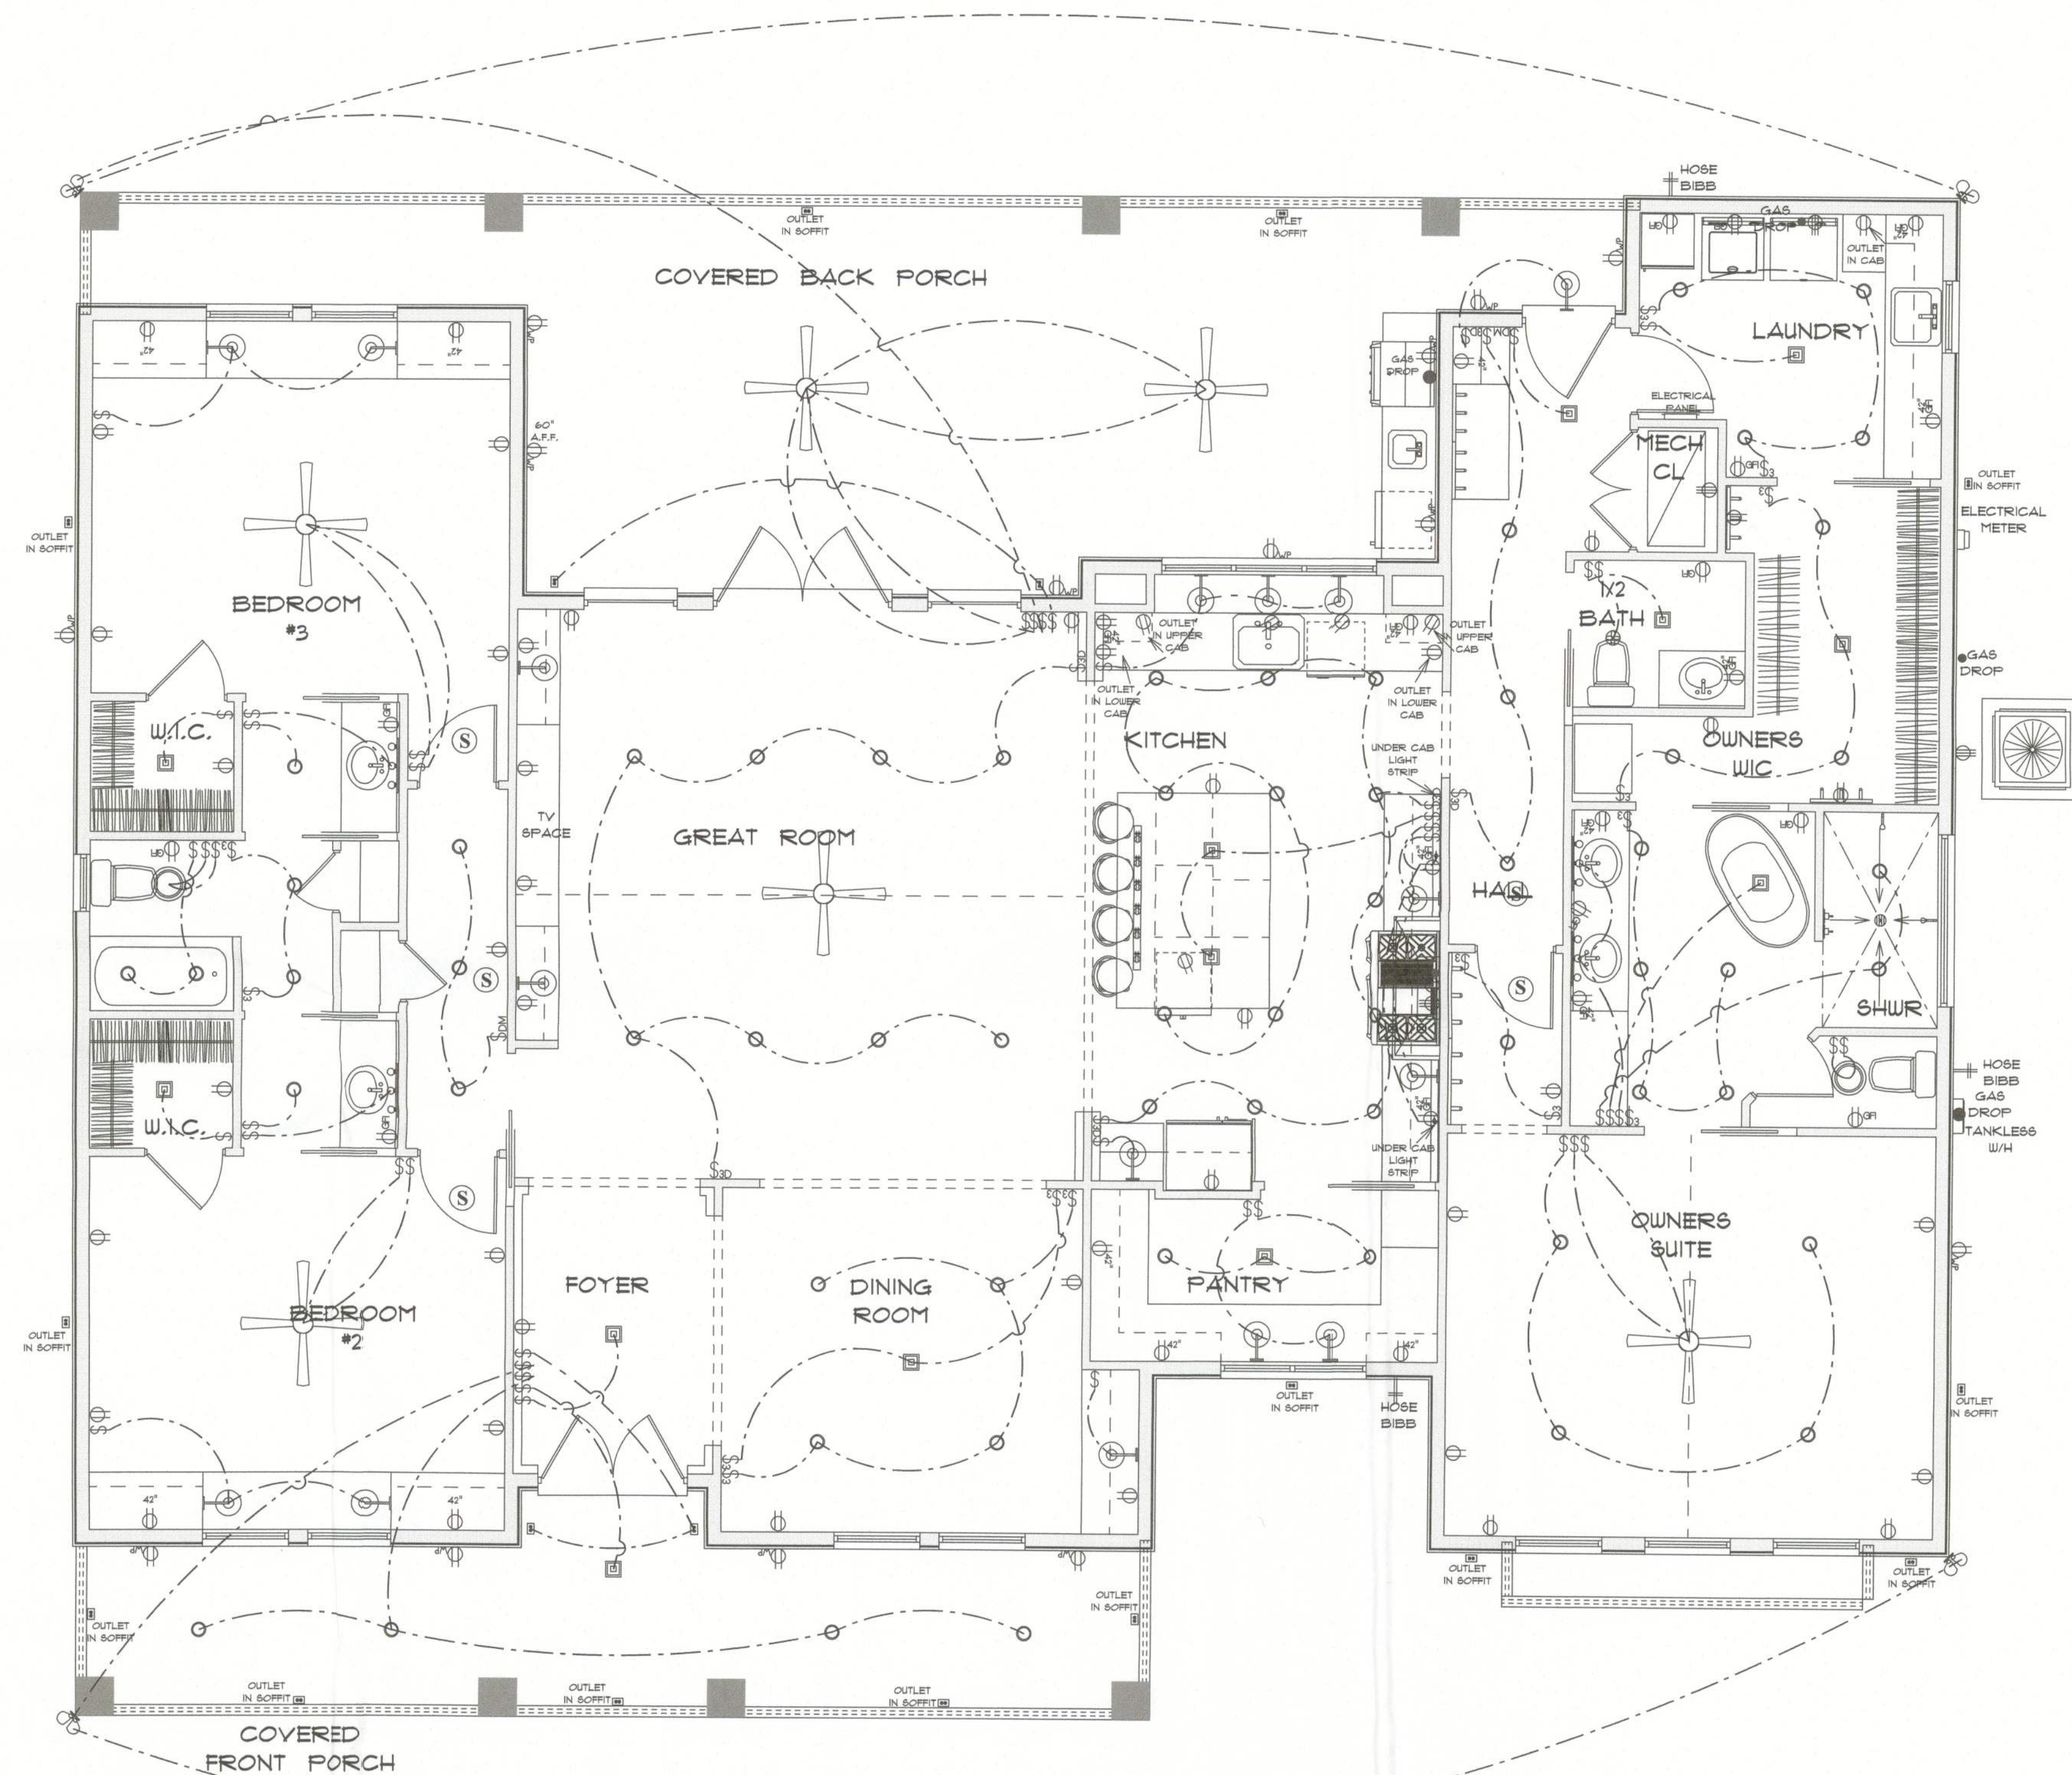

ELECTRICAL LEGEND		
ELECTRICAL	COUNT	SYMBOL
ceiling fan globe O1	6	
combination exhaust fan/light	2	
pendant large	13	
pot light	62	
Under Cab Light Strip	2	
spotlight double	4	
wall sconce	16	
Smoke Detector	5	
ceiling outlet single	18	
electrical panel	1	
dimmer switch	2	
dimmer switch 3-way	6	
exhaust fan	1	
outlet	52	
outlet 220v	4	
outlet gfi	19	
outlet wp	14	
switch	44	
switch 3 way	14	
vanity bar light O2	5	
6 outlet power strip	1	

- ELECTRICAL PLAN NOTES**
- E-1 WIRE ALL APPLIANCES, HVAC UNITS AND OTHER EQUIPMENT PER MANUFACTURERS SPECIFICATIONS.
 - E-2 ALL INSTALLATIONS SHALL BE PER NATIONAL ELECTRIC CODE.
 - E-3 ALL SMOKE /CARBON MONOXIDE DETECTORS SHALL BE 120V W/BATTERY BACKUP OF THE PHOTOELECTRIC TYPE, AND SHALL BE INTERLOCKED TOGETHER. INSTALL INSIDE AND NEAR ALL BEDROOMS AS PER CODE.
 - E-4 TELEPHONE, TELEVISION AND OTHER LOW VOLTAGE DEVICES OR OUTLETS SHALL BE AS PER THE OWNERS DIRECTION AND IN ACCORDANCE WITH APPLICABLE SECTIONS OF NATIONAL ELCT. CODE LATEST EDITION.
 - E-5 ELECTRICAL CONTRACTOR SHALL BE RESPONSIBLE FOR THE DESIGN AND SIZING OF ELECTRICAL SERVICE AND CIRCUITS.
 - E-6 ENTRY OF SERVICE UNDERGROUND OR OVERHEAD) IS TO BE DETERMINED BY THE POWER COMPANY.
 - E-7 ALL BEDROOM RECEPTALS ARE TO BE AFCI (ARC FAULT CIRCUIT INTERRUPT)
 - E-8 15% OF ALL PERMANENT LIGHTS TO BE ENERGY EFFICIENT.

*** ELECTRICAL PLAN ***
SCALE : 3/16" = 1'-0"

NEW RESIDENCE
for
MARTIN & REBEKAH
McALHANY

Tesana M. Ruffo
2925 SW 8R 41
Lake City Florida, 32025
Call: (386) 861-1191
Email: tesanaruffo@gmail.com

PRINTED DATE:
Thursday, May 30, 2024

DRAWN BY: Tesana M. Ruffo
CHECKED BY:
BUILDING CONTRACTOR:

FINALS DATE:

JOB NUMBER:

DRAWING NUMBER

A-6

OF 6 SHEETS