


REVISIONS


SOFTPLAN
ARCHITECTURAL DESIGN SOFTWARE

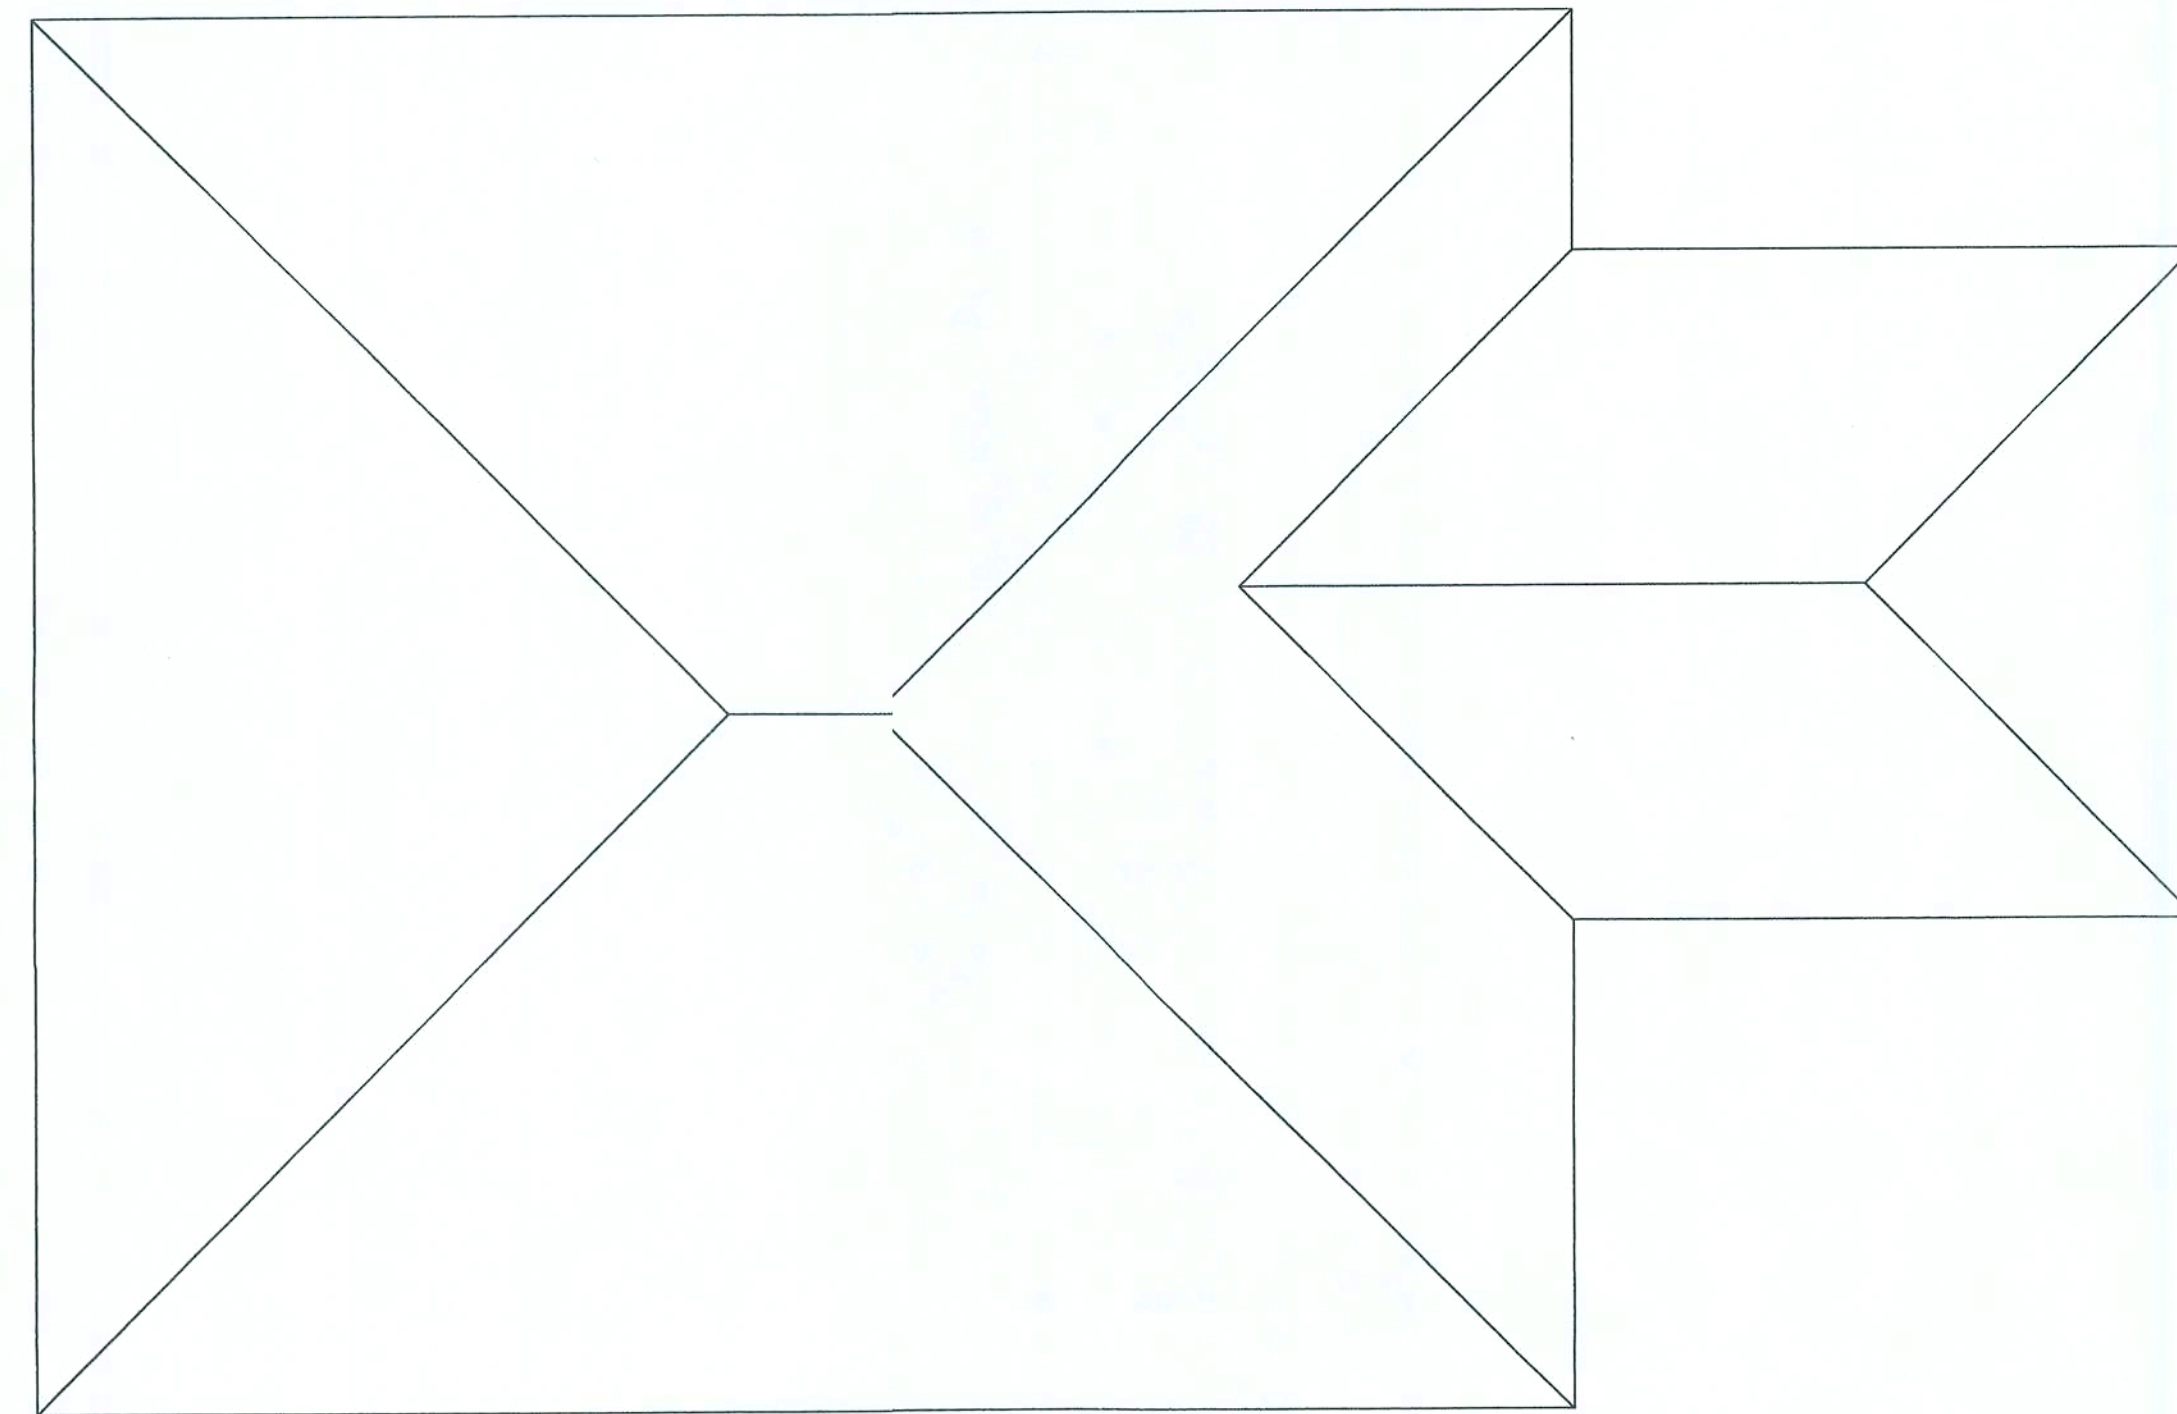

* ROOF PLAN *

SCALE : 1/8" = 1'-0"


6/12 PITCH WITH 24" O'ALL EAVES

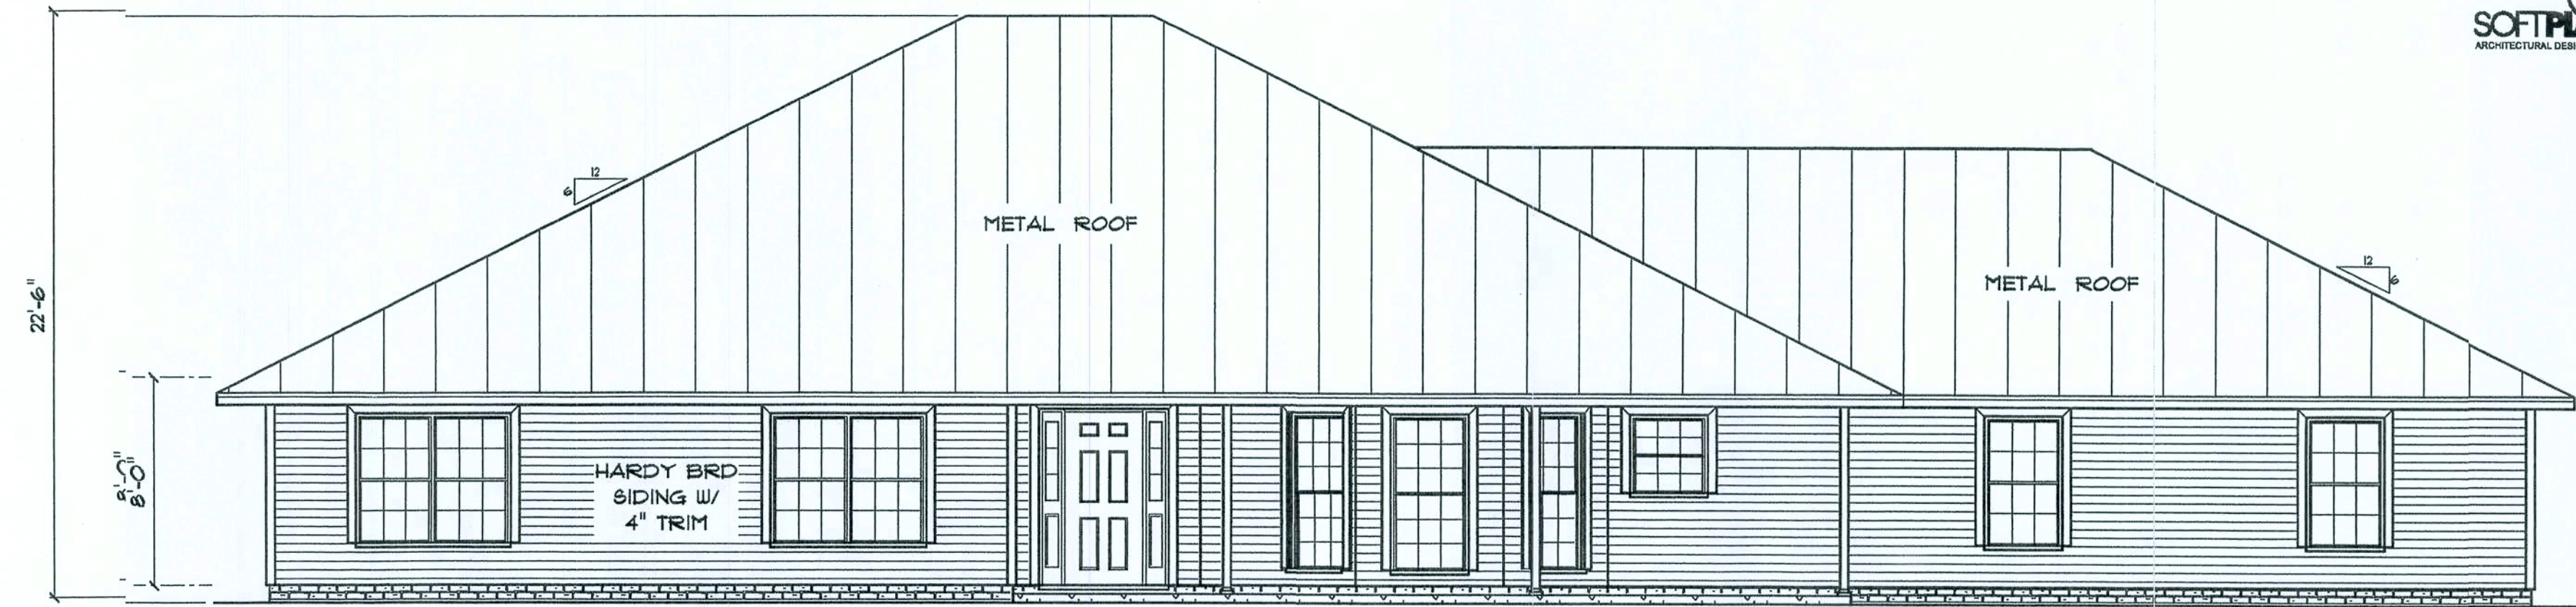

* FRONT ELEVATION *


SCALE : 1/4" = 1'-0"

24" OVERHANG ON ALL EAVES

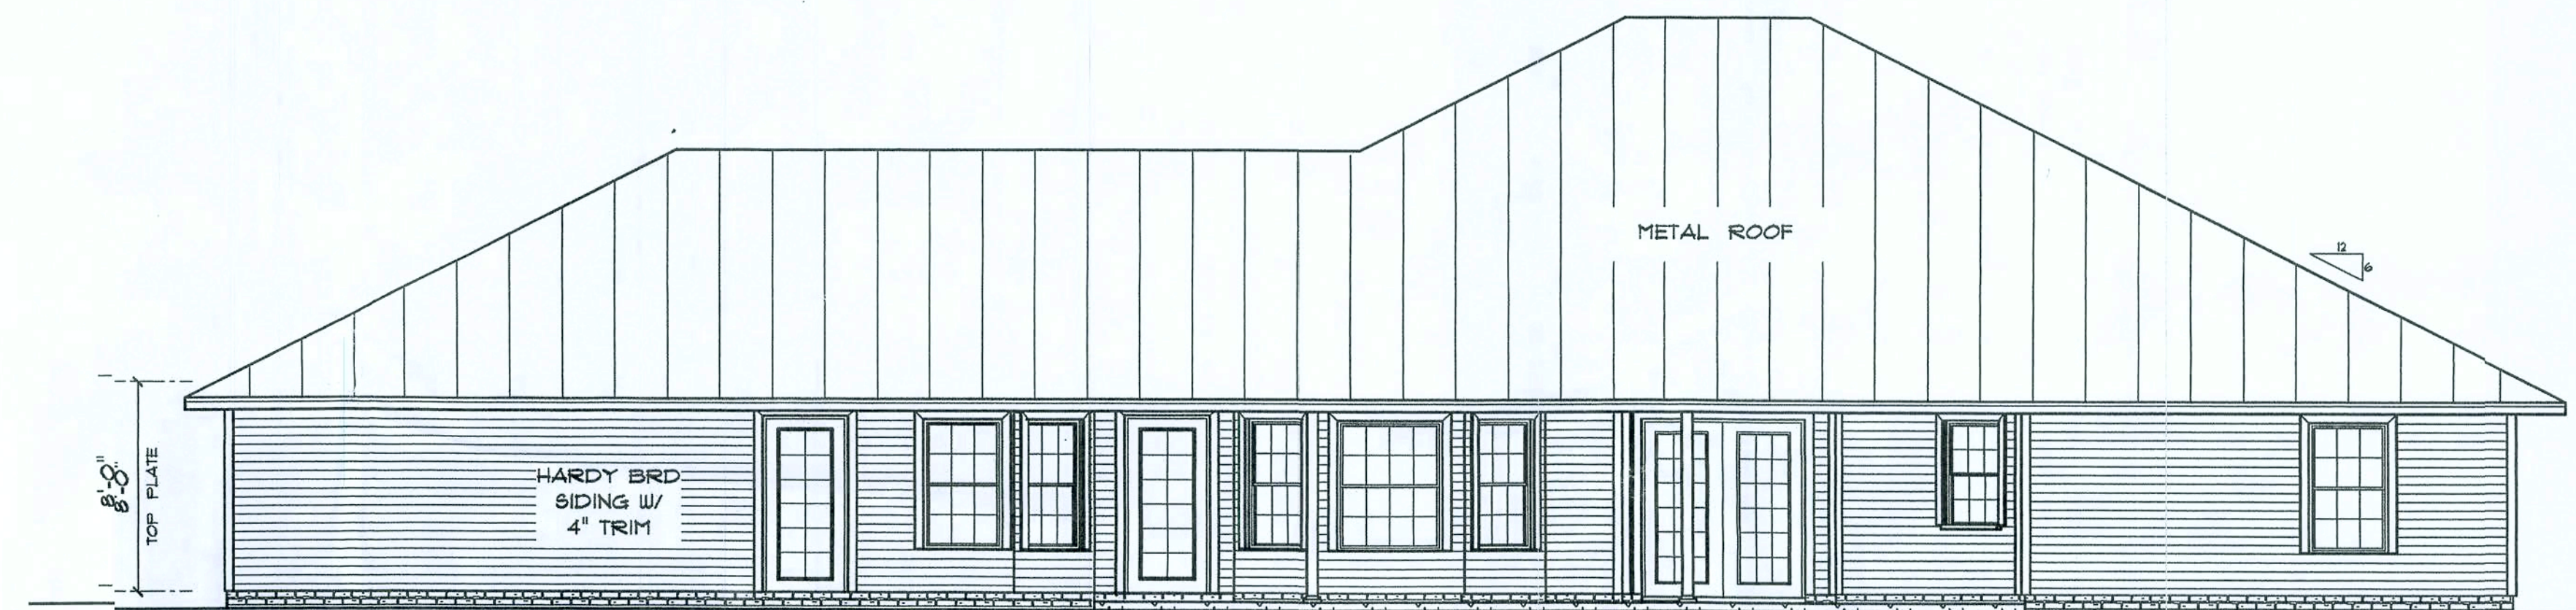


* REAR ELEVATION *

SCALE : 3/16" = 1'-0"

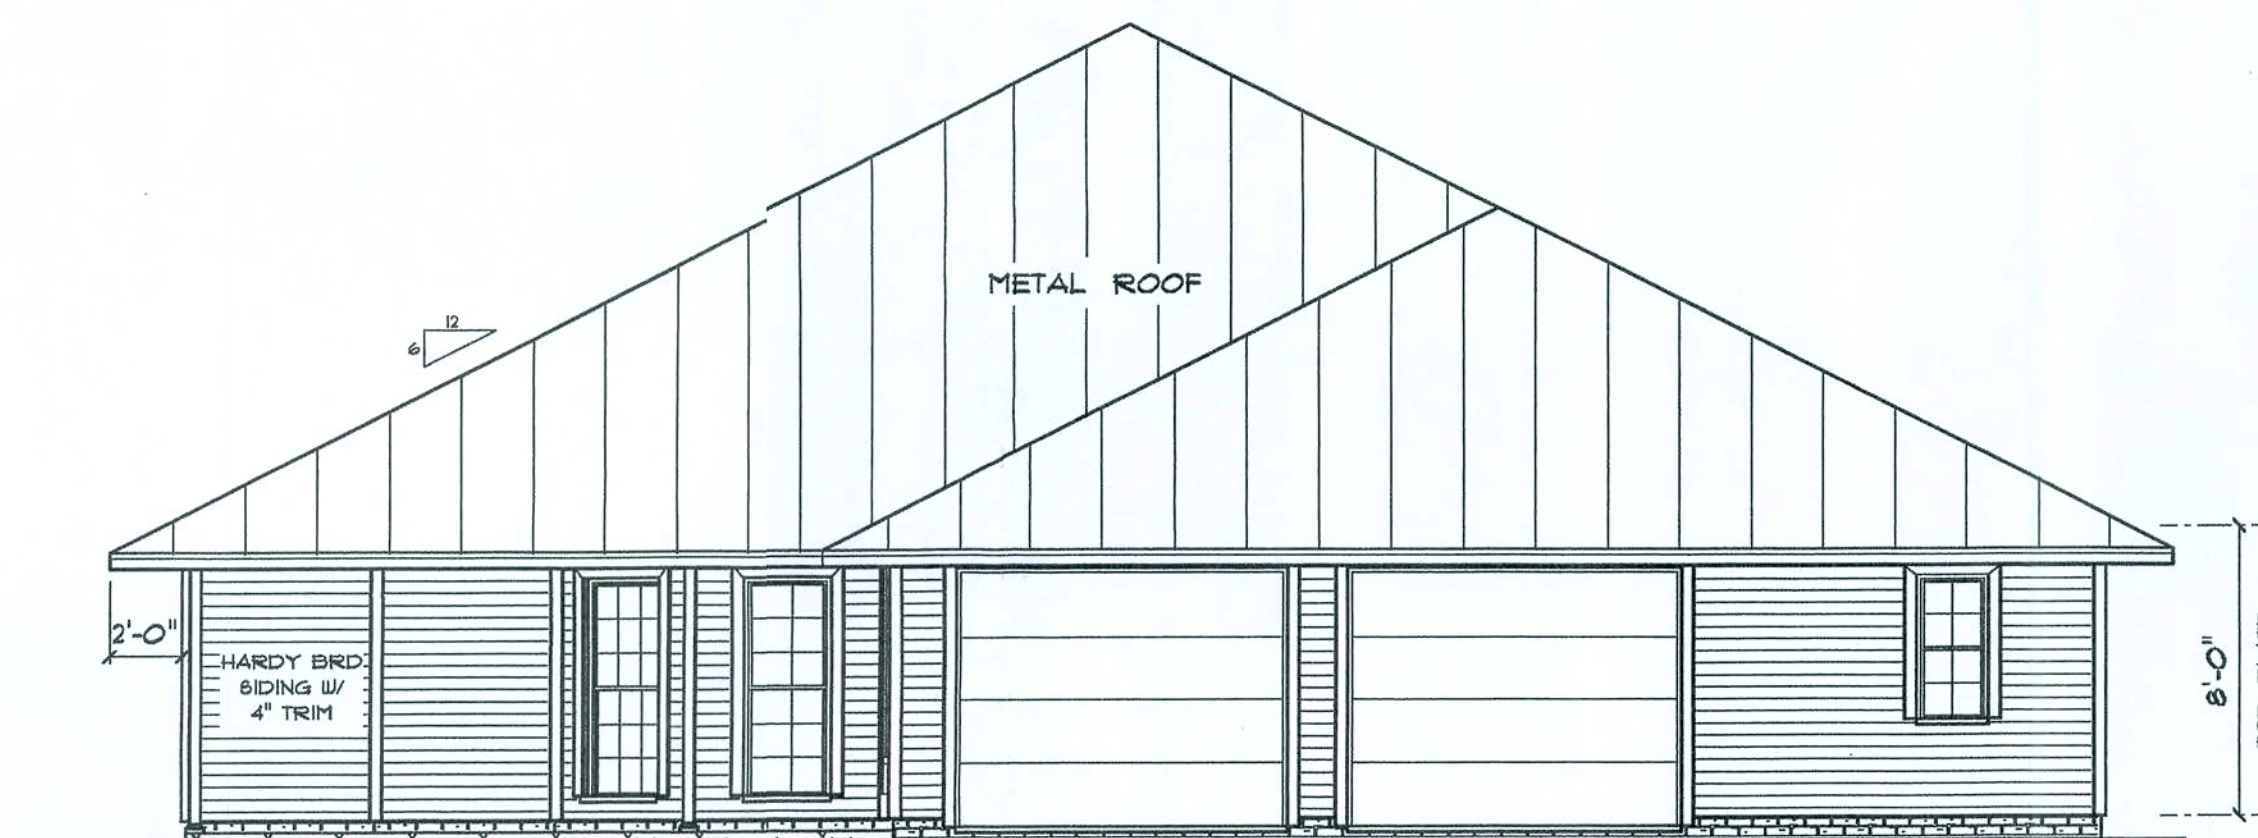

* RIGHT SIDE ELEVATION *

SCALE : 1/4" = 1'-0"

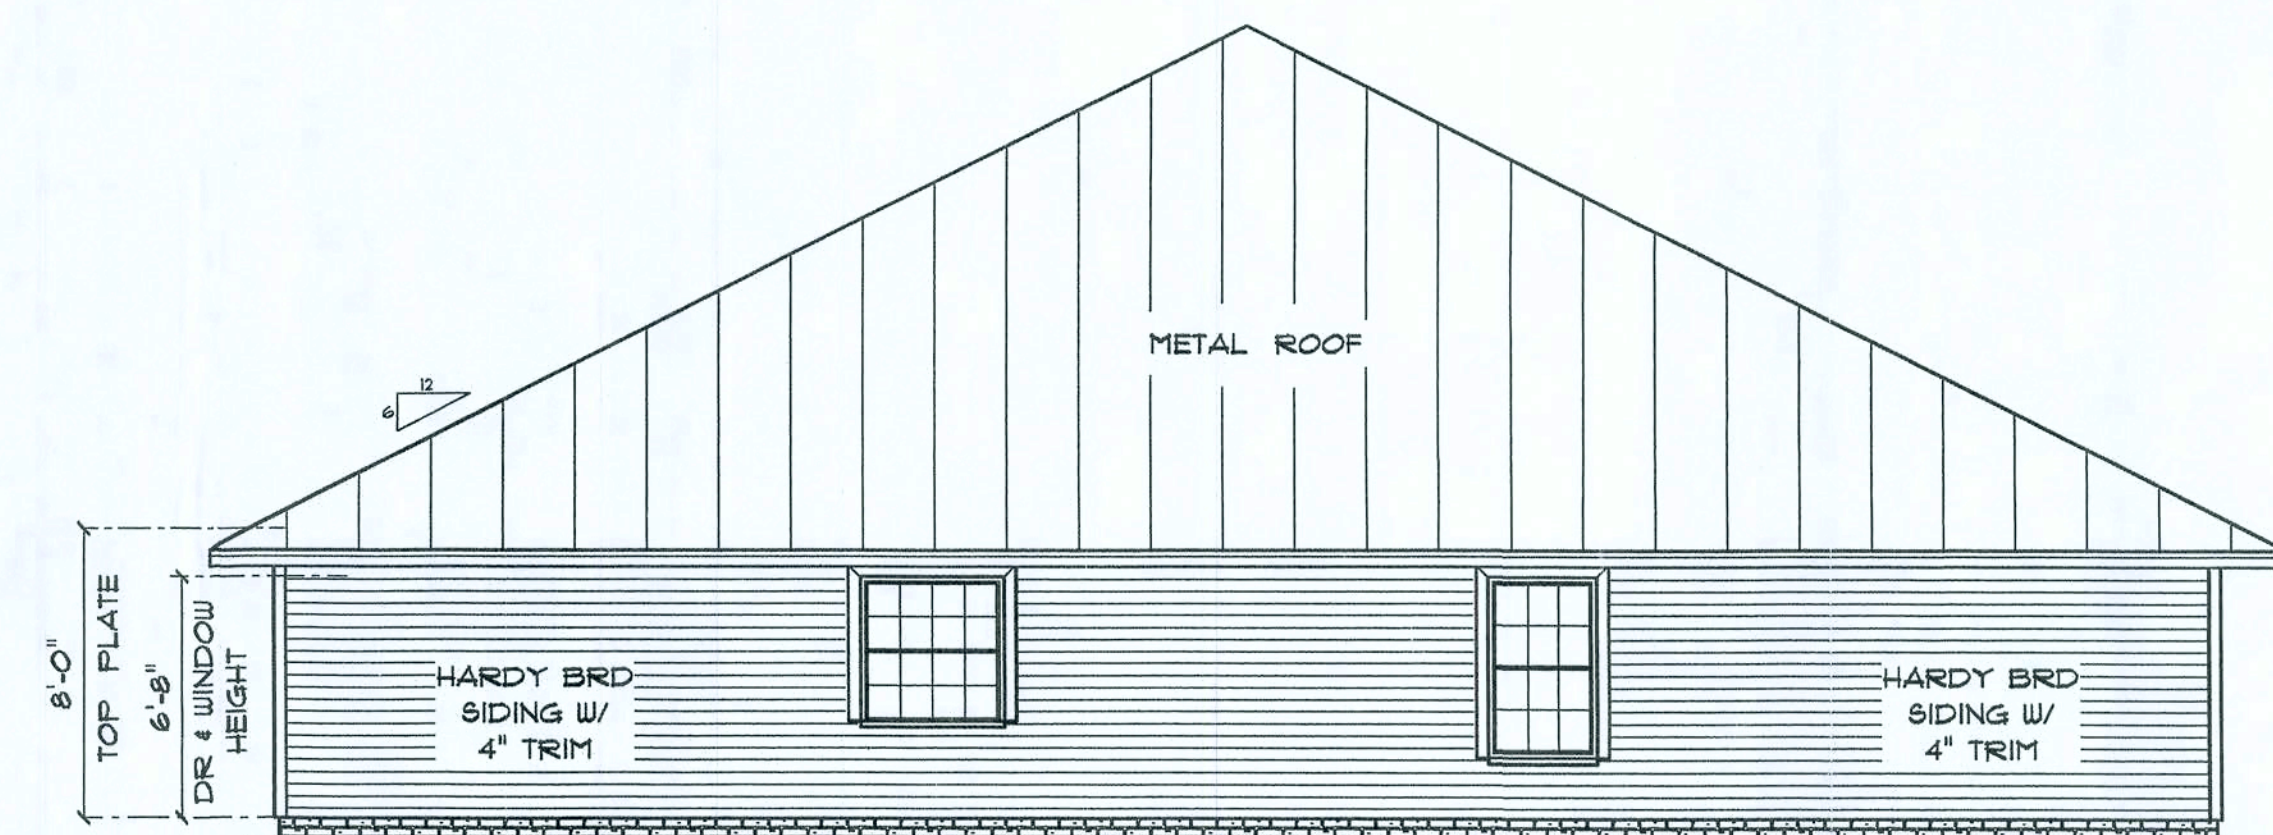

* LEFT SIDE ELEVATION *

SCALE : 1/4" = 1'-0"

RESIDENCE
for
Dwight & Jenny
LORD

Teresa M. Ruffo
25 NW Hall of Fame Dr.
Lake City, Florida 32055
Phone: (386) 759 - 9953
Cell: (386) 861 - 1191
Email: m@archdesigns@lani.net

PRINTED DATE:
September 18, 2008

DRAWN BY: *Teresa M. Ruffo* CHECKED BY:

BUILDING CONTRACTOR

FINAL DATE:
DEC 2008

JOB NUMBER:

DRAWING NUMBER


A-3

OF 4 SHEETS

ELECTRICAL	COUNT	SYMBOL
chandelier	1	
200 amp service panel	1	
3 way switch with dimmer	2	
Garbage disposal	1	
automatic garage dr opener	2	
cable tv outlet	4	
ceiling fan	10	
oble flood lights	4	
dimmer switch	5	
electric meter	1	
fluorescent lt fixture	2	
garage dr opener	2	
gfi waterproof outlet	5	
Jamb switch	5	
light	32	
outlet	52	
outlet 220v	5	
outlet gfi	18	
recessed can light	12	
smoke detector	7	
switch	37	
switch 3 way	16	
telephone	4	
vent light combo	4	

ELECTRICAL PLAN NOTES

- E-1 WIRE ALL APPLIANCES, HVAC UNITS AND OTHER EQUIPMENT PER MANUFACTURERS SPECIFICATIONS.
- E-2 CONSULT THE OWNER FOR THE NUMBER OF SEPARATE TELEPHONE LINES TO BE INSTALLED.
- E-4 ALL INSTALLATIONS SHALL BE PER NATIONAL ELECTRIC CODE.
- E-3 ALL SMOKE DETECTORS SHALL BE 120V BATTERY BACKUP OF THE PHOTOELECTRIC TYPE, AND SHALL BE INTERLOCKED TOGETHER. INSTALL INSIDE AND NEAR ALL BEDROOMS.
- E-5 TELEPHONE, TELEVISION AND OTHER LOW VOLTAGE DEVICES OR OUTLETS SHALL BE AS PER THE OWNERS DIRECTION AND IN ACCORDANCE WITH APPLICABLE SECTION OF NATIONAL ELCT. CODE LATEST EDITION.
- E-6 ELECTRICAL CONTRACTOR SHALL BE RESPONSIBLE FOR THE DESIGN AND SIZING OF ELECTRICAL SERVICE AND CIRCUITS.
- E-7 ENTRY OF SERVICE UNDERGROUND OR OVERHEAD IS TO BE DETERMINED BY THE POWER COMPANY.
- E-8 ALL BEDROOM RECEPTALS ARE TO BE AFCI (ARC FAULT CIRCUIT INTERRUPT)

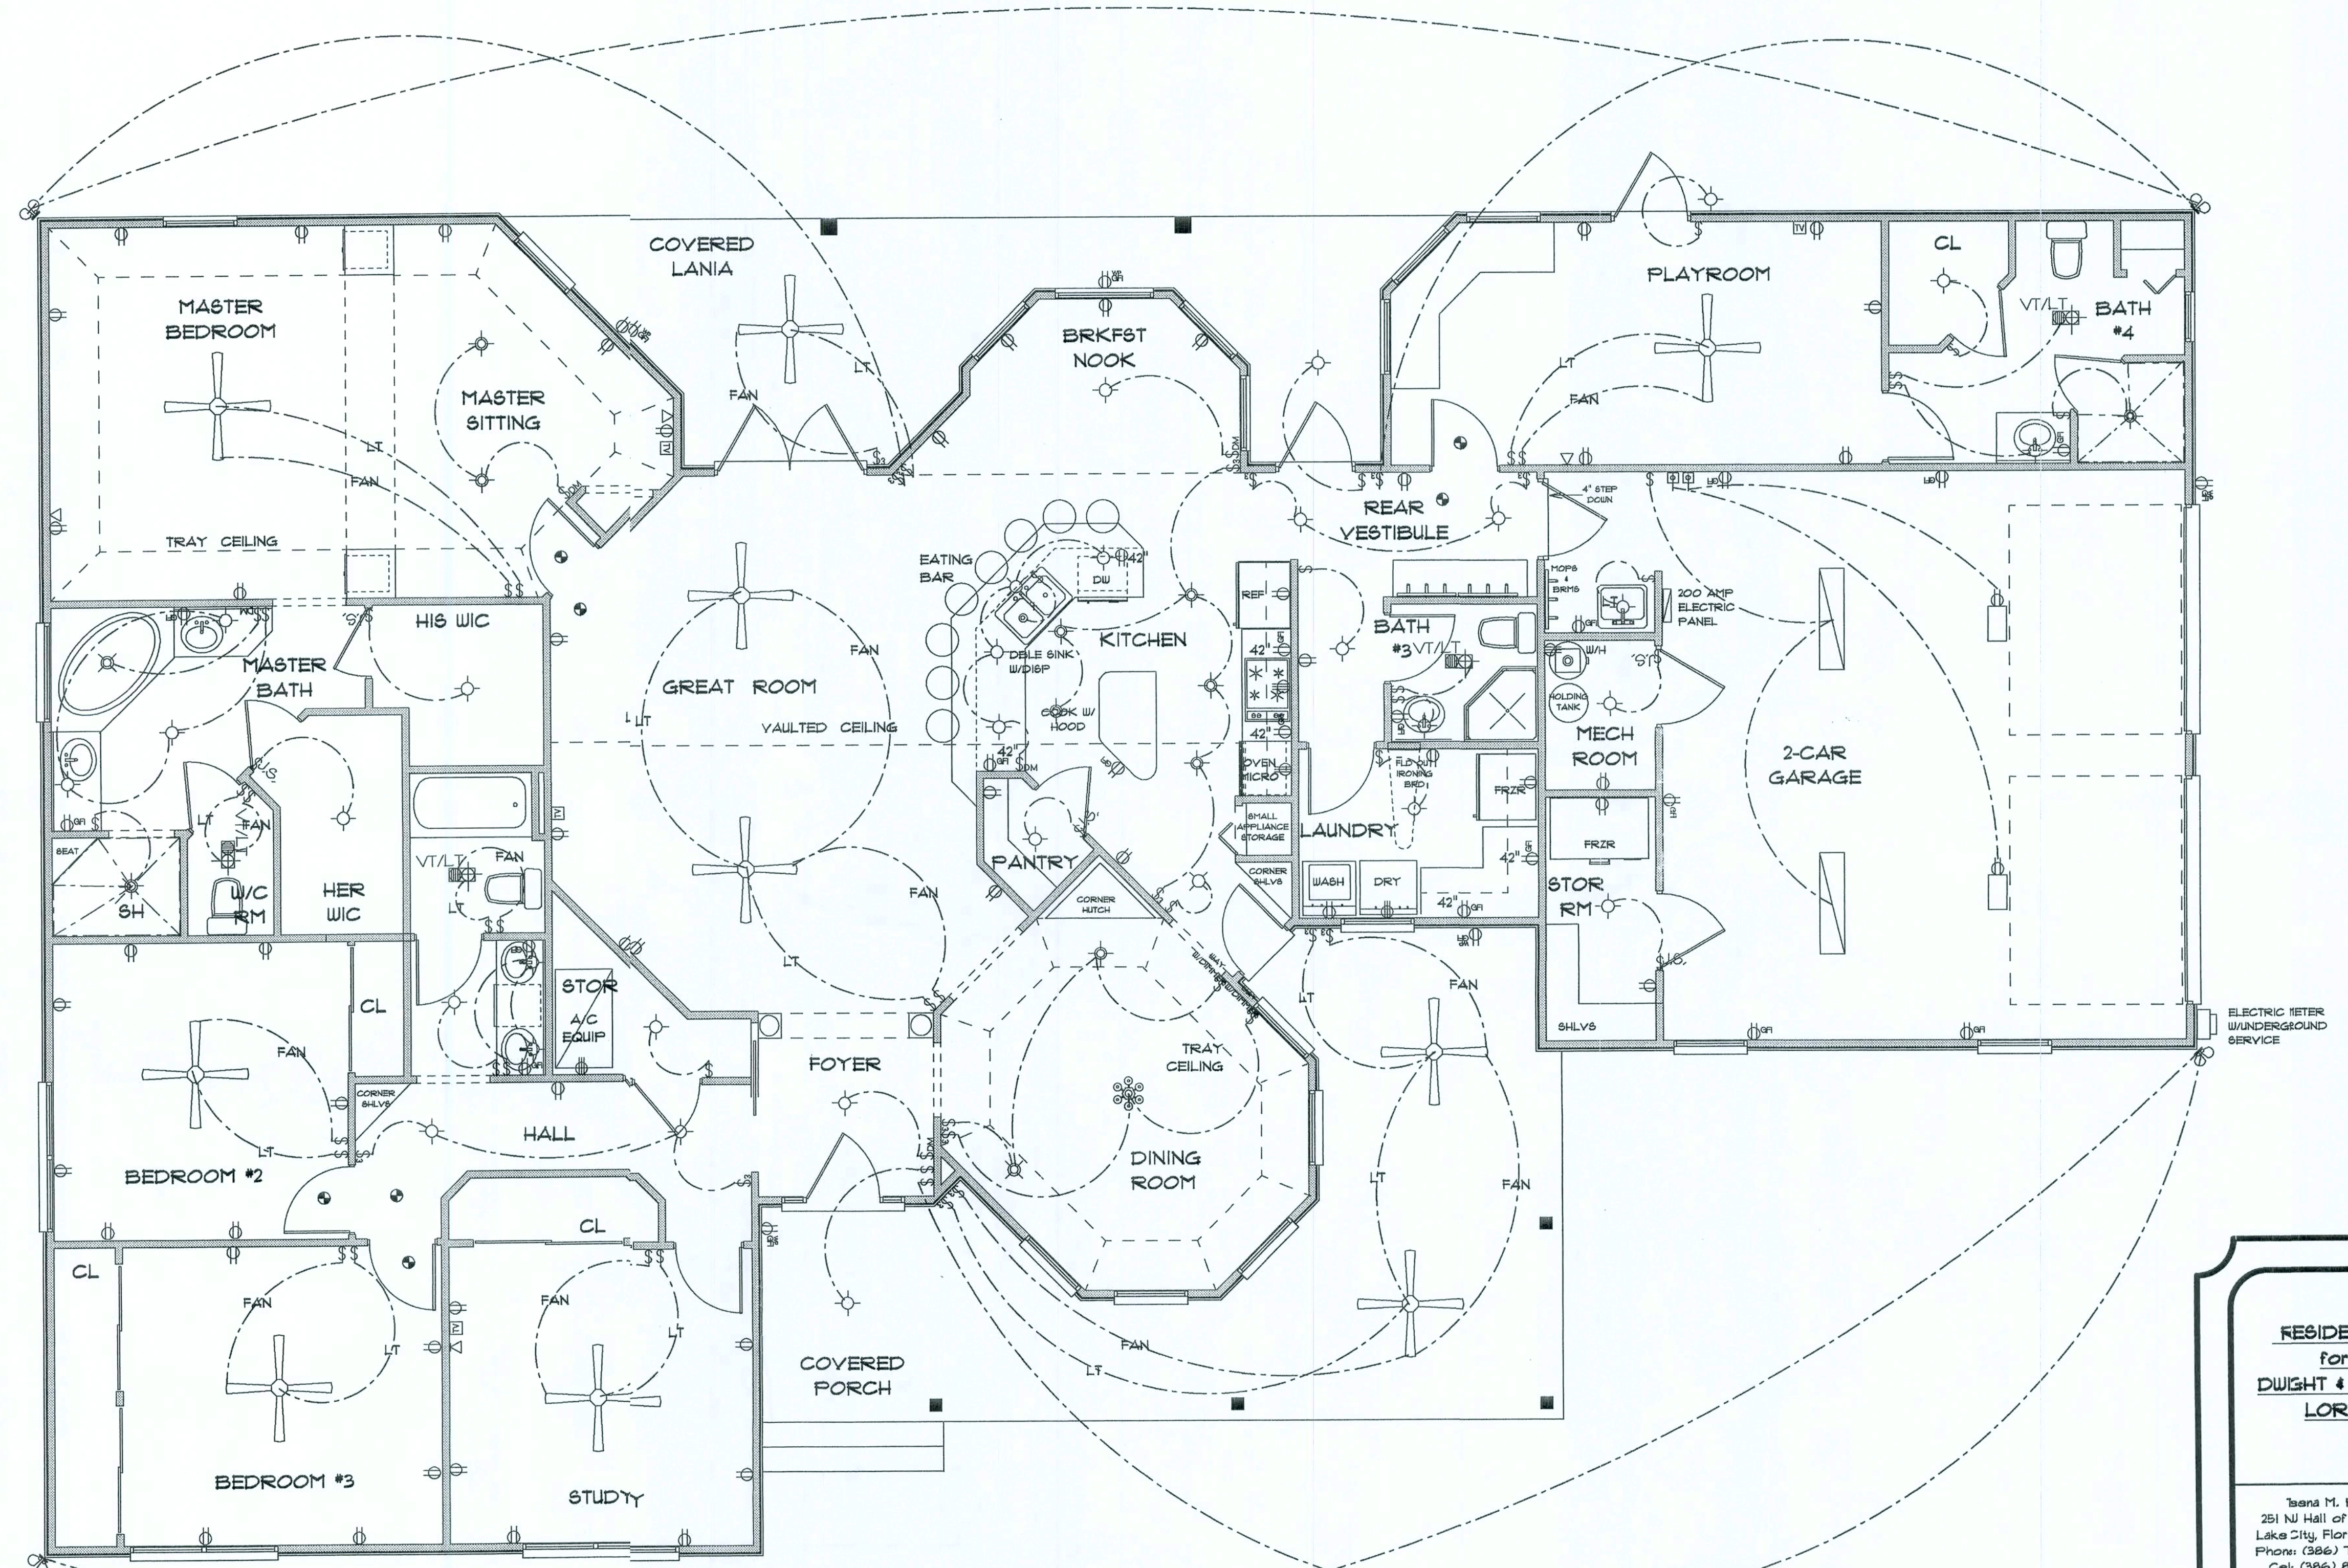

*** ELECTRICAL PLAN ***

SCALE : 1/4" = 1'-0"

**RESIDENCE
for
DAUGHT & JENNY
LORD**

Isana M. Ruffo
251 NJ Hall of Fame Dr.
Lake City, Florida 32055
Phone: (386) 755 - 9993
Cell: (386) 867 - 1181
Email: farchitects@ian.net

PRINTED DATE:
September 18, 2008

DRAWN BY: Isana M. Ruffo
CHECKED BY:
BUILDING CONTRACTOR

FINAL DATE:
DEC 008

JOB NUMBER:

DRAWING NUMBER

A-4

OF 4 SHEETS