

BEASLEY RESIDENCE PLANS COLUMBIA COUNTY, FL

Plan Sheet Index:

Sheet No.	Description
1	title/index sheet
2	floor plan
3	front & right elevations
4	rear & left elevations
5	wall typical/ strapping requirements
6	special details
7	foundation plan
8	electrical plan



Marty J. Humphries
4-29-13



PLANS PREPARED BY:
MARTY J. HUMPHRIES P.E. # 51976
7932 240TH ST., O'BRIEN, FL 32071

BEASLEY RESIDENCE PLANS
COLUMBIA COUNTY, FL

SHEET
1
OF
8




PLANS PREPARED BY:
MARTY J. HUMPHRIES P.E. # 51976
7932 240TH ST., O'BRIEN, FL 32071

BEASLEY RESIDENCE PLANS COLUMBIA COUNTY, FL

SHEET
2 OF
8

Marty J. Humphries
4-29-13

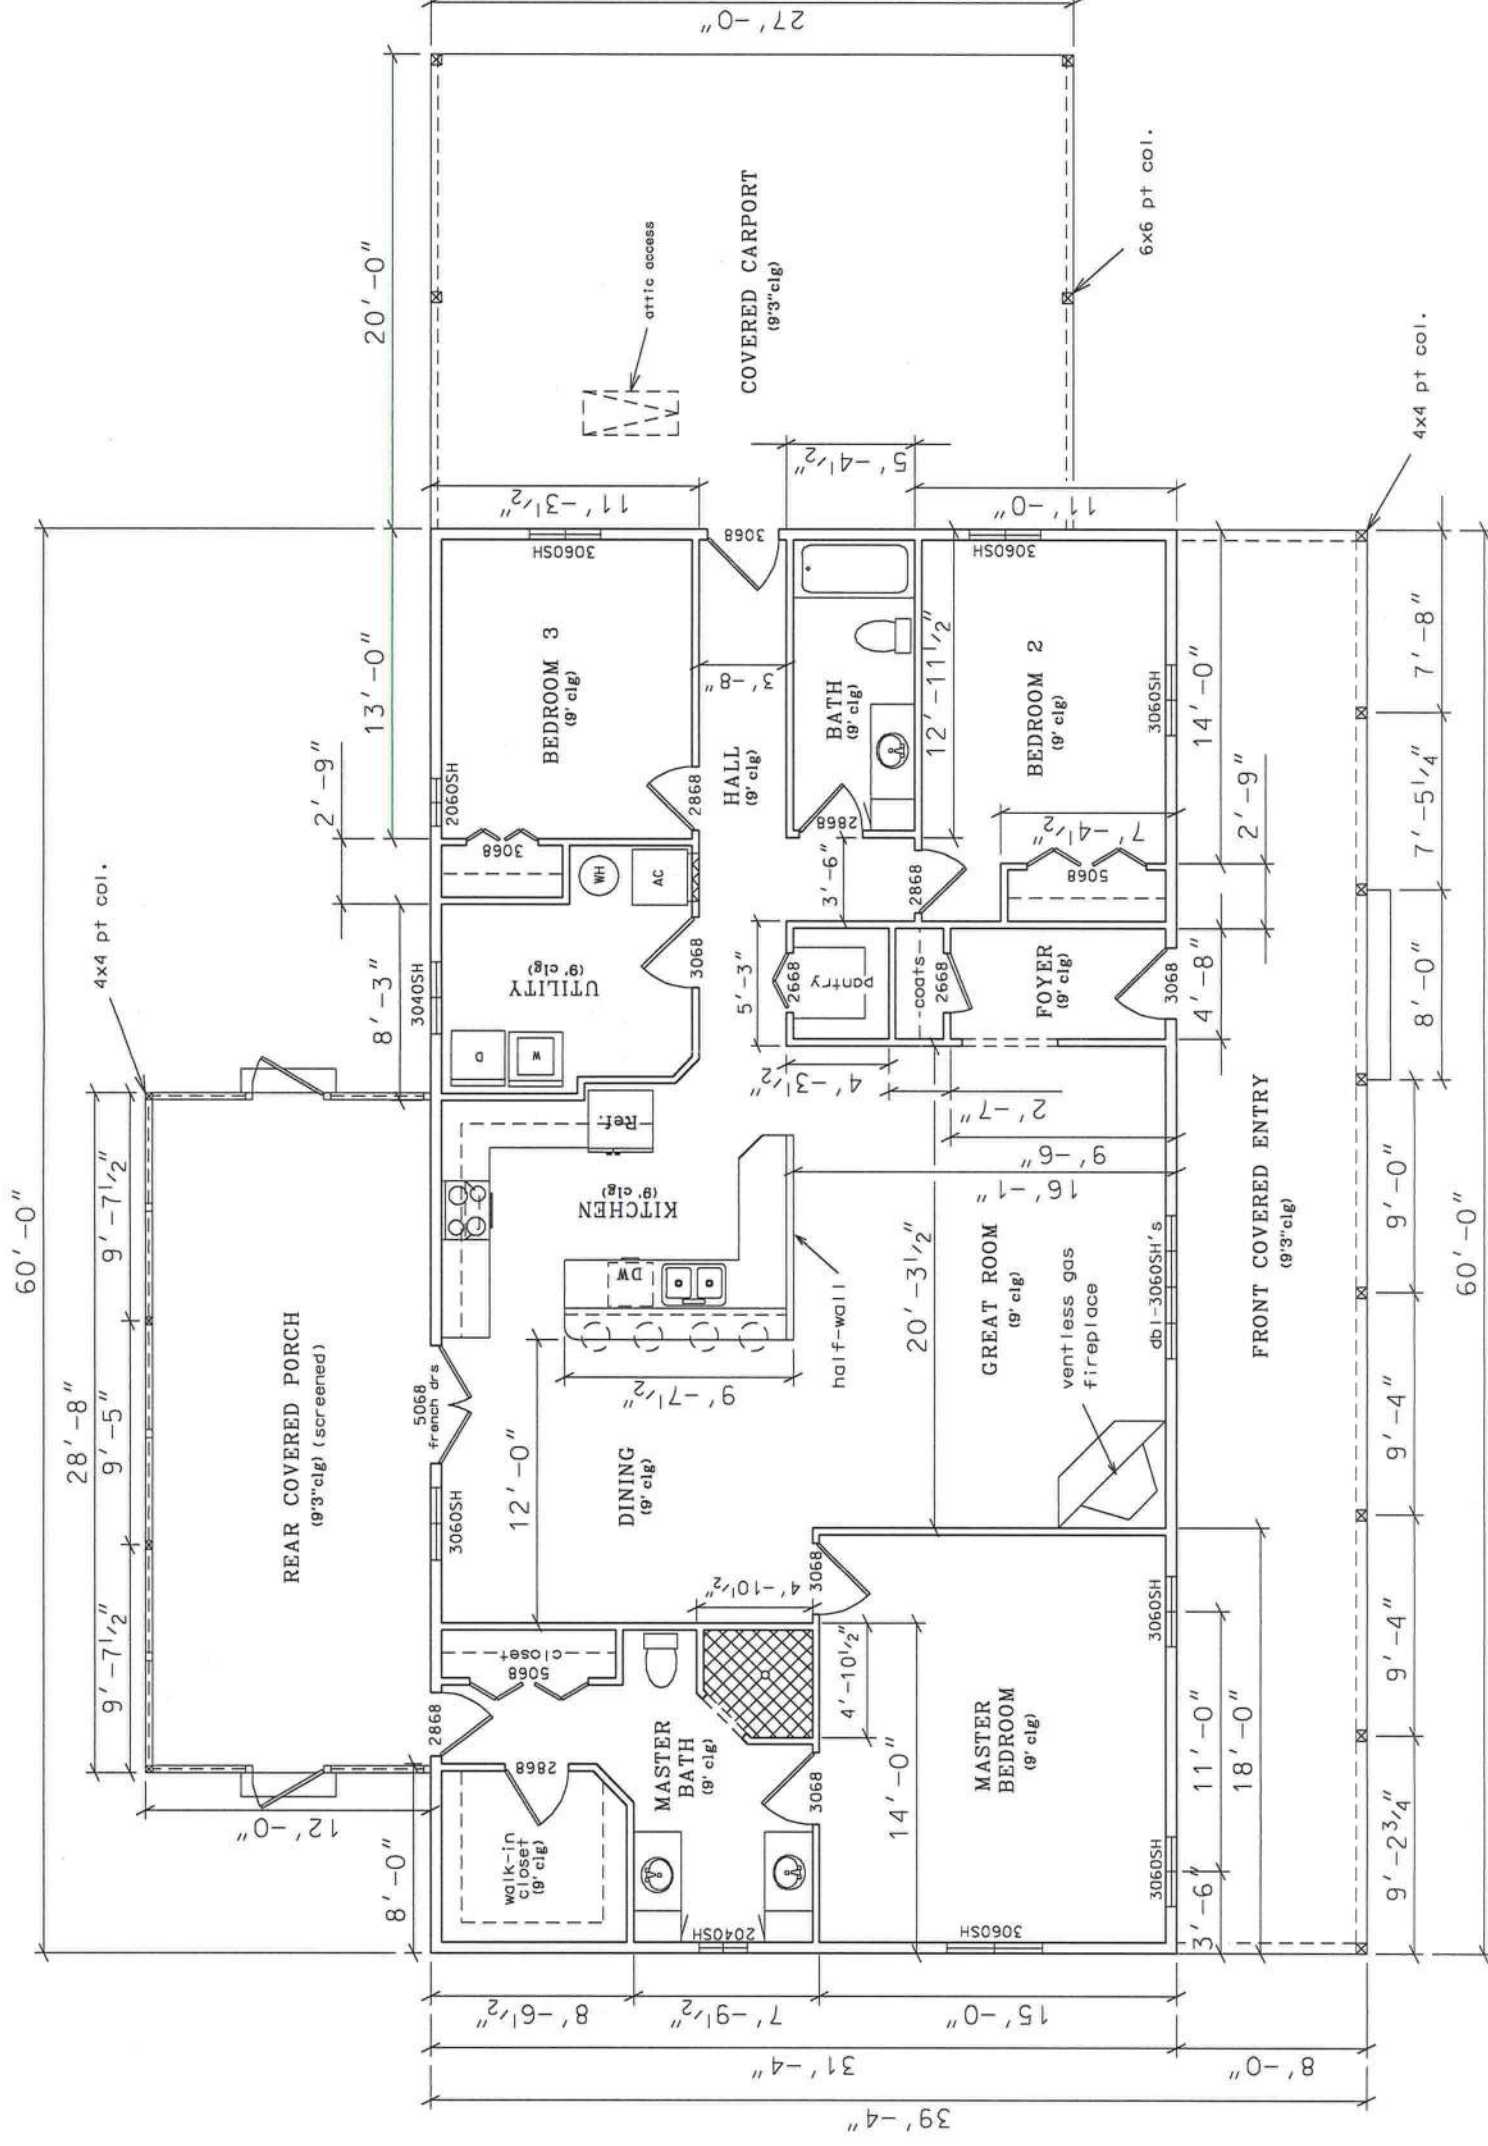

FLOOR PLAN

0 4' 8'
scale


LIVING AREA - 1880 sq. ft.
PORCHES - 824 sq. ft.
CARPORT - 540 sq. ft.





PLANS PREPARED BY:
MARTY J. HUMPHRIES P.E. # 51976
7932 240TH ST. • O'BRIEN, FL 32071

BEASLEY RESIDENCE PLANS
COLUMBIA COUNTY, FL


SHEET
3
OF
8

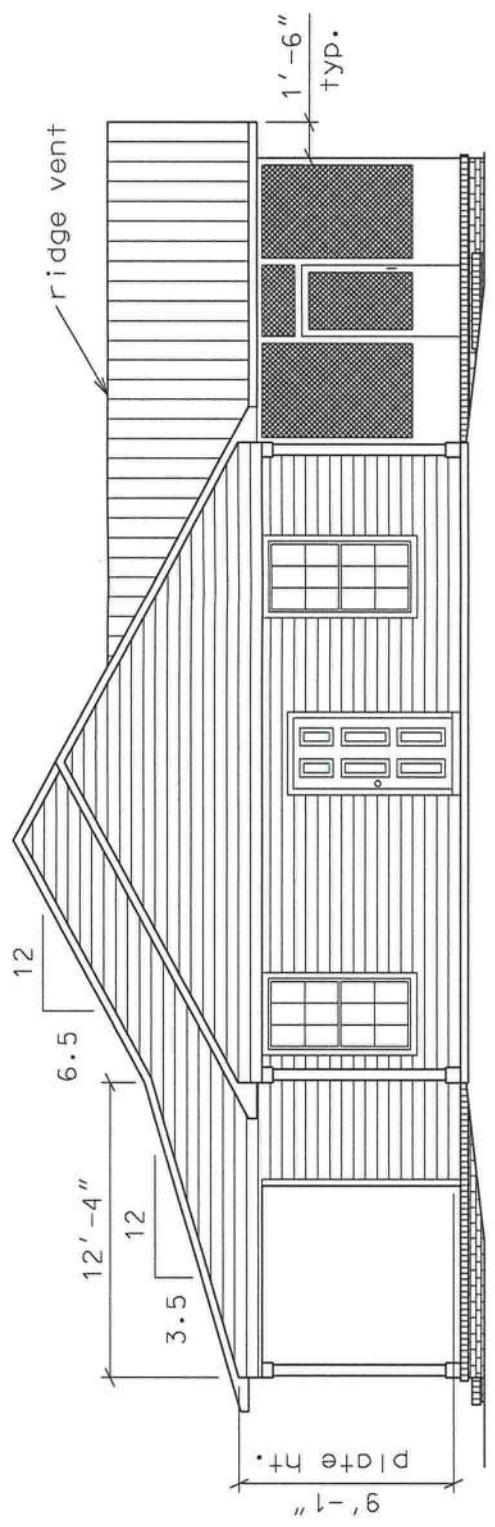

RIGHT ELEVATION

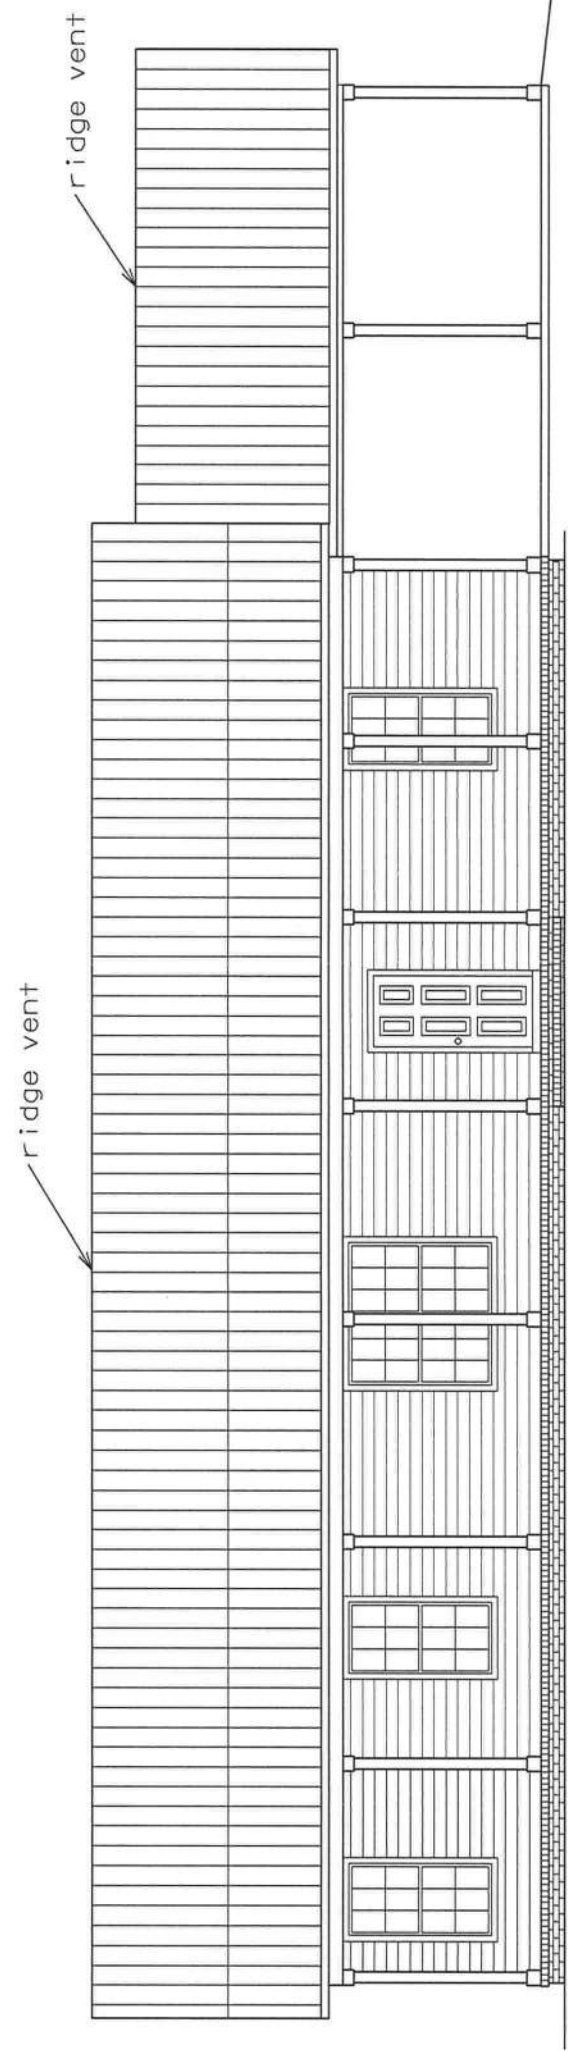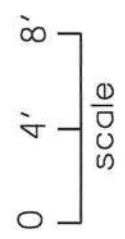

FRONT ELEVATION

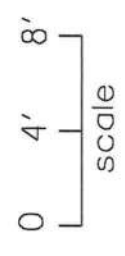


Marty J. Humphries
4-29-13



PLANS PREPARED BY:
MARTY J. HUMPHRIES P.E. # 51976
7932 240TH ST. • O'BRIEN, FL 32071


BEASLEY RESIDENCE PLANS
COLUMBIA COUNTY, FL

SHEET
4
OF
8

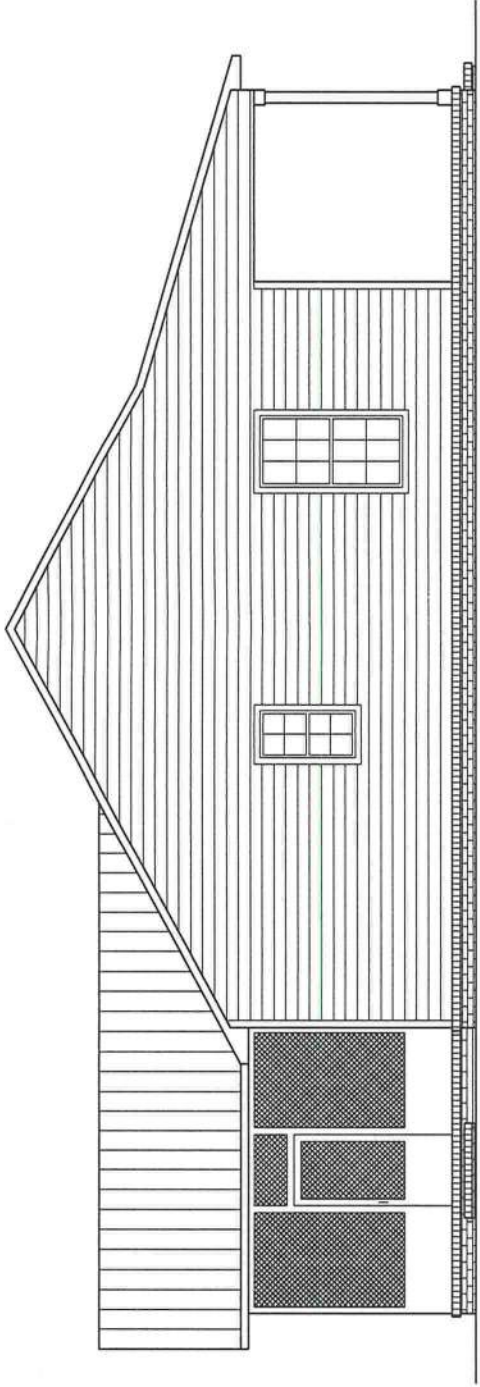

LEFT ELEVATION


0 4' 8'
scale

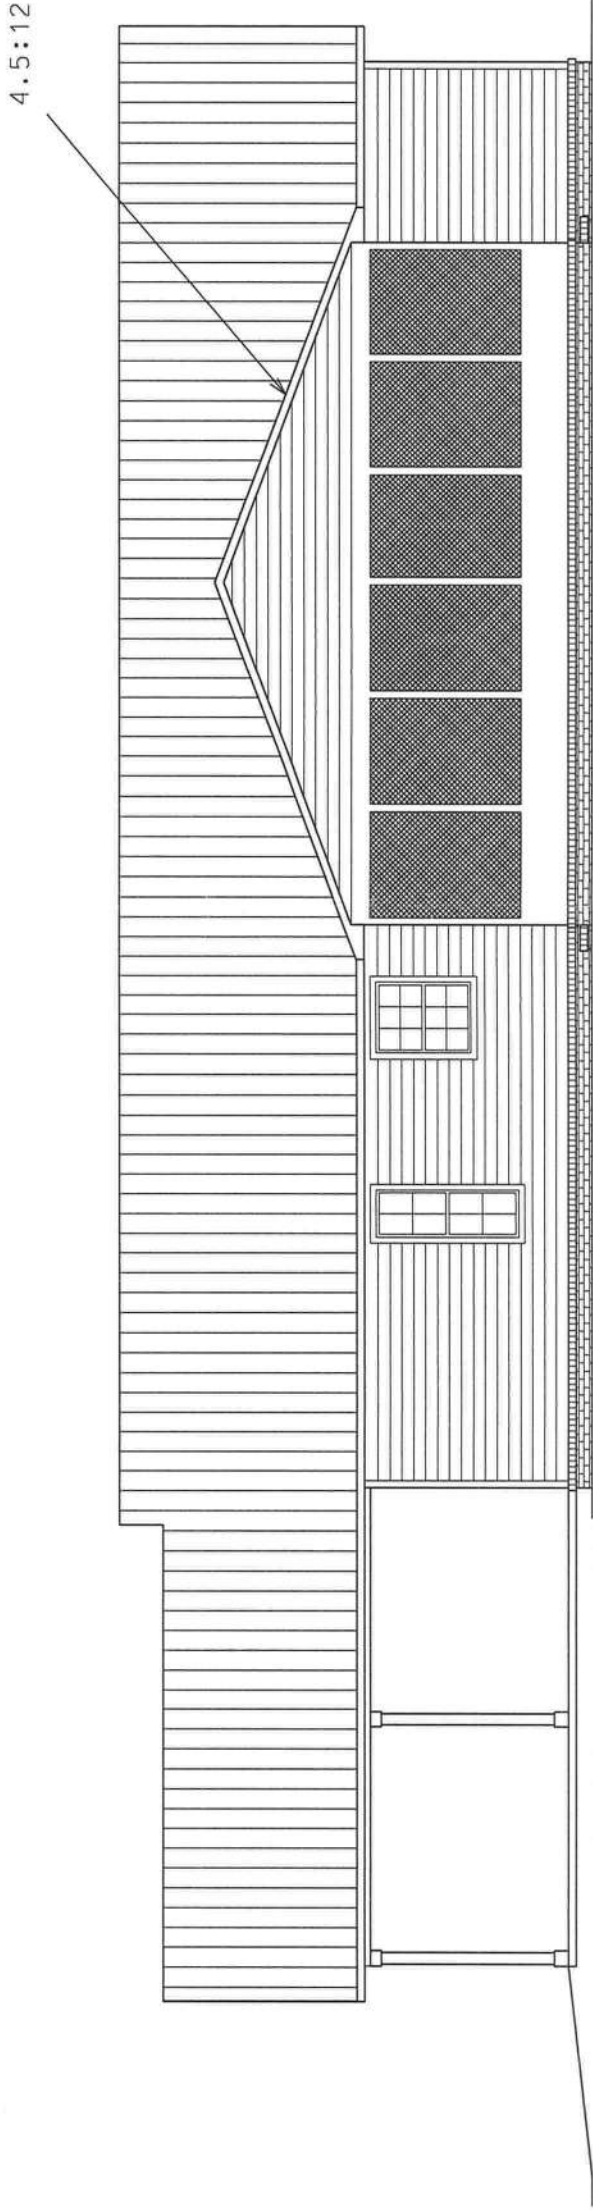

REAR ELEVATION


0 4' 8'
scale

M. J. Humphries
4-29-13

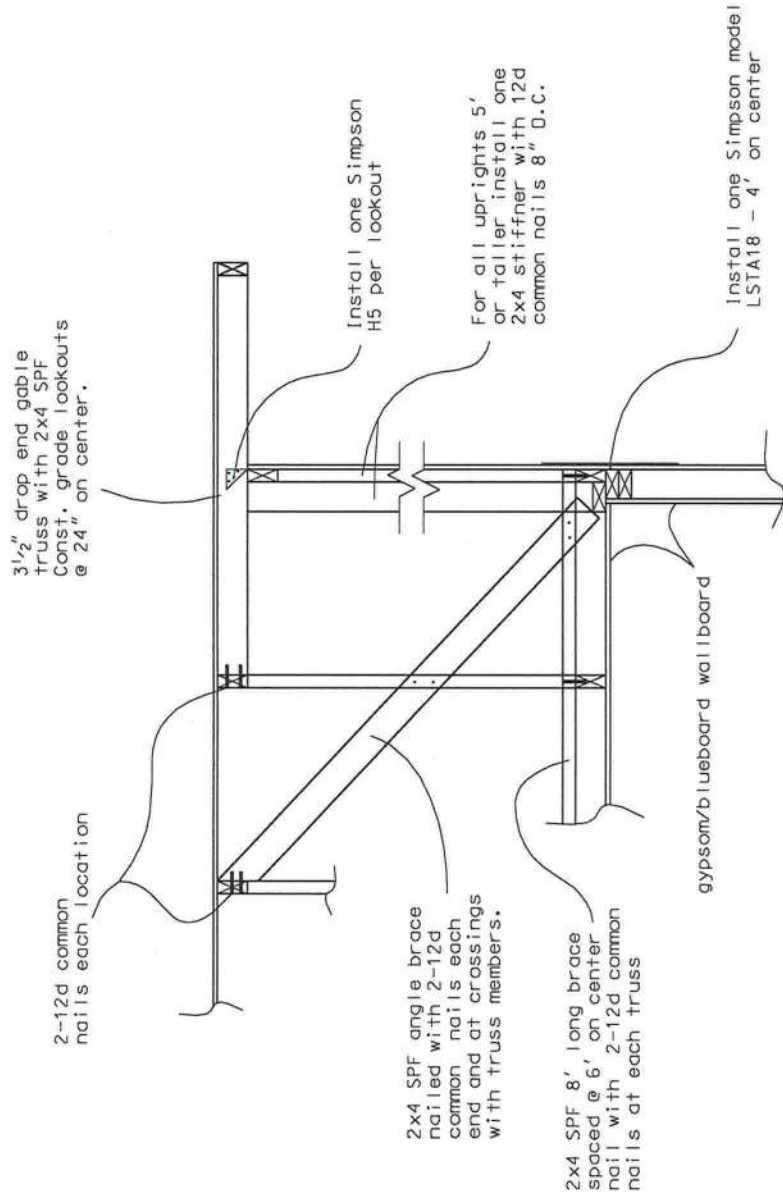


**GABLE END BRACING
DETAIL (N.T.S.)**

NOTE: Cable end trusses shall be dropped 3 1/2" for construction of lookouts & overhang.

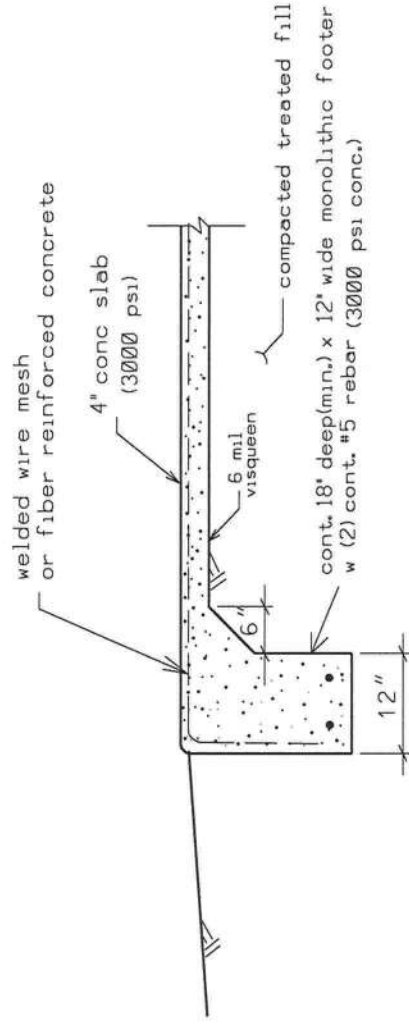

**DETAIL "C"
CARPORT FOUNDATION (N.T.S.)**

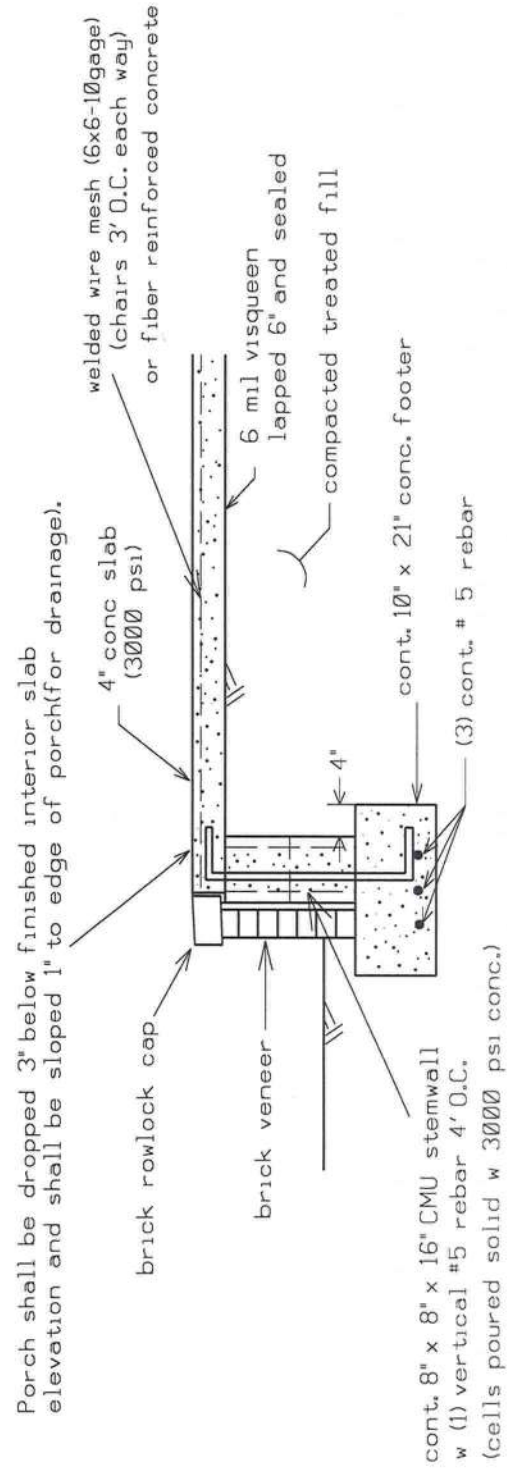

DETAIL B - PORCH FOUNDATION (N.T.S.)

My 2/2/21
4-29-13



PLANS PREPARED BY:
MARTY J. HUMPHRIES P.E., # 51976
7932 240TH ST., O'BRIEN, FL 32071

BEASLEY RESIDENCE PLANS
COLUMBIA COUNTY, FL

SHEET
6 OF 8



PLANS PREPARED BY:
MARTY J. HUMPHRIES P.E. # 51976
7932 240TH ST., O'BRIEN, FL 32071

BEASLEY RESIDENCE PLANS
COLUMBIA COUNTY, FL

SHEET
8 OF
8

Marty J. Humphries
4-29-13

ELECTRICAL LEGEND

-  - CEILING FAN w LIGHTS
-  - LIGHT FIXTURE
-  - RECESSED CAN LIGHT FIXTURE
-  - SINGLE POLE SWITCH
-  - THREE-WAY SWITCH
-  - DIMMER SWITCH
-  - THREE-WAY DIMMER SWITCH
-  - RECEPT.
-  - GFI RECEPT OR PART OF A GFI CIRCUIT.
-  - SECURITY LIGHT
-  - EXHAUST WITH LIGHT
-  - 220 V.
-  - SMOKE DETECTOR (AC/DC and interconnected)
-  - SMOKE & CARBON MONOXID DETECTOR (AC/DC and interconnected)
-  - COAX & TELEPHONE
-  - TELEPHONE

NOTES:

- 1.) ALL EXTERIOR RECEPTACLES SHALL BE WEATHERPROOF.
- 2.) ALL RECPTS NOT A GFI OR PART OF A GFI CIRCUIT SHALL BE PART OF AN AFCI CIRCUIT.
- 3.) PLACE 4 LIGHTS IN HOME ATTIC AREA WITH SWITCH NEAR ATTIC ACCESS.

ELECTRICAL PLAN

