




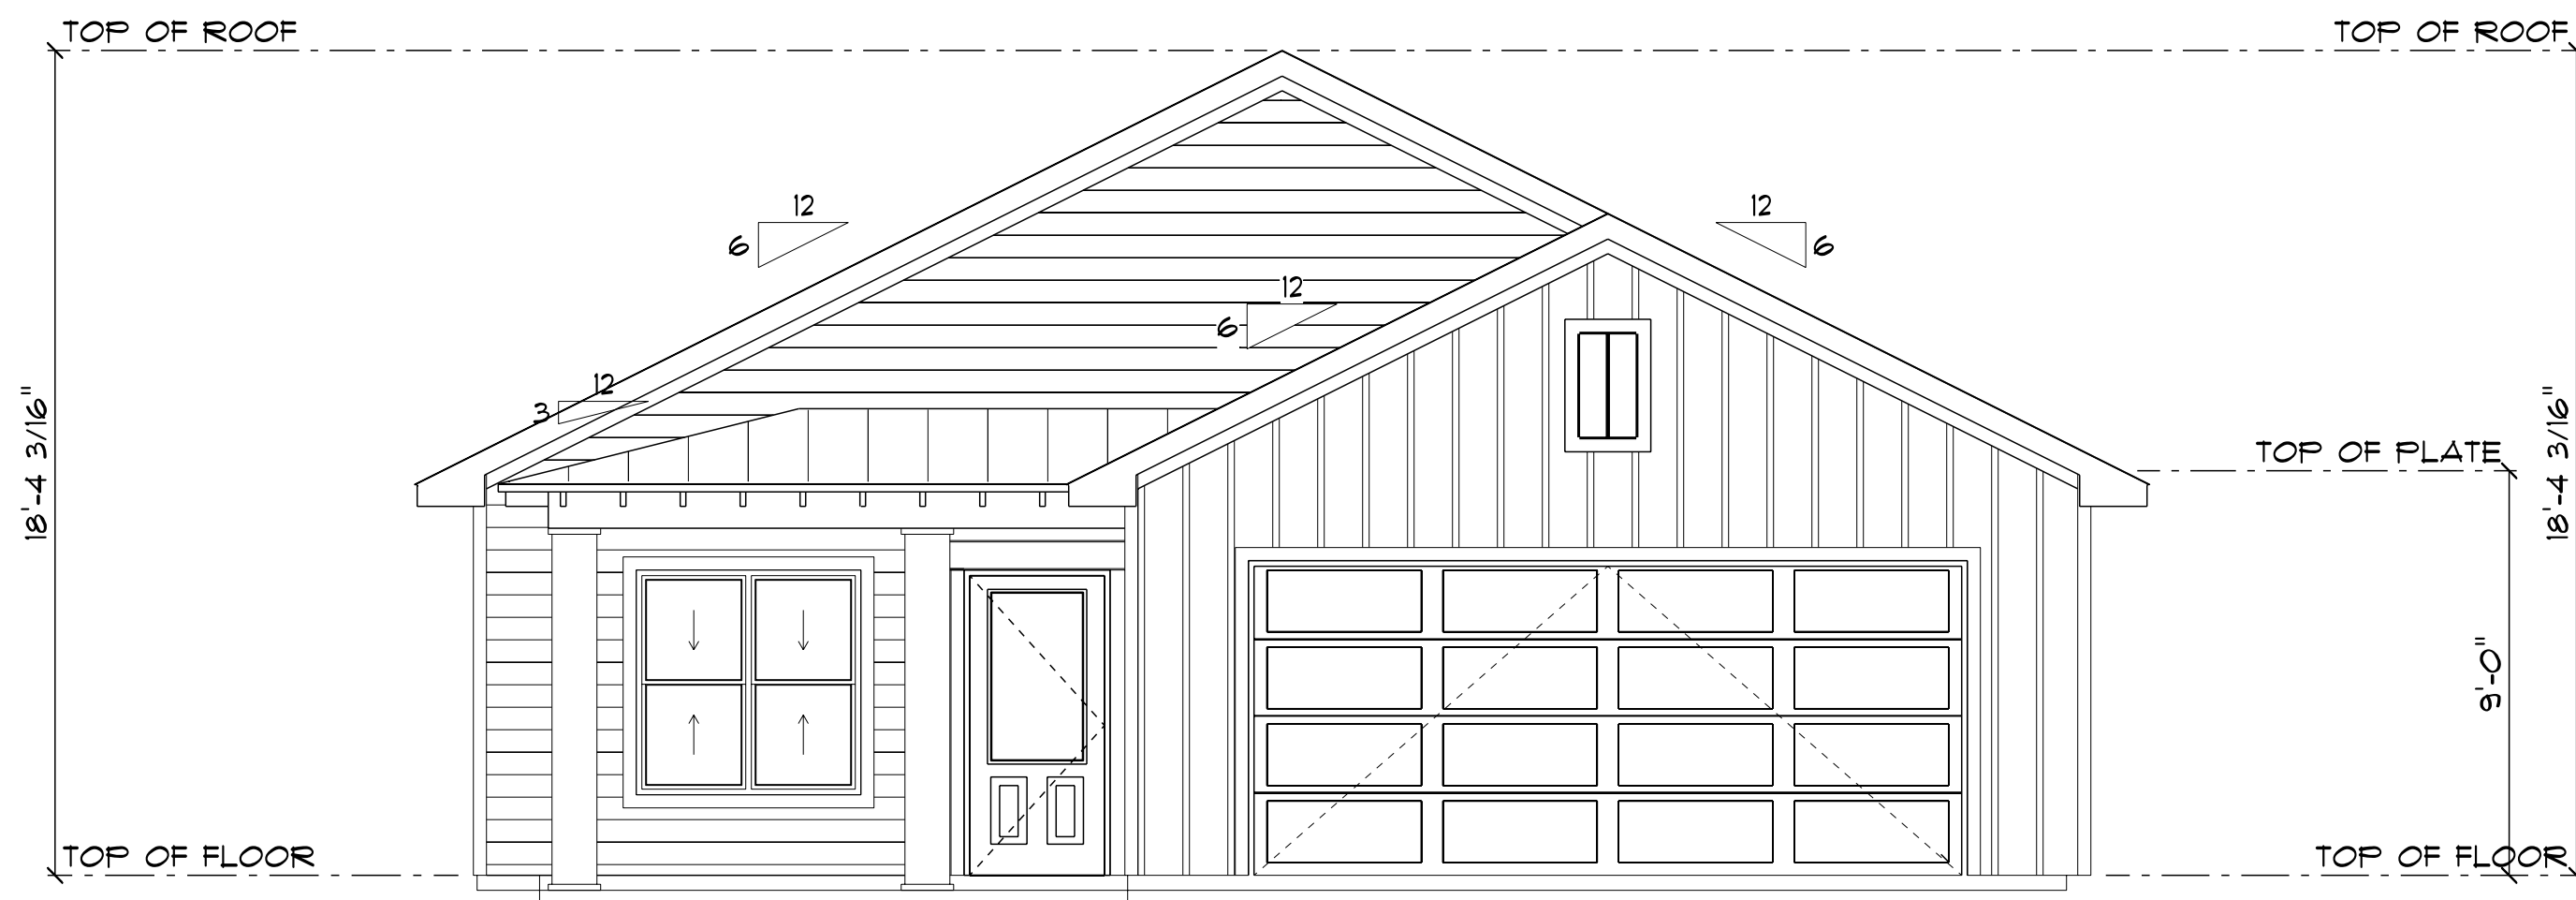


FRONT ELEVATION
SCALE: 1/4" = 1'-0"

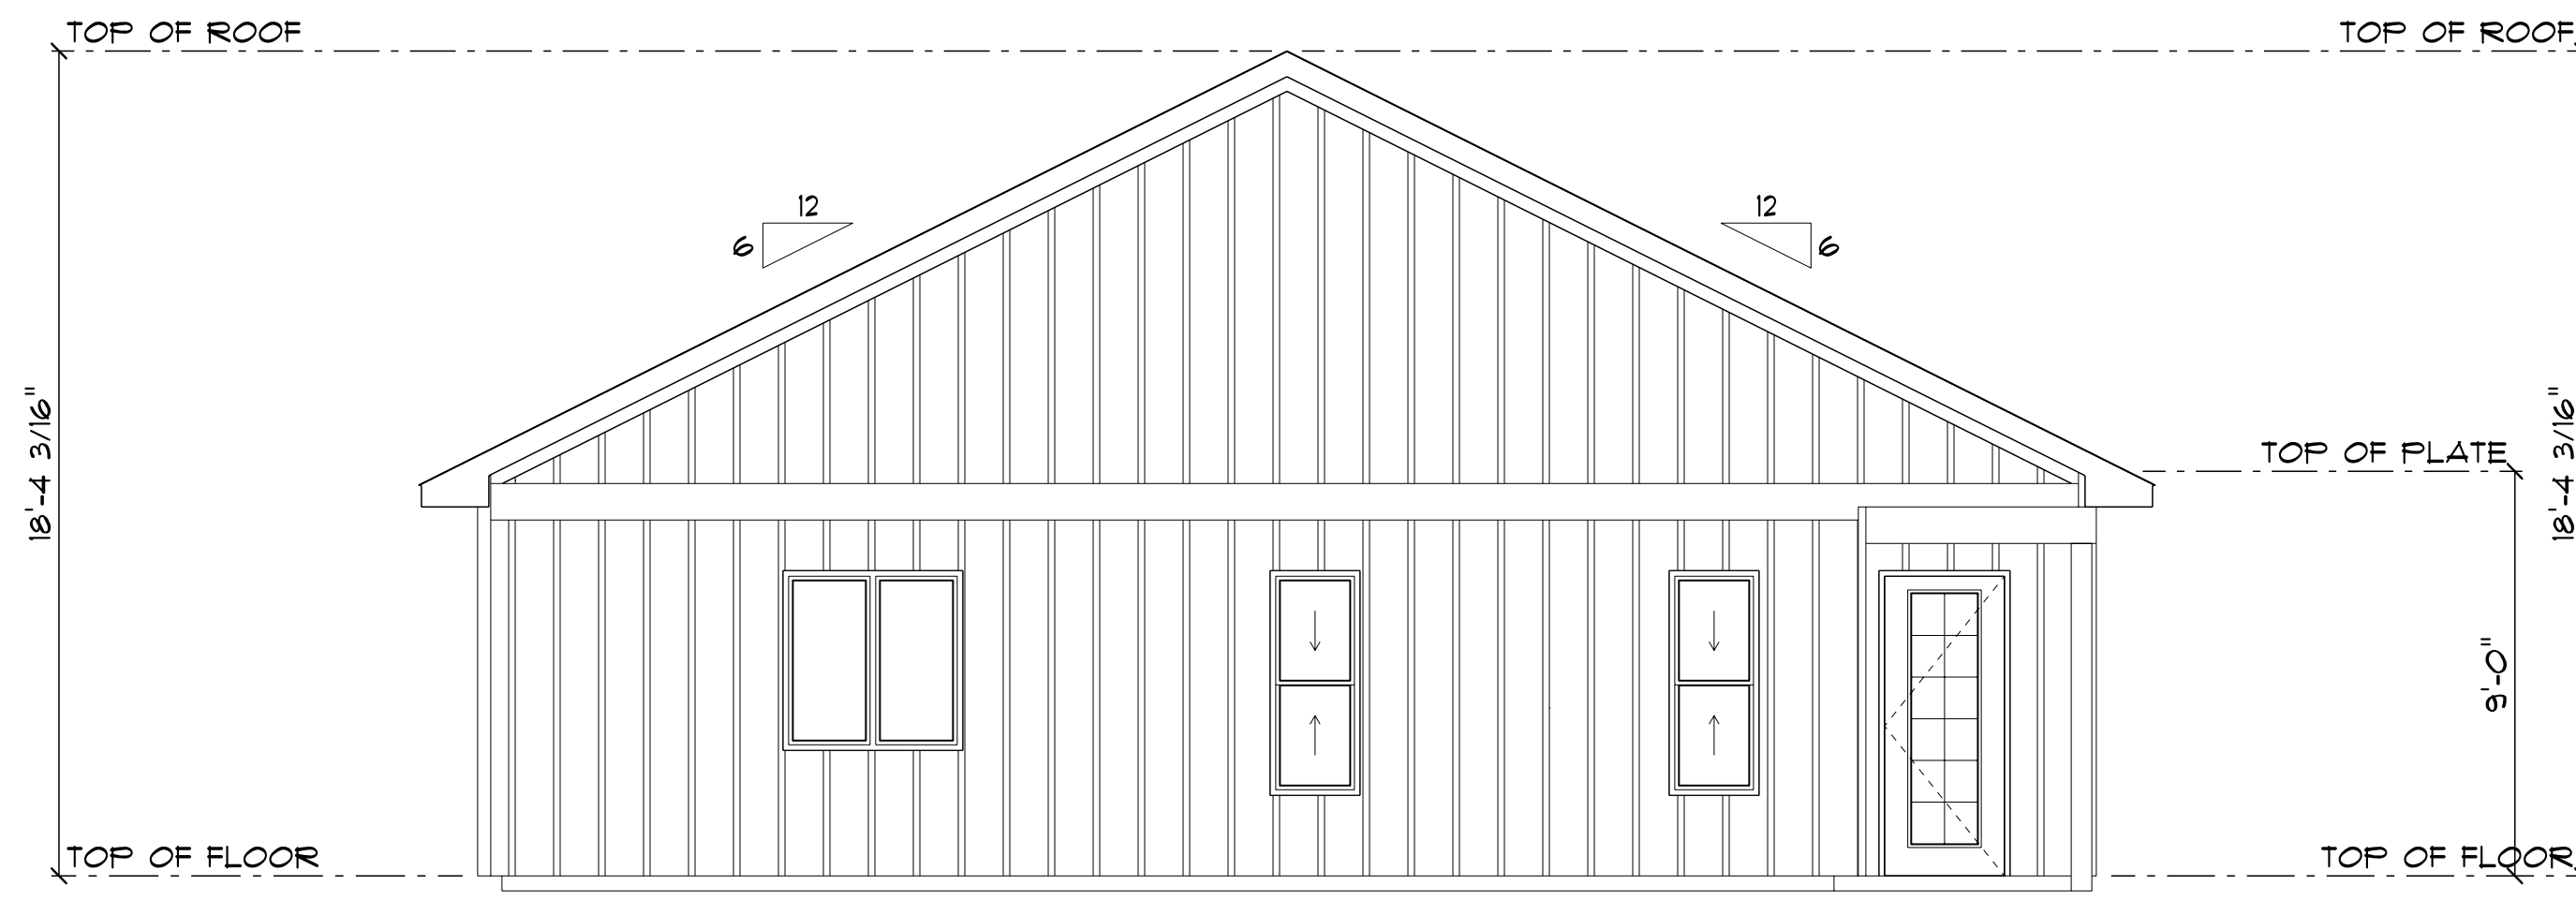


REAR ELEVATION
SCALE: 1/4" = 1'-0"

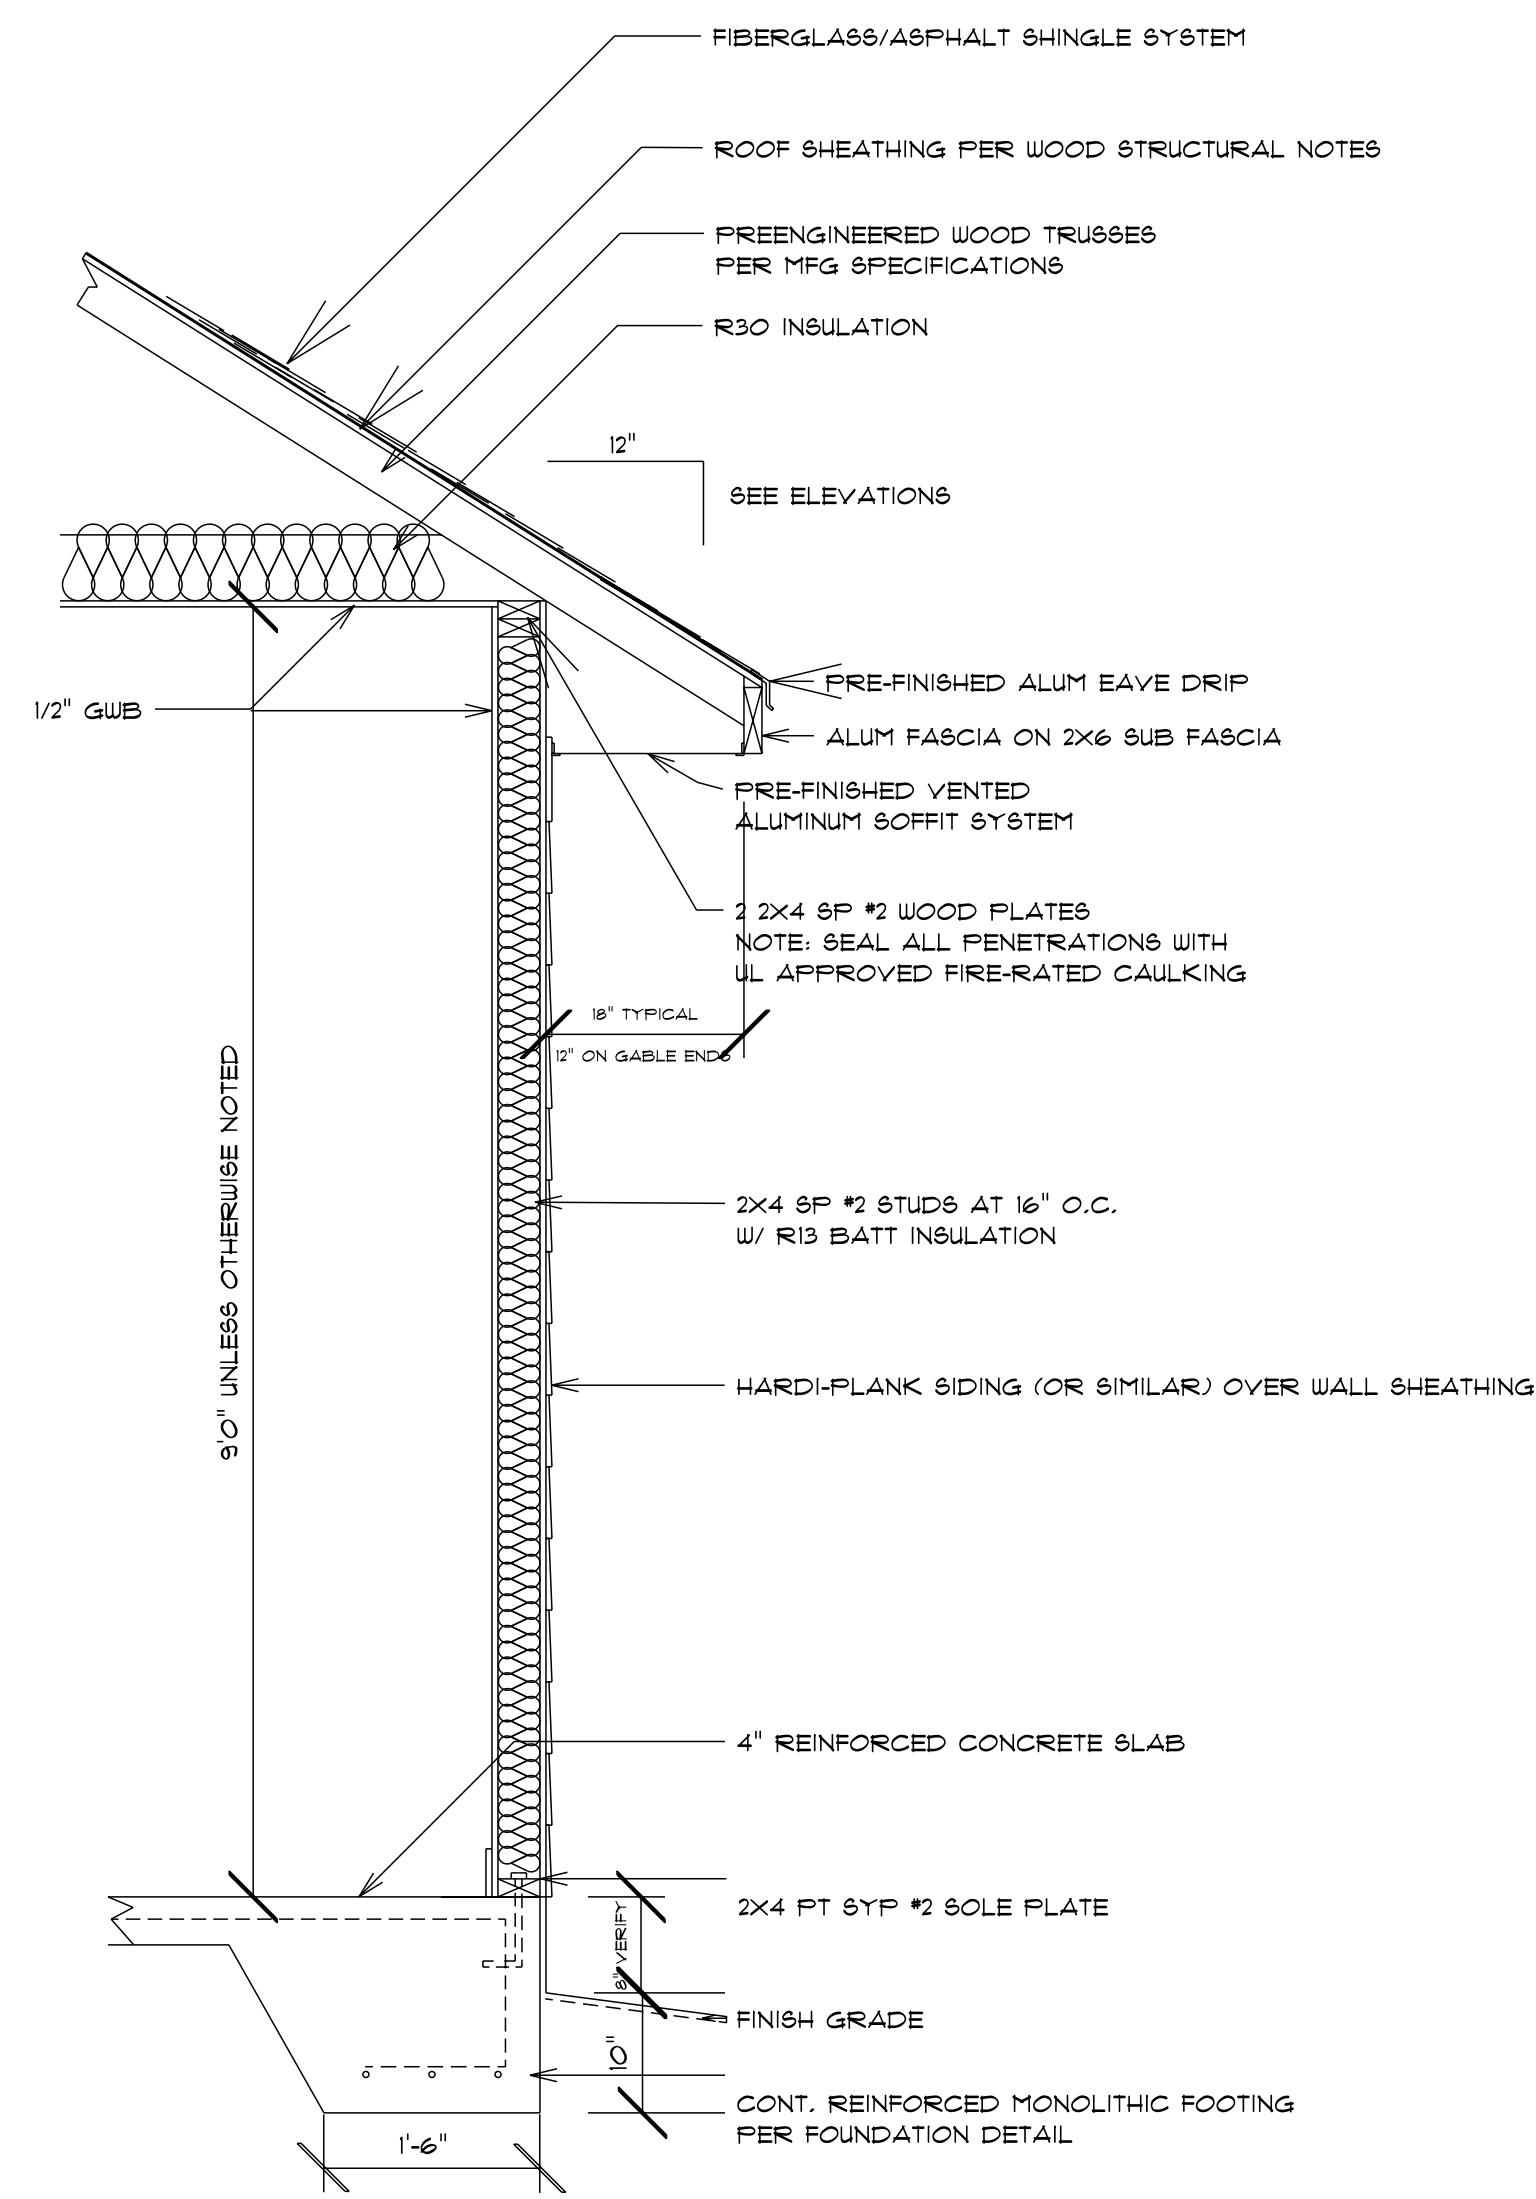

TYPICAL WALL SECTION
SCALE: 3/4" = 1'-0"

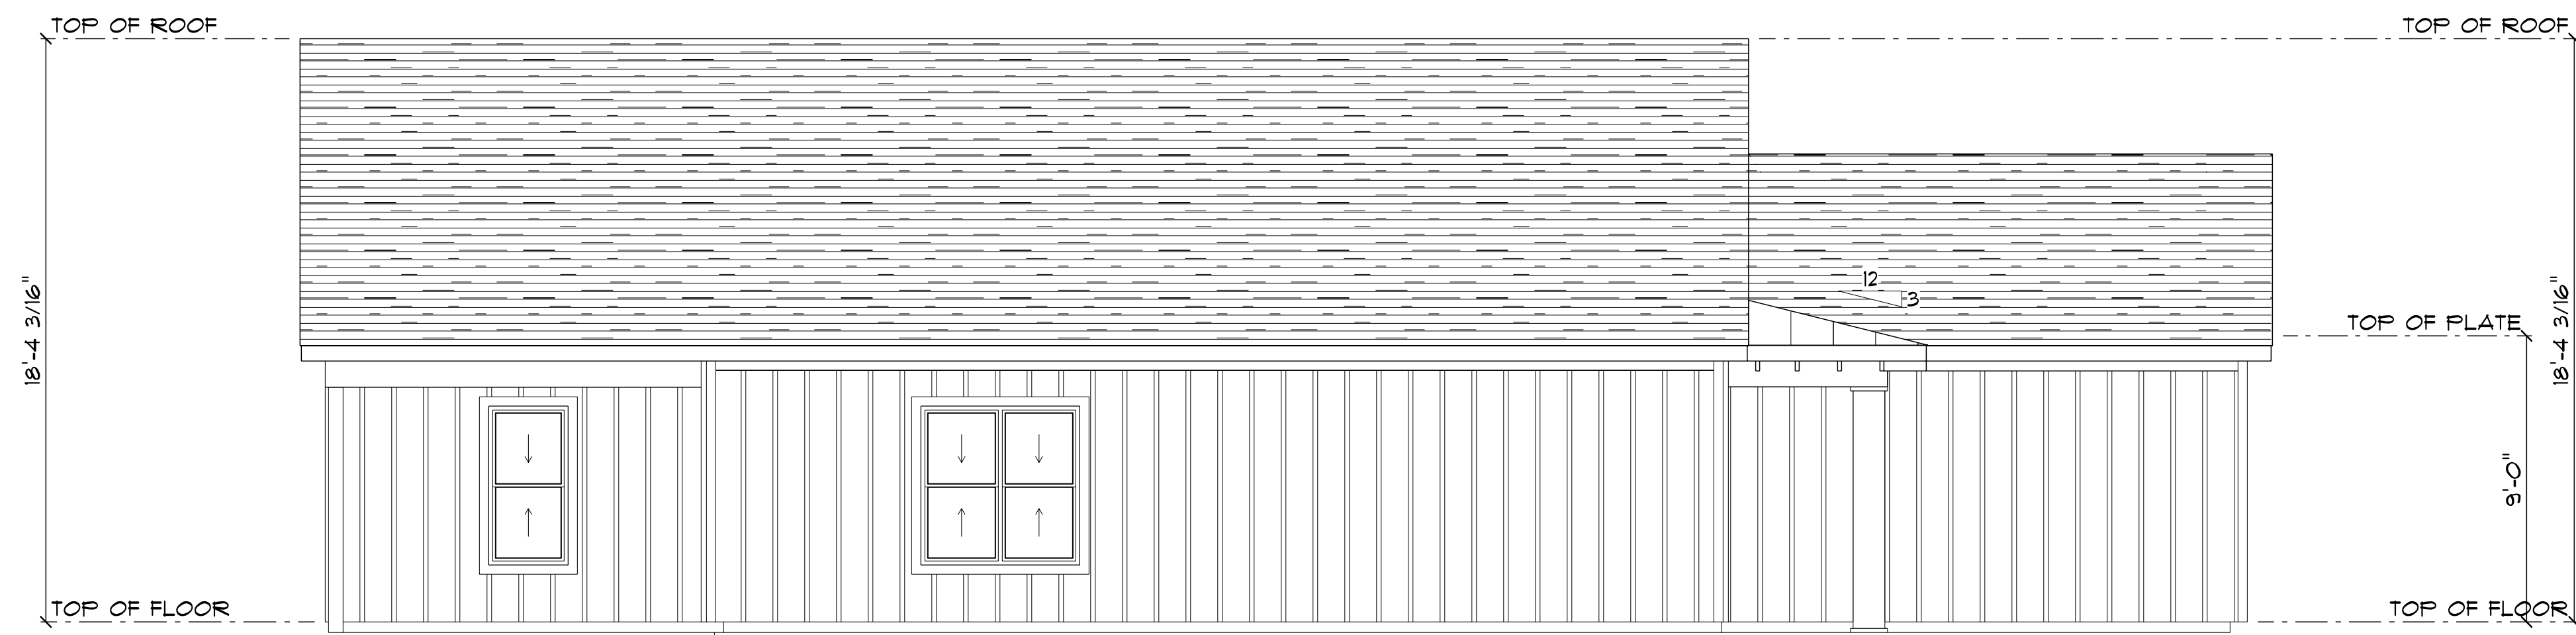

LEFT ELEVATION
SCALE: 1/4" = 1'-0"

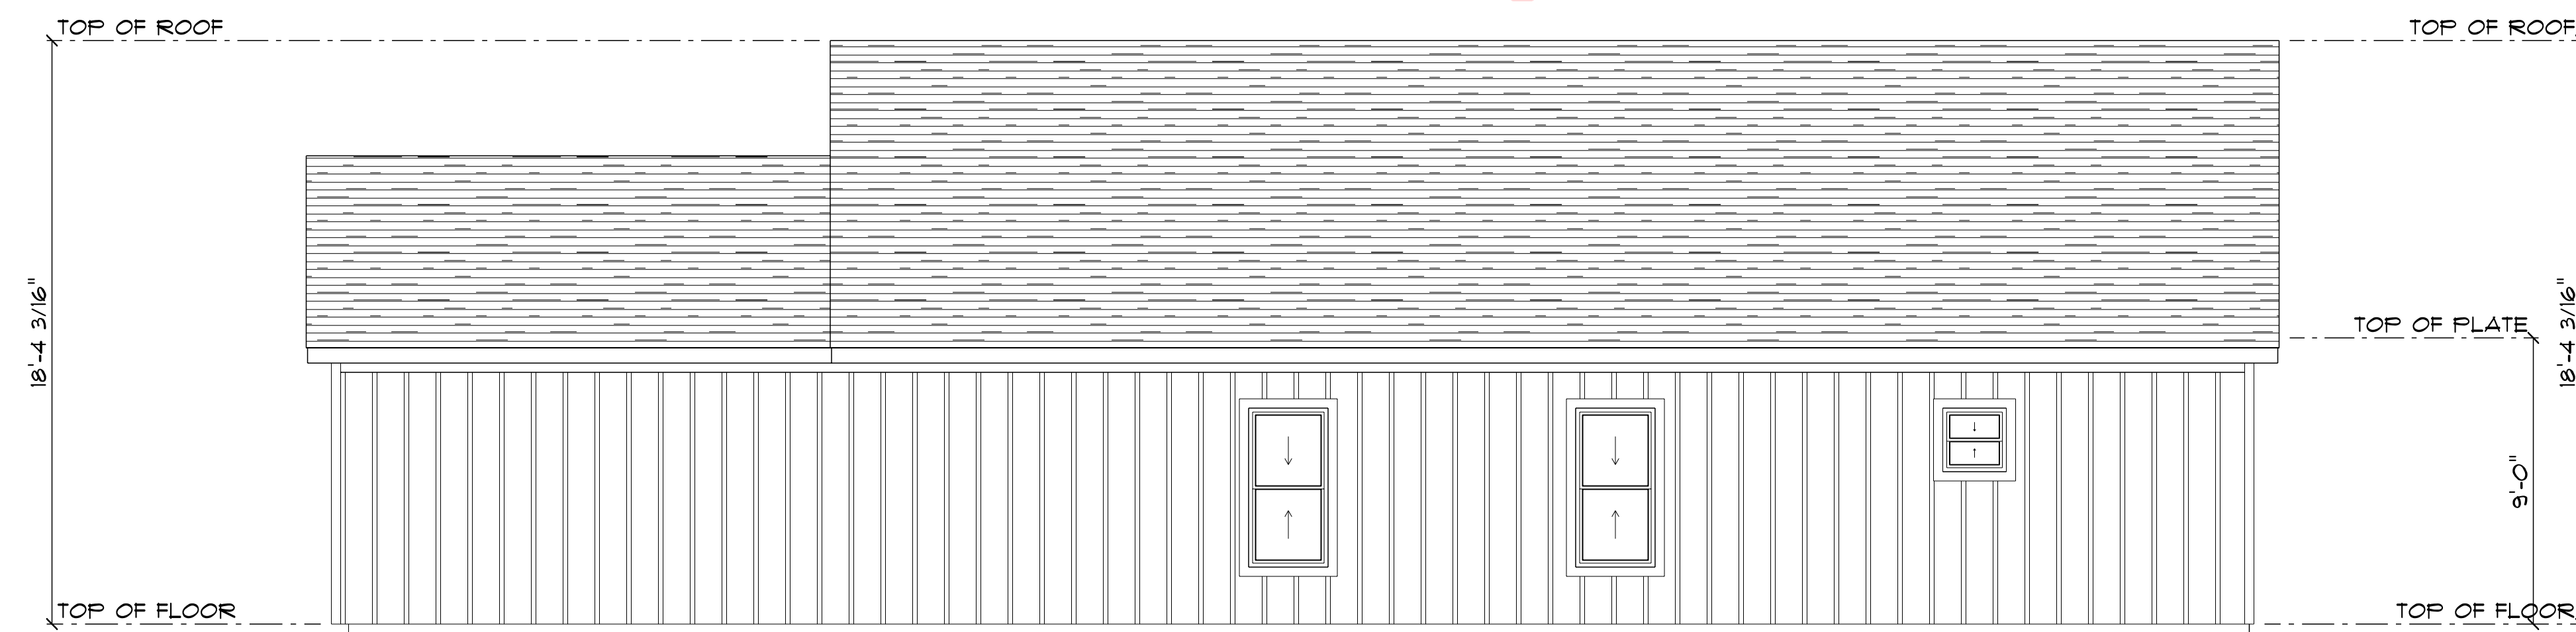



RIGHT ELEVATION
SCALE: 1/4" = 1'-0"

Digitally signed by BARRETT C CROOK
DN: c=US, o=North Carolina,
dnQualifier=A01410D00000180F676140B000077E0,
cn=BARRETT C CROOK
Date: 2023.04.10 16:41:47 -04'00'



ELECTRICAL LEGEND		
ELECTRICAL	COUNT	SYMBOL
can light 4inch	4	○
pot light	8	○
spotlight double	5	○
cable tv outlet	4	TV
light	18	○
outlet	36	○
outlet gfi	8	○GFI
switch	30	⚡
vanity bar light 02	3	○
outlet 220v	5	⚡
electrical panel	1	⚡
smoke detector	4	⚡
ceiling light vent square	2	□

ELECTRICAL FLOORPLAN - ELECTRICAL
SCALE: 1/4" = 1'-0"

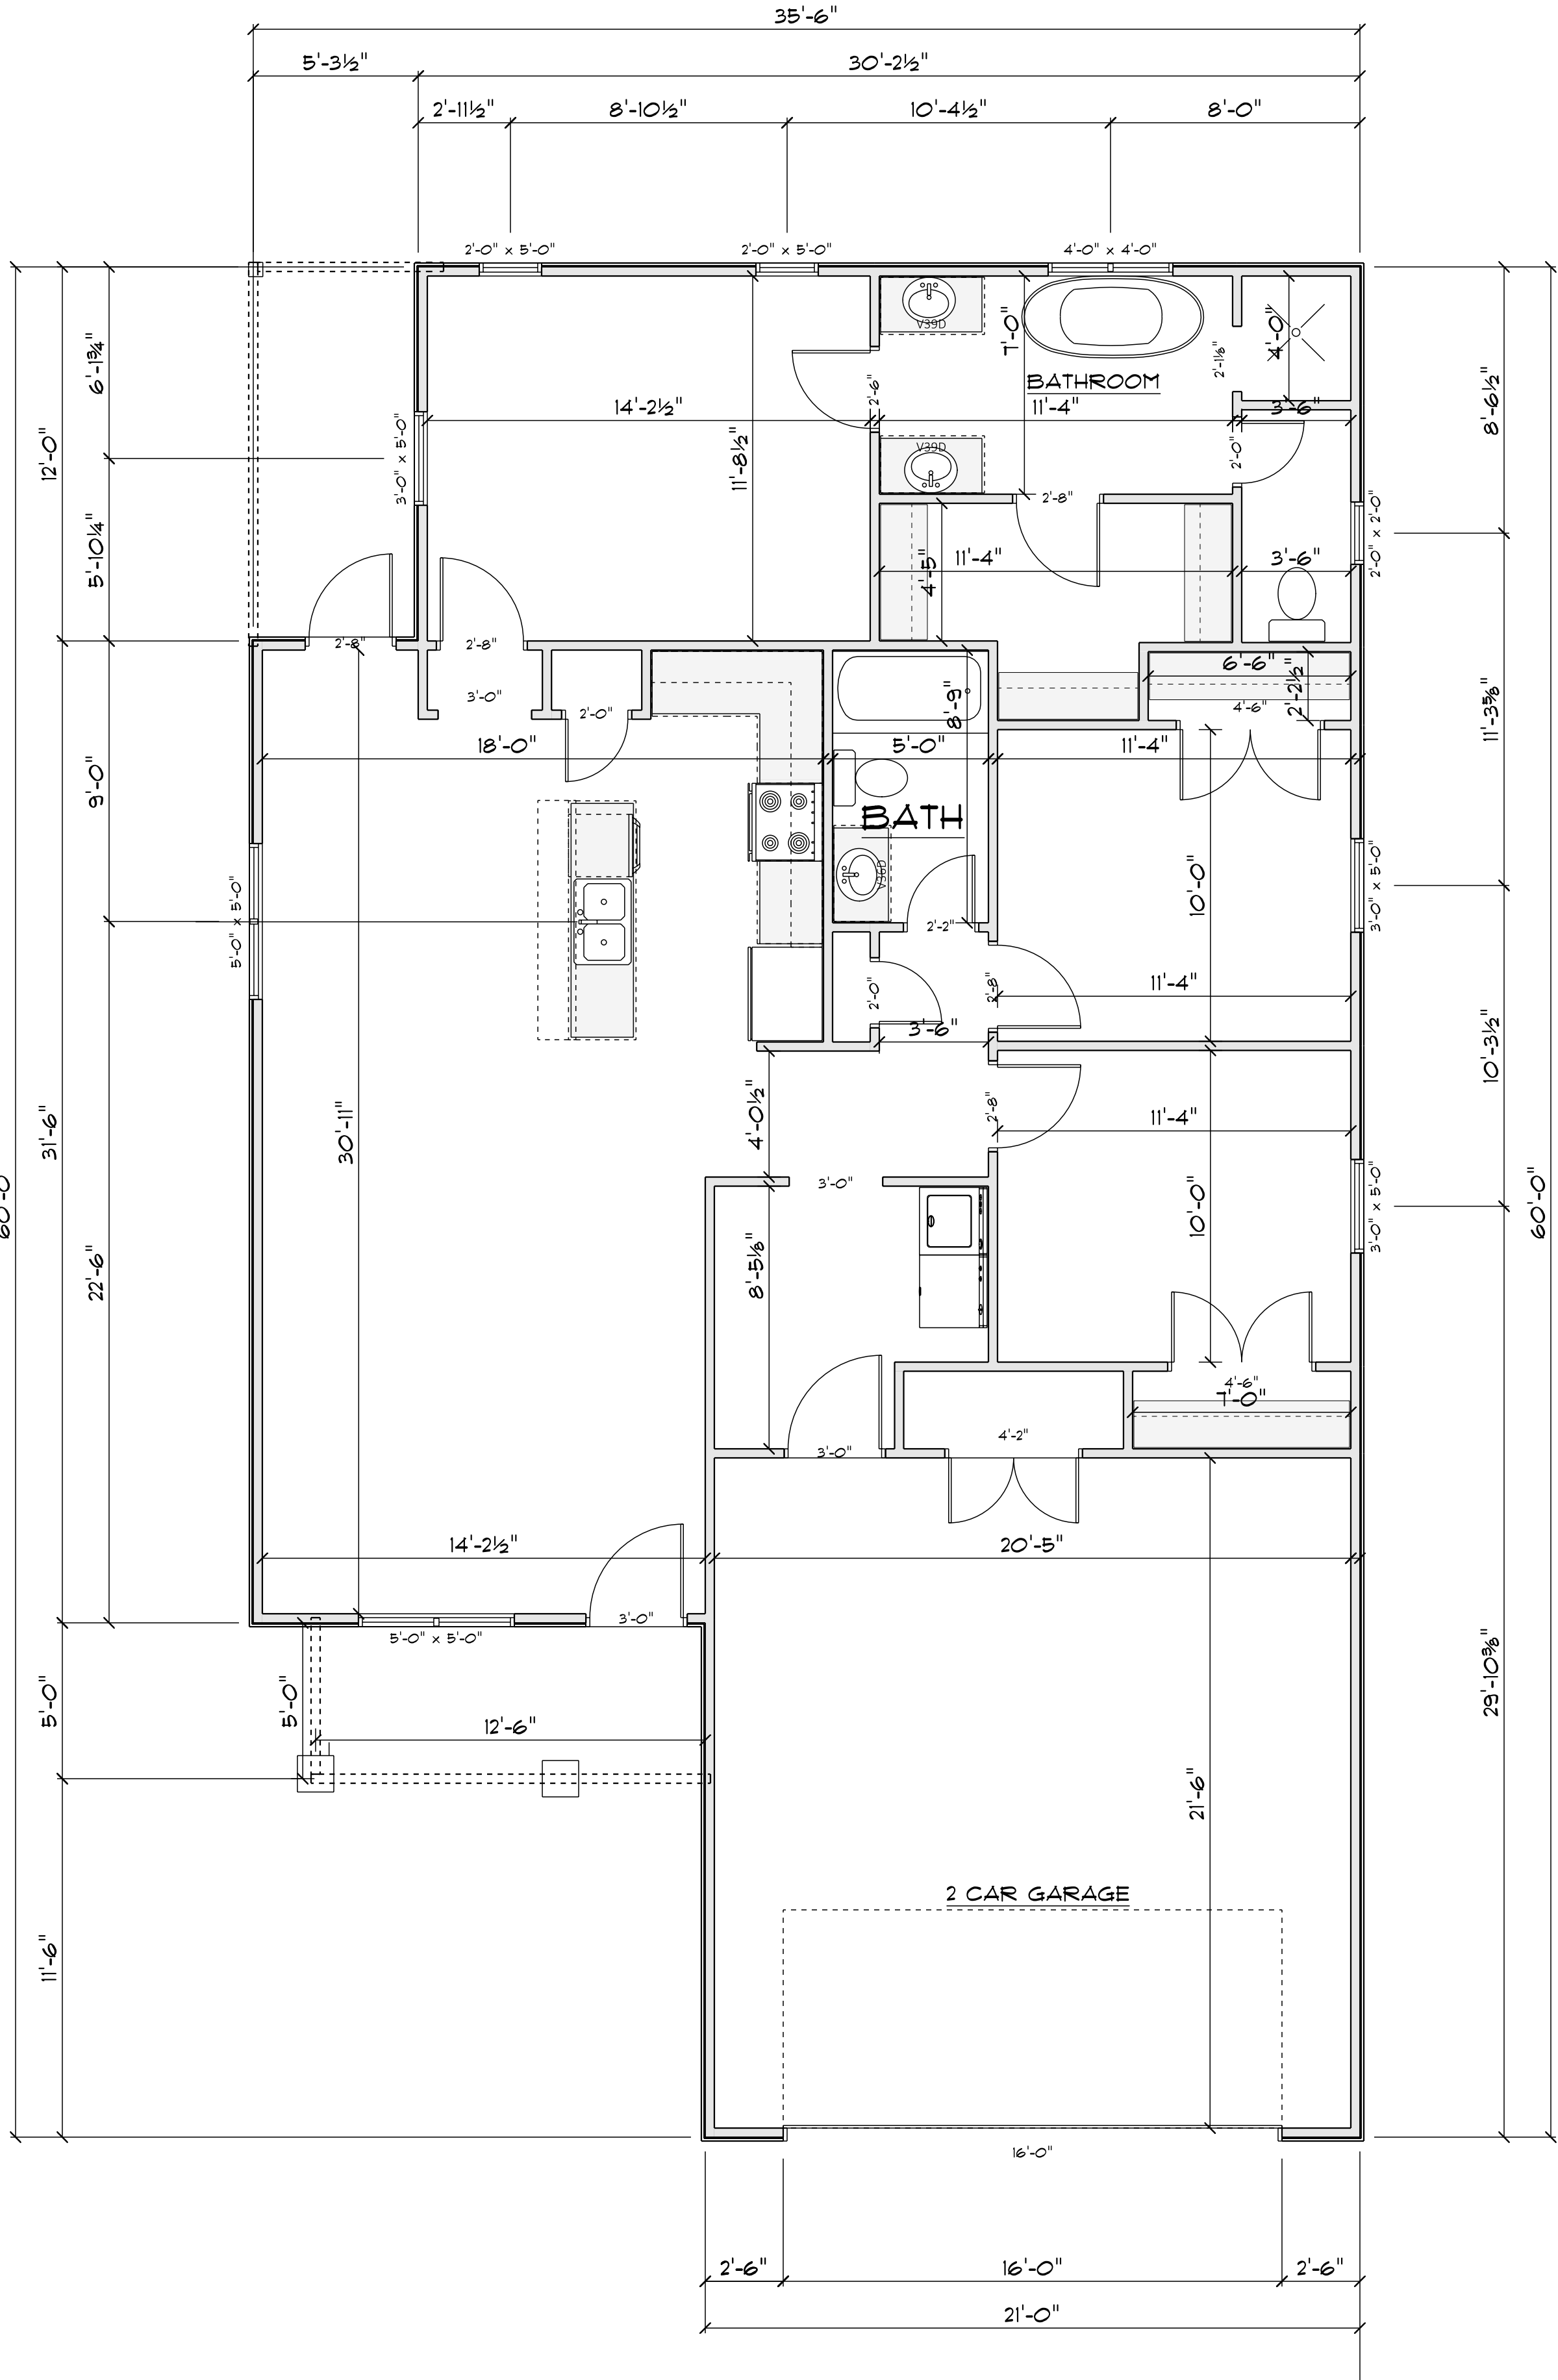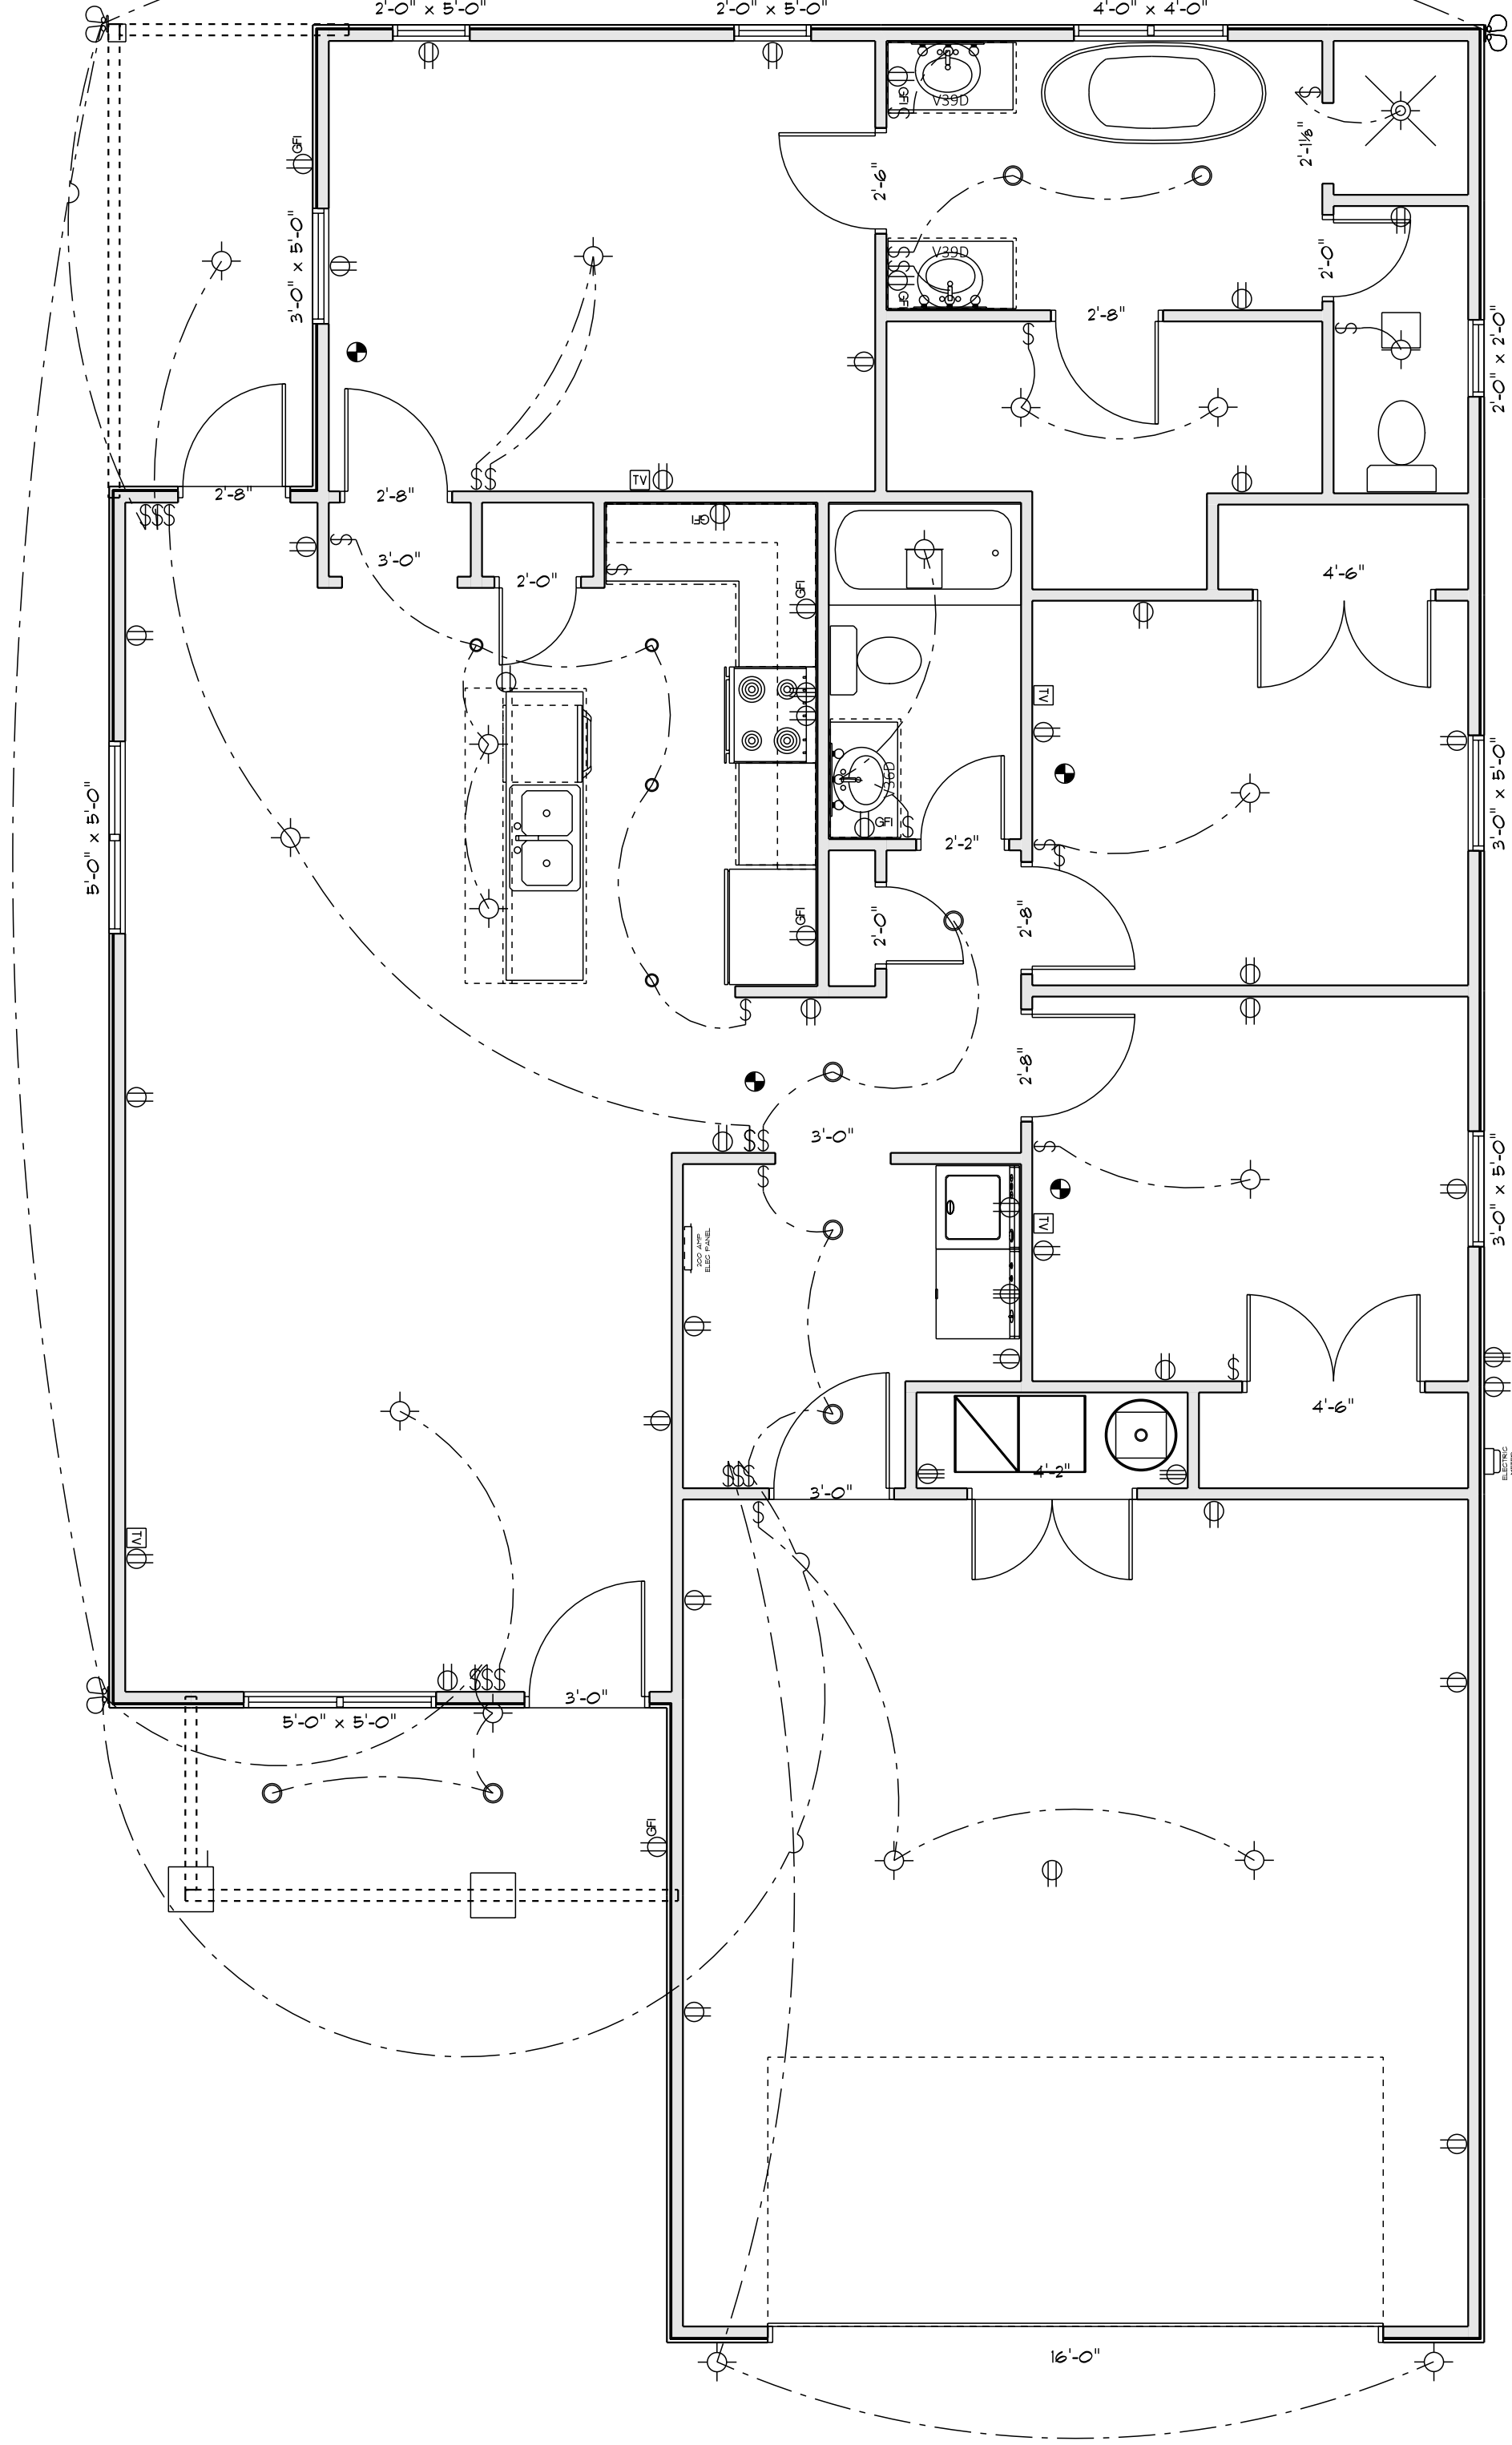

MAIN FLOOR
SCALE: 1/4" = 1'-0"

AREA SUMMARY



NAME	AREA
Living Area	1389 sq ft.
Covered Porch	128 sq ft.
Garage	465 sq ft.
Total Area	1987 sq ft.
Total	3970 sq ft.




Digitally signed by BARRETT C CROOK
DN: c=US, o=North Carolina,
dnQualifier=A01410D00000180F6761
40B000077E0, cn=BARRETT C CROOK
Date: 2023.04.10 16:42:26 -04'00'



ROOFING METALS FOR FLASHING / ROOFING MIN THICKNESS REQ.			
MATERIAL	MINIMUM THICKNESS (IN.)	GAGE	WEIGHT (OZ.)
COPPER	N/A	N/A	16
ALUMINUM	0.024	N/A	N/A
STAINLESS STEEL	N/A	28	N/A
GALVANIZED STEEL	0.0179	26 (ZINC G90)	N/A
ZINC ALLOY LEAD PAINTED TERNE	0.027	N/A	40 / 20

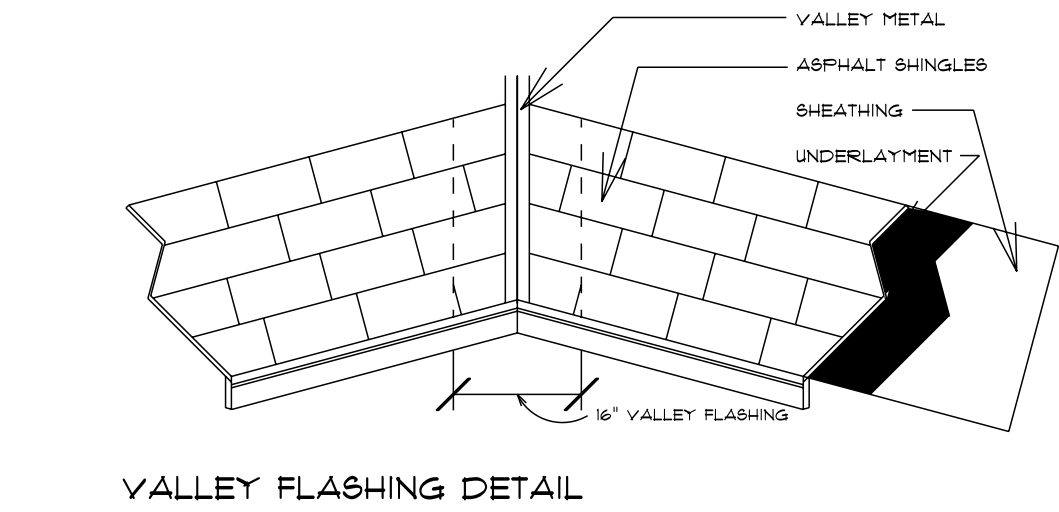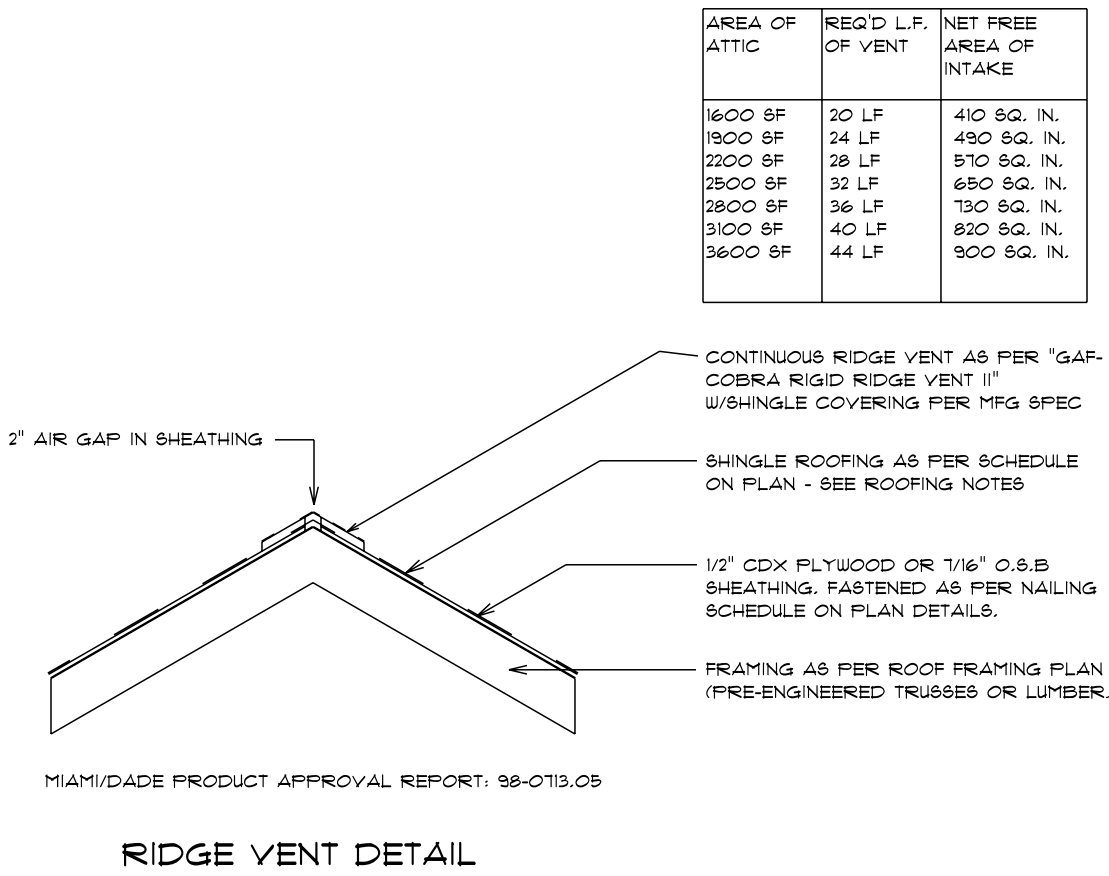

Roof Sections
SCALE: NOT TO SCALE

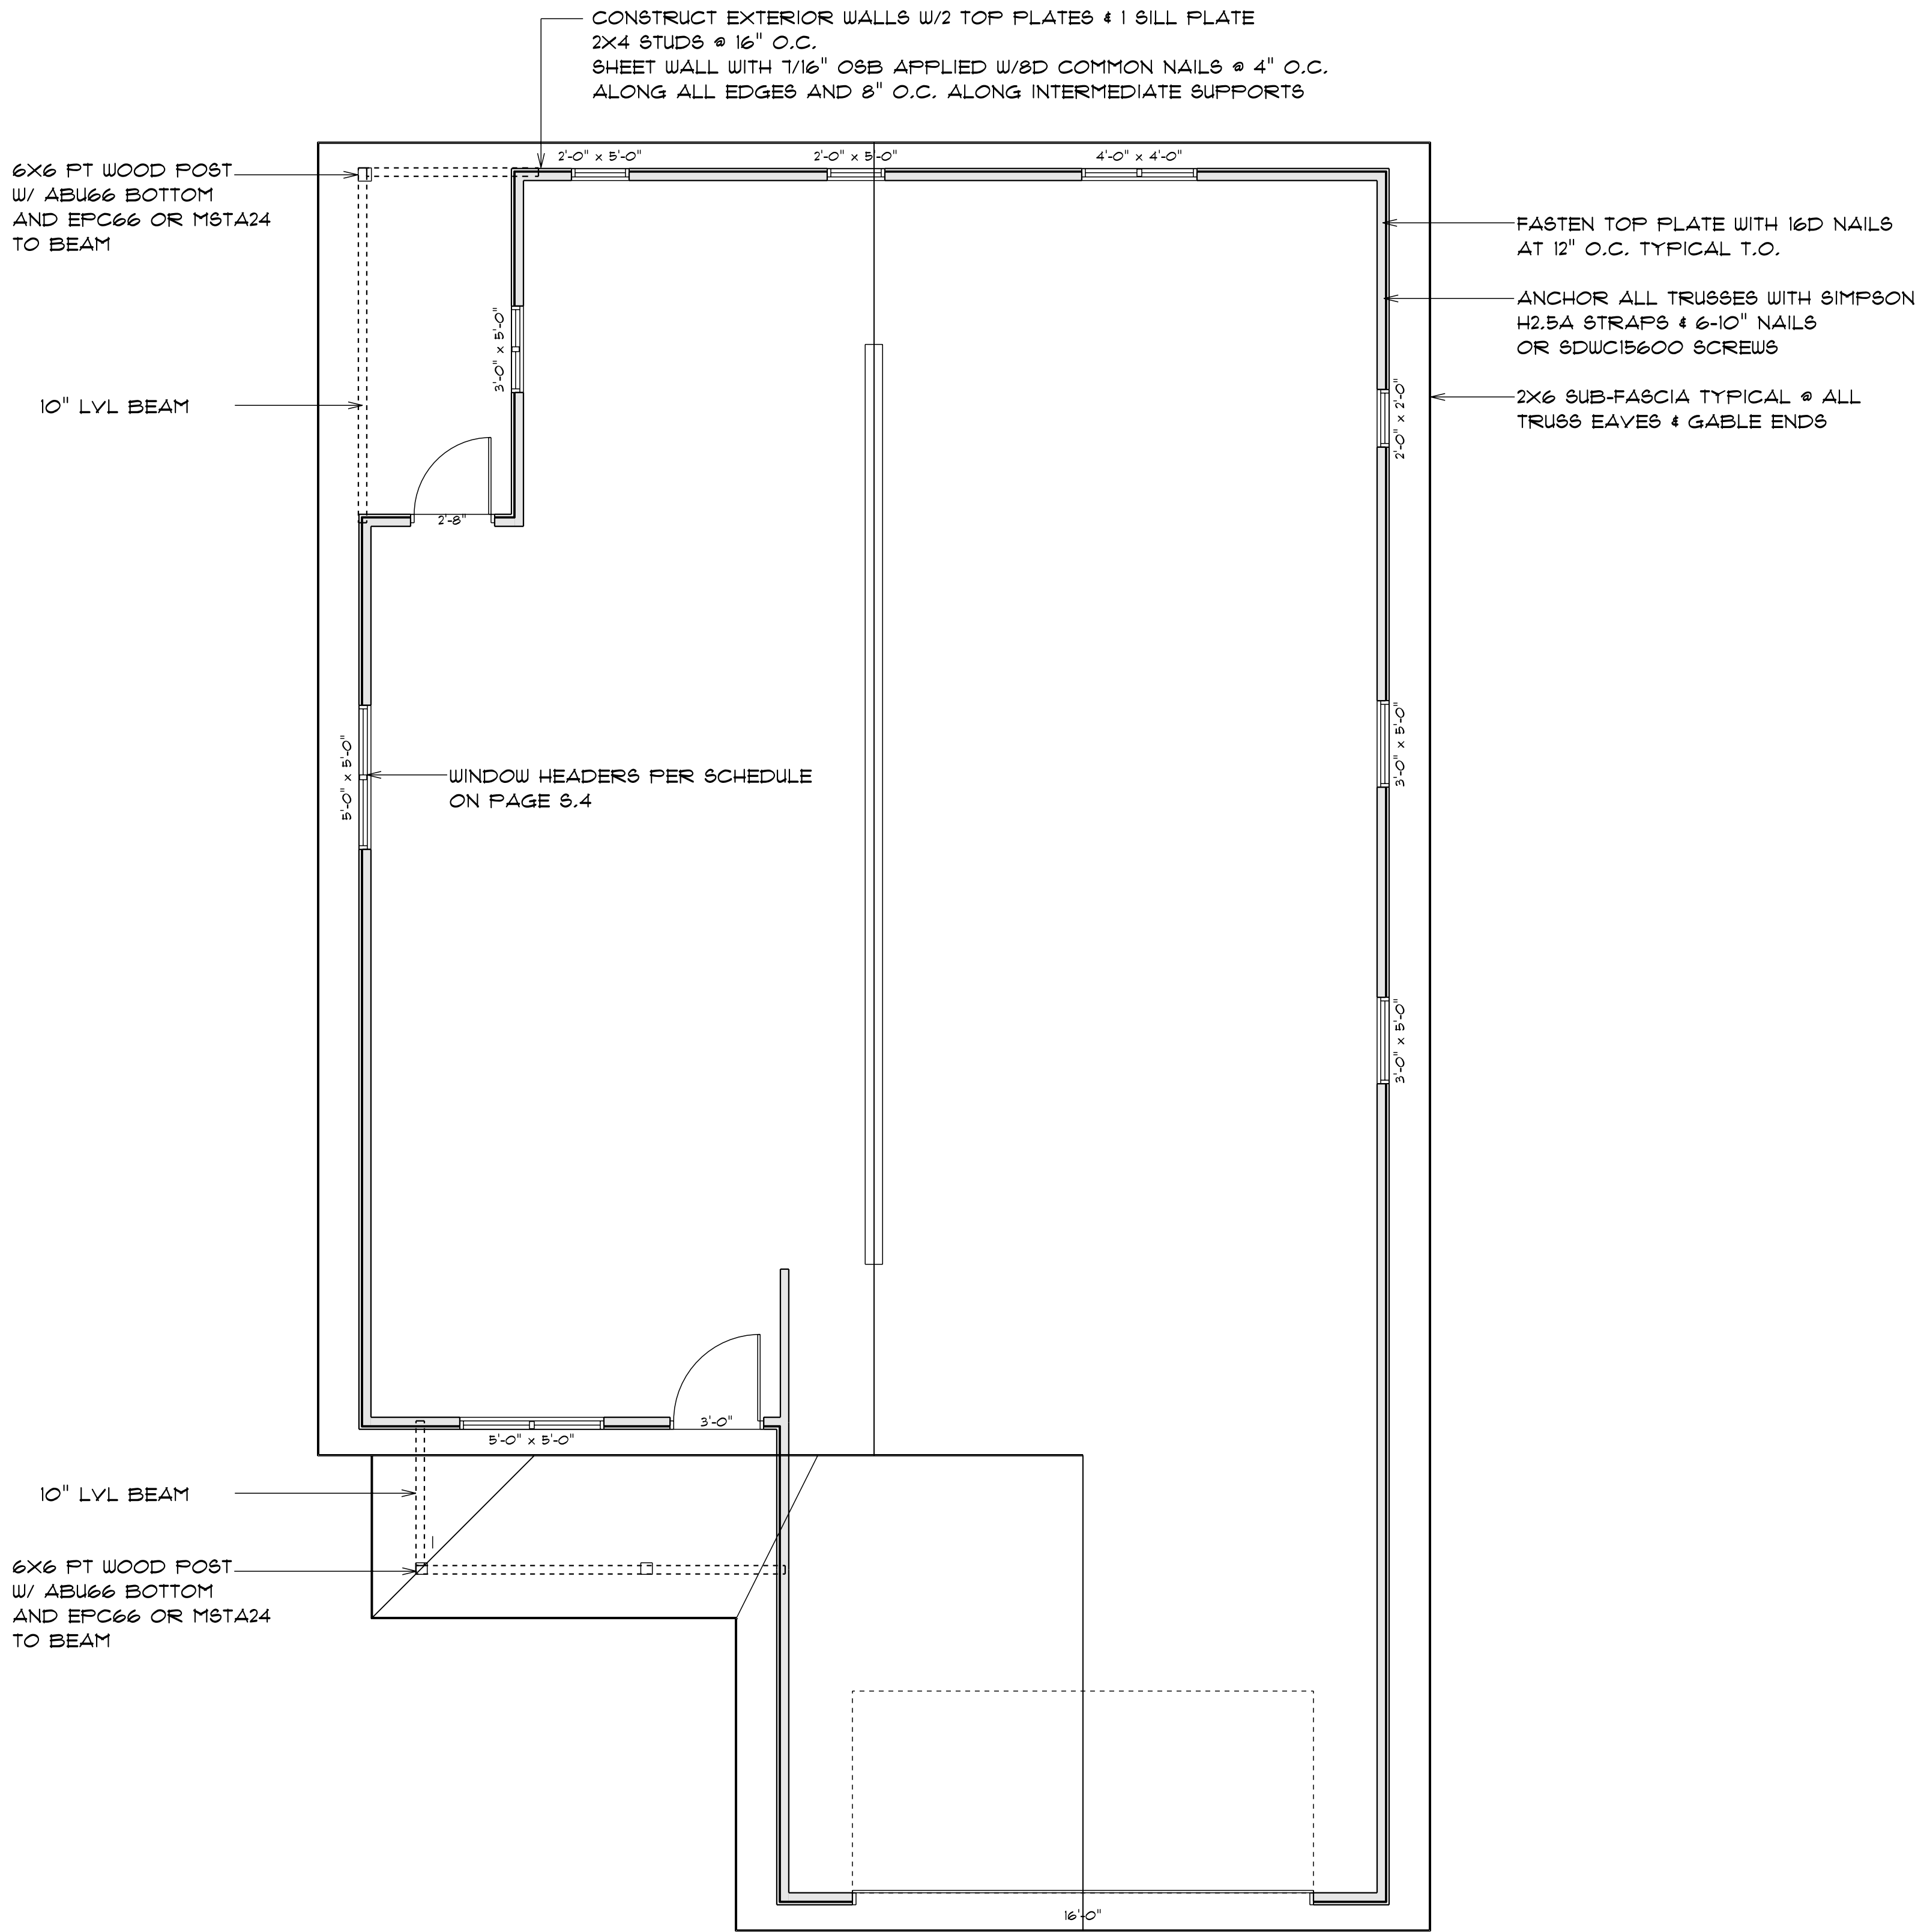

ROOF PLAN
SCALE: 1/4" = 1'-0"

Digitally signed by BARRETT C CROOK
DN: c=US, o=North Carolina,
dnQualifier=A01410D00000180F6761
40B000077E0, cn=BARRETT C CROOK
Date: 2023.04.10 16:43:04 -04'00'



FLORIDA BUILDING CODE


COMPLIANCE SUMMARY

TYPE OF CONSTRUCTION
ROOF: HIP & GABLE CONSTRUCTION, WOOD TRUSSES @ 24" O.C.
WALLS: 2X4 WOOD STUDS 16" O.C.
FLOOR: 4" THICK SLAB W/FIBERMESH CONCRETE ADD.
FOUNDATION: MONOLITHIC CONTINUOUS FOOTING
ROOF DECKING
MATERIAL: ½" CDX PLYWOOD OR 7/16" O.S.B.
SHEET SIZE: 48"X96" SHEETS PERP TO ROOF FRAMING
FASTENERS: 8D COMMON OR RING SHANK NAILS PER SCHEDULE ON SHEET S.4

SHEARWALLS
MATERIAL: ½" CDX PLYWOOD OR 7/16" O.S.B.
SHEET SIZE: 48"X96" SHEETS PLACED VERTICAL, STAGGER EACH SHEET
FASTENERS: 8D COMMON @ 4" O.C. EDGES & 8" O.C. INTERIOR
DRAGSTRUT: DOUBLE TOP PLATE (S.Y.P.) W/16D NAILS @ 12" O.C.
WALL STUDS: 2X4 WOOD STUDS @ 16" O.C.

HURRICANE UPLIFT CONNECTORS
TRUSS ANCHORS: SIMPSON H2.5A (OR EQUIVALENT), W/6D-10D NAILS
WALL TENSION: WALL SHEATHING NAILING IS ADEQUATE — 8D @ 4" O.C. TOP & BOTTOM
ANCHOR BOLTS: ½" A307 BOLTS @ 48" O.C. — 1ST BOLTS 6" FROM CORNER
CORNER HOLD-DOWN DEVICE: (1) DTT2Z OR EQ. EACH CORNER
PORCH COLUMN BASE CONNECTOR: SIMPSON ABU66/ABU66 AT EACH CORNER
PORCH COLUMN TO BEAM CONNECTOR: SIMPSON EPC66PC66 AT EACH CORNER

FOOTINGS AND FOUNDATIONS
FOOTINGS: 18"X18" CONTINUOUS MONOLITHIC FOOTING WITH 3 #5 BARS AS PER DETAIL ON FOUNDATION PLAN
STEMWALL: N/A

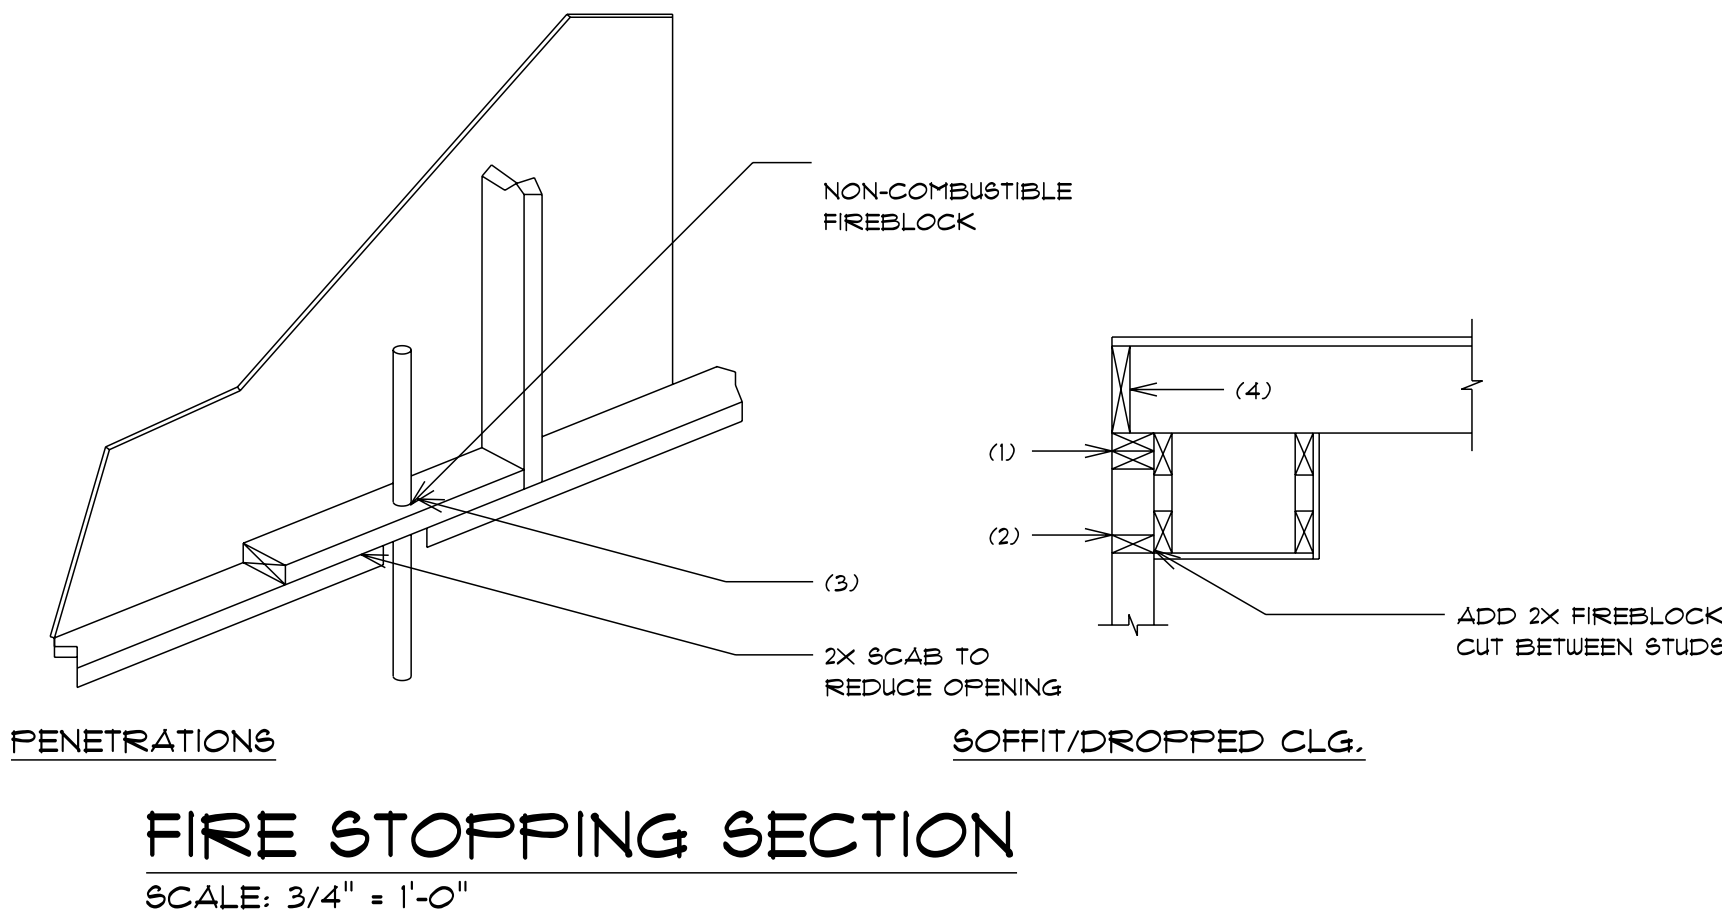

WALL	ROOF T - 2T	45° SLOPE AREA	BUILDING COMPONENTS & CLADDING LOADS			
			MEAN BUILDING HEIGHT = 30.0', EXPOSURE "B"			
			ROOF ANGLE 1° TO 21°			
			VULT 100 MPH	VULT 150 MPH	VULT 180 MPH	VULT 160 MPH
1	1	10	12.0 / -18.9	14.9 / -23.1	17.5 / -27.8	20.3 / -32.3
		20	11.4 / -18.4	13.6 / -23.0	16.0 / -27.0	18.5 / -31.4
		30	10.0 / -18.6	11.9 / -22.2	13.9 / -22.2	16.1 / -30.2
	2	10	12.5 / -34.1	14.9 / -41.3	17.5 / -48.4	20.3 / -56.2
		20	11.4 / -31.9	13.6 / -38.0	16.0 / -44.6	18.5 / -51.1
		30	10.0 / -38.2	11.9 / -33.6	13.9 / -39.4	16.1 / -45.1
	3	10	12.5 / -51.3	14.9 / -61.0	17.5 / -71.6	20.3 / -83.1
		20	11.4 / -47.9	13.6 / -57.1	16.0 / -64.6	18.5 / -77.1
		30	10.0 / -43.5	11.9 / -39.8	13.9 / -46.0	16.1 / -52.5
	4	10	21.8 / -23.6	25.9 / -34.1	30.4 / -33.0	35.3 / -38.2
		20	20.8 / -22.6	24.1 / -26.9	28.0 / -31.8	33.1 / -36.1
		30	19.9 / -21.3	23.2 / -25.4	27.2 / -29.8	31.6 / -34.6
	5	10	21.8 / -29.1	25.9 / -34.1	30.4 / -40.1	35.3 / -47.2
		20	20.8 / -27.2	24.1 / -32.4	28.0 / -38.0	33.1 / -44.0
		30	19.9 / -24.6	23.2 / -29.3	27.2 / -34.3	31.6 / -39.8

HEIGHT AND EXPOSURE ADJUSTMENT COEFFICIENTS			
FOR BUILDING COMPONENTS & CLADDING			
BUILDING HEIGHT	EXPOSURE "B"	EXPOSURE "C"	EXPOSURE "D"
15	1.00	1.21	1.41
20	1.00	1.29	1.59
25	1.00	1.39	1.61
30	1.00	1.40	1.66

Digitally signed by BARRETT C CROOK
DN: c=US, o=North Carolina, dnQualifier=A01410D00000180F676140B000077E0, cn=BARRETT C CROOK
Date: 2023.04.10 16:44:50 -04'00'




Lot 1 Church Street
695 SW Church Ave
Lake City
FL
32025
PHONE: 386-687-3534
FAX:
MOBILE:

Aaron Marc Company
PHONE:
FAX:
MOBILE:


SCALE: As Noted
DRAWN BY: AMIN
DATE: Wednesday, April 5, 2023

APPROVED:
PAGE NAME:
S.3 FBC NOTES & SECTIONS


PAGE:
5/6

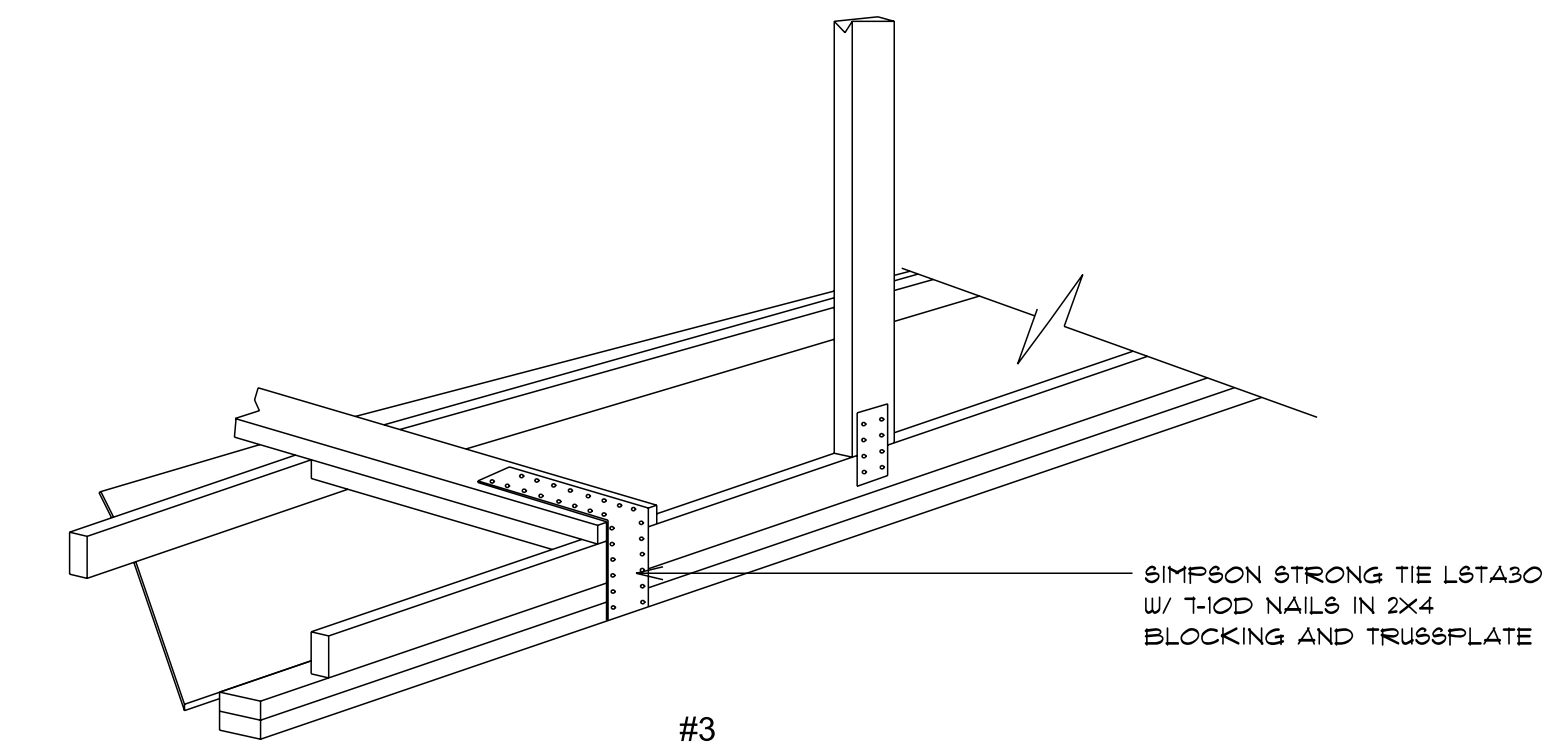

GABLE END GYP DIAPHRAGM HOLDOWN SECTION
SCALE: NOT TO SCALE

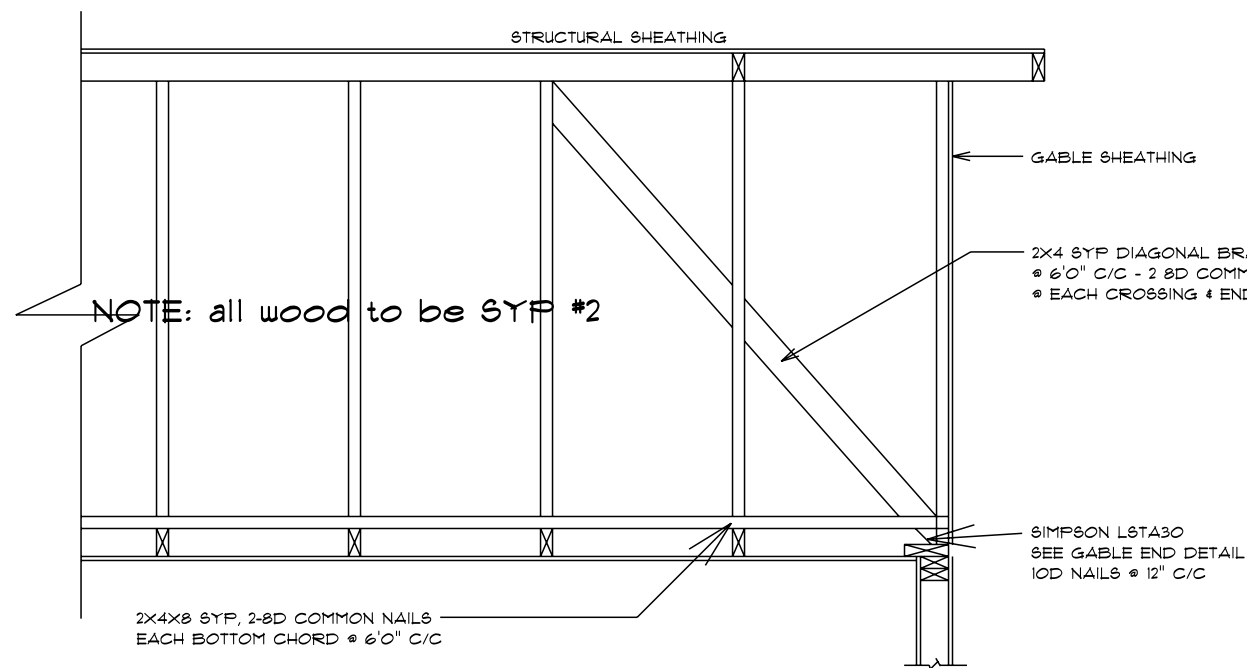


END WALL BRACING FOR CEILING SECTION
SCALE: NOT TO SCALE

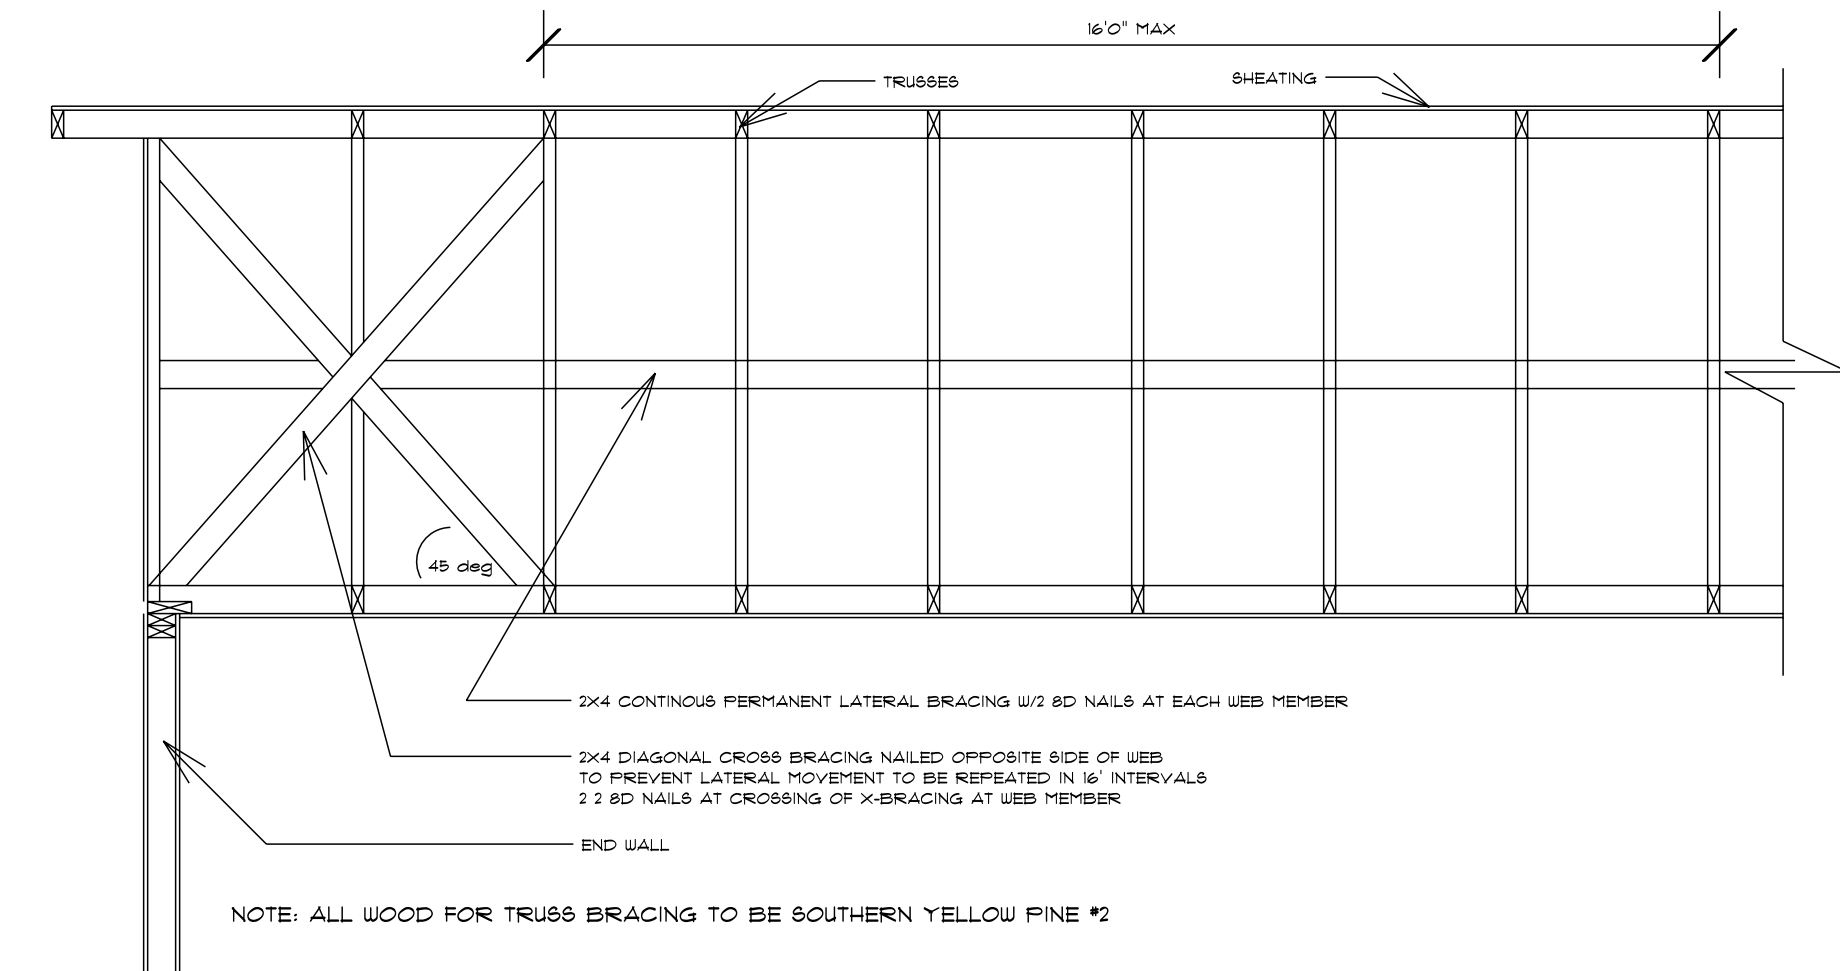


TYP PERM TRUSS BRACING SECTION
SCALE: NOT TO SCALE

ROOF SHEATHING FASTENING			
NAILING ZONE	SHEATHIN G TYPE	FASTENER	SPACING
1	7/16" OSB or 15/32 CDX	.113 RING SHANK NAILS	6" O.C. EDGE 12" O.C. FIELD
2	7/16" OSB or 15/32 CDX	.113 RING SHANK NAILS	6" O.C. EDGE 12" O.C. FIELD
3	7/16" OSB or 15/32 CDX	.113 RING SHANK NAILS	6" O.C. EDGE 12" O.C. FIELD

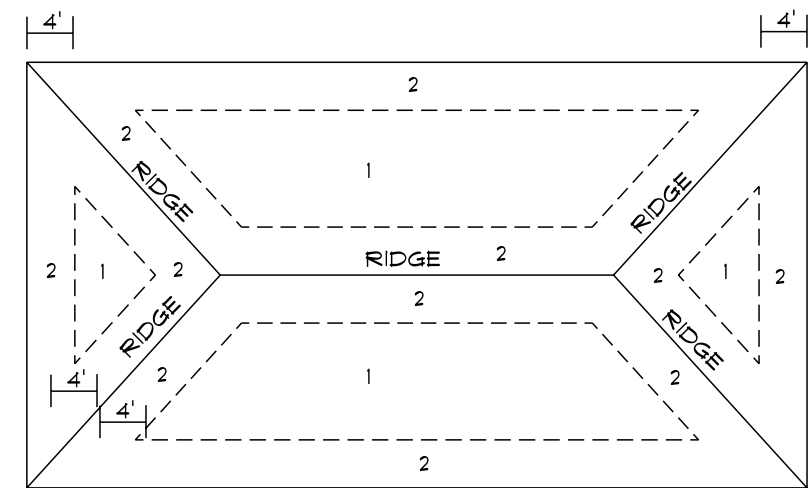


ROOF SHEATHING NAILING ZONES (HIP ROOF)

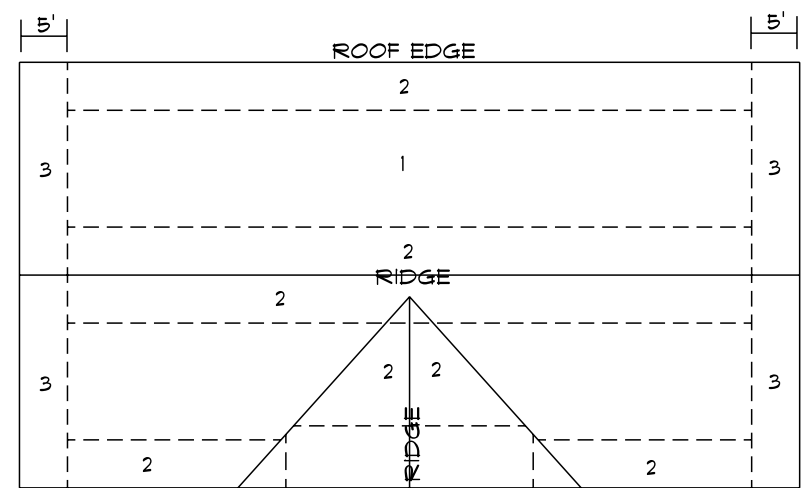


ROOF SHEATHING NAILING ZONES (GABLE ROOF)


ROOF NAIL PATTERN SECTION
SCALE: 1/4" = 1'-0"

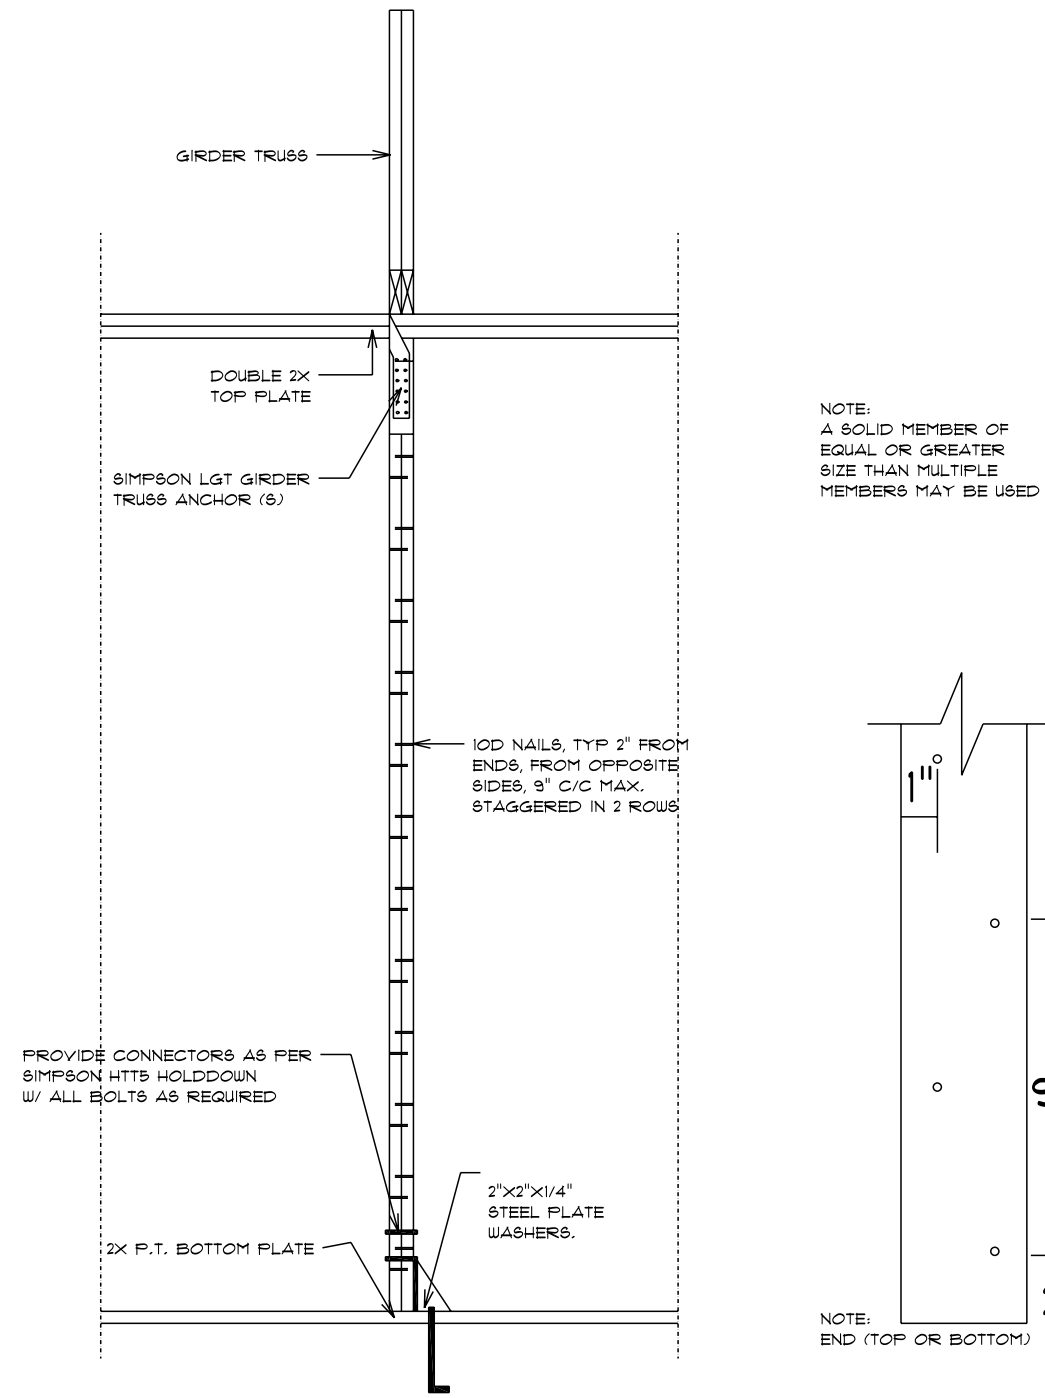


GIRDER TRUSS COLUMN SECTION
SCALE: 1/2" = 1'-0"

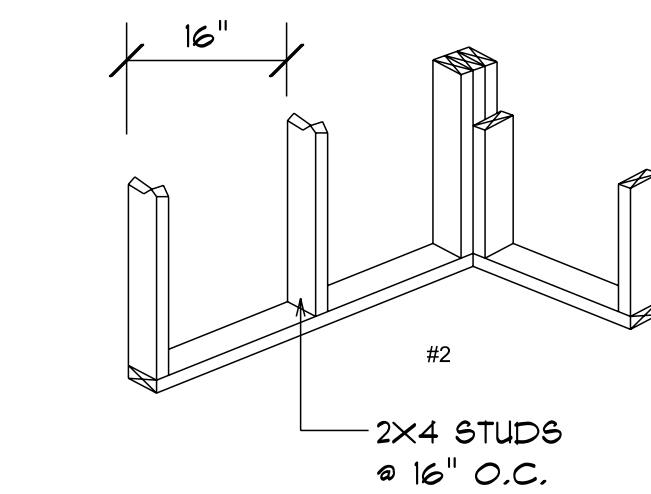


WALL CORNER

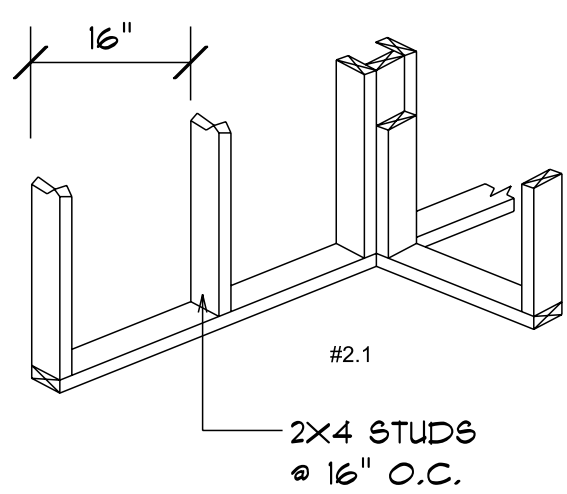


WALL INTERSECTION

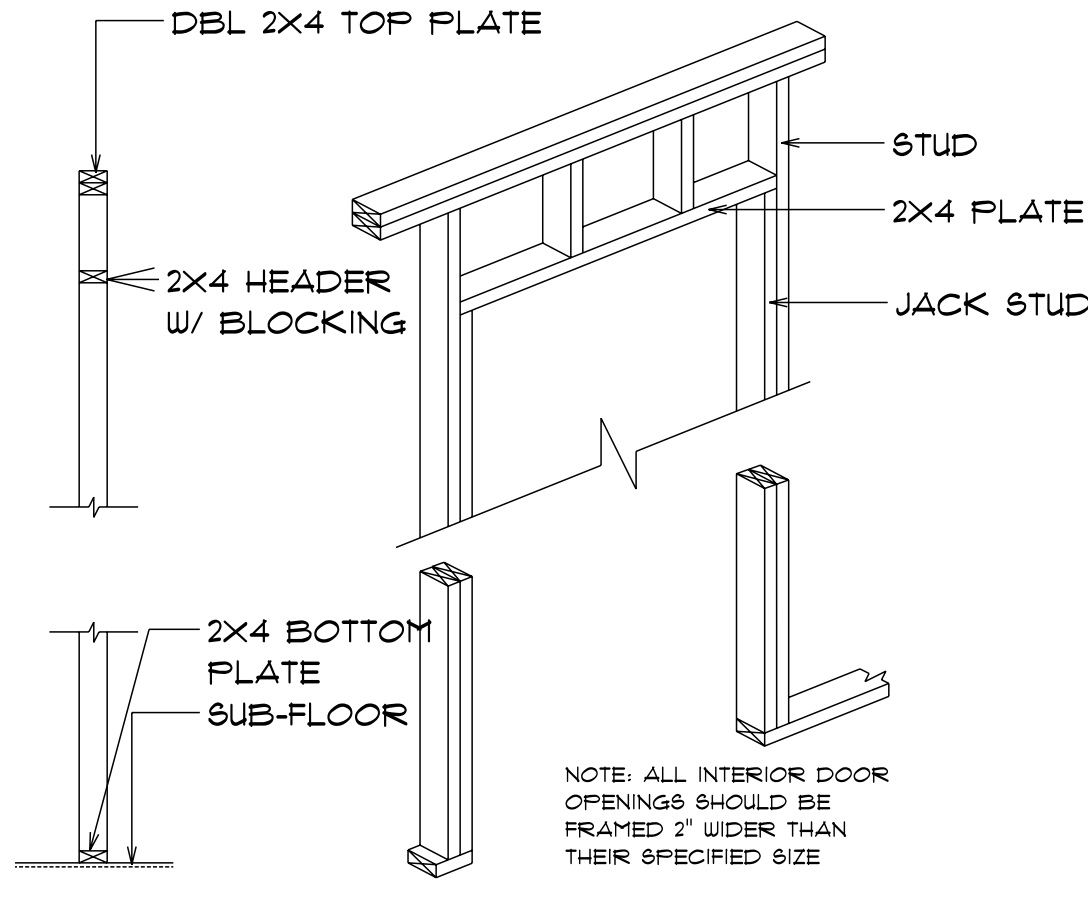


NON-BEARING WALL HEADER

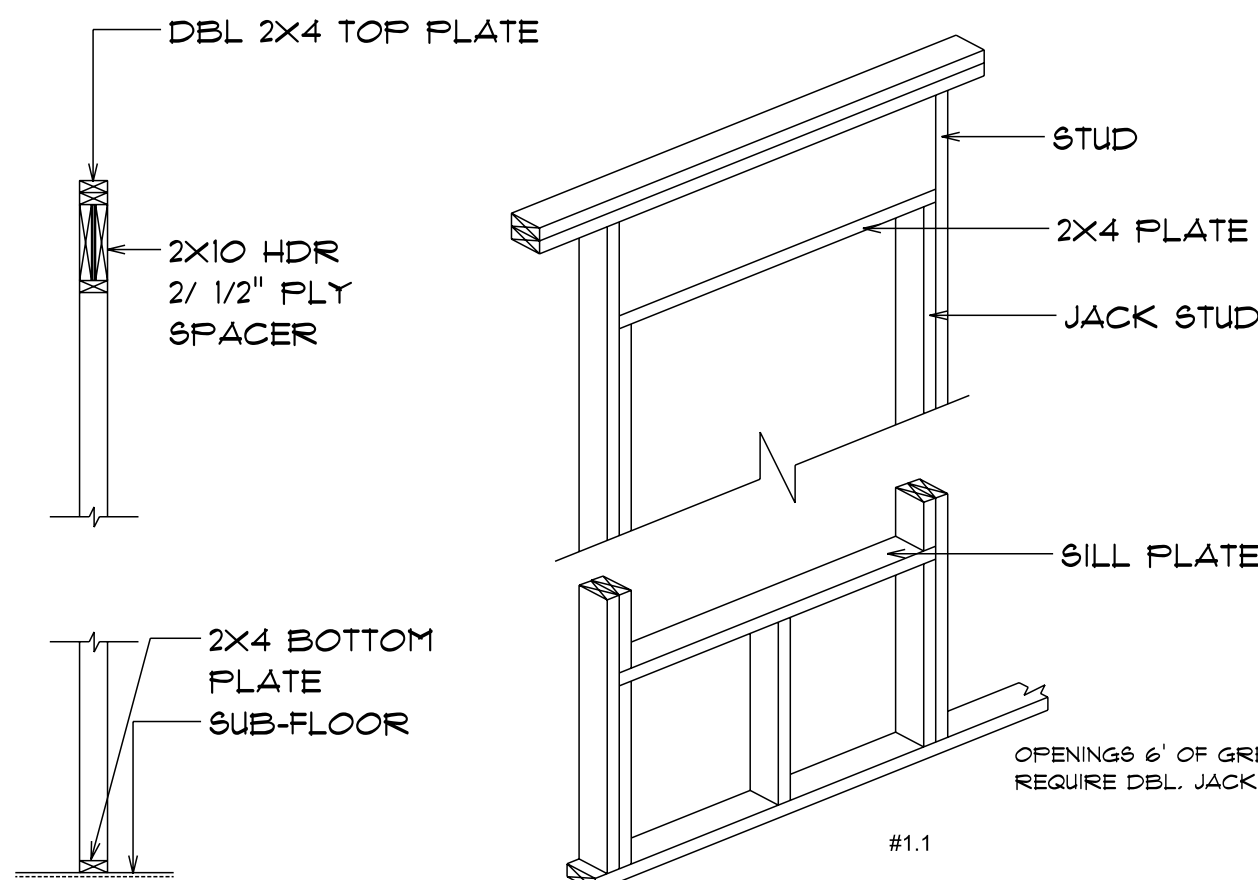

TYPICAL WINDOW HEADER

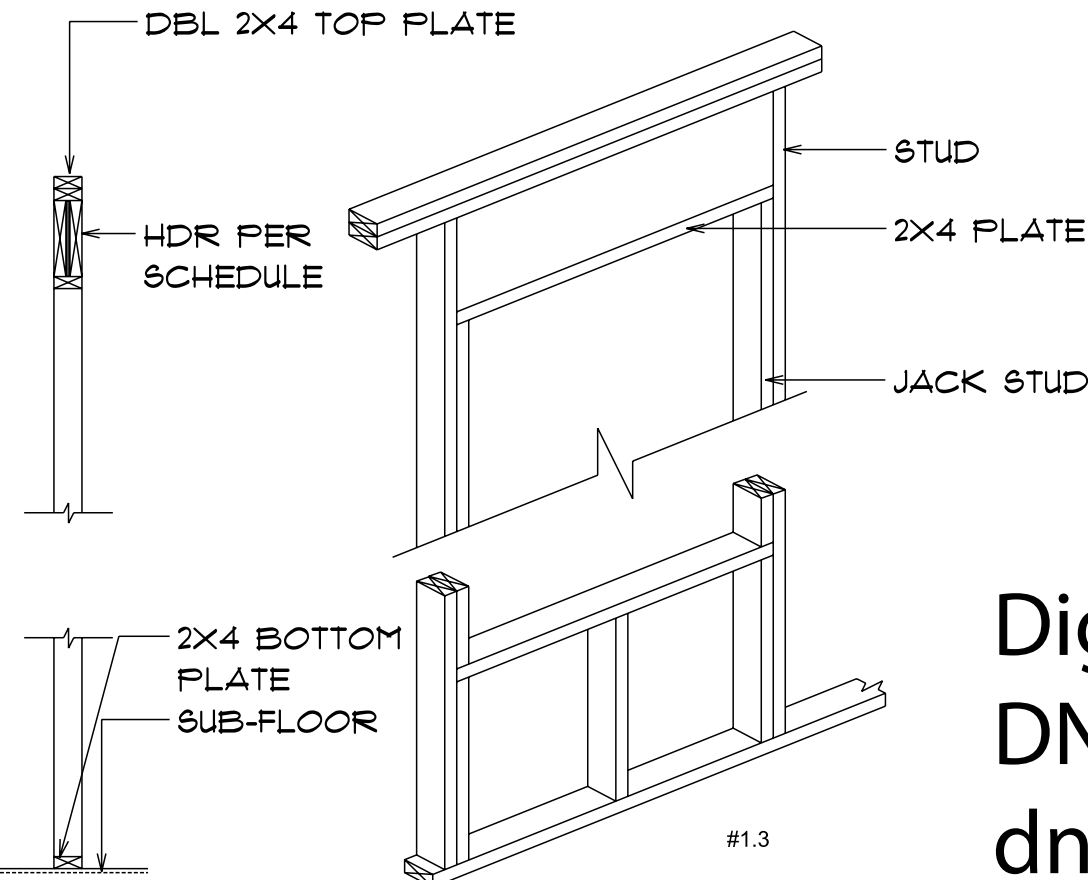

BEARING WALL HEADER

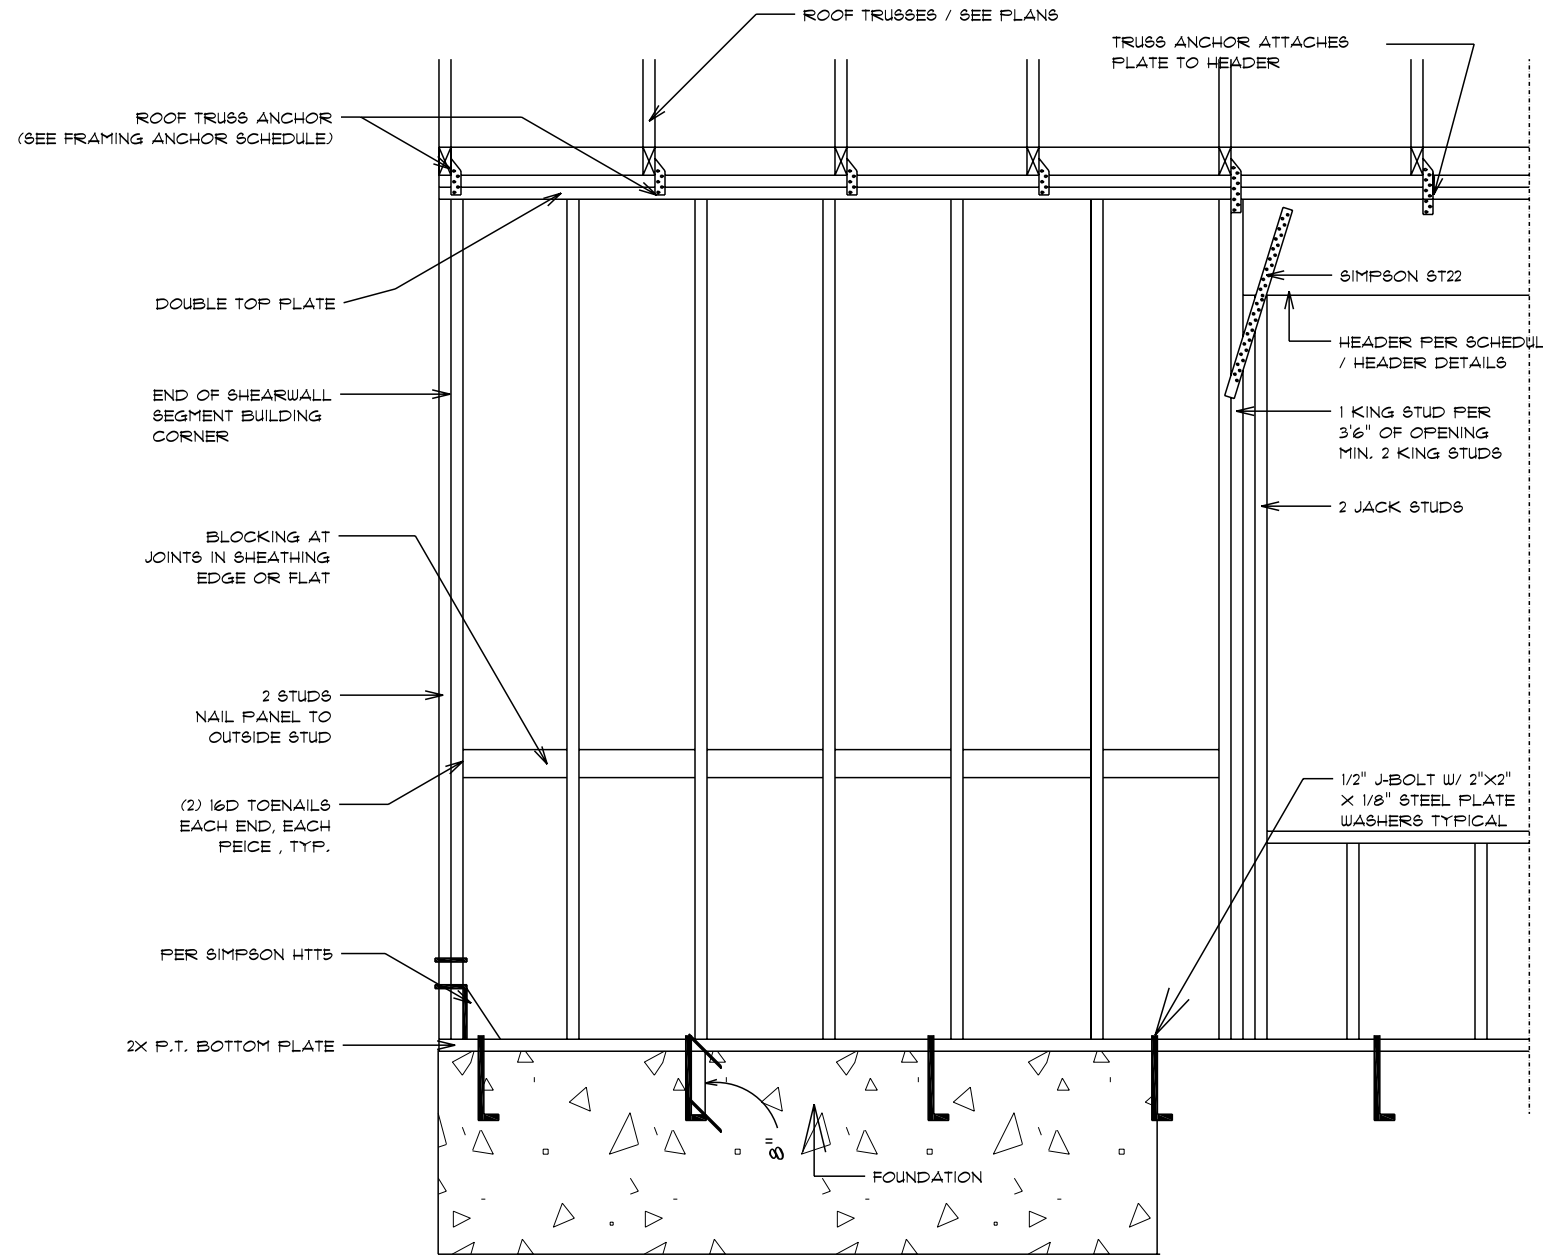

SHEAR WALL DETAIL SECTION
SCALE: 1/2" = 1'-0"

Digitally signed by BARRETT C CROOK
DN: c=US, o=North Carolina,
dnQualifier=A01410D00000180F6761
40B000077E0, cn=BARRETT C CROOK
Date: 2023.04.10 16:46:45 -04'00'

OPENING WIDTH	SILL PLATES	16D TOE NAILS EACH END
UP TO 6'-0"	(1) 2X4 OR 2X6	1
+6' - 9'-0"	(1) 2X4 OR 2X6	2
+9' - 12'-0"	(1) 2X4 OR 2X6	3

