


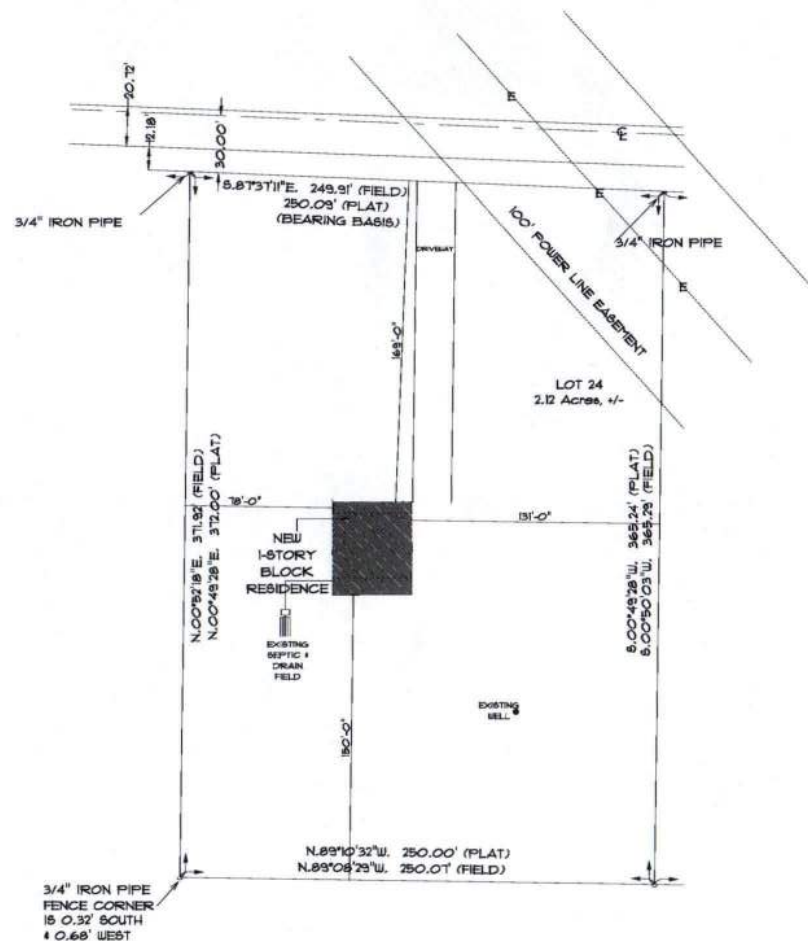

* SITE PLAN *

SCALE: 1" = 30'-0"



NEW RESIDENCE FOR BETSY BOTO

Teresa F. Ruffo
2025 3rd St. #1
Lake City, Florida, 32009
Cell: (904) 861-1191
Email: terraruffo@gmail.com

PREPARED DATE:
Friday, May 18, 2024

DRAWN BY: Teresa F. Ruffo

CHECKED BY:

REVISION CONTRACTOR:


TRAILER DATE:

JOB NUMBER:

DRAWING NUMBER:

A-1

OF 6 SHEETS

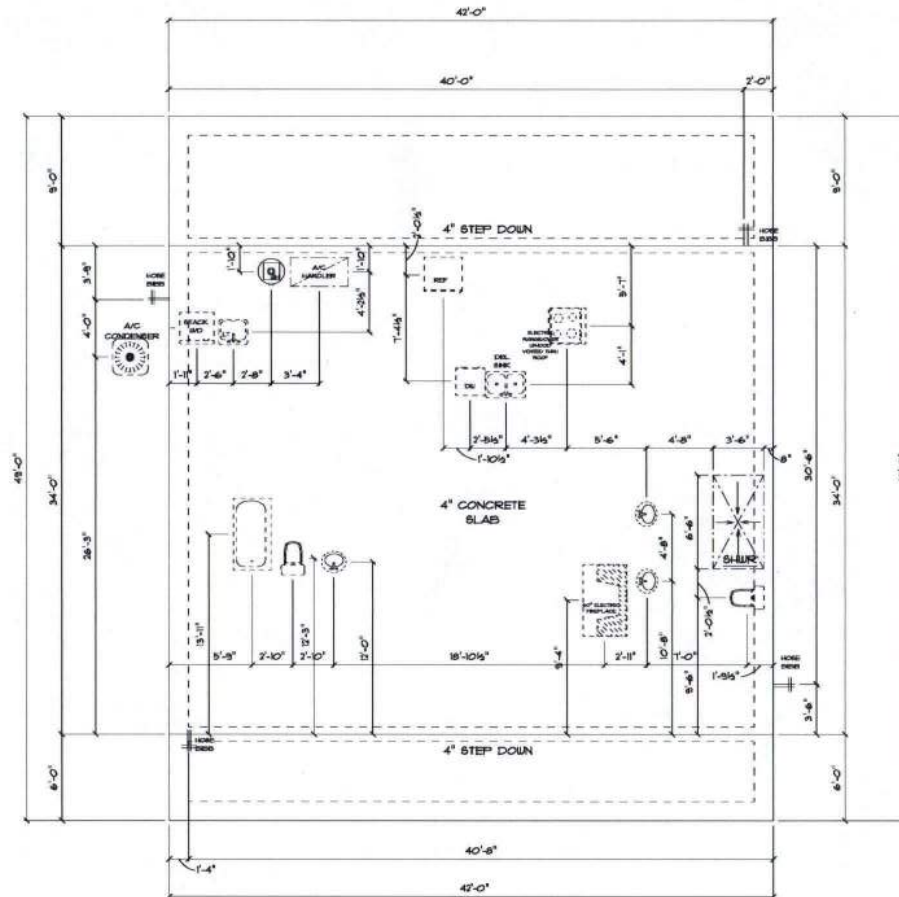

* FOUNDATION & *
* PLUMBING PLAN *

SCALE : 1/4" = 1'-0"

IMPORTANT NOTE:

1. IT IS THE BUILDER'S RESPONSIBILITY TO VERIFY ALL GEOMETRY AND DIMENSIONS BEFORE ORDERING ANY MATERIALS OR BEGINNING CONSTRUCTION.
2. THESE PLANS ARE FOR LAYOUT AND DESIGN PURPOSES ONLY. ALL STRUCTURAL NOTES AND DETAILS TO BE PROVIDED BY AN ENGINEER.

NEW RESIDENCE
FOR
BETSY BOTO

Teresa P. Ruffo
2025 Rd 66 #1
Lake City Florida, 33009
Cell: 352-341-1751
Email: tsera@tpruffo.com

PRINTED DATE:
Friday, May 10, 2023

DRAWN BY: T. RUFFO
CHECKED BY: T. RUFFO

SCALE CONTRACTOR:


TRIALS DATE:

JOB NUMBER:

DRAWING NUMBER:

A-2

OF 6 SHEETS

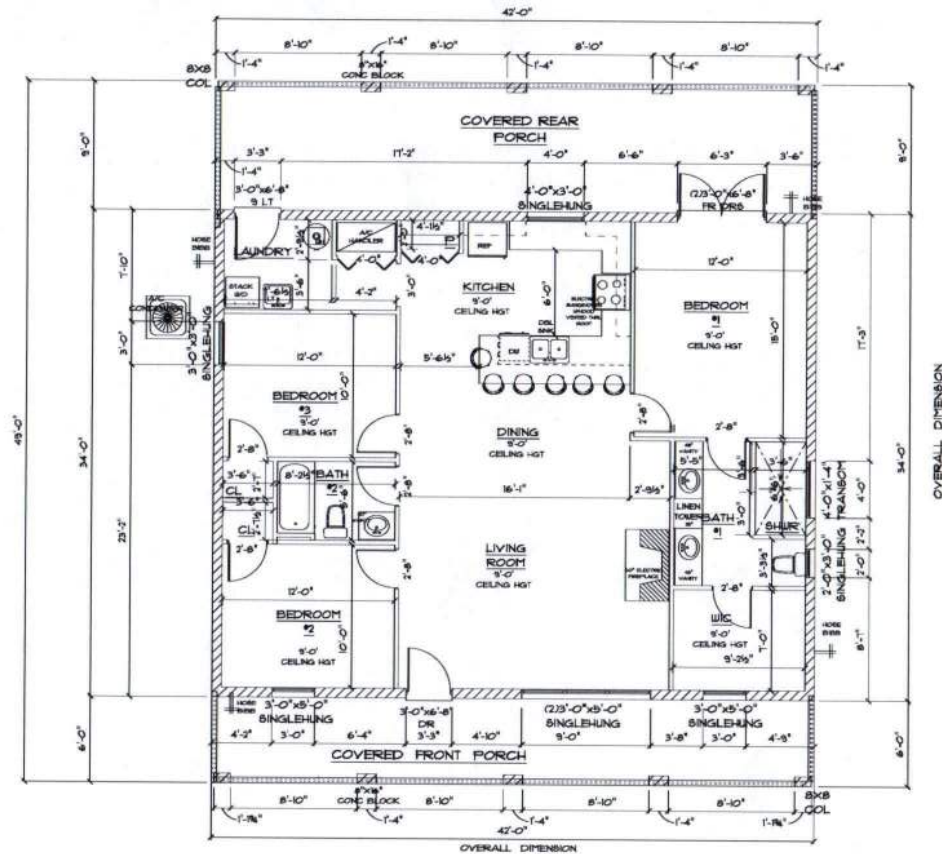

* FLOOR PLAN *

SCALE : 1/4" = 1'-0"

IMPORTANT NOTE:

1. IT IS THE BUILDERS RESPONSIBILITY TO VERIFY ALL GEOMETRY AND DIMENSIONS BEFORE ORDERING ANY MATERIALS OR BEGINNING CONSTRUCTION.
2. THESE PLANS ARE FOR LAYOUT AND DESIGN PURPOSES ONLY. ALL STRUCTURAL NOTES AND DETAILS TO BE PROVIDED BY AN ENGINEER.

A/C LIVING AREA	= 1428 S.F.
COVERED BACK PORCH	= 355 S.F.
COVERED FRONT PORCH	= 235 S.F.
TOTAL AREA UNDER ROOF	= 2,018 S.F.

NEW RESIDENCE
FOR
BETSY BOTO

Teresa P. Ruffo
2025 BE 06 41
Little City Homes, LLC
Cell: (562) 861-1781
Email: teresa@tpruffo.com

PRINTED DATE:
Friday, May 19, 2023

DRAWN BY: Teresa P. Ruffo

CHECKED BY:

BUILDING CONTRACTOR:

DATE:

JOB NUMBER:

DRAWING NUMBER:

A-3


CP & B-ESTS



• FRONT ELEVATION •

SCALE : 1/4" = 1'-0"

NOTE:
24" OVERHANG ON ALL EAVES

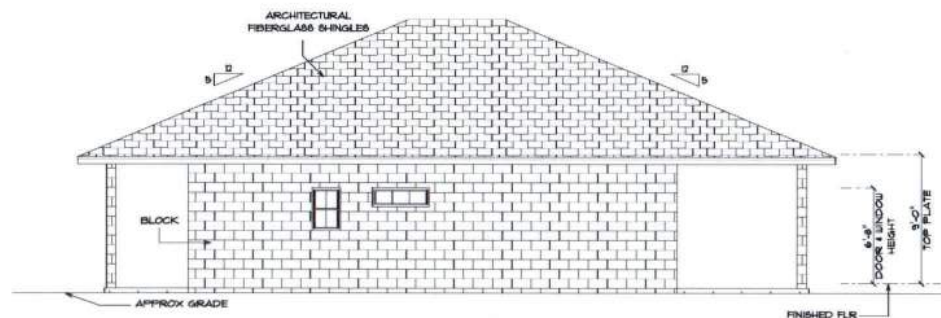

• RIGHT ELEVATION •

SCALE : 1/4" = 1'-0"

NEW RESIDENCE
FOR
BETSY BOTO

Teresa F. Ruffo
2525 82 88 41
Lafayette, LA 70001
Cell: (504) 861-1181
Email: teresaf@earthlink.net

PRINTED DATE:
1 May 19, 2023
DRAWN BY: TFR
CHECKED BY: TFR

SCALE CONTRACTOR

SCALE DATE:

JOB NUMBER:

DRAWING NUMBER:


A-4

OF 6 SHEETS



• REAR ELEVATION •

SCALE : 1/4" = 1'-0"

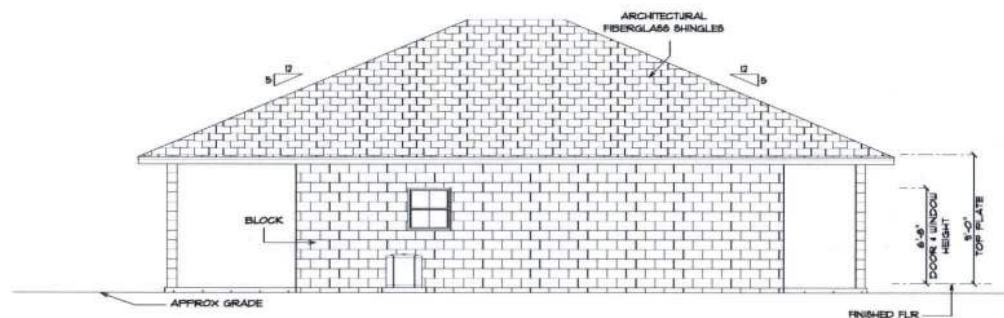

• LEFT ELEVATION •

SCALE : 1/4" = 1'-0"

NEW RESIDENCE
FOR
BETSY BOTO

Teresa T. Ruffo
3025 NW 5th Ave #1
Lakeland, Florida, 33809
Cell: 888/ 881-178
Email: teresa@teresaruffo.com

PRINTED DATE:
Friday, May 10, 2023


DRAWN BY:
Teresa T. Ruffo

CHECKED BY:
RESIDENT CONTRACTOR

FINAL DATE:

JOB NUMBER:

DRAWING NUMBER:
A-5
OF 8 SHEETS

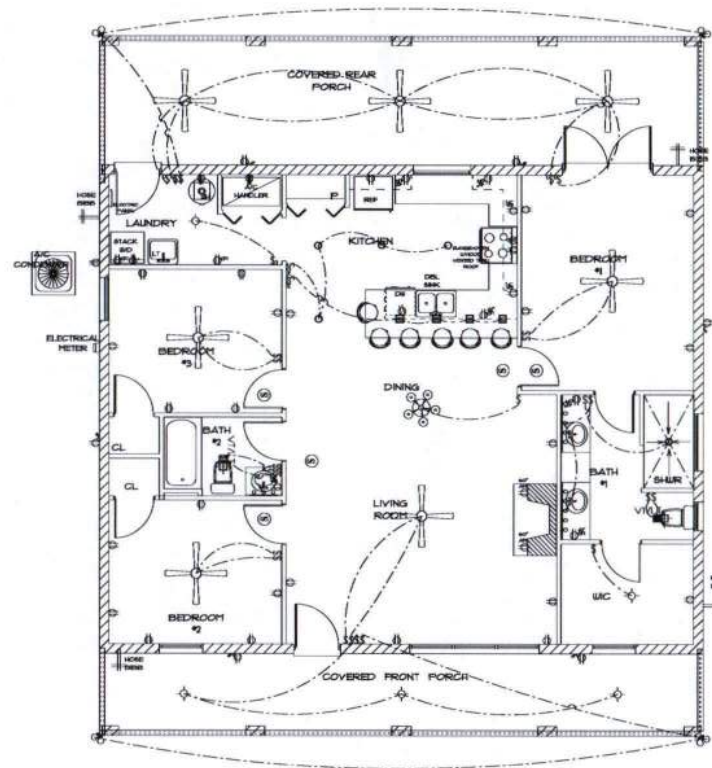

ELECTRICAL LEGEND		
ELECTRICAL	COUNT	SYMBOL
ceiling fan globe O1	7	
ceiling light I2	1	
pendant large	4	
pot light	5	
spotlight double	4	
Smoke Detector	5	
electrical panel	1	
dimmer switch	2	
light	5	
outlet	28	
outlet 220v	5	
outlet gfi	10	
outlet up	6	
switch	20	
switch 3 way	5	
vent light combo	2	
vanity bar light O1	2	
vanity bar light O2	1	

ELECTRICAL PLAN NOTES

- E-1 WIRE ALL APPLIANCES, HVAC UNITS AND OTHER EQUIPMENT PER MANUFACTURER'S SPECIFICATIONS.
- E-2 ALL INSTALLATIONS SHALL BE PER NATIONAL ELECTRIC CODE.
- E-3 ALL SMOKE (CARBON MONOXIDE DETECTORS SHALL BE 90V BATTERY BACKUP OF THE PHOTOELECTRIC TYPE, AND SHALL BE INTERLOCKED TOGETHER. INSTALL INIDE AND NEAR ALL BEDROOMS AS PER CODE.
- E-4 TELEPHONE, TELEVISION AND OTHER LOW VOLTAGE DEVICES OR OUTLETS SHALL BE AS PER THE COUNTRIES DIRECTION AND IN ACCORDANCE WITH APPLICABLE SECTIONS OF NATIONAL ELEC. CODE LATEST EDITION.
- E-5 ELECTRICAL CONTRACTOR SHALL BE RESPONSIBLE FOR THE DESIGN AND SIZES OF ELECTRICAL SERVICE AND CIRCUITS.
- E-6 ENTRY OF SERVICE UNDERGROUND (OR OVERHEAD) IS TO BE DETERMINED BY THE POWER COMPANY.
- ALL BEDROOM RECEPTALS ARE TO BE AFCI (ARC FAULT CIRCUIT INTERRUPT).
- 10% OF ALL PERMANENT LIGHTS TO BE ENERGY EFFICIENT.

* ELECTRIC PLAN *

SCALE : 1/4" = 1'-0"

NEW RESIDENCE
FOR
BETSY BOTO

Teresa P. Ruffo
2025 Rd 41
Lake City Florida, 32226
Cell: (904) 441-1700
Email: tsera@tereruffo.com

PRINTED DATE:
Friday, May 10, 2025

DRAWN BY: Teresa P. Ruffo
CHECKED BY: [Signature]
LICENSED CONTRACTOR

TRIALS DATE:
JOB NUMBER:

DRAWING NUMBER
A-6
OF 6 SHEETS