


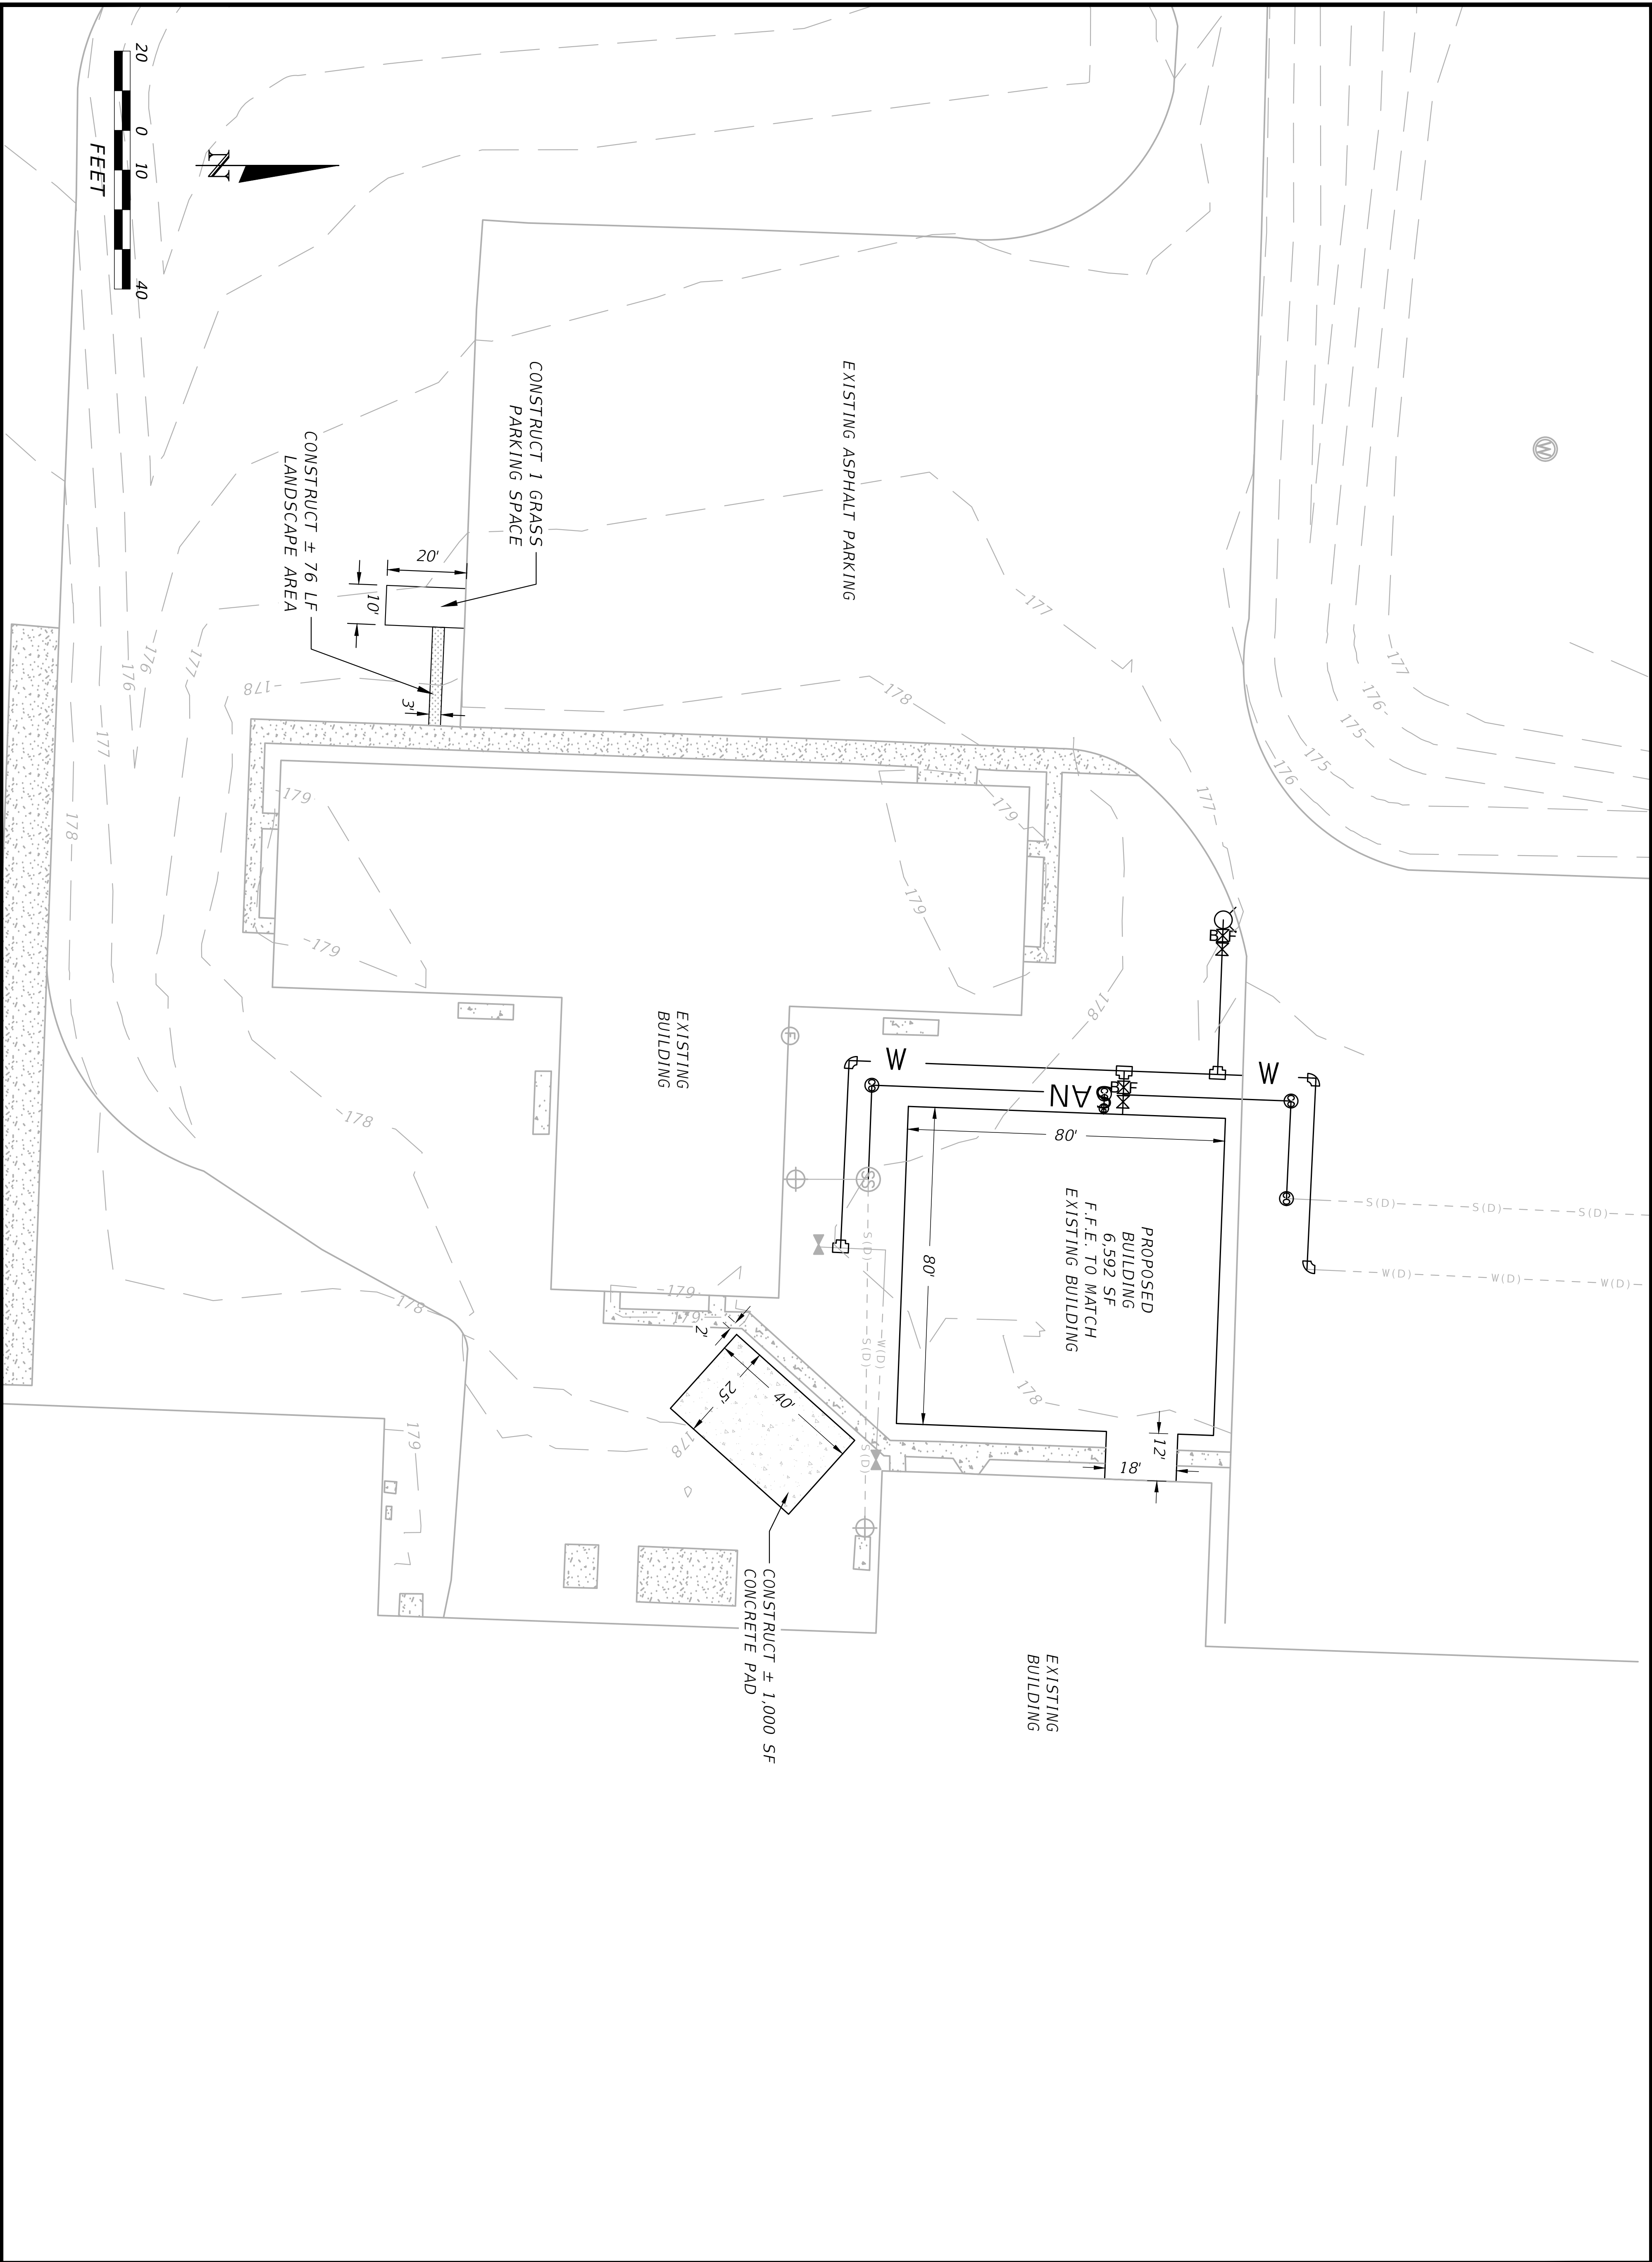

Robert 6/15/2022 4:54:39 PM C:\Users\Brian\Documents\pitman engineering\new millennium addition\project files\Scada Roadway\PLANR001.dwg

SHEET NAME
SITE PLAN

DATE
04-2022
PITMAN ENGINEERING PROJECT #
2022-07DOU

SHEET #

C-5

PROJECT NAME AND SITE ADDRESS

NEW MILLENNIUM ADDITION
1992 NW BASCOM NORRIS DR
LAKE CITY, FL 32055

FIRM NAME AND CONTACT INFORMATION:

PITMAN ENGINEERING
405 E DUVAL ST
LAKE CITY, FL 32055
(386) 965-5919
PITMANENGINEERING.COM
DBPR REGISTRY #: 35013

ENGINEER OF RECORD:

BRIAN JAMES PITMAN, P.E.
PE LICENSE NUMBER: 87495
BPITMAN@PITMANENGINEERING.COM
(386) 965-5919

THE OFFICIAL RECORD OF THIS SHEET IS THE ELECTRONIC FILE DIGITALLY SIGNED AND SEALED UNDER RULE 61G15-23.004, F.A.C.