




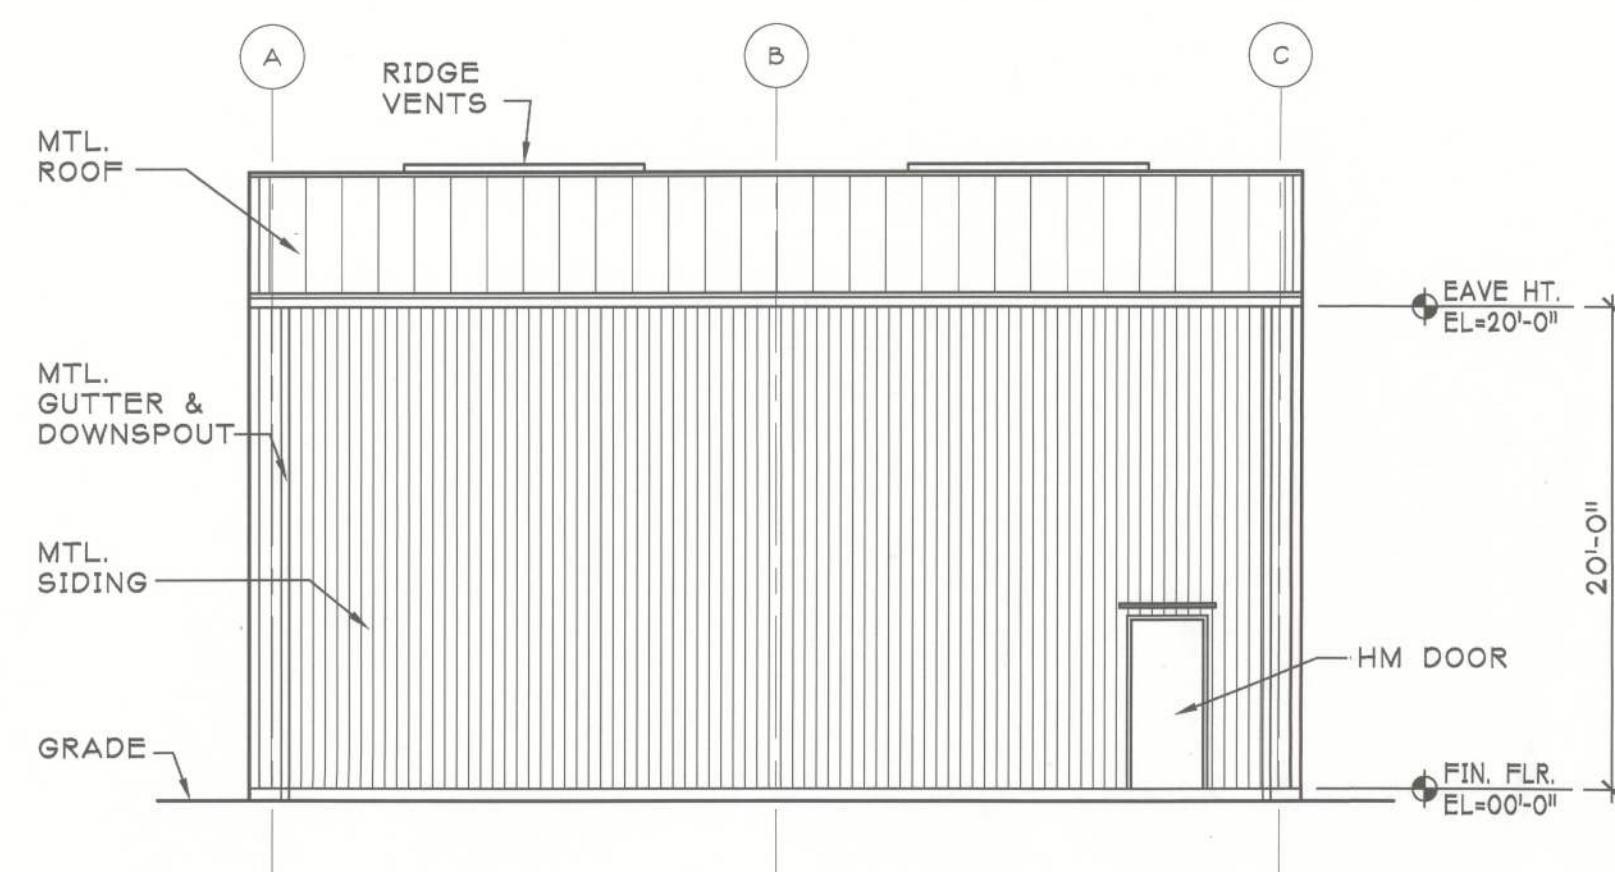


1B WEST ELEVATION
A1.2 SCALE: 1/8" = 1'-0"

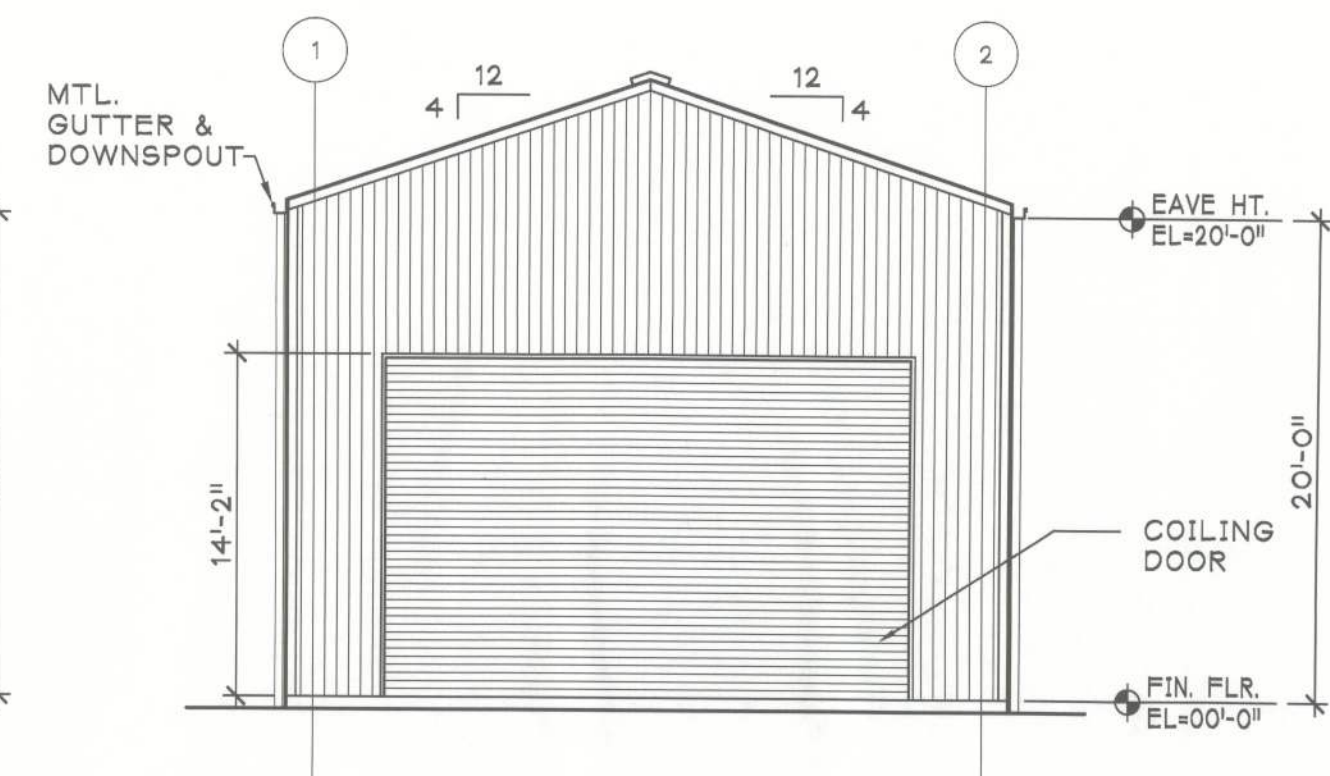

3B NORTH ELEVATION
A1.2 SCALE: 1/8" = 1'-0"

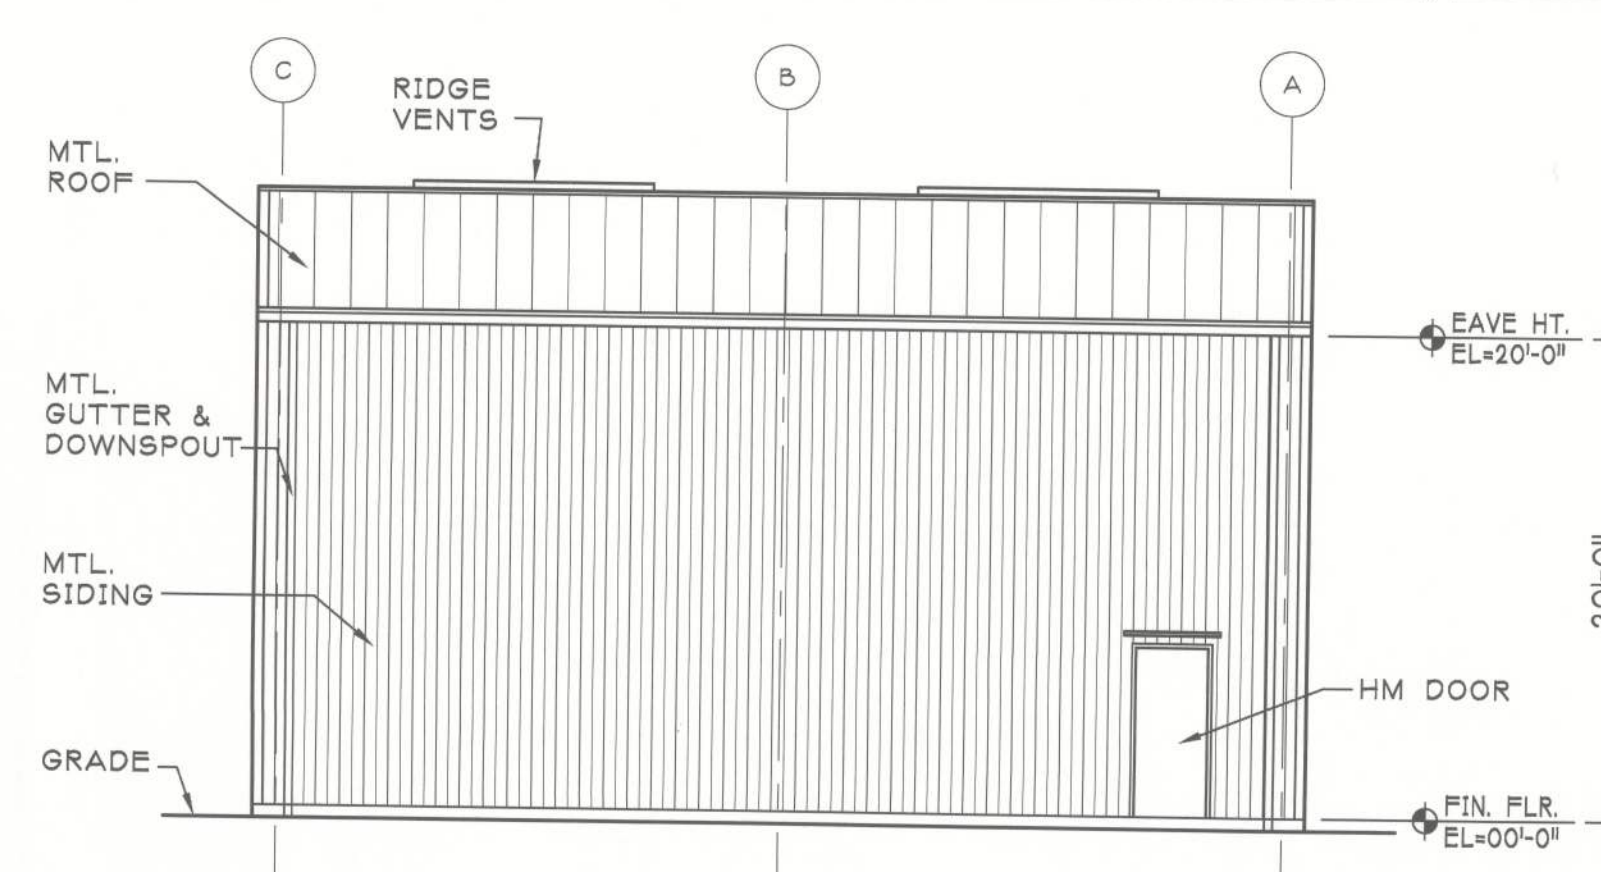


5B EAST ELEVATION
A1.2 SCALE: 1/8" = 1'-0"

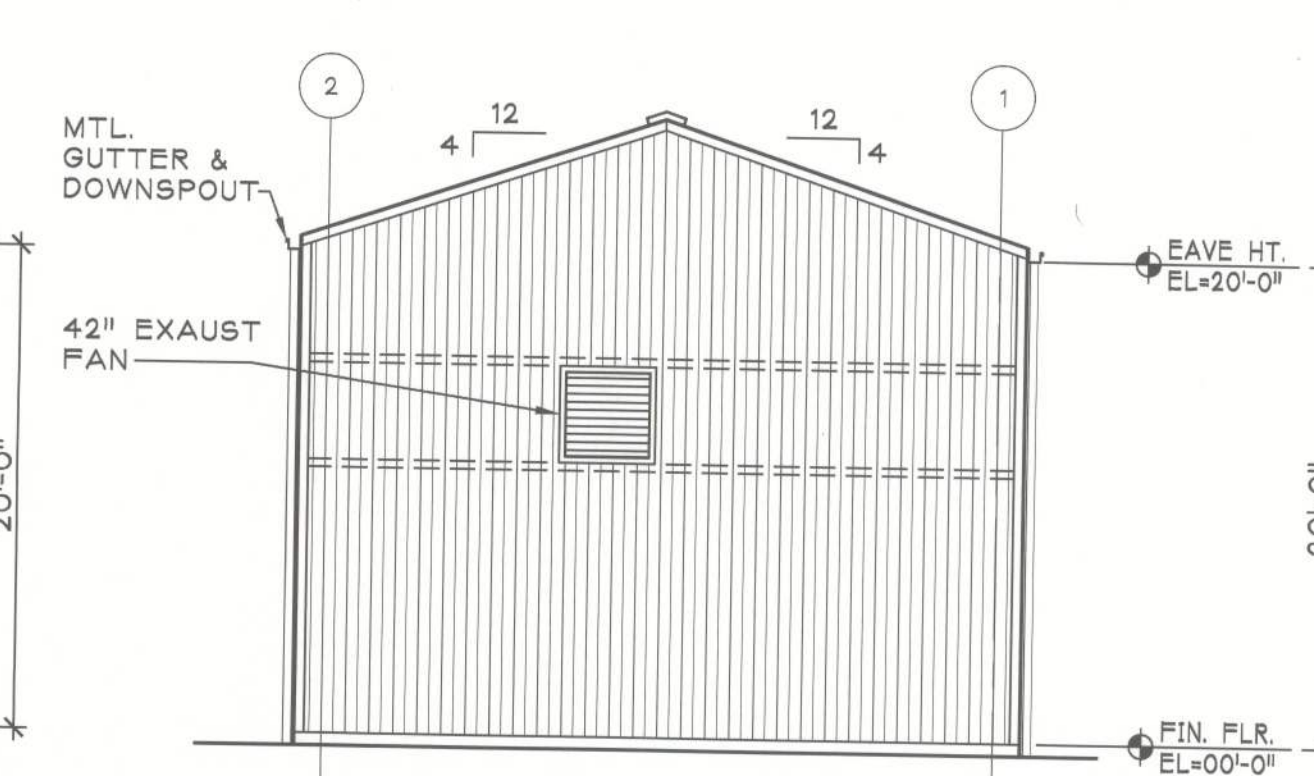


7B SOUTH ELEVATION
A1.2 SCALE: 1/8" = 1'-0"


NOTE:
ADJUST EXHAUST FAN
HEIGHT ACCORDING TO
SIDE WALL GIRT LOCATION

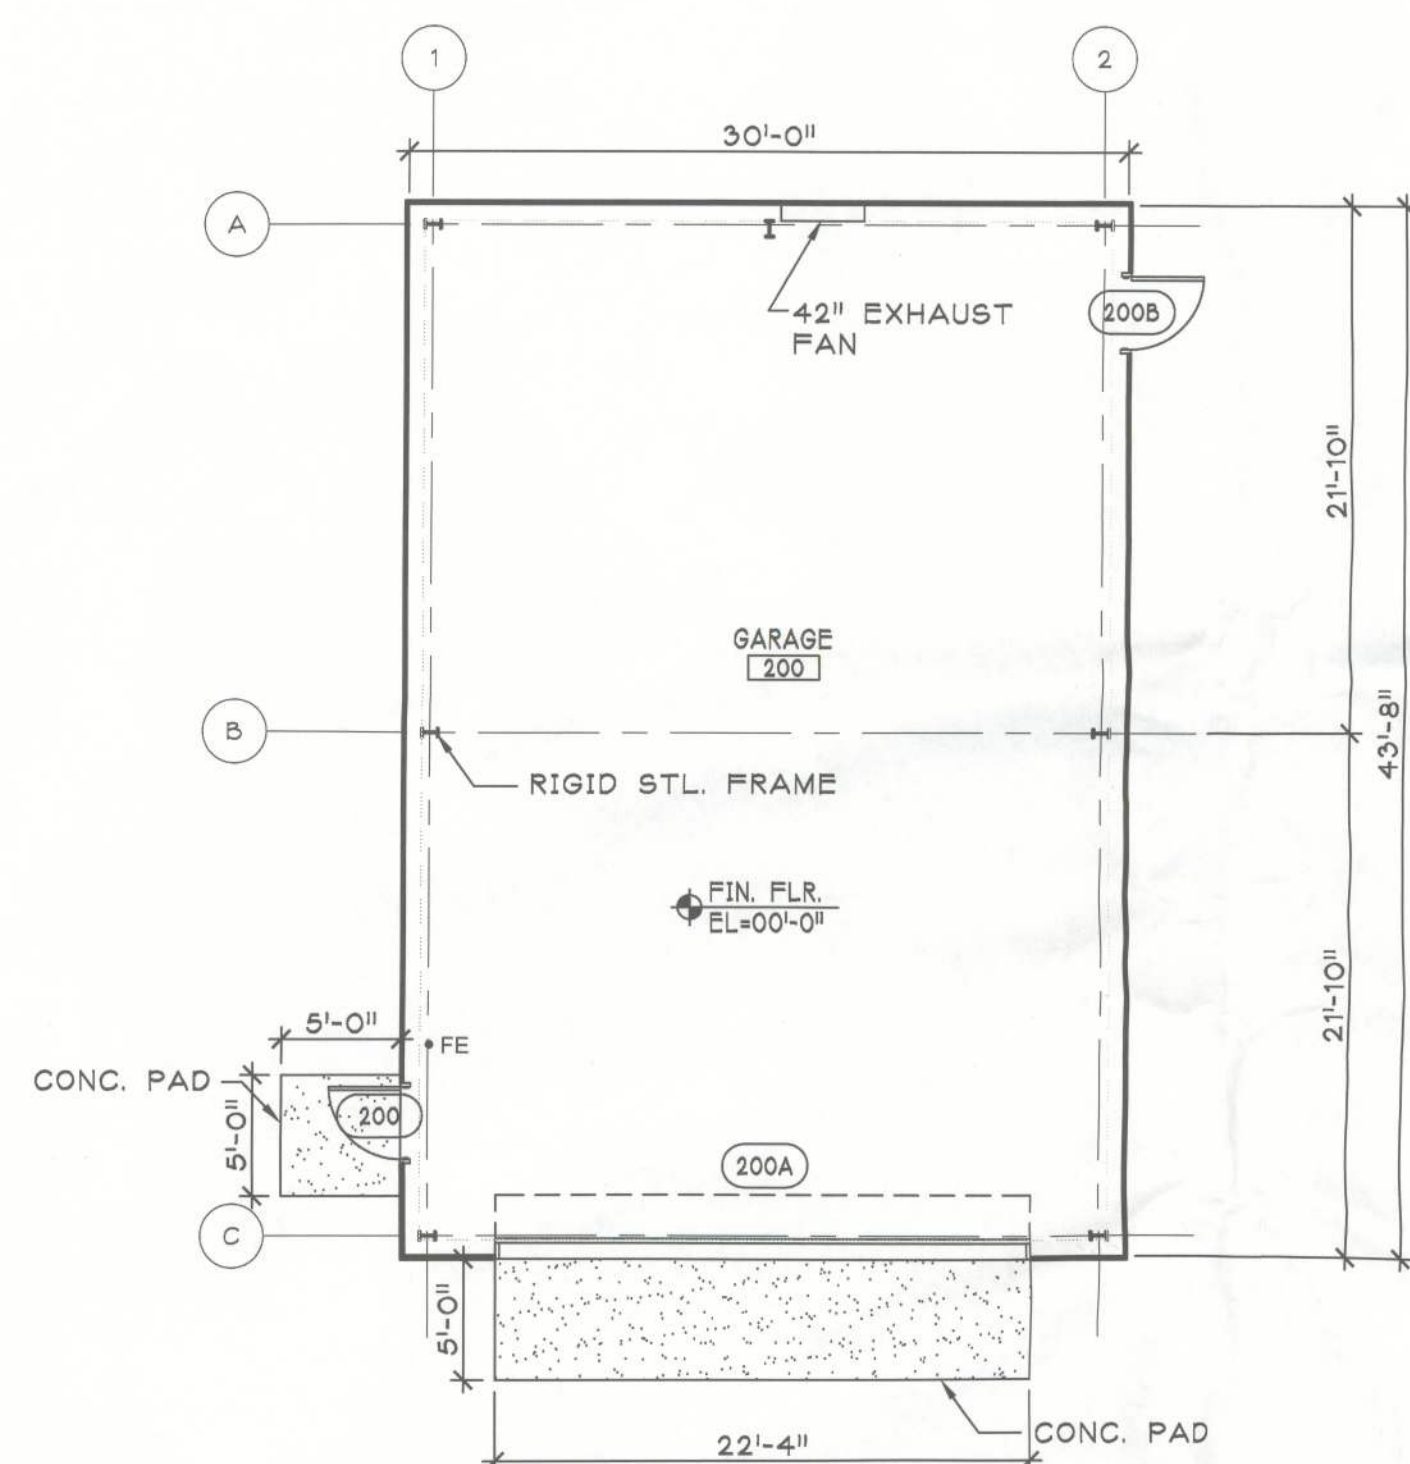

1E GARAGE PLAN
A1.2 SCALE: 1/8" = 1'-0"

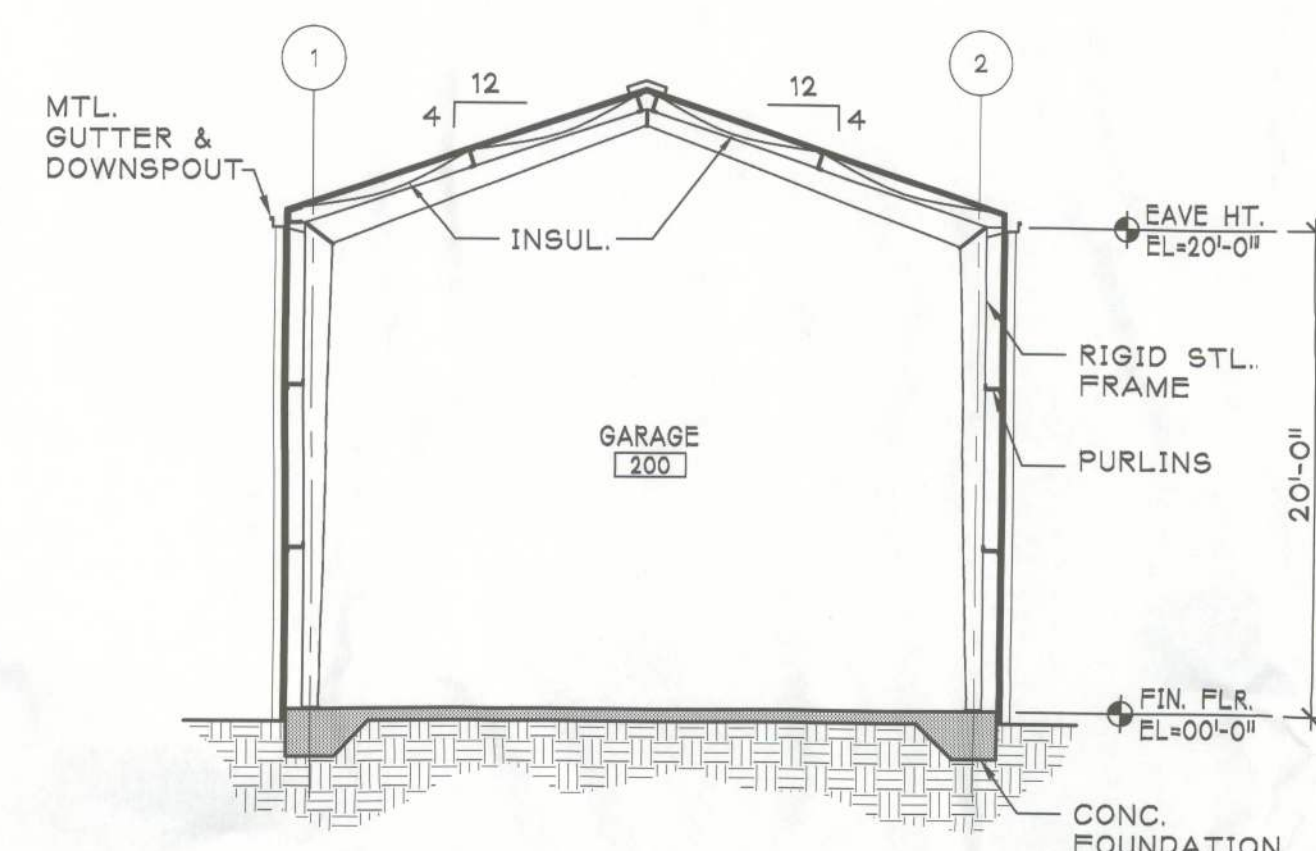

3D SECTION
A1.2 SCALE: 1/8" = 1'-0"

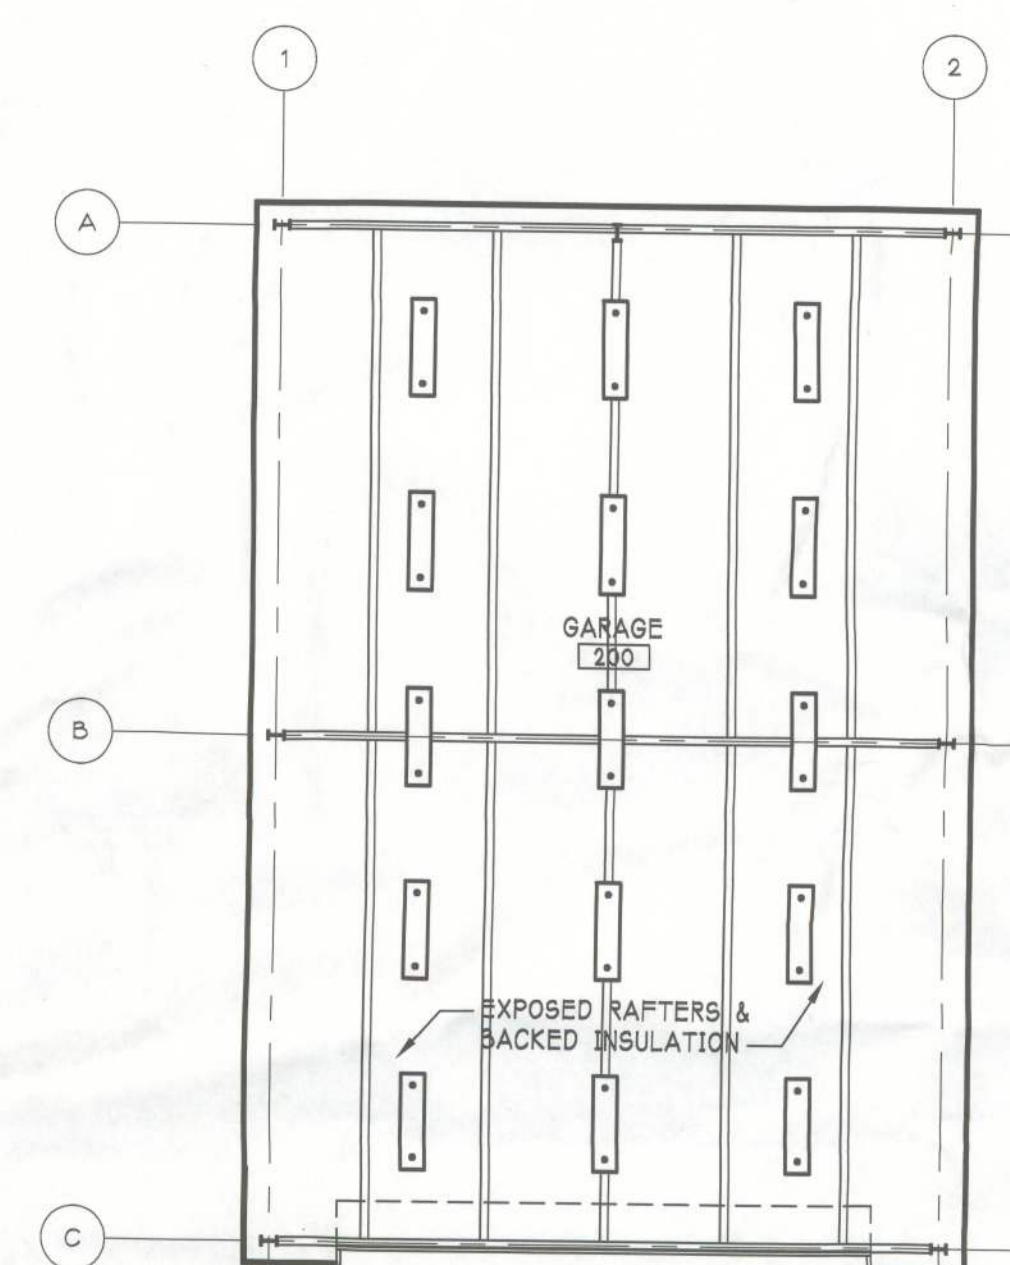

5E REFLECTED CEILING PLAN
A1.2 SCALE: 1/8" = 1'-0"

FLOOR PLAN LEGEND:

- WALL SECTION OR DETAIL TAG
- BUILDING ELEVATION TAG
- WALL MOUNTED FIRE EXTINGUISHER

GENERAL CONSTRUCTION NOTES:


- A. INTERIOR PARTITIONS TO BE WD STUDS @ 16" O.C. WITH 5/8" GYPSUM BD. BOTH SIDES AND SOUND BATTS AT CAVITY BETWEEN STUDS.
- B. INTERIOR DOOR FRAMES IN WD. STUD WALLS ARE TYPICALLY SET 4" OFF ADJACENT WALL; UNLESS OTHERWISE SHOWN.
- C. THE CONTRACTOR SHALL REPORT ANY DISCREPANCIES WITHIN CONTRACT DOCUMENTS TO THE ARCHITECT IMMEDIATELY.
- D. ESTABLISHING THE TOP OF SLAB ELEVATION AT 0'-0" IS FOR REFERENCE ONLY. REFER TO CIVIL DRAWINGS FOR ACTUAL ELEVATION OF FLOOR.
- E. ALL FURNITURE SHOWN IS FOR OWNER'S REFERENCE ONLY AND IS NOT IN CONTRACT.
- F. DIMENSIONS ARE TO THE FACE OF STUDS AND FACE OF CMU UNLESS OTHERWISE DENOTED WITH ASTERISK WHICH INDICATES FINISHED FACE OF WALL.

REFLECTED CEILING PLAN LEGEND:


- 1x4' HANGING FLUORESCENT LIGHT

GENERAL CEILING NOTES:


- A. CEILING IS THE EXPOSED BOTTOM SIDE OF ROOF DECK.
- B. SEE ELECTRICAL PLANS FOR TYPES OF FIXTURES, ETC.. FOR ADDITIONAL INFORMATION NOT SHOWN.

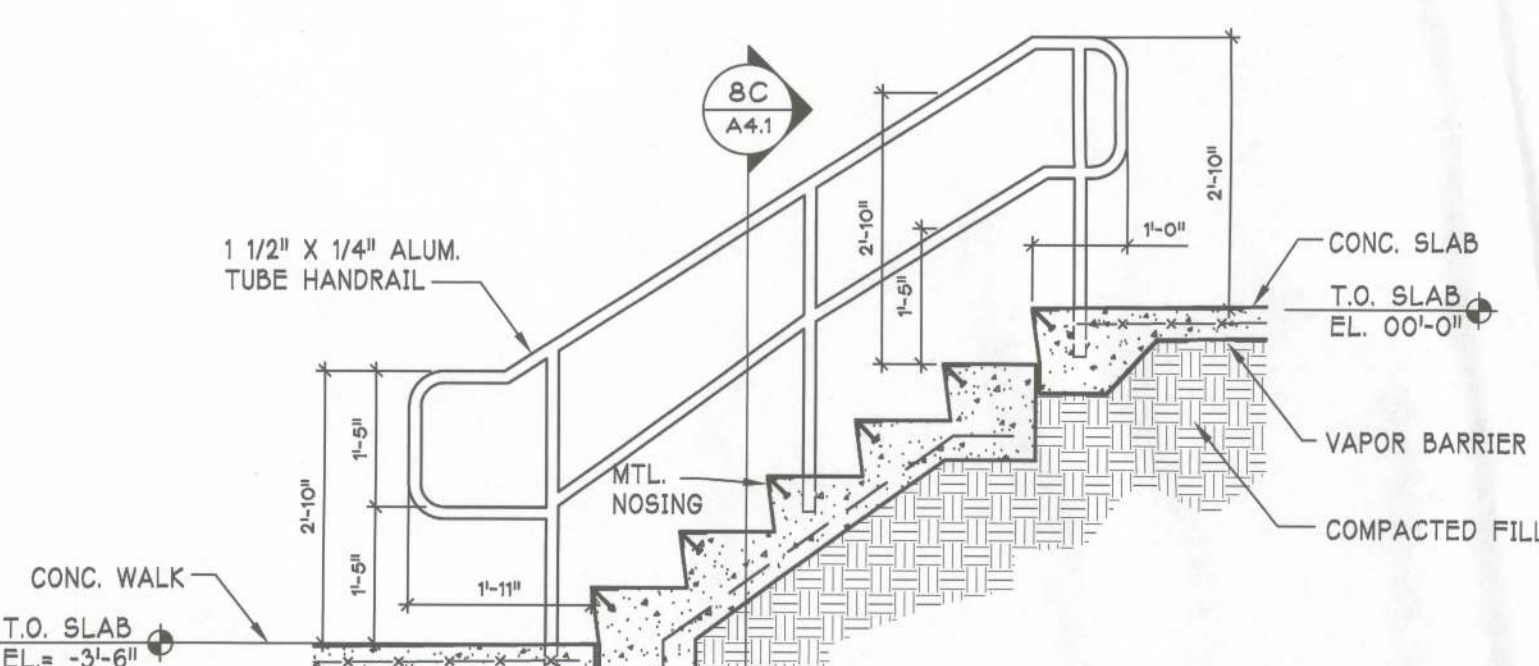


2G CONC. STEP SECTION
A1.2 SCALE: 1/2" = 1'-0"

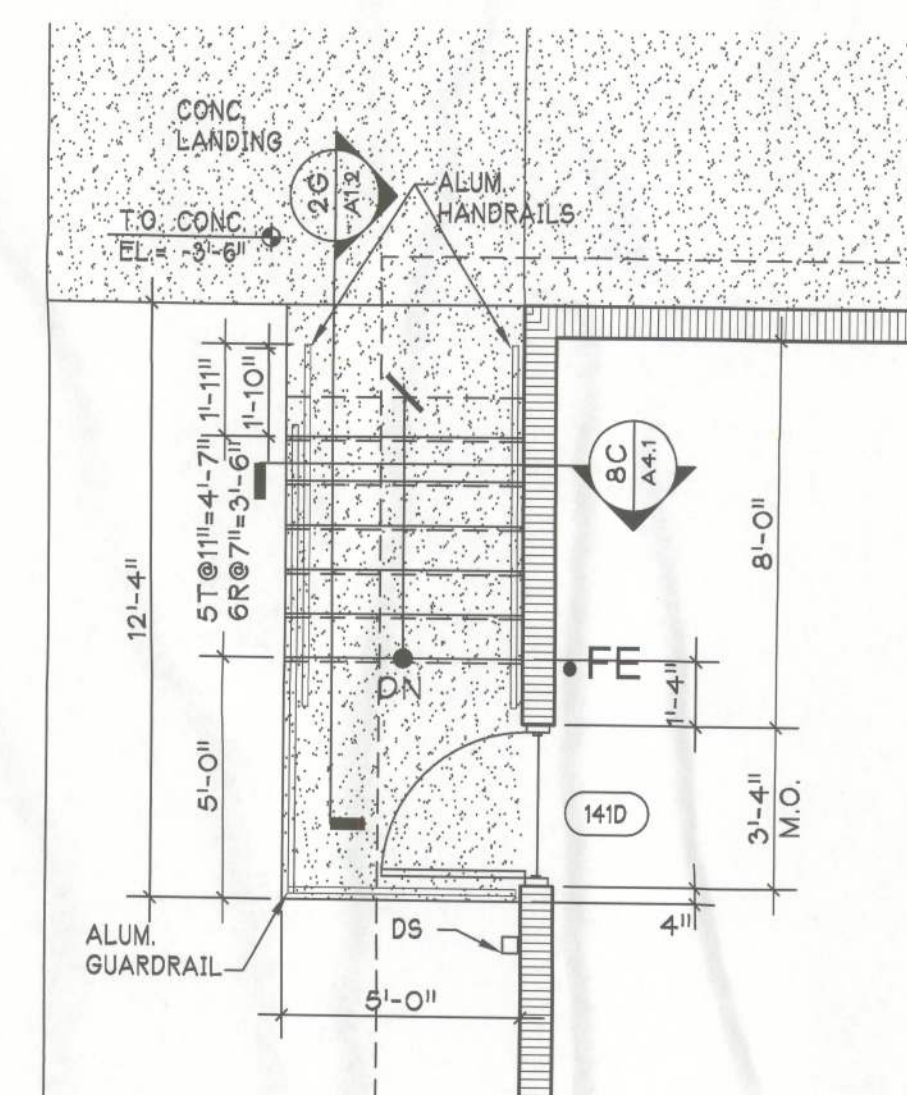

3G ENLARGED STAIR PLAN
A1.2 SCALE: 1/4" = 1'-0"

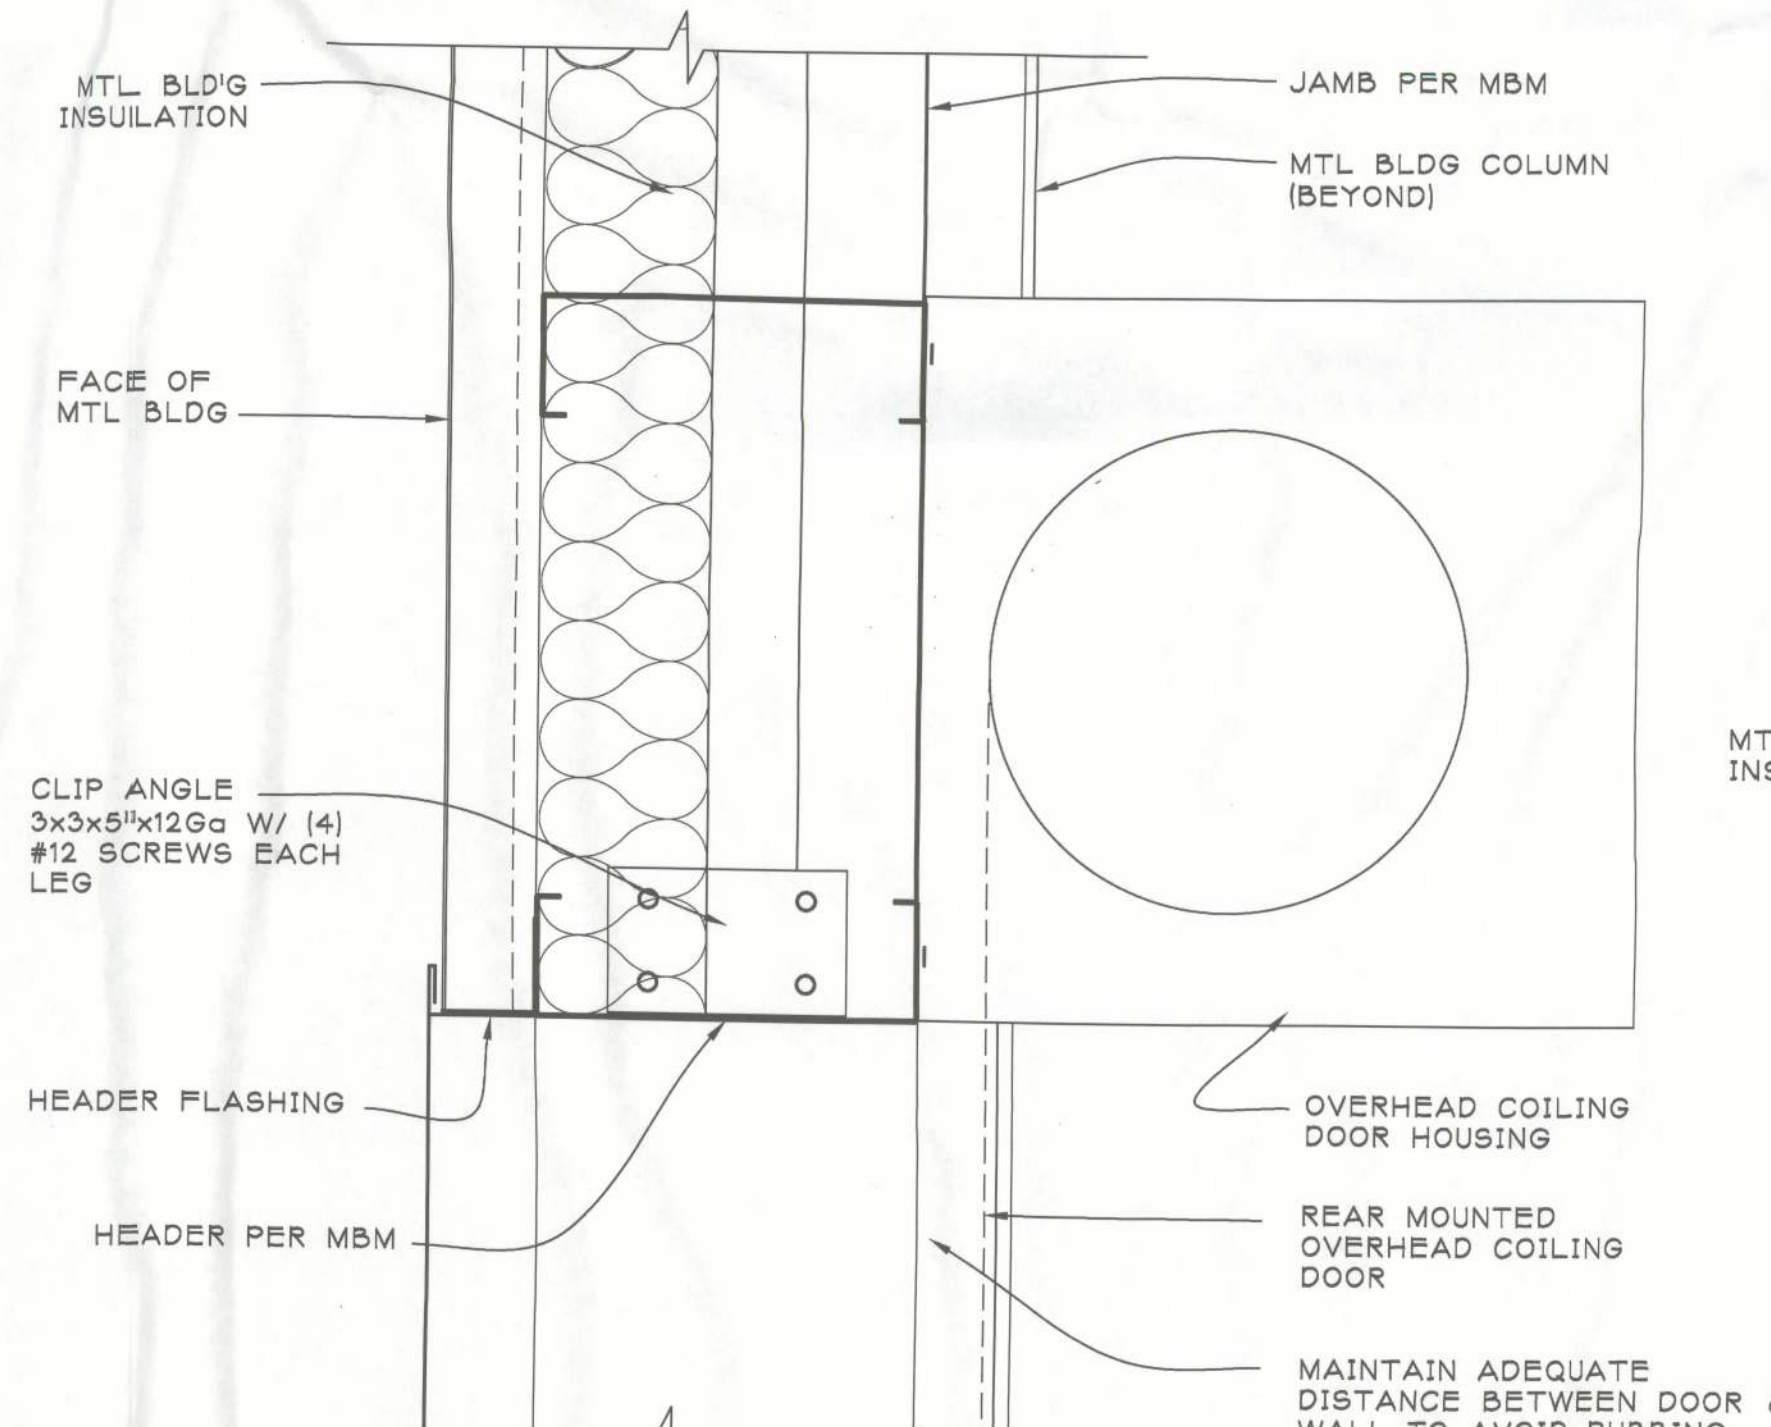

5G HEAD DETAIL @ COILING DOOR
A1.2 SCALE: 3" = 1'-0"

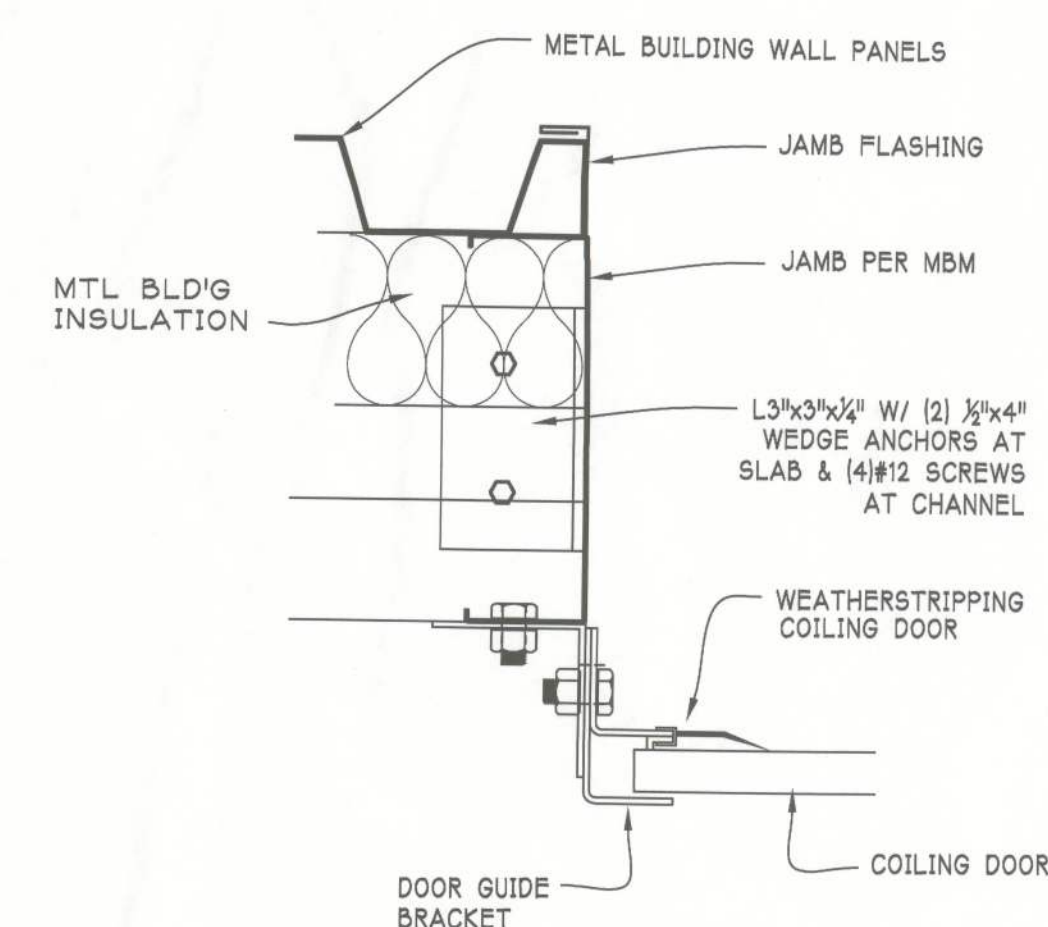

8G COILING DOOR JAMB
A1.2 SCALE: 3/16" = 1'-0"