


This item has been electronically signed and sealed by the individual named above, using a dated Digital Signature in the space below, per F.A.C. Rule 1G15-23.004. Printed copies of this document are not considered signed and sealed, and the signature must be verified in any electronic copies.

Digitally signed by Christopher Floegel
DN: cn=Christopher Floegel,
ou=03430000006732478F30000065C2,
o=ILIC ENGINEERING SOLUTIONS, C=US
Date: 2022.07.22 09:28:45-0400

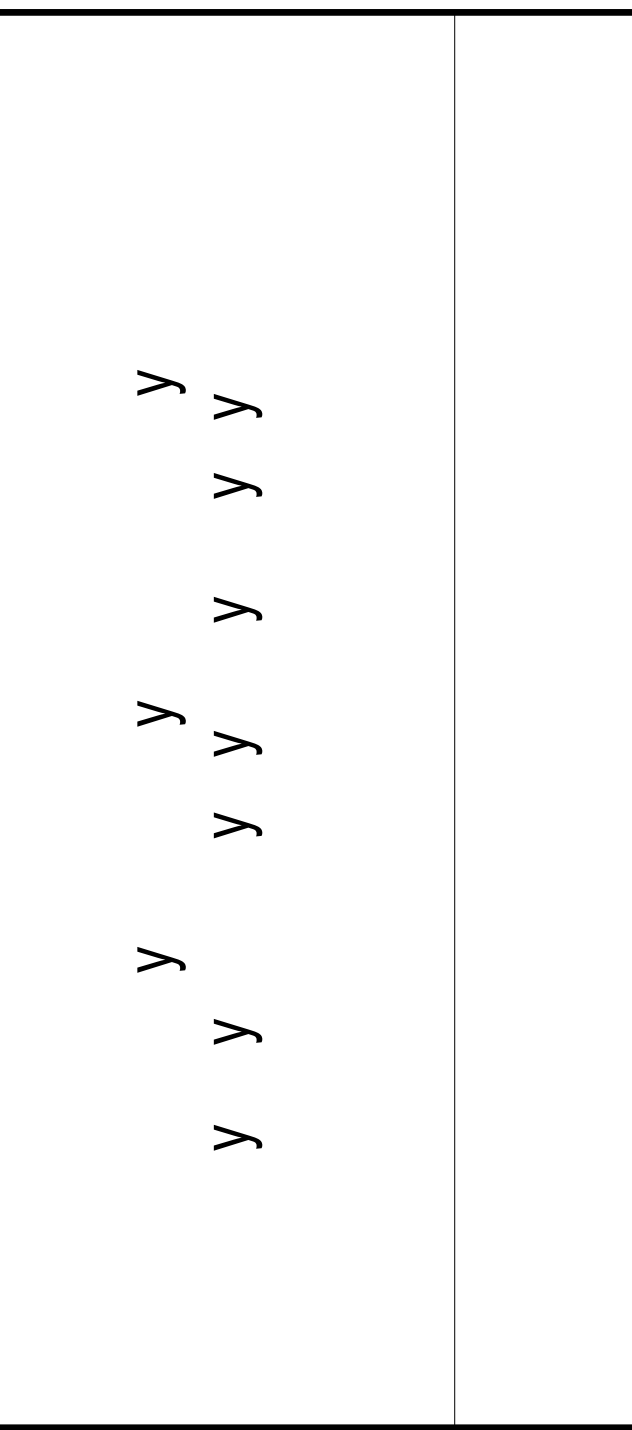

SCALE 1/8" = 1'-0"

[illegible]

REVISIONS

DRAWN BY	D PETERSON
APPROVED BY	F ROBERTSON
CHECKED BY	F GARDNER
DATE	JULY 24, 2020

TITLE


PLUMBING OVERALL ROOF PLAN

PROJECT NO.	50101397
-------------	----------

P-131

SHEET NO.

DESTROY AFTER USE

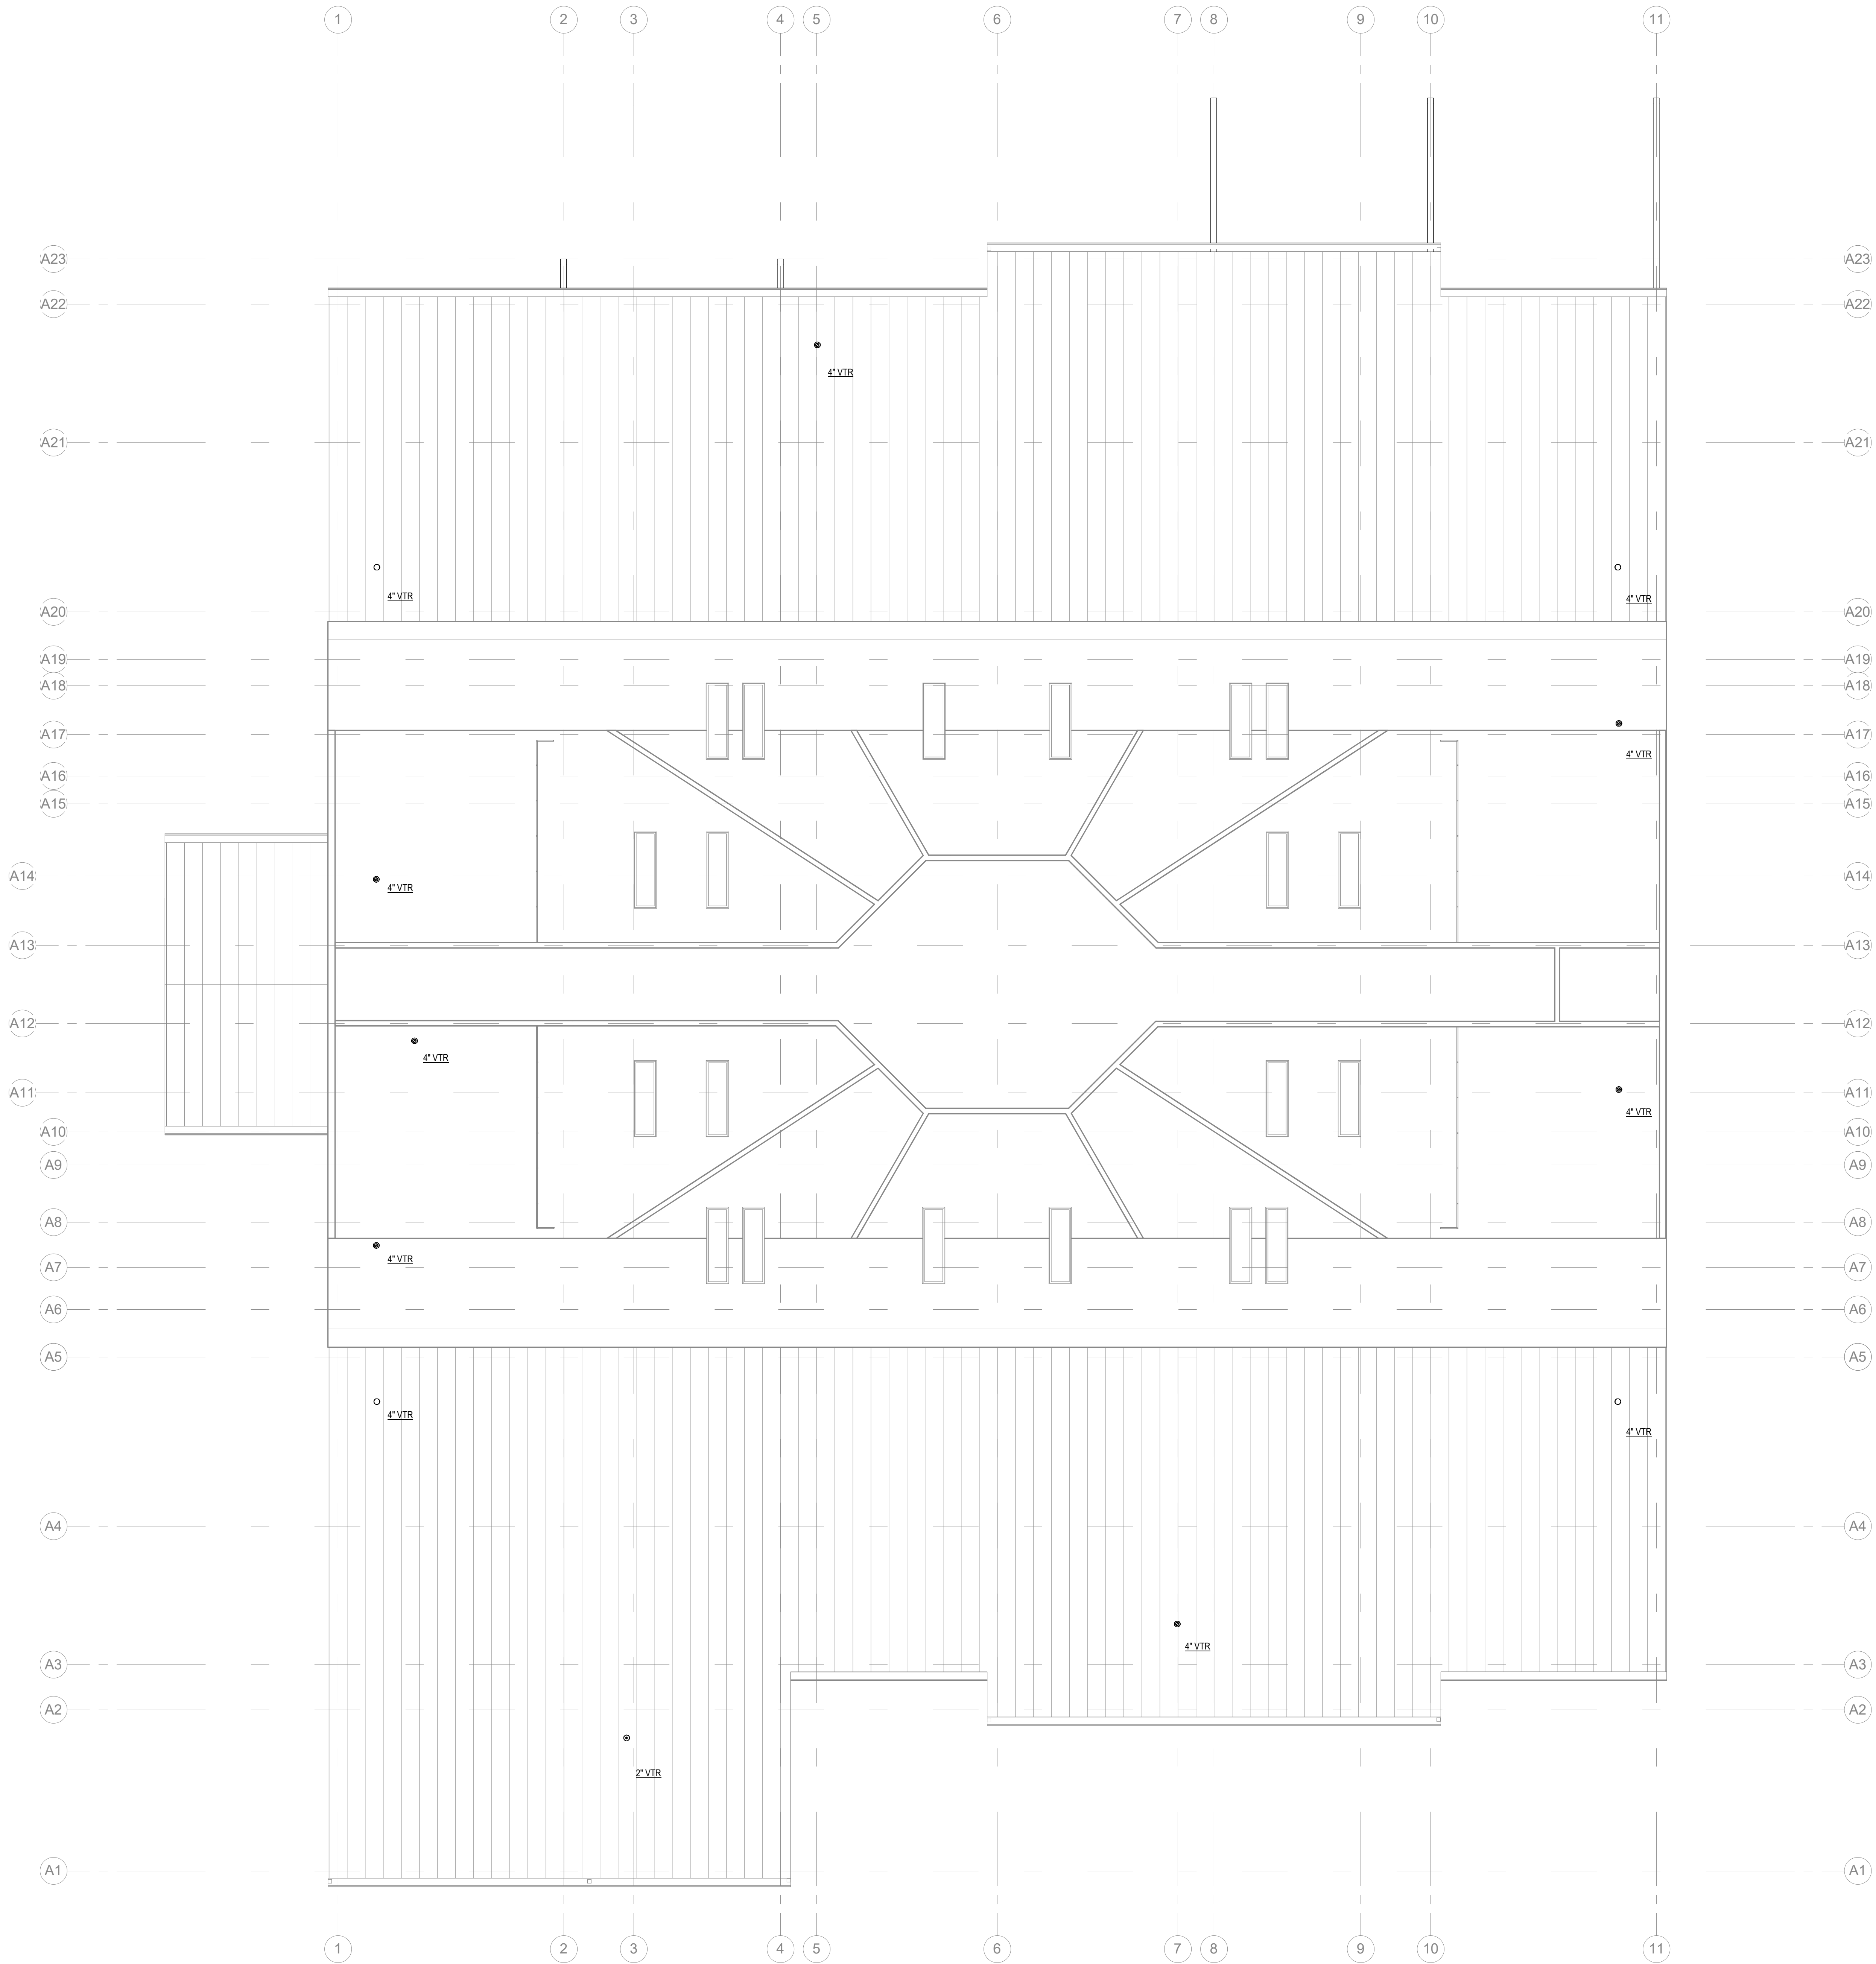

A6 PLUMBING OVERALL ROOF PLAN
Scale: 1/8" = 1'-0"