



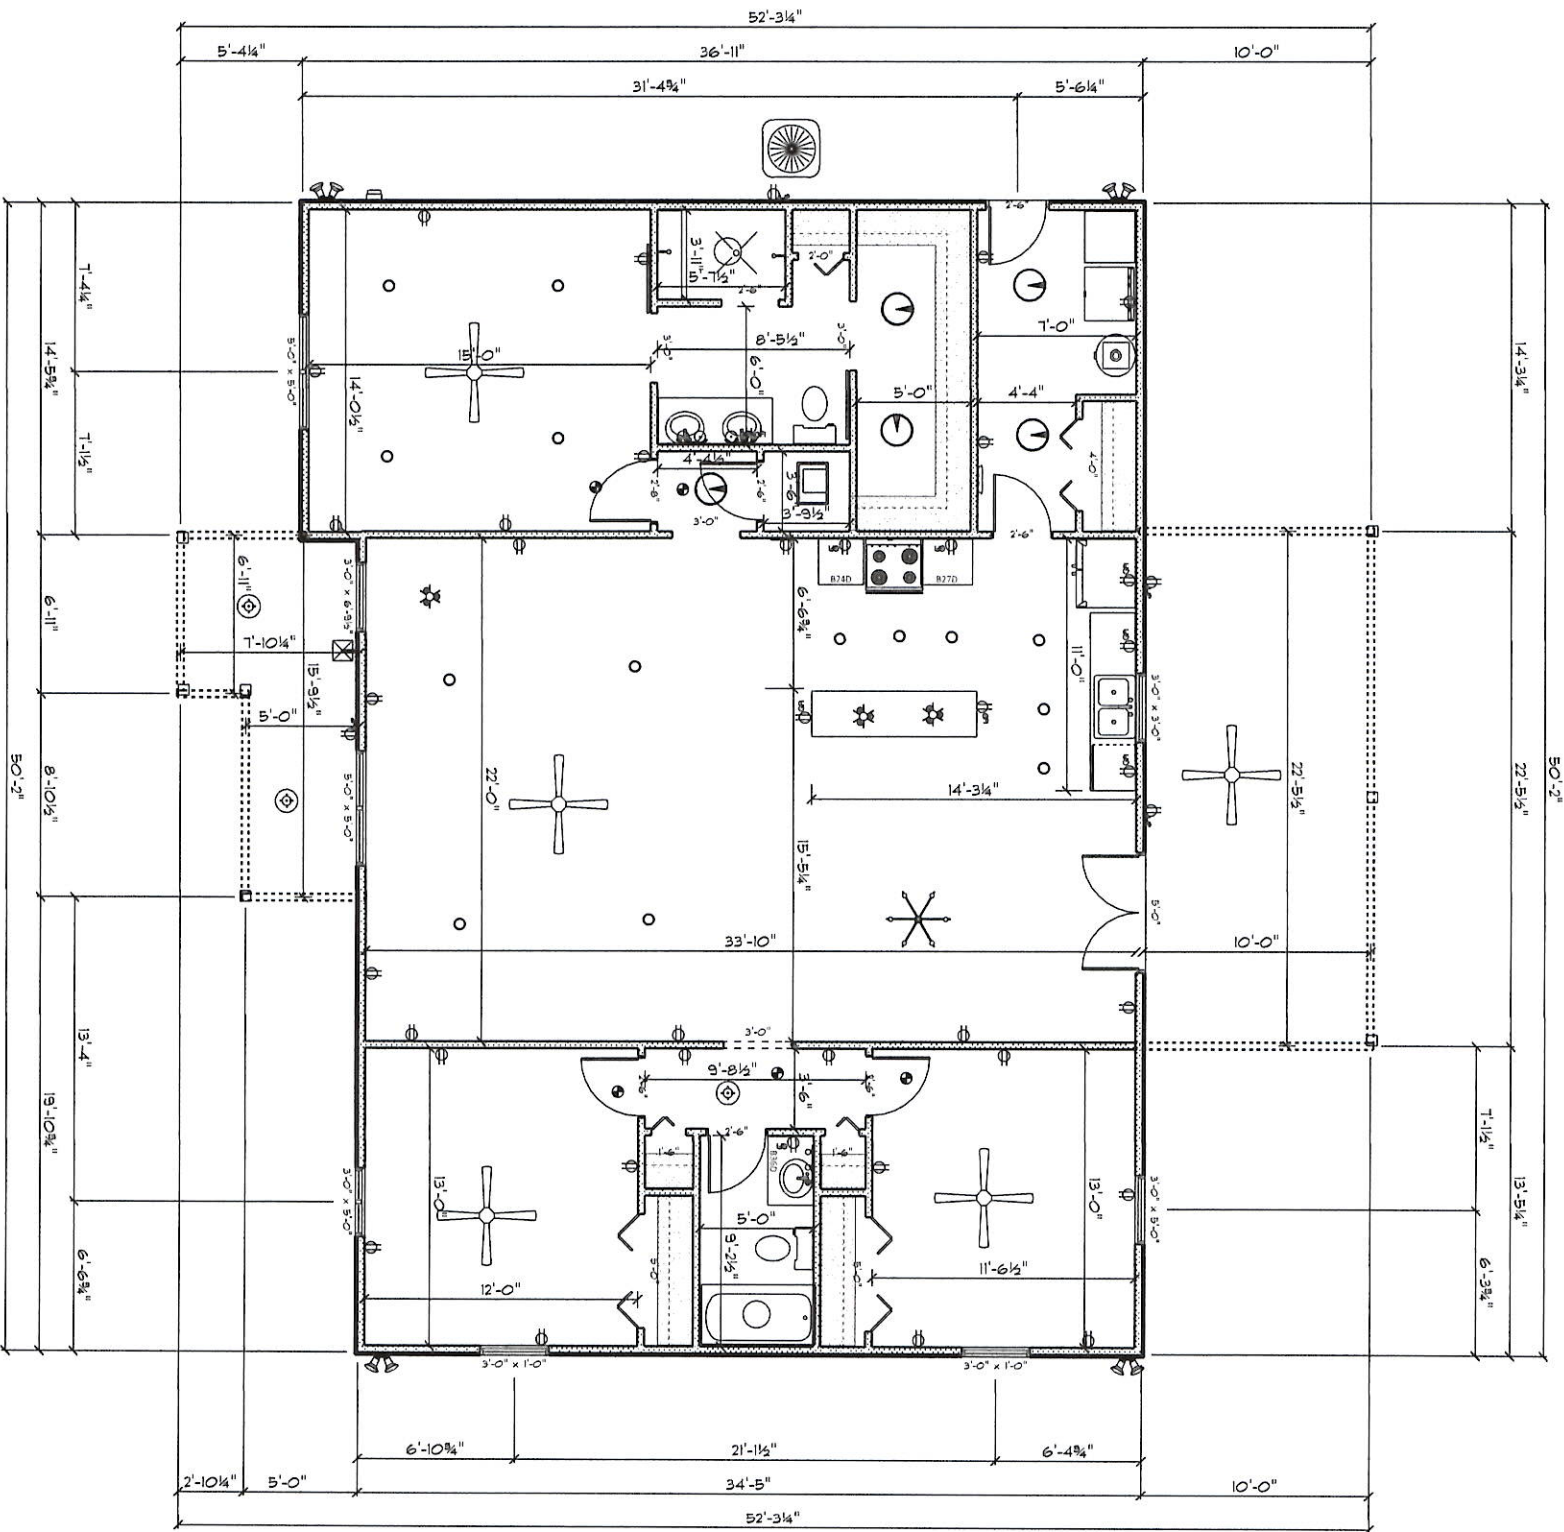

ELECTRICAL LEGEND		
ELECTRICAL	COUNT	SYMBOL
ceiling fan 1 blade 01	5	
can light 6inch	14	
ceiling light 01	5	
ceiling light 22	3	
ceiling light 30	3	
ceiling light vent round	2	
chandelier 03	1	
exterior craftsman light fixture	1	
spotlight double with motion detector	4	
cover switch	1	
electrical panel	1	
stove outlet	1	
outlet	28	
outlet 01	9	
outlet wp	4	
smoke detector	5	
vanity bar light 02	1	
wall mounted 02 1 lights	2	


AREA SCHEDULE	
NAME	AREA
Total Heated SqFt 1785.0 sq ft.	
Porches SqFt	329.3 sq ft.

John Norris Construction, LLC
Voidanoff Residence
Columbia County, FL

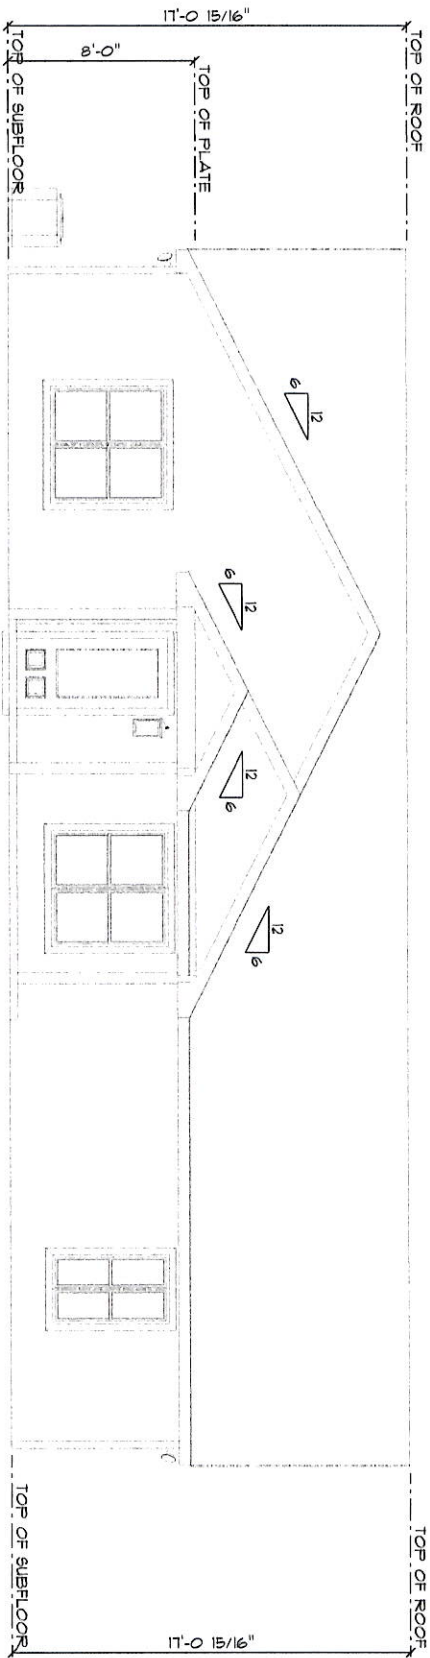


FRONT ELEVATION

SCALE: 1/8" = 1'-0"

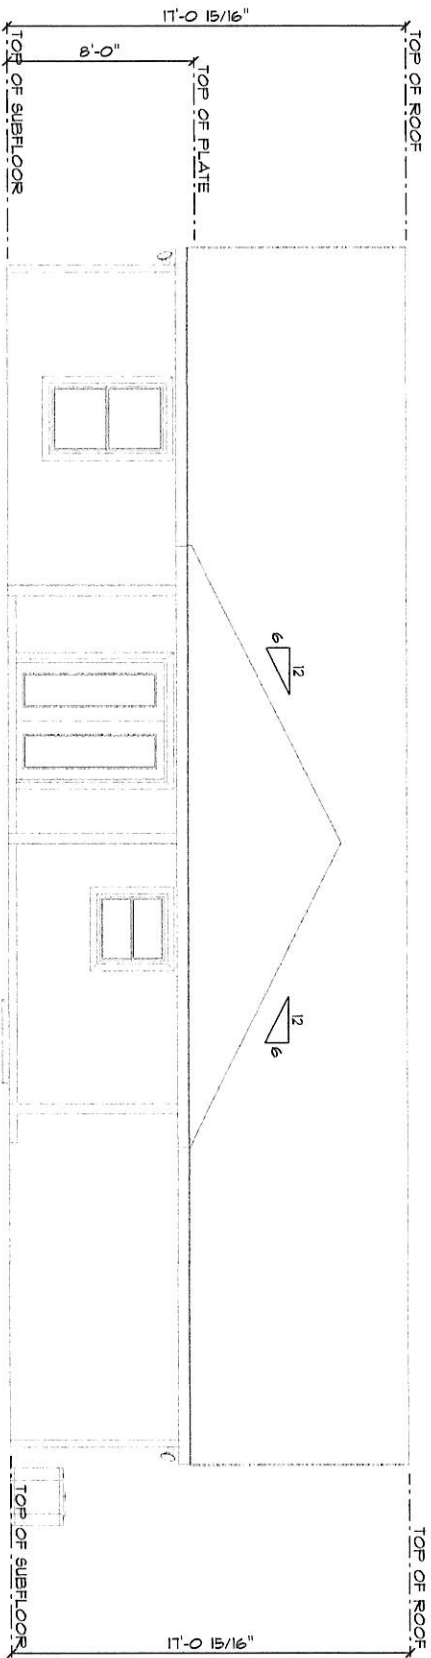


REAR ELEVATION

SCALE: 1/8" = 1'-0"

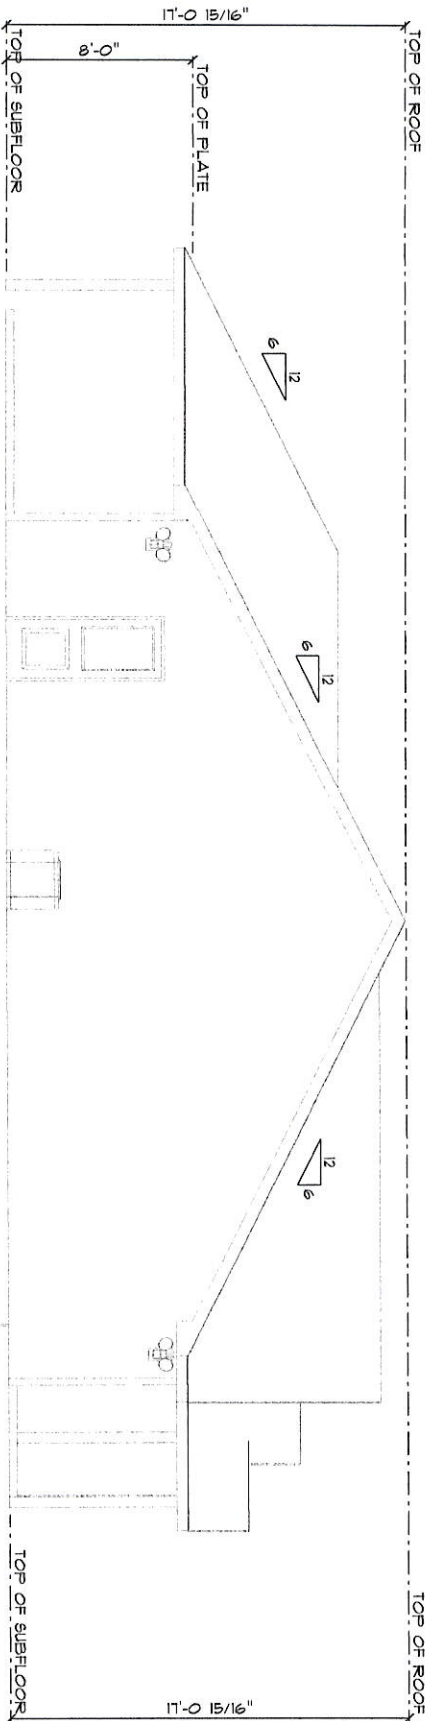

LEFT ELEVATION

SCALE: 1/8" = 1'-0"

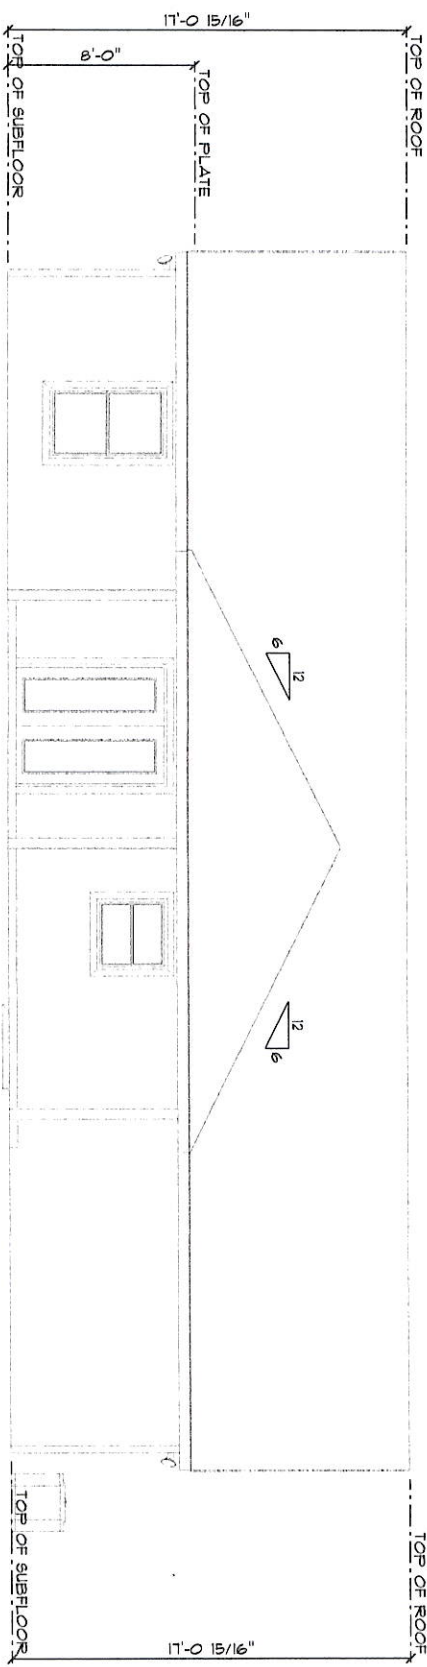

REAR ELEVATION

SCALE: 1/8" = 1'-0"