
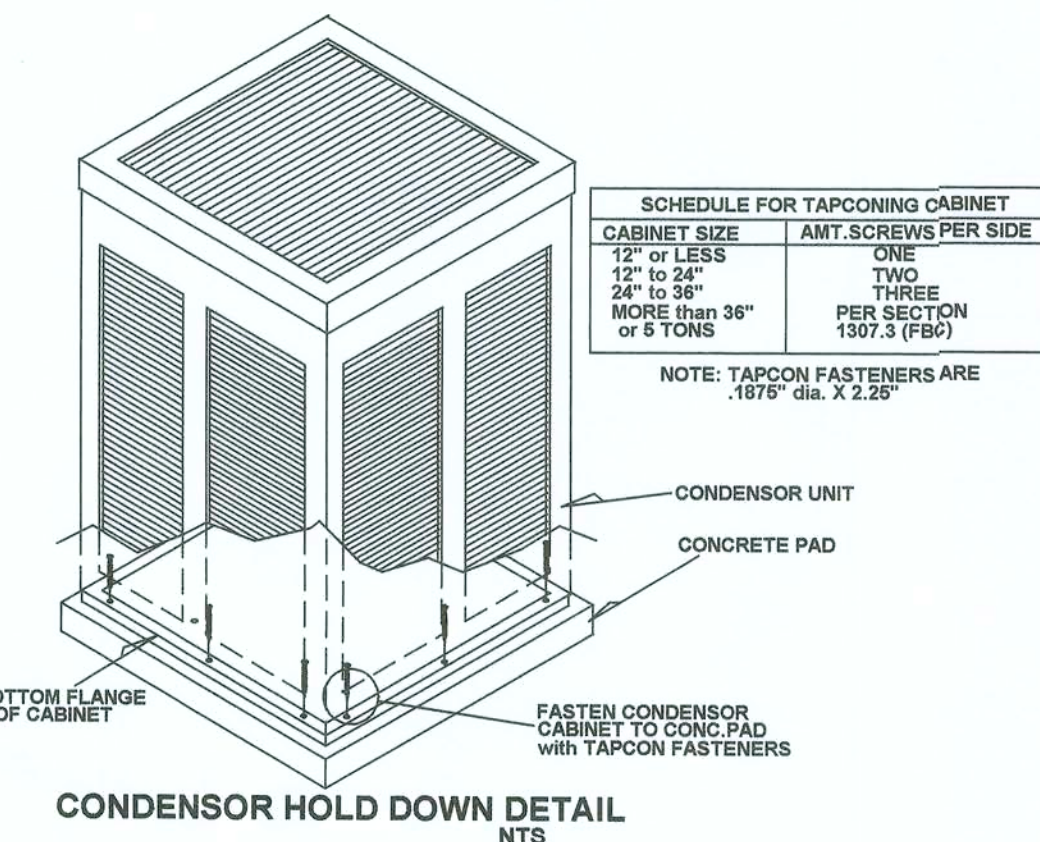
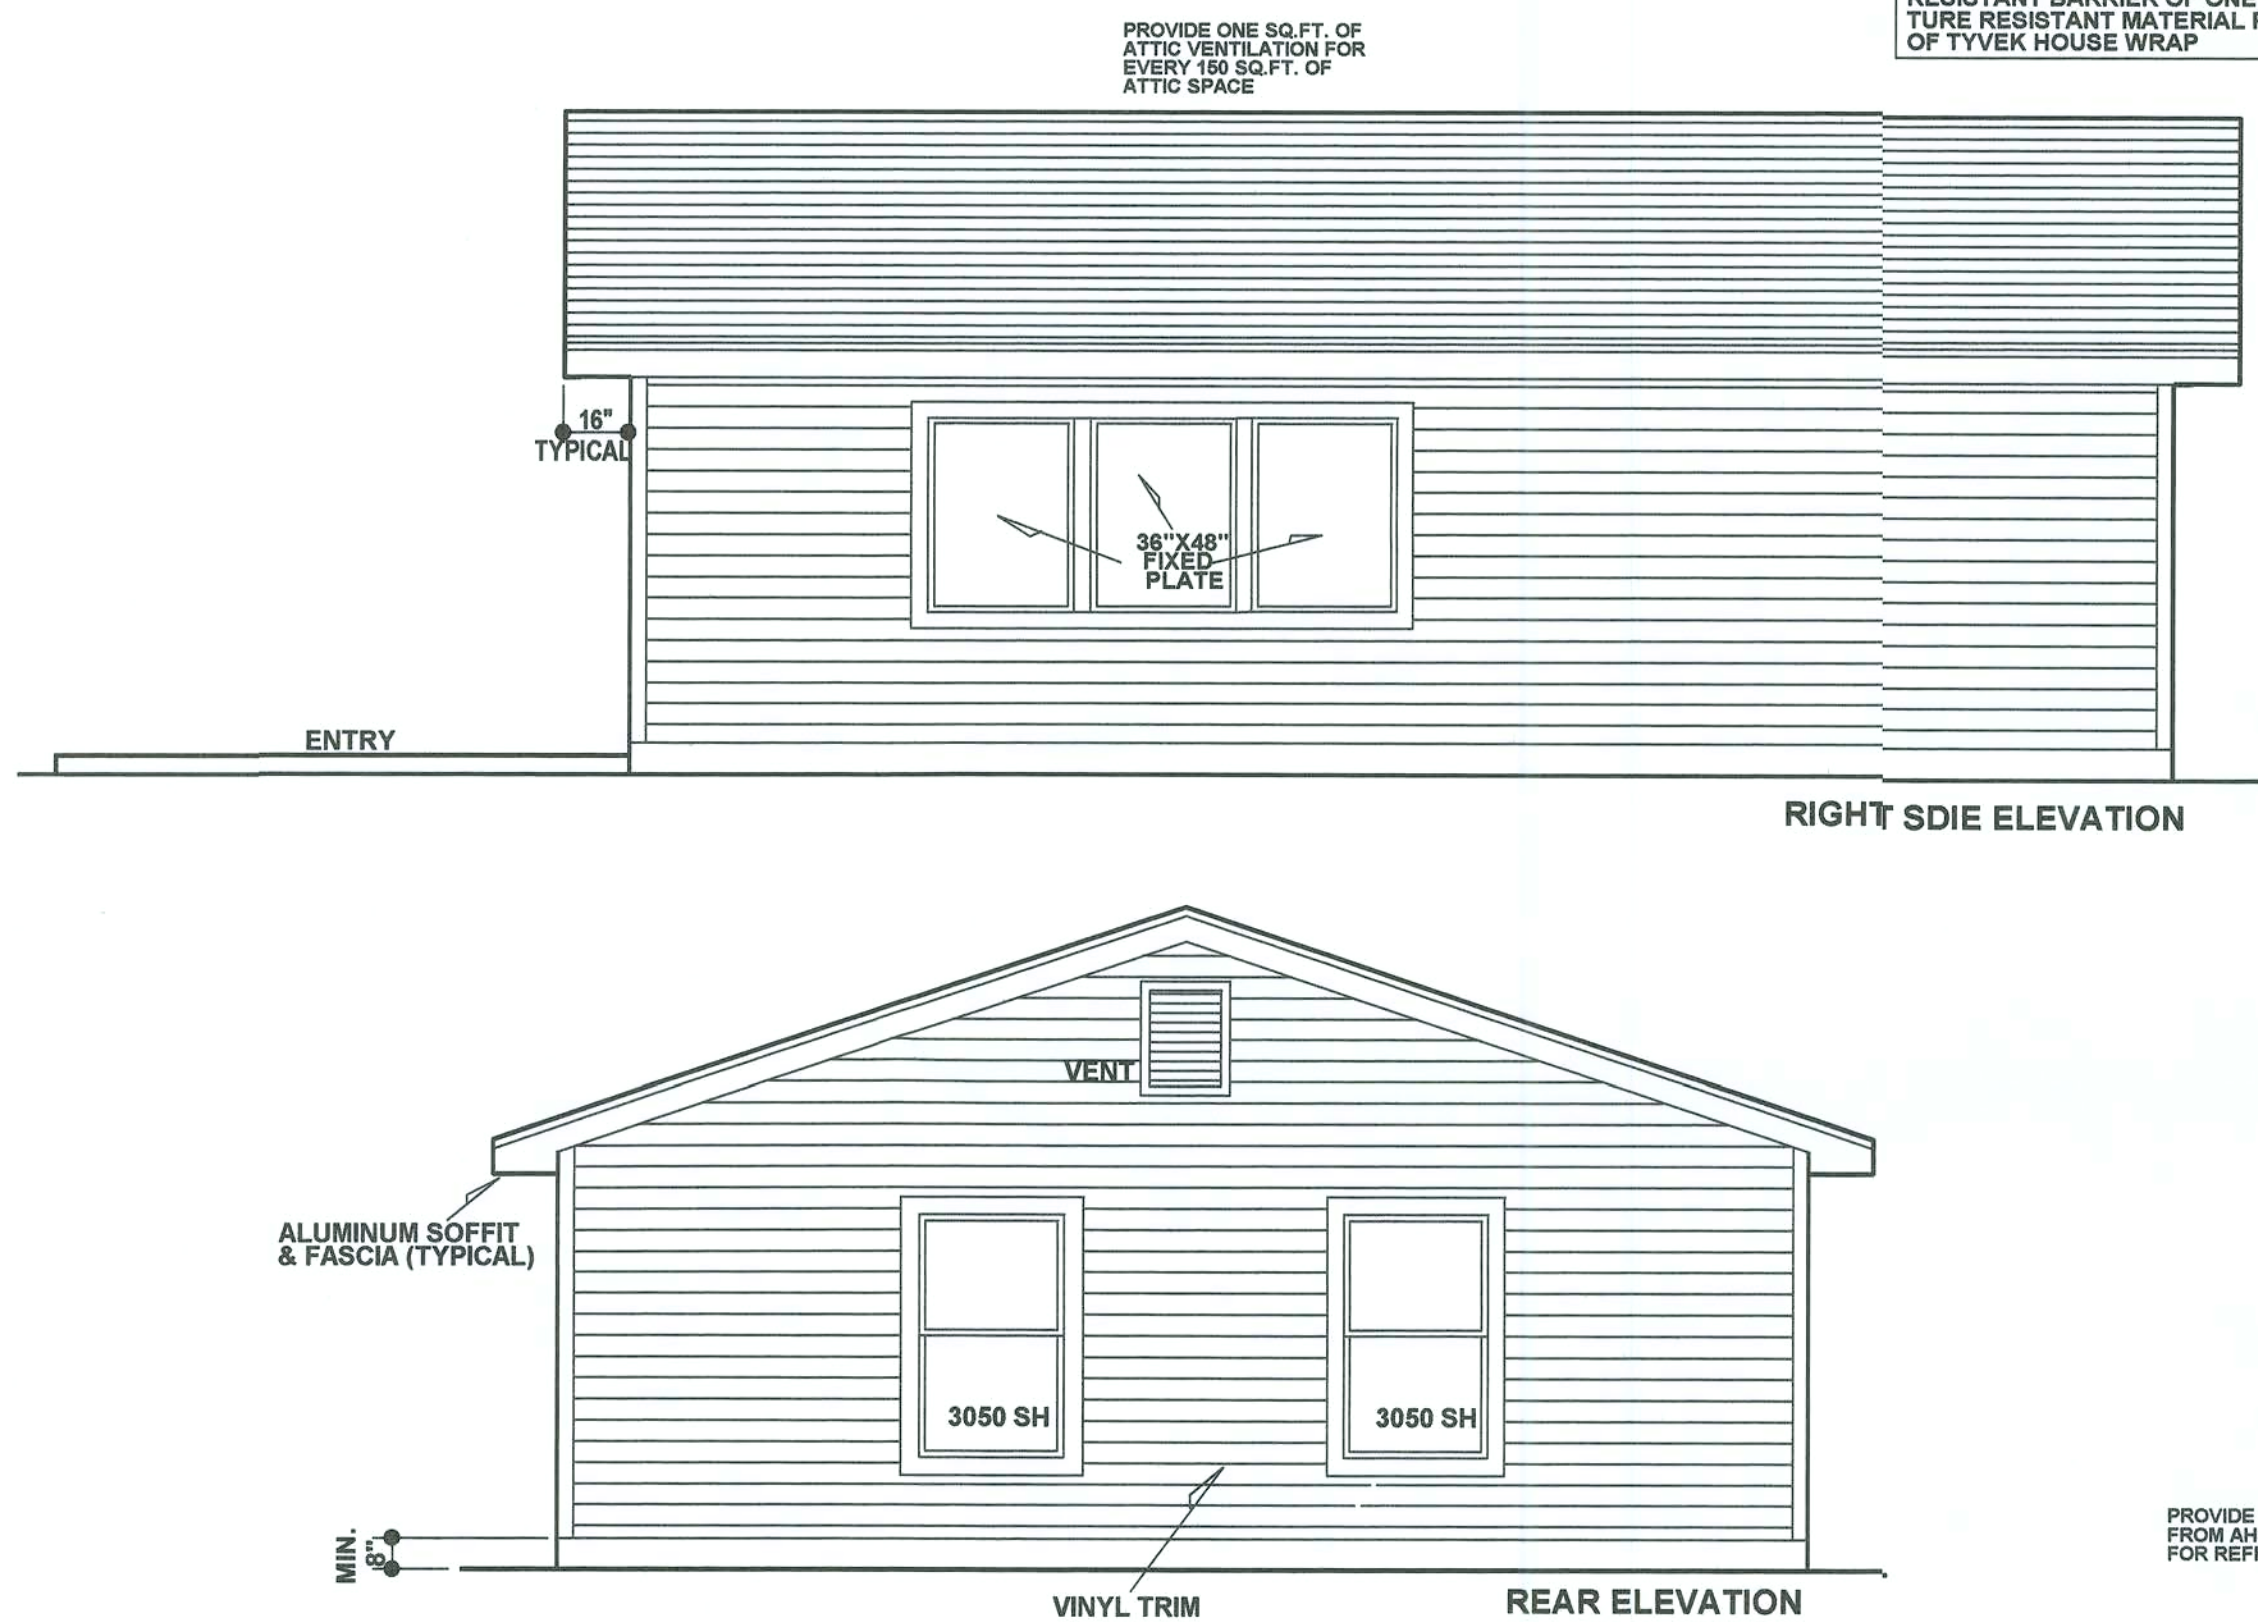


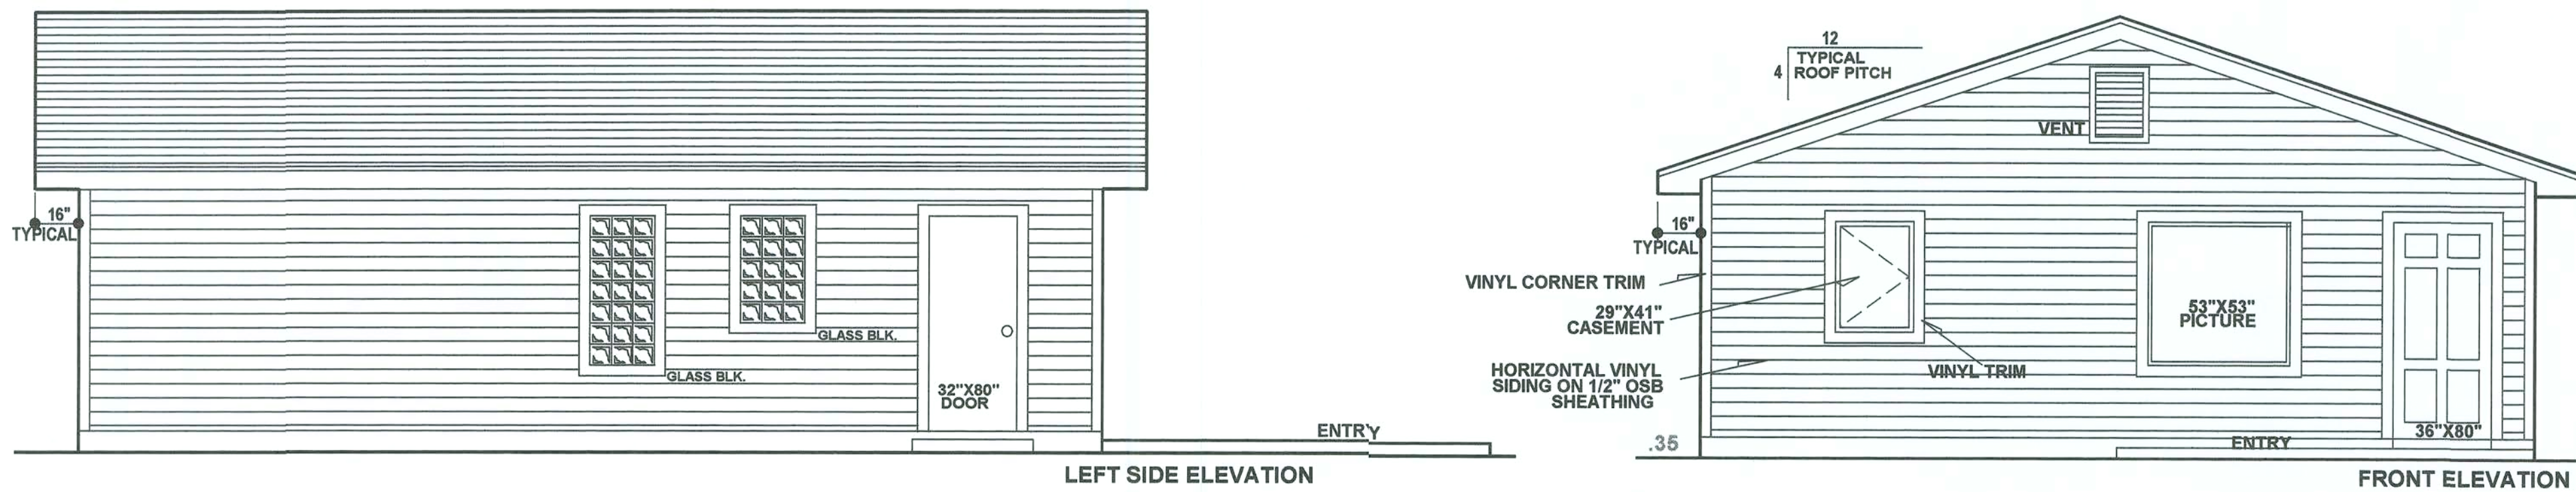

DOOR SCHEDULE			
No.	SIZE	DESCRIPTION	AMOUNT
1	3'0\"x6'8"	EXTERIOR WOOD/SOLID CORE	1
2	2'8\"x6'8"	INTERIOR WOOD/SOLID CORE	4
3	2'0\"x6'8"	LOUVERED BIFOLD	1
5	2'8\"x6'8"	EXTERIOR WOOD/SOLID CORE	1

NOTE: ON DEMAND WATER HEATER & KITCHEN RANGE SHALL BE GAS

PRODUCT APPROVALS

ALL PLANS SUBMITTED FOR PLAN REVIEW MUST INCLUDE INFORMATION MEETING THE REQUIREMENTS OF FLORIDA STATUTES 553.842 AND FLORIDA ADMINISTRATIVE CODE 6B-7.2 FOR EIGHT PRODUCT GROUPS:

- WINDOWS
- EXTERIOR DOORS
- SHUTTERS
- STRUCTURAL COMPONENTS
- SKYLIGHTS
- PANEL WALLS
- ROOFING
- NEW BUILDING PRODUCTS (AFFECTING STRUCTURAL INTEGRITY OF BUILDING)


FLORIDA PRODUCT APPROVAL NUMBERS MAY BE OBTAINED FROM SUPPLIERS OR BY VISITING THE DEPARTMENT OF COMMUNITY AFFAIRS' FLORIDA BUILDING CODE WEB SITE AT www.floridabuilding.org. USE THE PRODUCT APPROVAL LINK TO SEARCH FOR CURRENT APPROVED PRODUCTS.

PRODUCT TYPE	APPROVAL NUMBER	MANUFACTURER and DESCRIPTION
WINDOWS	FL 663.1 FL 663.2 FL 639.3	BETTERBILT (SINGLE HUNG/INSULATED)
EXTERIOR DOORS	FL 498.1 FL 639.3	JELD WEN WOOD SOLID CORE & WOOD STEEL CLAD
GARAGE DOOR	FL 642.2	CLOPAY BUILDING PRODUCTS, INC. STEEL paneled/overhead
SHINGLES	FL 86.1	OWENS CORNING COMPANY FIBREGLAS COMPOSITE
ROOFING UNDERLAYMENT	FL 2346.1	THE WARRIOR COMPANY 30# FELT
ROOF TRUSS CONNECTORS	474.108/474.109 474.115/474.118 1423.19/1901.68 1901.67/3760.93	SIMPSON STRONG TIE COMPANY WOOD ROOF CONNECTORS
TRUSS PLATES	FL 1999	SIMPSON STRONG TIE COMPANY PLATES FOR TRUSS MANUFACTURING
CONCRETE LINTELS	FL 168	CASTCRETE COMPANY

NOTE: WHERE LOT LINES AND/OR SLOPES PROHIBIT 6 INCHES OF FALL WITHIN 10 FEET OF STRUCTURE, DRAINS OR SWALES SHALL BE CONSTRUCTED TO ENSURE DRAINAGE AWAY FROM SAID STRUCTURE.

THIS STRUCTURE HAS BEEN DESIGNED IN ACCORDANCE WITH THE 2004 RESIDENTIAL BUILDING CODE ALONG WITH THE 2006 RESIDENTIAL BUILDING CODE SUPPLEMENTS FOR 110 MPH OR LESS WIND SPEED AND COMPLIES WITH SECTION R301.1 DESIGN CRITERIA. WIND LOADING CRITERIA IS GOVERNED BY ASCE 7 - 02. BASIC WIND SPEED: 110 MPH. WIND IMPORTANCE FACTOR: 1.0. WIND EXPOSURE CATEGORY: B. INTERNAL PRESSURE COEFFICIENT: +0.18 (FULLY ENCLOSED). AVERAGE DESIGN WIND PRESSURE: 26 psf. WIND PRESSURE FOR COMPONENTS & CLADDING FOR WALL ELEMENTS SHALL BE (+) 26.9 & (-) 34.7 psf.

CERTIFIED TO 110 MPH WIND ZONE PER FLORIDA BUILDING CODE, 2004 EDITION, ONLY AND THE 2006 SUPPLEMENTS OF SAID CODE

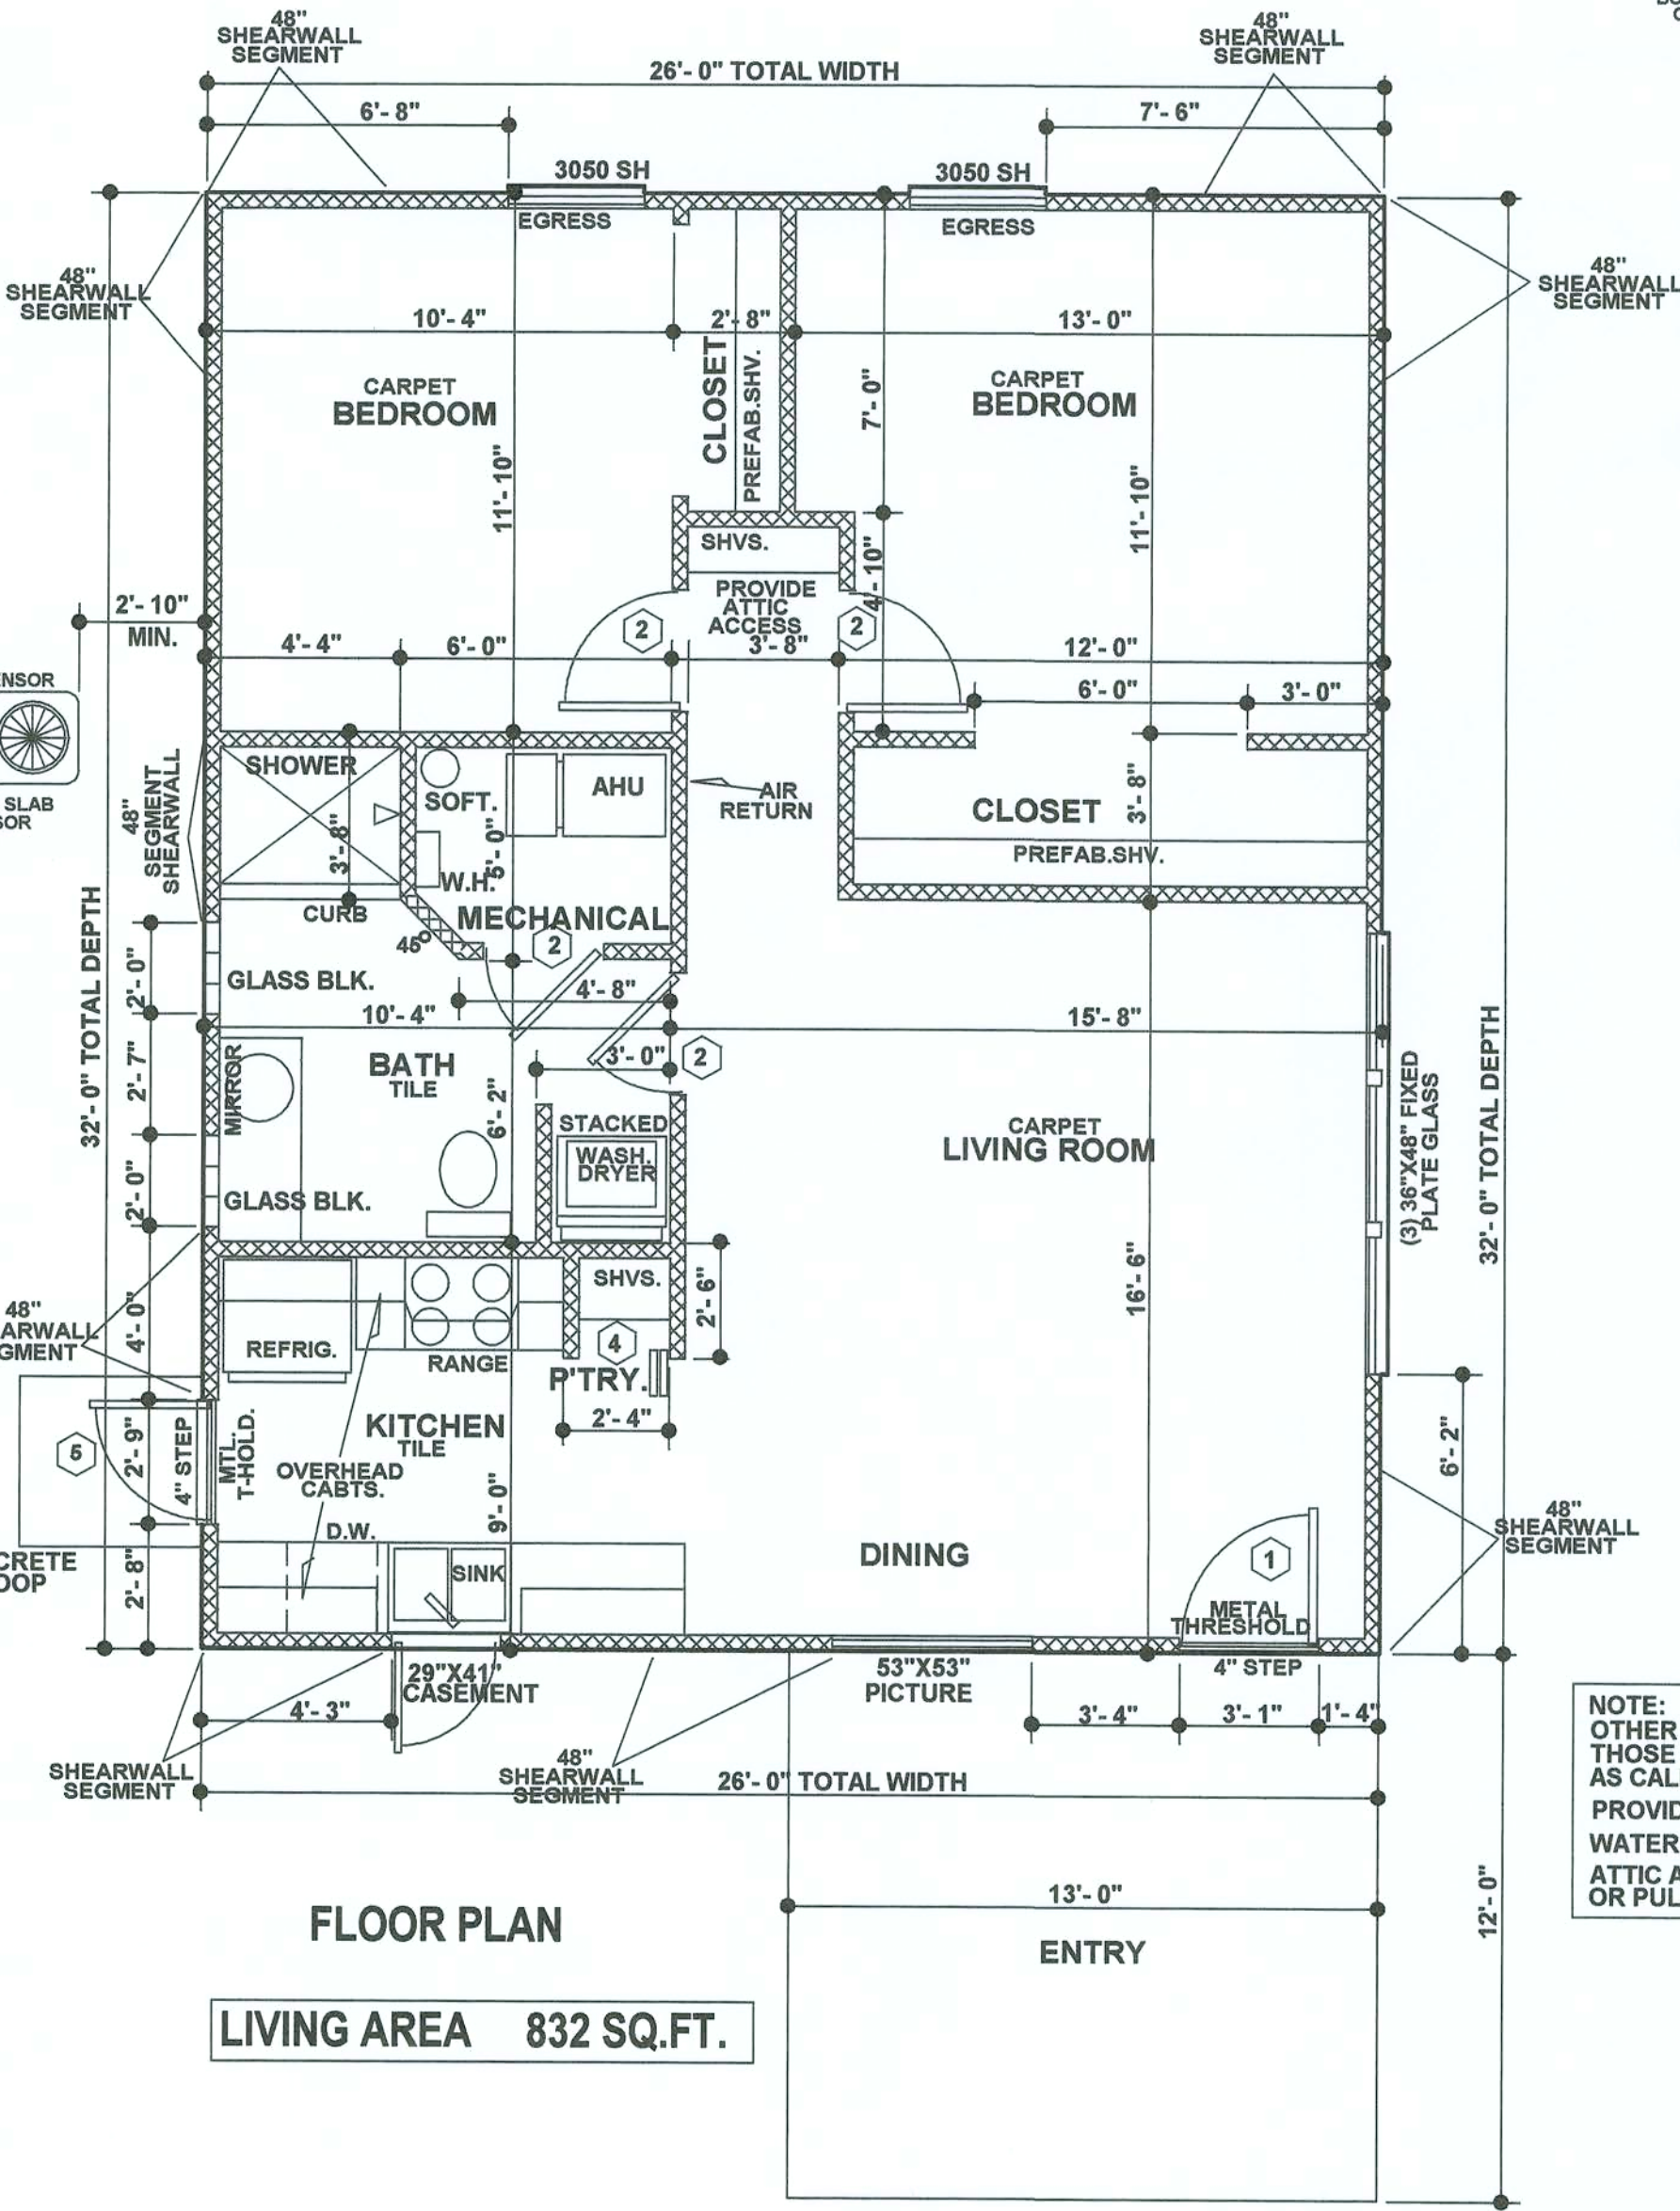


NOTE: OTHER WINDOWS MAY BE SUBSTITUTED FOR THOSE SHOWN. MAINTAIN AS CLOSE A SIZE AS CALLED FOR. PROVIDE VENTED HOOD FOR RANGE. WATER HEATER SHALL BE INSTANT (ON-DEMAND) TYPE. ATTIC ACCESS SHALL BE A MINIMUM 20\"x36\" OR PULL-DOWN STAIRS.

ENGINEER OF RECORD
JAMES LEE SMITH, P.E.
2221 LEE ROAD, SUITE 24
WINTER PARK, FL 32789
PHONE (407) 744-1111

THESE DOCUMENTS ARE THE PROPERTY OF JAMES LEE SMITH & ASSOCIATES, INC. AND ANY FLORIDA DESIGN GROUP FOR ANY PURPOSE WITH OUT THE WRITTEN CONSENT OF THE AFORESAIDED.

THESE DOCUMENTS ARE NOT VALID FOR PERMITTING UNLESS SIGNED AND SEALED WITH THE EMBOSSED SEAL OF THE PROFESSIONAL ENGINEER.
BOB MADDOX (NCBDC/ABD)
AMERICAN SOCIETY OF MECHANICAL ENGINEERS
FLORIDA SOCIETY No. FL-148

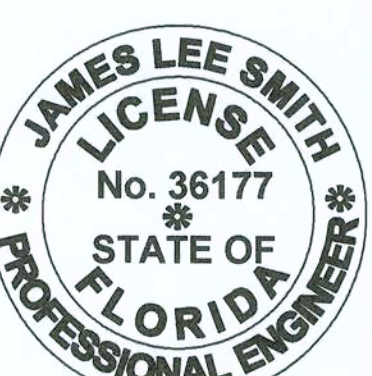

James Lee Smith & Associates, Inc.
DESIGN GROUP
PROFESSIONAL DESIGNERS
1250 MT. HOOPER RD., SUITE 8
WINTER PARK, FL 32789
PHONE: 329.699.6400
e-mail: jls@jlsdesign.com
www.jlsdesign.com

A CUSTOM DESIGNED HOME FOR...
STONEPAINTER
LAKE COUNTY, FLORIDA
SCALE: 1/4\"=1'-0\"
DATE: 10/2007

DESIGNED BY: BOB
REVISED:
SHEET 1 OF 3
DRAWING NO. 2007 - 31

PROFESSIONAL DESIGNER
[Signature]

REGISTERED ENGINEER
[Signature]

REGISTERED ENGINEER
[Signature]

THESE DOCUMENTS ARE THE PROPERTY OF JAMES LEE SMITH & ASSOCIATES, INC. AND ANY FLORIDA DESIGN GROUP FOR ANY PURPOSE WITH OUT THE WRITTEN CONSENT OF THE AFORESAIDED.

THESE DOCUMENTS ARE NOT VALID FOR PERMITTING UNLESS SIGNED AND SEALED WITH THE EMBOSSED SEAL OF THE PROFESSIONAL ENGINEER.
BOB MADDOX (NCBDC/ABD)
AMERICAN SOCIETY OF MECHANICAL ENGINEERS
FLORIDA SOCIETY No. FL-148

James Lee Smith & Associates, Inc.
DESIGN GROUP
PROFESSIONAL DESIGNERS
1250 MT. HOOPER RD., SUITE 8
WINTER PARK, FL 32789
PHONE: 329.699.6400
e-mail: jls@jlsdesign.com
www.jlsdesign.com

DESIGNED BY: BOB
REVISED:
SHEET 1 OF 3
DRAWING NO. 2007 - 31

PROFESSIONAL DESIGNER
[Signature]




REGISTERED ENGINEER
[Signature]

REGISTERED ENGINEER
[Signature]

THESE DOCUMENTS ARE THE PROPERTY OF JAMES LEE SMITH & ASSOCIATES, INC. AND ANY FLORIDA DESIGN GROUP FOR ANY PURPOSE WITH OUT THE WRITTEN CONSENT OF THE AFORESAIDED.

THESE DOCUMENTS ARE NOT VALID FOR PERMITTING UNLESS SIGNED AND SEALED WITH THE EMBOSSED SEAL OF THE PROFESSIONAL ENGINEER.
BOB MADDOX (NCBDC/ABD)
AMERICAN SOCIETY OF MECHANICAL ENGINEERS
FLORIDA SOCIETY No. FL-148

James Lee Smith & Associates, Inc.
DESIGN GROUP
PROFESSIONAL DESIGNERS
1250 MT. HOOPER RD., SUITE 8
WINTER PARK, FL 32789
PHONE: 329.699.6400
e-mail: jls@jlsdesign.com
www.jlsdesign.com

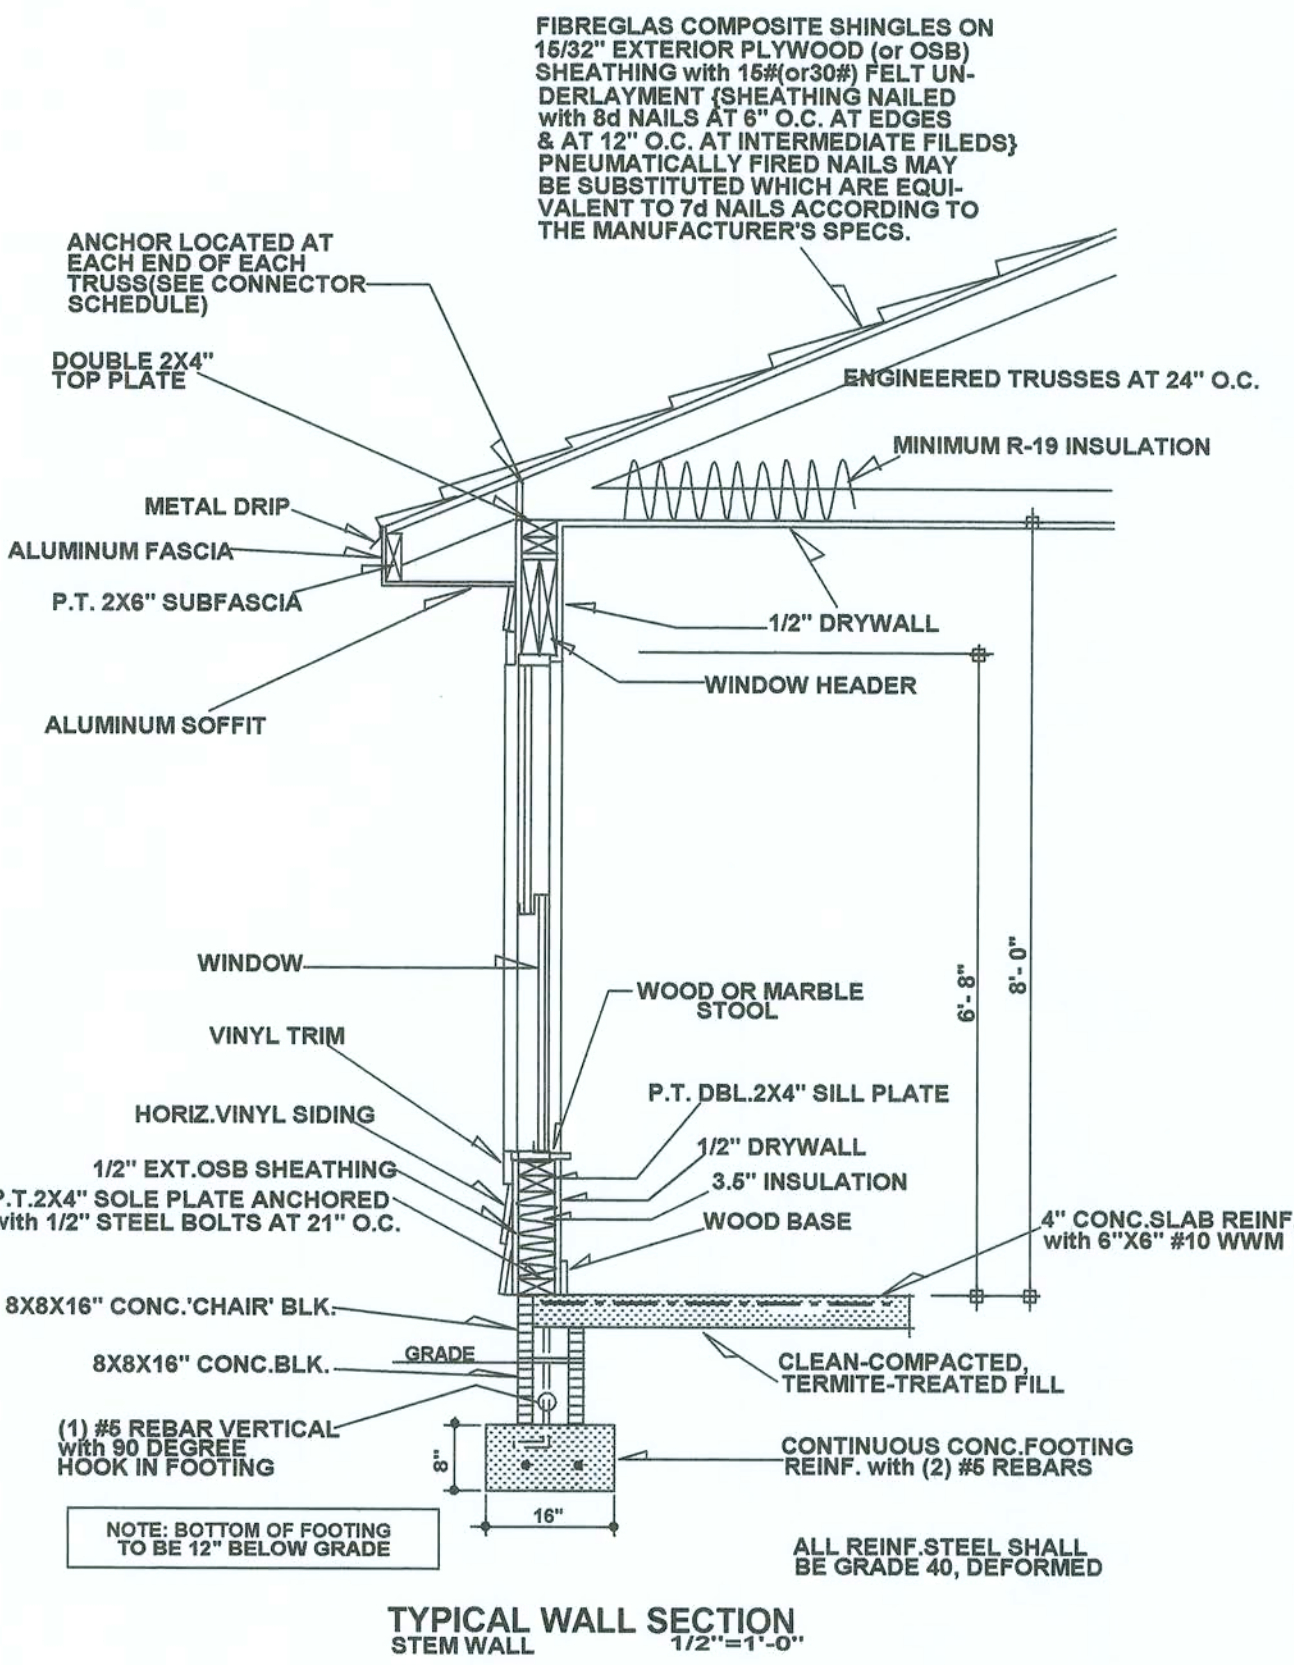
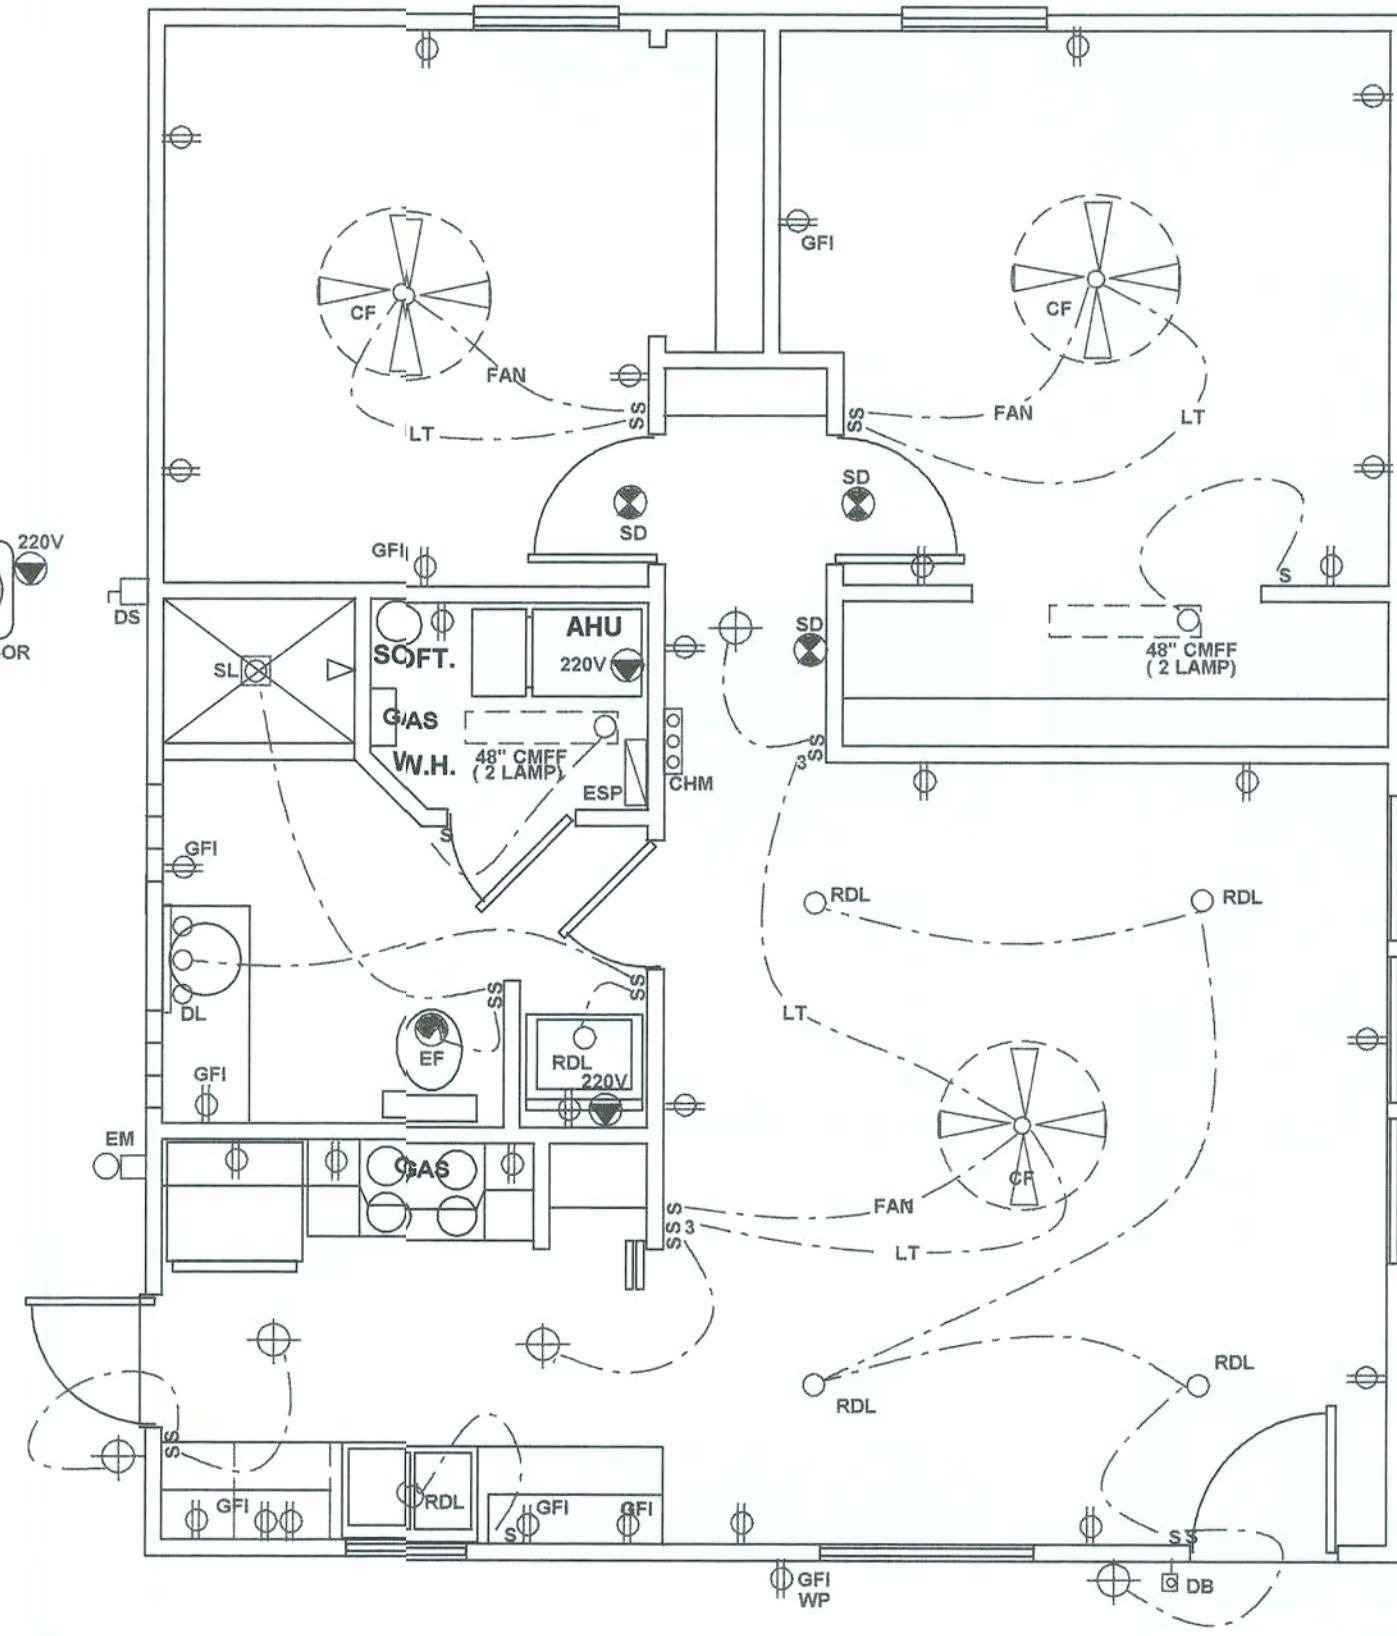
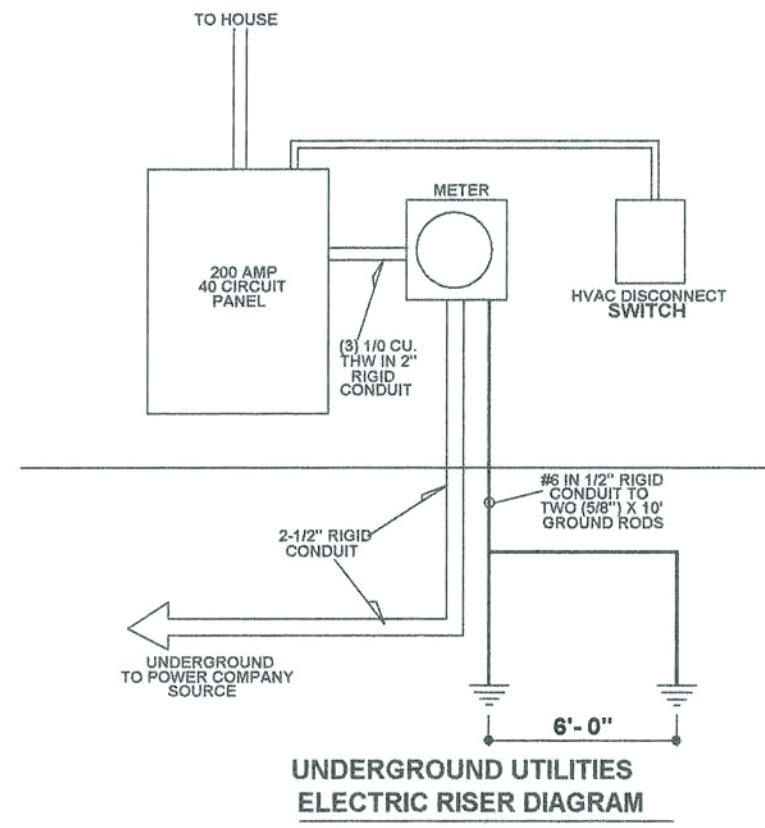


ELECTRICAL SYMBOLS

	GROUND FAULT INTERRUPT
	GARAGE DR. OPERATOR(DO)
	SMOKE DETECTOR(SD)
	EXHAUST FAN(EF)
	INCANDESCENT LIGHT FIXTURE
	SINGLE POLE SWITCH
	3-WAY SWITCH
	RECESSED DOWN LIGHT(RL)
	SHOWER LIGHT(SL)
	110V. RECEPTACLE
	WEATHER-PROOF(110V.)OUTLET
	220V. OUTLET
	FLUORESCENT FIXTURE (RECESSED)(FF)
	(CEILING MOUNTED)(CMFF)
	T.V. LEAD-IN (TVL)
	PHONE OUTLET(PH)
	AIR COND. DISCONNECT(DS)
	ELECT. METER(EM)
	DOORBELL(DB)
	CHIMES(CH)
	ELECT. SERVICE PANEL(ESP)
	CEILING FAN(CF)
	TRACK LIGHTING(TL)
	DRESSING LIGHT(DL)

NOTE: SMOKE DETECTORS SHALL BE INTERCONNECTED TOGETHER SO THAT ALL ALARMS WILL SOUND AT THE SAME TIME. EACH DETECTOR SHALL HAVE TWO POWER SOURCES. ALL RECEPTACLES IN BEDROOMS SHALL BE "ARC" FAULT PROTECTED.

PANEL SCHEDULE							
CRCT.	AMPS	COND.	EQUIPMENT	EQUIPMENT	COND.	AMPS	CRCT.
1	46	8	RANGE	DISHWASHER	12	20	4
3				REFRIGERATOR	12	20	7
5	30	10	DRYER	LIGHTS	12	15	6
7				LIGHTS	12	15	8
9	40	10	WELL(OPTIONAL)	RECEPTACLES	12	15	10
11				RECEPTACLES	12	15	12
13	46	8	AHU	RECEPTACLES	12	15	14
16				RECEPTACLES	12	15	16
17	40	10	A/C COMPRESSOR	WASHER	12	20	18
19				COMPUTER	12	15	20
21	20	12	SMALL APPLIANCES	GF(EXTERIOR)			22
23	20	12	SMALL APPLIANCES	SPARE			24
26	16	12	GF(BATH)	▲			26
27	16	12	GF(BEDROOMS)				28
28	16	12	GF(GARAGE)				30
31	16	12	GF(KITCHEN)				32
33			SPARE				34
36			SPARE				36
37			SPARE				38
39			SPARE	▼			40

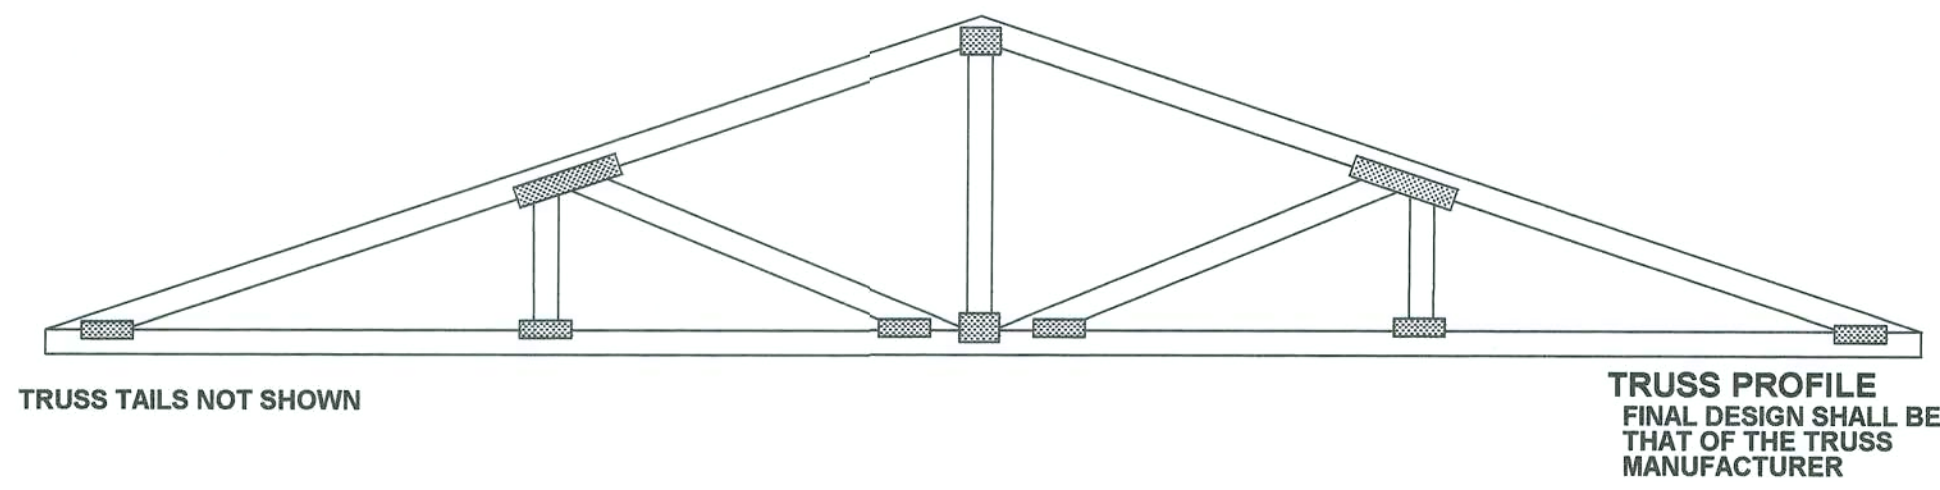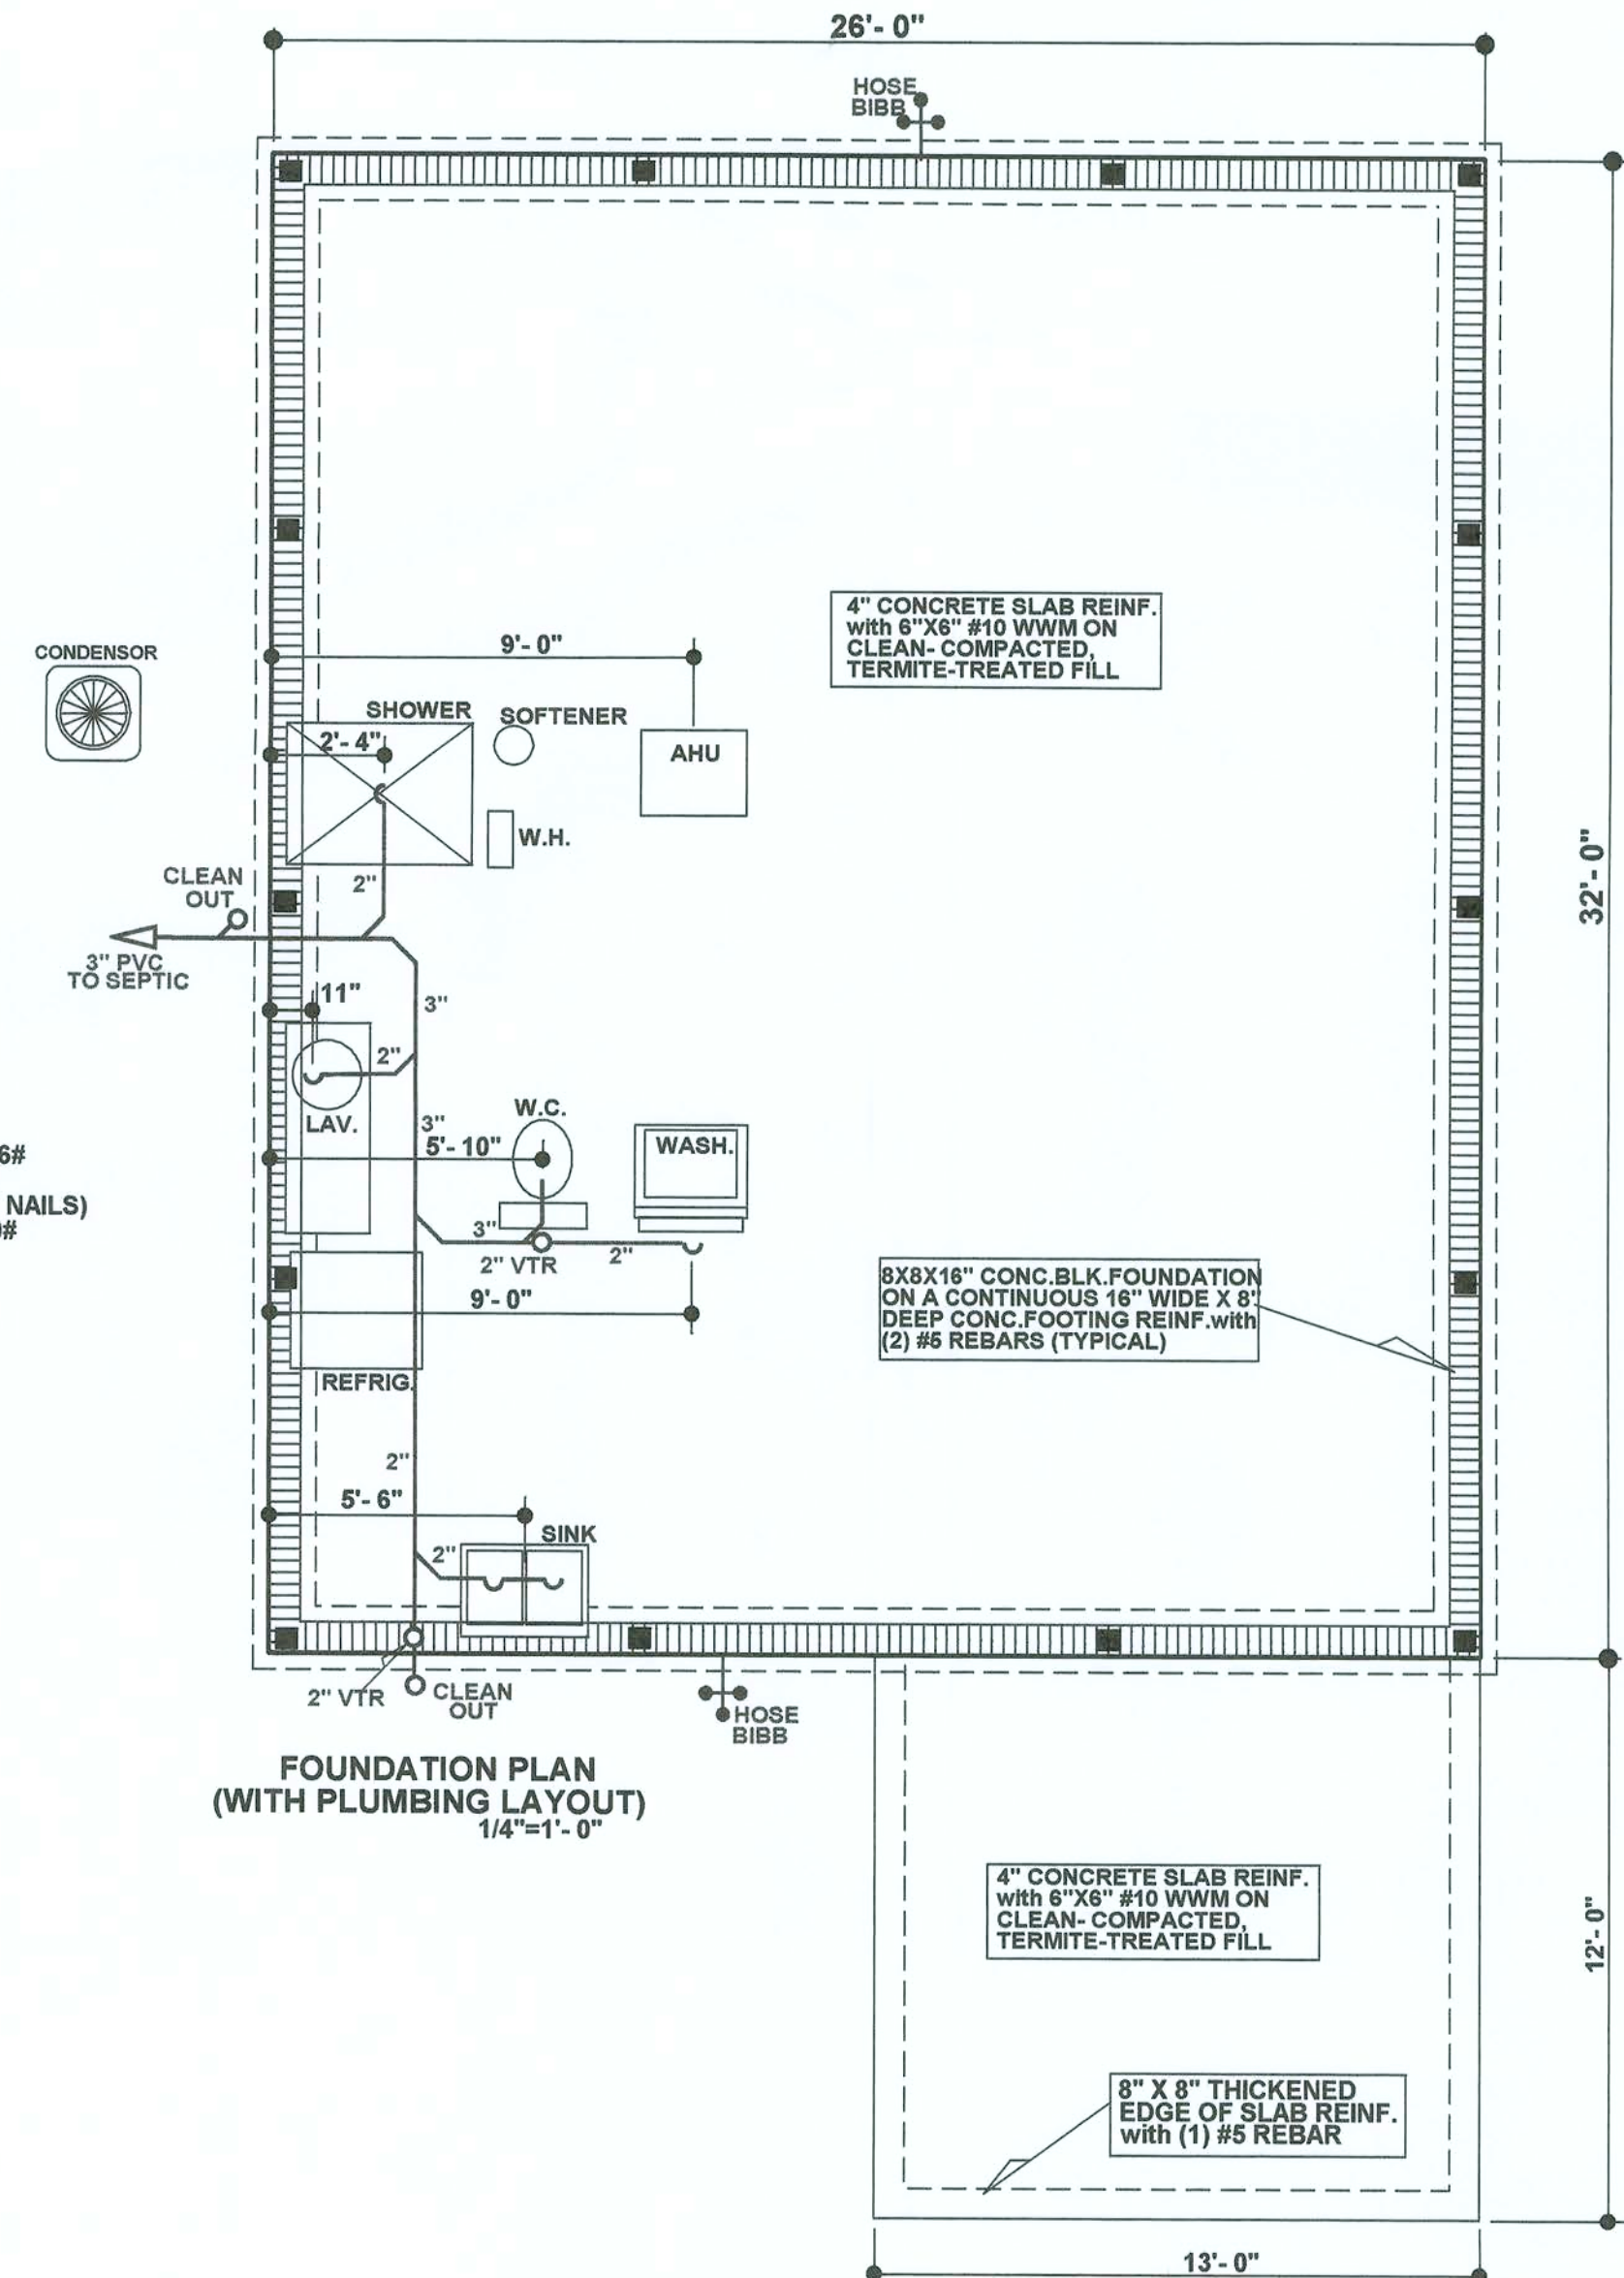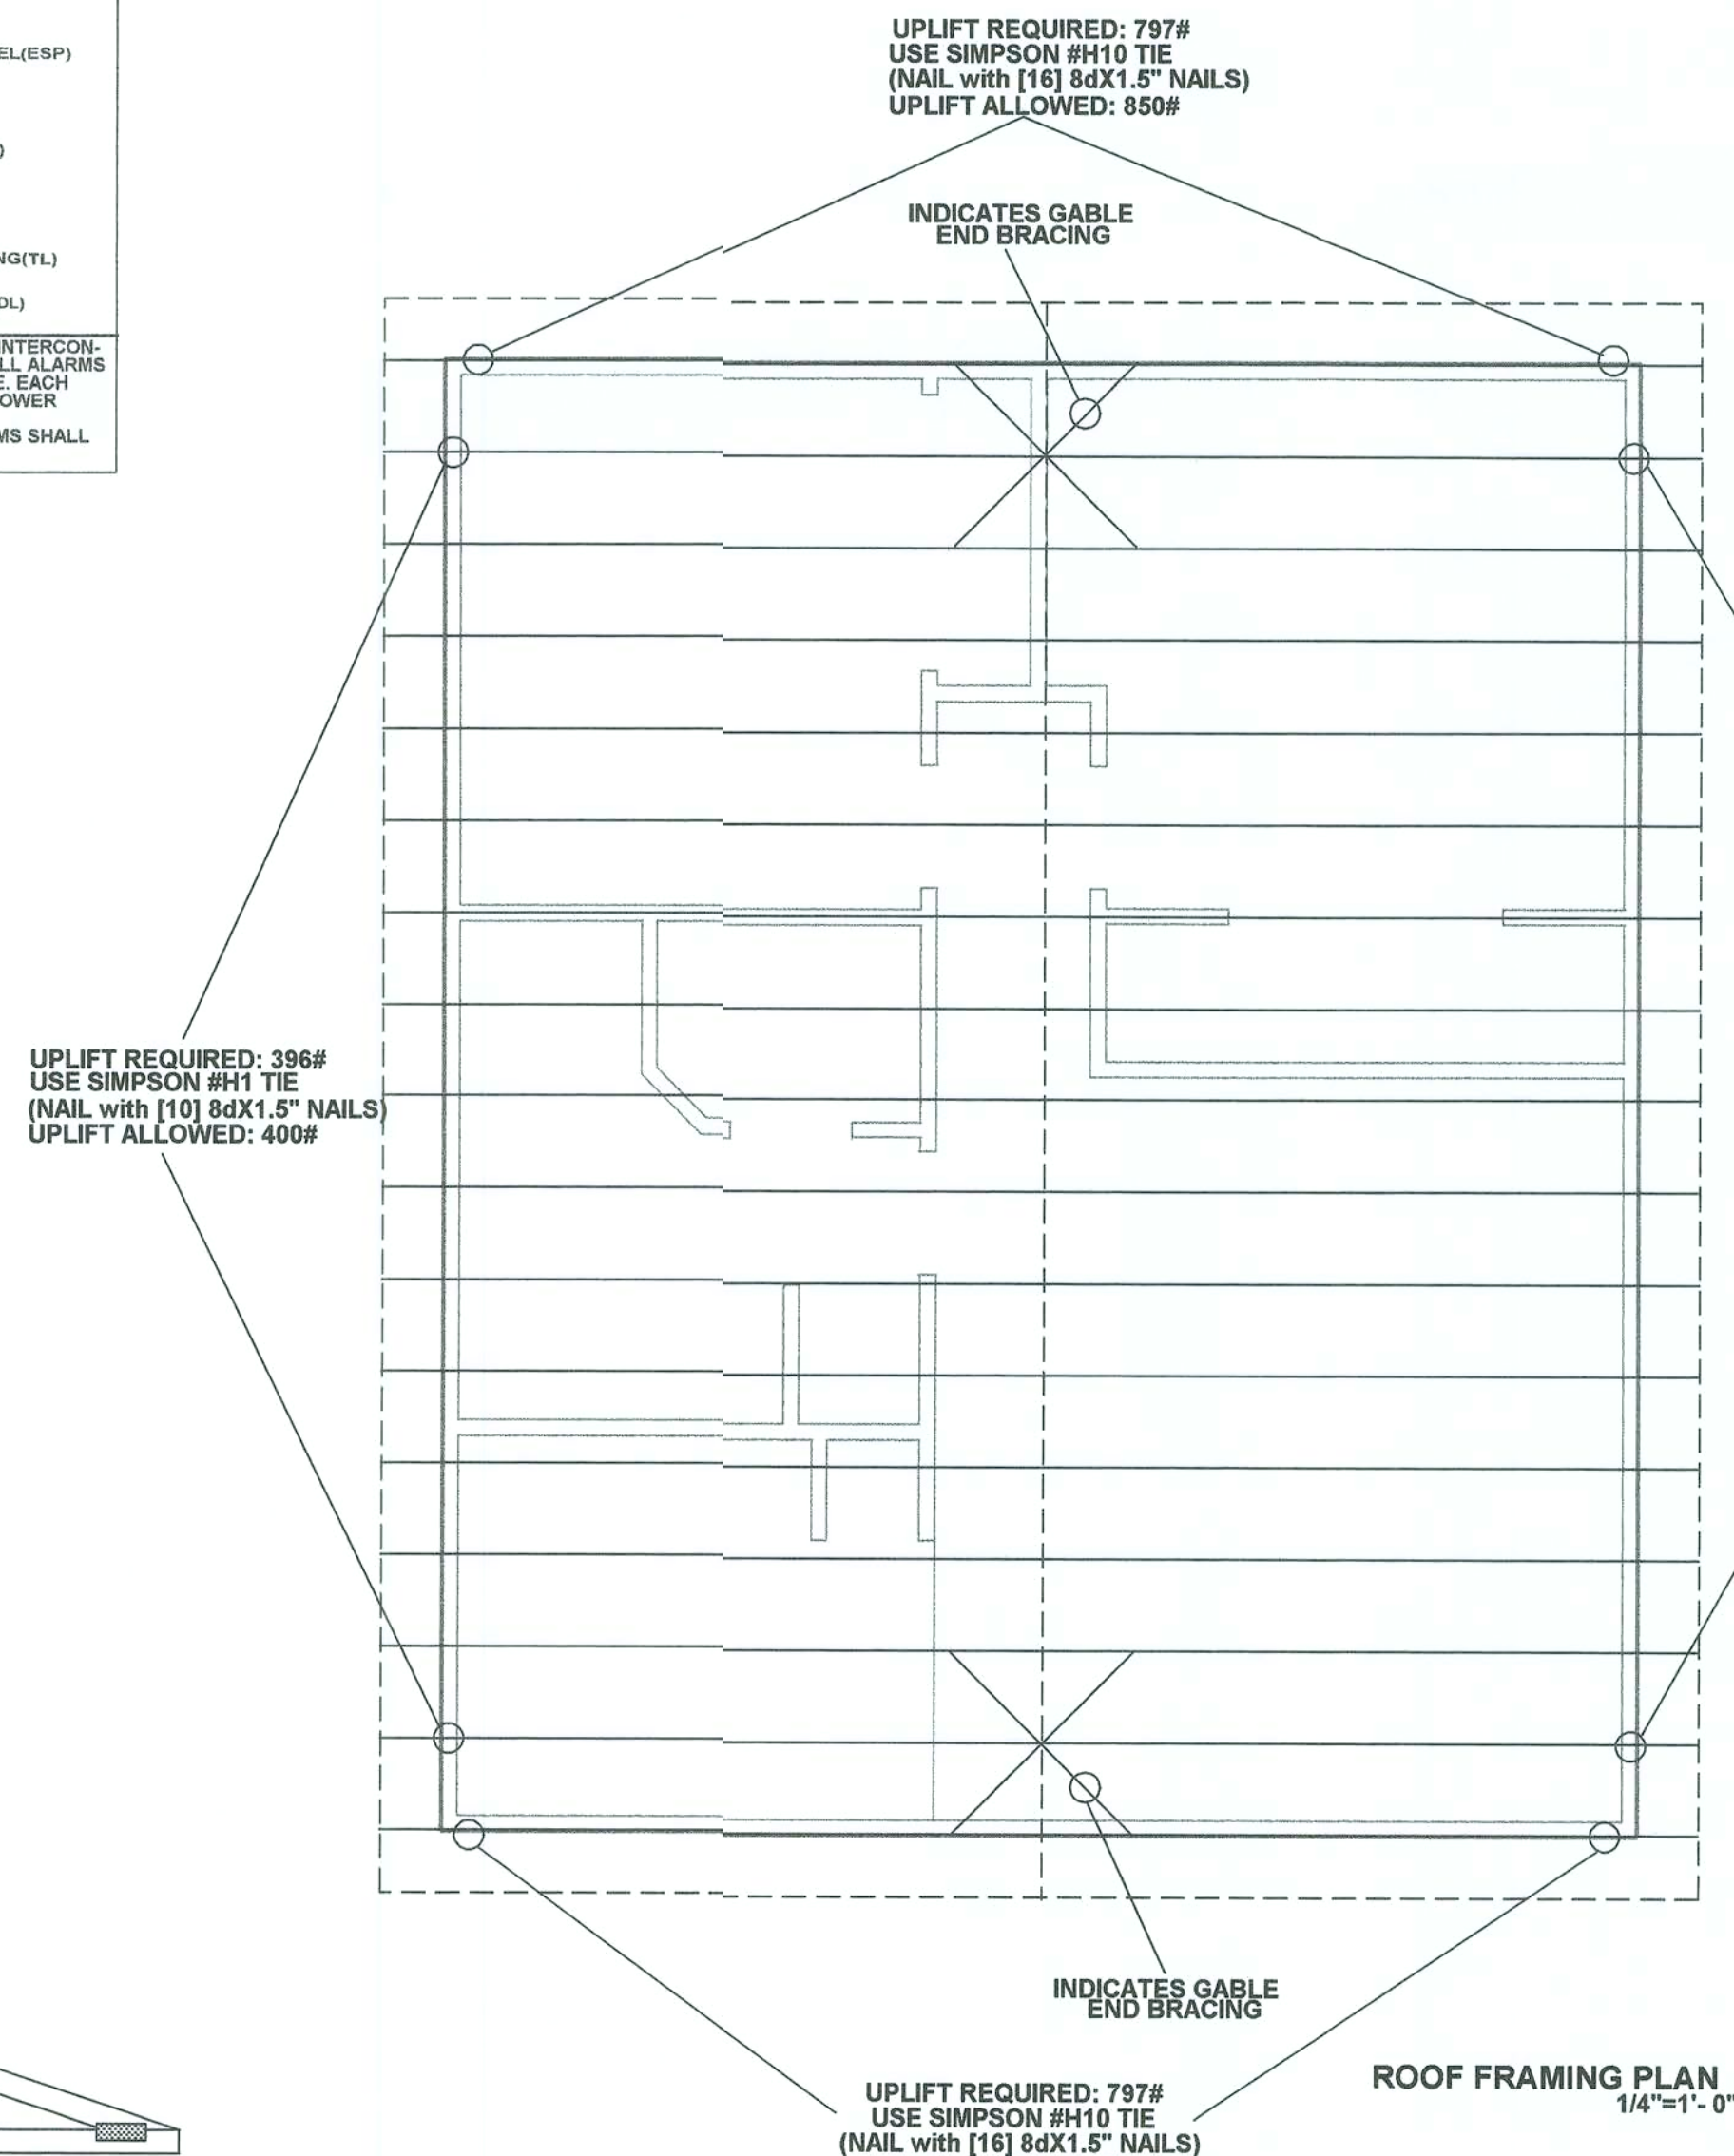

D I S C L A I M E R

ANY DEVIATION FROM, ALTERATION TO OR CHANGES TO THIS PROJECT AS DEPICTED ON THESE DOCUMENTS SHALL BE DEEMED THAT PORTION OF OR THE WHOLE PROJECT NULL AND VOID. THE CONTRACTOR SHALL BE RESPONSIBLE FOR OBTAINING ALL NECESSARY PERMITS AND THE PRIVILEGE TO USE SUBSTITUTE PRODUCTS OF EQUAL OR GREATER QUALITY. THE CONTRACTOR HAS THE PRIVILEGE TO USE SUBSTITUTE PRODUCTS OF EQUAL OR GREATER QUALITY, EQUAL OR GREATER STRENGTH AS DEEMED NECESSARY FOR THE BETTERMENT OF PROJECT.

THIS NOT A CONTRACTOR BILLING DEPARTMENT OF FISCAL SERVICE. THIS SET OF DOCUMENTS IS NOT TO BE USED FOR ANY OTHER PURPOSES. THESE ONLY IF THEY ARE TO BE REUSED FOR PERMITTING A NEW SEAL TO BE SUBMITTED TO THE DEPARTMENT OF FISCAL SERVICE. THIS SET OF DOCUMENTS IS NOT LEGAL AND WILL BE DEEMED A COPYRIGHT VIOLATION IF REUSED.

SCALE: 1/4"=1', 0"		DESIGNED BY: BOB	
DATE: 10/2007		REVIEWED:	
FOUNDATION PLAN SHEET 2 OF 3			
DRAWING NO.		2007 - 31	

Sheel
06/07/2017

THESE DOCUMENTS ARE THE PROPERTY OF
FLORIDA DESIGN GROUP
AND MAY NOT BE COPIED, REUSED OR REPRODUCED
FOR ANY PURPOSE WITHOUT THE WRITTEN CONSENT
OF THE AFOREMENTIONED

THESE DOCUMENTS ARE NOT VALID FOR PERMITTING
UNLESS SIGNED AND SEALED WITH THE EMBOSSED
SEAL OF

BOB MADDOX (NCBDC/AIBD)
NATIONAL COUNCIL OF BUILDING DESIGNER
CERTIFICATION No. 10-218
AMERICAN SOCIETY OF BUILDING DESIGNERS
(FLORIDA SOCIETY) No. FL-048

Florida

DESIGN GROUP
PROFESSIONAL DESIGNERS
1250 MT. HOMER RD., SUITE 8
EUSTIS, FLORIDA 32726

PHONE: 352/589-6400
e-mail: fdg500@atlantic.net

WEB SITE:

A circular professional engineer seal for the State of Florida. The outer ring contains the text "JAMES LEE SMITH" at the top and "PROFESSIONAL ENGINEER" at the bottom, separated by two small floral symbols. The inner circle contains the word "LICENSE" at the top, "No. 36177" in the center, and "STATE OF FLORIDA" at the bottom, also separated by two small floral symbols.

