



These drawings, as instruments of service, are the sole property of the architect, and may not be used, copied or reproduced in whole or in part for use on or incorporated within any other job without specific and individual authorization by the architect.

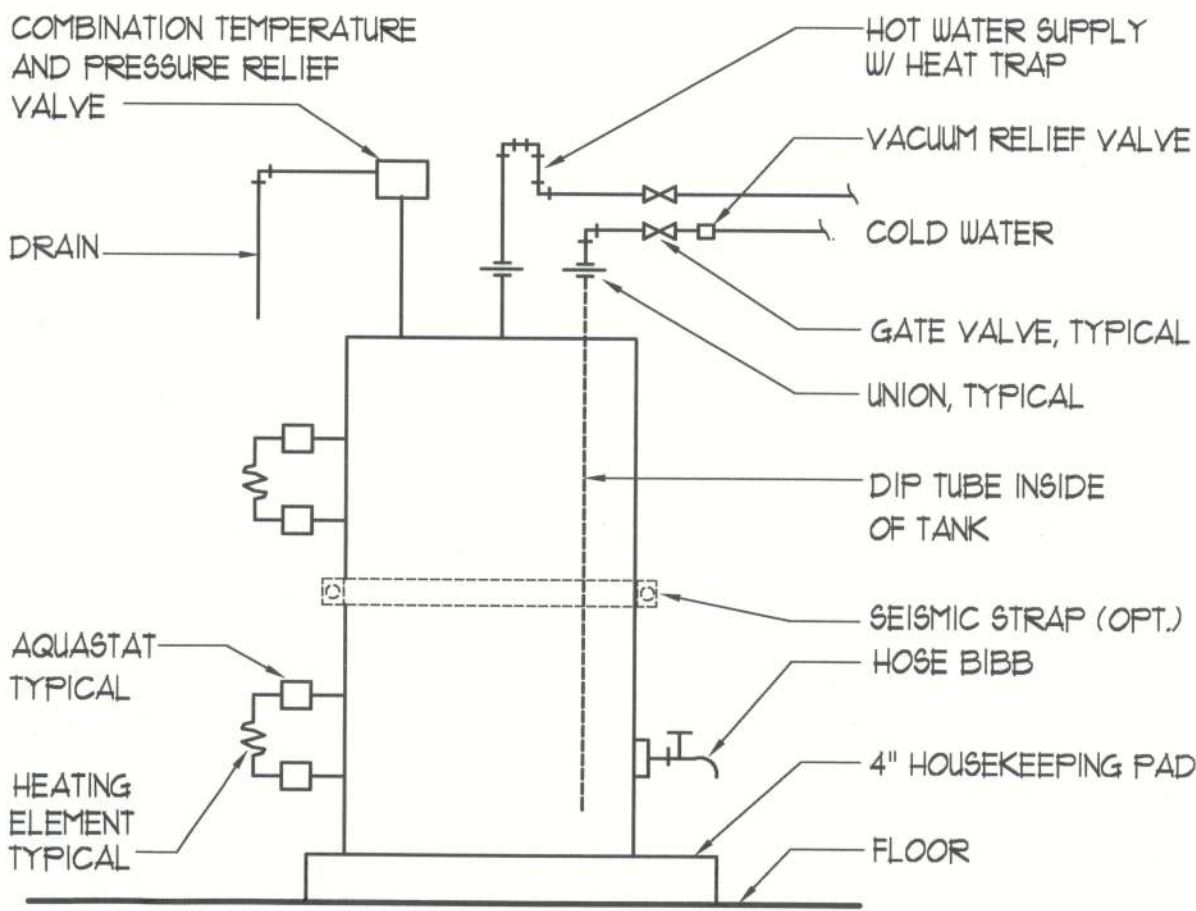

Electric Water Heater DETAIL

SCALE: NONE

B

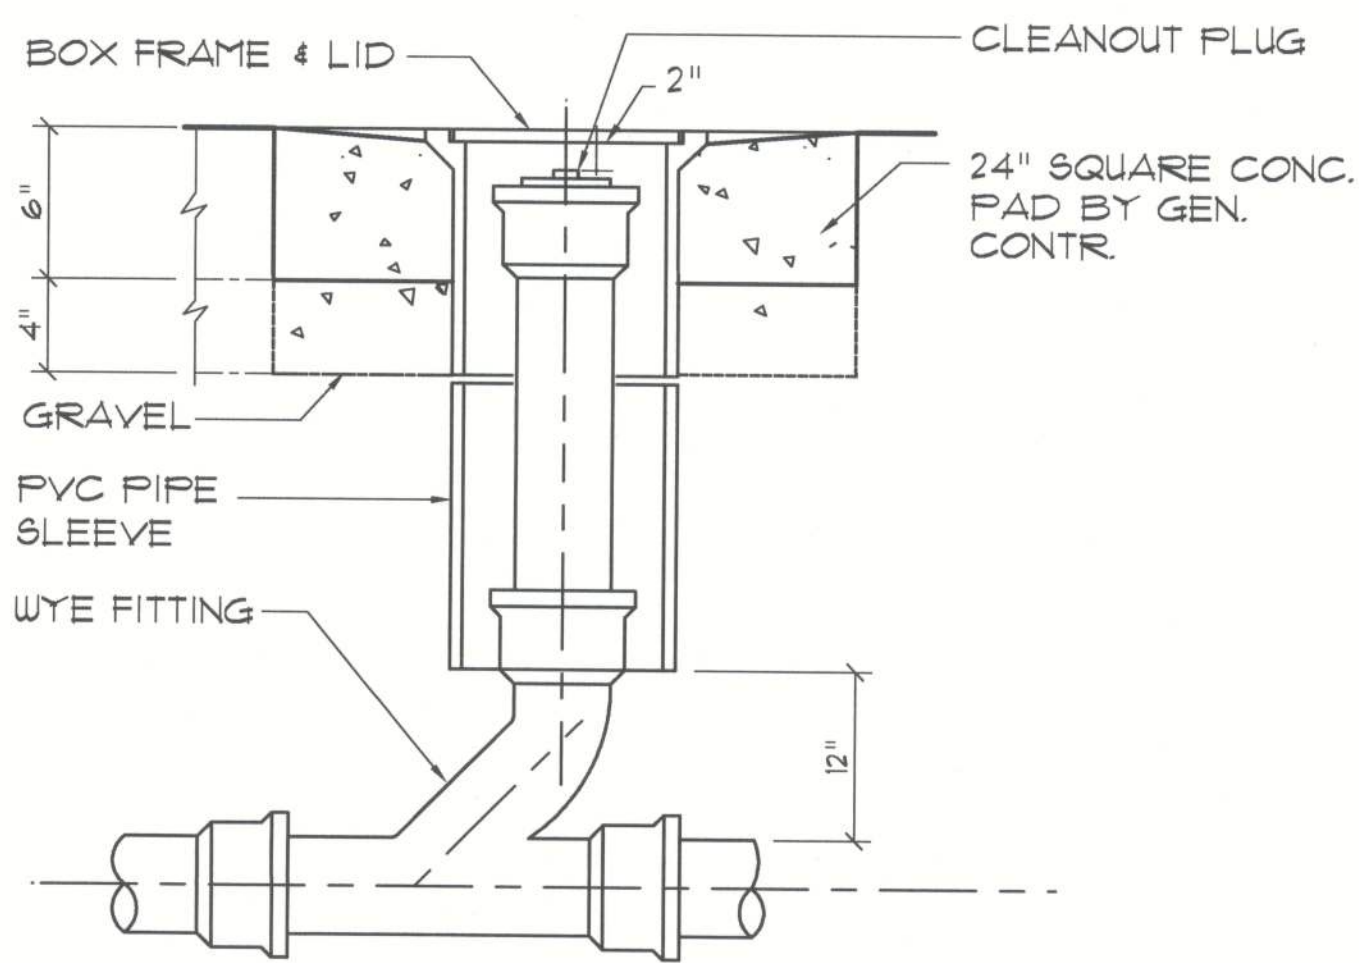


Outdoor Cleanout DETAIL

N.T.S.

C

PLUMBING NOMENCLATURE

1/4"	PIPING SIZE	TUB	BATH TUB
1/2"	PIPING SIZE	SHOW.	SHOWER
2"	PIPING SIZE	SINK	SINGLE BASIN SINK
3"	PIPING SIZE	DBL.SINK	DOUBLE BASIN SINK
4"	PIPING SIZE	TRI.SINK	TRIPLE BASIN SINK
1 1/2" LV	1 1/2" LOOP VENT	BAR	BAR SINK
2" LV	2" LOOP VENT	DWASH.	DISHWASHER
2" VTR	2" VENT THRU ROOF	2" F.D.	2" FLOOR DRAIN
3" VTR	3" VENT THRU ROOF	3" F.D.	3" FLOOR DRAIN
C.O.T.G.	CLEAN-OUT TO GRADE	3" F.S.	3" FLOOR SINK
C.O.	CLEAN-OUT	EWC	ELECTRIC WATER COOLER
W.C.O.	WALL CLEAN-OUT	EWU	ELECTRIC WATER HEATER
F.C.O.	FLOOR CLEAN-OUT	GUH	GAS WATER HEATER
LAV.	LAVATORY	TRAY	LAUNDRY TRAY (SINK)
WC.	WATER CLOSET (TOILET)	WASH.	WASHING MACHINE
BID.	BIDET	H.B.	HOSE BIBB
URIN.	URINAL	TSD	TO SANITARY DISPOSAL

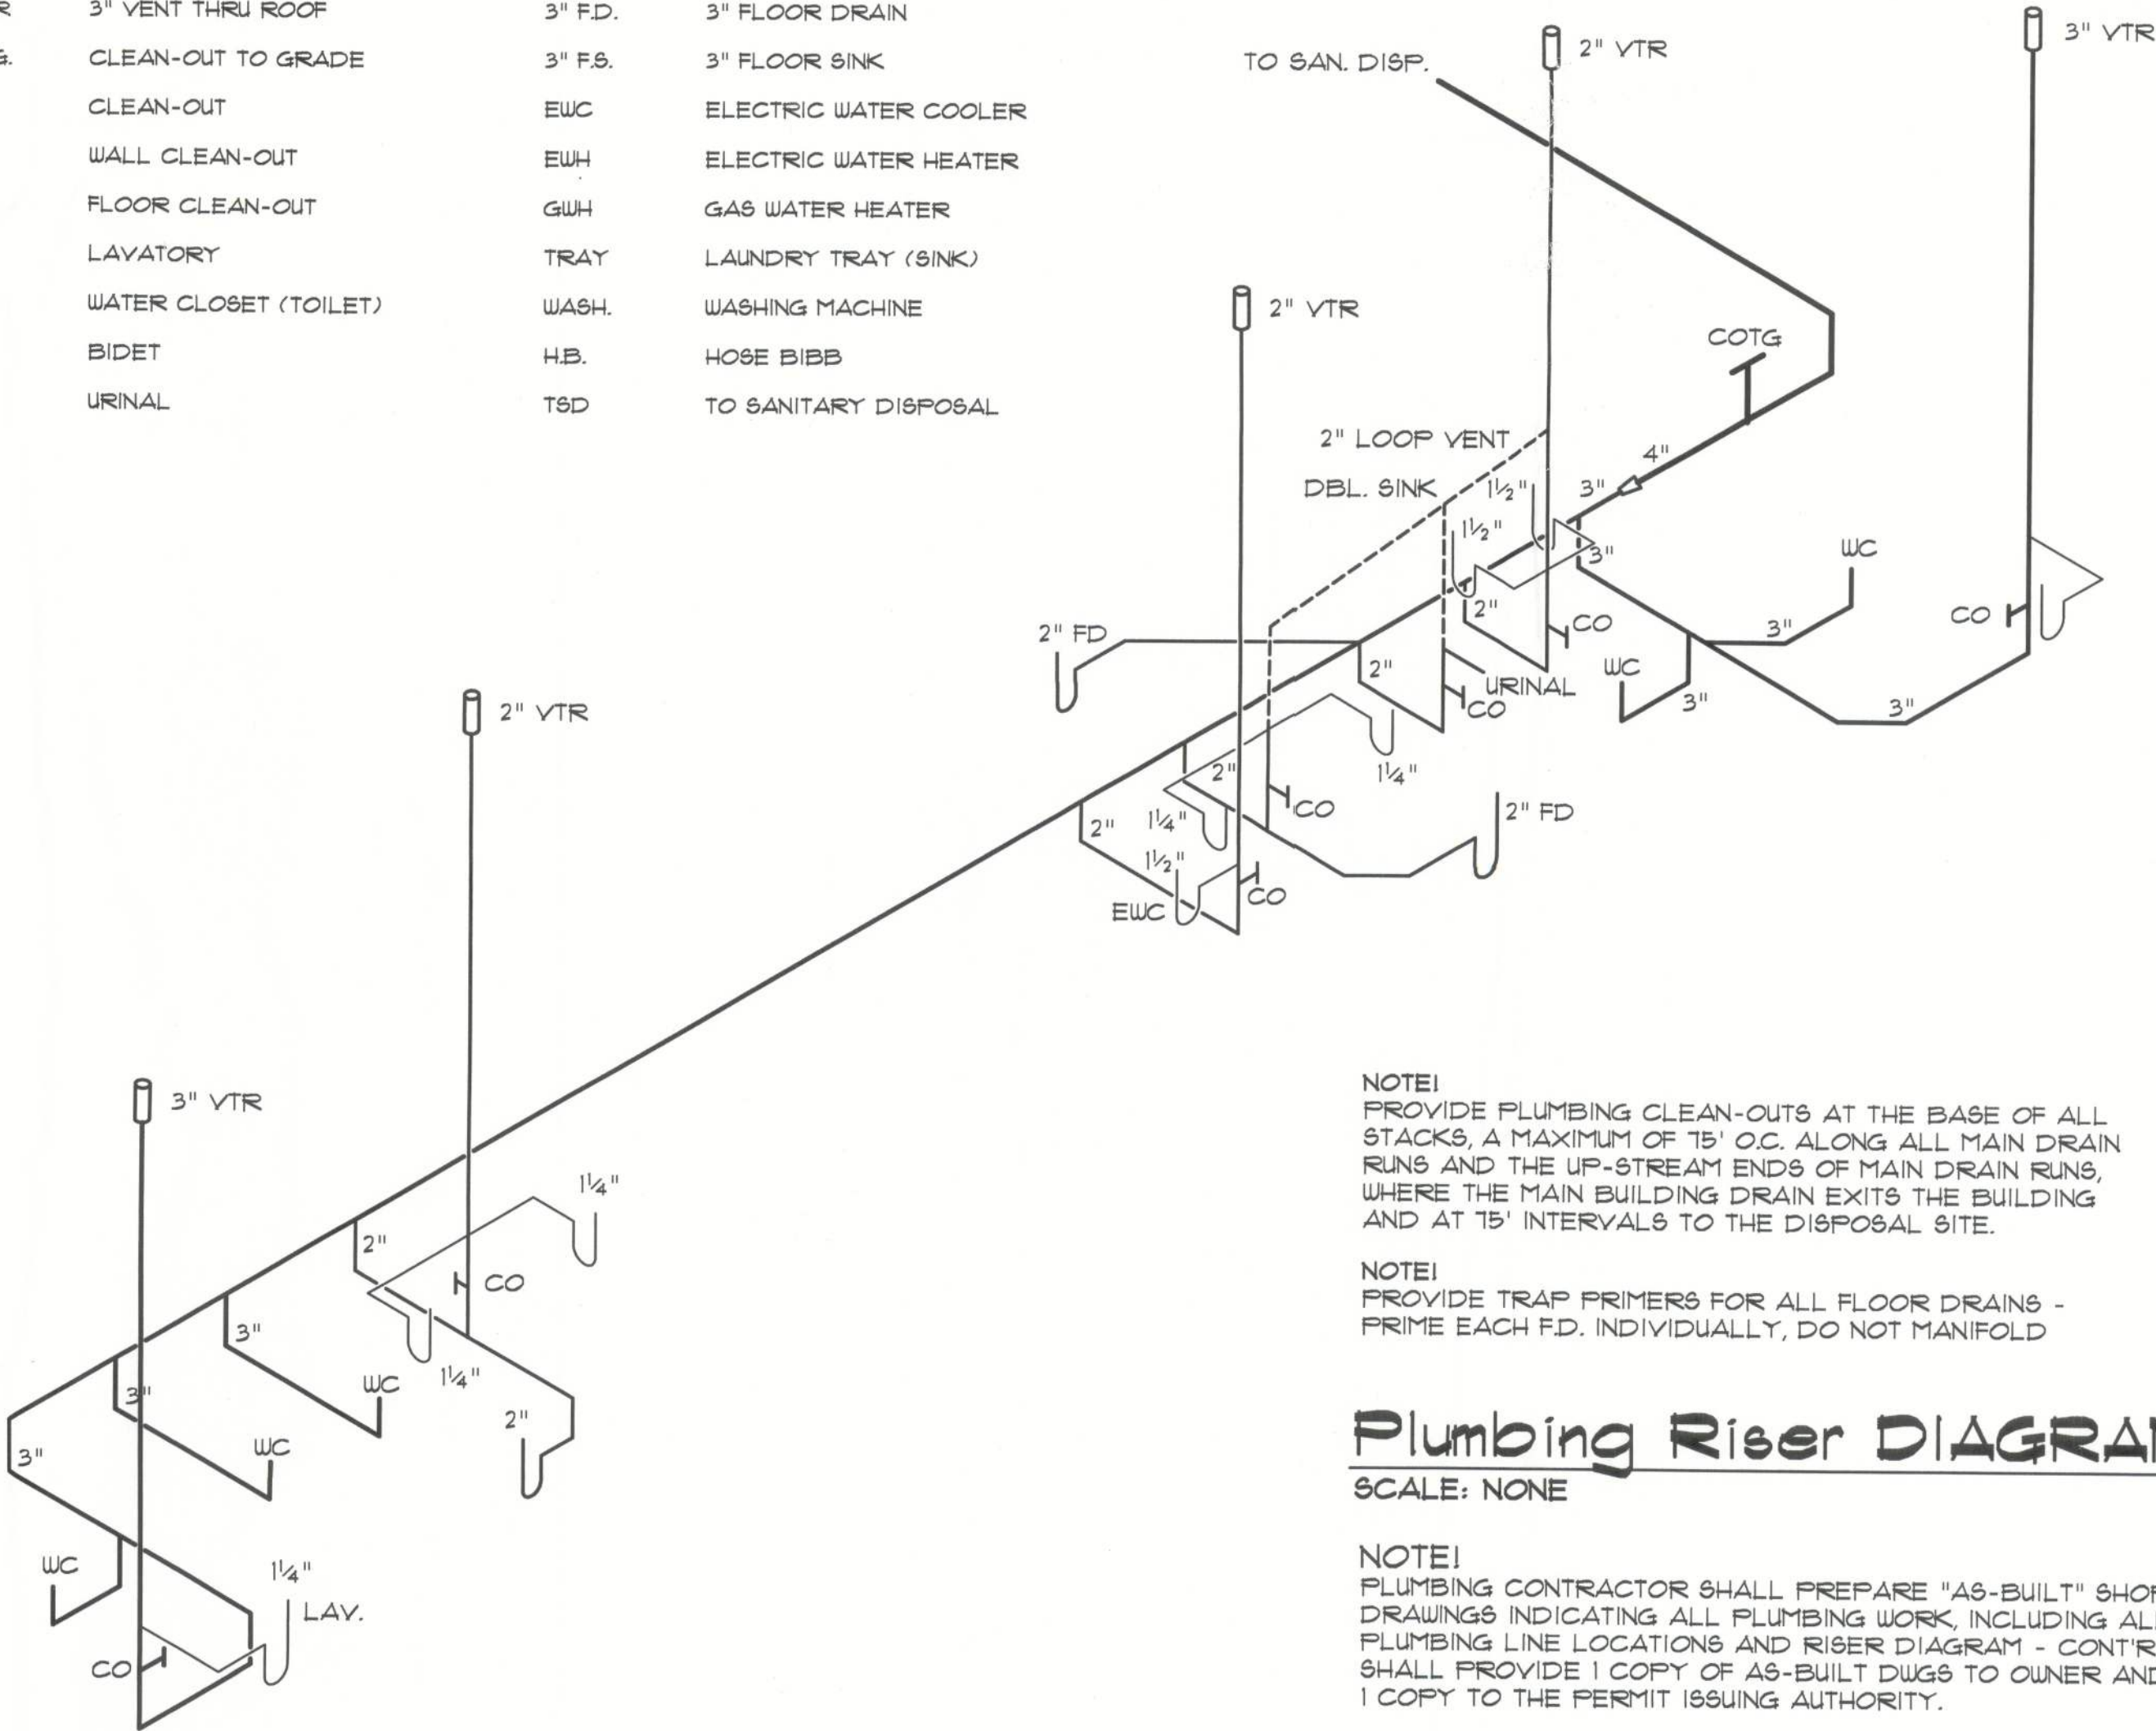

NOTE:
PROVIDE PLUMBING CLEAN-OUTS AT THE BASE OF ALL STACKS, A MAXIMUM OF 15' O.C. ALONG ALL MAIN DRAIN RUNS AND THE UP-STREAM ENDS OF MAIN DRAIN RUNS, WHERE THE MAIN BUILDING DRAIN EXITS THE BUILDING AND AT 15' INTERVALS TO THE DISPOSAL SITE.

NOTE:
PROVIDE TRAP PRIMERS FOR ALL FLOOR DRAINS - PRIME EACH F.D. INDIVIDUALLY, DO NOT MANIFOLD

Plumbing Riser DIAGRAM

SCALE: NONE

NOTE:
PLUMBING CONTRACTOR SHALL PREPARE "AS-BUILT" SHOP DRAWINGS INDICATING ALL PLUMBING WORK, INCLUDING ALL PLUMBING LINE LOCATIONS AND RISER DIAGRAM - CONTR. SHALL PROVIDE 1 COPY OF AS-BUILT DWGS TO OWNER AND 1 COPY TO THE PERMIT ISSUING AUTHORITY.

REVISION:

Copyright 2012 ©
N.P. Geisler, Architect

DRAWN:

mpg

WORSHIP CENTER for:
CROSS POINT COMMUNITY CHURCH
COLUMBIA COUNTY, FLORIDA
PLUMBING NOTES

Celebrating
40 Years of Service
1972 - 2012
N.P. Geisler, Architect
AIA000000

**NICHOLAS
PAUL
GEISLER
ARCHITECT**
N.C.A.R.B. Certified

DATE:

30 JUL 2012

COMM:

2K1239

SHEET:

P.2

2 of 2

mpg
07/30/12
AR0007005