
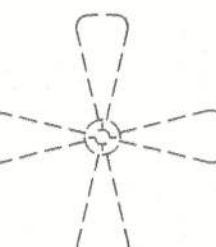


ELECTRICAL SYMBOLS	
	THREE-WAY SWITCH
	SINGLE-POLE SWITCH
	DUPLEX RECEPTACLE OUTLET
	WATER PROOF OUTLET
	220 VOLT OUTLET
	CEILING OUTLET FIXTURE
	SMOKE DETECTOR
	EXHAUST FAN
HB	HOSE B/B
	TELEVISION HOOK-UP
	TELEPHONE HOOK-UP
	FLOOD LIGHT
	CEILING FAN W/ LIGHT

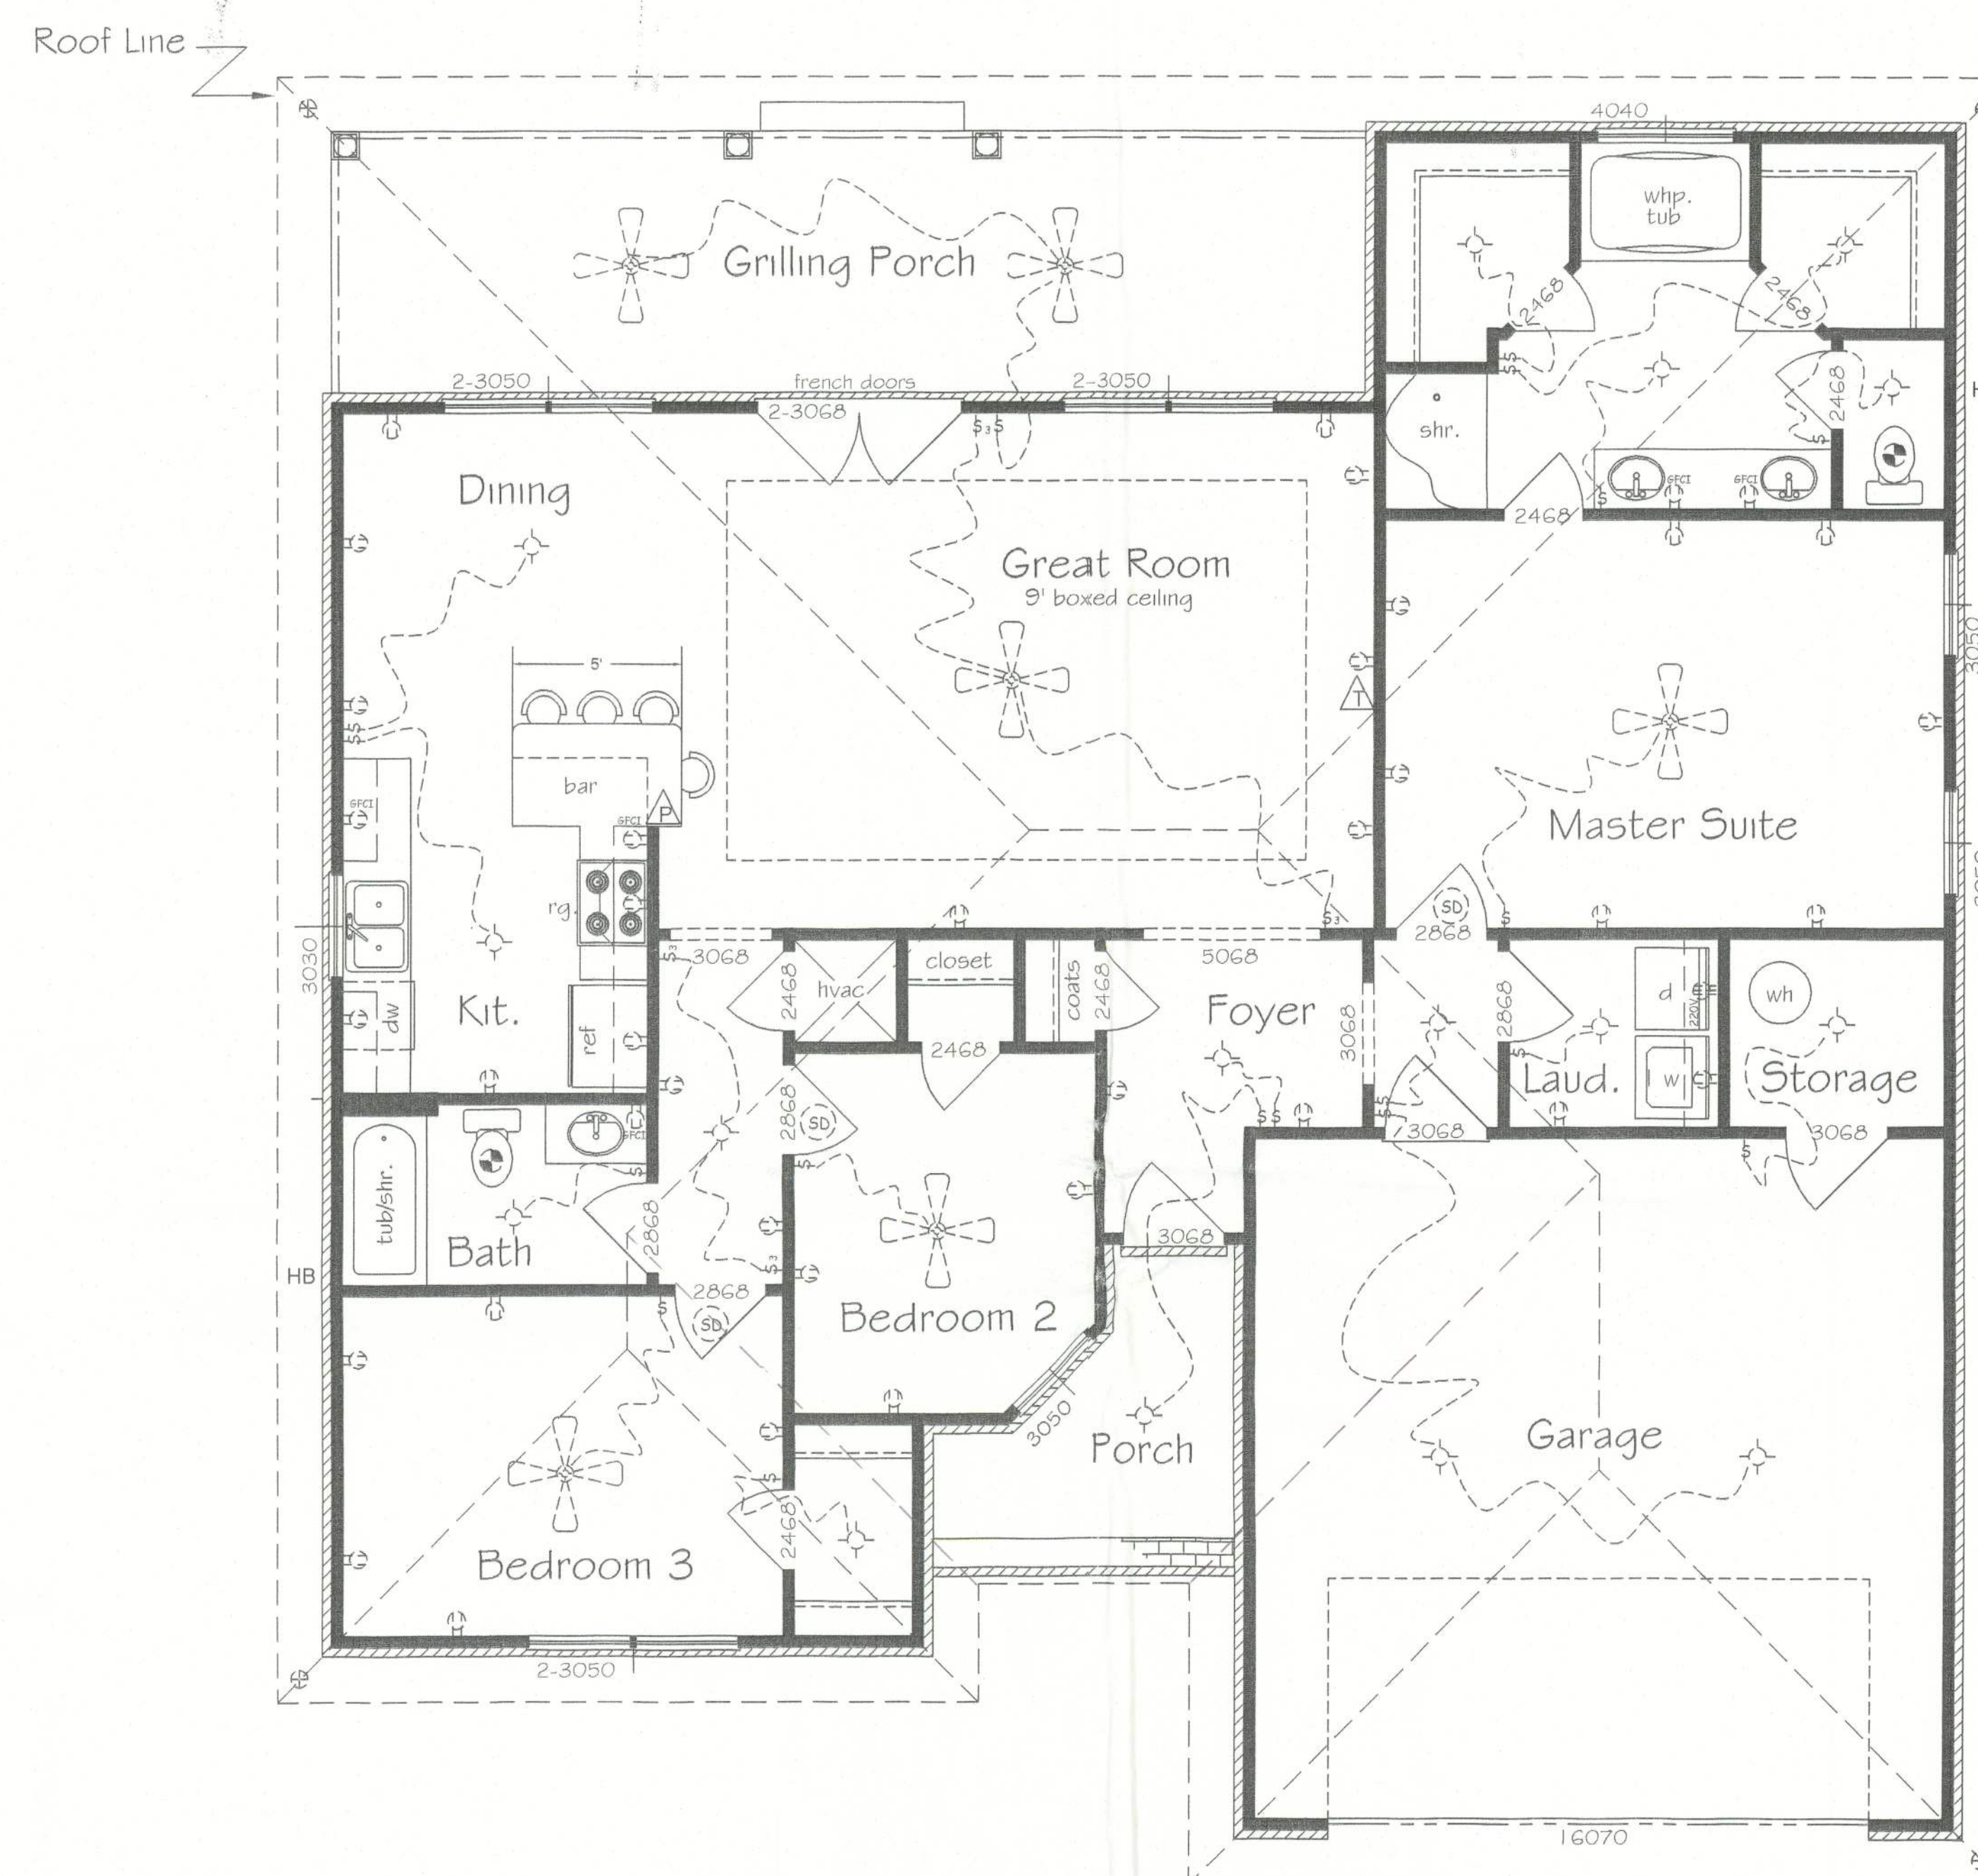

Electrical Note:
This Electrical Plan is basic in nature. Owner preferences shall be managed by contractor.

ELECTRICAL PLAN

Scale - 1/4" = 1'

NOTES

1-CHECK ALL DIMENSIONS FOR ACCURACY PRIOR TO CONSTRUCTION.

2-ALL ELECTRICAL, PLUMBING AND MECHANICAL (HVAC) TO BE INSTALLED BY CURRENTLY LICENCED CONTRACTORS CONFORMING TO STATE AND LOCAL CODES WHERE APPLICABLE.

3-ENERGY CALCULATIONS TO BE PROVIDED BY MECHANICAL CONTRACTOR.

4-EXACT DESCRIPTION AND/OR SPECIFICATIONS NOT NOTED ON PLANS TO BE PROVIDED BY OWNER AND/OR CONTRACTOR.(DOORS, WINDOWS, ETC.)

5-ALL CONSTRUCTION MUST CONFORM TO CURRENT STATE AND LOCAL CODES WHERE APPLICABLE.



114-B WEST GREEN STREET
PERRY, FLORIDA 32347
TEL: (850) 584-4408
FAX: (850) 223-1552

CERTIFICATION

WINDLOAD CERTIFICATION:
THESE PLANS WILL COMPLY WITH THE FLORIDA BUILDING CODE FOR A 100 MILE PER HOUR WINDLOAD (THREE SECOND INTERVAL)

John K. Gentry
9-2-05

John K. Gentry, P.E. # 16990
Engineering Business # 25890

PREPARED FOR:
Plumb Level Construction
Columbia County, Florida

PREPARED BY:
COOPER DESIGNS
Jodi Cooper
1772 N.E. CHERVIL DRIVE
LEE, FLORIDA 32059
850-971-5607
E-MAIL: mijocooper@vol.com

PROJECT
**FLOOR PLAN
ROOF LINE**

DATE August 25, 2005

PROJECT # 05-073

3 OF 4