


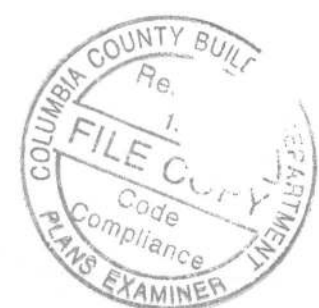

ADDITION PLANS FOR GRANGER RESIDENCE COLUMBIA COUNTY, FL


Plan Sheet Index:

Sheet No.	Description
1	title/index sheet
2	floor plan
3	front and right elevations
4	rear and left elevations
5	wall typical
6	roof plan
7	foundation & plumbing plan
8	electrical plan bottom floor

PLANS PREPARED BY:
CHRISTOPHER Q. DICKS
4035 SE CR 252, LAKE CITY, FL 32025

GRANGER RESIDENCE
COLUMBIA COUNTY, FLORIDA

SHEET
1
OF
8

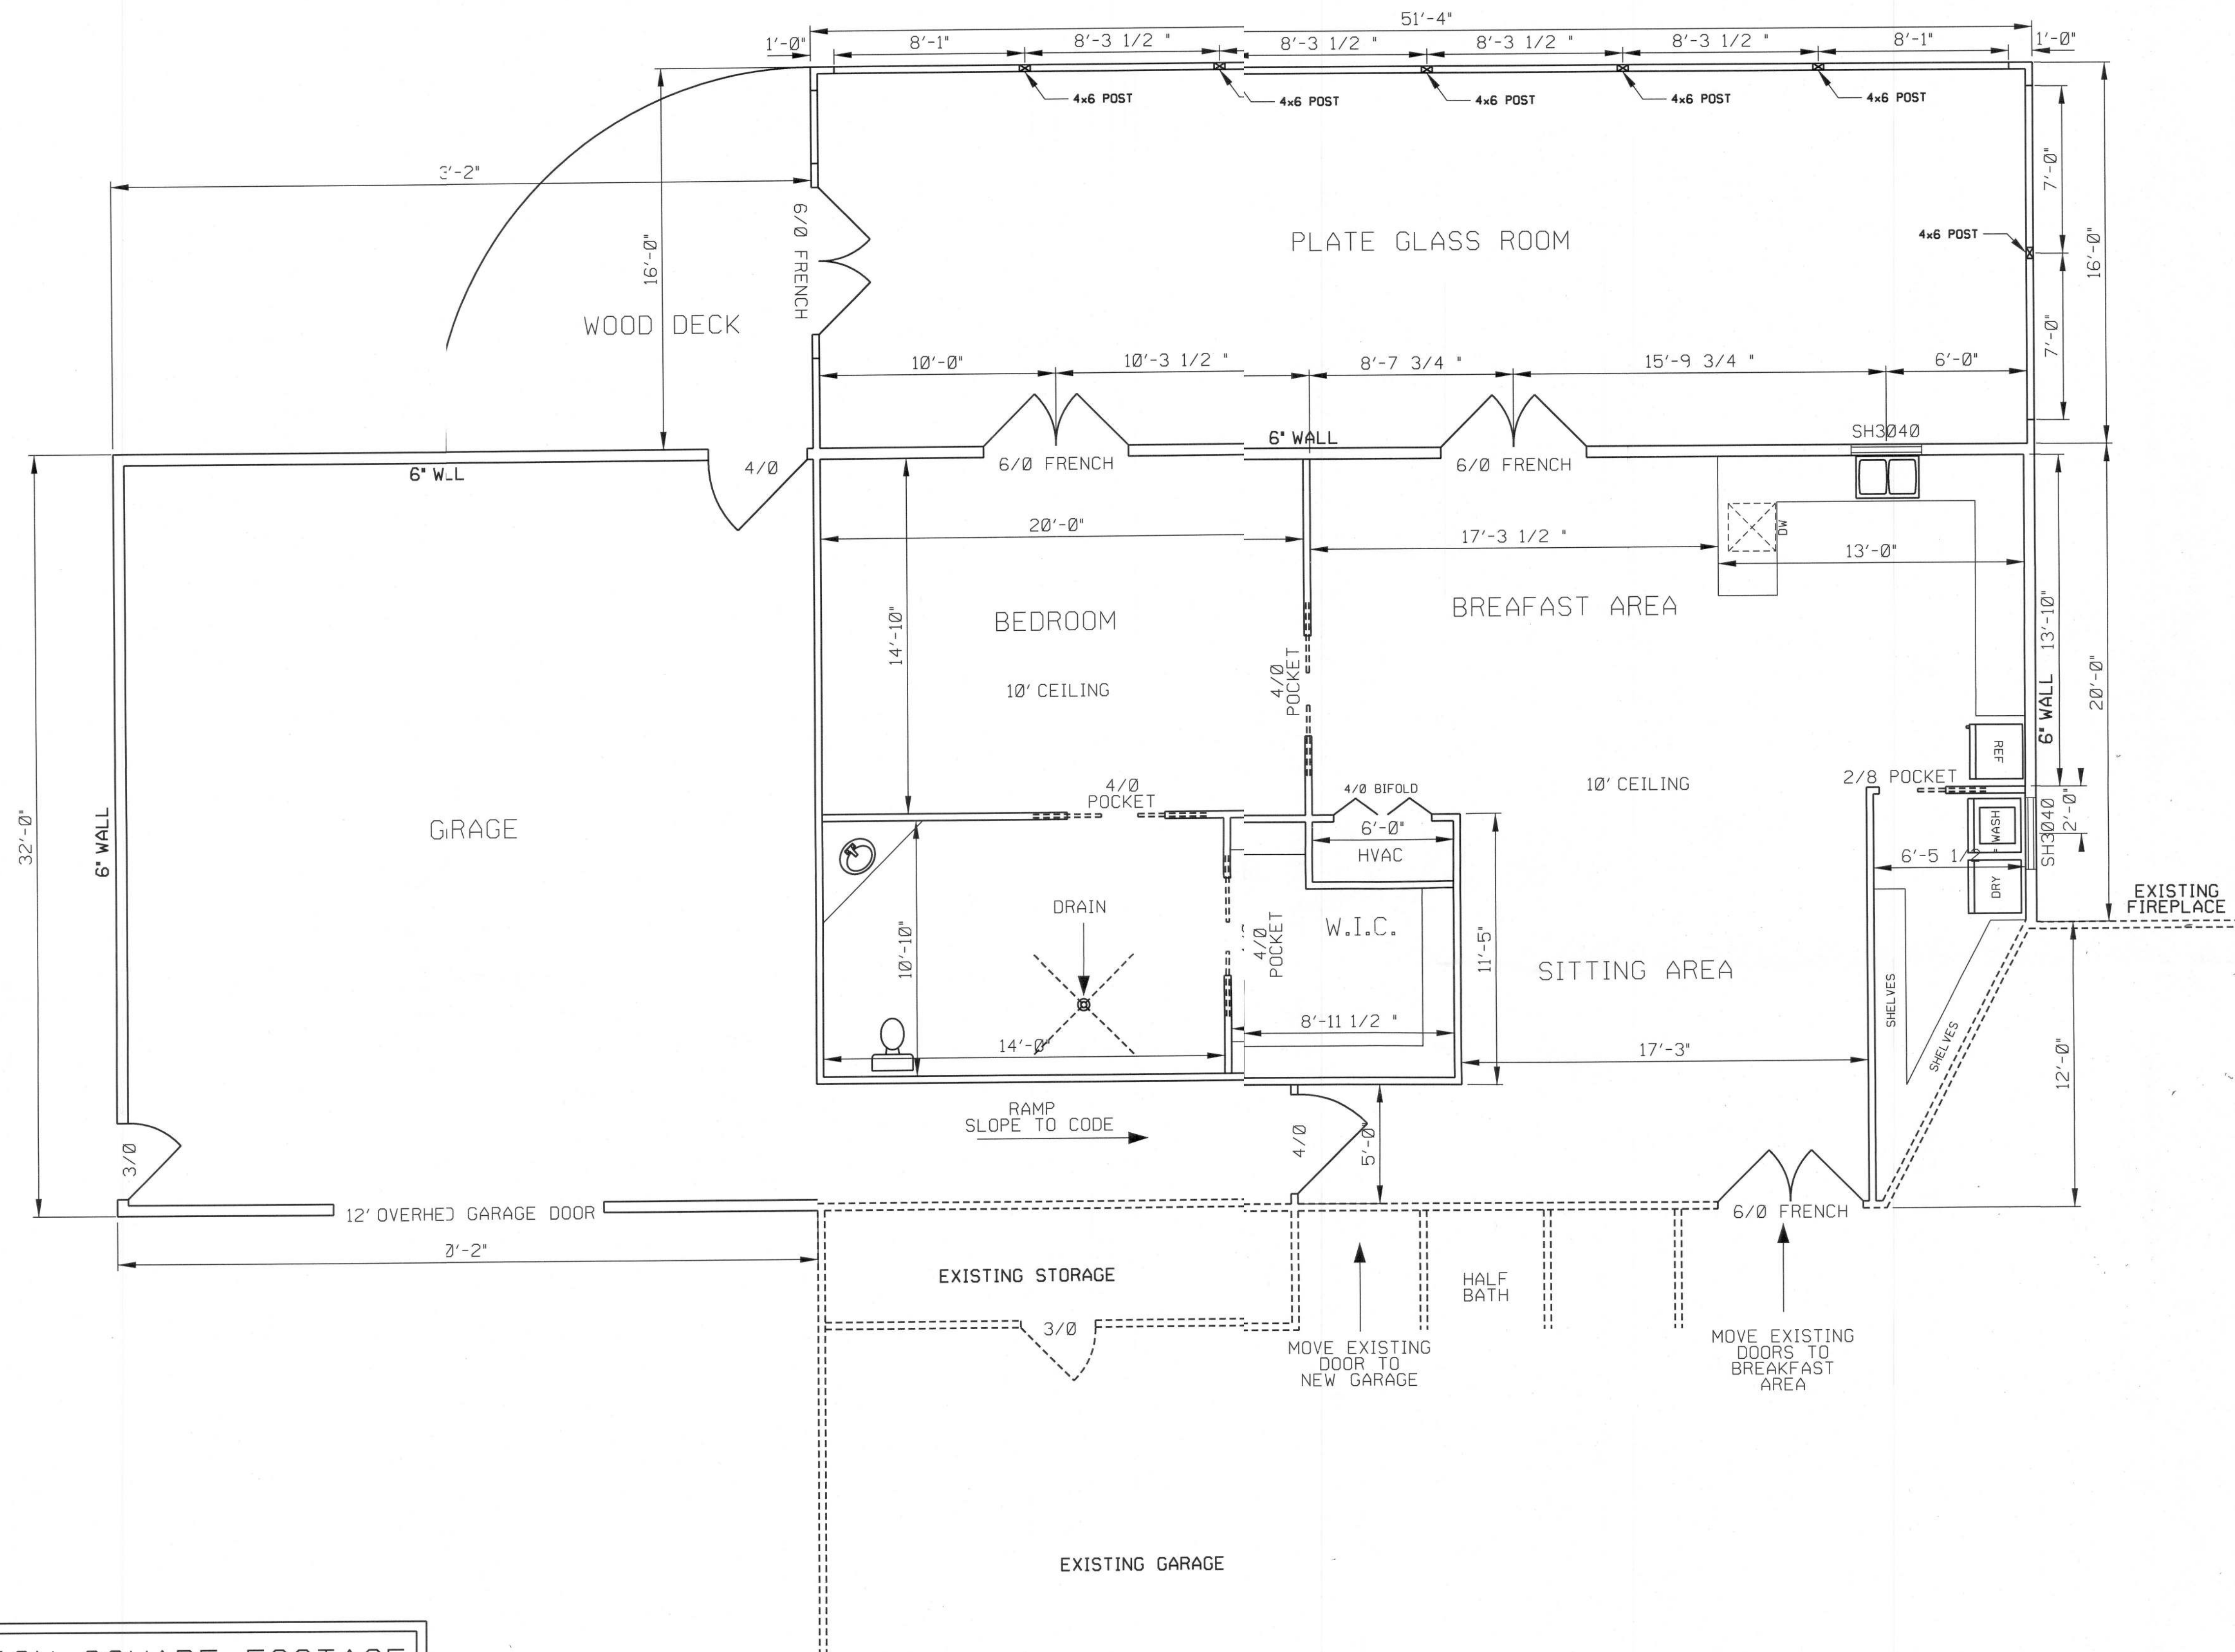

ADDITION SQUARE FOOTAGE	
HEATED AREA	1603 SF
GARAGE	965 SF
GLASS PORCH	845 SF
DECK	201 SF
TOTAL	3614 SF


FLOOR PLAN

0 4' 8'
scale


PLANS PREPARED BY:
CHRISTOPHER Q. DICKS
4035 SE CR 252, LAKE CITY, FL 32025

GRANGER RESIDENCE
COLUMBIA COUNTY, FLORIDA

SHEET
2
OF
8

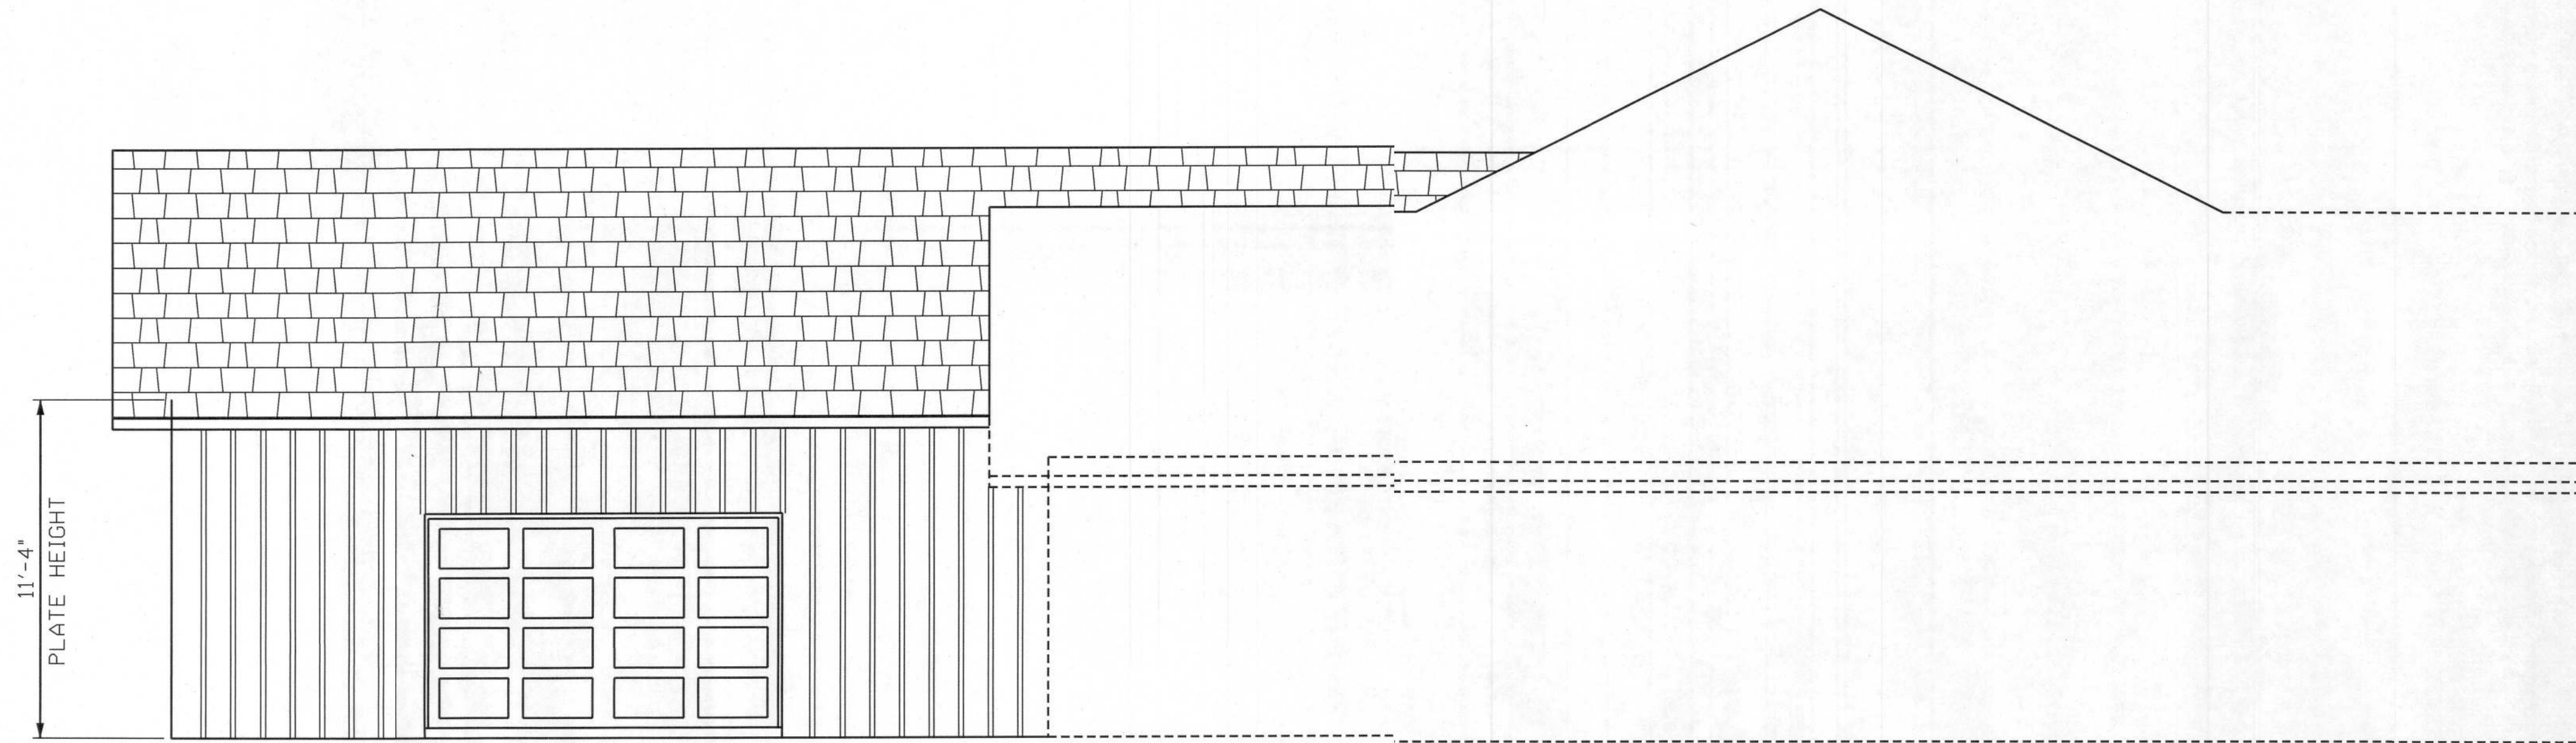

FRONT ELEVATION

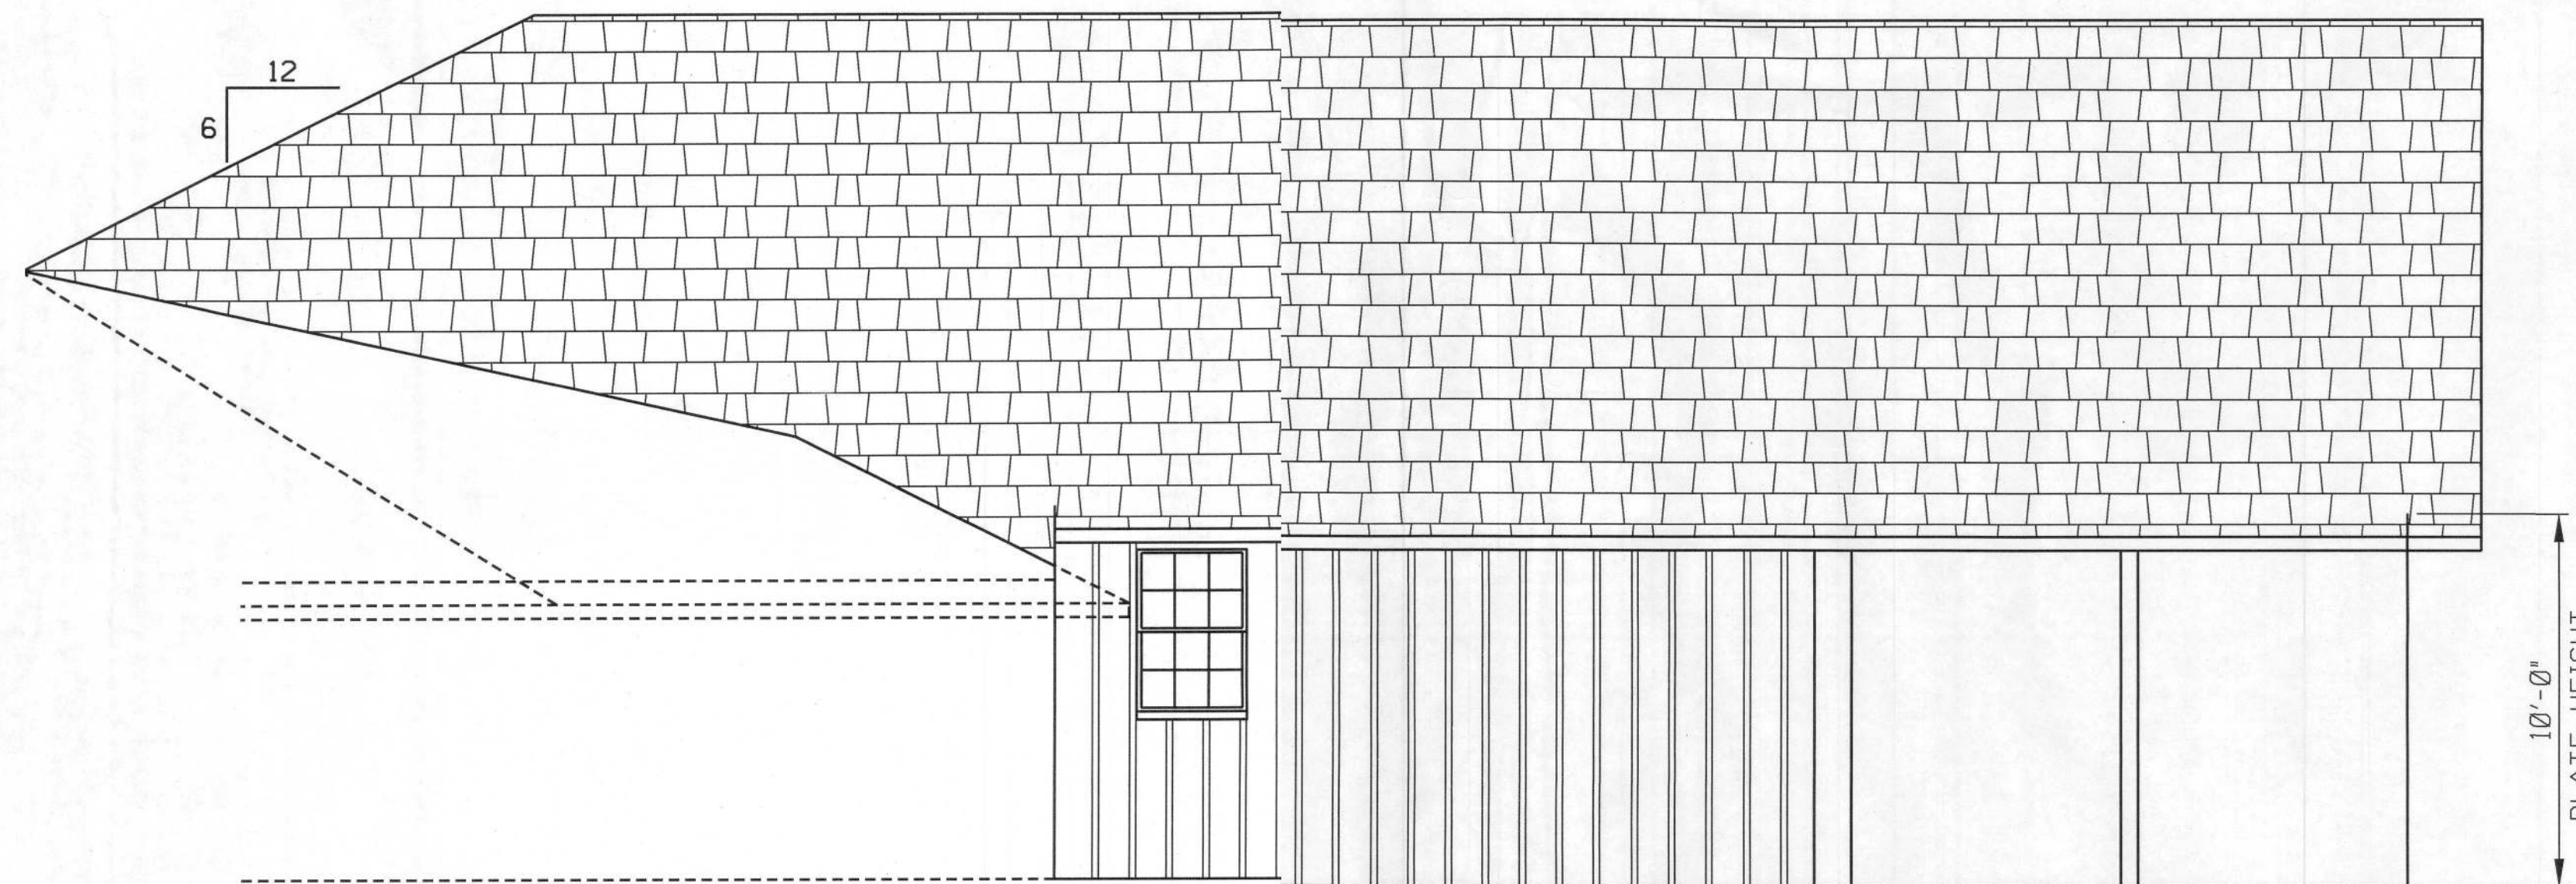


RIGHT ELEVATION

4' 8'
scale


GRANGER RESIDENCE
COLUMBIA COUNTY, FLORIDA

PLANS PREPARED BY:
CHRISTOPHER Q. DICKS
4035 SE CR 252, LAKE CITY, FL 32025

SHEET
3
OF
8

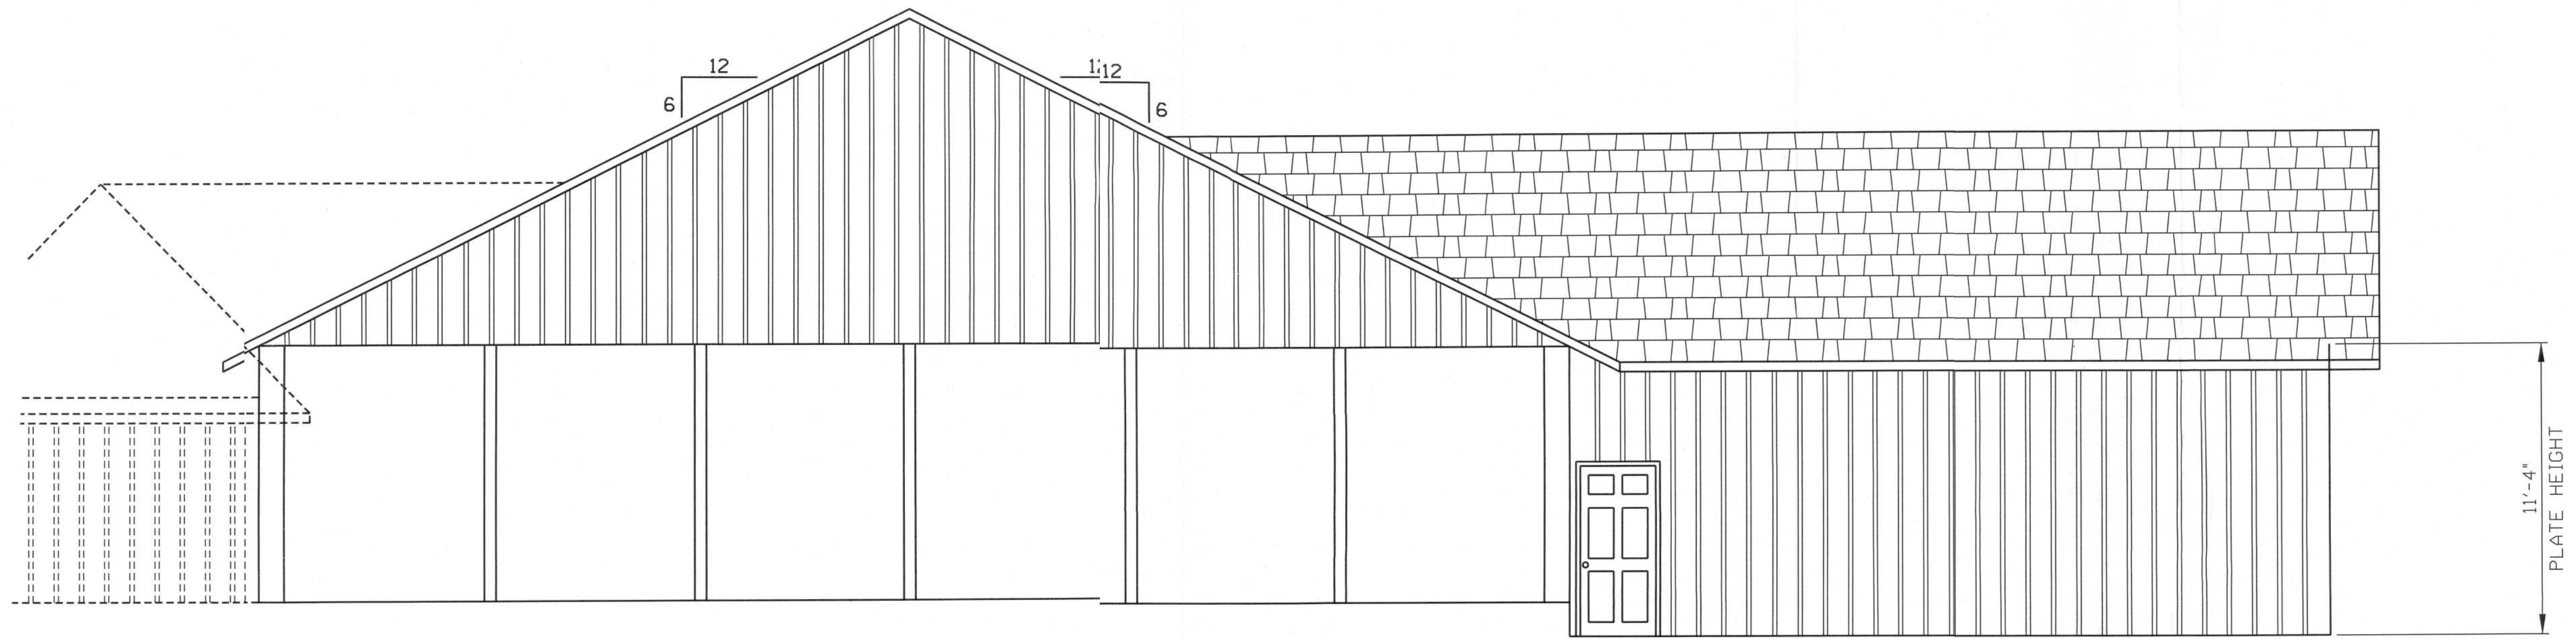

REAR ELEVATION

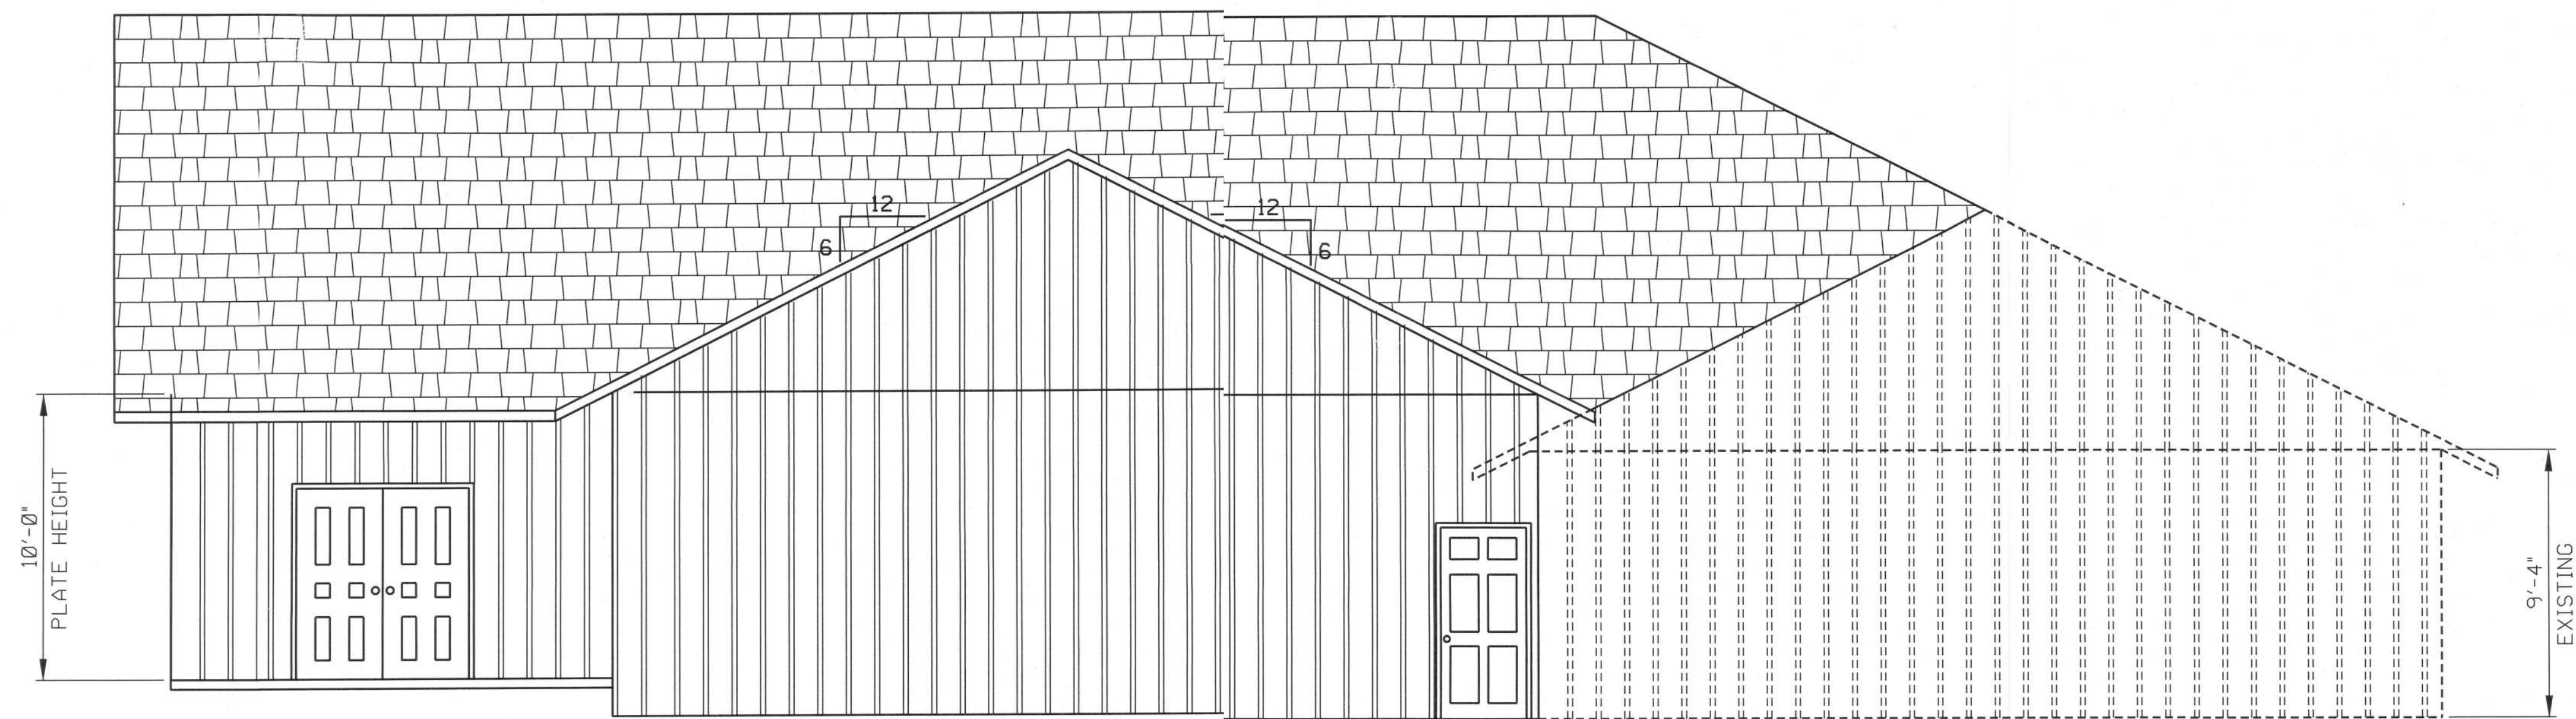



LEFT ELEVATION

0 4' 8'
scale

PLANS PREPARED BY:
CHRISTOPHER Q. DICKS
4035 SE CR 252, LAKE CITY, FL 32025

GRANGER RESIDENCE
COLUMBIA COUNTY, FLORIDA

SHEET
4
OF
8

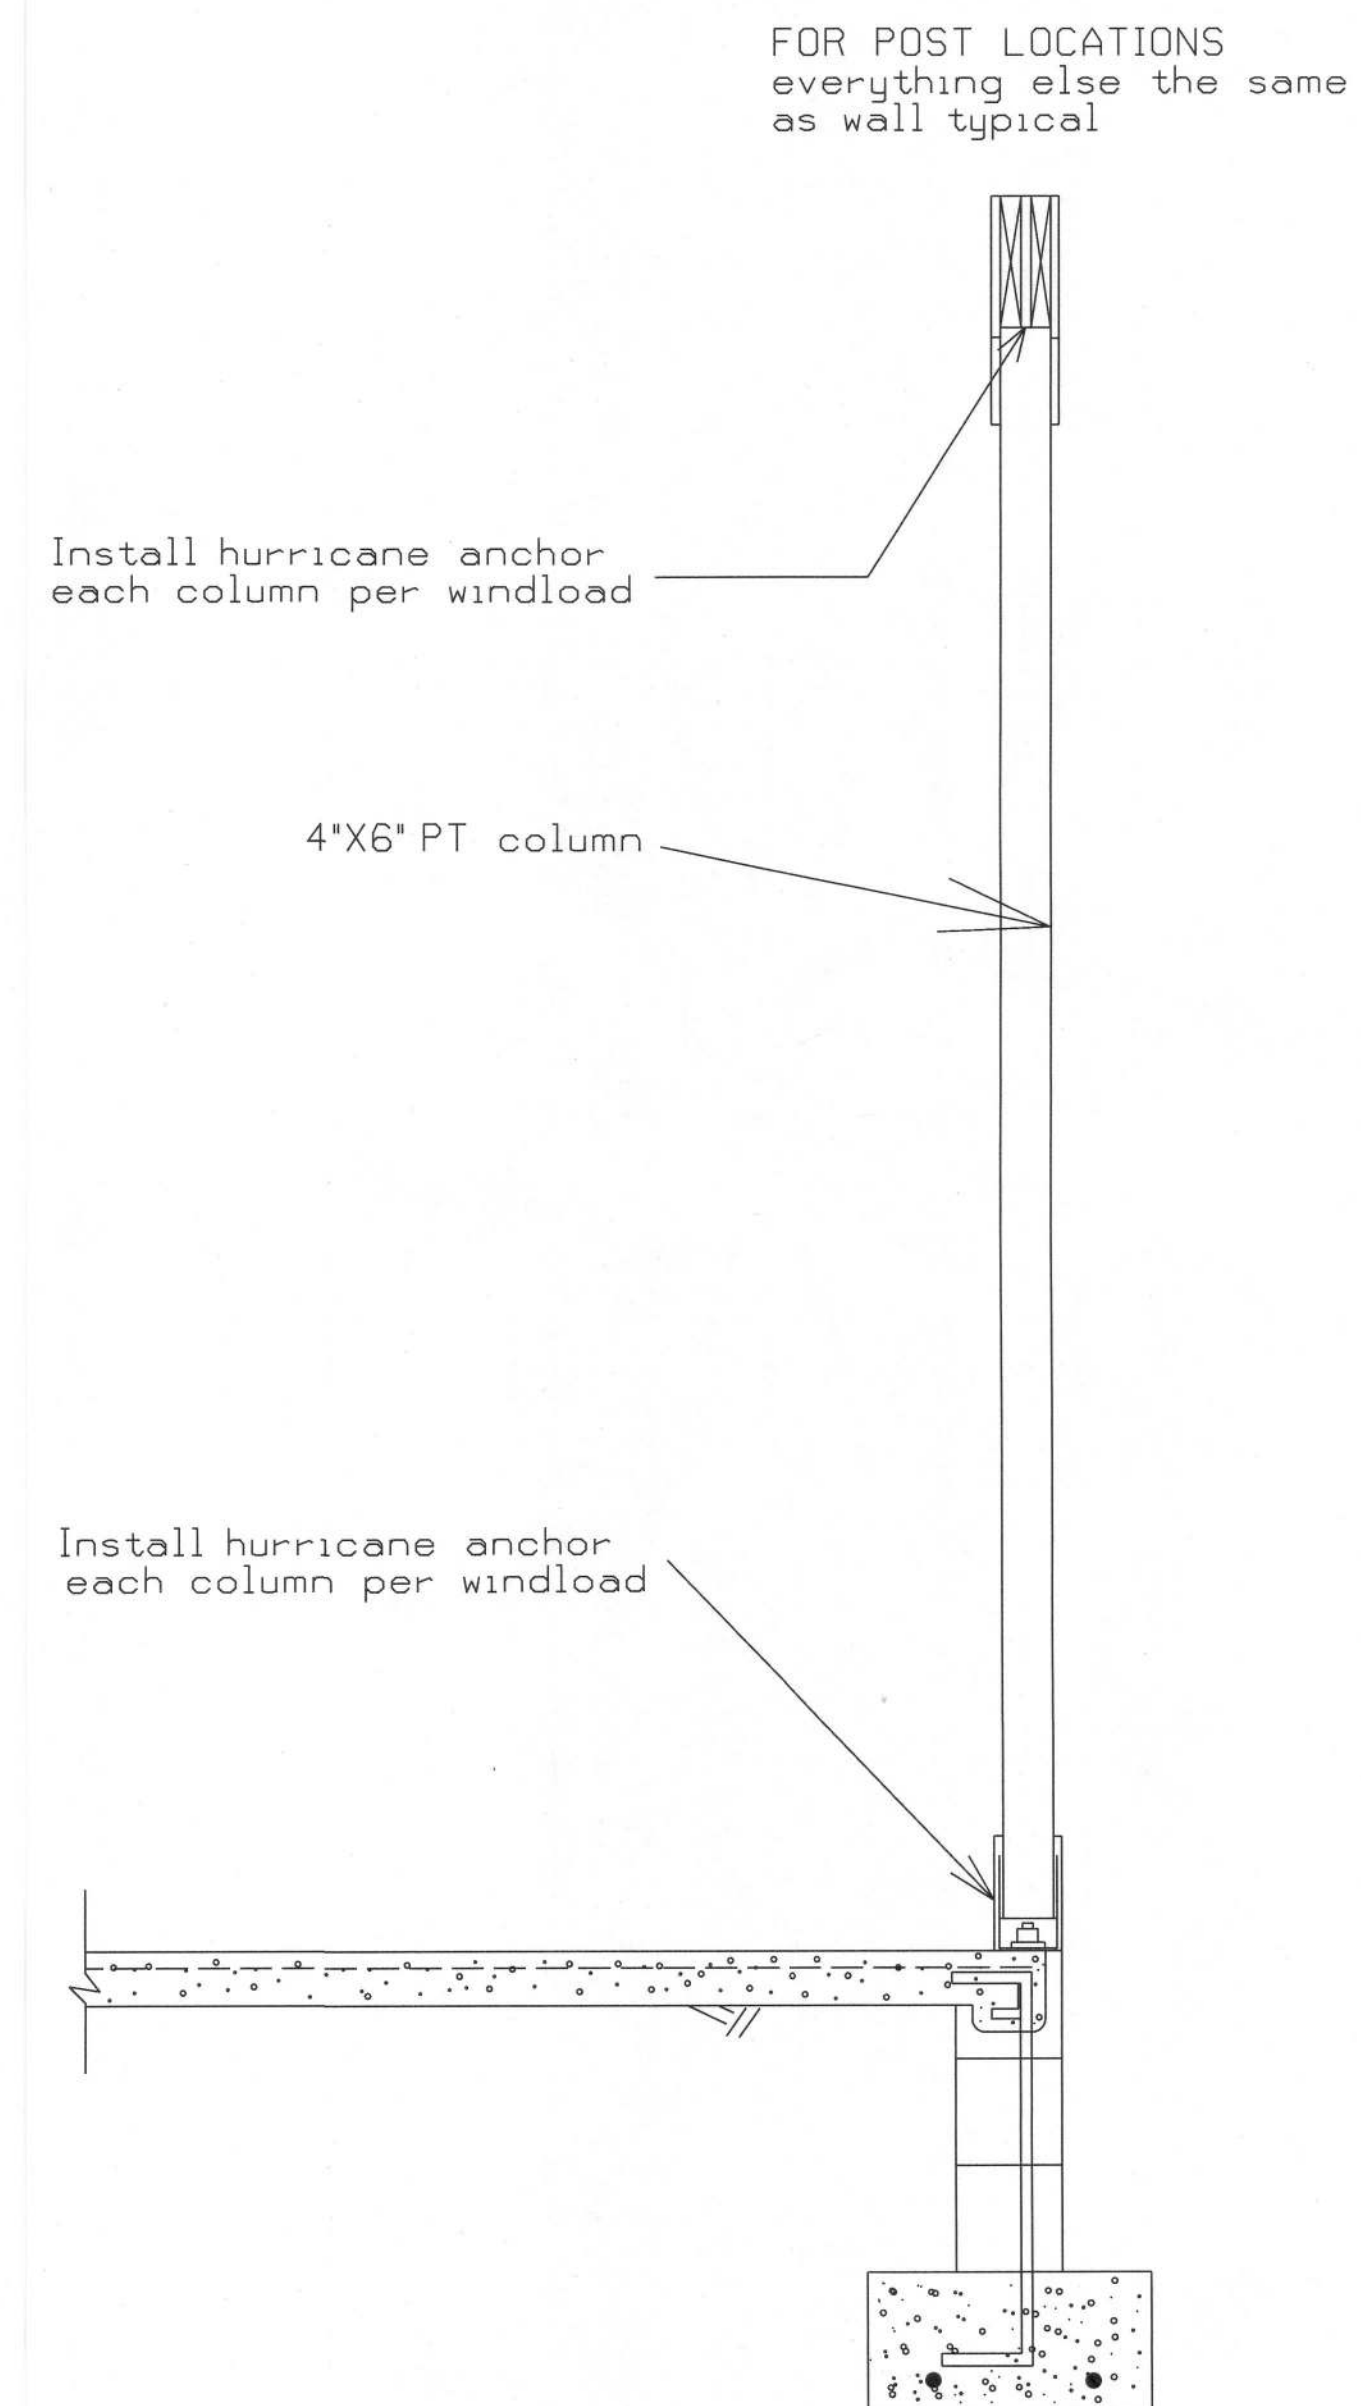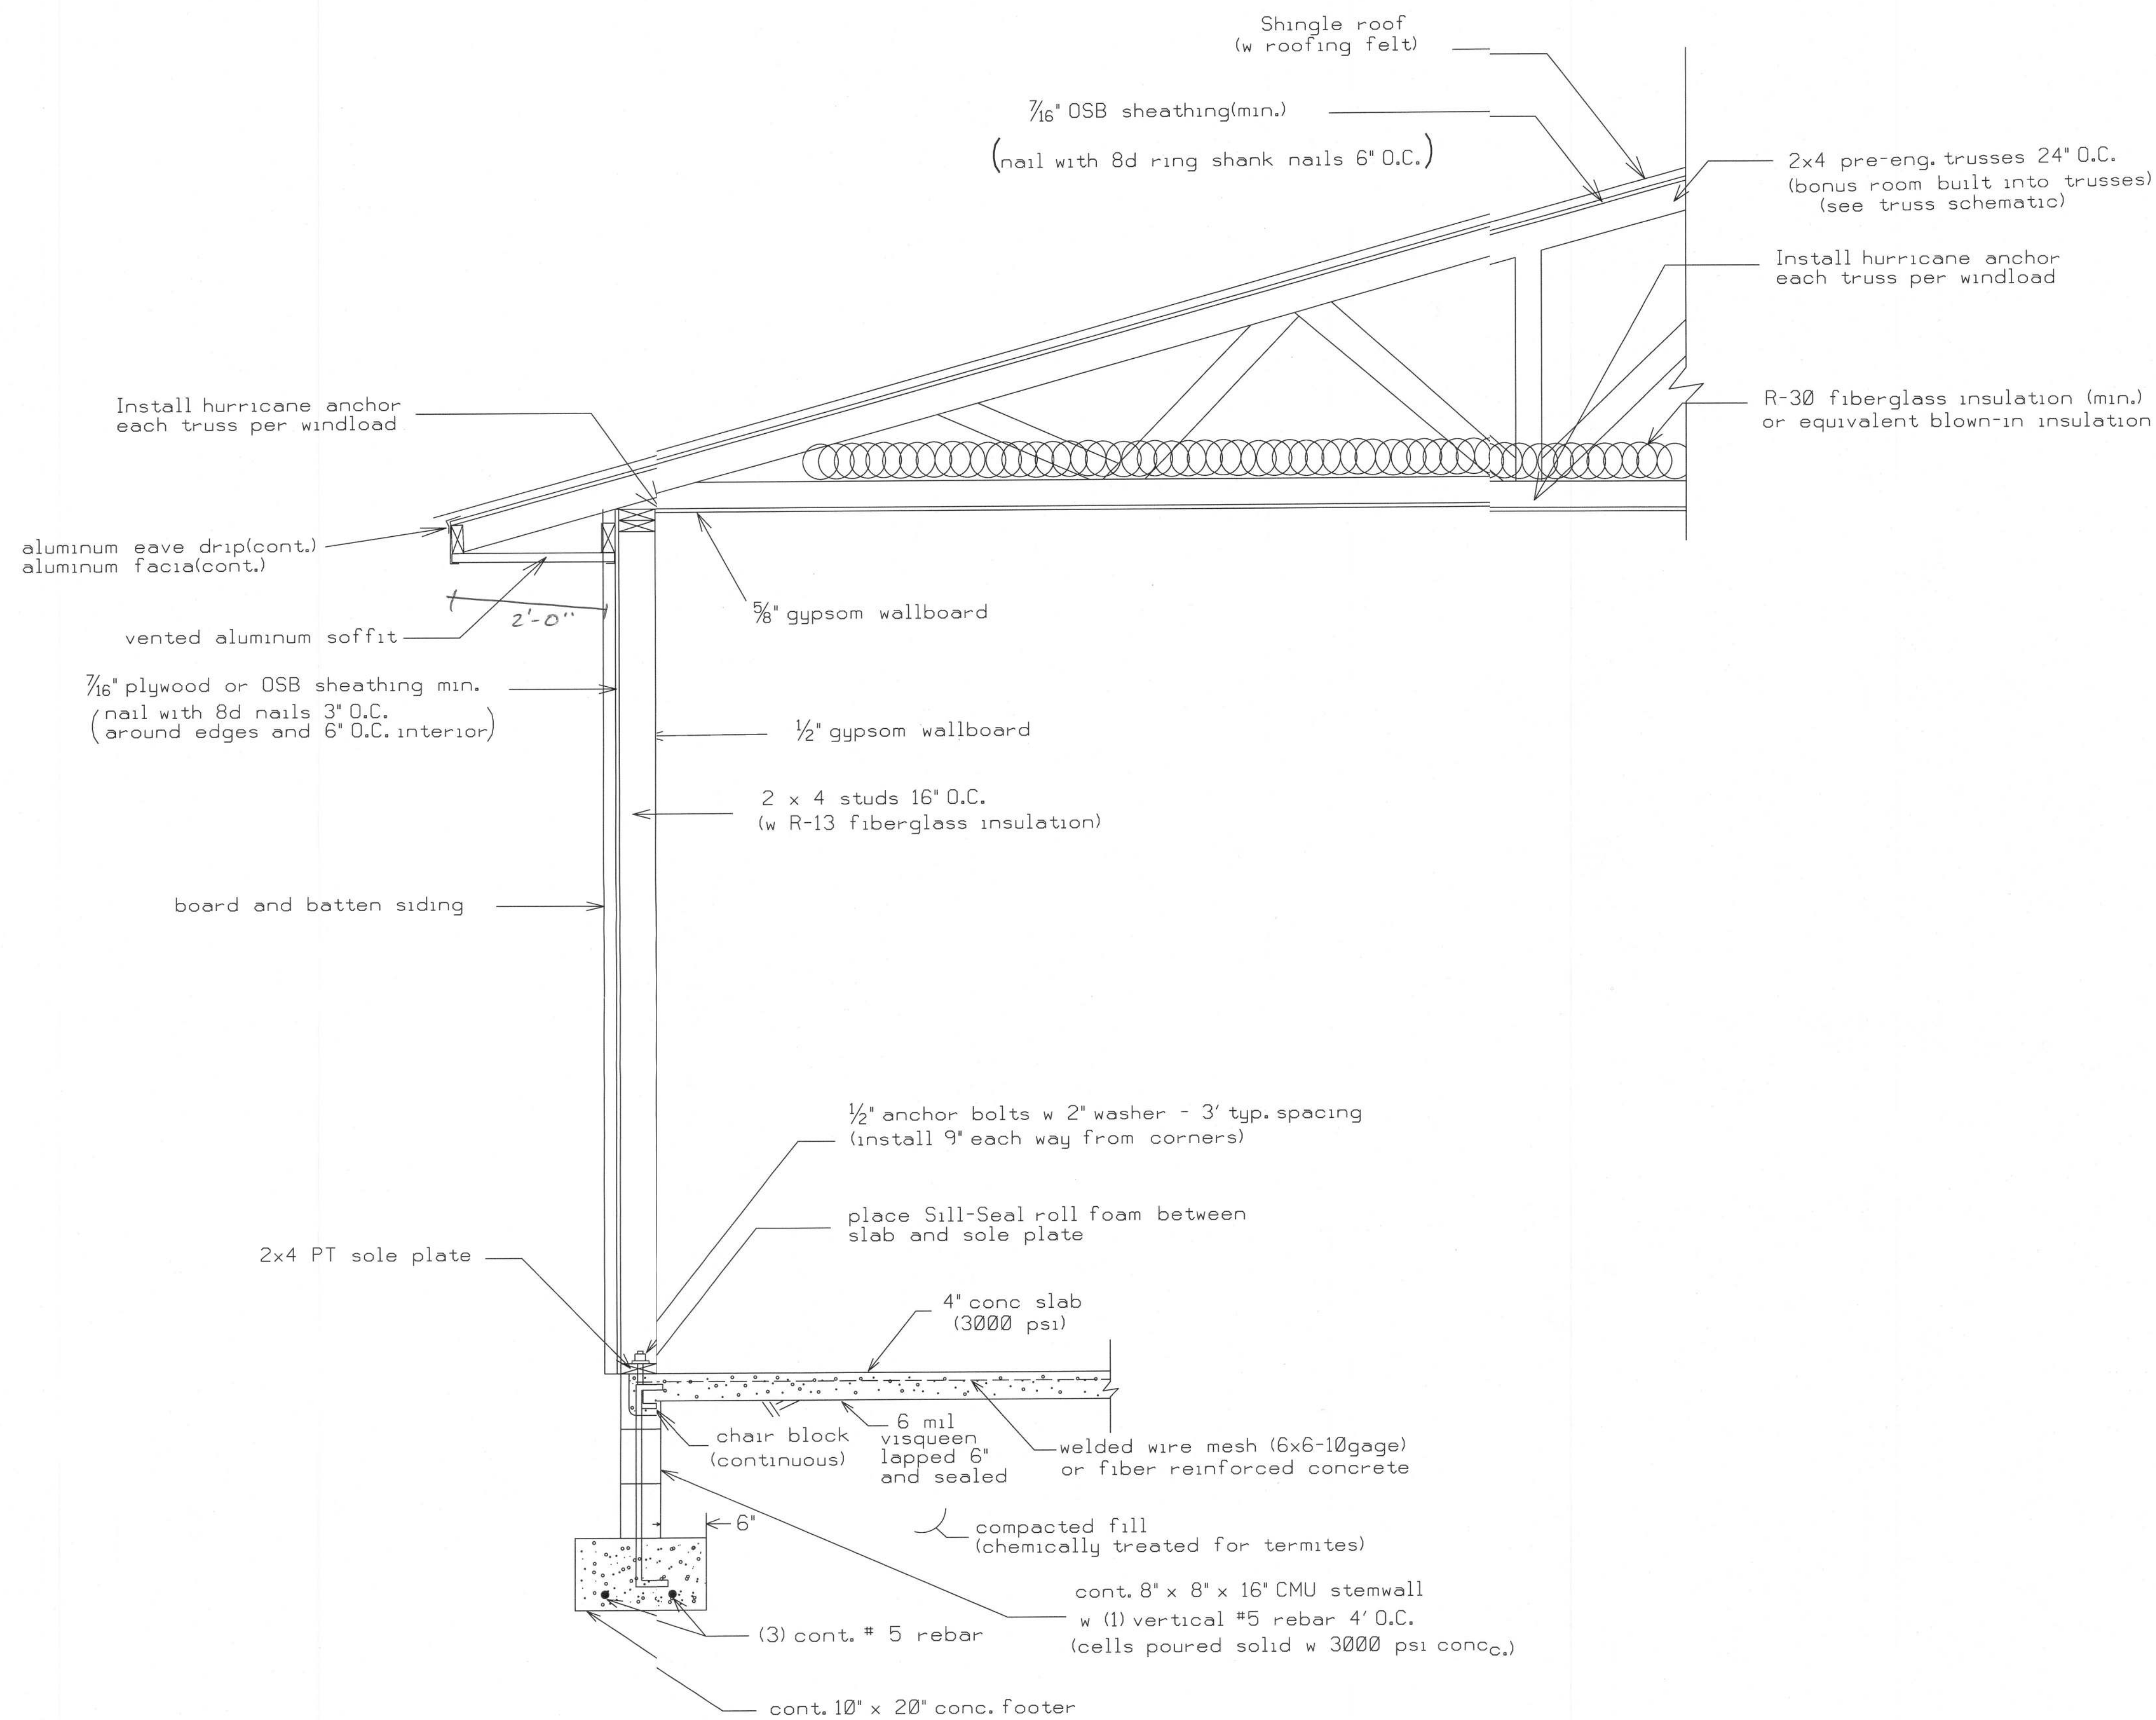


Note: Headers for windows ad doors
shall be 2-2x12's(#2 G.P) with $\frac{1}{2}$ "
plywood between. Porch beam
shall be 2 -2x10's(#2 GYP)with $\frac{1}{2}$ "
plywood between.

TYPICAL WALL SECTION N.T.S.


PLANS PREPARED BY:
CHRISTOPHER Q. DICKS
4035 SE CR 252, LAKE CITY, FL 32025

GRANGER RESIDENCE
COLUMBIA COUNTY, FLORIDA

SHEET
5
OF
8

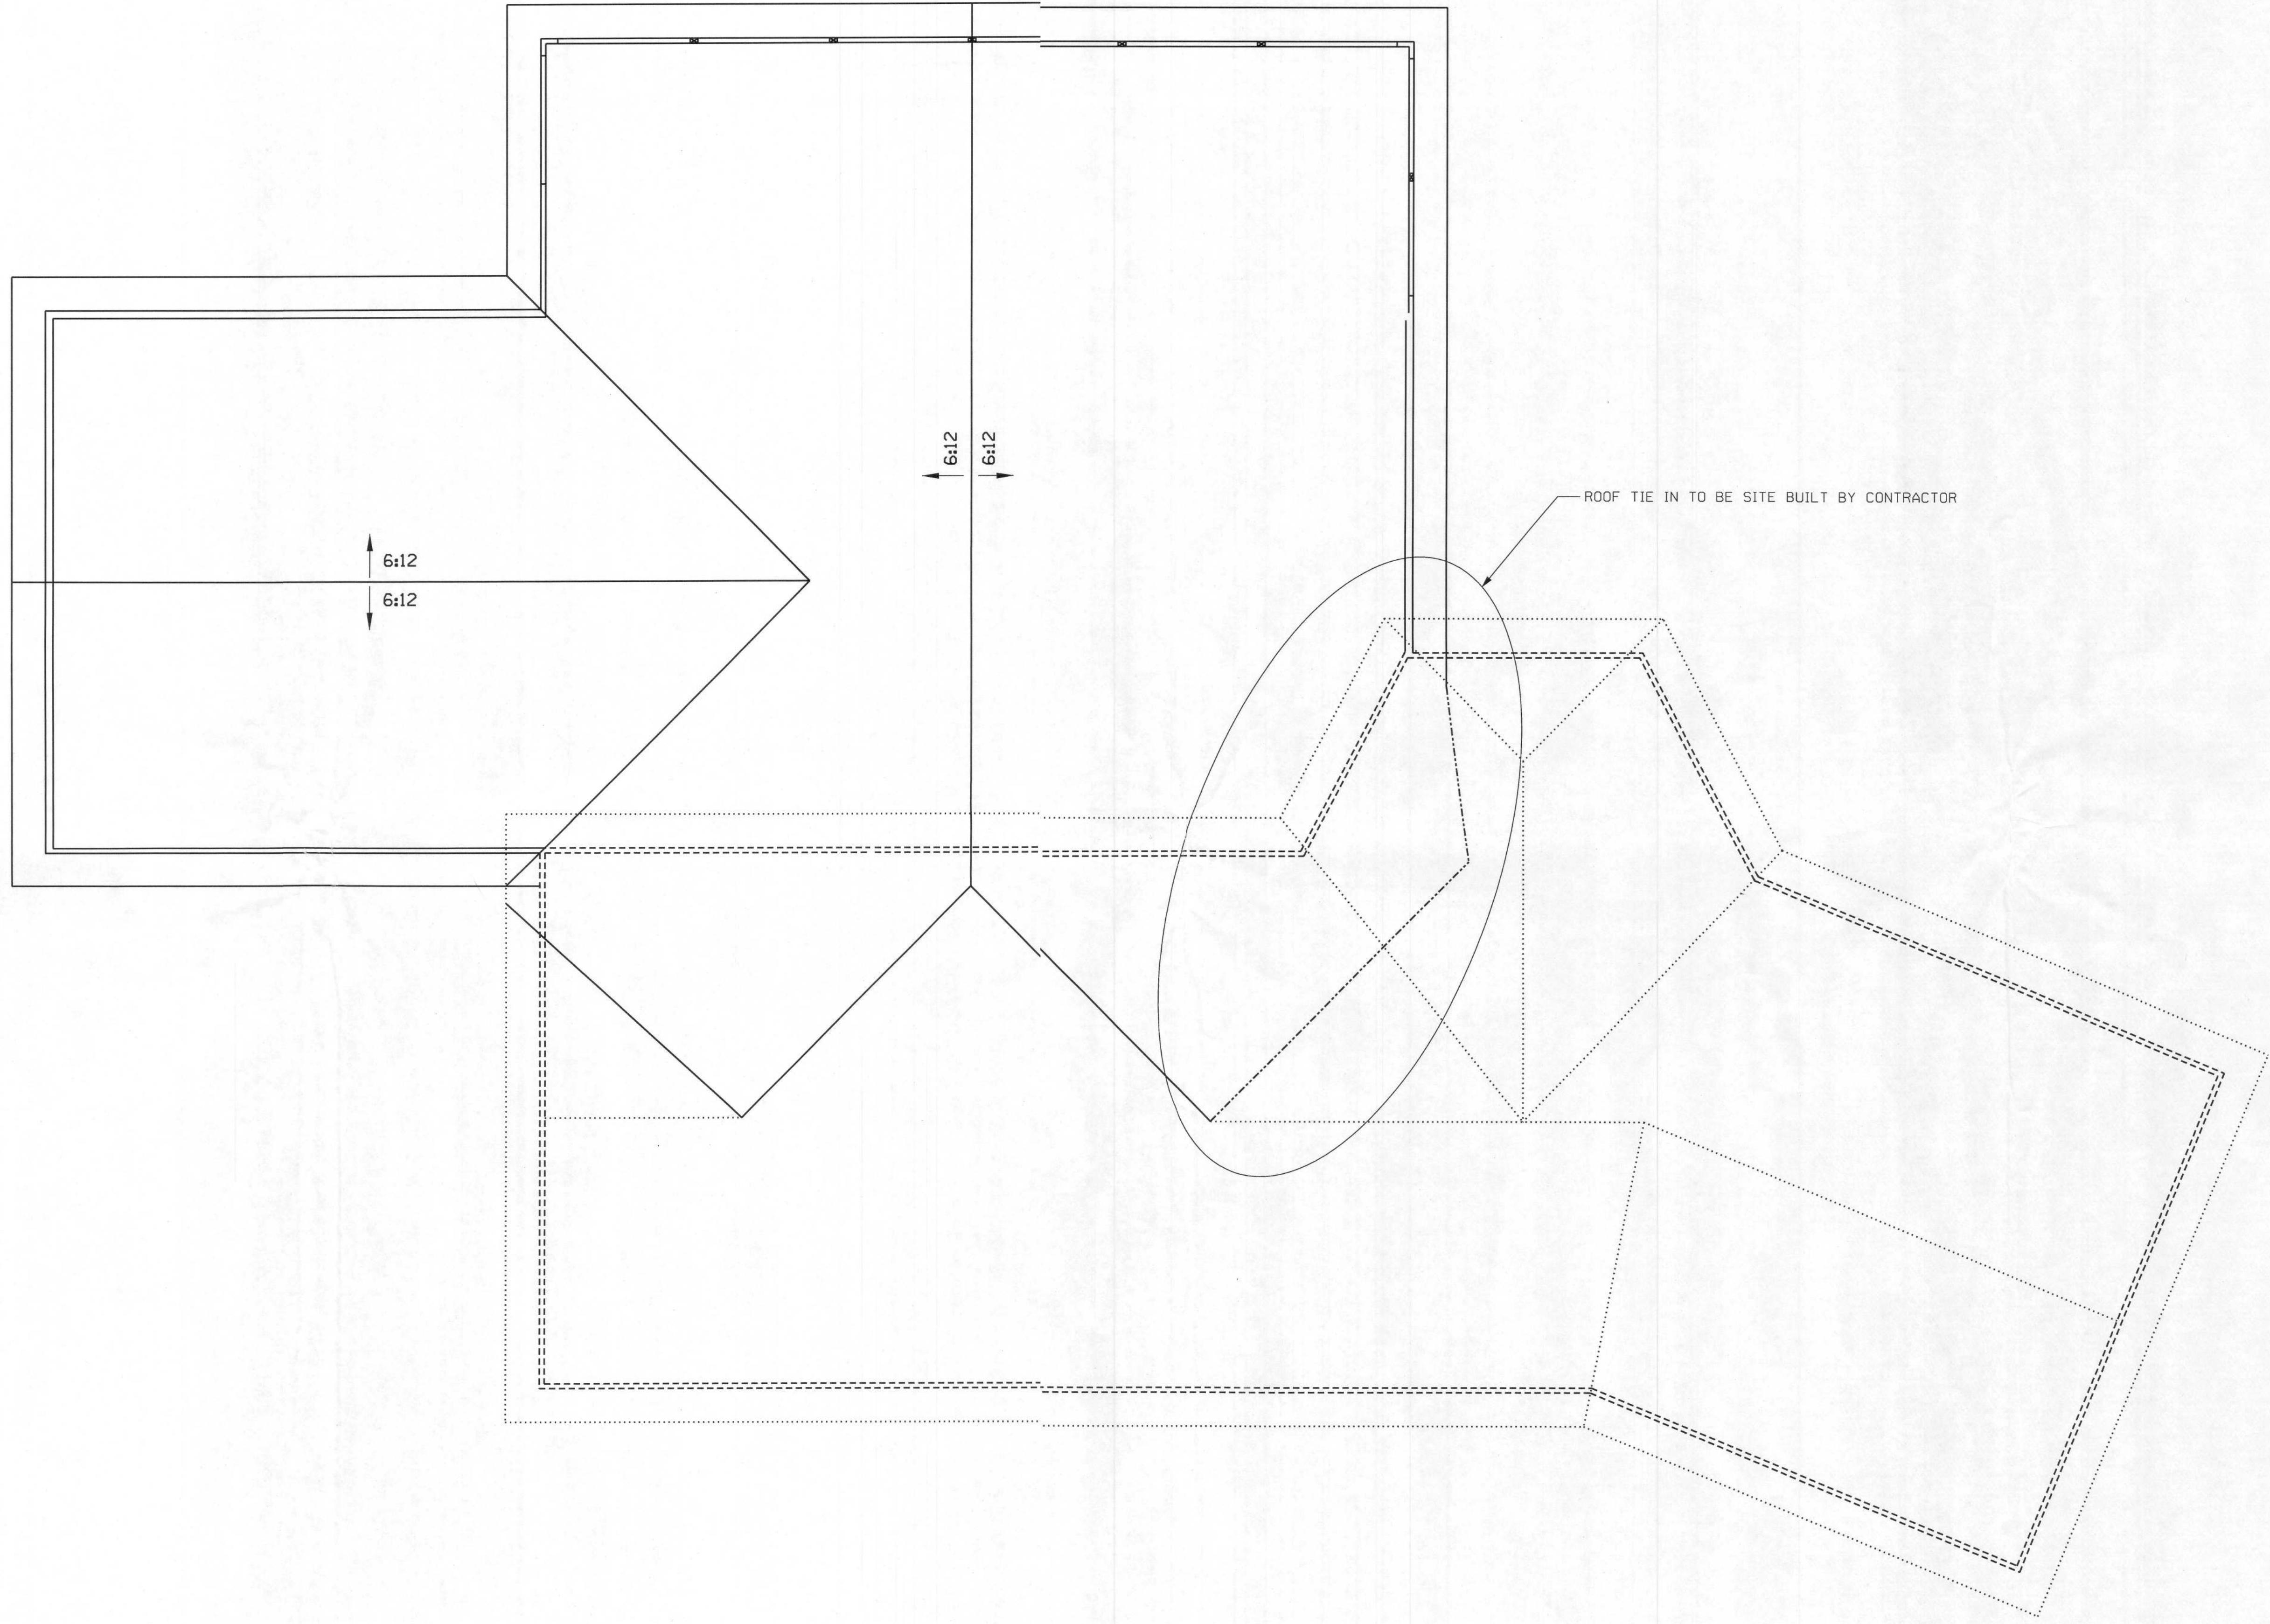

ROOF PLAN

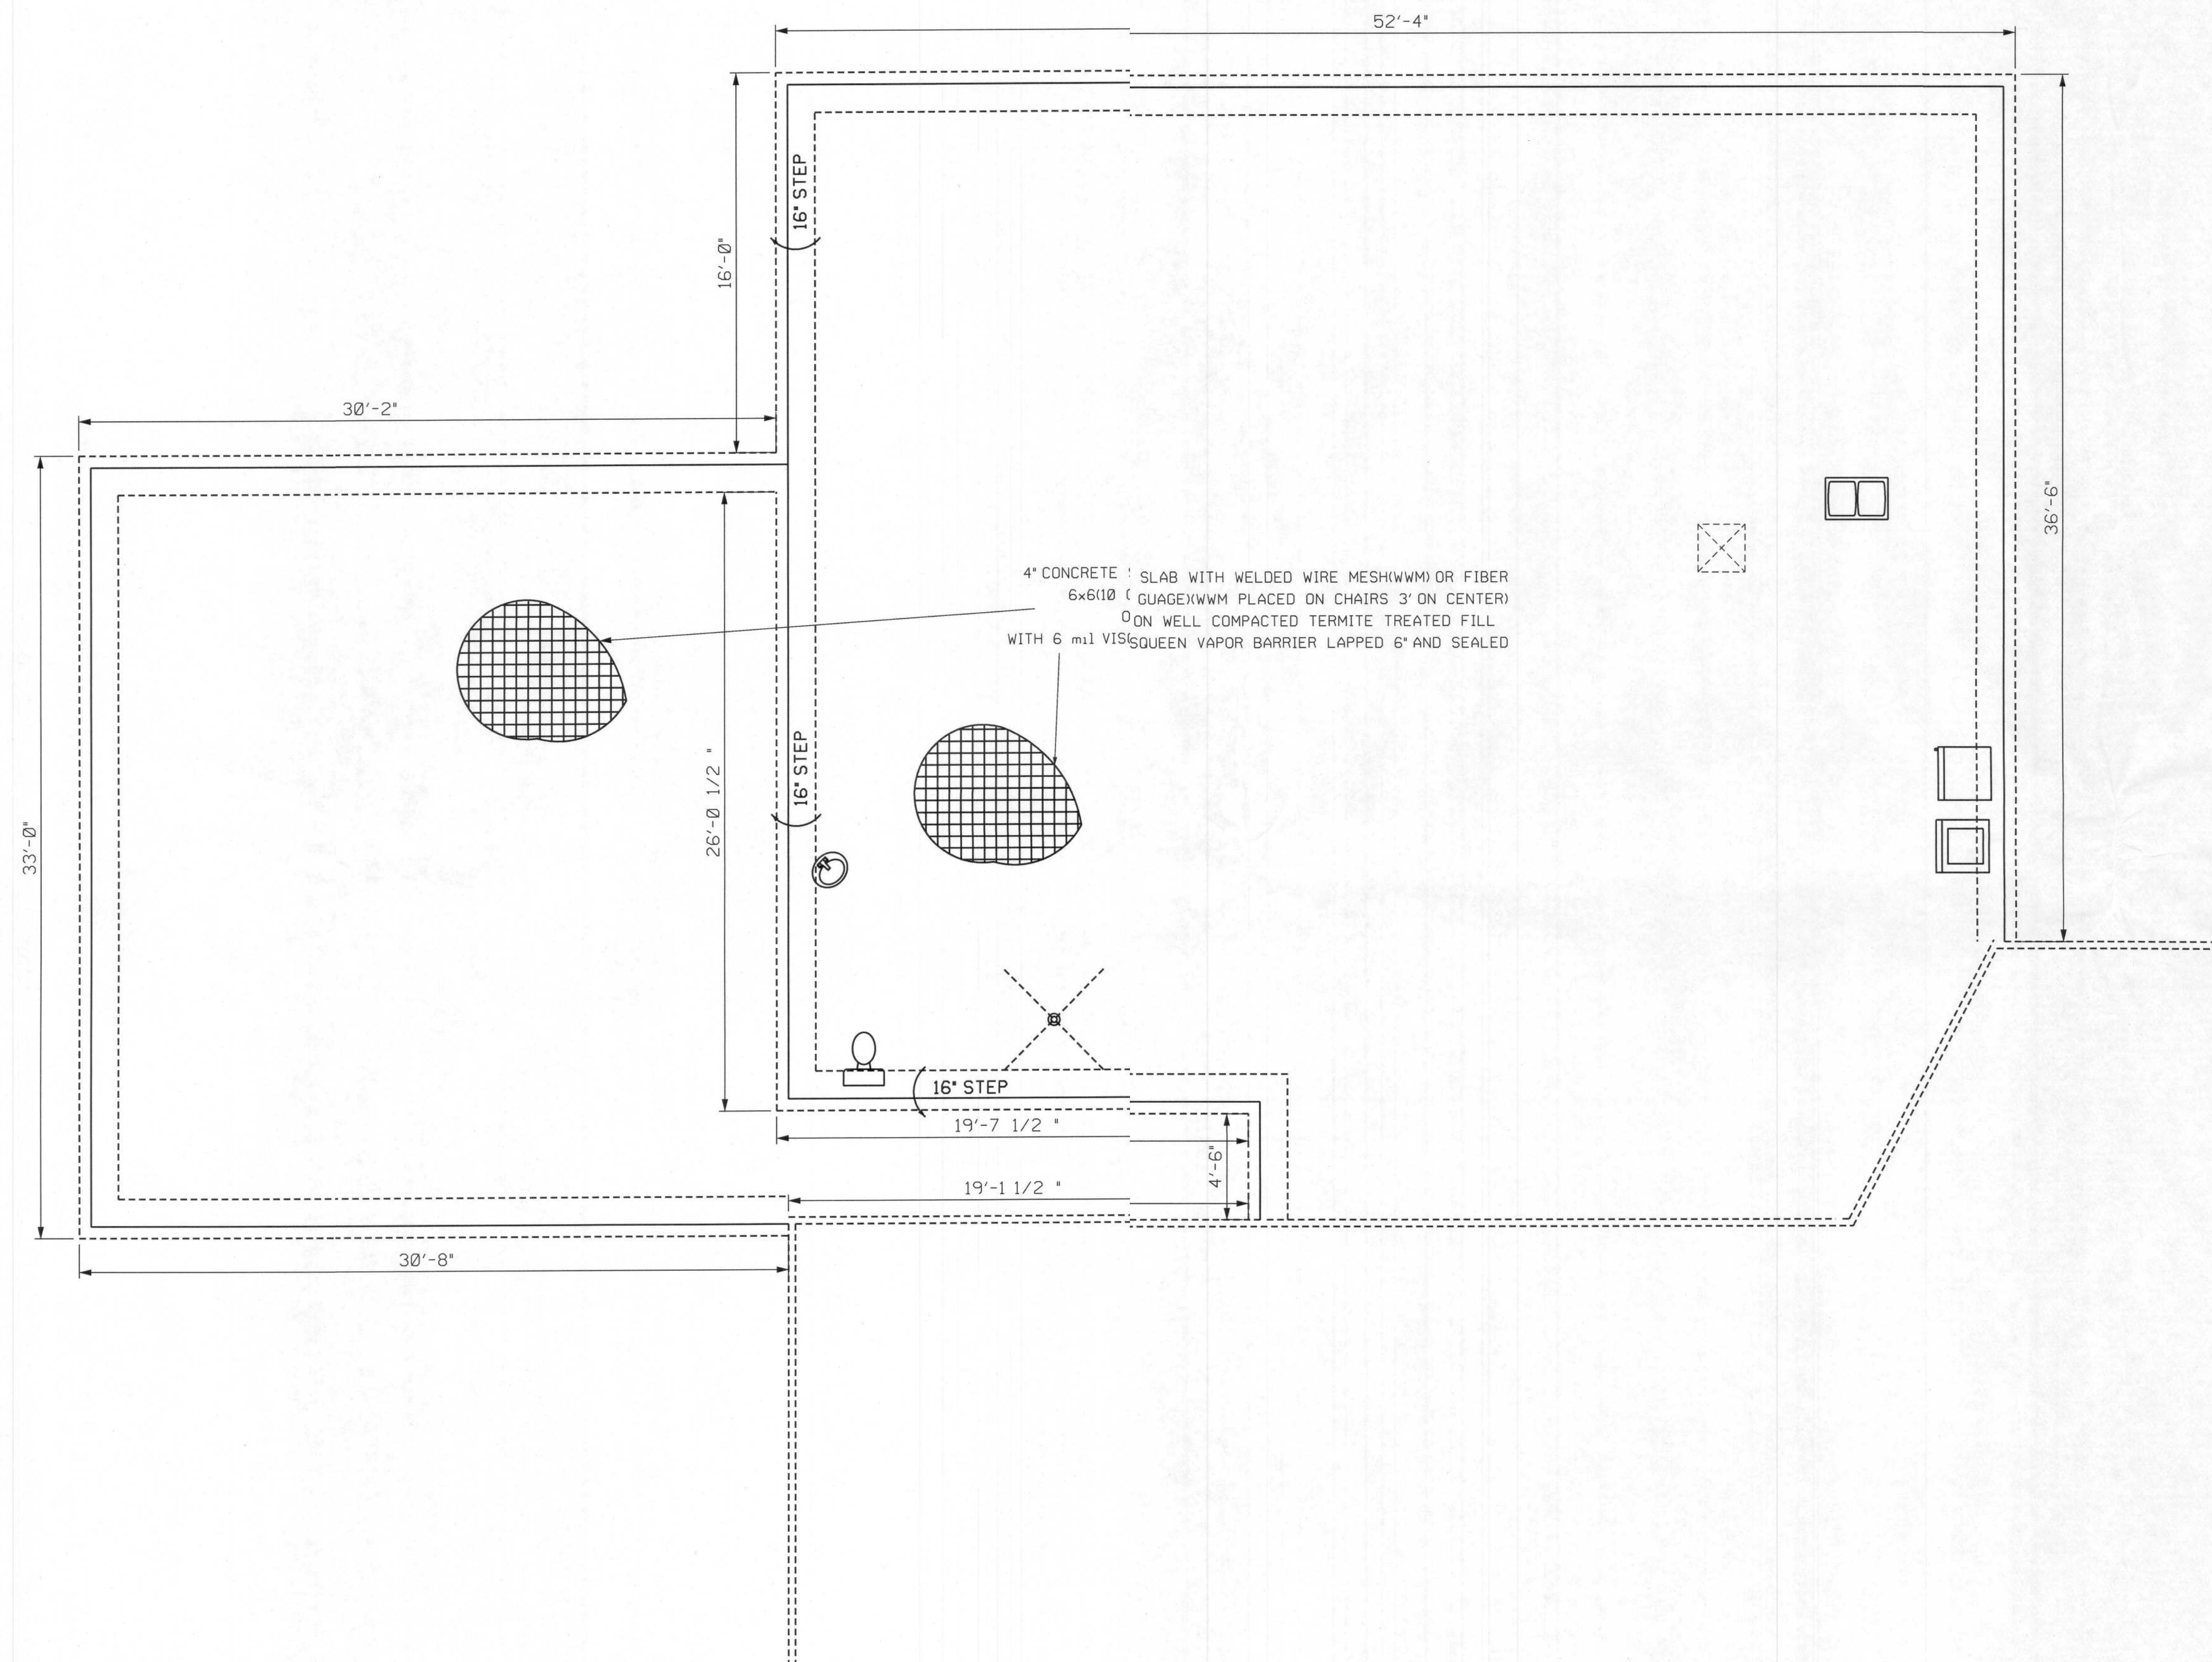

FOUNDATION & PLUMBING PLAN


 
 
0 4' 8'
scale

GRANGER RESIDENCE
COLUMBIA COUNTY, FLORIDA

PLANS PREPARED BY:
CHRISTOPHER Q. DICKS
4035 SE CR 252, LAKE CITY, FL 32025


SHEET
7
OF
8

ELECTRICAL LEGEND

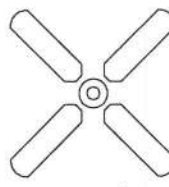-  - CEILING FAN w LIGHTS
-  - LIGHT FIXTURE
-  - RECESSED CAN LIGHT
-  - SINGLE POLE SWITCH
-  - THREE-WAY SWITCH
-  - RECEPT.
-  - GFI RECEPT OR PART OF A GFI CIRCUIT.
-  - SECURITY LIGHT
-  - EXHAUST WITH LIGHT
-  - 220 V.
-  - SMOKE DETECTOR
(AC/DC and interconnected)
-  - SMOKE/CARBON MONOXIDE DETECTOR COMINATION
(AC/DC and interconnected)
-  - TELEPHONE AND RG6 COAX
-  - FLUORESCENT LIGHT FIXTURE

NOTES:

1. ALL ELECTRICAL COMPONENTS, EQUIPMEN AND SYSTEMS SHALL COMPLY WITH THE PROVISIONS OF NFPA 70, NATIONAL ELECTRICAL CODE (LATEST EDITION) AND THE FLORIDA BUILDING CODE (LATEST EDITION).
2. ALL EXTERIOR RECEPTACLES SHALL BE WEATHERPROOF.
3. ALL BEDROOM RECEPTS SHALL BE PART OF AN AFCI CIRCUIT. EACH BEDROOM SHALL BE ON AN INDIVIDUAL AFC CIRCUIT.
4. ALL RECEPTACLES SHALL BE CHILDPROOF.

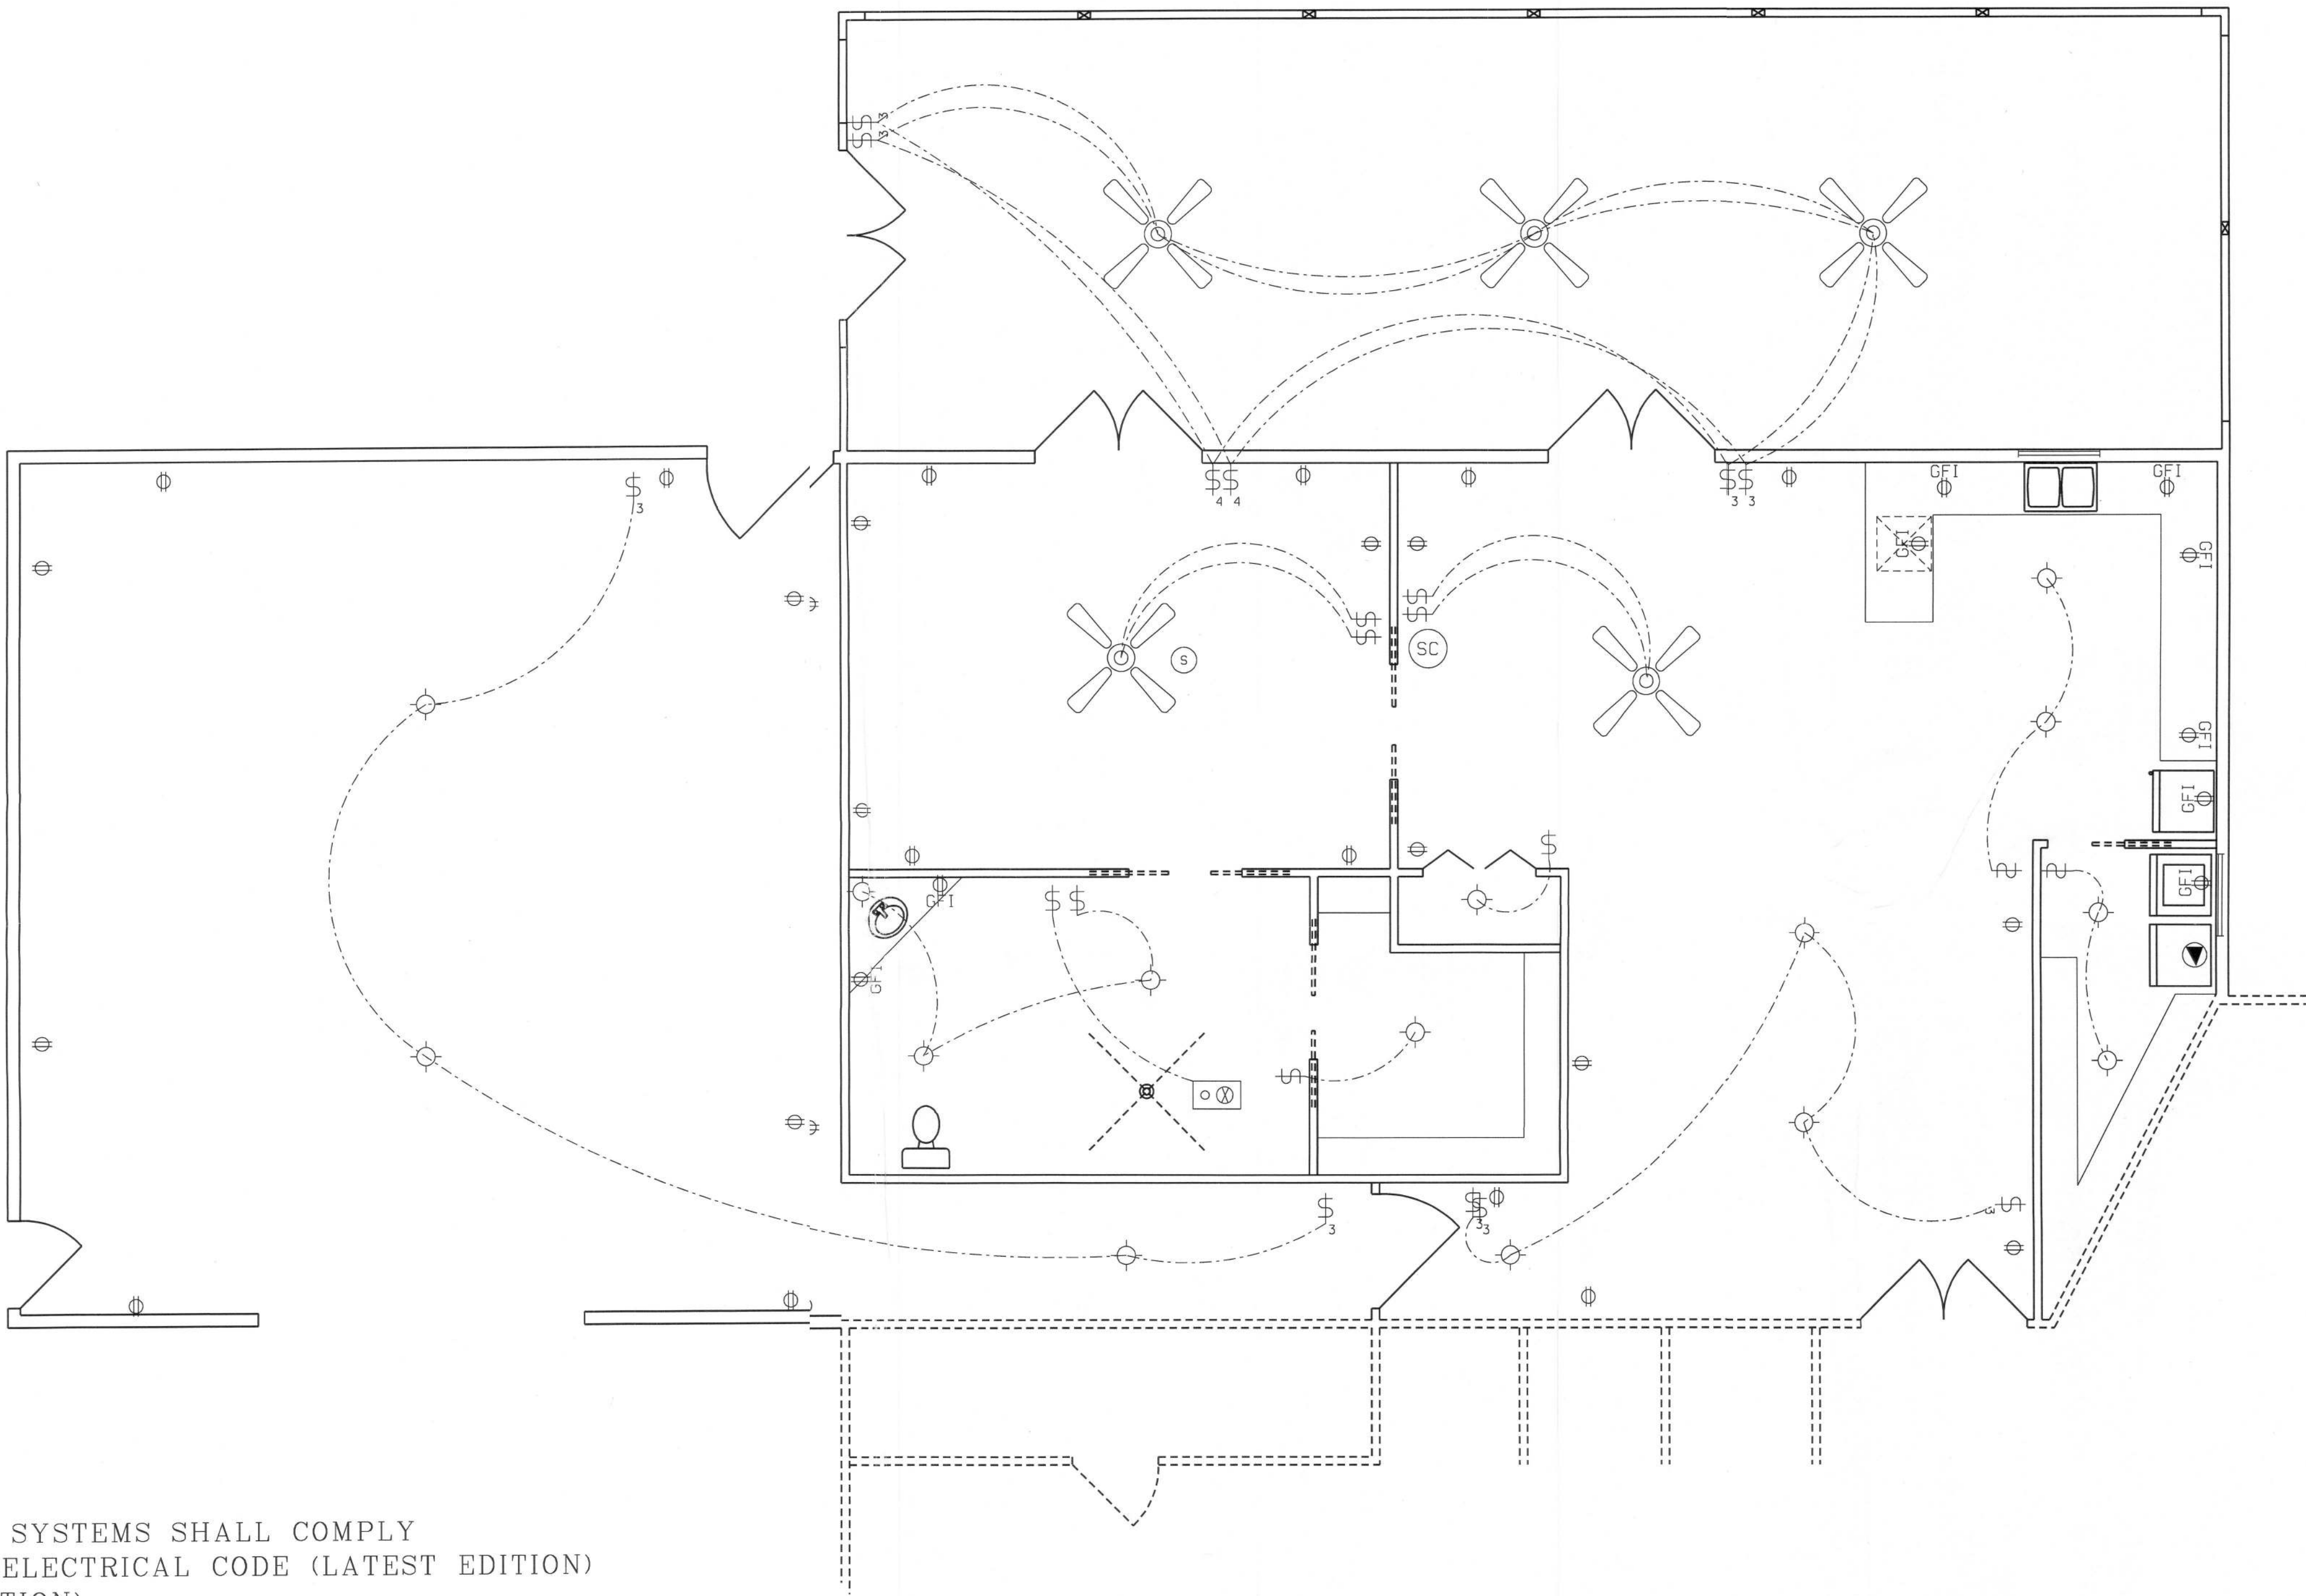

ELECTRICAL PLAN

0 4' 8'
scale

PLANS PREPARED BY:
CHRISTOPHER Q. DICKS
4035 SE CR 252, LAKE CITY, FL 32025

GRANGER RESIDENCE
COLUMBIA COUNTY, FLORIDA

SHEET
8
OF
8