
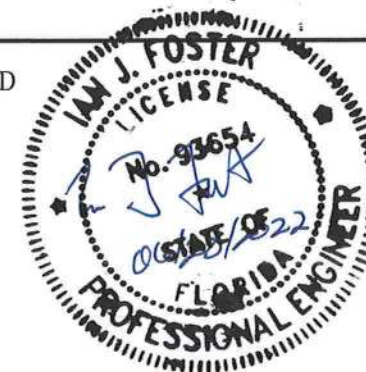


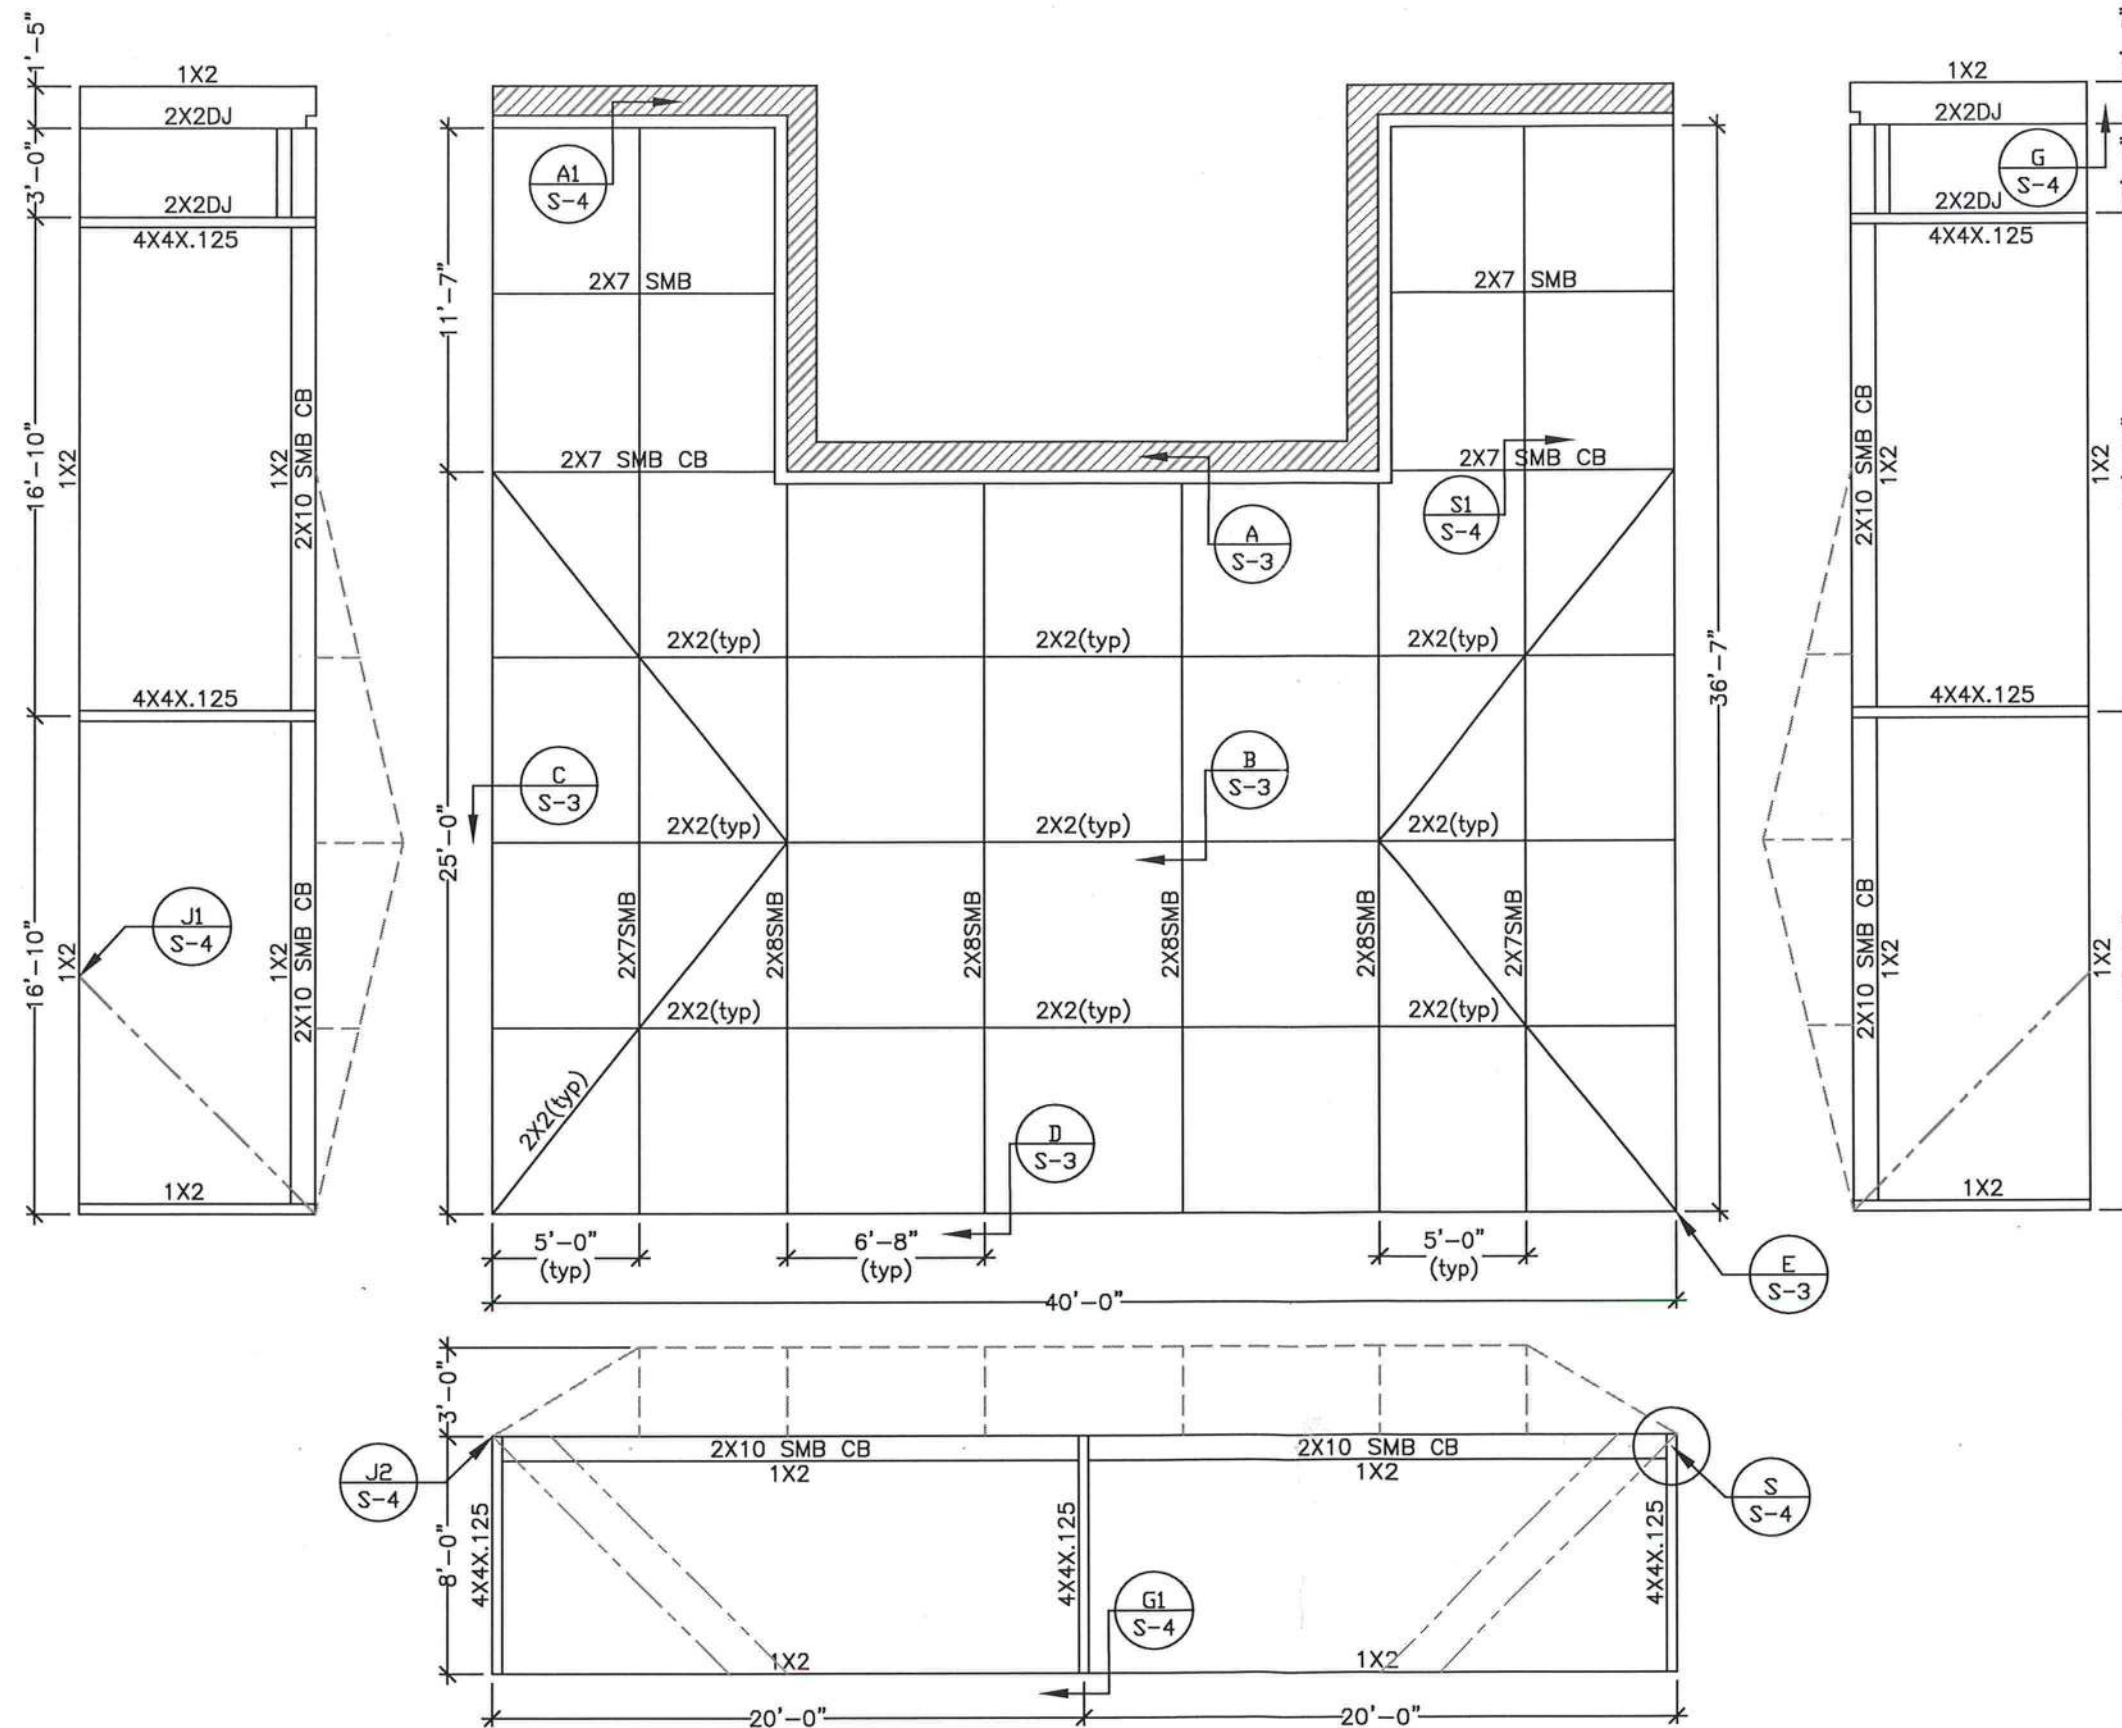

PROFESSIONAL ENGINEER SEAL

ENGINEER OF RECORD:

David W. Smith P.E.

FLORIDA LICENSE: 53608

Thomas L. Hanson P.E.

FLORIDA LICENSE: 38654

Ian J. Foster P.E.

FLORIDA LICENSE: 93654

Joel Falardeau P.E.

FLORIDA LICENSE: 70667

Erik Stuart P.E.

FLORIDA LICENSE: 77605

FBC Plans & Engineering Services, Inc.

6272 Abbott Station Dr. Unit 101

Zephyrhills, FL 33542

Ph# (813)788-5314

Fax# 1-(866)824-7894

E-mail-erb@fbcplans.com

Website-www.fbcplans.com

C.O.A.-#29054

DATE: 06/27/2022

DRAWN BY: BB

REVISION:	DATE:
RO 1	
RO 2	
RO 3	
RO 4	

Job# 22_0621_286

PROJECT ADDRESS:

SLONE

198 SW MAGPIE CT

FORT WHITE, FL 32038

CONTRACTOR:

LAKE SIDE ALUMINUM, INC.

FLOOR PLAN

S-2

18/14 SCREEN CAGE