
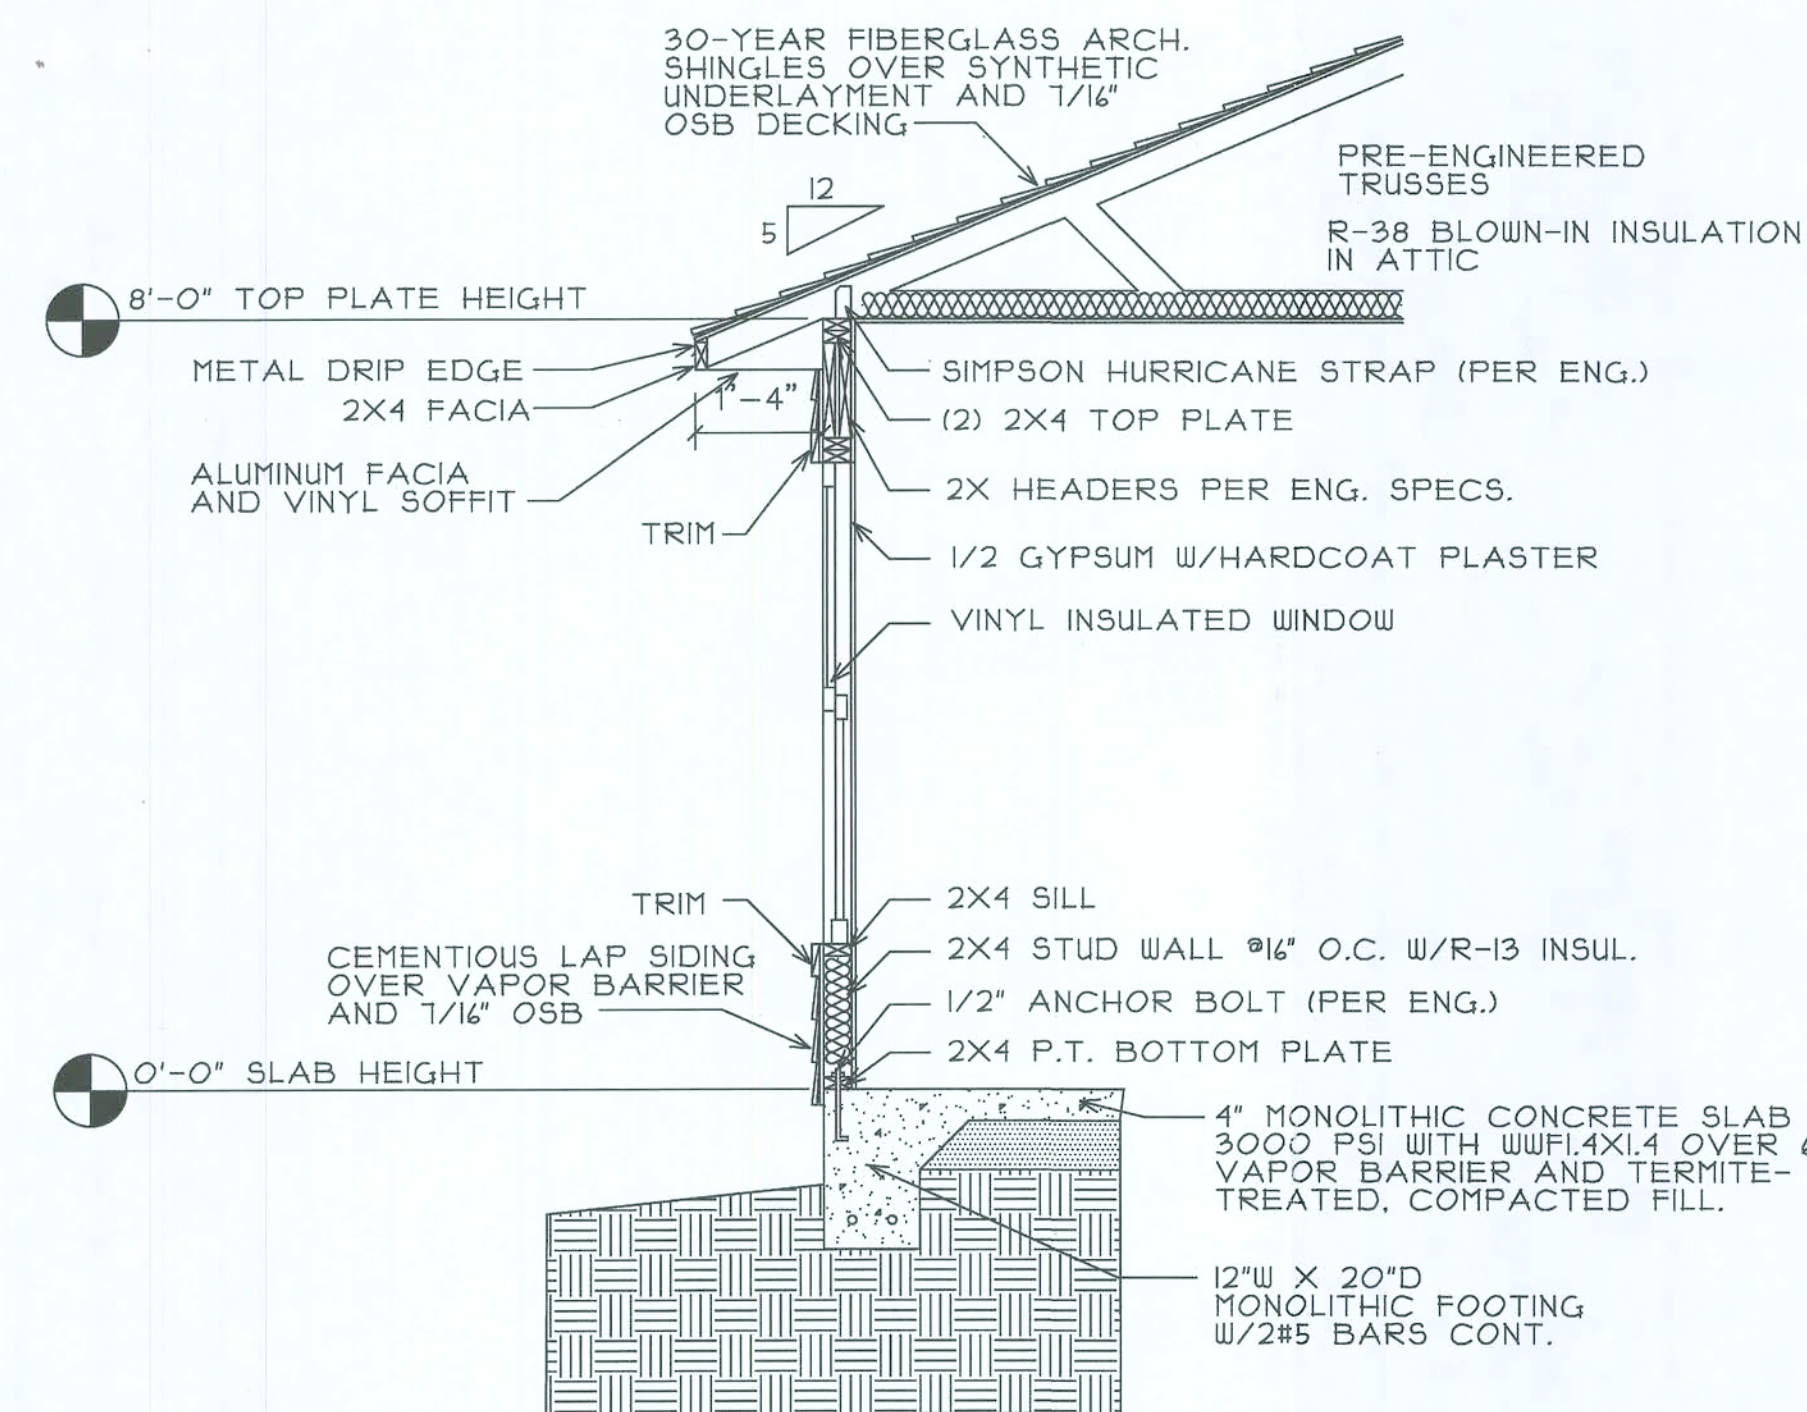
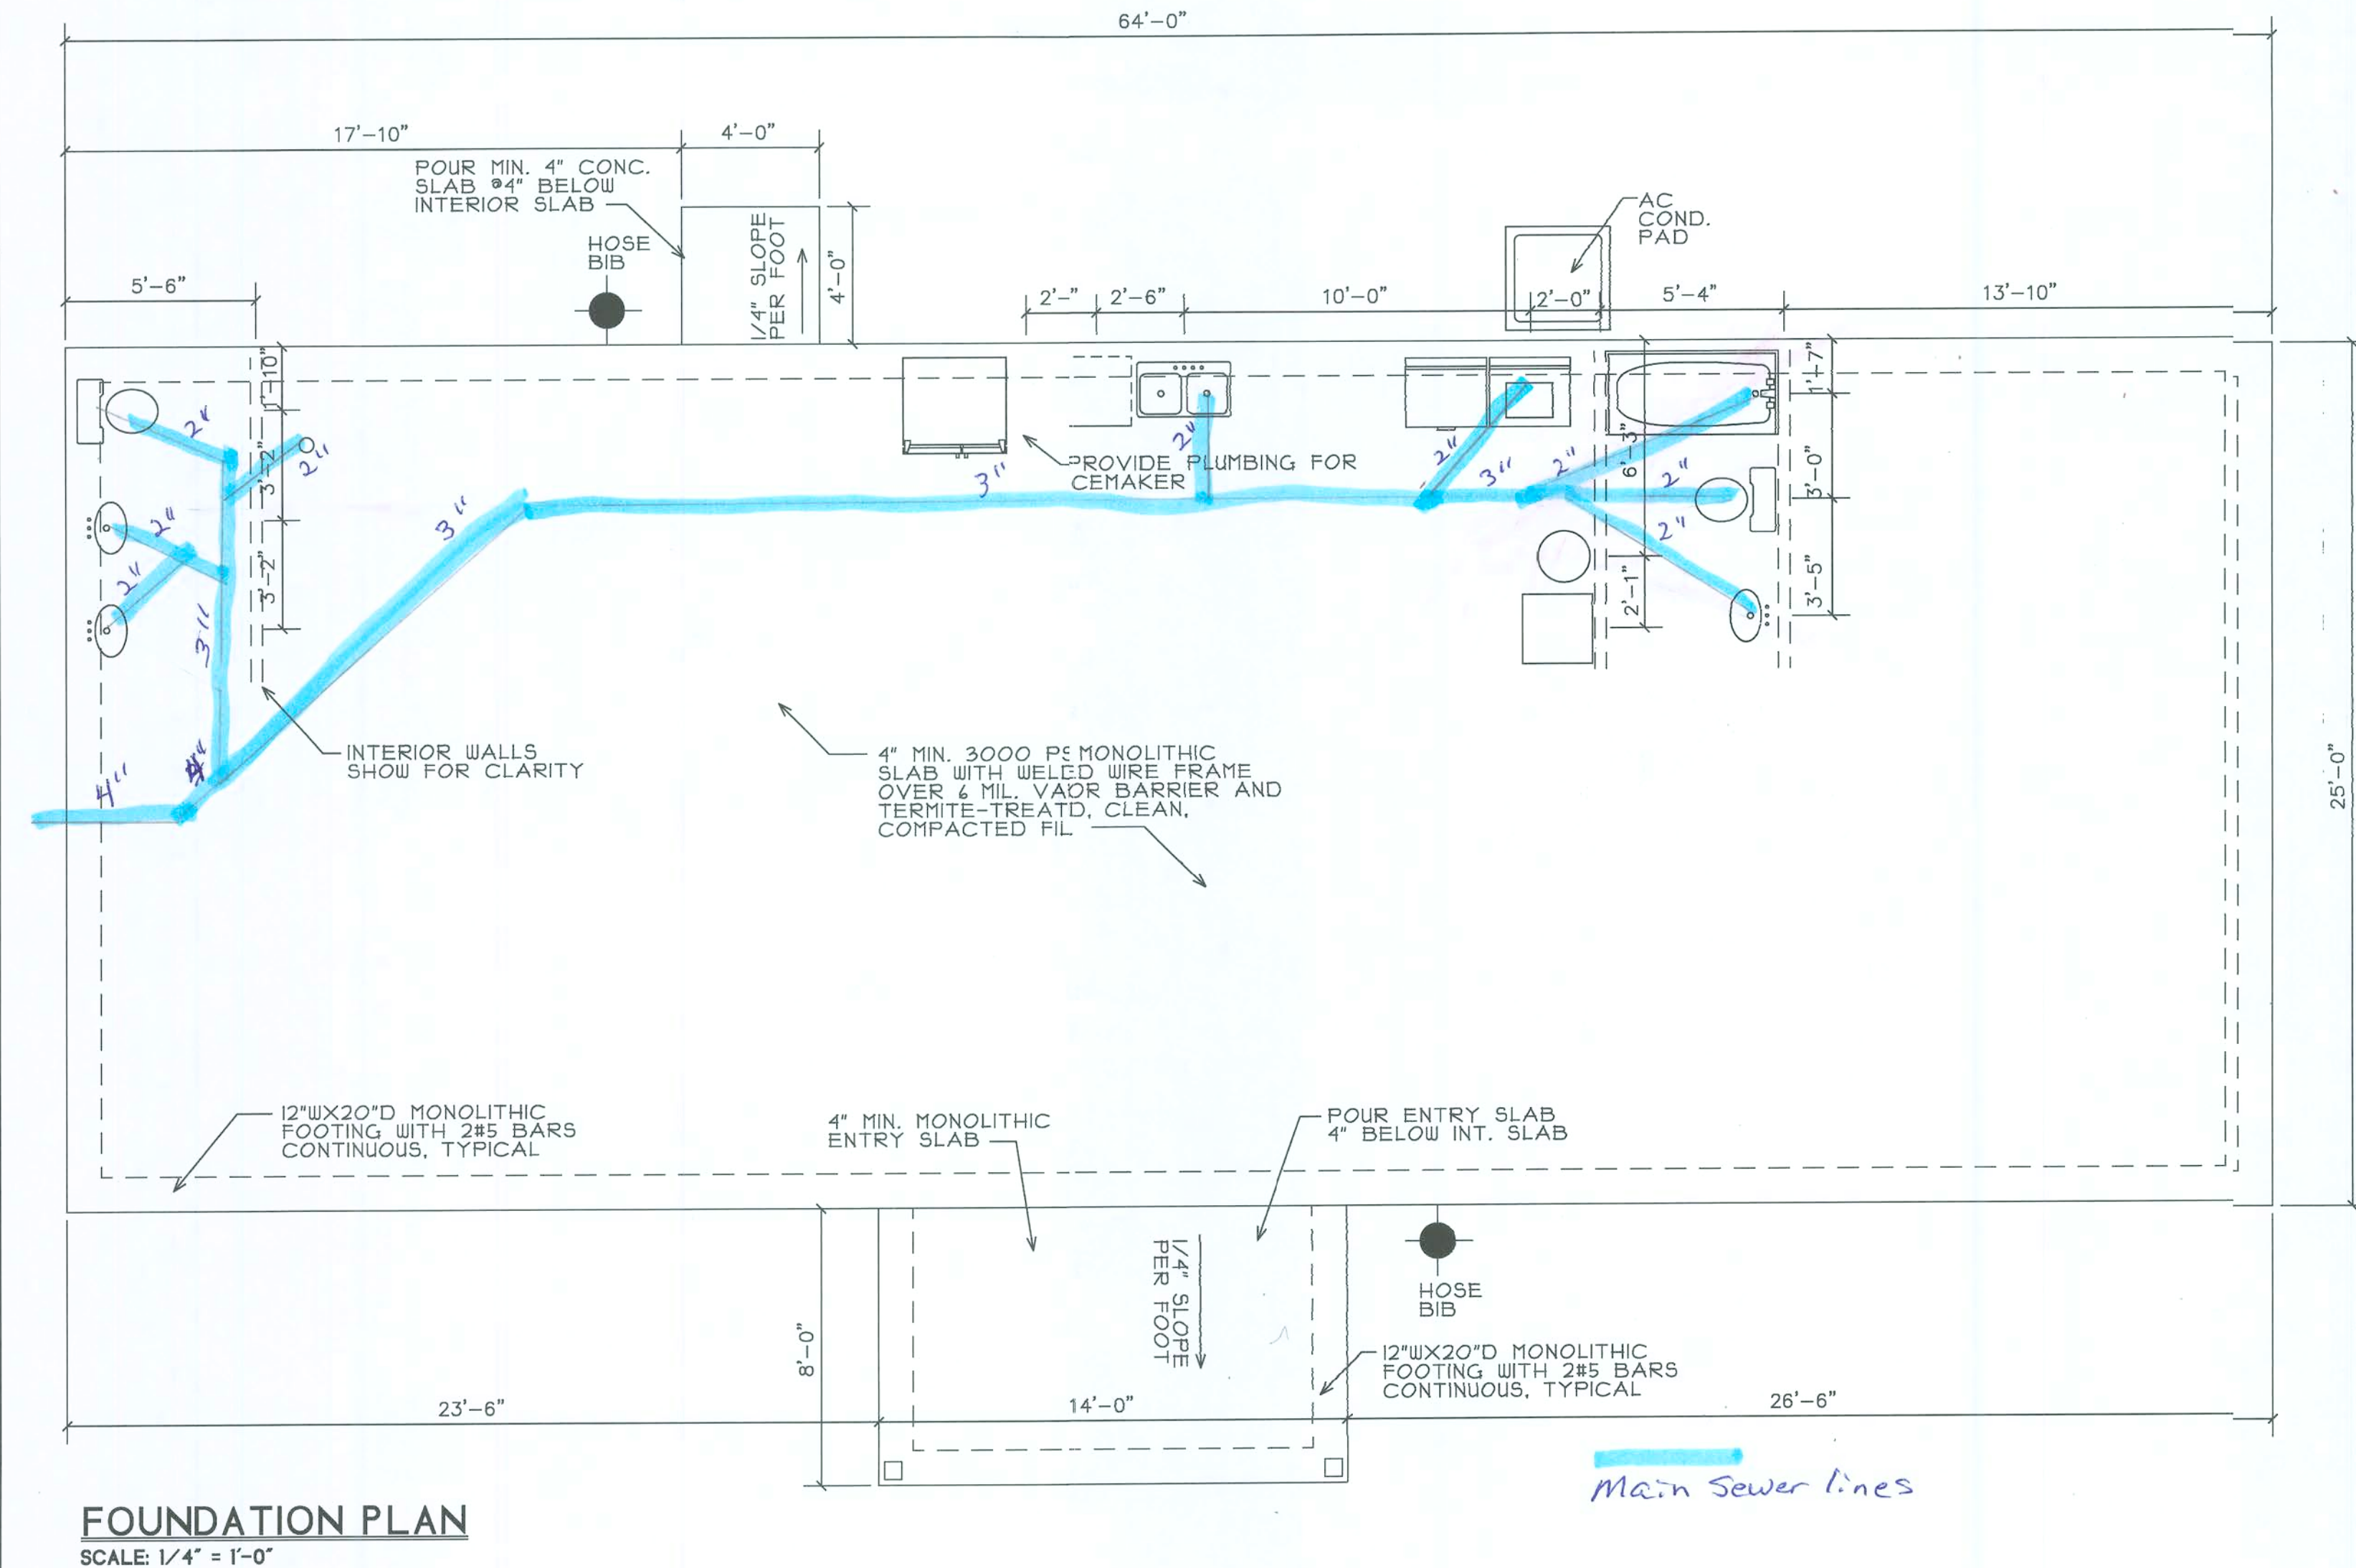


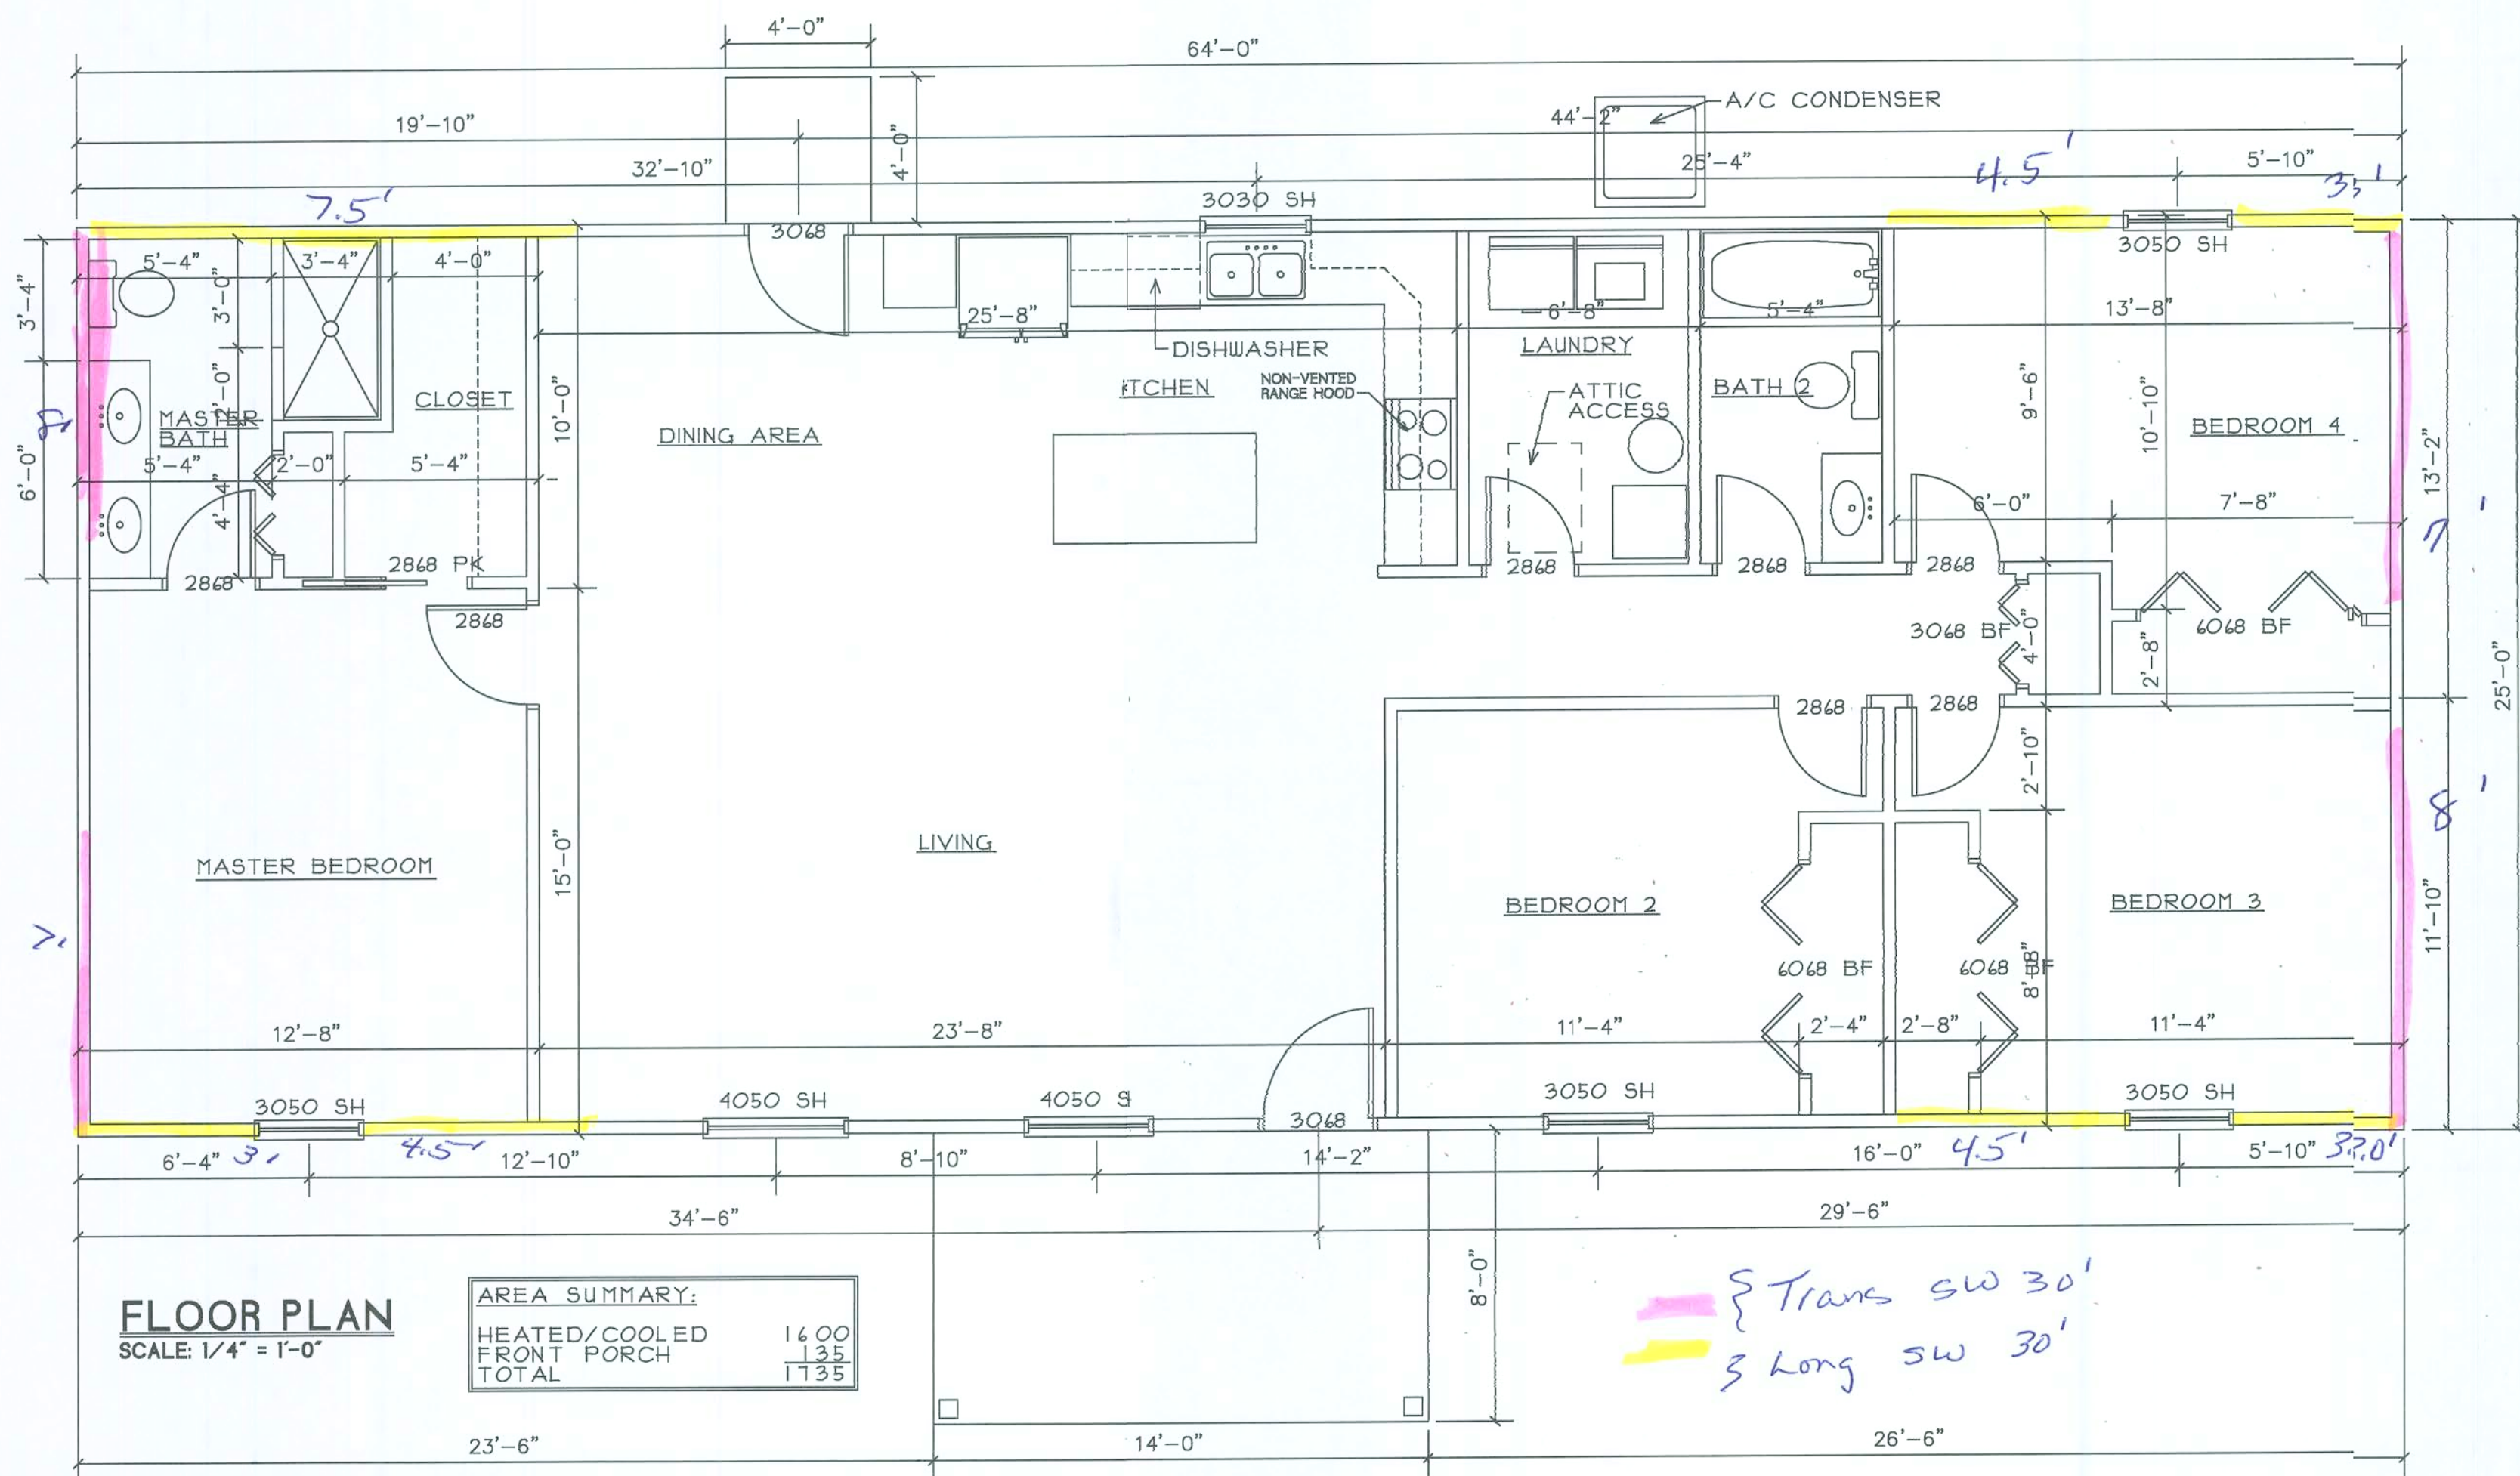

CUSTOMER NAME:

FLA HOMES, INC. R/C

13919 NW 145TH AVENUE, ALACHUA, FLORIDA 32615
(386) 418-4663 flahomes@windstream.net LICENSE # CGC 052062

AREA SUMMARY

H/C:	1600
OVERHANG:	
FRONT PORCH:	112
TOTAL:	1712

UNLESS OTHERWISE NOTED

PLAN NAME:
The Santa Fe Model

SHEET NUMBER
1 of 3


PAGE CONTENT:
**FLOOR PLAN
FOUNDATION PLAN
BASE CABINET LAYOUT
WALL SECTION**

REVISION DATE
OCTOBER 10, 2017


SUBDIVISION:
LOT #:

DRAWN BY:
Steve Ryan CAD Services
4855 Maguire Court Dr., Apt. 418
Jacksonville, FL 32217
850-971-9231
steve@ryan-cad.com




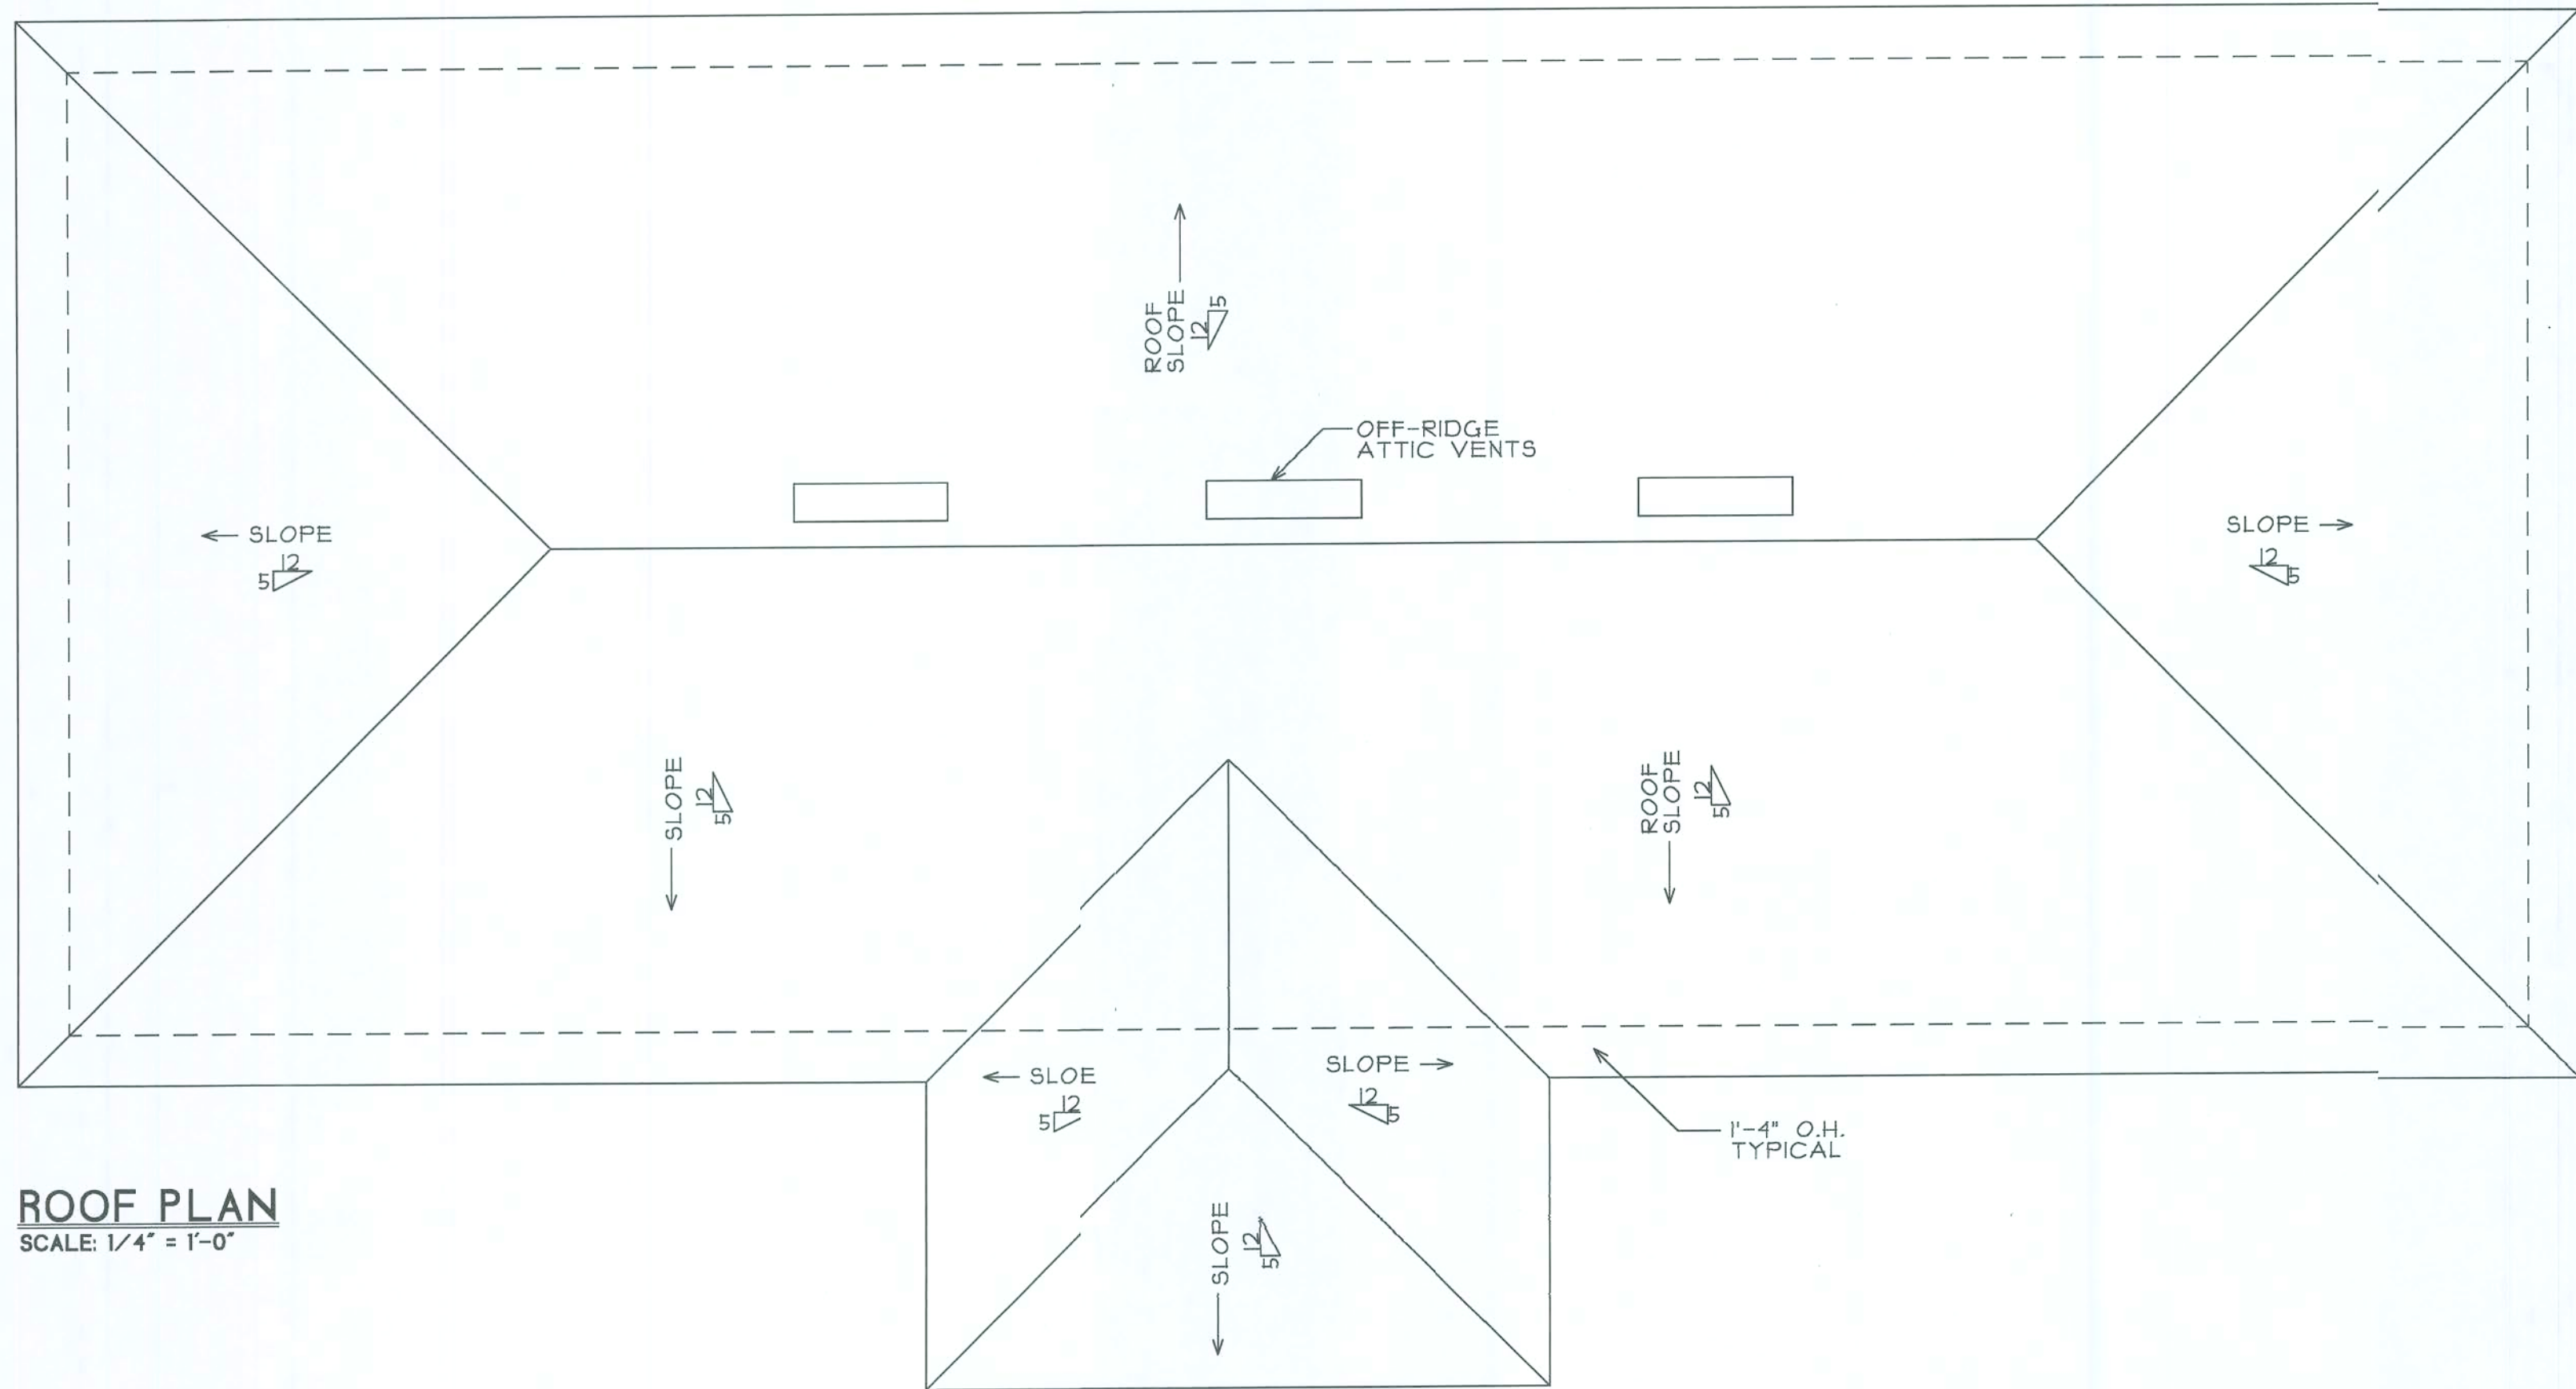


ROOF PLAN
SCALE: 1/4" = 1'-0"

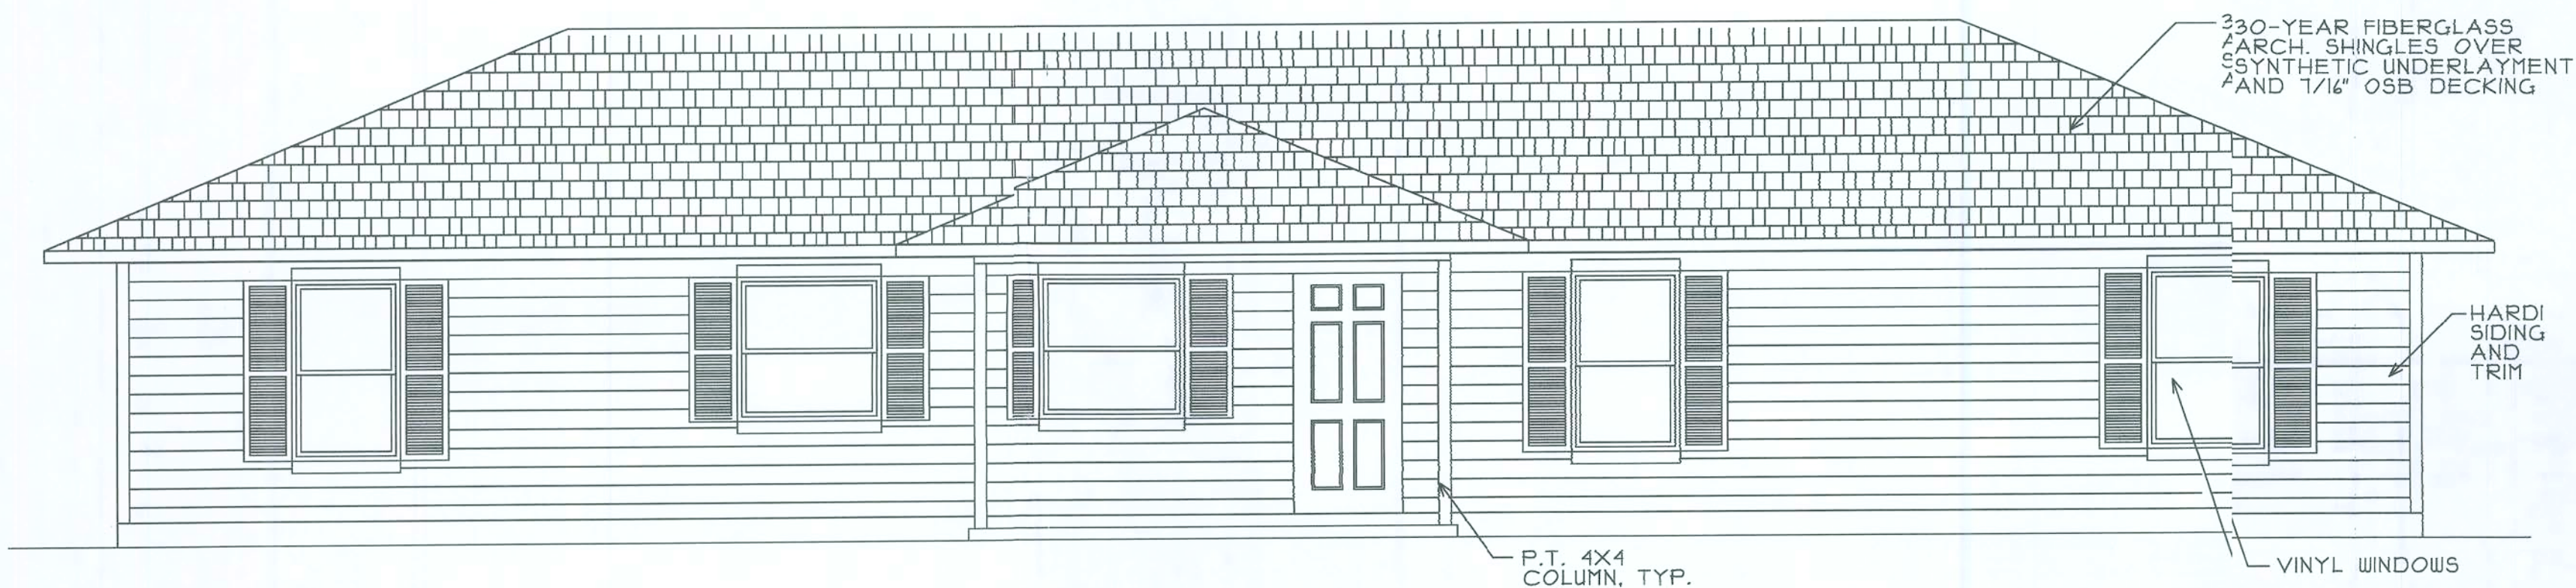


FRONT ELEVATION
SCALE: 1/4" = 1'-0"

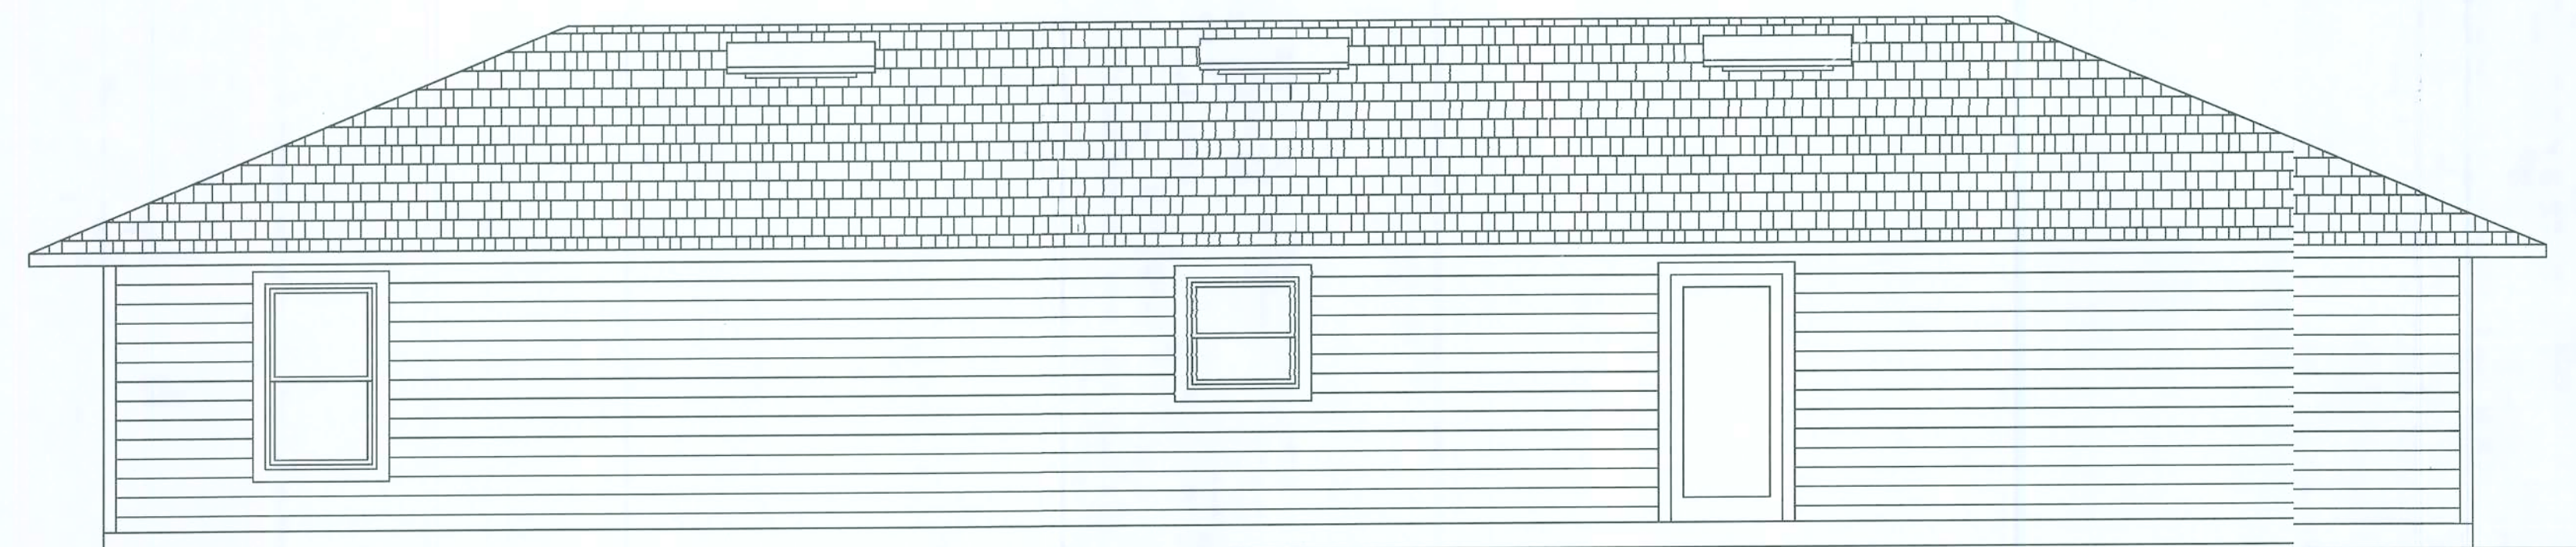

REAR ELEVATION
SCALE: 1/4" = 1'-0"

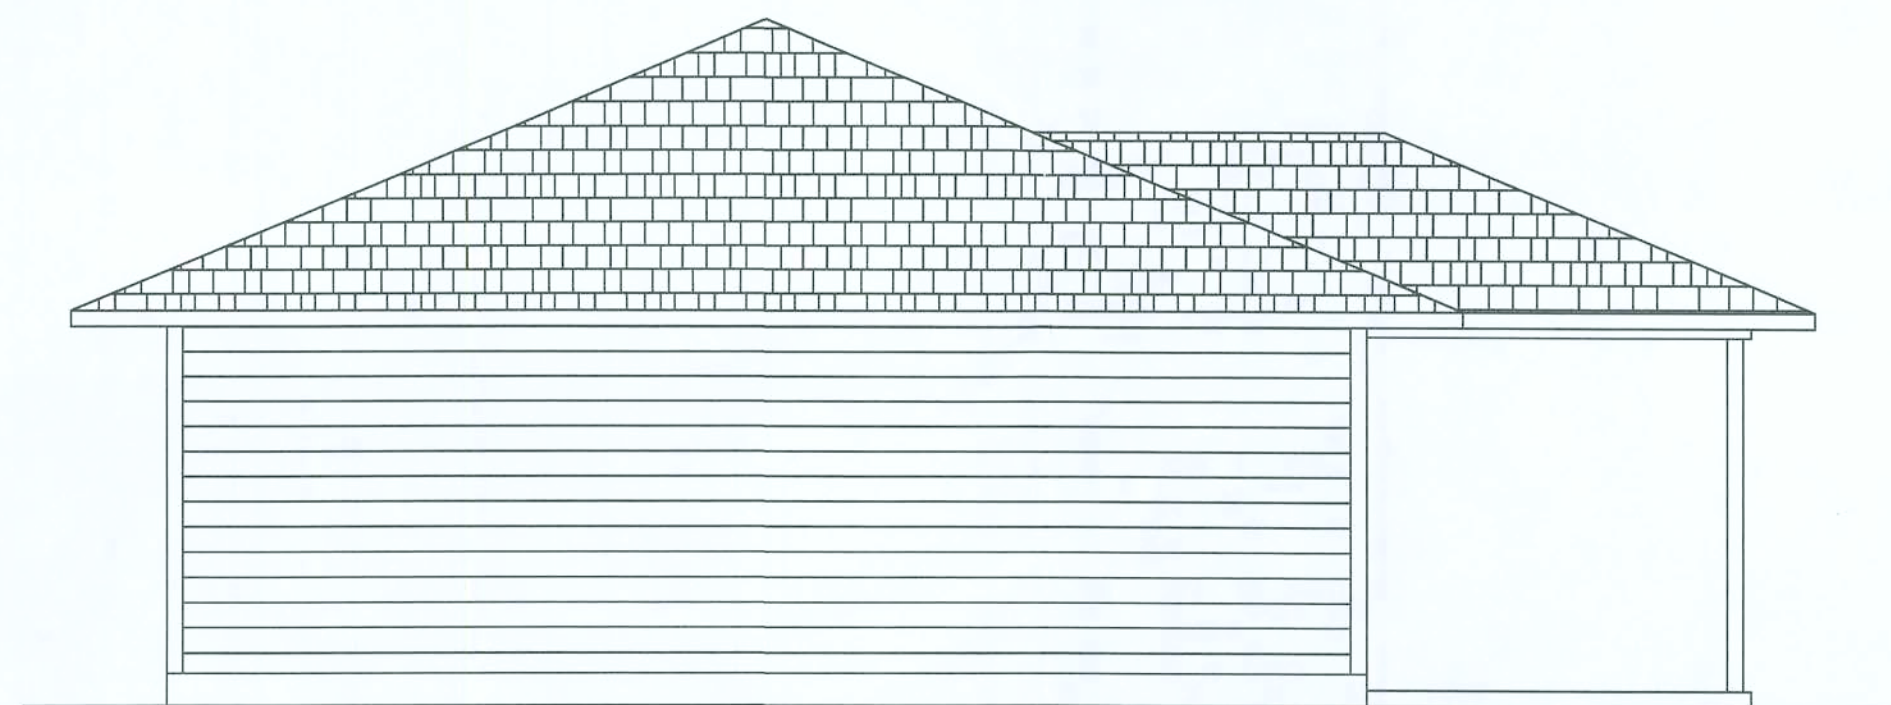

LEFT ELEVATION
SCALE: 1/4" = 1'-0"

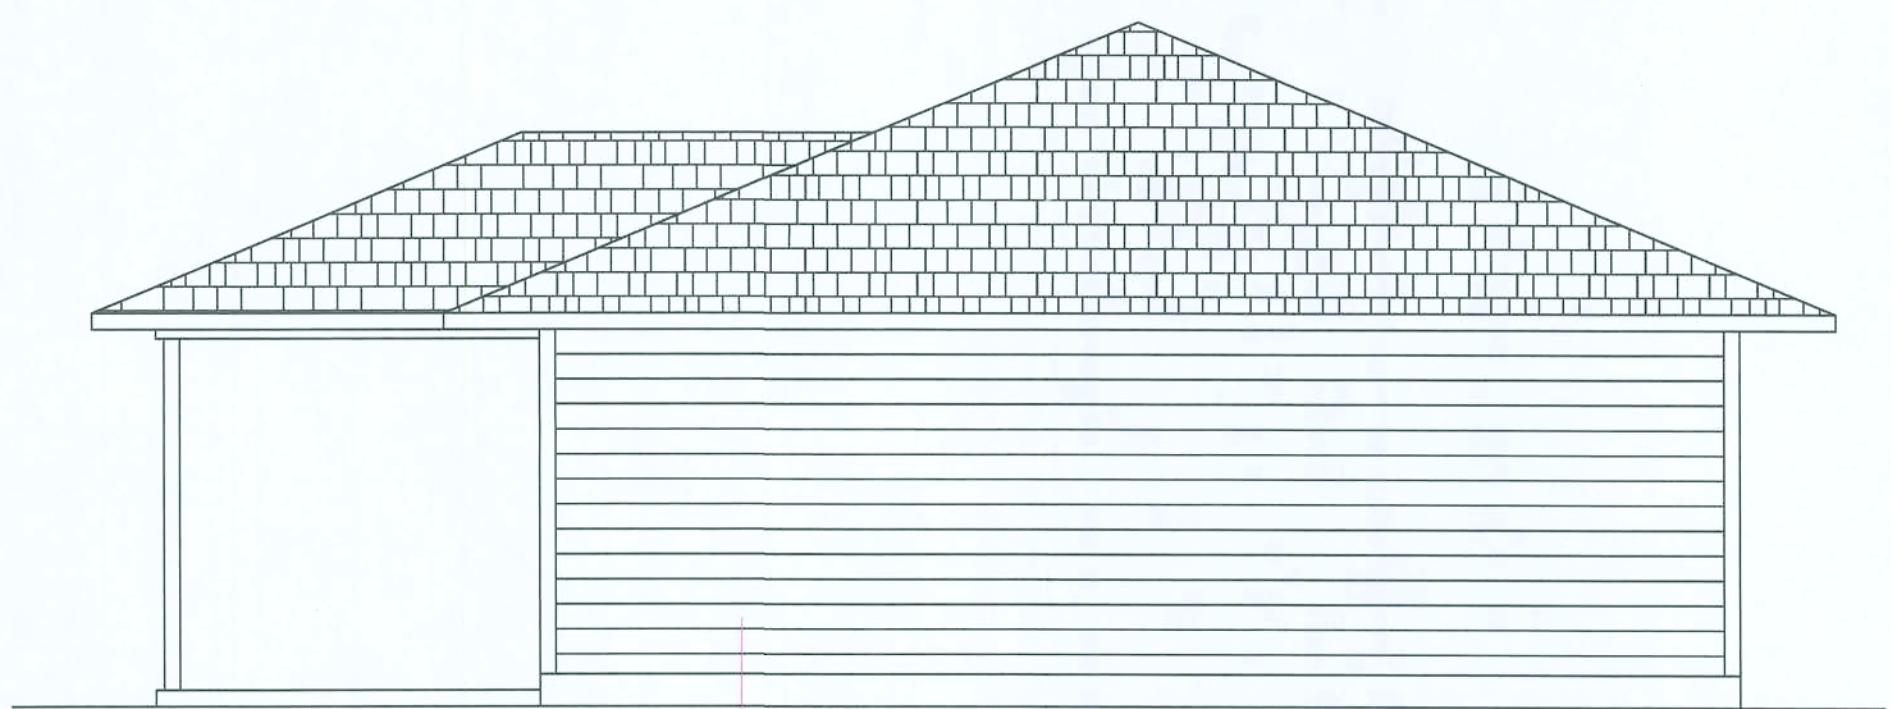

RIGHT ELEVATION
SCALE: 1/4" = 1'-0"

CUSTOMER NAME:

FLA HOMES, INC. R/C

13919 NW 145TH AVENUE, ALACHUA, FLORIDA 32815
(386)418-4883 flahomes@windstream.net LICENSE # CGC 052062

PLAN NAME:
The Santa Fe Model

SHEET NUMBER

2 of 3

SCALE: 1/4" = 1'-0"
UNLESS OTHERWISE NOTED


*ALL WORK SHALL COMPLY WITH APPLICABLE LOCAL CODES
*THESE PLANS AND NOTES ARE THE PROPERTY AND SOLE RESPONSIBILITY OF FLA HOMES, INC. IS PROHIBITED
*THESE PLANS ARE SUBJECT TO MODIFICATION AS NECESSARY TO MEET ANY APPLICABLE LOCAL CODES
*THESE PLANS ARE NOT TO BE USED FOR ANY OTHER PROJECT WITHOUT THE WRITTEN CONSENT OF FLA HOMES, INC.
*WHEN A DISCREPANCY, ERROR, OR OMISSION EXISTS, THE SUBCONTRACTOR SHALL COMPLY WITH APPLICABLE LOCAL CODES AND CONTACT THE BUILDER IN WRITING FOR PROPER ADJUSTMENT.

AREA SUMMARY
H/C: 1600
OVERHANG: 112
FRONT PORCH: 112
TOTAL: 1712

PAGE CONTENT:
**ROOF PLAN
ELEVATIONS**

SUBDIVISION:
LOT #:
REVISION DATE
OCTOBER 10, 2017

DRAWN BY:
Steve Ryall CAD Services
4885 Maguire Court Dr. Apt. 418
(386)797-8251
steve@genlions.com

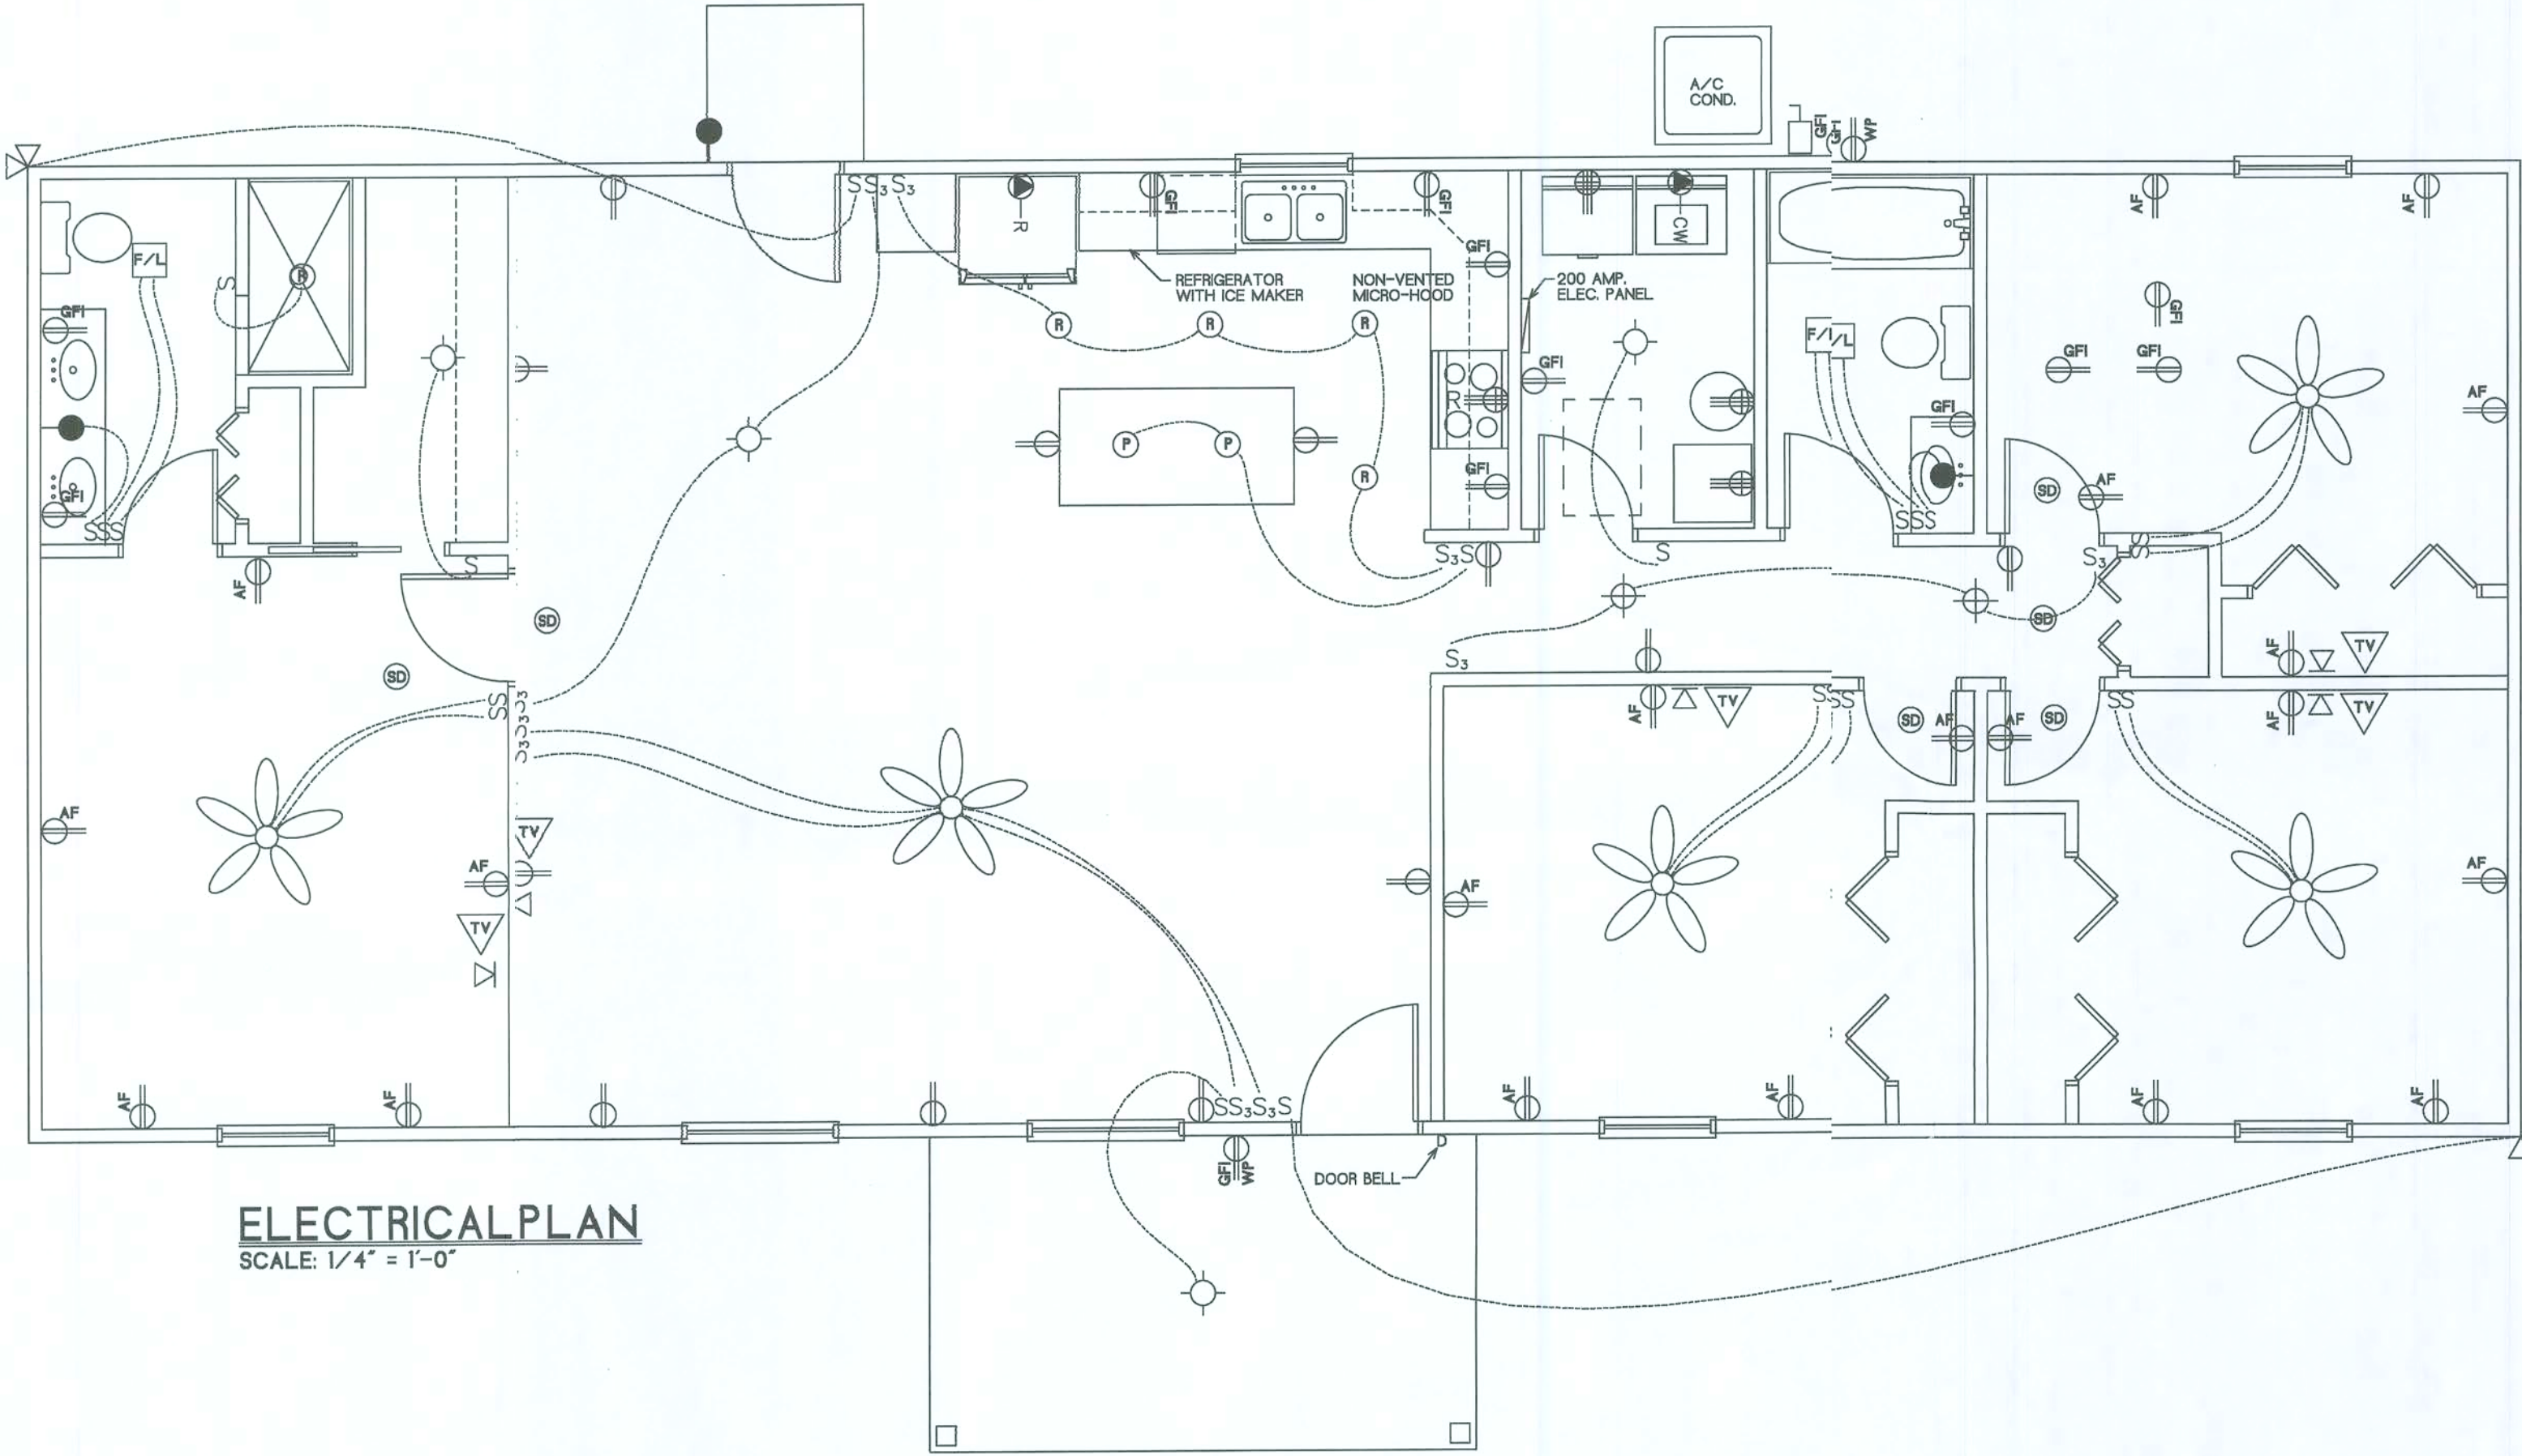

ELECTRICAL PLAN
SCALE: 1/4" = 1'-0"

LIGHTING & ELECTRICAL LEGEND	
	CEILING FAN WITH INCANDESCENT LIGHT FIXTURE
	COMB. CO/SMOKE DETECTOR COMBINATION SMOKE DETECTOR AND CO DETECTOR LINKED PER CODE
	PENDANT LIGHT
	RECESSED INCANDESCENT
	SINGLE SWITCH
	3-WAY SWITCH
	ELECTRICAL DISCONNECT
	DUPLEX RECEPTACLE
	DUPLEX GFI RECEPTACLE
	ARC-FAULT RECEPTACLE
	220 OUTLET
	RANGE RECEPTACLE
	WEATHER-PROTECTED DUPLEX
	REFRIGERATOR
	FREEZER
	CLOTHES WASHER
	TV/CABLE OUTLET
	PHONE/ETHERNET
	EXHAUST FAN
	EXHAUST FAN WITH LIGHT
	EXTERIOR FLOOD LIGHT WITH MOTION DETECTOR
	2X4 SURFACE FLOURESCENT
	WALL-MOUNTED INCANDESCENT
	SURFACE-MOUNTED LIGHT FIXTURE
	SURFACE-MOUNTED HANGING FIXT.

CUSTOMER NAME:

FLA HOMES, INC. R/C

13919 NW 145TH AVENUE, ALACHUA, FLORIDA 32815
(386)419-4663 flatohomes@windstream.net LICENSE #: CGC 052062

SHEET NUMBER
3 of 3

PLAN NAME:
The Santa Fe Model

SCALE: 1/4" = 1'-0"
UNLESS OTHERWISE NOTED

AREA SUMMARY	
H/C:	1600
OVERHANG:	
FRONT PORCH:	1412
TOTAL:	1712

*ALL WORK SHALL COMPLY WITH APPLICABLE LOCAL CODES
*THESE PLANS AND NOTES ARE THE PROPERTY AND SOLE RESPONSIBILITY OF
FLA HOMES, INC. NO PART OF THESE PLANS OR NOTES SHALL BE REPRODUCED
OR TRANSMITTED IN ANY FORM OR BY ANY MEANS, ELECTRONIC OR MECHANICAL,
INCLUDING PHOTOCOPYING, RECORDING, OR BY ANY INFORMATION STORAGE
RETRIEVAL SYSTEM, WITHOUT THE WRITTEN PERMISSION OF FLA HOMES, INC.
*INCORPORATE DESIGN IMPROVEMENTS. THE BUILDER RESERVES THE RIGHT TO
MAKE SUCH IMPROVEMENTS AS MAY BE NECESSARY TO COMPLY WITH ALL
APPLICABLE LOCAL, STATE AND FEDERAL CODES AND ORDINANCES.
*WHEN A DISCREPANCY, ERROR, OR OMISSION EXISTS, THE SUBCONTRACTOR SHALL
CONTACT THE BUILDER IMMEDIATELY TO CORRECT THE ERROR OR OMISSION.
*FOR NOTES, SEE DRAWING NOTES.

REVISION DATE
OCTOBER 10, 2017

SUBDIVISION:
LOT #:
SUBDIVISION:
LOT #:
SUBDIVISION:
LOT #:
SUBDIVISION:
LOT #:

PAGE CONTENT:
ELECTRICAL PLAN

FLA HOMES, INC.
Steve Ryall CAD Services
13919 NW 145th Ave., Apt. 418
Alachua, FL 32815
(386) 971-4261
steve@flahomes.com