

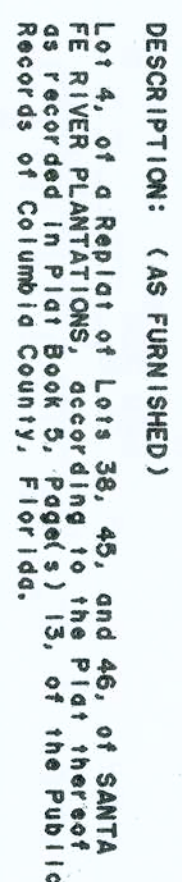


Ray Davis

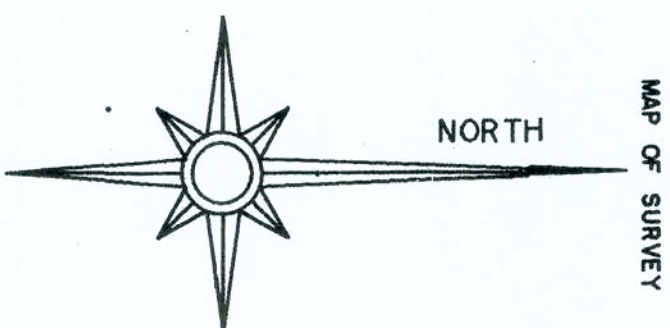

Note: This survey was performed without the benefit of a "TITLE ABSTRACT."

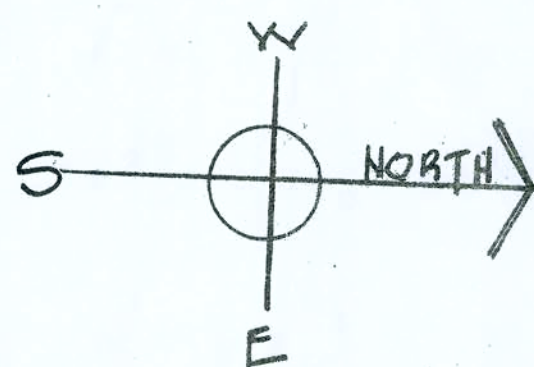

ITEM NO.	DESCRIPTION	UNIT	QTY	PRICE	TOTAL
1.	CONCRETE	CU YD	1.00	1.00	1.00
2.	IRON PIPE	LB	1.00	1.00	1.00
3.	CONCRETE	CU YD	1.00	1.00	1.00
4.	IRON PIPE	LB	1.00	1.00	1.00
5.	CONCRETE	CU YD	1.00	1.00	1.00
6.	IRON PIPE	LB	1.00	1.00	1.00
7.	CONCRETE	CU YD	1.00	1.00	1.00
8.	IRON PIPE	LB	1.00	1.00	1.00
9.	CONCRETE	CU YD	1.00	1.00	1.00
10.	IRON PIPE	LB	1.00	1.00	1.00
11.	CONCRETE	CU YD	1.00	1.00	1.00
12.	IRON PIPE	LB	1.00	1.00	1.00
13.	CONCRETE	CU YD	1.00	1.00	1.00
14.	IRON PIPE	LB	1.00	1.00	1.00
15.	CONCRETE	CU YD	1.00	1.00	1.00
16.	IRON PIPE	LB	1.00	1.00	1.00
17.	CONCRETE	CU YD	1.00	1.00	1.00
18.	IRON PIPE	LB	1.00	1.00	1.00
19.	CONCRETE	CU YD	1.00	1.00	1.00
20.	IRON PIPE	LB	1.00	1.00	1.00
21.	CONCRETE	CU YD	1.00	1.00	1.00
22.	IRON PIPE	LB	1.00	1.00	1.00
23.	CONCRETE	CU YD	1.00	1.00	1.00
24.	IRON PIPE	LB	1.00	1.00	1.00
25.	CONCRETE	CU YD	1.00	1.00	1.00
26.	IRON PIPE	LB	1.00	1.00	1.00
27.	CONCRETE	CU YD	1.00	1.00	1.00
28.	IRON PIPE	LB	1.00	1.00	1.00
29.	CONCRETE	CU YD	1.00	1.00	1.00
30.	IRON PIPE	LB	1.00	1.00	1.00
31.	CONCRETE	CU YD	1.00	1.00	1.00
32.	IRON PIPE	LB	1.00	1.00	1.00
33.	CONCRETE	CU YD	1.00	1.00	1.00
34.	IRON PIPE	LB	1.00	1.00	1.00
35.	CONCRETE	CU YD	1.00	1.00	1.00
36.	IRON PIPE	LB	1.00	1.00	1.00
37.	CONCRETE	CU YD	1.00	1.00	1.00
38.	IRON PIPE	LB	1.00	1.00	1.00
39.	CONCRETE	CU YD	1.00	1.00	1.00
40.	IRON PIPE	LB	1.00	1.00	1.00
41.	CONCRETE	CU YD	1.00	1.00	1.00
42.	IRON PIPE	LB	1.00	1.00	1.00
43.	CONCRETE	CU YD	1.00	1.00	1.00
44.	IRON PIPE	LB	1.00	1.00	1.00
45.	CONCRETE	CU YD	1.00	1.00	1.00
46.	IRON PIPE	LB	1.00	1.00	1.00
47.	CONCRETE	CU YD	1.00	1.00	1.00
48.	IRON PIPE	LB	1.00	1.00	1.00
49.	CONCRETE	CU YD	1.00	1.00	1.00
50.	IRON PIPE	LB	1.00	1.00	1.00
51.	CONCRETE	CU YD	1.00	1.00	1.00
52.	IRON PIPE	LB	1.00	1.00	1.00
53.	CONCRETE	CU YD	1.00	1.00	1.00
54.	IRON PIPE	LB	1.00	1.00	1.00
55.	CONCRETE	CU YD	1.00	1.00	1.00
56.	IRON PIPE	LB	1.00	1.00	1.00
57.	CONCRETE	CU YD	1.00	1.00	1.00
58.	IRON PIPE	LB	1.00	1.00	1.00
59.	CONCRETE	CU YD	1.00	1.00	1.00
60.	IRON PIPE	LB	1.00	1.00	1.00
61.	CONCRETE	CU YD	1.00	1.00	1.00
62.	IRON PIPE	LB	1.00	1.00	1.00
63.	CONCRETE	CU YD	1.00	1.00	1.00
64.	IRON PIPE	LB	1.00	1.00	1.00
65.	CONCRETE	CU YD	1.00	1.00	1.00
66.	IRON PIPE	LB	1.00	1	

FHA (Flood Hazard Area)

* This is to certify that I have consulted the Federal Insurance Administration Flood Hazard boundary map, Community No. 120070, Panel 001A, effective date 01-20-78, and estimate that the above described property is in Zone X. This Zone is not located in a special flood hazard area to the best of my knowledge and belief*.


BOUNDARY SURVEY 11-14-05

SCALE: 1" = .20"

CHECKED BY: KAG

KRIS ANN GATH
LAND SURVEYING AND MAPPING, INC.
Professional Land Surveying and Mapping Services
2341 N.W. 41st STREET, SUITE C
GAINESVILLE, FLORIDA 32608
Fid. Certification No. LB 6578
(352) 336-3363

**Kris Ann Gath, President
Professional Surveyor and Mapper**

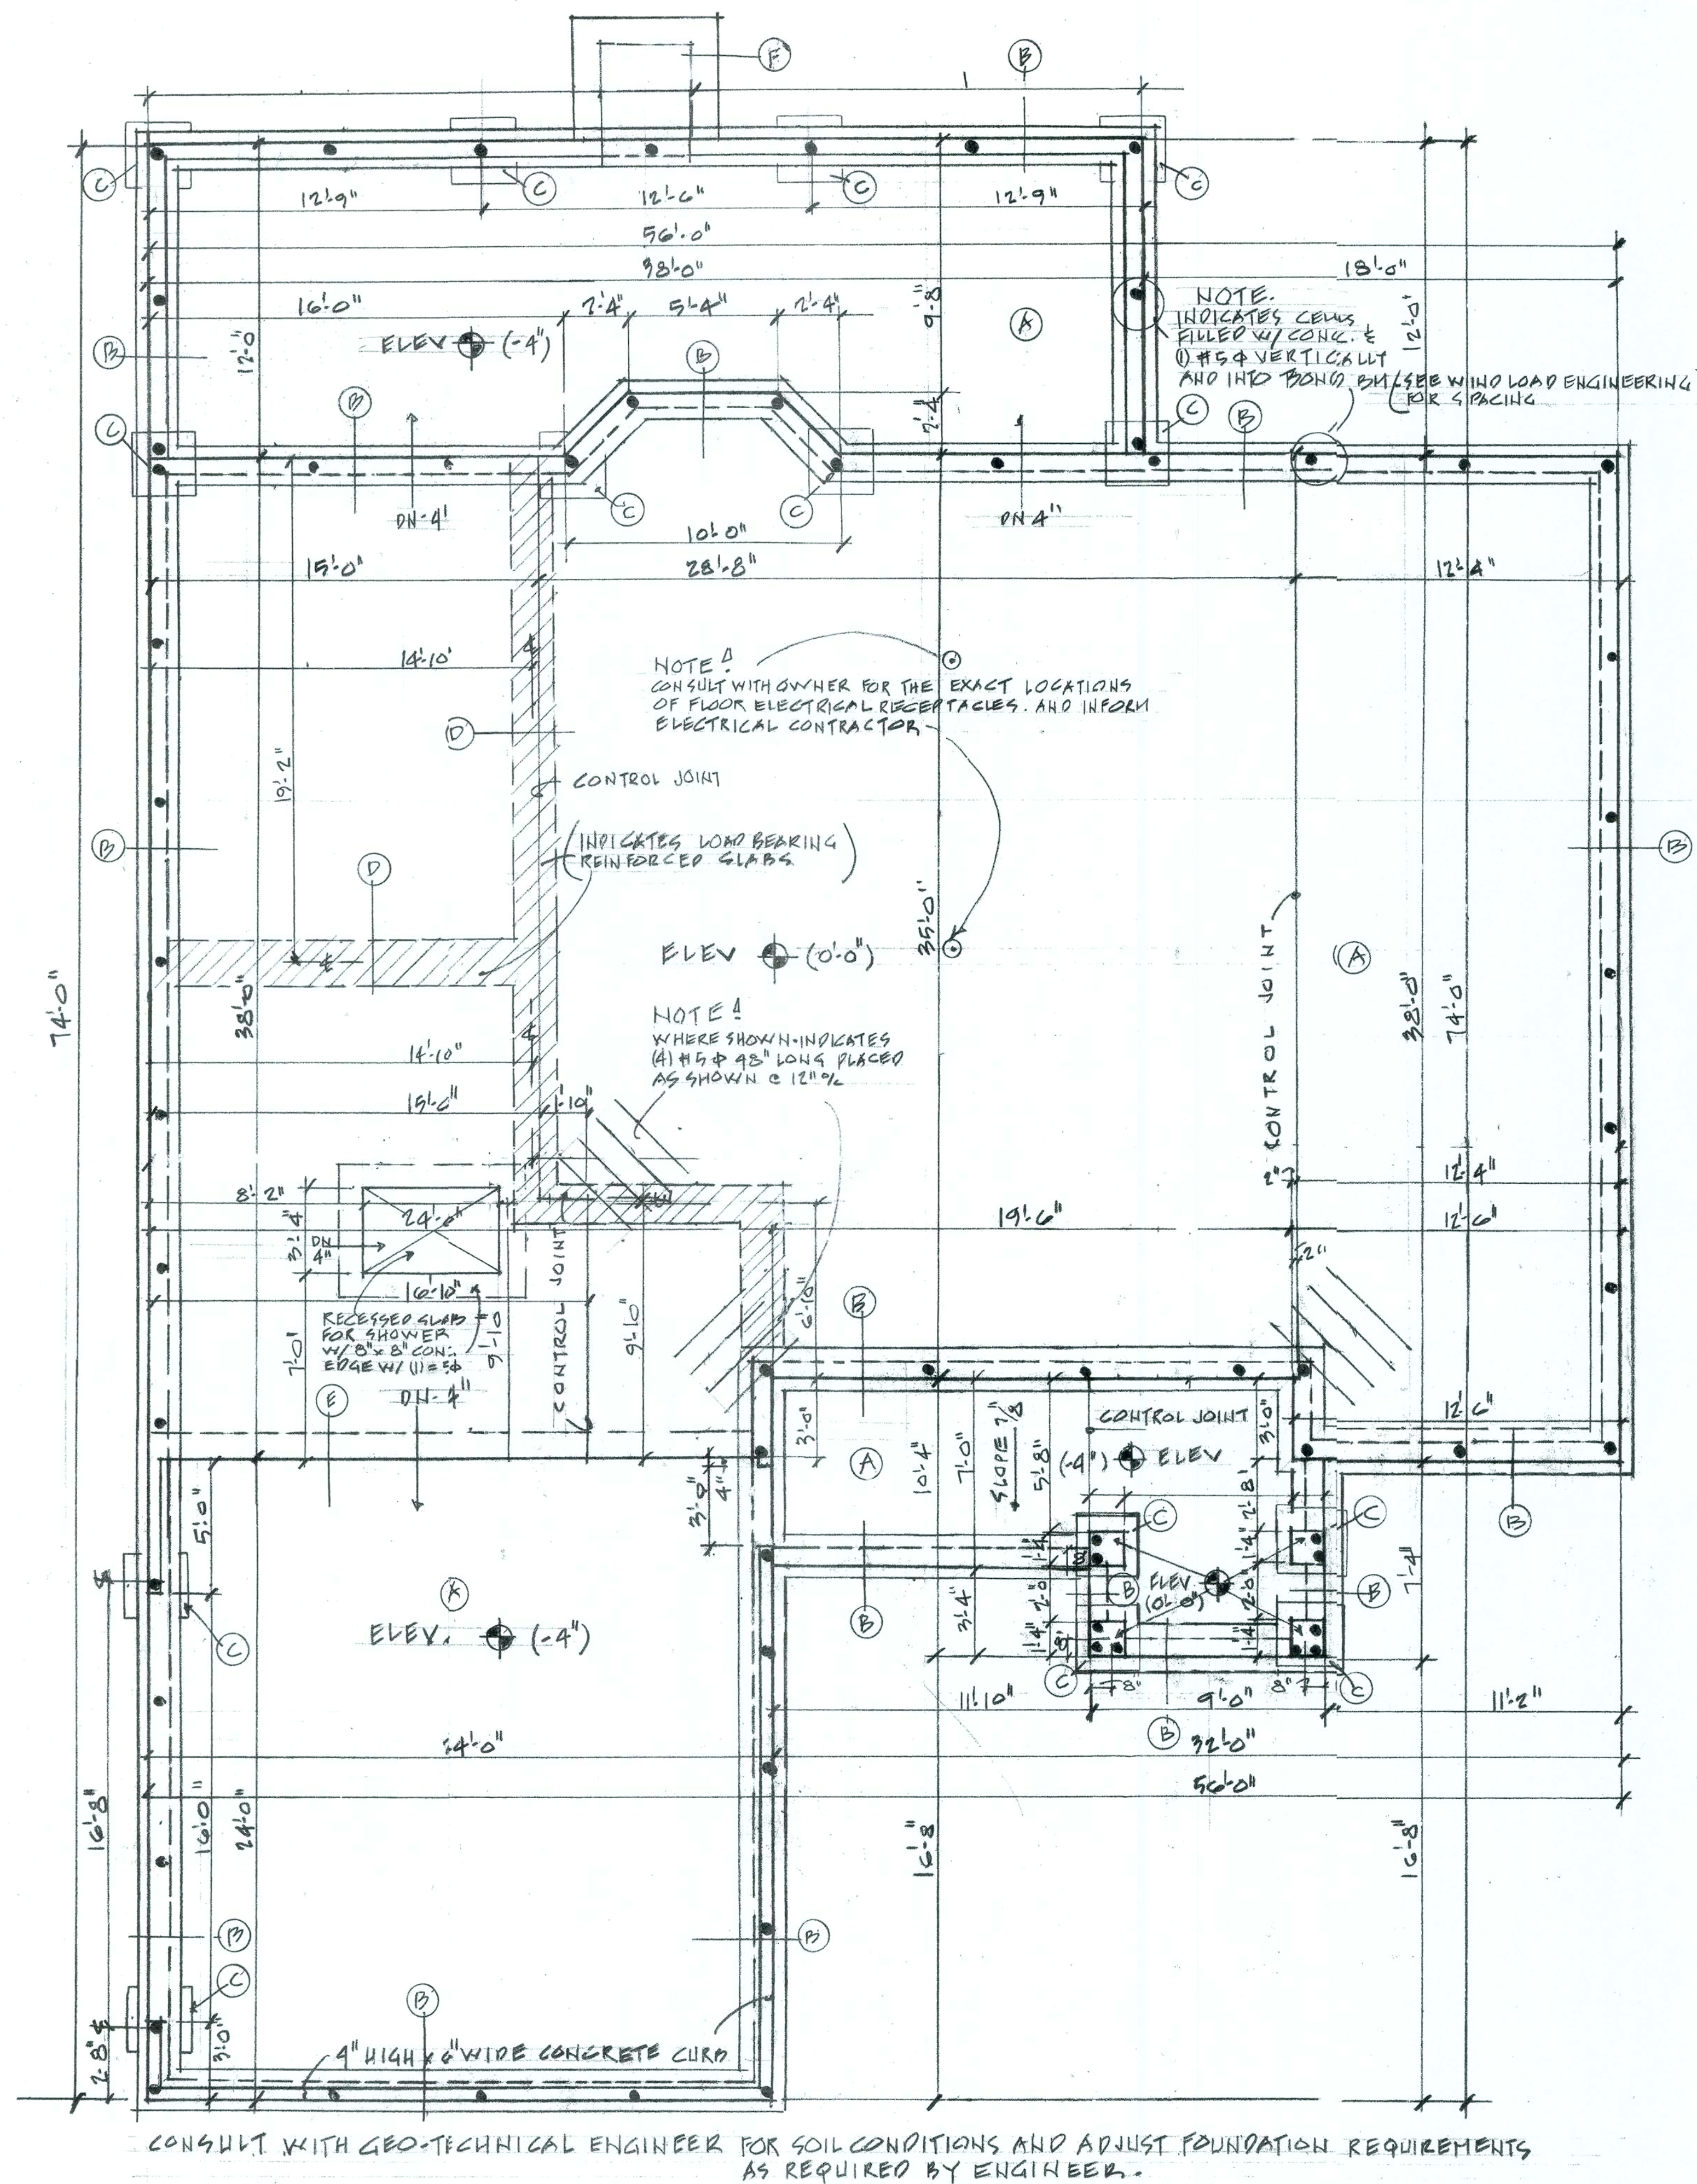

GENERAL NOTES.

All footings shall be excavated down to undisturbed soil.

Compaction of fill under floor slabs shall produce a density as shown by field density test, equal to 95% as obtained by tests of the modified AASHTO method. Compaction shall be by mechanical means.

SOIL TREATMENT: HOUSE AND STORAGE SHED
PREVAIL - (PERMETRIN)

TERMIDOR (FIPRONIL)

BOTH PRODUCTS ARE EPA REGISTERED AND APPLIED PER LABEL RATE.
(ONE GALLON PER 10 SQ. FT.)


All concrete work as pertains to, but not limited to, inspections, tests, quality of concrete materials, tests for concrete materials, proportions, reinforcement, mixing, placing, curing, formwork and details for reinforcing shall be in accord with the requirements of the latest edition for the A. C. I. Code requirements for reinforced concrete (ACI 318), parts 1, 2, 3. The American Concrete Institute Building Code (ACI 318) and the Manual of Standard Practice for Detailing Reinforced Concrete Structures (ACI 315) shall be applicable to this project. (Latest editions) The following minimum compressive strengths PSI at 28 days after placing are required: 3000 PSI concrete for use in all toppings, slabs, beams, precast concrete filled cells and/or self supporting structures. Concrete for filled cells shall have small aggregate. 3000 PSI concrete for use in all footings, floors on fill and other concrete work. Concrete for floors shall have aggregate of a size that will permit a smooth trowel finish.






All concrete block masonry shall meet all standards of the ASTM for Grade "A" Hollow Loadbearing Concrete Masonry Units. The moisture content at the time the units are delivered to the job site shall not exceed 30% of the weight of water contained in a completely saturated unit. Units to conform to ASTM C-90. Masonry wall reinforcement shall be galvanized steel especially fabricated for this purpose. The materials shall be in continuous strips, spaced as near to 16" vertically as mortar jointing will permit or according to notes on the Drawings, if indicated as otherwise.


Provide and install piping, wiring and controls at points required, and of construction necessary to conform to the requirements of the National Board of Fire Underwriters, municipal, State, and other authorities having jurisdiction.

All electrical work shall be in strict accordance with regulations of authorities in this locality, and shall conform to National Electric Code.


Wood trusses shall be placed at 2'-0" o. c.s. indicated on this Drawing. Engineering of all wood trusses shall be performed and certified by a structural engineer holding current license to practice engineering in the State of Florida. Wood trusses shall be designed to meet all of the dead, live, and wind load requirements as set forth in the (FLORIDA Building Code (latest edition)).

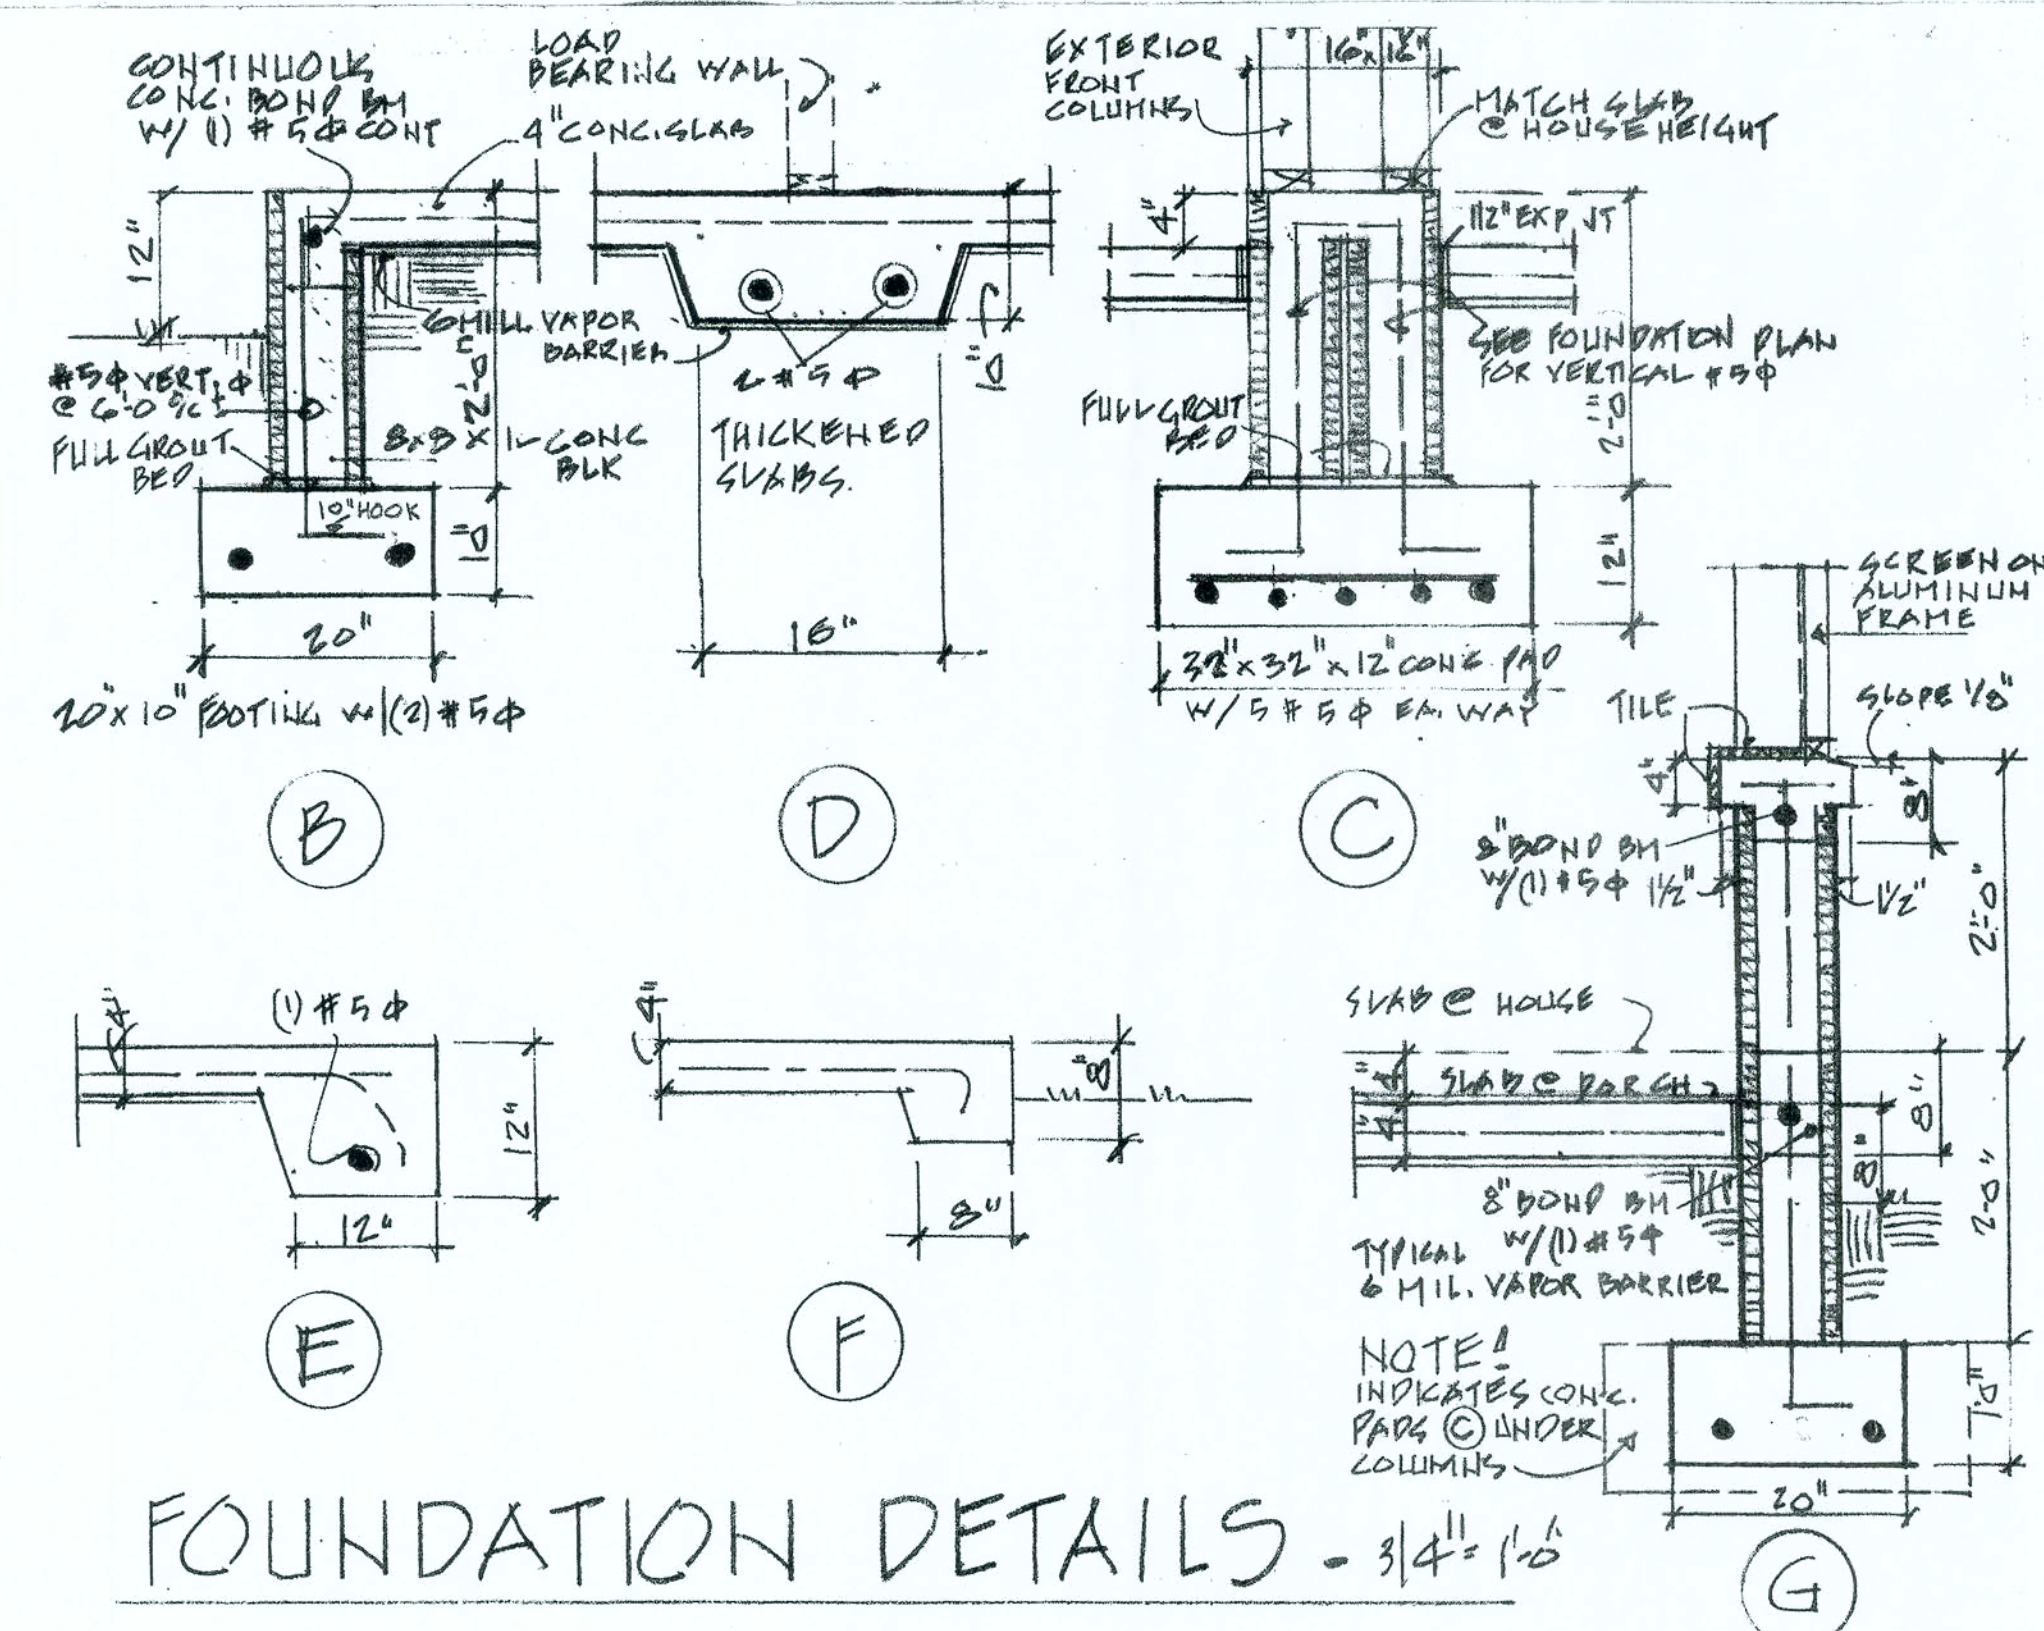

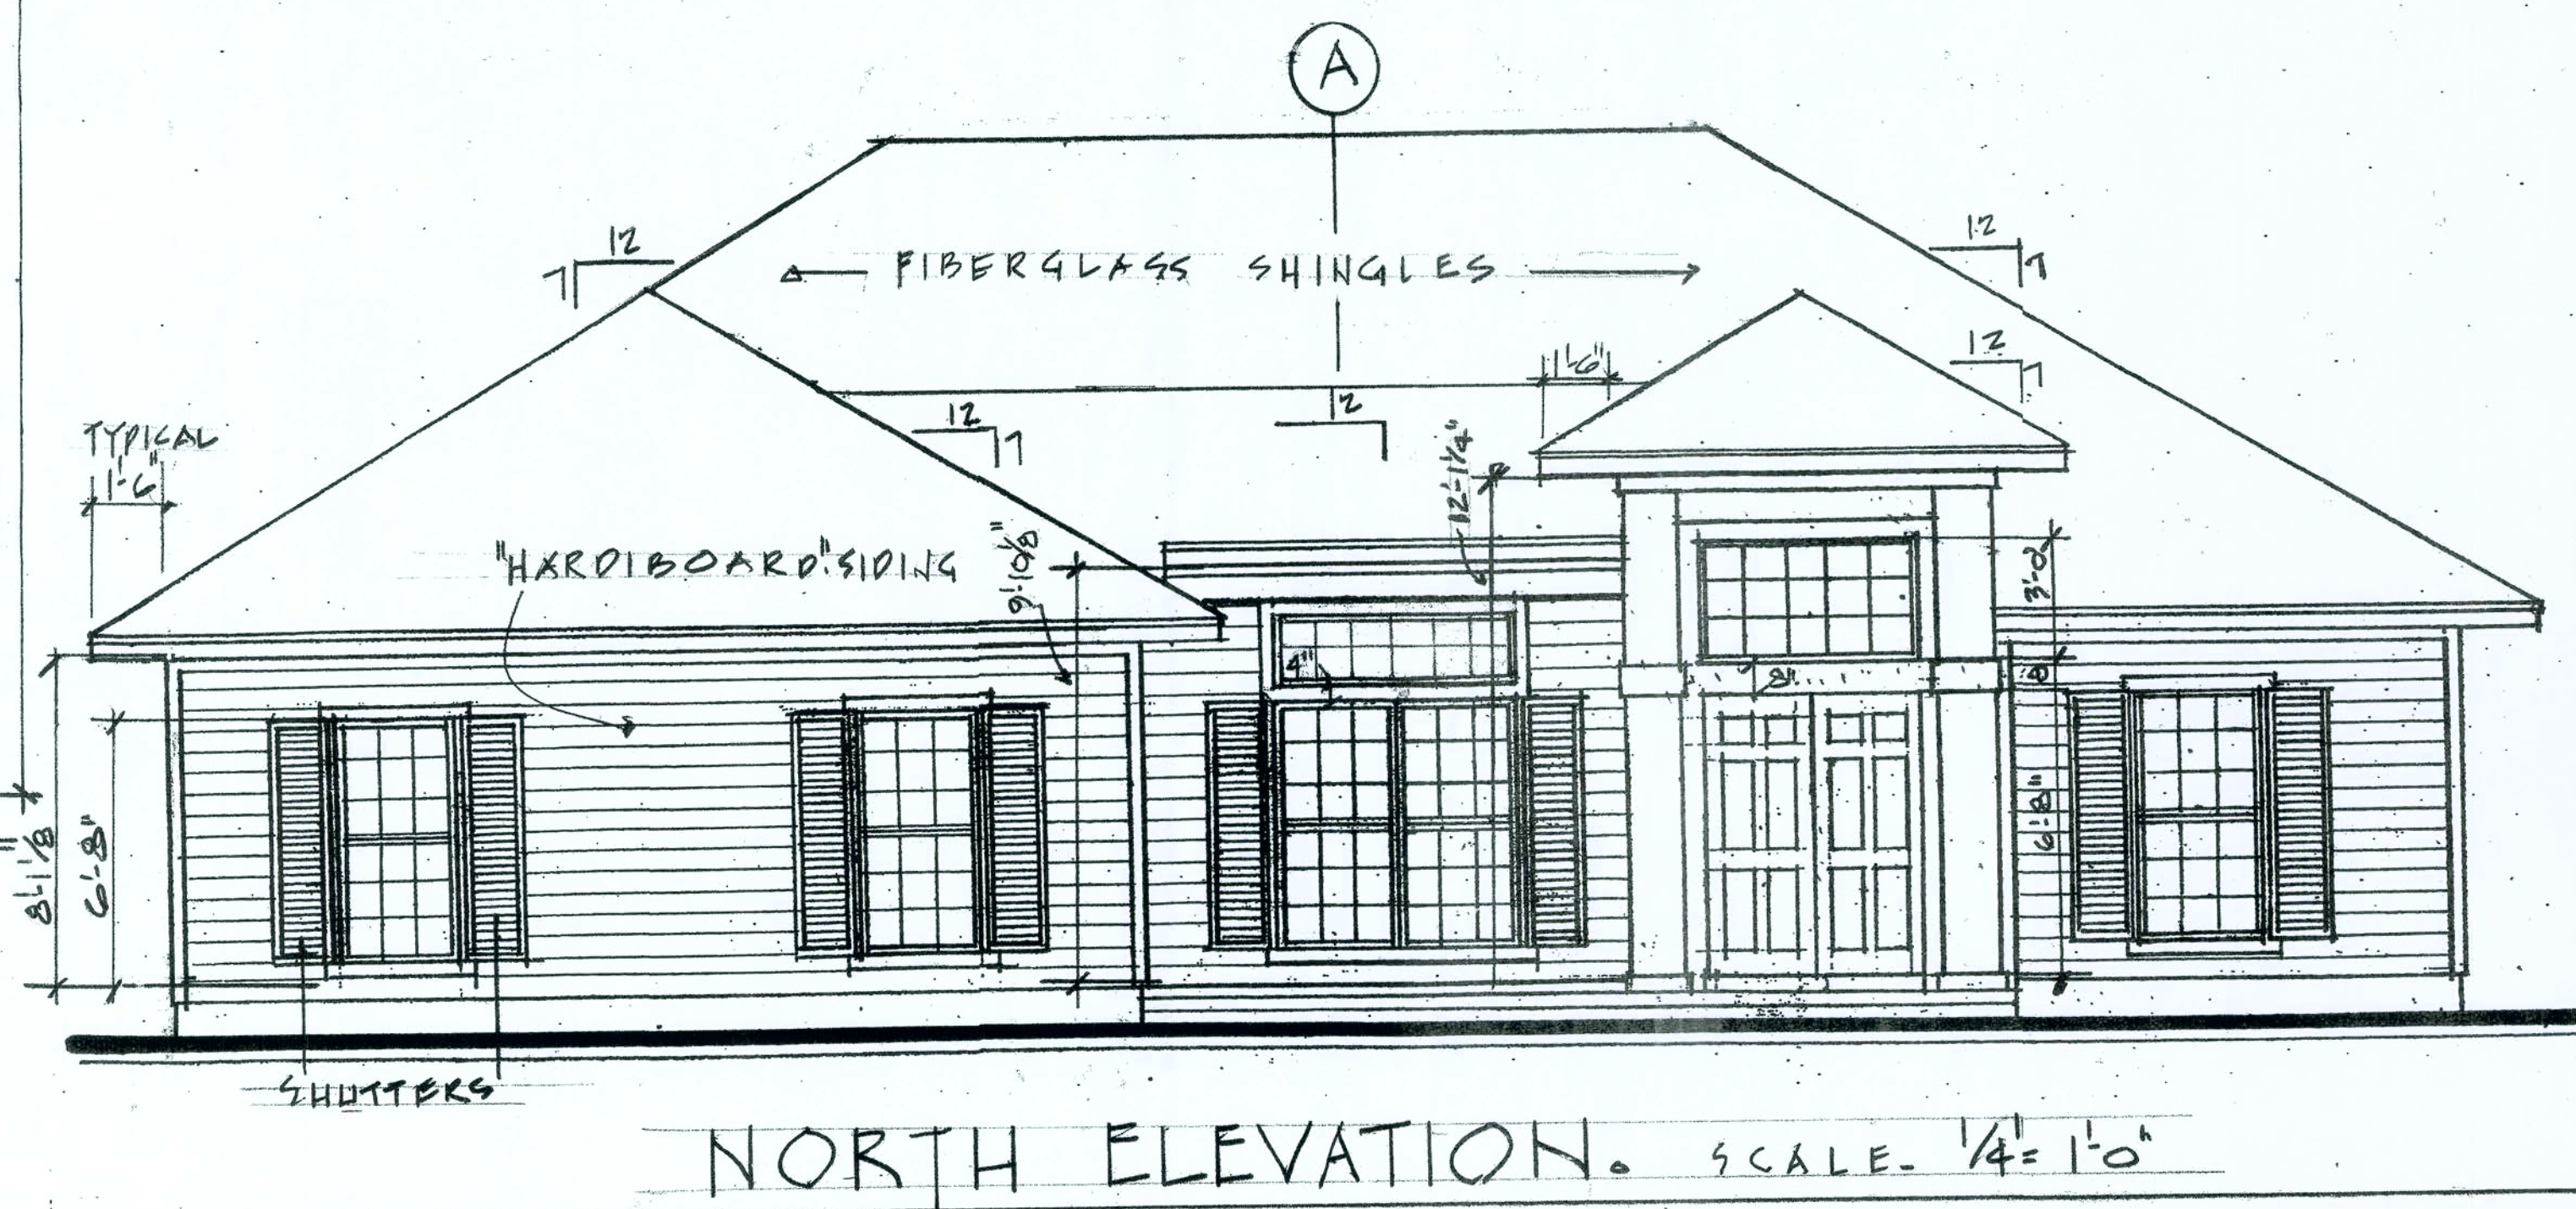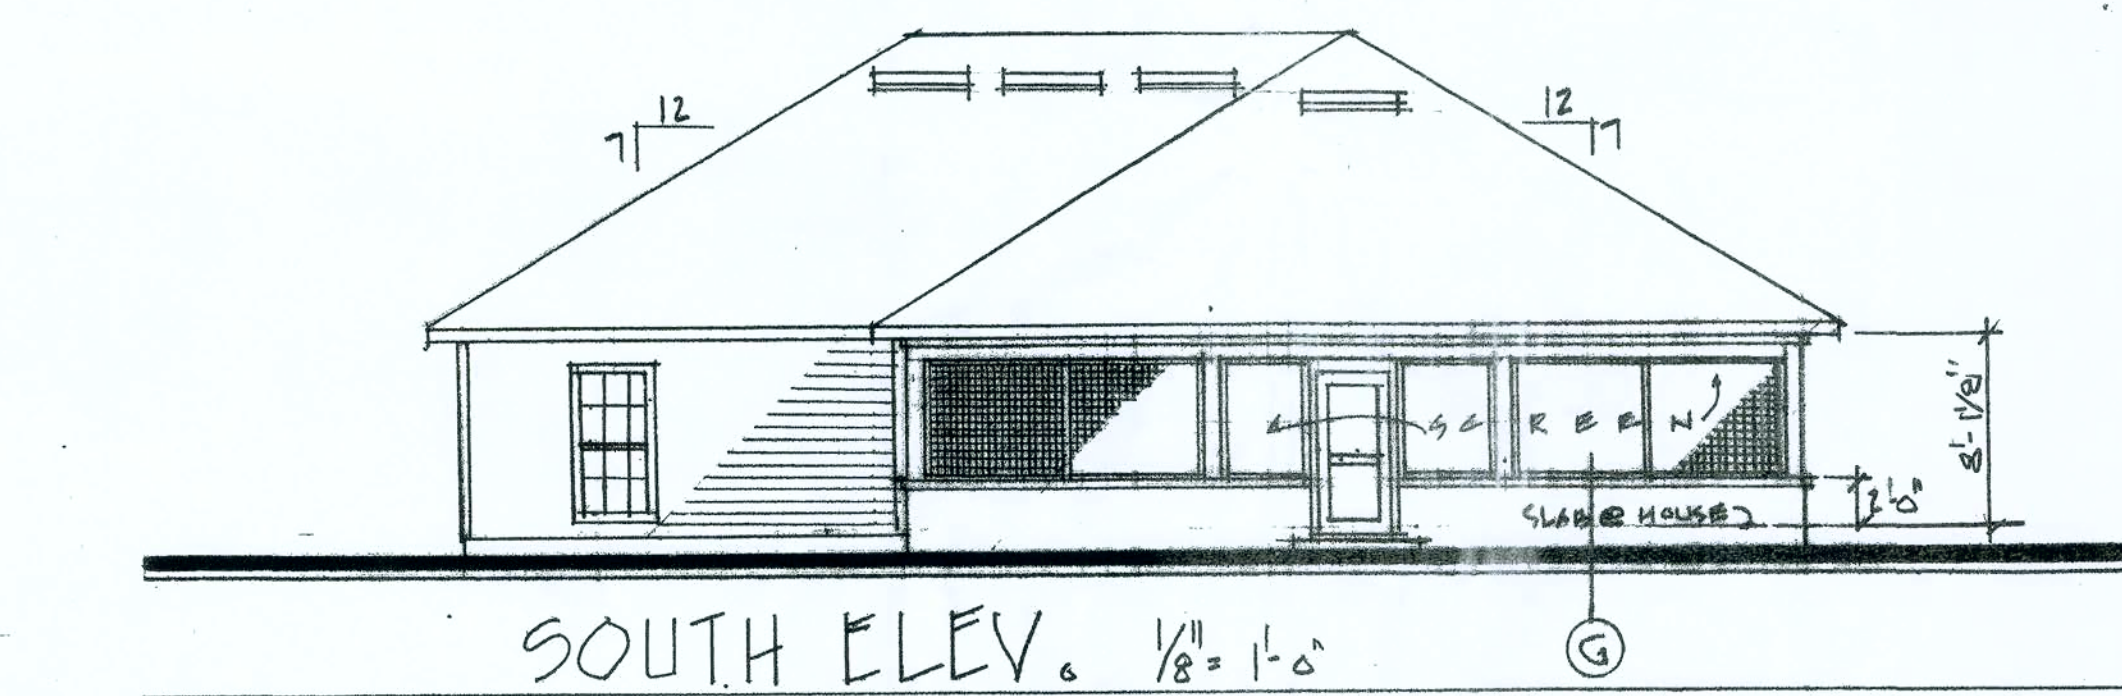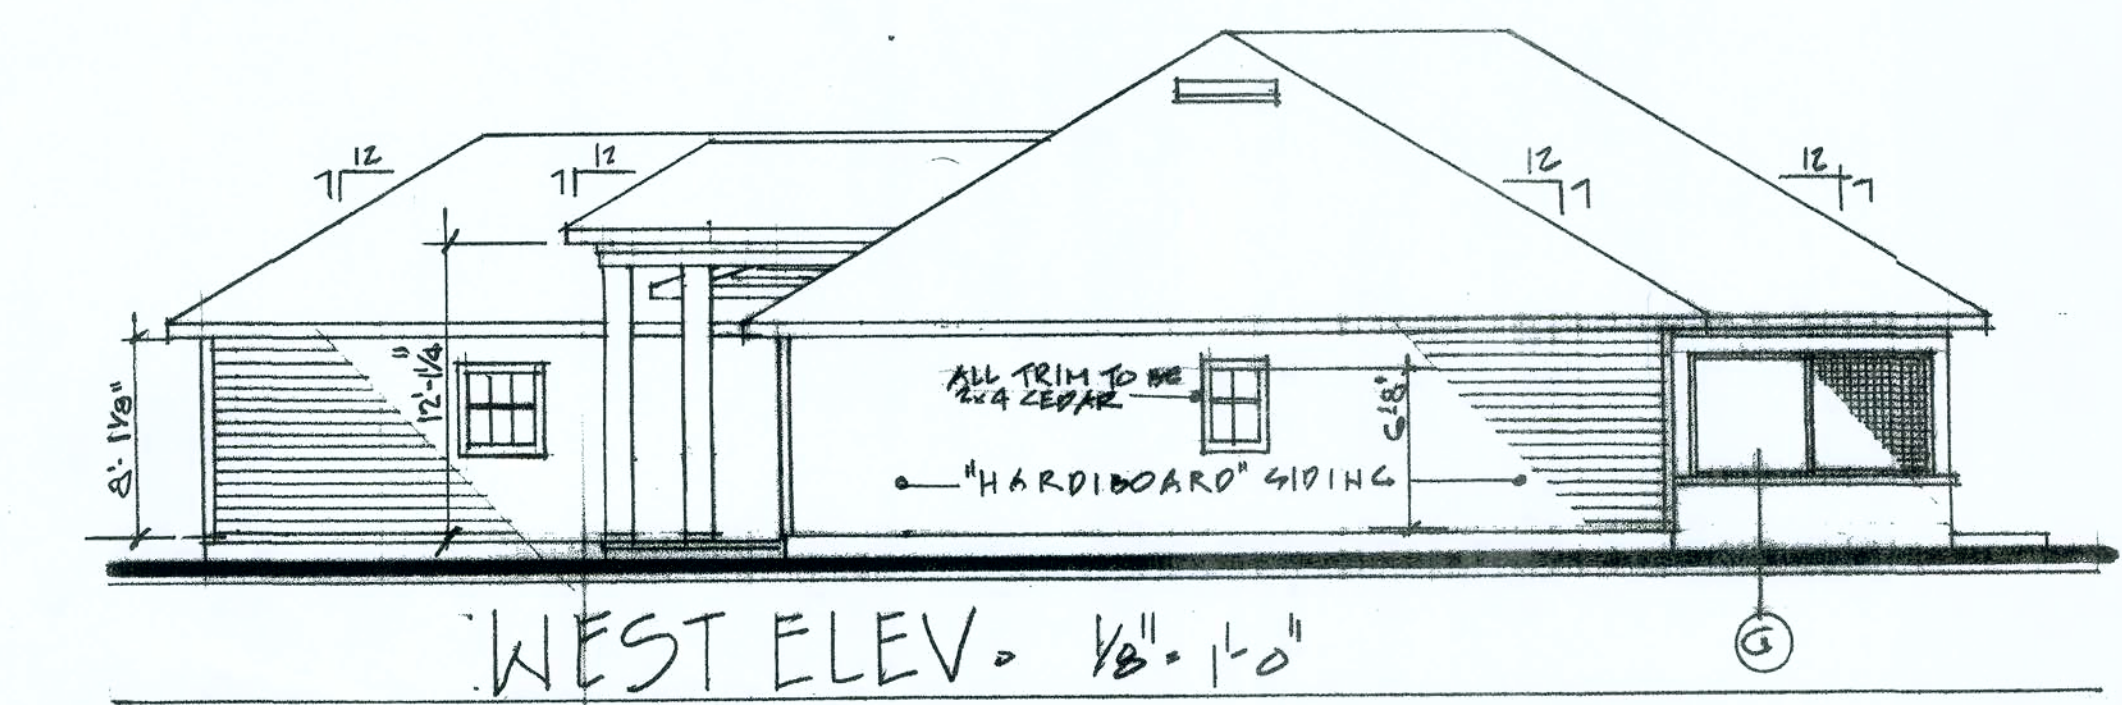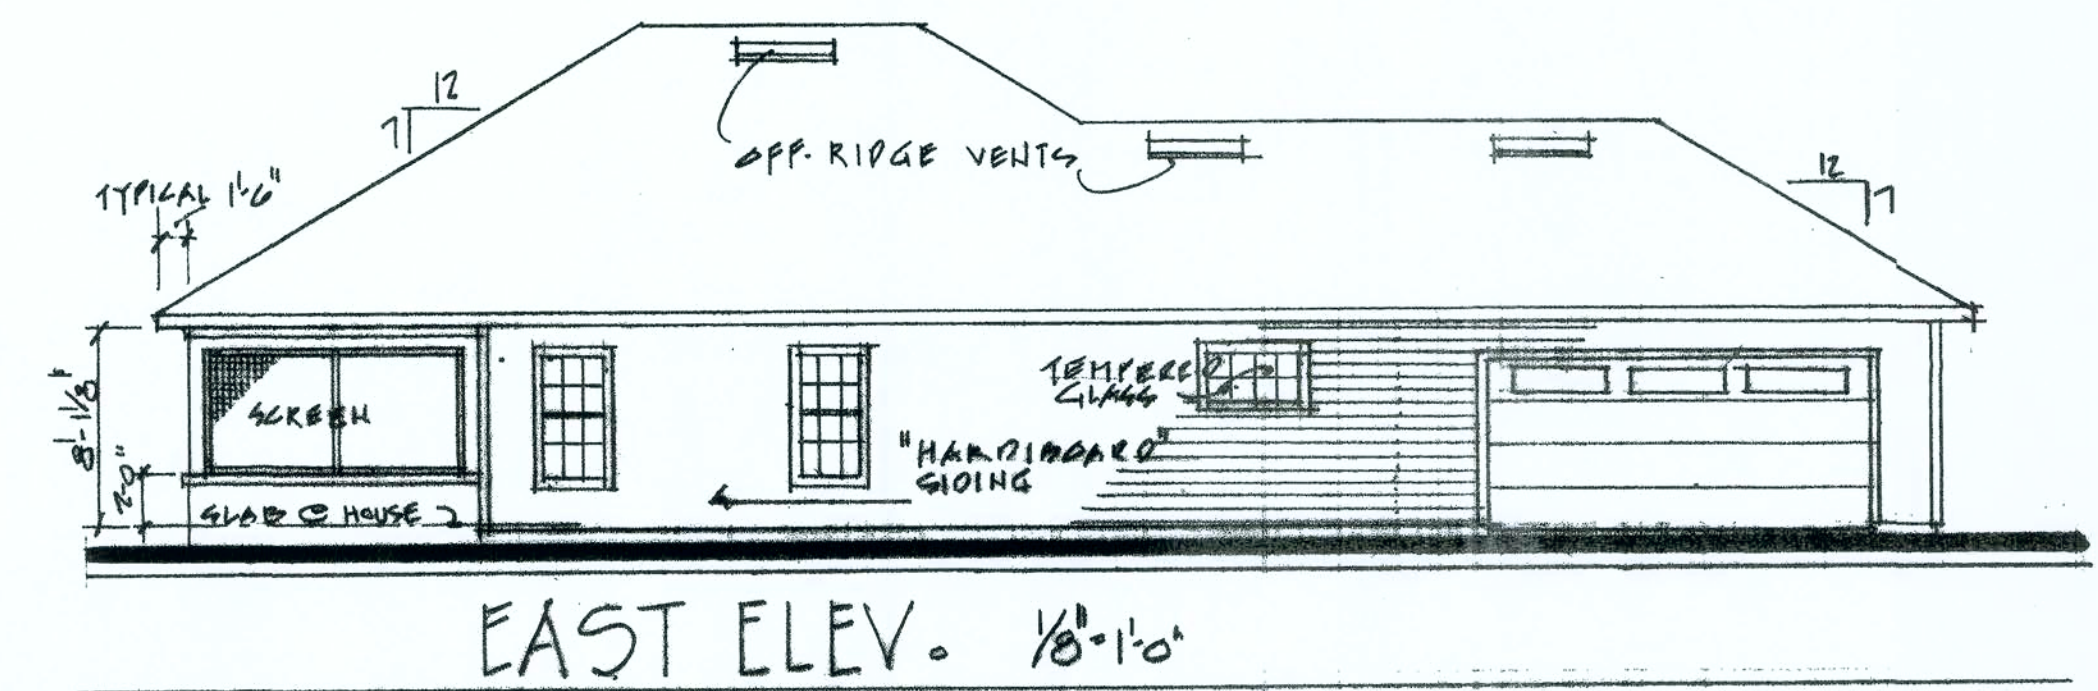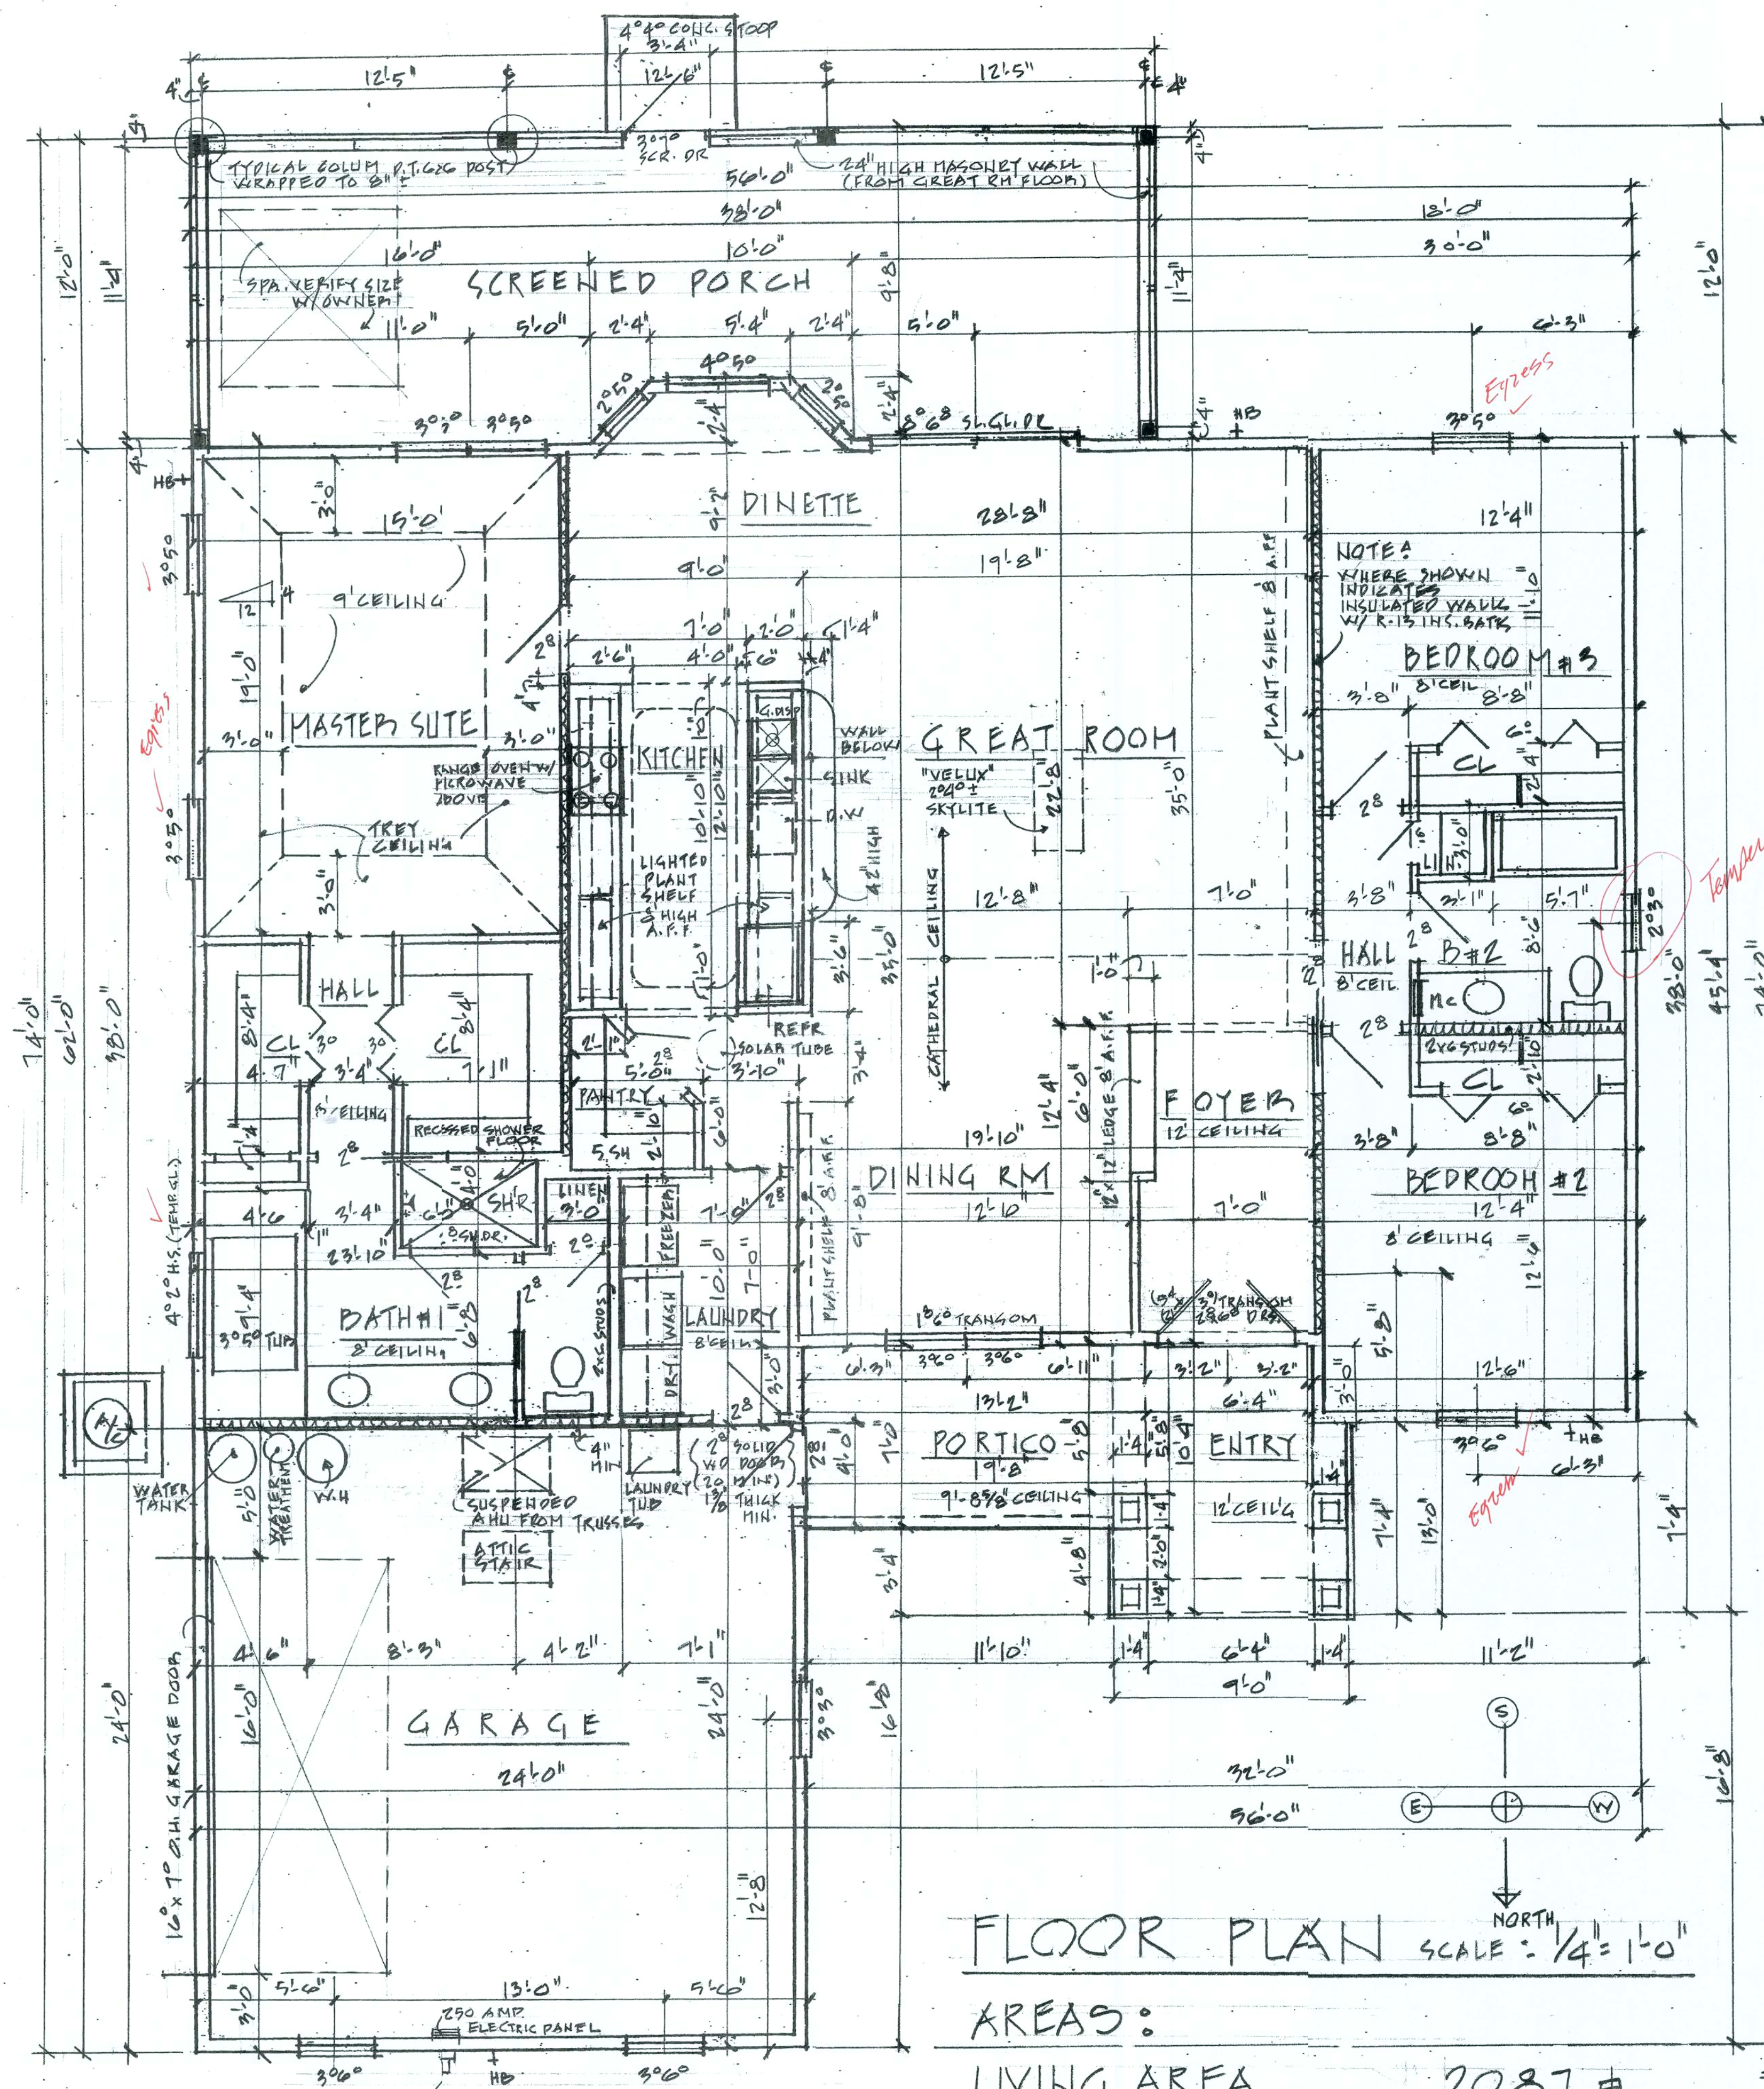


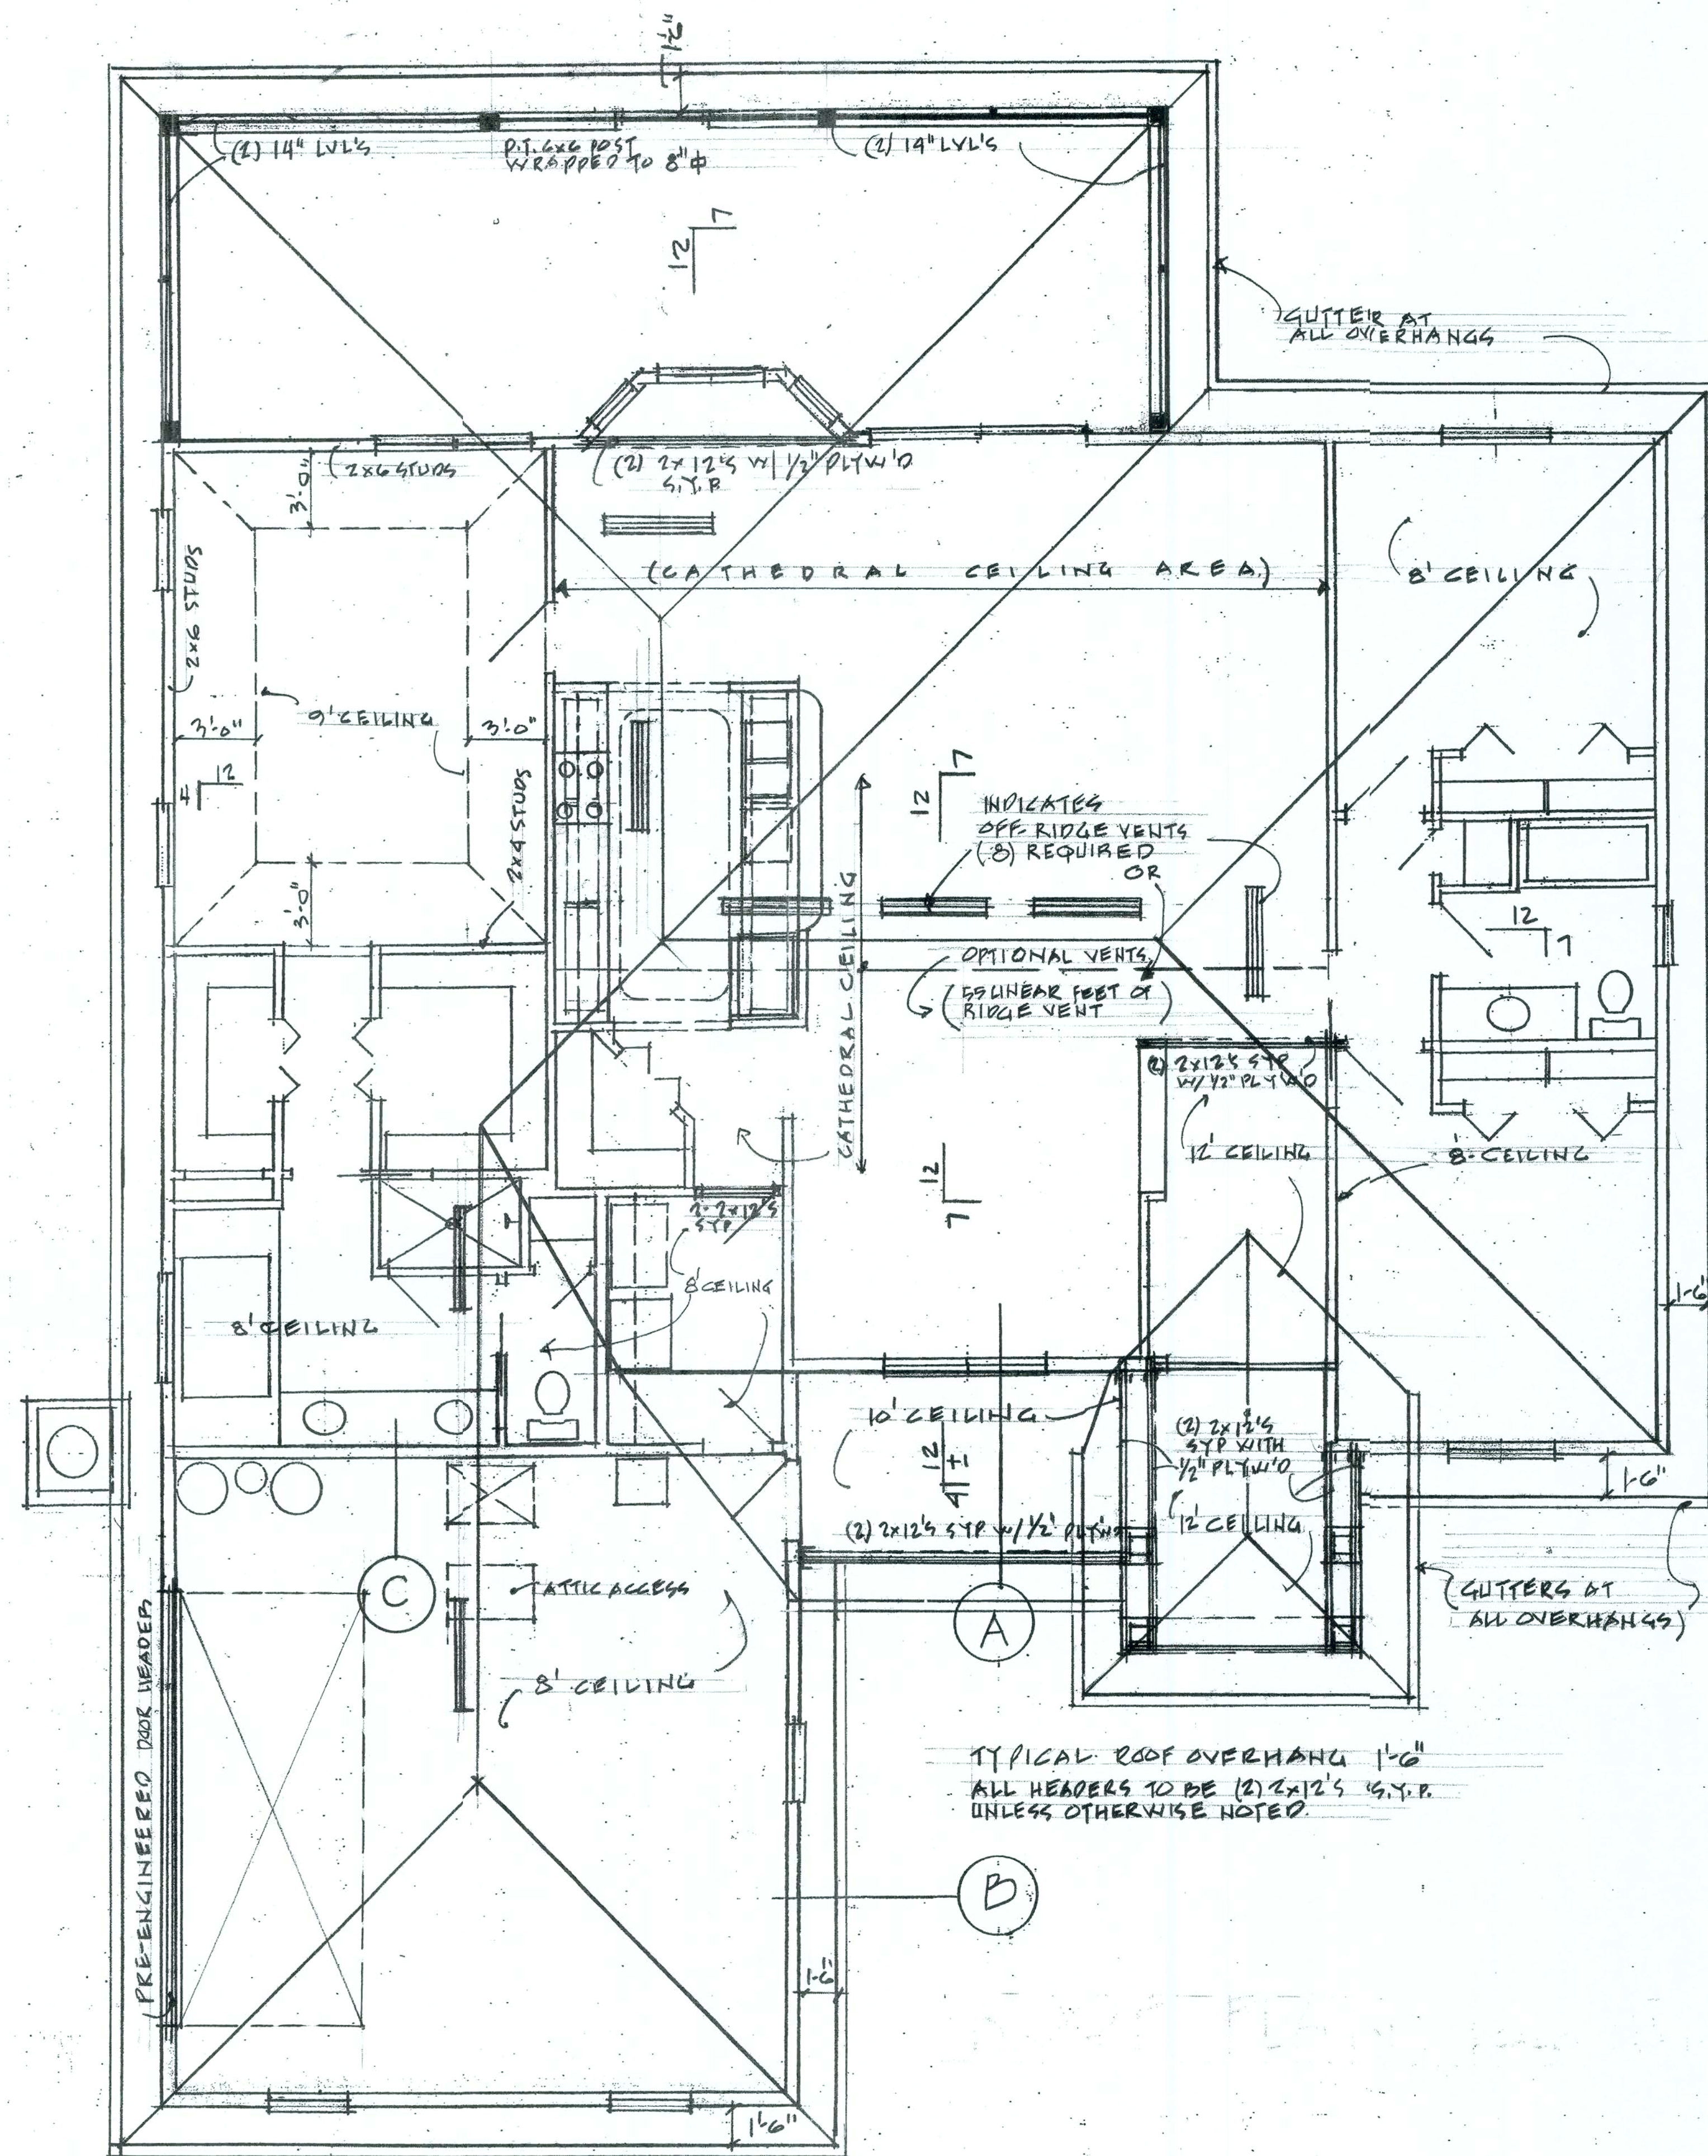



ROOF PLAN. SCALE. 1/4" = 1'-0"

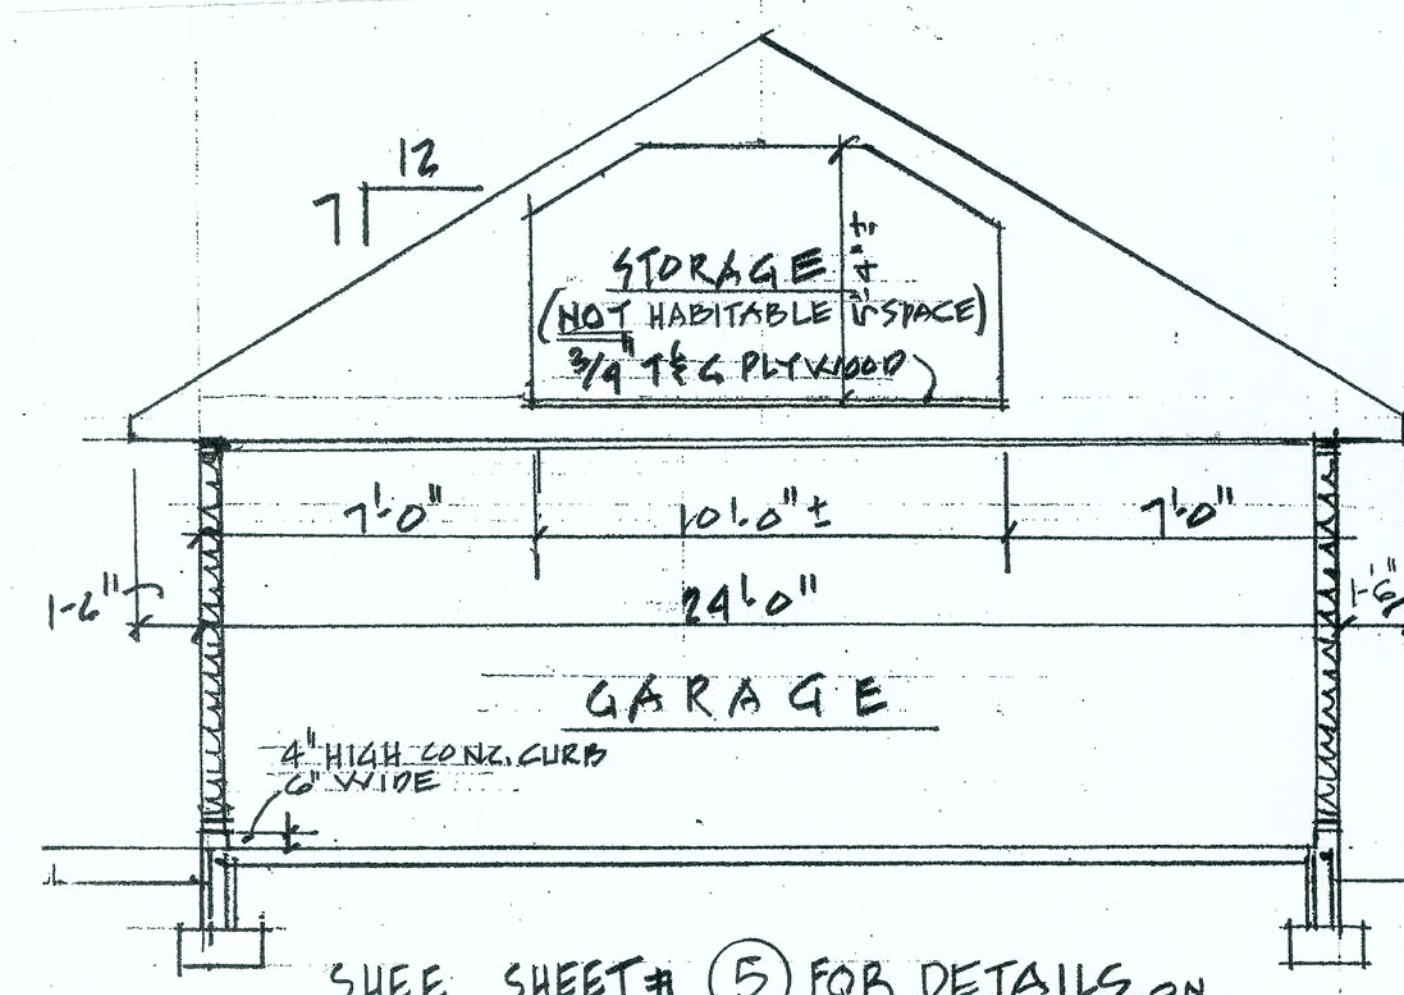


SECTION (B) SCALE. 1/4" = 1'-0"

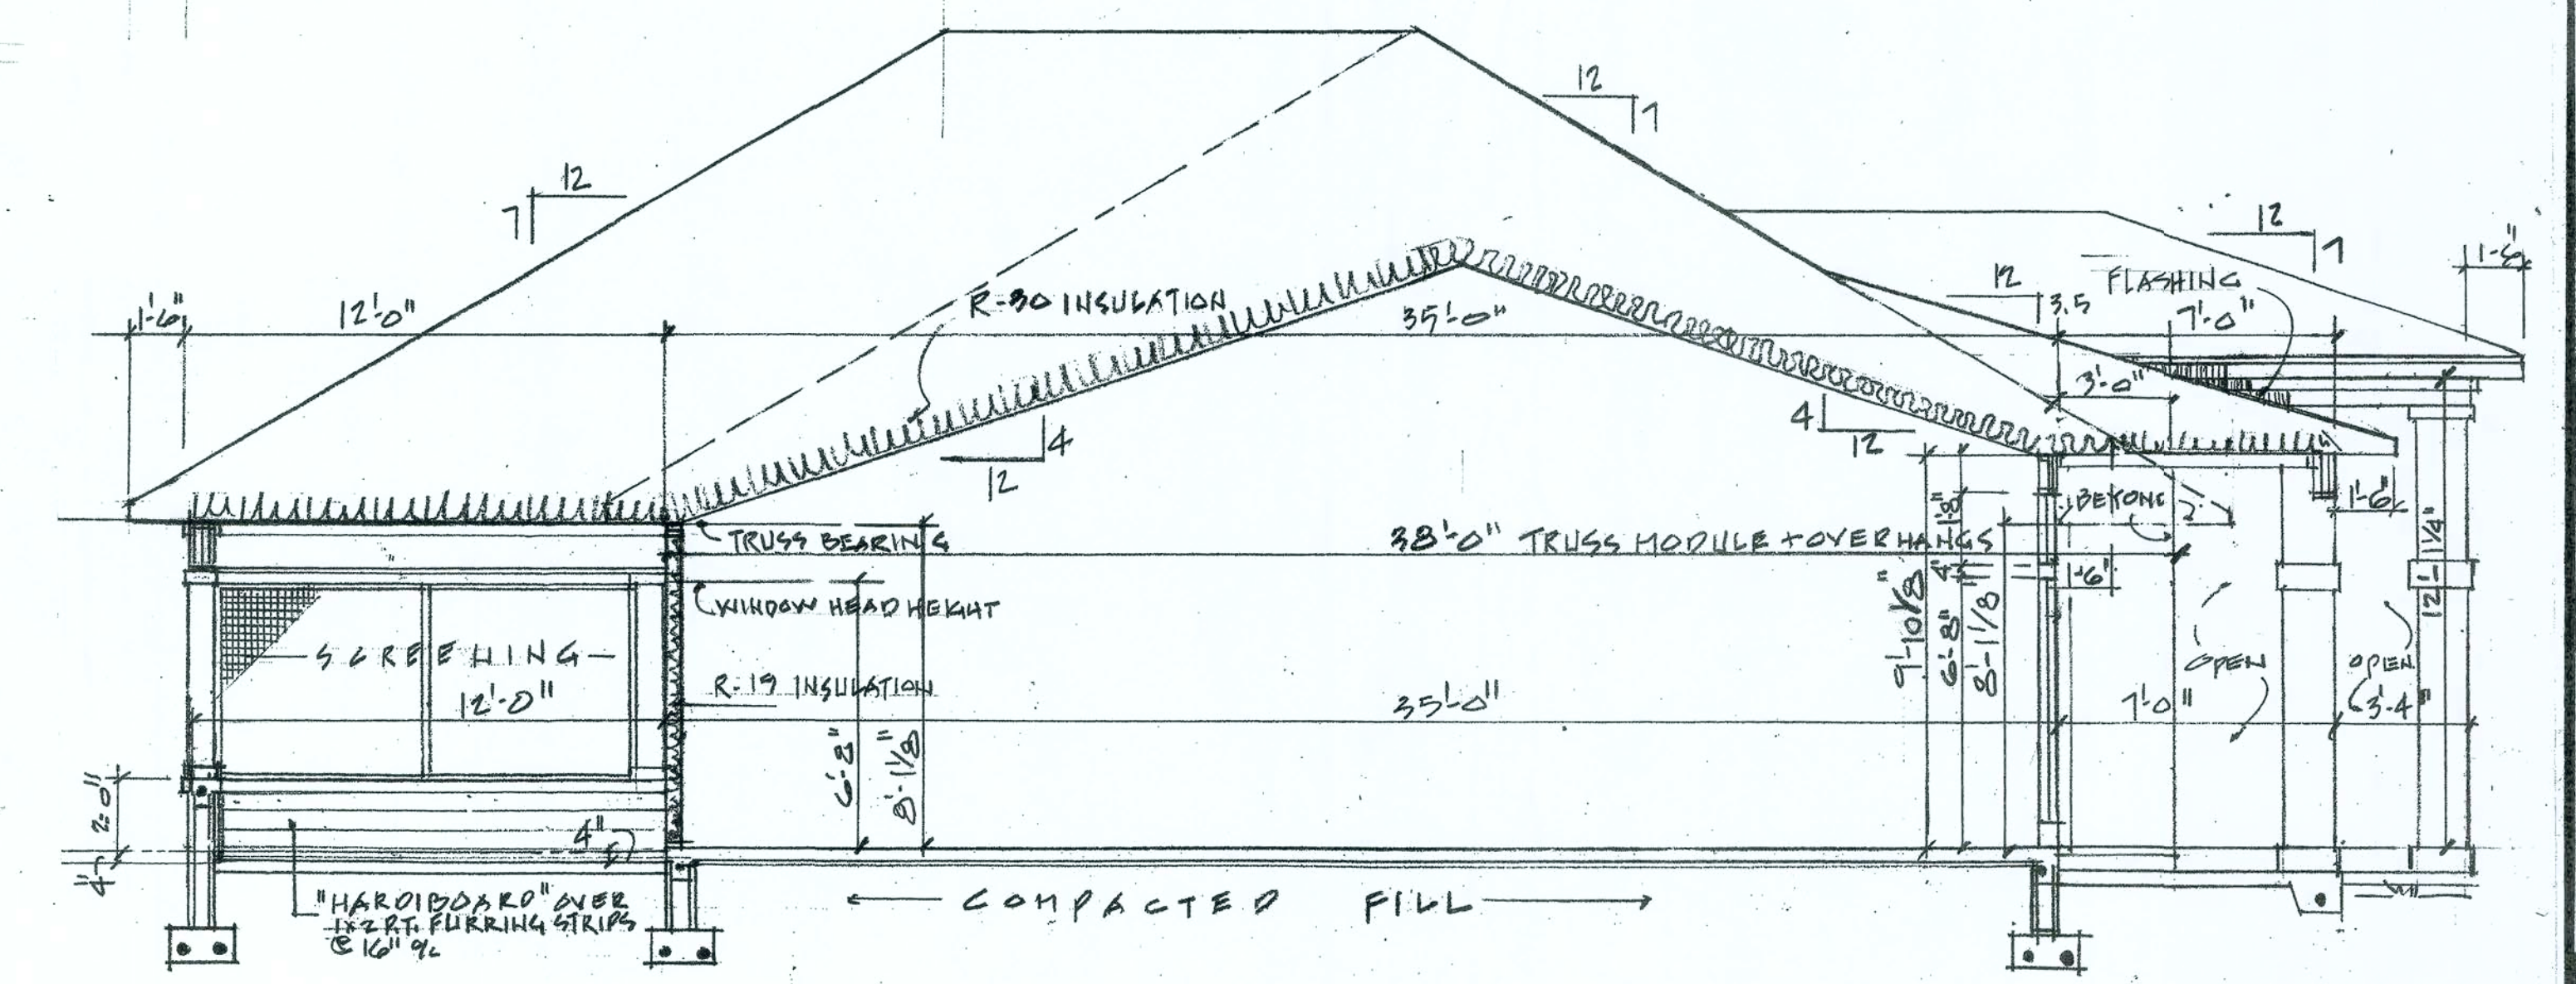

SECTION (A) SCALE. 1/4" = 1'-0"

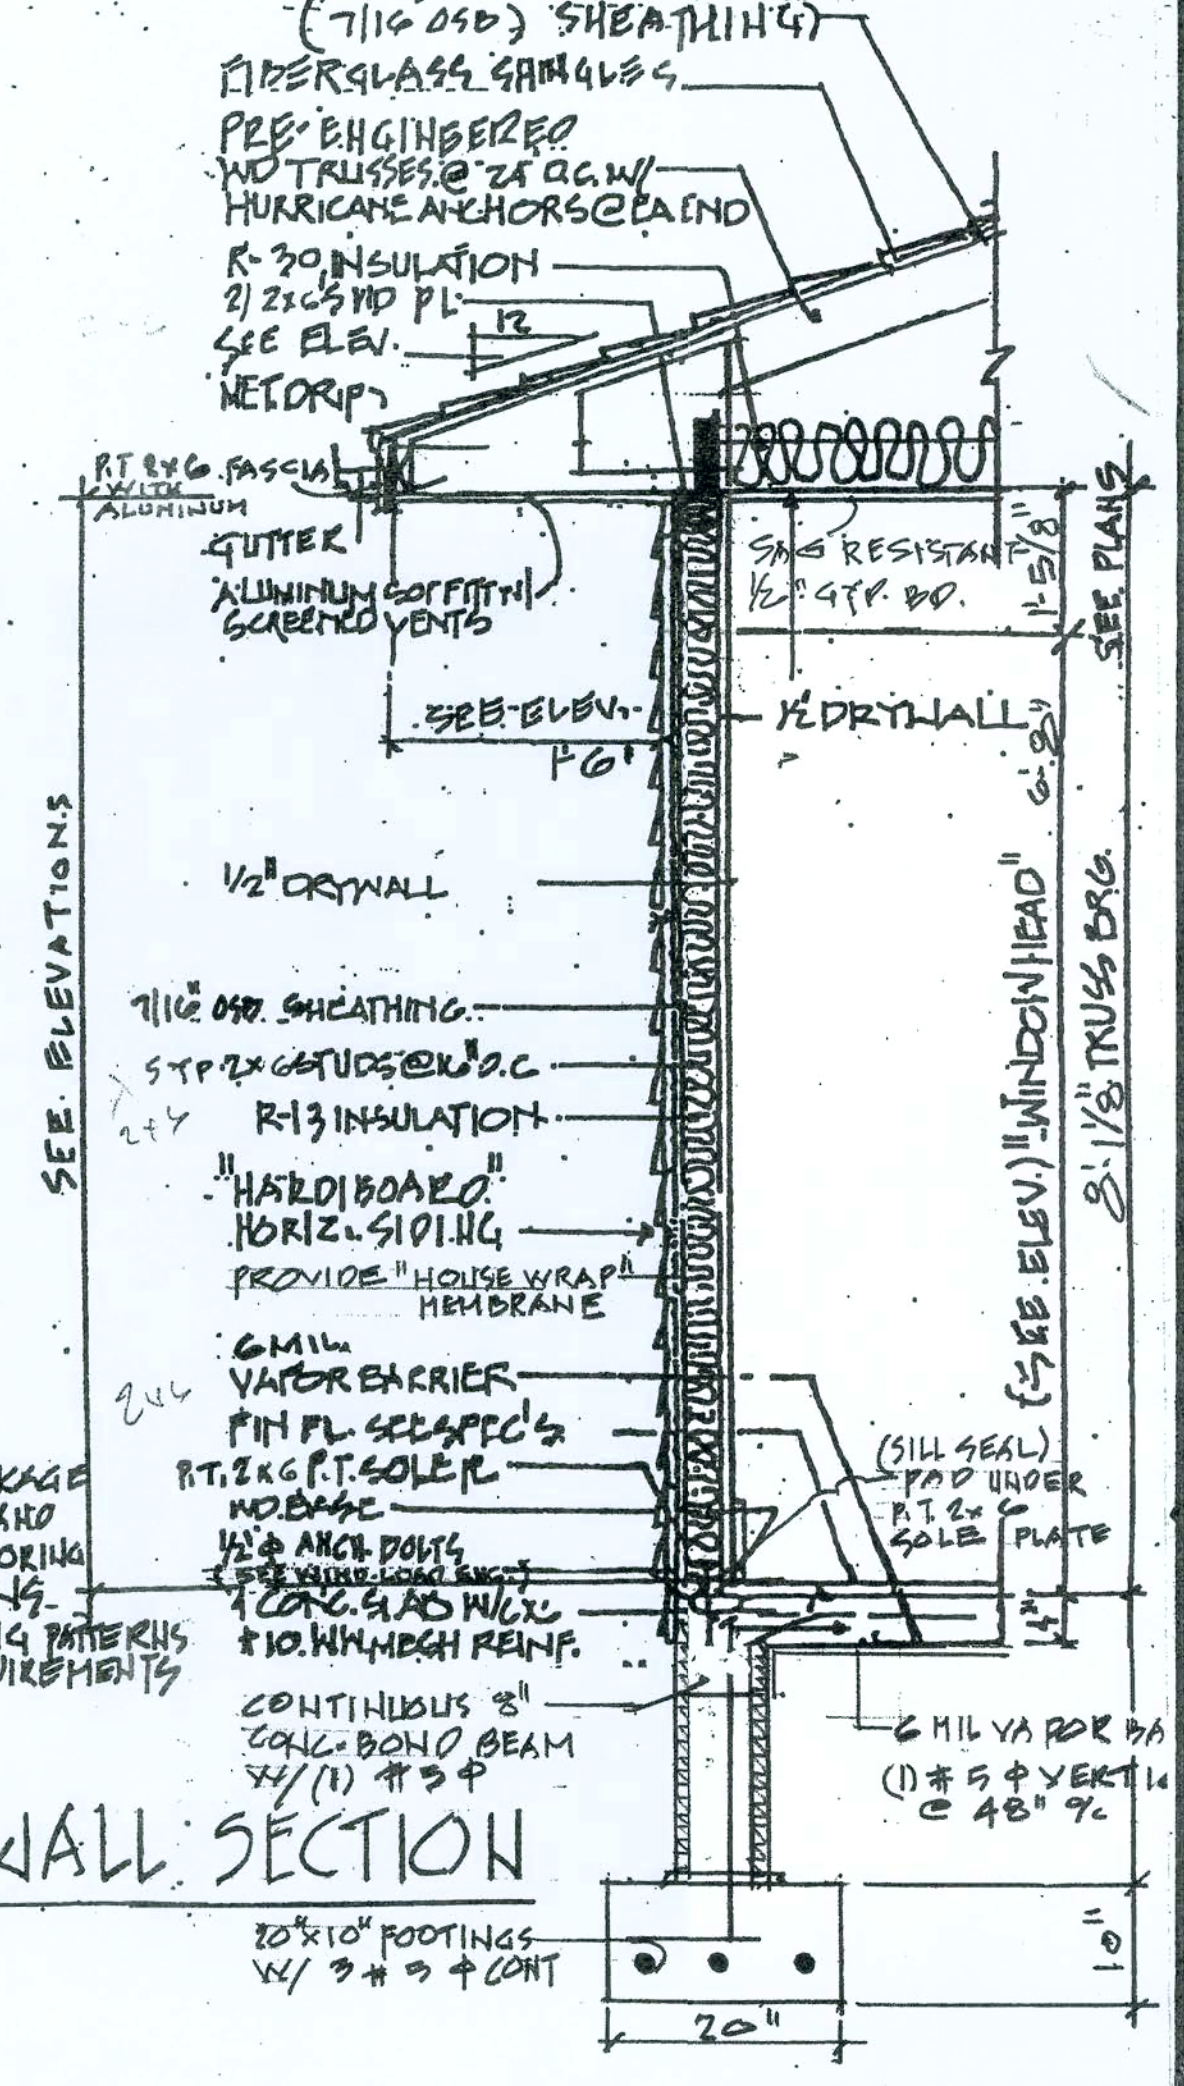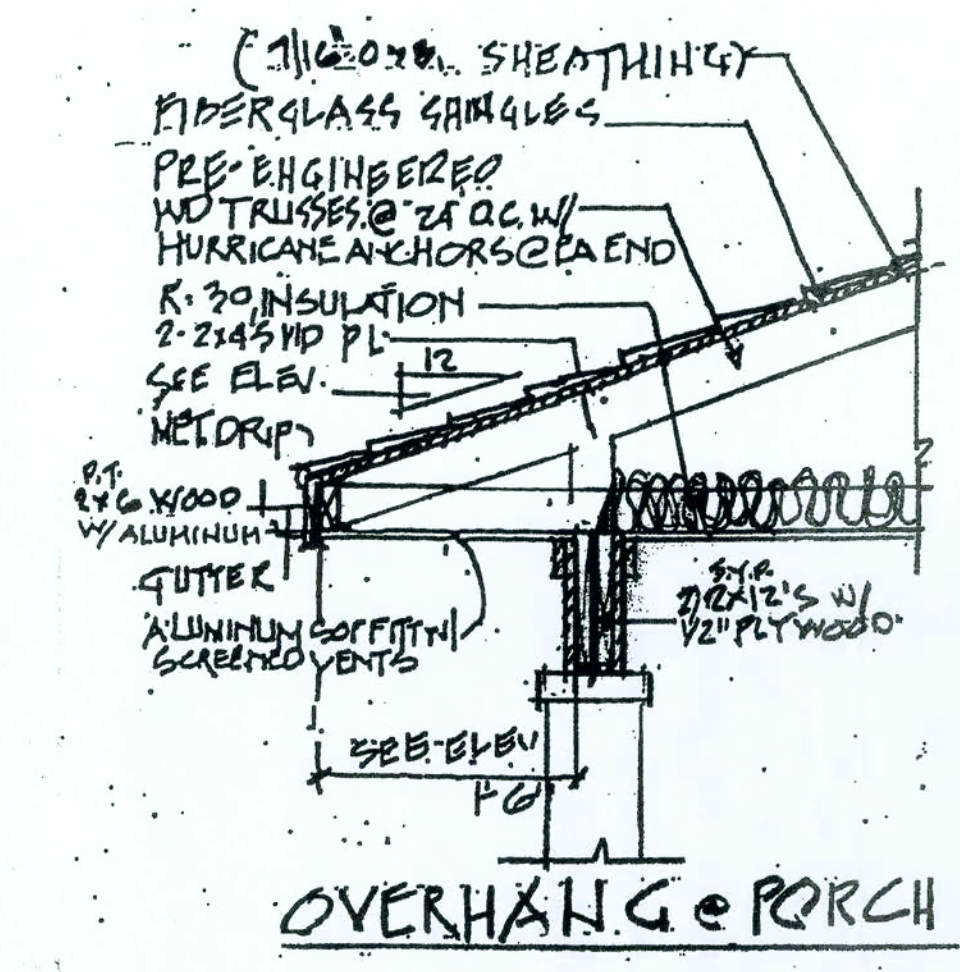

NOTE!
SEE WIND LOAD PACKAGE
OR WOOD SPECIES AND
ALL REQUIRED ANCHORING
AND CALCULATIONS
AS WELL AS NAILING PATTERNS
AND SPACING REQUIREMENTS

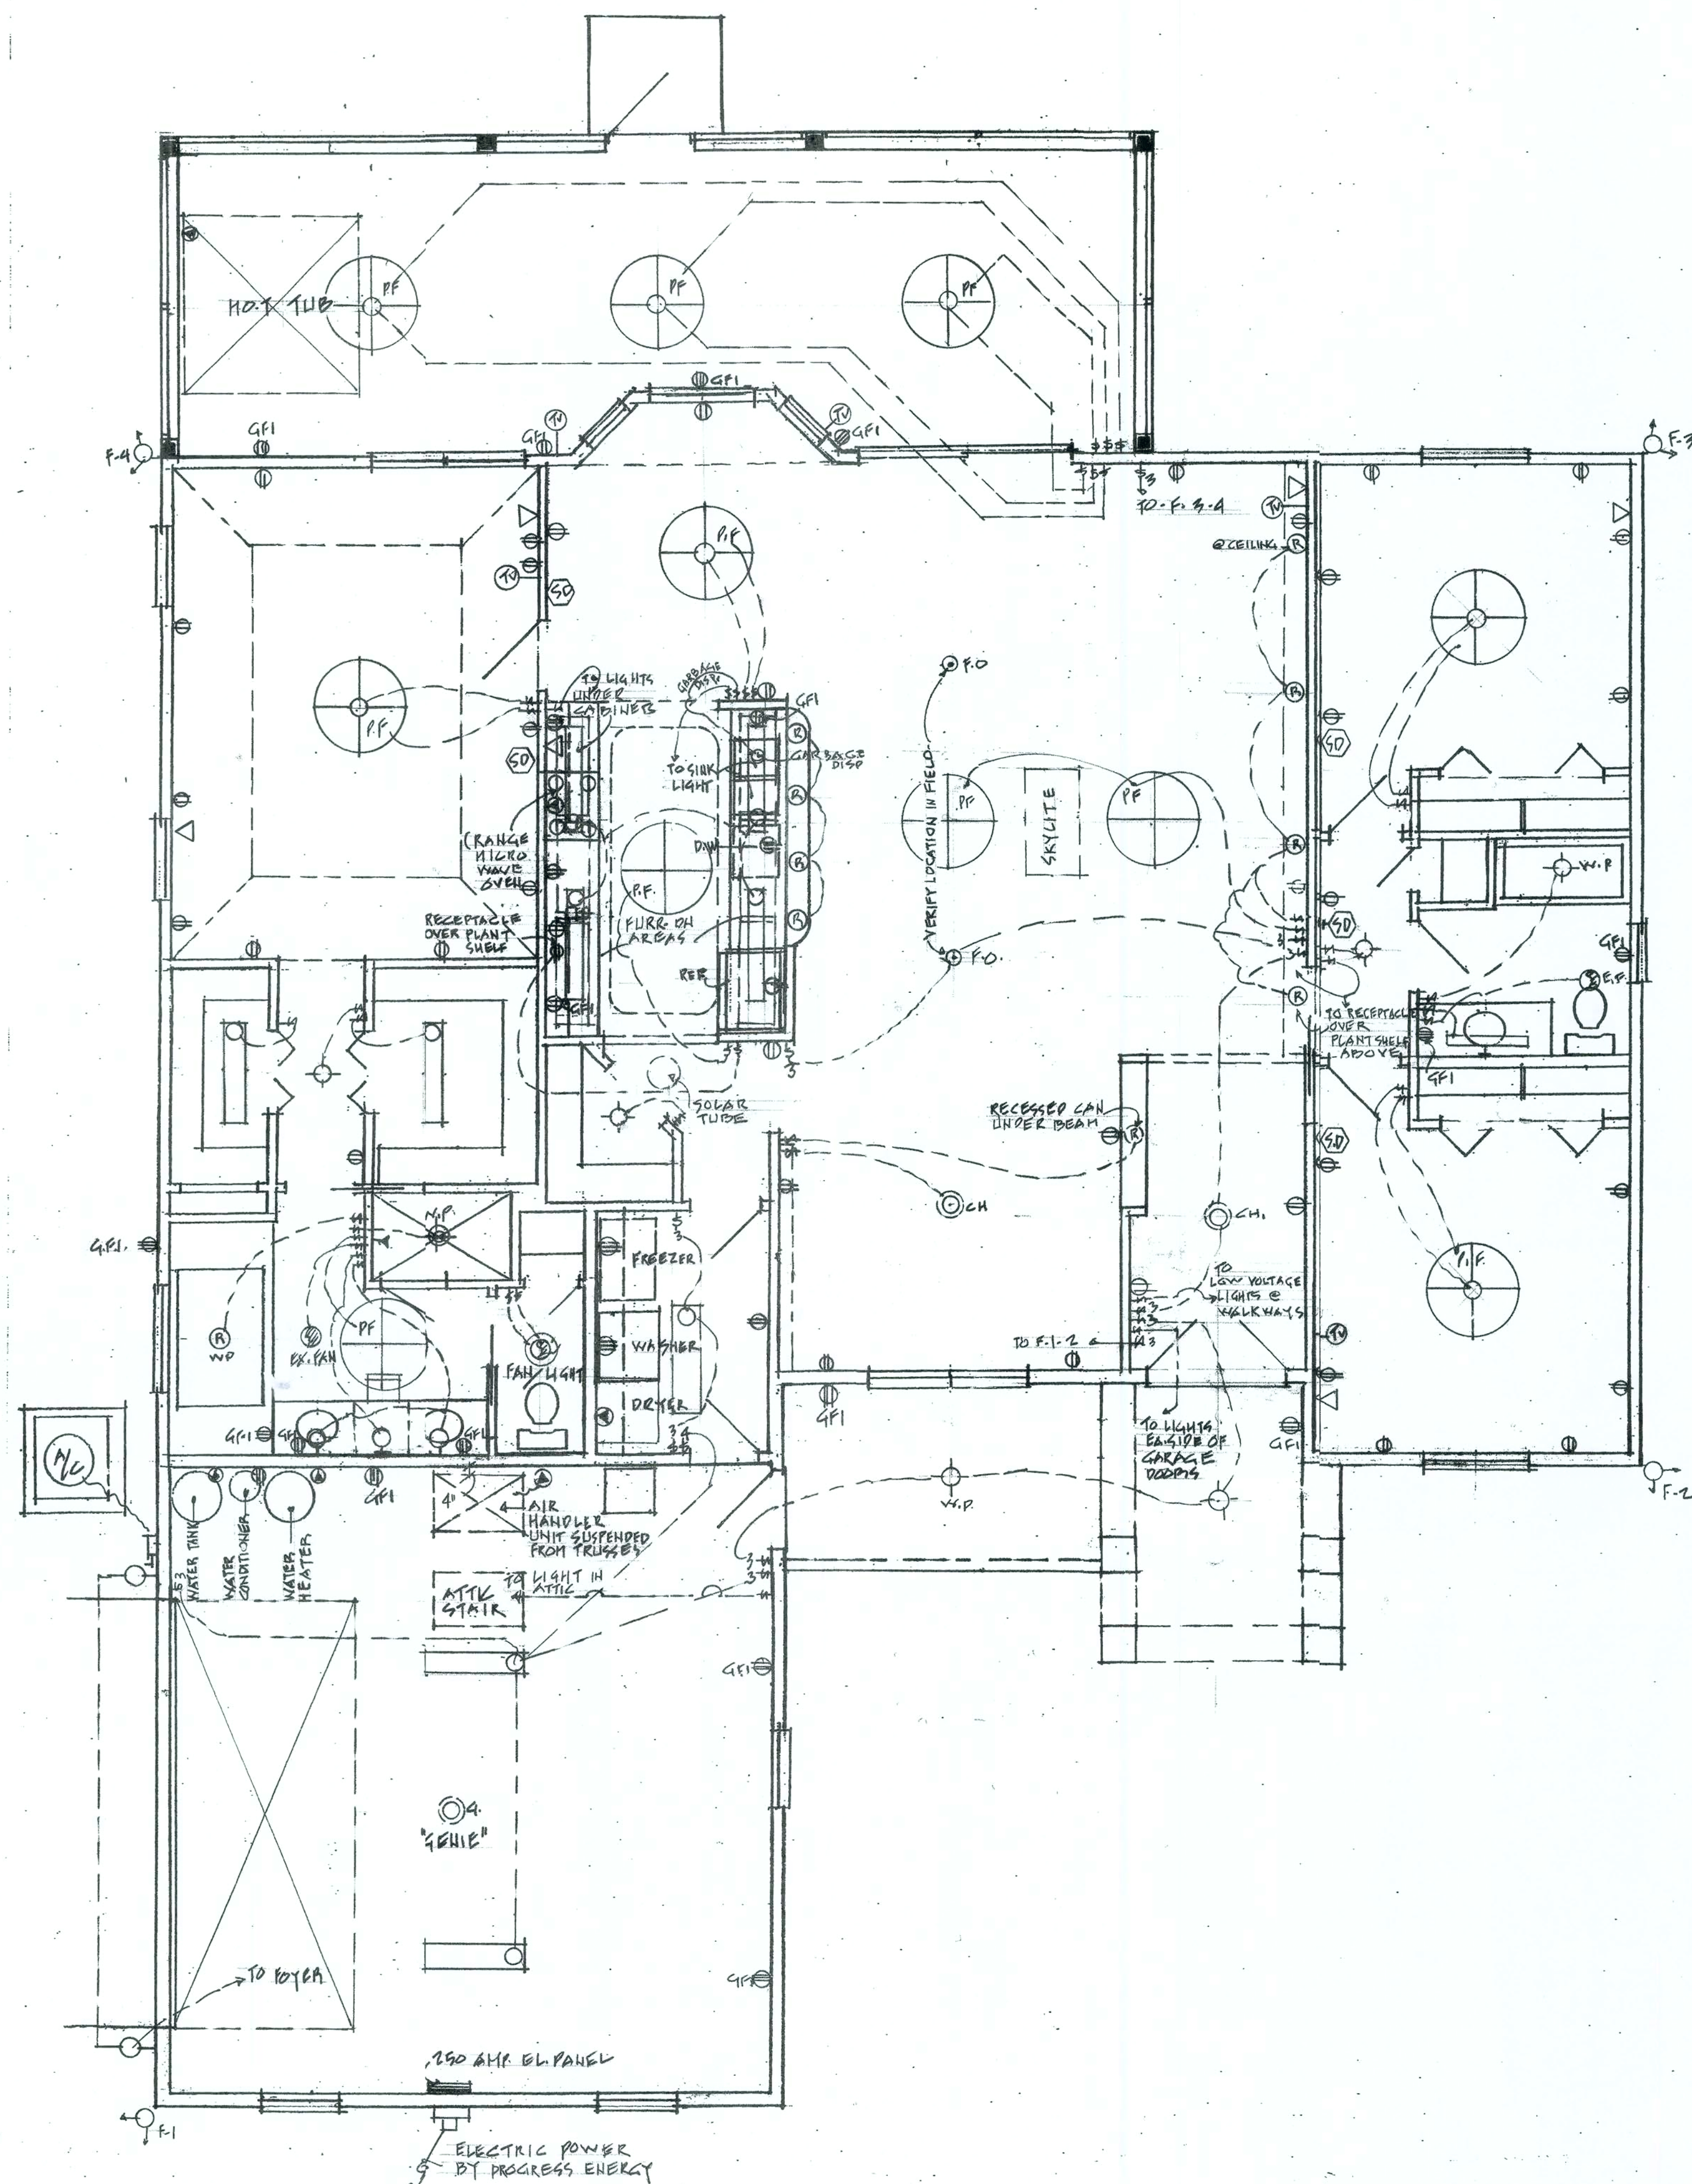


ELECTRICAL LEGEND.

- ⊕ DUPLEX RECEPTACLE @ 16" A.B.F.
- ⊕ GFI RECEPTACLE @ 42" A.B.F.
- ⊕ WATERPROOF G.F.I. RECEPTACLE
- ⊕ 220 VOLT RECEPTACLE
- ⊕ TELEPHONE JACK
- ⊕ TELEVISION OUTLET
- ⊕ EXHAUST FAN
- ⊕ EXHAUST FAN W/ LIGHT
- ⊕ CEILING MOUNTED LIGHT FIXTURE
- ⊕ RECESSED LIGHT FIXTURE
- ⊕ PADDLE FAN
- ⊕ PADDLE FAN WITH LIGHT
- ⊕ SMOKE DETECTOR
- ⊕ FLUORESCENT LIGHT FIXTURE
- ⊕ FLOOD LIGHT
- ⊕ WALL MOUNTED LIGHT
- ⊕ TOGGLE SWITCH
- ⊕ TOGGLE SWITCH - 3 WAY
- ⊕ FLOOR RECEPTACLE
- ⊕ GYS MOTOR
- ⊕ GARAGE PR. OPENER
- ⊕ CHANDELIER
- ⊕ ELECTRIC PANEL

Electrical Main Disconnecting means with meter & SE of wire

PROVIDE ARC FAULT CIRCUITS IN ALL BEDROOMS (AFCI)

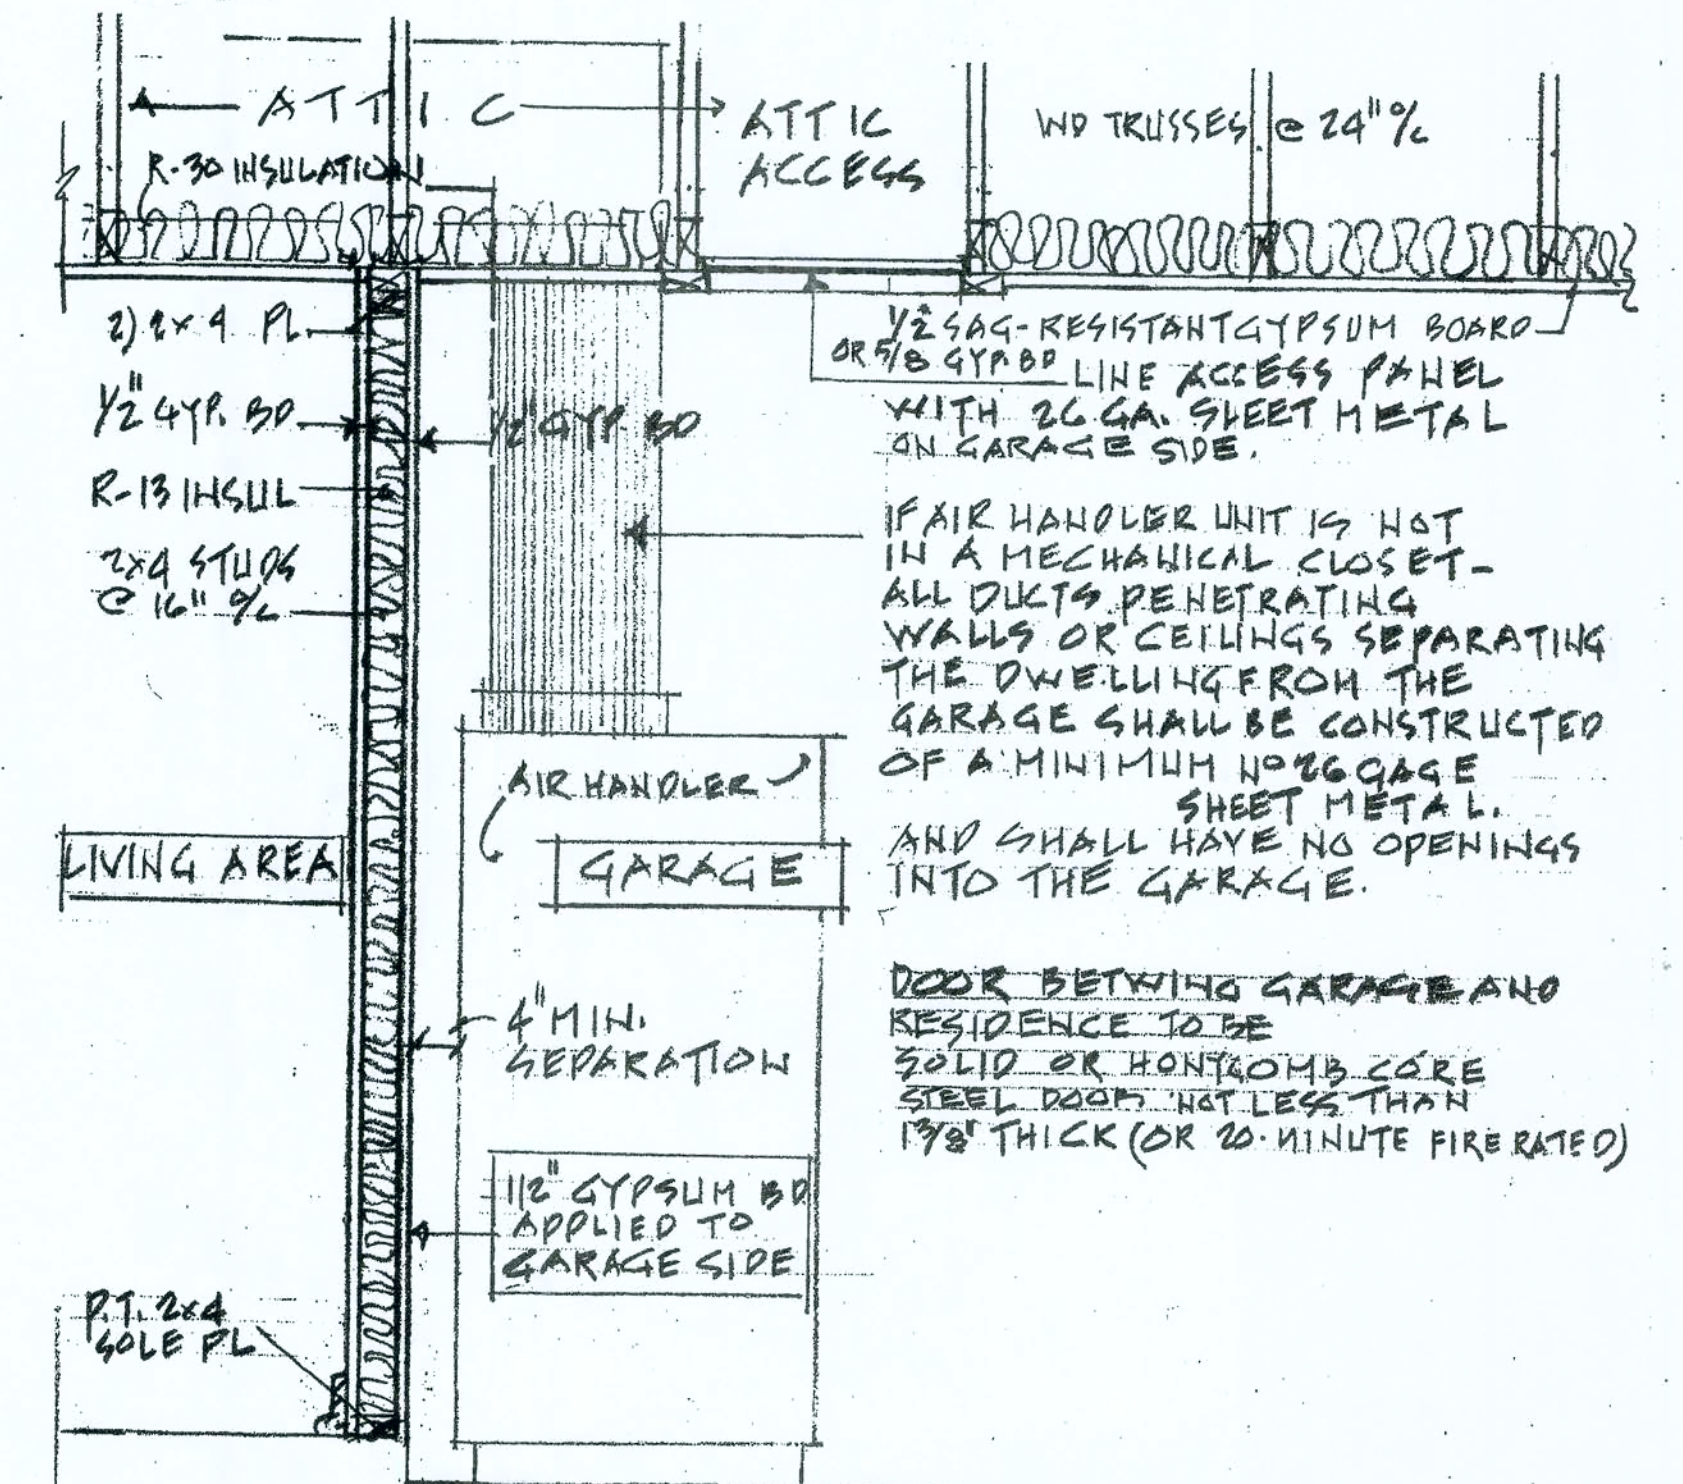


1. OPENING PROTECTION / DUCT PENETRATION
2. SEPARATION REQUIREMENTS BETWEEN GARAGE AND RESIDENCE AND ITS ATTIC AREA

DETAILS - SCALE - 3/4" = 1'-0"

HEAT & A/C LAYOUT

AC Notes

- ▲ = Supply
- = Return
- = Exhaust Fan 40 CFM
- 1 1/2" = 1 1/2" Reducing Extended Plenum
- ~ = Flex duct
- ★ = Thermostat (Digital)
- ☼ = Heat Pump Condensor
- ☒ = Air Handler

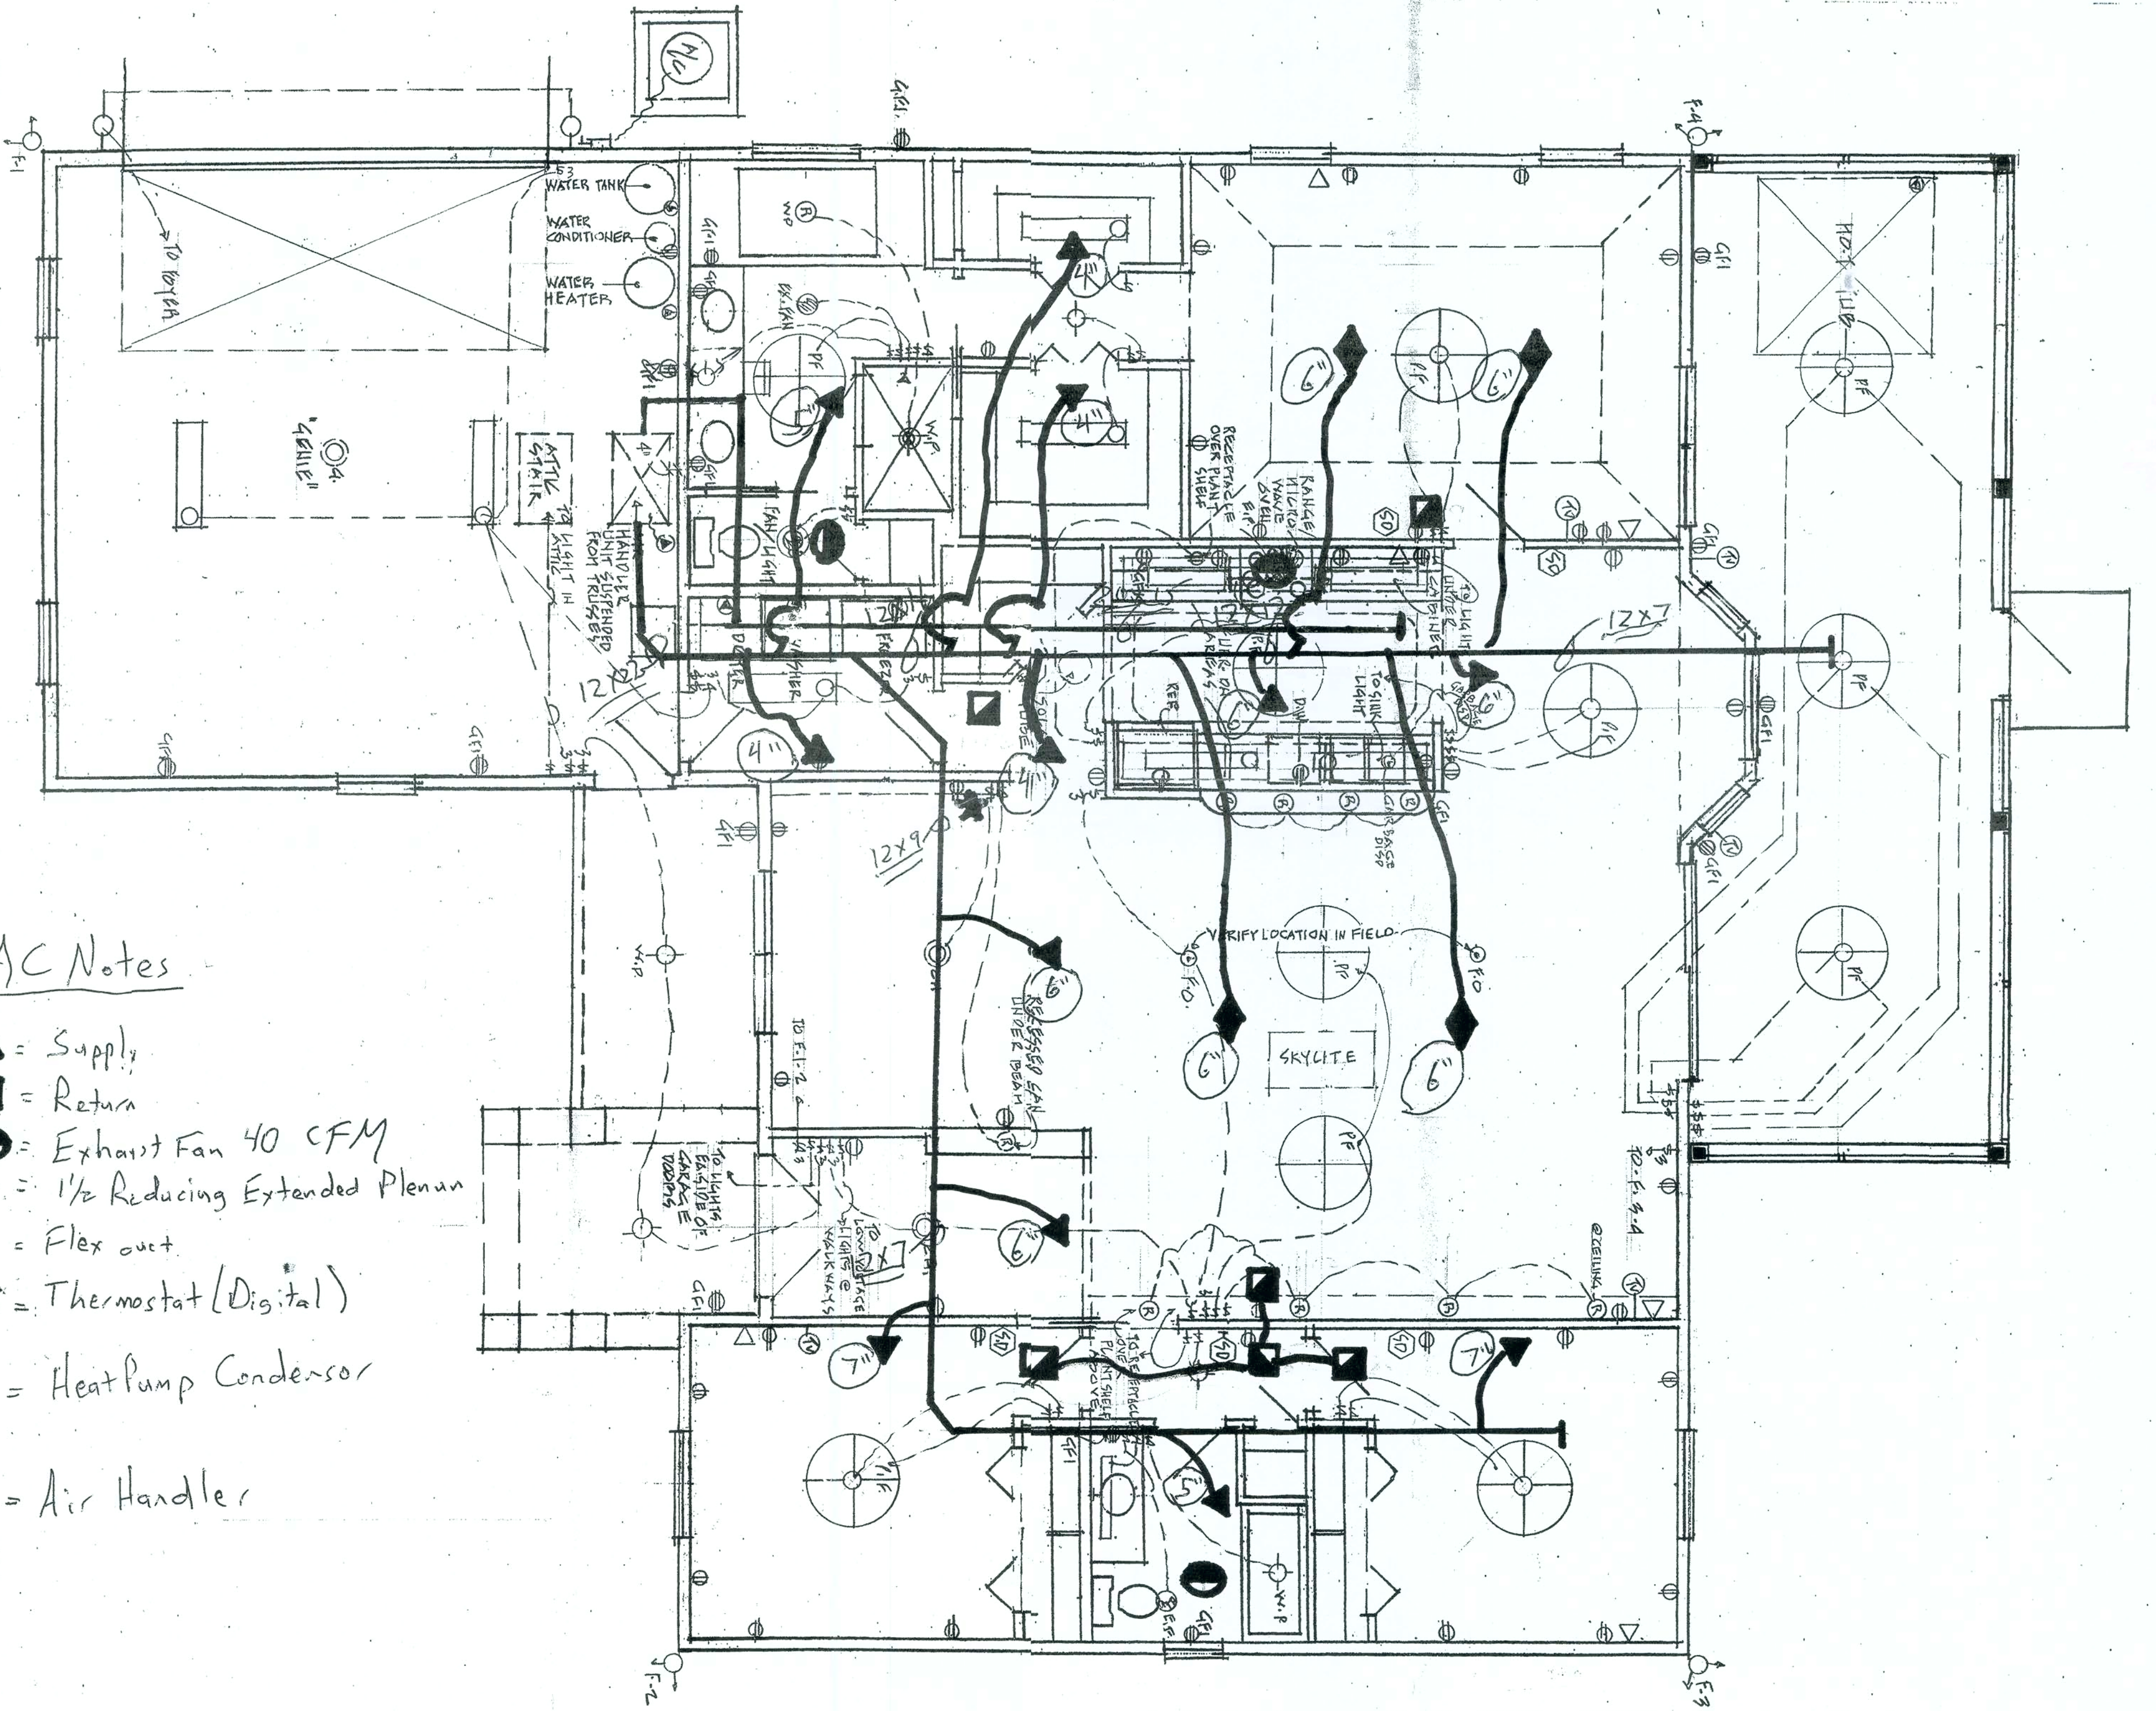

LOT NO. 1 NEW LAYOUT ON LOT



20 0 20 40 60

GRAPHIC SCALE - FEET

DESCRIPTION: (AS FURNISHED)
Lot 1, of a Replat of Lots 39, 45, and 46, of SANTA FE RIVER PLANTATIONS, according to the Plat thereof as recorded in Plat Book 5, Page(s) 13, of the Public Records of Columbia County, Florida.

Certifying Land Surveyor accepts no responsibility for rights-of-way, assessments, restrictions, or other matters affecting title to lands surveyed other than those recited in current deed and/or other instruments of record furnished by client.

Note: This survey was performed without the benefit of a "TITLE ABSTRACT."

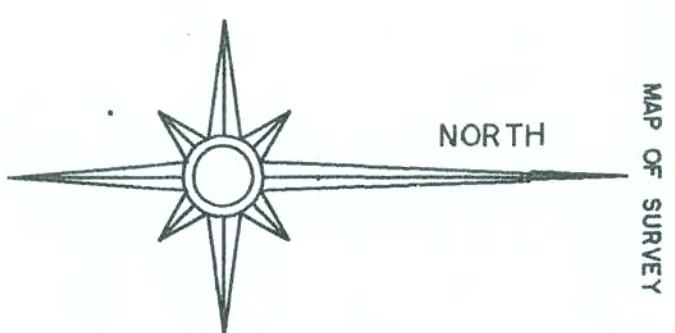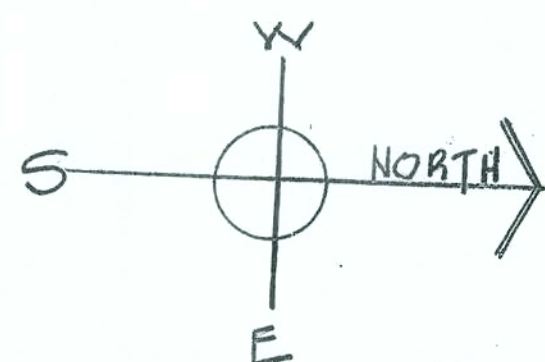

MERIDIAN PER PLAT BEARING ON
BAY AVENUE (S.W. BAY PLACE)
S 87°37' 11"E

	LEGEND	
T & M	TERMINAL SYMBOLARY	
I.D.#	IDENTIFICATION NUMBER	
F	FOUND	
S	SET	
I.P.	IRON PIPE	
C.M.	CONCRETE MOUNTMENT	
C.I.P.	CAP & IRON PIPE	
N & D	NAIL & DISK	
P.R.M.	P.R. MAIL	
D.T.	DEET DIMENSION	
(P)	PLAT DIMENSION	
(F)	FIELD DIMENSION	
C.C.	CALCULATED DIMENSION	
CH	CHAIN LINK	
CONC.	CONCRETE	
W	WAY	
OVERHEAD WIRE (POWER)		
FINCE		

NO UNDERGROUND FOUNDATIONS AND/OR UNDERGROUND UTILITIES HAVE BEEN LOCATED.

DECLARATION IS MADE SOLELY TO THOSE THAT THIS SURVEY IS CERTIFIED TO AND IS NOT TRANSFERABLE TO ADDITIONAL INSTITUTIONS OR SUBSEQUENT OWNERS.

FHA (Flood Hazard Area)

* This is to certify that I have consulted the Federal Insurance Administration Flood Hazard boundary map, Community No. 120070, Panel No. 011A, effective date 01-20-78, and estimate that the above described property is in Zone X. This Zone is not located in a special flood hazard area to the best of my knowledge and belief*.

CERTIFIED TO:
Ronald R. Olczak
Marcid Olczak
First American Title Insurance Company

BOUNDARY SURVEY 11-14-05

CLIENT:
Ronald R. Olszak
Marcia Olszak

SCALE: 1" = .20'

DRAWN BY: SD	DATE: 11-15-05
CHECKED BY: KAG	DATE: 11-15-05

KRIS ANN GATH
LAND SURVEYING & MAPPING, INC.
Professional Land Surveying and Mapping Services
2341 N.W. 41st STREET, SUITE C
GAINESVILLE, FLORIDA 32606
Fid. Certification No. LB 8578
(352) 336-3363


SURVEYOR 3 CERTIFICATE:
 I HEREBY CERTIFY THAT THE SURVEY OF THE AERON DITCH
 AND PROPERTY WAS MADE UNDER MY DIRECTION AND SUPERVISION AND
 THAT THE SURVEY MEETS OR EXCEEDS THE MINIMUM TECHNICAL STANDARDS
 SET FORTH IN CHAPTER 412.07, F.L.A. ADMINISTRATIVE CODE PURSUANT TO
 SECTION 412.07(2)(C) FLORIDA STATUTES.

[Signature]
 KRIS ANN GATH
 PROFESSIONAL SURVEYOR AND MAPPER
 P.L. CERTIFICATION NO. 5359

11-16-

"NOT VALID WITHOUT THE SIGNATURE AND THE ORIGINAL, RAISED
 SEAL OF A FLORIDA LICENSED SURVEYOR AND MAPPER."

New Site Plan

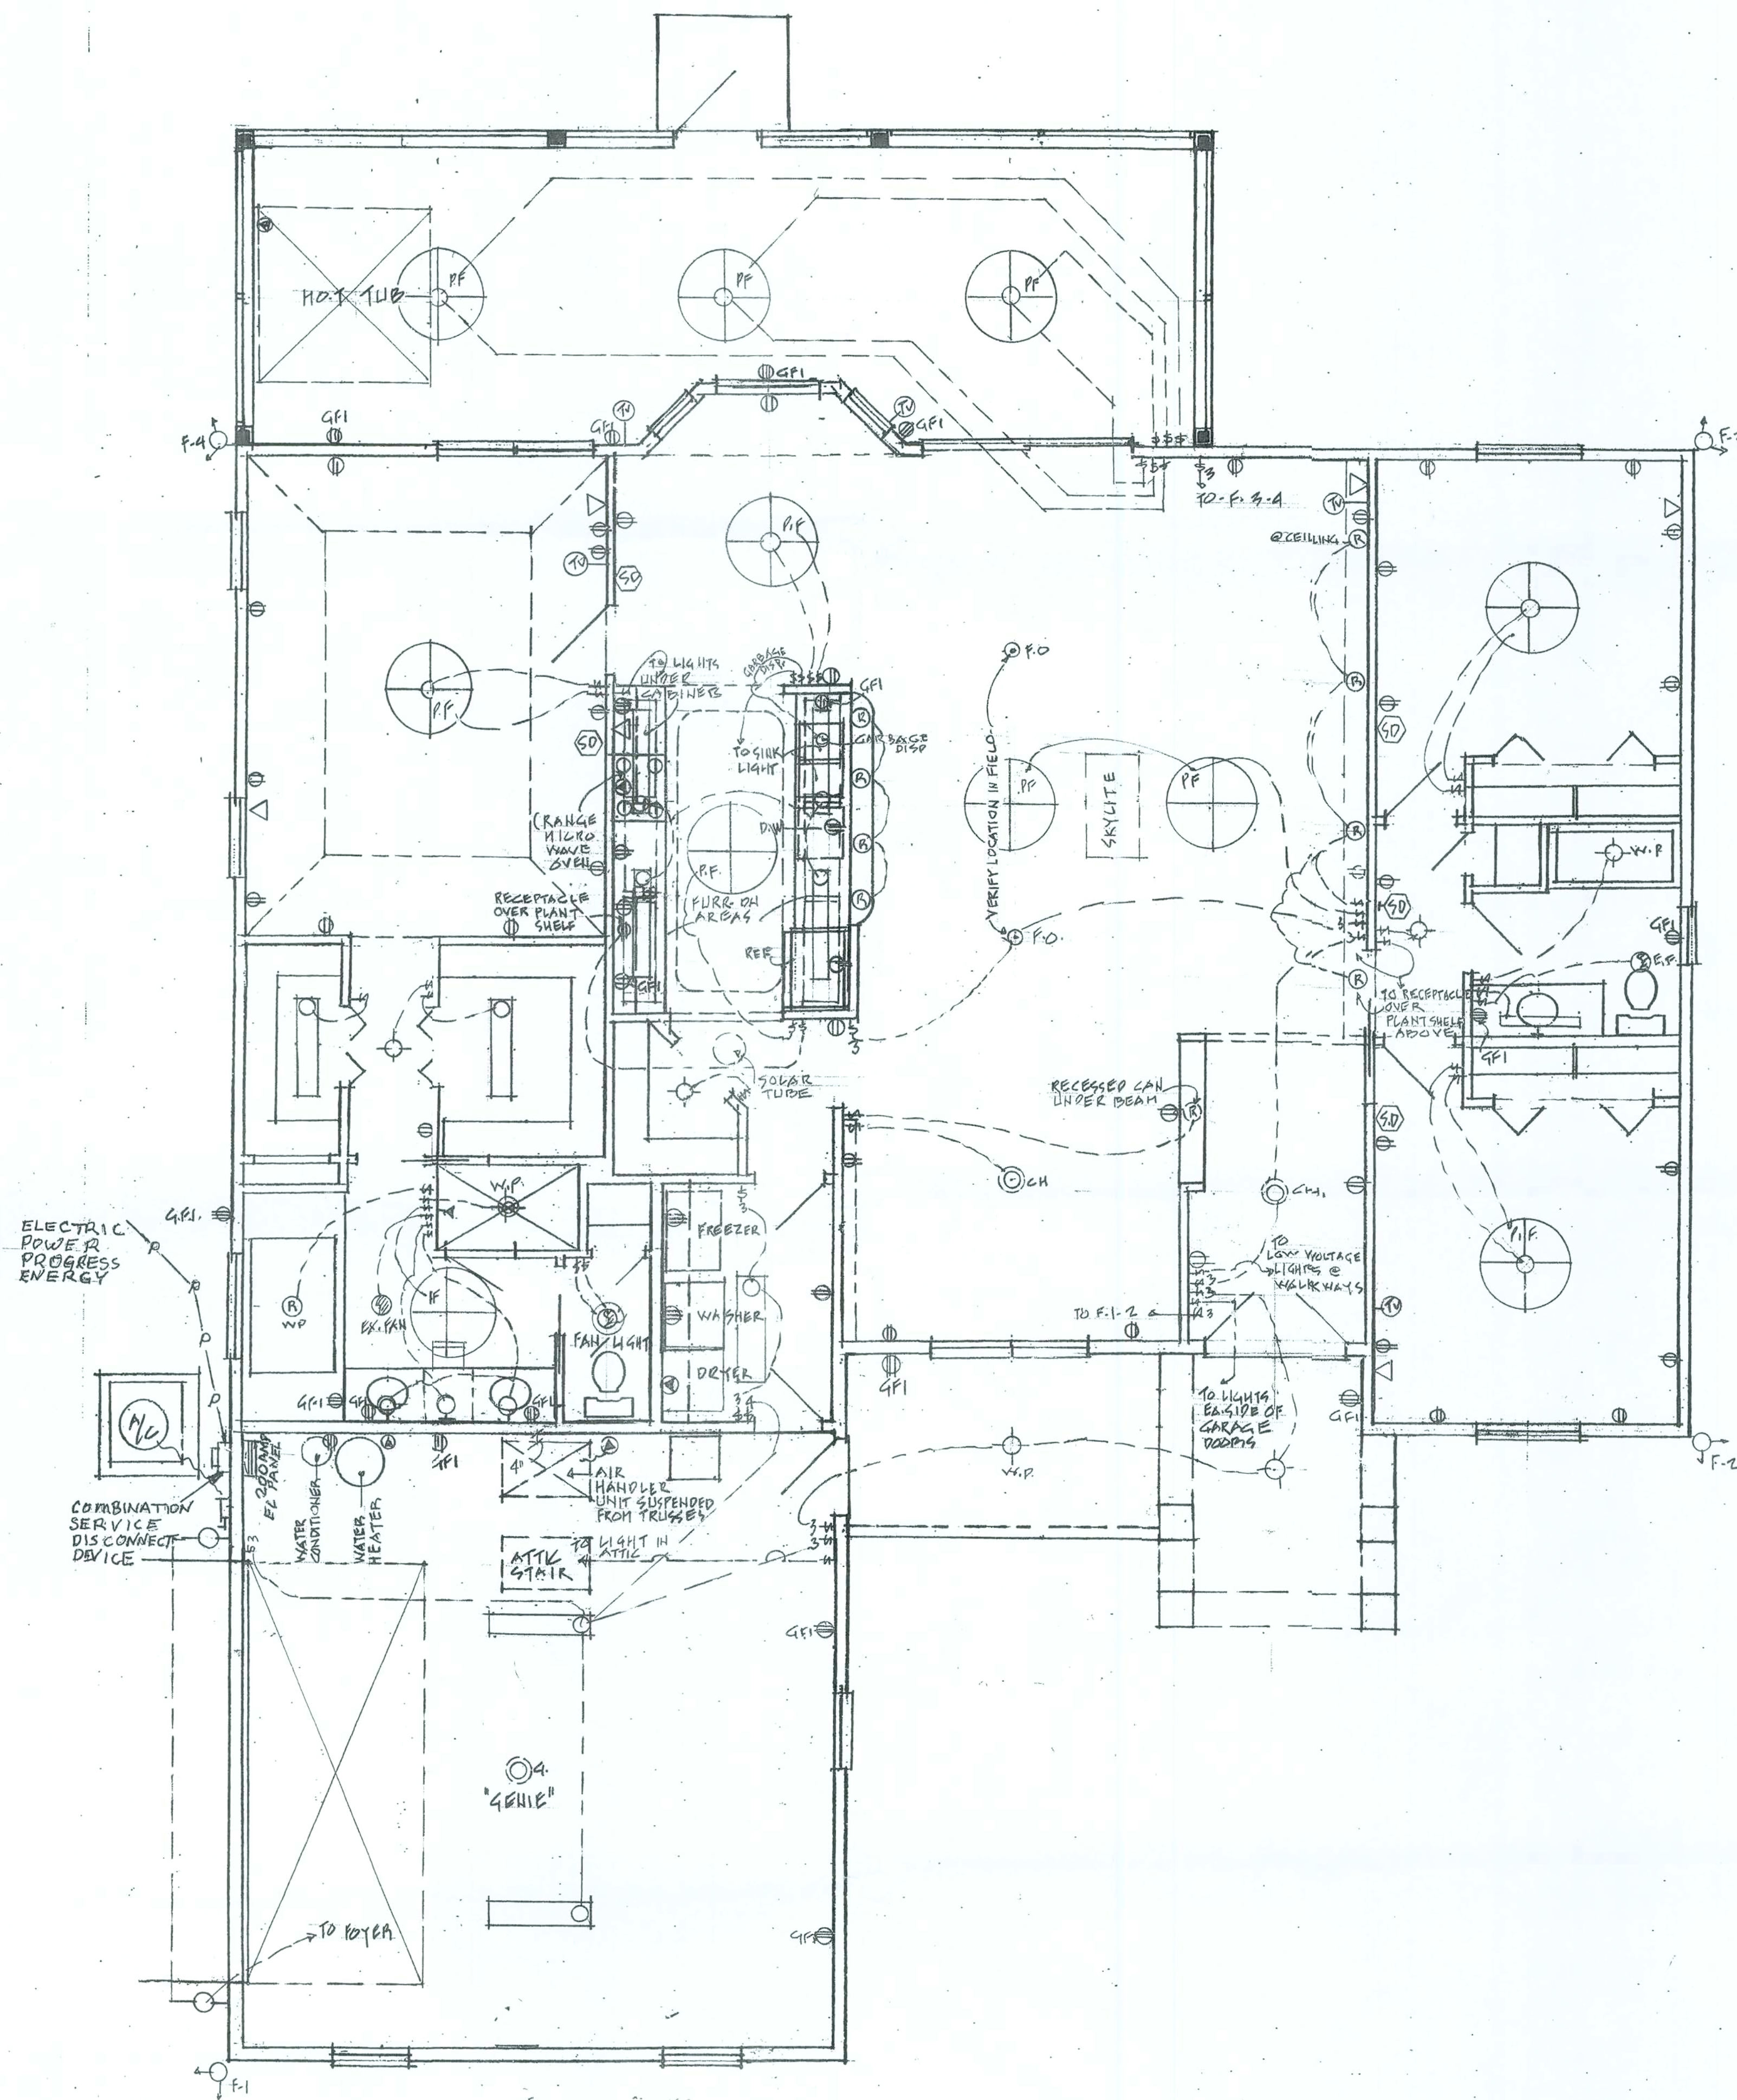


ELECTRICAL PLAN

ELECTRICAL LEGEND

- ⊕ DUPLEX RECEPTACLE @ 16" A.P.F.
- ⊕ GFI RECEPTACLE @ 42" A.P.F.
- ⊕ WATERPROOF G.F.I. RECEPTACLE
- ⊕ 220 VOLT RECEPTACLE
- ⊕ TELEPHONE JACK
- ⊕ TELEVISION OUTLET
- ⊕ EXHAUST FAN
- ⊕ EXHAUST FAN W/ LIGHT
- ⊕ CEILING MOUNTED LIGHT FIXTURE
- ⊕ RECESSED LIGHT FIXTURE
- ⊕ PADDLE FAN
- ⊕ PADDLE FAN WITH LIGHT
- ⊕ SMOKE DETECTOR
- ⊕ FLUORESCENT LIGHT FIXTURE
- ⊕ FLOOD LIGHT
- ⊕ WALL MOUNTED LIGHT
- ⊕ TOGGLE SWITCH
- ⊕ TOGGLE SWITCH - 3 WAY
- ⊕ FLOOR RECEPTACLE
- ⊕ SPA MOTOR
- ⊕ GARAGE DOOR OPENER
- ⊕ CHANDELIER
- ⊕ ELECTRIC PANEL

PROVIDE ARC FAULT CIRCUITS IN ALL BEDROOMS (AFCI)

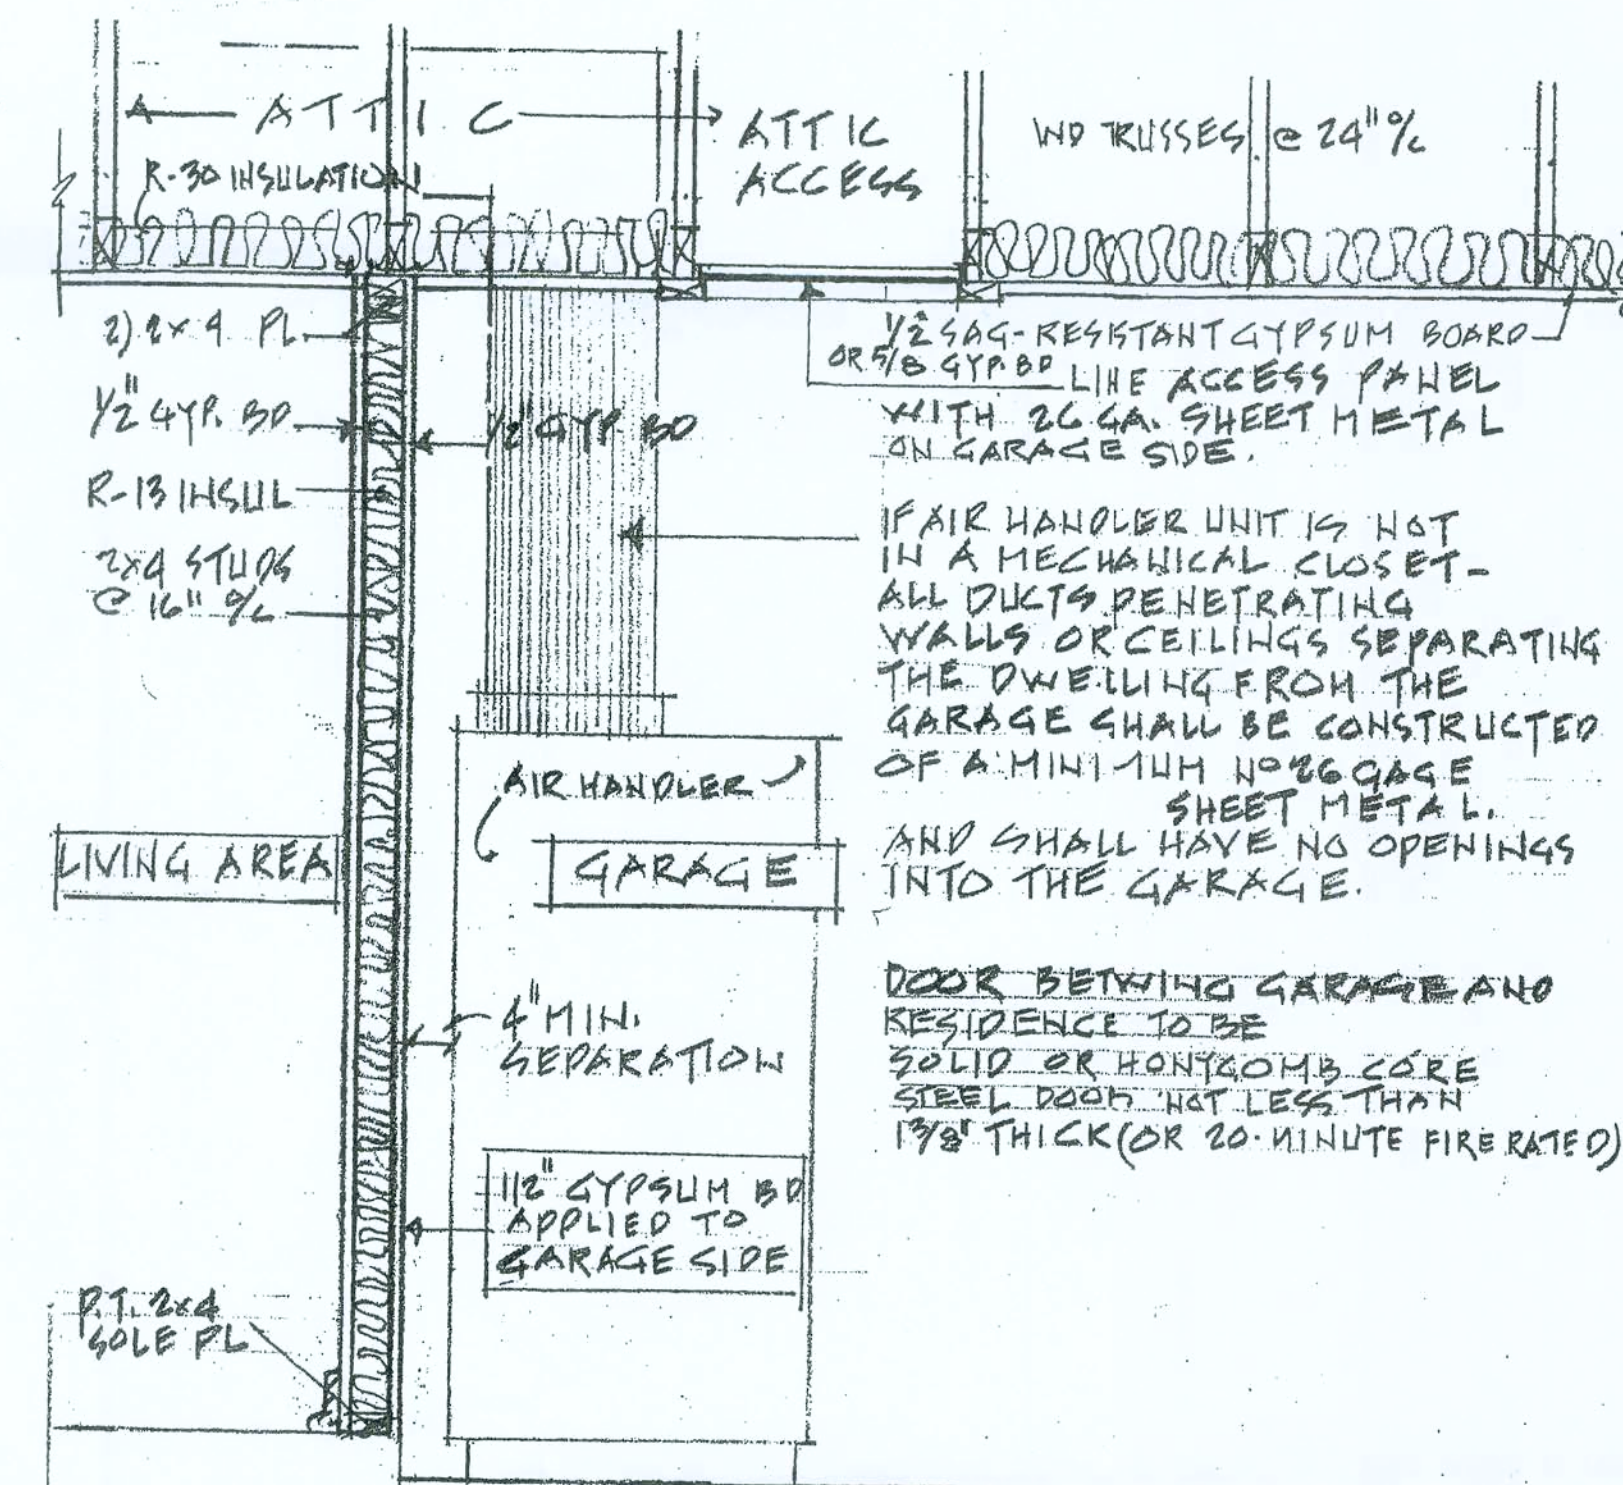

1. OPENING PROTECTION / DUCT PENETRATION
2. SEPARATION REQUIREMENTS BETWEEN GARAGE AND RESIDENCE AND ITS ATTIC AREA

DETAILS - SCALE: 3/4" = 1'-0"