


CONDENSER UNIT
RUUD, RHEEM MFRG
MODEL # 13PUL 240A01
208/230V, 60HZ,
HP 1/10

NEW PANEL EP-2
AHU #3, 60A BRKR
CIRCUITS 2, 4

6"X10" DIFFUSER WITH 6" DIA NECK AND
OPPOSED BLADE DAMPER, WHITE FINISH
4 REQUIRED

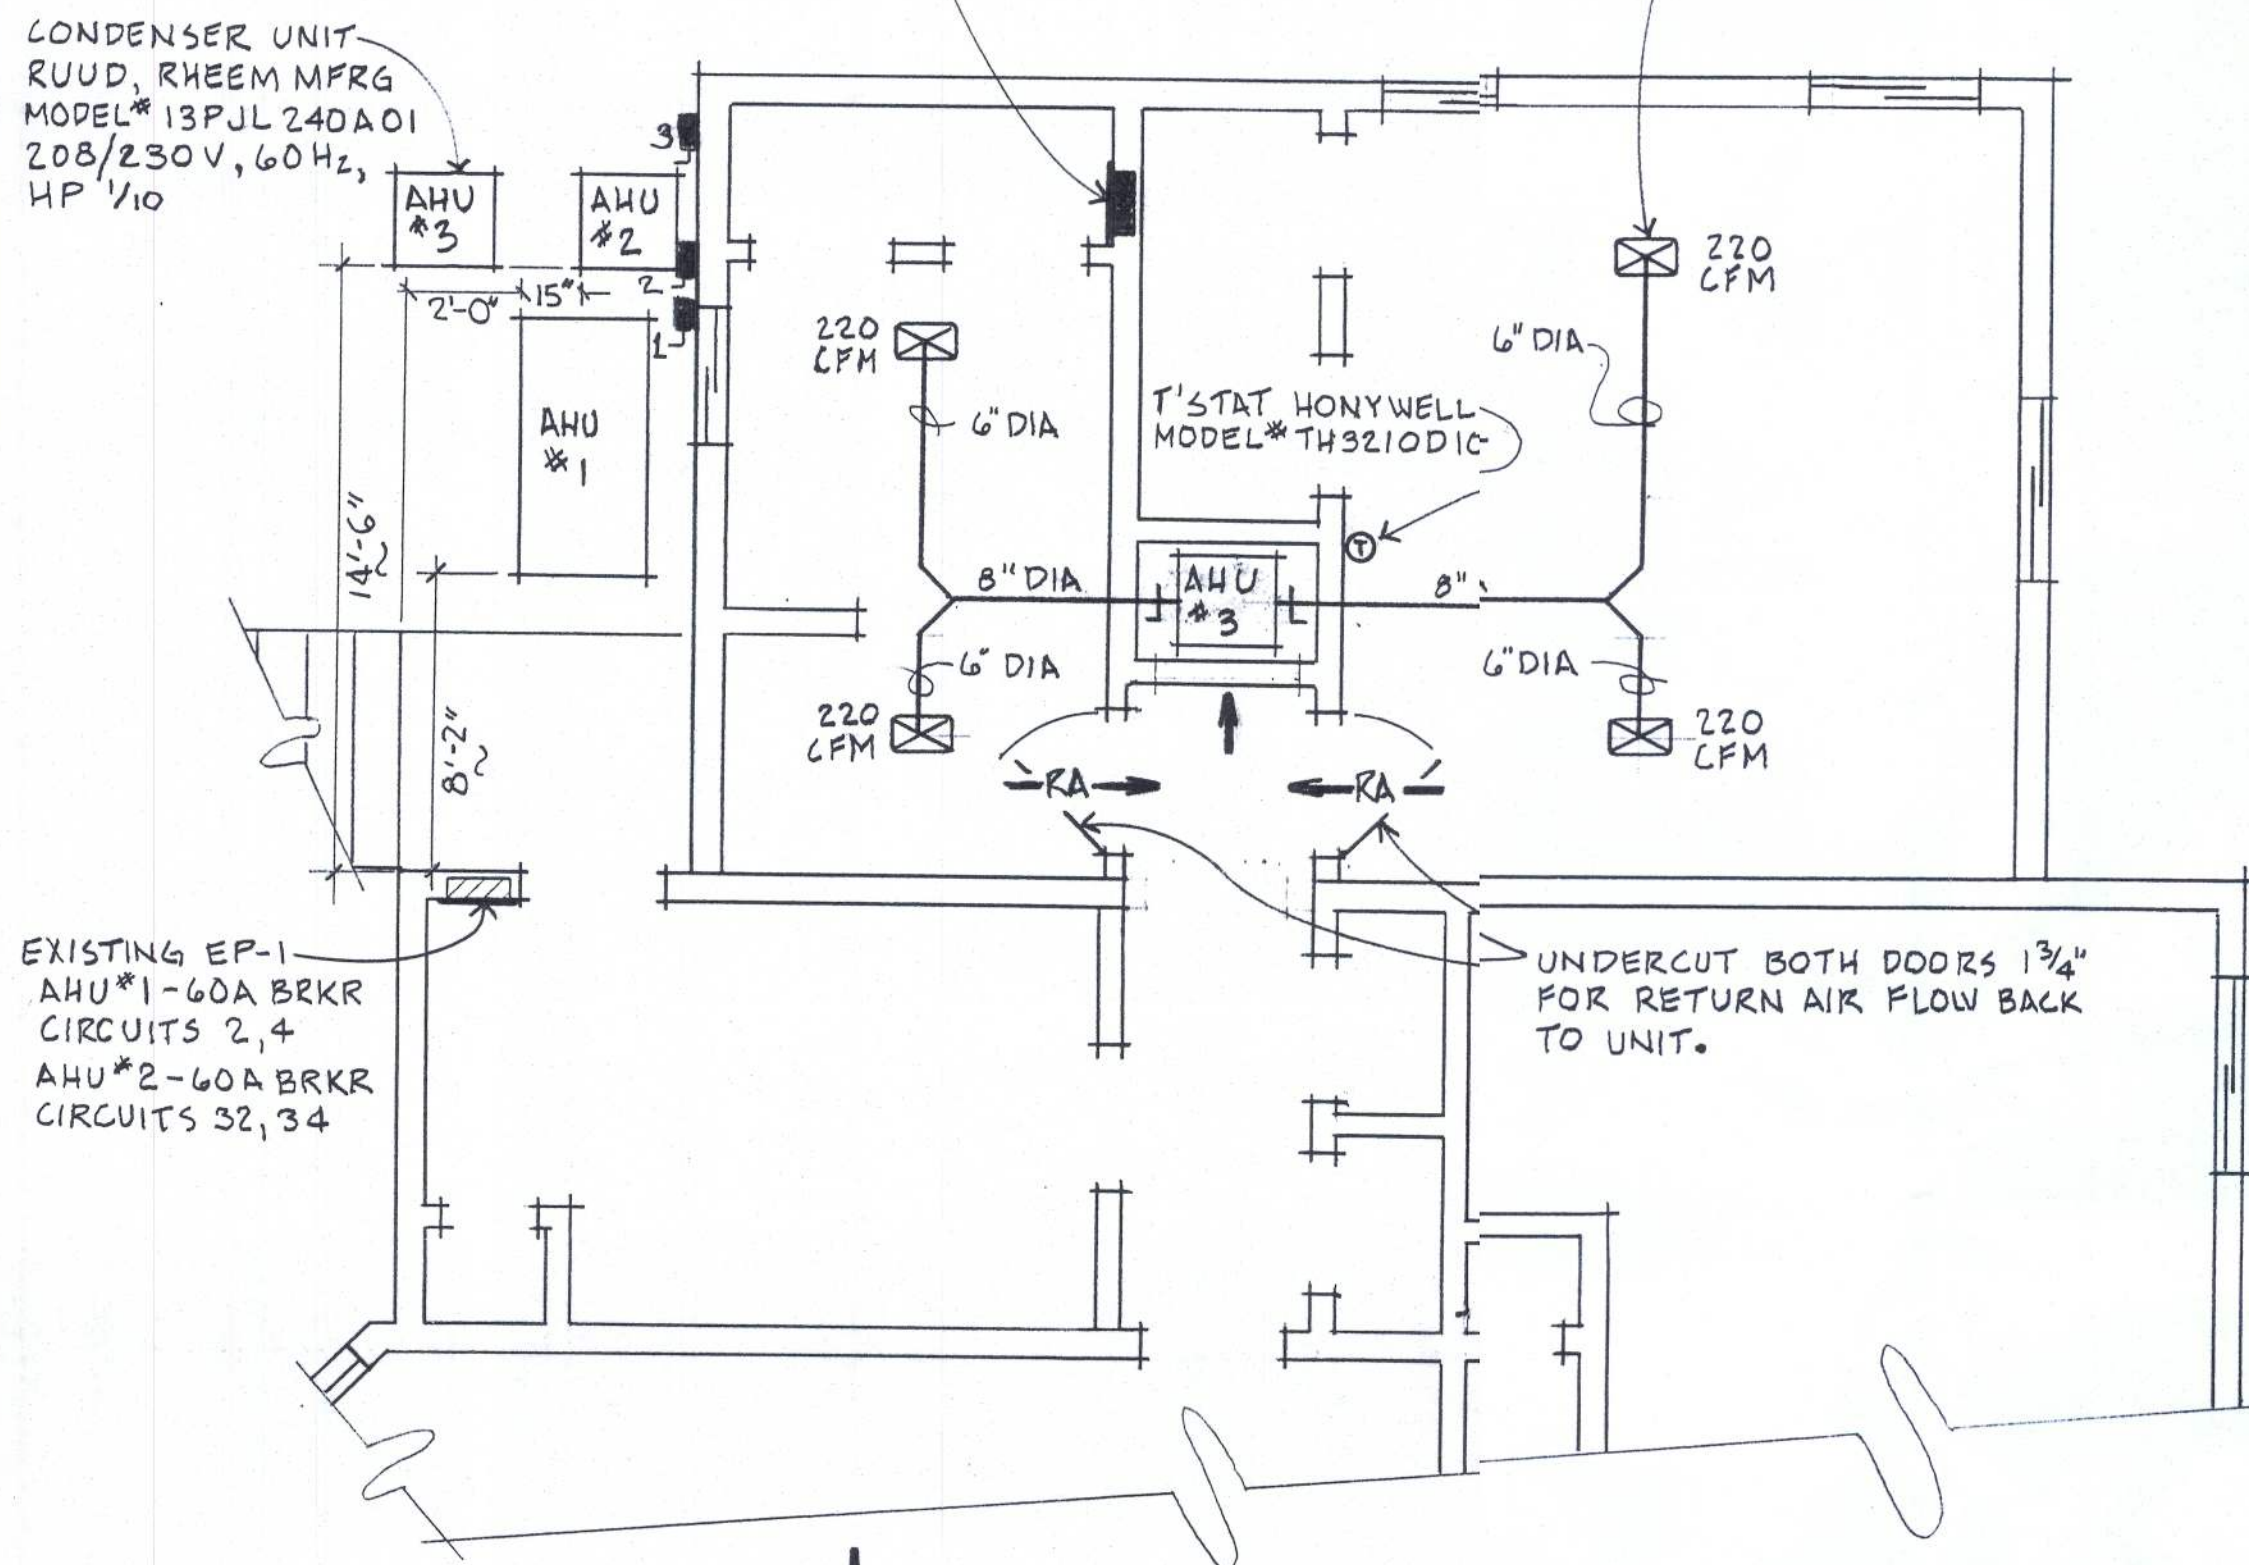

EXISTING EP-1
AHU #1 - 60A BRKR
CIRCUITS 2, 4
AHU #2 - 60A BRKR
CIRCUITS 32, 34

PROVIDE TEMPORARY
STANCHION, UNISTRUT
AND PLYWOOD, FOR
DISCONNECTS

FLOOR PLAN

SCALE = 1/4" = 1'-0"


CONNECT 2- DIA DUCTS
TO EXISTING PPLY AND
RETURN DUC

PARTIAL PLAN

SCALE = 1/4" = 1'-0"

NOTES:

1. ONE ADDITIONAL THERMOSTAT TO REPLACE EXISTING THERMOSTAT FOR AHU #1. THE THERMOSTAT IS LOCATED ON WEST WALL (LEFT) OF CHIMNEY/FIREPLACE.
2. "~" INDICATES DIMENSION NOT DRAWN TO SCALE.

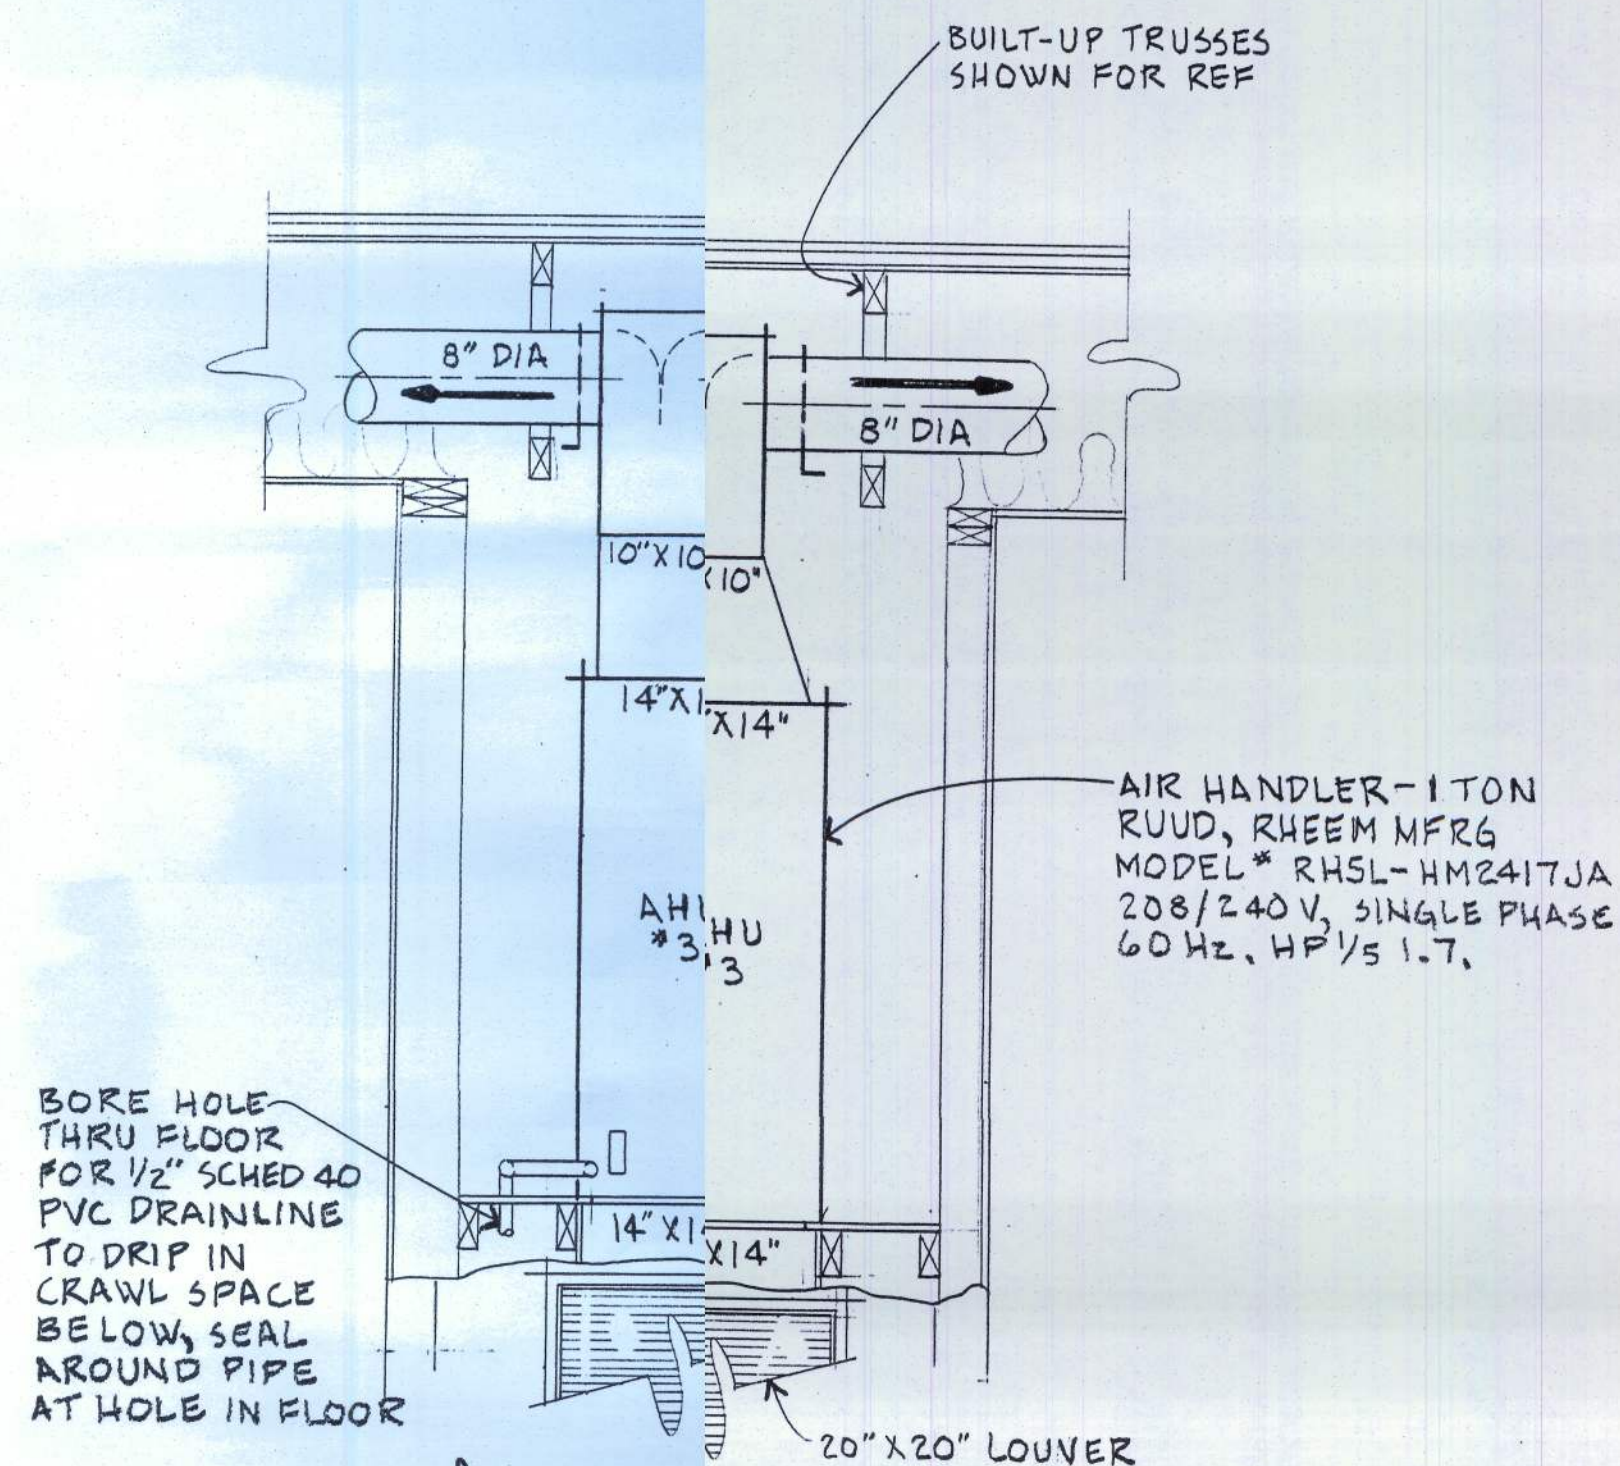

DETAIL

SCALE = 3/4" = 1'-0"

PROJECT: SPENCE RESIDENCE		
B+B ADDITION, 190 SW LONGCALA LOOP		
SHEET TITLE: HVAC PLAN		
DRAWN BY: GD SPENCE	DATE: 4 20 2014	SHEET NO. M-1 10