



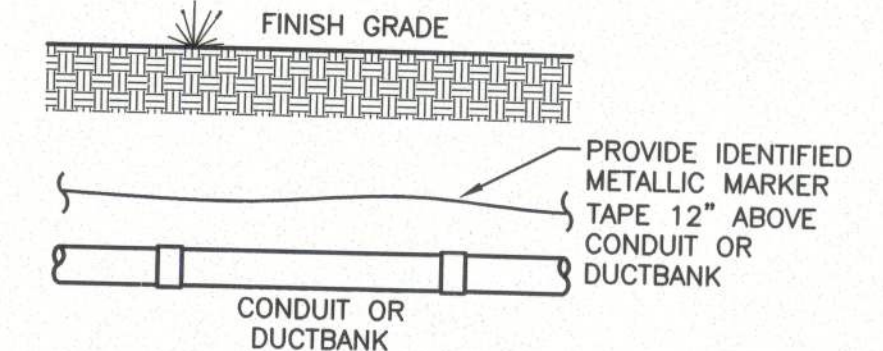

BURIED CONDUIT MARKER DETAIL
NOT TO SCALE


SHEET NOTES

- FUEL PUMP ELECTRICAL:
 - COMPLY WITH N.E.C. ARTICLE 514 NFPA 30 AND ALL APPLICABLE NATIONAL, STATE AND LOCAL CODES/REGULATIONS.
 - PROVIDE 1" RIGID THREADED ALUMINUM CONDUIT AT FUEL PUMPS.
 - UNDERGROUND RACEWAY BELOW PUMPS SHALL BE A MINIMUM OF 30" BELOW GRADE AND SHALL BE THREADED RGS ON ALL VERTICAL RUNS UP THRU GRADE.
 - PROVIDE SEPARATE GROUND WIRE FOR EACH CIRCUIT.
 - PROVIDE CONDUIT SEALS (EXPLOSION PROOF) ON ALL RACEWAY LEAVING FUEL DISPENSING ISLAND. COMPLY WITH N.E.C. ARTICLES 501-5 AND 502-5.

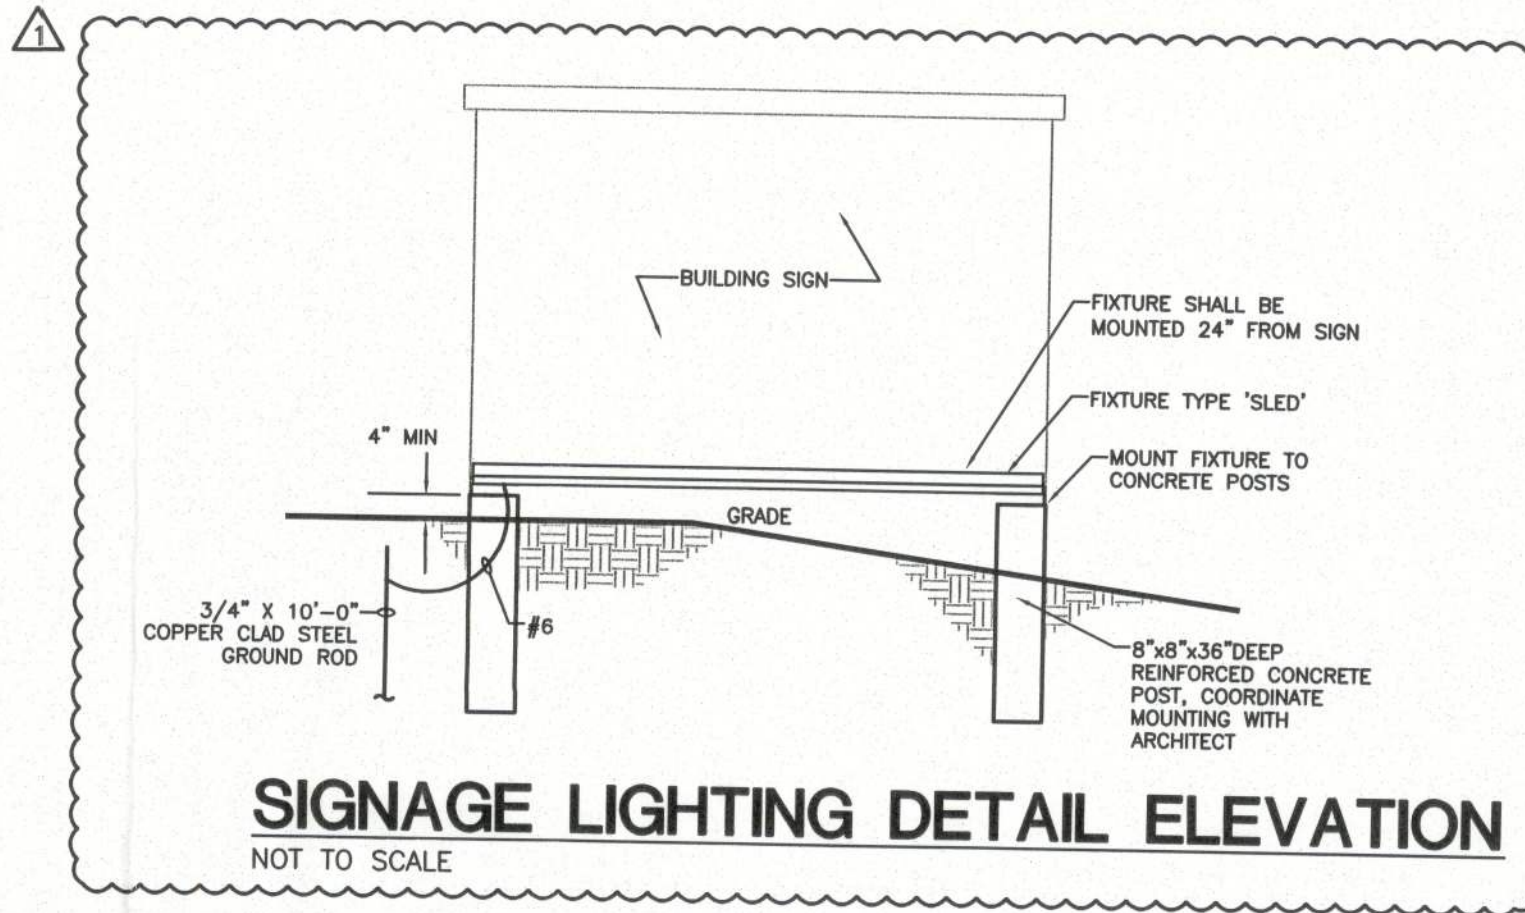

ELECTRICAL SITE PLAN

SCALE: 1" = 30'

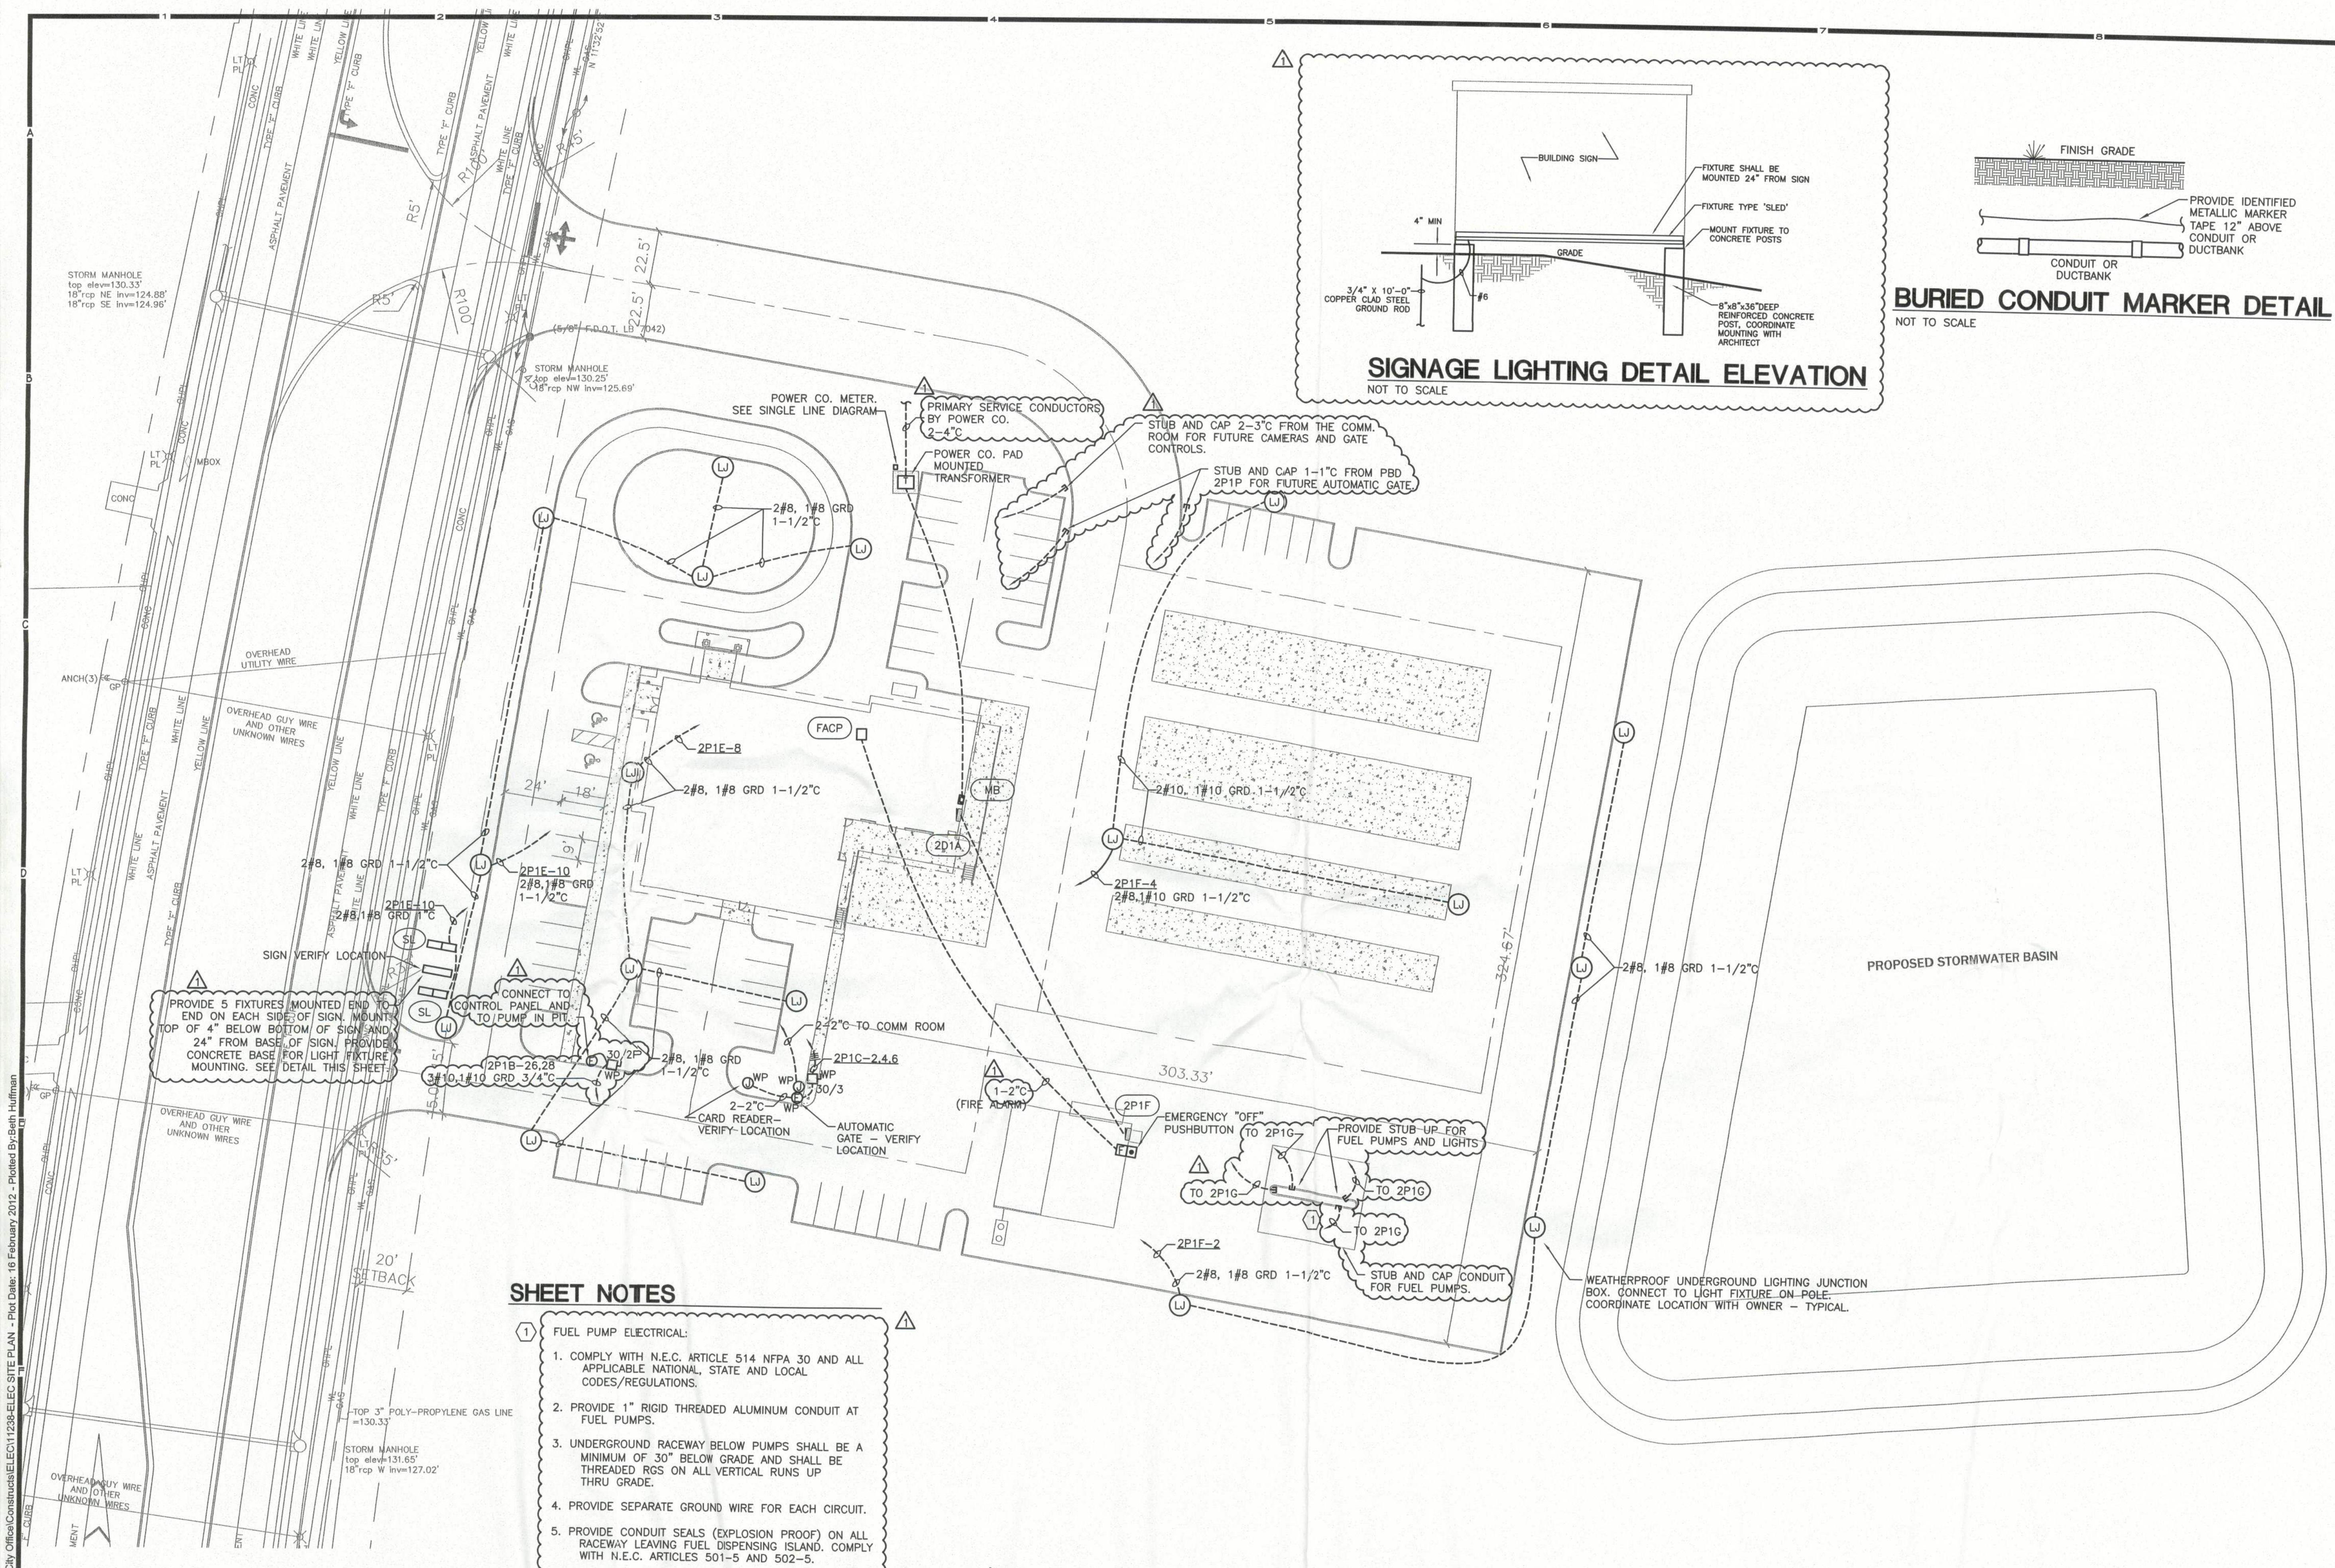

File name: N11238-Clay Electric Lake City Office\Constructors\ELEC011238-ELEC SITE PLAN - Plot Date: 16 February 2012 - Plotted By: Beth Huffman