


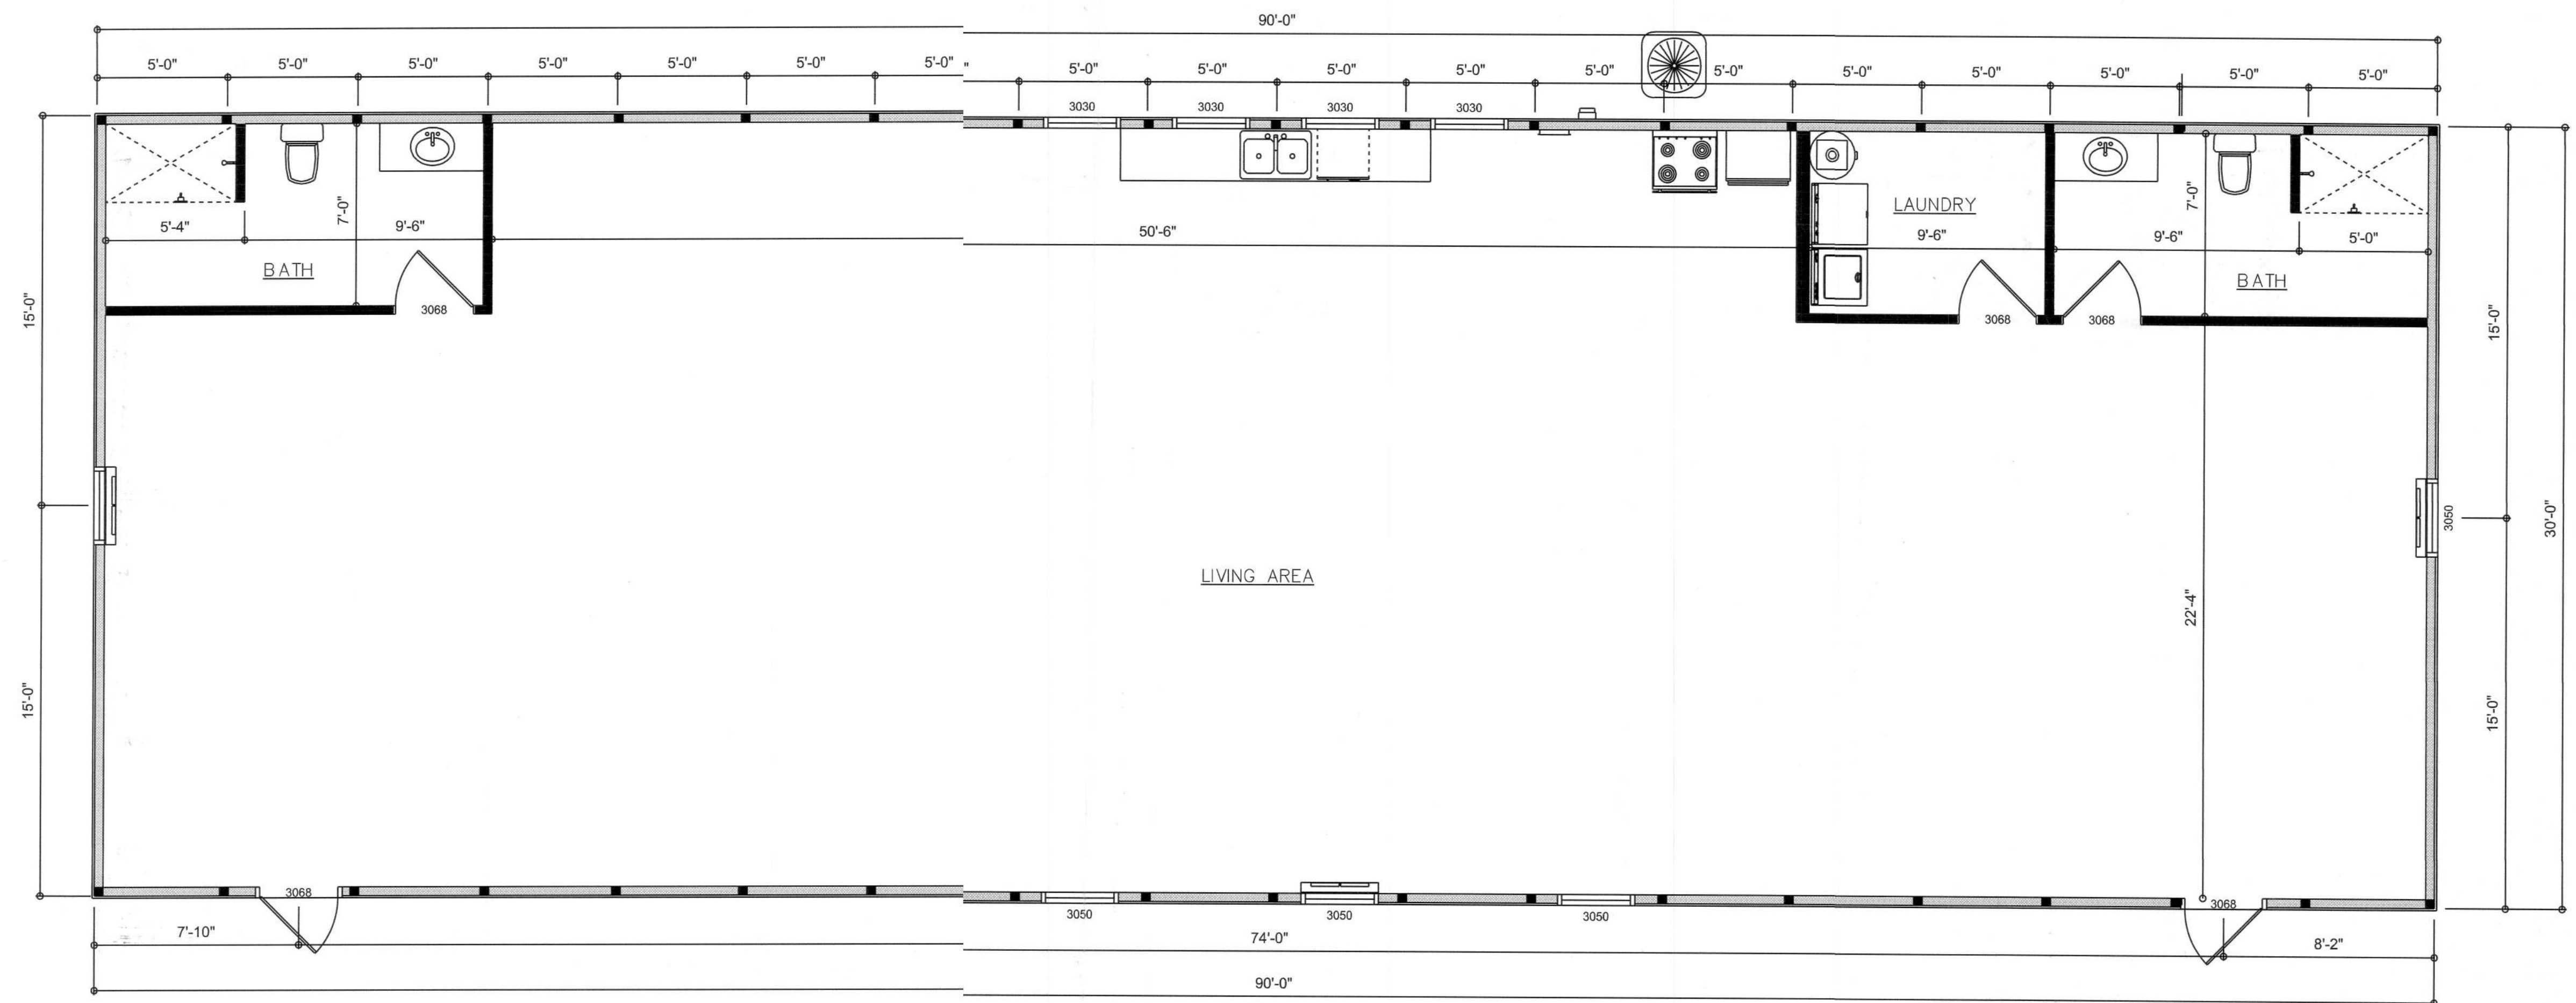


DIMENSIONED FLOOR PLAN

SCALE: 1/4" = 1'-0"

AREA SUMMARY

UNDER ROOF AREA	2,700	S.F.
TOTAL UNDER ROOF	2,700	S.F.

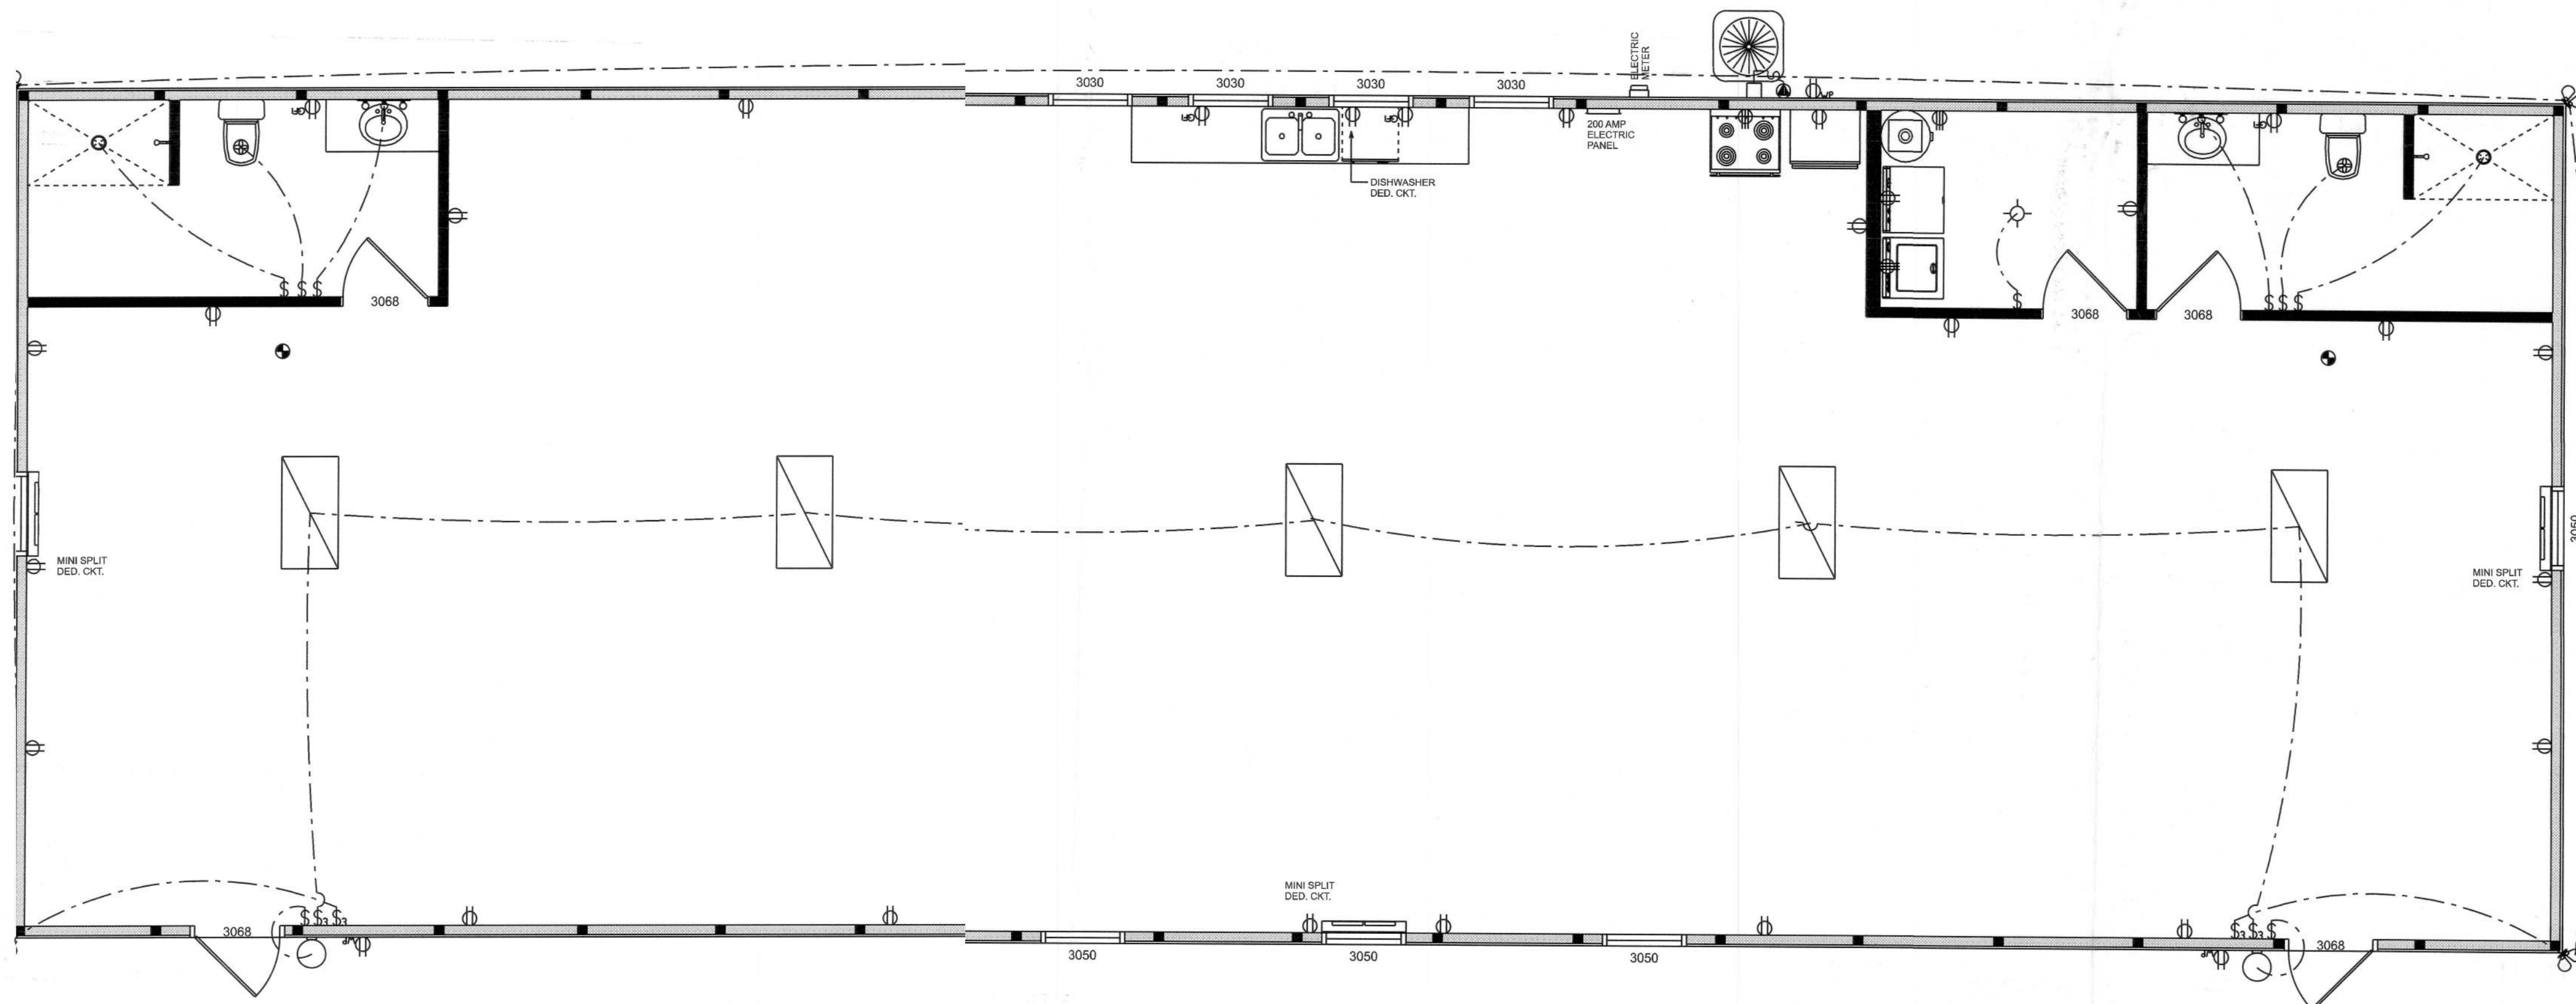

ELECTRICAL FLOOR PLAN

SCALE: 1/4" = 1'-0"

ELECTRICAL LEGEND

ELECTRICAL	COUNT	SYMBOL
FLUORESCENT LIGHT 2x4	5	
MOTION SECURITY LIGHT	4	
OUTLET	23	
SWITCH 3 WAY	4	
ELECTRIC PANEL	2	
OUTLET 220v	3	
OUTLET GFI	4	
CAN LIGHT 6inch	2	
EXTERIOR SCONCE	2	
AC DISCONNECT	1	
EXHAUST FAN	2	
OUTLET WP	3	
SMOKE DETECTOR	2	
STANDARD LIGHT	1	
SWITCH	9	
VANITY BAR LIGHT - SMALL	2	

ELECTRICAL PLAN NOTES:

INSTALLATION SHALL BE PER LATEST NAT'L ELECTRIC CODE.

WIRE ALL APPLIANCES, HVAC UNITS AND OTHER EQUIPMENT PER MANUF. SPECIFICATIONS

CONSULT WITH THE OWNER FOR THE NUMBER OF SEPARATE TELEPHONE LINES TO BE INSTALLED

ALL SMOKE DETECTORS SHALL BE 120V W/ BATTERY BACKUP OF THE PHOTOELECTRIC TYPE, AND SHALL BE INTERLOCKED TOGETHER. INSTALL INSIDE AND NEAR ALL BEDROOMS

TELEPHONE, TELEVISION AND OTHER LOW VOLTAGE DEVICES OR OUTLETS SHALL BE AS PER THE OWNER'S DIRECTIONS, & IN ACCORDANCE W/ APPLICABLE SECTIONS OF NEC-LATEST EDITION

ALL RECEPTALS, NOT OTHERWISE NOTED, SHALL BE ARC FAULT INTERRUPTER TYPE, EXCEPT DEDICATED OUTLETS

ALL RECEPTALS IN WET AREAS SHALL BE GROUND FAULT INTERRUPTER TYPE (GFI)

ALL EXTERIOR RECEPTALS SHALL BE WEATHERPROOF GROUND FAULT INTERRUPTER TYPE (WP/GFI)

NOTE:
ELECTRICAL CONTR SHALL PREPARE 'AS-BUILT' SHOP DWGS INDICATING ALL ELECTRICAL WORK, INCLUDING ANY CHANGES TO THE ELEC. PLAN, ADDS TO THE ELEC. PLAN, RISER DIAGRAM, AS-BUILT PANEL SCHEDULE W/ ALL CKTS IDENTIFIED W/ CKT N° DESCRIPTION & BRKR, SERVICE ENT, & ALL UNDERGROUND WIRE LOCATIONS/ROUTINGS / DEPTH, RISER DIA, SHALL INCLUDE WIRE SIZES/TYPE & EQUIPMENT TYPE W/ RATINGS & LOADS.
CONTRACTOR SHALL PROVIDE 1 COPY OF AS-BUILT DWGS TO OWNER & 1 COPY TO THE PERMIT ISSUING AUTHORITY

REVISIONS SCHEDULE

Aug. 17th, 2021	PROPOSAL
April 18th, 2022	INT. BUILDOUT

COLLAR RESIDENCE


A CUSTOM INTERIOR BUILD OUT FOR

359 SE Stewart Way, High Springs, FL 32643

RIDGEPOINT DESIGN

566 SW ARLINGTON BLVD, STE 101, LAKE CITY, FL 32025

P: 386-288-1188 E: RIDGEPOINTDESIGN@GMAIL.COM

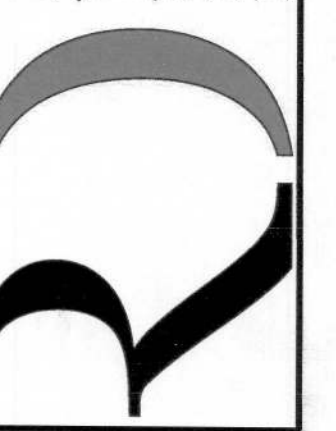

SHEET NUMBER

A.2

OF 3 SHEETS