

# BRUNO

## RESIDENCE PLANS

### COLUMBIA COUNTY, FL

#### Plan Sheet Index:

| Sheet No. | Description                                   |
|-----------|-----------------------------------------------|
| 1         | title/index sheet                             |
| 2         | floor plan                                    |
| 3         | front and right elevations                    |
| 4         | rear and left elevations                      |
| 5         | wall typical & strapping/nailing requirements |
| 6         | special details                               |
| 7         | special details                               |
| 8         | roof plan                                     |
| 9         | foundation plan                               |
| 10        | electrical plan                               |


*Marty J. L.*  
6-1-21

B

PLANS PREPARED BY:  
MARTY J. HUMPHRIES P.E. # 51976  
7932 240TH ST., O'BRIEN, FL 32071

BRUNO RESIDENCE PLANS  
COLUMBIA COUNTY, FLORIDA

SHEET  
—  
OF  
10

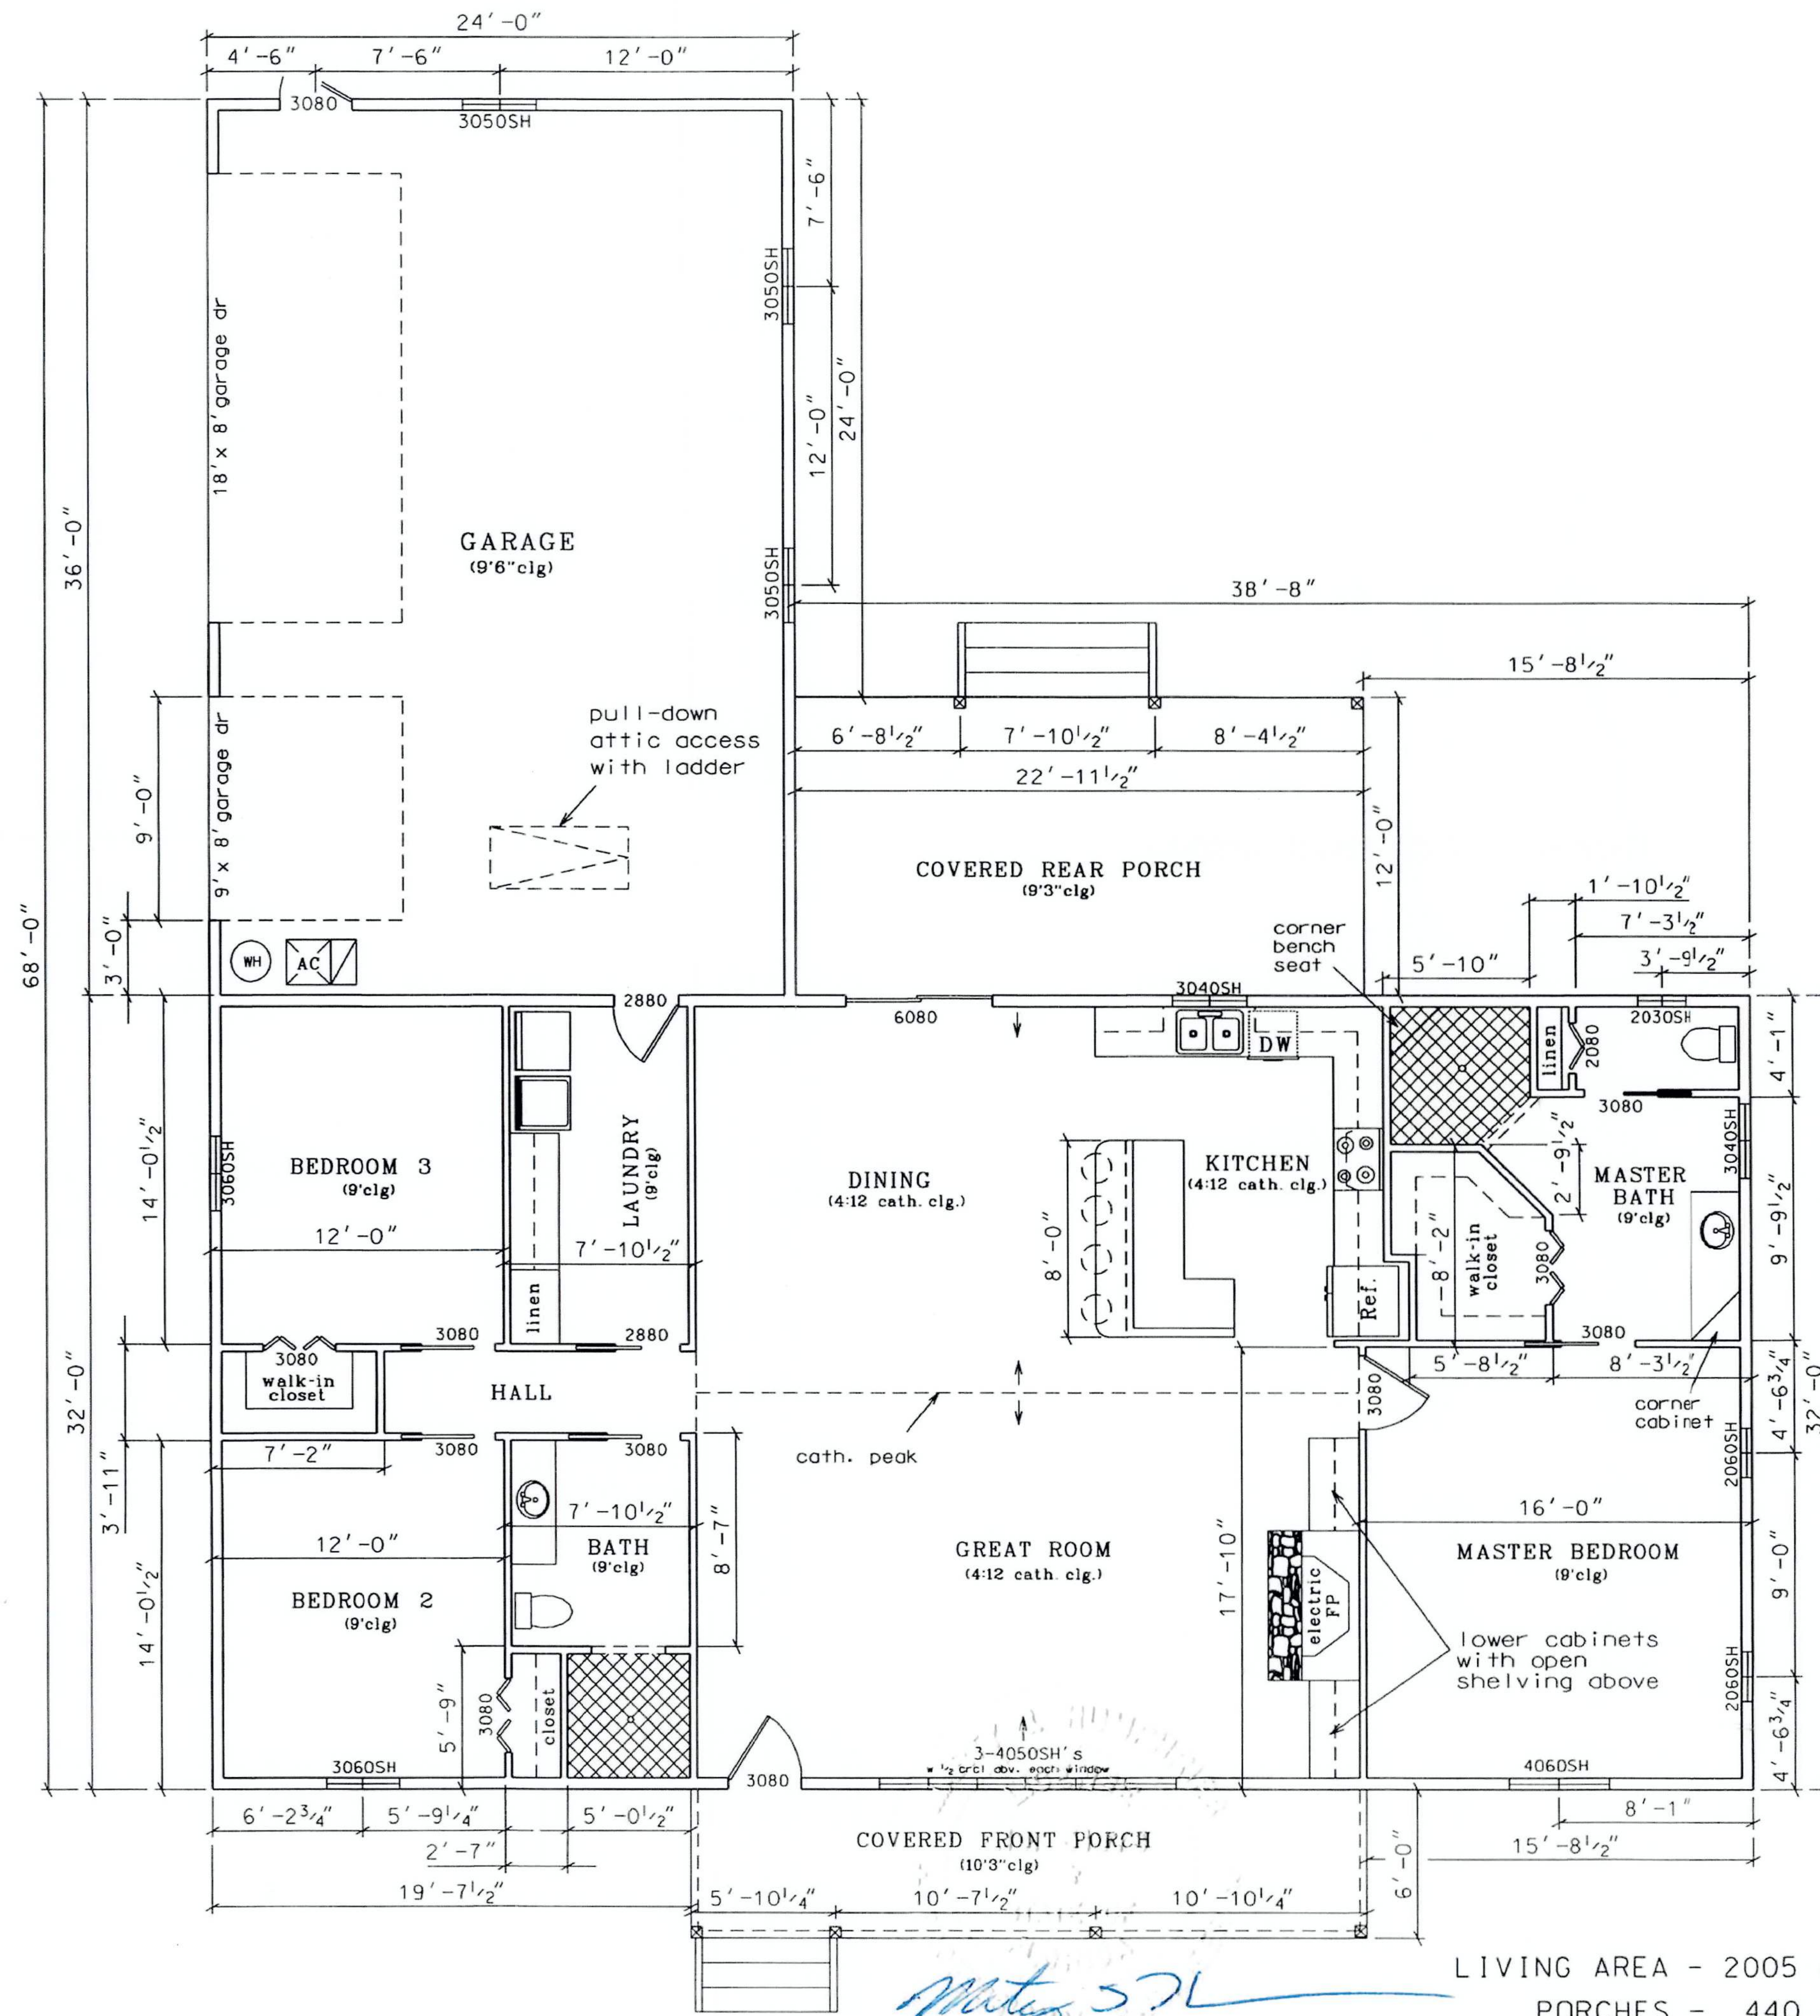

*Marty 57L*  
6-1-21

LIVING AREA - 2005 sq. ft.  
PORCHES - 440 sq. ft.  
GARAGE - 864 sq. ft.

0 4' 8'  
scale


FLOOR PLAN

B



PLANS PREPARED BY:  
MARTY J. HUMPHRIES P.E. # 51976  
7932 240TH ST., O'BRIEN, FL 32071

BRUNO RESIDENCE PLANS  
COLUMBIA COUNTY, FLORIDA


SHEET  
2  
OF  
10

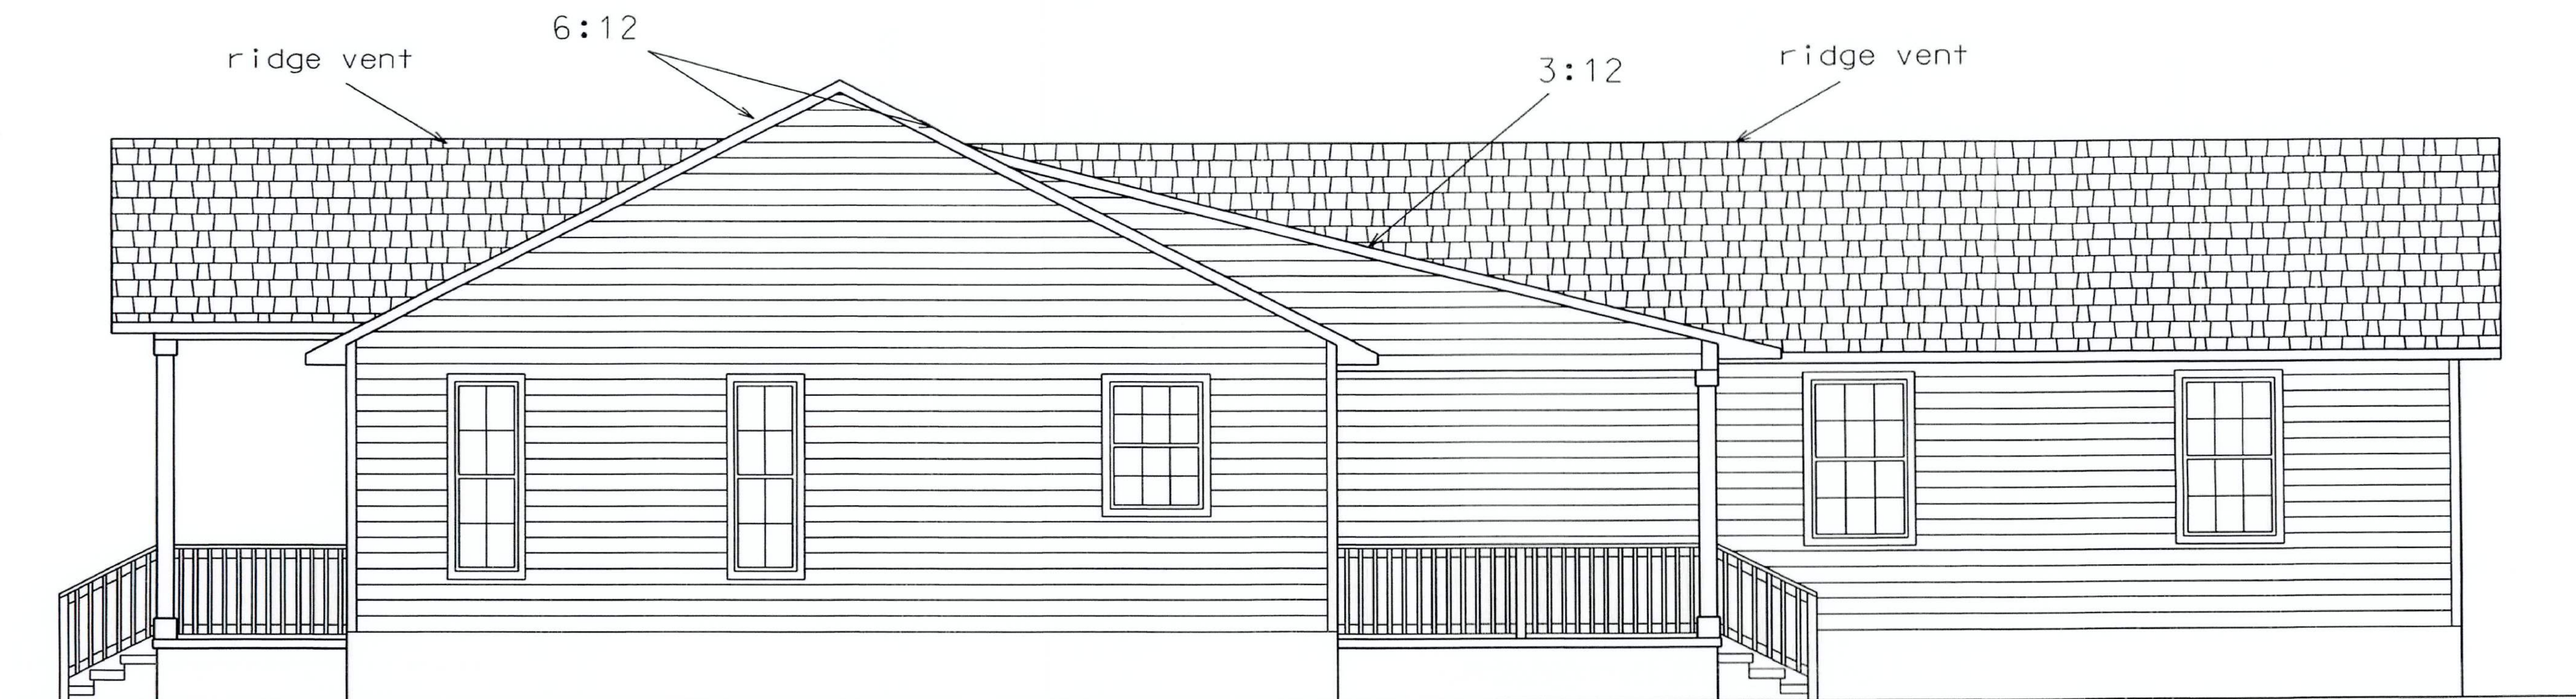

RIGHT ELEVATION

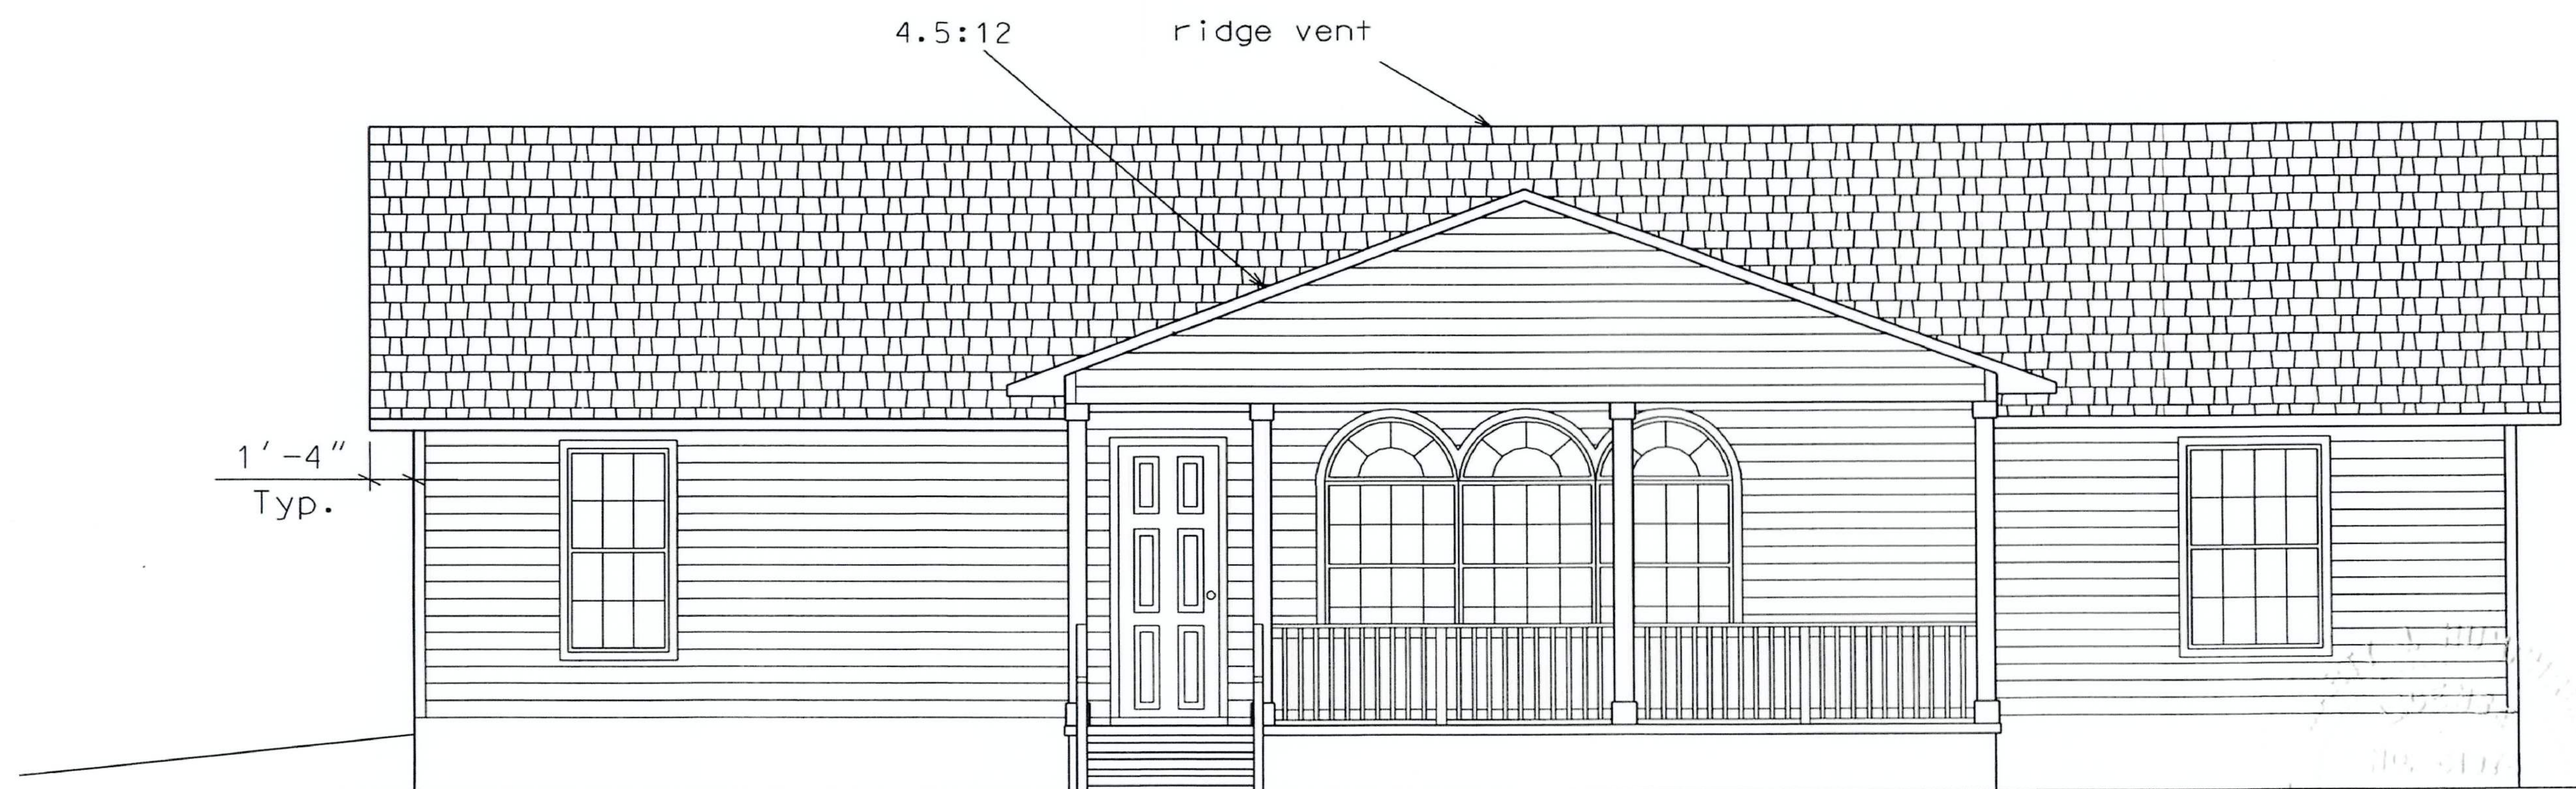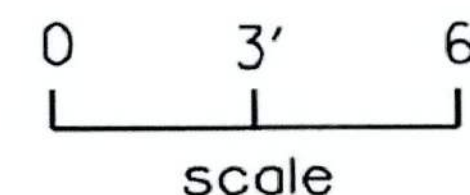

FRONT ELEVATION

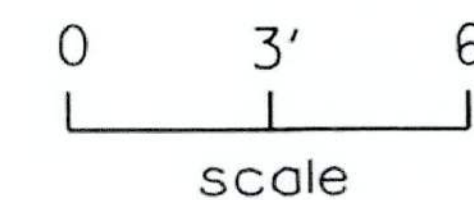


*Marty J. Humphries*  
6-1-21

B


PLANS PREPARED BY:  
MARTY J. HUMPHRIES P.E. # 51976  
7932 240TH ST., O'BRIEN, FL 32071

BRUNO RESIDENCE PLANS  
COLUMBIA COUNTY, FLORIDA


SHEET  
3  
OF  
10

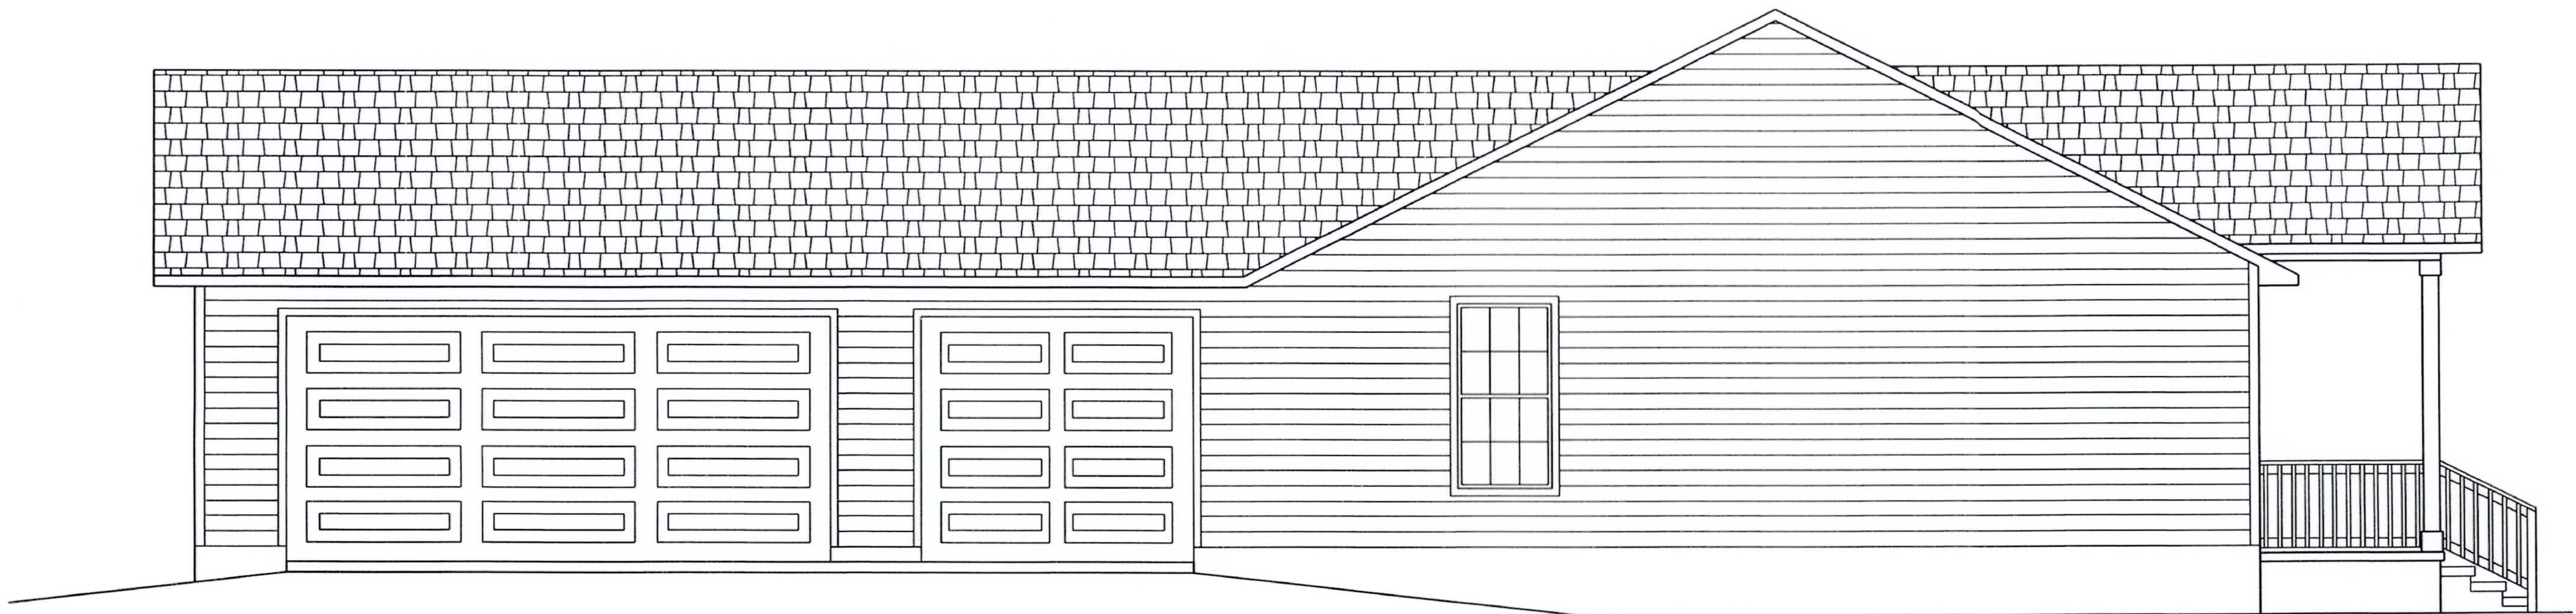

LEFT ELEVATION

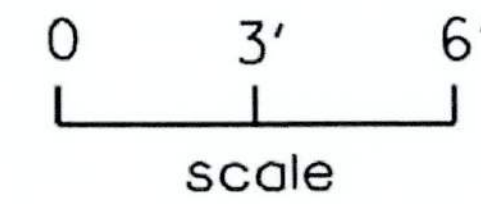

REAR ELEVATION

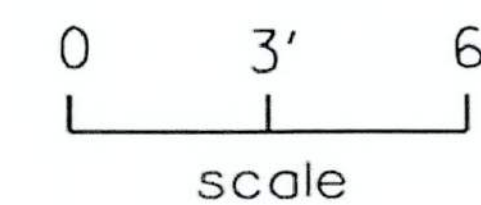

*Marty J. Humphries*  
6-1-21

B

PLANS PREPARED BY:  
MARTY J. HUMPHRIES P.E. # 51976  
7932 240TH ST., O'BRIEN, FL 32071

BRUNO RESIDENCE PLANS  
COLUMBIA COUNTY, FLORIDA

SHEET  
4  
OF  
10

# STRAPPING AND ANCHOR REQUIREMENTS

(Designed In accordance with the 2020 FBC):

## WINDLOAD DATA AND EXPOSURE:

Basic Wind Speed = 120 mph Vult.  
 Importance Factor = 1.0  
 Exposure Category = B  
 Residential Occupancy = Group R3  
 Mean Roof Height = 15'  
 Height and Exposure Adjustment Coefficient = 1.0  
 Roof Cross Slope = 3:12, 4.5:12, 6:12  
 Wall Height = 9' primarily with 10' wall at front and rear porches  
 Risk Category = II  
 Component and Cladding Pressures = Roof(Zone 1=11.6,-22.1, Zone 2=11.6,-35.3, Zone 3=11.6,-41.9), Wall(Zone 4=15.5,-16.9, Zone 5=15.5,-20.8)(units are psf)

## TRUSS ANCHORS:

At Truss to exterior walls and garage/living wall and porch beam locations: install one Simpson Model H10A anchor for all trusses. For valley trusses install Simpson VTCR clips 4' on center.

## WALL STRAPPING:

At the top and bottom of the wall install one SP6 each side of each window or door 4' or less in width and install 2 each side top and bottom of the wall for windows or doors over 4' in width. At triple 4050 front window install 2 SPH6's each side top and bottom of the wall. At 9' garage door install 2 SPH6's each side top and bottom of the wall. At 18' garage door install 3 SPH6's each side top and bottom of the wall. All other locations install 1 SP6 top and bottom of the wall 4' on center. For wall between garage and living area install one SP6 top and bottom of the wall 32" on center and each side of door.

## SHEATHING:

Wall sheathing shall be installed with long dimension vertical on exterior walls and full-depth blocking shall be required at horizontal joints in sheathing.

## PORCH COLUMNS:

At each column Install Simpson model ABU66 and notch top of column to receive header and install 2 galvanized 3/4" carriage bolts.

## PORCH CEILINGS:

Install 1x4 SPF lathes 16" on center nailed to trusses with 2-8d nails or install 7/16" OSB sheathing nailed with 8d nails 6" on center and cover with solid aluminum or vinyl soffit material or hardipanel.


## PORCH HEADER TO HOME CONNECTION:

For Porch Headers install Simpson HUCQ410-SDS. Connect with Simpson SDS 1/4" x 2 1/2" screws.

Equivalent capacity anchors may be substituted, installed in accordance with the manufacturers requirements.

SYP = SOUTHERN YELLOW PINE

*Marty J. Humphries*  
6-1-21

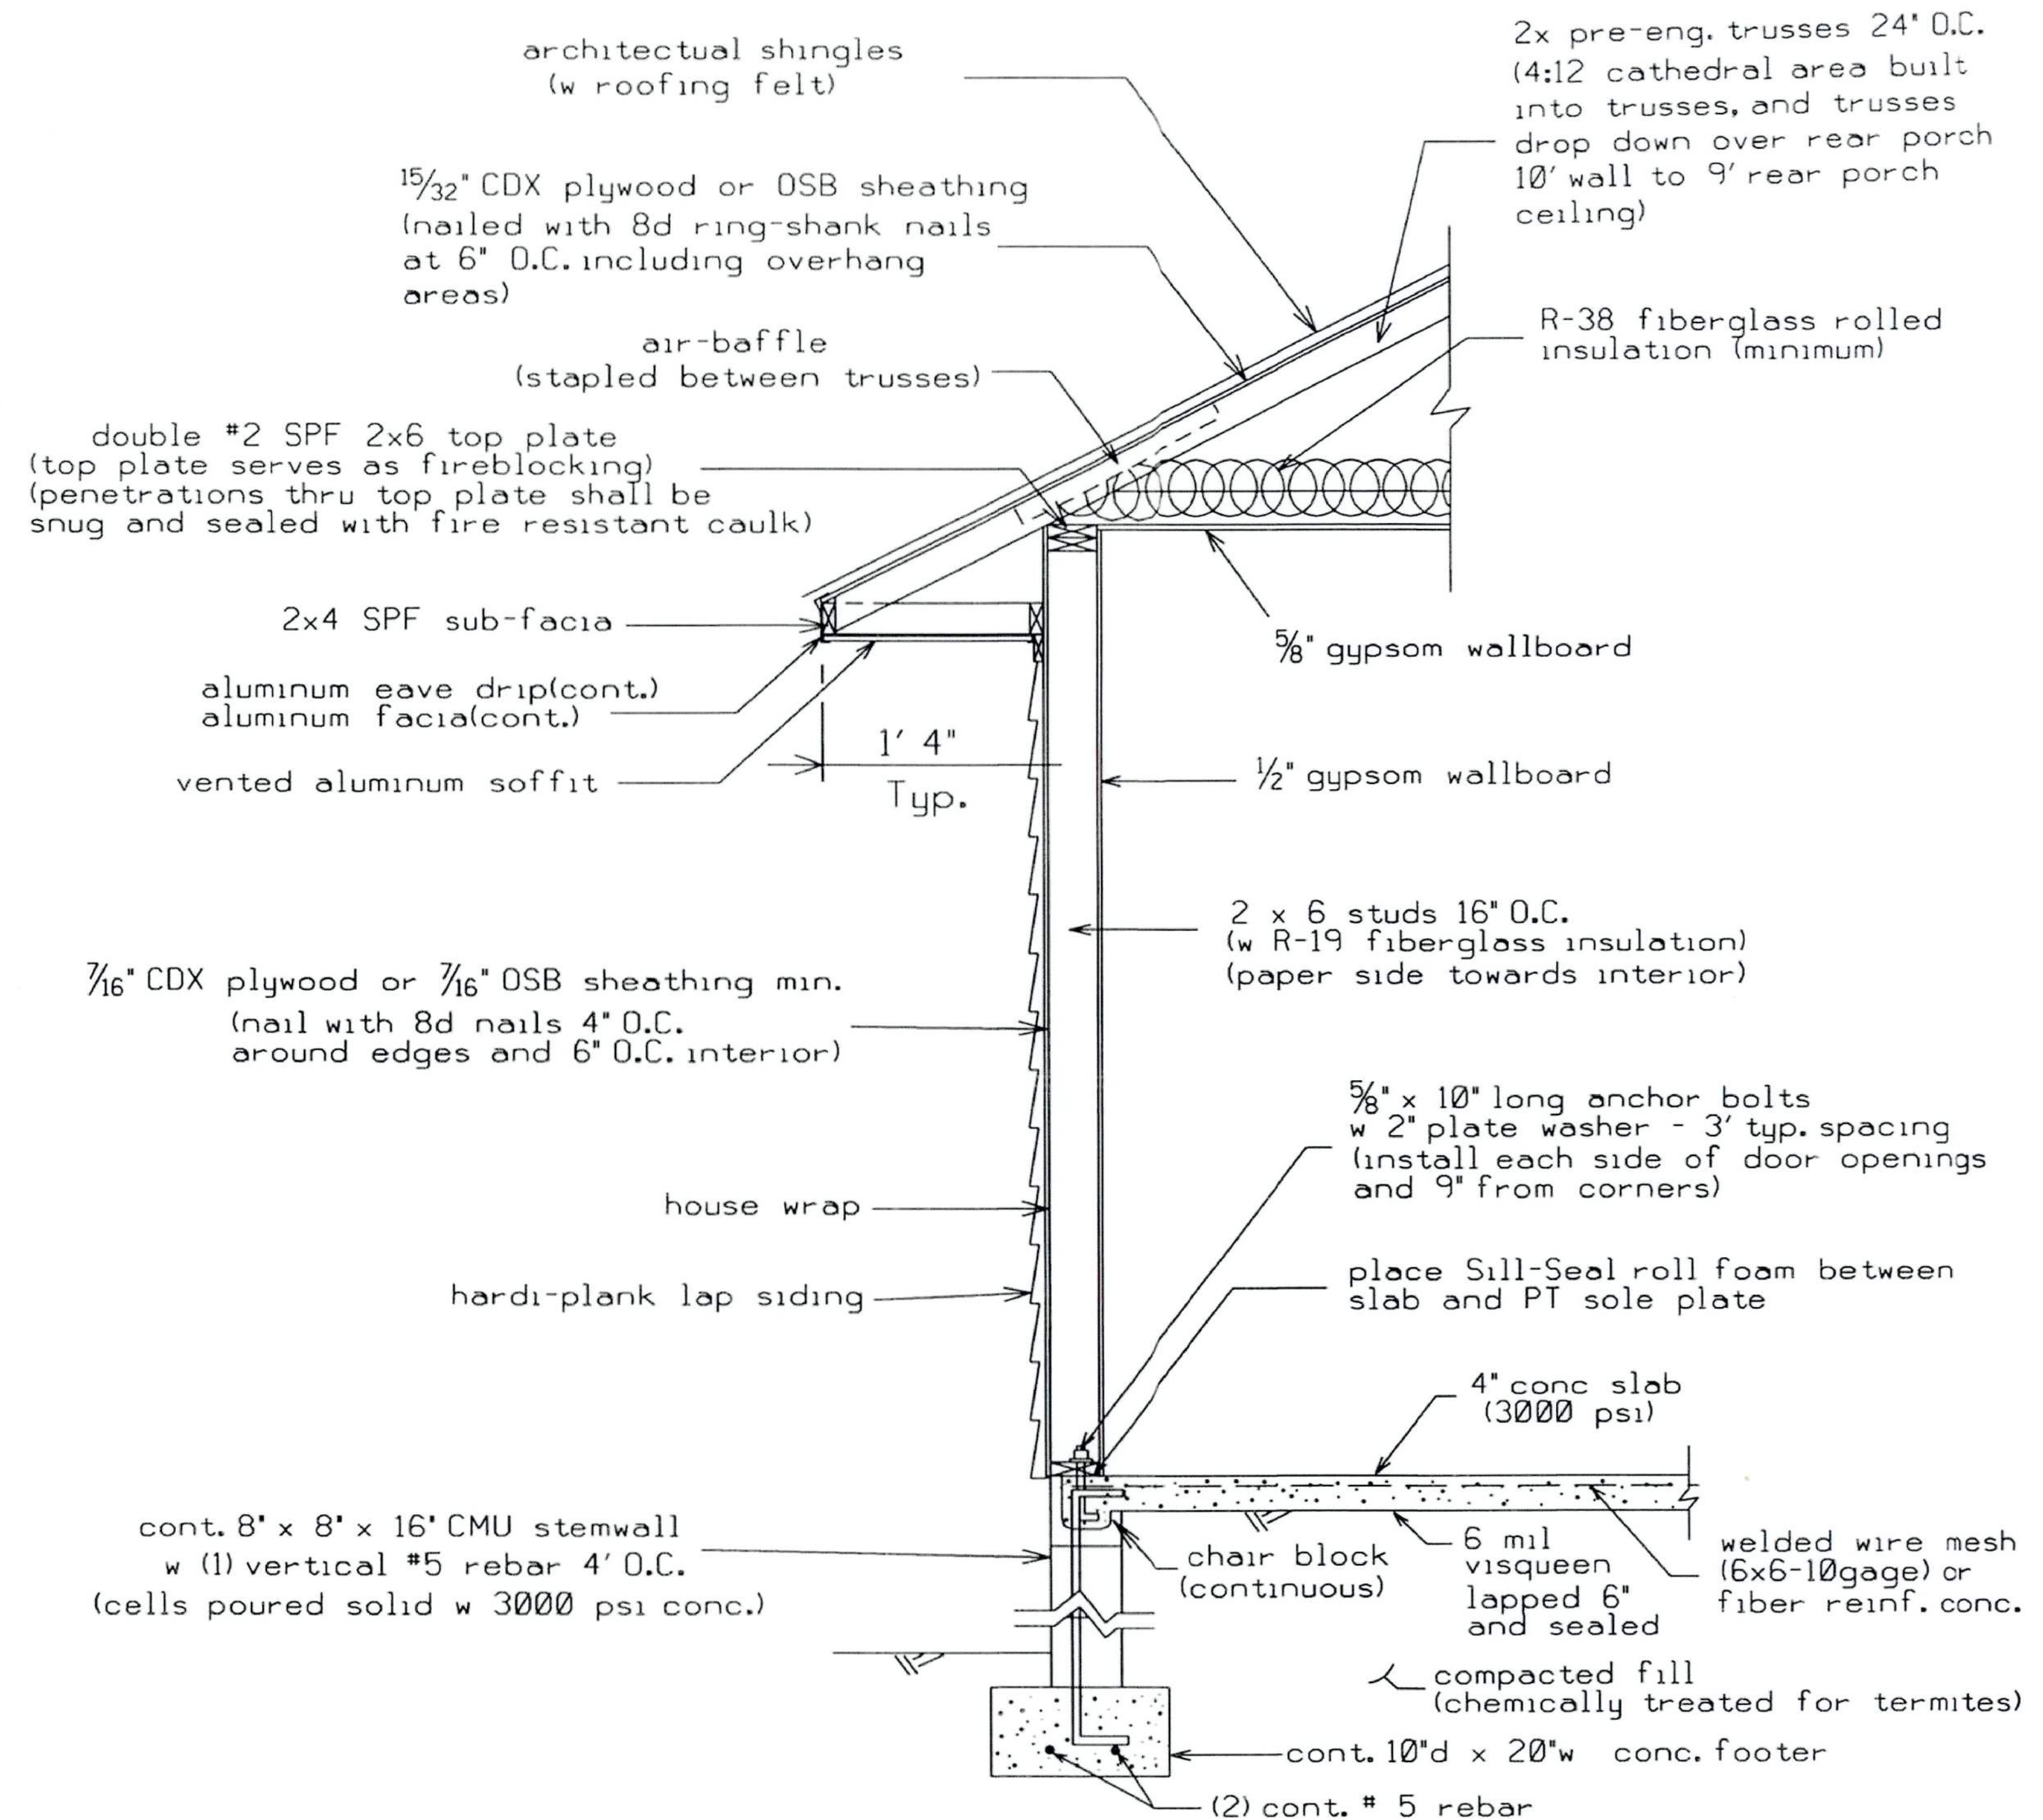

DETAIL A - WALL TYPICAL (N.T.S.)

## HEADER SIZES/MATERIAL SHALL BE AS FOLLOWS:

WINDOW AND DOORS: doors and windows: 3 - #2 SYP 2X8's w 1/2" plywood or OSB between nailed with 4-12d nails 10" O.C.  
 FRONT TRIPLE 4050 WINDOWS: 3 - 1.75" x 11.25" LVL's (Fb=2650 psi min., 1.8E min.) nailed with 4-12d nails 10" O.C.  
 REAR 6080 SLIDER DOOR: 3 - #2 SYP 2X10's w 1/2" plywood or OSB between nailed with 4-12d nails 10" O.C.  
 9' WIDE GARAGE DOOR: 3 - #2 SYP 2X10's w 1/2" plywood or OSB between nailed with 4-12d nails 10" O.C.  
 18' WIDE GARAGE DOOR: 3 - 1.75" x 14" LVL's (Fb=2650 psi min., 1.8E min.) nailed with 4-12d nails 10" O.C.  
 FRONT AND REAR PORCHES: 2 - #2 SYP 2X10'S w 1/2" plywood or OSB between nailed with 4-12d nails 10" O.C.


B

PLANS PREPARED BY:  
 MARTY J. HUMPHRIES P.E. # 51976  
 7932 240TH ST., O'BRIEN, FL 32071


BRUNO RESIDENCE PLANS  
 COLUMBIA COUNTY, FLORIDA

SHEET  
 5  
 OF  
 10


Porch shall be dropped 3' below finished interior slab elevation and shall be sloped to edge of porch for drainage.

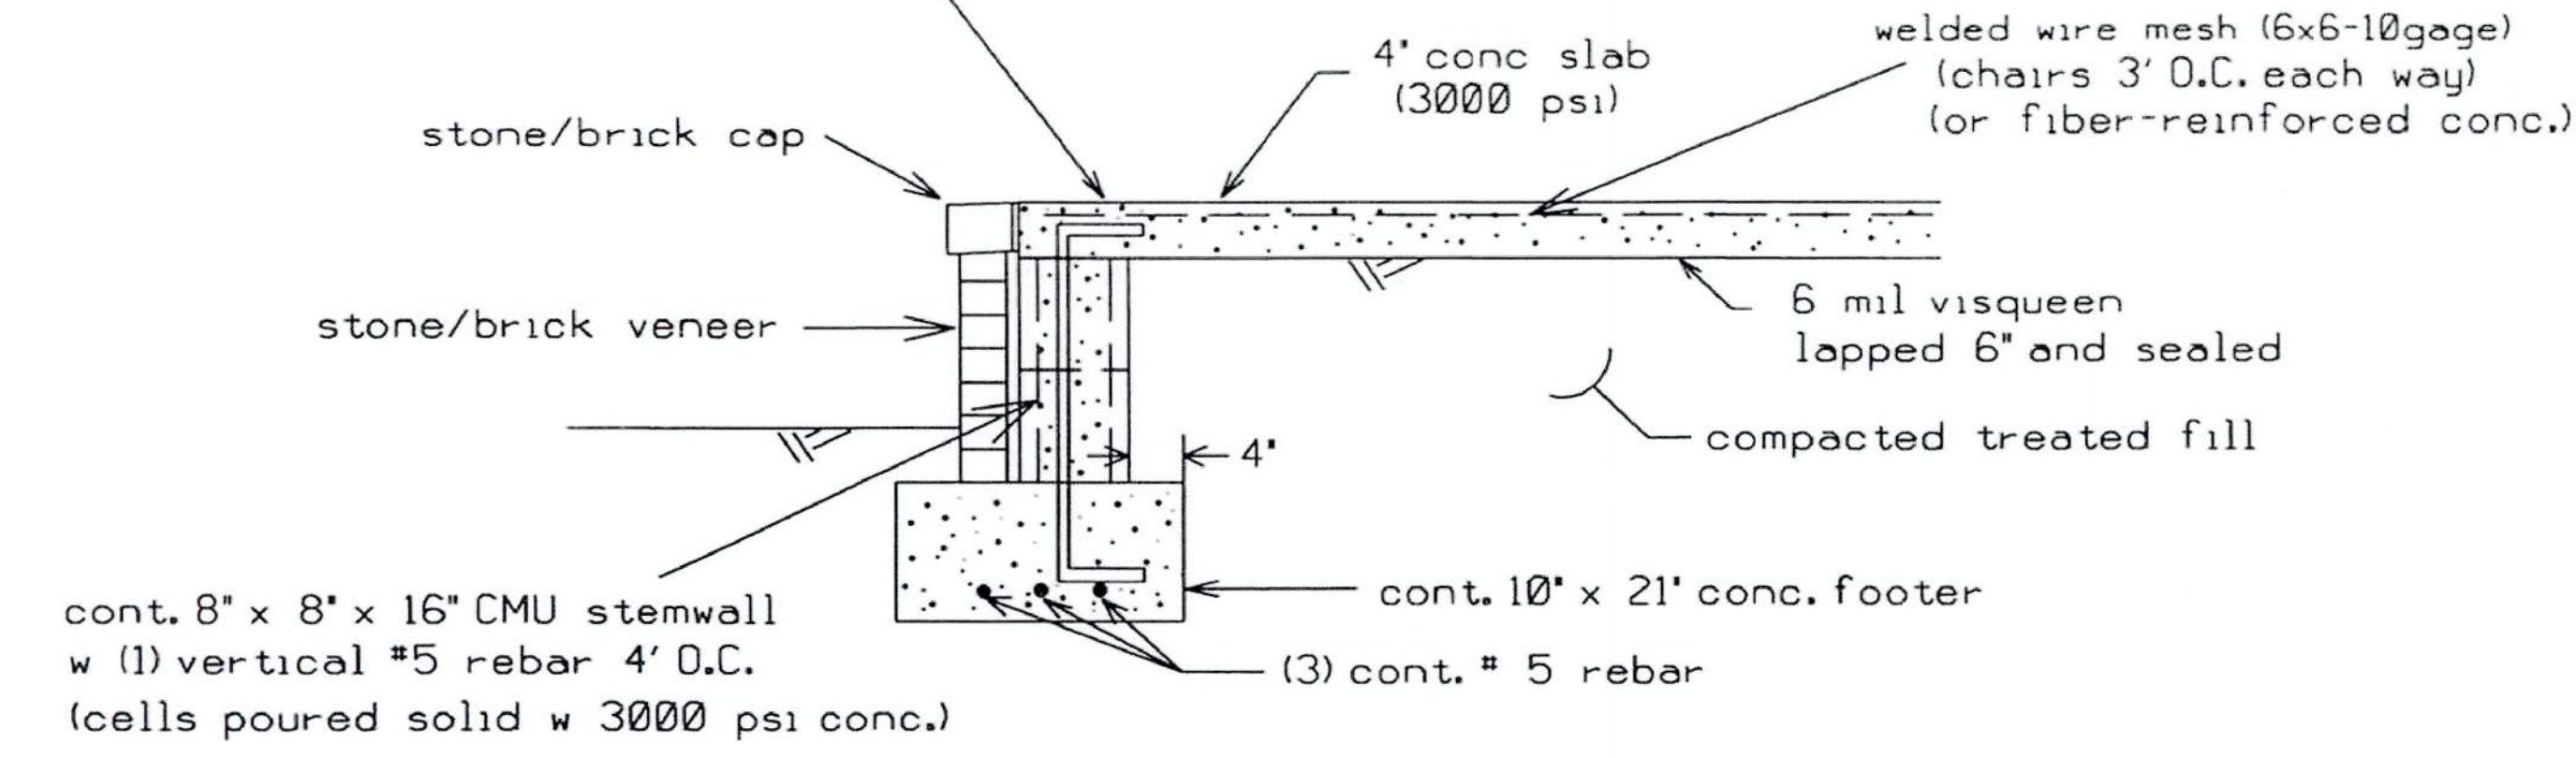

OPTIONAL PORCH FOUNDATION w STONE DETAIL (N.T.S.)

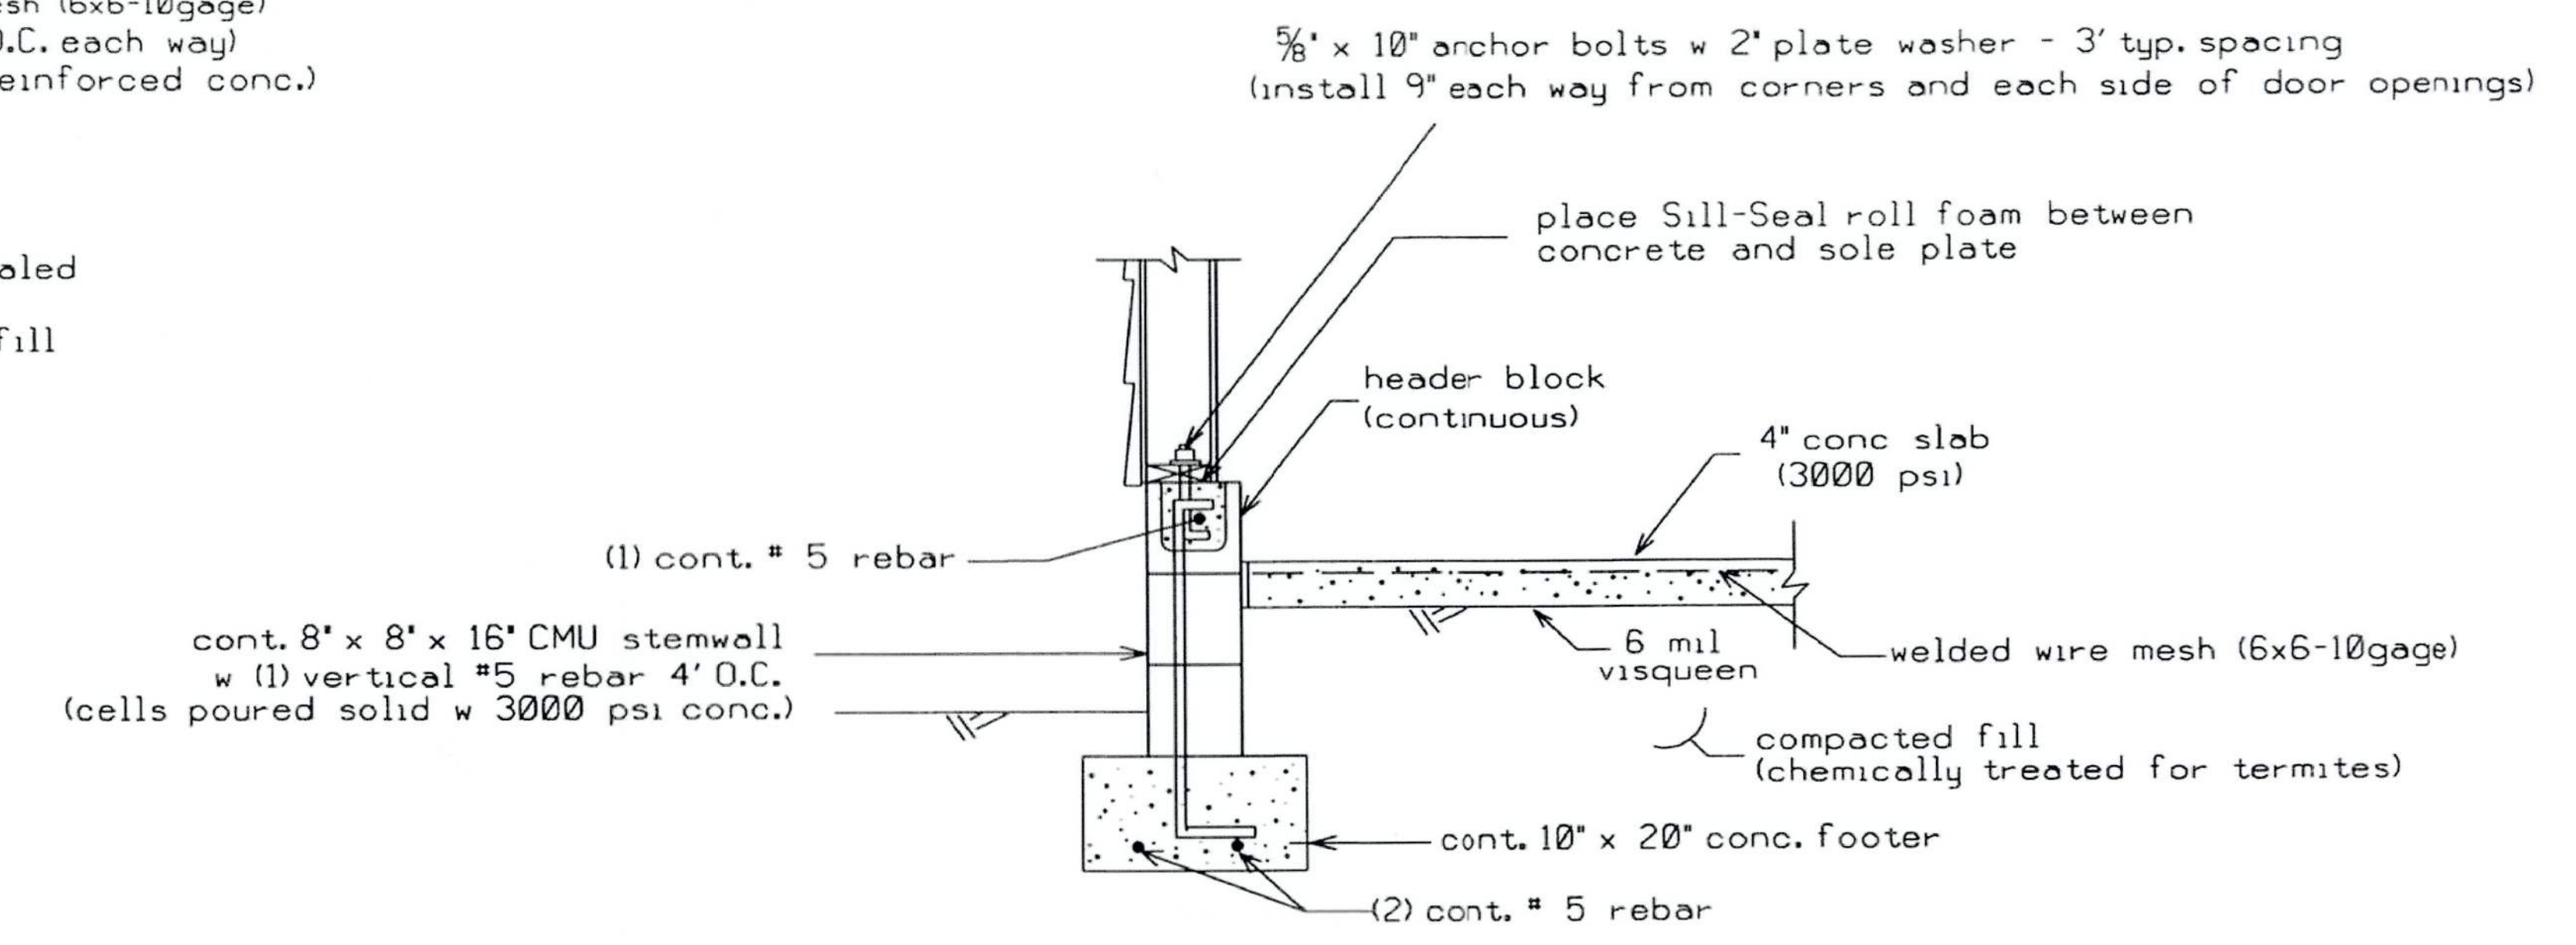


DETAIL C - GARAGE STEMWALL WITH FLOATING SLAB (N.T.S.)

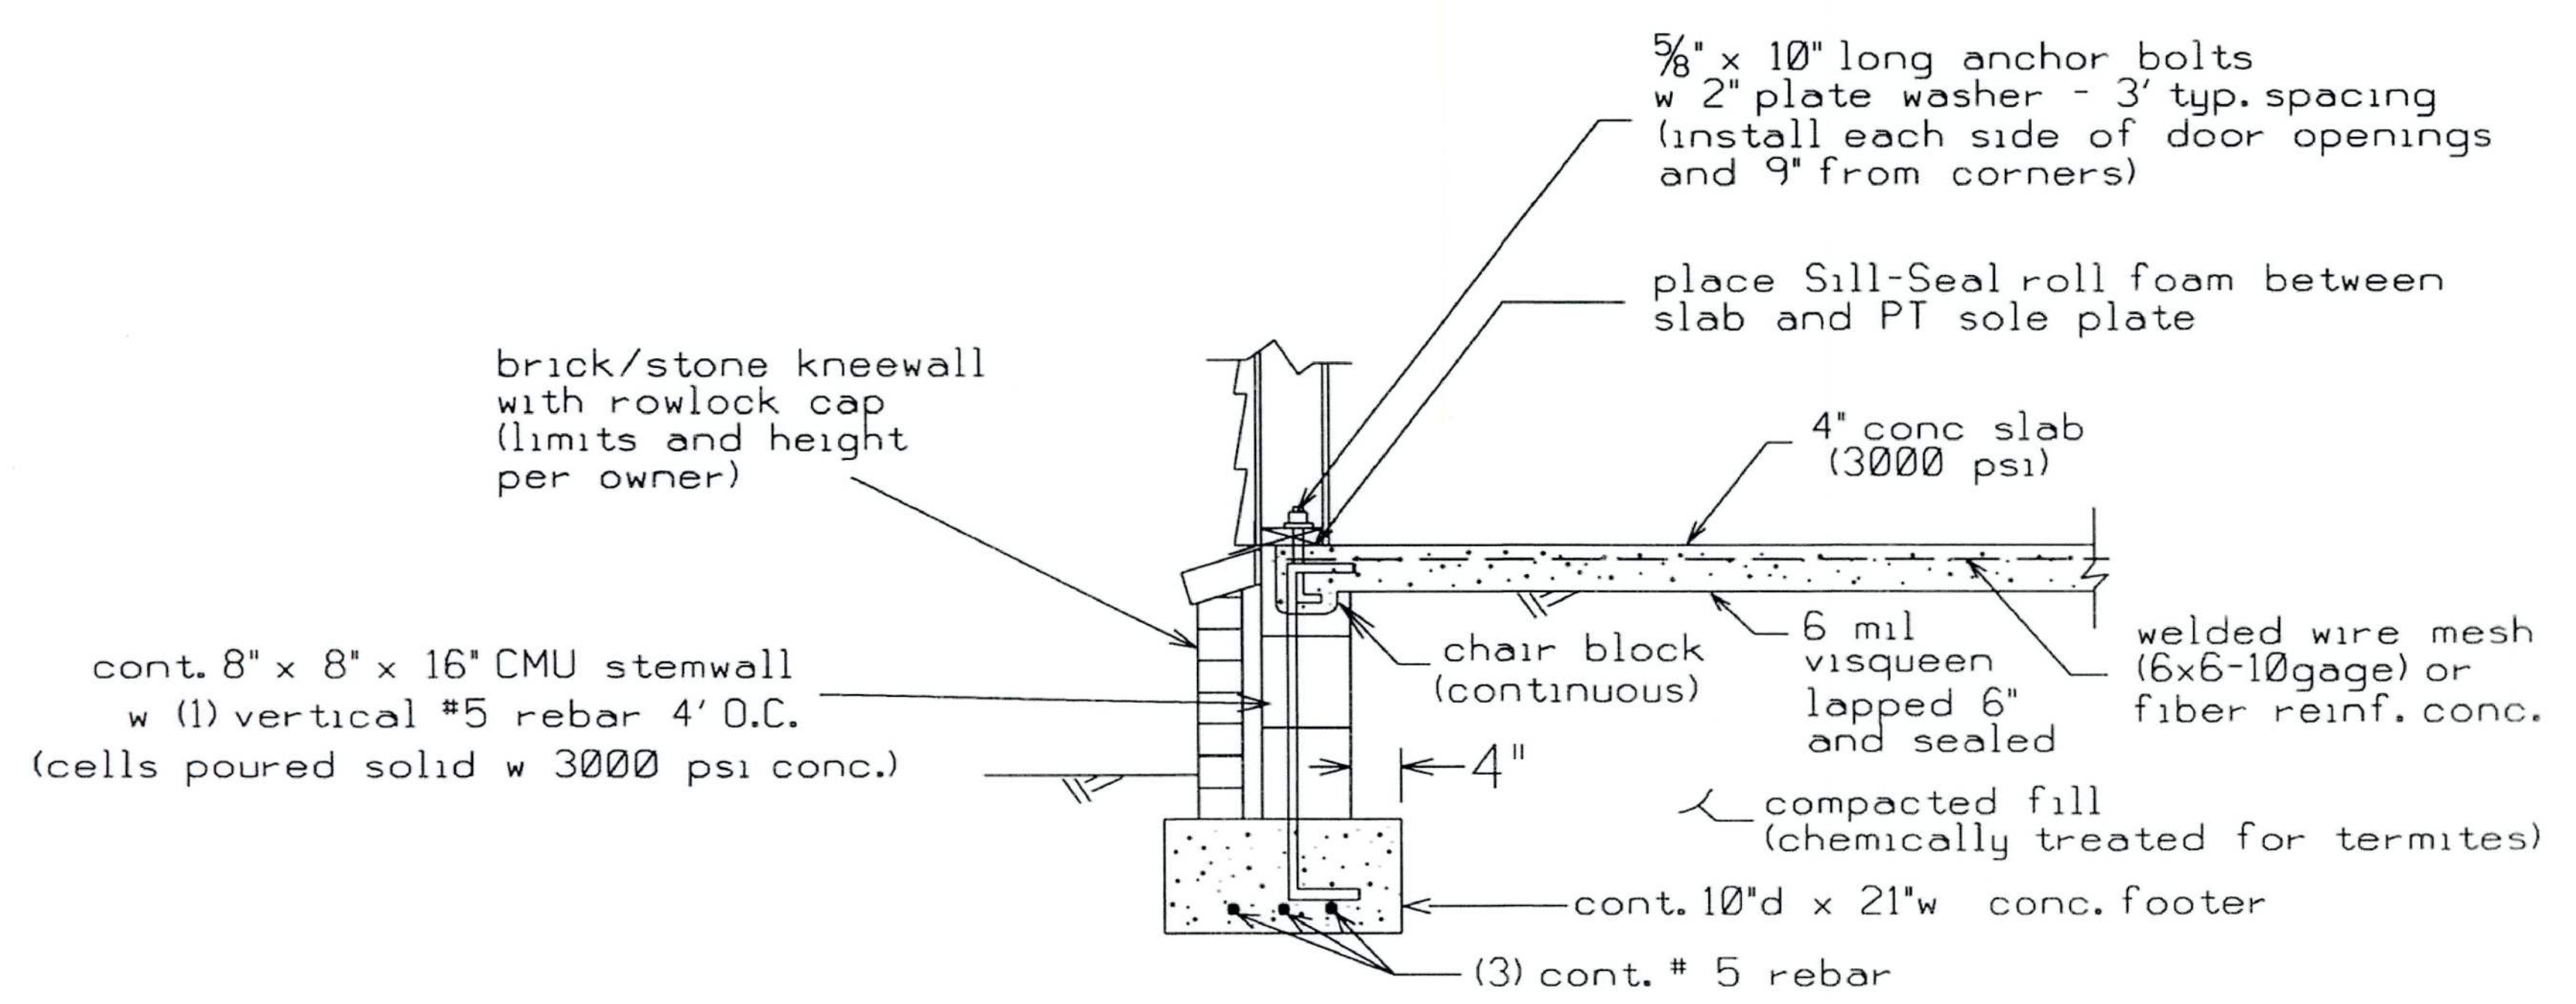


OPTIONAL EXTERIOR WALL FOUNDATION w STONE DETAIL (N.T.S.)

Porch shall be dropped 3' below finished interior slab elevation and shall be sloped to edge of porch (for drainage).

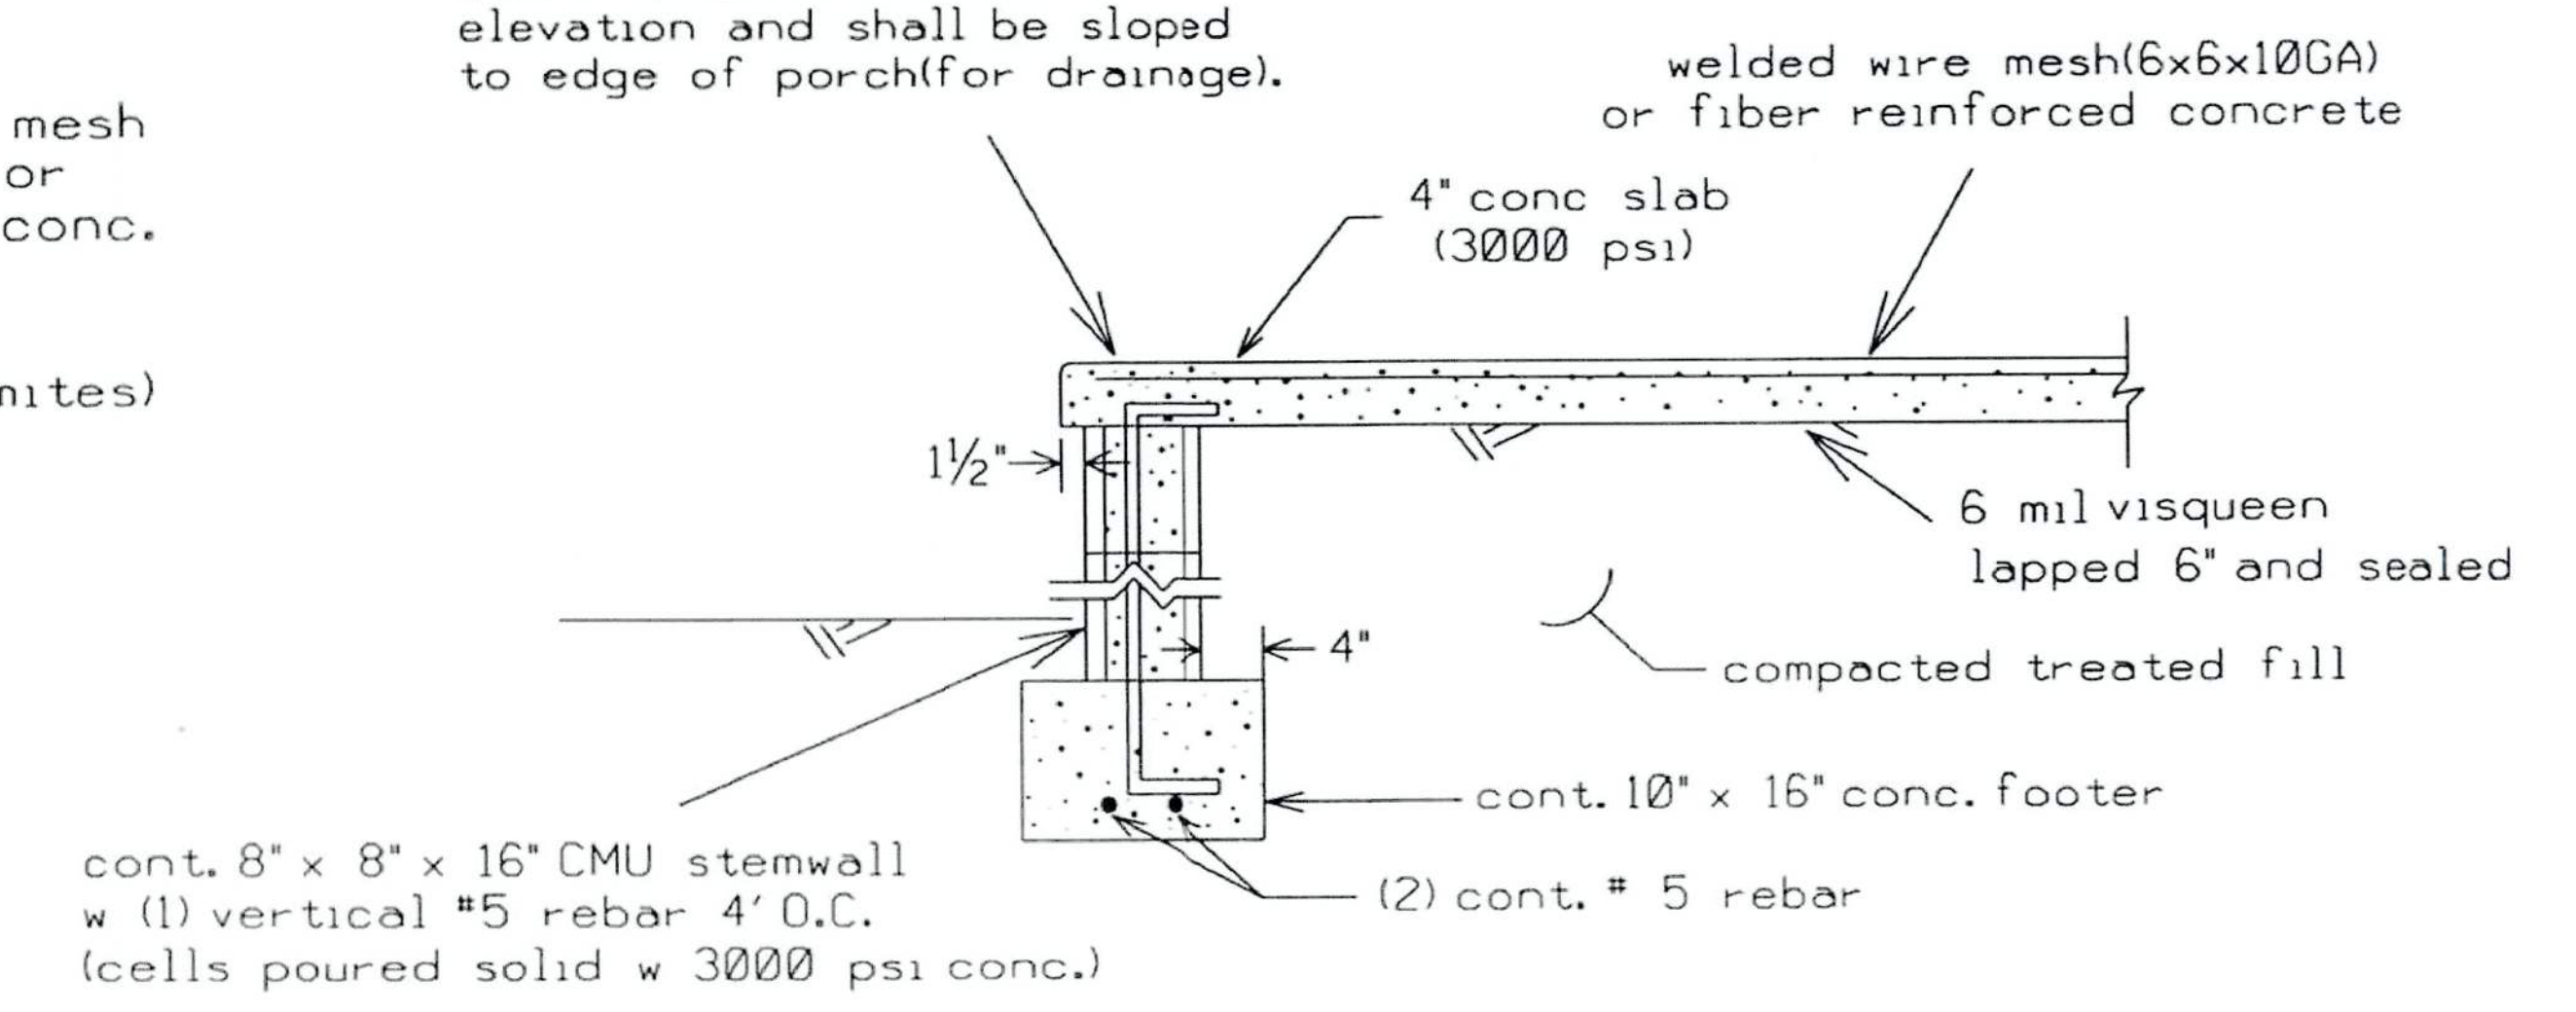


DETAIL B - PORCH FOUNDATION (N.T.S.)

*Marty J. Humphries*  
6-1-21

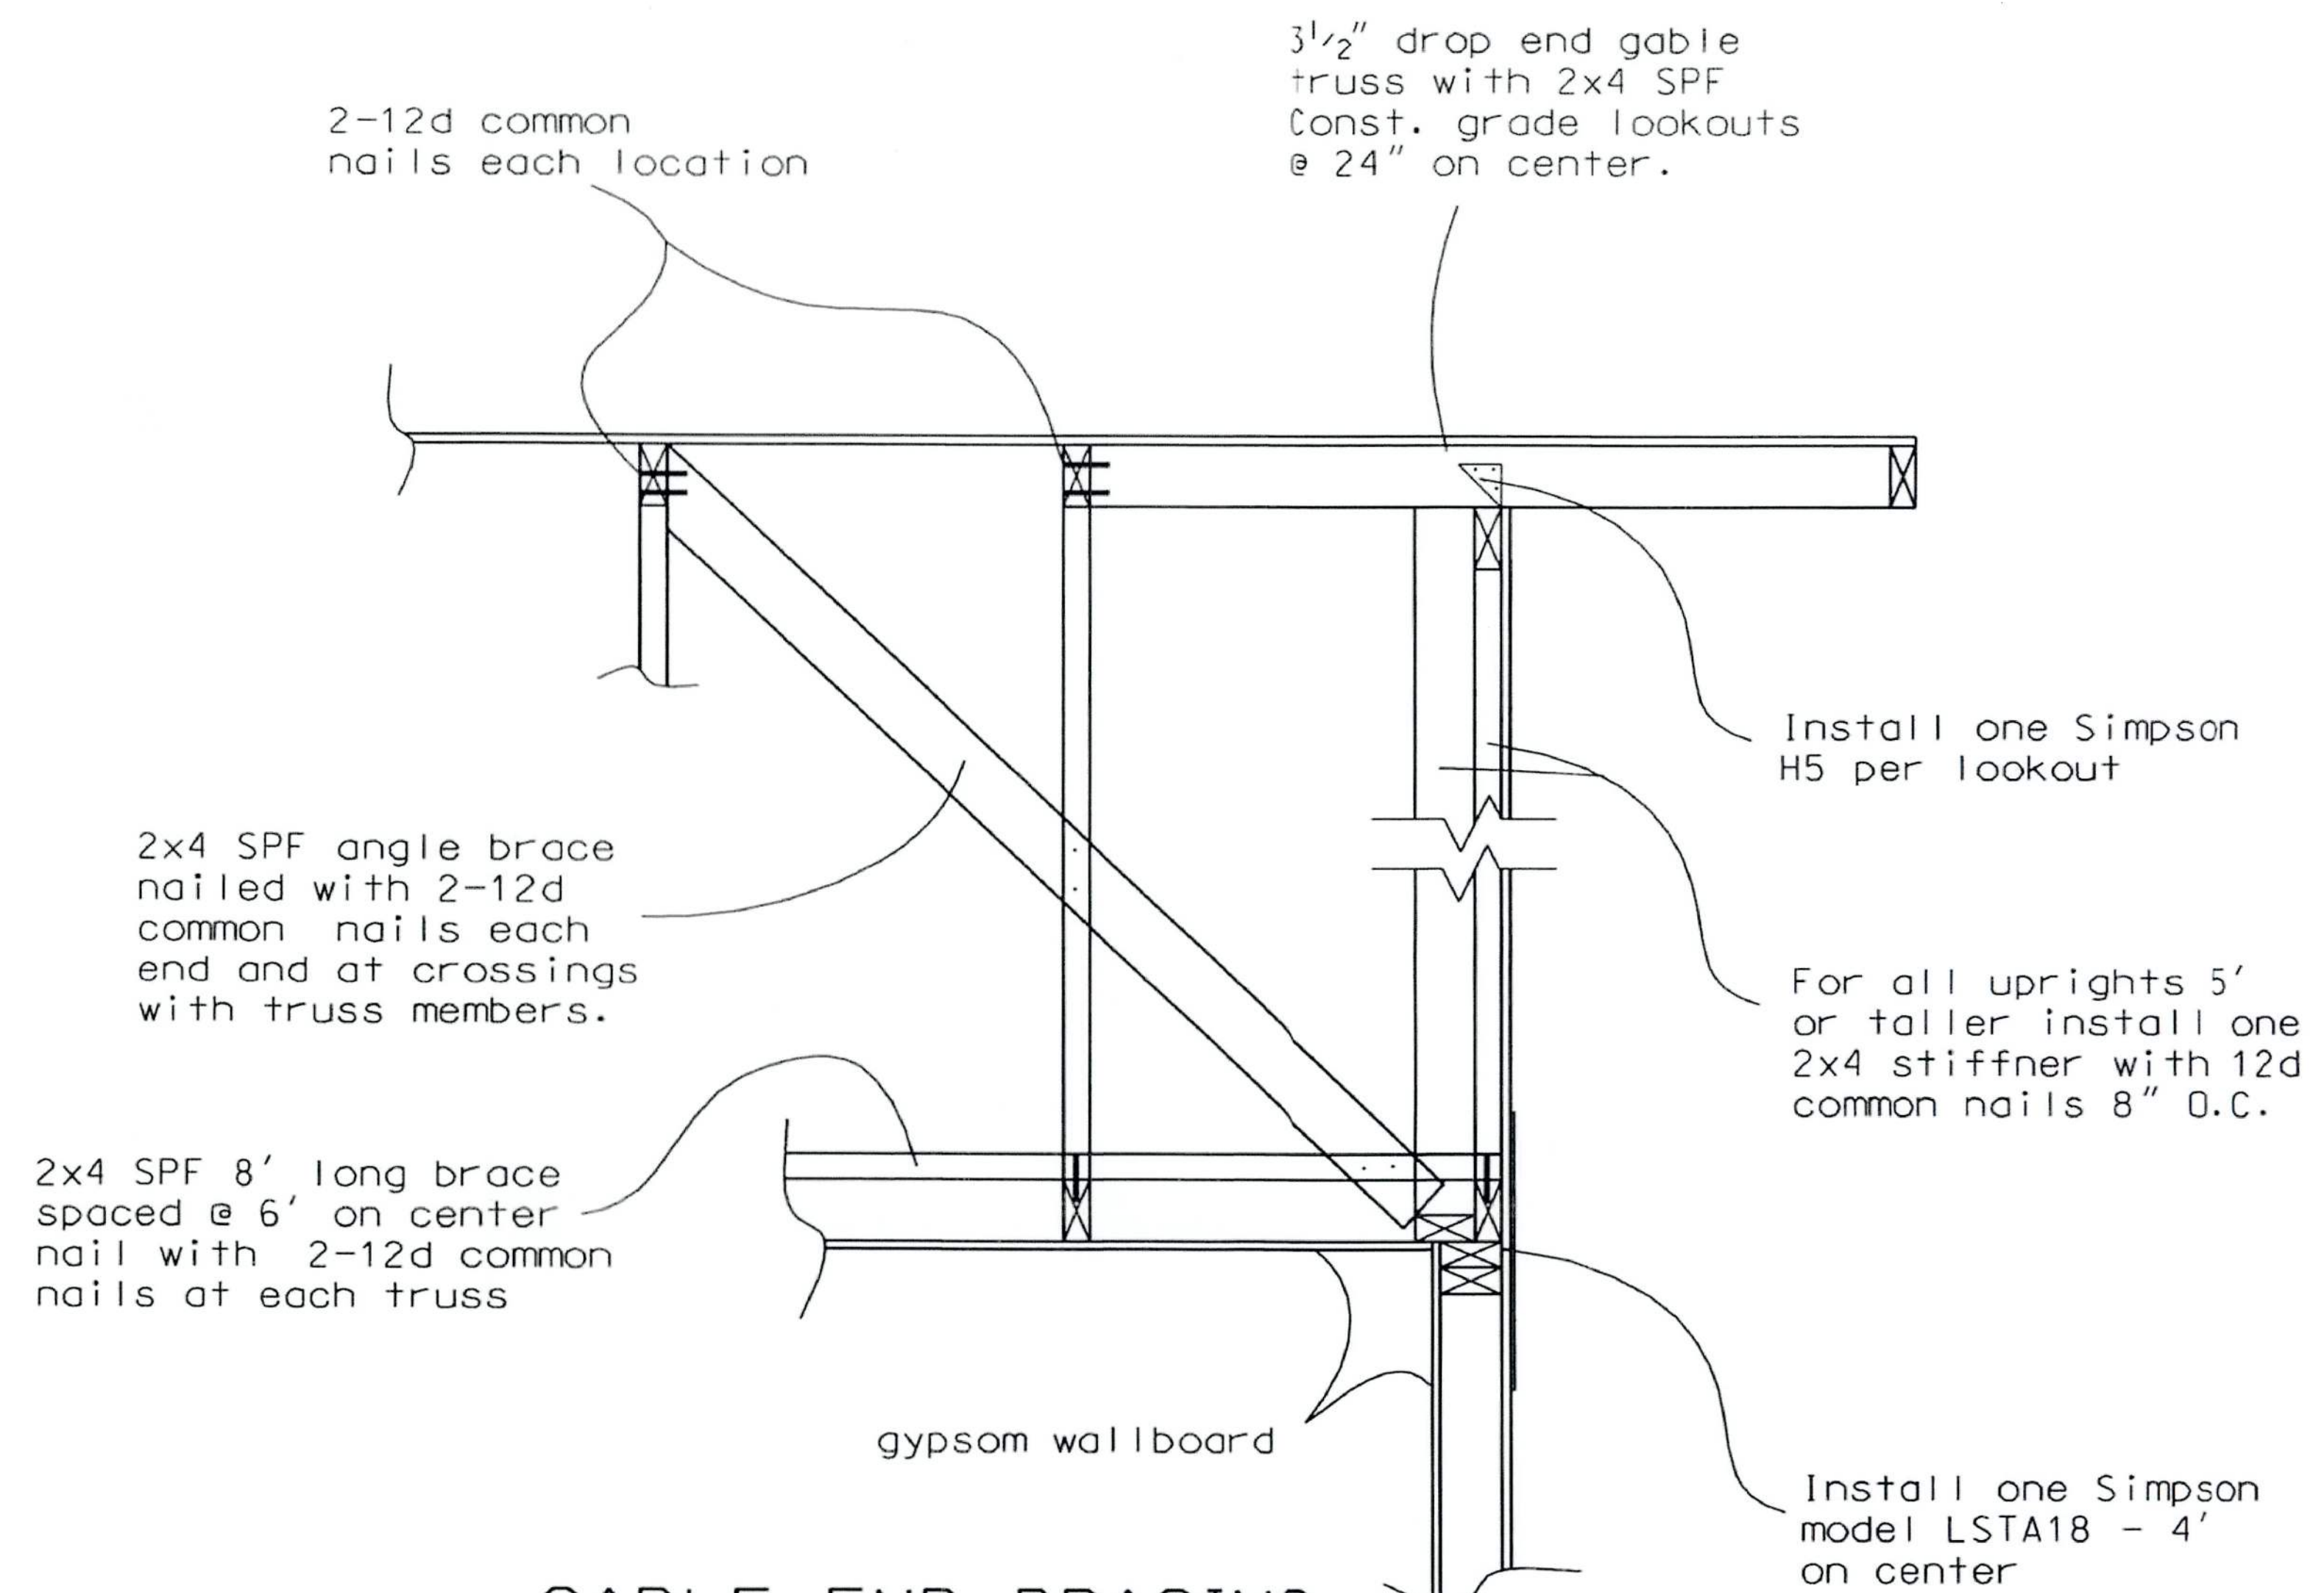

### GABLE END BRACING DETAIL (N.T.S.)

NOTE: Gable end trusses shall be dropped 3 1/2" for construction of lookouts & overhang.

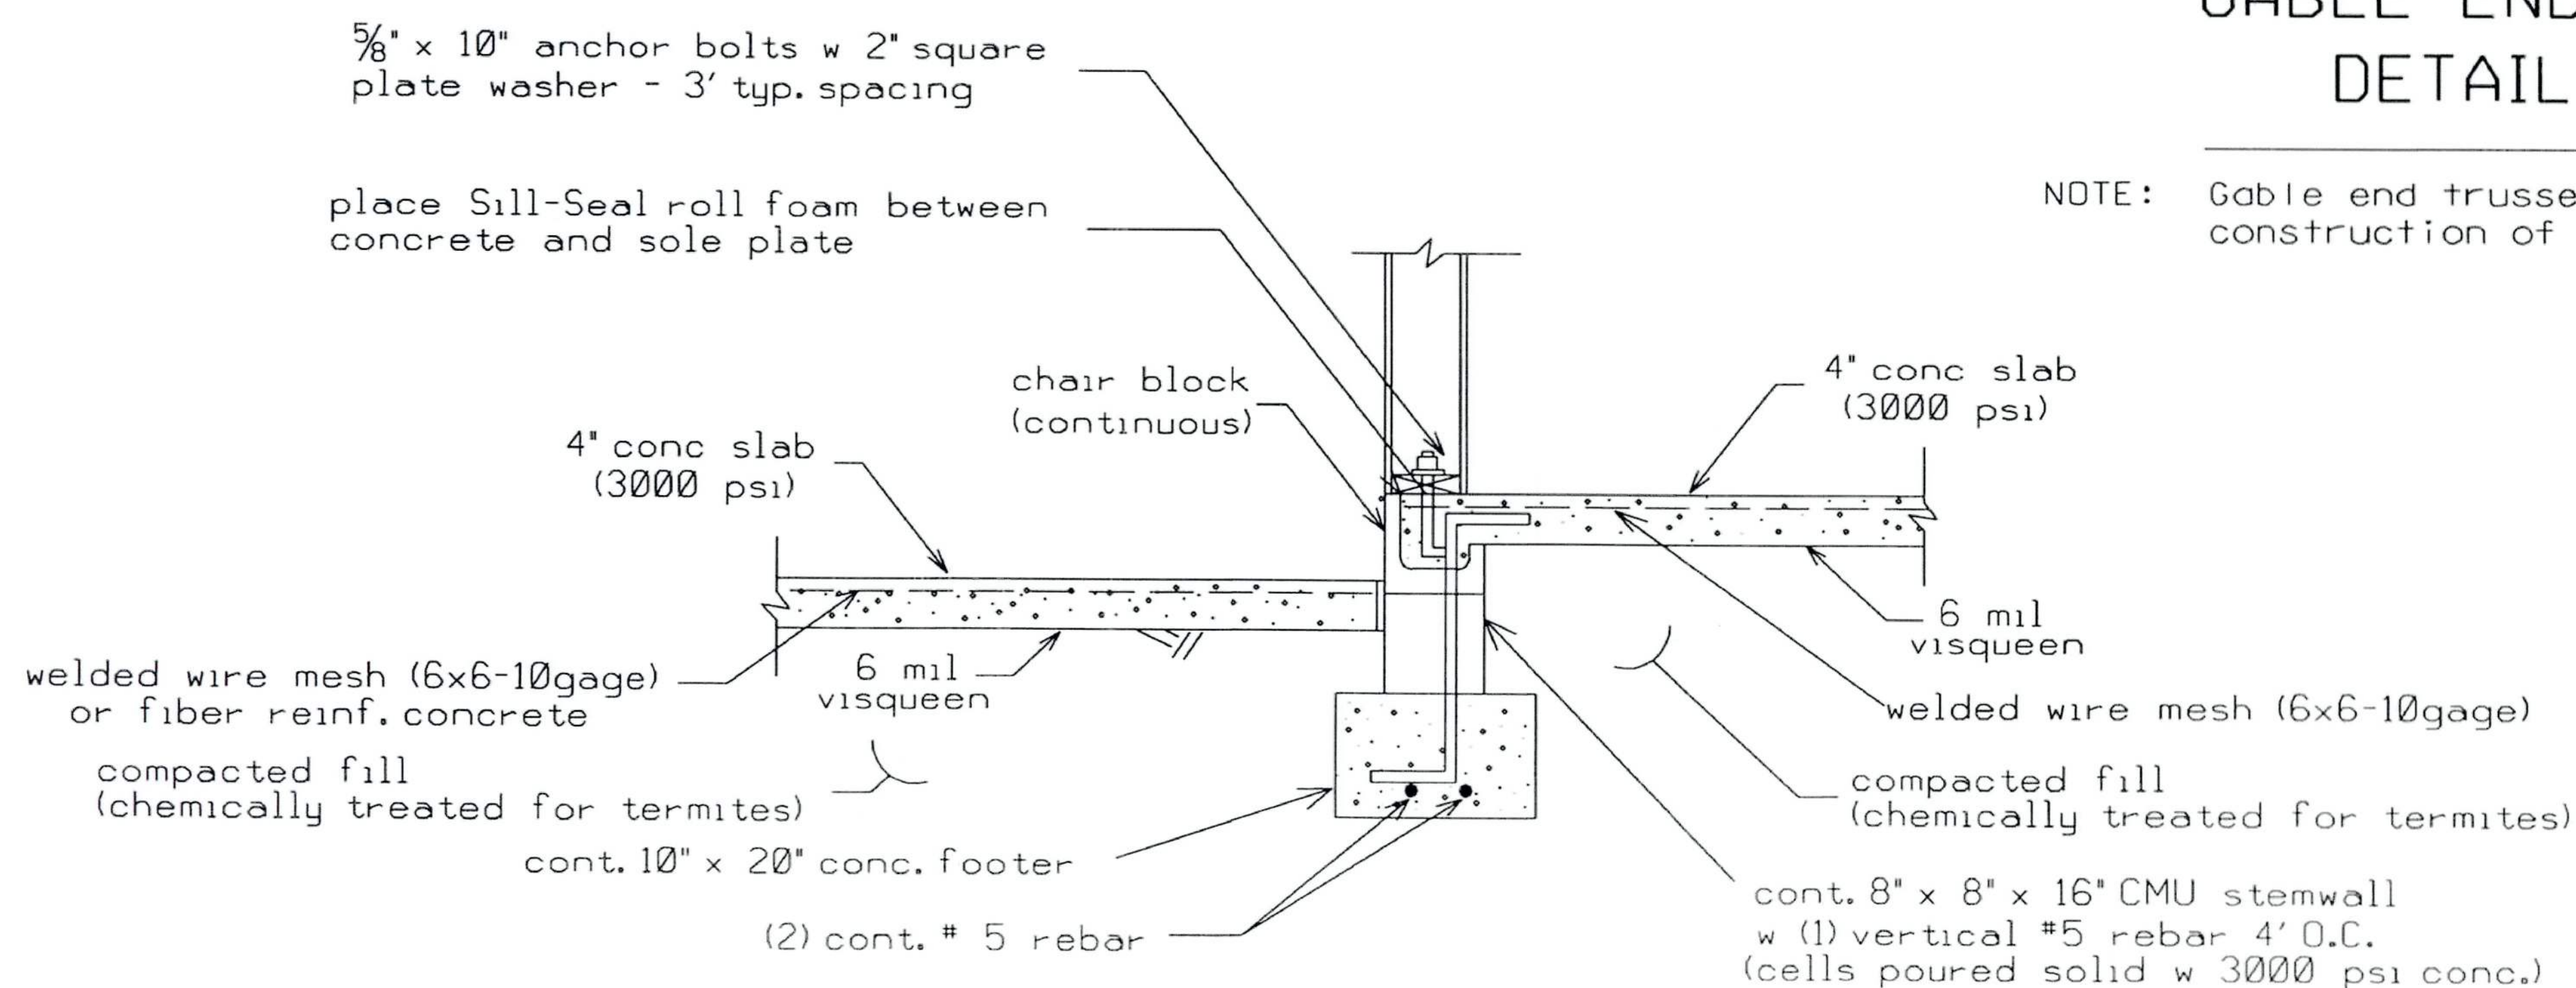

### DETAIL D - INTERIOR GARAGE STEMWALL WITH FLOATING SLAB (N.T.S.)

*Marty J. Humphries*  
6-1-21


B

PLANS PREPARED BY:  
MARTY J. HUMPHRIES P.E. # 51976  
7932 240TH ST., O'BRIEN, FL 32071

BRUNO RESIDENCE PLANS  
COLUMBIA COUNTY, FLORIDA

SHEET  
7  
OF  
10

ROOF PLAN (N.T.S.)

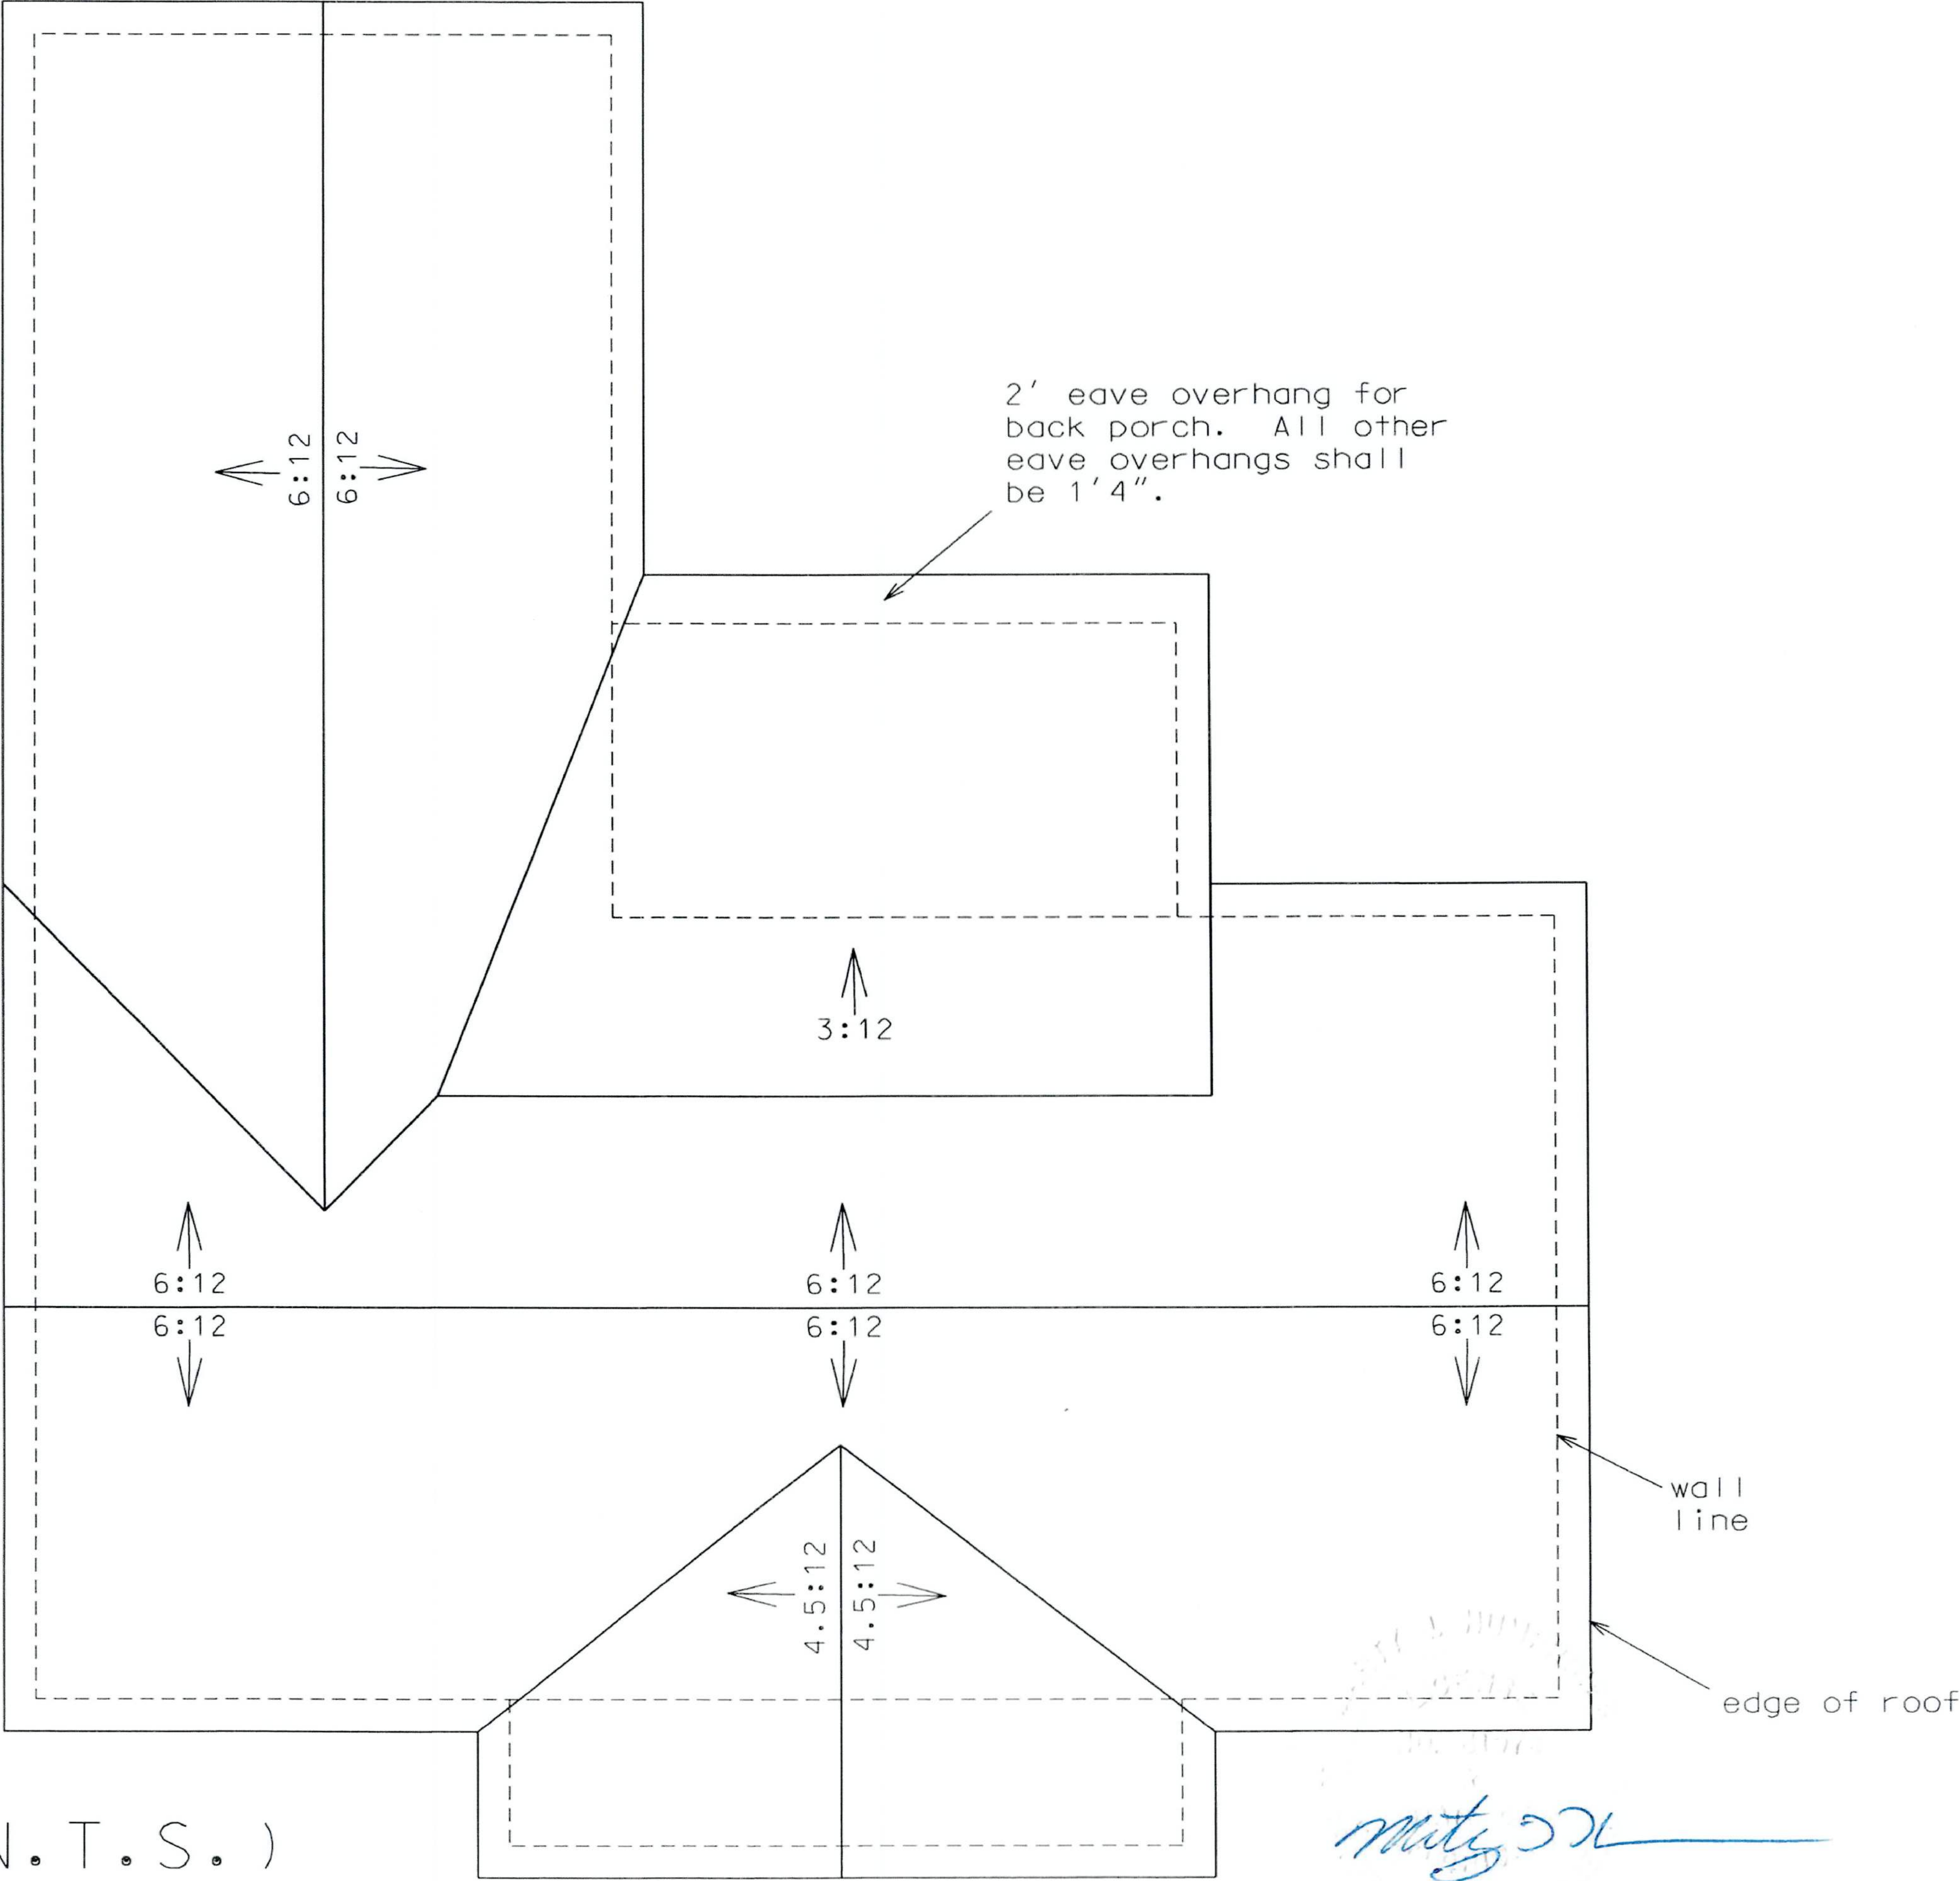




*Marty J. O'Brien*  
6-1-21

BRUNO RESIDENCE PLANS  
COLUMBIA COUNTY, FLORIDA

PLANS PREPARED BY:  
MARTY J. HUMPHRIES P.E. # 51976  
7932 240TH ST., O'BRIEN, FL 32071

SHEET  
8  
OF  
10

B

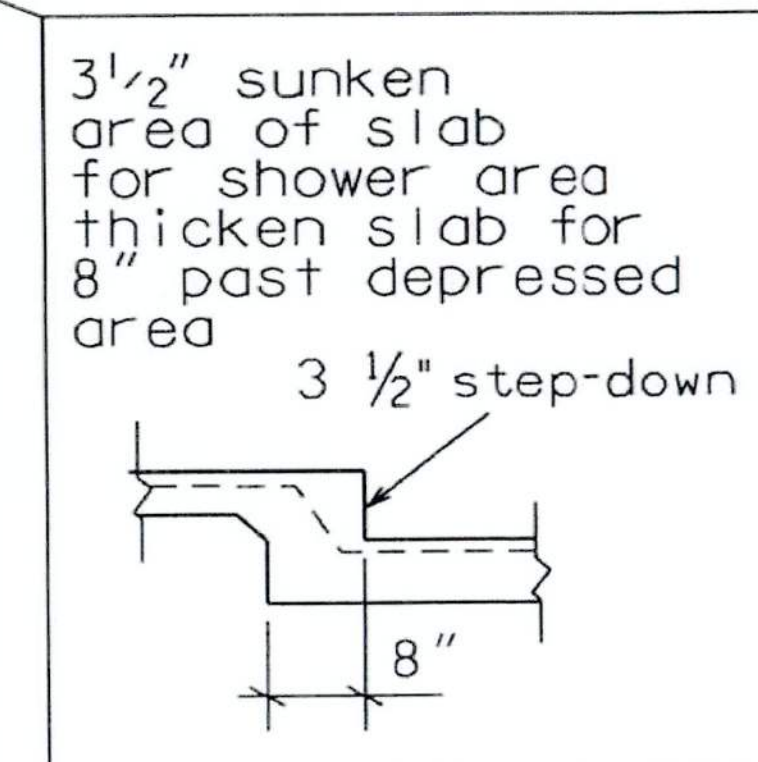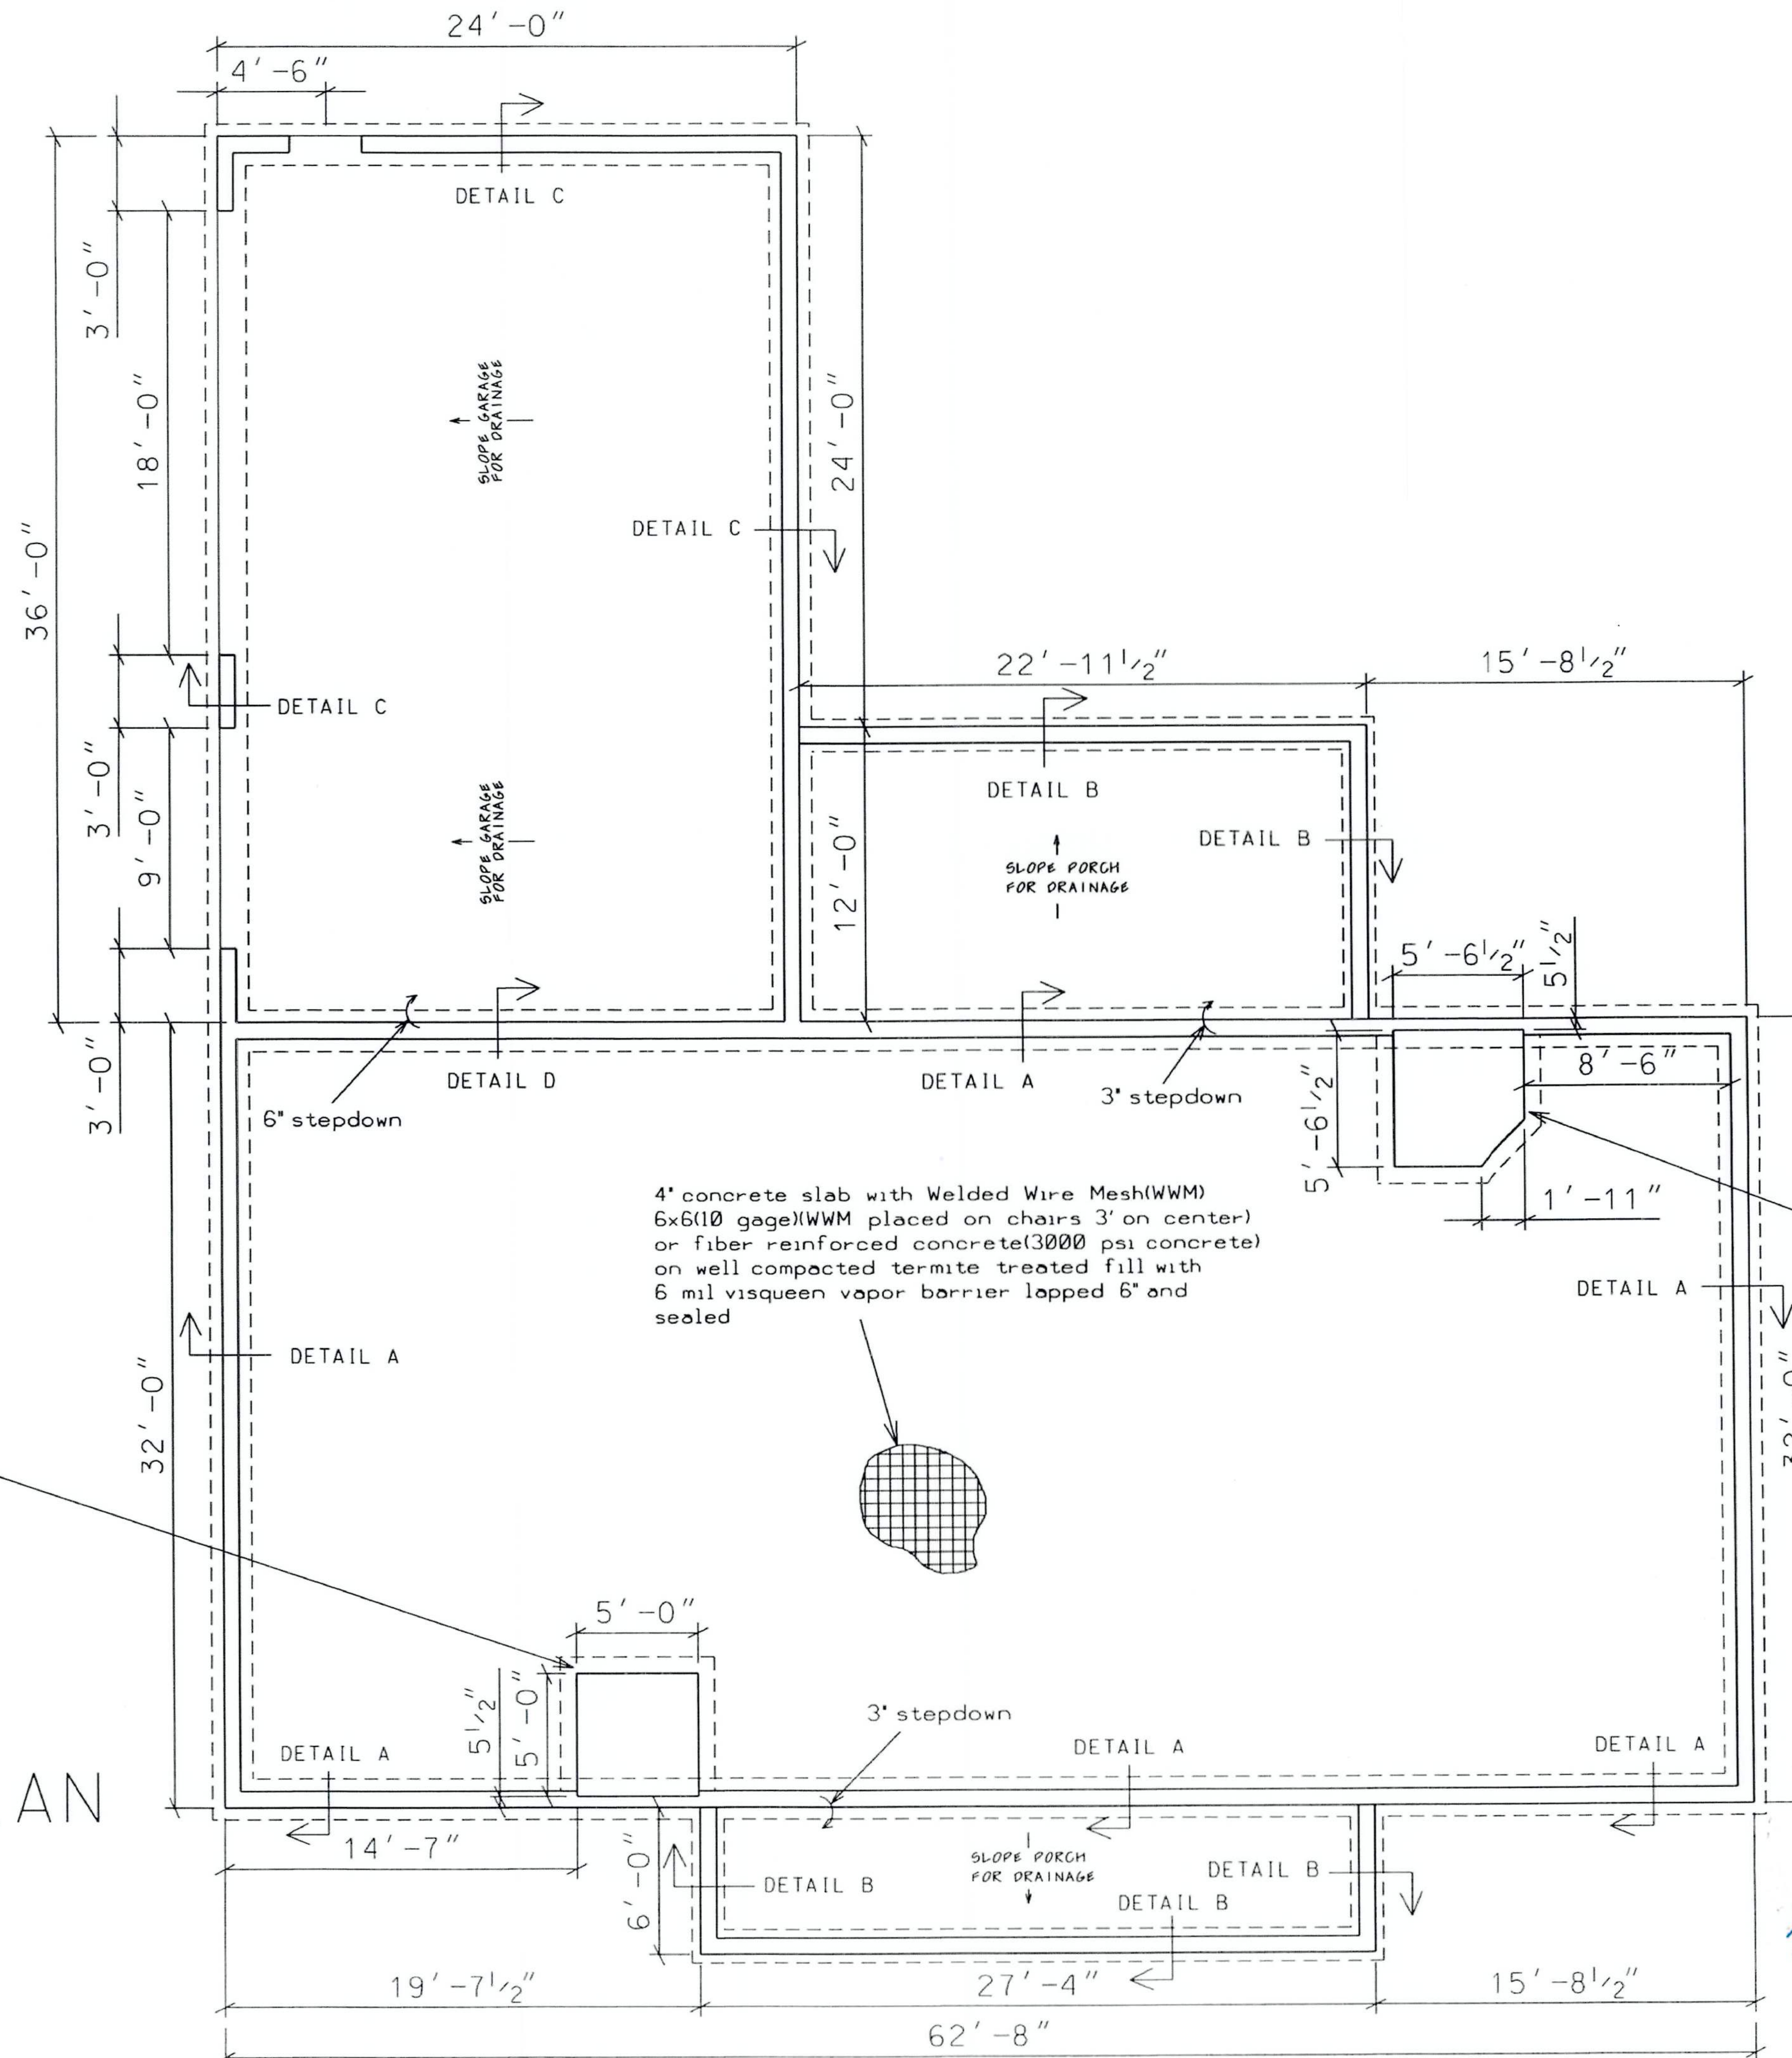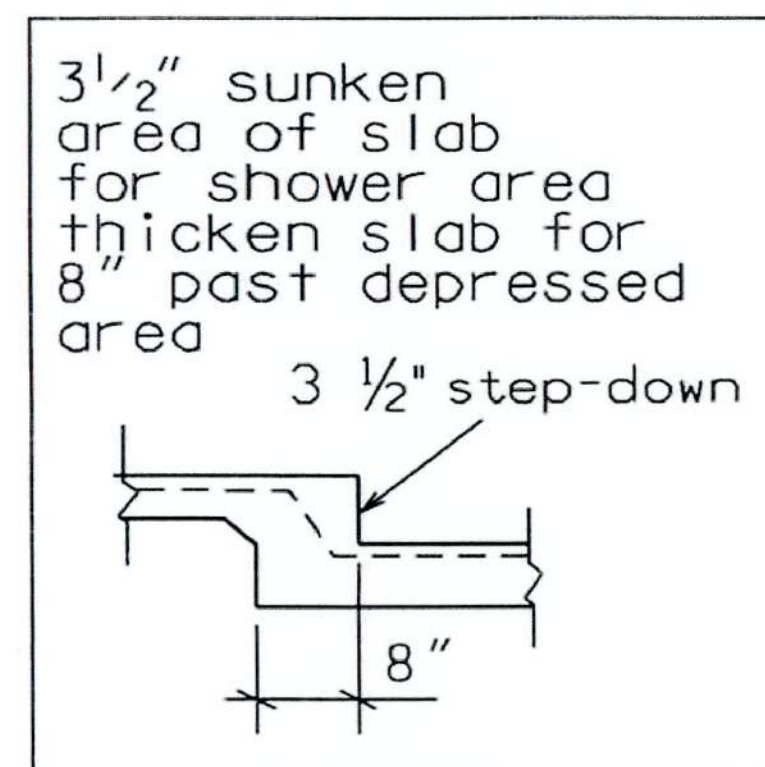


mtg 57L  
6-1-21

PLANS PREPARED BY:  
MARTY J. HUMPHRIES P.E. # 51976  
7932 240TH ST., O'BRIEN, FL 32071


SHEET  
9  
OF  
10

ELECTRICAL LEGEND

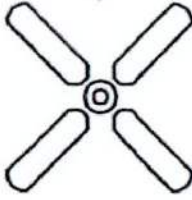-  - CEILING FAN w LIGHTS
-  - LIGHT FIXTURE
-  - RECESSED CAN LIGHT FIXTURE
-  - SINGLE POLE SWITCH
-  - THREE-WAY SWITCH
-  - DIMMER SWITCH
-  - THREE-WAY DIMMER SWITCH
-  - RECEPT.
-  - GFI RECEPT OR PART OF A GFI CIRCUIT.
-  - SECURITY LIGHT
-  - EXHAUST WITH DECORATIVE LIGHT
-  - 220 V.
-  - SMOKE DETECTOR (AC/DC and interconnected)
-  - SMOKE & CARBON MONOXIED DETECTOR (AC/DC and interconnected)
-  - COAX & TELEPHONE

NOTES:

- 1.) ALL EXTERIOR RECEPTACLES SHALL BE WEATHERPROOF.
- 2.) ALL RECPTS NOT A GFI OR PART OF A GFI CIRCUIT SHALL BE PART OF AN AFCI CIRCUIT.
- 3.) PLACE 4 LIGHTS IN HOME ATTIC AREA WITH SWITCH NEAR ATTIC ACCESS.

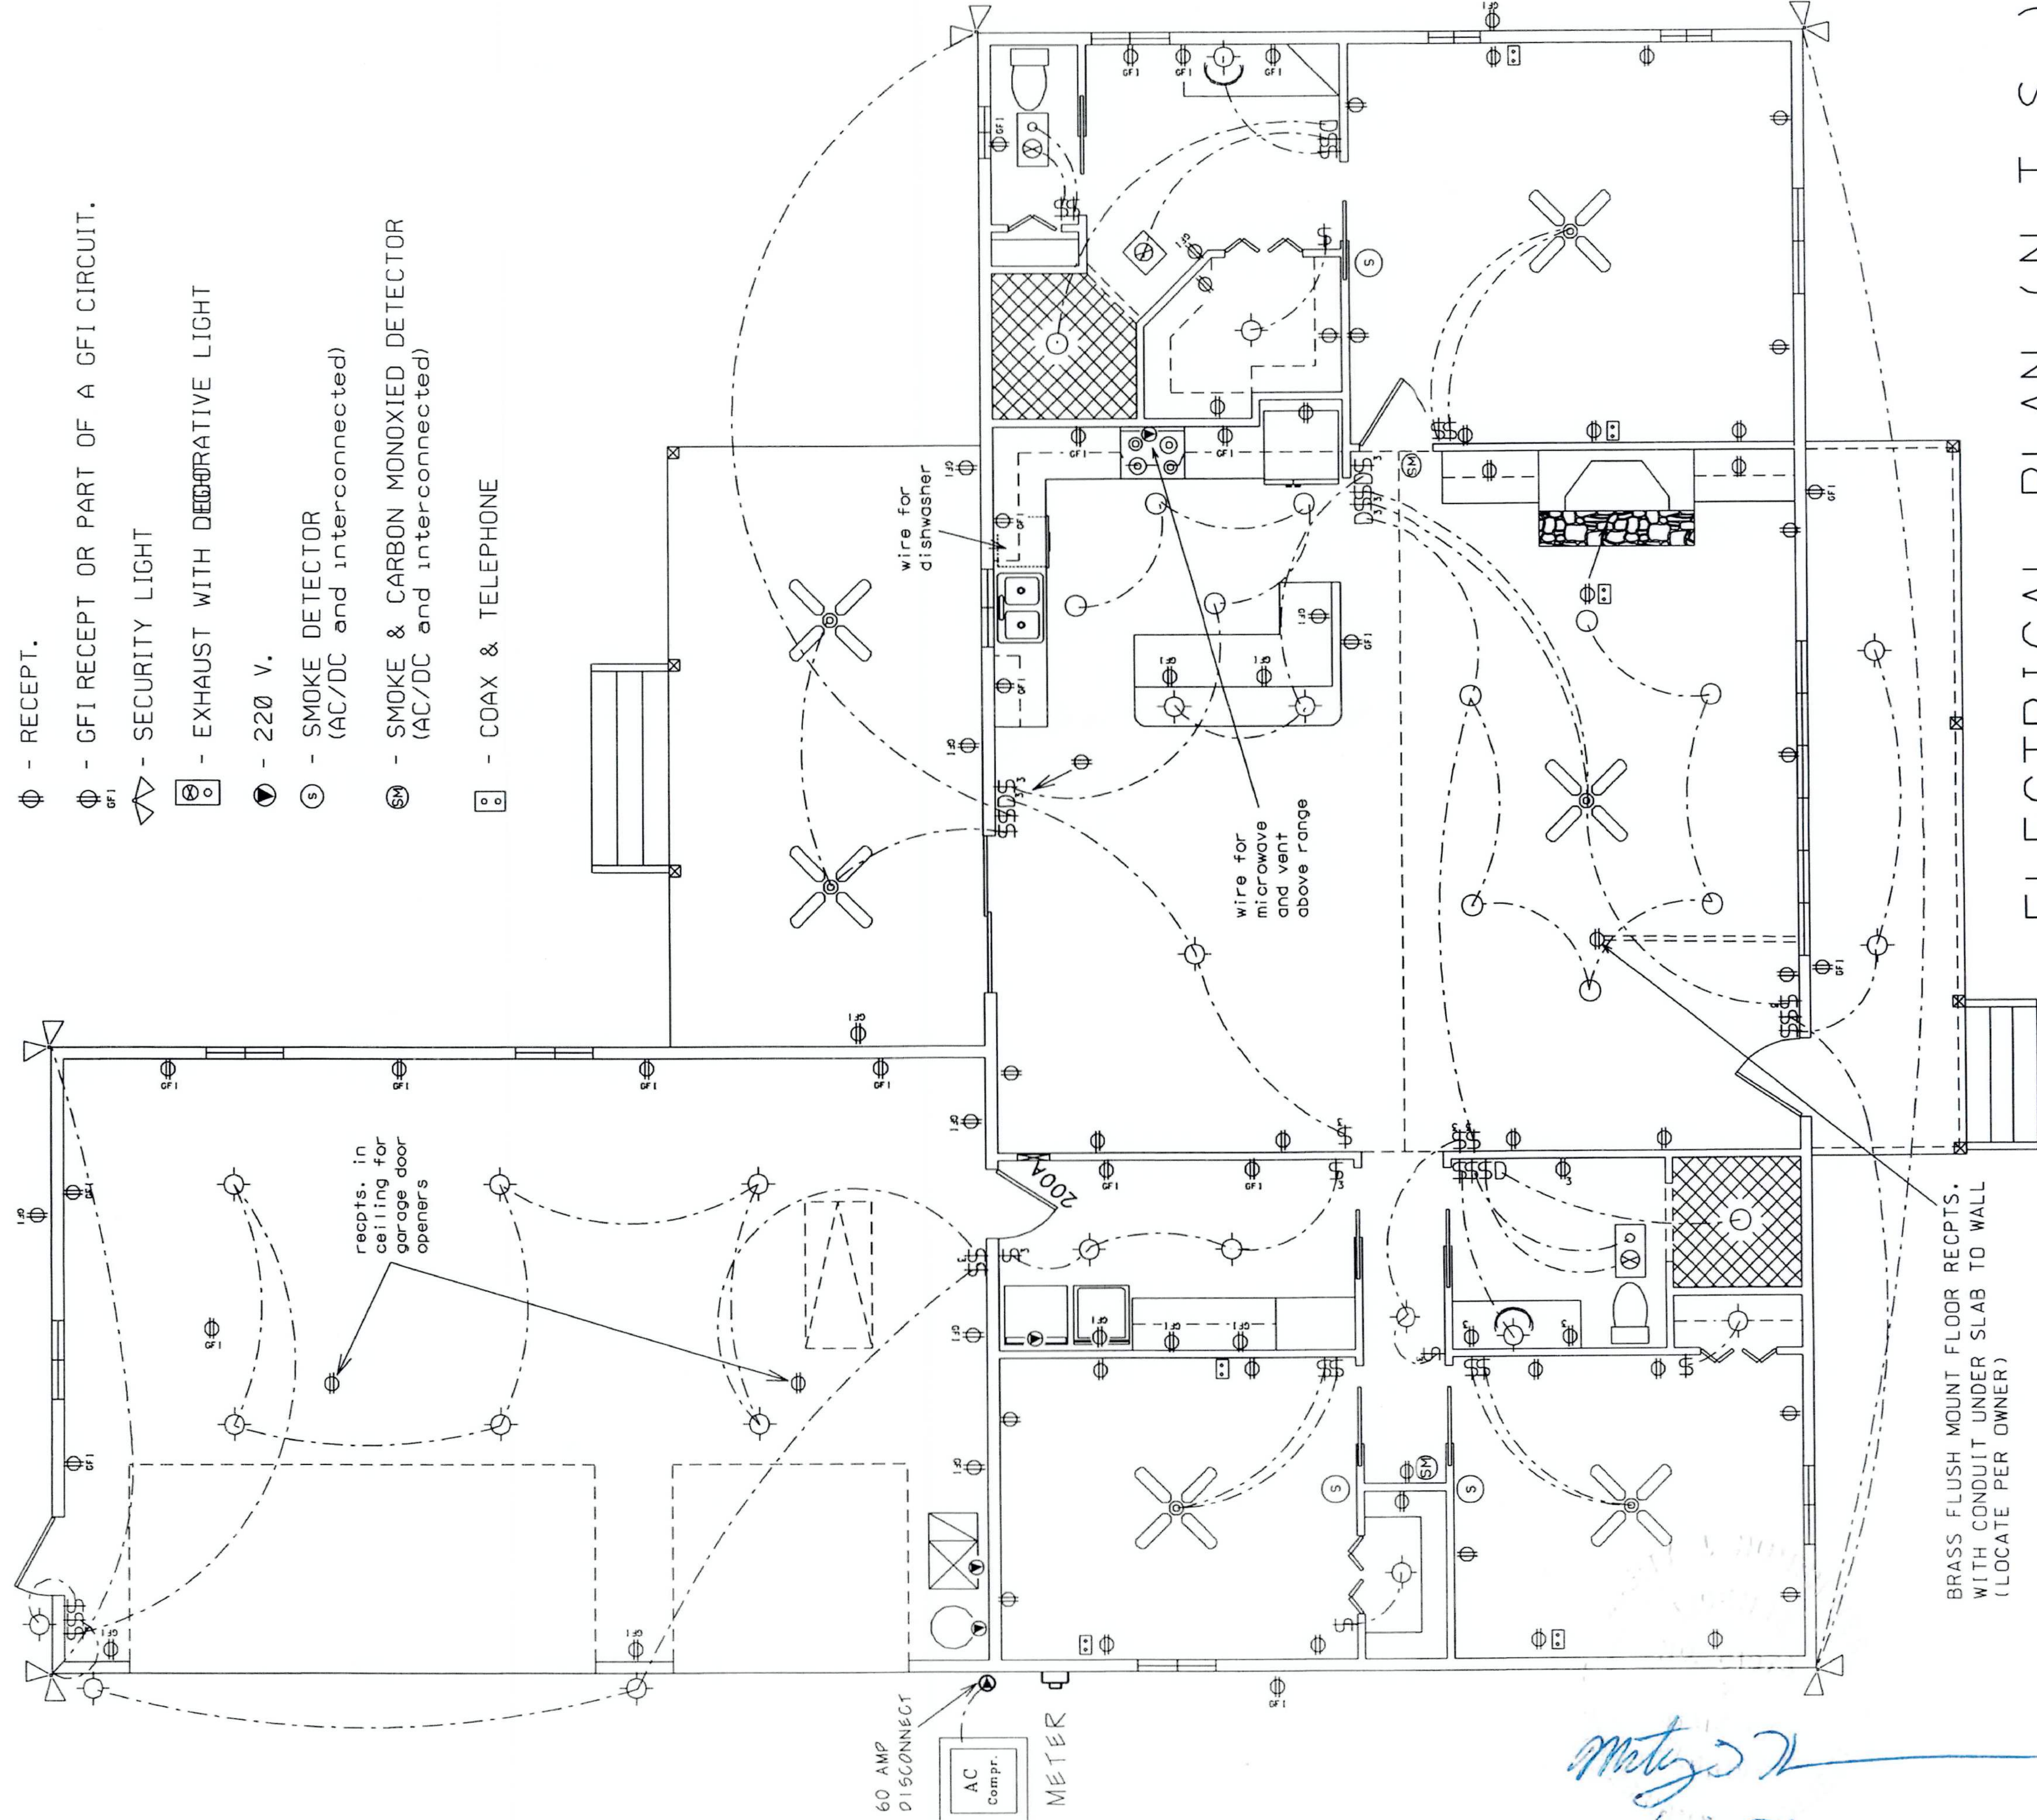

ELECTRICAL PLAN (N.T.S.)

BRUNO RESIDENCE PLANS  
COLUMBIA COUNTY, FLORIDA

PLANS PREPARED BY:  
MARTY J. HUMPHRIES P.E. # 51976  
7932 240TH ST., O'BRIEN, FL 32071

SHEET  
10  
OF  
10

B