



MF

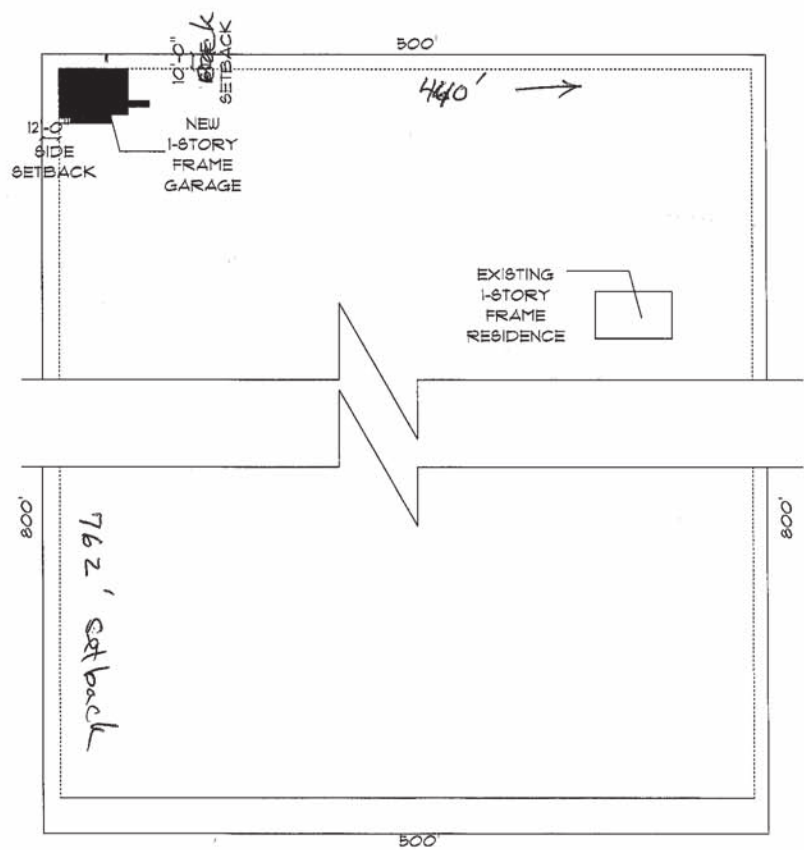

*** SITE PLAN ***
 SCALE : 1" = 40'-0"

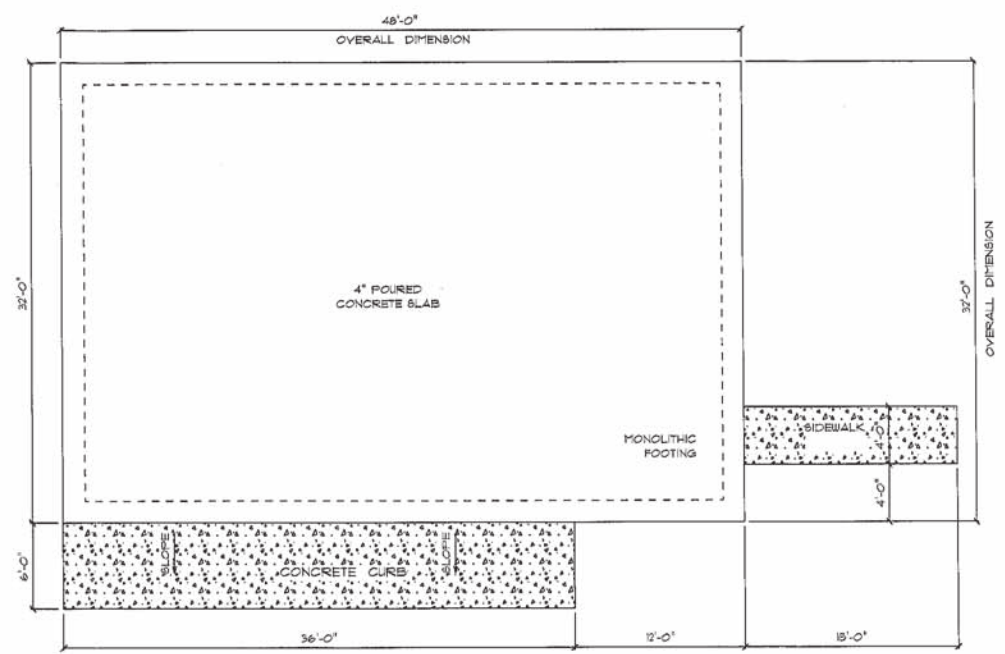


*** FOUNDATION PLAN ***
 SCALE : 1/4" = 1'-0"

IMPORTANT NOTES:
 1. IT IS THE BUILDER'S RESPONSIBILITY TO VERIFY ALL GEOMETRY AND DIMENSIONS BEFORE ORDERING ANY MATERIALS OR BEGINNING CONSTRUCTION.
 2. THESE PLANS ARE FOR LAYOUT AND DESIGN PURPOSES ONLY. ALL STRUCTURAL NOTES AND DETAILS TO BE PROVIDED BY AN ENGINEER.
 3. ALL EXTERIOR WALLS TO BE 2x6


GARAGE	
for	
LUN MARC	
485 DARWIN GLEN LAKE CITY, FLORIDA	
TERRY H. BLAIR 2000 82 44 41 Lake City, Florida 32009 Cell: 786.571.8871 Fax: 786.571.8871 Email: terryh@terryh.com	
PRINTED DATE	MOODY, NOVEMBER 2, 2023
DRAWN BY	CHECKED BY
TERRY H. BLAIR	
REGISTERED PROFESSIONAL	FLORIDA
DON REED CONSTRUCTION	
ISSUE DATE	
JOB NUMBER	
DRAWING NUMBER	
A-1	
OF 1 SHEETS	

mtl

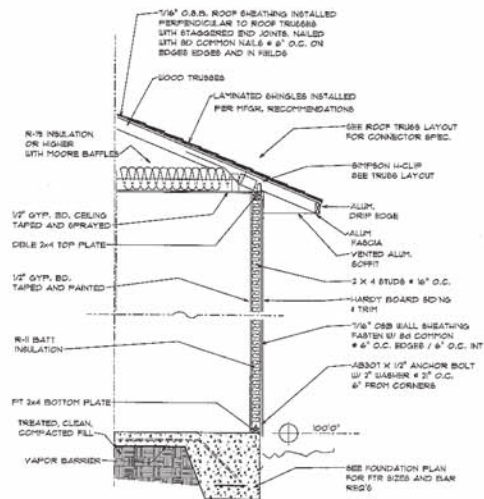

TYPICAL WALL SECTION

N.T.S.

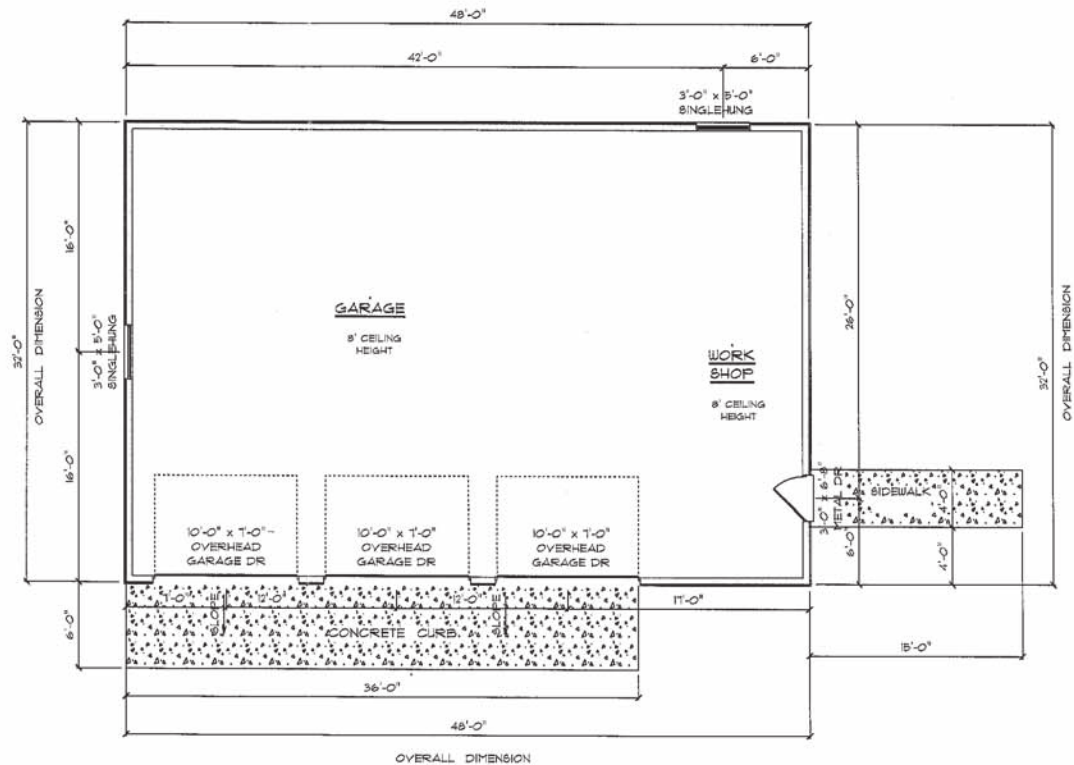

• FLOOR PLAN •

SCALE : 1/4" = 1'-0"

TOTAL COVERED AREA = 1536 S.F.


GARAGE
for
LUEN MARC

485 DARWIN GLEN
LAKE CITY FLORIDA


Tampa FL 33610
2505 50th St. #1
Lake City, Florida 33605
Cell: (813) 881-1736
Email: luenuy@comcast.net

PRINTED DATE: Monday, November 2, 2009	
DRAWN BY: Tampa FL 33610	CHECKED BY:
BUILDING CONTRACTOR DOCK REED CONSTRUCTION	
FINAL DATE:	
JOB NUMBER:	
DRAWING NUMBER A-2	
OF 4 SHEETS	


mad

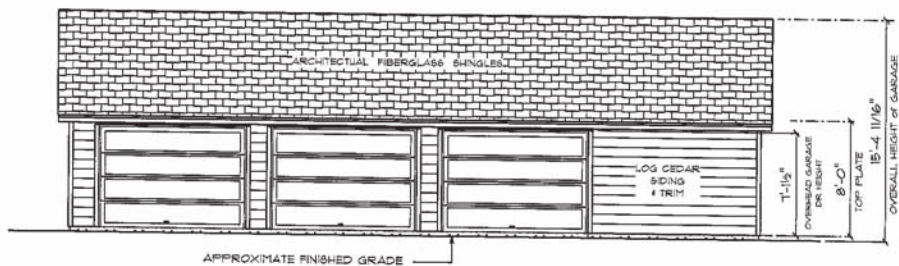

• FRONT ELEVATION •
SCALE : 1/4" = 1'-0"

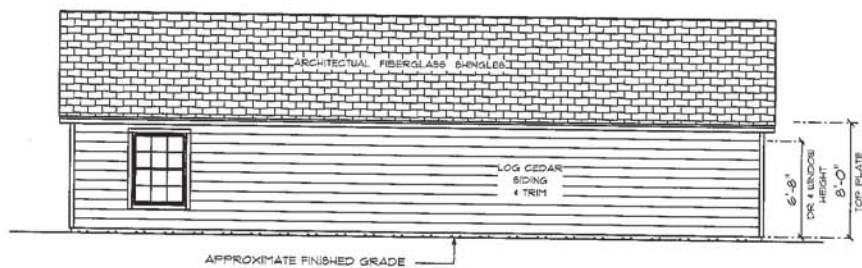

• REAR ELEVATION •
SCALE : 1/4" = 1'-0"

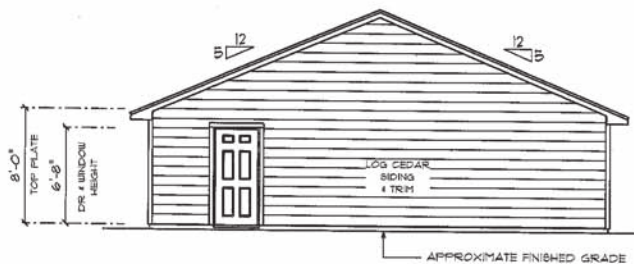

• RIGHT SIDE ELEVATION •
SCALE : 1/4" = 1'-0"



• LEFT SIDE ELEVATION •
SCALE : 1/4" = 1'-0"

**GARAGE
for
LUEN MARC**

488 DARWIN GLEN
LAKE CITY FLORIDA

Teresa H. Ruffo
2015 SU DR 47
Lake City, Florida 32025
Cell: (386) 881-1196
Email: luenmarc@aol.com

ISSUED DATE:
Monday, November 2, 2020

DESIGN BY: THERESA H. RUFFO
CHECKED BY: THERESA H. RUFFO

CONSTRUCTION:
DON REED CONSTRUCTION

TRAINED DATE: _____
JOB NUMBER: _____

DRAWING NUMBER:
A-3


OF 4 SHEETS

m f j

ELECTRICAL LEGEND		
ELECTRICAL	COUNT	SYMBOL
fluorescent light 1 x 4	6	
exterior light 03	4	
electrical panel	1	
automatic garage dr opener	3	
garage dr opener	3	
outlet gfi	12	
switch	3	

ELECTRICAL PLAN NOTES

- B-1 ALL INSTALLATIONS SHALL BE PER NATIONAL ELECTRIC CODE.
- B-2 ELECTRICAL CONTRACTOR SHALL BE RESPONSIBLE FOR THE DESIGN AND SIZING OF ELECTRICAL SERVICE AND CIRCUITS.
- B-3 ENTRY OF SERVICE UNDERGROUND OR OVERHEAD IS TO BE DETERMINED BY THE POWER COMPANY.
- B-4 75% OF ALL PERMANENT LIGHTS TO BE ENERGY EFFICIENT.

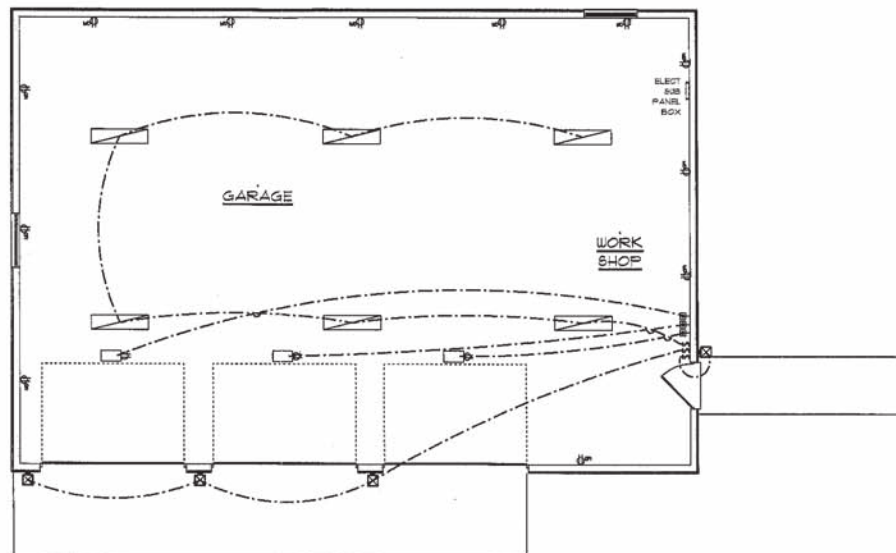

ELECTRICAL PLAN

SCALE : 1/4" = 1'-0"

GARAGE
for
LUEN MARC

488 DARWIN GLEN
LAKE CITY FLORIDA

Team: T. Ruffo
2025 03 04
Lake City, Florida 33508
Cell: (262) 661-1910
Email: lumenforluc@gmail.com

PRINTED DATE:
Monday, November 2, 2025

DRAWN BY: lumenforluc@gmail.com

Team: T. Ruffo

Building Contractor:

DO NOT NEED CONSTRUCTION

PROJECT DATE:

JOB NUMBER:

DRAWING NUMBER:

A-4

OF 4 SHEETS