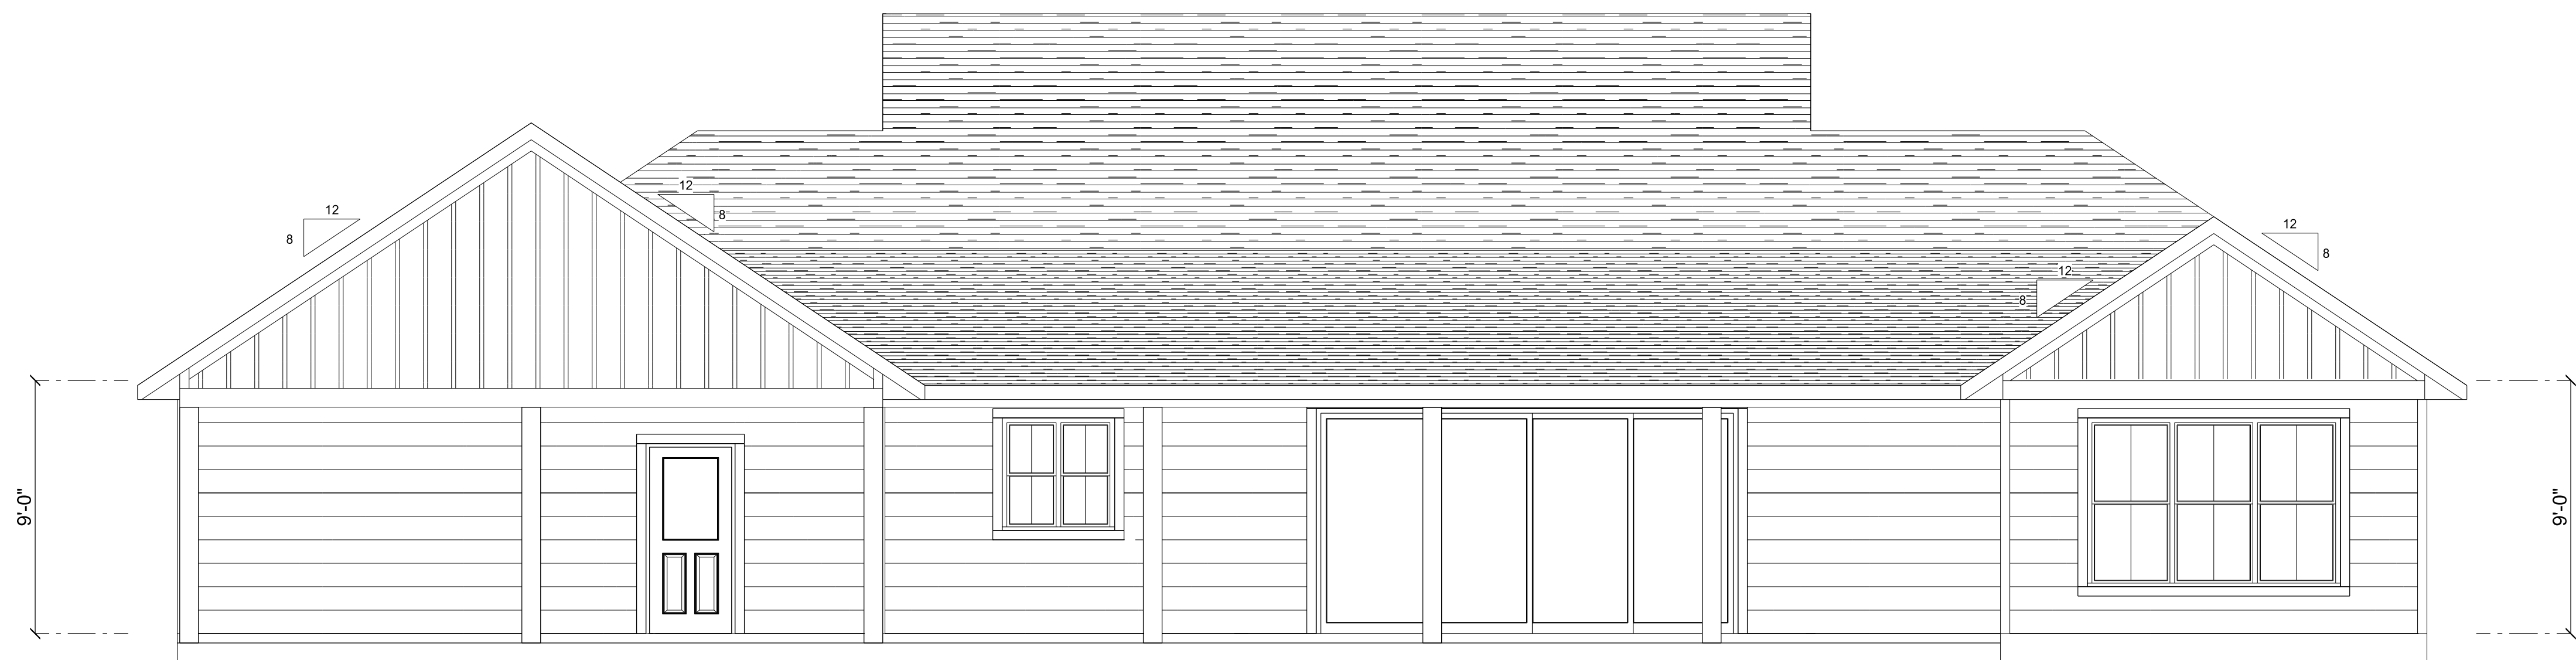




FRONT ELEVATION
SCALE: 1/4" = 1'-0"



REAR ELEVATION
SCALE: 1/4" = 1'-0"





REVISIONS SCHEDULE		
May 10th, 2023	Proposal Drawing	
June 21st, 2023	Revisions	

CONSTRUCTION LLC
818 W DUVAL ST, LAKE CITY, FL 32055

CUSTOM HOME FOR:
MEREDITH RESIDENCE
COLUMBIA COUNTY, FLORIDA

RIDGEPOINT
DESIGN
566 SW ARLINGTON BLVD, STE 101, LAKE CITY, FL 32025
P: 386-288-1188
E: RIDGEPOINTDESIGN@GMAIL.COM

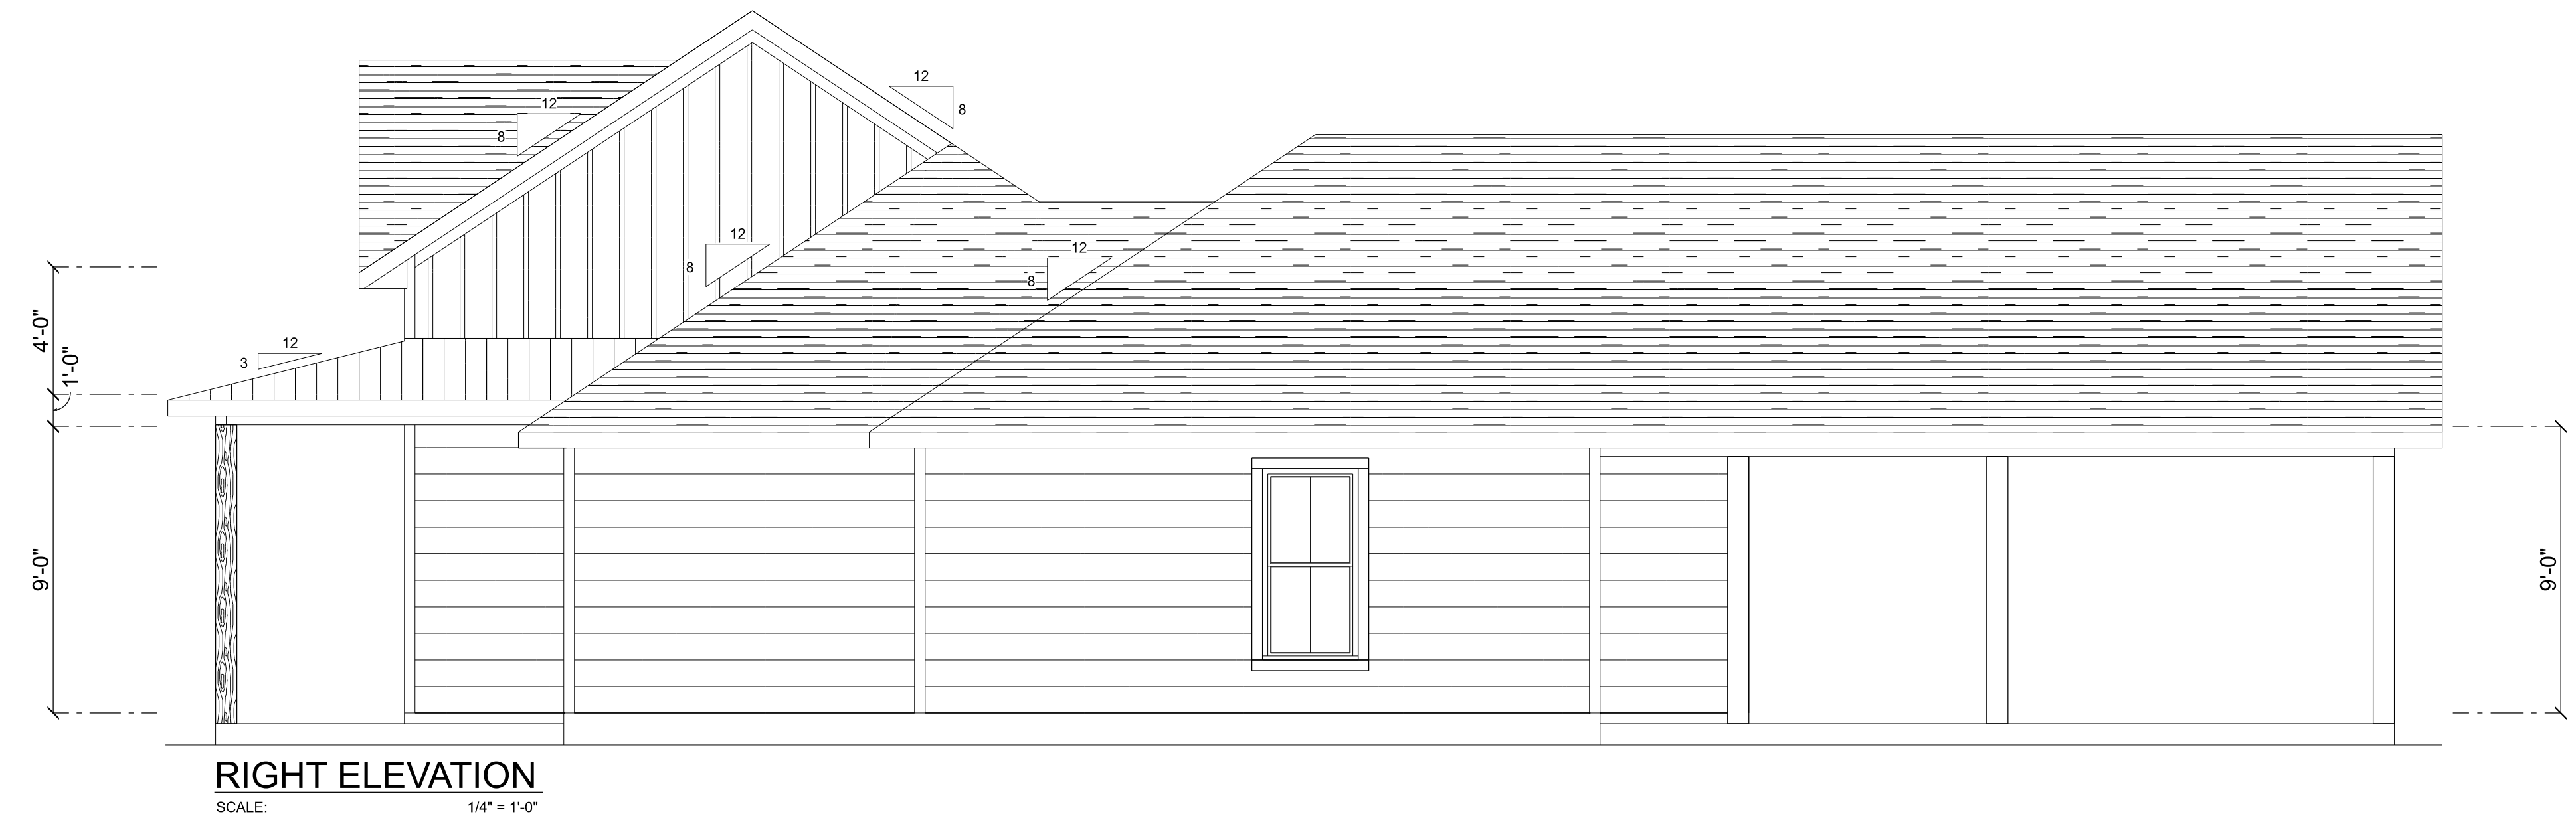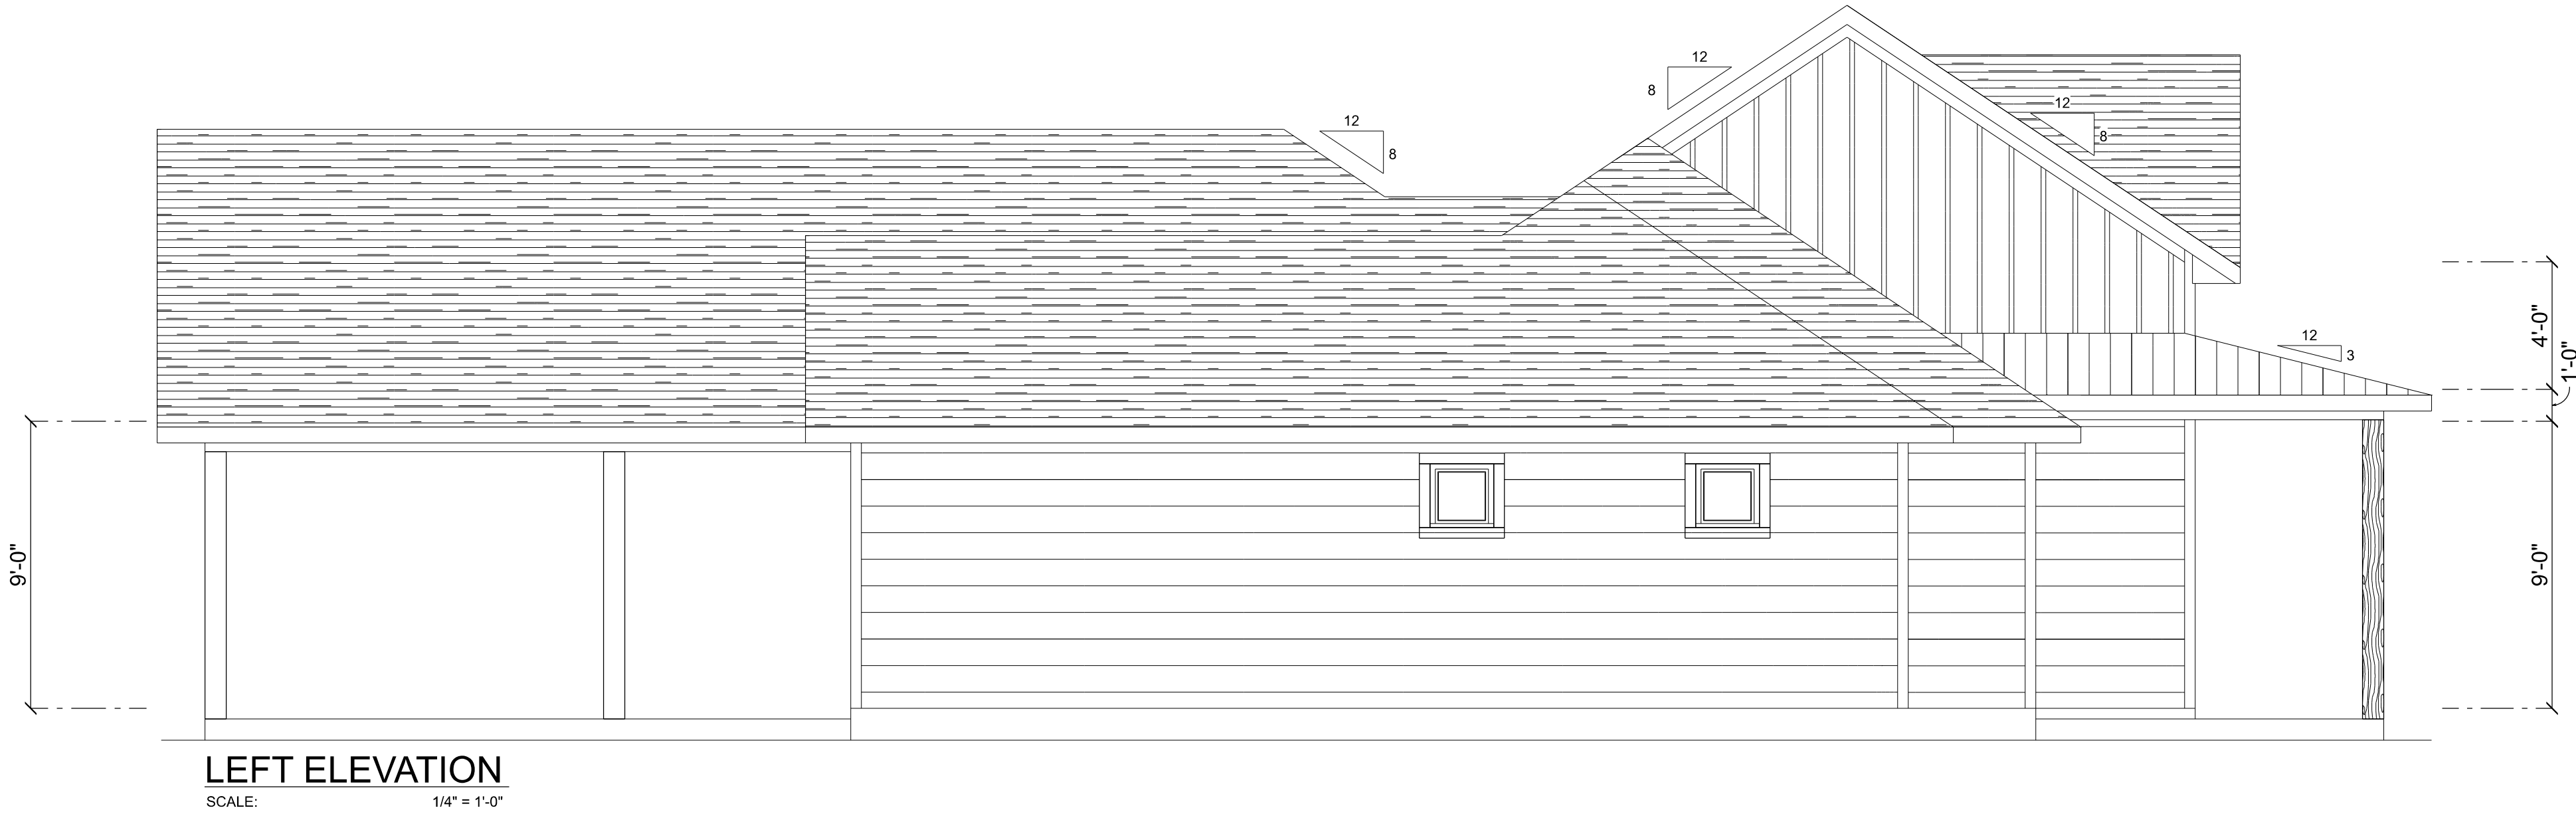SHEET NUMBER
A.1
OF 4 SHEETS




REVISIONS SCHEDULE	
May 10th, 2023	Proposal Drawing
June 21st, 2023	Revisions




CONSTRUCTION LLC
818 W DUVAL ST, LAKE CITY, FL 32055

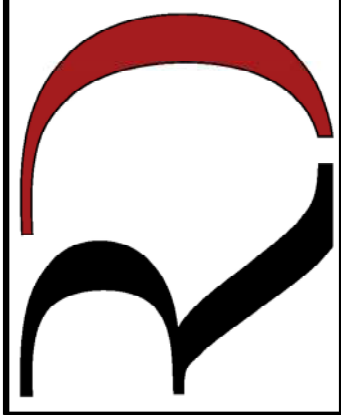CUSTOM HOME FOR:
MEREDITH RESIDENCE
COLUMBIA COUNTY, FLORIDA



RIDGEPOINT
DESIGN
566 SW ARLINGTON BLVD. STE 101, LAKE CITY, FL 32025
P: 386-288-1188
E: RIDGEPOINTDESIGN@GMAIL.COM

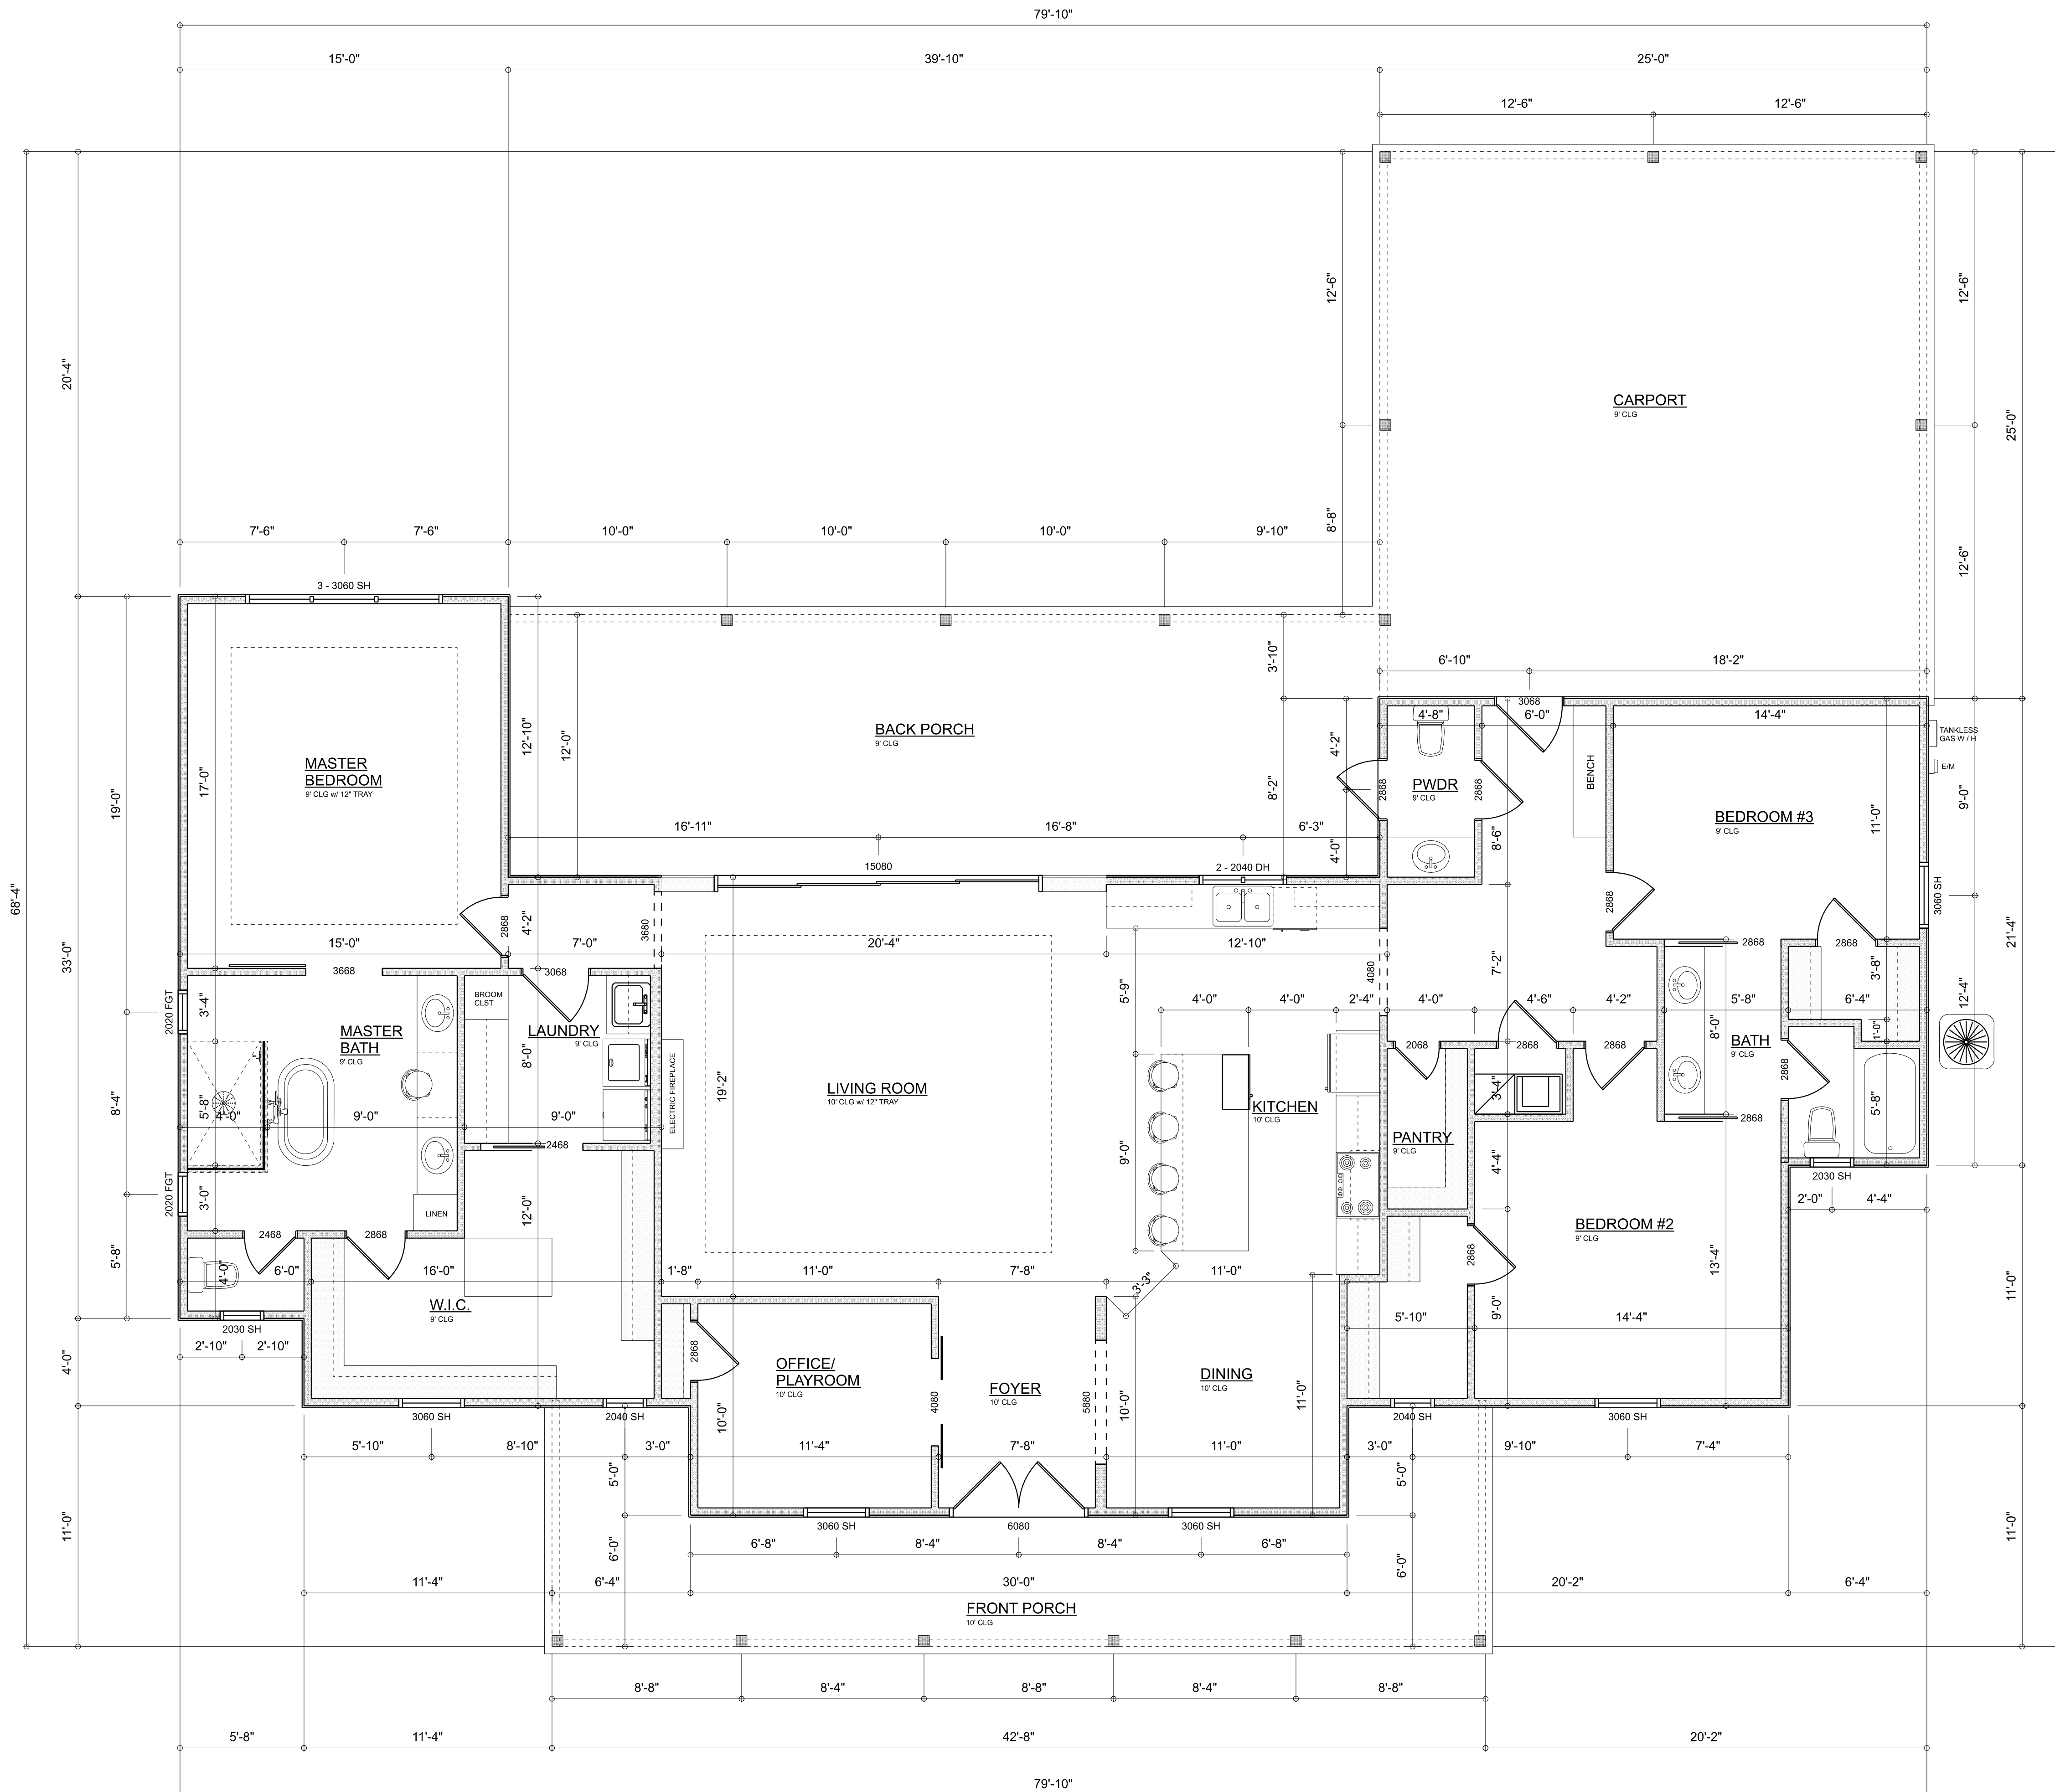SHEET NUMBER
A.2
OF 4 SHEETS



DIMENSIONED FLOOR PLAN
SCALE: 1/4" = 1'-0"

AREA SUMMARY		
LIVING	2,384	S.F.
FRONT PORCH	340	S.F.
BACK PORCH	478	S.F.
GARAGE	629	S.F.
TOTAL AREA	3,831	S.F.








REVISIONS SCHEDULE		
May 10th, 2023	Proposal Drawing	
June 21st, 2023	Revisions	



CUSTOM HOME FOR:
MEREDITH RESIDENCE
COLUMBIA COUNTY, FLORIDA




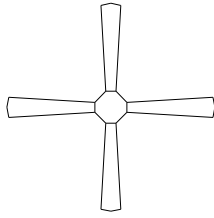      SHEET NUMBER
A.3
OF 4 SHEETS

ELECTRICAL LEGEND		
ELECTRICAL	COUNT	SYMBOL
CEILING FAN	7	
CAN LIGHT 6inch	47	
CHANDELIER	2	
LED CEILING LIGHT 1x4	3	
PENDANT LIGHT	3	
MOTION SECURITY LIGHT	5	
ELECTRIC PANEL	1	
AC DISCONNECT	2	
CABLE TV OUTLET	6	
CARBON DETECTOR	2	
EXHAUST FAN	3	
OUTLET	34	
OUTLET 220v	2	
OUTLET GFI	13	
OUTLET WP	5	
SMOKE DETECTOR	6	
STANDARD LIGHT	1	
SWITCH	30	
SWITCH 3 WAY	27	
VANITY BAR LIGHT - SMALL	5	

ELECTRICAL PLAN NOTES:

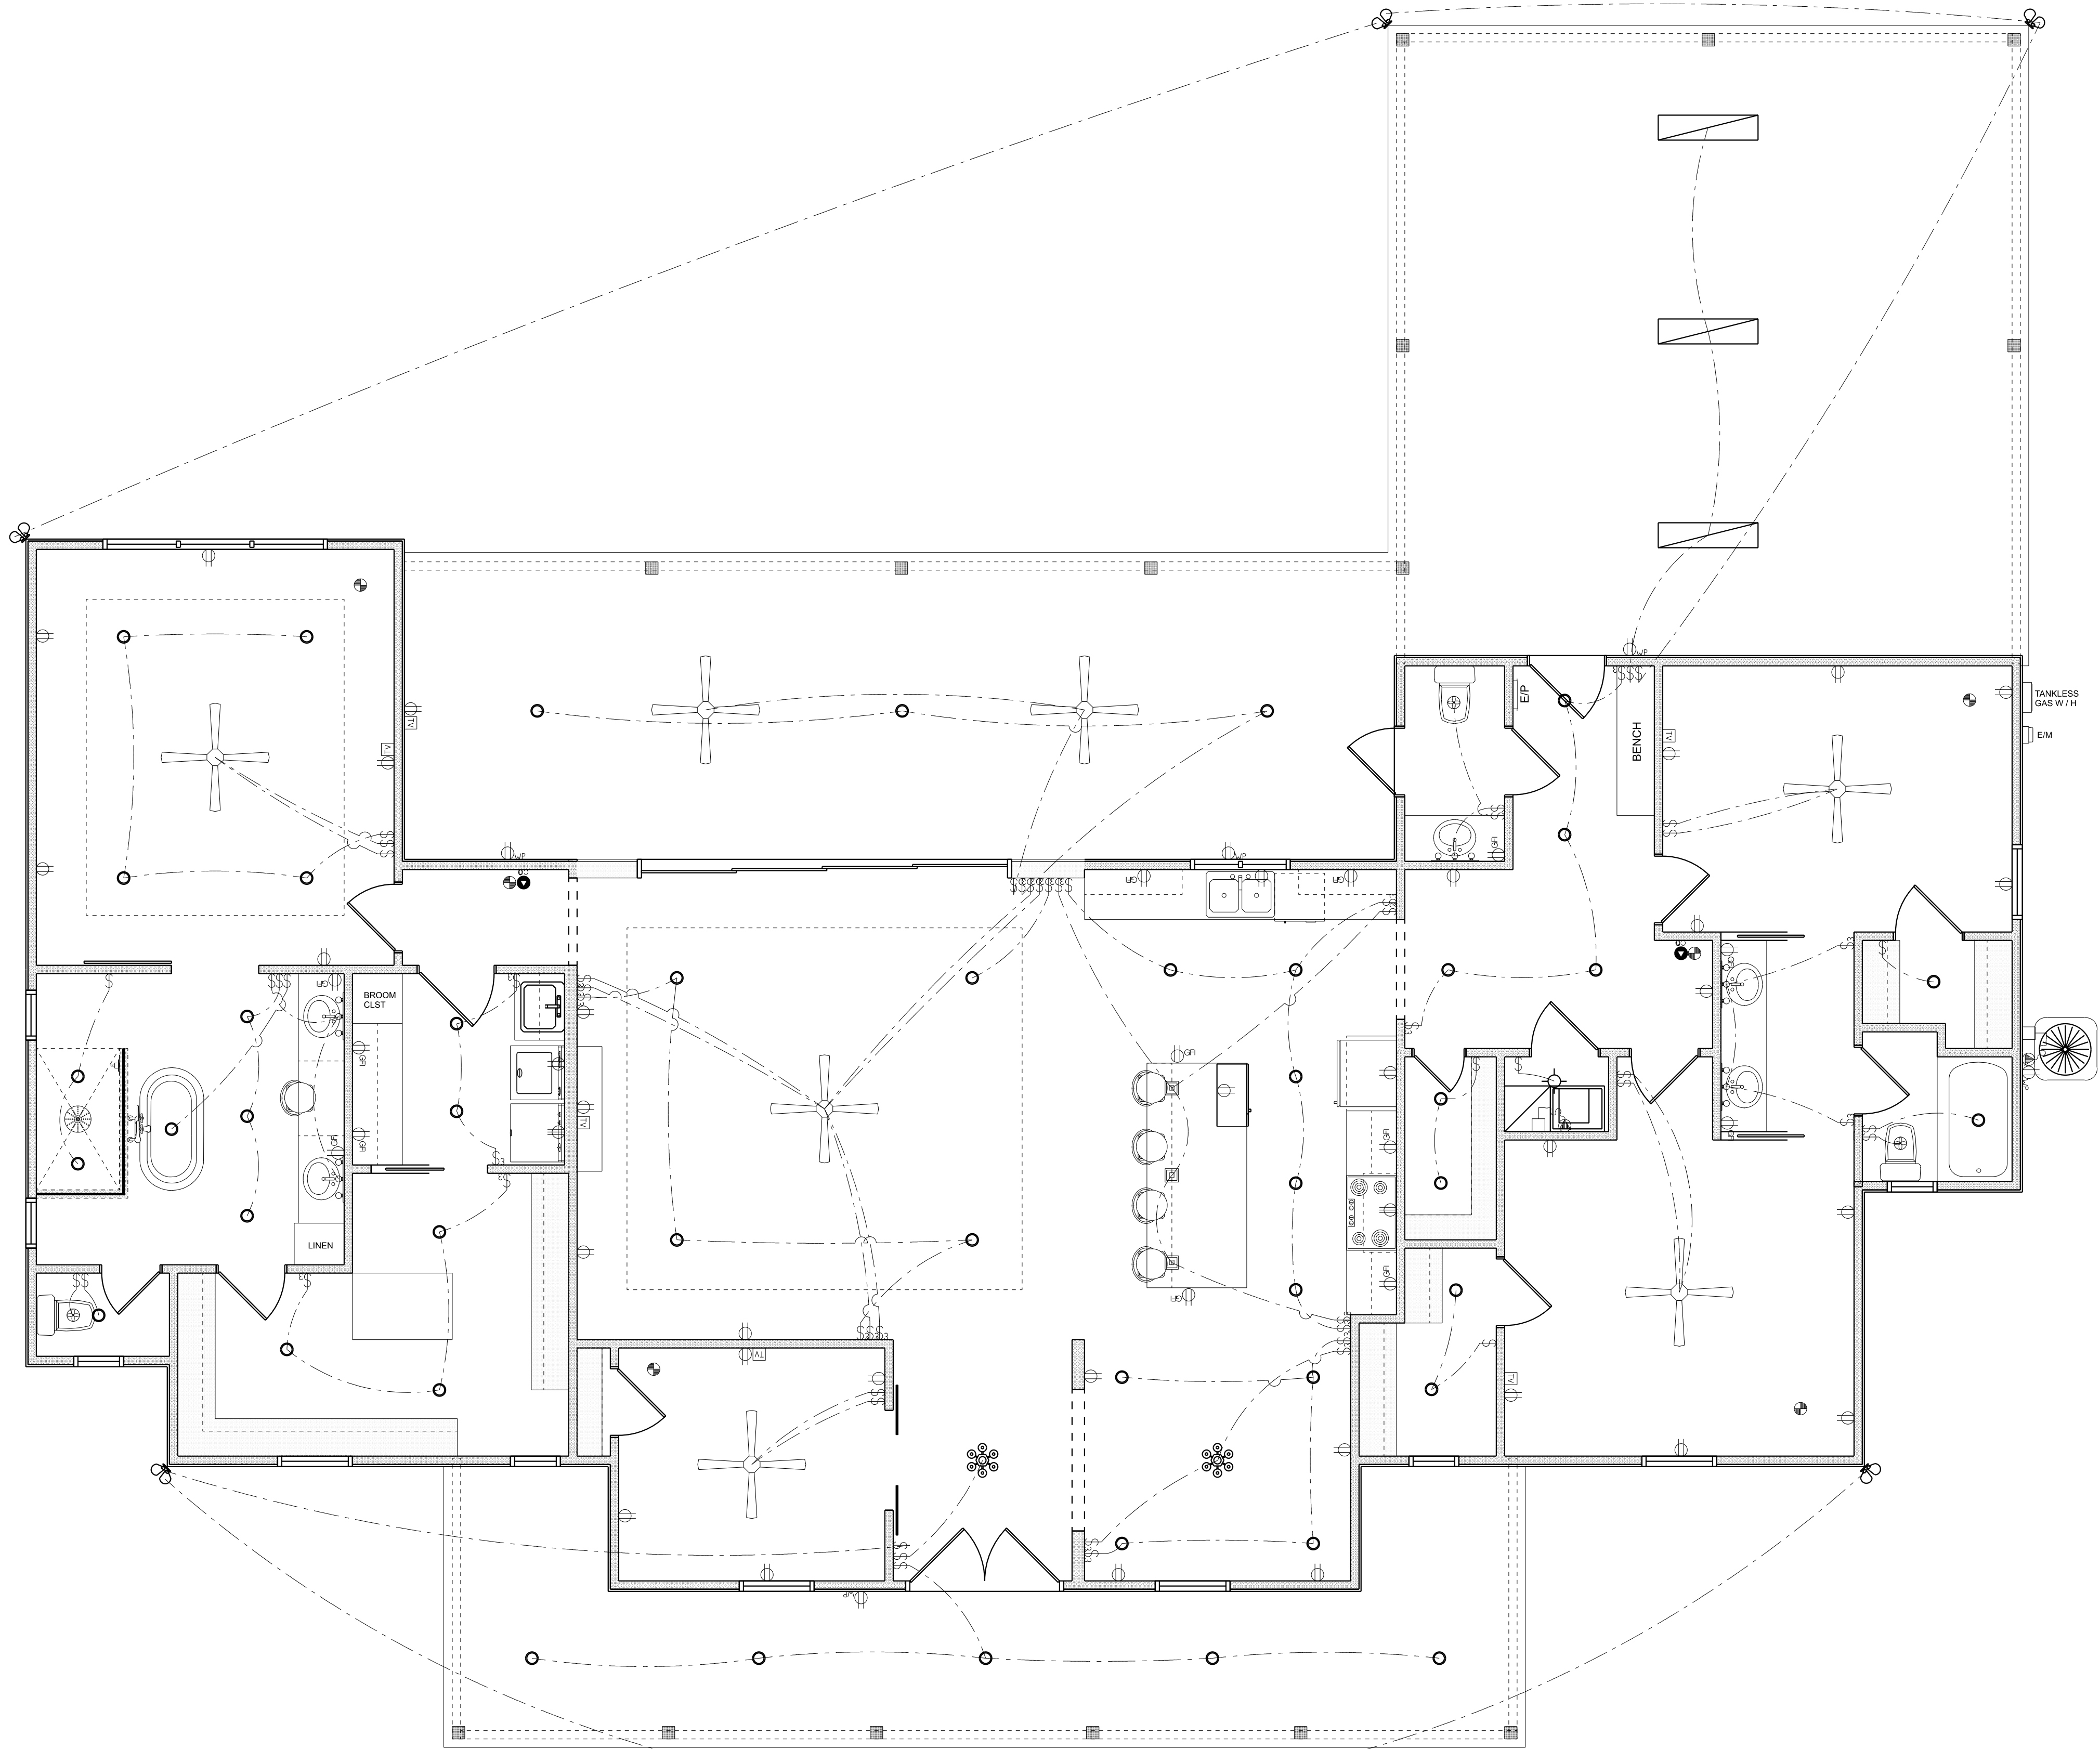- INSTALLATION SHALL BE PER LATEST NAT'L ELECTRIC CODE.
- WIRE ALL APPLIANCES, HVAC UNITS AND OTHER EQUIPMENT PER MANUF. SPECIFICATIONS
- CONSULT WITH THE OWNER FOR THE NUMBER OF SEPERATE TELEPHONE LINES TO BE INSTALLED
- ALL SMOKE DETECTORS SHALL BE 120v W/ BATTERY BACKUP OF THE PHOTOELECTRIC TYPE, AND SHALL BE INTERLOCKED TOGETHER. INSTALL INSIDE AND NEAR ALL BEDROOMS
- TELEPHONE, TELEVISION AND OTHER LOW VOLTAGE DEVICES OR OUTLETS SHALL BE AS PER THE OWNER'S DIRECTIONS, & IN ACCORDANCE W/ APPLICABLE SECTIONS OF NEC-LATEST EDITION.
- ALL RECEPTALS, NOT OTHERWISE NOTED, SHALL BE ARC FAULT INTERRUPTER TYPE, EXCEPT DEDICATED OUTLETS
- ALL RECEPTALS IN WET AREAS SHALL BE GROUND FAULT INTERRUPTER TYPE (GFI)
- ALL EXTERIOR RECEPTALS SHALL BE WEATHERPROOF GROUND FAULT INTERRUPTER TYPE (WP/GFI)
- NOTE:
ELECTRICAL CONT'R SHALL PREPARE "AS-BUILT" SHOP DWGS INDICATING ALL ELECTRICAL WORK, INCLUDING ANY CHANGES TO THE ELEC. PLAN, ADD'NS TO THE ELEC. PLAN, RISER DIAGRAM, AS-BUILT PANEL SCHEDULE W/ ALL CKTS IDENTIFIED W/ CKT N°. DESCRIPTION & BRKR. SERVICE ENT. & ALL UNDERGROUND WIRE LOCATIONS/ROUTING / DEPTH. RISER DIA. SHALL INCLUDE WIRE SIZES/TYPE & EQUIPMENT TYPE W/ RATINGS & LOADS.
CONTRACTOR SHALL PROVIDE 1 COPY OF AS-BUILT DWGS TO OWNER & 1 COPY TO THE PERMIT ISSUING AUTHORITY



ELECTRICAL PLAN
SCALE: 1/4" = 1'-0"

REVISIONS SCHEDULE	
May 10th, 2023	Proposal Drawing
June 21st, 2023	Revisions



CONSTRUCTION LLC
818 W DUVAL ST, LAKE CITY, FL 32055

CUSTOM HOME FOR:
MEREDITH RESIDENCE
COLUMBIA COUNTY, FLORIDA



RIDGEPOINT
DESIGN

566 SW ARLINGTON BLVD, STE 101, LAKE CITY, FL 32025
P: 386-288-1188
E: RIDGEPOINTDESIGN@GMAIL.COM

SHEET NUMBER
A.4
OF 4 SHEETS