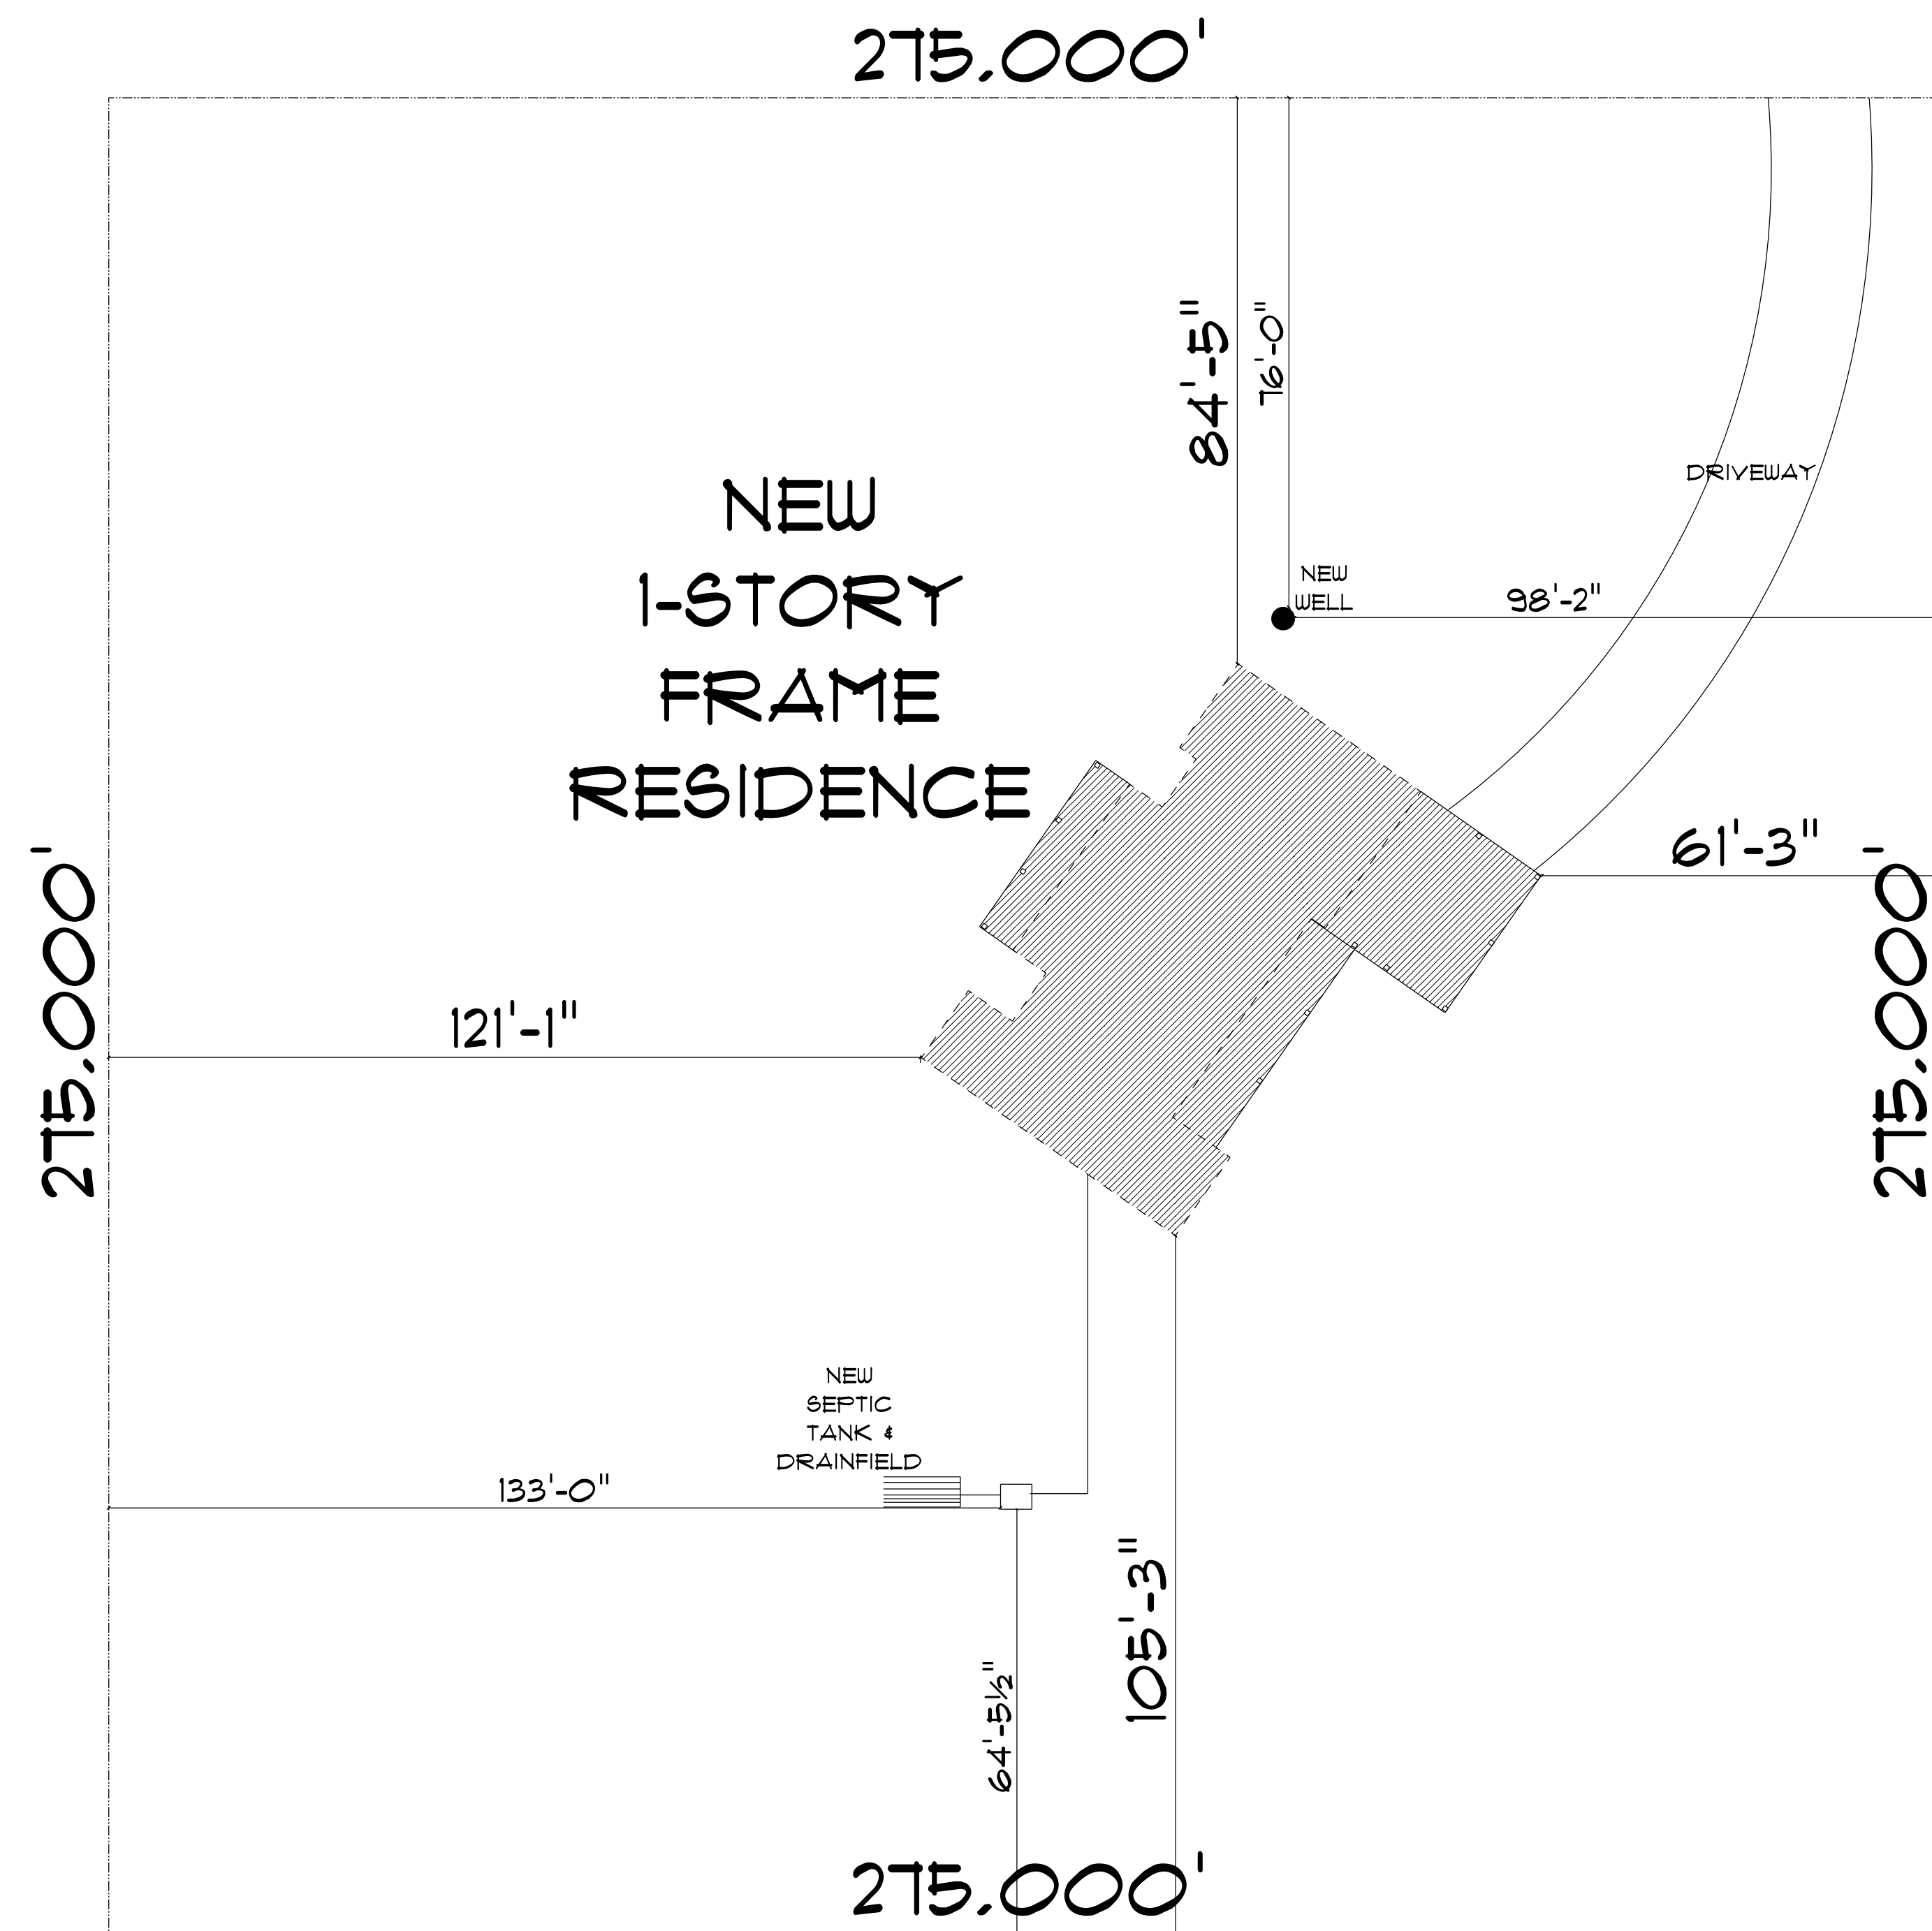
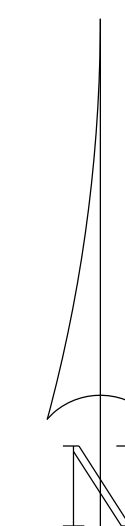




* SITE PLAN *

SCALE: 1" = 20'



NEW RESIDENCE
for
PHILIP & KATIE
GLOVER

Teena M. Ruffo
2925 SW SR 47
Lake City Florida, 32025
Cell: (386) 867-1191
Email: teenaruffo@gmail.com

PRINTED DATE:
Thursday, September 8, 2022

DRAWN BY: Teena M. Ruffo CHECKED BY:

BUILDING CONTRACTOR
BRYAN ZECHER CONSTRUCTION

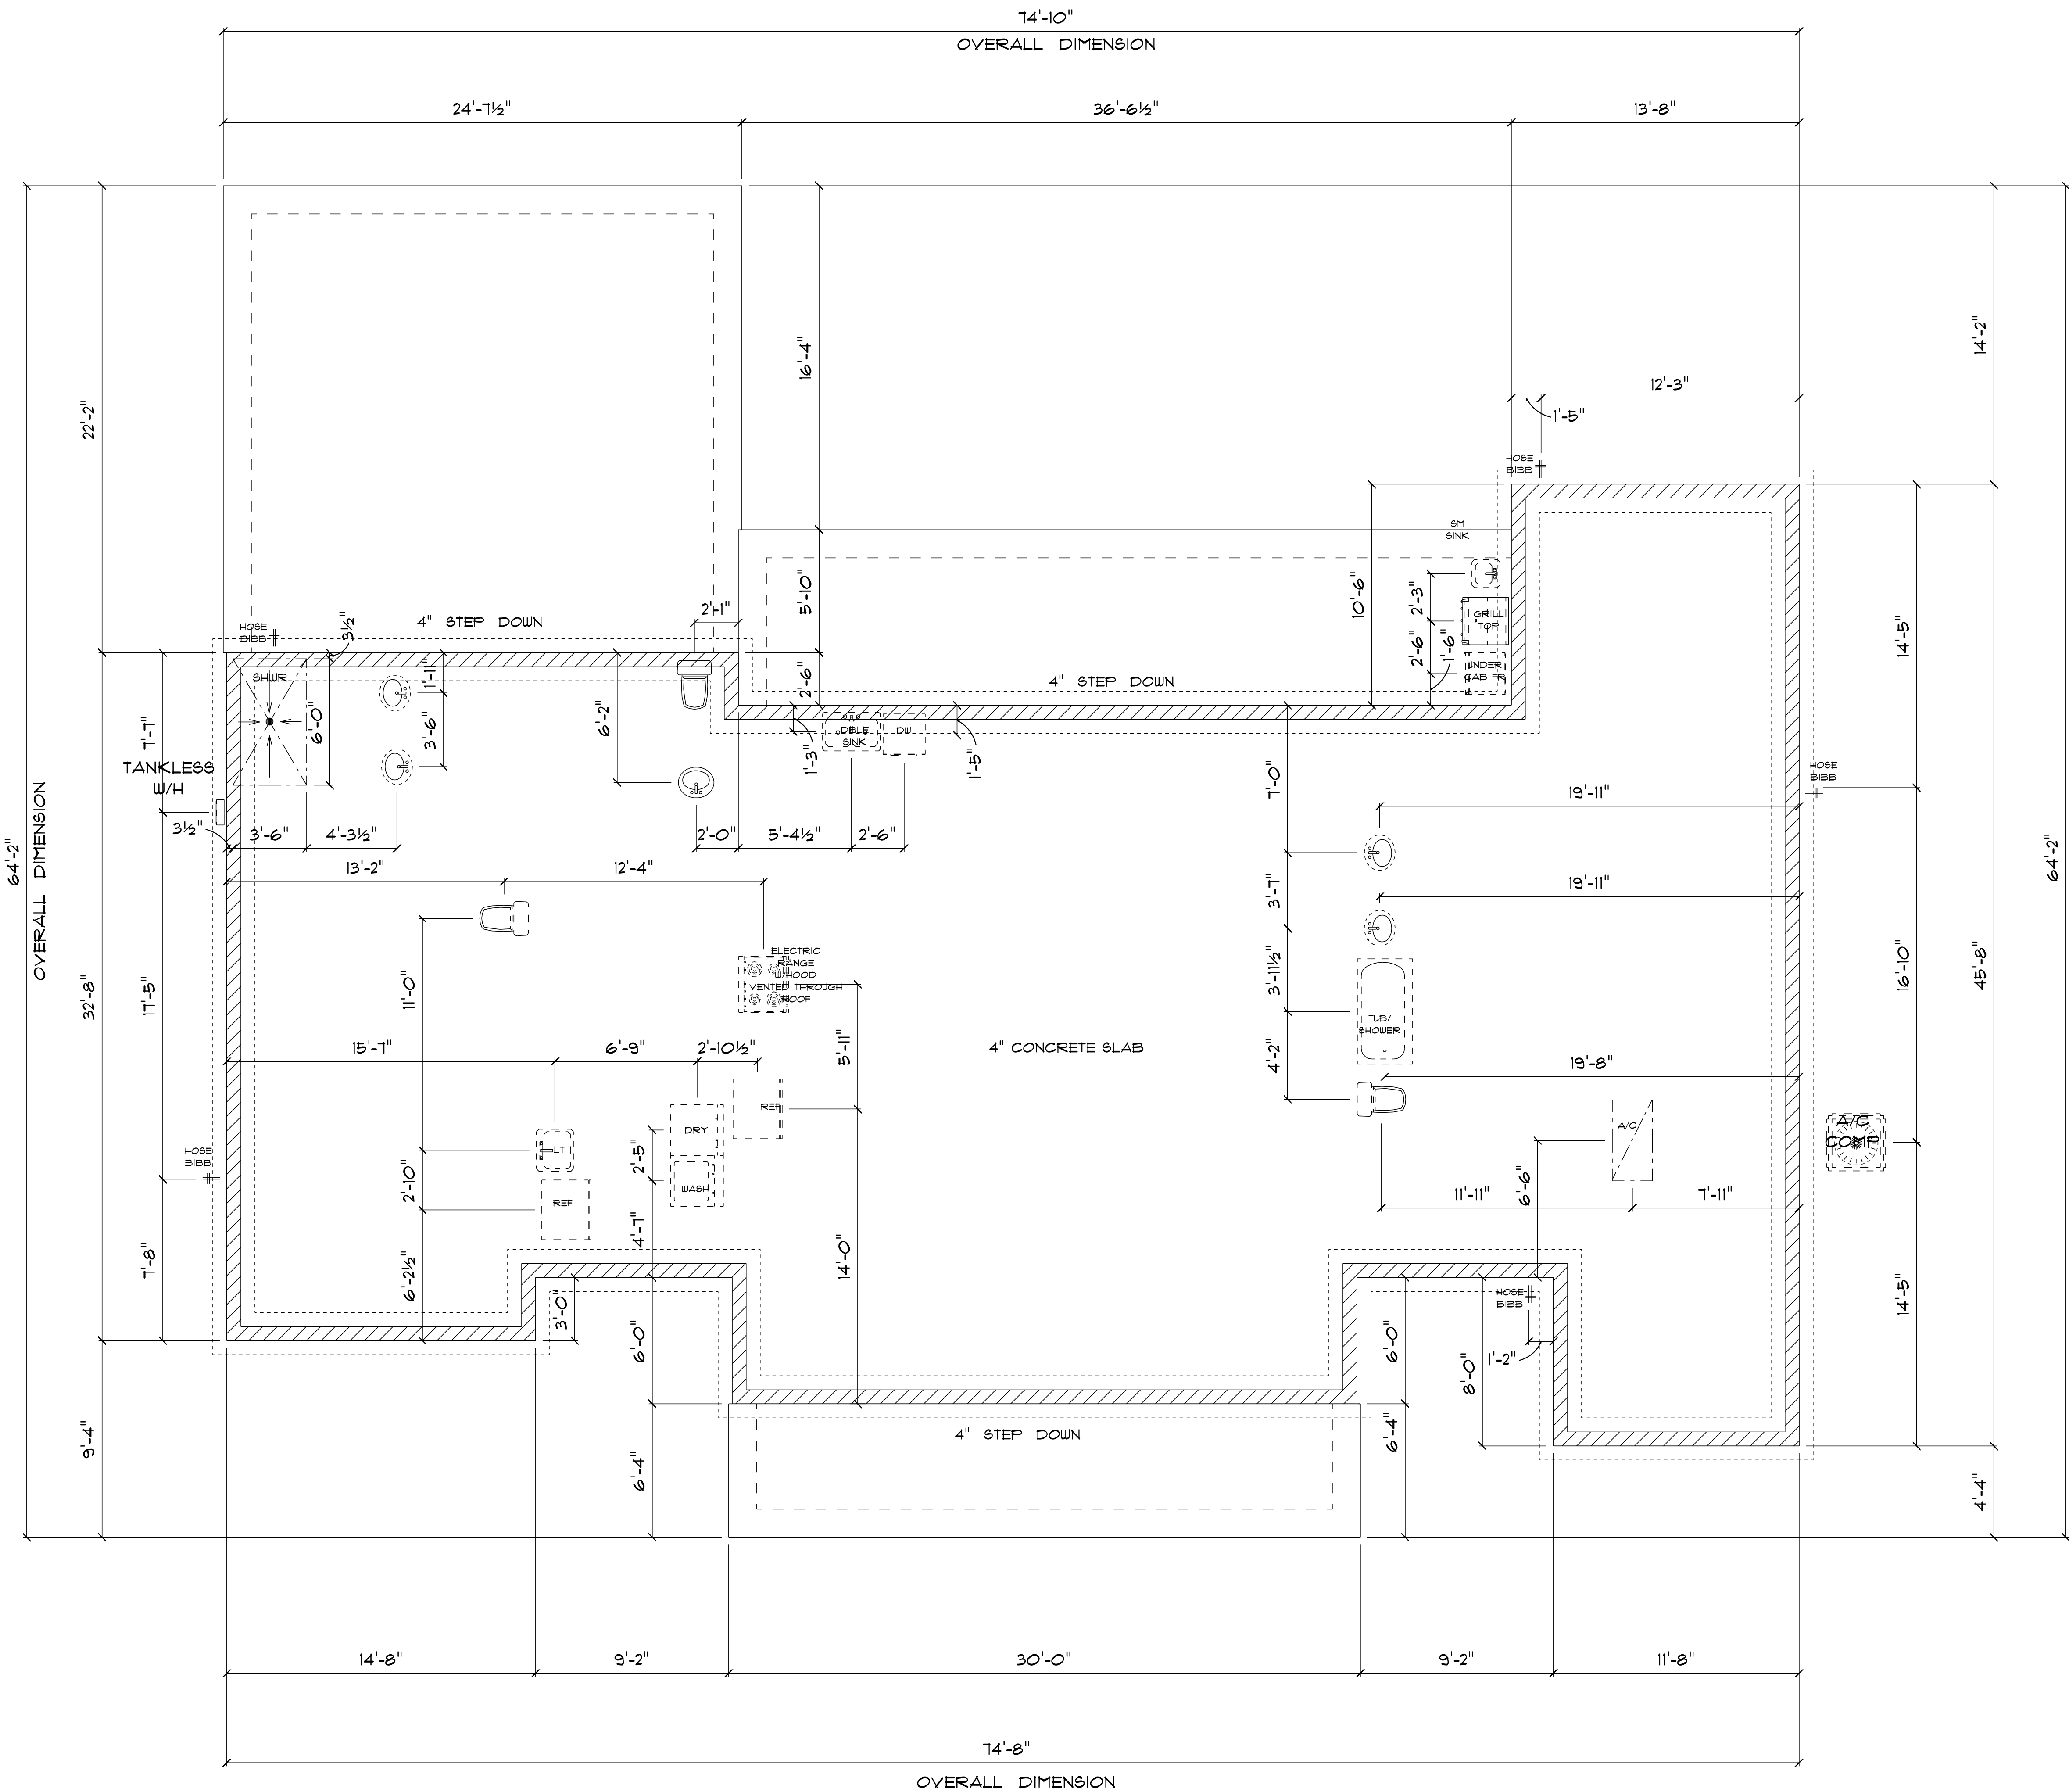
FINAL DATE:

JOB NUMBER:

DRAWING NUMBER

A-1

OF 6 SHEETS



*** PLUMBING/FOUNDATION
PLAN ***
SCALE : 1/4" = 1'-0"

IMPORTANT NOTES:
1. IT IS THE BUILDER'S RESPONSIBILITY TO VERIFY ALL GEOMETRY AND DIMENSIONS BEFORE ORDERING ANY MATERIALS OR BEGINNING CONSTRUCTION.
2. THESE PLANS ARE FOR LAYOUT AND DESIGN PURPOSES ONLY ALL STRUCTURAL NOTES AND DETAILS TO BE PROVIDED BY AN ENGINEER.

NEW RESIDENCE
for
PHILIP & KATIE
GLOVER

Teena M. Ruffo
2925 SW 8R 41
Lake City Florida, 32025
Cell: (386) 867-1191
Email: teenaruffo@gmail.com

PRINTED DATE:
Thursday, September 8, 2022

DRAWN BY: Teena M. Ruffo CHECKED BY:

BUILDING CONTRACTOR
BRYAN ZECHER CONSTRUCTION

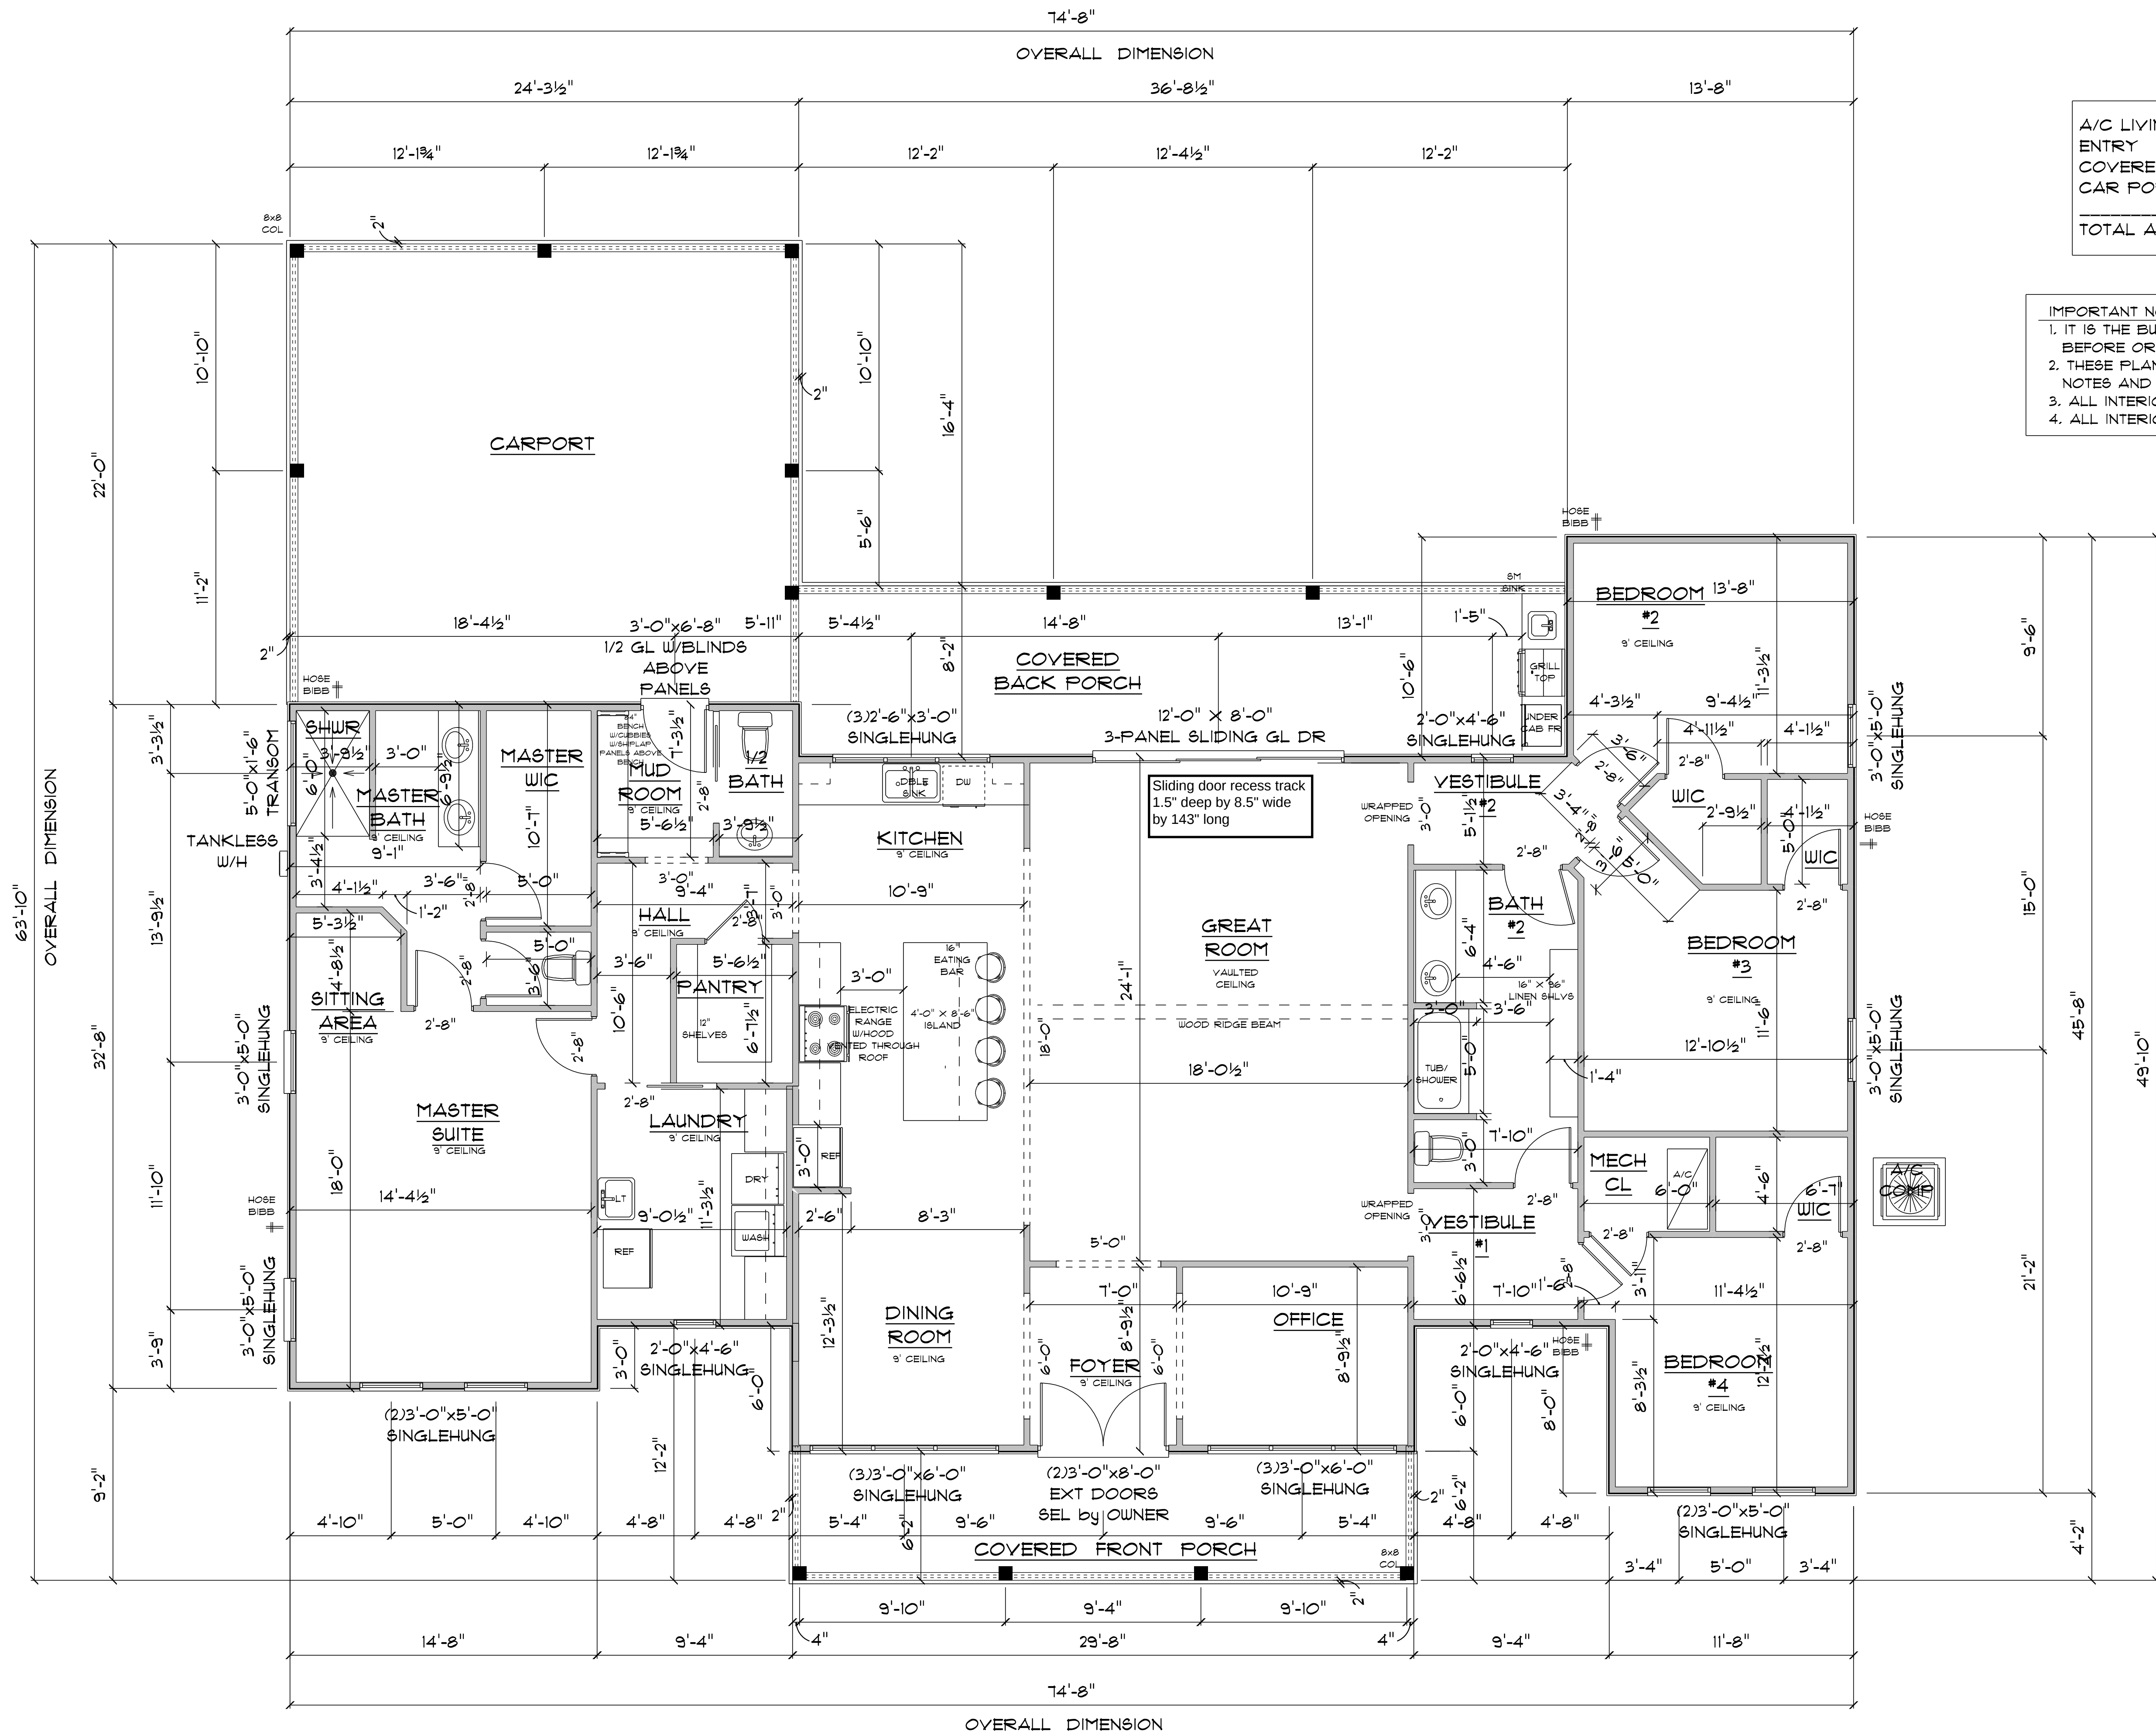
FINAL DATE:

JOB NUMBER:

DRAWING NUMBER

A-2

OF 6 SHEETS



A/C LIVING AREA	=	2548 S.F.
ENTRY	=	179 S.F.
COVERED BACK PORCH	=	296 S.F.
CAR PORT	=	532 S.F.
TOTAL AREA UNDER ROOF		= 3555 S.F.

- IMPORTANT NOTES:
1. IT IS THE BUILDER'S RESPONSIBILITY TO VERIFY ALL GEOMETRY AND DIMENSIONS BEFORE ORDERING ANY MATERIALS OR BEGINNING CONSTRUCTION.
 2. THESE PLANS ARE FOR LAYOUT AND DESIGN PURPOSES ONLY ALL STRUCTURAL NOTES AND DETAILS TO BE PROVIDED BY AN ENGINEER.
 3. ALL INTERIOR AND EXTERIOR WALLS ARE 2X4 FRAME.
 4. ALL INTERIOR DOORS 6'-8".

* FLOOR PLAN *

SCALE : 1/4" = 1'-0"

NEW RESIDENCE
for
PHILIP & KATIE
GLOVER

Teresa M. Ruffo
2925 SW 8R 41
Lake City Florida, 32025
Cell: (386) 867-1191
Email: tesaruffo@gmail.com

PRINTED DATE:
Thursday, September 8, 2022

DRAWN BY: Teresa M. Ruffo CHECKED BY:

BUILDING CONTRACTOR
BRYAN ZECHER CONSTRUCTION

FINAL DATE:

JOB NUMBER:

DRAWING NUMBER

A-3

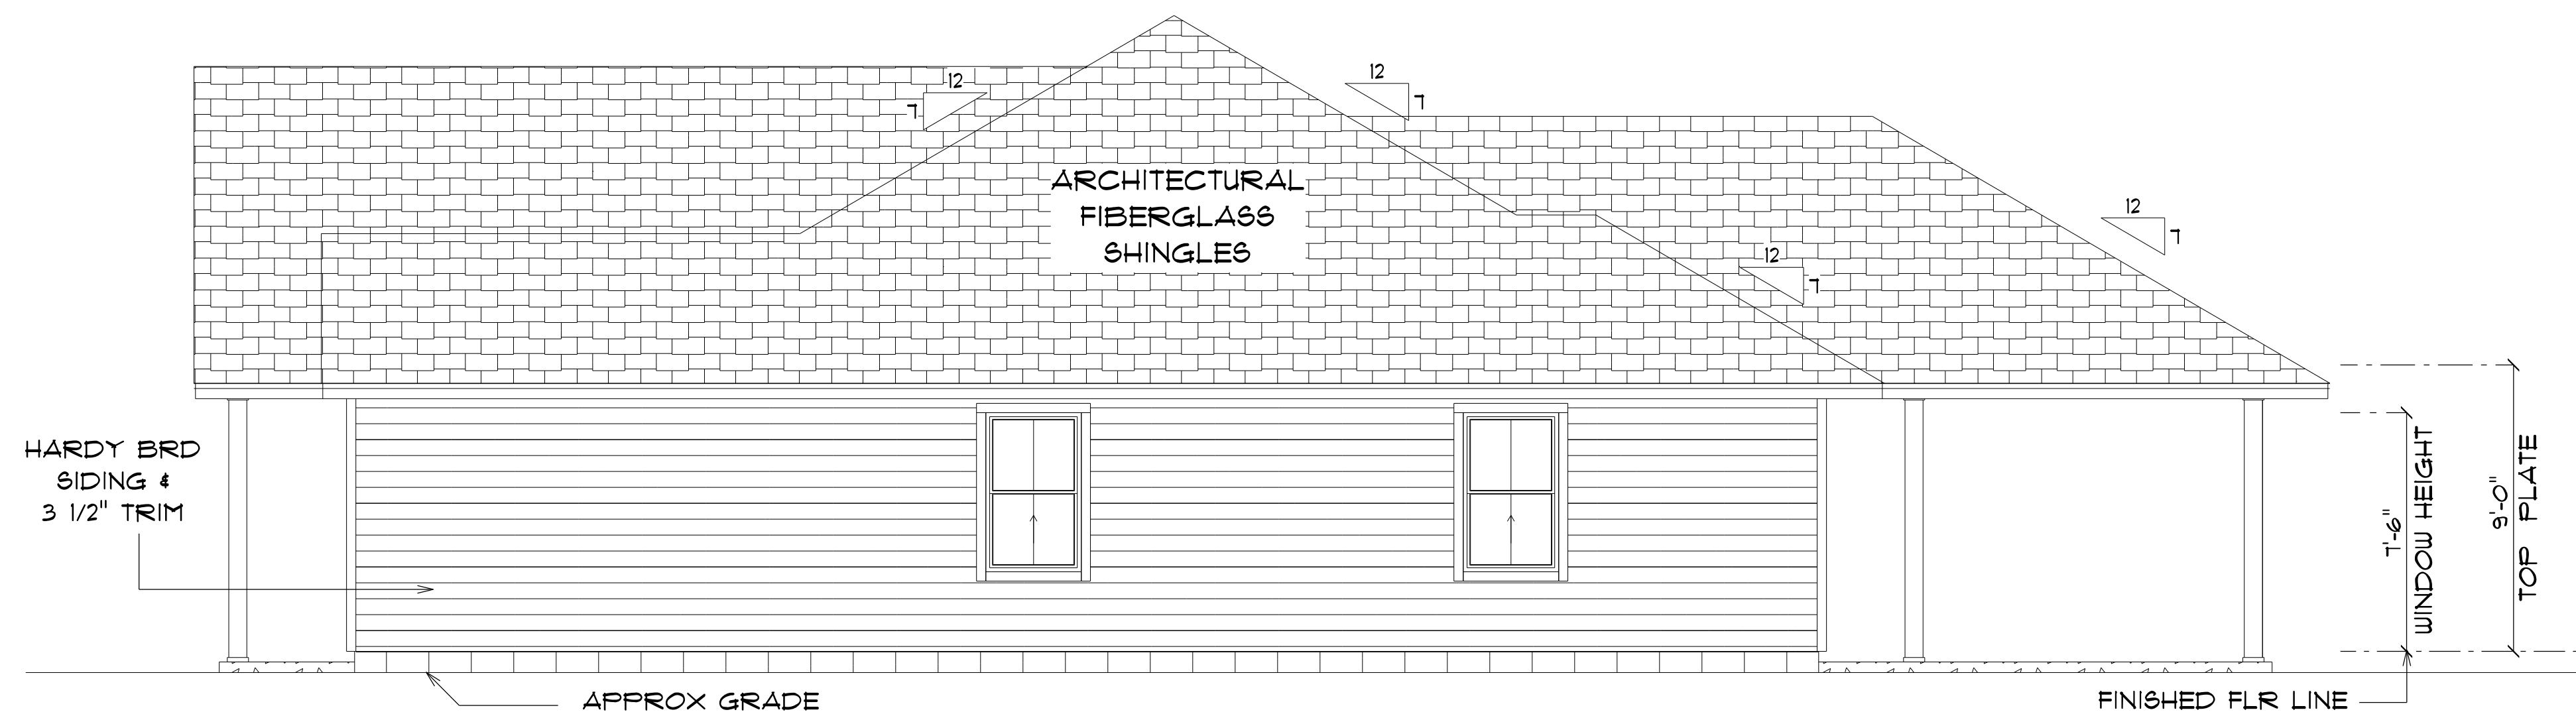
OF 6 SHEETS



* FRONT ELEVATION *

SCALE : 1/4" = 1'-0"

12" OVERHANG ON GABLE ENDS
24" OVERHANG ON ALL OTHER EAVES



* RIGHT ELEVATION *

SCALE : 1/4" = 1'-0"

NEW RESIDENCE
for
PHILIP & KATIE
GLOVER

Teena M. Ruffo
2925 SW SR 41
Lake City Florida, 32025
Cell: (386) 867-1191
Email: teenaruffo@gmail.com

PRINTED DATE:
Thursday, September 8, 2022

DRAWN BY: Teena M. Ruffo CHECKED BY:

BUILDING CONTRACTOR
BRYAN ZECHER CONSTRUCTION

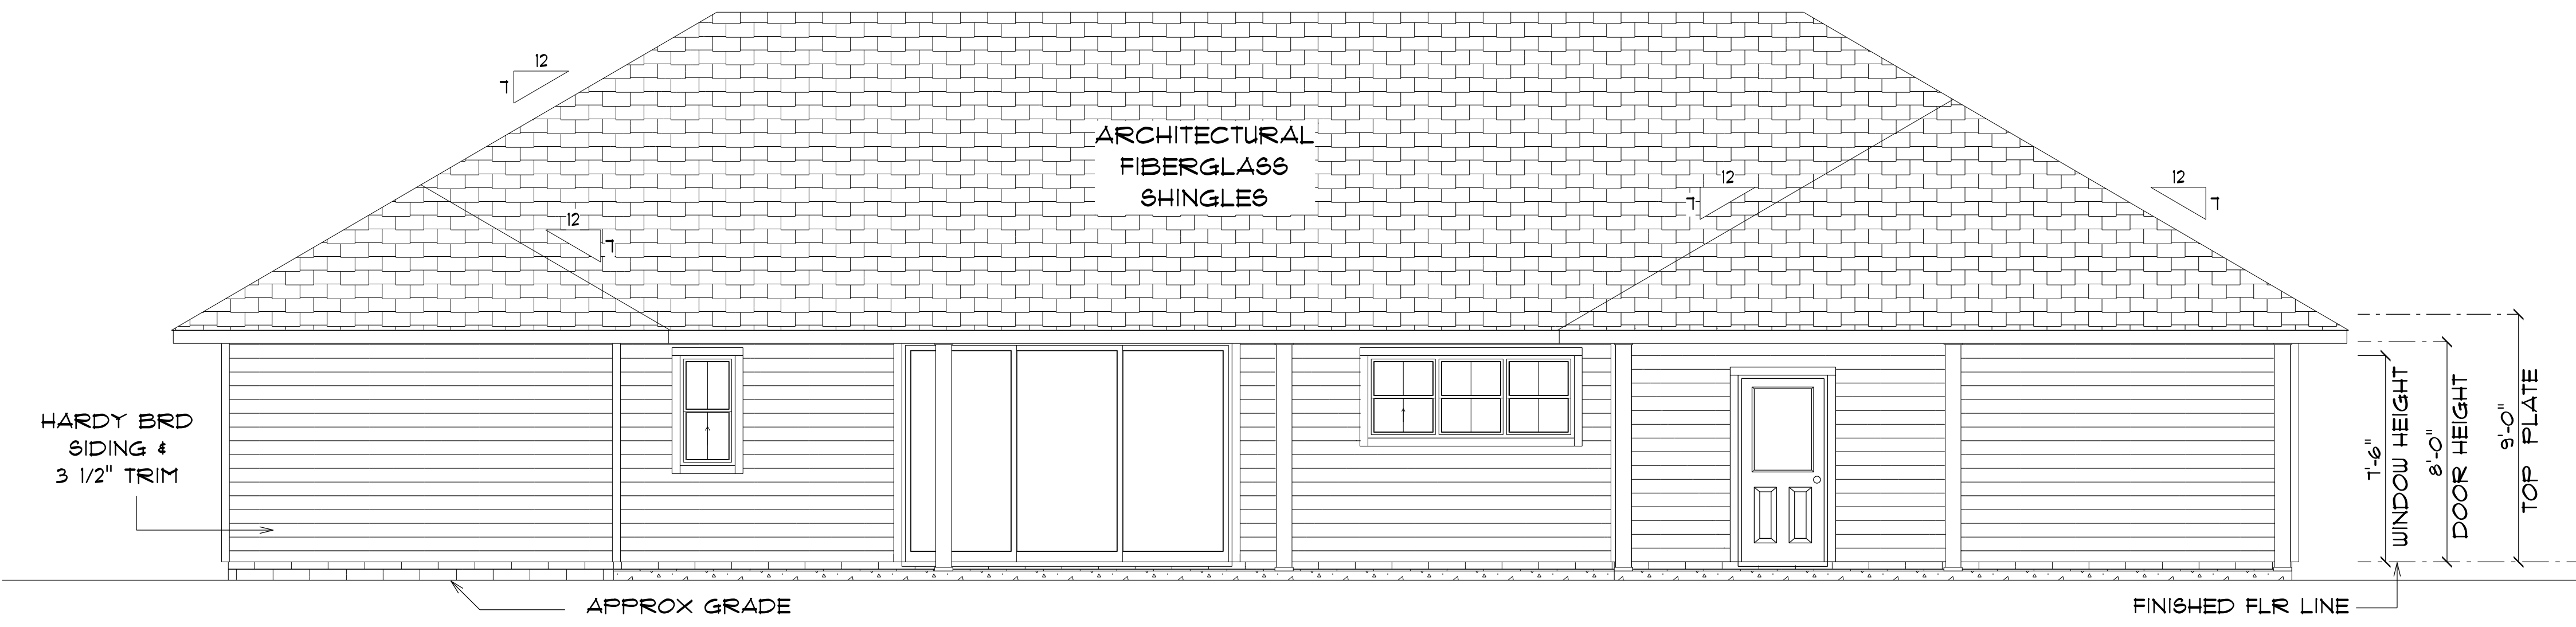
FINAL DATE:

JOB NUMBER:

DRAWING NUMBER

A-4

OF 6 SHEETS



* REAR ELEVATION *

SCALE : 1/4" = 1'-0"



* LEFT ELEVATION *

SCALE : 1/4" = 1'-0"

NEW RESIDENCE
for
PHILIP & KATIE
GLOVER

Teena M. Ruffo
2925 SW SR 41
Lake City Florida, 32025
Cell: (386) 861 - 1191
Email: teenaruffo@gmail.com

PRINTED DATE:
Thursday, September 8, 2022

DRAWN BY: Teena M. Ruffo CHECKED BY:

BUILDING CONTRACTOR
BRYAN ZECHER CONSTRUCTION

 
 
 
 
 
 
 
 
 
 
 
FINAL DATE:

JOB NUMBER:


DRAWING NUMBER

A-5

OF 6 SHEETS

ELECTRICAL LEGEND		
ELECTRICAL	COUNT	SYMBOL
ceiling fan globe 01	12	
ceiling light 12	2	
pendant large	5	
pot light	31	
spotlight double	4	
Smoke Detector	7	
electrical meter	1	
electrical panel	1	
dimmer switch	7	
dimmer switch 3-way	2	
light	14	
outlet	48	
outlet 220v	3	
outlet gfi	19	
outlet wp	11	
switch	37	
switch 3 way	10	
vent light combo	3	
vanity bar light 02	5	

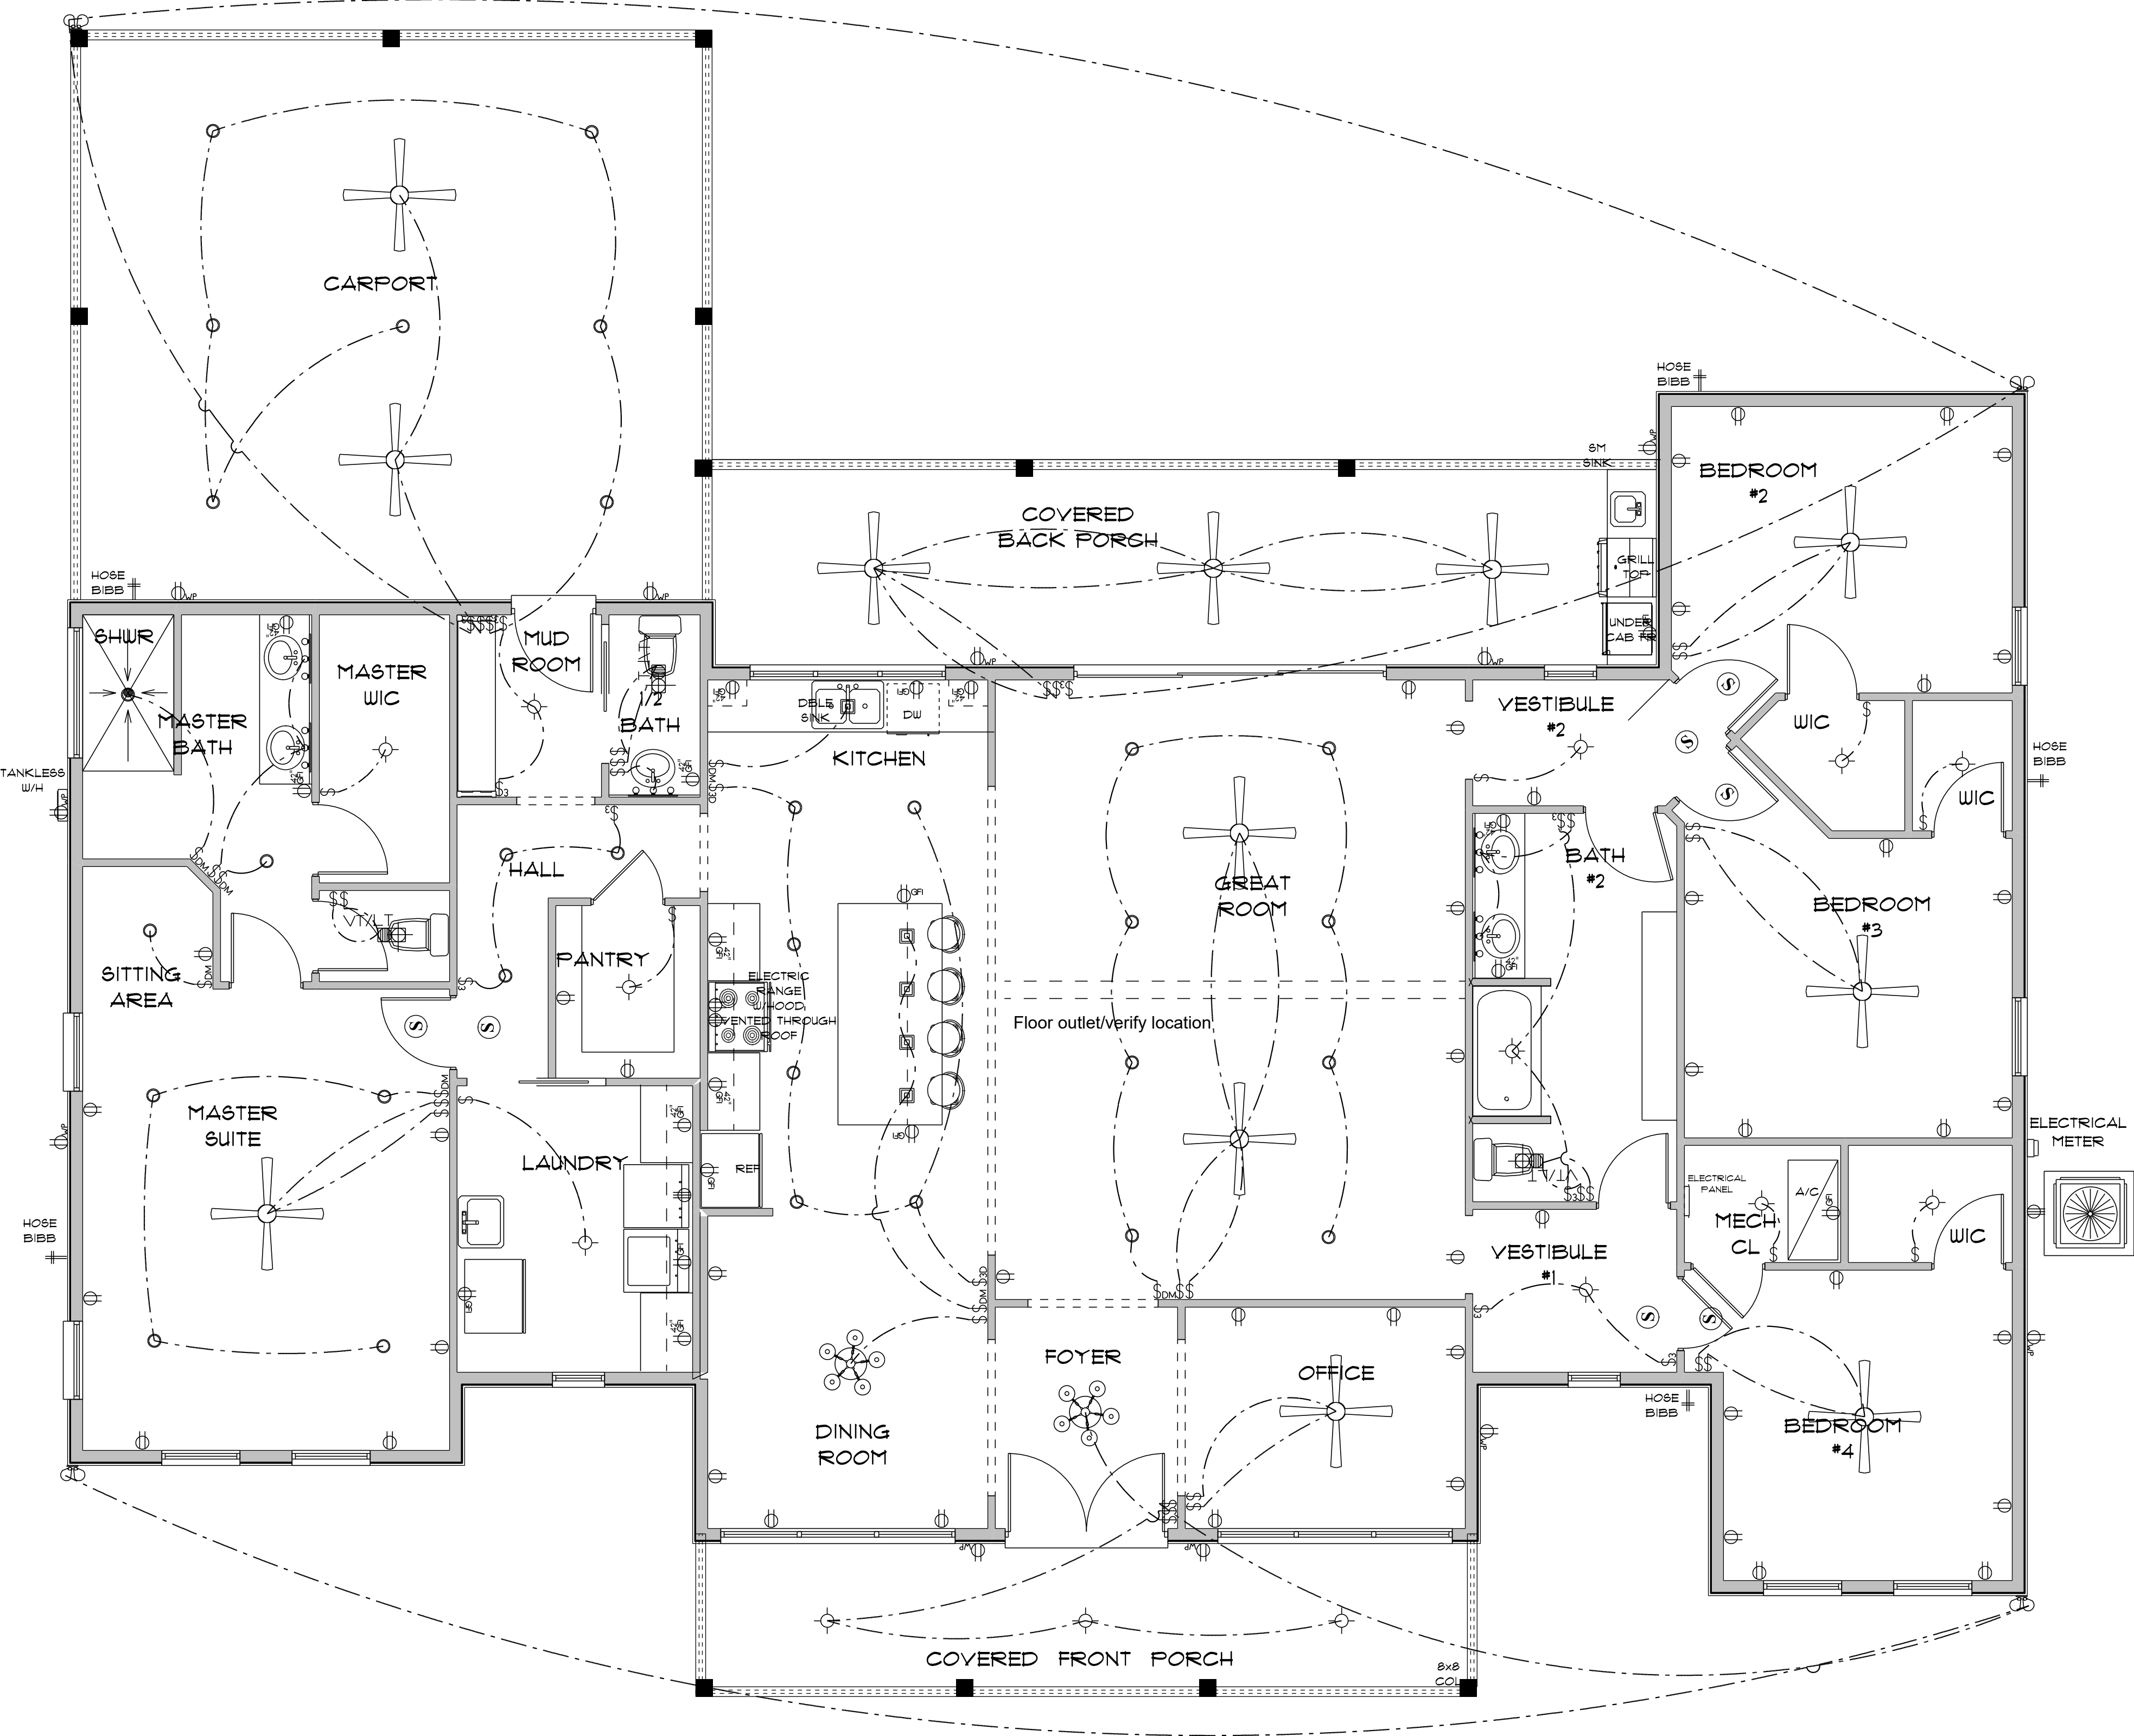- ELECTRICAL PLAN NOTES
- E-1 WIRE ALL APPLIANCES, HVAC UNITS AND OTHER EQUIPMENT PER MANUFACTURERS SPECIFICATIONS.
- E-2 ALL INSTALLATIONS SHALL BE PER NATIONAL ELECTRIC CODE.
- E-3 ALL SMOKE /CARBON MONOXIDE DETECTORS SHALL BE 120V W/BATTERY BACKUP OF THE PHOTOELECTRIC TYPE, AND SHALL BE INTERLOCKED TOGETHER. INSTALL INSIDE AND NEAR ALL BEDROOMS AS PER CODE.
- E-4 TELEPHONE, TELEVISION AND OTHER LOW VOLTAGE DEVICES OR OUTLETS SHALL BE AS PER THE OWNERS DIRECTION AND IN ACCORDANCE WITH APPLICABLE SECTIONS OF NATIONAL ELCT. CODE LATEST EDITION.
- E-5 ELECTRICAL CONTRACTOR SHALL BE RESPONSIBLE FOR THE DESIGN AND SIZING OF ELECTRICAL SERVICE AND CIRCUITS.
- E-6 ENTRY OF SERVICE UNDERGROUND OR OVERHEAD IS TO BE DETERMINED BY THE POWER COMPANY.
- ALL BEDROOM RECEPTALS ARE TO BE AFCI (ARC FAULT CIRCUIT INTERRUPT)
- 75% OF ALL PERMANENT LIGHTS TO BE ENERGY EFFECIENT.



* ELECTRIC PLAN *

SCALE: 1/4" = 1'-0"

NEW RESIDENCE
for
PHILIP & KATIE
GLOVER

Teena M. Ruffo
2925 SW SR 47
Lake City Florida, 32025
Cell: (386) 867-1191
Email: teenaruffo@gmail.com

PRINTED DATE:
Thursday, September 8, 2022

DRAWN BY: Teena M. Ruffo CHECKED BY:

BUILDING CONTRACTOR
BRYAN ZECHER CONSTRUCTION

FINAL DATE:

JOB NUMBER:

DRAWING NUMBER

A-6

OF 6 SHEETS