

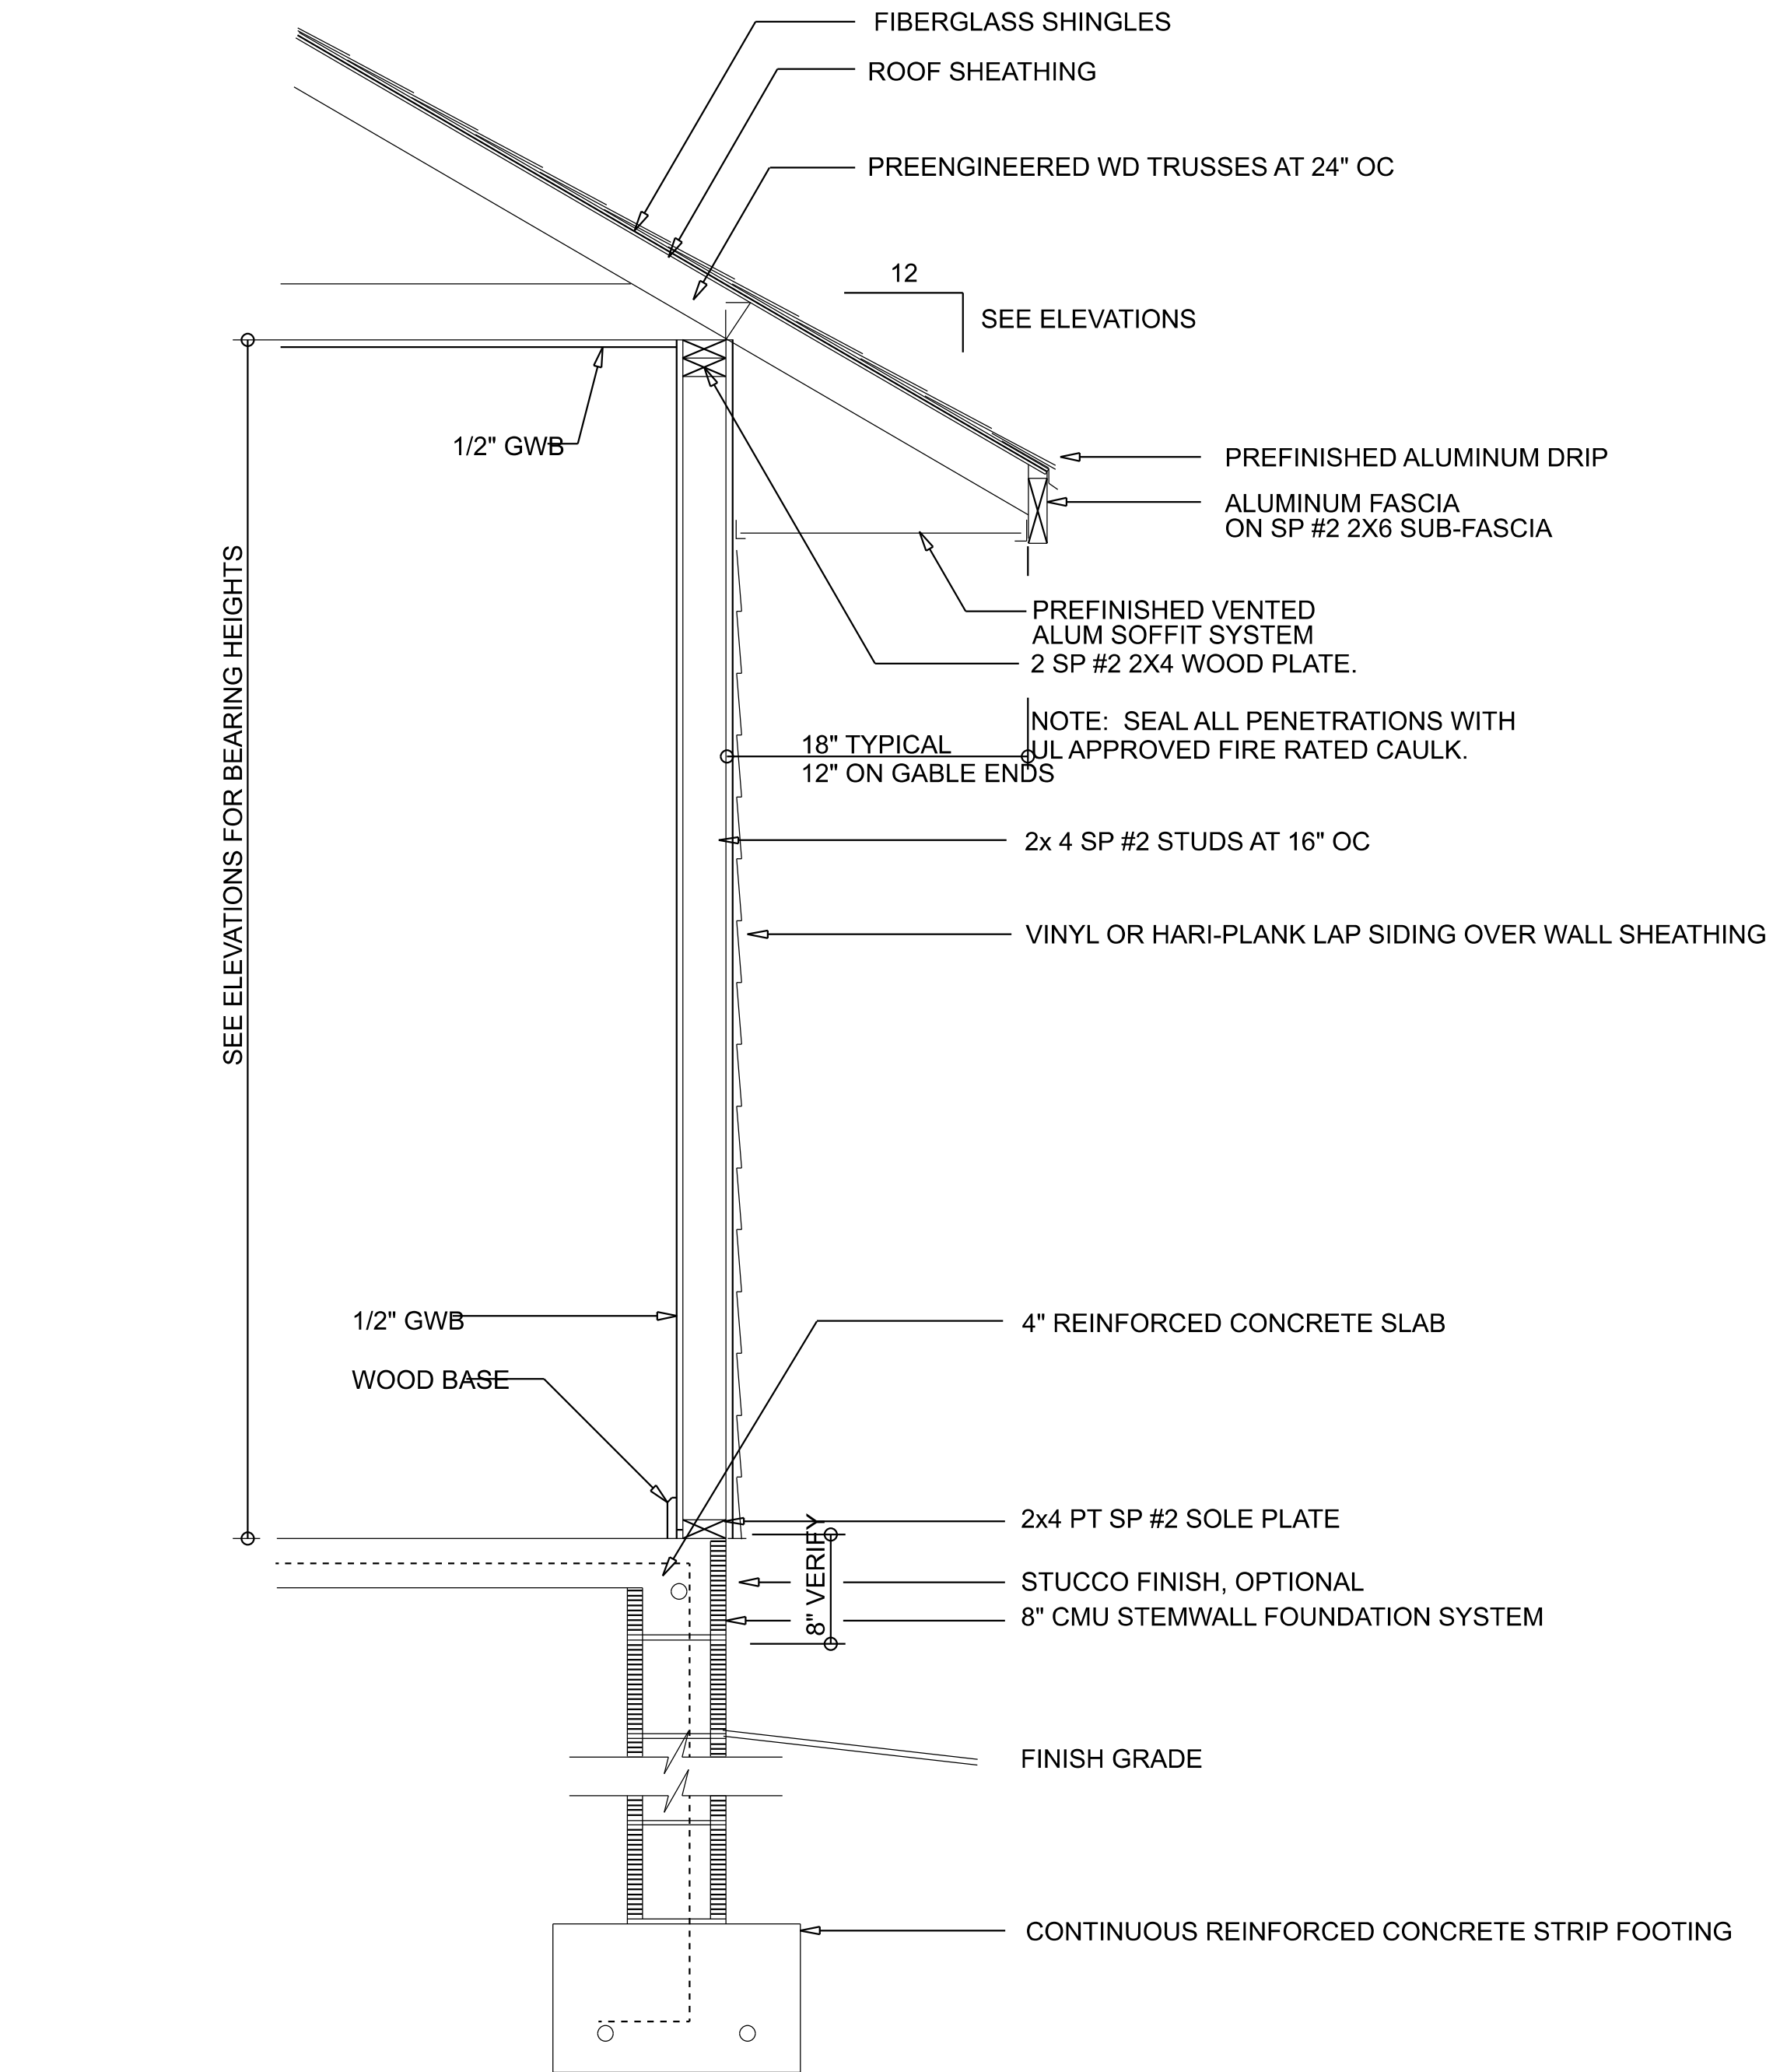
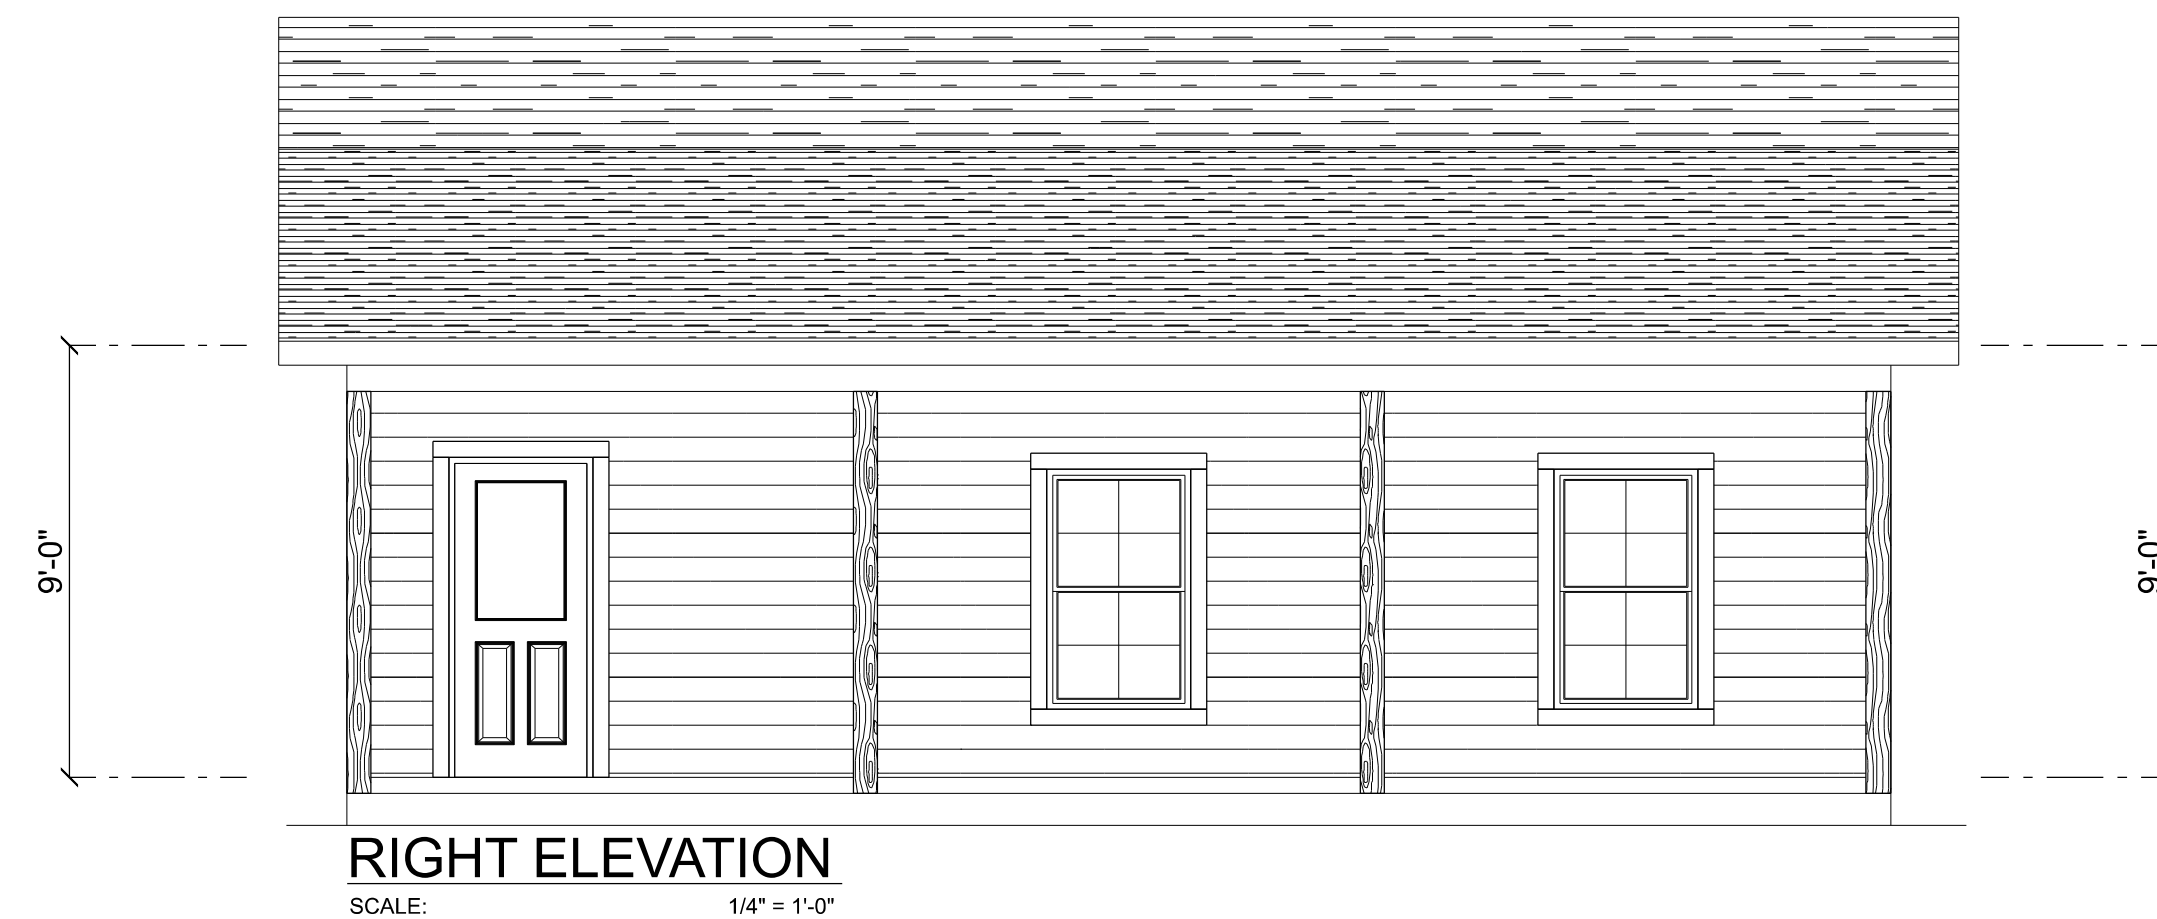
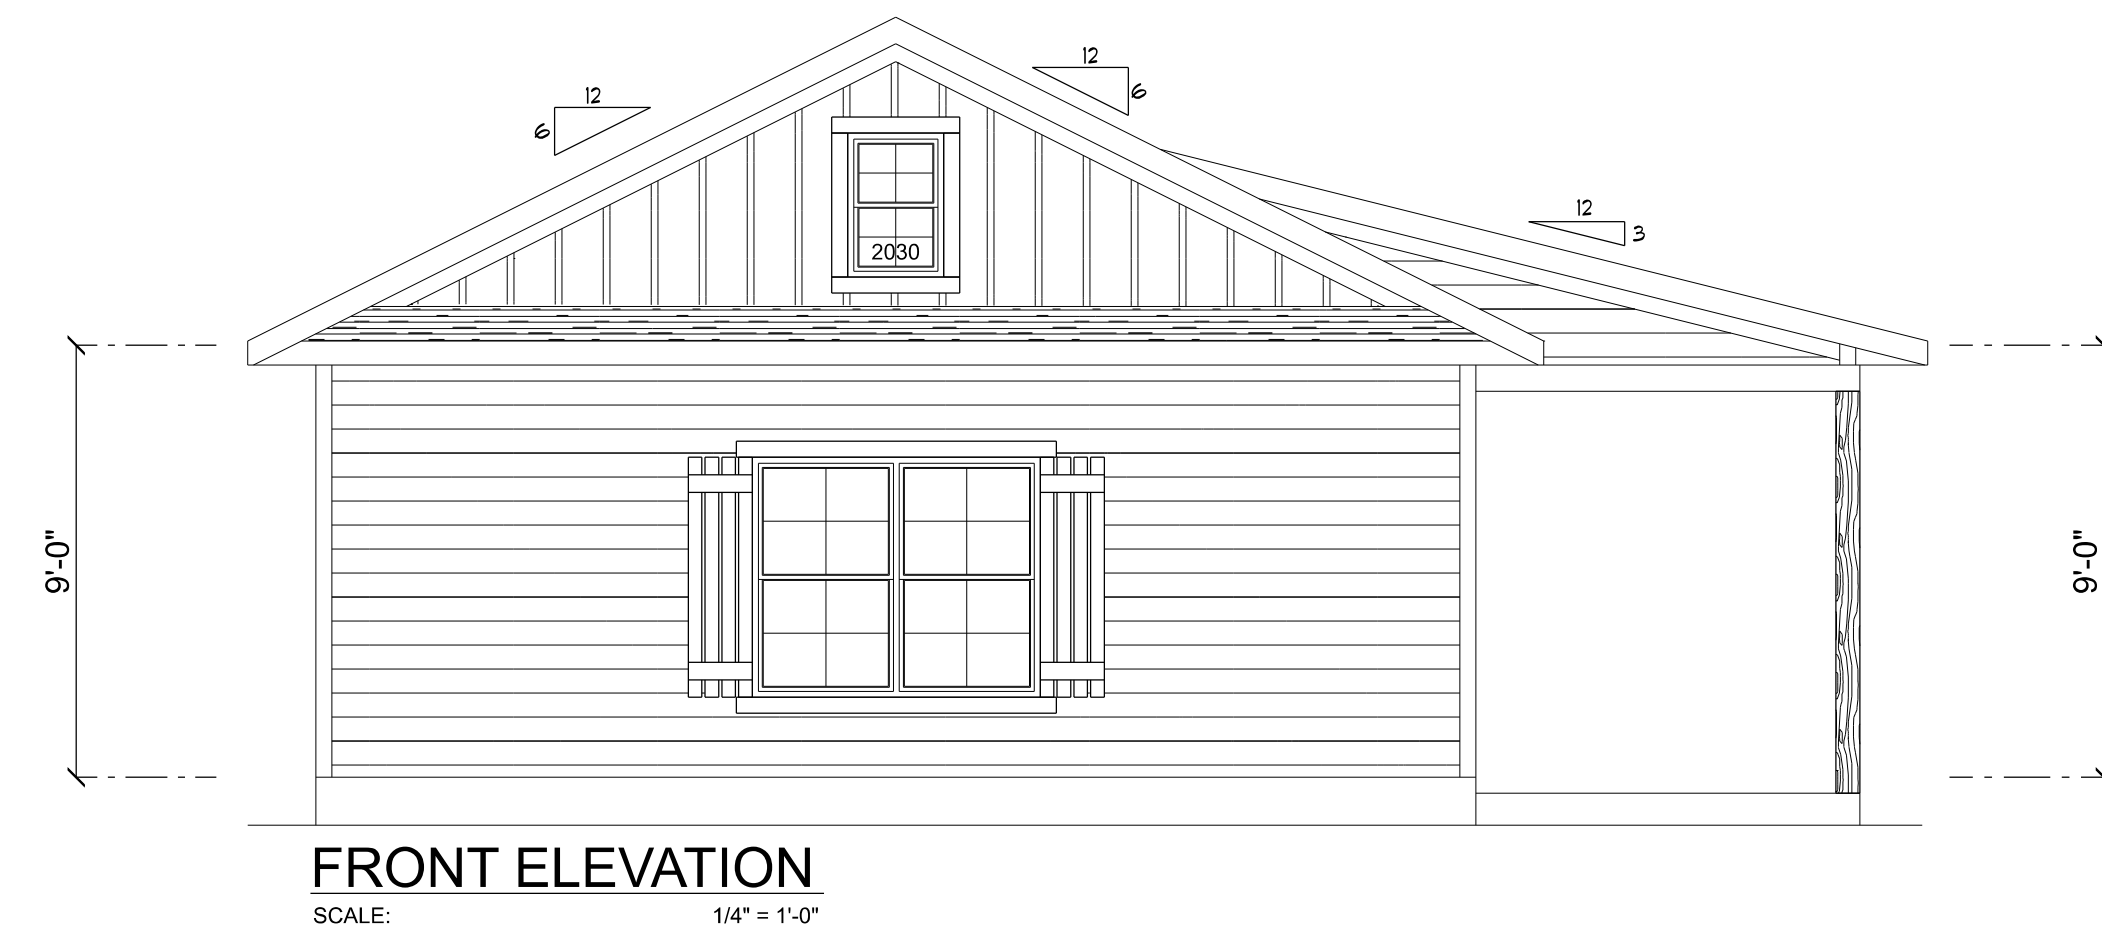


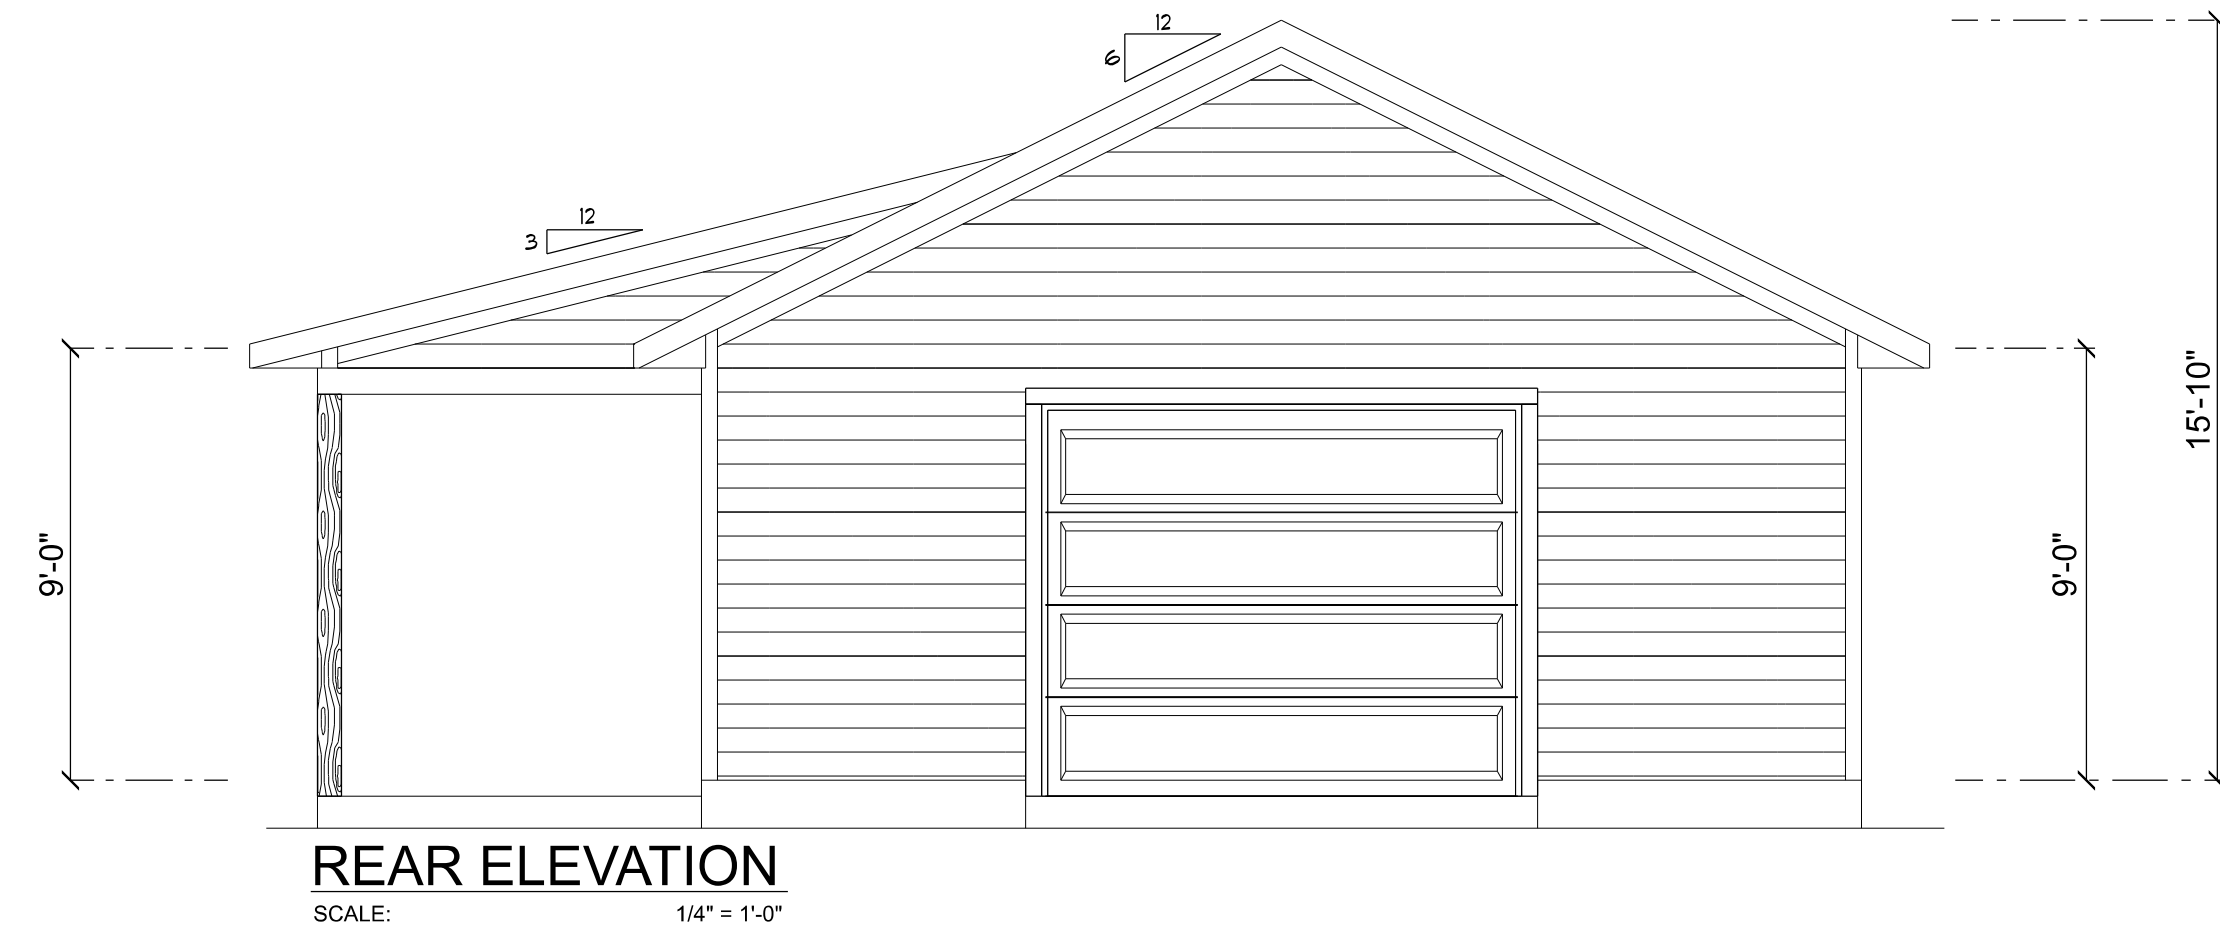


TYPICAL WALL SECTION
SCALE: 1" = 1'-0"

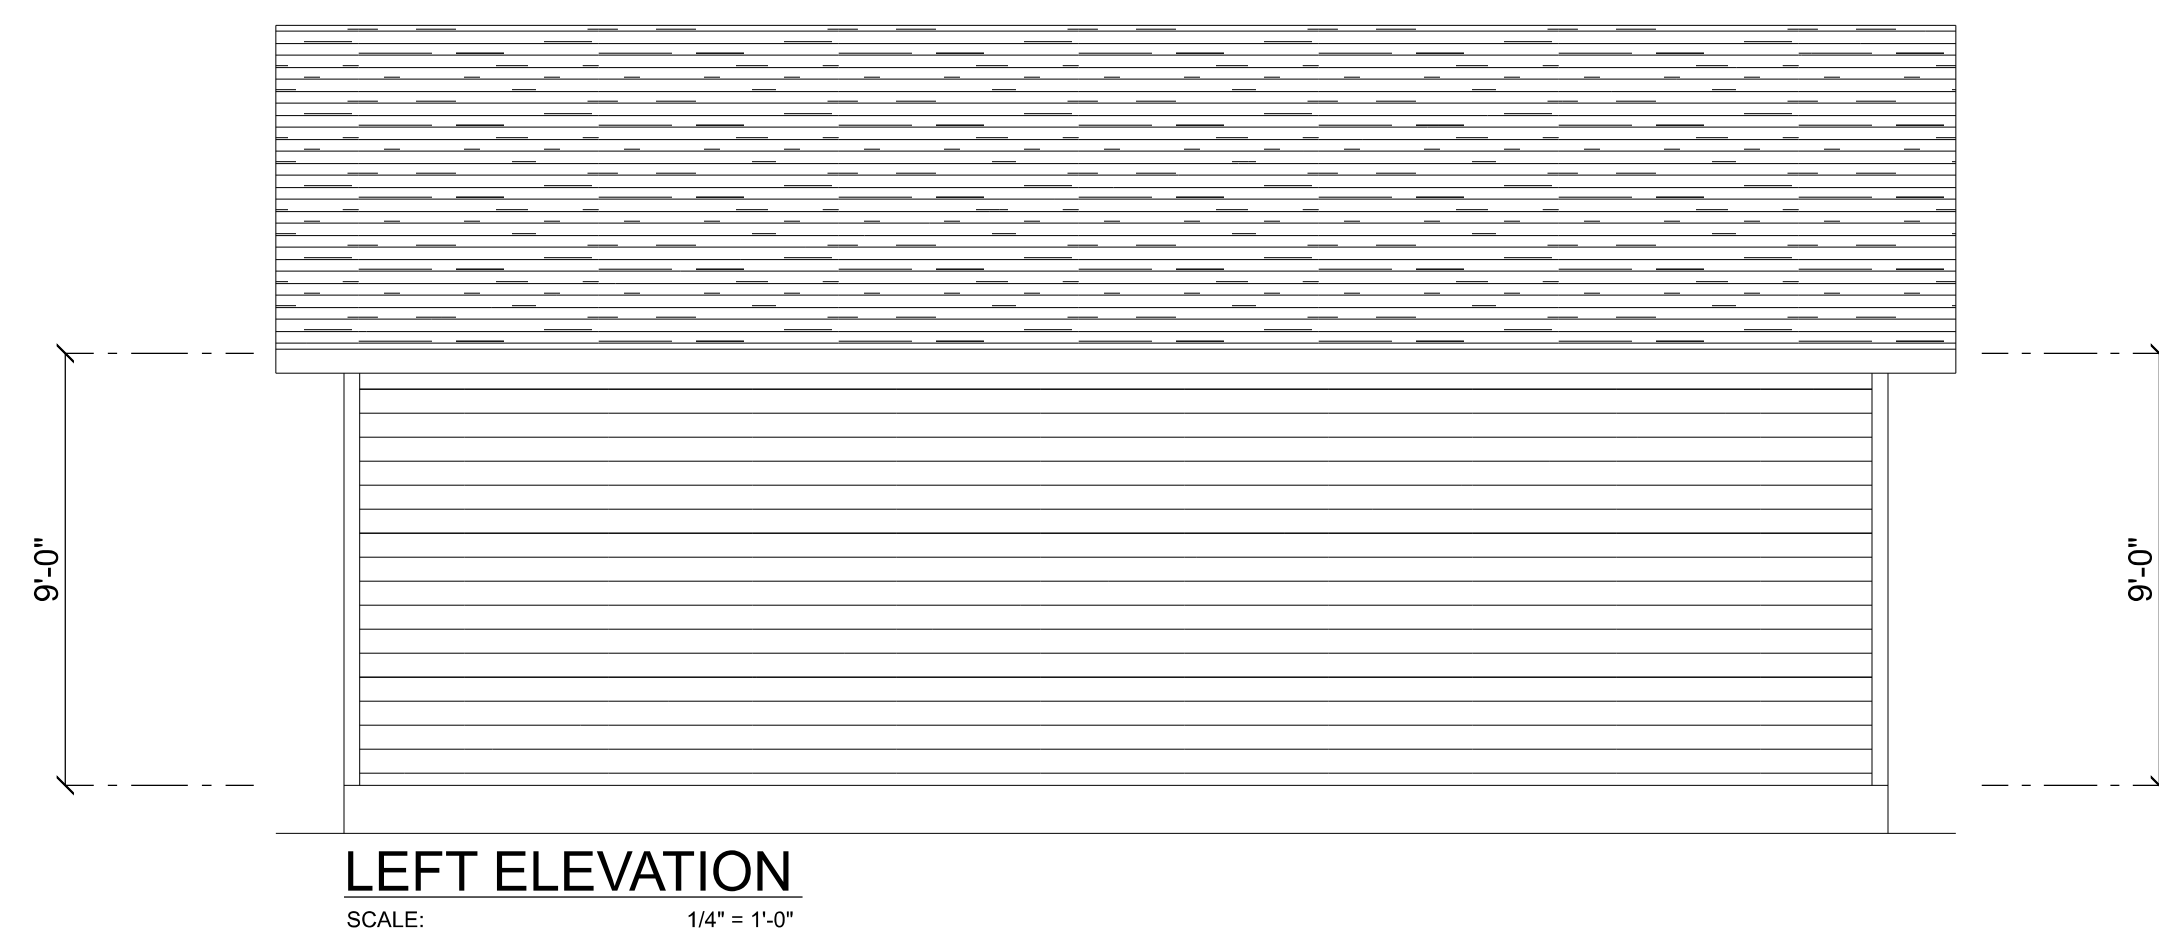

REVISIONS SCHEDULE			
PROPOSAL	Oct. 30th, 2023		
REVISIONS	Dec. 1st, 2023		


DETACHED GARAGE FOR:
CHILDERS RESIDENCE
COLUMBIA COUNTY, FL

RIDGEPOINT DESIGN
566 SW ARLINGTON BLVD STE 101, LAKE CITY, FL 32025
P: 386-288-1188
E: RIDGEPOINTDESIGN@GMAIL.COM

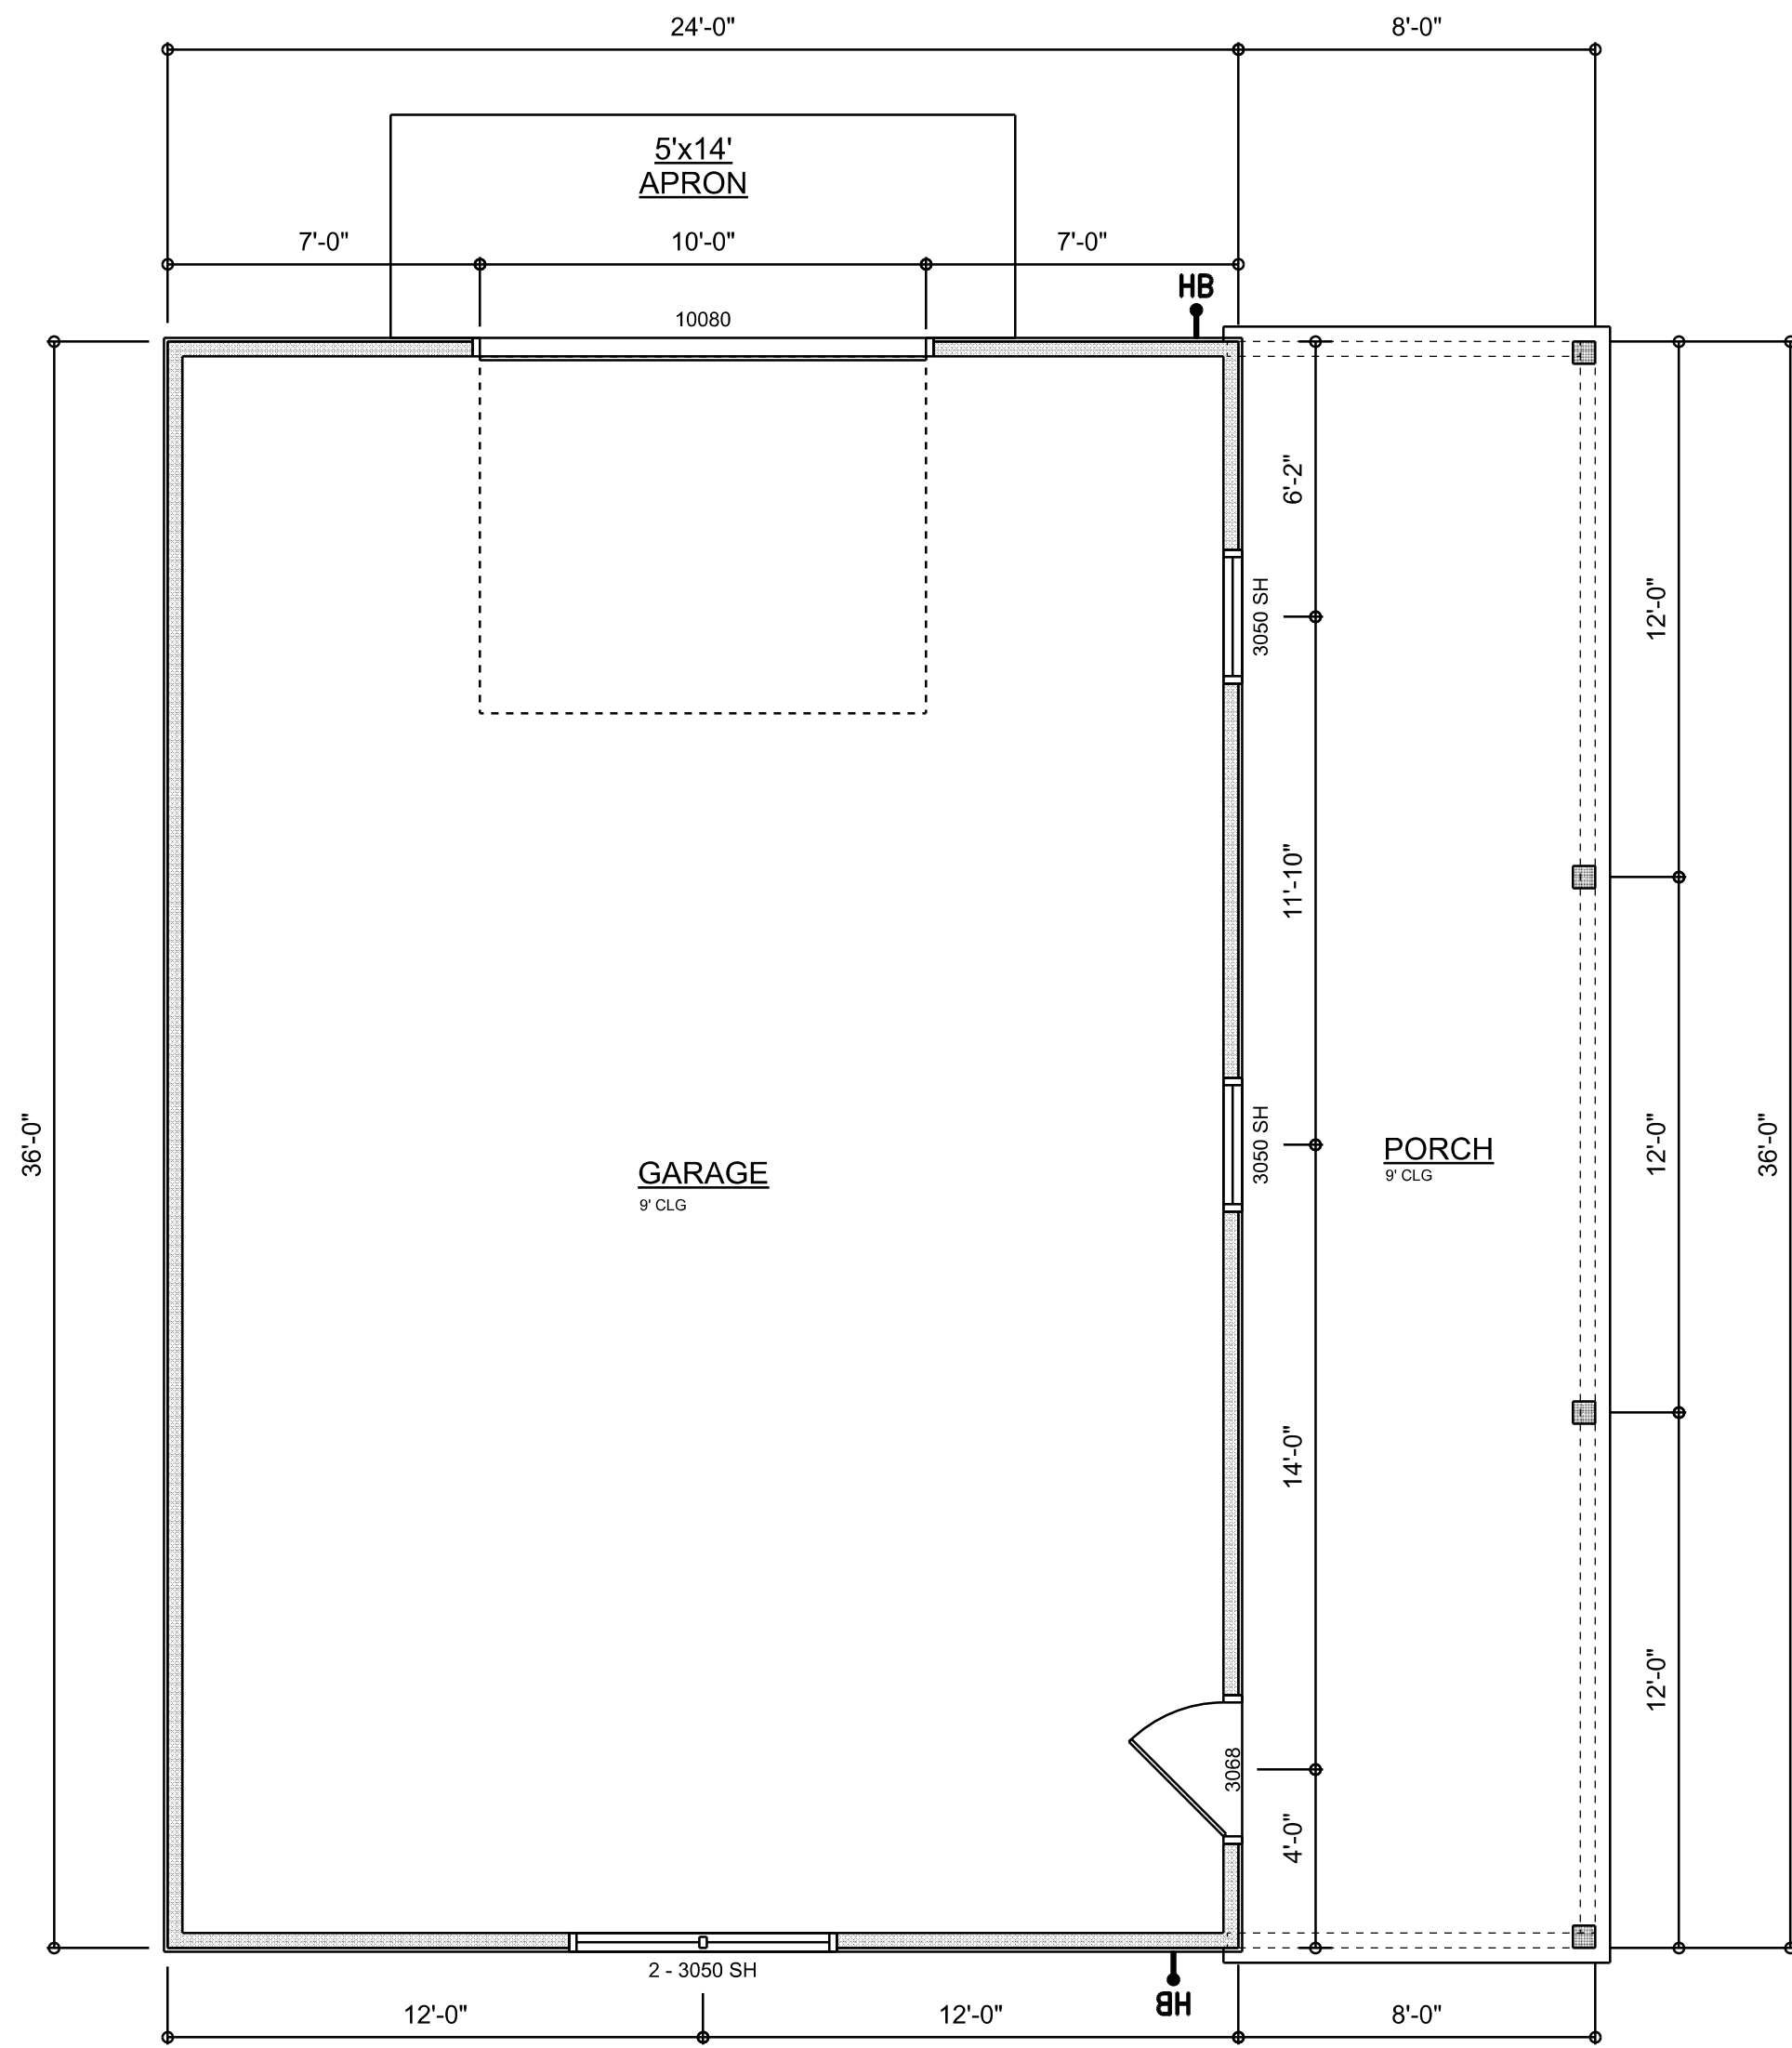

DIMENSIONED FLOOR PLAN
SCALE: 1/4" = 1'-0"

A R E A S U M M A R Y		
GARAGE	864	S.F.
Porch	288	S.F.
TOTAL AREA	1,152	S.F.

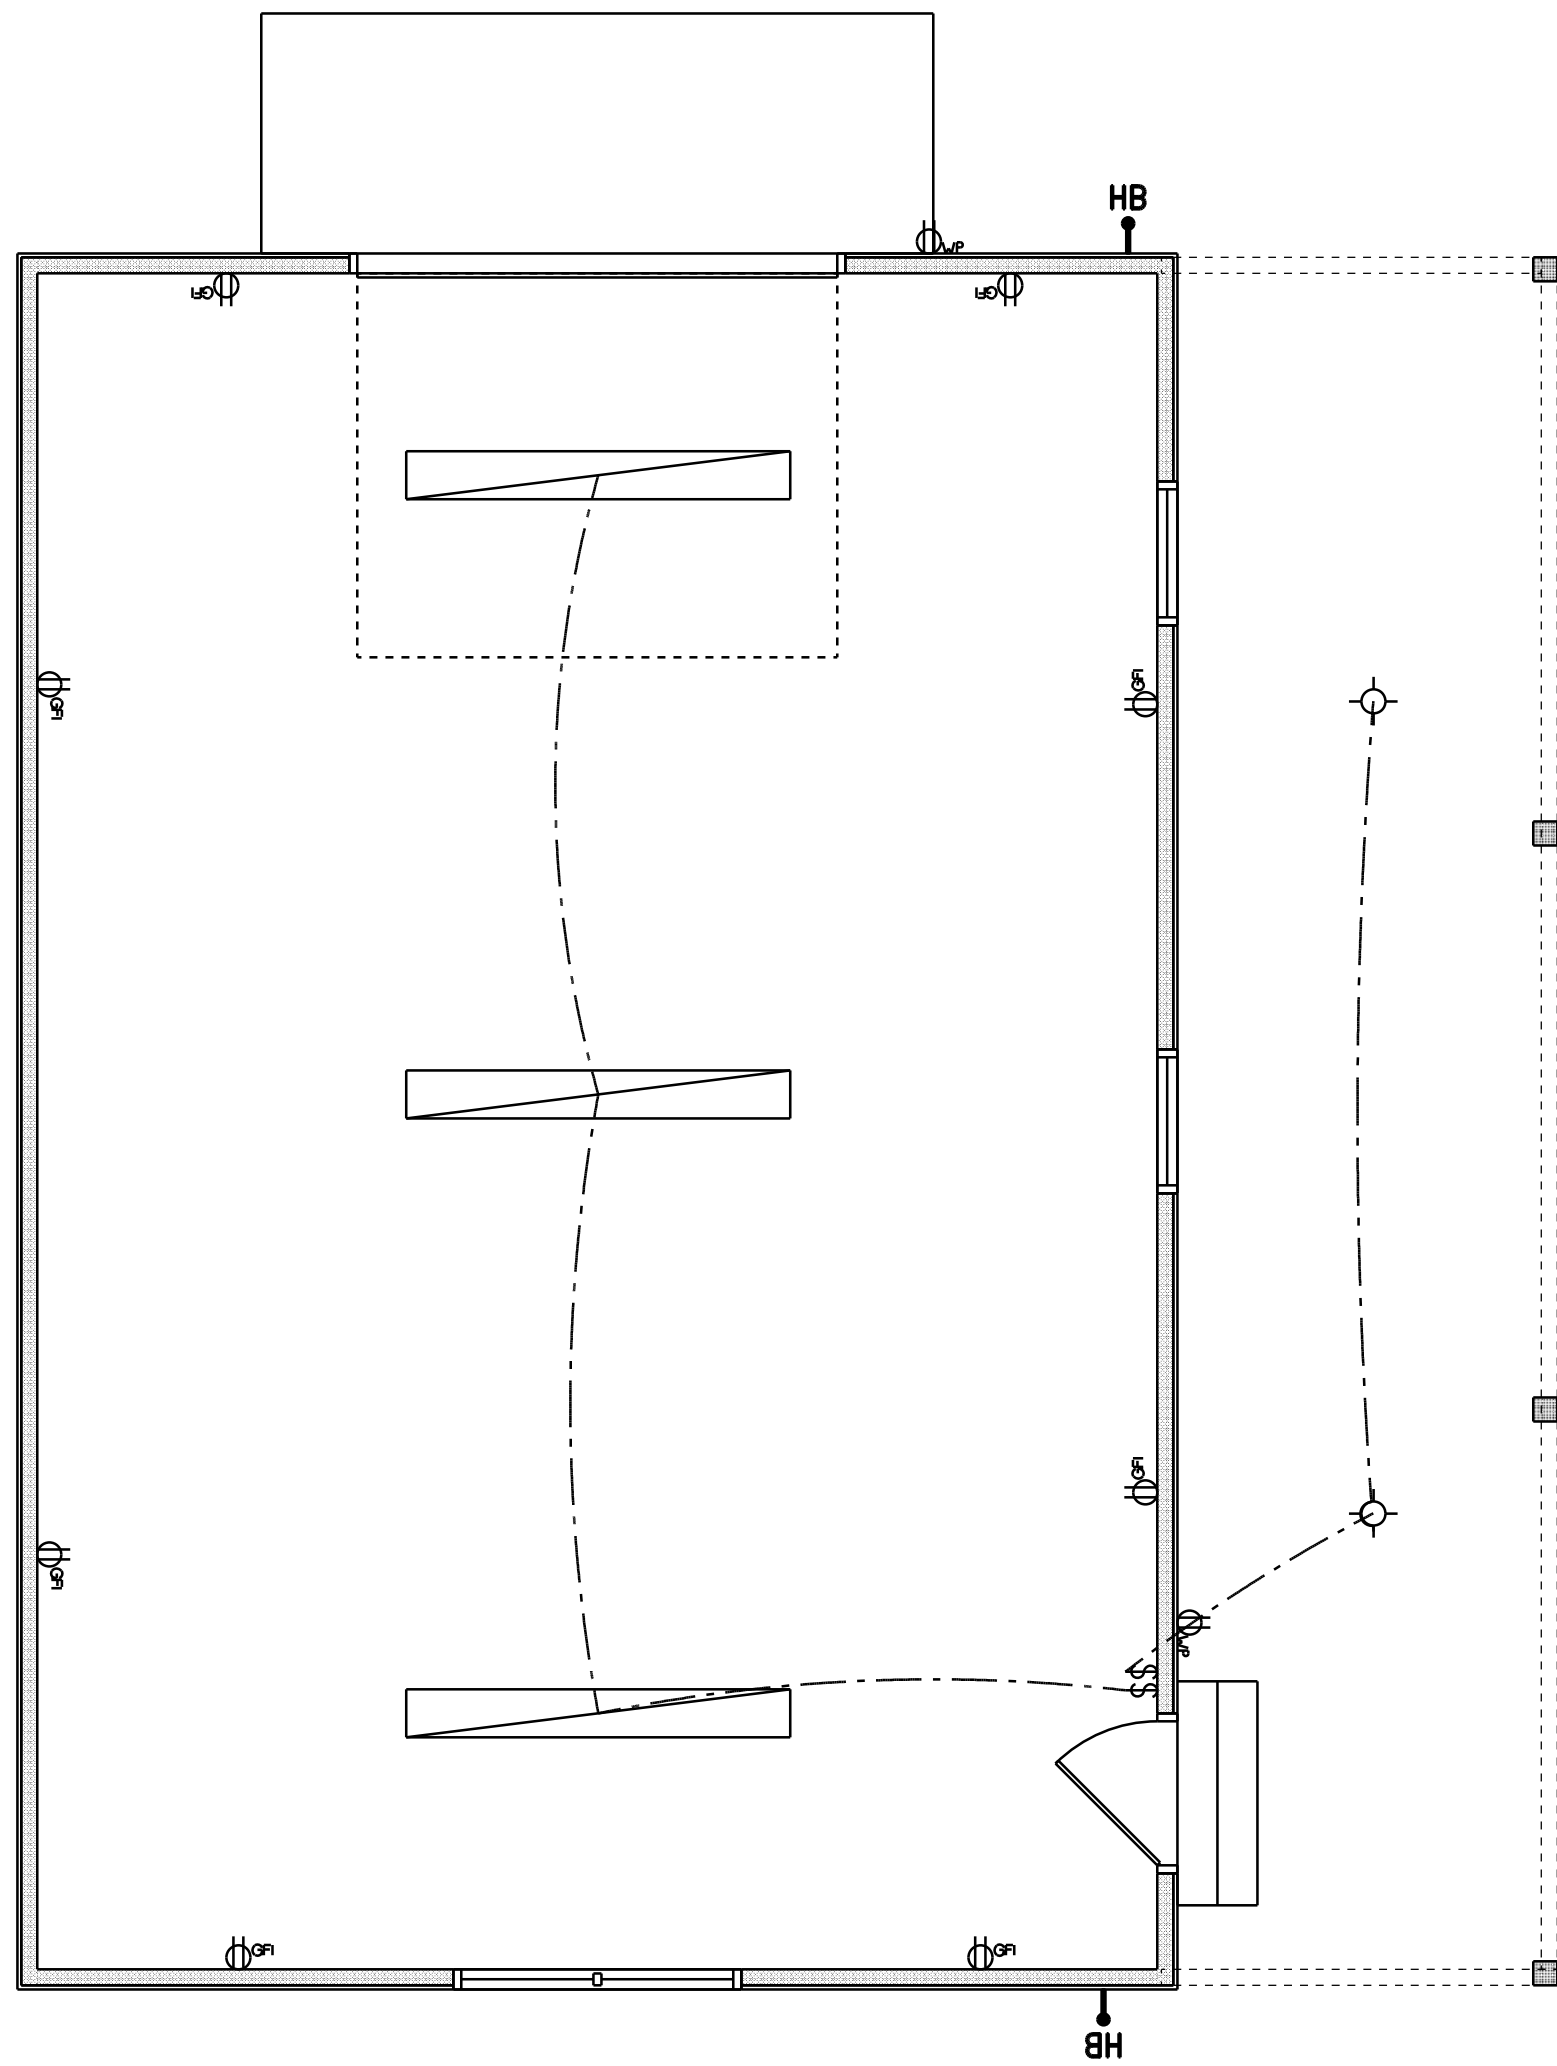

ELECTRICAL LEGEND		
ELECTRICAL COUNT SYMBOL		
LED CEILING LIGHT 1x8	3	
OUTLET GFI	8	
OUTLET WP	2	
STANDARD LIGHT	2	
SWITCH	2	

ELECTRICAL PLAN NOTES:

INSTALLATION SHALL BE PER LATEST NAT'L ELECTRIC CODE.

WIRE ALL APPLIANCES, HVAC UNITS AND OTHER EQUIPMENT PER MANUF. SPECIFICATIONS

CONSULT WITH THE OWNER FOR THE NUMBER OF SEPERATE TELEPHONE LINES TO BE INSTALLED

ALL SMOKE DETECTORS SHALL BE 120v W/ BATTERY BACKUP OF THE PHOTOELECTRIC TYPE, AND SHALL BE INTERLOCKED TOGETHER. INSTALL INSIDE AND NEAR ALL BEDROOMS

TELEPHONE, TELEVISION AND OTHER LOW VOLTAGE DEVICES OR OUTLETS SHALL BE AS PER THE OWNER'S DIRECTIONS, & IN ACCORDANCE W/ APPLICABLE SECTIONS OF NEC-LATEST EDITION.

ALL RECEPTICALS, NOT OTHERWISE NOTED, SHALL BE ARC FAULT INTERRUPTER TYPE, EXCEPT DEDICATED OUTLETS

ALL RECEPTICALS IN WET AREAS SHALL BE GROUND FAULT INTERRUPTER TYPE (GFI)

ALL EXTERIOR RECEPTICALS SHALL BE WEATHERPROOF GROUD FAULT INTERRUPTER TYPE (WP/GFI)

NOTE:
ELECTRICAL CONTR SHALL PREPARE "AS-BUILT" SHOP DWGS INDICATING ALL ELECTRICAL WORK, INCLUDING ANY CHANGES TO THE ELEC. PLAN, ADDNS TO THE ELEC. PLAN, RISER DIAGRAM, AS-BUILT PANEL SCHEDULE W/ ALL CKTS IDENTIFIED W/ CKT Nr. DESCRIPTION & BRKR. SERVICE ENT. & ALL UNDERGROUND WIRE LOCATIONS/ROUTING / DEPTH. RISER DIA. SHALL INCLUDE WIRE SIZES/TYPE & EQUIPMENT TYPE W/ RATINGS & LOADS.
CONTRACTOR SHALL PROVIDE 1 COPY OF AS-BUILT DWGS TO OWNER & 1 COPY TO THE PERMIT ISSUING AUTHORITY

REVISIONS SCHEDULE	
PROPOSAL	Oct. 30th, 2023
REVISIONS	Dec. 1st, 2023

DETACHED GARAGE FOR:
CHILDERS RESIDENCE
COLUMBIA COUNTY, FL

**RIDGEPOINT
DESIGN**
566 SW ARLINGTON BLVD STE 101, LAKE CITY, FL 32025
P: 386-288-1188
E: RIDGEPOINTDESIGN@GMAIL.COM