


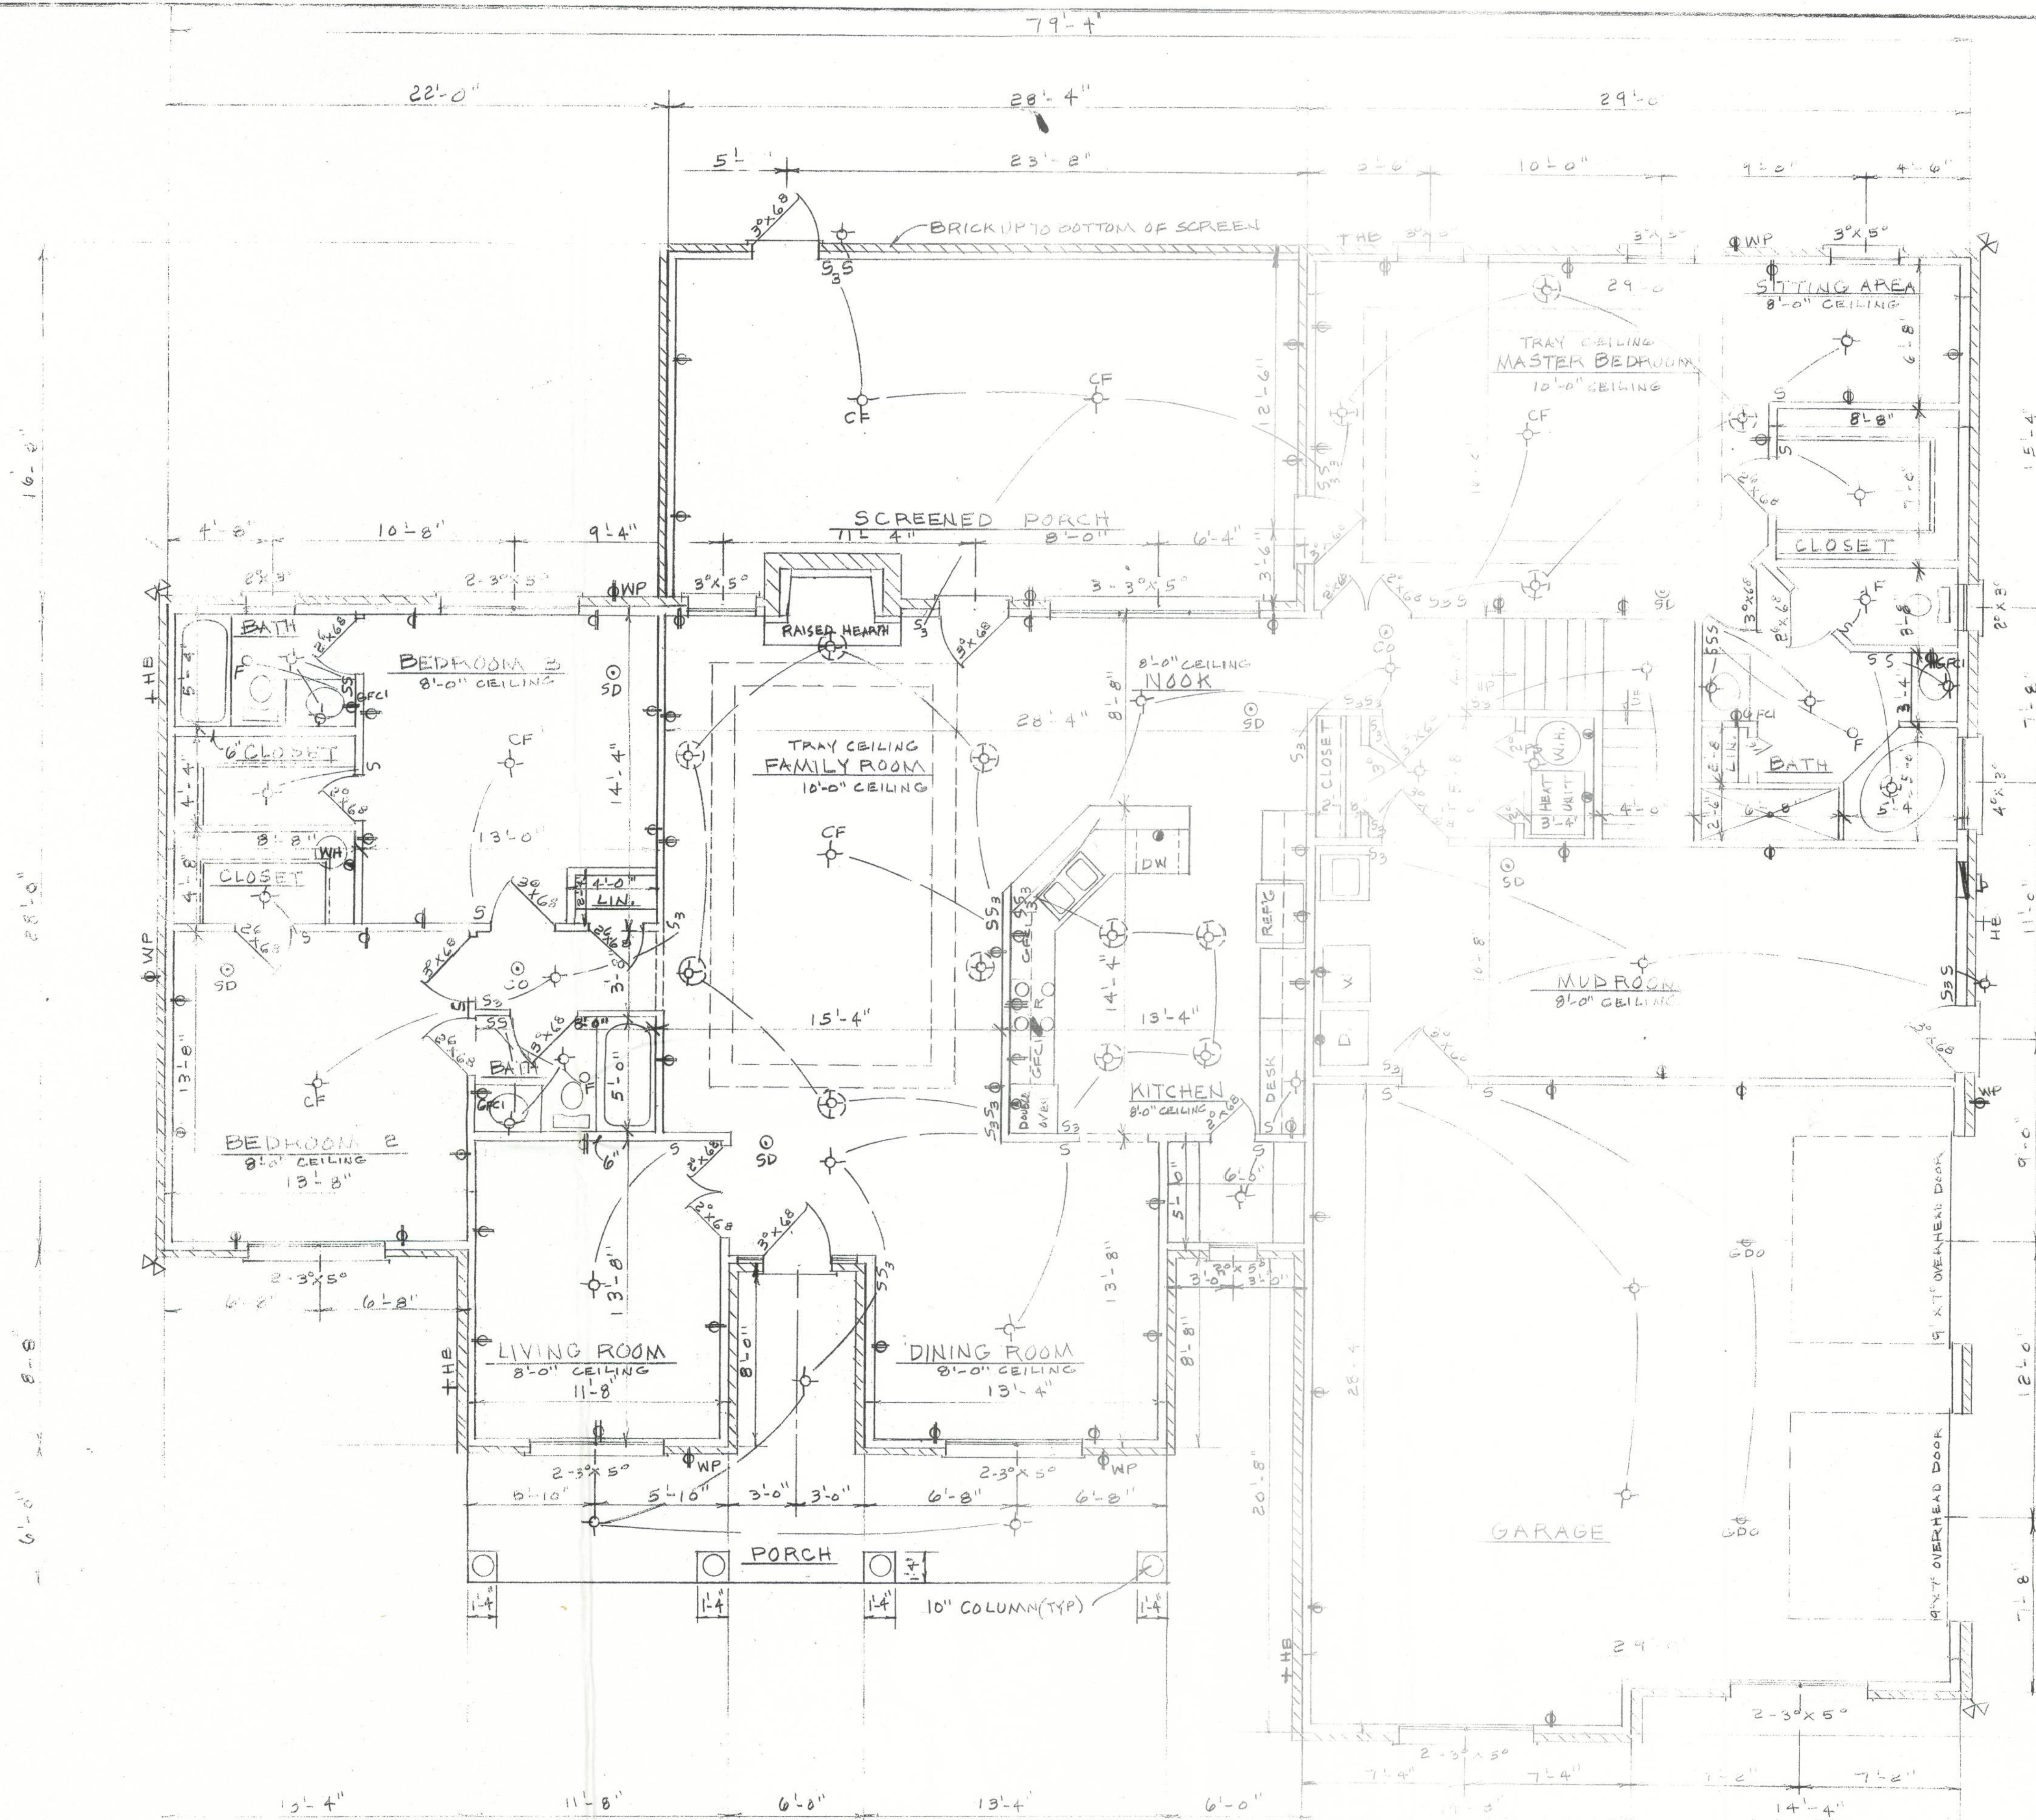

FLOOR PLAN


SCALE: 1/4" = 1'-0"

LIVING AREA: 2874 SQ. FT. GARAGE: 792 SQ. FT. SCREENED PORCH: 451 SQ. FT. ENTRY PORCH: 174 SQ. FT.

TOTAL: 4291 SQ. FT.

ELECTRICAL LEGEND

S - SINGLE POLE SWITCH S₃ - THREE-WAY SWITCH ⚡ - DUPLEX CONK OUTLET ⚡ - CEILING LIGHT ⚡ - CEILING FAN W/LIGHT ⚡ - GROUND FAULT CIRCUIT
 PS - PULL SWITCH CO - CARBON MONOXIDE DETECTOR ⚡ - SPECIAL PURPOSE OUTLET ⚡ - RECESSED LIGHT ⚡ - WALL MOUNTED LIGHT ⚡ - SECURITY LIGHTS ⚡ - RANGE OUTLET ⚡ - EXHAUST FAN ⚡ - EXHAUST FAN W/LIGHT ⚡ - WEATHERPROOF OUTLET
 SD - SMOKE DETECTOR ⚡ - GARAGE DOOR OPENER ⚡ - ELECTRICAL PANEL ⚡ - ELECTRIC METER

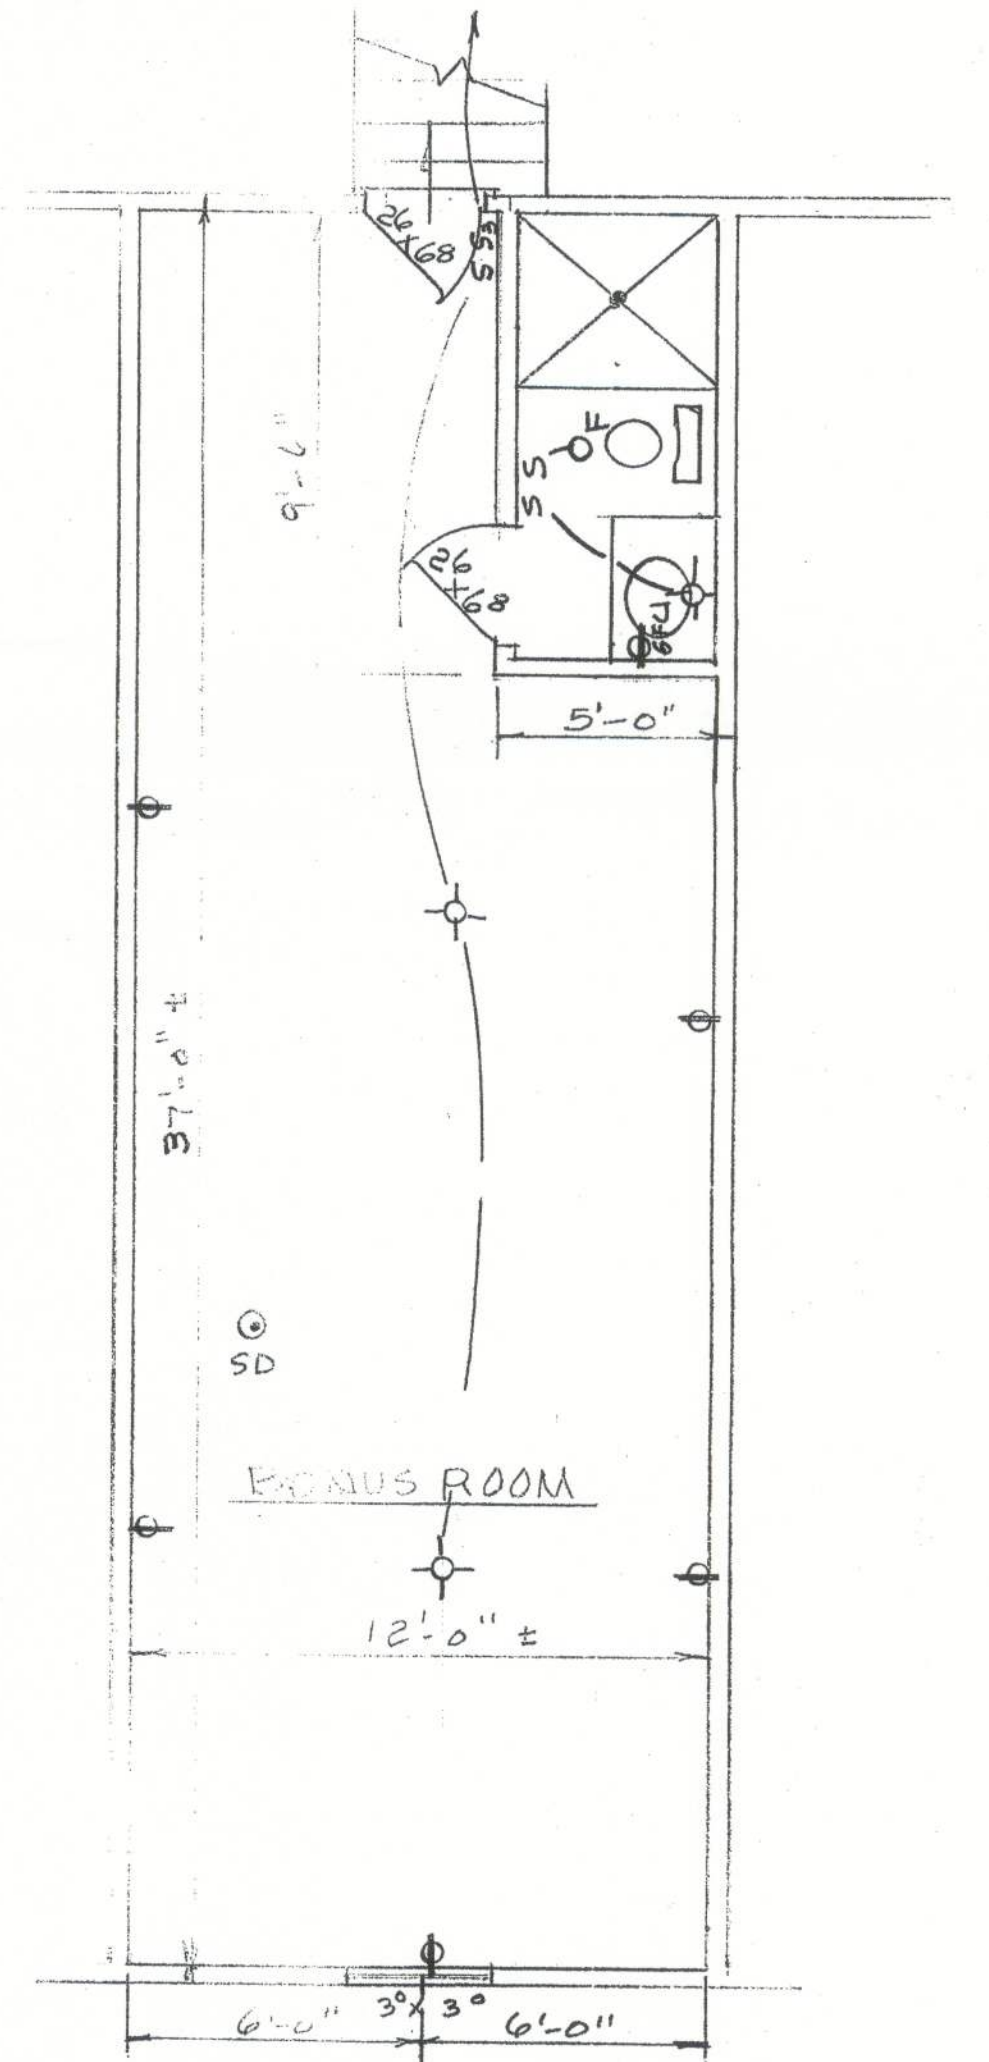

BONUS ROOM FLOOR PLAN

SCALE: 1/4" = 1'-0"

SQUARE FOOTAGE: 444

* EXACT SIZE OF BONUS ROOM SHALL BE DETERMINED BY CONTRACTOR