



1st FLOOR REFLECTED CEILING PLAN


**OWNER MEETING SET -
NOT FOR CONSTRUCTION**

CEILING FINISH NOTE:
RECESSED CLG SURFACES, BOTH
HORIZONTAL AND VERTICAL,
SHALL HAVE SMOOTH FINISH


NOTE:
VERIFY CLEARANCE OF TRM IN ALL
CEILINGS AND SOFFITS WITH
RECESSED CAN, A/C SUPPLY AND
RETURN GRILLE LOCATIONS

CEILING FINISH NOTE:
RECESSED CLG SURFACES, BOTH
HORIZONTAL AND VERTICAL,
SHALL HAVE SMOOTH FINISH


NOTE:
VERIFY CLEARANCE OF TRM IN ALL
CEILINGS AND SOFFITS WITH
RECESSED CAN, A/C SUPPLY AND
RETURN GRILLE LOCATIONS

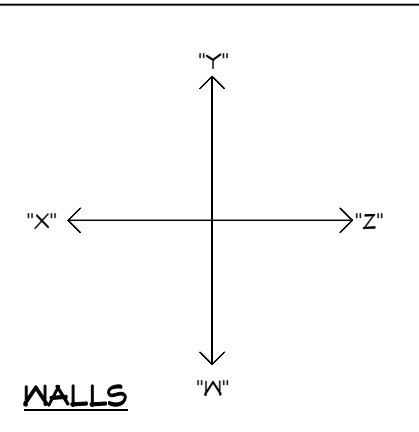

2nd FLOOR REFLECTED CEILING PLAN

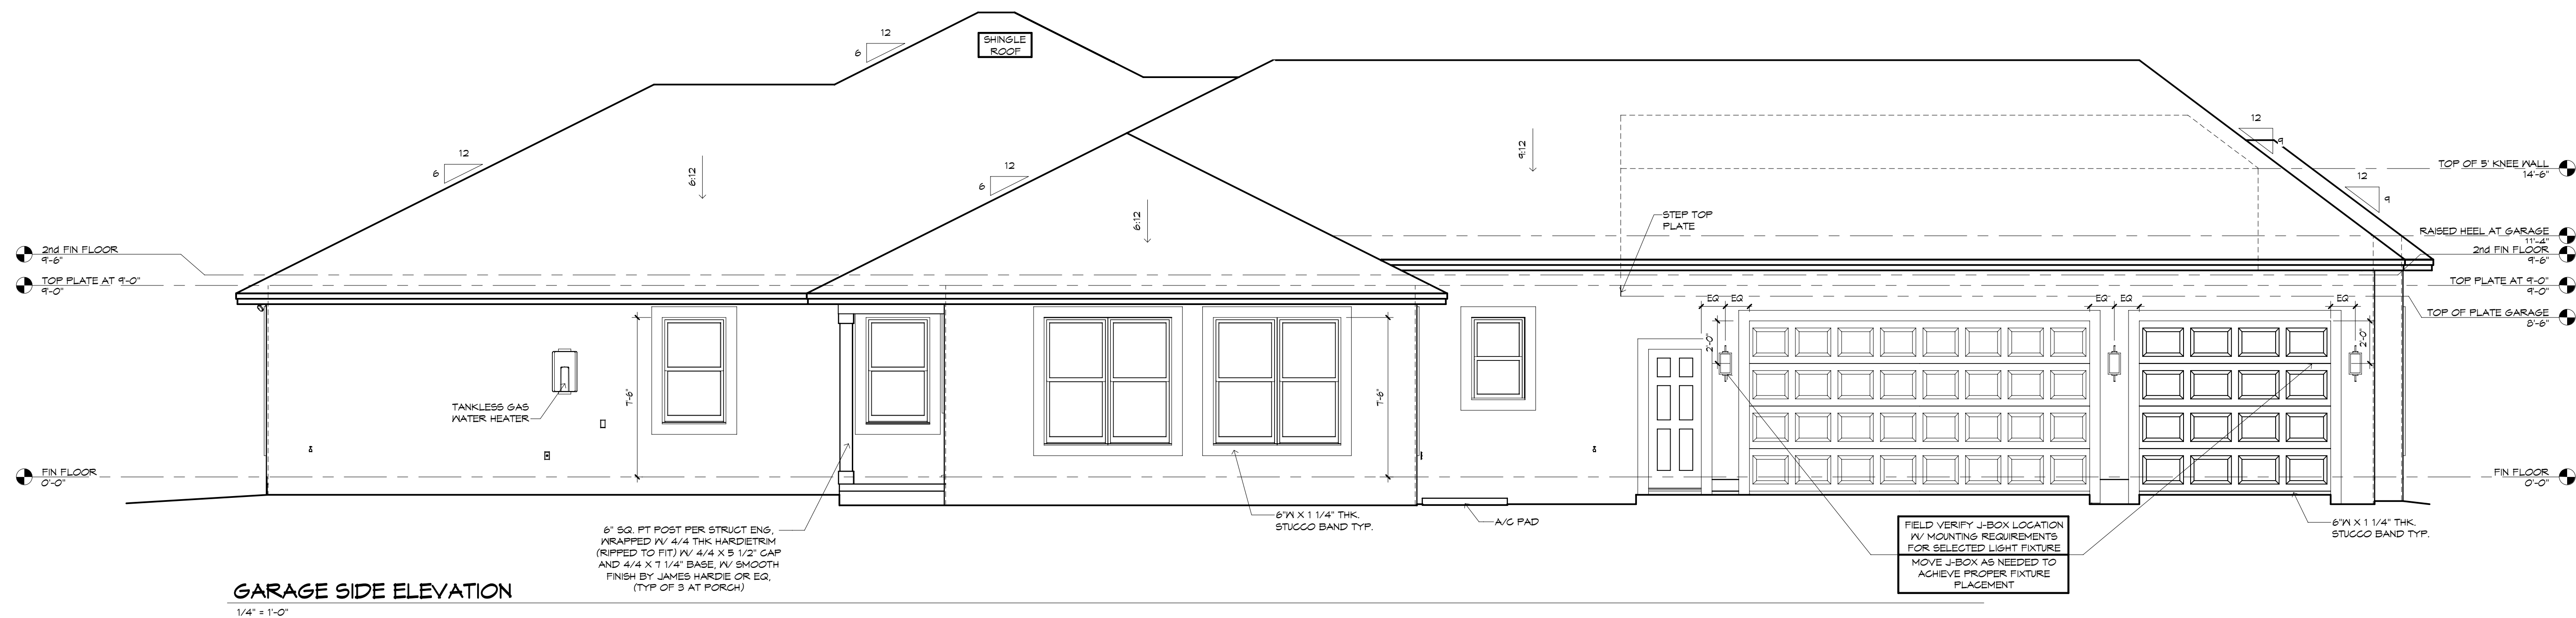

GARAGE SIDE ELEVATION
1/4" = 1'-0"

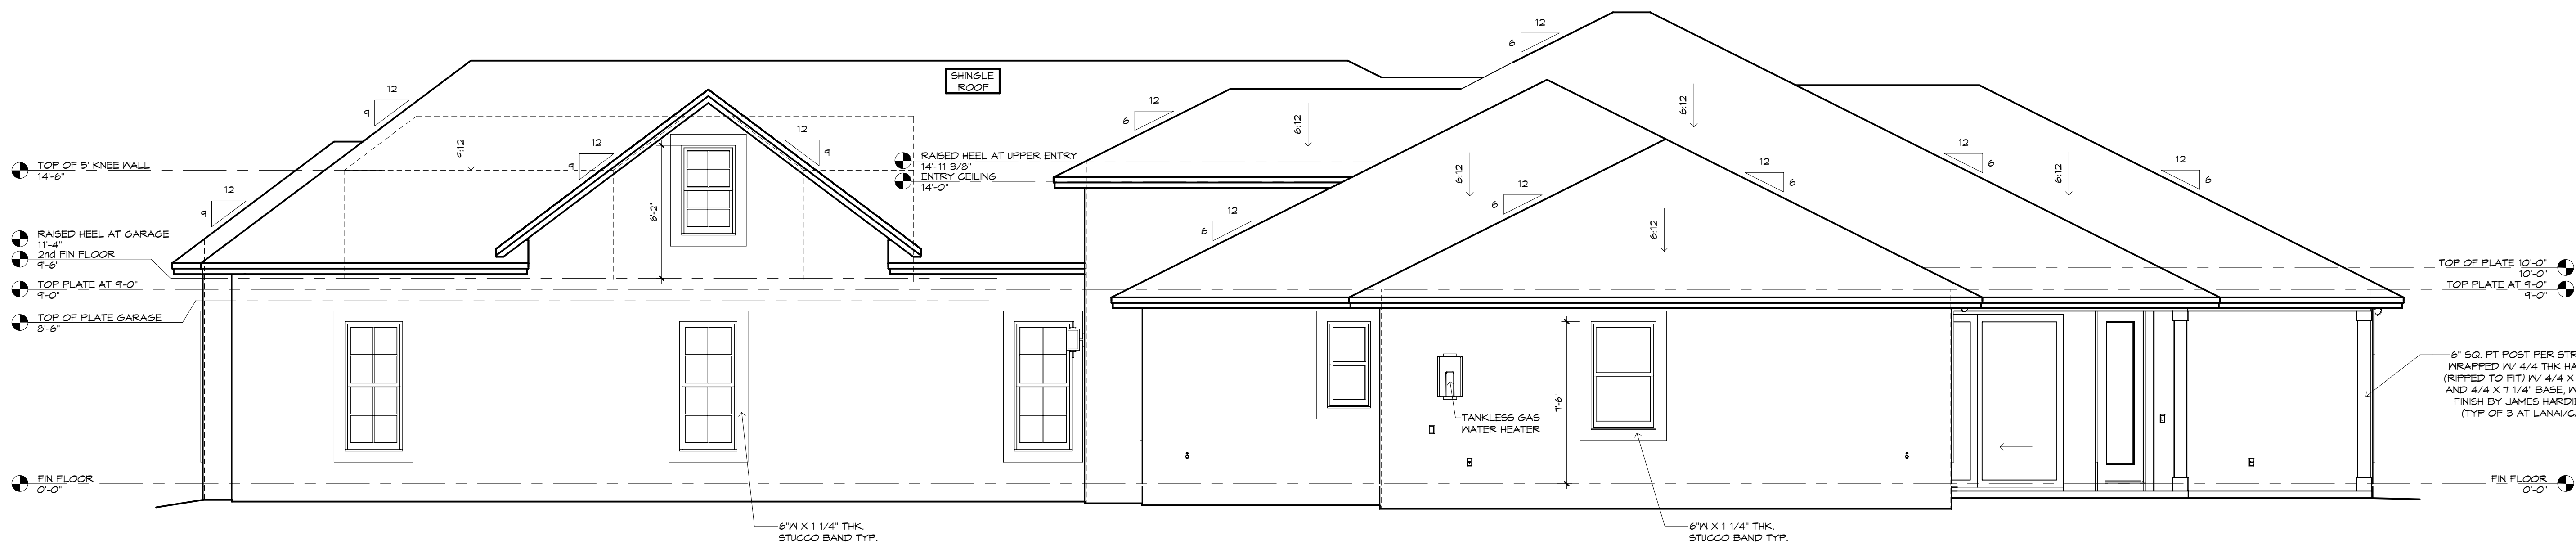

SIDE ELEVATION
1/4" = 1'-0"

!! ATTENTION !!
NOTE: IT IS THE RESPONSIBILITY OF THE BUILDER TO COORDINATE THE INSTALLATION OF ALL WATERPROOFING METHODS NECESSARY TO PROVIDE A WATER TIGHT BUILDING ENVELOPE. REFER TO MFR INSTALLATION RECOMMENDATION FOR ALL SELECTED WATERPROOFING MATERIALS, FLASHING SEALERS AND AD-MIX COMPONENTS.

FRAMING PLAN DISCLAIMER
THE FRAMING PLANS REPRESENTED IN THESE DRAWINGS ARE INTENDED TO ESTABLISH PROPOSED FRAMING MEMBER LOCATIONS, FRAMING MEMBER DEPTH, POTENTIAL BEARING LOCATIONS AND ELEVATIONS, AND IS IN NO WAY INTENDED TO BE INTERPRETED AS STRUCTURAL ENGINEERED DRAWINGS. THE CONTRACTOR (BUILDER) SHALL ENSURE THAT THE STRUCTURE CONFORMS TO THOSE STANDARDS IN ALL RESPECTS INCLUDING STRENGTH, STRESSES, STRAINS, LOADS, CONNECTIONS AND STABILITY. REFER TO PLAN DISCLAIMER LOCATED ON THIS SHEET FOR ADDITIONAL STIPULATIONS AND REQUIREMENTS.

PLAN DISCLAIMER
THESE DRAWINGS ARE THE PROPERTY OF RHOMES & ASSOCIATES, INC. AND ARE NOT TO BE REPRODUCED OR COPIED IN ANY MANNER WITHOUT THE WRITTEN PERMISSION OF RHOMES & ASSOCIATES, INC. THE BUILDER IS RESPONSIBLE FOR OBTAINING ALL NECESSARY PERMITS AND FOR THE PROPER INSTALLATION OF ALL MATERIALS AND METHODS. THE BUILDER SHALL BE RESPONSIBLE FOR THE PROPER MAINTENANCE AND REPAIR OF THE STRUCTURE. THE BUILDER SHALL BE RESPONSIBLE FOR THE PROPER MAINTENANCE AND REPAIR OF THE STRUCTURE. THE BUILDER SHALL BE RESPONSIBLE FOR THE PROPER MAINTENANCE AND REPAIR OF THE STRUCTURE.

THE LANCASTER 1752F - L - EVERETT ABELT & JENNI JONES

SIDE ELEVATIONS
PLAN 1752F 3/4" x 11'-0" (1752F)
30'-0" x 20'-0" (1752F)
BUILDER: BRYAN ZECHER RHOMES, INC.
AN INDEPENDENTLY OWNED AND OPERATED FRANCHISE


NOTE: IT IS THE RESPONSIBILITY OF THE BUILDER TO COORDINATE THE INSTALLATION OF ALL WATER PROOFING METHODS NECESSARY TO PROVIDE A WATER TIGHT BUILDING ENVELOPE. REFER TO MFR INSTALLATION RECOMMENDATION FOR ALL SELECTED WATERPROOFING MATERIALS, FLASHING SEALERS AND ADH-K COMPONENTS

FRAMING PLAN DISCLAIMER
THE FRAMING PLANS REPRESENTED IN THESE DRAWINGS ARE INTENDED TO ESTABLISH PROPOSED FRAMING MEMBER LOCATIONS, FRAMING MEMBER DEPTH, POTENTIAL BEARING LOCATIONS AND ELEVATIONS, AND IS IN NO WAY INTENDED TO BE INTERPRETED AS STRUCTURAL ENGINEERED DRAWINGS. THE CONTRACTOR (BUILDER) SHALL ENSURE THAT THE STRUCTURE CONFORMS TO THOSE STANDARDS IN ALL RESPECTS INCLUDING STRENGTH, STRESSES, STRAINS, LOADS, CONNECTIONS, AND STABILITY. REFER TO PLAN DISCLAIMER LOCATED ON THIS SHEET FOR ADDITIONAL STIPULATIONS AND REQUIREMENTS.


11/11/2020 10:11 A
02/24/21 10:25 A
RHOMES
BRYAN ZECHER RHOMES, INC.
ALL RIGHTS RESERVED



BUILDING SECTION "A"
1/4" = 1'-0"

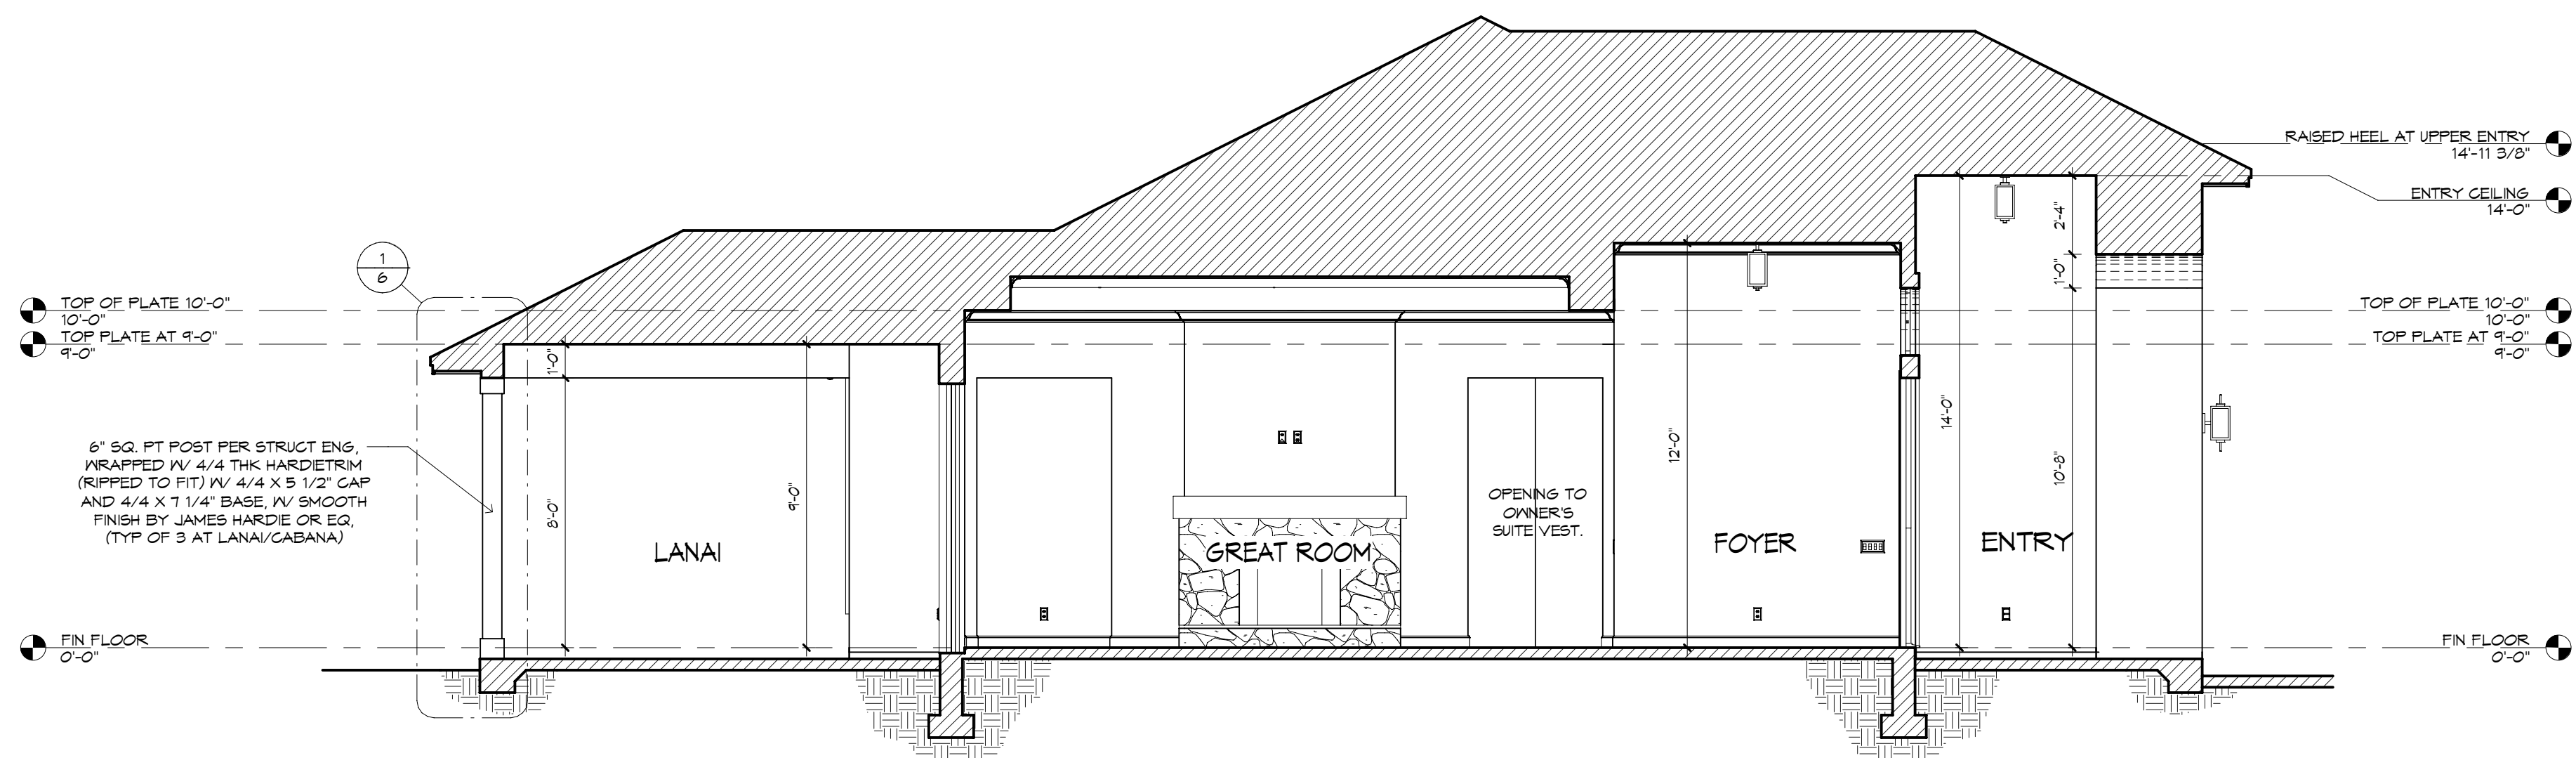


BUILDING SECTION "B"
1/4" = 1'-0"

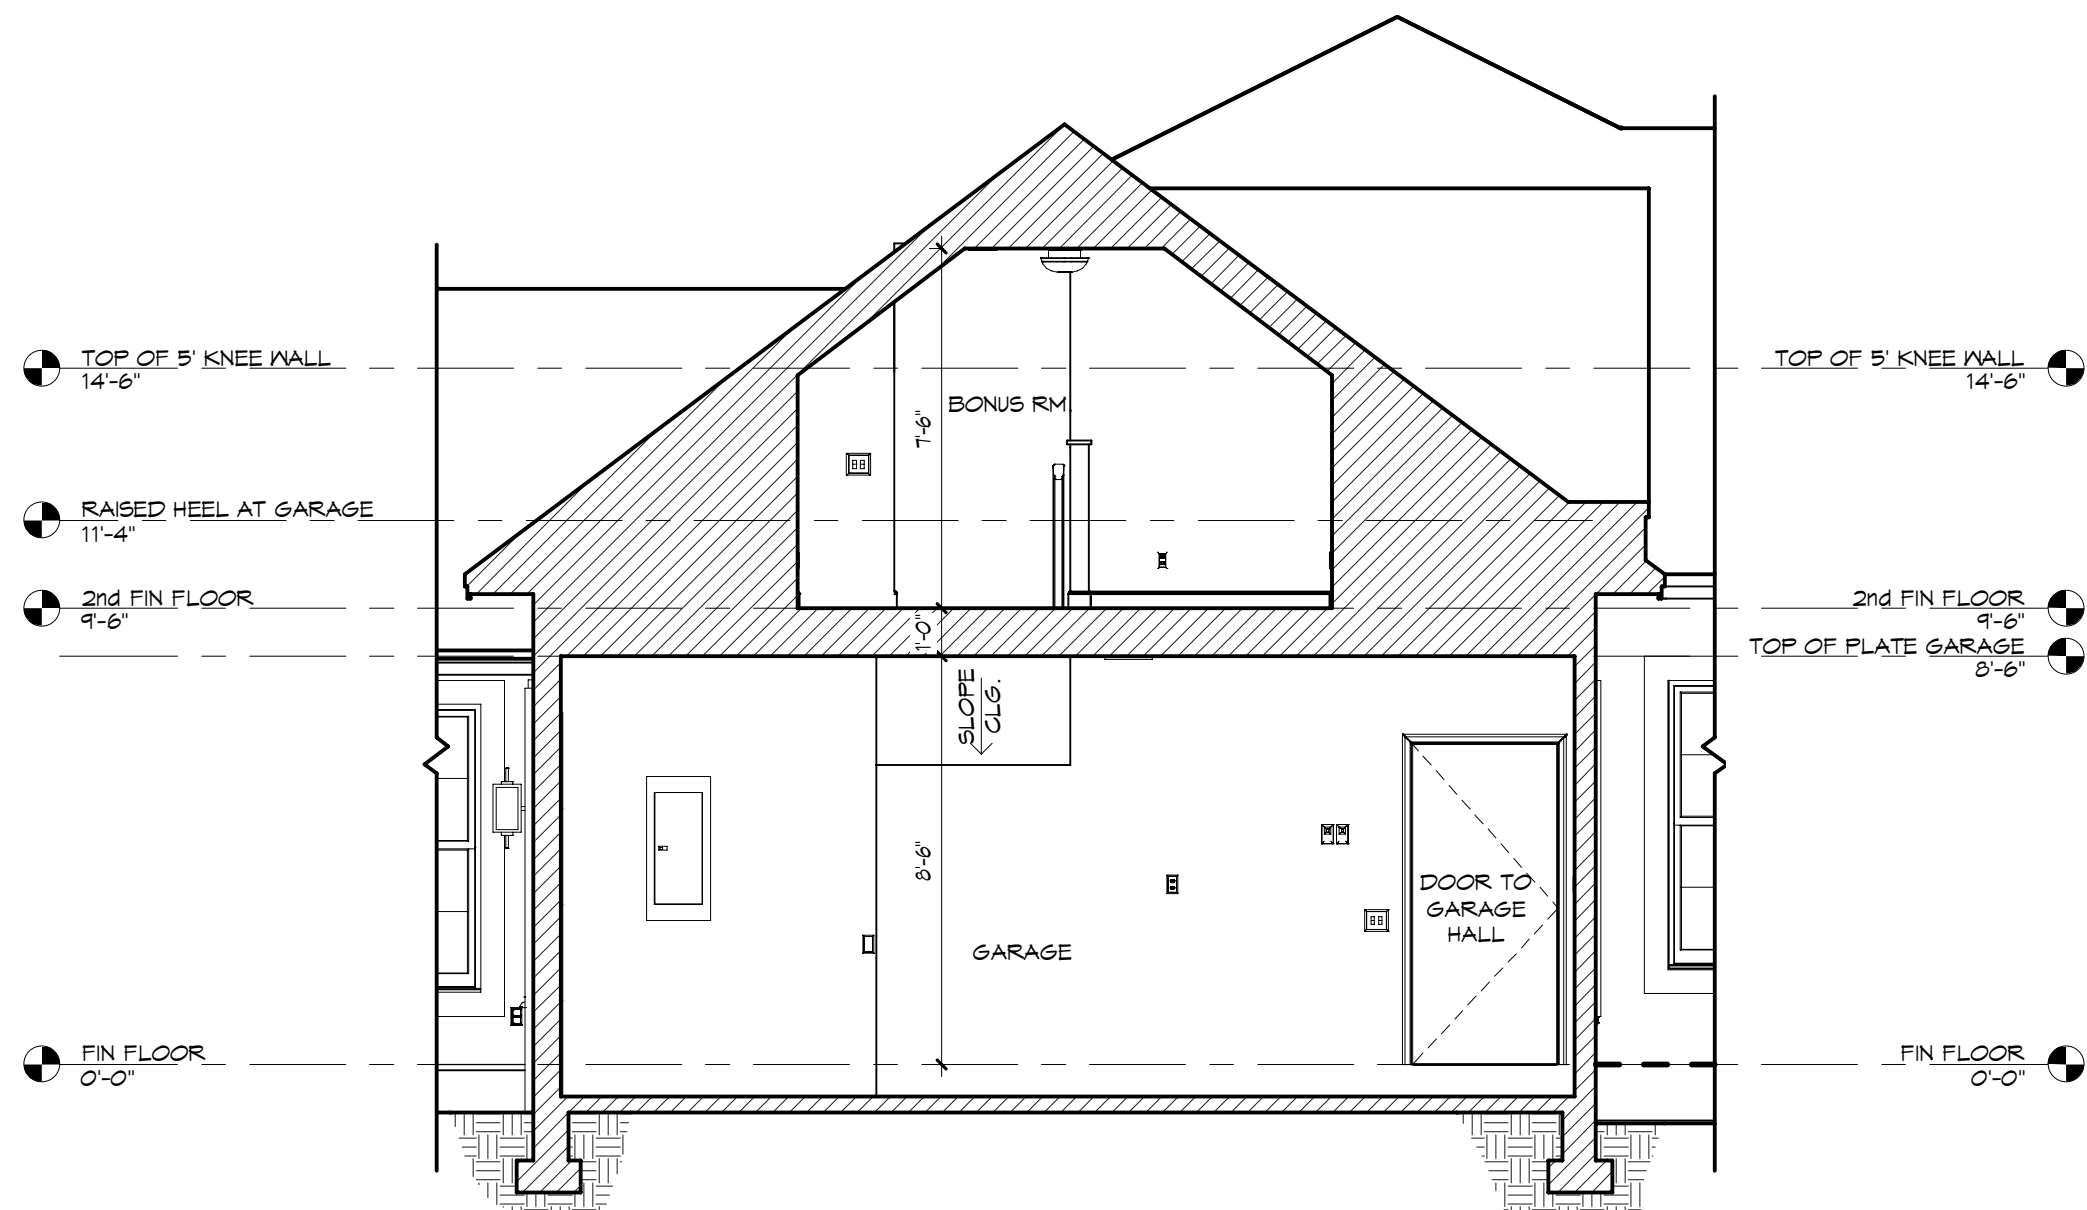

BUILDING SECTION "C"
1/4" = 1'-0"

THE LANCASTER 1752F - L - EVERETT APBET & JENNI JONES


BUILDING SECTIONS
PLAN 1752F 3/4"=1'-0" 1/4"=1'-0"
55'-20" H. JONES B
BUILDER: BRYAN ZECHER RHOMES, INC.
AN INDEPENDENTLY OWNED AND OPERATED FRANCHISE

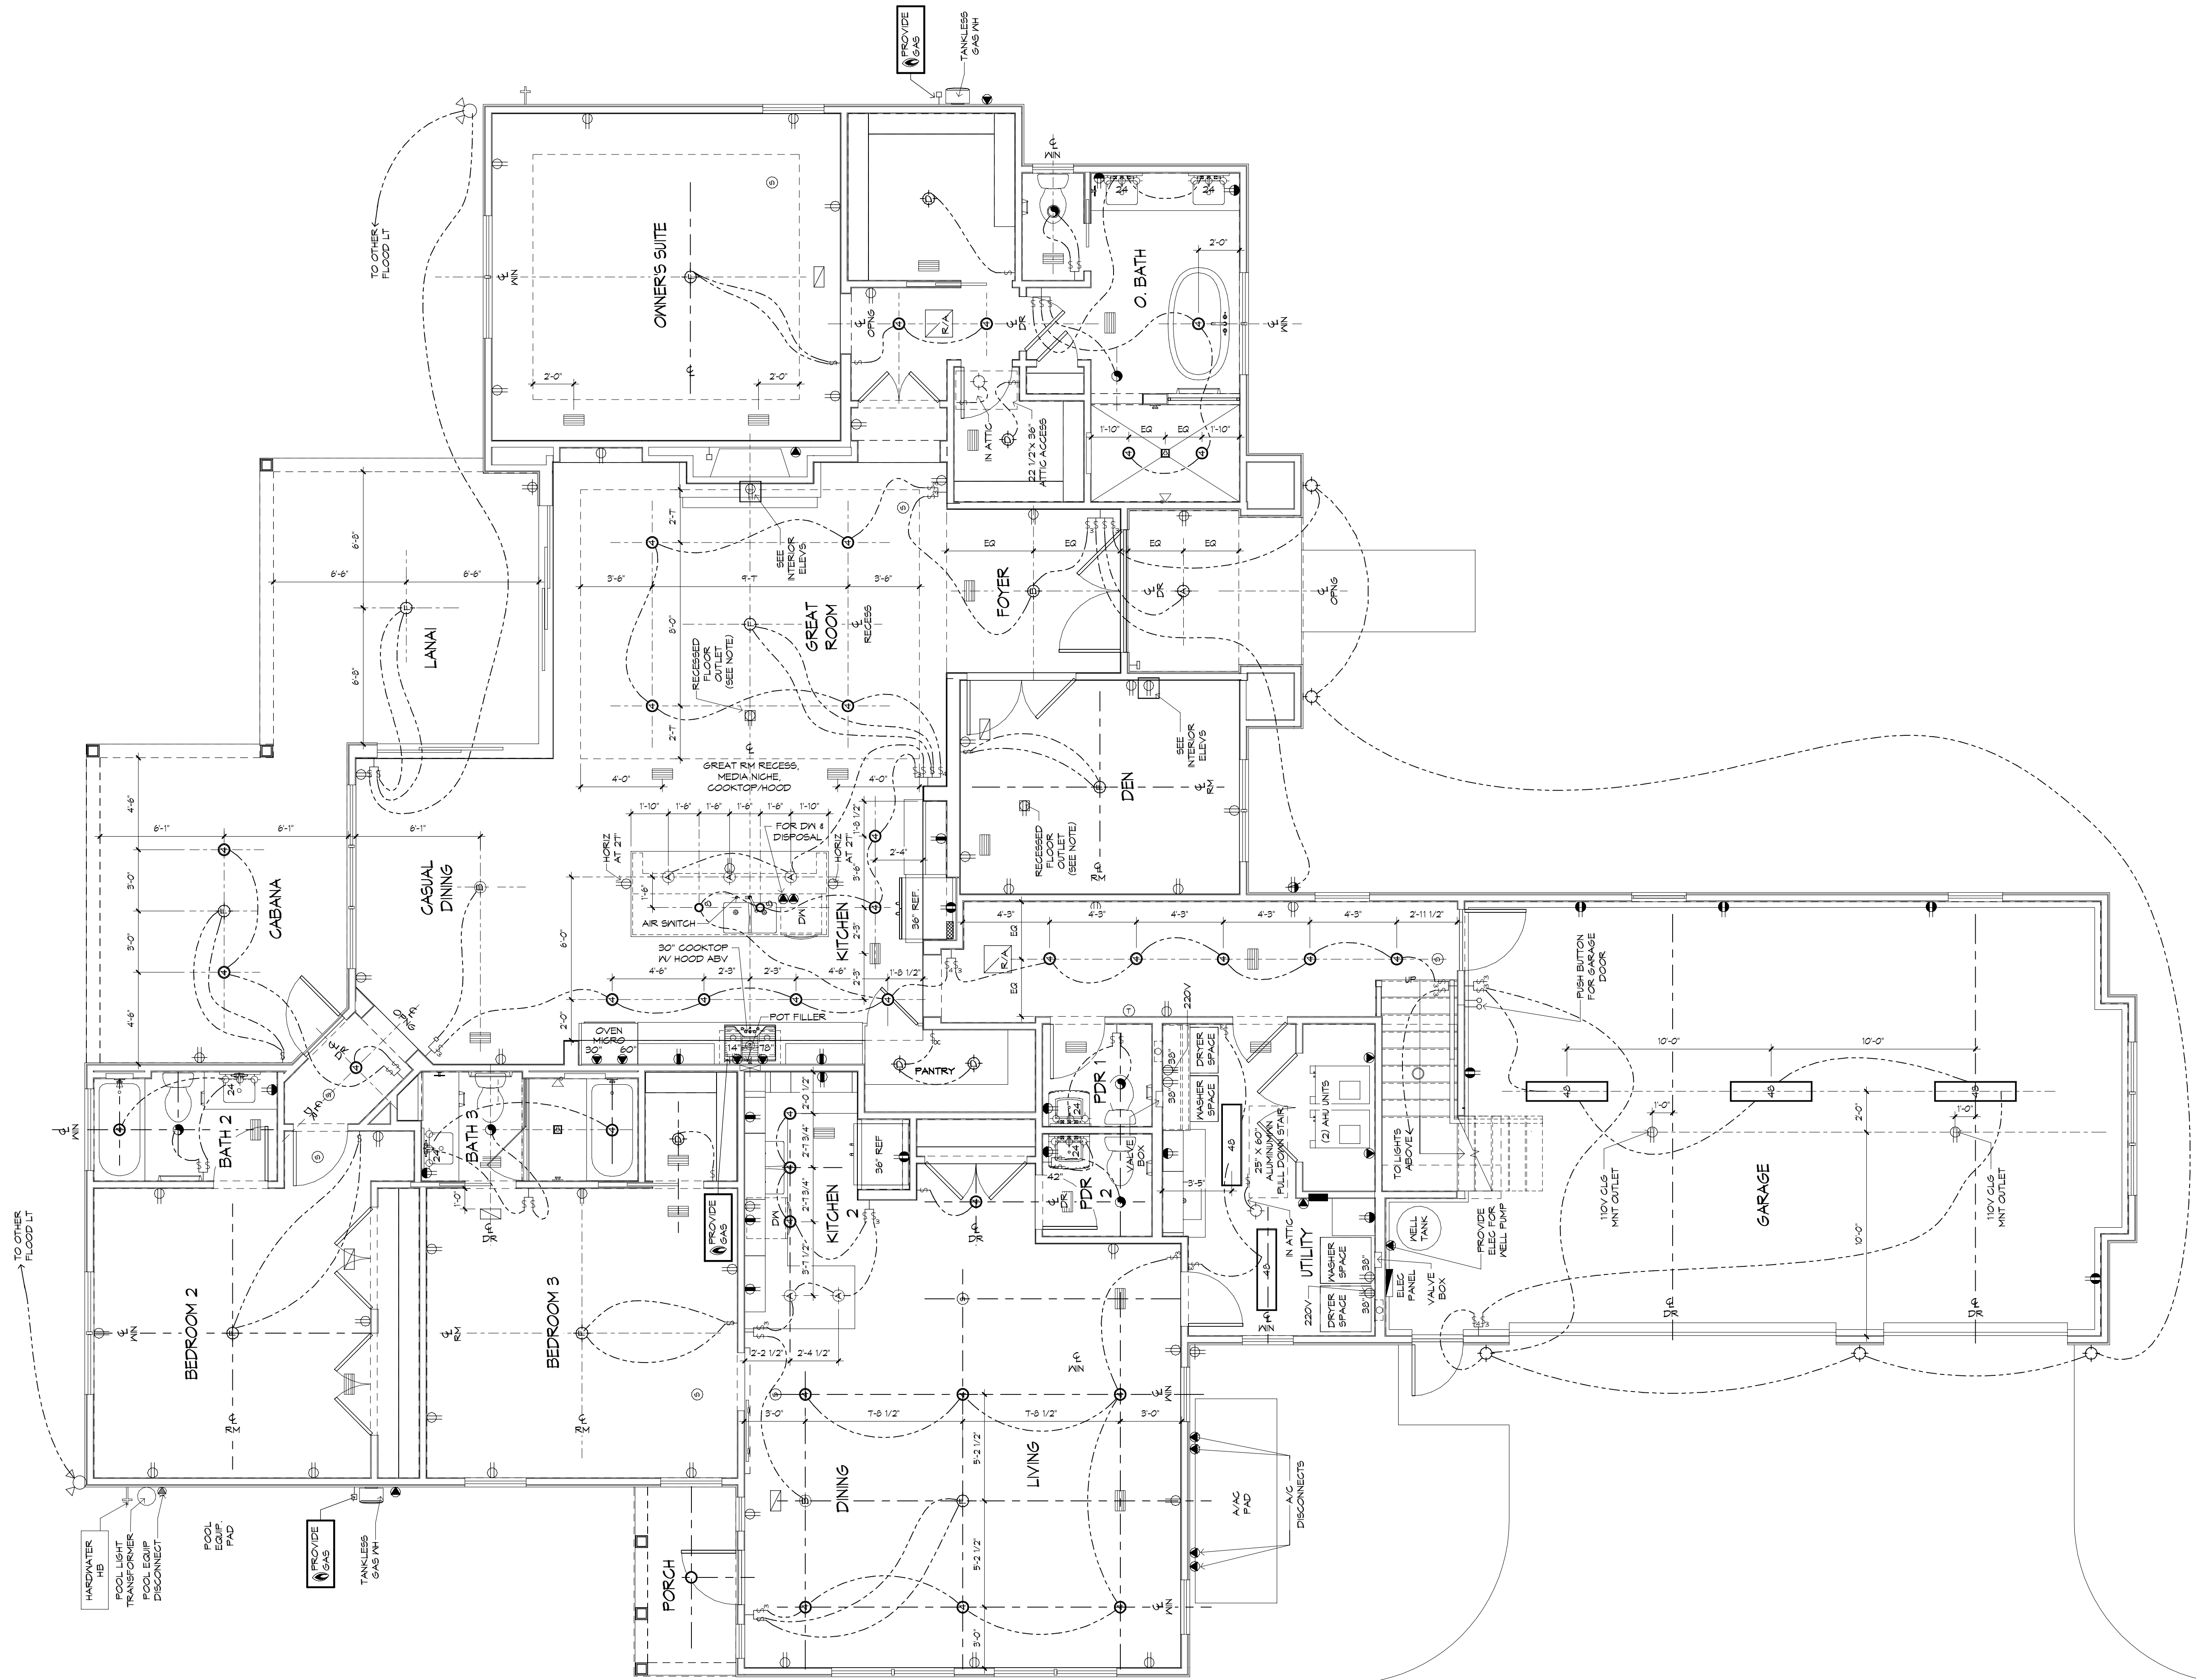

1st FLOOR ELECTRICAL PLAN
1/4" = 1'-0"

- II NOTE II**
UNDER CABINET LIGHTING & SWITCHES SHOWN FOR LOCATION PURPOSES ONLY. PLEASE REFER TO BUILDING COMPANY STANDARDS.
- WATER HEATER NOTE:**
INSTALL WATER HEATER PER MANUFACTURER'S INSTALLATION INSTRUCTIONS AND CURRENT APPLICABLE CODES.
- LOW VOLTAGE NOTE:**
BUILDING COMPANY TO COORDINATE ALL TV AND CABLE OUTLETS WITH LOW VOLTAGE CONTRACTOR.
- LED LIGHTING NOTE:**
ALL LED LIGHTING, INCLUDING RECESSED CAN BULBS, LED TAPE LIGHT, UNDER CABINET LIGHTING AND ACCENT LIGHTING SHALL BE 3000K.
- NOTE:**
VERIFY CLEARANCE OF TRIM IN ALL CEILINGS AND SOFFITS WITH RECESSED CAN, A/C SUPPLY AND RETURN GRILLE LOCATIONS.
- FLOOR OUTLET NOTE:**
RECESSED FLOOR OUTLET (FULLY CONCEAL, BELOW FLOOR LEVEL) 160-P W/COVER PLATE BY: THOMAS & BETTS, INC. OR EQUAL.

MECHANICAL DISCLAIMER
ANY DUCT ROUTING AND HVAC EQUIPMENT SHOWN ON THESE DRAWINGS ARE DIAGNOSTIC ONLY. THE BUILDER IS SOLELY RESPONSIBLE FOR COORDINATING ALL ASPECTS OF MECHANICAL INSTALLATION WITH ALL TRADES. THE BUILDER SHALL COORDINATE BETWEEN THE PRE-ENGINEERED TRUSS HFR AND/OR FRAMING REQUIREMENTS WITH THE MECHANICAL CONTRACTOR TO ENSURE ADEQUATE SPACE FOR DUCT ROUTING AND EQUIPMENT PLACEMENT AND SUPPORT. HVAC INSTALLATION SHALL BE INSTALLED ACCORDING TO ALL CURRENT STATE AND LOCAL MECHANICAL CODES.

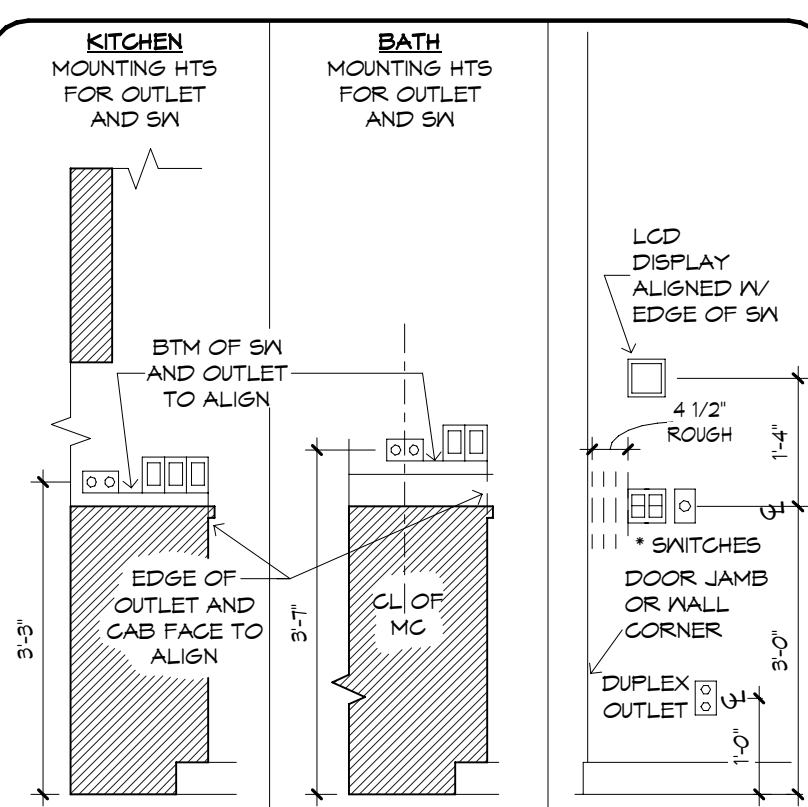

THE ITEMS BELOW ARE SHOWN FOR LOCATION PURPOSES ONLY. PLEASE REFER TO LOCAL SPECS TO DETERMINE WHETHER OR NOT THE FOLLOWING ITEMS ARE INCLUDED:

- LIGHTING OR ELECTRONICS (LCD DISPLAY OR LIGHTING AUTOMATION PUSH BUTTON CONTROLLER)
- VOLUME CONTROL KNOB

* USE MAX OF 6 GANG BOXES. FOR GANG BOXES OF 3 OR MORE THAT ARE LOCATED ON BLOCK WALL, CHOP OUT THE BLOCK TO ACCOMMODATE DEEPER BOX.


NOTE: ALL DIMENSIONS ARE FOR ROUGH FRAMING

ELECTRICAL DETAILS
SCALE: 1/2" = 1'-0" UPDATED 10/14/16
1/2" = 1'-0"

ELECTRICAL LEGEND

- 1) DUPLEX OUTLET (110V AT 12" OR AS NTD)
 - 2) DUPLEX OUTLET (110V AT 36")
 - 3) DUPLEX OUTLET (110V AT 48")
 - 4) SPLIT DUPLEX OUTLET (110V AT 12") TOP IS HOT WEATHERPROOF DUPLEX OUTLET (110V AT 12") TOP PLUS IS HOT
 - 5) 220V OUTLET
 - 6) RECESSED FLOOR OUTLET
 - 7) SPECIAL PURPOSE CONN
 - 8) STRUCTURED WIRE COMBO OUTLET
 - 9) USB PORT FOR OUTLETS (110V AT 12" OR AS NTD)
 - 10) 5W SEE ELEC DTL
 - 11) 3-WAY 5W SEE ELEC DTL
 - 12) 4-WAY 5W SEE ELEC DTL
 - 13) 5-GANG COMBINATION FAN / LIGHT SWITCH OCCUPANCY/MOTION DETECTOR SWITCH
 - 14) PUSH-BUTTON FOR GARAGE DOOR AT 60"
 - 15) DIMMER 5W AT 36"
 - 16) PUSH-BUTTON DOORBELL
 - 17) CLG MNT LIGHT FIXTURE
 - 18) CLG MNT PREHIRE - FIXTURE BY OWNER
 - 19) SURFACE MNT FIXTURE
 - 20) 7" SURFACE MNT 3000K, 1000 LUMEN, LED FIXTURE
 - 21) WALL MNT FIXTURE
 - 22) 6" ROUND RECESS 3000K LED RETROFIT TRIM W/OVEN BAFFLE
 - 23) 4" MINI ROUND RECESS 3000K LED RETROFIT TRIM W/OVEN BAFFLE
 - 24) 4" MINI ROUND RECESS 3000K LED EYEBALL TRIM
 - 25) 6" ROUND SLOPE CLG RECESS WITH 3000K LED BULB (INTERIOR SLOPED GLG)
 - 26) 2 1/2" MINI ROUND LED 3000K
 - 27) CLG FAN/LIGHT PREHIRE AND SWITCHES
 - 28) SMOKE DETECTOR OR COMBO SMOKE & CARBON MONOXIDE DETECTOR, PER CODE
 - 29) 4"-14" UNDER CABINET LED 14"
 - 30) 4"-22" UNDER CABINET LED 22"
 - 31) U-3000 UNDER CABINET LED 30"
 - 32) 40" CLG MNT 3000K, LED FIXTURE
 - 33) 24" VANITY LIGHTING (SEE SPECS)
 - 34) 36" VANITY LIGHTING (SEE SPECS)
 - 35) EXHAUST FAN / LIGHT FIXTURE COMBO
 - 36) EXHAUST FAN
 - 37) SOFFIT MNT FLOOD LIGHT
 - 38) CLG MNT SPEAKER
 - 39) GAMES
 - 40) ELEC PANEL
 - 41) STRUCTURED WIRING PANEL
 - 42) CLG RETURN AIR
 - 43) A/C REGISTER
 - 44) THERMOSTAT
 - 45) SECURITY PAD
- NOTE: ALL OUTLETS ABOVE COUNTERS SHALL BE MOUNTED HORIZONTALLY.
- NOTE: ALL 120V, 15 AND 20 AMP OUTLETS TO BE TAMPER-RESISTANT IN AREAS SPECIFIED BY NEC 2014 408.12
- NOTE: ALL EXTERIOR OUTLETS, OUTLETS IN GARAGE, WALL OUTLETS IN KITCHENS AND BATHROOMS AND ALL OUTLETS WITHIN 6'-0" OF A WATER SOURCE SHALL BE GFI. ALL NON-GFI OR 220V OUTLETS ARE PROTECTED BY AN ARC-FAULT CIRCUIT INTERRUPTER. ALL HEIGHTS TO CENTERLINE AFF.
- NOTE: LIGHTS, FANS, SMOKE DETECTORS, A/C SUPPLIES AND RETURN AIRS TO BE PLACED ON CENTERLINES OF DOORS, ROOMS AND HALLWAYS, TYP UNO
- NOTE: COORDINATE LOCATION OF ALL REG ELECTRICAL, CABLE, AUDIO/VIDEO & DATA RECEPTACLES WITH MOUNTING HARDWARE & HFR INSTALLATION REQ FOR ALL FLAT PANEL DISPLAYS.

- ELECTRICAL NOTES:**
- 1) BASE PLAN ELECTRIC - COPPER WIRING FROM BREAKER PANEL THROUGHOUT HOME. PANEL BOX W/ SURGEBREAKER SURGE PROTECTION DEVICE (WQ217958) MINIMUM 200 AMP SINGLE PHASE 120/240 V SERVICE.
 - 2) STRUCTURED WIRING: 1-36" STRUCTURED CABLING ENCLOSURE & FLUSH MOUNT COVER 1-36" ELECTRICAL OUTLET FOR Foyer IN ENCLOSURE 1-5 PORT BRIDGED TELECOM MODULE WITH RJ45X PORT FOR THE SECURITY SYSTEM 1-10 KVM VIDEO SPLITTER 1-6/6 GIGABIT ETHERNET SWITCH 5X 10/ 100/ 1000 1-UTILITY INTERFACE WIRE WITH ONE CAT 5E AND ONE RG-6 CABLE TO GO FROM THE D-MARK TO THE STRUCTURED WIRING CABINET 10-TV/CABLE VIDEO OR MODERN PORTS 12-PHONE AND DATA CONNECTION, HOME NETWORK AND BROADBAND PORTS
 - 3) PROVIDE AFCIS (ARC-FAULT CIRCUIT INTERRUPTERS) IN ALL DWELLING UNIT BEDROOMS PER NEC, SECTION 210-12.
 - 4) HVAC - CARRIER 16 SEER STRAIGHT COOL, 1/4" VARIABLE SPEED HANDLER & 1.5-10 KW HEAT STRIPS, FV PROGRAMMABLE THERMOSTAT.
 - 5) LED LIGHTING: RECESSED CAN BULBS, FLUORESCENT LIGHTING, UNDER CABINET LIGHTING, IN-CABINET LIGHTING AND ROPE LIGHTING FIXTURES AND BULBS TO BE LED.
 - 6) SECURITY SYSTEM - 1-PS96 POWERSERIES PG 18932 CONTROL PANEL INCLUDES 1 STANDARD KEYPAD, EXTERIOR SIREN, INTERIOR SIREN, MOTION DETECTOR, ALL WINDOWS AND DOORS SENSORED AND BATTERY BACKUP.
 - 7) HVAC (2) ADDITIONAL HVAC ZONES AS SHOWN AT THE REGATTA MODEL AT 605 N. HENRY ST. PUNTA GORDA.
 - 8) WHOLE HOUSE SPEAKER SYSTEM AS SHOWN AT THE REGATTA MODEL AT 605 N. HENRY ST. PUNTA GORDA.
 - 9) HOME AUTOMATION SYSTEM AS SHOWN AT THE REGATTA MODEL AT 605 N. HENRY ST. PUNTA GORDA.
 - 10) PREHIRE FOR MOTORIZED SHADES, LOCATIONS T.B.D.

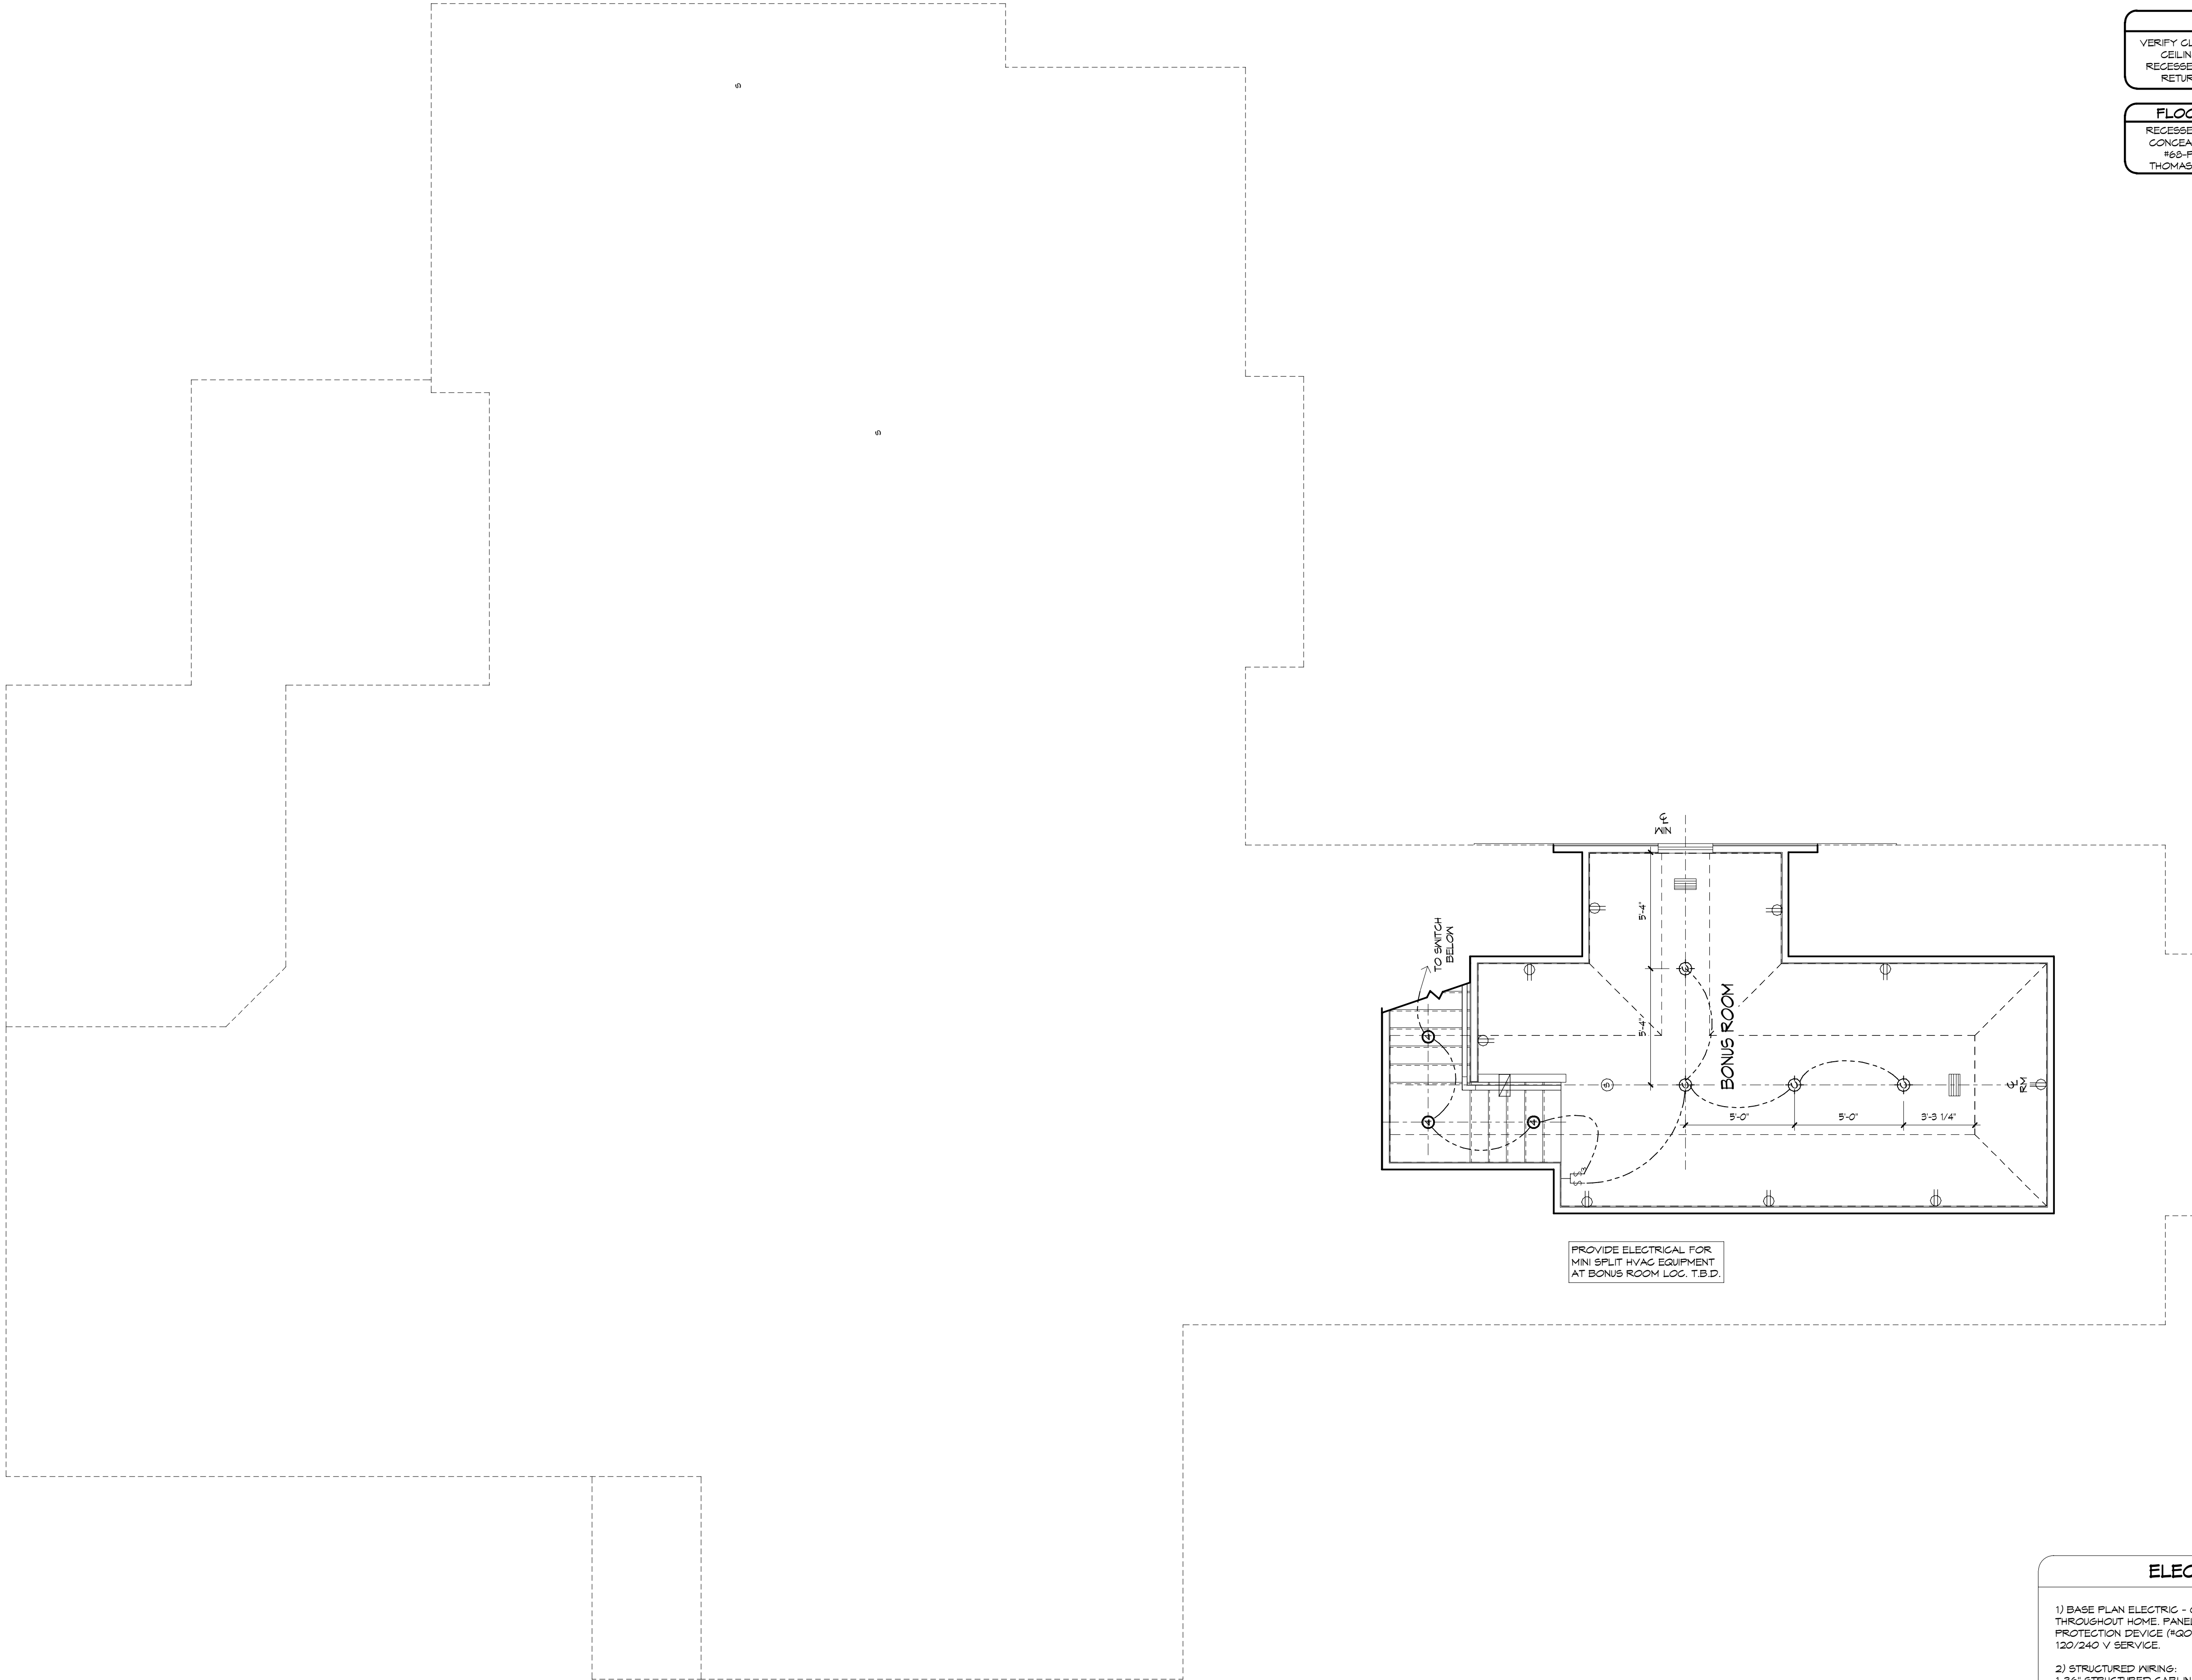

2nd FLOOR ELECTRICAL PLAN
1/4" = 1'-0"

ELECTRICAL NOTES:

- 1) BASE PLAN ELECTRIC - COPPER WIRING FROM BREAKER PANEL THROUGHOUT HOME. PANEL BOX W/ SURGEBREAKER SURGE PROTECTION DEVICE (400217558). MINIMUM 200 AMP SINGLE PHASE 120/240 V SERVICE.
- 2) STRUCTURED WIRING:
1-36" STRUCTURED CABLES ENCLOSURE 1 FLUSH MOUNT COVER
1-36" ELECTRICAL OUTLET FOR POWER IN ENCLOSURE
1-8 PORT BRIDGED TELECOM MODULE WITH RJ-45/1X PORT FOR THE SECURITY SYSTEM
1-10 WAY VIDEO SPLITTER
1-6/8GBIT ETHERNET SWITCH 5X 10/ 100/ 1000
1-UTILITY INTERFACE WIRE WITH ONE CAT 5E AND ONE RG-6 CABLE TO GO FROM THE 24-MARK TO THE STRUCTURED WIRING CABINET
10-TV/CABLE VIDEO OR MODEM PORTS
12-PHONE AND DATA CONNECTION, HOME NETWORK AND BROADBAND PORTS
- 3) PROVIDE AFCIS (ARC-FAULT CIRCUIT INTERRUPTERS) IN ALL DWELLING UNIT BEDROOMS PER NEC, SECTION 210-12.
- 4) HVAC - CARRIER 16 SEER STRAIGHT COOL W/ VARIABLE SPEED HANDLER & 15-10 KW HEAT STRIPS W/ PROGRAMMABLE THERMOSTAT.
- 5) LED LIGHTING, RECESSED CAN BULBS, FLUORESCENT LIGHTING, UNDER CABINET LIGHTING, IN-CABINET LIGHTING AND ROPE LIGHTING FIXTURES AND BULBS TO BE LED
- 6) SECURITY SYSTEM - 1-DS2 POWERSERIES PC 1892 CONTROL PANEL INCLUDES 1 STANDARD KEYPAD, EXTERIOR SIREN, INTERIOR SIREN, MOTION DETECTOR, ALL WINDOWS AND DOORS MONITORED AND BATTERY BACKUP.
- 7) HVAC (2) ADDITIONAL HVAC ZONES AS SHOWN AT THE REGATTA MODEL AT 605 N. HENRY ST. PUNTA GORDA.
- 8) WHOLE HOUSE SPEAKER SYSTEM AS SHOWN AT THE REGATTA MODEL AT 605 N. HENRY ST. PUNTA GORDA.
- 9) HOME AUTOMATION STEM AS SHOWN AT THE REGATTA MODEL AT 605 N. HENRY ST. PUNTA GORDA.
- 10) PREWIRE FOR MOTORIZED SHADES, LOCATIONS T.B.D.

ELECTRICAL LEGEND

- DUPLEX OUTLET (110V AT 12" OR AS NTD)
 - DUPLEX OUTLET (110V AT 54") *
 - DUPLEX OUTLET (110V AT 48") *
 - DUPLEX OUTLET (110V AT 48") *
 - SPLIT DPLX OUTLET (110V AT 12") TOP IS HOT
 - WEATHERPROOF DPLX OUTLET (110V AT 12")
 - WEATHERPROOF DPLX OUTLET (110V AT 12")
 - TOP PLUG IS HOT
 - 220V OUTLET
 - RECESS FLOOR OUTLET
 - SPECIAL PURPOSE CONN
 - STRUCTURED WIRE COMBO OUTLET
 - USB PORT FOR OUTLETS (110V AT 12" OR AS NTD)
 - 5X SEE ELEG DTL
 - 3-WAY 5X SEE ELEG DTL
 - 4-WAY 5X SEE ELEG DTL
 - 1-6" SANG COMBINATION FAN / LIGHT SWITCH
 - OCCUPANCY/MOTION DETECTOR SWITCH
 - PUSH-BUTTON FOR GARAGE DOOR AT 60"
 - DIMMER 5X AT 36"
 - PUSH-BUTTON DOORBELL
 - CLG MNT LST FIXTURE
 - CLG MNT PREWIRE - FIXTURE BY OWNER
 - SURFACE MNT FIXTURE
 - 1" SURFACE MNT 3000K, 1000 LUMEN, LED FIXTURE
 - WALL MNT FIXTURE
 - 6" ROUND RECESS 3000K LED RETROFIT TRIM W/ OPEN BAFFLE
 - 4" MINI ROUND RECESS 3000K LED RETROFIT TRIM W/ OPEN BAFFLE
 - 4" MINI ROUND RECESS 3000K LED EYEBALL TRIM
 - 6" ROUND SLOPE CLG RECESS WITH 3000K LED BULB INTERIOR SLOPED GLG
 - 2 1/2" MINI ROUND LED 3000K
 - CLG FAN/LIGHT PREWIRE AND SWITCHES
 - SMOKE DETECTOR OR COMBO SMOKE & CARBON MONOXIDE DETECTOR, PER CODE
 - 48" CLG MNT 3000K, LED FIXTURE
 - 24" VANTY LIGHTING (SEE SPECS)
 - 36" VANTY LIGHTING (SEE SPECS)
 - EXHAUST FAN / LIGHT FIXTURE COMBO
 - EXHAUST FAN
 - CLG MNT SPEAKER
 - GHMS
 - ELEG PANEL
 - STRUCTURED WIRING PANEL
 - CLG RETURN AIR
 - A/C REGISTER
 - THERMOSTAT
 - SECURITY PAD
- * NOTE: ALL OUTLETS ABOVE COUNTERS SHALL BE MOUNTED HORIZONTALLY.
- * NOTE: ALL 120V, 15 AND 20 AMP OUTLETS TO BE TAMPER-RESISTANT IN AREAS SPECIFIED BY NEC 2014 408.12.
- * NOTE: ALL EXTERIOR OUTLETS, OUTLETS IN GARAGE, WALL OUTLETS IN KITCHENS AND BATHROOMS AND ALL OUTLETS WITHIN 6'-0" OF A WATER SOURCE SHALL BE GFI.
- * NOTE: ALL NON-GFI OR 220V OUTLETS ARE PROTECTED BY AN ARC-FAULT CIRCUIT INTERRUPTER, ALL HEIGHTS TO CENTERLINE AFF.
- * NOTE: LIGHTS, FANS, SMOKE DETECTORS, A/C SUPPLIES AND RETURN AIRS TO BE PLACED ON CENTERLINES OF DOORS, MDYS AND HALLWAYS, TYP UNO
- * NOTE: COORDINATE LOCATION OF ALL REG ELECTRICAL, CABLE, AUDIO/VIDEO & DATA RECEPTACLES W/ MOUNTING HARDWARE & WFR INSTALLATION REQ FOR ALL FLAT PANEL DISPLAYS.

UPDATED 6/30/20

|| NOTE ||
UNDER CABINET LIGHTING & SWITCHES SHOWN FOR LOCATION PURPOSES ONLY. PLEASE REFER TO BUILDING COMPANY STANDARDS.

WATER HEATER NOTE:
INSTALL WATER HEATER PER MANUFACTURERS INSTALLATION INSTRUCTIONS AND CURRENT APPLICABLE CODES.


LOW VOLTAGE NOTE:
BUILDING COMPANY TO COORDINATE ALL TV AND CABLE OUTLETS W/ LOW VOLTAGE CONTRACTOR.


LED LIGHTING NOTE:
ALL LED LIGHTING, INCLUDING RECESSED CAN BULBS, LED TAPE LIGHT, UNDER CABINET LIGHTING AND ACCENT LIGHTING SHALL BE 3000K.

NOTE:
VERIFY CLEARANCE OF TRIM IN ALL CEILINGS AND SOFFITS WITH RECESSED CAN, A/C SUPPLY AND RETURN GRILLE LOCATIONS.


FLOOR OUTLET NOTE:
RECESSED FLOOR OUTLET (FULLY CONCEAL BELOW FLOOR LEVEL) 165-P W/ COVER PLATE BY: THOMAS & BETTS, INC. OR EQUAL.

MECHANICAL DISCLAIMER
ANY DUCT ROUTING AND HVAC EQUIPMENT SHOWN ON THESE DRAWINGS ARE DIAGRAMMATIC ONLY. THE BUILDER IS SOLELY RESPONSIBLE FOR COORDINATING ALL ASPECTS OF MECHANICAL INSTALLATION WITH ALL TRADES. THE BUILDER SHALL COORDINATE BETWEEN THE PRE-ENGINEERED TRUSS WFR AND/OR FRAMING REQUIREMENTS WITH THE MECHANICAL CONTRACTOR TO ENSURE ADEQUATE SPACE FOR DUCT ROUTING AND EQUIPMENT PLACEMENT AND SUPPORT. HVAC INSTALLATION SHALL BE INSTALLED ACCORDING TO ALL CURRENT STATE AND LOCAL MECHANICAL CODES.

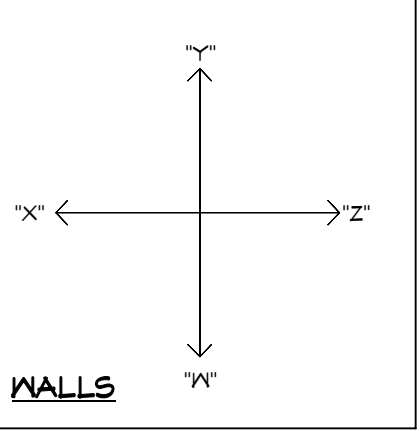

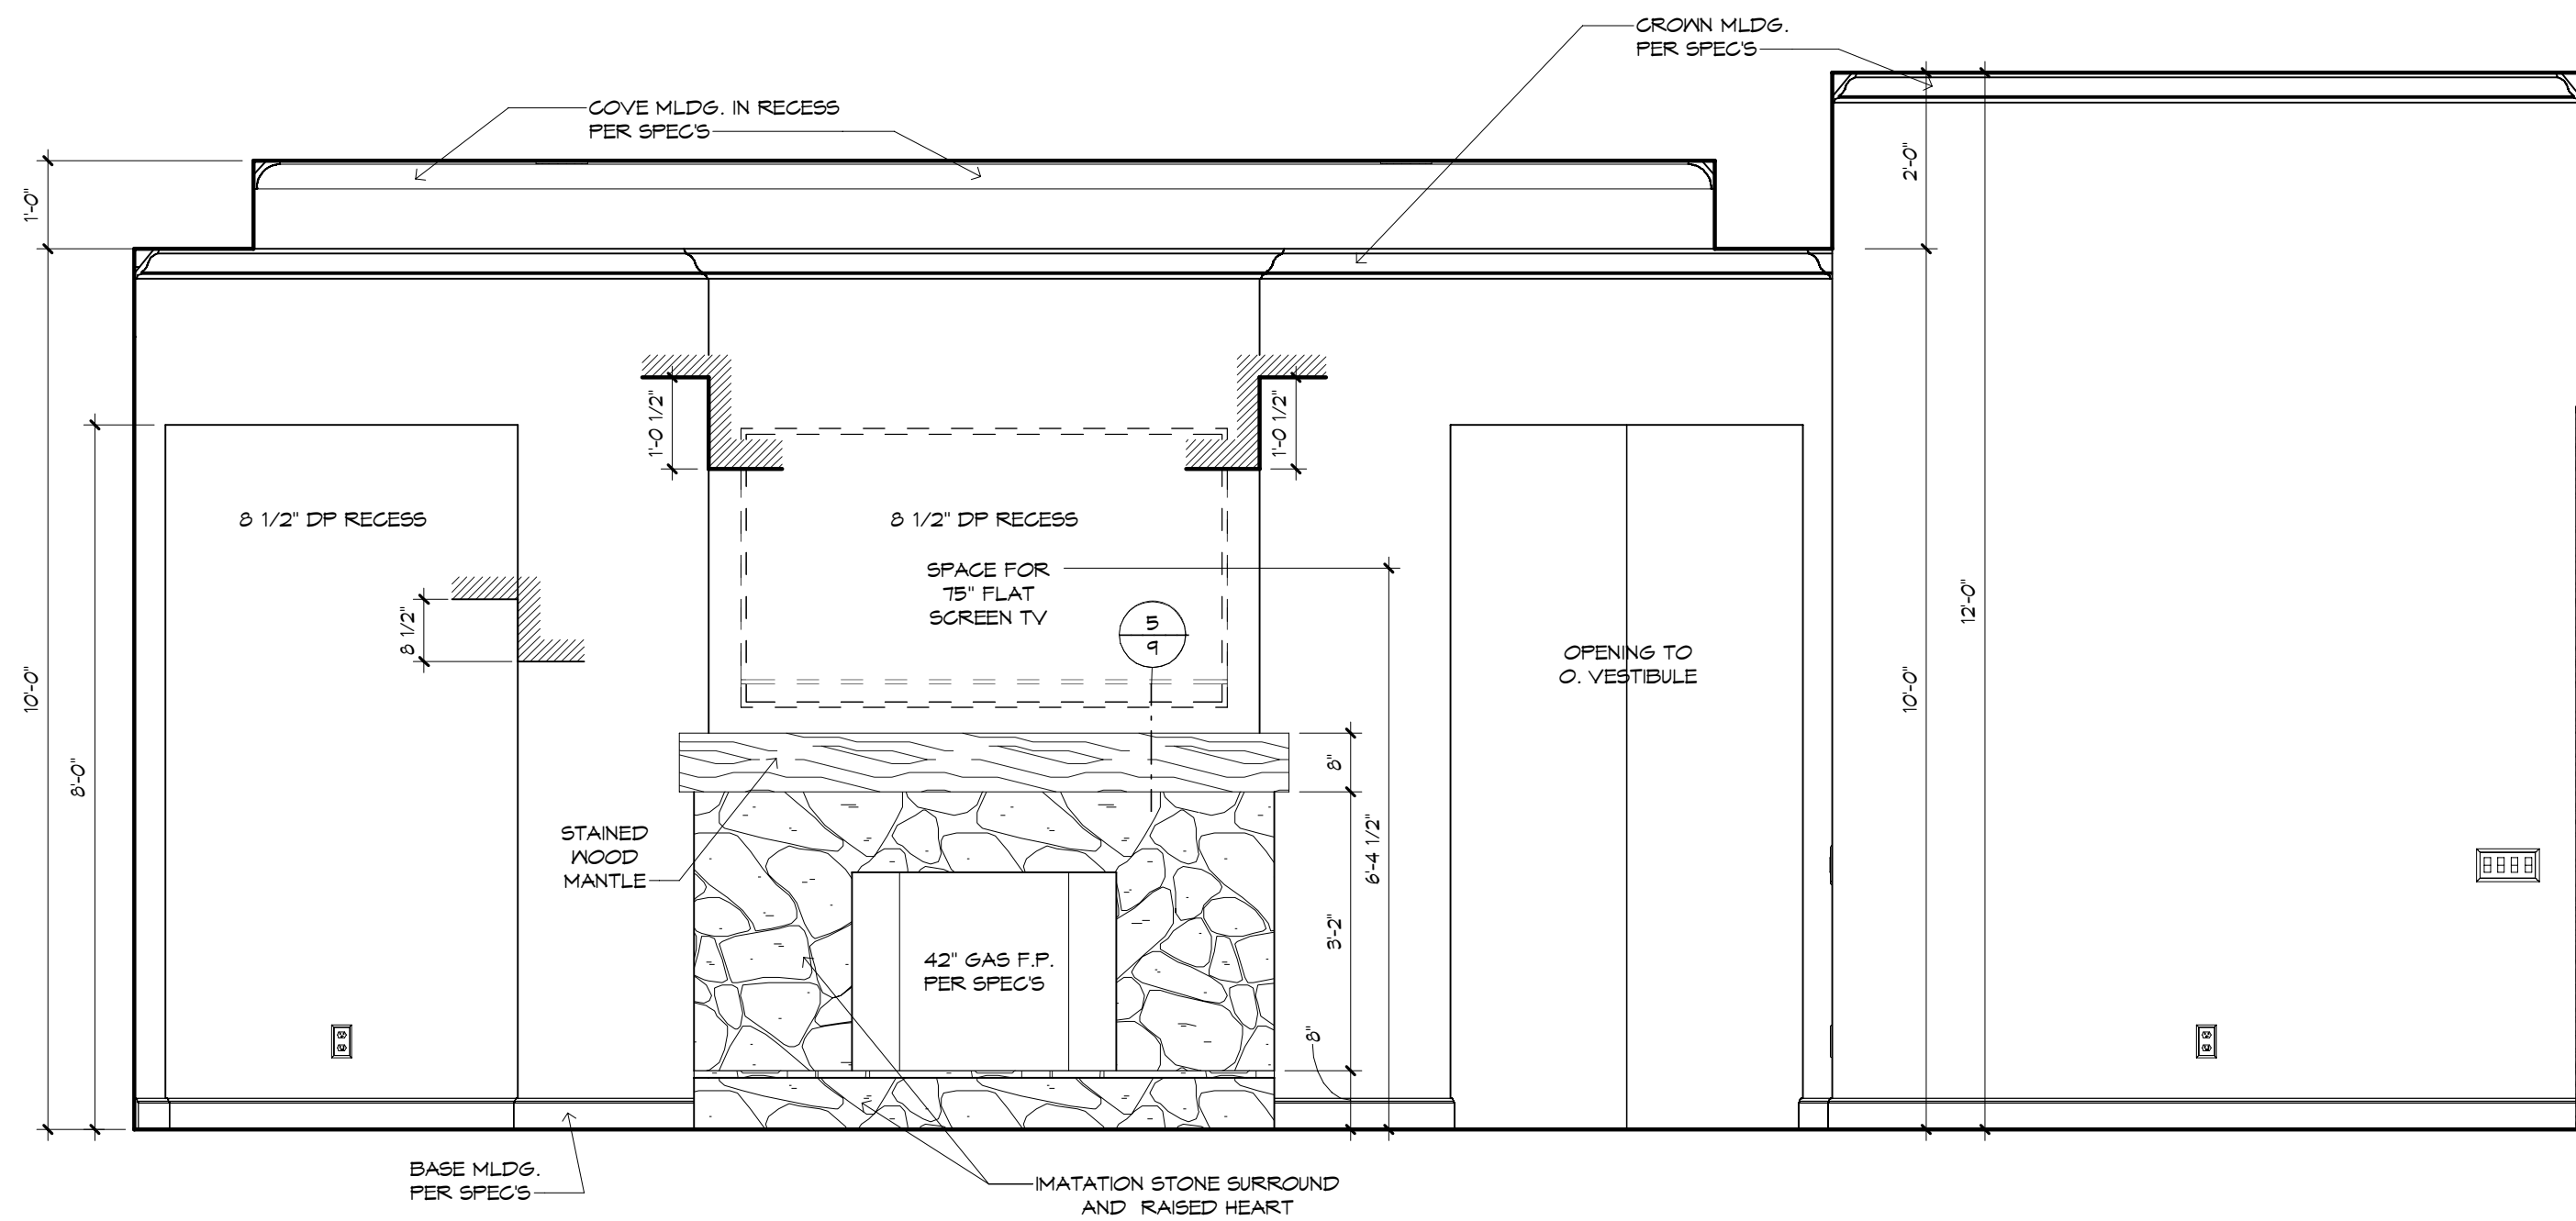

GREAT ROOM / FOYER - "Y"
1/2" = 1'-0"

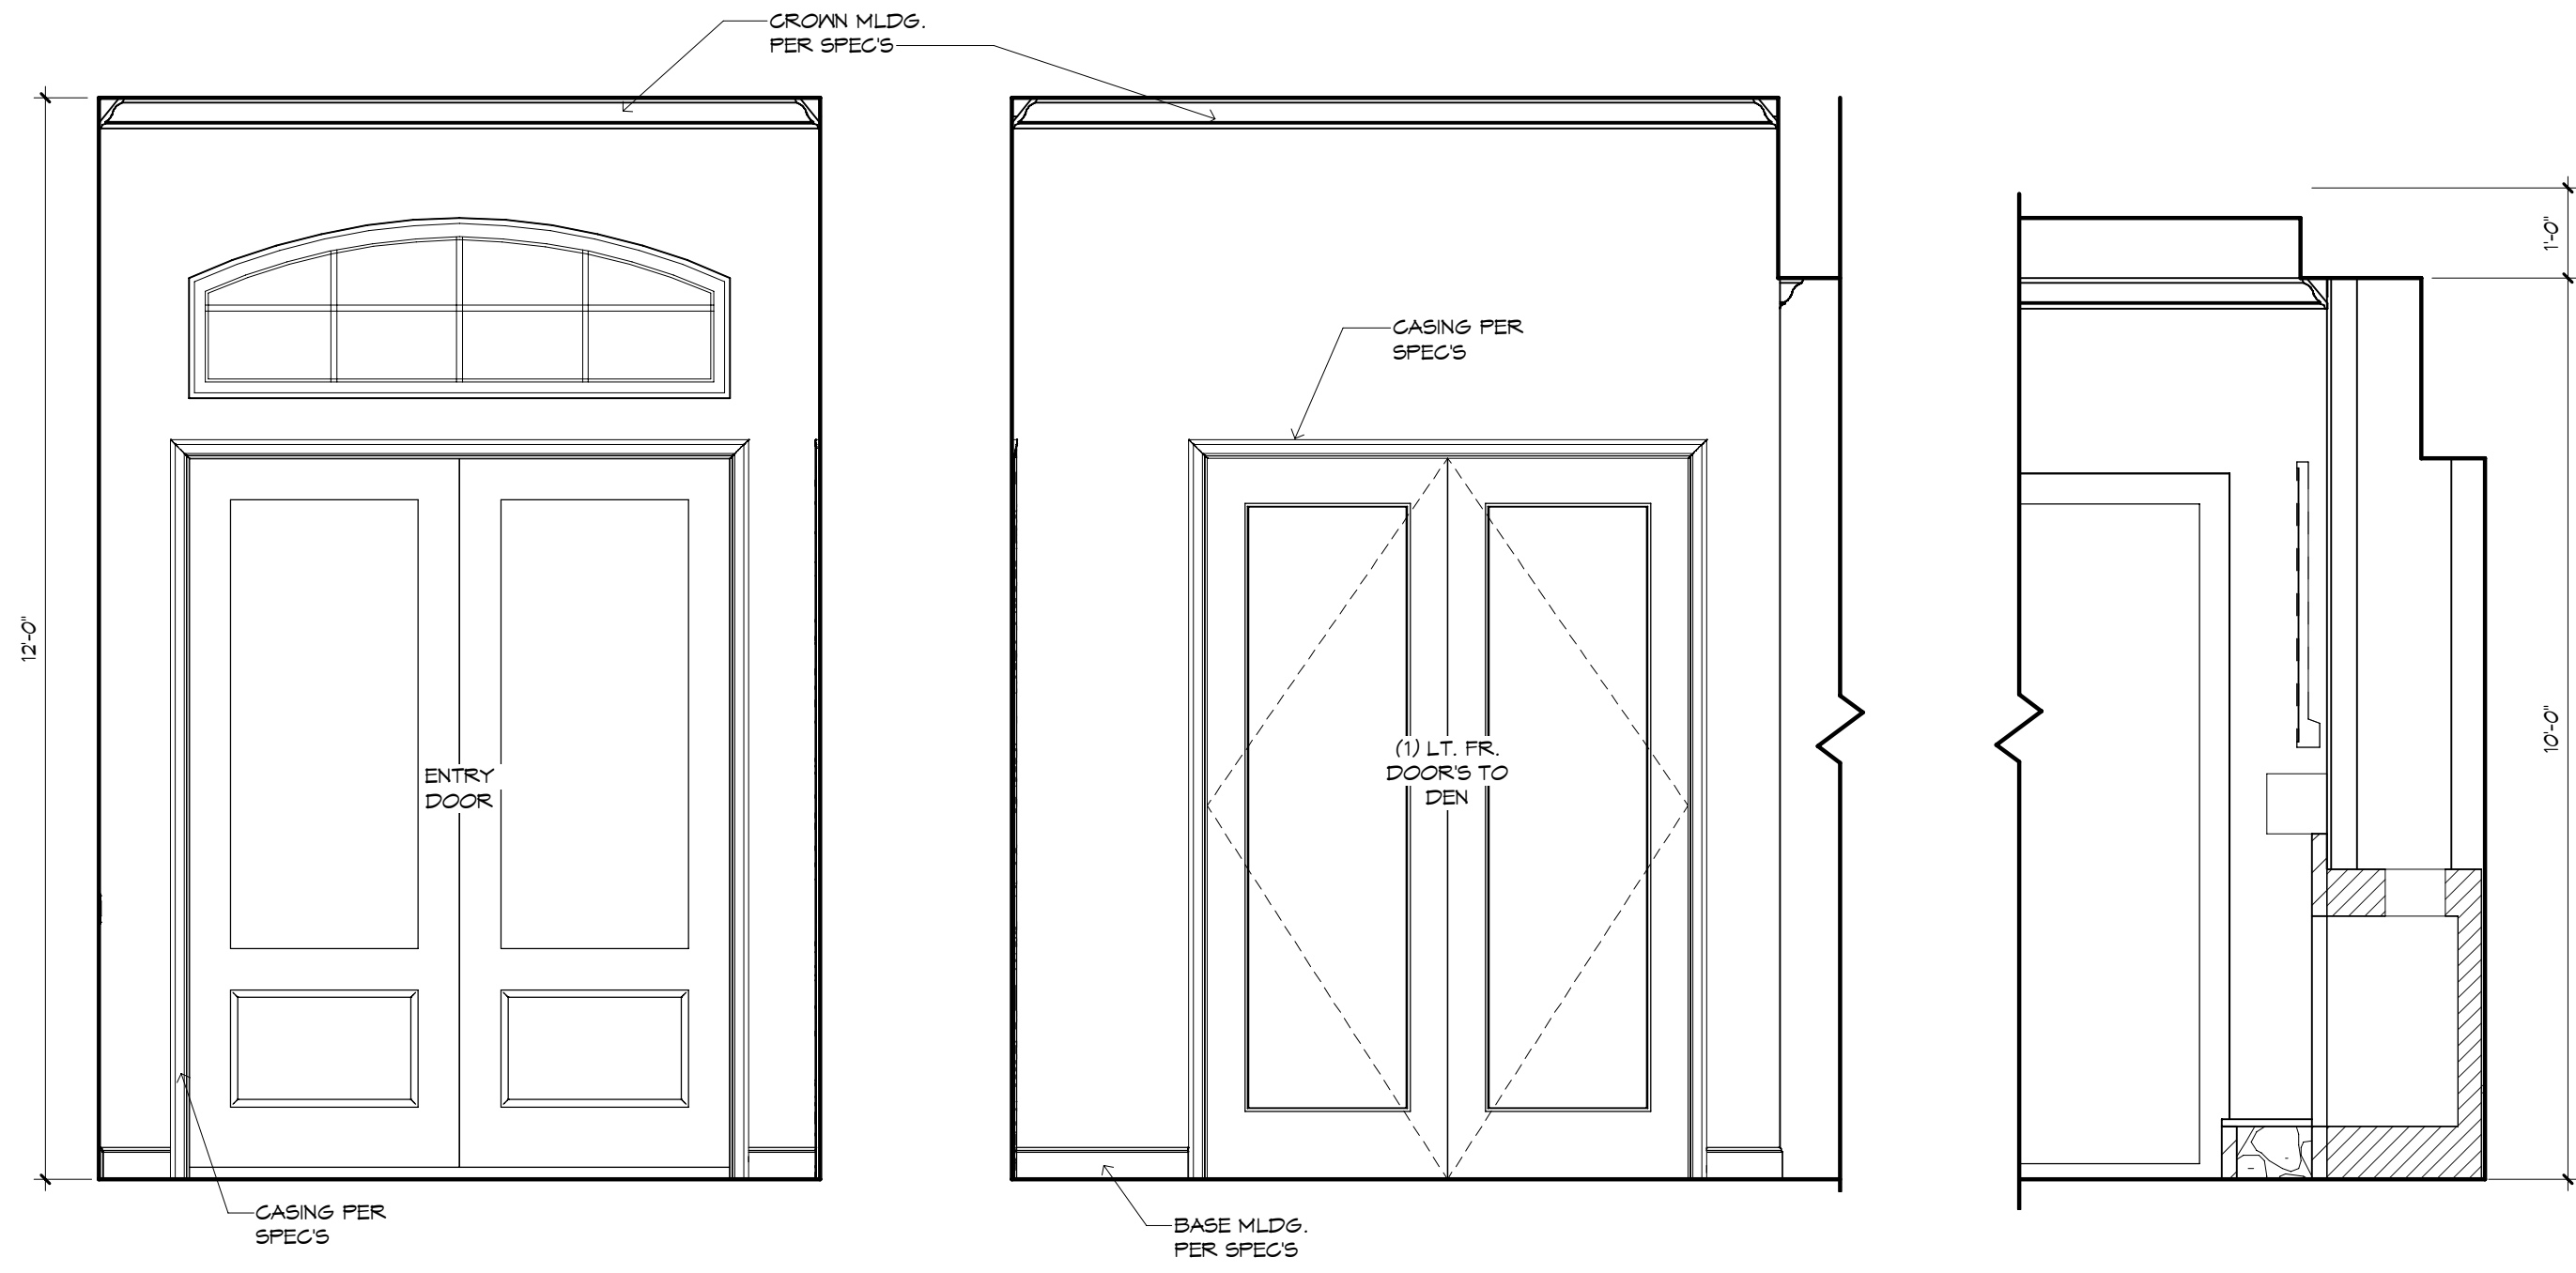

FOYER - "Z"
1/2" = 1'-0"

FOYER - "W"
1/2" = 1'-0"

GREAT ROOM - "X"
1/2" = 1'-0"


GENERAL NOTES:

CABINET ELEVATIONS AND LIGHTING ARE GRAPHIC REPRESENTATIONS ONLY. REFERENCE SHOULD BE MADE TO THE ELECTRICAL SHEET, CABINET MFR. DRAWINGS AND SPECS FOR FURTHER INFORMATION.


REFER TO CABINET SHOP DRAWINGS FOR CABINET & VANITY TOP DIMENSIONS.

THE TOE KICK IS 4".


PLUMBING, TILE, BASE MLDG, DOOR CASING & DECORATIVE LIGHTING & DECORATIVE MIRRORS ARE ILLUSTRATED FOR LOCATION PURPOSES ONLY. PLEASE REFER TO COMMUNITY STANDARDS FOR SIZES & SPECS.

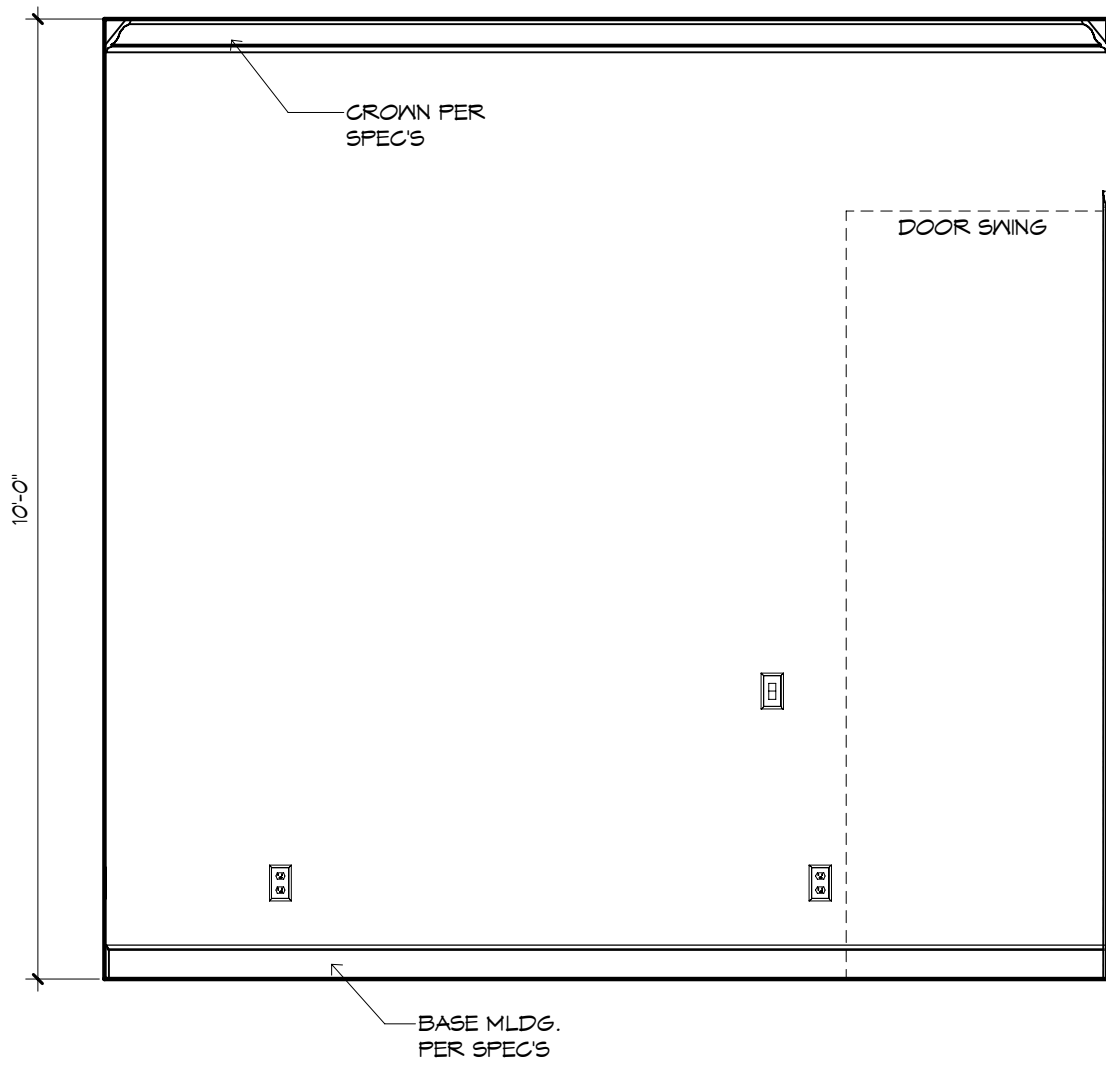


DEN - "X"
1/2" = 1'-0"

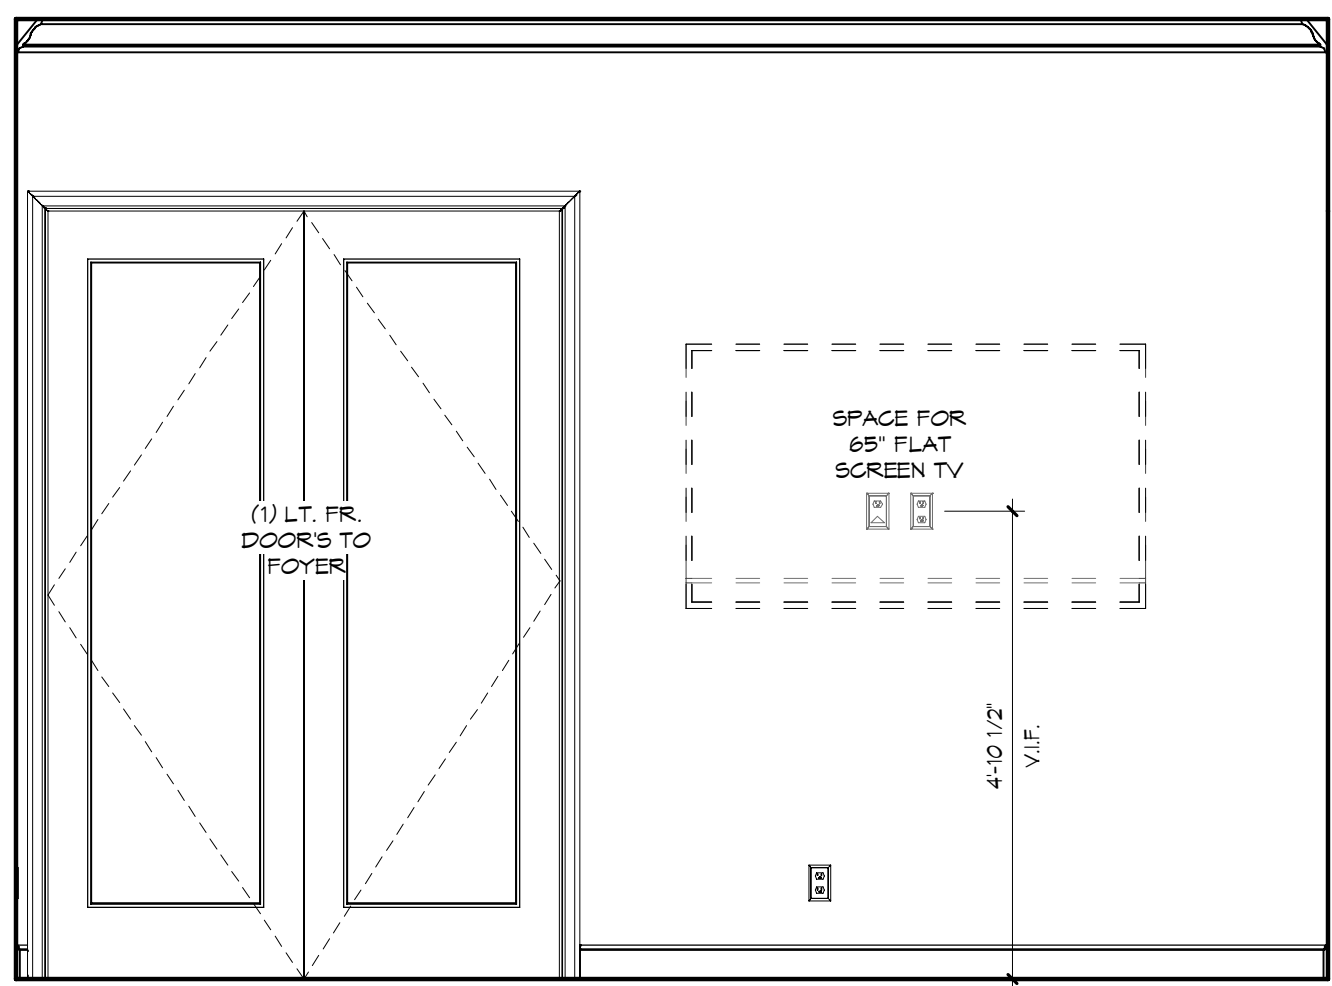

DEN - "Y"
1/2" = 1'-0"

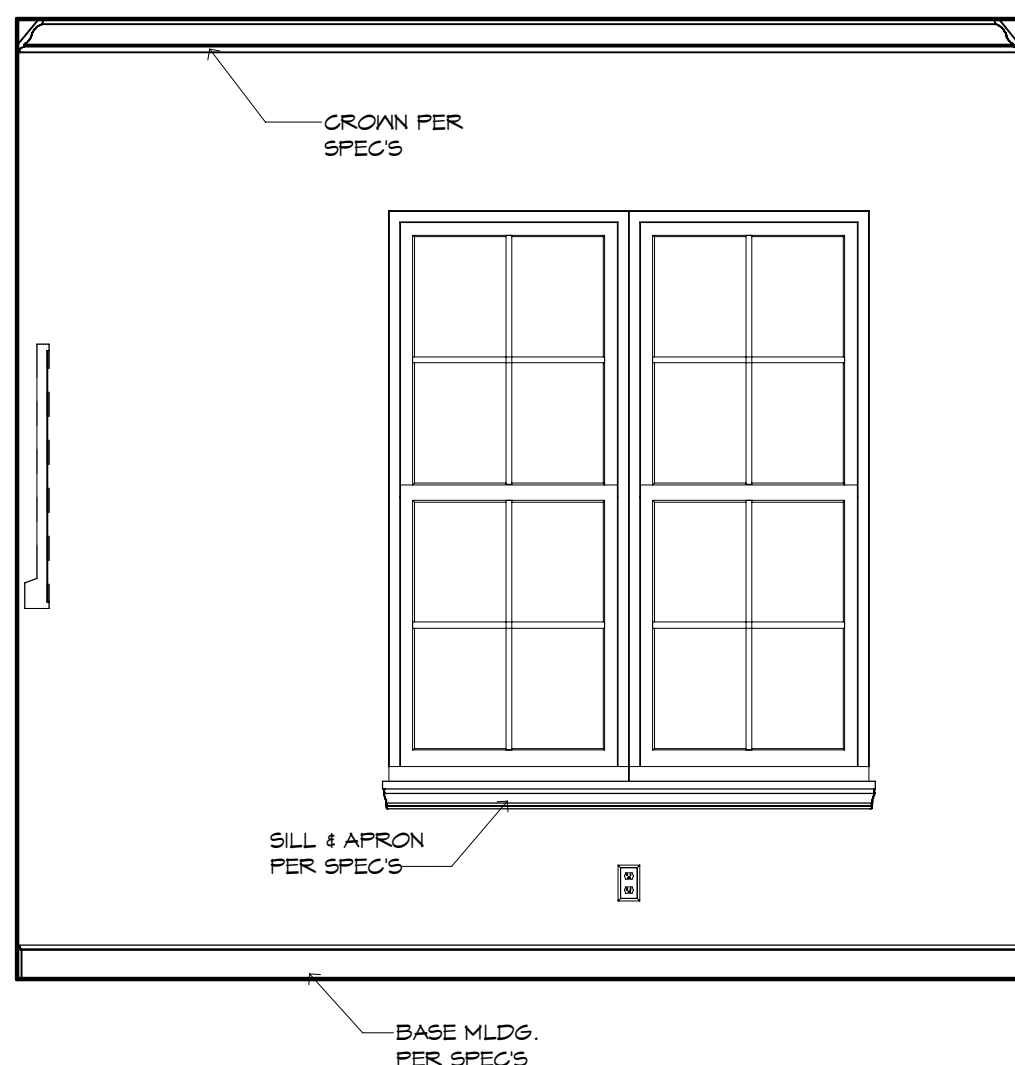


DEN - "Z"
1/2" = 1'-0"

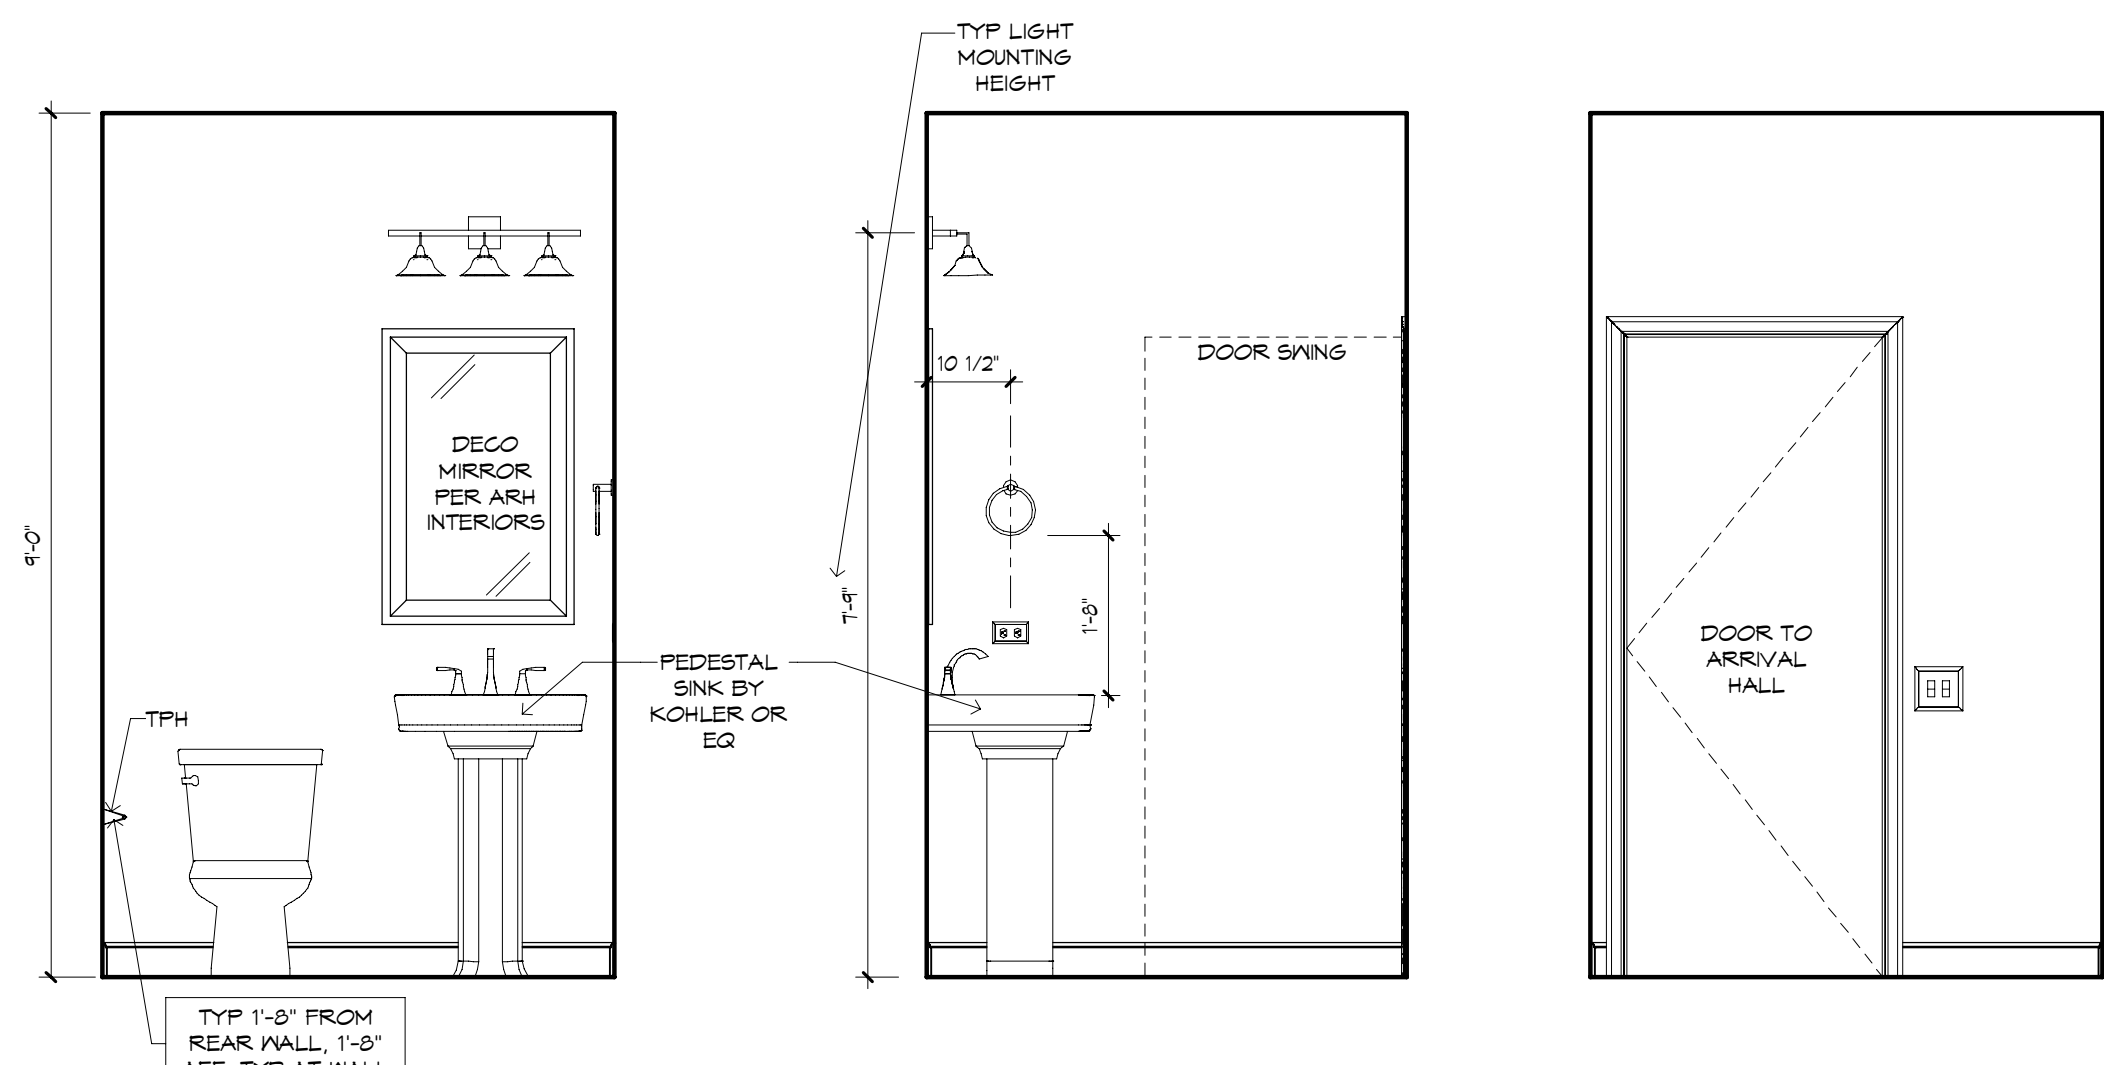

POWDER BATH 1 - "W"
1/2" = 1'-0"

POWDER BATH 1 - "X"
1/2" = 1'-0"

POWDER BATH 1 - "Y"
1/2" = 1'-0"

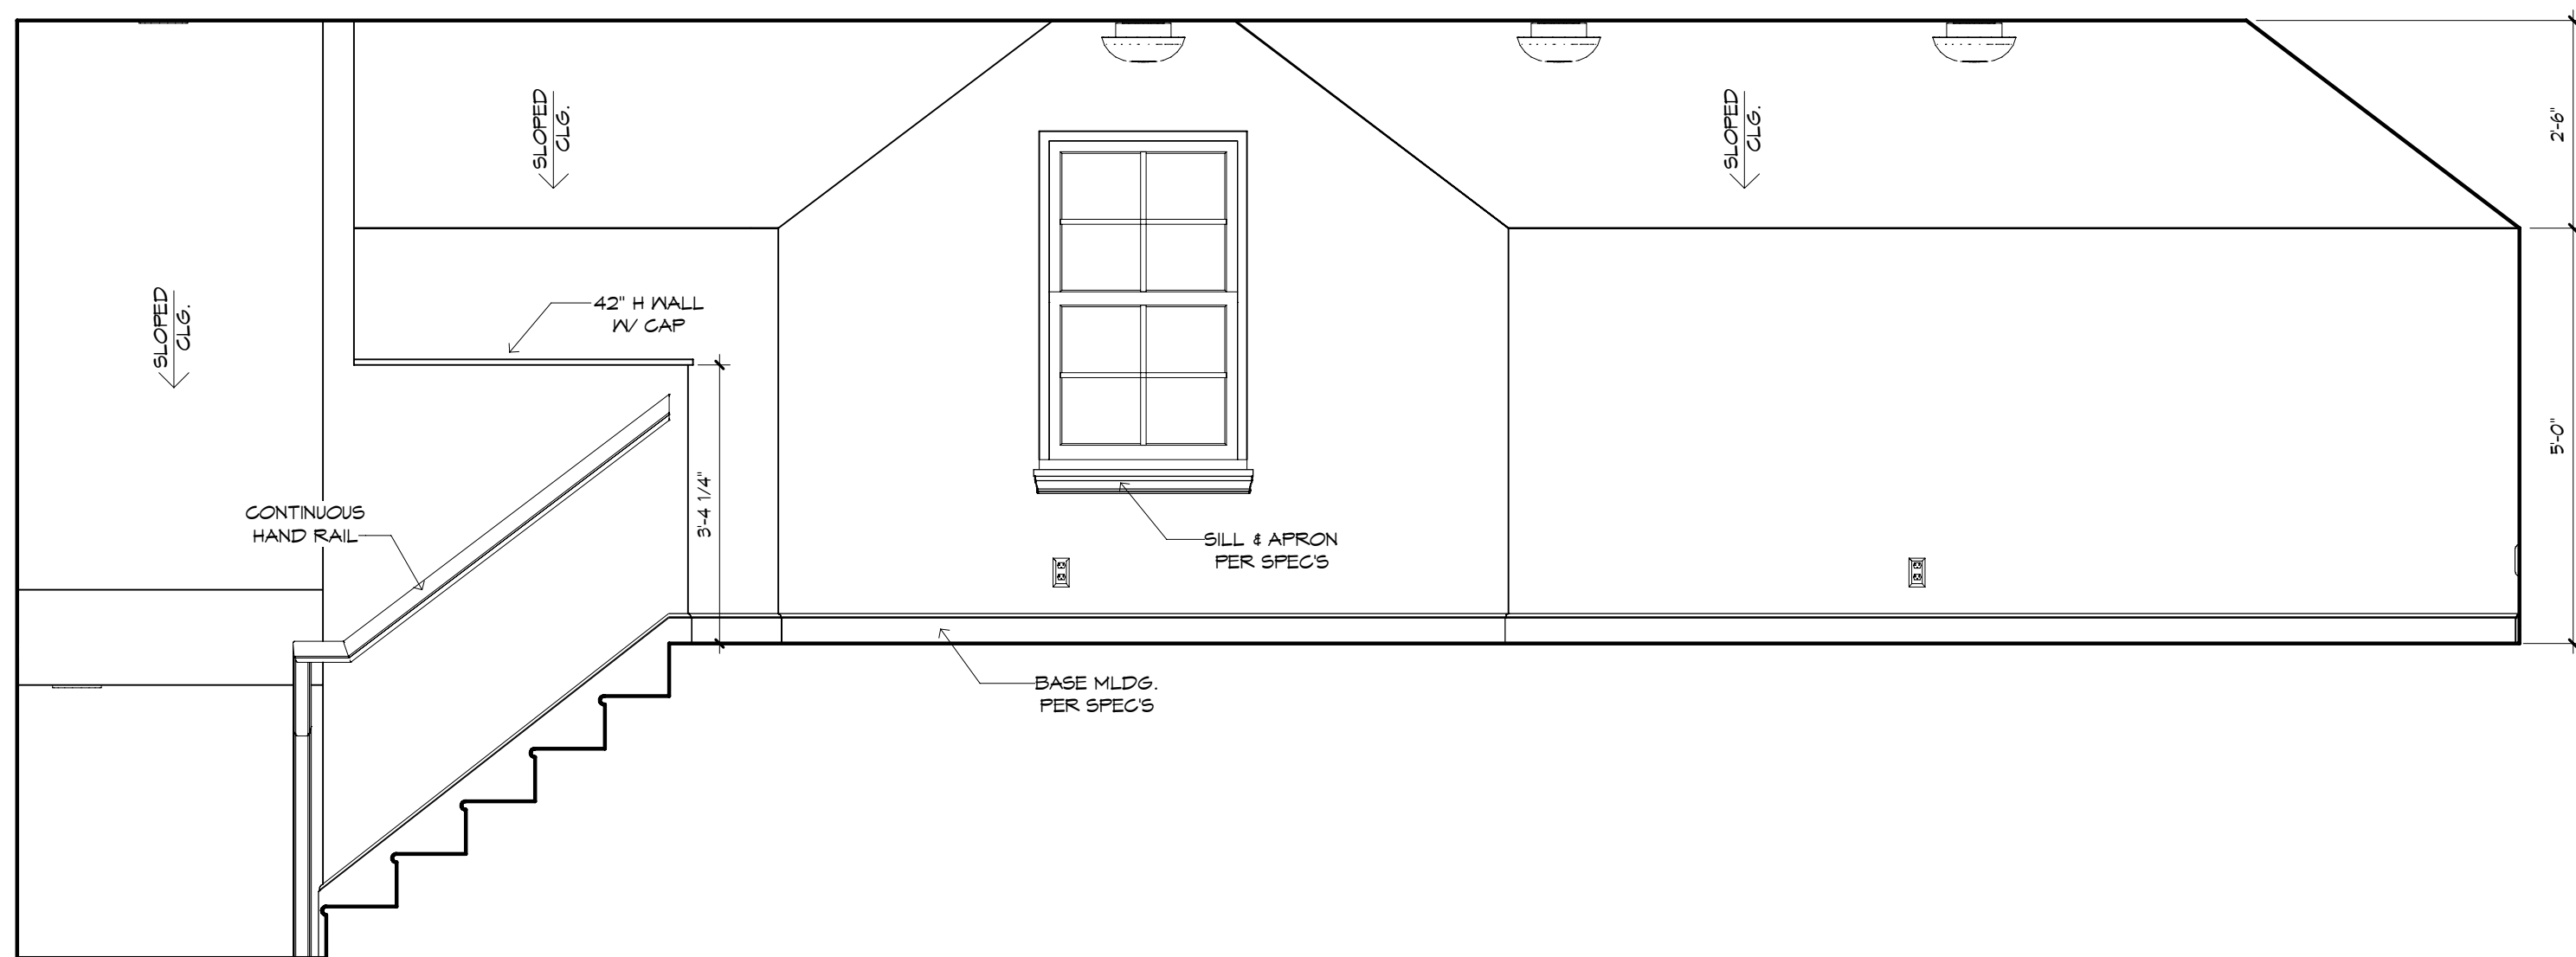

BONUS ROOM - "Y"
1/2" = 1'-0"

CABINET ELEVATIONS AND LIGHTING ARE GRAPHIC REPRESENTATIONS ONLY. REFERENCE SHOULD BE MADE TO THE ELECTRICAL SHEET, CABINET MFR. DRAWINGS AND SPECS FOR FURTHER INFORMATION.


REFER TO CABINET SHOP DRAWINGS FOR CABINET & VANITY TOP DIMENSIONS.











THE TOE KICK IS 4".


PLUMBING, TILE, BASE MLDs, DOOR CASING & DECORATIVE LIGHTING & DECORATIVE MIRRORS ARE ILLUSTRATED FOR LOCATION PURPOSES ONLY. PLEASE REFER TO COMMUNITY STANDARDS FOR SIZES & SPECS.

are FRANCHISING, INC., THE DESIGNER, IS RESPONSIBLE FOR THE ARCHITECTURAL DESIGN ONLY AS REPRESENTED IN THESE DRAWINGS ("PLANS"), BUT NOT FOR ANY STRUCTURAL INFORMATION INCLUDED OR OMITTED. THE BUILDER IS RESPONSIBLE FOR CONFORMING THESE PLANS AND CONSTRUCTING THE RESIDENCE TO ALL APPLICABLE FEDERAL, STATE AND LOCAL BUILDING CODES, ORDINANCES AND LAWS, INCLUDING BUT NOT LIMITED TO THE FOLLOWING: EGRESS, FIRE SAFETY, TECHNICAL CODES, FLOOD ZONE CRITERIA, HURRICANE CODES, PRE-ENGINEERED FOUNDATIONS, FRAMING MEMBERS, FLASHING, AND MOISTURE PROTECTION. AN FRANCHISING, INC. IS NOT RESPONSIBLE FOR REVISIONS MADE TO THESE DRAWINGS BY OTHER DESIGNERS OR DRAFTSMEN USED BY BUILDERS OR OWNER. BY JOE OF THESE DRAWINGS THE OWNER, BUILDER, AND SUB-CONTRACTORS ACKNOWLEDGE AND AGREE TO THIS DISCLAIMER.

KITCHEN, UTILITY, HALL TO GARAGE	PLAN PLAN 1125F-3M-15-01-CUST.* C.I.#1 - #20 80-2019-JONES-B	BUILDER: BRYAN ZECHER HOMES, INC. LAKE CITY, FLORIDA AN INDEPENDENTLY OWNED AND OPERATED FRANCHISE
--	---	--

 


          

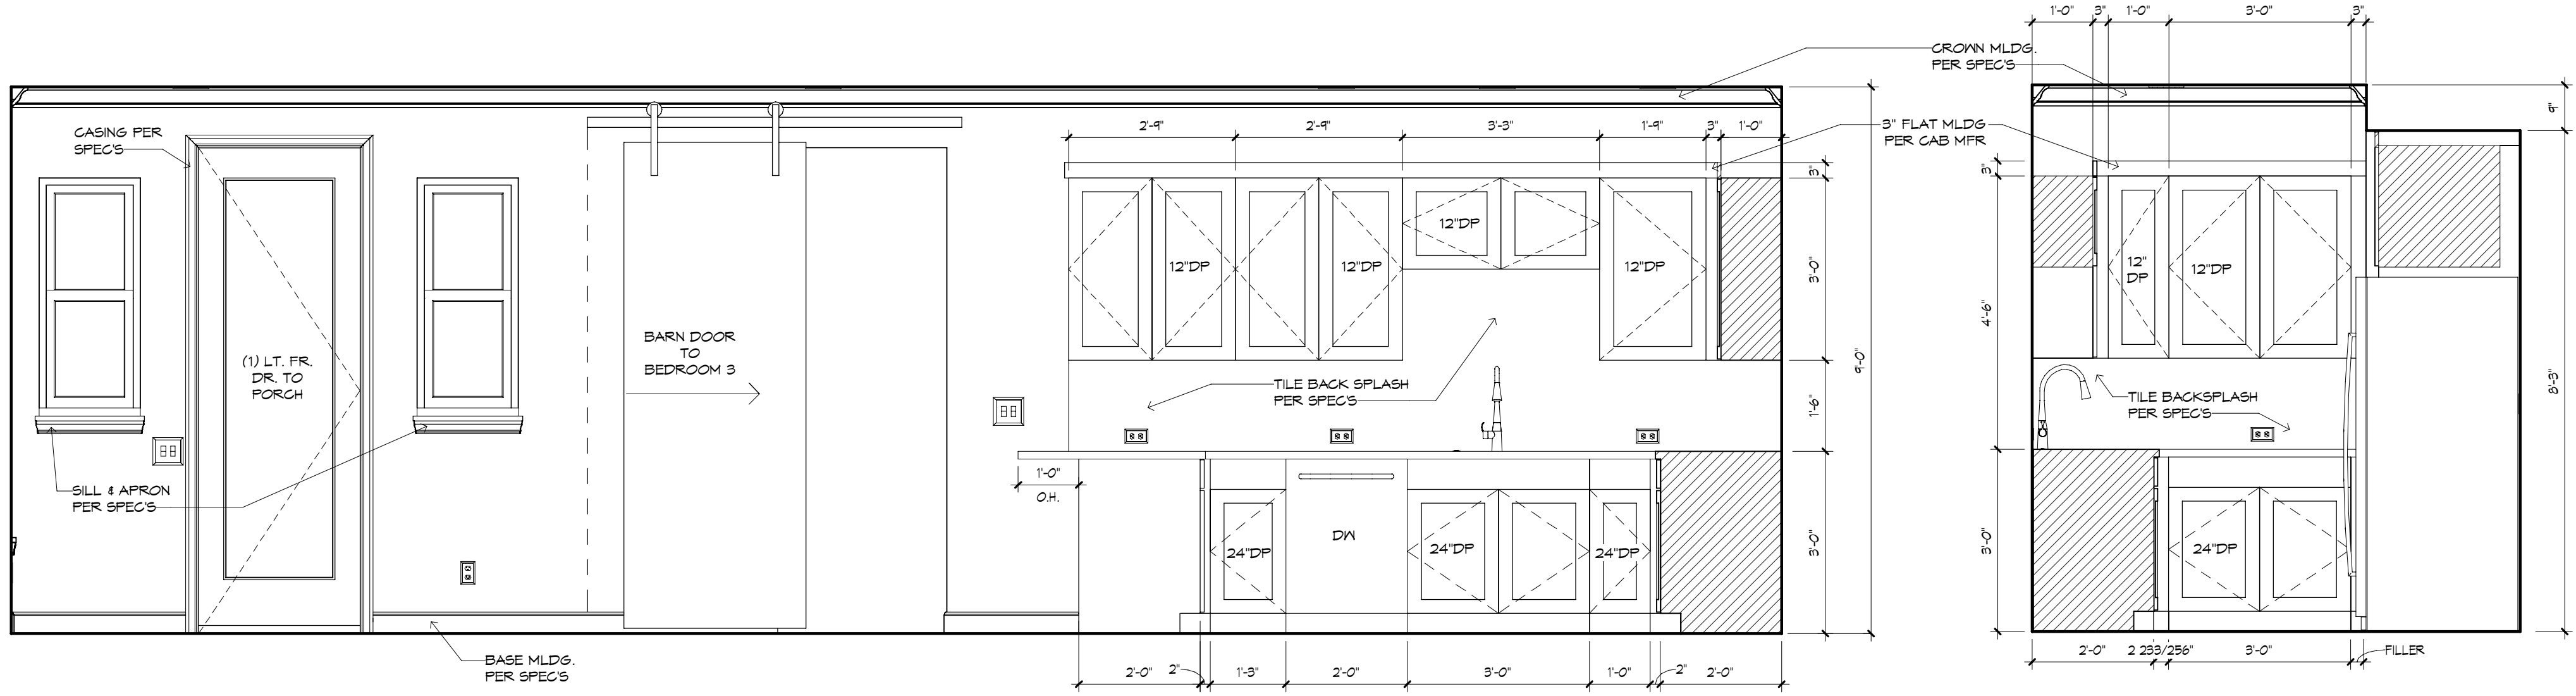


DINING/KITCHEN 2 - "X"
1/2" = 1'-0"


KITCHEN 2 - "Y"
1/2" = 1'-0"

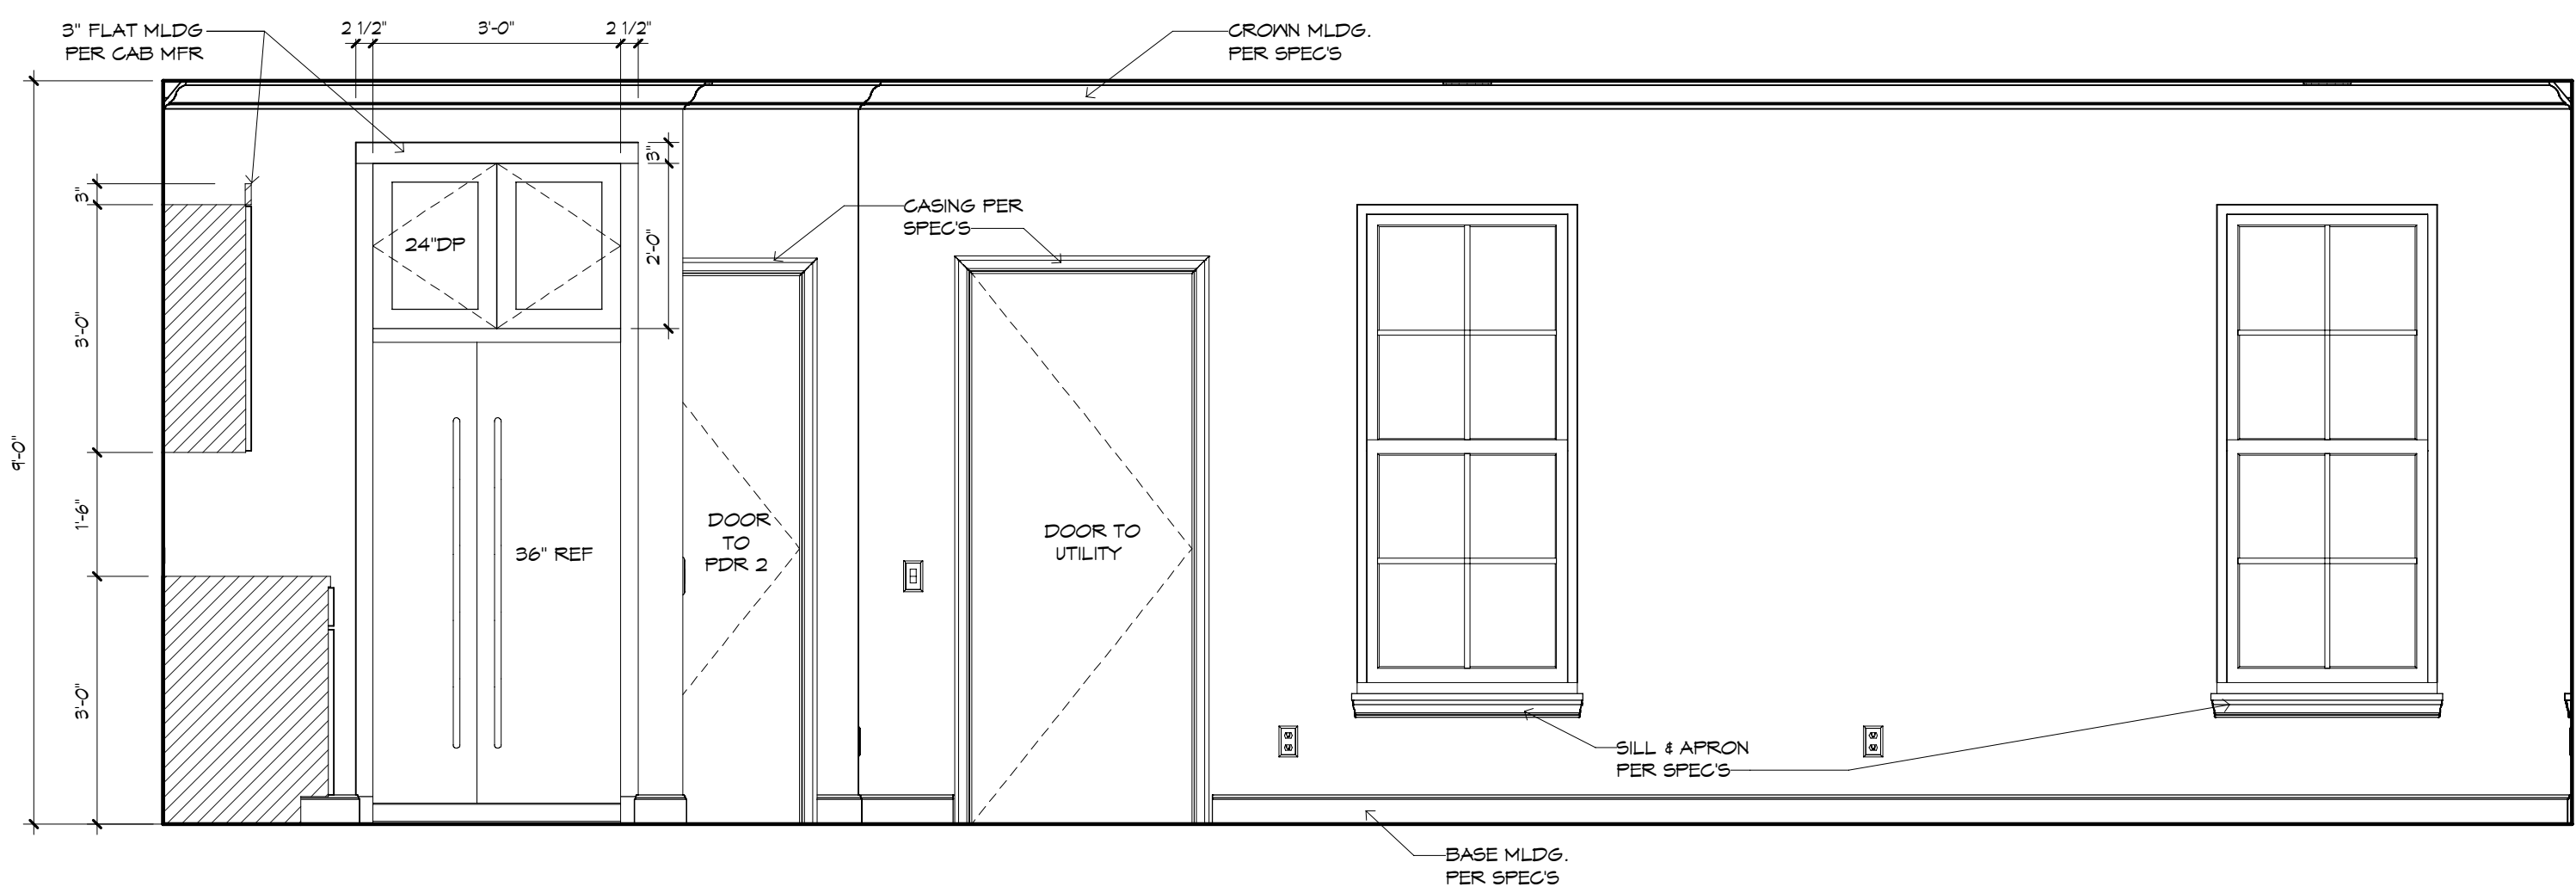

KITCHEN 2/LIVING 2 - "Z"
1/2" = 1'-0"

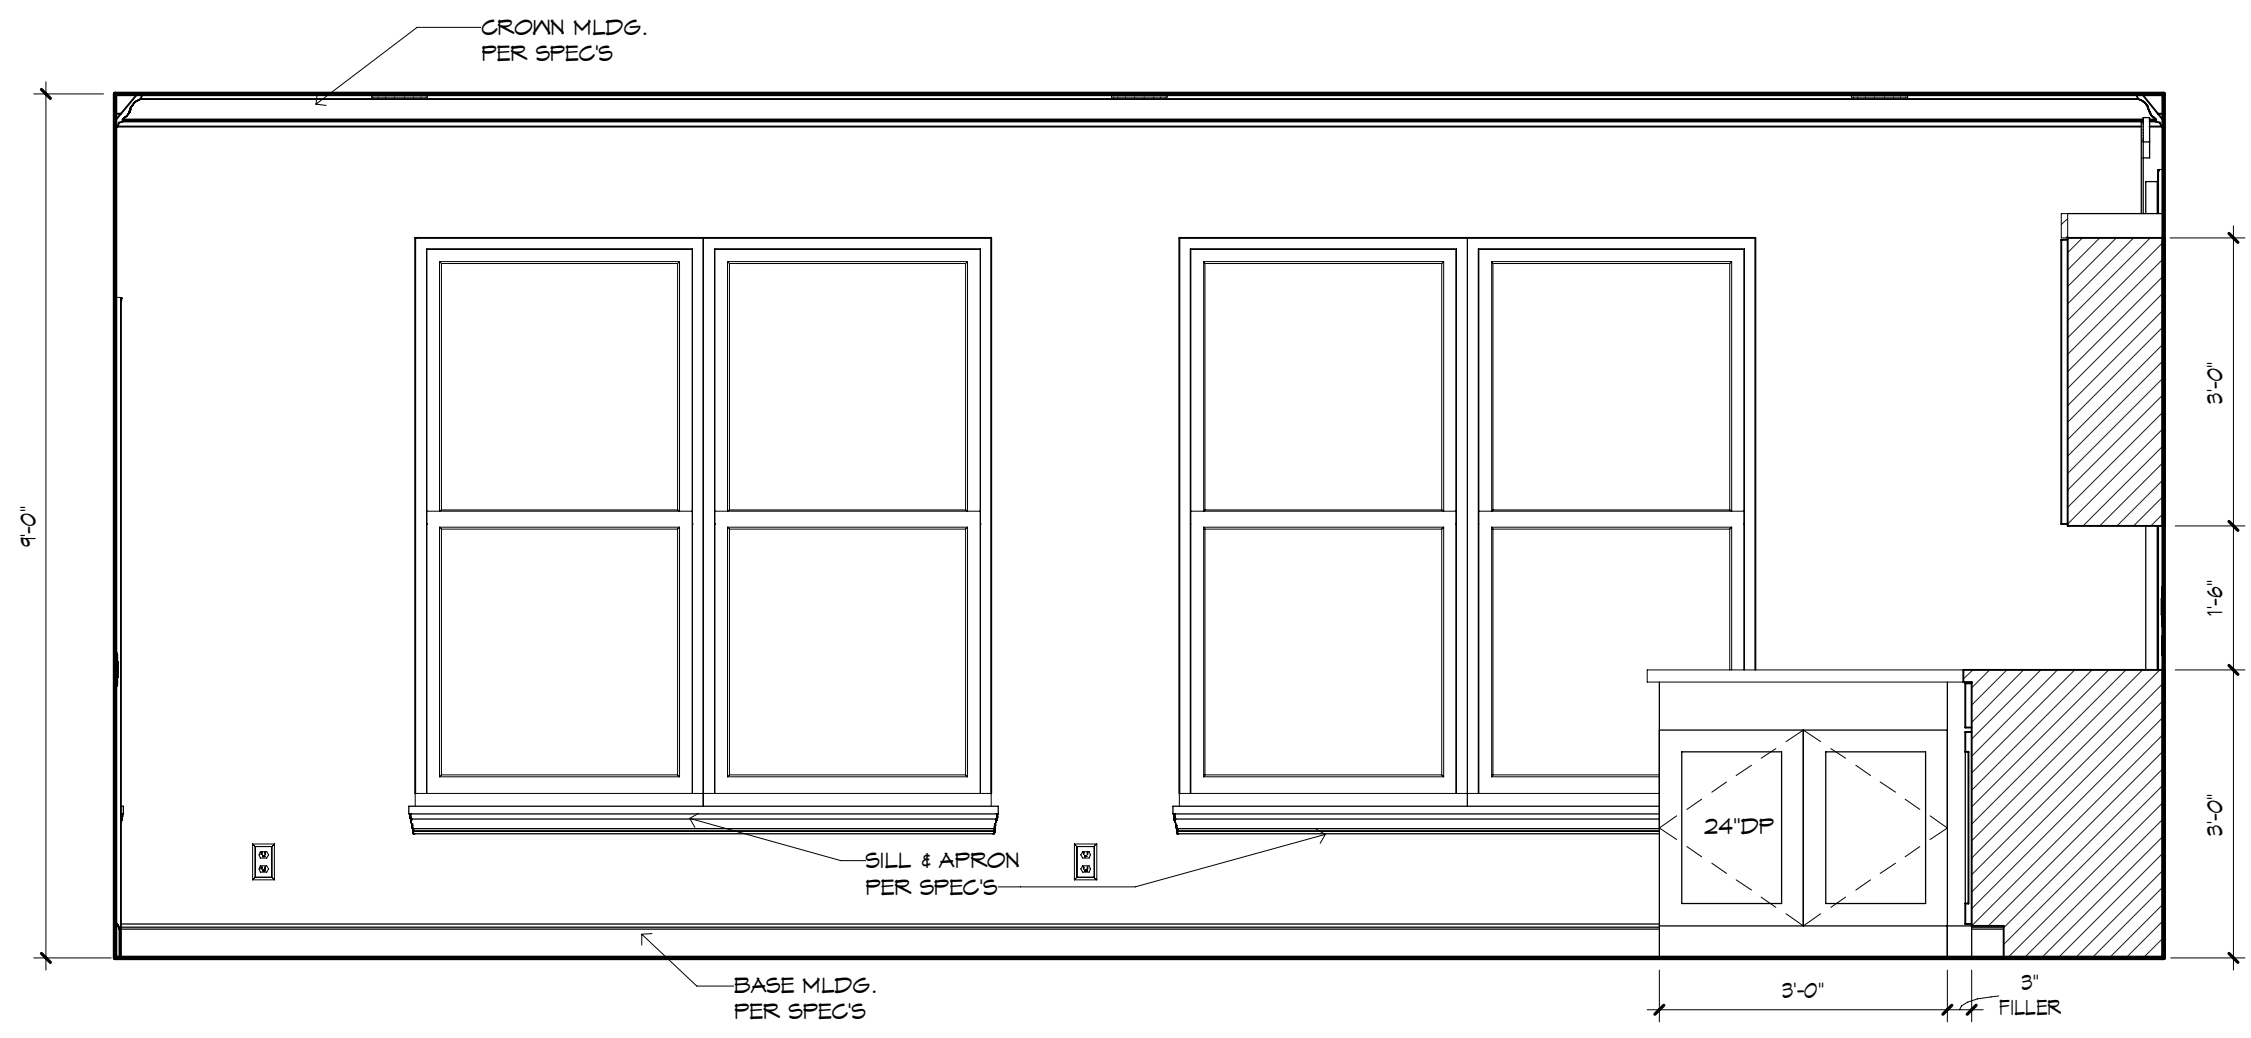

LIVING/KITCHEN 2 - "W"
1/2" = 1'-0"

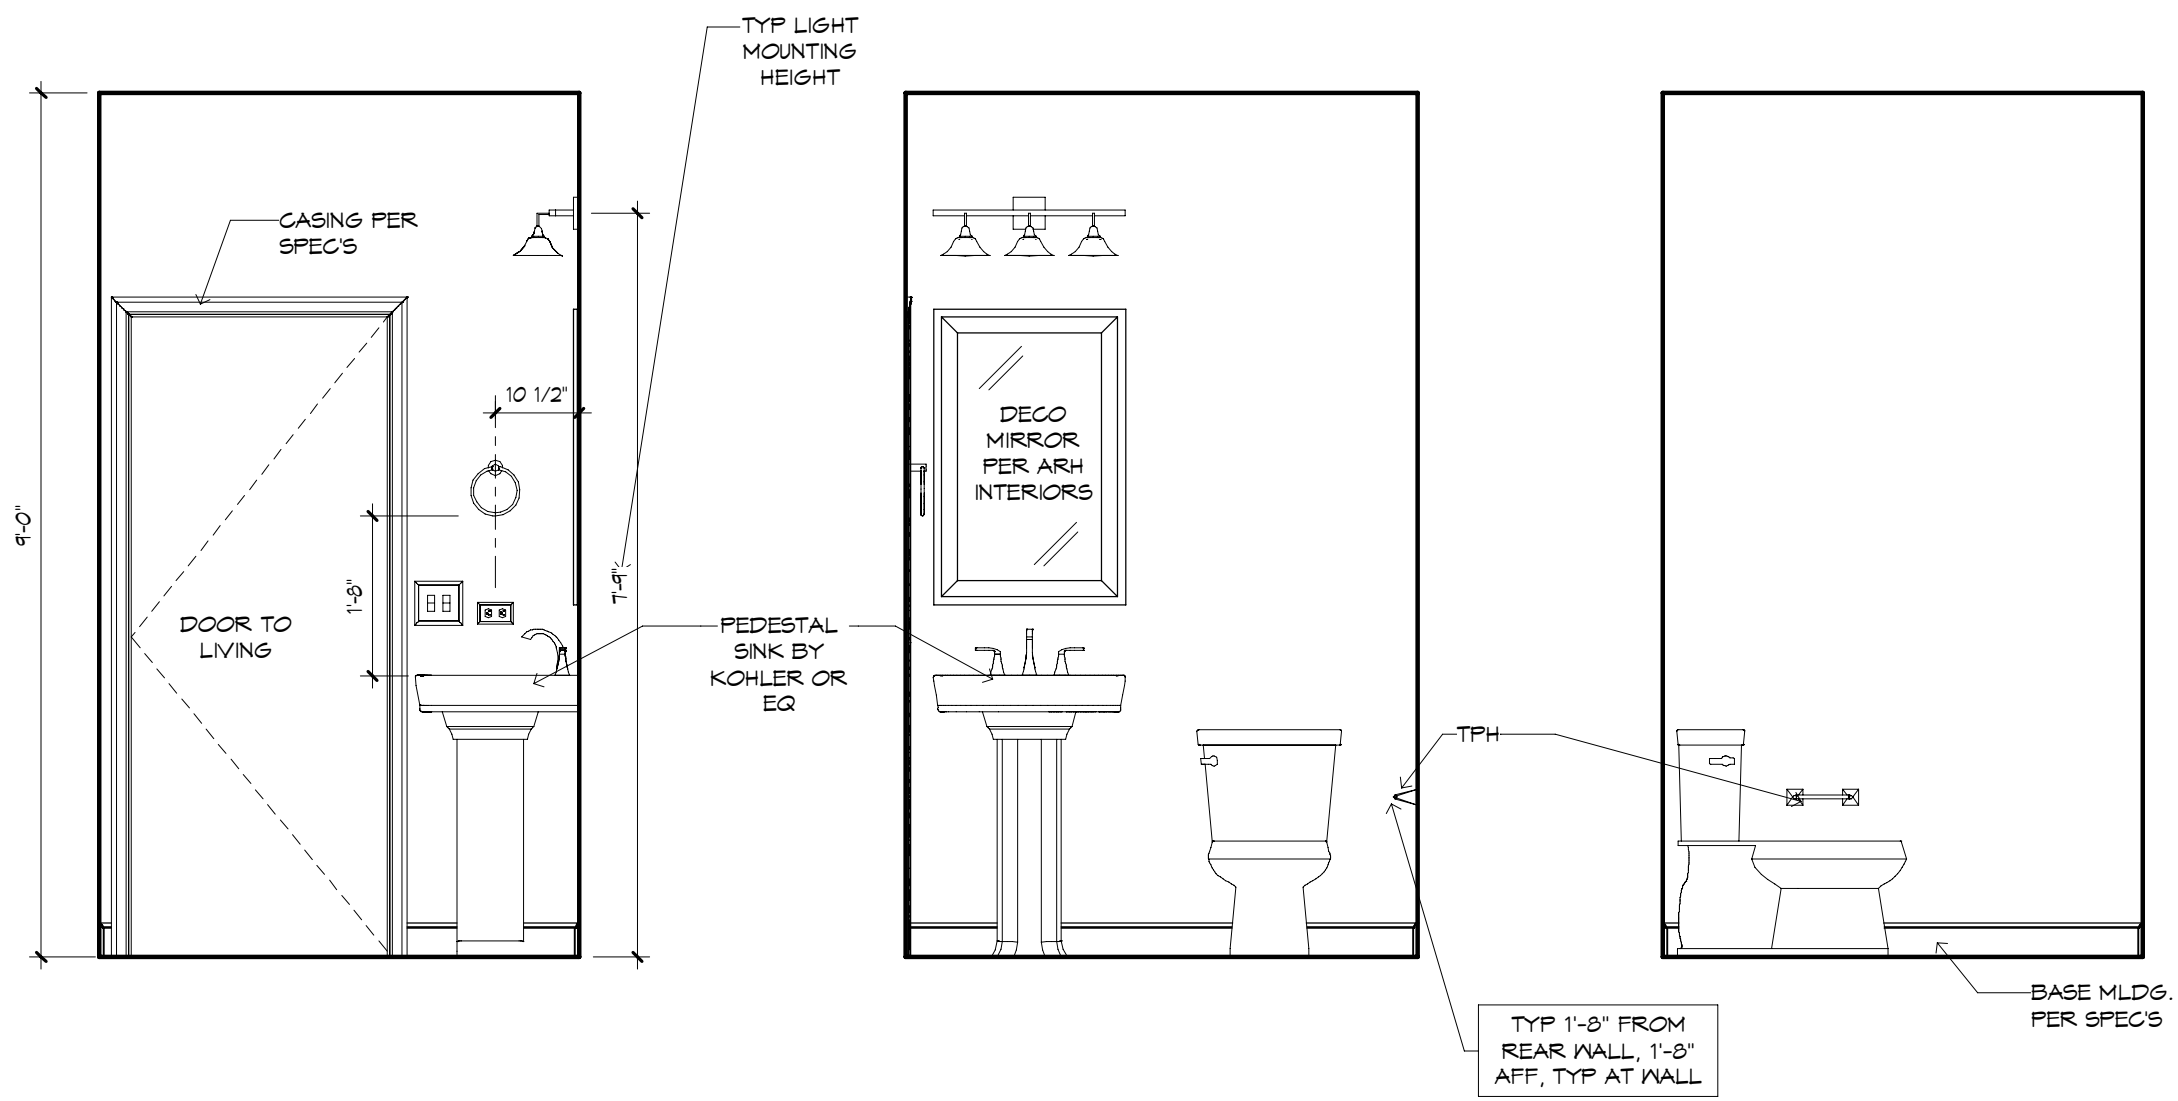

POWDER BATH 2 - "X"
1/2" = 1'-0"

POWDER BATH 2 - "Y"
1/2" = 1'-0"

POWDER BATH 2 - "Z"
1/2" = 1'-0"

CABINET ELEVATIONS AND LIGHTING ARE GRAPHIC REPRESENTATIONS ONLY. REFERENCE SHOULD BE MADE TO THE ELECTRICAL SHEET, CABINET MFR DRAWINGS AND SPECS FOR FURTHER INFORMATION.

REFER TO CABINET SHOP DRAWINGS FOR CABINET & VANITY TOP DIMENSIONS.

THE TOE KICK IS 4".

PLUMBING, TILE, BASE MOLD, DOOR CASING & DECORATIVE LIGHTING & DECORATIVE MIRRORS ARE ILLUSTRATED FOR LOCATION PURPOSES ONLY. PLEASE REFER TO COMMUNITY STANDARDS FOR SIZES & SPECS.

