



REVISIONS
June 27, 2022

SOFTPLAN
ARCHITECTURAL DESIGN SOFTWARE

Wahl C-777

A CUSTOM BARNDOMINIUM DESIGN FOR:
ADAM & CARRIE HOGUE
PROJECT ADDRESS: 229 SW STELL GLEN, LAKE CITY, FLORIDA 32024

N. P.
GEISLER
ER

Digitally signed by: N. P. GEISLER
DN: CN = N. P. GEISLER, C = US, O = AR0007005 OUS
ARCHITECT
Date: 2022.06.29 11:04:39 -0500

AR0007005



**NICHOLAS
PAUL
GEISLER
ARCHITECT**
■ 1758 NW Brown Rd.
■ Lake City, FL 32055

JOINT VENTURED WITH

© WM DESIGN &
ASSOCIATES, INC.
426 SW COMMERCE DR., STE 1
LAKE CITY, FL 32025
(386) 758-8406
will@willmvers.net



JOB NUMBER
20220501
DATE:
June 27, 2022

 
SHEET NUMBER


A.1



AREA SUMMARY		
LIVING AREA	980	S.F.
LOFT AREA	430	S.F.
COVERED PORCH AREA	160	S.F.
TOTAL AREA	1,570	S.F.

NOTE: ALL DRAWINGS NOT TO BE SCALED, WRITTEN DIMENSIONS TAKE PRECEDENCE OVER SCALED DIMENSIONS

REVISIONS	
June 27, 2022	
SOFTPLAN ARCHITECTURAL DESIGN BY TABLET 	
A CUSTOM BARNDOMINIUM DESIGN FOR: ADAM & CARRIE HOGUE PROJECT ADDRESS: 228 SW STELL GLEN, LAKE CITY, FLORIDA 32024	
	
 NICHOLAS GEISLER ARCHITECT N.C.A.R.B. Certified ■ 1758 NW Brown Rd. ■ Lake City, FL 32055 ■ (386) 365-4355	
JOINT VENTURED WITH  W & M ASSOCIATES, INC. 526 S 26th COMMERCIAL DR., STE 130 LAKE CITY, FL 32055 (386) 758-8406 w@wmyners.net	
JOB NUMBER 20220501 DATE: June 27, 2022	
SHEET NUMBER A.2	

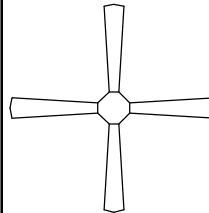	ELECTRICAL LEGEND
	CEILING FAN (PRE-WIRE FOR LIGHT KIT)
	DOUBLE SECURITY LIGHT
	RECESSED CAN LIGHT
	BATH EXHAUST FAN
	LIGHT FIXTURE
	DUPLEX OUTLET (AFCI & TAMPER RESISTANT)
	SWITCHED DUPLEX OUTLET
	220v OUTLET
	GFI DUPLEX OUTLET (PER NEC 406.8)
	TELEVISION JACK
	CIRCUIT FOR MINI-SPLIT A/C UNIT
	SMOKE / CARBON MONOXIDE DETECTOR (see note below)
	WALL SWITCH
	3 WAY WALL SWITCH
	WATER PROOF GFI OUTLET
48" FLOOR.	2 OR 4 TUB FLUORESCENT FIXTURE



NOTE:
ALL INTERIOR RECEPTACLES SHALL BE AFCI
(ARC FAULT CIRCUIT INTERRUPT) PER NEC 210.12 & TAMPER RESISTANT PER
NEC 406.11

ALL INTERIOR & EXTERIOR LIGHTING SHALL MEET OR EXCEED THE MIN. 75% HIGH-EFFICIENCY
LIGHTING PER FBC-ENERGY CONSERVATION R404.

ALL SMOKE DETECTORS BE A COMBO SMOKE & CARBON MONOXIDE DETECTOR
AND SHALL HAVE BATTERY BACKUP POWER
AND ALL WIRED TOGETHER SO IF ANY ONE UNIT IS ACTUATED THEY
ALL ACTIVATE.

THE ELECTRICAL SERVICE OVERCURRENT PROTECTION DEVICE SHALL BE
INSTALLED ON THE EXTERIOR OF STRUCTURES TO SERVE AS A DISCONNECT MEANS.
CONDUCTORS USED FROM THE EXTERIOR DISCONNECTING MEANS TO A PANEL OR SUB
PANEL SHALL HAVE FOUR-WIRE CONDUCTORS, OF WHICH ONE CONDUCTOR
SHALL BE USED AS AN EQUIPMENT GROUND.

IT IS THE LICENSED ELECTRICAL CONTRACTORS RESPONSIBILITY TO INSURE THAT ALL
WORK PERFORMED AND EQUIPMENT INSTALLED MEETS OR EXCEEDS THE 2017 (NFPA-70) NATIONAL
ELECTRIC CODE AND ALL OTHER LOCAL CODES AND ORDINANCES.

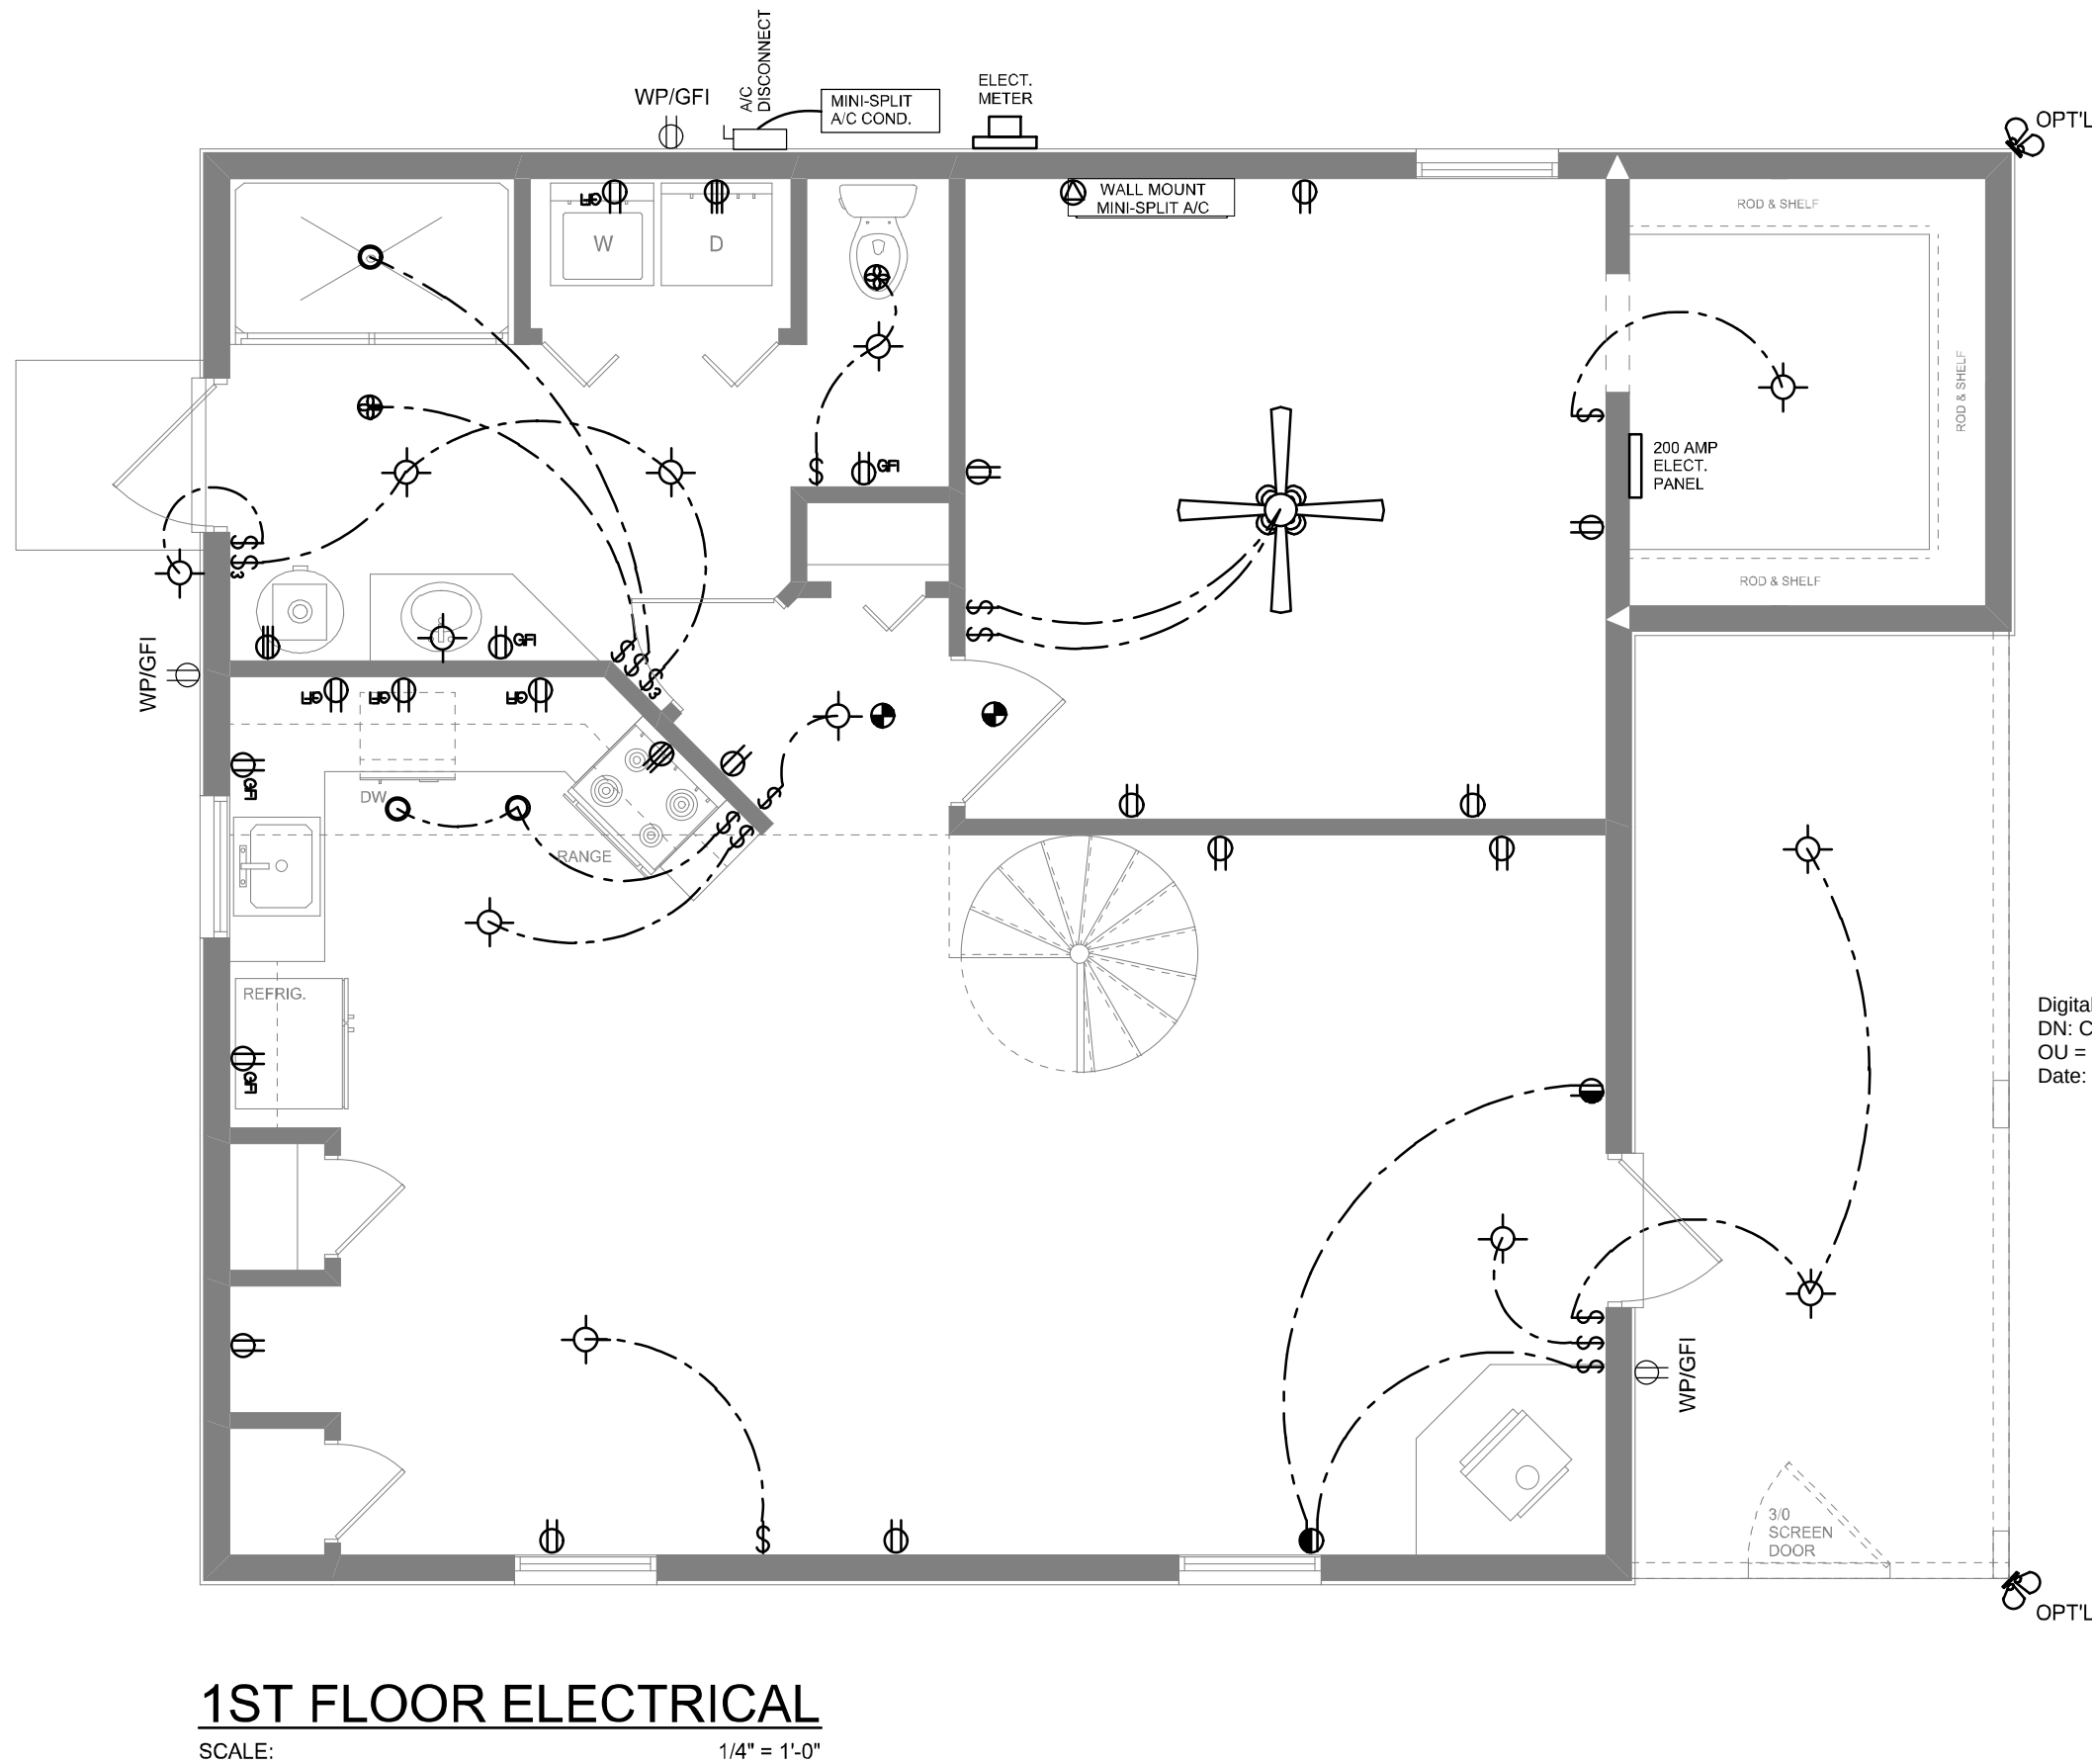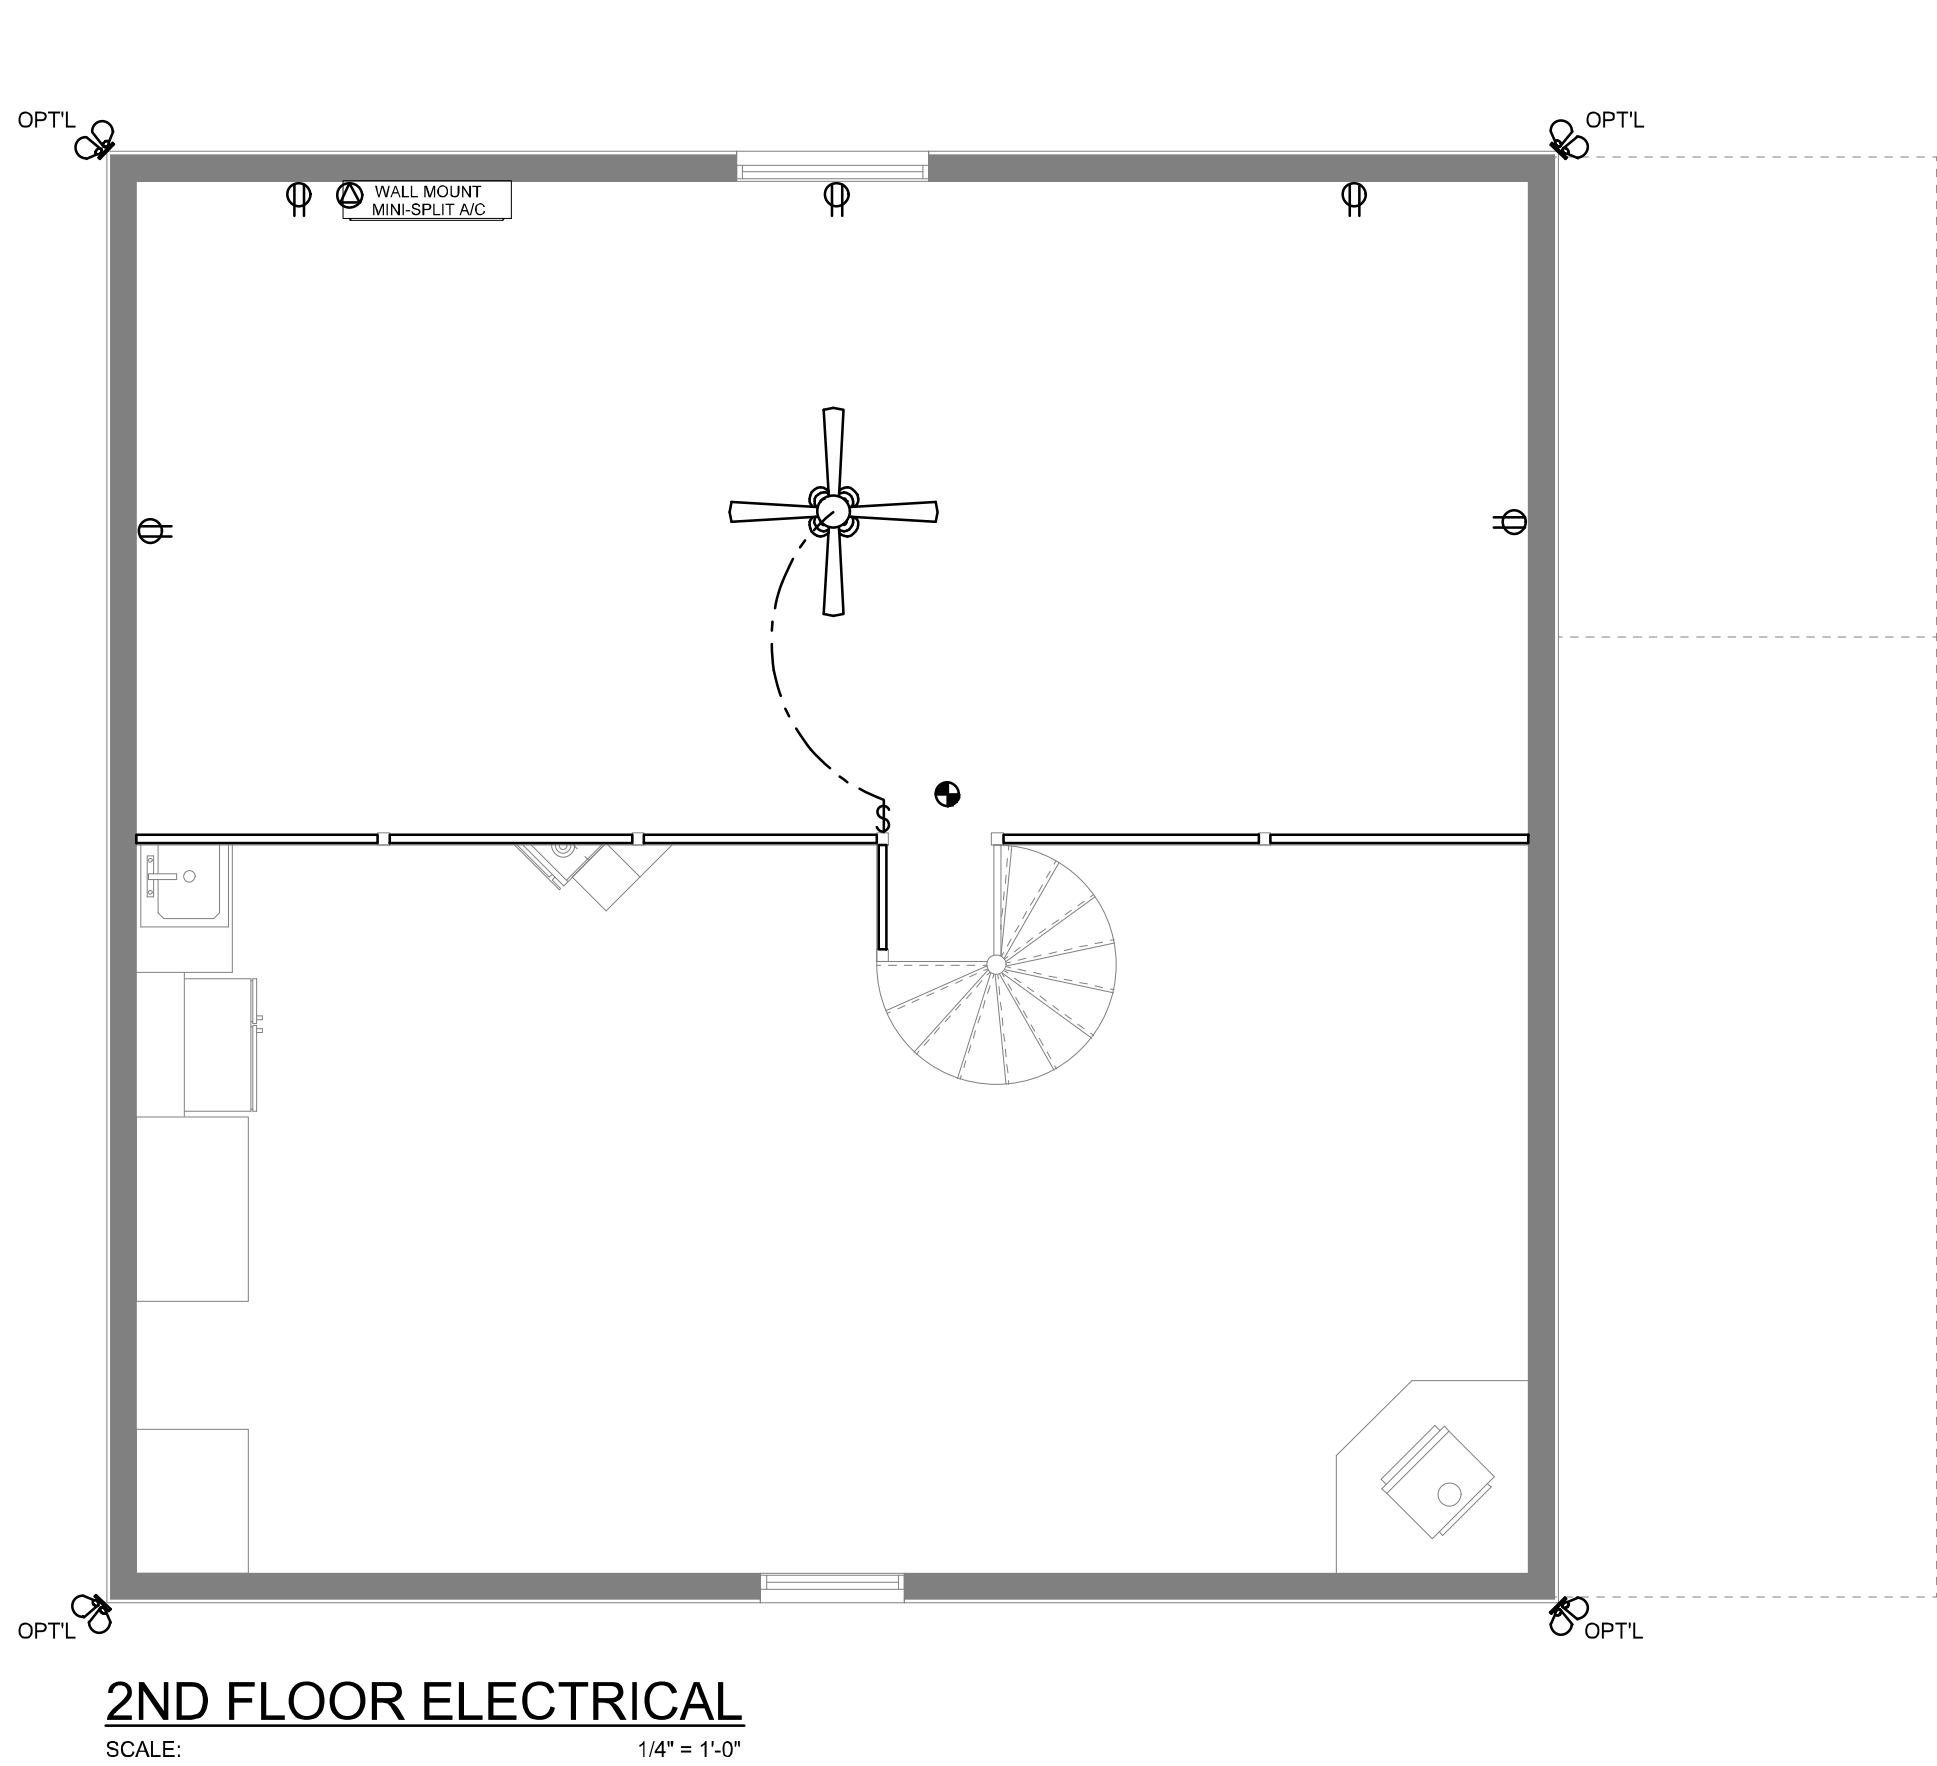

REVISIONS

June 28, 2022

SOFTPLAN

ARCHITECTURAL DESIGN SOFTWARE

Will C. Hogue

A CUSTOM BARNDOMINIUM DESIGN FOR:

ADAM & CARRIE HOGUE

PROJECT ADDRESS: 229 SW STELL GLEN, LAKE CITY, FLORIDA 32024

N. P. GEISLER

Digitally signed by: N. P. GEISLER
DN: CN = N. P. GEISLER C = US O = AR0007005
OU = ARCHITECT
Date: 2022.06.29 11:02:00 -05'00'

AR0007005

NICHOLAS PAUL GEISLER ARCHITECT

1758 NW Brown Rd.
Lake City, FL 32055
(386) 365-4355

N.C.A.A. Certified

JOINT VENTURED WITH

WM DESIGN ASSOCIATES, INC.

426 SW COMMERCE DR., STE 130
LAKE CITY, FL 32025
(386) 758-8406
will@willmayers.net

WILL MAYERS

JOB NUMBER

20220501

DATE:

June 28, 2022


SHEET NUMBER

A.3

NOTE: ALL DRAWINGS NOT TO BE SCALED, WRITTEN DIMENSIONS TAKE PRECEDENCE OVER SCALED DIMENSIONS

BUILDING COMPONENTS & CLADDING LOADS						
MEAN BUILDING HEIGHT = 30.0', EXPOSURE "B"						
	ZONE	AREA	Vult 110 MPH	Vult 120 MPH	Vult 130 MPH	Vult 140 MPH
ROOF 7'- TO 27'	1	10	12.0 / -19.9	14.9 / -23.7	17.5 / -27.8	20.3 / -32.3
	1	20	11.4 / -19.4	13.6 / -23.0	16.0 / -27.0	18.5 / -31.4
	1	50	10.0 / -18.6	11.9 / -22.2	13.9 / -26.0	16.1 / -30.2
	2	10	12.5 / -34.7	14.9 / -41.3	17.5 / -48.4	20.3 / -56.2
	2	20	11.4 / -31.9	13.6 / -38.0	16.0 / -44.6	18.5 / -51.7
	2	50	10.0 / -28.2	11.9 / -33.6	13.9 / -39.4	16.1 / -45.7
	3	10	12.5 / -51.3	14.9 / -61.0	17.5 / -71.6	20.3 / -83.1
	3	20	11.4 / -47.9	13.6 / -57.1	16.0 / -67.0	18.5 / -77.7
	3	50	10.0 / -43.5	11.9 / -51.8	13.9 / -60.8	16.1 / -70.5
WALL	4	10	21.8 / -23.6	25.9 / -34.7	30.4 / -33.0	35.3 / -38.2
	4	20	20.8 / -22.6	24.7 / -26.9	29.0 / -31.6	33.7 / -36.7
	4	50	19.5 / -21.3	23.2 / -25.4	27.2 / -29.8	31.6 / -34.6
	5	10	21.8 / -29.1	25.9 / -34.7	30.4 / -40.7	35.3 / -47.2
	5	20	20.8 / -27.2	24.7 / -32.4	29.0 / -38.0	33.7 / -44.0
	5	50	19.5 / -24.6	23.2 / -29.3	27.2 / -34.3	31.6 / -39.8

HEADER SPANS FOR EXTERIOR BEARING WALLS							
HEADERS SUPPORTING:	HEADER SIZE	BUILDING WIDTH (FT)					
		20'		28'		36'	
		SPAN	# JACKS	SPAN	# JACKS	SPAN	# JACKS
ROOF, CEILING	2-2x4	3'-6"	1	3'-2"	1	2'-10"	1
	2-2x6	5'-5"	1	4'-8"	1	4'-2"	1
	2-2x8	6'-10"	1	5'-11"	2	5'-4"	1
	2-2x10	8'-5"	2	7'-3"	2	6'-8"	2
	2-2x12	9'-9"	2	8'-5"	2	7'-6"	2
	3-2x8	8'-4"	1	7'-5"	1	6'-8"	1
	3-2x10	10'-6"	1	9'-1"	2	8'-2"	1
	3-2x12	12'-2"	2	10'-7"	2	9'-5"	2
	4-2x8	9'-2"	1	8'-4"	1	9'-2"	1
	4-2x10	11'-8"	1	10'-6"	1	9'-5"	1
	4-2x12	14'-1"	1	12'-2"	2	10'-11"	1

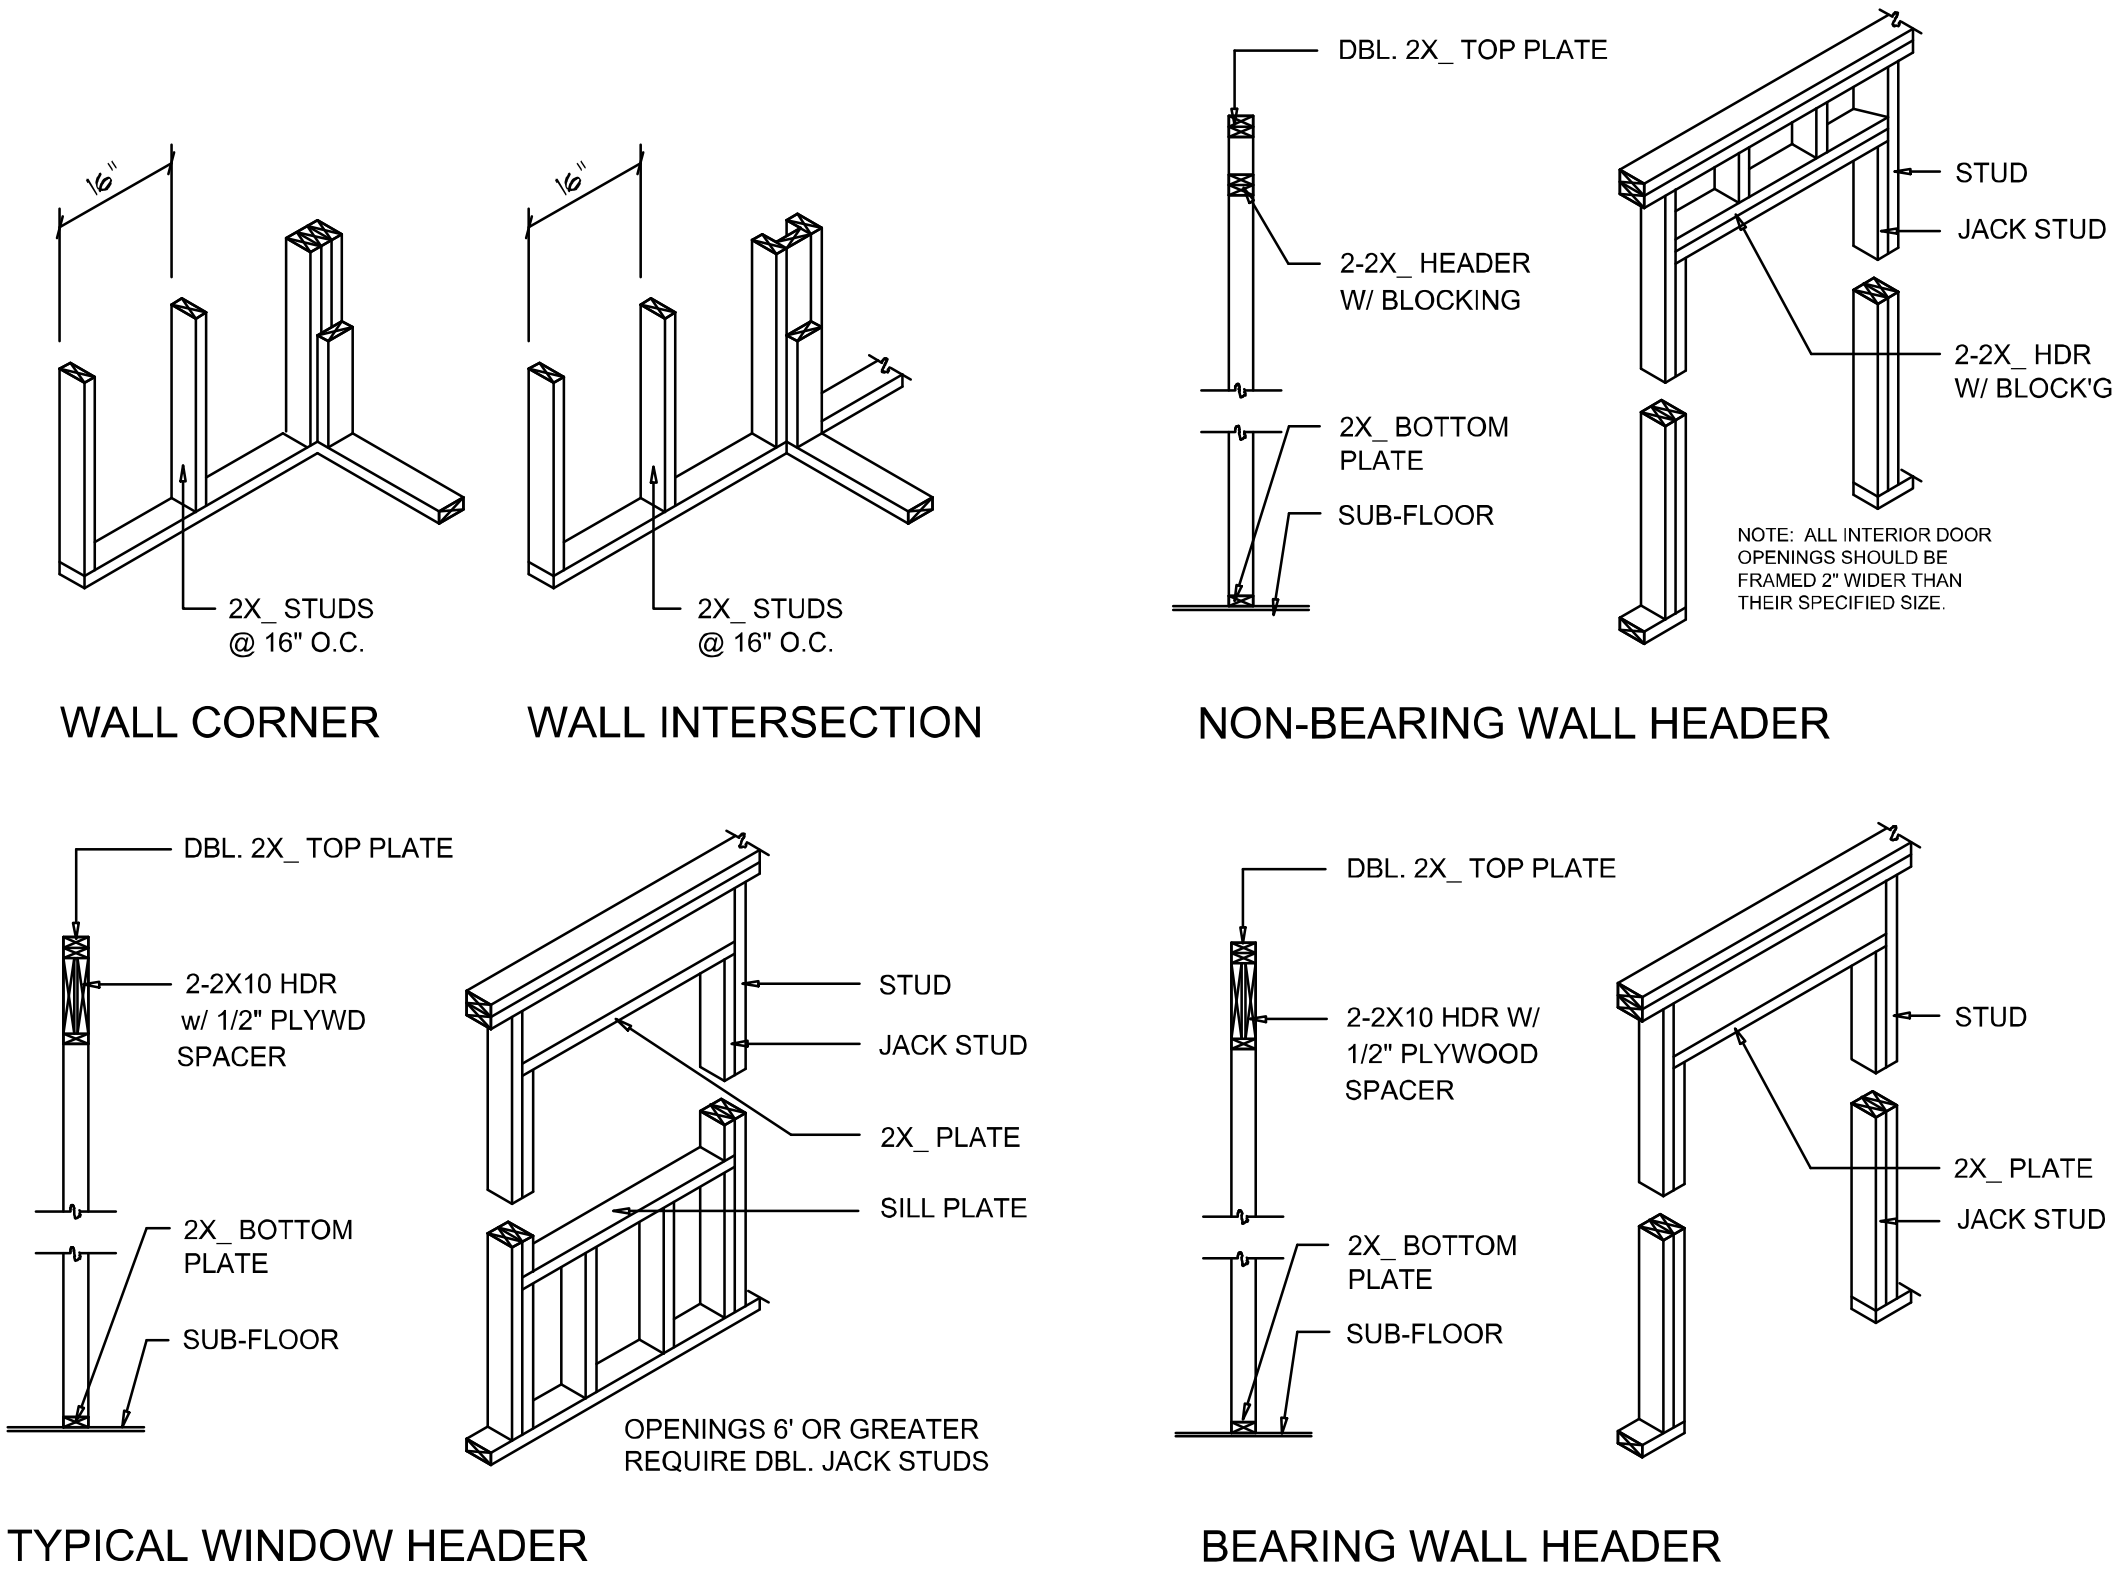

Wall Framing/Header DETAILS

SCALE: NONE

F

Wall DETAILS

SCALE: NONE

"WindSTORM" ALT. SHEATHING METHOD:

ALTERNATIVE METHOD FOR ANCHORING THE TOP WALL PLATE TO THE FOUNDATION IN LIEU OF THE SP1/SP2 OR SP4 STRIPS INDICATED IN THE CONSTRUCTION DOCUMENTS FOR THIS PROJECT SHALL ALLOWED AS FOLLOWS:

1. APPLY VERTICALLY, "WindSTORM" 7/16" OSB 48" X 97", 109", 121" OR 145" SHEATHING, FASTEN TO THE TOP PLATE AND THE SILL PLATE WITH EITHER 6d COMMONS @ 3" O.C. OR 6d COMMONS @ 4" O.C., FASTEN TO EACH STUD WITH EITHER 6d COMMONS @ 6" O.C. OR 6d COMMONS @ 8" O.C.

Alternate "Titan" bolt concrete anchor system

ANCHOR SILL PLATE WITH 5/8" TITAN ANCHOR BOLT, PLACED AT 40" O.C. AROUND PERIMETER OF SLAB AND ALL INTERIOR BEARING WALLS.

A CUSTOM BARNDOMINIUM DESIGN FOR:
ADAM & CARRIE HOGUE
PROJECT ADDRESS: 229 SW STELL GLEN, LAKE CITY, FLORIDA 32024

N. P. GEISLER

Digitally signed by N. P. GEISLER
DN: CN = N. P. GEISLER, C = US, O = AR0007005
OU = ARCHITECT
Date: 2022.06.29 10:58:03 -0500

AR0007005

NICHOLAS PAUL GEISLER ARCHITECT
N.C.A.A. Certified
1758 NW Brown Rd.
Lake City, FL 32055
(386) 365-4355

JOINT VENTURED WITH

WM DESIGN ASSOCIATES, INC.
426 SW COMMERCE DR., STE 130
LAKE CITY, FL 32025
(386) 758-8406
wm@wmtyers.net



JOB NUMBER
20220501
DATE:
June 27, 2022

SHEET NUMBER
A.4

SHEARWALL NOTES:

1. ALL SHEARWALLS SHALL BE TYPE 2 SHEARWALLS AS DEFINED BY STD 10-97 SBC01.05.4.3.
2. THE WALL SHALL BE ENTIRELY SHEATHED WITH 7/16" O.S.B. INCLUDING AREAS ABOVE AND BELOW OPENINGS.
3. ALL SHEATHING SHALL BE ATTACHED TO FRAMING ALONG ALL FOUR EDGES WITH JOINTS FOR ADJACENT PANELS OCCURRING OVER COMMON FRAMING MEMBERS OR ALONG BLOCKING.
4. NAIL SPACING SHALL BE 4" O.C. EDGES AND 8" O.C. IN THE FIELD.
5. TYPE 2 SHEARWALLS ARE DESIGNED FOR THE OPENING IT CONTAINS. MAXIMUM HEIGHT OF OPENING SHALL BE 5/8 TIMES THE WALL HEIGHT. THE MINIMUM DISTANCE BETWEEN OPENINGS SHALL BE THE WALL HEIGHT/3.5 FOR 8'-0" WALLS (2'-3").

OPENING WIDTH	SILL PLATES	16d TOE NAILS EACH END
UP TO 6'-0"	(1) 2x4 OR (1) 2x6	1
> 6' TO 9'-0"	(3) 2x4 OR (1) 2x6	2
> 9' TO 12'-0"	(5) 2x4 OR (2) 2x6	3