



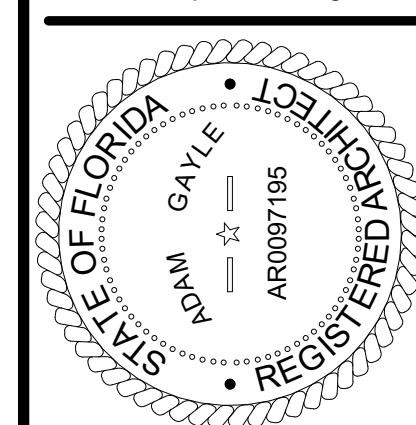

12/05/2025

TO THE BEST OF THE ARCHITECT'S OR THE ENGINEER'S KNOWLEDGE, THE PLANS AND SPECIFICATIONS COMPLY WITH THE APPLICABLE MINIMUM BUILDING CODES & THE APPLICABLE FIRE SAFETY STANDARDS AS DETERMINED BY THE LOCAL AUTHORITY IN ACCORDANCE WITH THE SECTION AND CHAPTER 633, FL. STATUTES.

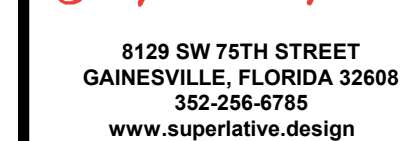

PINNACLE OFFICE

19816 US-441
HIGH SPRINGS, FL 32643

REVISIONS

NO:	DATE:	REF:	BY:
-----	-------	------	-----

DRAWING STATUS:

100% CONSTRUCTION
DOCUMENTS

ISSUE DATE:
12.05.2025

<u>DRAWN BY:</u> ARG	<u>CHECKED BY:</u> ARG
-------------------------	---------------------------


PROJECT NUMBER:
24030

DRAWING TITLE:
LEVEL 1 ELECTRICAL PLAN

SHEET NO.

E1.01

DATE/TIME STAMP:
12/5/2025 2:17:48 PM

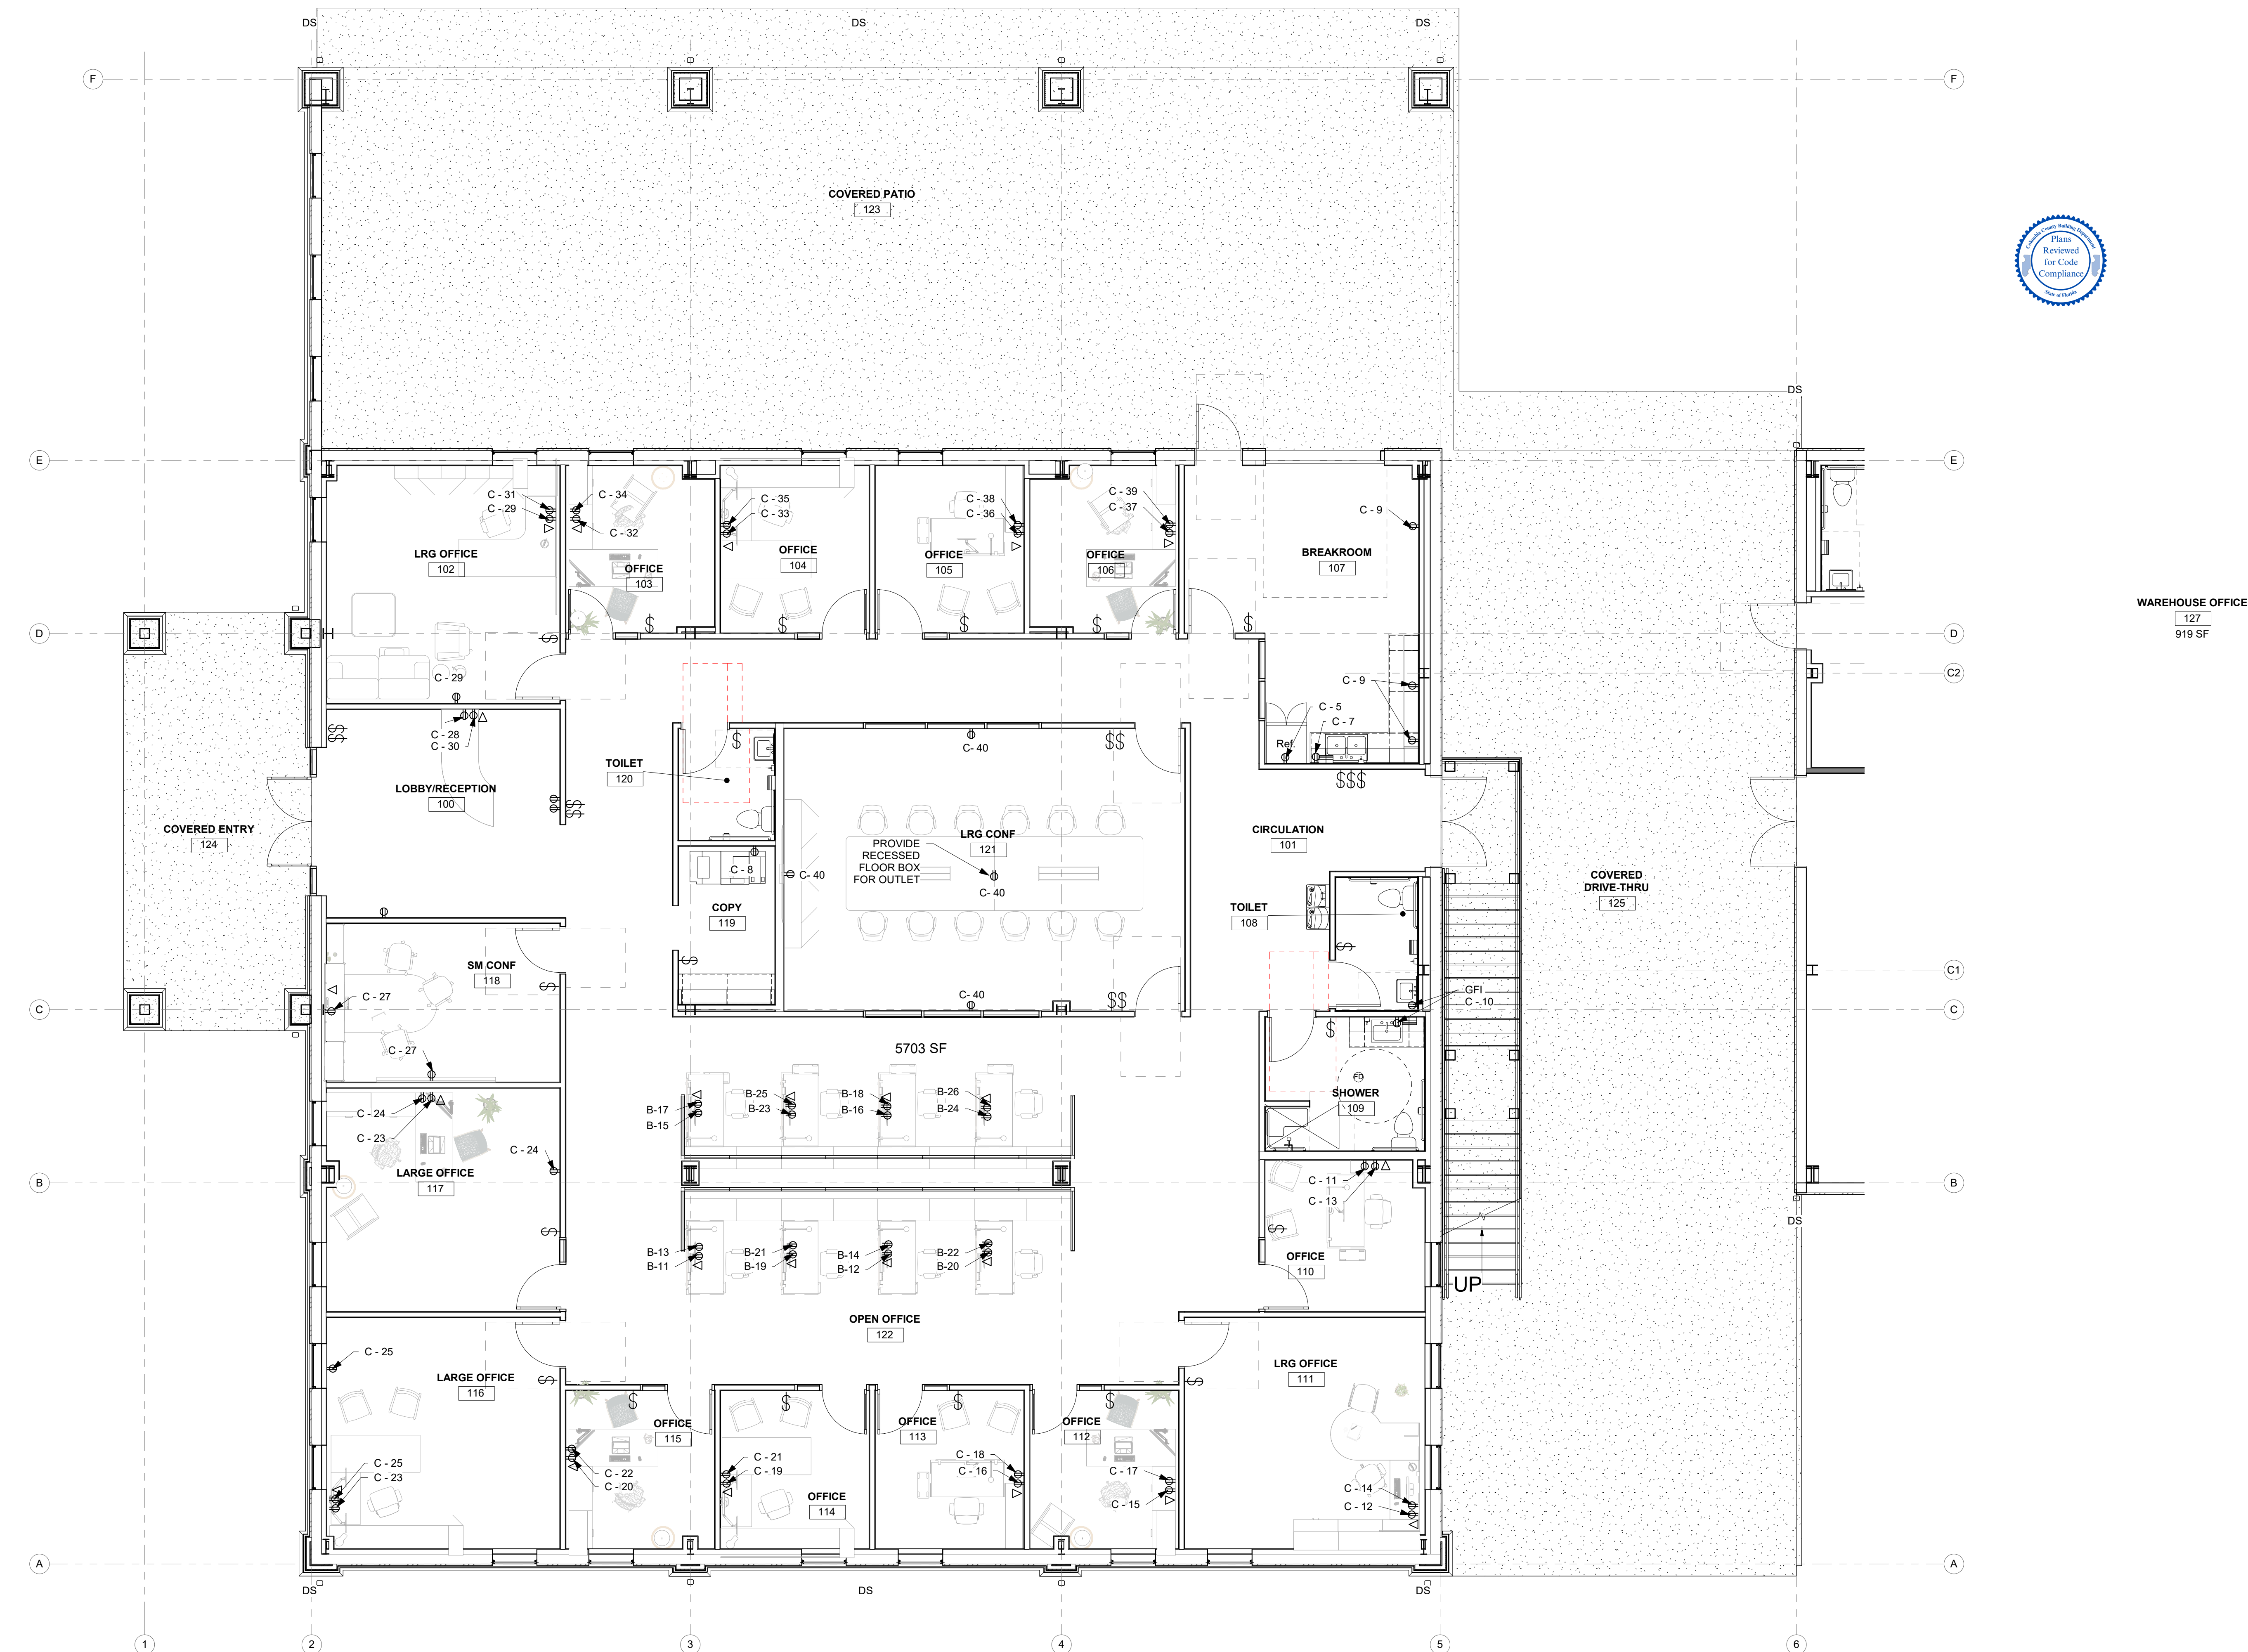

1 LEVEL 1 ELECTRICAL PLAN

$$3/16'' = 1'-0''$$

SIEMENS

Proposal

To: CITY ELECTRIC SUPPLY COMPANY
462 SW ARLINGTON BLVD
LAKE CITY, FL 32025-5604
USA

From:

USA

Attention:

Tel. No.:

Job Name: Pinnacle Office
Quote Name: Pinnacle Office
Quote #: cdomrx00c_11082501_00_00_M00
Bid Date: 11/06/2025

Siemens Industry, Inc. (Company) agrees to sell to Purchaser and Purchaser agrees to purchase from the Company the goods described below. Written quotations are valid for 30 calendar days from price approval date unless otherwise stated in the quotation. Quotations are subject to change by Siemens Industry, Inc. at any time upon written notice to Purchaser. Estimated Lead times refer to the manufacturing cycles, in working days, at time of quotation and are subject to change.

Quote Notes:

Line #:	Qty	Description
20000	1	MAIN DISC--HF326NRA Estimated Lead Time until Ready for Shipment : 14 Working Days. Heavy Duty (600 V max), Fusible, Number of Poles:3, Voltage AC Max:240V, Voltage DC Max:250, Max Ampere Rating:600A, Type 3R, None, None, Fuse Class- Standard Mounting:CLASS H, K, Fuse Class - Move Load Base:NONE, Fuse Class- Need Mounting KIT:CLASS J, R, T, 1 - HF326NRA 1 - HDSS FUS 3P4W 240V 600A N3R SERIES A
21000	1	MDP--PANELBOARD P2 Estimated Lead Time until Ready for Shipment : 30 Working Days. 1 - SECTION P2C42ML600FTS, System Voltage: 208Y/120 3Ø 4W Wye AC, IR @ 10,000 AIC, Top Feed, Surface Mount, Bus Rating: 600A, Bus Material: Copper, Plating: Tin, NEMA 1 INDOOR. 1 - INTERIOR W/ 600A MAIN LUG 1 - (2)3/0-500Kcmil 1 - Special Front Door in Door 1 - Card Holder-Std Plastic Sleeve 1 - Certification - UL 1 - Std Al/Cu Gnd Connector 3 - 20A /2P-BL 1 - Catalog #: B220 1 - 30A /2P-BL

cdomrx00c_11082501_00_00_M00 1 11/6/2025

SIEMENS

Proposal

- 1 - Catalog #: B230
- 5 - 45A /2P-BL
- 1 - Catalog #: B245
- 5 - 50A /2P-BL
- 1 - Catalog #: B250
- 2 - BL/BQD PROVISION
- 1 - 150A /3P-QR2
- 1 - Catalog #: QR23B150
- 1 - 225A /3P-QR2
- 1 - Catalog #: QR23B225
- Enclosure, Catalog Number B56
- 1 - 20W TYPE 1 BOX W/O GROUND BUS, 56H X 20W
- Front, Catalog Number S56D
- 1 - DOOR-N-DOOR FRONT ASSY 20W 56H, SURFACE

22000 1 **B--PANELBOARD P1**
Estimated Lead Time until Ready for Shipment : 30 Working Days.

- 1 - SECTION
P1C42ML250CTST, System Voltage: 208Y/120 3Ø 4W Wye AC, IR @ 10,000 AIC, Top Feed, Surface Mount, Bus Rating: 250A, Bus Material: Copper, Plating: Tin, NEMA 1 INDOOR.
- 1 - INTERIOR W/ 250A MAIN LUG
1 - AL/CU Main Lug - (1)#6-350Kcmil
1 - Subfeed/Feedthru Provision
1 - Special Front Door in Door
1 - Card Holder-Std Plastic Sleeve
1 - Gnd Conn-Shipped w/ Interior
1 - Std Al/Cu Gnd Connector
1 - 250A 100% Neutral 42, 54Cir (AL/CU Branch Connector)
1 - Certification - UL
- 12 - BL/BQD PROVISION
- 30 - 20A /1P-BL
- 1 - Catalog #: B120
- 1 - 125A /3P-QR2
- 1 - Mechanical Lug - QR Subfeed (1)#3-300Kcmil Cu/Al
- 1 - RP1 3 Phase Std Kit QR
- 1 - Catalog #: QR23B125
- Enclosure, Catalog Number B44
- 1 - 20W TYPE 1 BOX W/O GROUND BUS, 44H X 20W
- Front, Catalog Number S44D
- 1 - DOOR-N-DOOR FRONT ASSY 20W 44H, SURFACE

23000 1 **G--PANELBOARD P1**
Estimated Lead Time until Ready for Shipment : 30 Working Days.

- 1 - SECTION
P1C42ML250CTST, System Voltage: 208Y/120 3Ø 4W Wye AC, IR @ 10,000 AIC, Top Feed, Surface Mount, Bus Rating: 250A, Bus Material: Copper, Plating: Tin, NEMA 1 INDOOR.

cdomrx00c_11082501_00_00_M00 2 11/6/2025

SIEMENS


Proposal

- 1 - INTERIOR W/ 250A MAIN LUG
- 1 - AL/CU Main Lug - (1)#6-350Kcmil
- 1 - Subfeed/Feedthru Provision
- 1 - Special Front Door in Door
- 1 - Gnd Conn-Shipped w/ Interior
- 1 - Card Holder-Std Plastic Sleeve
- 1 - Std Al/Cu Gnd Connector
- 1 - 250A 100% Neutral 42, 54Cir (AL/CU Branch Connector)
- 1 - Certification - UL
- 2 - BL/BQD PROVISION
- 40 - 20A /1P-BL
- 1 - Catalog #: B120
- Enclosure, Catalog Number B44
- 1 - 20W TYPE 1 BOX W/O GROUND BUS, 44H X 20W
- Front, Catalog Number S44D
- 1 - DOOR-N-DOOR FRONT ASSY 20W 44H, SURFACE


24000 1 **D--PANELBOARD P1**
Estimated Lead Time until Ready for Shipment : 30 Working Days.

- 1 - SECTION
P1C30ML125CTST, System Voltage: 208Y/120 3Ø 4W Wye AC, IR @ 10,000 AIC, Top Feed, Surface Mount, Bus Rating: 250A, Bus Material: Copper, Plating: Tin, NEMA 1 INDOOR.
- 1 - INTERIOR W/ 125A MAIN LUG
1 - Subfeed/Feedthru Provision
- 1 - AL/CU Main Lug - (1)#6-350Kcmil
- 1 - Special Front Door in Door
- 1 - Card Holder-Std Plastic Sleeve
- 1 - Gnd Conn-Shipped w/ Interior
- 1 - Std Al/Cu Gnd Connector
- 1 - 250A 100% Neutral 30Cir (AL/CU Branch Connector)
- 1 - Certification - UL
- 20 - BL/BQD PROVISION
- 1 - 30A /2P-BL
- 1 - Catalog #: B230
- 2 - 50A /2P-BL
- 1 - Catalog #: B250
- 4 - 20A /1P-BL
- 1 - Catalog #: B120
- Enclosure, Catalog Number B38
- 1 - 20W TYPE 1 BOX W/O GROUND BUS, 38H X 20W
- Front, Catalog Number S38D
- 1 - DOOR-N-DOOR FRONT ASSY 20W 38H, SURFACE

cdomrx00c_11082501_00_00_M00 3 11/6/2025

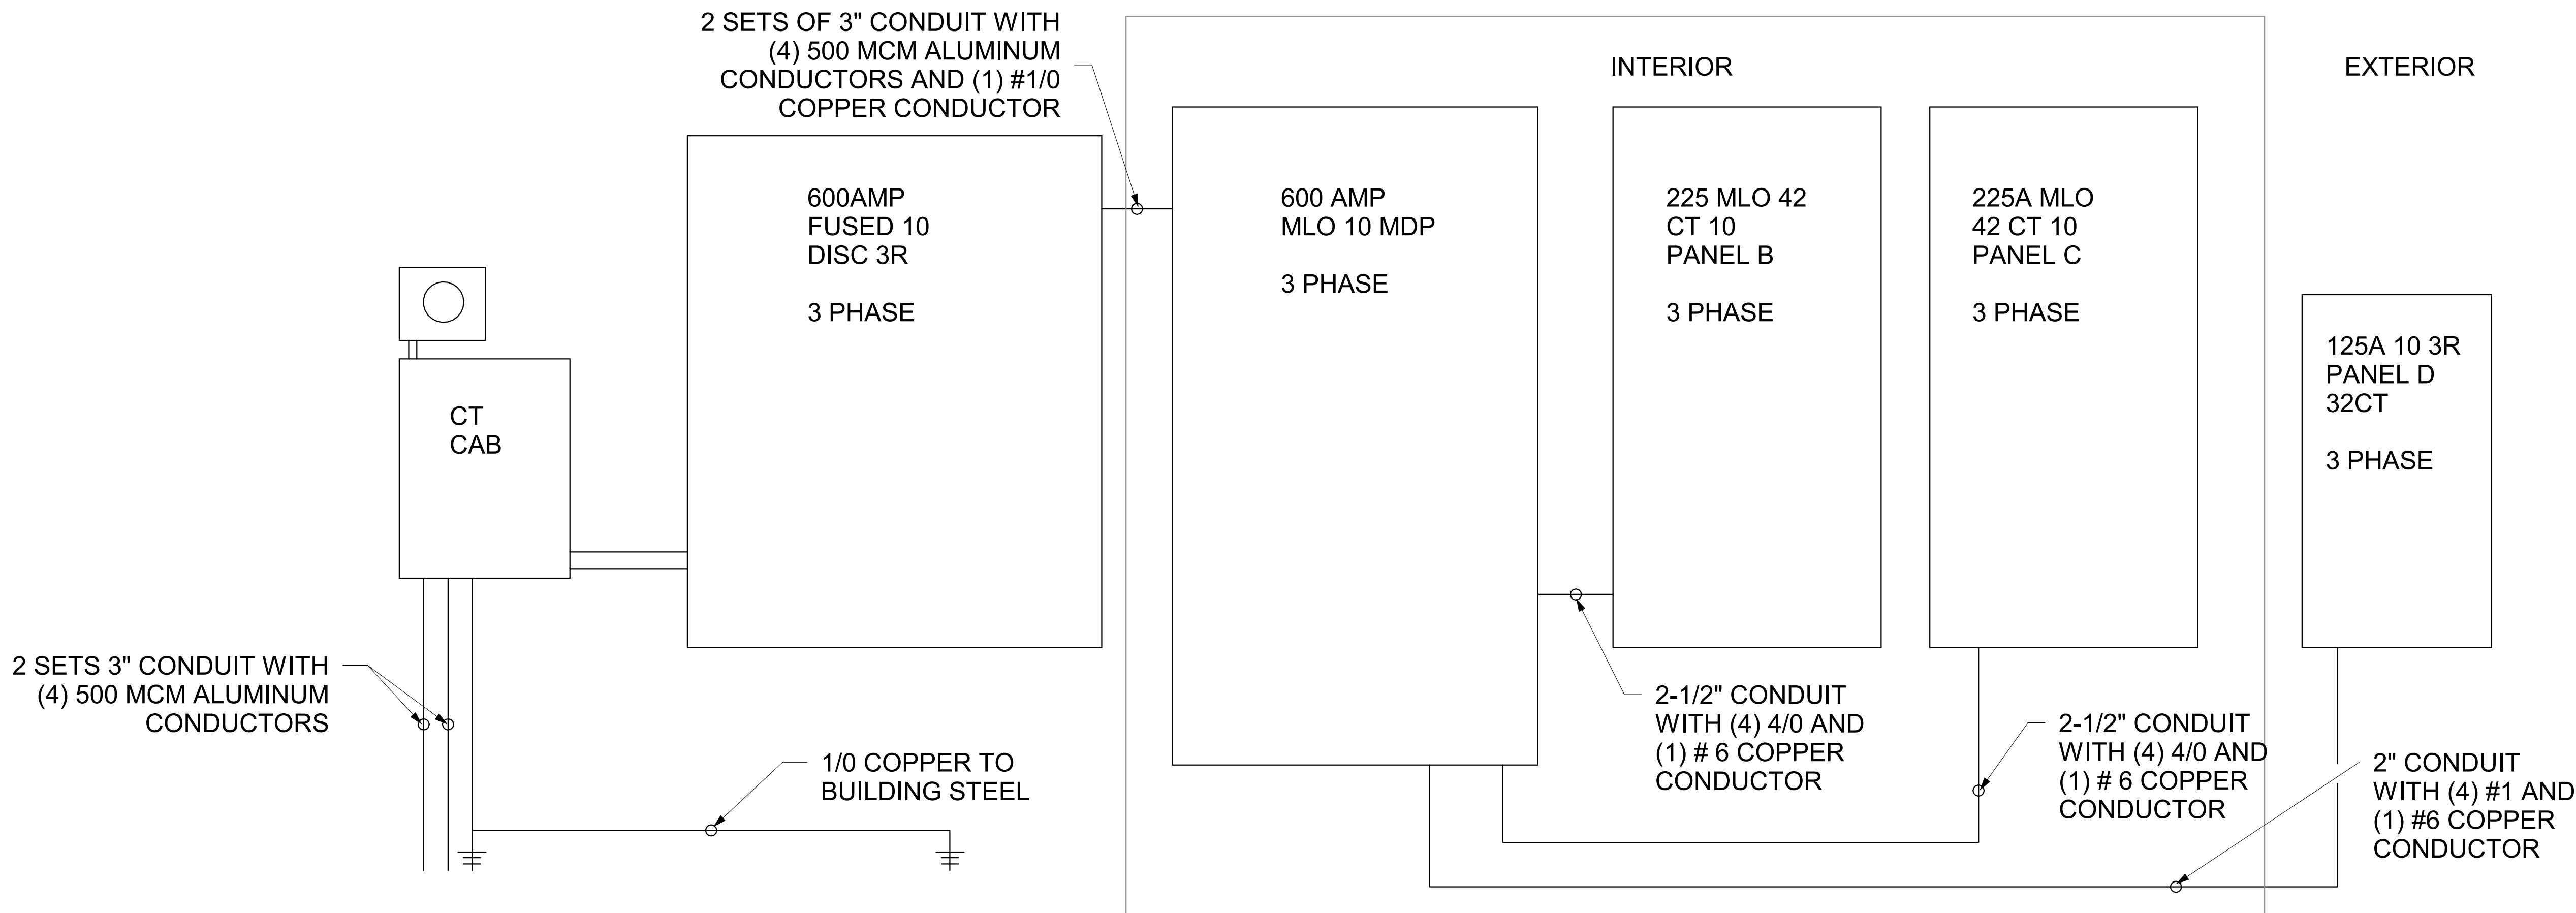

Supervisory
8129 SW 75TH STREET
GAINESVILLE, FLORIDA 32608
352-256-6785
www.superlative.design

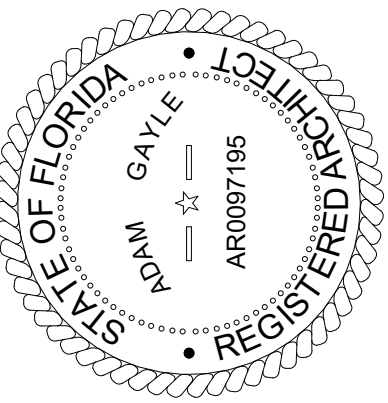

12/05/2025

TO THE BEST OF THE ARCHITECTS OR THE ENGINEER'S KNOWLEDGE, THE PLANS AND SPECIFICATIONS COMPLY WITH ALL CITY, COUNTY, STATE AND FEDERAL REQUIREMENTS. THE ARCHITECTS OR ENGINEER'S LIABILITY IS LIMITED TO THE DESIGN AND CONSTRUCTION OF THE PROJECT ONLY. THE ARCHITECTS OR ENGINEER'S LIABILITY IS NOT EXTENDED TO ANY OTHER PROJECTS OR TO ANY OTHER PROFESSIONAL SERVICES. THE ARCHITECTS OR ENGINEER'S LIABILITY IS NOT EXTENDED TO ANY OTHER PROFESSIONAL SERVICES. THE ARCHITECTS OR ENGINEER'S LIABILITY IS NOT EXTENDED TO ANY OTHER PROFESSIONAL SERVICES.

PINNACLE
SITE SOLUTIONS

PINNACLE OFFICE

19816 US-441
HIGH SPRINGS, FL 32643

REVISIONS

NO. DATE REF. BY:

DRAWING STATUS:

100% CONSTRUCTION DOCUMENTS

ISSUE DATE:
12.05.2025

DRAWN BY: ARG CHECKED BY: ARG


PROJECT NUMBER:
24030

DRAWING TITLE:
LEVEL 1 ELECTRICAL PLAN - LEGENDS

SHEET NO.

E1.02

DATE/TIME STAMP:
12/5/2025 2:17:50 PM

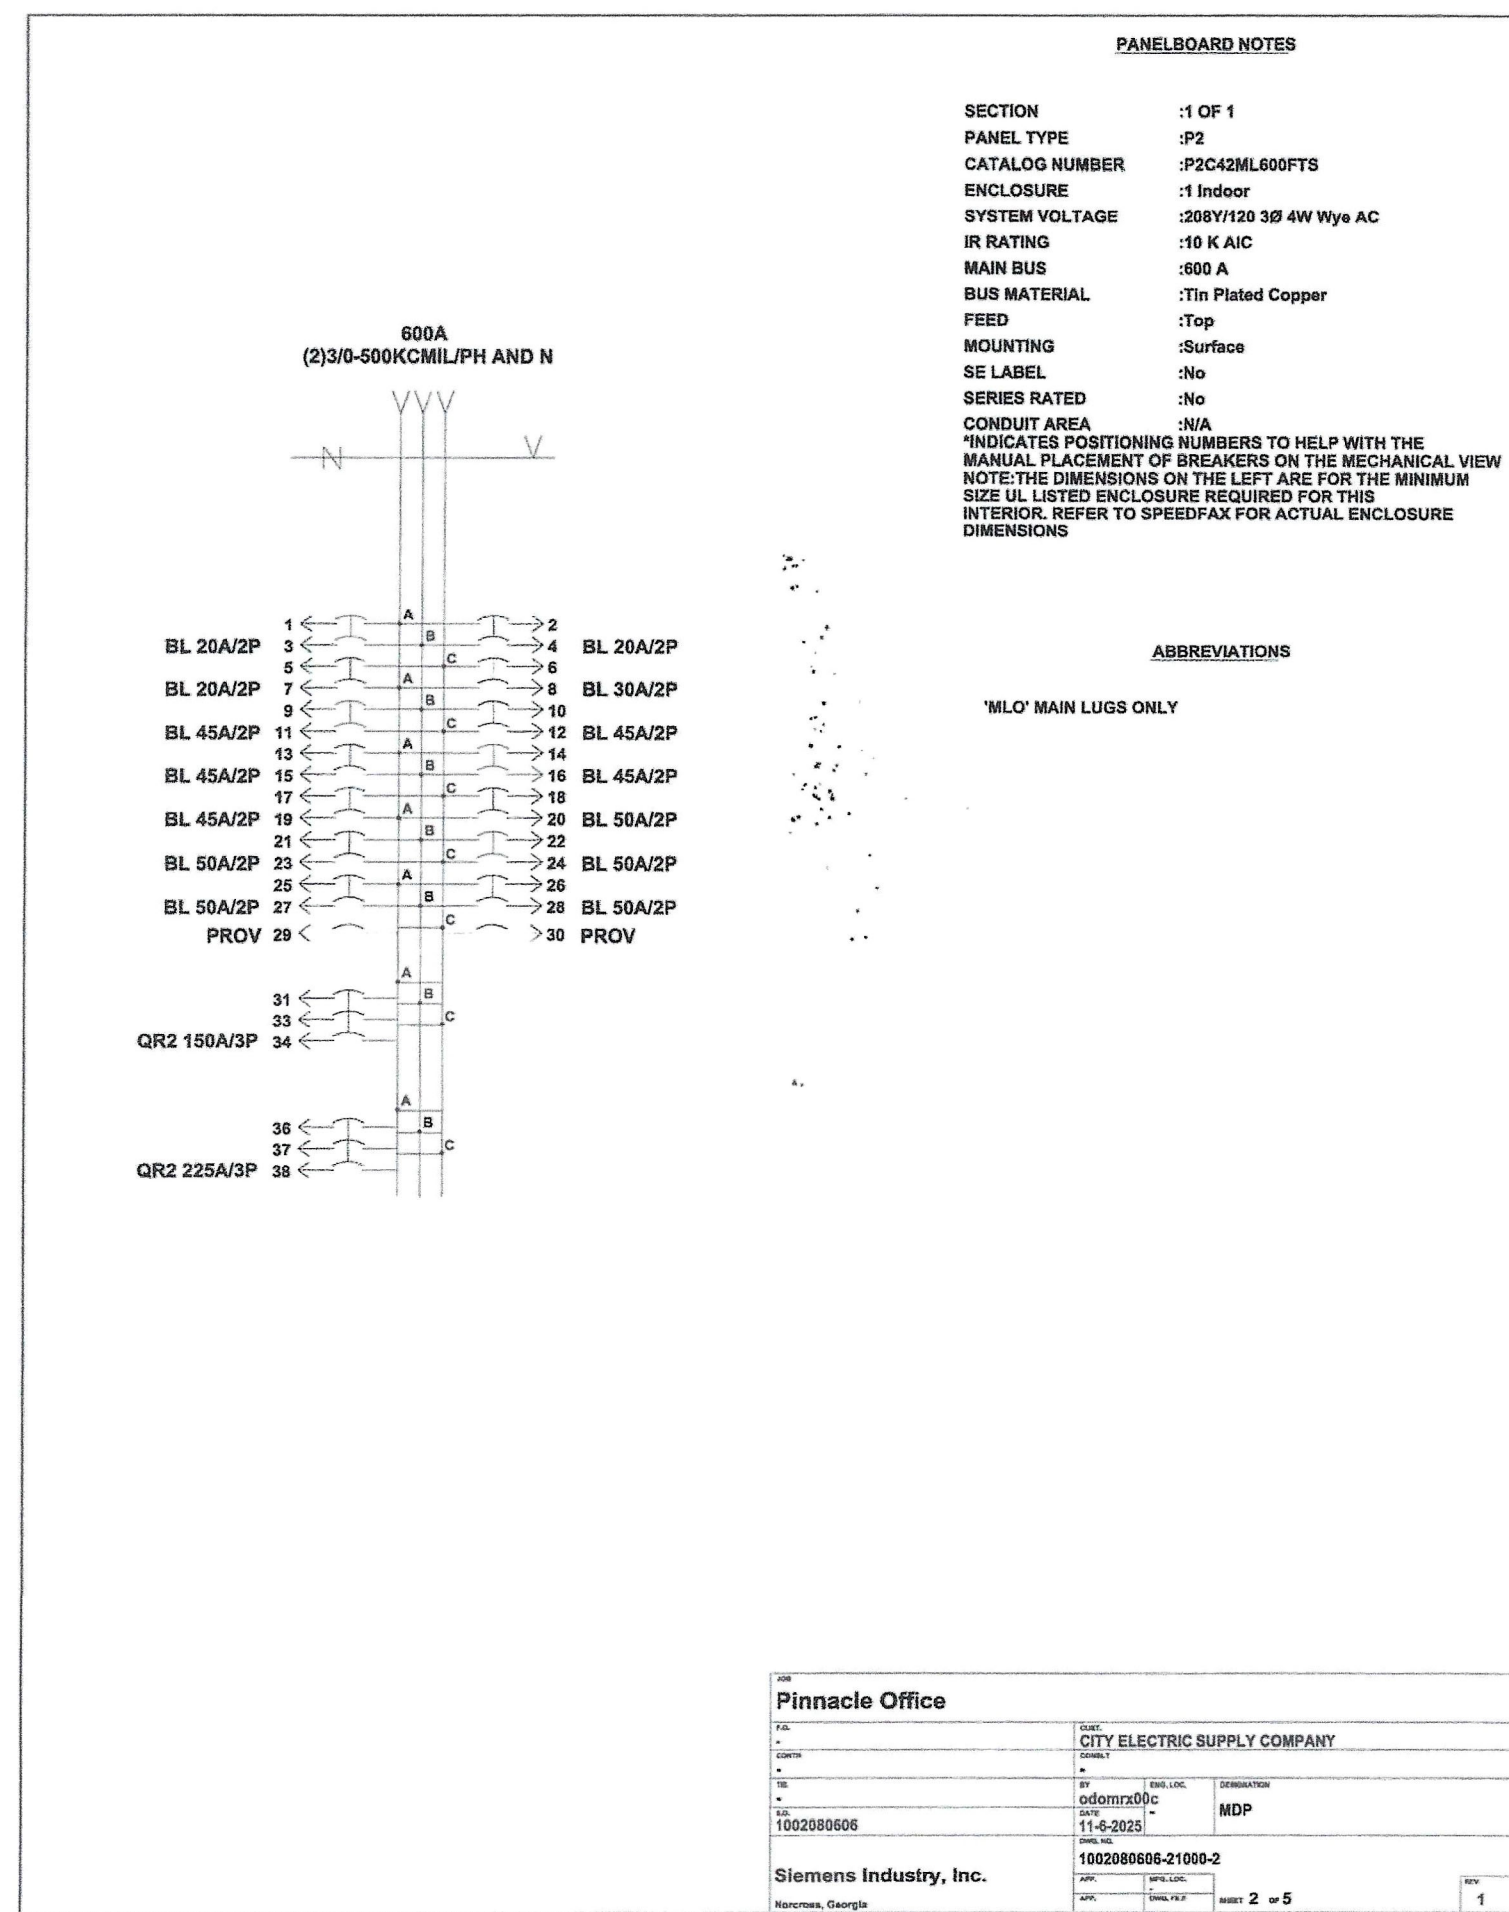

CIRCUIT SCHEDULE									
CIRCUIT NUMBER	UNIQUE ID NO.	TRIP AMPS (A)	POLES	DEVICE TYPE	INTERRUPT RATING (AIC)	METER ACC	CT RATING	LOAD LUG SIZE PER PHASE	CIRCUIT IDENTIFICATION
1/3	8	20	2	BL	10,000	N/A	N/A	(1)1/4-#10 CU / #12-#10 AL	-
5/7	10	20	2	BL	10,000	N/A	N/A	(1)1/4-#10 CU / #12-#10 AL	-
9/11	12	45	2	BL	10,000	N/A	N/A	(1)#8-#6 CU / #8-#4 AL	-
13/15	15	45	2	BL	10,000	N/A	N/A	(1)#8-#6 CU / #8-#4 AL	-
17/19	17	45	2	BL	10,000	N/A	N/A	(1)#8-#6 CU / #8-#4 AL	-
21/23	19	50	2	BL	10,000	N/A	N/A	(1)#8-#6 CU / #8-#4 AL	-
25/27	21	50	2	BL	10,000	N/A	N/A	(1)#8-#6 CU / #8-#4 AL	-
29	24	-	1	B-PROV	-	-	-	-	-
31/33/34	27	150	3	QR2	10,000	N/A	N/A	(1)W3-300KCMIL CU/AL	-
35/37/38	29	225	3	QR2	10,000	N/A	N/A	(1)W3-300KCMIL CU/AL	-
2/4	9	20	2	BL	10,000	N/A	N/A	(1)1/4-#10 CU / #12-#10 AL	-
6/8	11	30	2	BL	10,000	N/A	N/A	(1)1/4-#10 CU / #12-#10 AL	-
10/12	13	45	2	BL	10,000	N/A	N/A	(1)#8-#6 CU / #8-#4 AL	-
14/16	16	45	2	BL	10,000	N/A	N/A	(1)#8-#6 CU / #8-#4 AL	-
18/20	18	50	2	BL	10,000	N/A	N/A	(1)#8-#6 CU / #8-#4 AL	-
22/24	20	50	2	BL	10,000	N/A	N/A	(1)#8-#6 CU / #8-#4 AL	-
26/28	23	50	2	BL	10,000	N/A	N/A	(1)#8-#6 CU / #8-#4 AL	-
3/5	25	-	1	B-PROV	-	-	-	-	-

Pinnacle Office

City Electric Supply Company

114-2021

1002080506

City Electric Supply Company

114-2021


MDP

1002080506-21000-3

Siemens Industry, Inc.

Revision: 000000

Page 3 of 5

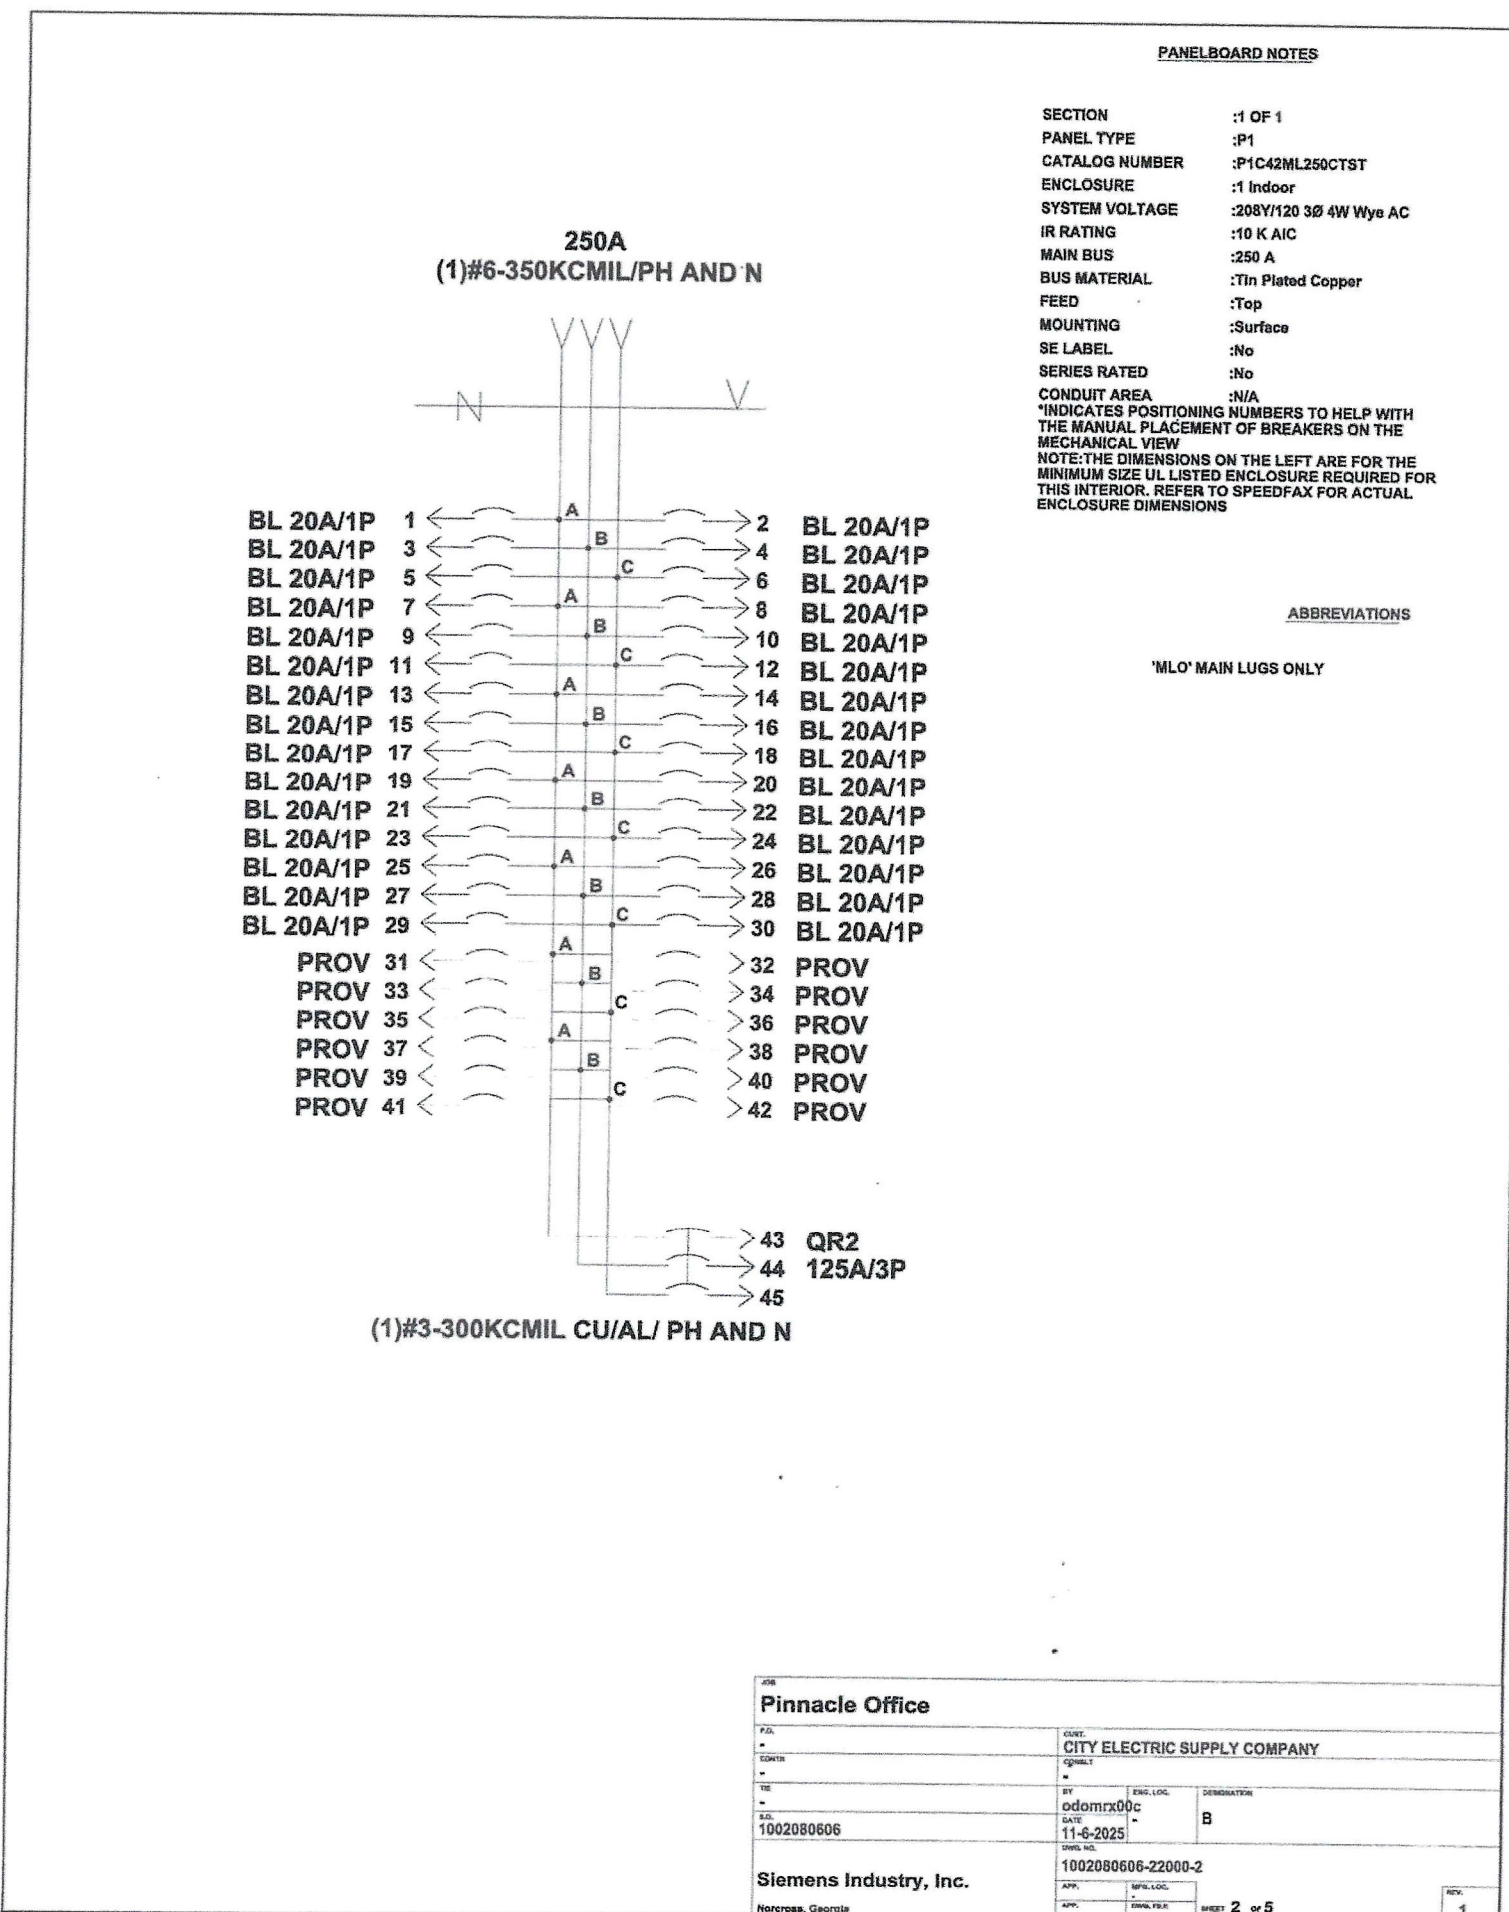

CIRCUIT SCHEDULE									
CIRCUIT NUMBER	UNIQUE ID NO.	TRIP AMPS (A)	POLES	DEVICE TYPE	INTERUPT RATING (AIC)	METER ACC	CT RATING	LOAD LUG SIZE PER PHASE	CIRCUIT IDENTIFICATION
1	45	20	1	BL	10,000	N/A	N/A	(1)M14-810 CU / #12-810 AL	-
3	47	20	1	BL	10,000	N/A	N/A	(1)M14-810 CU / #12-810 AL	-
5	49	20	1	BL	10,000	N/A	N/A	(1)M14-810 CU / #12-810 AL	-
7	51	20	1	BL	10,000	N/A	N/A	(1)M14-810 CU / #12-810 AL	-
9	53	20	1	BL	10,000	N/A	N/A	(1)M14-810 CU / #12-810 AL	-
11	55	20	1	BL	10,000	N/A	N/A	(1)M14-810 CU / #12-810 AL	-
13	57	20	1	BL	10,000	N/A	N/A	(1)M14-810 CU / #12-810 AL	-
15	59	20	1	BL	10,000	N/A	N/A	(1)M14-810 CU / #12-810 AL	-
17	61	20	1	BL	10,000	N/A	N/A	(1)M14-810 CU / #12-810 AL	-
19	63	20	1	BL	10,000	N/A	N/A	(1)M14-810 CU / #12-810 AL	-
21	65	20	1	BL	10,000	N/A	N/A	(1)M14-810 CU / #12-810 AL	-
23	67	20	1	BL	10,000	N/A	N/A	(1)M14-810 CU / #12-810 AL	-
25	69	20	1	BL	10,000	N/A	N/A	(1)M14-810 CU / #12-810 AL	-
27	71	20	1	BL	10,000	N/A	N/A	(1)M14-810 CU / #12-810 AL	-
29	73	20	1	BL	10,000	N/A	N/A	(1)M14-810 CU / #12-810 AL	-
31	75	-	1	B-PROV	-	-	-	-	-
33	77	-	1	B-PROV	-	-	-	-	-
35	79	-	1	B-PROV	-	-	-	-	-
37	81	-	1	B-PROV	-	-	-	-	-
39	83	-	1	B-PROV	-	-	-	-	-
41	85	-	1	B-PROV	-	-	-	-	-
4304645	89	125	3	QR2	10,000	N/A	N/A	(1)R3-300KCMIL CU/AL	-
2	46	20	1	BL	10,000	N/A	N/A	(1)M14-810 CU / #12-810 AL	-
4	48	20	1	BL	10,000	N/A	N/A	(1)M14-810 CU / #12-810 AL	-
6	50	20	1	BL	10,000	N/A	N/A	(1)M14-810 CU / #12-810 AL	-
8	52	20	1	BL	10,000	N/A	N/A	(1)M14-810 CU / #12-810 AL	-
10	54	20	1	BL	10,000	N/A	N/A	(1)M14-810 CU / #12-810 AL	-
12	56	20	1	BL	10,000	N/A	N/A	(1)M14-810 CU / #12-810 AL	-
14	58	20	1	BL	10,000	N/A	N/A	(1)M14-810 CU / #12-810 AL	-
16	60	20	1	BL	10,000	N/A	N/A	(1)M14-810 CU / #12-810 AL	-
18	62	20	1	BL	10,000	N/A	N/A	(1)M14-810 CU / #12-810 AL	-
20	64	20	1	BL	10,000	N/A	N/A	(1)M14-810 CU / #12-810 AL	-
22	66	20	1	BL	10,000	N/A	N/A	(1)M14-810 CU / #12-810 AL	-
24	68	20	1	BL	10,000	N/A	N/A	(1)M14-810 CU / #12-810 AL	-
26	70	20	1	BL	10,000	N/A	N/A	(1)M14-810 CU / #12-810 AL	-
28	72	20	1	BL	10,000	N/A	N/A	(1)M14-810 CU / #12-810 AL	-
30	74	20	1	BL	10,000	N/A	N/A	(1)M14-810 CU / #12-810 AL	-
32	76	-	1	B-PROV	-	-	-	-	-
34	78	-	1	B-PROV	-	-	-	-	-
36	80	-	1	B-PROV	-	-	-	-	-
38	82	-	1	B-PROV	-	-	-	-	-
40	84	-	1	B-PROV	-	-	-	-	-
42	86	-	1	B-PROV	-	-	-	-	-

438

Pinnacle Office

City

CITY ELECTRIC SUPPLY COMPANY

City

CHICAGO, IL

State

IL

Zip

60606

Phone

773-3055

Fax

773-3055

1020200006

1020200006-22000-3

Siemens Industry, Inc.

1020200006-22000-3

Rev

Rev. 01/01

Rev

Rev. 01/01

Rev


Rev. 01/01

Rev

Rev. 01/01

Rev

Rev. 01/01

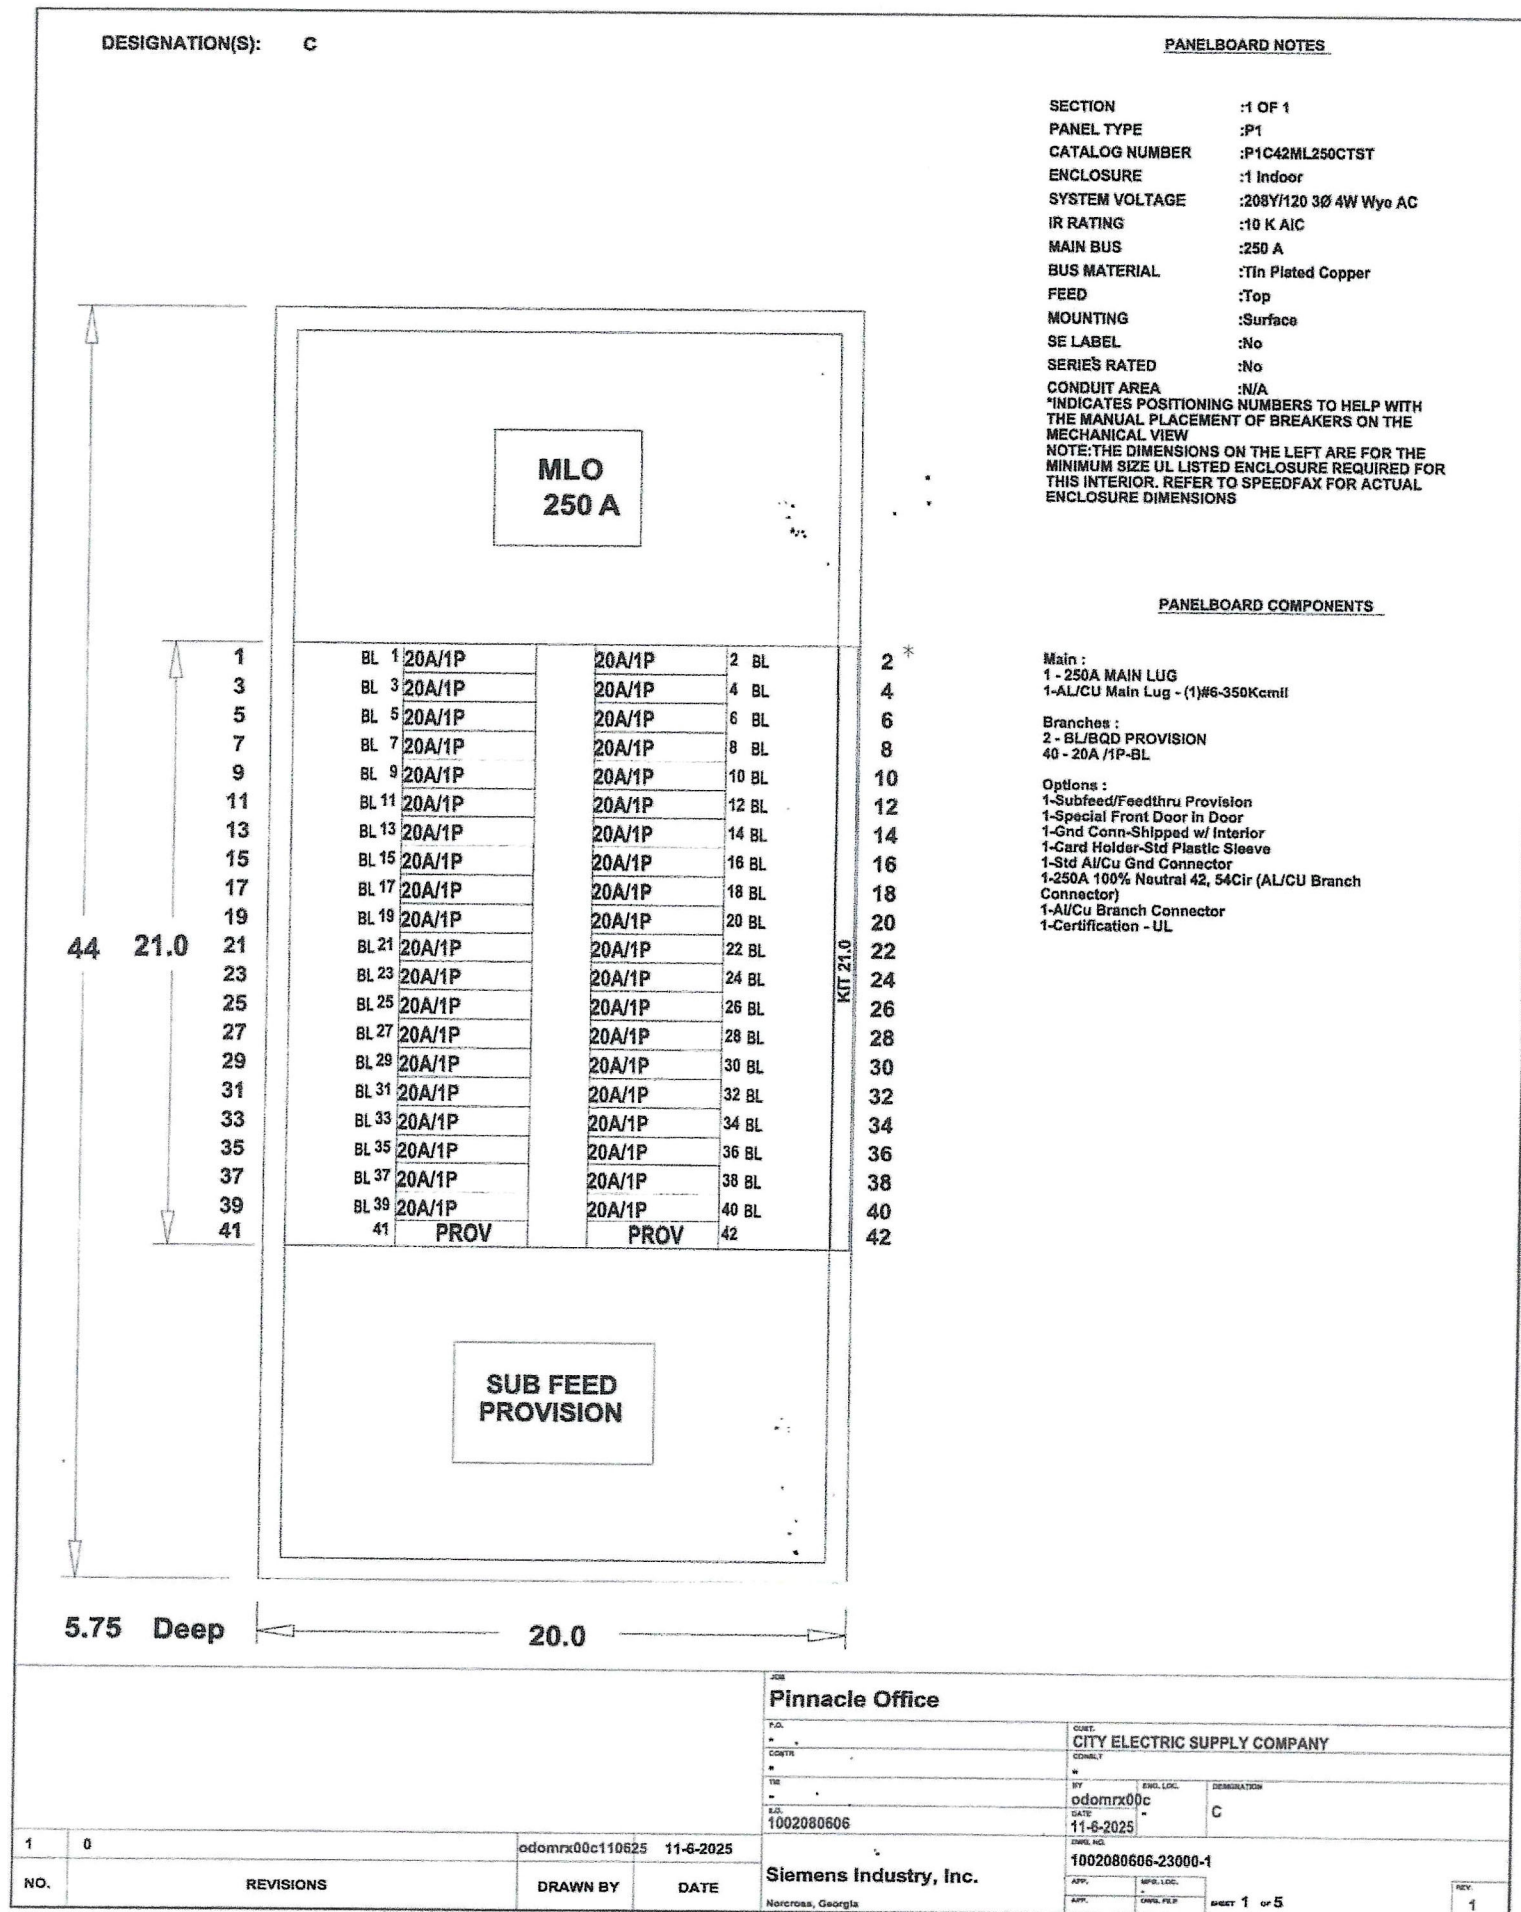

NAMEPLATE SCHEDULE

DESCRIPTION	NAMEPLATE UNIQUE NUMBER ID NO.	ENGRAVING 1	ENGRAVING 2	ENGRAVING 3	LEAVE BLANK
MASTER	N1		B		No


NAMEPLATE

MASTER SIZE 1x3
COLOR Black/White Core

DEVICE SIZE 1x3
COLOR Black/White Core

Pinnacle Site Solutions

Siemens Industry, Inc.

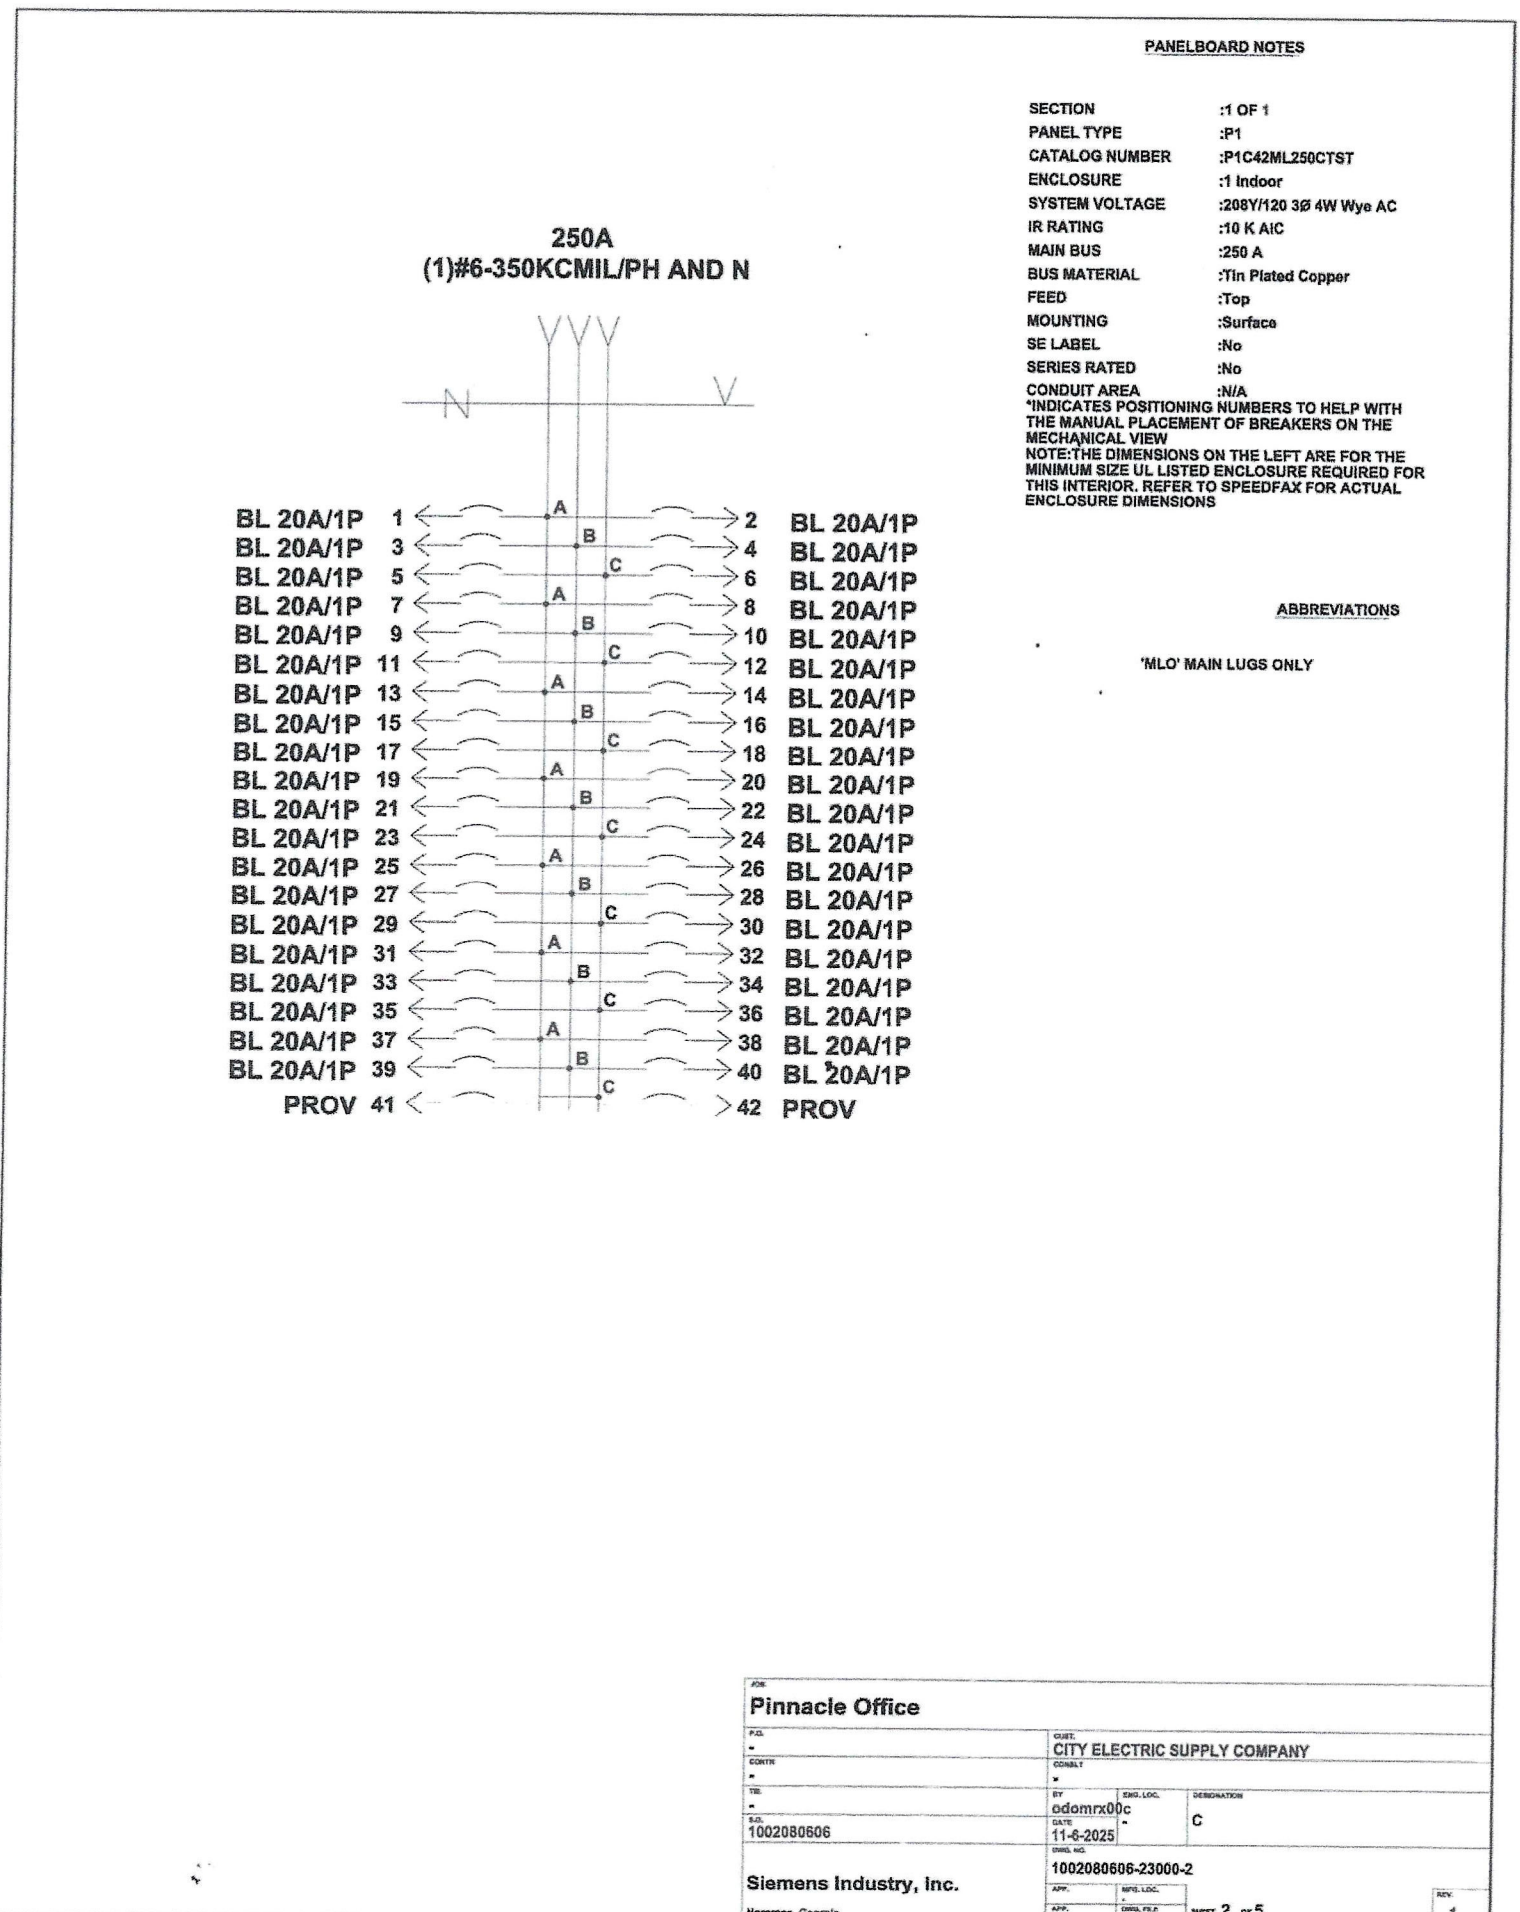

CIRCUIT SCHEDULE

CIRCUIT NUMBER	UNIQUE ID NO.	TRIP AMPS (A)	POLES	DEVICE TYPE	INTERRUPT RATING (AIC)	METER ACC	CT RATING	LOAD LUG SIZE PER PHASE	CIRCUIT IDENTIFICATION
1	8	20	1	BL	10,000	N/A	N/A	(1)154-#10 CU / #12-#10 AL	-
2	9	20	1	BL	10,000	N/A	N/A	(1)154-#10 CU / #12-#10 AL	-
3	10	20	1	BL	10,000	N/A	N/A	(1)154-#10 CU / #12-#10 AL	-
4	11	20	1	BL	10,000	N/A	N/A	(1)154-#10 CU / #12-#10 AL	-
5	12	20	1	BL	10,000	N/A	N/A	(1)154-#10 CU / #12-#10 AL	-
6	13	20	1	BL	10,000	N/A	N/A	(1)154-#10 CU / #12-#10 AL	-
7	14	20	1	BL	10,000	N/A	N/A	(1)154-#10 CU / #12-#10 AL	-
8	15	20	1	BL	10,000	N/A	N/A	(1)154-#10 CU / #12-#10 AL	-
9	16	20	1	BL	10,000	N/A	N/A	(1)154-#10 CU / #12-#10 AL	-
10	17	20	1	BL	10,000	N/A	N/A	(1)154-#10 CU / #12-#10 AL	-
11	18	20	1	BL	10,000	N/A	N/A	(1)154-#10 CU / #12-#10 AL	-
12	19	20	1	BL	10,000	N/A	N/A	(1)154-#10 CU / #12-#10 AL	-
13	20	20	1	BL	10,000	N/A	N/A	(1)154-#10 CU / #12-#10 AL	-
14	21	20	1	BL	10,000	N/A	N/A	(1)154-#10 CU / #12-#10 AL	-
15	22	20	1	BL	10,000	N/A	N/A	(1)154-#10 CU / #12-#10 AL	-
16	23	20	1	BL	10,000	N/A	N/A	(1)154-#10 CU / #12-#10 AL	-
17	24	20	1	BL	10,000	N/A	N/A	(1)154-#10 CU / #12-#10 AL	-
18	25	20	1	BL	10,000	N/A	N/A	(1)154-#10 CU / #12-#10 AL	-
19	26	20	1	BL	10,000	N/A	N/A	(1)154-#10 CU / #12-#10 AL	-
20	27	20	1	BL	10,000	N/A	N/A	(1)154-#10 CU / #12-#10 AL	-
21	28	20	1	BL	10,000	N/A	N/A	(1)154-#10 CU / #12-#10 AL	-
22	29	20	1	BL	10,000	N/A	N/A	(1)154-#10 CU / #12-#10 AL	-
23	30	20	1	BL	10,000	N/A	N/A	(1)154-#10 CU / #12-#10 AL	-
24	31	20	1	BL	10,000	N/A	N/A	(1)154-#10 CU / #12-#10 AL	-
25	32	20	1	BL	10,000	N/A	N/A	(1)154-#10 CU / #12-#10 AL	-
26	33	20	1	BL	10,000	N/A	N/A	(1)154-#10 CU / #12-#10 AL	-
27	34	20	1	BL	10,000	N/A	N/A	(1)154-#10 CU / #12-#10 AL	-
28	35	20	1	BL	10,000	N/A	N/A	(1)154-#10 CU / #12-#10 AL	-
29	36	20	1	BL	10,000	N/A	N/A	(1)154-#10 CU / #12-#10 AL	-
30	37	20	1	BL	10,000	N/A	N/A	(1)154-#10 CU / #12-#10 AL	-
31	38	20	1	BL	10,000	N/A	N/A	(1)154-#10 CU / #12-#10 AL	-
32	39	20	1	BL	10,000	N/A	N/A	(1)154-#10 CU / #12-#10 AL	-
33	40	20	1	BL	10,000	N/A	N/A	(1)154-#10 CU / #12-#10 AL	-
34	41	20	1	BL	10,000	N/A	N/A	(1)154-#10 CU / #12-#10 AL	-
35	42	20	1	BL	10,000	N/A	N/A	(1)154-#10 CU / #12-#10 AL	-
36	43	20	1	BL	10,000	N/A	N/A	(1)154-#10 CU / #12-#10 AL	-
37	44	20	1	BL	10,000	N/A	N/A	(1)154-#10 CU / #12-#10 AL	-
38	45	20	1	BL	10,000	N/A	N/A	(1)154-#10 CU / #12-#10 AL	-
39	46	20	1	BL	10,000	N/A	N/A	(1)154-#10 CU / #12-#10 AL	-
40	47	20	1	BL	10,000	N/A	N/A	(1)154-#10 CU / #12-#10 AL	-
41	48	-	1	B-PROV	-	-	-	-	-
42	49	-	1	B-PROV	-	-	-	-	-

Pinnacle Office

Siemens Industry, Inc.

1 0 REVISIONS

NAMEPLATE SCHEDULE

DESCRIPTION	NAMEPLATE UNIQUE NUMBER ID NO.	ENGRAVING 1	ENGRAVING 2	ENGRAVING 3	LEAVE BLANK
MASTER	N1		C		No



NAMEPLATE

MASTER SIZE 1x3
COLOR Black/White Core

DEVICE SIZE 1x3
COLOR Black/White Core

Pinnacle Site Solutions

Siemens Industry, Inc.

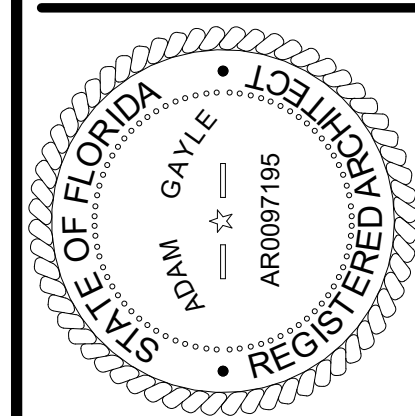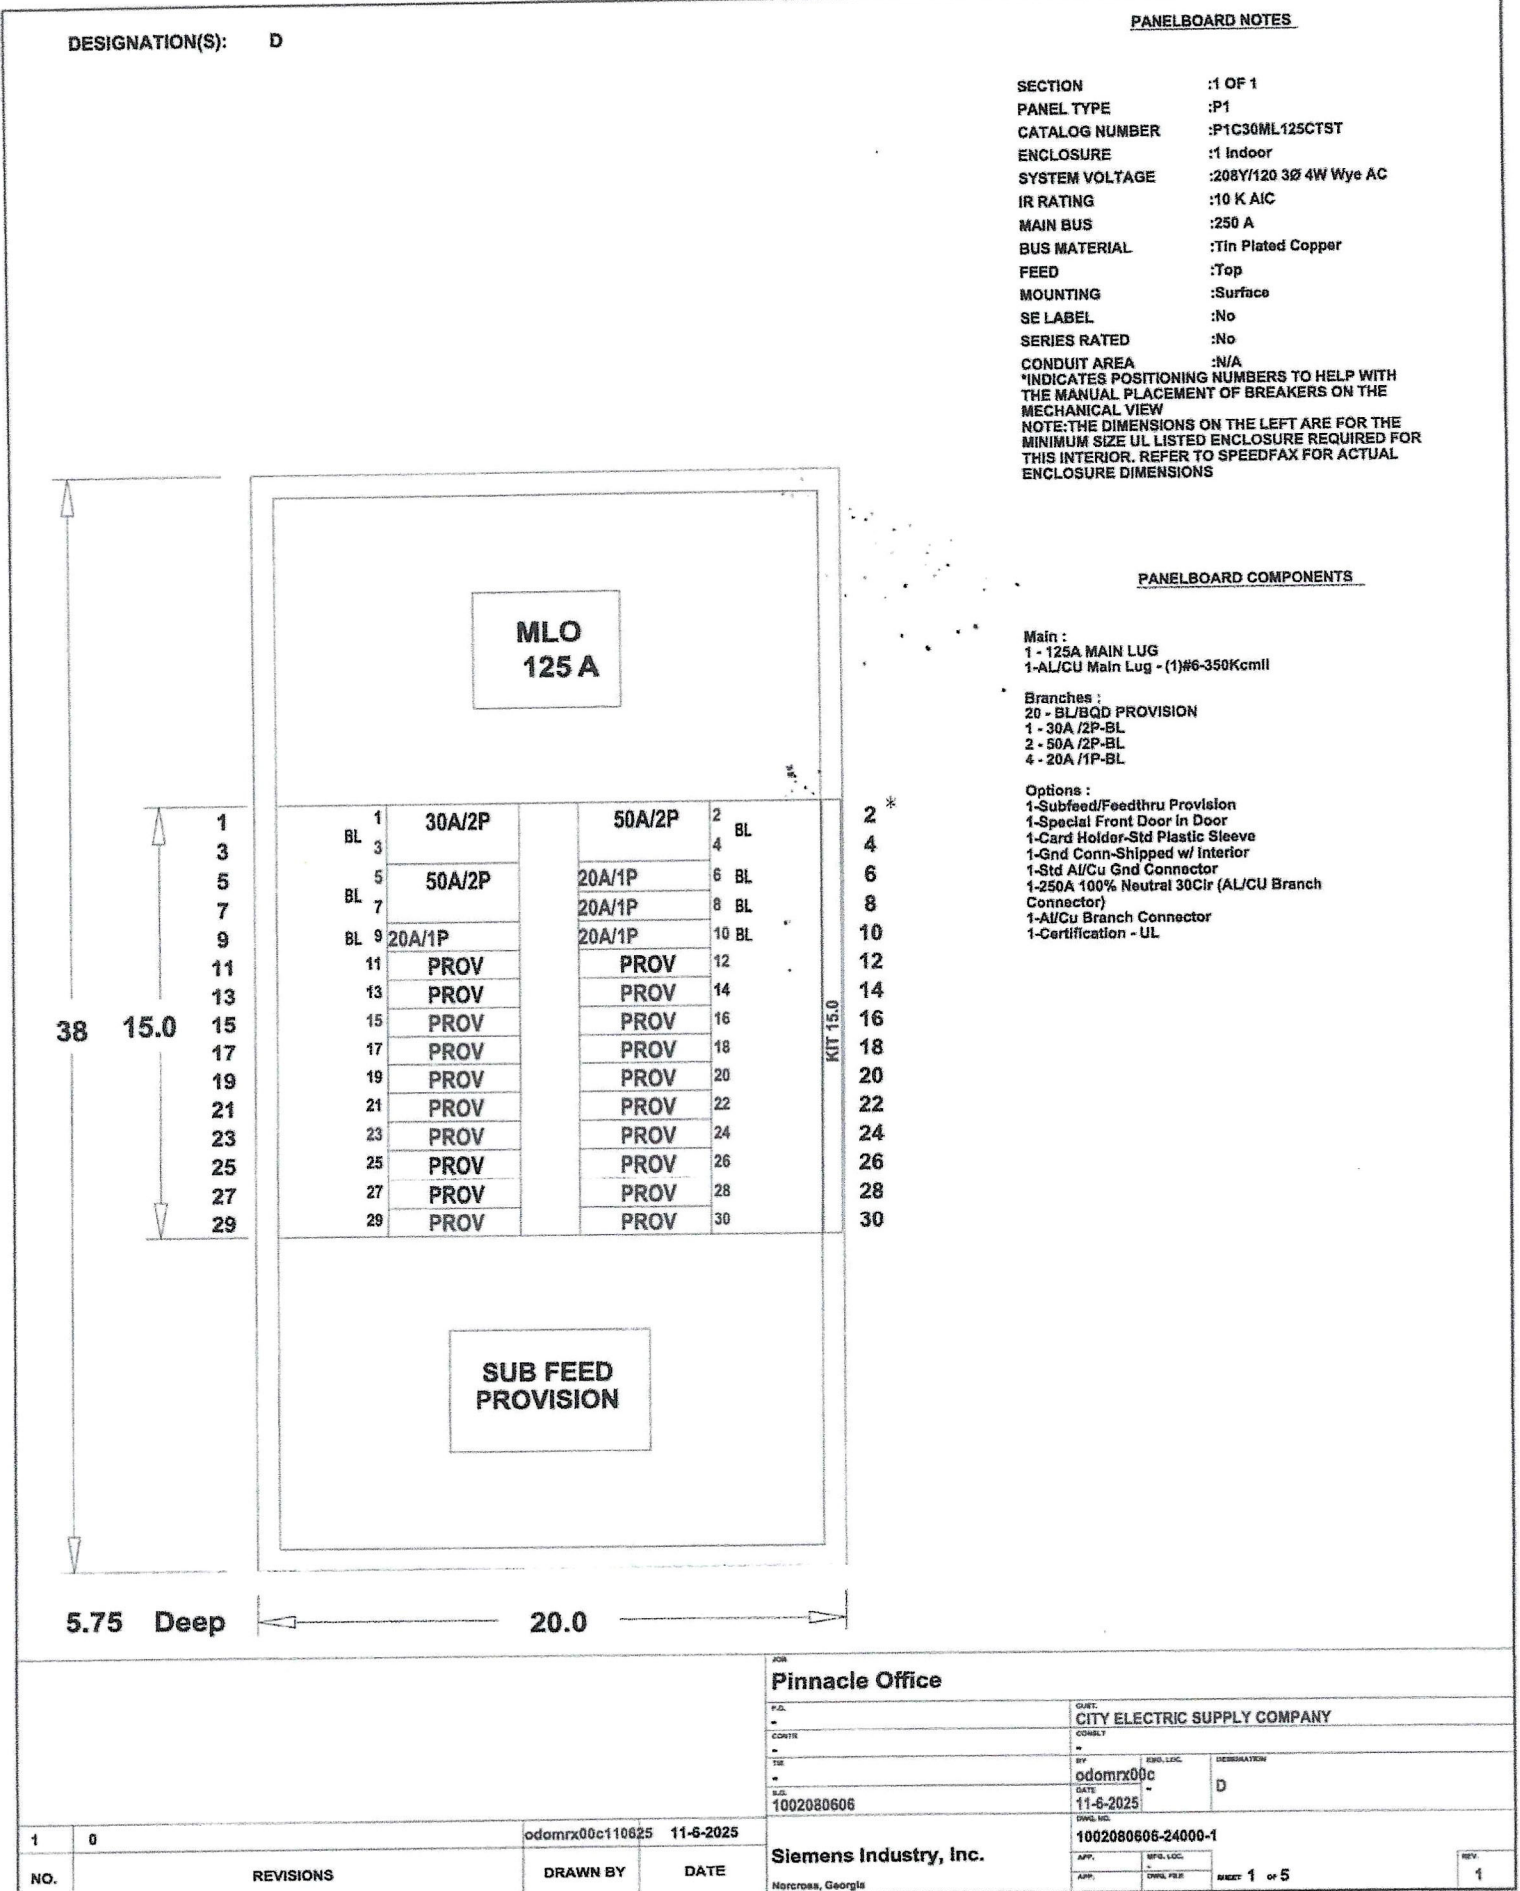

12/05/2025

TO THE BEST OF THE ARCHITECTS OR THE ARCHITECTS OF THE SPECIFICATIONS, THE ARCHITECTS AND ENGINEERS HAVE CONDUCTED A VISUAL GENERAL REVIEW OF THE DRAWINGS FOR CONFORMANCE WITH THE MINIMUM BUILDING CODES AND STANDARDS. THE ARCHITECTS AND ENGINEERS DO NOT WARRANT THE ACCURACY OF THE INFORMATION PROVIDED HEREIN. THE ARCHITECTS AND ENGINEERS SHALL NOT BE RESPONSIBLE FOR ANY ERRORS OR OMISSIONS IN THE DRAWINGS OR FOR ANY CONSEQUENCES ARISING THEREFROM.



PINNACLE OFFICE

19816 US-441
HIGH SPRINGS, FL 32643

REVISIONS

NO.	DATE	REF.	BY
-----	------	------	----

DRAWING STATUS:
100% CONSTRUCTION DOCUMENTS

ISSUE DATE:
12.05.2025

DRAWN BY: ARG
CHECKED BY: ARG

PROJECT NUMBER:
24030

DRAWING TITLE:
LEVEL 1 ELECTRICAL PLAN - SCHEDULES

SHEET NO.


E1.04

DATE/TIME STAMP:
12/5/2025 2:18:08 PM

NAMEPLATE SCHEDULE						
DESCRIPTION	NAMEPLATE/UNIQUE NUMBER ID NO.		ENGRAVING 1	ENGRAVING 2	ENGRAVING 3	LEAVE BLANK
MASTER	N1			D		No

NAMEPLATE			26 Pinnacle Site Solutions		
MASTER	SIZE	1x3	24	26 CITY ELECTRIC SUPPLY COMPANY	
	COLOR	Black/White Core	24	26 CITY	
	SIZE	1x3	1001899531	26 4-18-2025	
DEVICE	COLOR	Black/White Core	1001899531-24000-4 Siemens Industry, Inc.		
			26 4-18-2025		

Superlative
8129 SW 75TH STREET
GAINESVILLE, FLORIDA 32608
352-256-6785
www.superlative.design

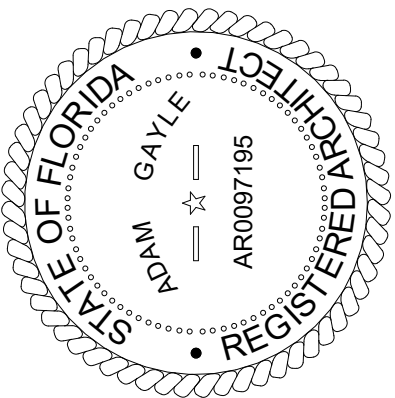

12/05/2025

TO THE BEST OF THE ARCHITECT'S OR THE ENGINEER'S KNOWLEDGE, THE PLANS AND SPECIFICATIONS COMPLY WITH THE APPLICABLE MINIMUM BUILDING CODES AND THE APPLICABLE FIRE SAFETY STANDARDS AS DETERMINED BY THE LOCAL AUTHORITY IN ACCORDANCE WITH THE SECTION AND CHAPTER 633, FL. STATUTES.



PINNACLE OFFICE

19816 US-441
HIGH SPRINGS, FL 32643

REVISIONS			
NO:	DATE:	REF:	BY:

DRAWING STATUS:
100% CONSTRUCTION
DOCUMENTS

ISSUE DATE
12.05.2025

<u>DRAWN BY:</u>	<u>CHECKED BY:</u>
ABC	ABC

PROJECT NUMBER
24030

DRAWING TITLE:
LEVEL 1 ELECTRICAL PLAN
SCHEDULES

SHEET NO.

E1.05

DATE/TIME STAMP:

12/5/2025 2:18:13 PM