



864 SQ. FT. HEATED
1 BR 1 Bath with Den

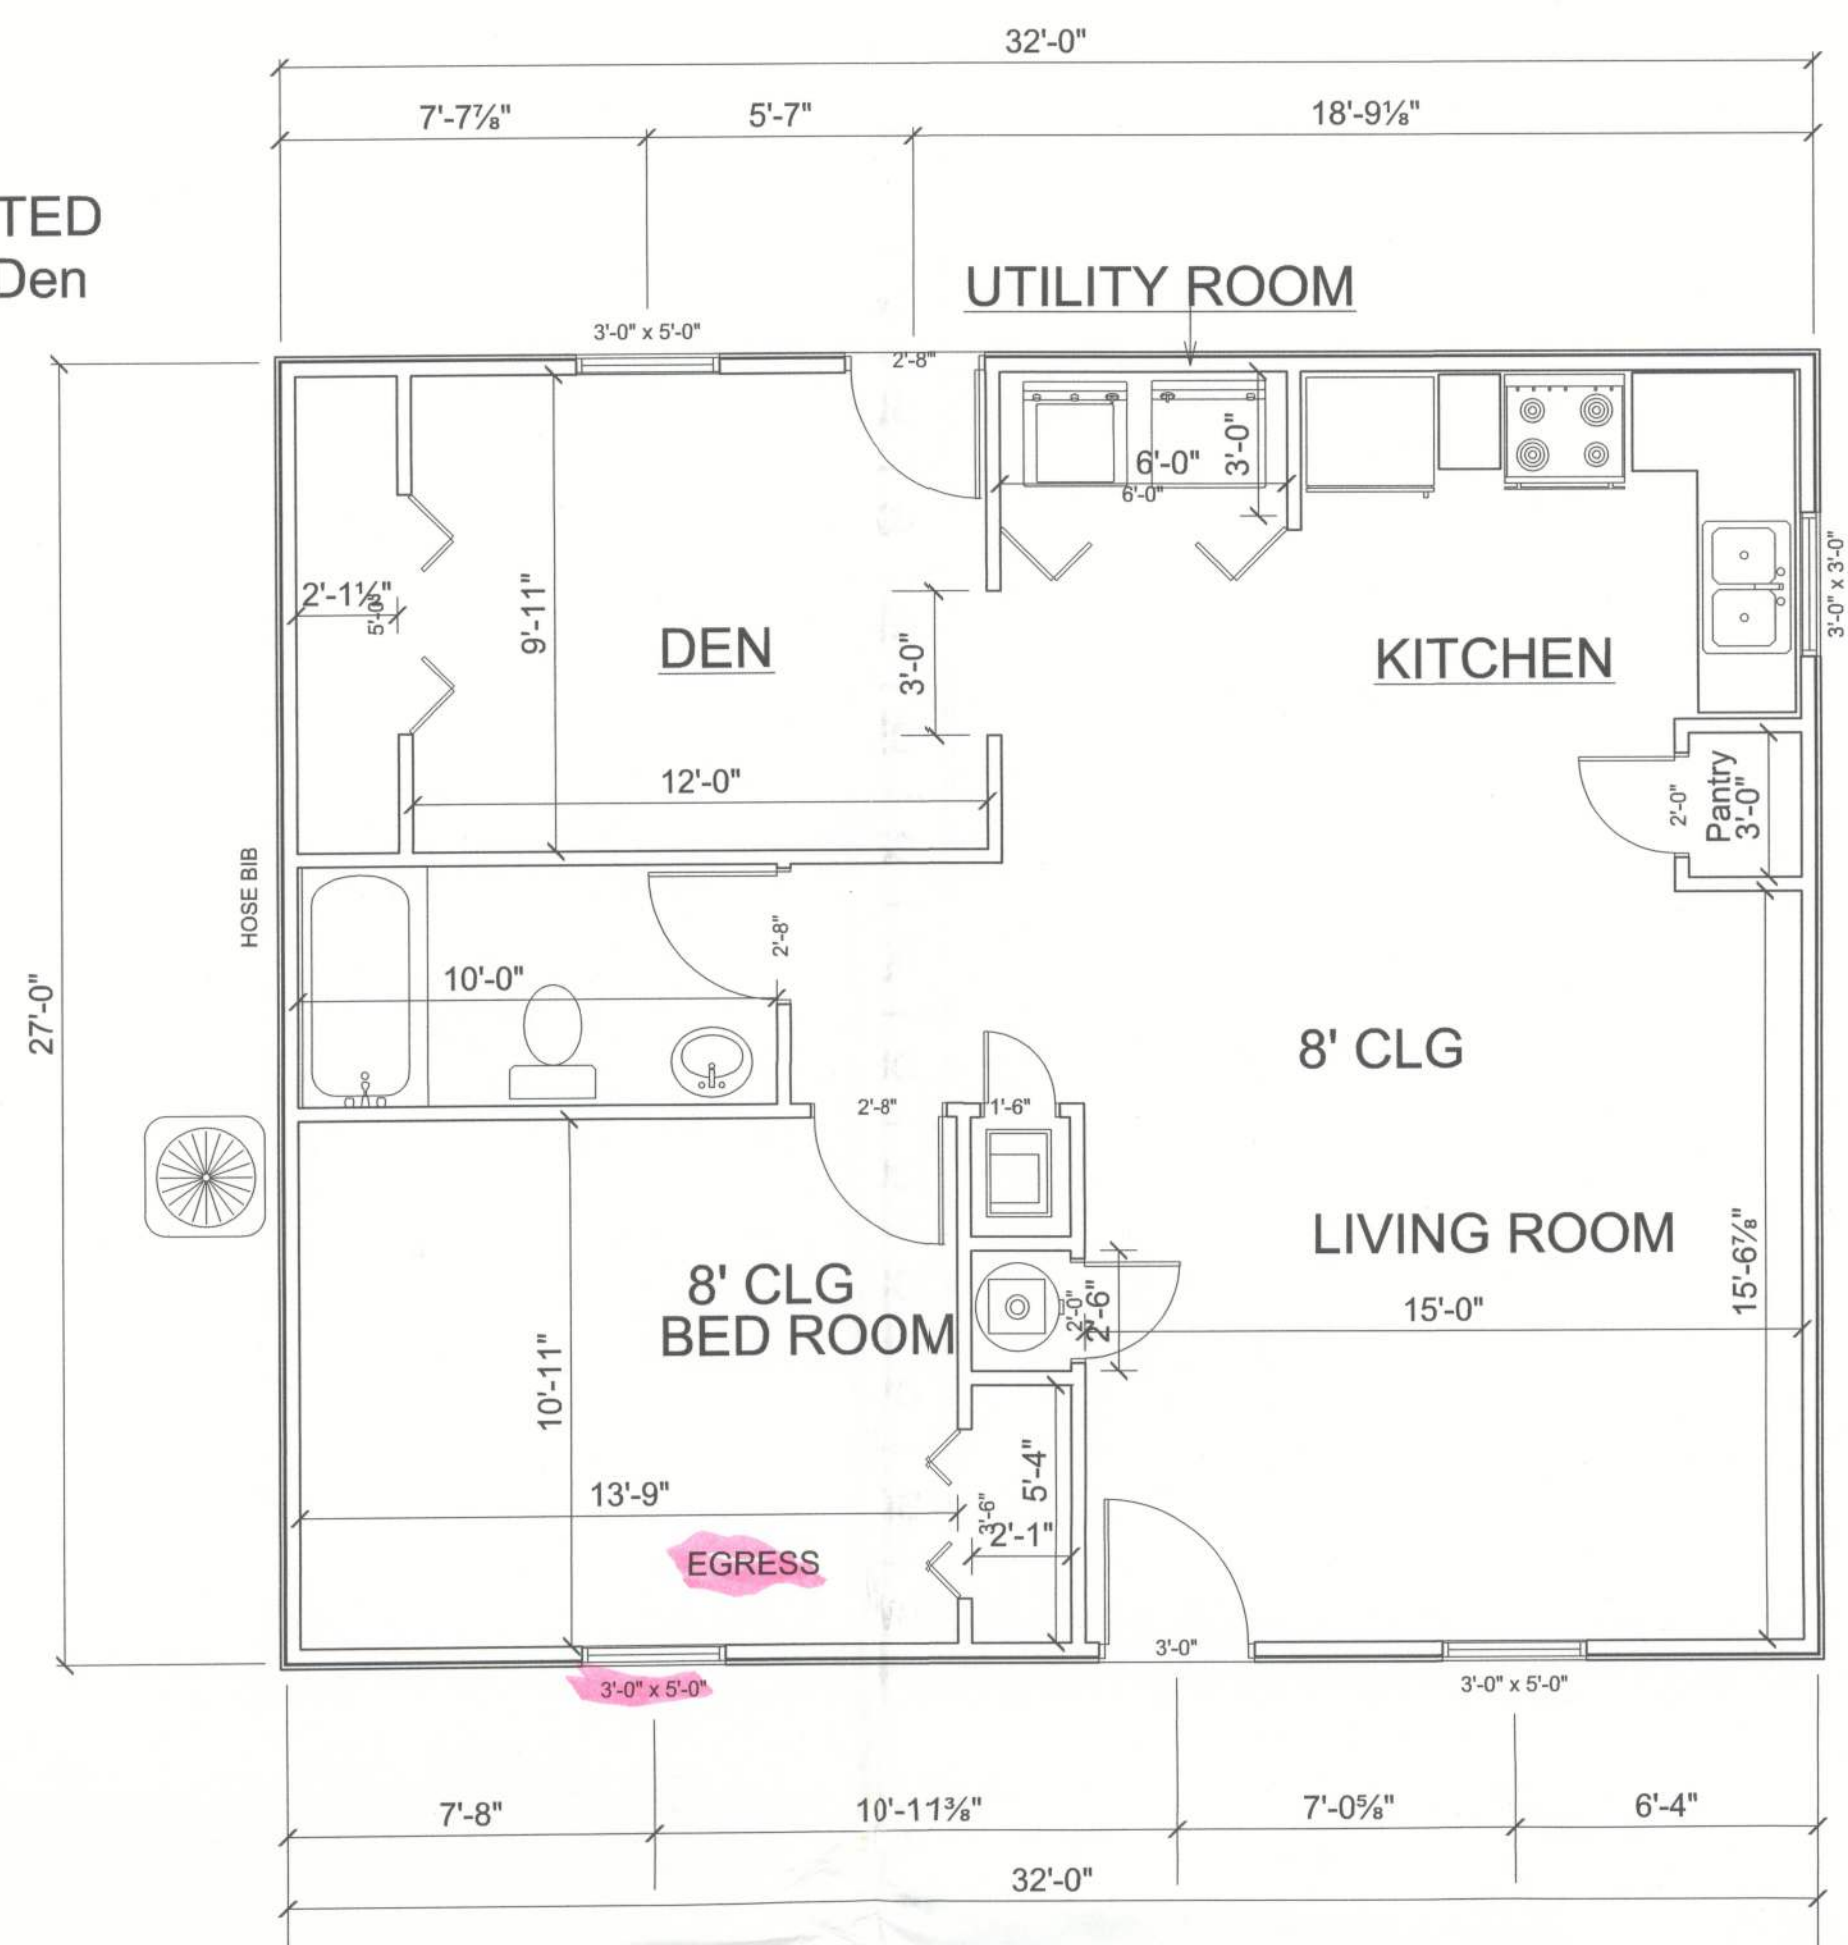


FLOOR PLAN

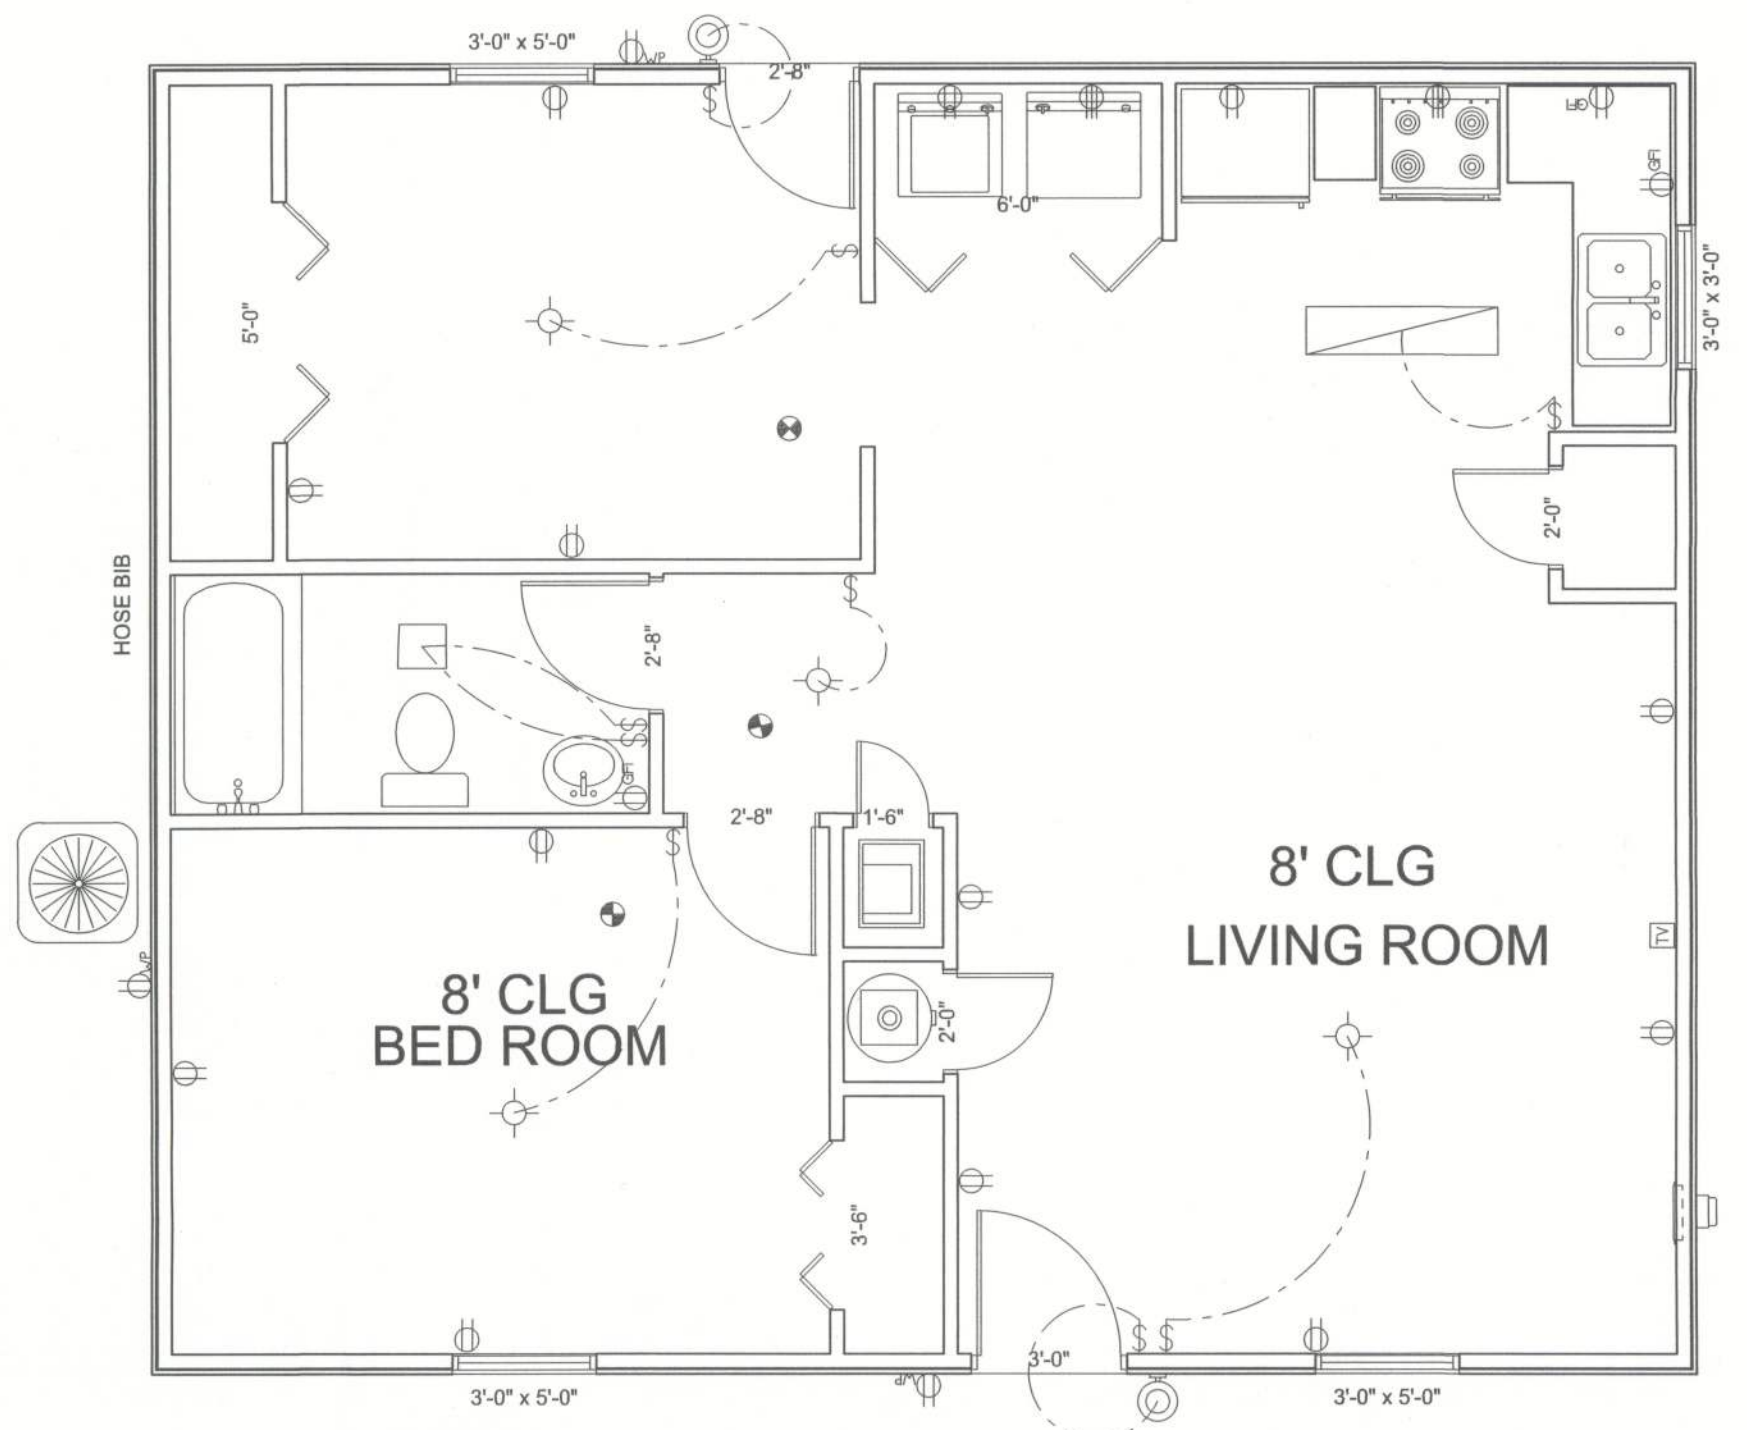

ELECTRICAL	SYMBOL
ceiling light vent square	
fluorescent light 1 x 4	
exterior light 5	
electrical meter	
electrical panel	
cable tv outlet	
light	
outlet	
outlet 220v	
outlet gfi	
outlet wp	
smoke detector	
switch	

864 SQ. FT. HEATED
1 BR 1 Bath with Den

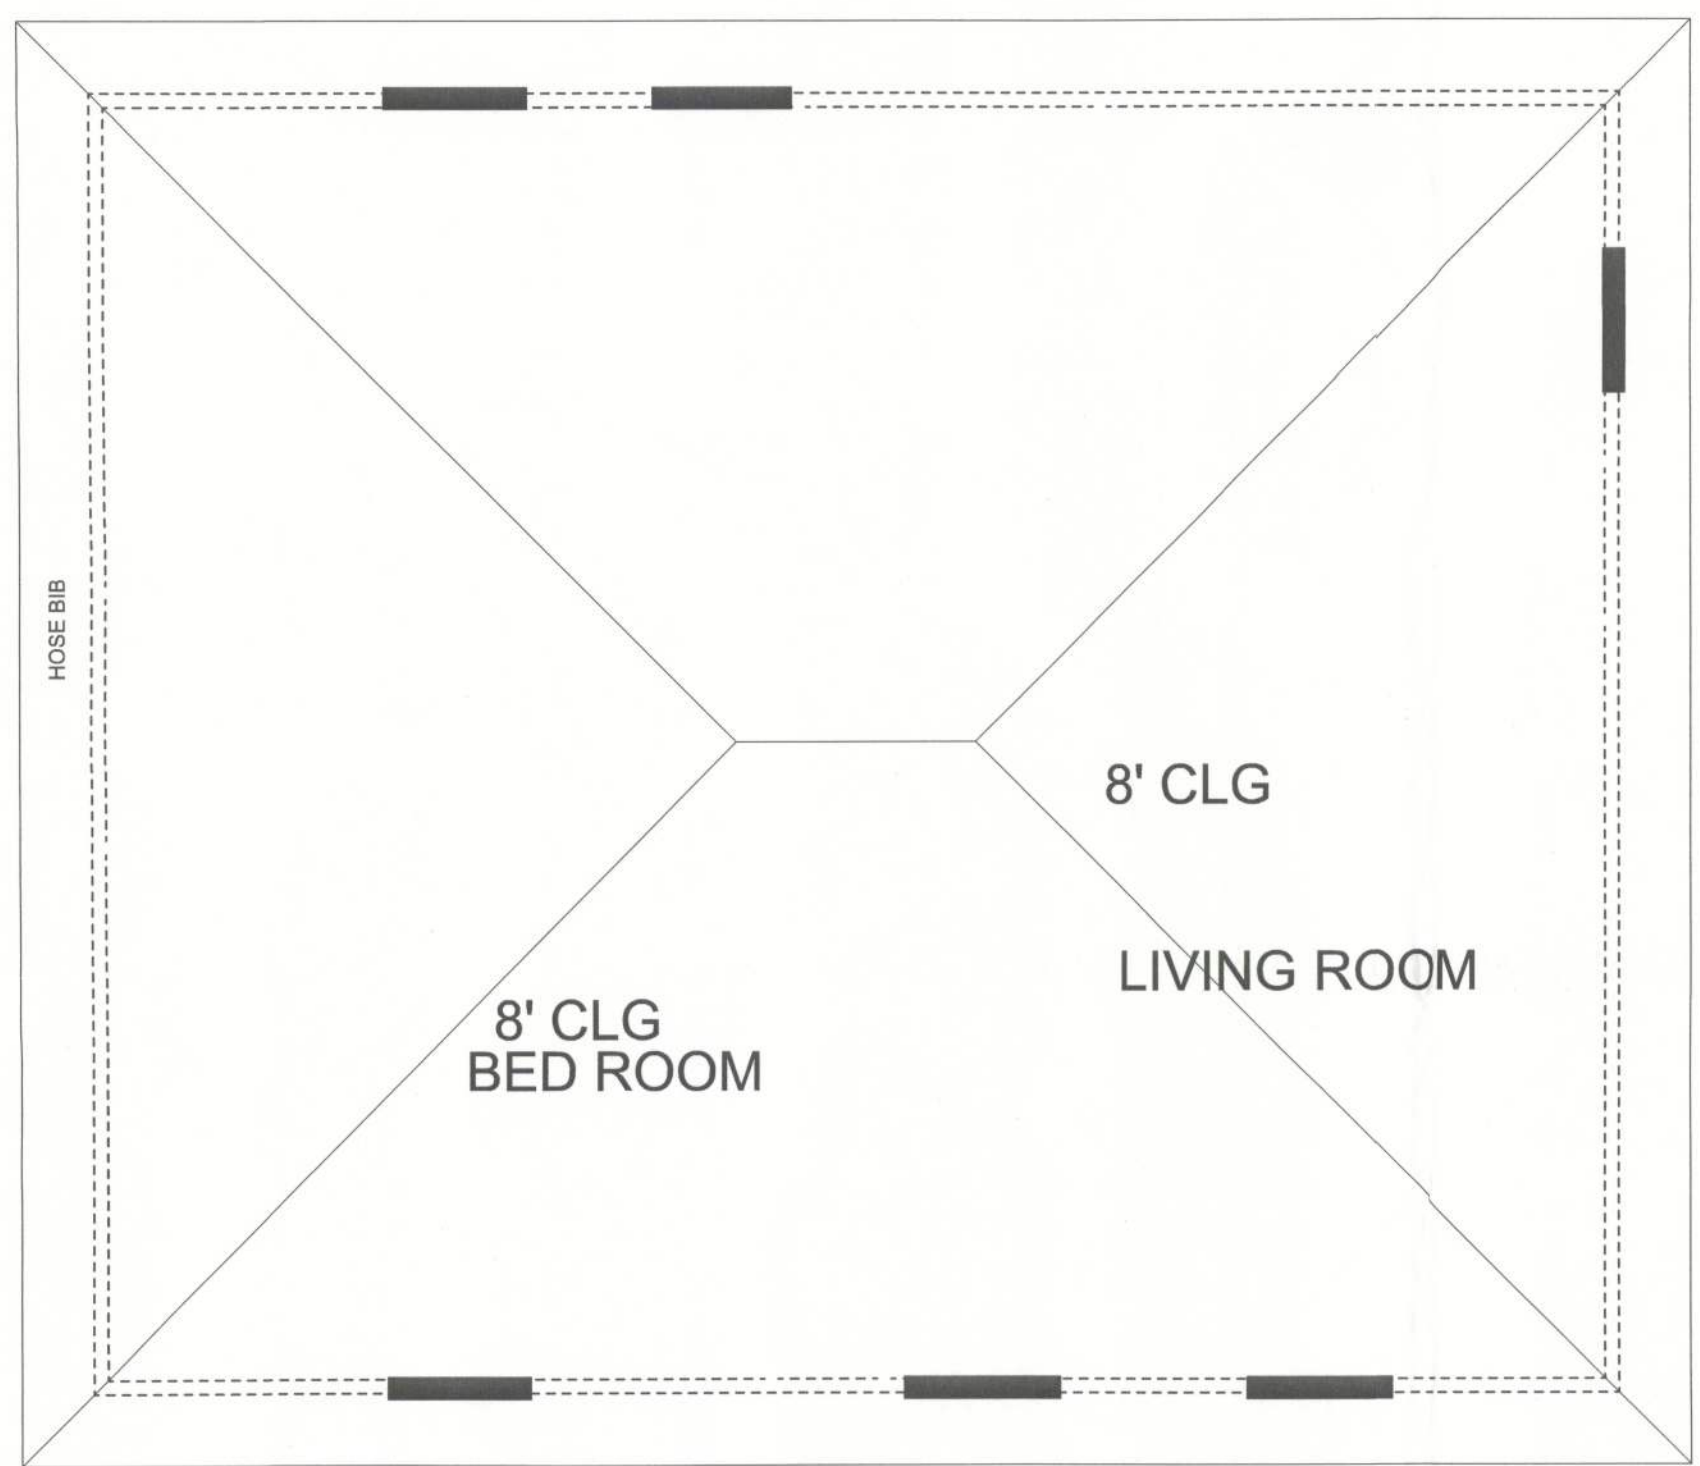

FLOOR PLAN

REVISIONS	

SOFTPLAN
ARCHITECTURAL DESIGN SOFTWARE



HOME TOWN HOMES	
MURPHY RES.	
ADDRESS: COLUMBIA COUNTY	
PRINTED DATE: February 01, 2012	
DRAWN BY: JPB	CHECKED BY:
DESIGNED BY: HOMETOWN HOMES	
FINALS DATE:	
JOB NUMBER:	
DRAWING NUMBER A1	
1 OF 3 SHEETS	

29967