



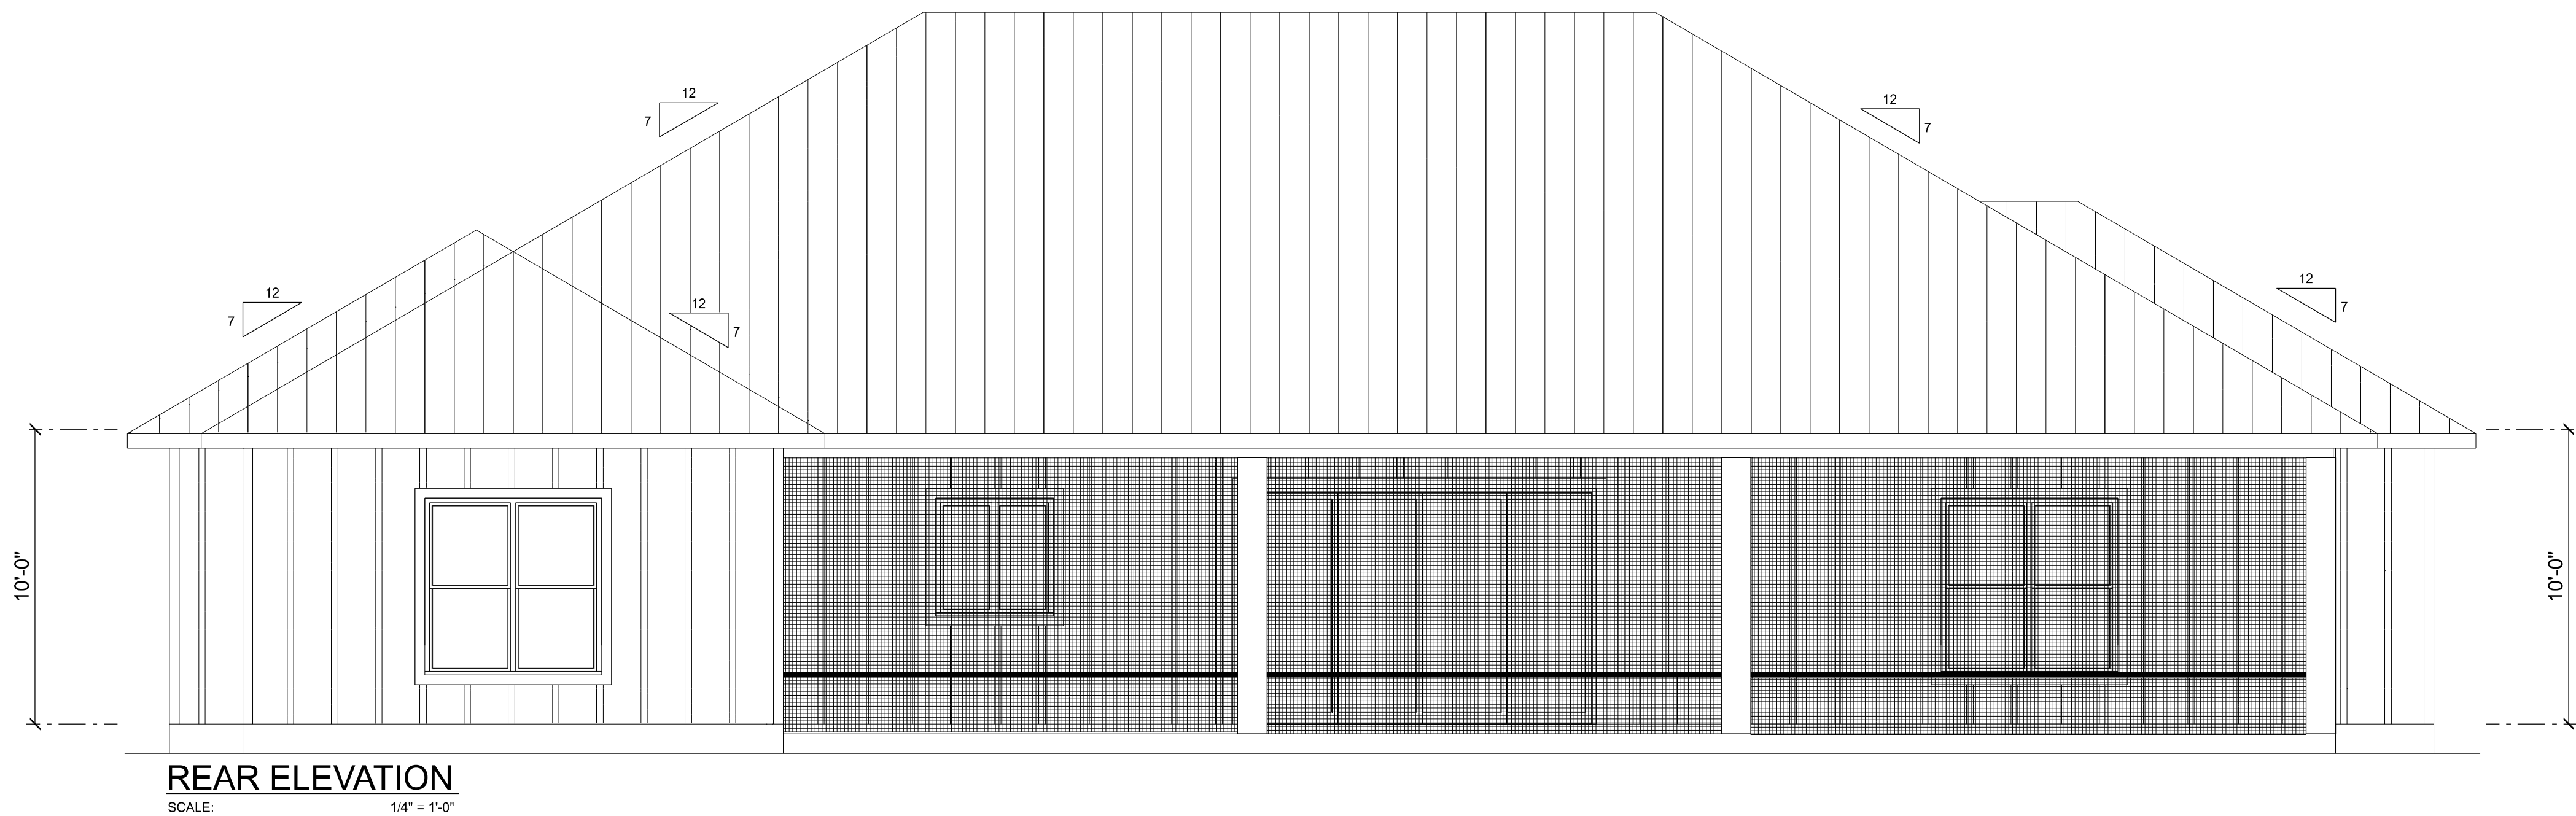


REVISIONS SCHEDULE		
March 17th, 2021	Proposal Drawing	
May, 12th, 2021	Revisions	

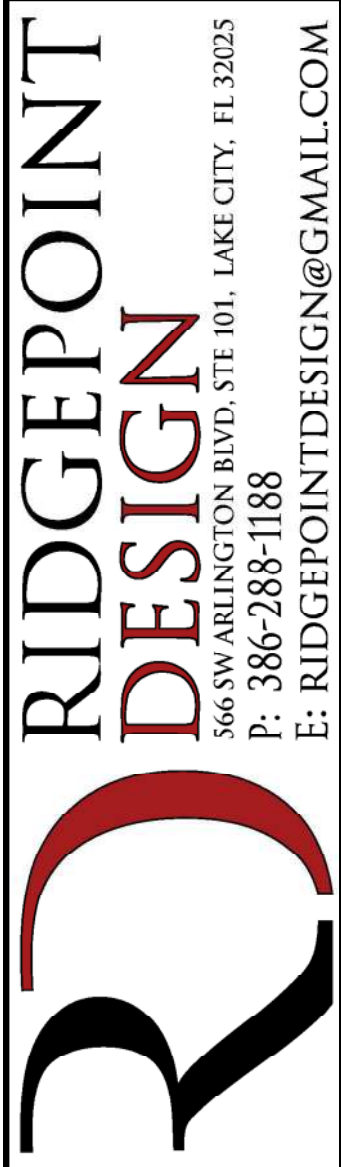


CUSTOM HOME FOR:
GOMEZ / CARTLET RES.
LOT 77, THE OAKS S/D, COLUMBIA COUNTY, FLORIDA



SHEET NUMBER
A.1
OF 4 SHEETS

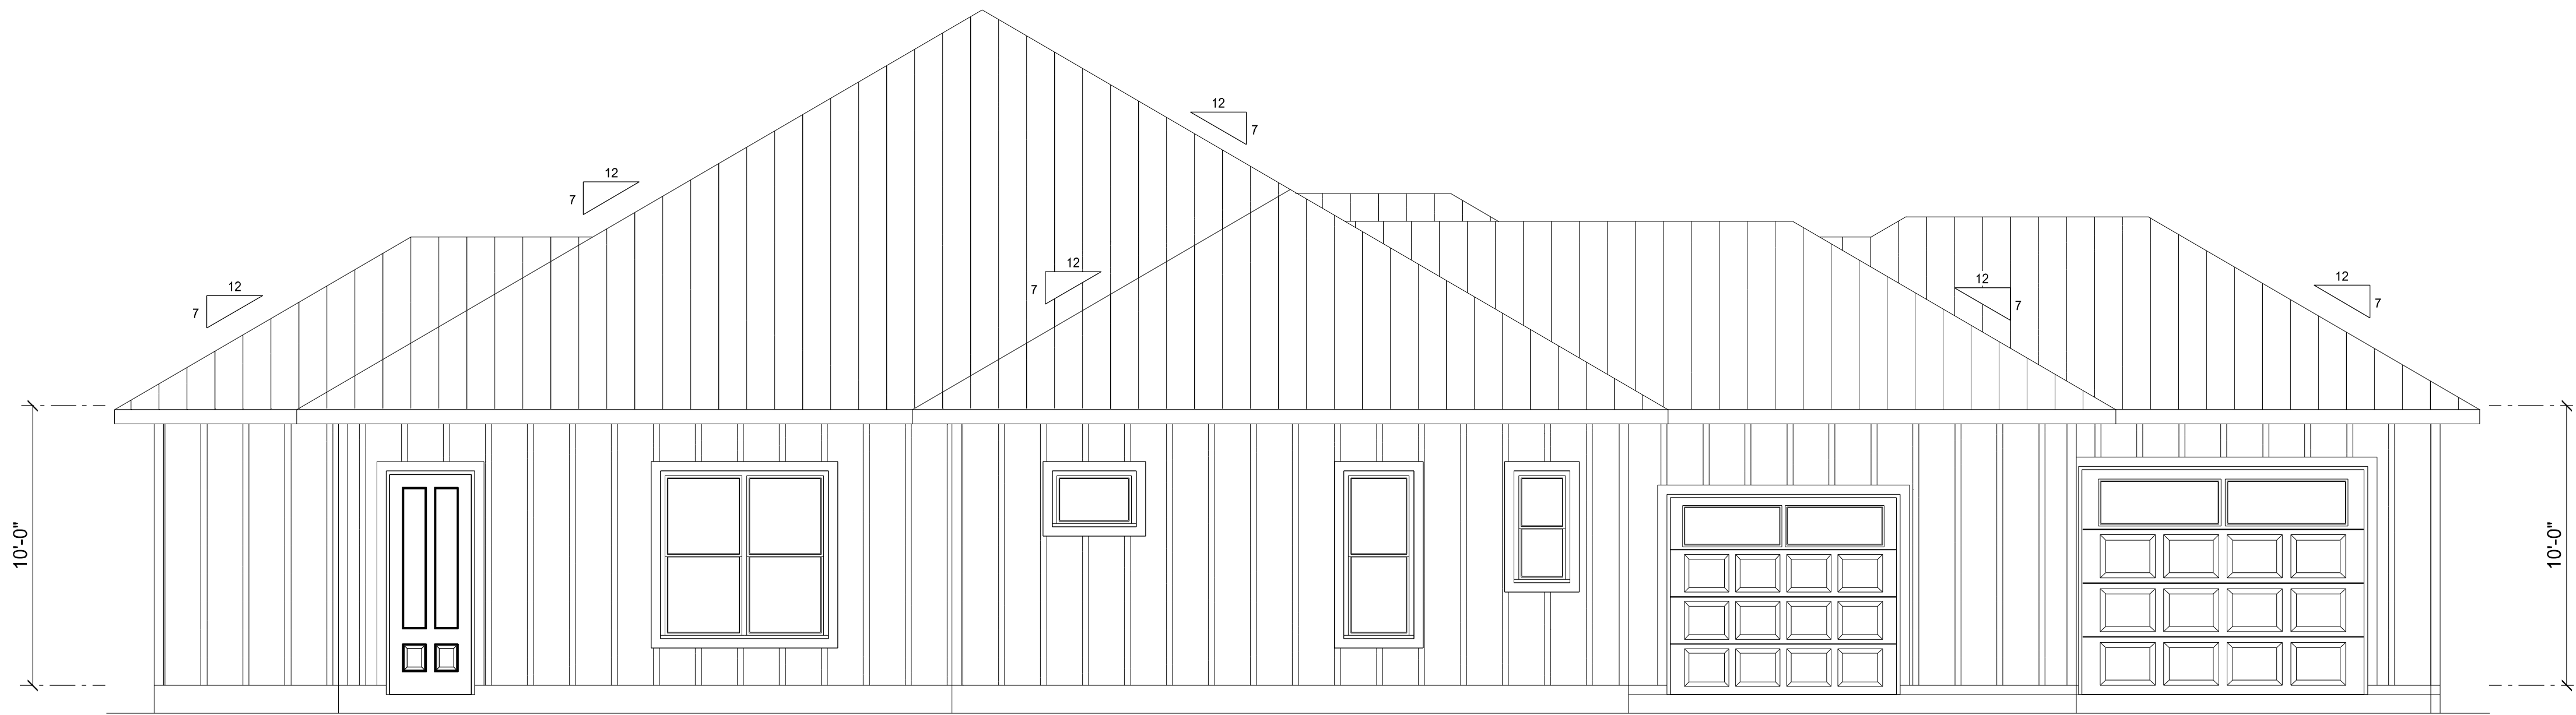

LEFT ELEVATION
SCALE: 1/4" = 1'-0"

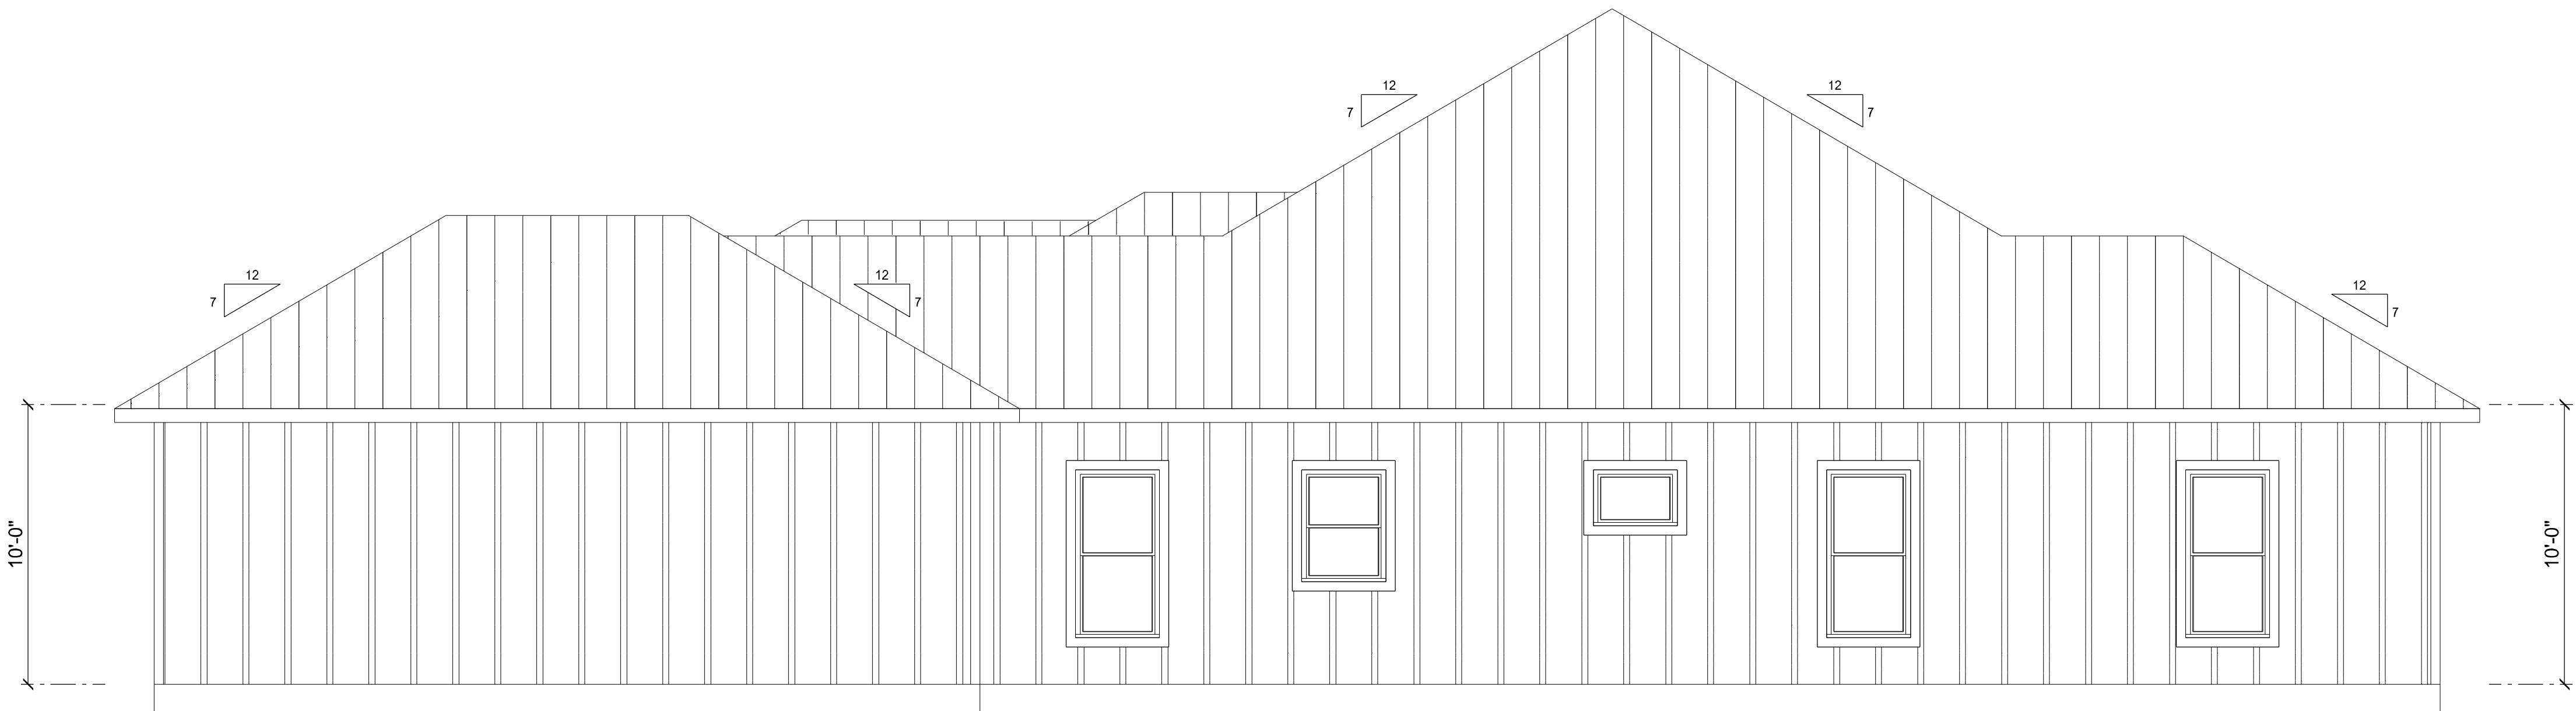

RIGHT ELEVATION
SCALE: 1/4" = 1'-0"

REVISIONS SCHEDULE		
March 17th, 2021	Proposal Drawing	
May, 12th, 2021	Revisions	




CUSTOM HOME FOR:
GOMEZ / CARTLET RES.
LOT 77, THE OAKS S/D, COLUMBIA COUNTY, FLORIDA



SHEET NUMBER
A.2
OF 4 SHEETS



DIMENSIONED FLOOR PLAN

SCALE: 1/4" = 1'-0"

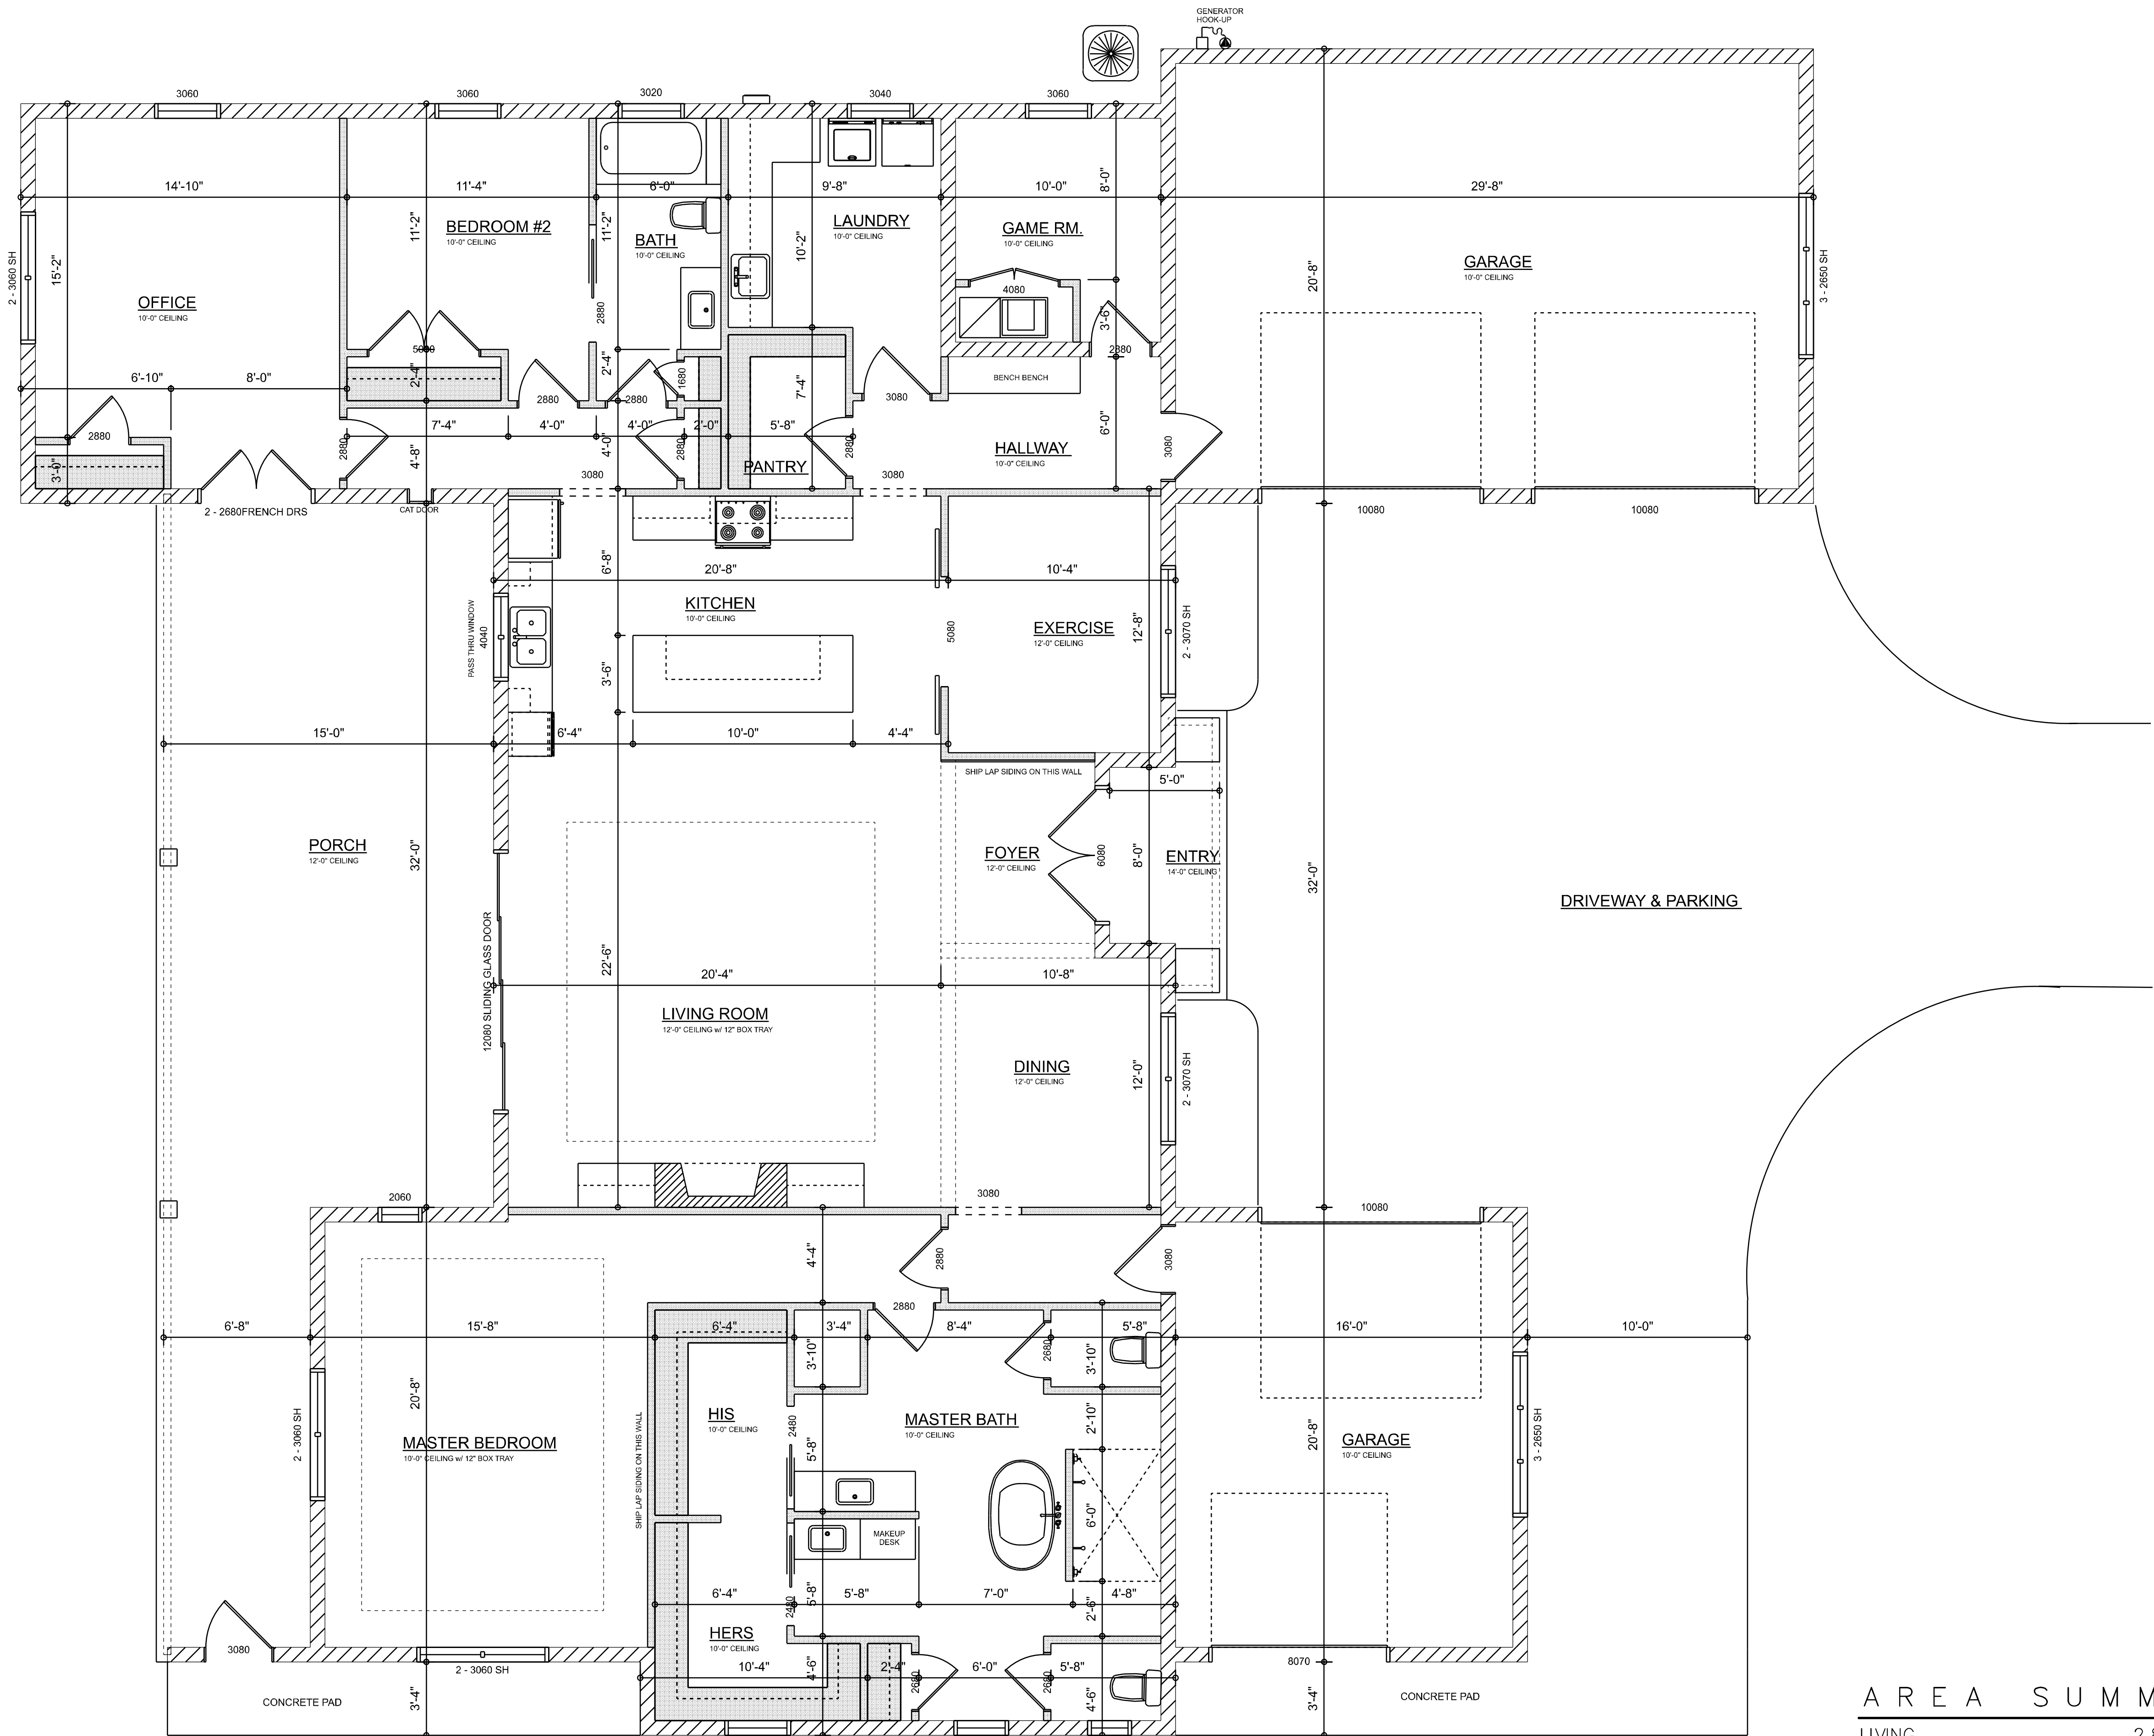

AREA SUMMARY

LIVING	2,815	S.F.
GARAGE	931	S.F.
REAR PORCH	618	S.F.
ENTRY PORCH	41	S.F.
TOTAL AREA	4,405	S.F.

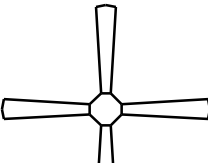 ELECTRICAL LEGEND		
ELECTRICAL	COUNT	SYMBOL
CEILING FAN	7	
CAN LIGHT 6inch	28	
CHANDELIER	2	
LED CEILING LIGHT 1x4	4	
PENDANT LIGHT	3	
EXTERIOR SCONCE	7	
MOTION SECURITY LIGHT	4	
AC DISCONNECT	2	
CABLE TV OUTLET	5	
CARBON DETECTOR	2	
EXHAUST FAN	3	
OUTLET	48	
OUTLET 220v	2	
OUTLET GFI	18	
OUTLET WP	7	
SMOKE DETECTOR	7	
STANDARD LIGHT	8	
SWITCH	37	
SWITCH 3 WAY	22	
floor receptacle 1G duplex	2	
VANITY BAR LIGHT - SMALL	3	

ELECTRICAL PLAN NOTES:

INSTALLATION SHALL BE PER LATEST NAT'L ELECTRIC CODE.

WIRE ALL APPLIANCES, HVAC UNITS AND OTHER EQUIPMENT PER MANUF. SPECIFICATIONS

CONSULT WITH THE OWNER FOR THE NUMBER OF SEPERATE TELEPHONE LINES TO BE INSTALLED

ALL SMOKE DETECTORS SHALL BE 120v W/ BATTERY BACKUP OF THE PHOTOELECTRIC TYPE, AND SHALL BE INTERLOCKED TOGETHER. INSTALL INSIDE AND NEAR ALL BEDROOMS


TELEPHONE, TELEVISION AND OTHER LOW VOLTAGE DEVICES OR OUTLETS SHALL BE AS PER THE OWNER'S DIRECTIONS, & IN ACCORDANCE W/ APPLICABLE SECTIONS OF NEC-LATEST EDITION.

ALL RECEPTICALS, NOT OTHERWISE NOTED, SHALL BE ARC FAULT INTERRUPTER TYPE, EXCEPT DEDICATED OUTLETS

ALL RECEPTICALS IN WET AREAS SHALL BE GROUND FAULT INTERRUPTER TYPE (GFI)

ALL EXTERIOR RECEPTICALS SHALL BE WEATHERPROOF GROUD FAULT INTERRUPTER TYPE (WP/GFI)

NOTE:
ELECTRICAL CONTR SHALL PREPARE "AS-BUILT" SHOP DWGS INDICATING ALL ELECTRICAL WORK, INCLUDING ANY CHANGES TO THE ELEC. PLAN, ADDNS TO THE ELEC. PLAN, RISER DIAGRAM, AS-BUILT PANEL SCHEDULE W/ ALL CKTS IDENTIFIED W/ CKT N°. DESCRIPTION & BRKR. SERVICE ENT. & ALL UNDERGROUND WIRE LOCATIONS/ROUTING / DEPTH. RISER DIA. SHALL INCLUDE WIRE SIZES/TYPE & EQUIPMENT TYPE W/ RATINGS & LOADS.
CONTRACTOR SHALL PROVIDE 1 COPY OF AS-BUILT DWGS TO OWNER & 1 COPY TO THE PERMIT ISSUING AUTHORITY

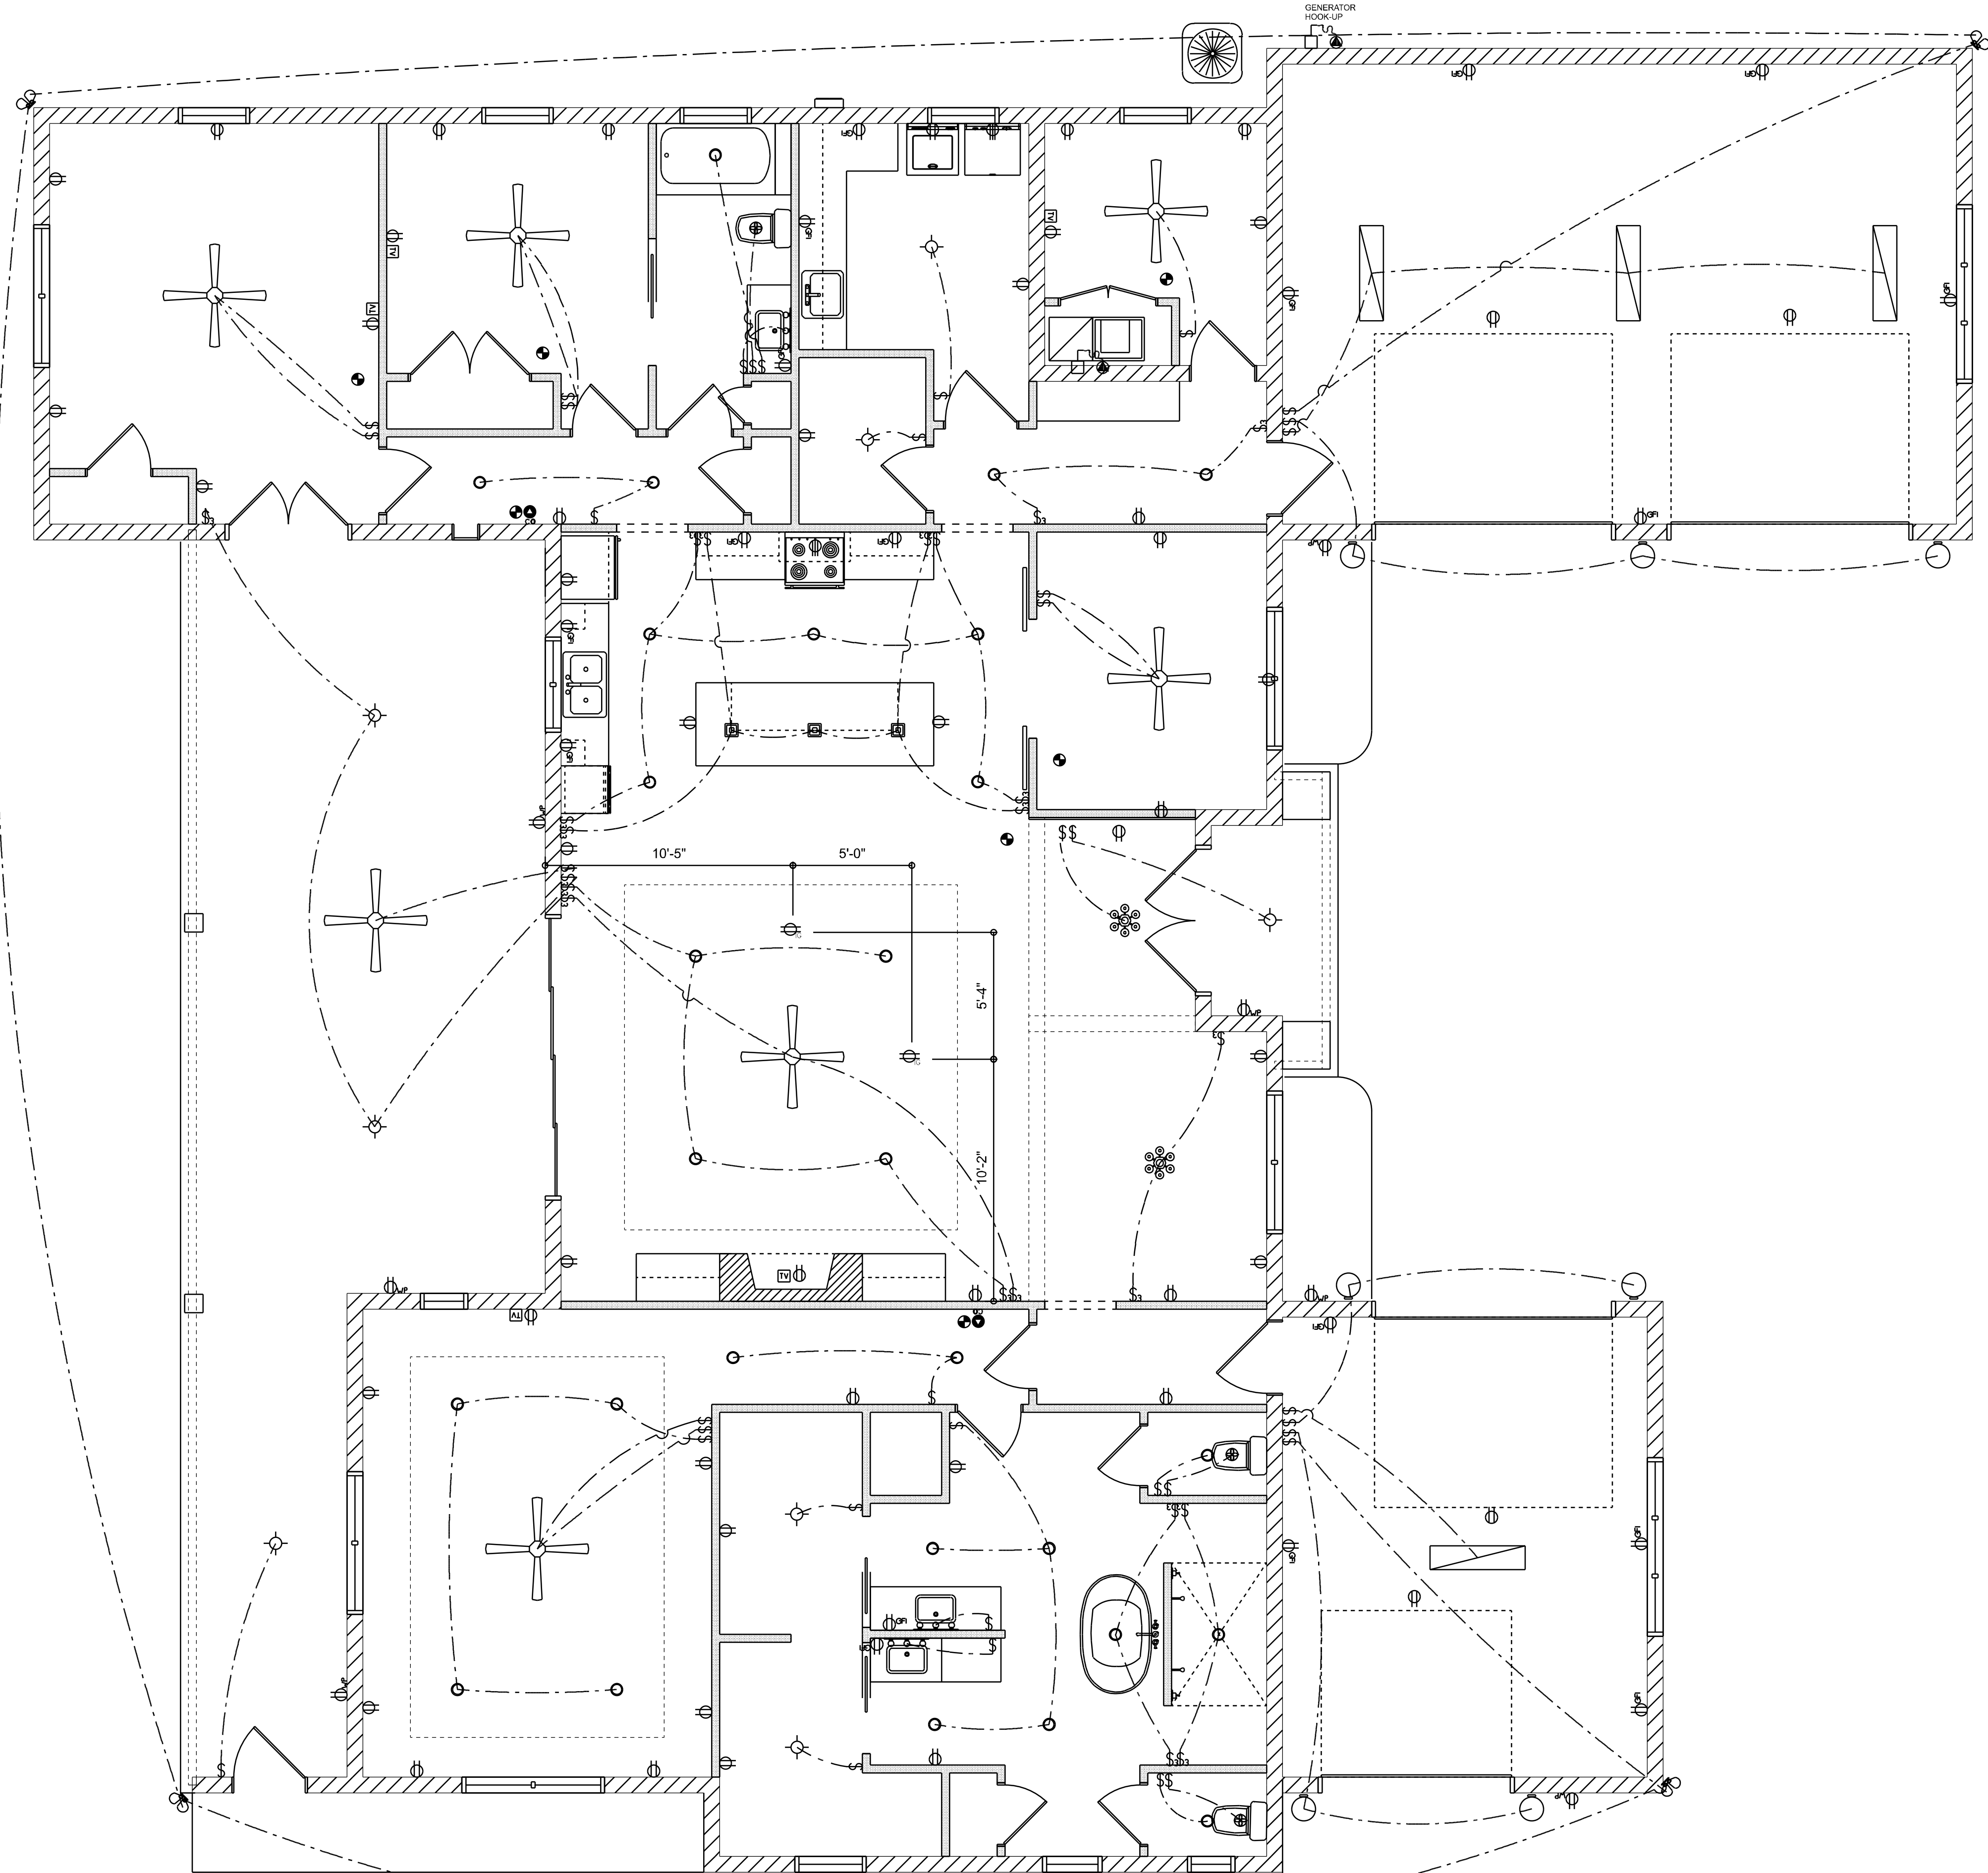


ELECTRICAL PLAN
SCALE: 1/4" = 1'-0"

REVISIONS SCHEDULE	
March 17th, 2021	Proposal Drawing
May, 12th, 2021	Revisions



IC
Construction LLC
Residential • Commercial • Remodels
818 W DUVAL ST, LAKE CITY, FL 32055

CUSTOM HOME FOR:
GOMEZ / CARTLET RES.
LOT 77, THE OAKS S/D, COLUMBIA COUNTY, FLORIDA

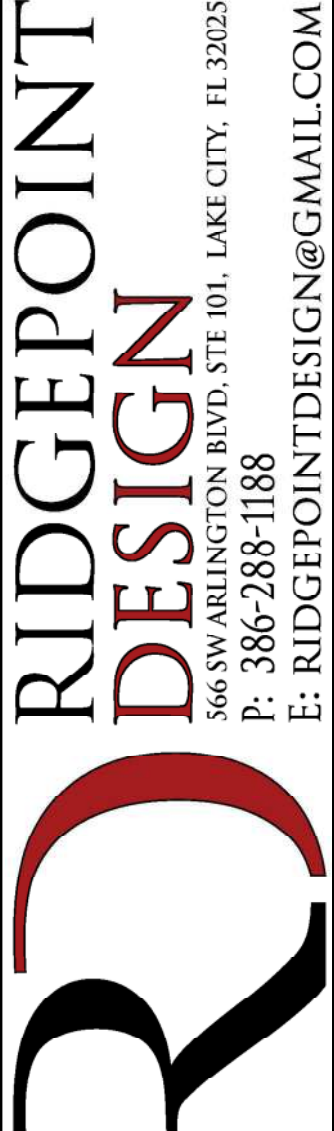

RIDGEPOINT
DESIGN
566 SW ARLINGTON BLVD, STE 101, LAKE CITY, FL 32025
P: 386-288-1188
E: RIDGEPOINTDESIGN@GMAIL.COM

SHEET NUMBER
A.4
OF 4 SHEETS