



1 Life Safety and Fixture Floor Plan
A102 SCALE: 1/8" = 1'-0"

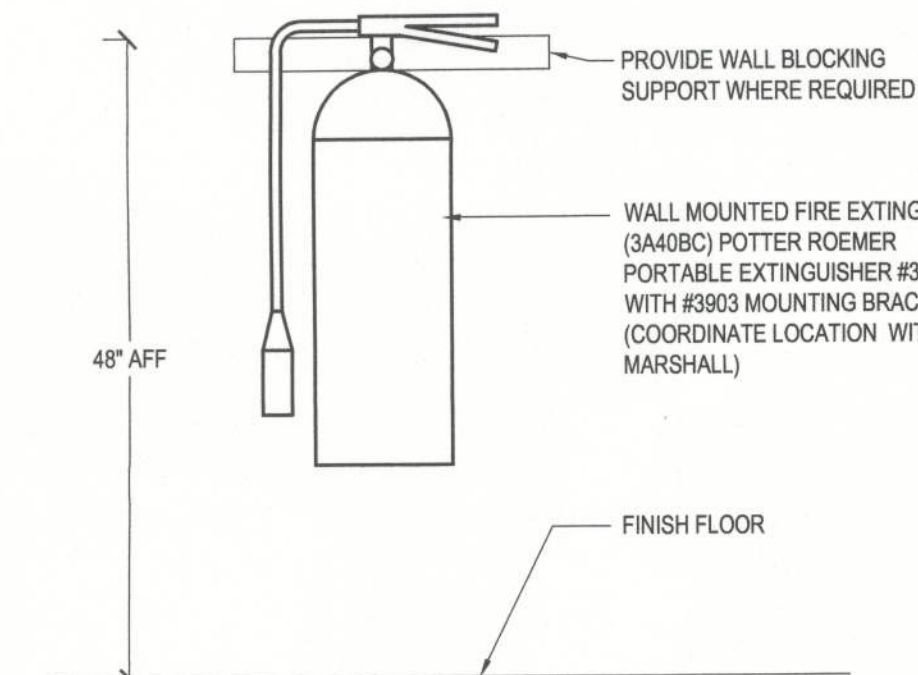

3 Fire Extinguisher Detail
A102 SCALE: NTS



5 Exit Signage
A102 SCALE: NTS

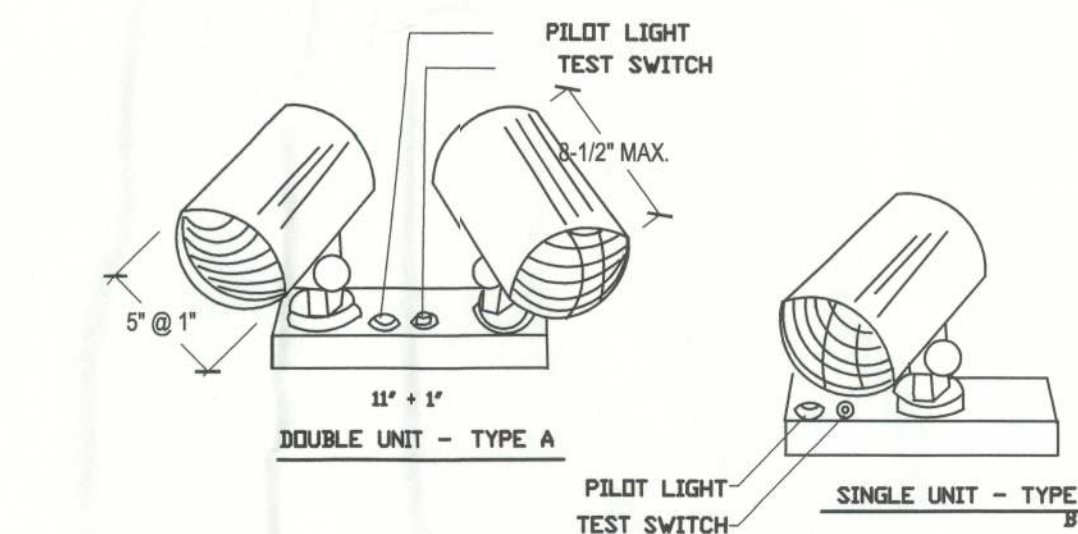

4 Emergency Lighting Fixture
A102 SCALE: NTS

- LUMINAIRE REQUIREMENTS**
1. ALUMINUM FINISHED CHANNEL MOUNTING BASE WITH TEST SWITCH AND PILOT OR HIGH RATE INDICATING LIGHT.
 2. CYLINDERS FOR LIGHTS AND BATTERY AND CHARGER SHALL BE PAINTED, MATTE WHITE AND SHALL BE FULLY ADJUSTABLE.
 3. BATTERY SHALL BE MAINTENANCE FREE NICKEL CADMIUM WITH FULL 5 YEAR WARRANTY.
 4. UNIT SHALL HAVE AUTOMATIC TWO RATE CHARGER.
 5. SWITCHING AND CONTROLS - COMPLETELY SOLID STATE WITH AUTO TRANSFER AND LOW VOLTAGE CUTOFF. TEST SWITCH AND HIGH RATE INDICATING LIGHT.
 6. 9 WATT TUNGSTEN HALOGEN LAMP.


LEGEND	
SYMBOL	DESCRIPTION
	EXIT LIGHT
	EMERGENCY LIGHTING WALL PACK
	MAXIMUM EGRESS PATH
	FIRE EXTINGUISHER, WALL MOUNTED (F.E.) RE: NFPA
	MOST REMOTE POINT
	EGRESS DISTANCE (FEET)
	EGRESS CAPACITY (PEOPLE)

OCCUPANT LOAD (TABLE 1004.1.1)
MERCANTILE OCCUPANCY (50 FT AREA PER OCCUPANT) = 30 GROSS
TOTAL OCCUPANT LOAD = 8,320/30 = 277 OCCUPANTS


FRP NOTE:
INSTALL FRP (KEMITE - LASCOCORBOARD #419 WHITE WEMBOSSED FINISH OR EQUAL) 4'-0" A.F.F. ON ALL WALL SURFACES IN THE RESTROOMS. INSTALL FRP TO 4'-0" A.F.F. BEHIND THE MOP SINK AND WATER COOLER A MINIMUM OF 1 FT TO EACH SIDE. COMPLETE FRP WITHRIP CAP ON TOP, SIDES, CORNERS, AND JOINTS, INCLUDING CAULKING AS REQ. BY MFG. VERIFY LOCAL CODE FOR ADDITIONAL APPLICATION IF REQ.

FIXTURE PLAN NOTE:
THE FIXTURE PLAN IS PROTOTYPICAL. OBTAIN UPDATED DRAWING FROM FAMILY DOLLAR PROJECT MANAGER PRIOR TO PLACING ANY SPECIAL ELECTRICAL EQUIPMENT AND PRIOR TO PLACING ANY FINAL SALES FLOOR LIGHTING.

ACCESSIBILITY NOTE:
GENERAL CONTRACTOR IS ADVISED THAT IT IS THEIR RESPONSIBILITY TO INSURE THAT ALL CONSTRUCTION IS IN COMPLIANCE WITH STATE AND LOCAL CODES AND THE AMERICANS WITH DISABILITY ACT. GC IS TO VERIFY THE COORDINATION OF THE VARIOUS DRAWINGS. IF CONFLICT OF INFORMATION IS FOUND, CONTACT THE PARTIES IN THE DISCREPANCY BEFORE PROCEEDING.

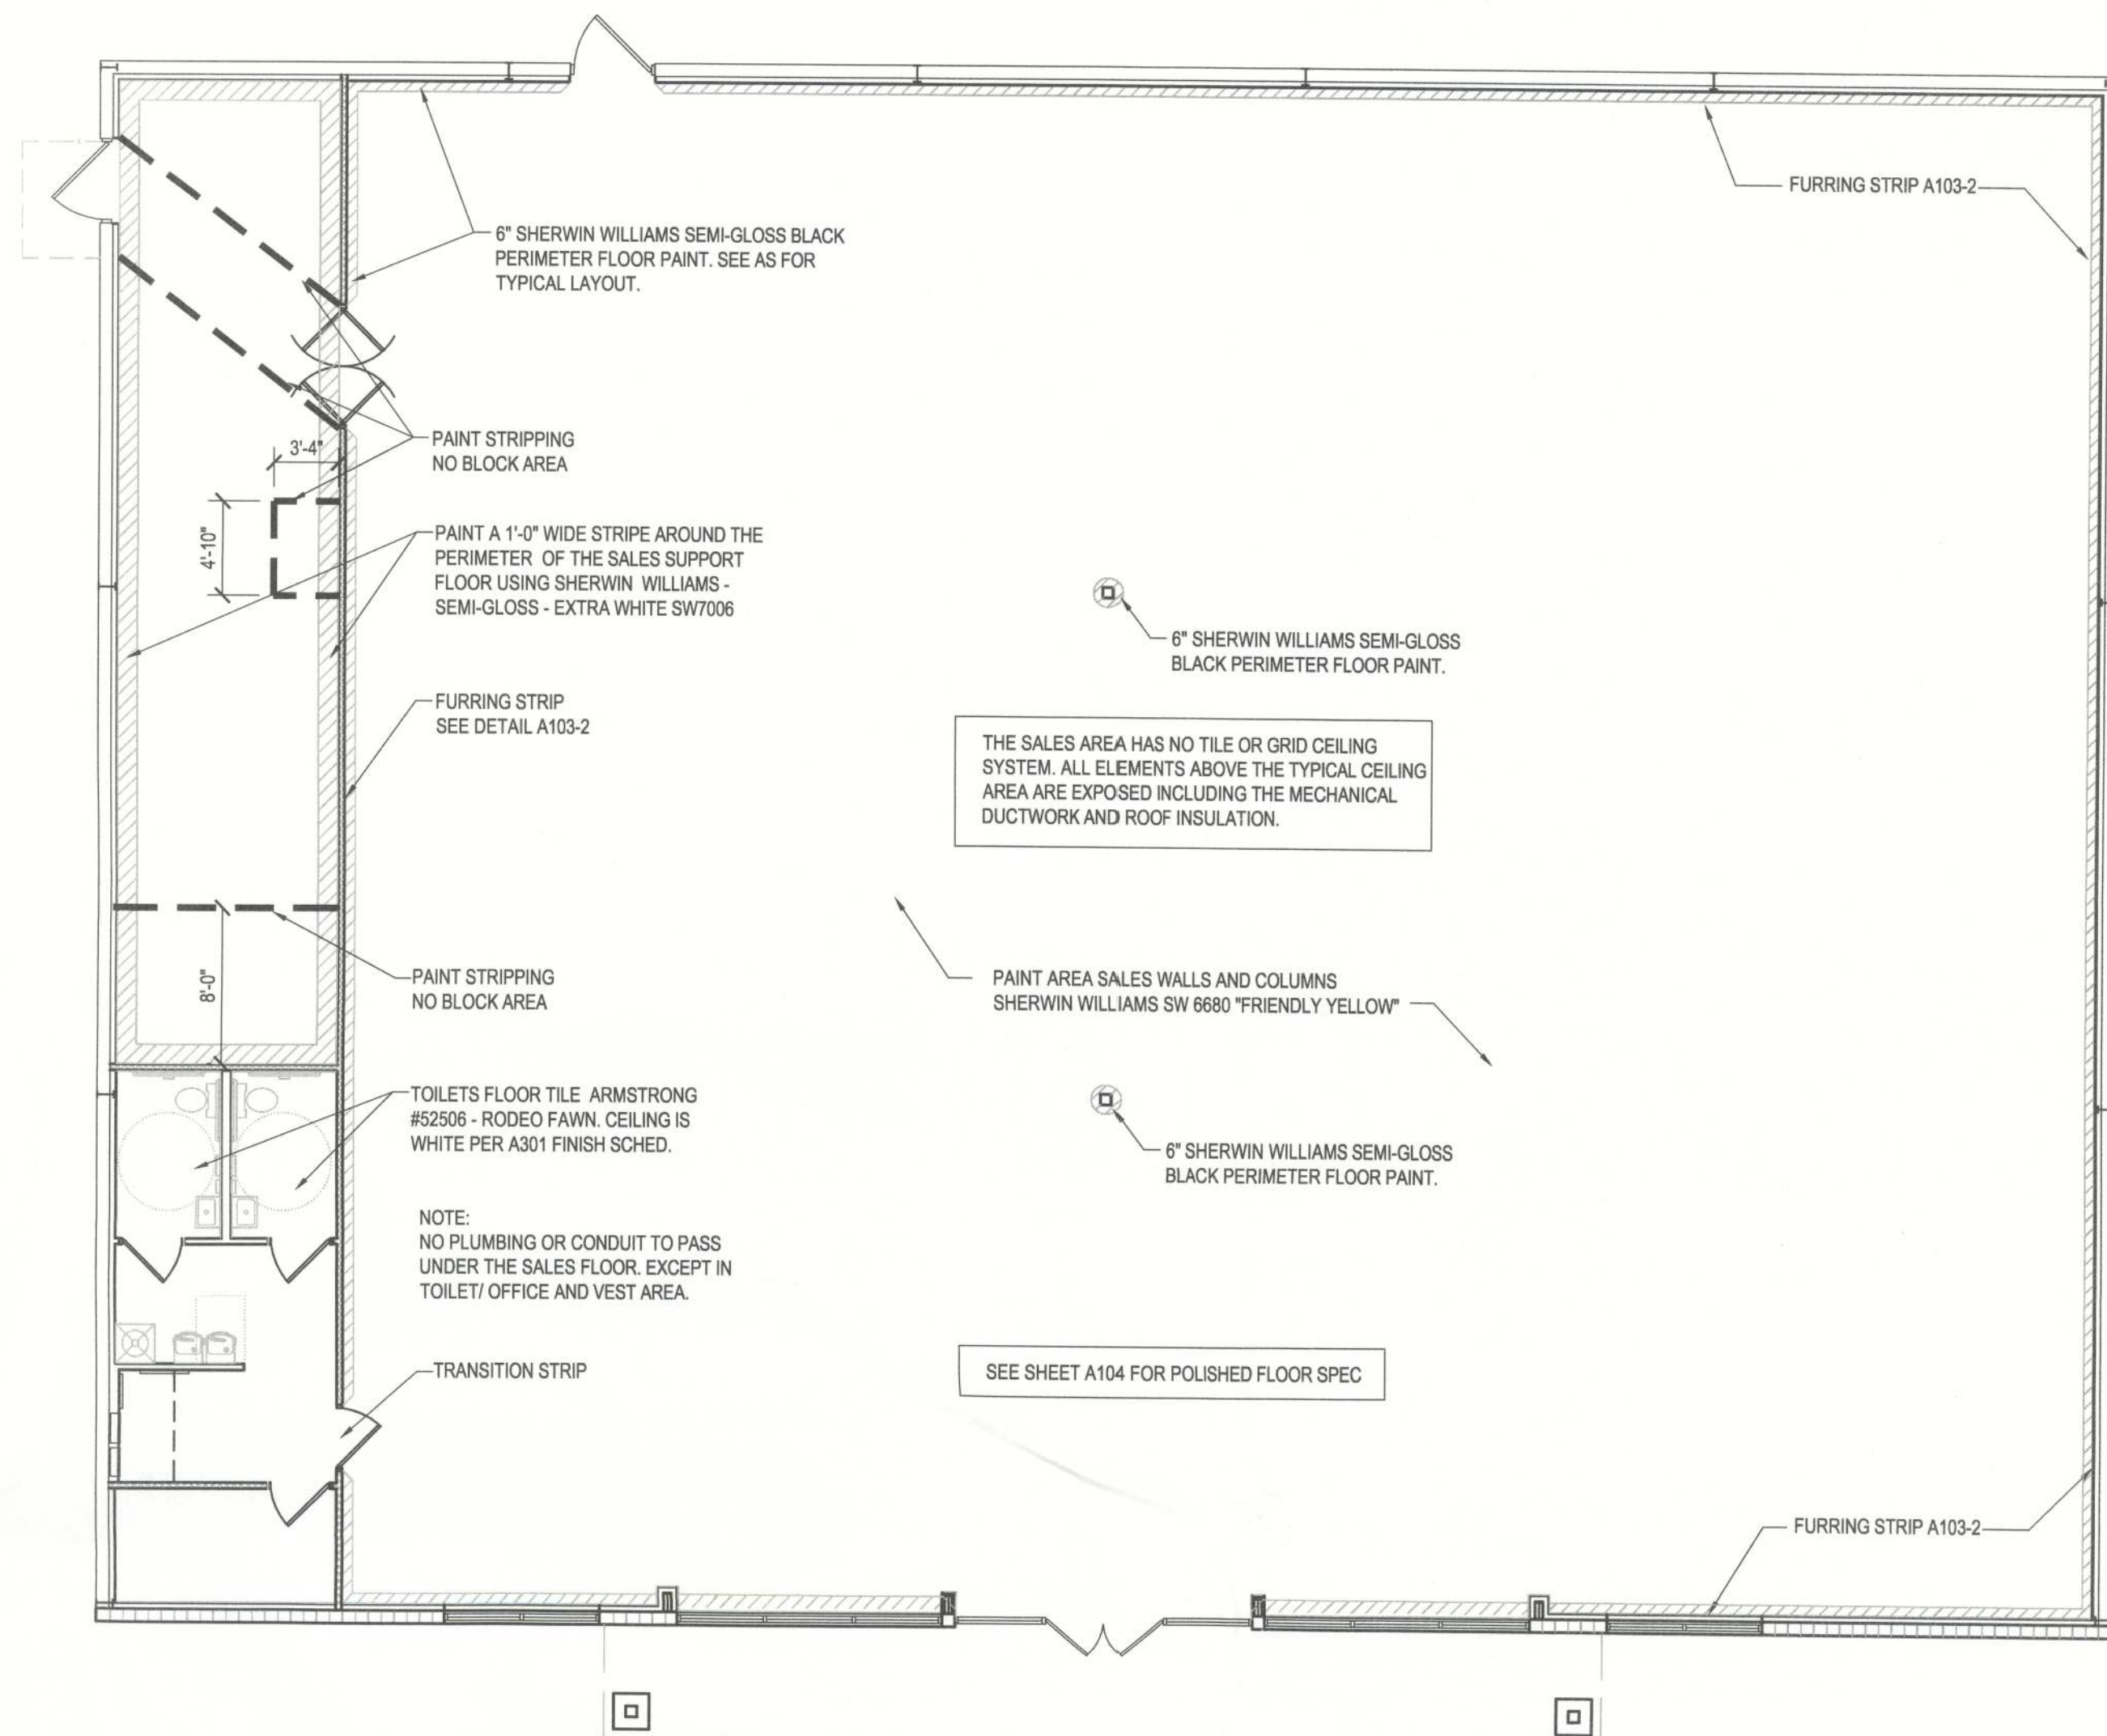

2 Interior Floor and Finishes
A102 SCALE: 1/8" = 1'-0"

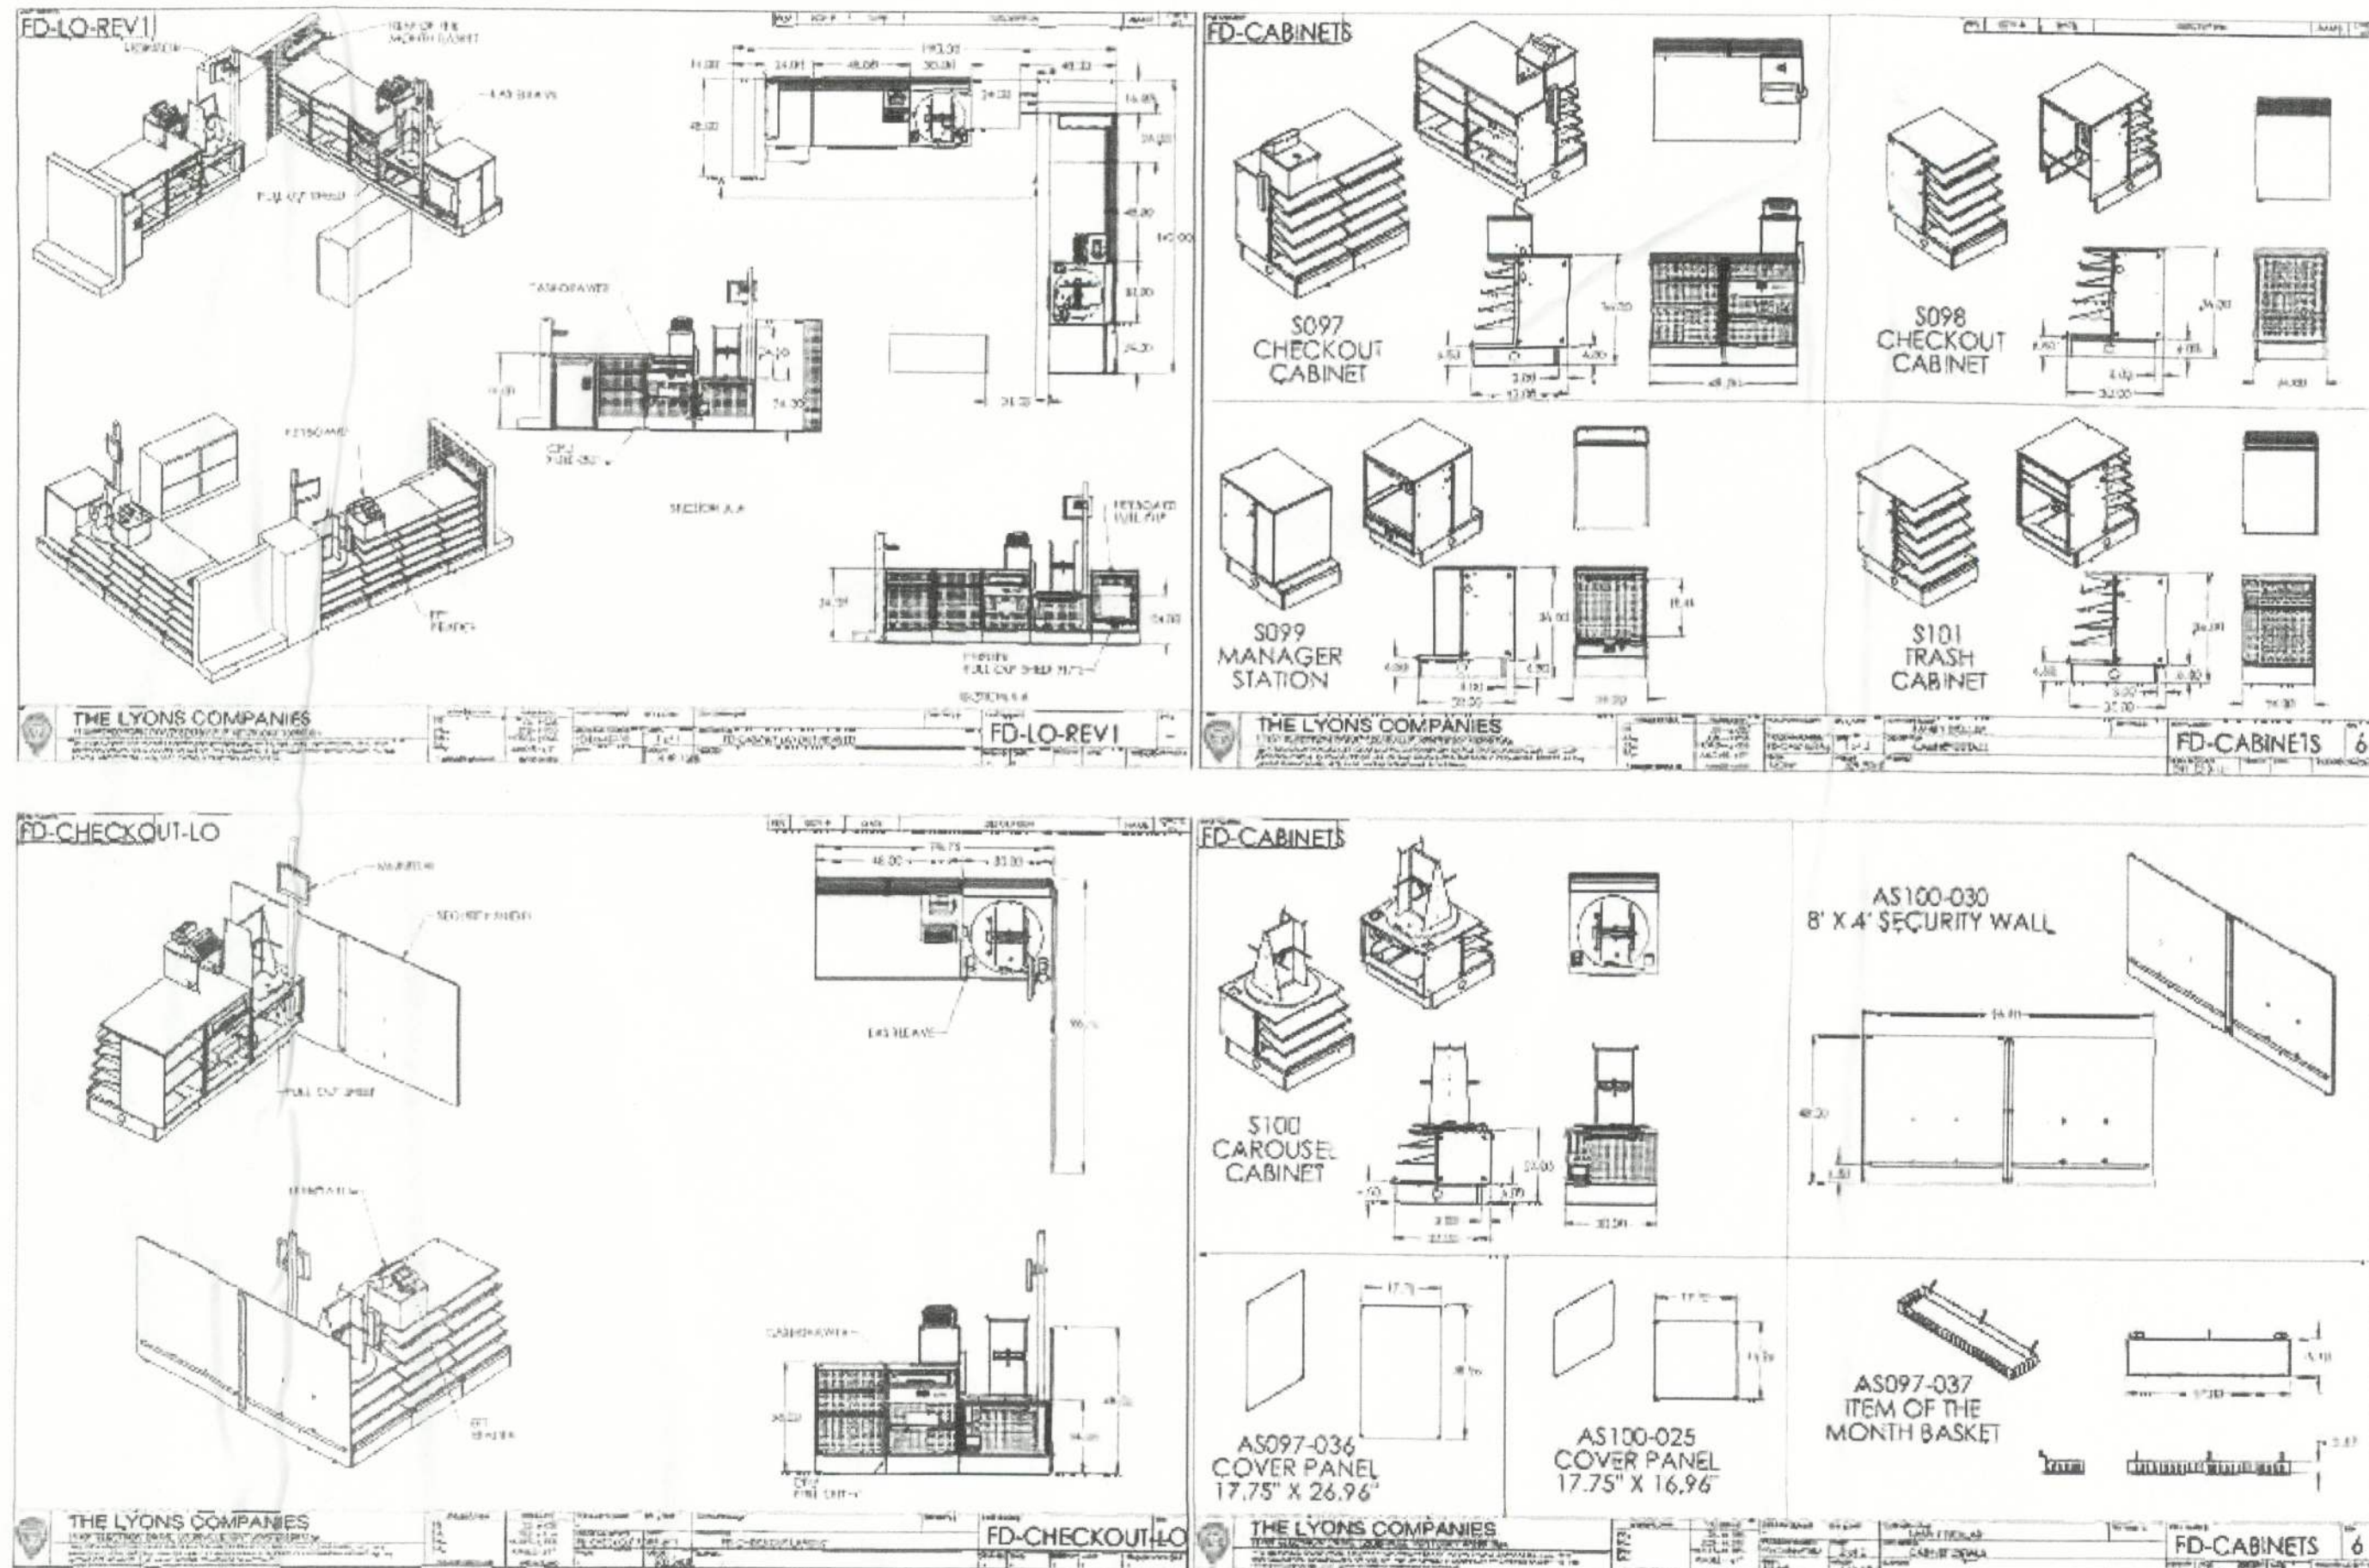

6 CHECK OUT DETAILS
A102 NOT TO SCALE

ARCHITECTURE
ENGINEERING
LAND SURVEYING

LIS

21430 Palm Beach Blvd.
Alva, Fla. 33920
Phone: (239) 693-9244
Facsimile: (239) 693-9828

CA NO.: 6953
LB1057

2572 West State Road 426
Suite 2064, Oviedo, FL 32765
Phone: (321) 244-0402
Facsimile: (321) 244-9419

CLIENT NAME

STEPHENS BARRIOS

823 IRMA AVENUE
ORLANDO, FLORIDA, 32803

PROJECT NAME

FAMILY DOLLAR STORE

PLAN # 2011-04 / 104-80
FORT WHITE, FL

SHEET TITLE

Life Safety, Fixture & Detail Plans

SEAL

MAR 06 2012

DONALD DIBERNARDO
AF93507

RELEASE	DATE
1	
2	
3	
4	
5	
6	

PROJECT NO.

2012-001

ISSUE DATE

02/22/2012

DRAWN

JC

CHECKED

CS

A102

LIS EXPRESSLY RESERVES ITS COPYRIGHT AND ALL OTHER PROPERTY RIGHTS TO THESE DOCUMENTS AND THEIR DESIGN, HENCE, THEY ARE NOT TO BE REPRODUCED.