



FRONT ELEVATION  
SCALE: 1/4" = 1'-0"



REAR ELEVATION  
SCALE: 1/4" = 1'-0"

| REVISIONS SCHEDULE |  |                  |  |
|--------------------|--|------------------|--|
| PROPOSAL           |  | June 20th, 2023  |  |
| REVISIONS          |  | Aug. 29th, 2023  |  |
| REVERSED DRWG      |  | Sept. 25th, 2023 |  |
|                    |  |                  |  |
|                    |  |                  |  |

CUSTOM HOME FOR:

COPPOCK RESIDENCE

BRADFORD COUNTY, FL

RIDGEPOINT

DESIGN


566 SW ARLINGTON BLVD STE 101, LAKE CITY, FL 32025  
P: 386-288-1188  
E: RIDGEPOINTDESIGN@GMAIL.COM

SHEET NUMBER


A.1

OF 8 SHEETS



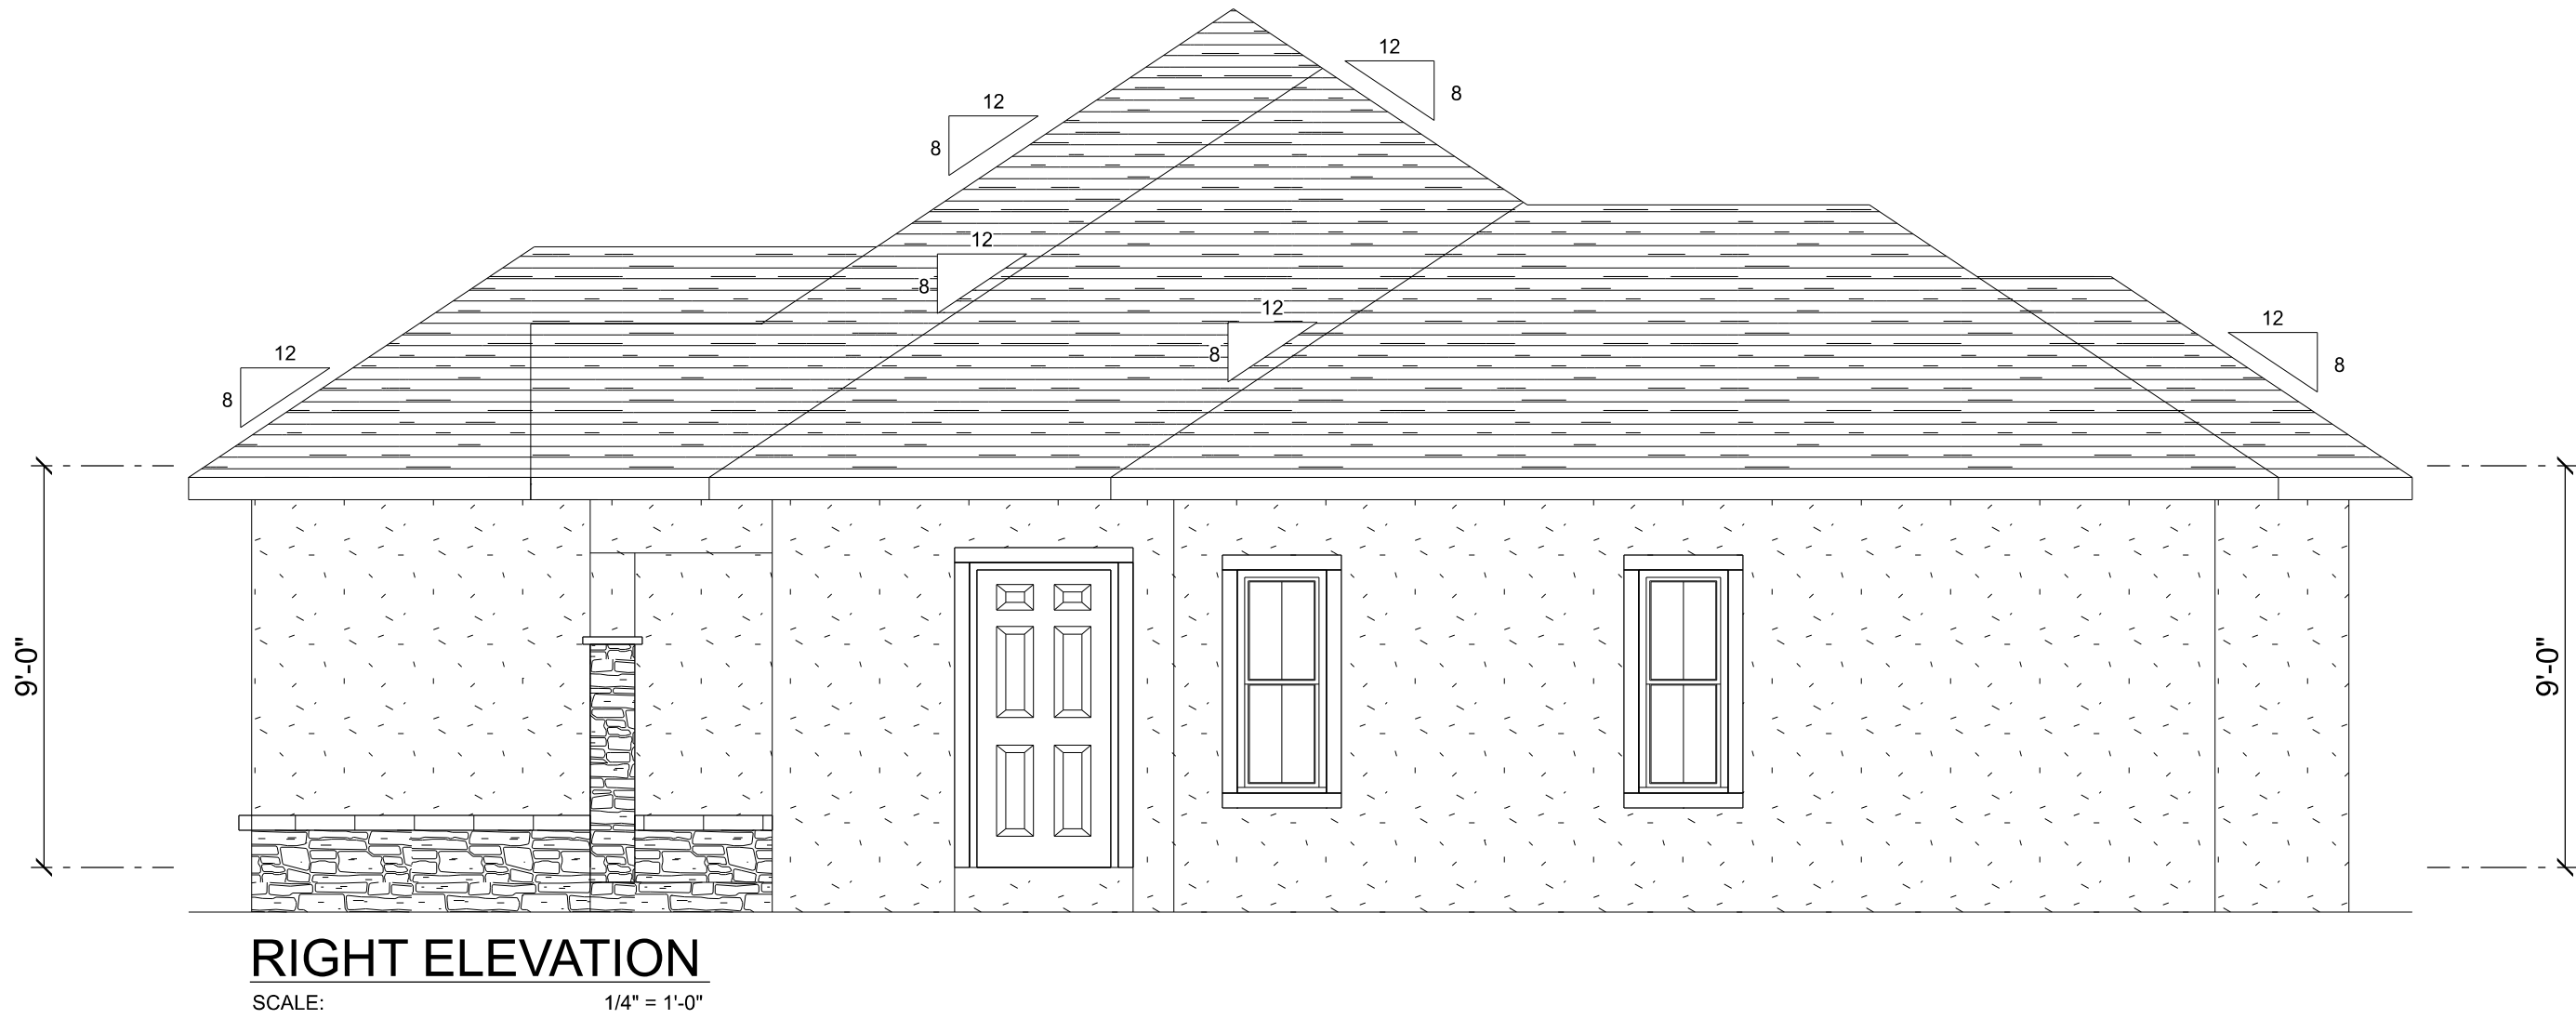


RIGHT ELEVATION  
SCALE: 1/4" = 1'-0"

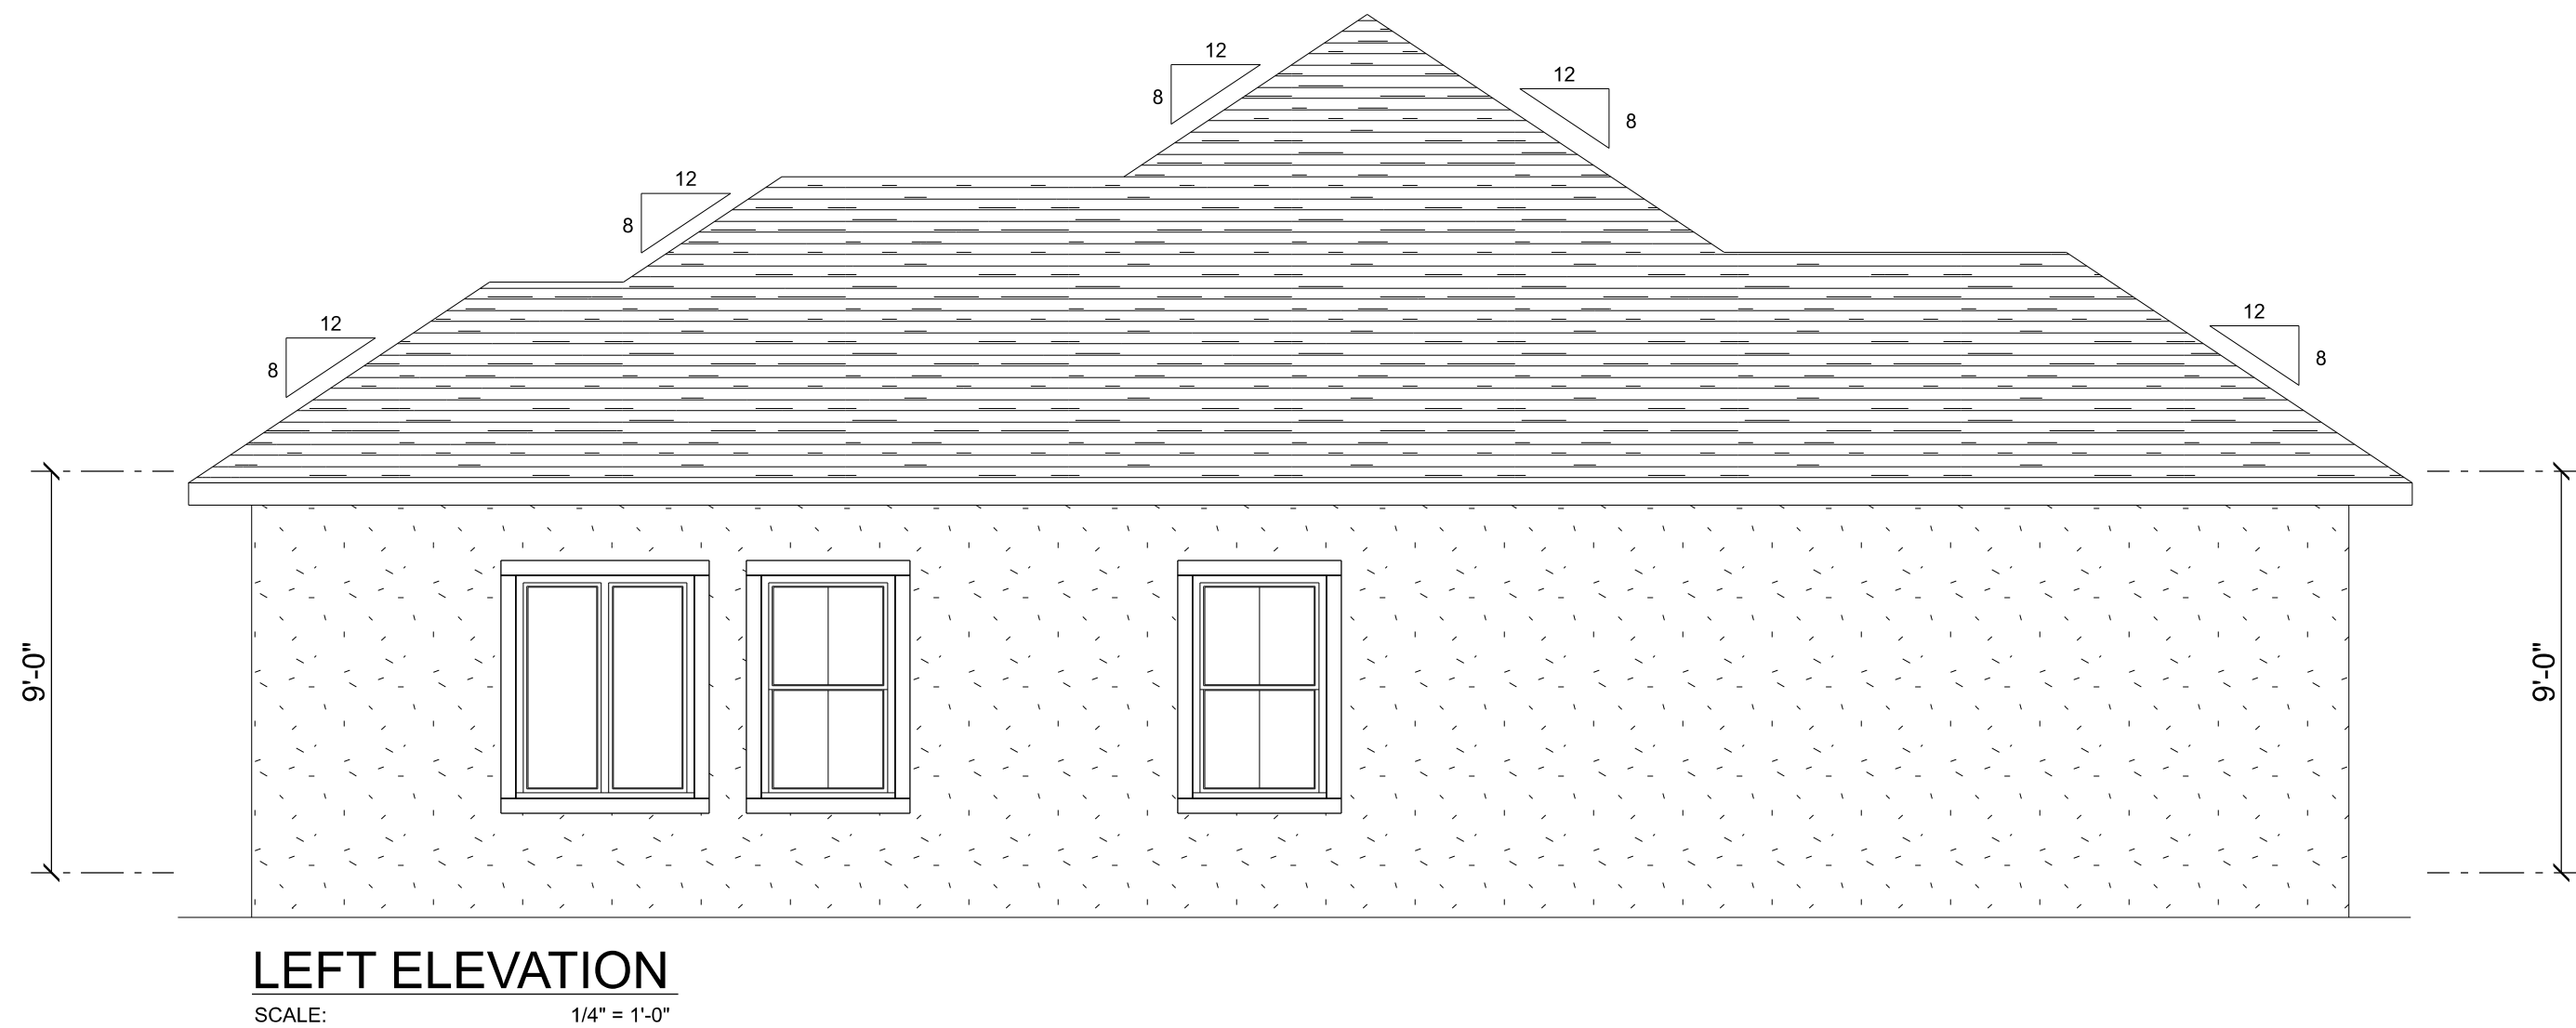

LEFT ELEVATION  
SCALE: 1/4" = 1'-0"


| REVISIONS SCHEDULE |  |                  |  |
|--------------------|--|------------------|--|
| PROPOSAL           |  | June 20th, 2023  |  |
| REVISIONS          |  | Aug. 29th, 2023  |  |
| REVERSED DRWG      |  | Sept. 25th, 2023 |  |
|                    |  |                  |  |
|                    |  |                  |  |

CUSTOM HOME FOR:  
**COPPOCK RESIDENCE**  
BRADFORD COUNTY, FL

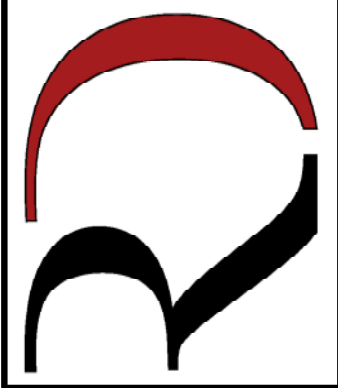
**RIDGEPOINT  
DESIGN**

566 SW ARLINGTON BLVD STE 101, LAKE CITY, FL 32025  
P: 386-288-1188  
E: RIDGEPOINTDESIGN@GMAIL.COM



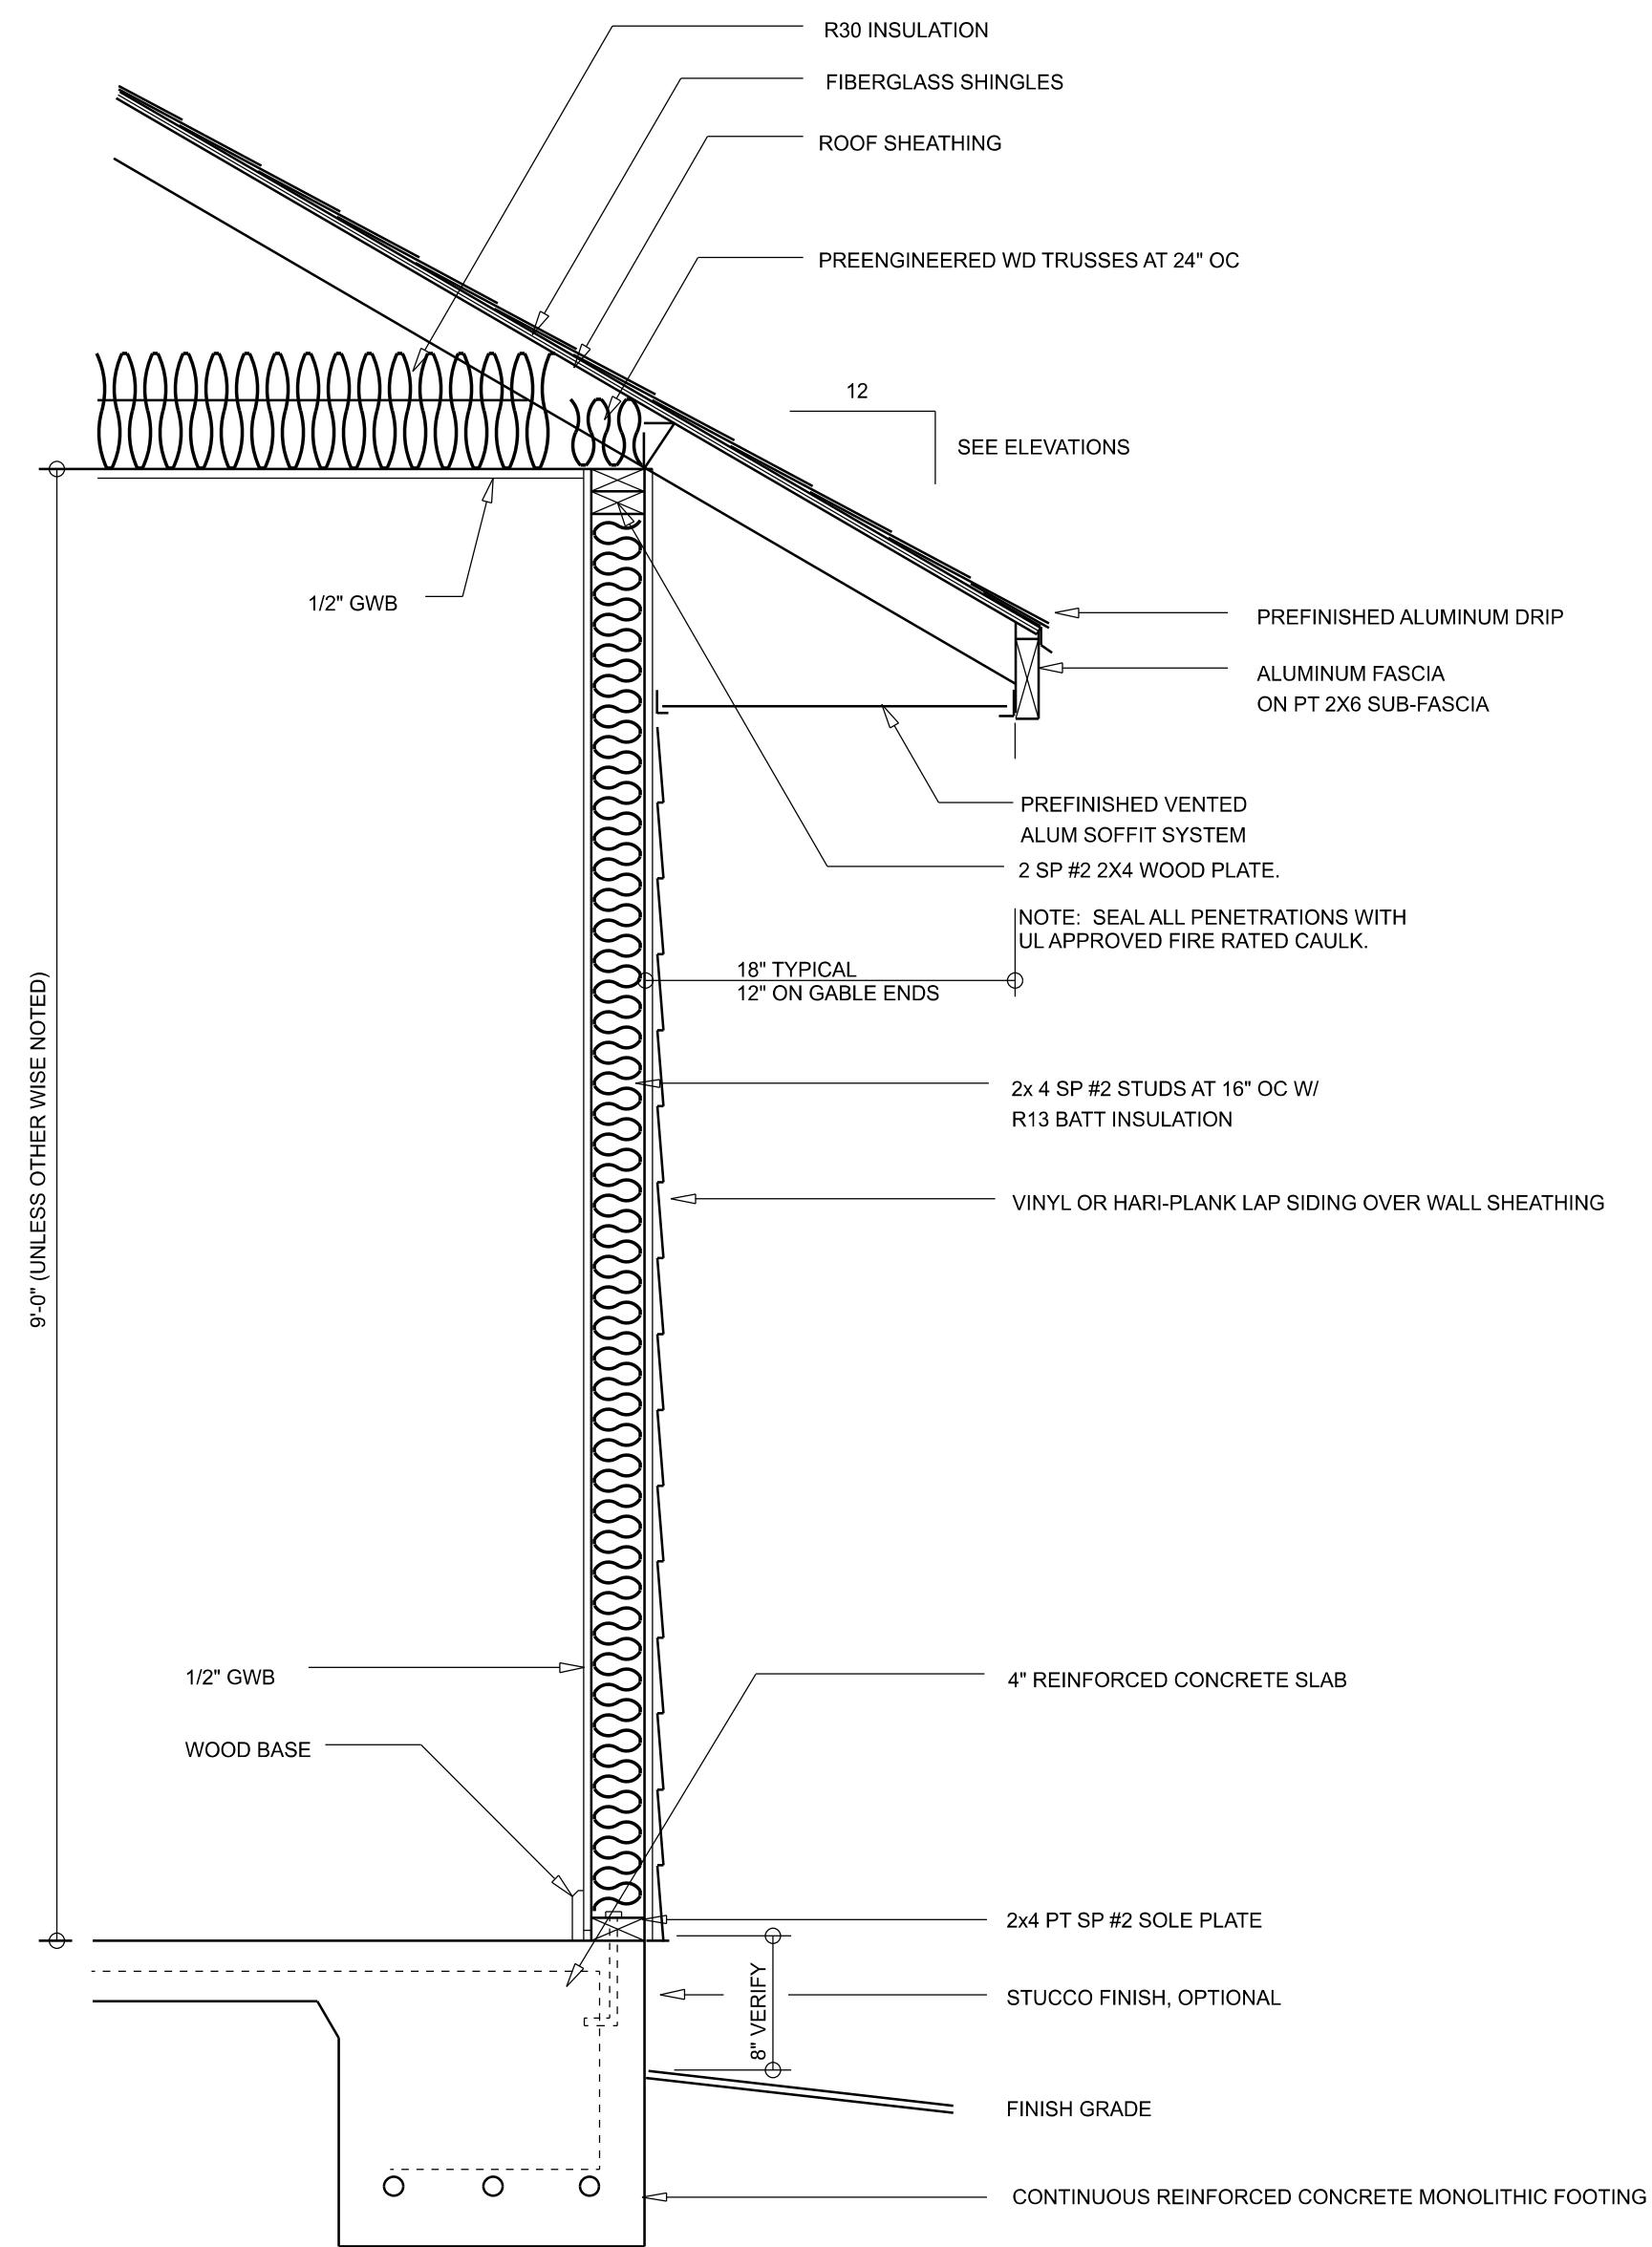

TYPICAL WALL SECTION  
SCALE: 1" = 1'-0"

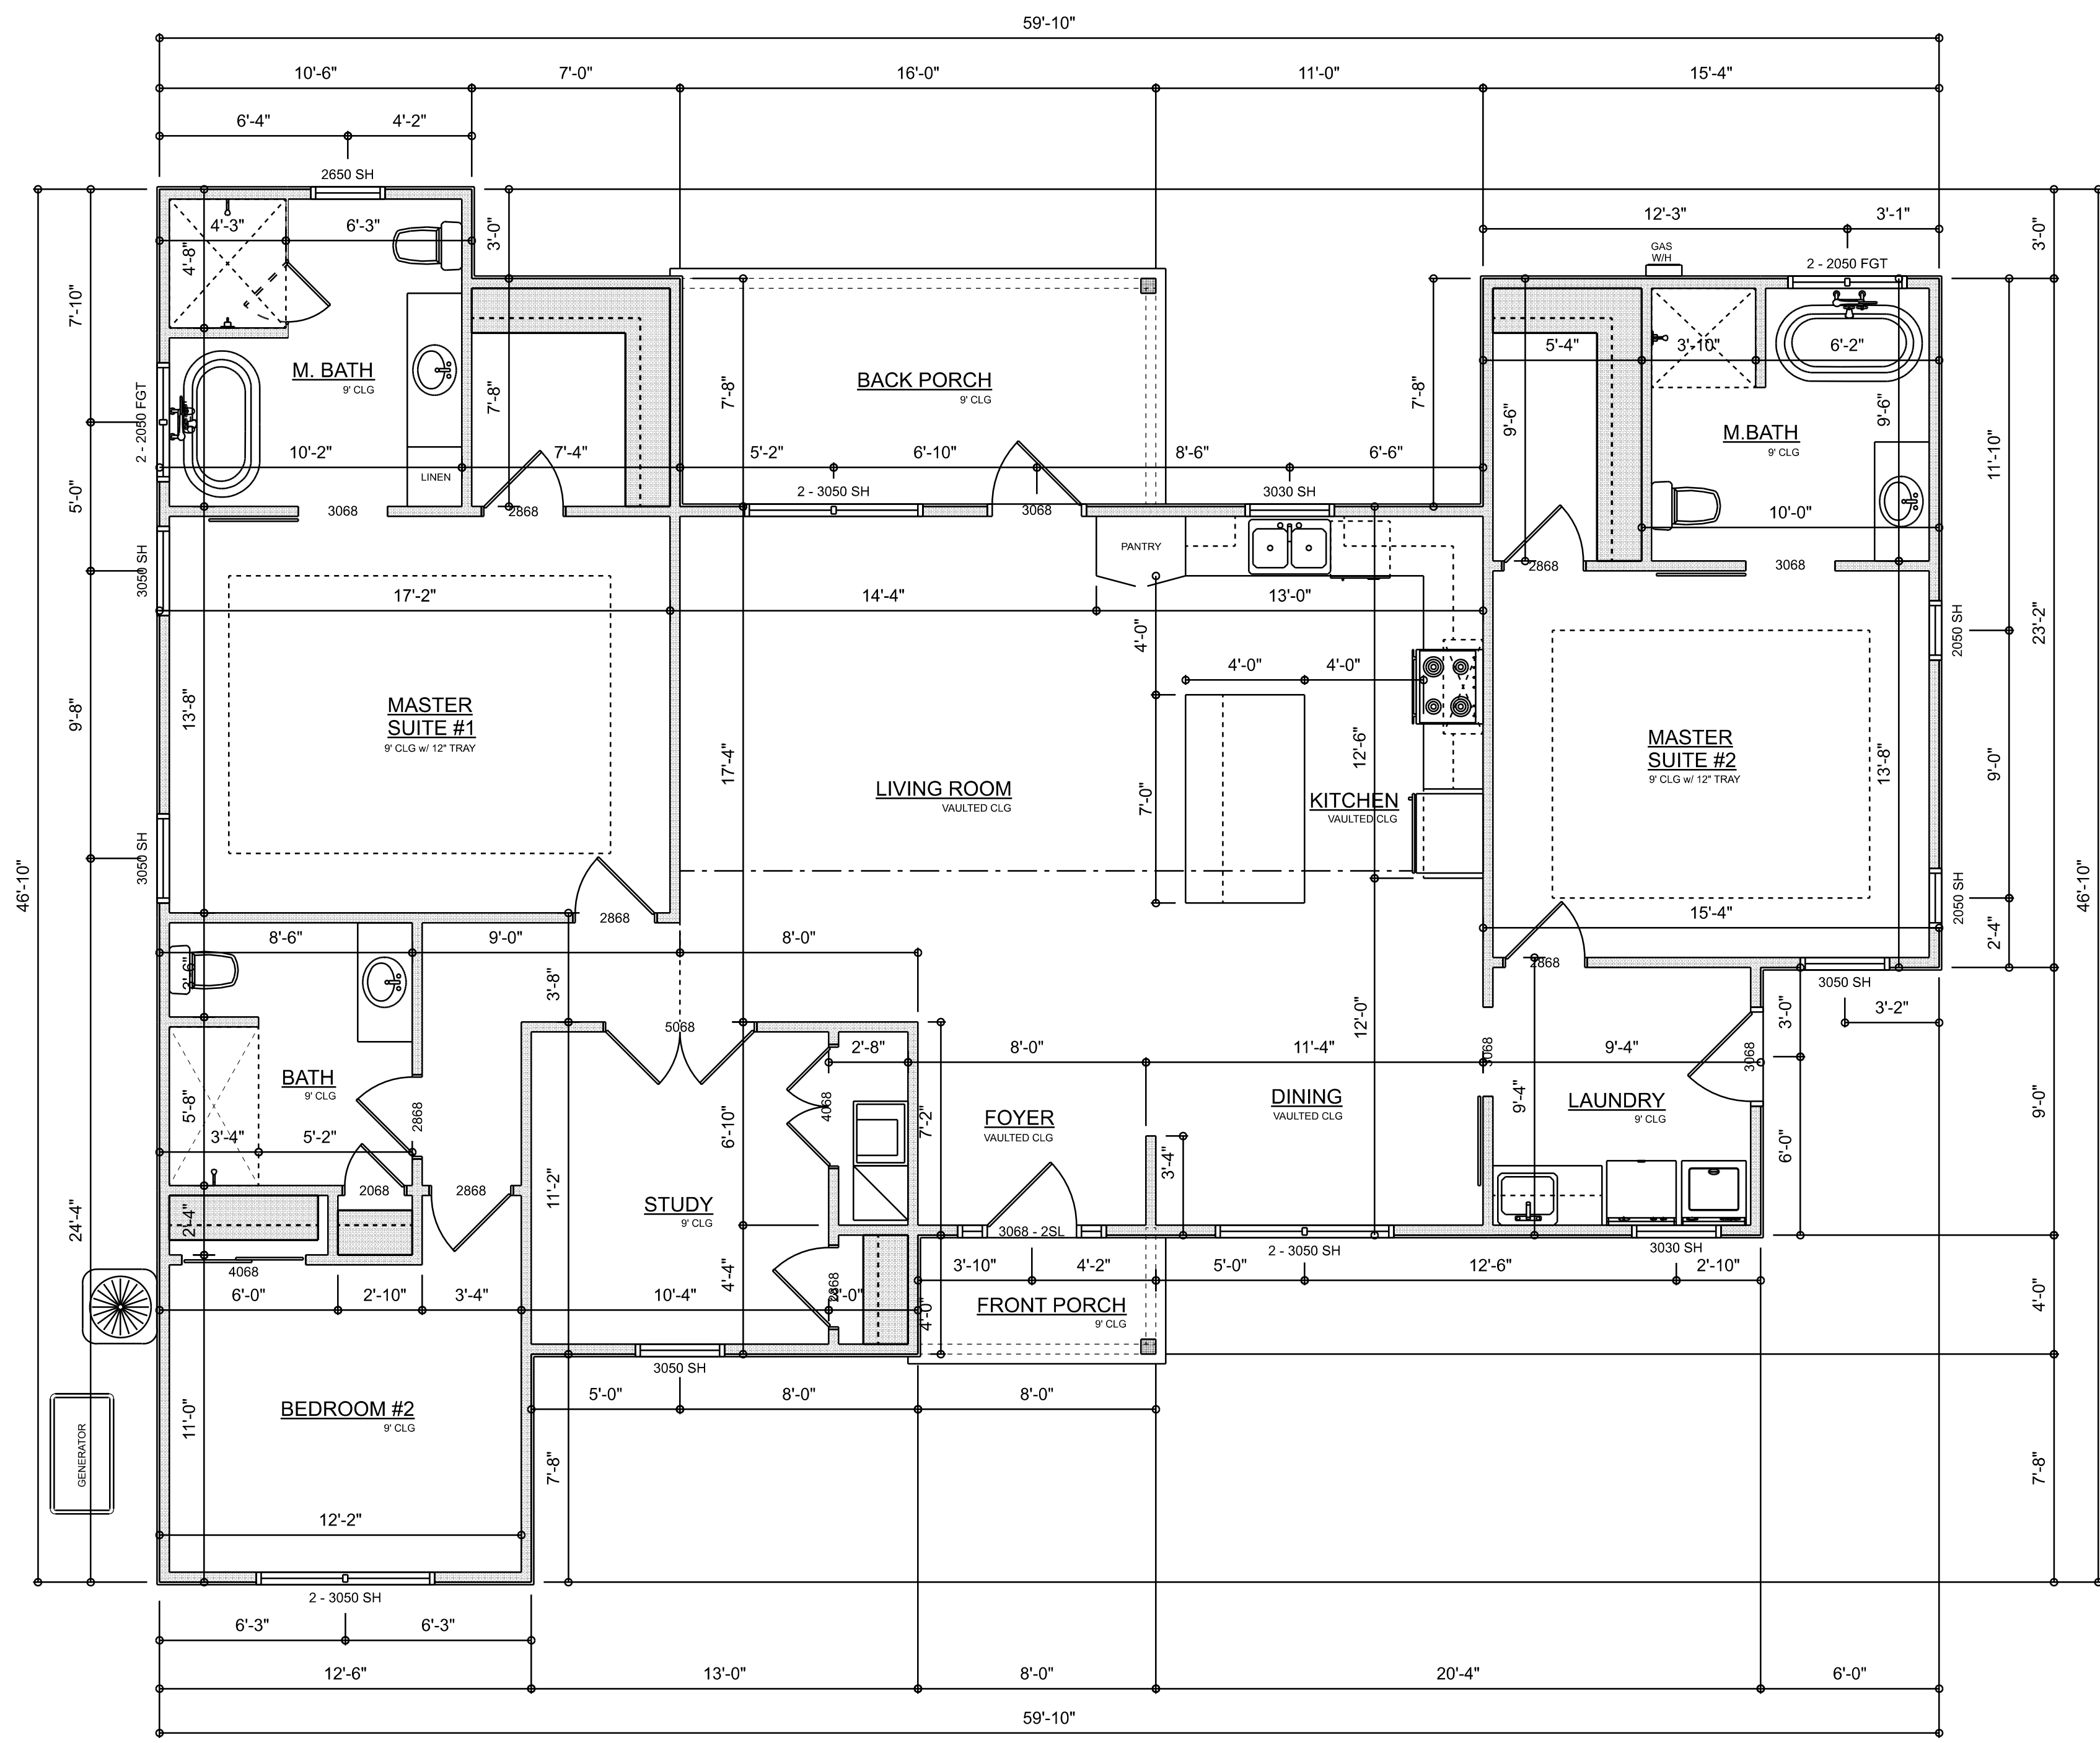

DIMENSIONED FLOOR PLAN  
SCALE: 1/4" = 1'-0"










| AREA SUMMARY |       |      |
|--------------|-------|------|
| LIVING       | 1,893 | S.F. |
| BACK PORCH   | 123   | S.F. |
| ENTRY PORCH  | 34    | S.F. |
| TOTAL AREA   | 2,050 | S.F. |

| REVISIONS SCHEDULE |                  |  |  |
|--------------------|------------------|--|--|
| PROPOSAL           | June 20th, 2023  |  |  |
| REVISIONS          | Aug. 29th, 2023  |  |  |
| REVERSED DRWG      | Sept. 25th, 2023 |  |  |

CUSTOM HOME FOR:  
**COPPOCK RESIDENCE**  
BRADFORD COUNTY, FL

        **RIDGEPOINT DESIGN**  
566 SW ARLINGTON BLVD STE 101, LAKE CITY, FL 32025  
P: 386-288-1188  
E: RIDGEPOINTDESIGN@GMAIL.COM

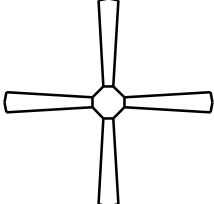

| ELECTRICAL LEGEND        |       |                                                                                     |
|--------------------------|-------|-------------------------------------------------------------------------------------|
| ELECTRICAL               | COUNT | SYMBOL                                                                              |
| CEILING FAN              | 6     |    |
| CAN LIGHT 6inch          | 25    |    |
| CHANDELIER               | 1     |    |
| LED CEILING LIGHT 1x4    | 1     |    |
| PENDANT LIGHT            | 3     |    |
| EXTERIOR SCONCE          | 2     |    |
| MOTION SECURITY LIGHT    | 4     |    |
| AC DISCONNECT            | 2     |    |
| CARBON DETECTOR          | 2     |    |
| EXHAUST FAN              | 3     |    |
| OUTLET                   | 30    |    |
| OUTLET 220v              | 2     |    |
| OUTLET GFI               | 10    |    |
| OUTLET WP                | 4     |    |
| SMOKE DETECTOR           | 7     |   |
| STANDARD LIGHT           | 3     |  |
| SWITCH                   | 32    |  |
| SWITCH 3 WAY             | 17    |  |
| VANITY BAR LIGHT - SMALL | 3     |  |
| CABLE TV OUTLET          | 5     |  |

ELECTRICAL PLAN NOTES:

INSTALLATION SHALL BE PER LATEST NAT'L ELECTRIC CODE.

WIRE ALL APPLIANCES, HVAC UNITS AND OTHER EQUIPMENT PER MANUF. SPECIFICATIONS

CONSULT WITH THE OWNER FOR THE NUMBER OF SEPERATE TELEPHONE LINES TO BE INSTALLED

ALL SMOKE DETECTORS SHALL BE 120v W/ BATTERY BACKUP OF THE PHOTOELECTRIC TYPE, AND SHALL BE INTERLOCKED TOGETHER. INSTALL INSIDE AND NEAR ALL BEDROOMS


TELEPHONE, TELEVISION AND OTHER LOW VOLTAGE DEVICES OR OUTLETS SHALL BE AS PER THE OWNER'S DIRECTIONS, & IN ACCORDANCE W/ APPLICABLE SECTIONS OF NEC-LATEST EDITION.

ALL RECEPTICALS, NOT OTHERWISE NOTED, SHALL BE ARC FAULT INTERRUPTER TYPE, EXCEPT DEDICATED OUTLETS

ALL RECEPTICALS IN WET AREAS SHALL BE GROUND FAULT INTERRUPTER TYPE (GFI)

ALL EXTERIOR RECEPTICALS SHALL BE WEATHERPROOF GROUD FAULT INTERRUPTER TYPE (WP/GFI)


NOTE:  
ELECTRICAL CONTR SHALL PREPARE "AS-BUILT" SHOP DWGS INDICATING ALL ELECTRICAL WORK, INCLUDING ANY CHANGES TO THE ELEC. PLAN, ADD'NS TO THE ELEC. PLAN, RISER DIAGRAM, AS-BUILT PANEL SCHEDULE W/ ALL CKTS IDENTIFIED W/ CKT N°. DESCRIPTION & BRKR, SERVICE ENT. & ALL UNDERGROUND WIRE LOCATIONS/ROUTING / DEPTH. RISER DIA. SHALL INCLUDE WIRE SIZES/TYPE & EQUIPMENT TYPE W/ RATINGS & LOADS.  
CONTRACTOR SHALL PROVIDE 1 COPY OF AS-BUILT DWGS TO OWNER & 1 COPY TO THE PERMIT ISSUING AUTHORITY

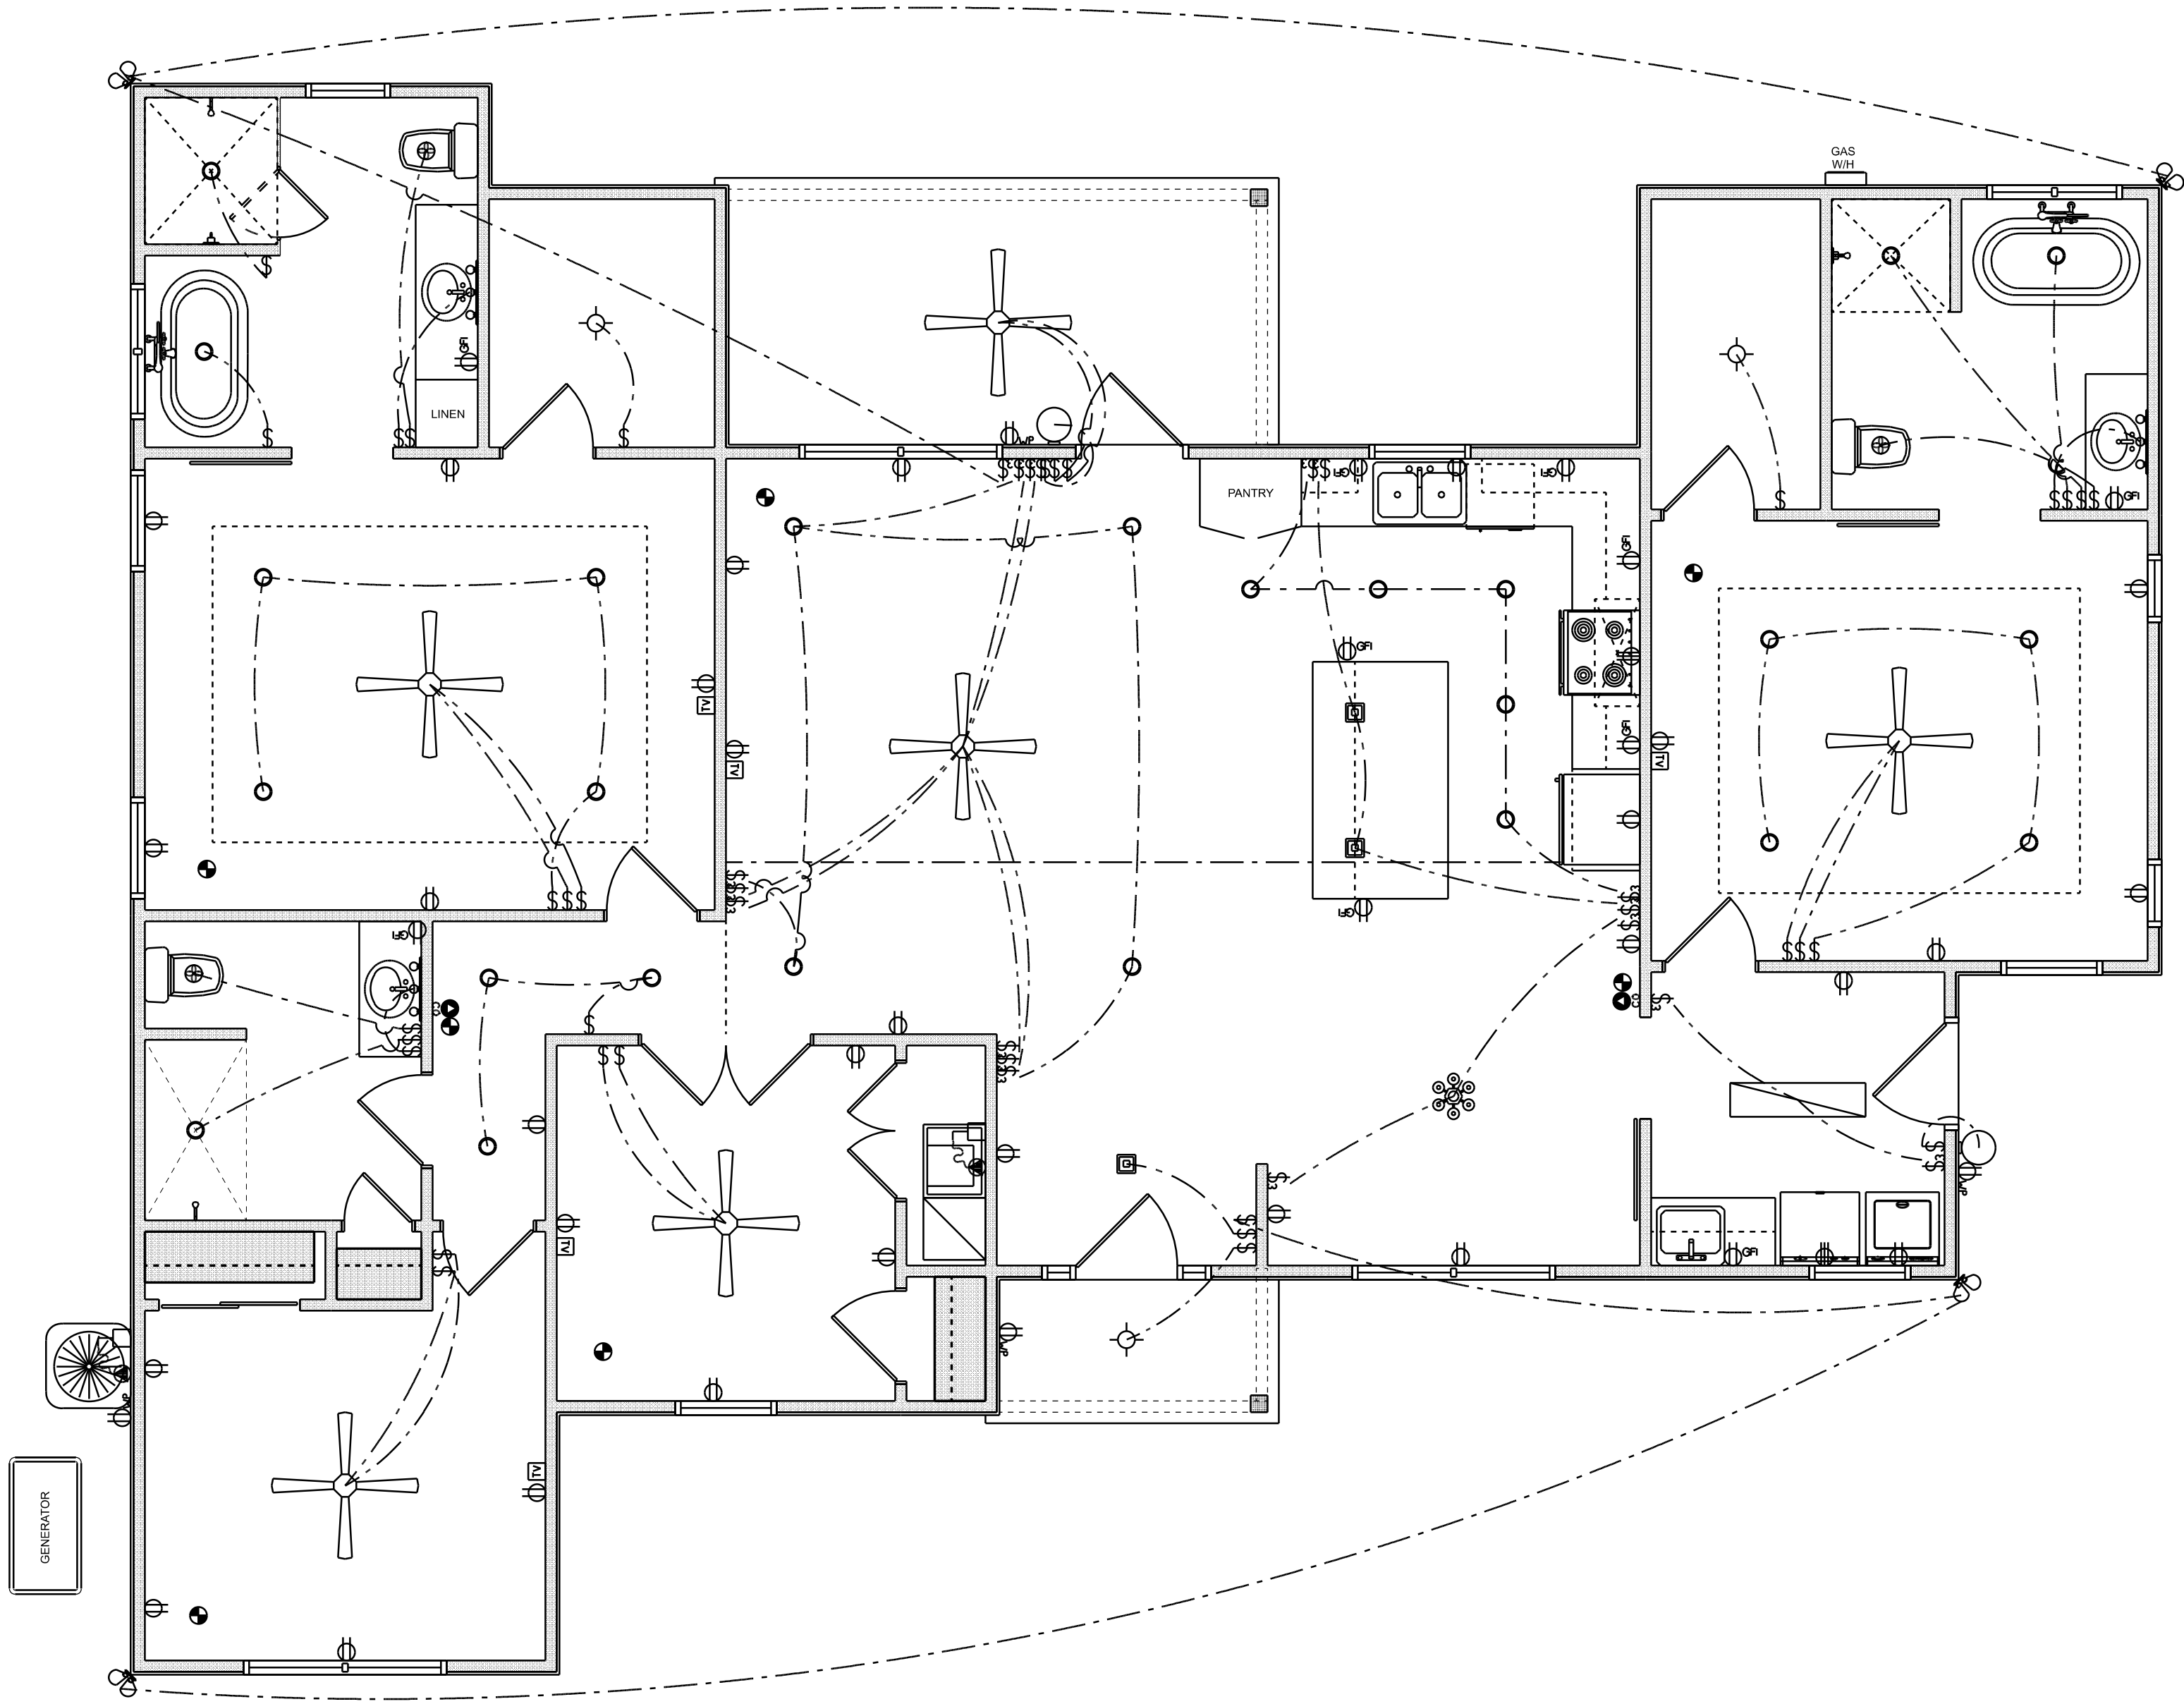

ELECTRICAL PLAN  
SCALE: 1/4" = 1'-0"

| REVISIONS SCHEDULE |                  |  |  |
|--------------------|------------------|--|--|
| PROPOSAL           | June 20th, 2023  |  |  |
| REVISIONS          | Aug. 29th, 2023  |  |  |
| REVERSED DRWG      | Sept. 25th, 2023 |  |  |
|                    |                  |  |  |

CUSTOM HOME FOR:  
**COPPOCK RESIDENCE**  
BRADFORD COUNTY, FL

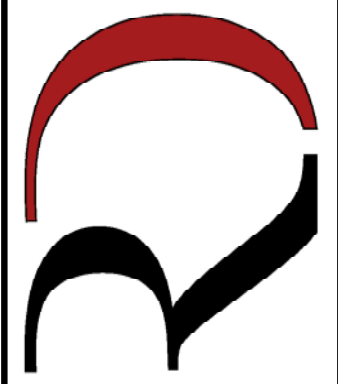**RIDGEPOINT  
DESIGN**

566 SW ARLINGTON BLVD STE 101, LAKE CITY, FL 32025  
P: 386-788-1188  
E: RIDGEPOINTDESIGN@GMAIL.COM