



IT IS THE OWNER AND OR THE CONTRACTORS RESPONSIBILITY TO VERIFY ALL STRUCTURAL ASPECTS OF THESE DRAWINGS, THIS INCLUDES BUT NOT LIMITED TO DIMENSIONS, WALL HEIGHTS AND MATERIAL, WINDOW SIZE AND LOCATION, ALSO ALL STATE AND LOCAL CODES MUST BE FOLLOWED BY EXCEPTING THESE PLANS OWNERS EXCEPTS ALL RESPONSIBILITY AND DOES NOT HOLD COLACINO DRAFTING AND DESIGN LIABLE FOR ANY ERRORS OR OMISSIONS

ALL WINDOWS AND DOORS TO BE INSTALLED PER MANUFACTURERS RECOMMENDATIONS AND MUST COMPLY WITH CURRENT CODES, SUBMIT ATTACHMENT WORKSHEET WITH PERMIT DOCUMENTS

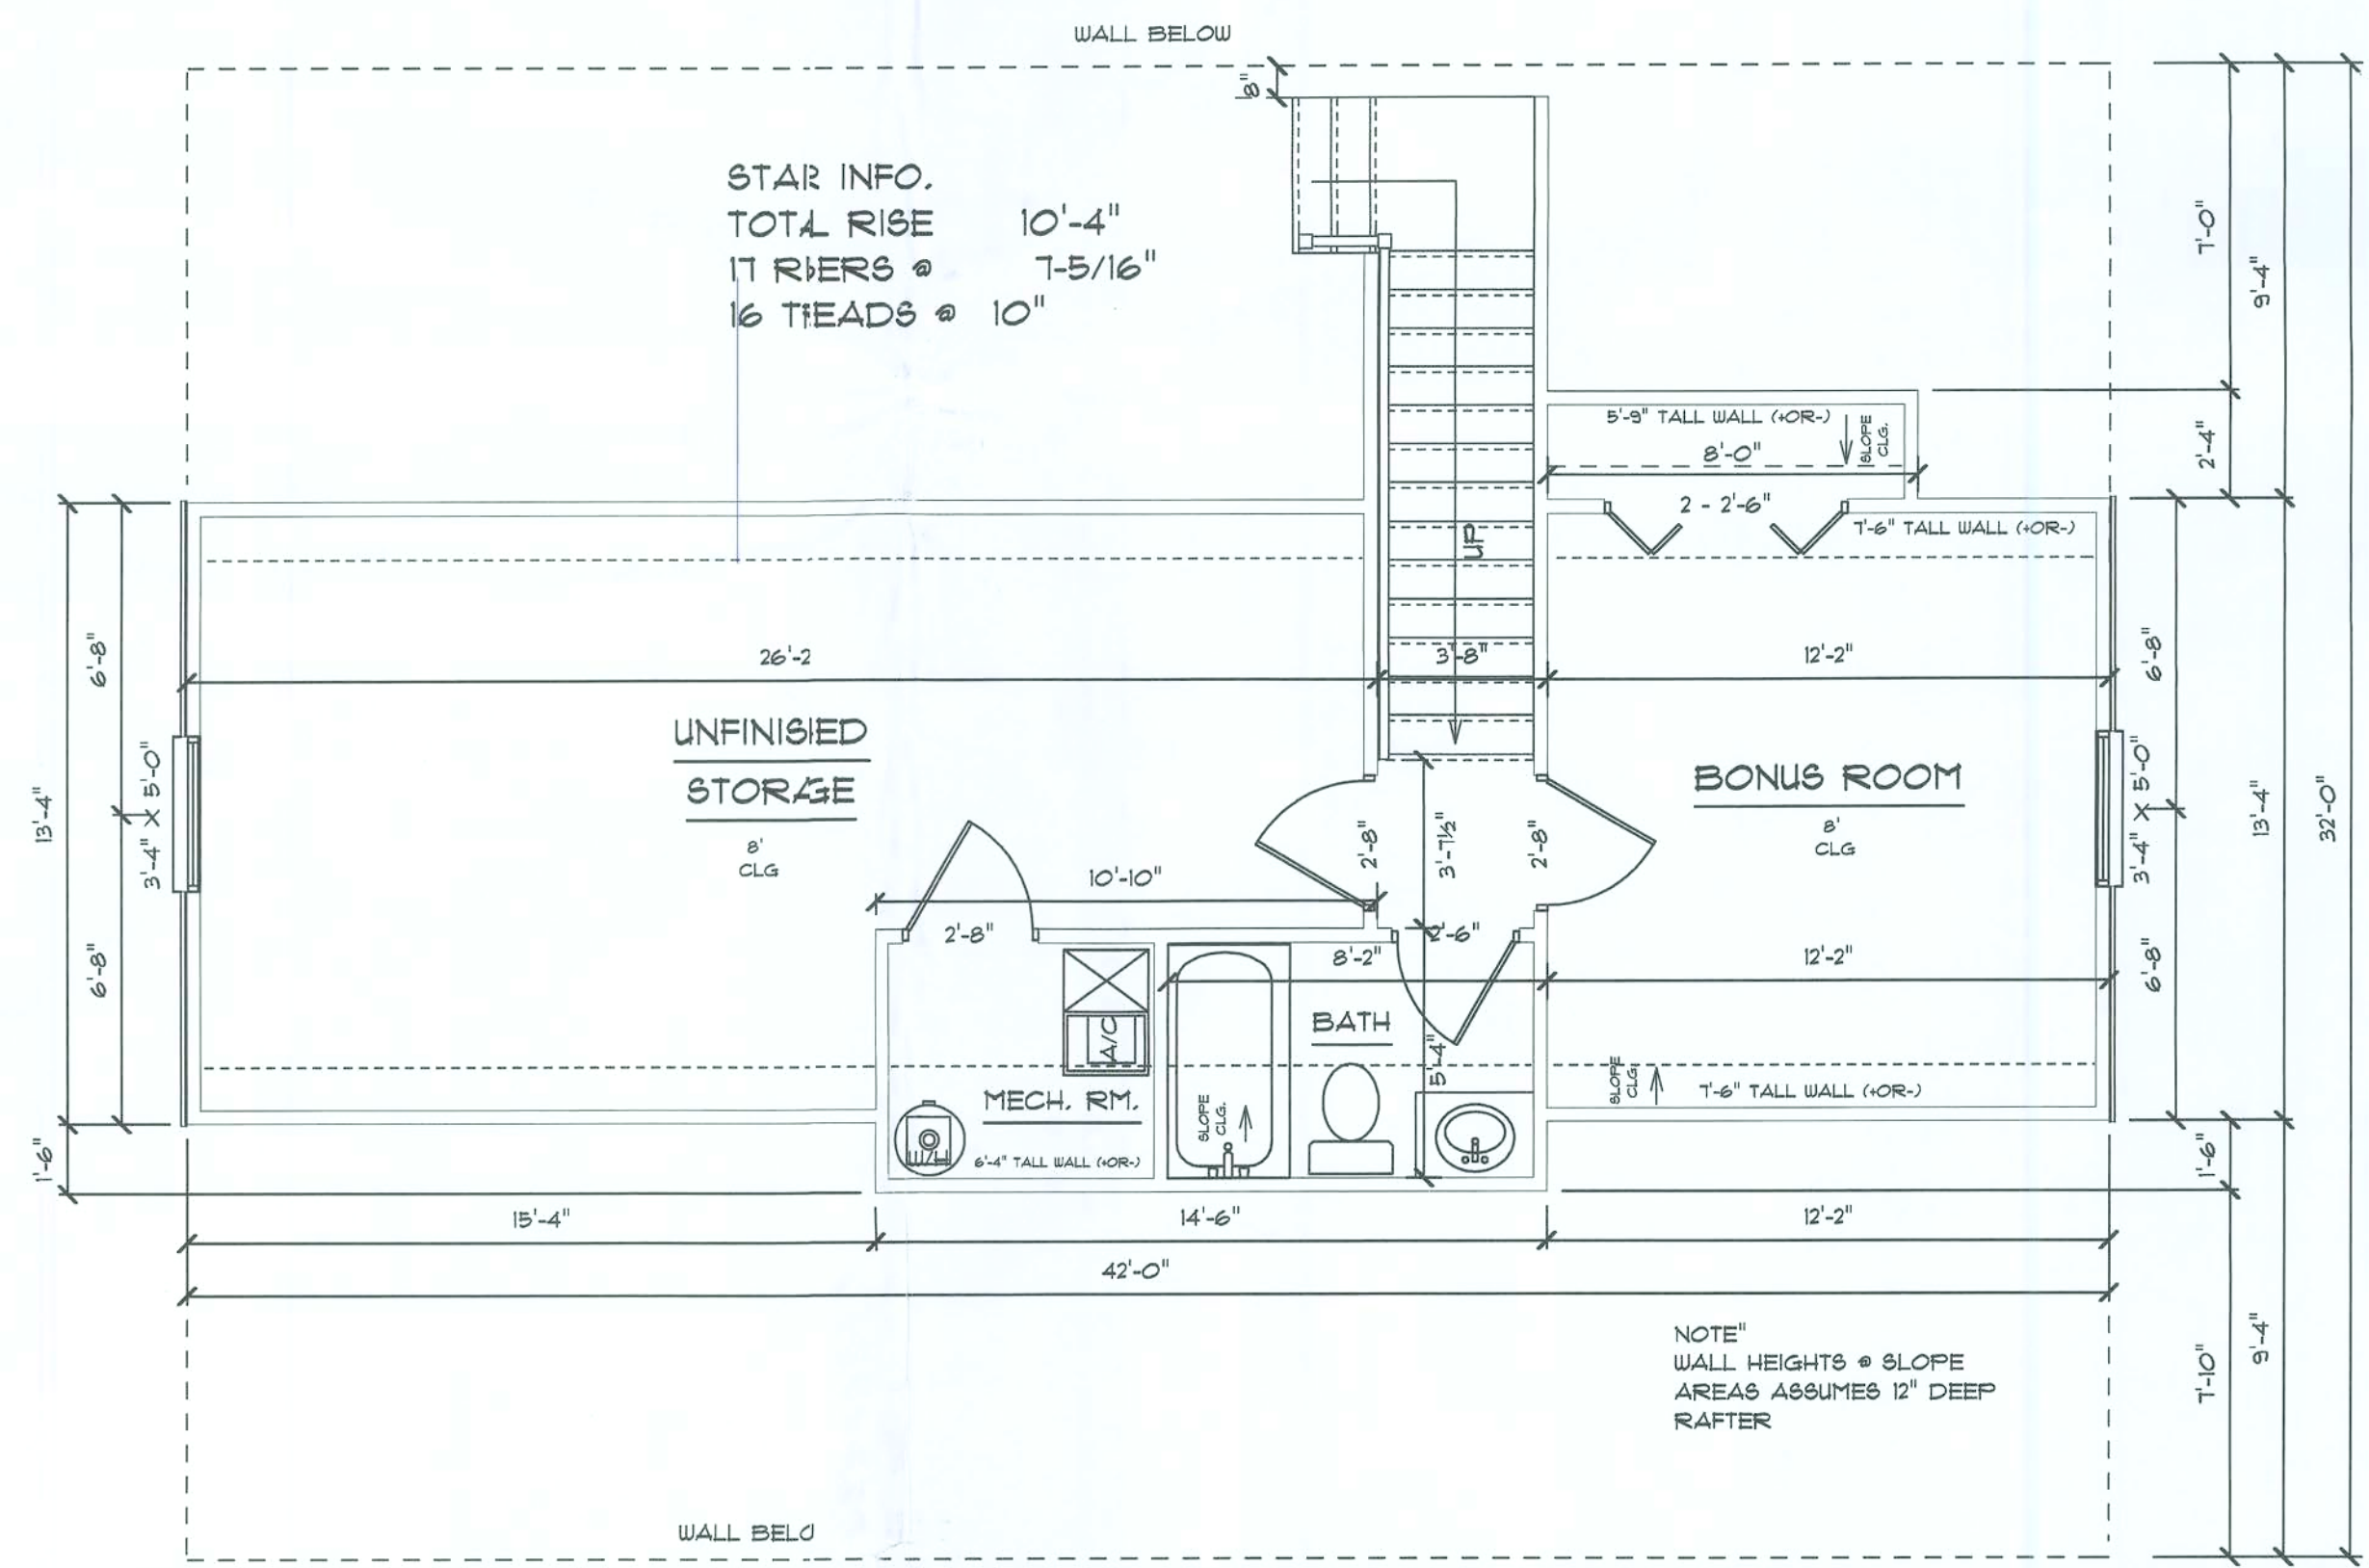

2nd FLOOR PLAN

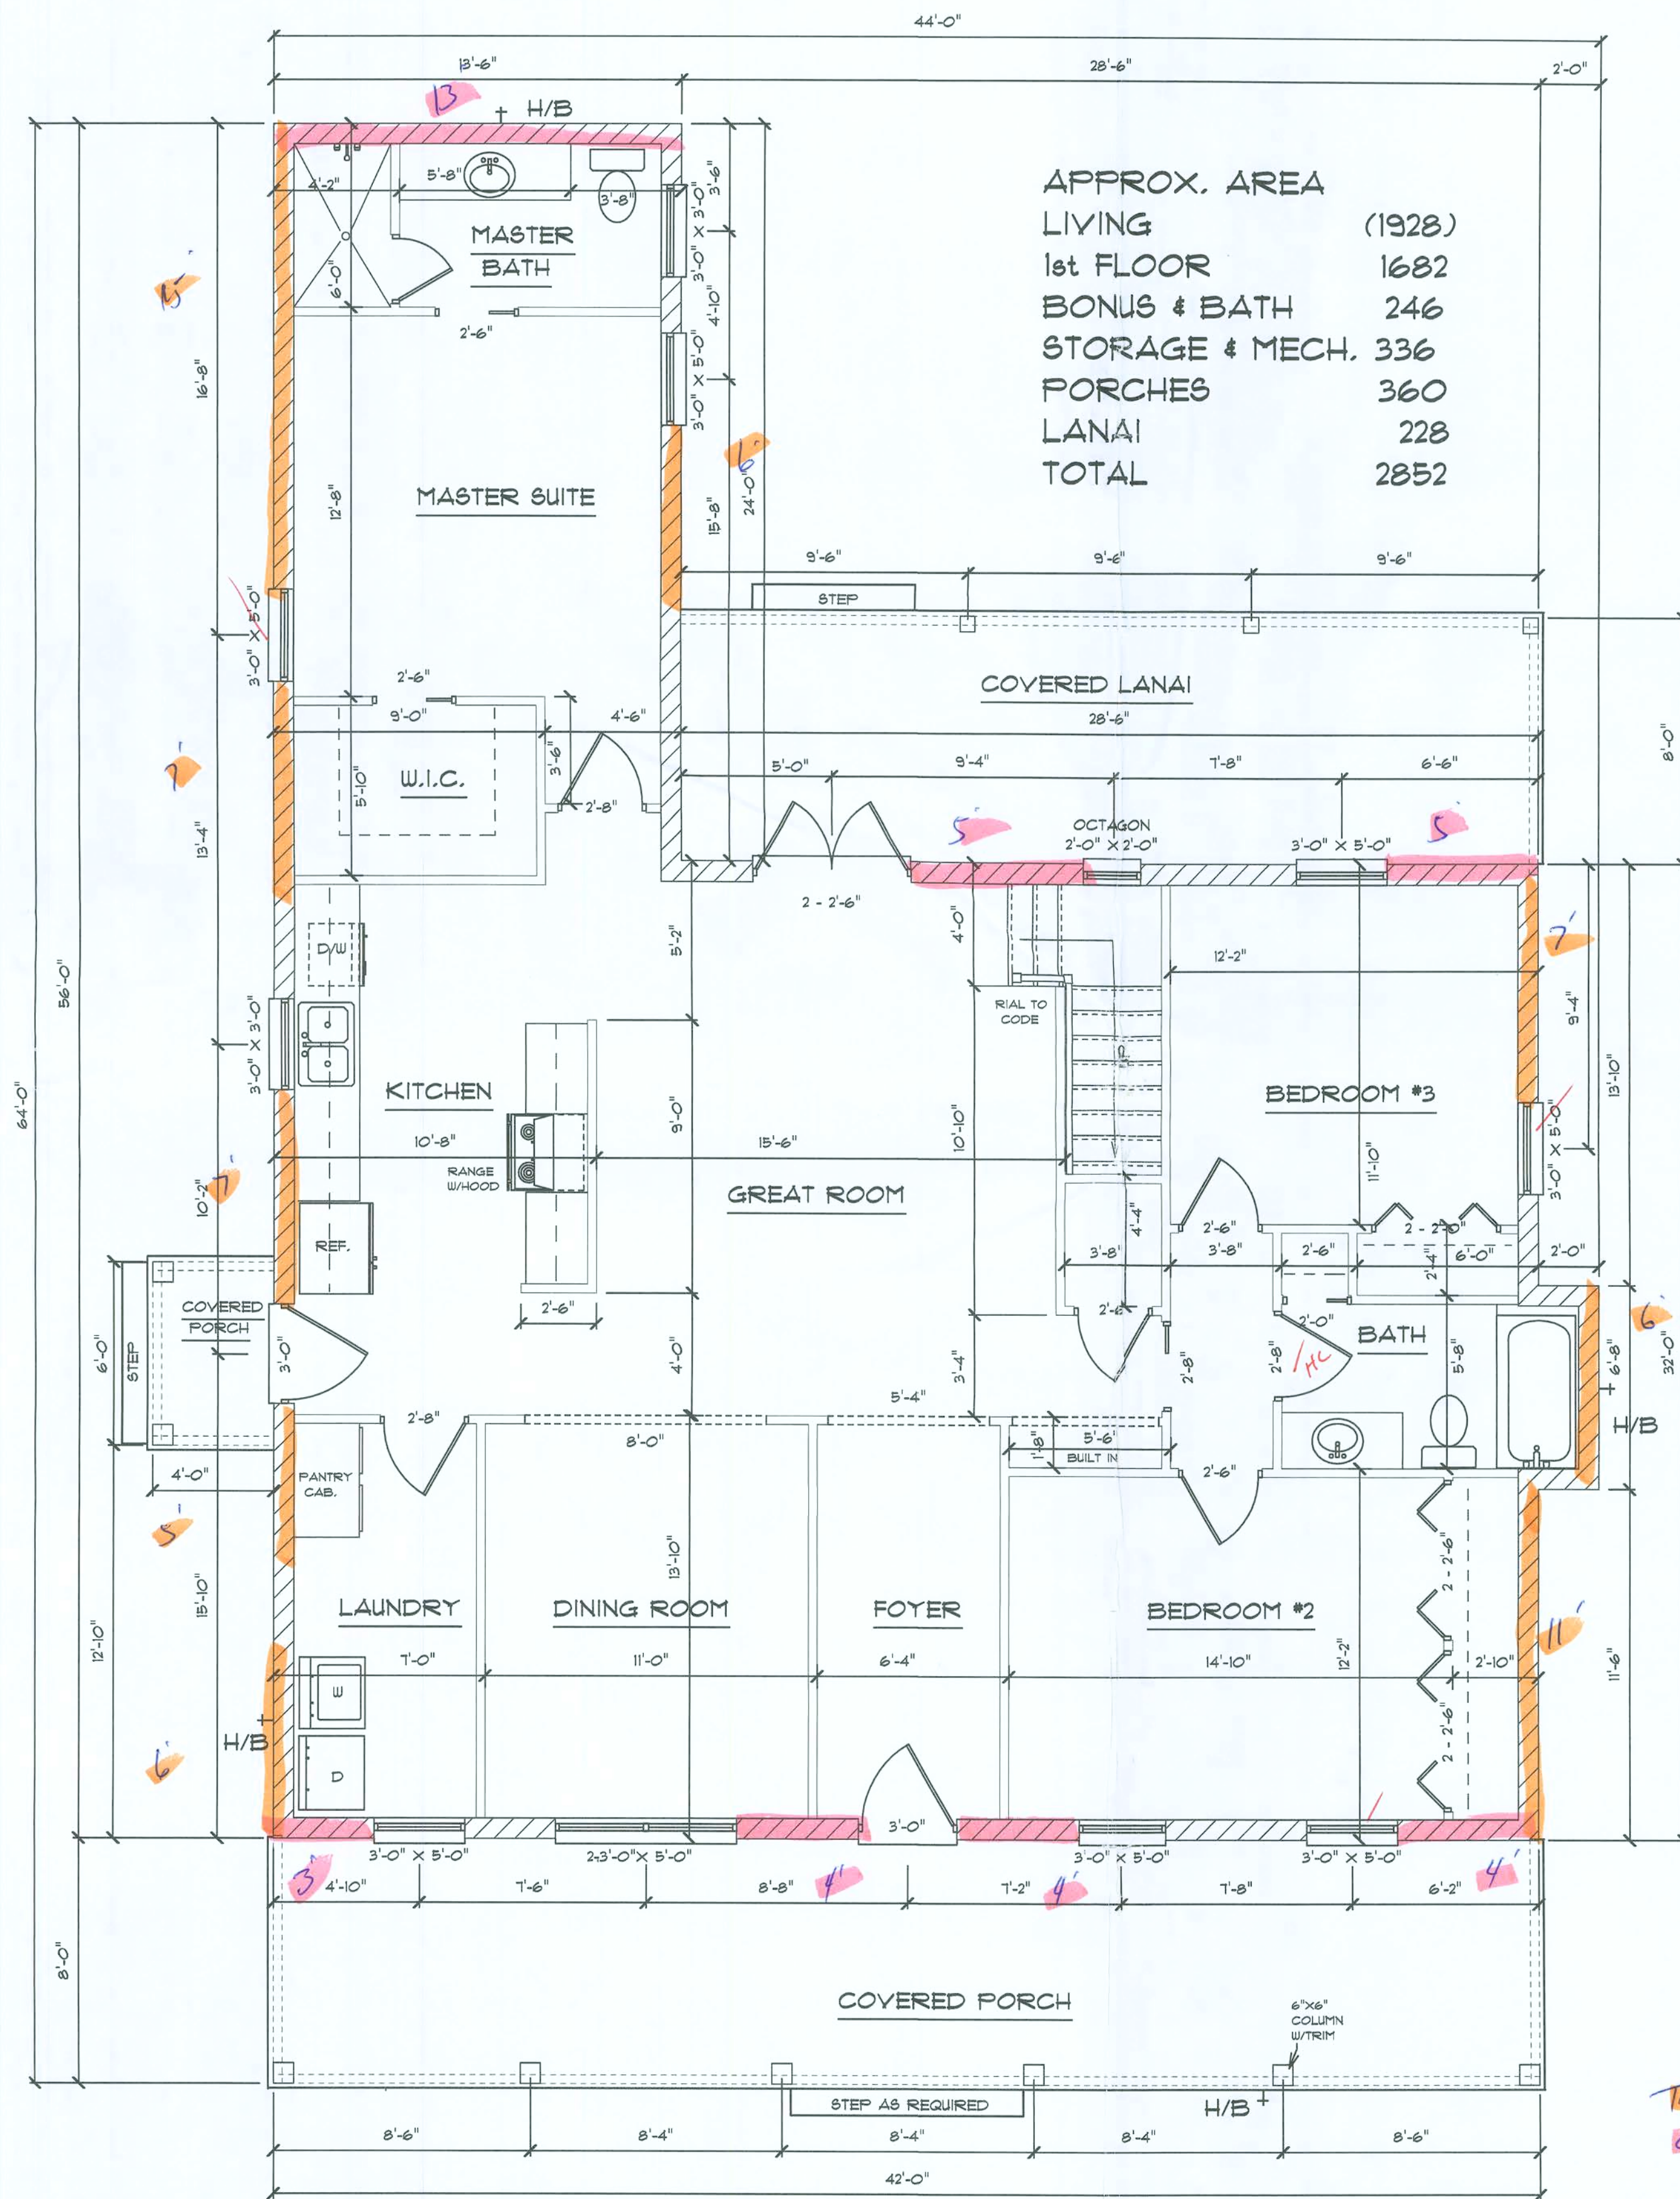

MAIN FLOOR PLAN

HINTON RESIDENCE

SCALE 1/4" = 1'

DRAWN BY P.A.C.

APPROVED

COLACINO DRAFTING & DESIGN
PH. 352-472-3462

DATE 2/1/07


REVISION

REVISION

REVISION

1



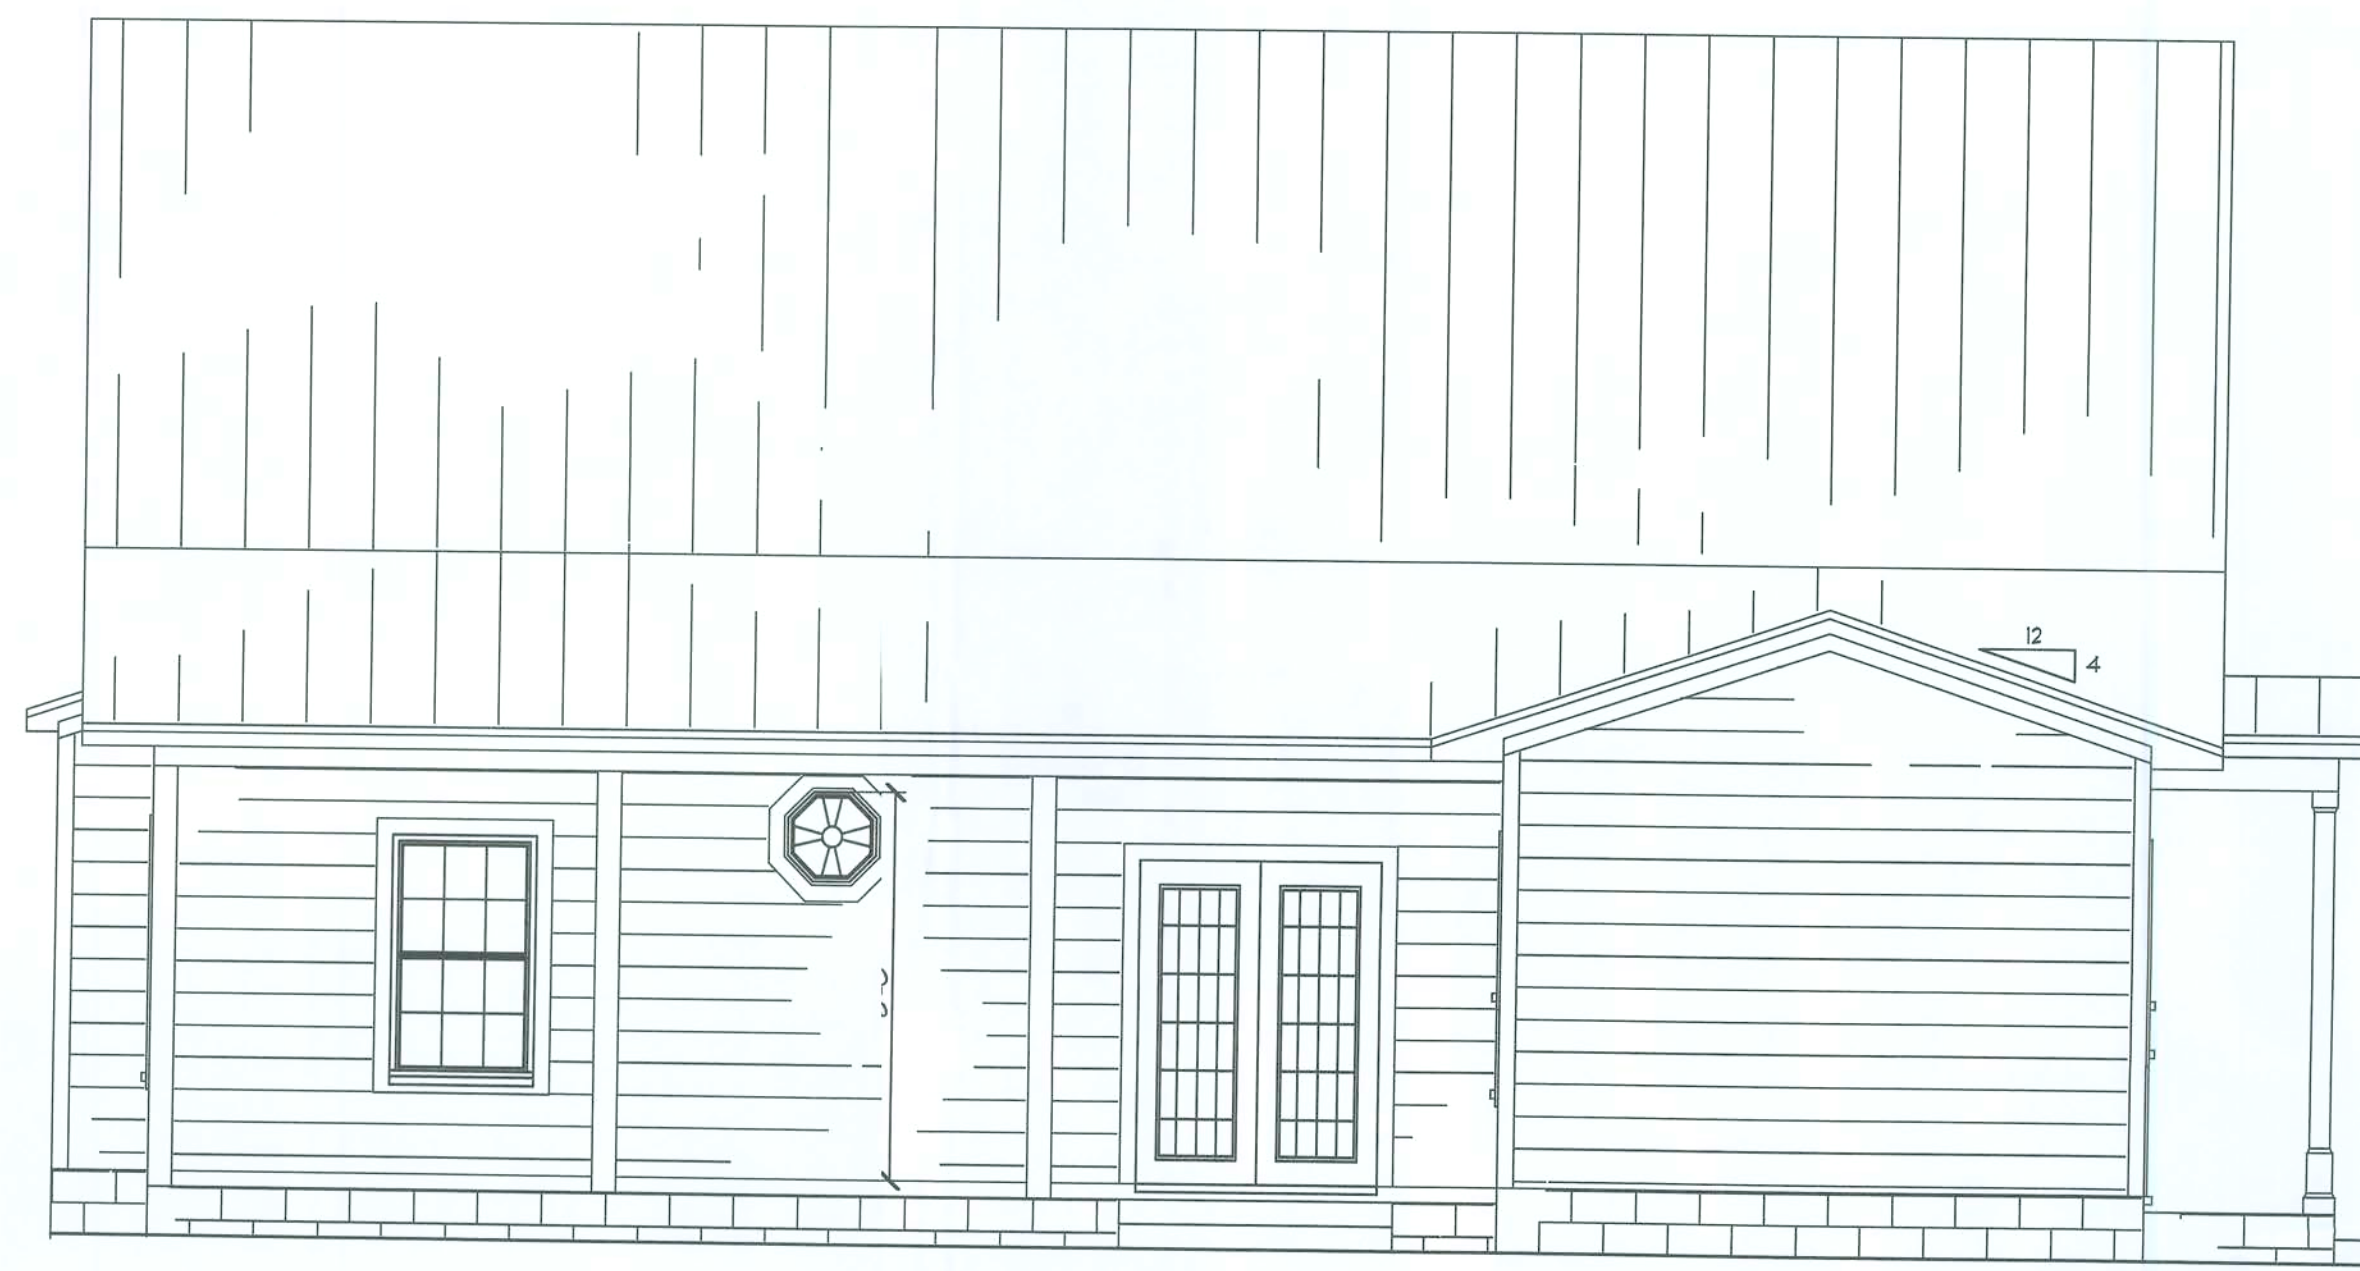

REAR ELEVATION



FRONT ELEVATION

HARDIE SIDING



RIGHT ELEVATION



LEFT ELEVATION

3

DATE 2/1/07

COLACINO
DRAFTING&DESIGN
PH. 352-472-3462

SCALE 1/4" = 1'


DRAWN BY P.A.C.

APPROVED

HINTON RESIDENCE



ELECTRICAL SYMBOLS	
OUTLET	
220 OUTLET	
SWITCH	
1 LIGHT	
RECESS 3 LIGHT	
FULL C CHAIN	
FLUORESCENT	
CEILING FAN	
WALL MOUNT 1 LIGHT	
VANITY 1 LIGHT	
FLOOD 1 LIGHT	
CLG. LIFE/FAN	
PANEL	
SMOKE DETECTOR	

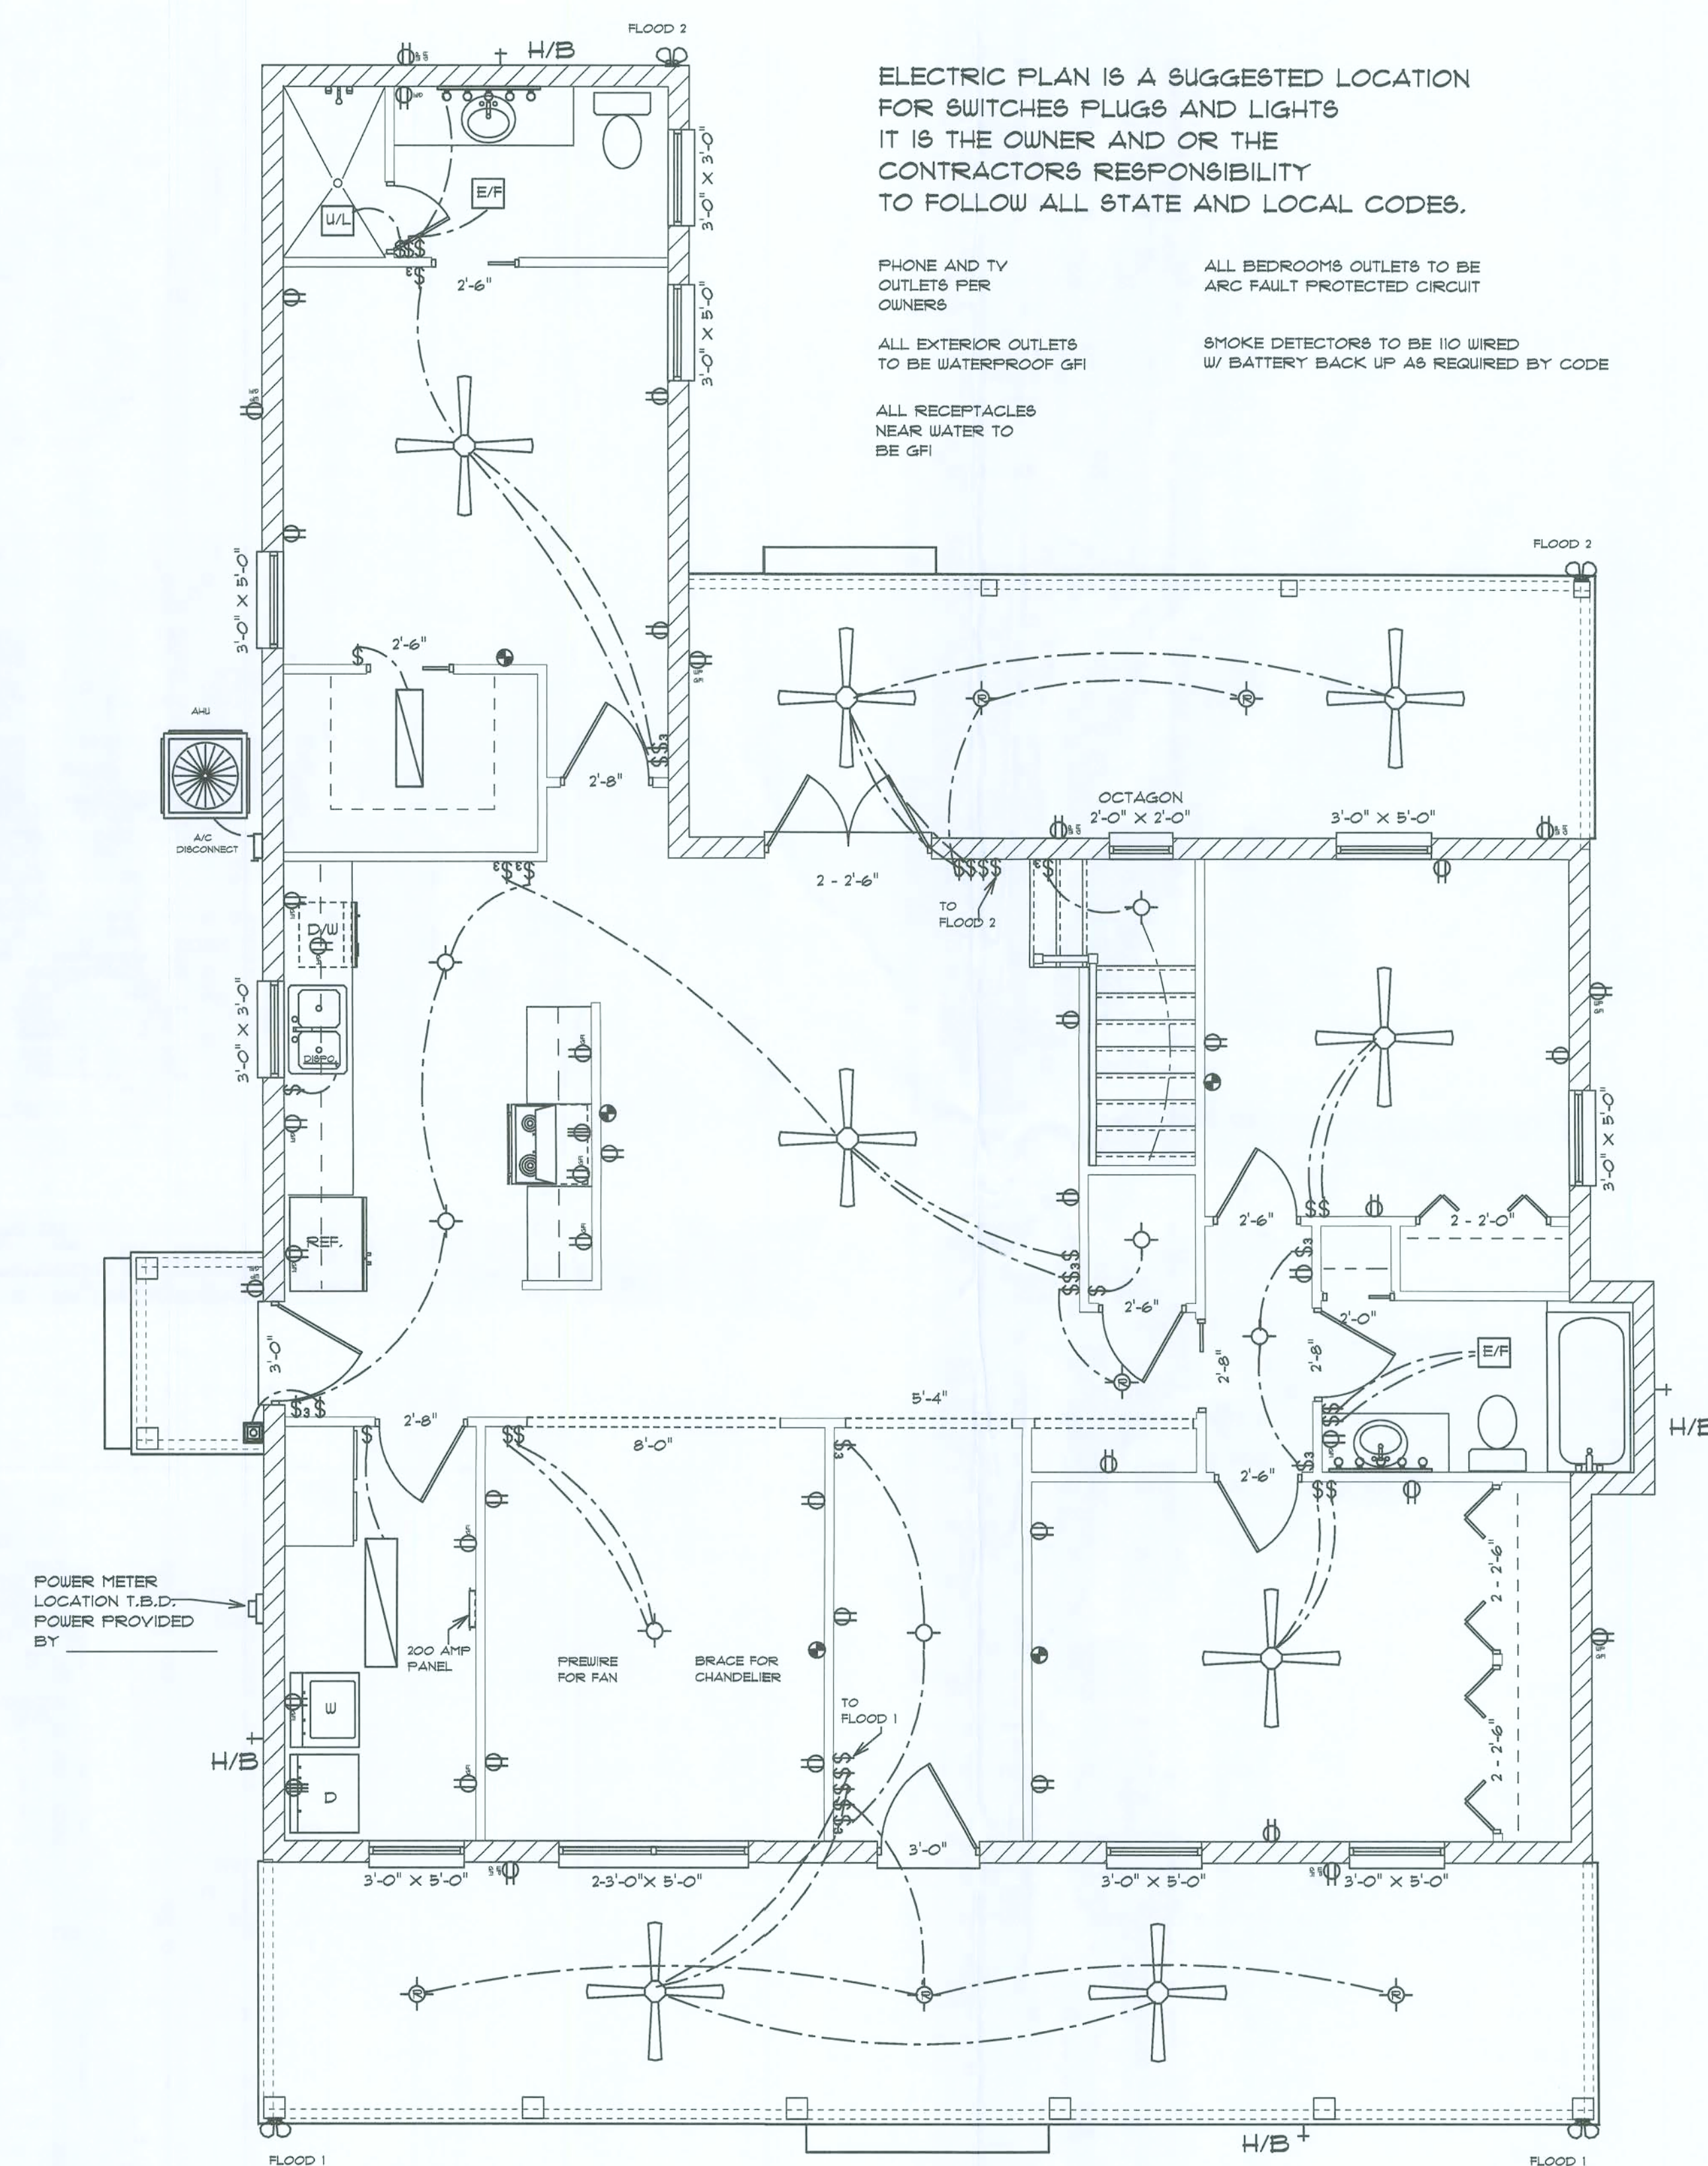

ELECTRICAL PLAN

ELECTRIC PLAN IS A SUGGESTED LOCATION
FOR SWITCHES PLUGS AND LIGHTS
IT IS THE OWNER AND OR THE
CONTRACTORS RESPONSIBILITY
TO FOLLOW ALL STATE AND LOCAL CODES.

PHONE AND TV
OUTLETS PER
OWNERS

ALL EXTERIOR OUTLETS
TO BE WATERPROOF GFI

ALL RECEPTACLES
NEAR WATER TO
BE GFI

ALL BEDROOMS OUTLETS TO BE
ARC FAULT PROTECTED CIRCUIT

SMOKE DETECTORS TO BE IIO WIRED
W/ BATTERY BACK UP AS REQUIRED BY CODE