


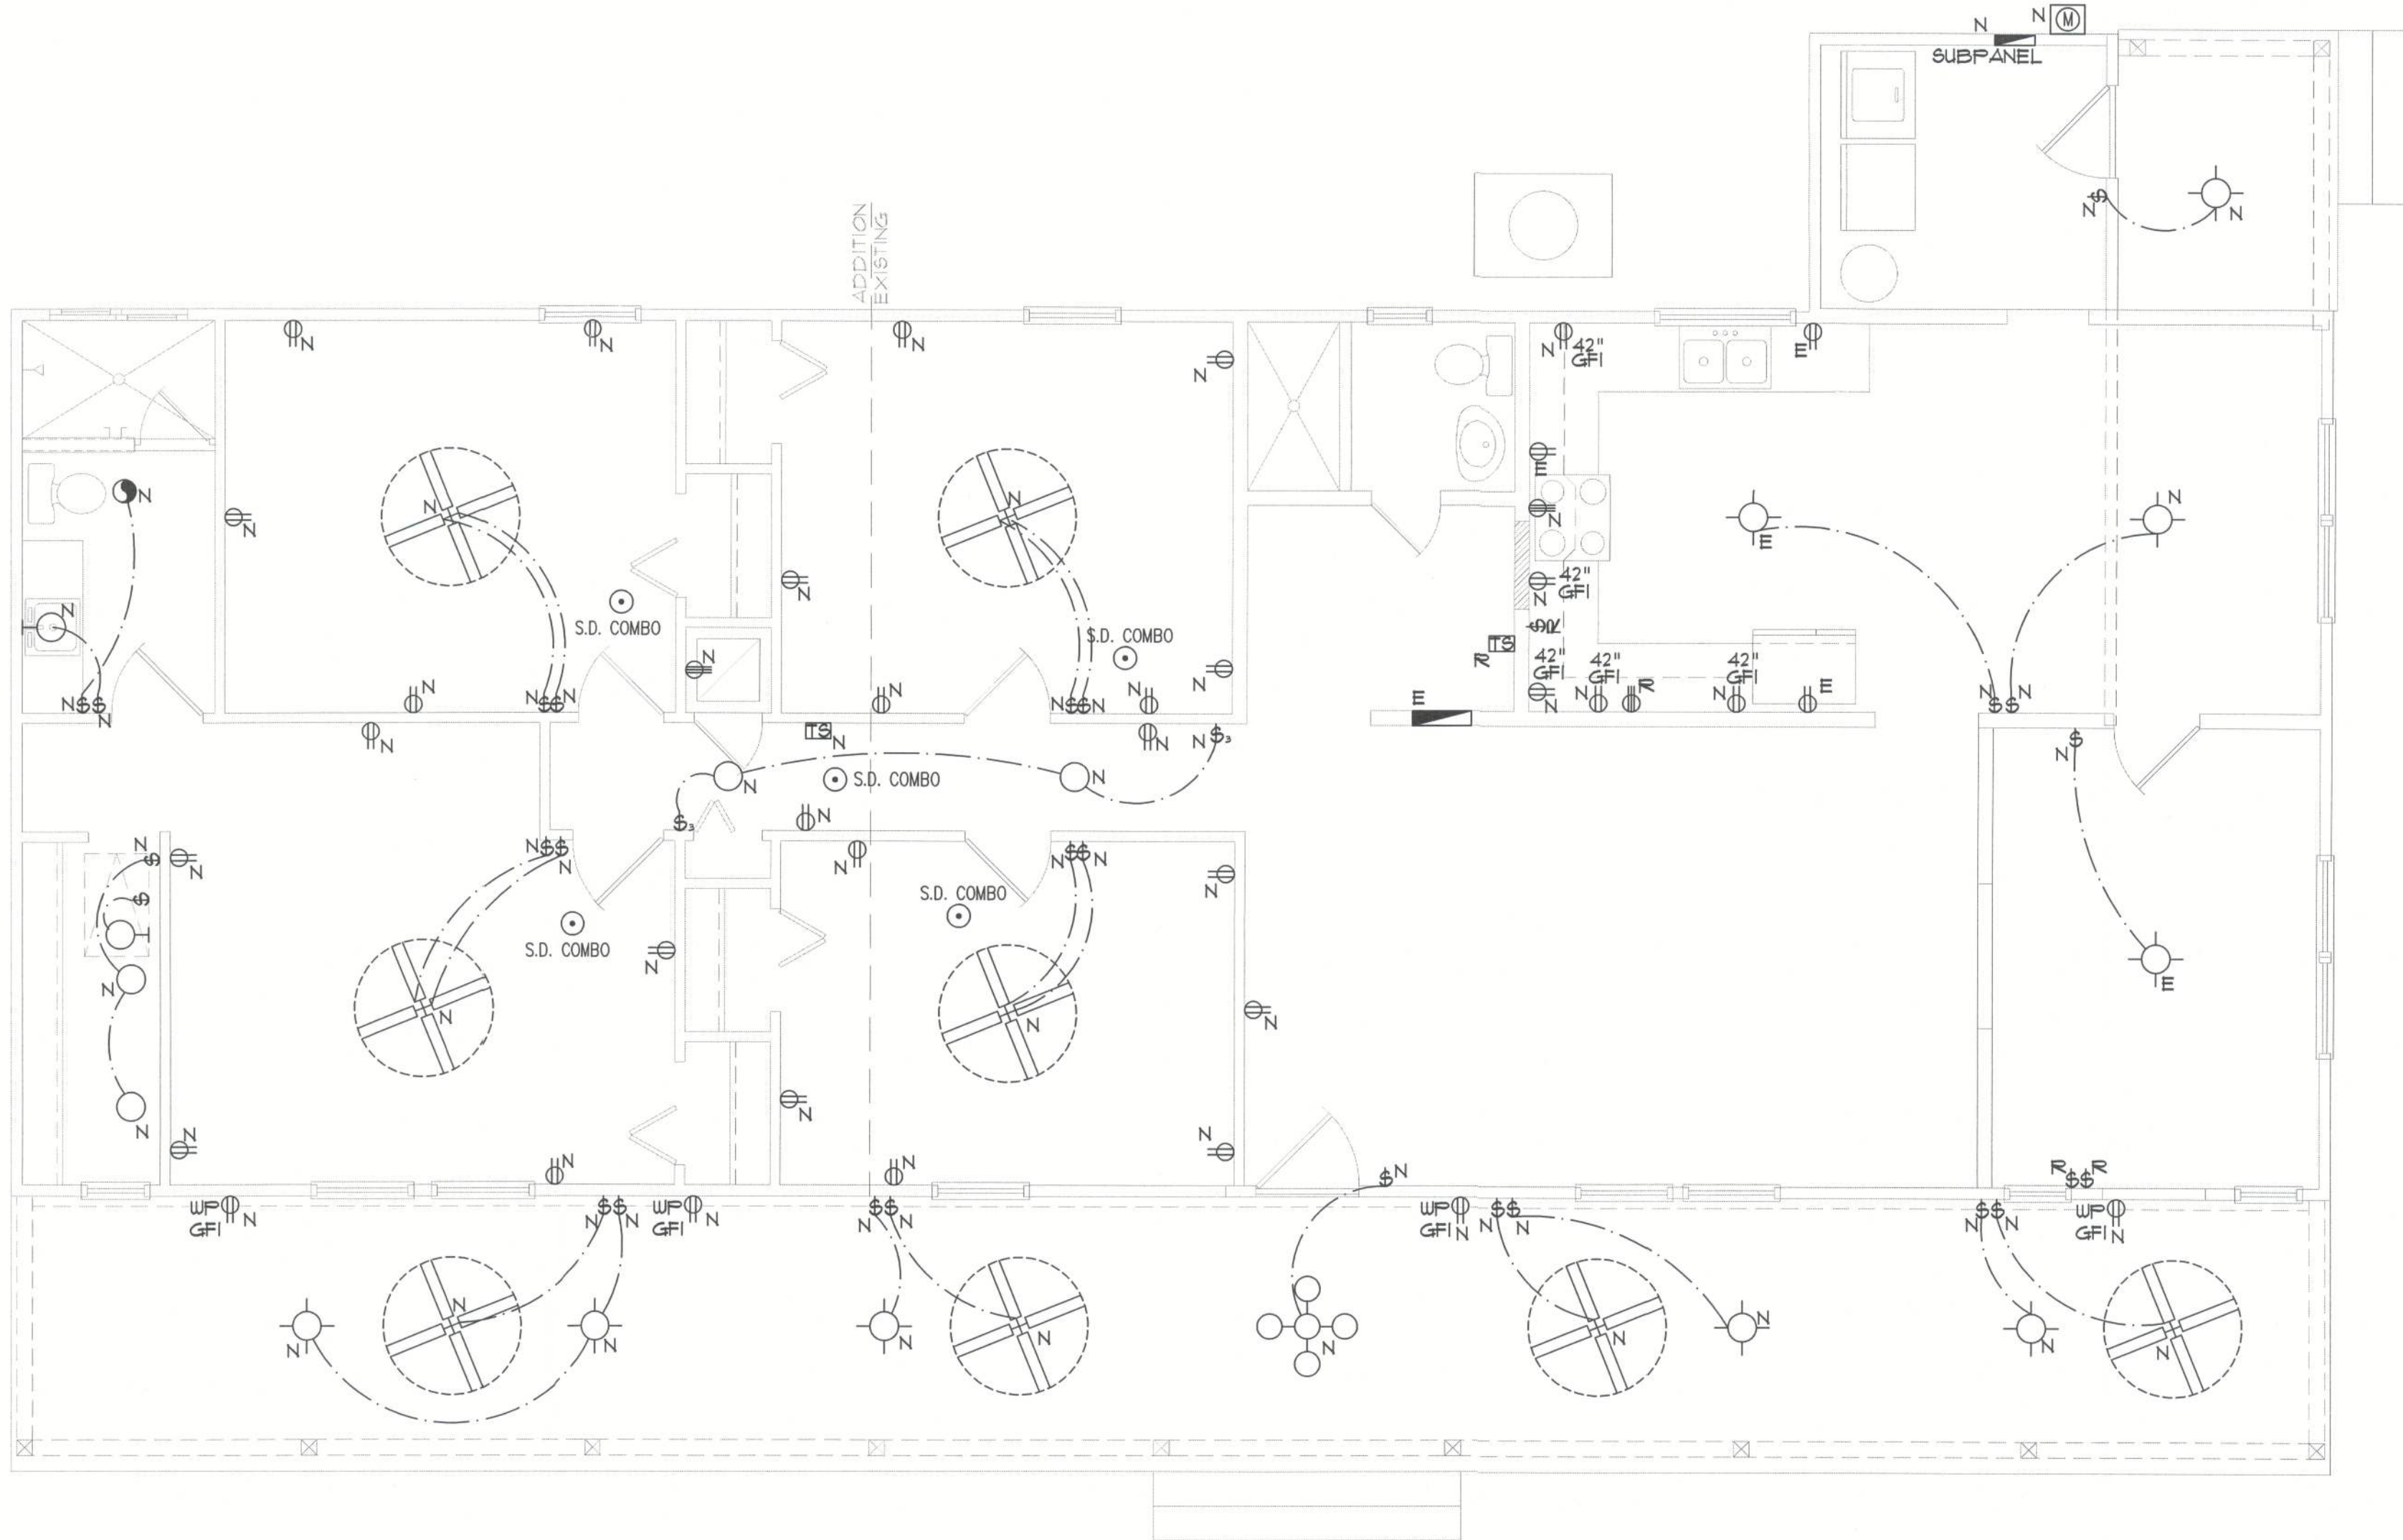

Proposed Right Elevation
SCALE: 1/4" = 1'-0"

ELECTRICAL LEGEND

	Ceiling Mounted Light		Water Proof Receptacle		Cable Jack		Ceiling Fan		Speaker
	Pull Chain Light		Floor Receptacle		Pre-Wire Garage Door Opener		Wall Sconce		Junction Box
	Recessed Light		Outlet in Ceiling		Fluorescent Light		Chandelier		Track Lighting
	Ceiling Mounted LED		Ground Fault Interrupt		Electrical Panel		Intercom		Theatrical Strip
	Wall Mounted Light		Wall Switch		Chime		Spot Light		NEW EXISTING REPLACE
	Wall Wash Recessed		3-Way Switch		Door Bell/Garage Door Switch		Flush Mount Fluorescent Light		
	Duplex Receptacle		Dimmer Switch		Disconnect Switch		Fan/Light Combination		
	220 V Receptacle		Telephone Jack		Electrical Meter		Garbage Disposal Motor		
	1/2 hot, 1/2 switched		Ethernet		S.D. Smoke Detector				

NOTES:

1. ALL SMOKE DETECTORS ARE TO BE HARD WIRED AND INTERCONNECTED.
2. PROVIDE ARC FAULT PROTECTION IN ALL LIVING SPACES, EXCEPT IN BATHROOMS, KITCHEN, LAUNDRY, AND GARAGES.
3. USE COMBINATION SMOKE AND CARBON MONOXIDE ALARMS, OR PROVIDE A CARBON MONOXIDE ALARM (IN ADDITION TO SMOKE) WITHIN 10' OF EACH ROOM USED FOR SLEEPING PURPOSES (SEE FBOR 2010, SEC. R315)
4. EXACT LOCATIONS OF FIXTURES AND/OR OUTLETS ARE SUGGESTED AND MEET MOST LOCAL CODE REQUIREMENTS. ADDITIONS OR ADJUSTMENTS MAY BE MADE BETWEEN OWNER AND BUILDER IN THE FIELD.



THE FINAL PLAN, INC.

WWW.THEFINALPLAN.COM
TEL. 352.410.2539

CUSTOM DESIGNS, SPACE PLANNING
TENANT BUILD OUTS, ADDITIONS, REMODELS

PARRISH ADDITION
151 SE SHADY WAY
LULL, FLORIDA

job no
PARRISH
drawn by
DA
checked
DA
date
08/03/22
scale
AS NOTED
drawing no.

1