


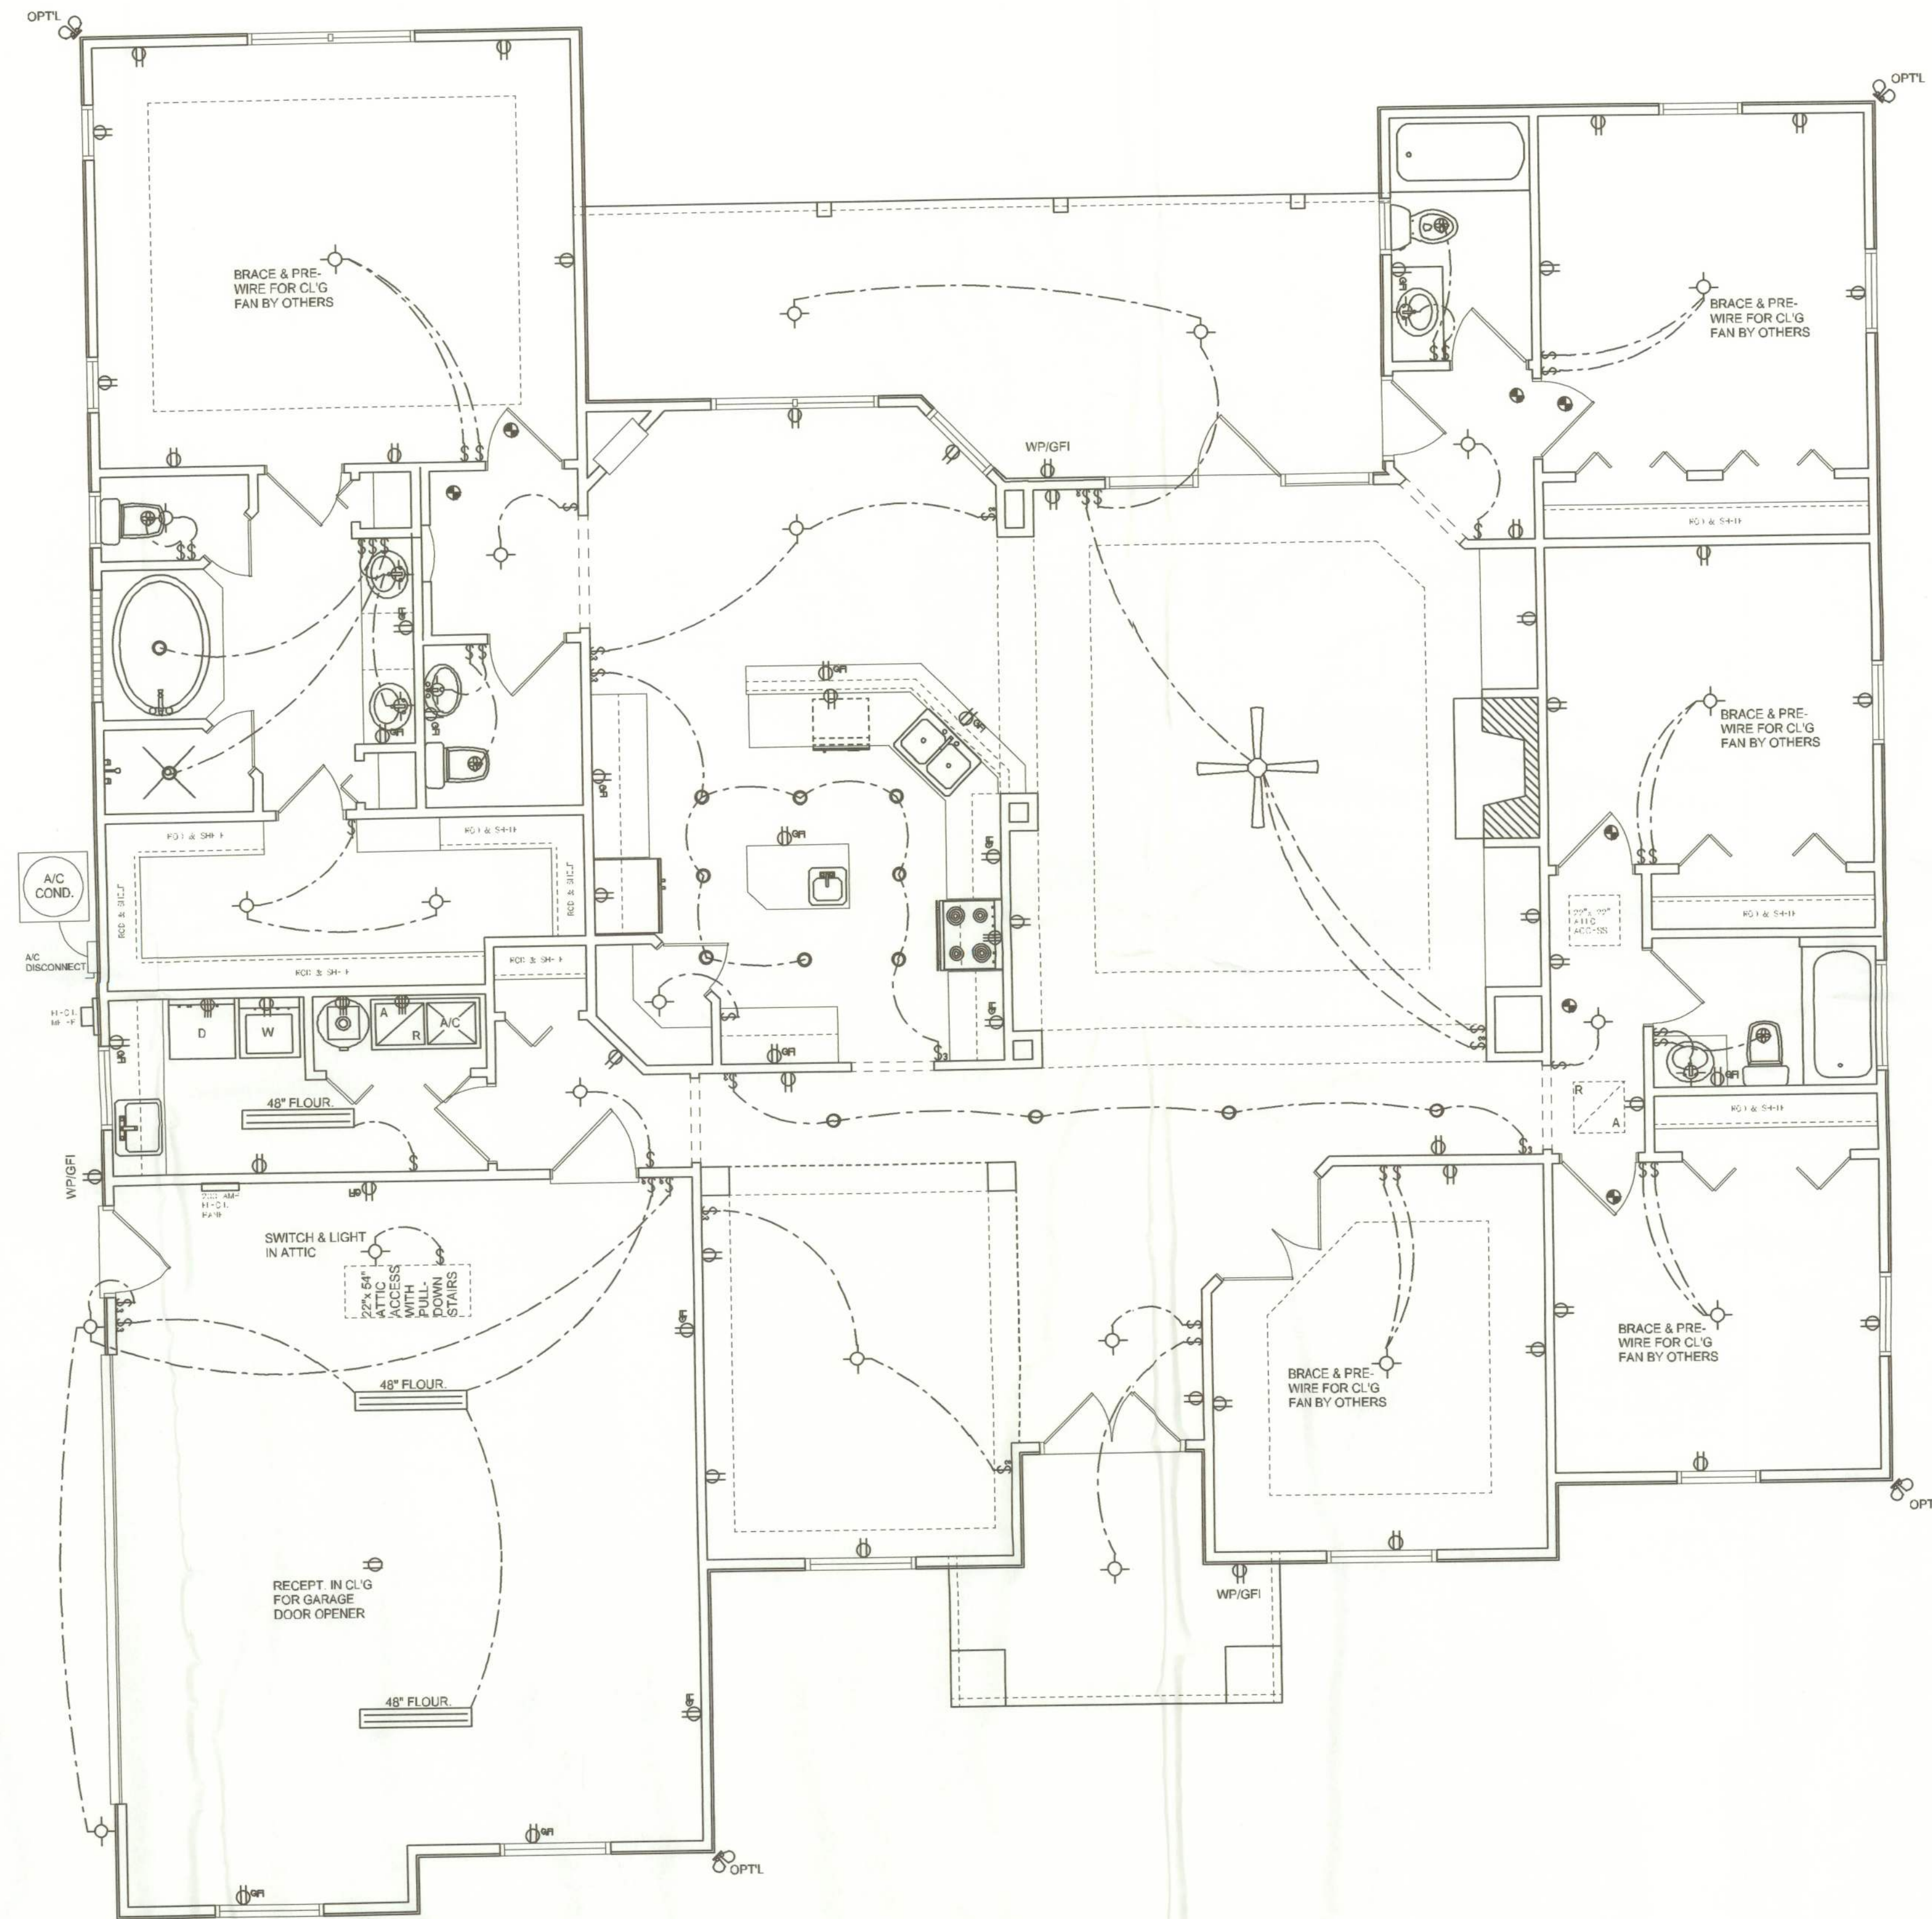

**ELECTRICAL PLAN**  
SCALE: 1/4" = 1'-0"

| ELECTRICAL LEGEND |                                         |
|-------------------|-----------------------------------------|
|                   | CEILING FAN<br>(PRE-WIRE FOR LIGHT KIT) |
|                   | DOUBLE SECURITY LIGHT                   |
|                   | RECESSED CAN LIGHT                      |
|                   | BATH EXHAUST FAN                        |
|                   | LIGHT FIXTURE                           |
|                   | DUPLEX OUTLET                           |
|                   | 220V OUTLET                             |
|                   | GFI DUPLEX OUTLET                       |
|                   | SMOKE DETECTOR (see note below)         |
|                   | WALL SWITCH                             |
|                   | 3 WAY WALL SWITCH                       |
|                   | WATER PROOF GFI OUTLET                  |
|                   | 2 OR 4 TUB FLUORESCENT FIXTURE          |


NOTE:  
ALL BEDROOM RECEPTACLES SHALL BE AFCI  
(ARC FAULT CIRCUIT INTERRUPT)

ALL SMOKE DETECTORS SHALL HAVE BATTERY BACKUP POWER  
AND ALL WIRED TOGETHER SO IF ANY ONE UNIT IS ACTUATED THEY  
ALL ACTIVATE.

| REVISIONS     |
|---------------|
| July 15, 2005 |




THE NORFOLK MODEL FOR:  
**LOT 10 COBBLESTONE**  
PROJECT ADDRESS: LOT 10, COBBLESTONE, COLUMBIA COUNTY, FLORIDA 32025  
**ISAC CONSTRUCTION, INC.**  
RT. 9 BOX 646 LAKE CITY, FLORIDA 32024

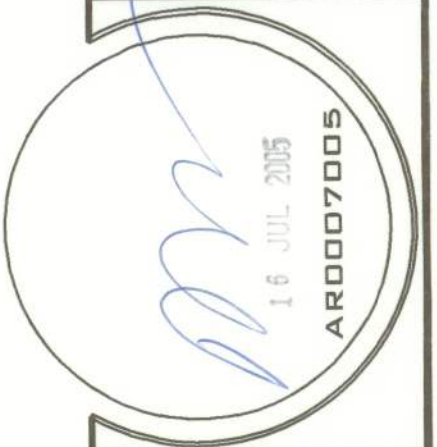

**NICHOLAS PAUL GEISLER ARCHITECT**  
N.C.A.R.B. Certified  
1756 NW Brown Rd.  
Lake City, FL 32055  
(386) 755-9021

JOINT VENTURED WITH

**©WILLIAM MYERS**  
DE-SIGN  
P.O. BOX 1513  
LAKE CITY, FL 32056  
(386) 758-8406  
will@willmyers.net

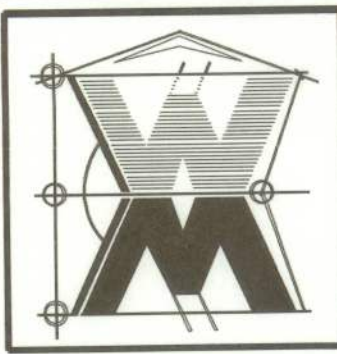

JOB NUMBER  
050710

SHEET NUMBER  
**A.3**  
OF 7 SHEETS

*Wm C Myers*