





FRONT ELEVATION
SCALE: 1/4" = 1'-0"

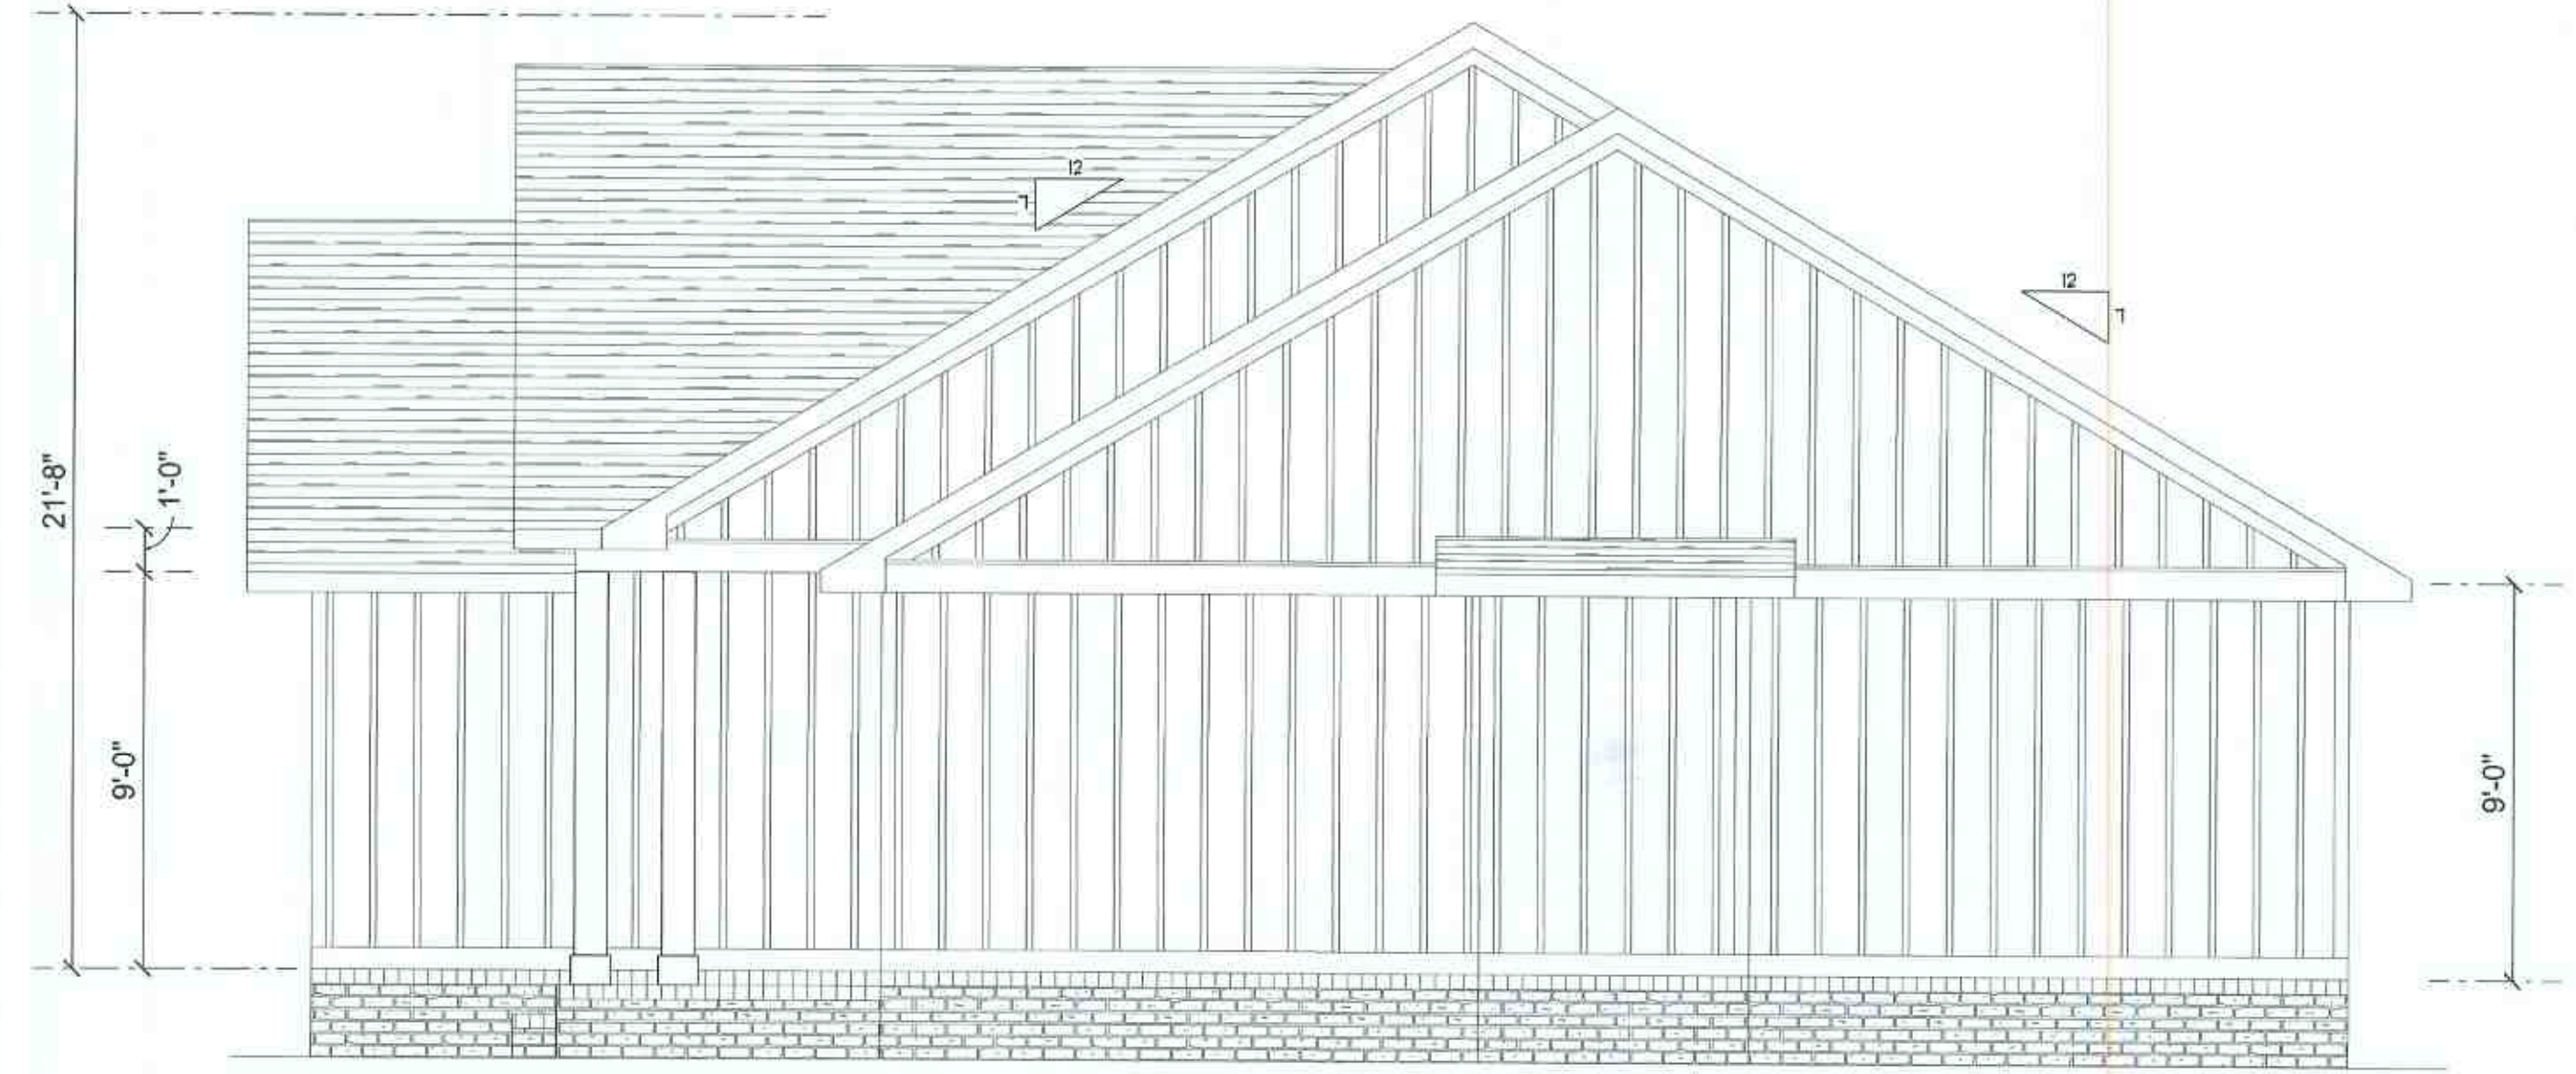

RIGHT ELEVATION
SCALE: 1/4" = 1'-0"

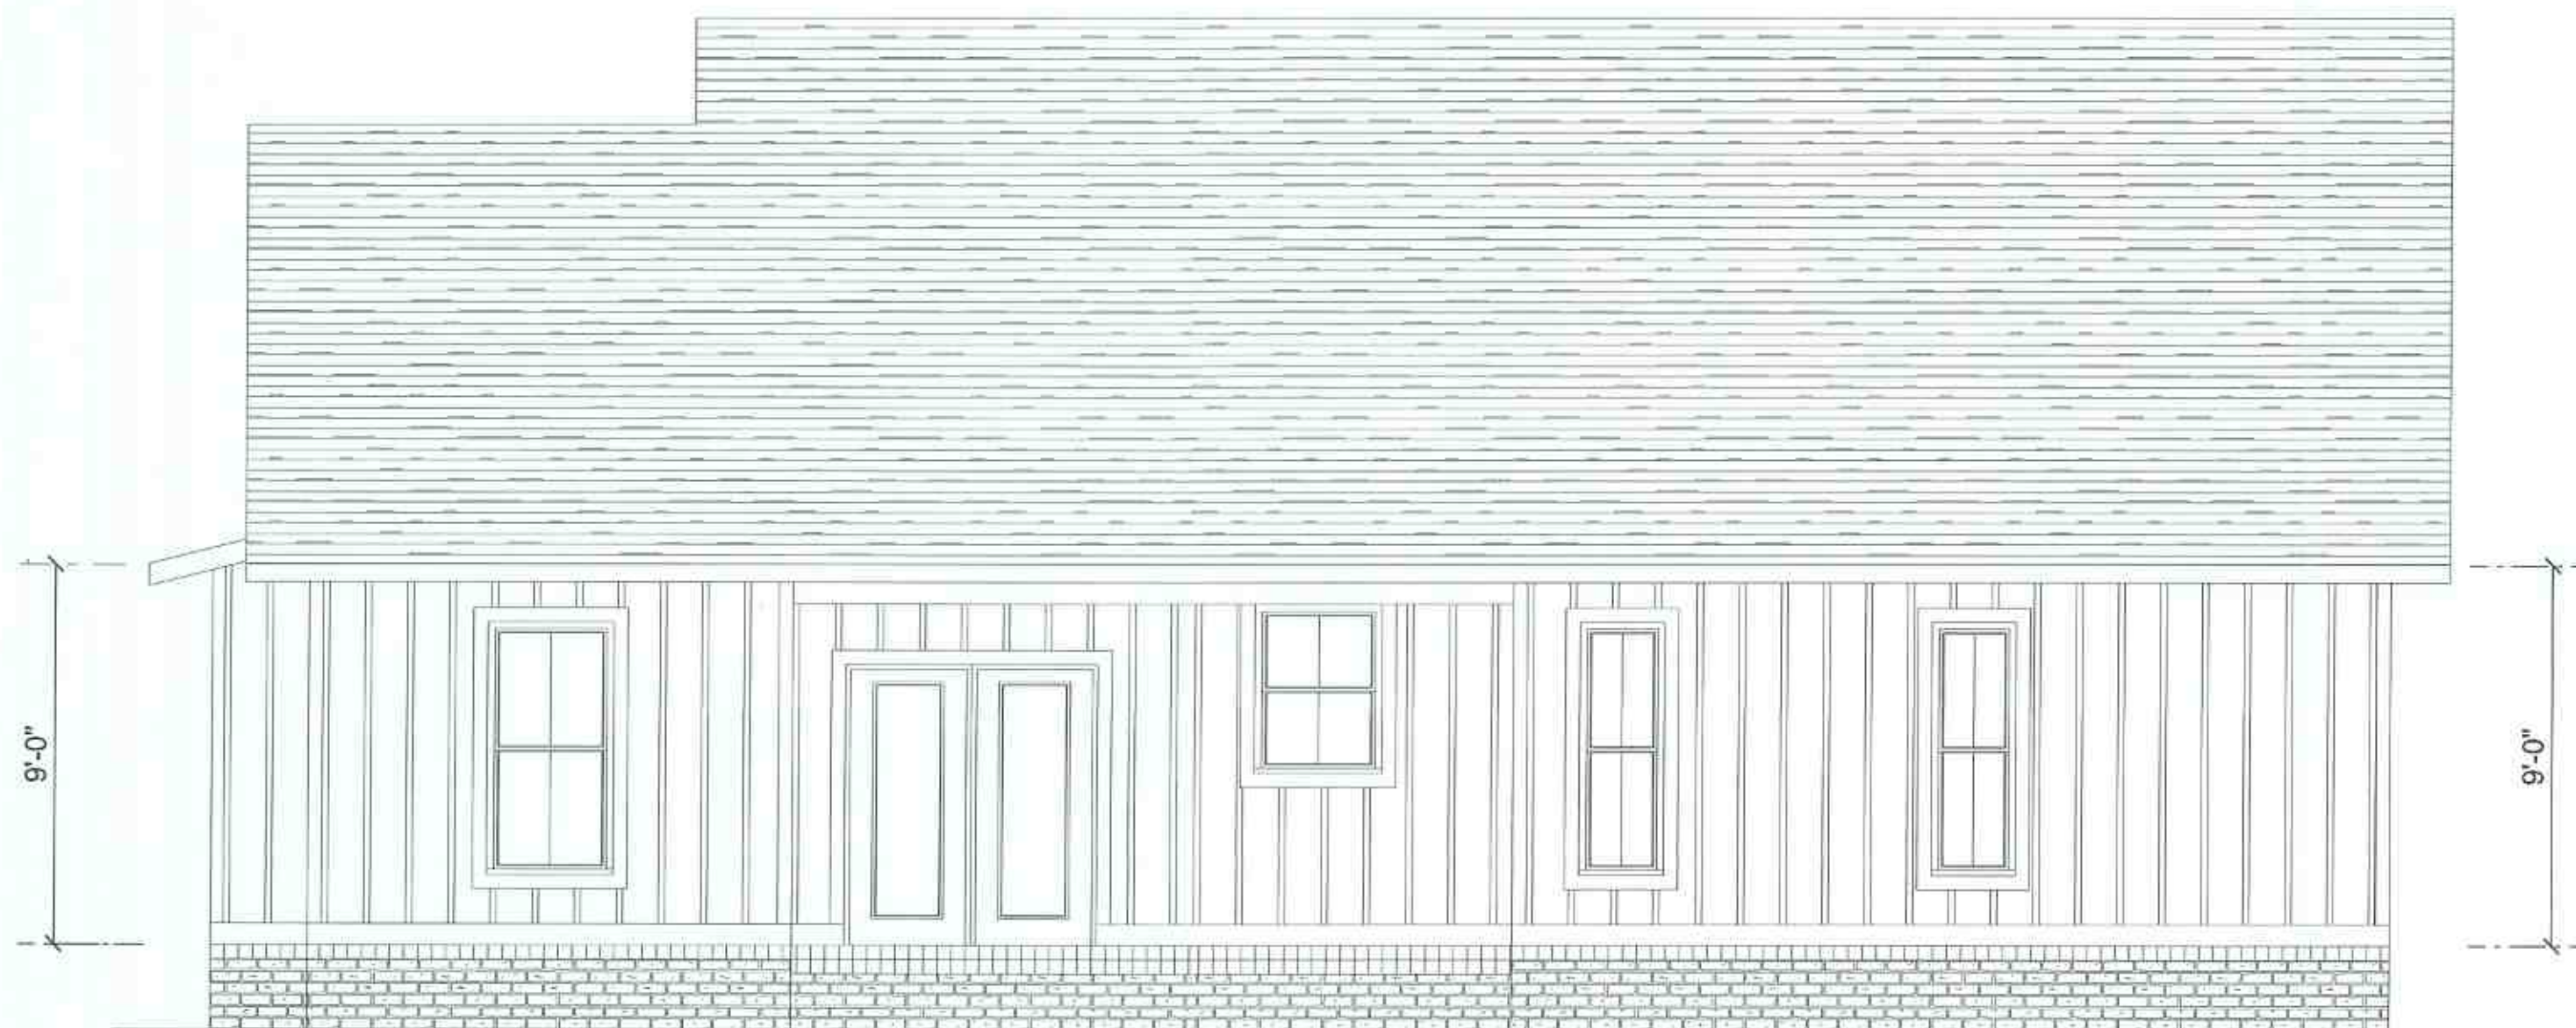

REAR ELEVATION
SCALE: 1/4" = 1'-0"




LEFT ELEVATION
SCALE: 1/4" = 1'-0"

REVISIONS SCHEDULE		
APRIL 1st, 2020	REVISIONS	
APRIL 9th, 2020	PERMIT SET	

CARTER RESIDENCE
COLUMBIA COUNTY, FLORIDA
Bambi Ln (Stamped)

RIDGEPOINT DESIGN
883 WEST DUVAL STREET, LAKE CITY, FLORIDA 32055
P: 386-288-1188
E: RIDGEPOINTDESIGN@GMAIL.COM


SHEET NUMBER
A.1
OF 3 SHEETS

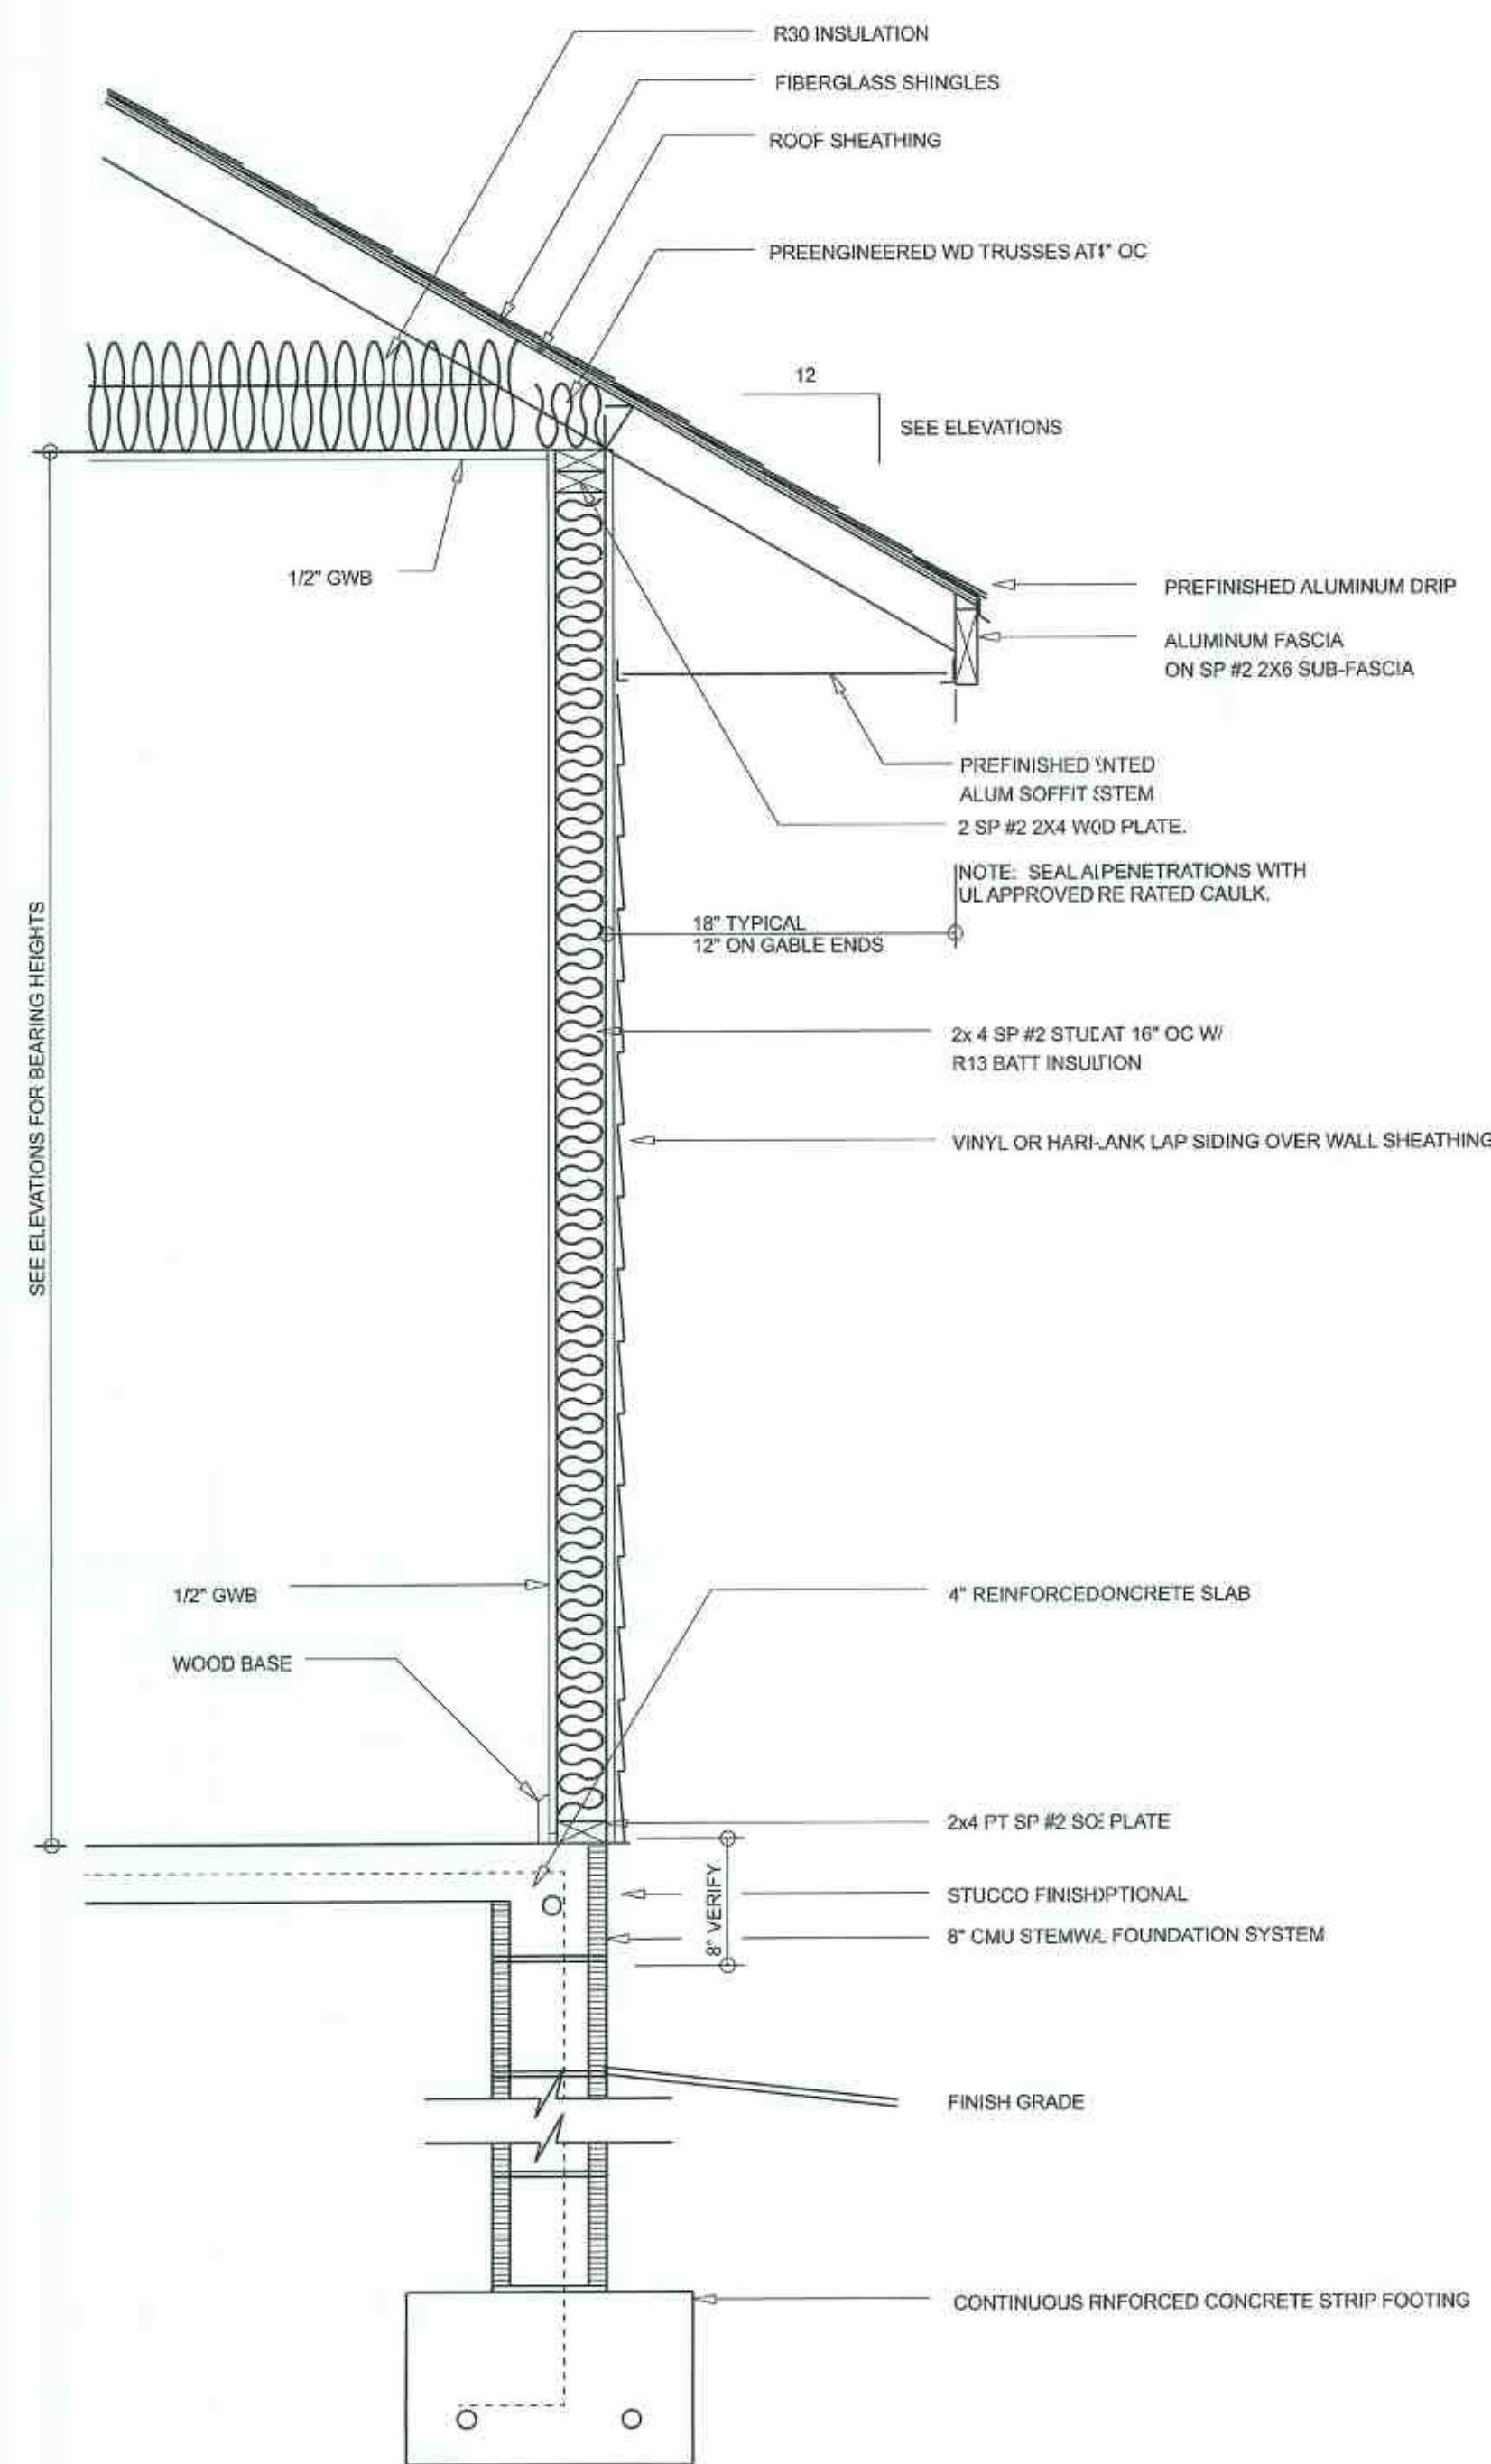

TYPICAL WALL SECTION
SCALE: 1" = 1'-0"

Garage fire separations shall comply with the following:

1. The private garage shall be separated from the dwelling unit and its attic area by means of a minimum 1/2-inch (12.7 mm) gypsum board applied to the garage side. Garages beneath habitable rooms shall be separated from all habitable rooms above by not less than 5/8-inch type X gypsum board or equivalent. Door openings between a private garage and the dwelling unit shall be equipped with either solid wood doors, or solid or honeycomb core steel doors not less than 3/8 inches (34.9 mm) thick, or doors in compliance with Section 715.3.3. Openings from a private garage directly into a room used for sleeping purposes shall not be permitted.
2. Ducts in a private garage and ducts penetrating the walls or ceilings separating the dwelling unit from the garage shall be constructed of a minimum 0.019-inch (0.48 mm) sheet steel and shall have no openings into the garage.
3. A separation is not required between a Group R-3 and U carport provided the carport is entirely open on two or more sides and there are not enclosed areas above.
4. When installing an attic access and/or pull-down stair unit in the garage, devise shall have a minimum 20 min. fire rating.

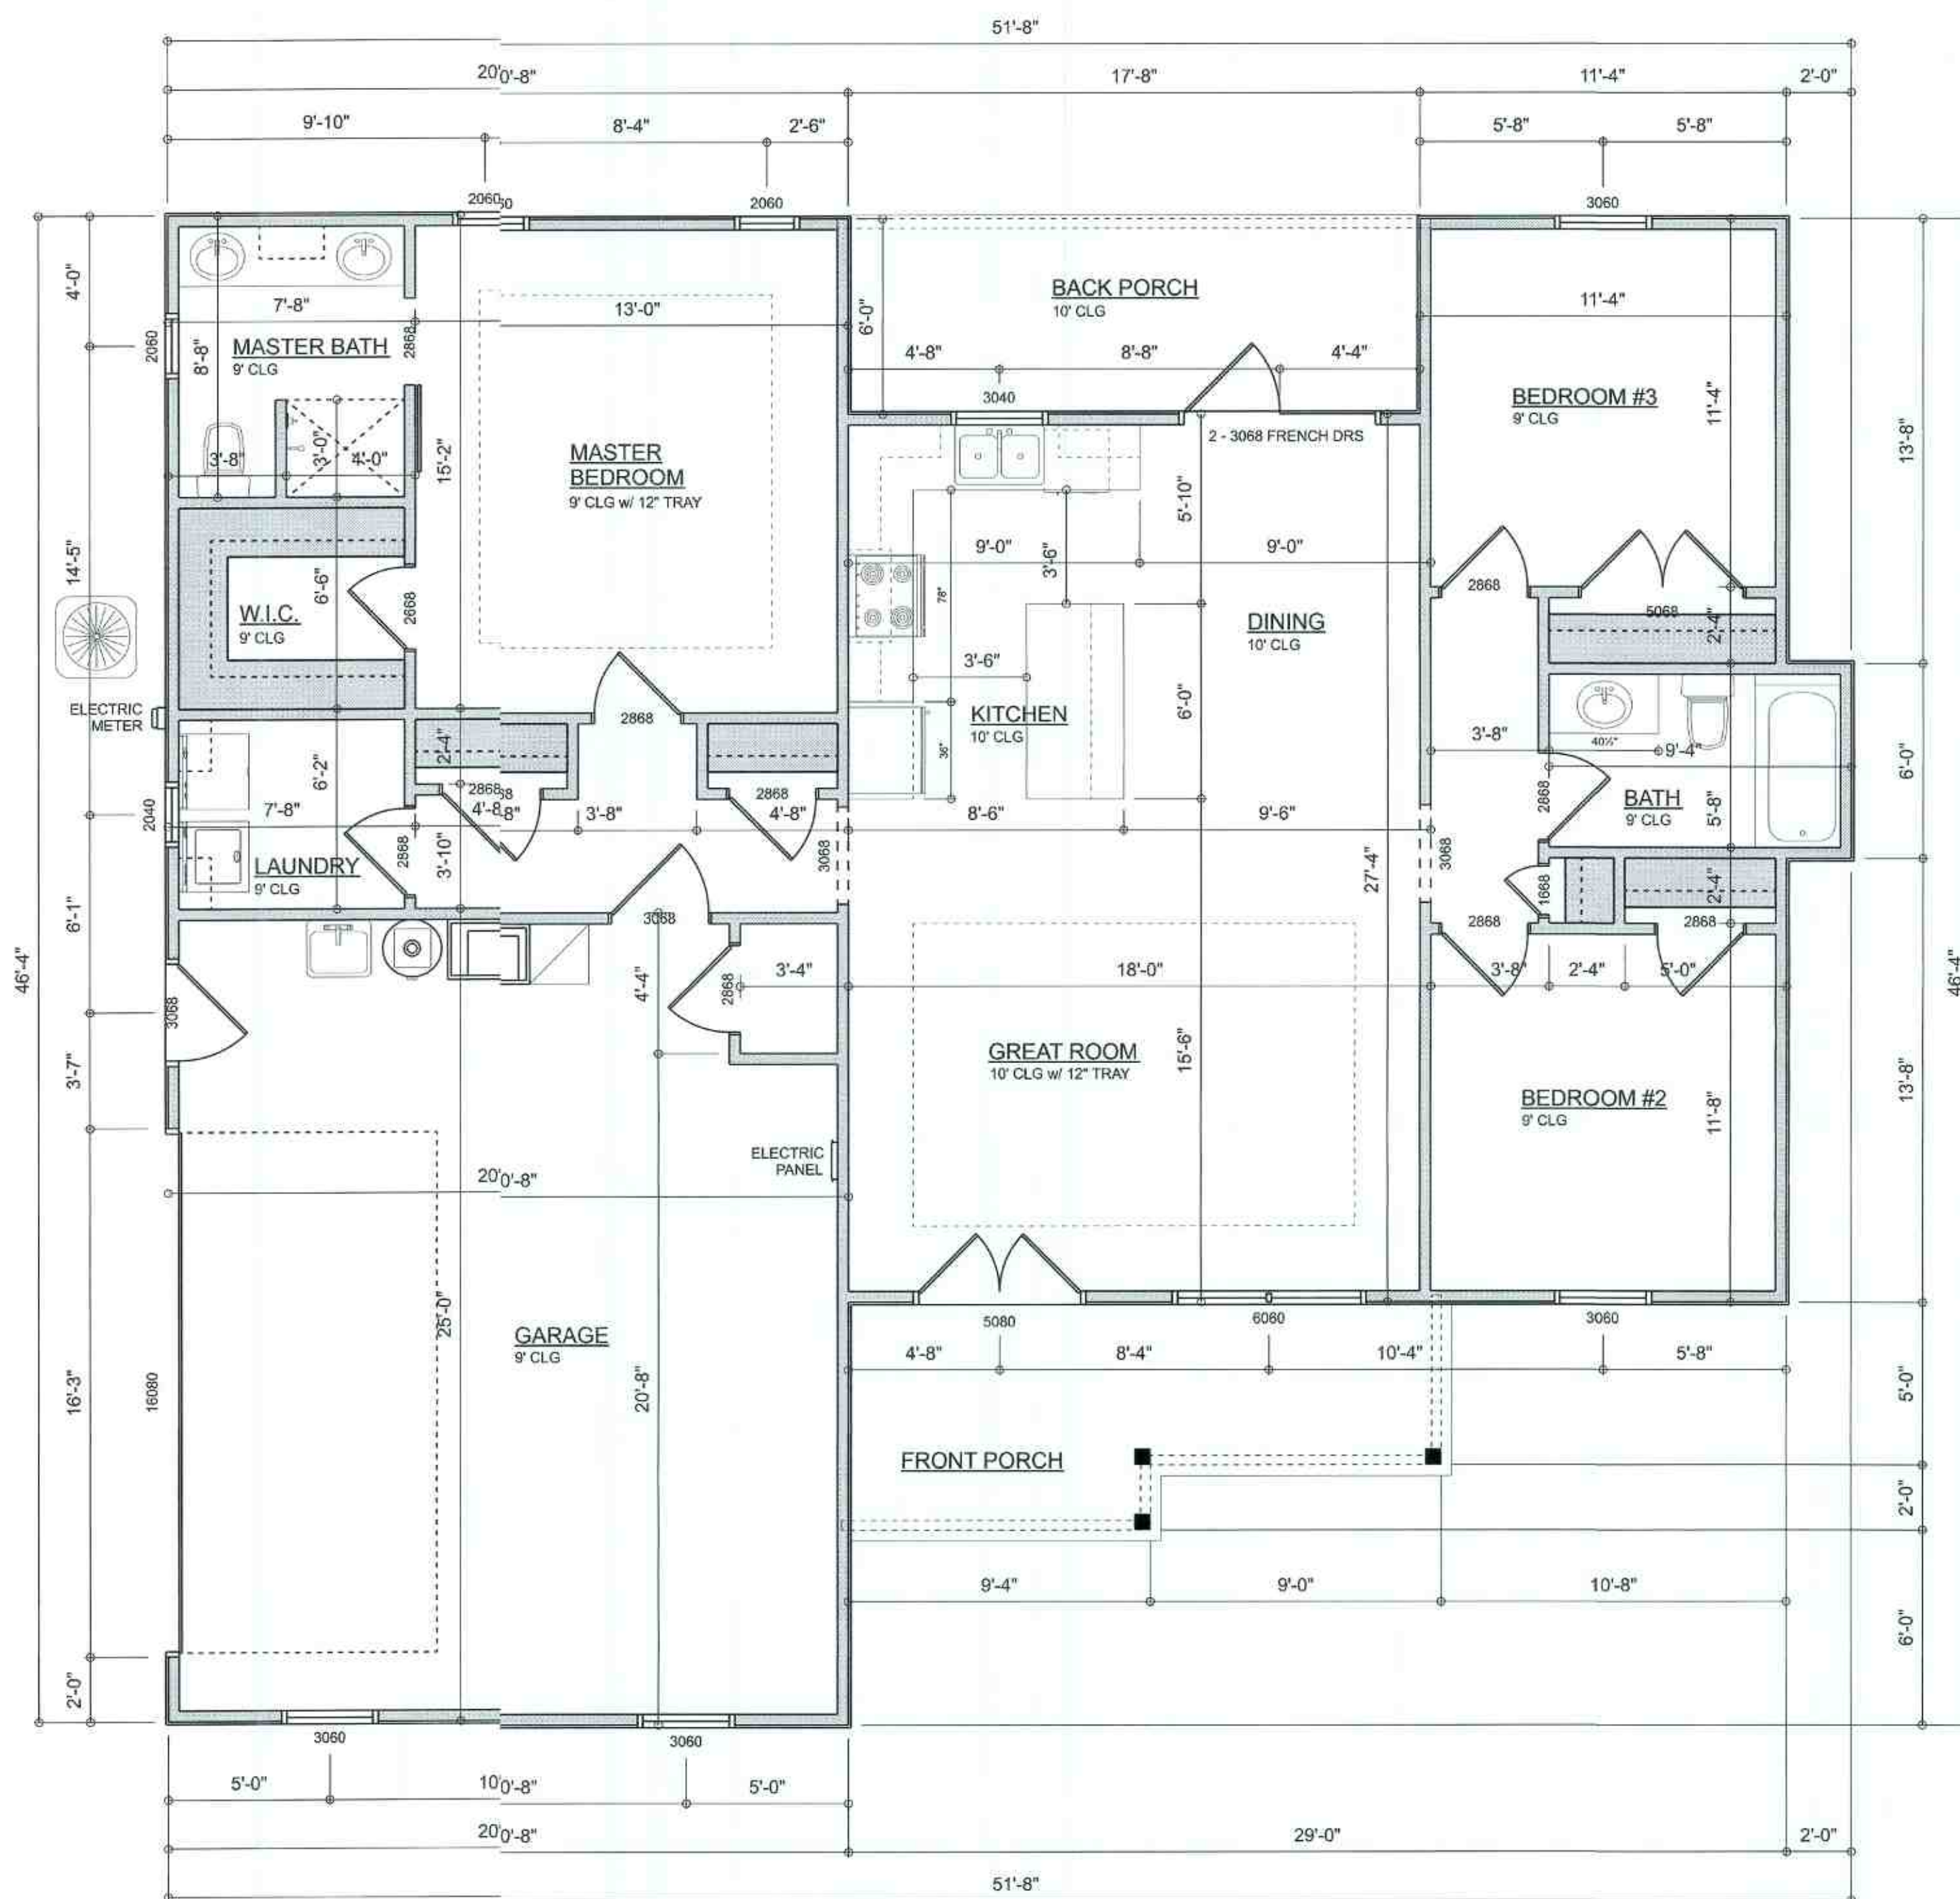


DIMENSIONED FLOOR PLAN
SCALE: 1/4" = 1'-0"

AREA SUMMARY		
LIVING	1,314	S.F.
FRONT PORCH	110	S.F.
BACK PORCH	106	S.F.
GARAGE	517	S.F.
TOTAL AREA	2,047	S.F.



TOTAL CUBIC FOOTAGE OF CONDITIONED SPACE IS: 12,539

REVISIONS SCHEDULE		
APRIL 1st, 2020	REVISIONS	
APRIL 9th, 2020	PERMIT SET	

CARTER RESIDENCE
COLUMBIA COUNTY, FLORIDA

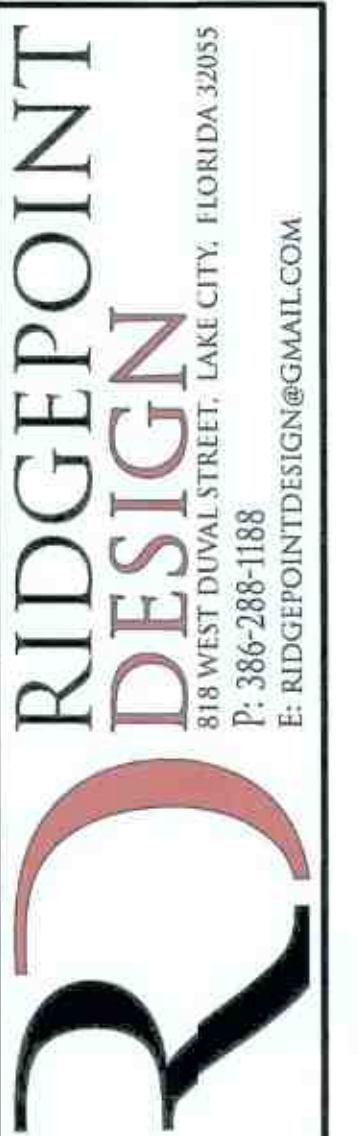

SHEET NUMBER
A.2
OF 3 SHEETS

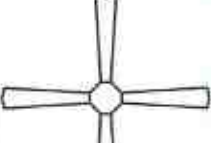 ELECTRICAL LEGEND		
ELECTRICAL	COUNT	SYMBOL
CEILING FAN	4	
CAN LIGHT 6inch	18	
LED CEILING LIGHT 1x4	2	
PENDANT LIGHT	2	
MOTION SECURITY LIGHT	3	
arts and craft exterior light	2	
ELECTRIC PANEL	1	
CABLE TV OUTLET	4	
EXHAUST FAN	2	
LAN CONNECTION	2	
OUTLET	30	
OUTLET 220v	5	
OUTLET GFI	12	
OUTLET WP	4	
SMOKE DETECTOR	4	
STANDARD LIGHT	10	
SWITCH	20	
SWITCH 3 WAY	12	
SWITCH DIMMER	3	
VANITY BAR LIGHT - SMALL	3	

ELECTRICAL PLAN NOTES:

INSTALLATION SHALL BE PER 2017 NAT'L ELECTRIC CODE.

WIRE ALL APPLIANCES, HVAC UNITS AND OTHER EQUIPMENT PER MANUF. SPECIFICATIONS

CONSULT WITH THE OWNER FOR THE NUMBER OF SEPERATE TELEPHONE LINES TO BE INSTALLED

ALL SMOKE DETECTORS SHALL BE 120v W/ BATTERY BACKUP OF THE PHOTOELECTRIC TYPE, AND SHALL BE INTERLOCKED TOGETHER. INSTALL INSIDE AND NEAR ALL BEDROOMS


TELEPHONE, TELEVISION AND OTHER LOW VOLTAGE DEVICES OR OUTLETS SHALL BE AS PER THE OWNER'S DIRECTIONS, & IN ACCORDANCE W/ APPLICABLE SECTIONS OF NEC-LATEST EDITION.

ALL RECEPTALS, NOT OTHERWISE NOTED, SHALL BE ARC FAULT INTERRUPTER TYPE, EXCEPT DEDICATED OUTLETS

ALL RECEPTALS IN WET AREAS SHALL BE GROUND FAULT INTERRUPTER TYPE (GFI)

ALL EXTERIOR RECEPTALS SHALL BE WEATHERPROOF GROUD FAULT INTERRUPTER TYPE (WP/GFI)

NOTE:
ELECTRICAL CONTR SHALL PREPARE "AS-BUILT" SHOP DWGS INDICATING ALL ELECTRICAL WORK, INCLUDING ANY CHANGES TO THE ELEC. PLAN, ADD'NS TO THE ELEC. PLAN, RISER DIAGRAM, AS-BUILT PANEL SCHEDULE W/ ALL CKTS IDENTIFIED W/ CKT N°. DESCRIPTION & BRKR. SERVICE ENT. & ALL UNDERGROUND WIRE LOCATIONS/ROUTING / DEPTH. RISER DIA. SHALL INCLUDE WIRE SIZES/TYPE & EQUIPMENT TYPE W/ RATINGS & LOADS.
CONTRACTOR SHALL PROVIDE 1 COPY OF AS-BUILT DWGS TO OWNER & 1 COPY TO THE PERMIT ISSUING AUTHORITY

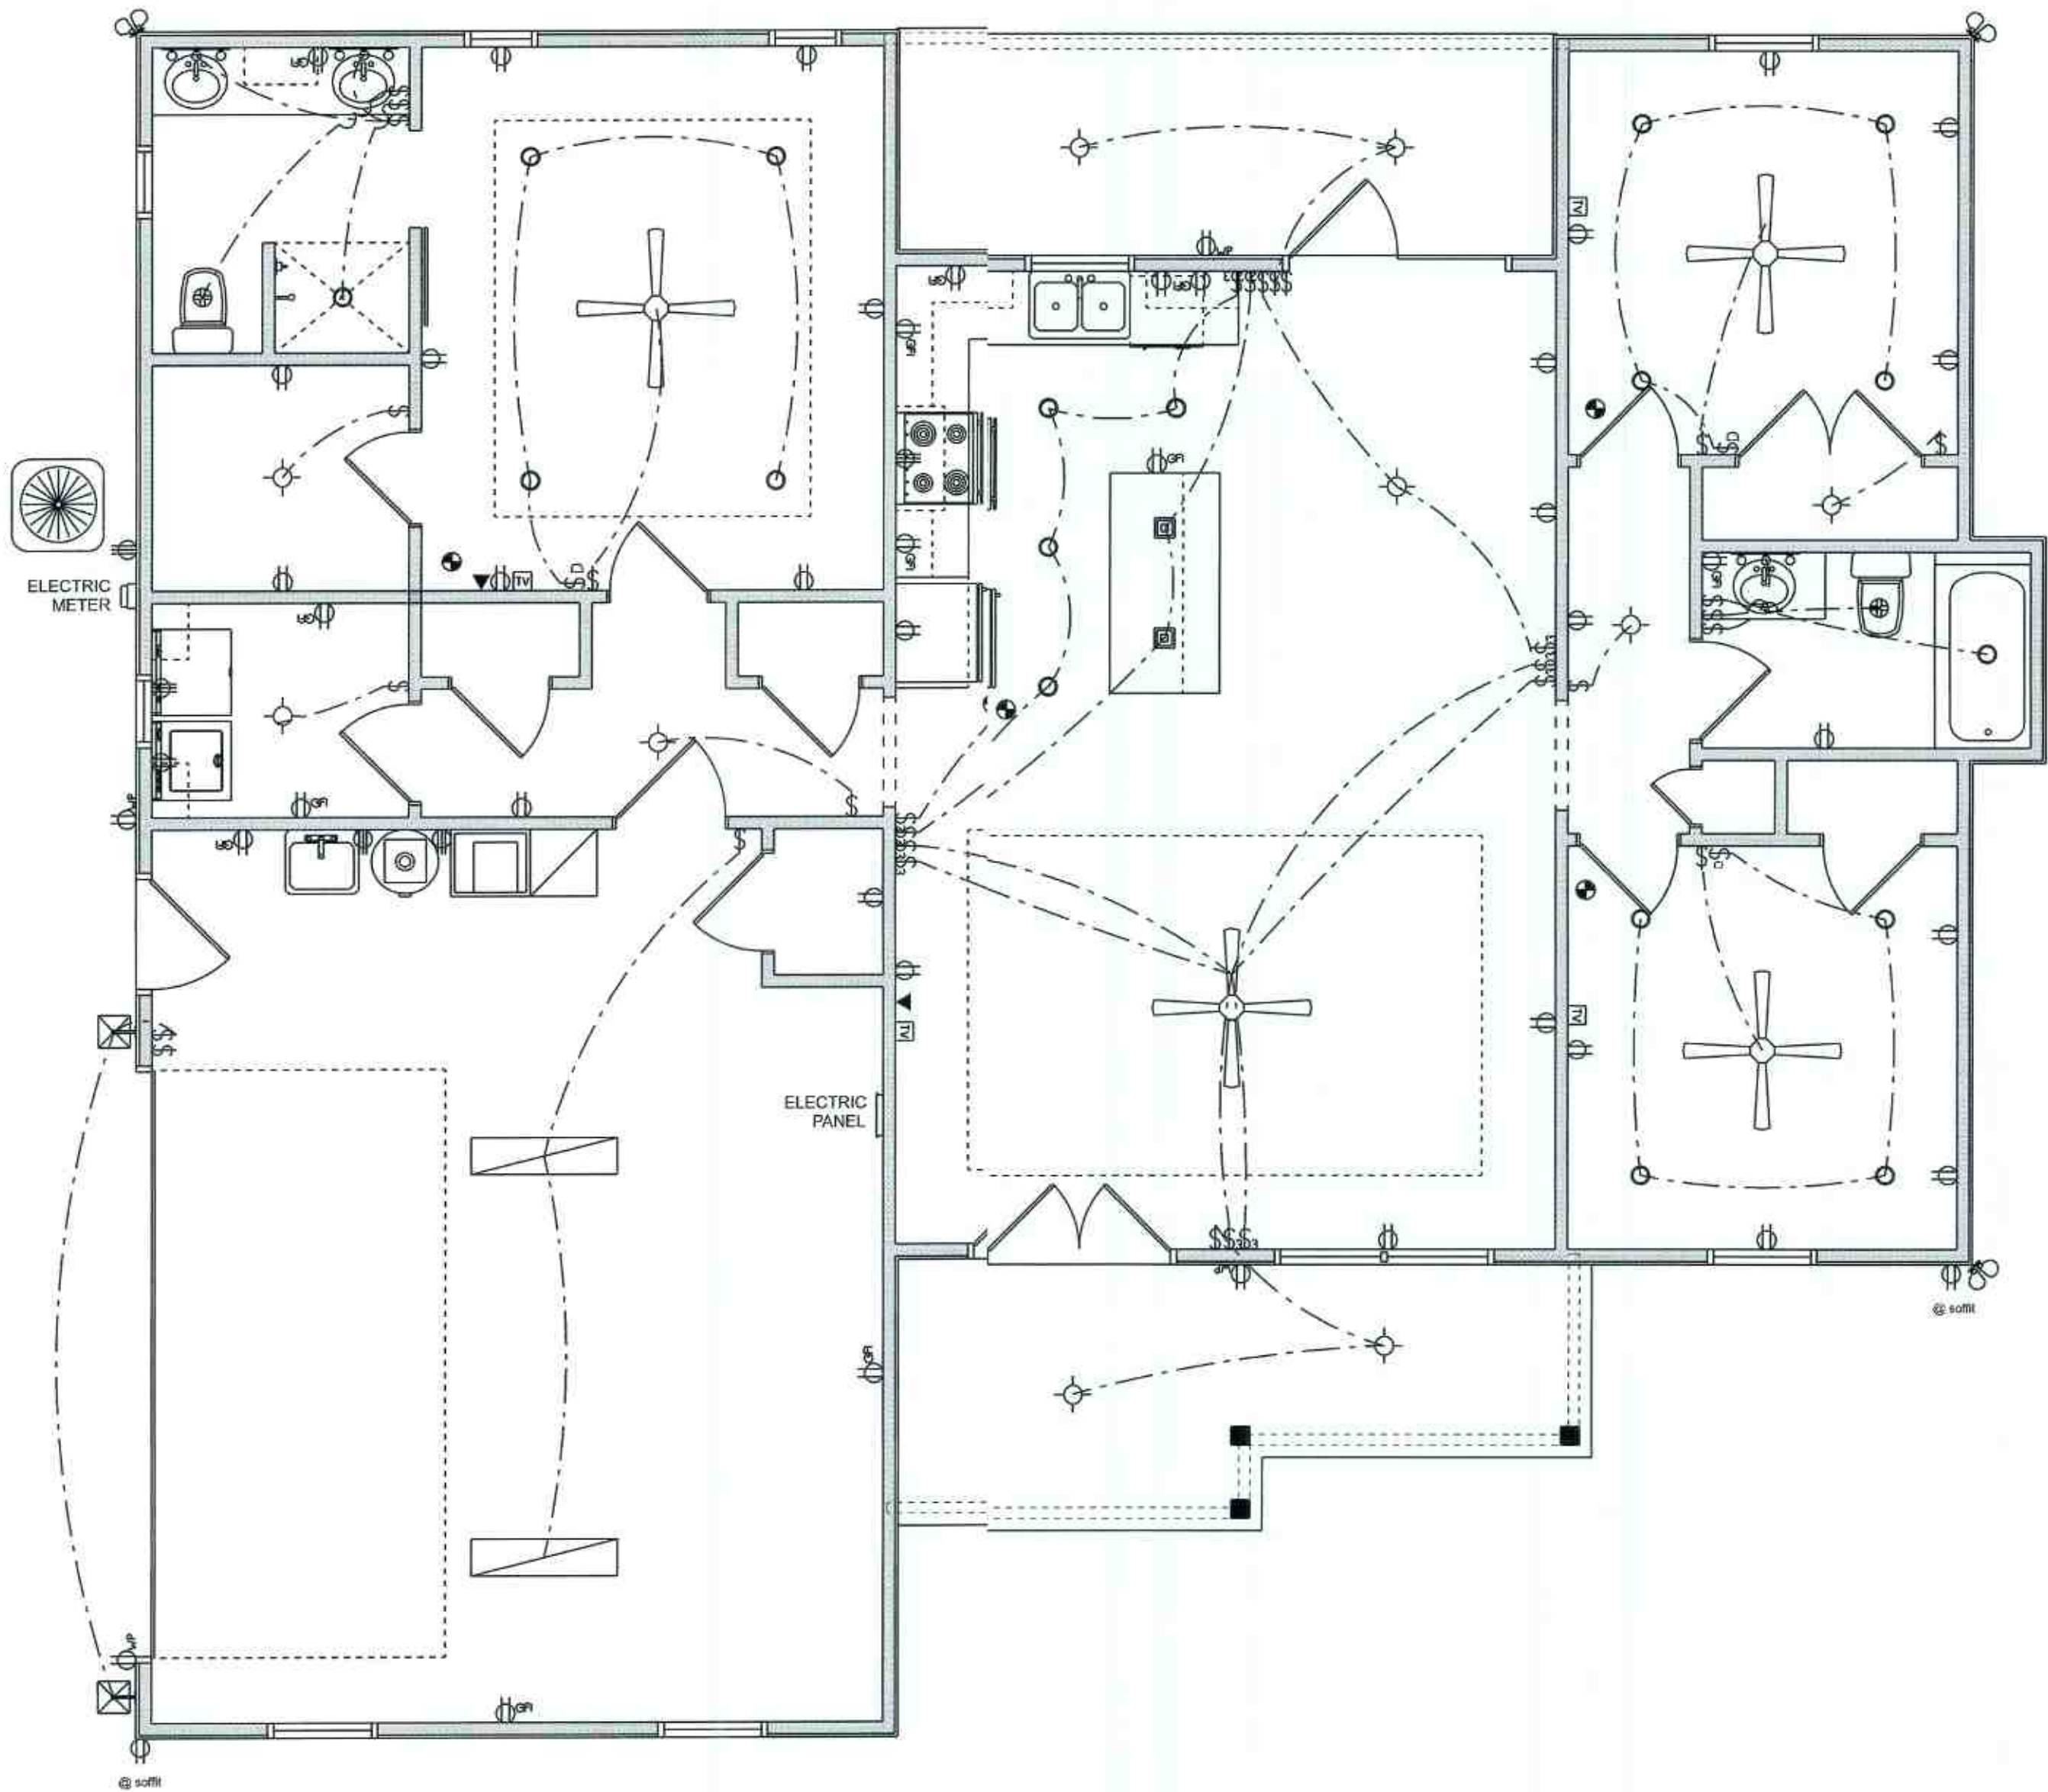


ELECTRICAL PLAN

SCALE: 1/4" = 1'-0"

REVISIONS SCHEDULE		
APRIL 1st, 2020	REVISIONS	
APRIL 9th, 2020	PERMIT SET	

CARTER RESIDENCE

COLUMBIA COUNTY, FLORIDA

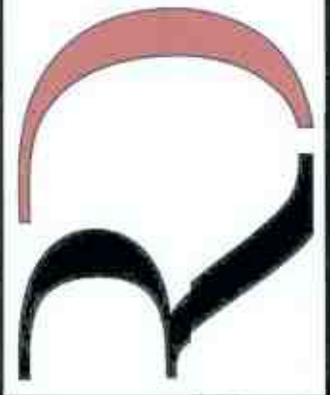

**RIDGEPOINT
DESIGN**

818 WEST DUVAL STREET, LAKE CITY, FLORIDA 32655
P: 386-288-1188
E: RIDGEPOINTDESIGN@GMAIL.COM

SHEET NUMBER

A.3

OF 3 SHEETS