


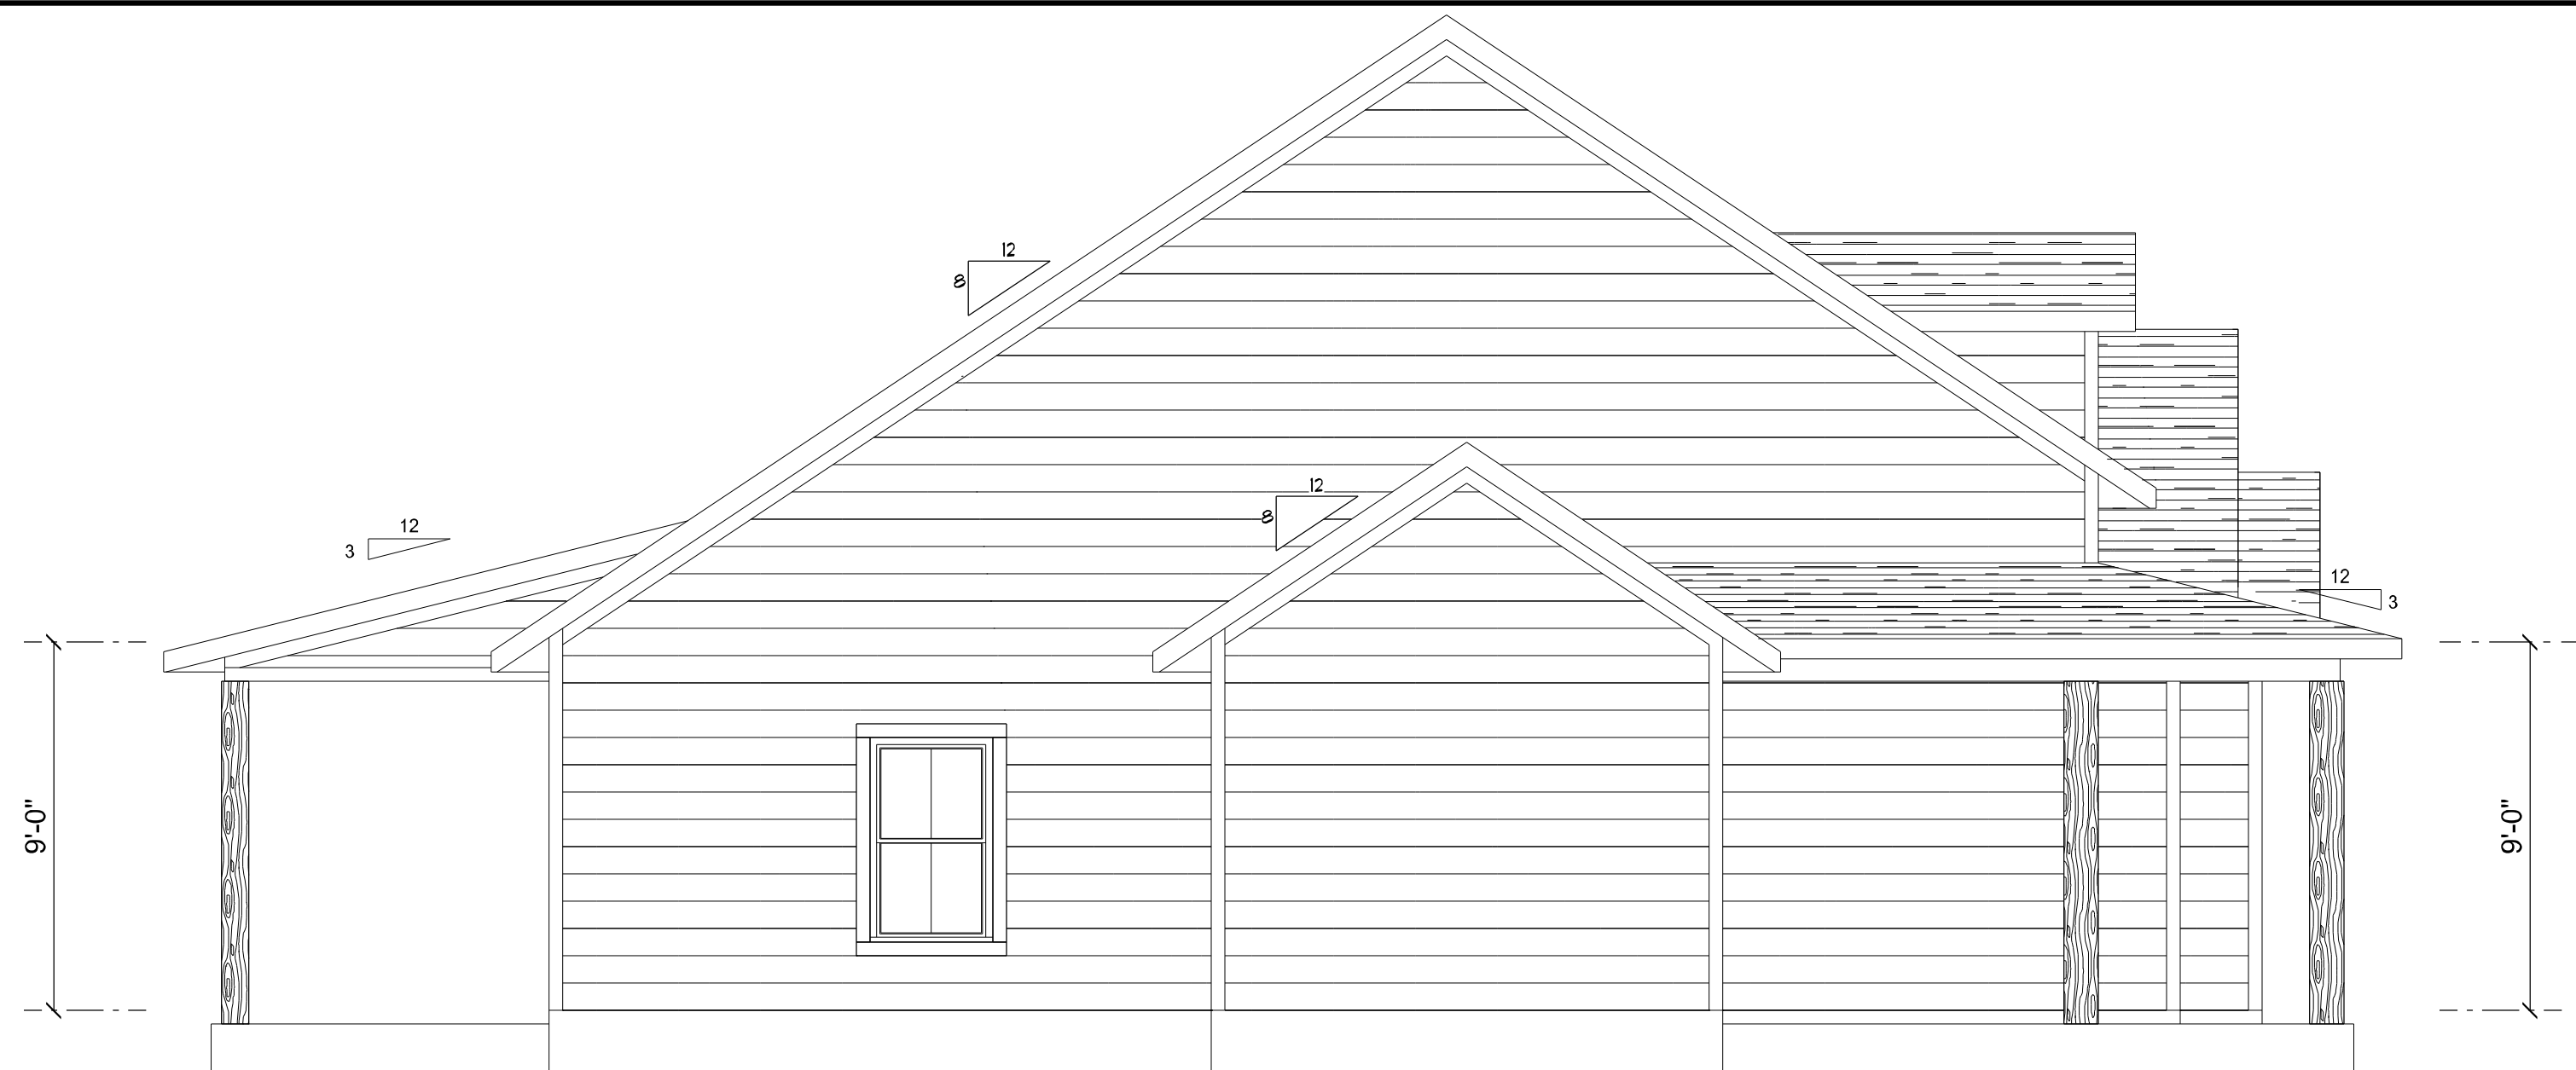

LEFT ELEVATION

SCALE: 1/4" = 1'-0"



RIGHT ELEVATION

SCALE: 1/4" = 1'-0"



REAR ELEVATION

SCALE: 1/4" = 1'-0"



FRONT ELEVATION

SCALE: 1/4" = 1'-0"

REVISIONS SCHEDULE			
PROPOSAL	Feb. 16th, 2022		
REVISIONS	Apr. 12th, 2022		
REVISIONS	July 15th, 2022		

CUSTOM HOME FOR:

WALDEN RESIDENCE


**RIDGEPOINT
DESIGN**

566 SW ARLINGTON BLVD. STE 101, LAKE CITY, FL 32025
P: 386-288-1188
E: RIDGEPOINTDESIGN@GMAIL.COM

SHEET NUMBER

A.1

OF 8 SHEETS

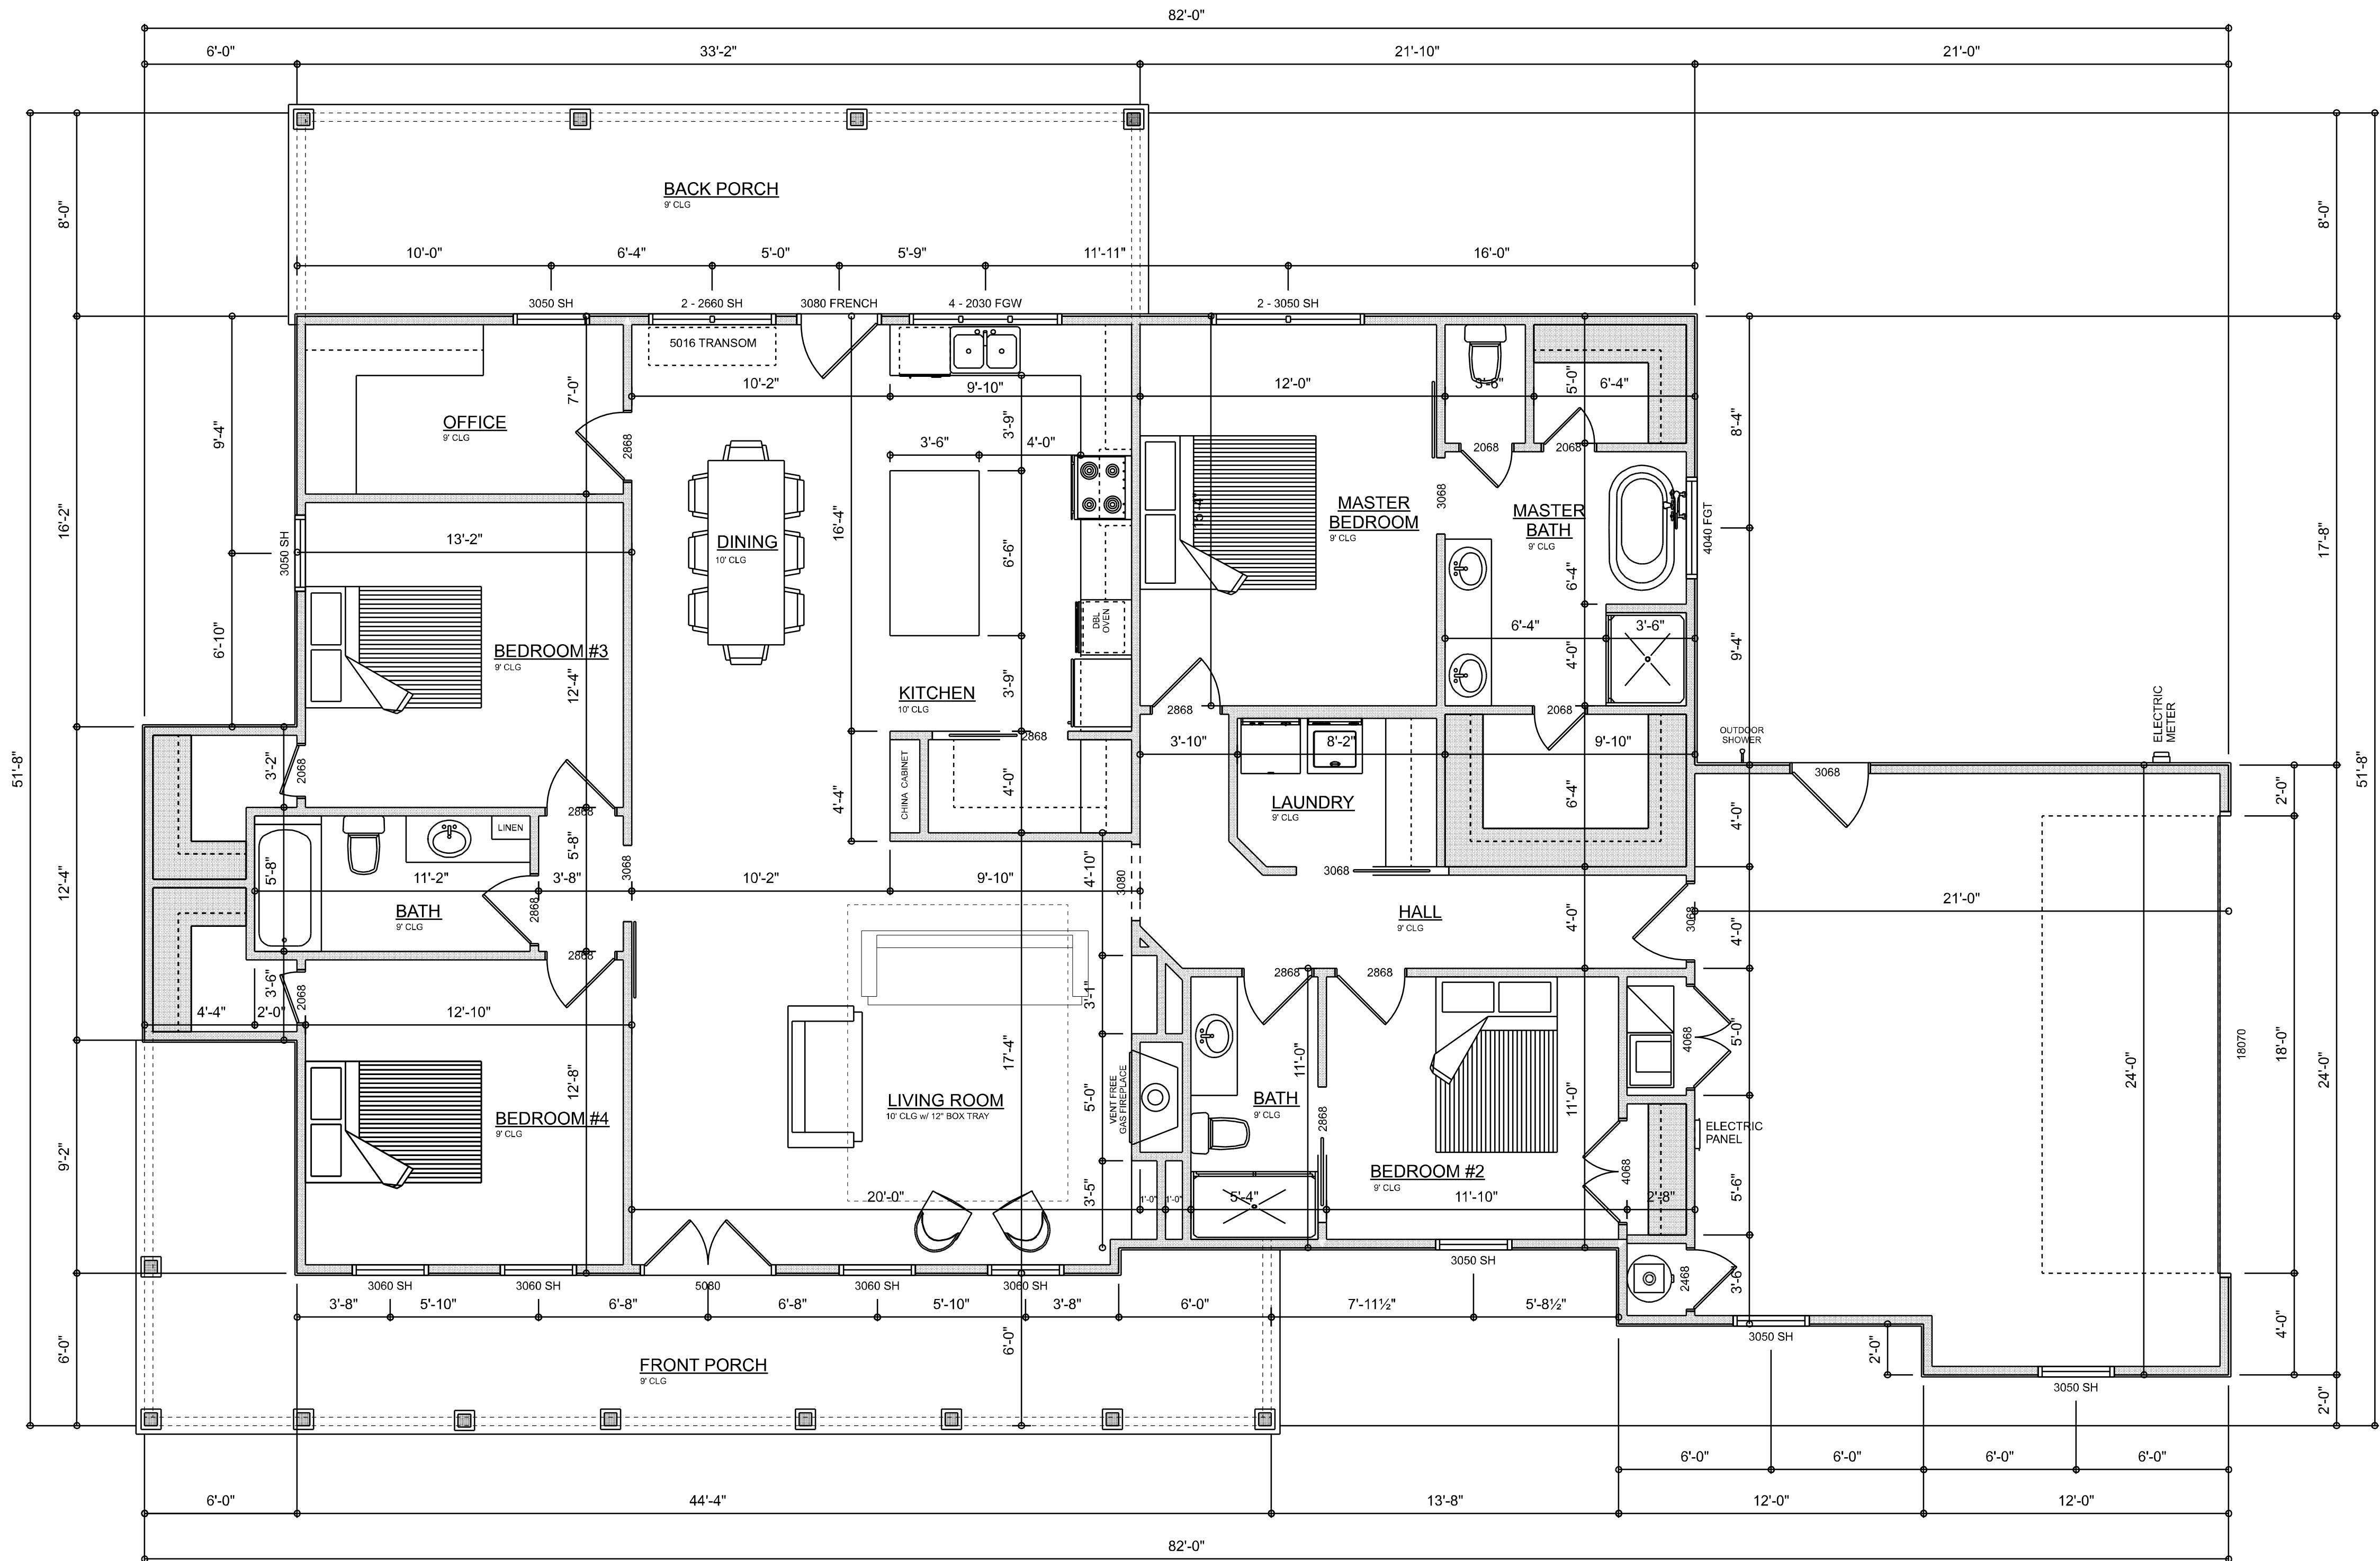

DIMENSIONED FLOOR PLAN
SCALE: 1/4" = 1'-0"


 
AREA SUMMARY		
LIVING AREA	2,092	S.F.
FRONT PORCH	327	S.F.
BACK PORCH	265	S.F.
GARAGE	526	S.F.
TOTAL AREA	3,210	S.F.

REVISIONS SCHEDULE	
PROPOSAL	Feb. 16th, 2022
REVISIONS	Apr. 12th, 2022
REVISIONS	July 15th, 2022

CUSTOM HOME FOR:
WALDEN RESIDENCE

RIDGEPOINT DESIGN
566 SW ARLINGTON BLVD. STE 101, LAKE CITY, FL 32025
P: 386-288-1188
E: RIDGEPOINTDESIGN@GMAIL.COM

SHEET NUMBER
A.2
OF 8 SHEETS

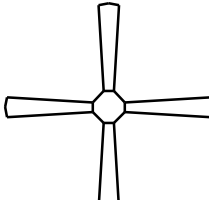ELECTRICAL LEGEND		
ELECTRICAL	COUNT	SYMBOL
CEILING FAN	7	
CAN LIGHT 6inch	15	
CHANDELIER	3	
LED CEILING LIGHT 1x4	2	
PENDANT LIGHT	2	
EXTERIOR SCONCE	5	
ELECTRIC PANEL	1	
AC DISCONNECT	2	
EXHAUST FAN	3	
OUTLET	46	
OUTLET 220v	6	
OUTLET GFI	21	
OUTLET WP	6	
STANDARD LIGHT	12	
SWITCH	37	
SWITCH 3 WAY	16	
VANITY BAR LIGHT - SMALL	1	
CABLE TV OUTLET	6	
uplight	2	
VANITY WALL SCONCE	7	

ELECTRICAL PLAN NOTES:

INSTALLATION SHALL BE PER LATEST NAT'L ELECTRIC CODE.

WIRE ALL APPLIANCES, HVAC UNITS AND OTHER EQUIPMENT PER MANUF. SPECIFICATIONS

CONSULT WITH THE OWNER FOR THE NUMBER OF SEPERATE TELEPHONE LINES TO BE INSTALLED

ALL SMOKE DETECTORS SHALL BE 120v W/ BATTERY BACKUP OF THE PHOTOELECTRIC TYPE, AND SHALL BE INTERLOCKED TOGETHER. INSTALL INSIDE AND NEAR ALL BEDROOMS


TELEPHONE, TELEVISION AND OTHER LOW VOLTAGE DEVICES OR OUTLETS SHALL BE AS PER THE OWNER'S DIRECTIONS, & IN ACCORDANCE W/ APPLICABLE SECTIONS OF NEC-LATEST EDITION.

ALL RECEPTICALS, NOT OTHERWISE NOTED, SHALL BE ARC FAULT INTERRUPTER TYPE, EXCEPT DEDICATED OUTLETS

ALL RECEPTICALS IN WET AREAS SHALL BE GROUND FAULT INTERRUPTER TYPE (GFI)

ALL EXTERIOR RECEPTICALS SHALL BE WEATHERPROOF GROUND FAULT INTERRUPTER TYPE (WP/GFI)


NOTE:
ELECTRICAL CON'TR SHALL PREPARE "AS-BUILT" SHOP DWGS INDICATING ALL ELECTRICAL WORK, INCLUDING ANY CHANGES TO THE ELEC. PLAN, ADD'NS TO THE ELEC. PLAN, RISER DIAGRAM, AS-BUILT PANEL SCHEDULE W/ ALL CKTS IDENTIFIED W/ CKT N°. DESCRIPTION & BRKR, SERVICE ENT. & ALL UNDERGROUND WIRE LOCATIONS/ROUTING / DEPTH. RISER DIA. SHALL INCLUDE WIRE SIZES/TYPE & EQUIPMENT TYPE W/ RATINGS & LOADS.
CONTRACTOR SHALL PROVIDE 1 COPY OF AS-BUILT DWGS TO OWNER & 1 COPY TO THE PERMIT ISSUING AUTHORITY

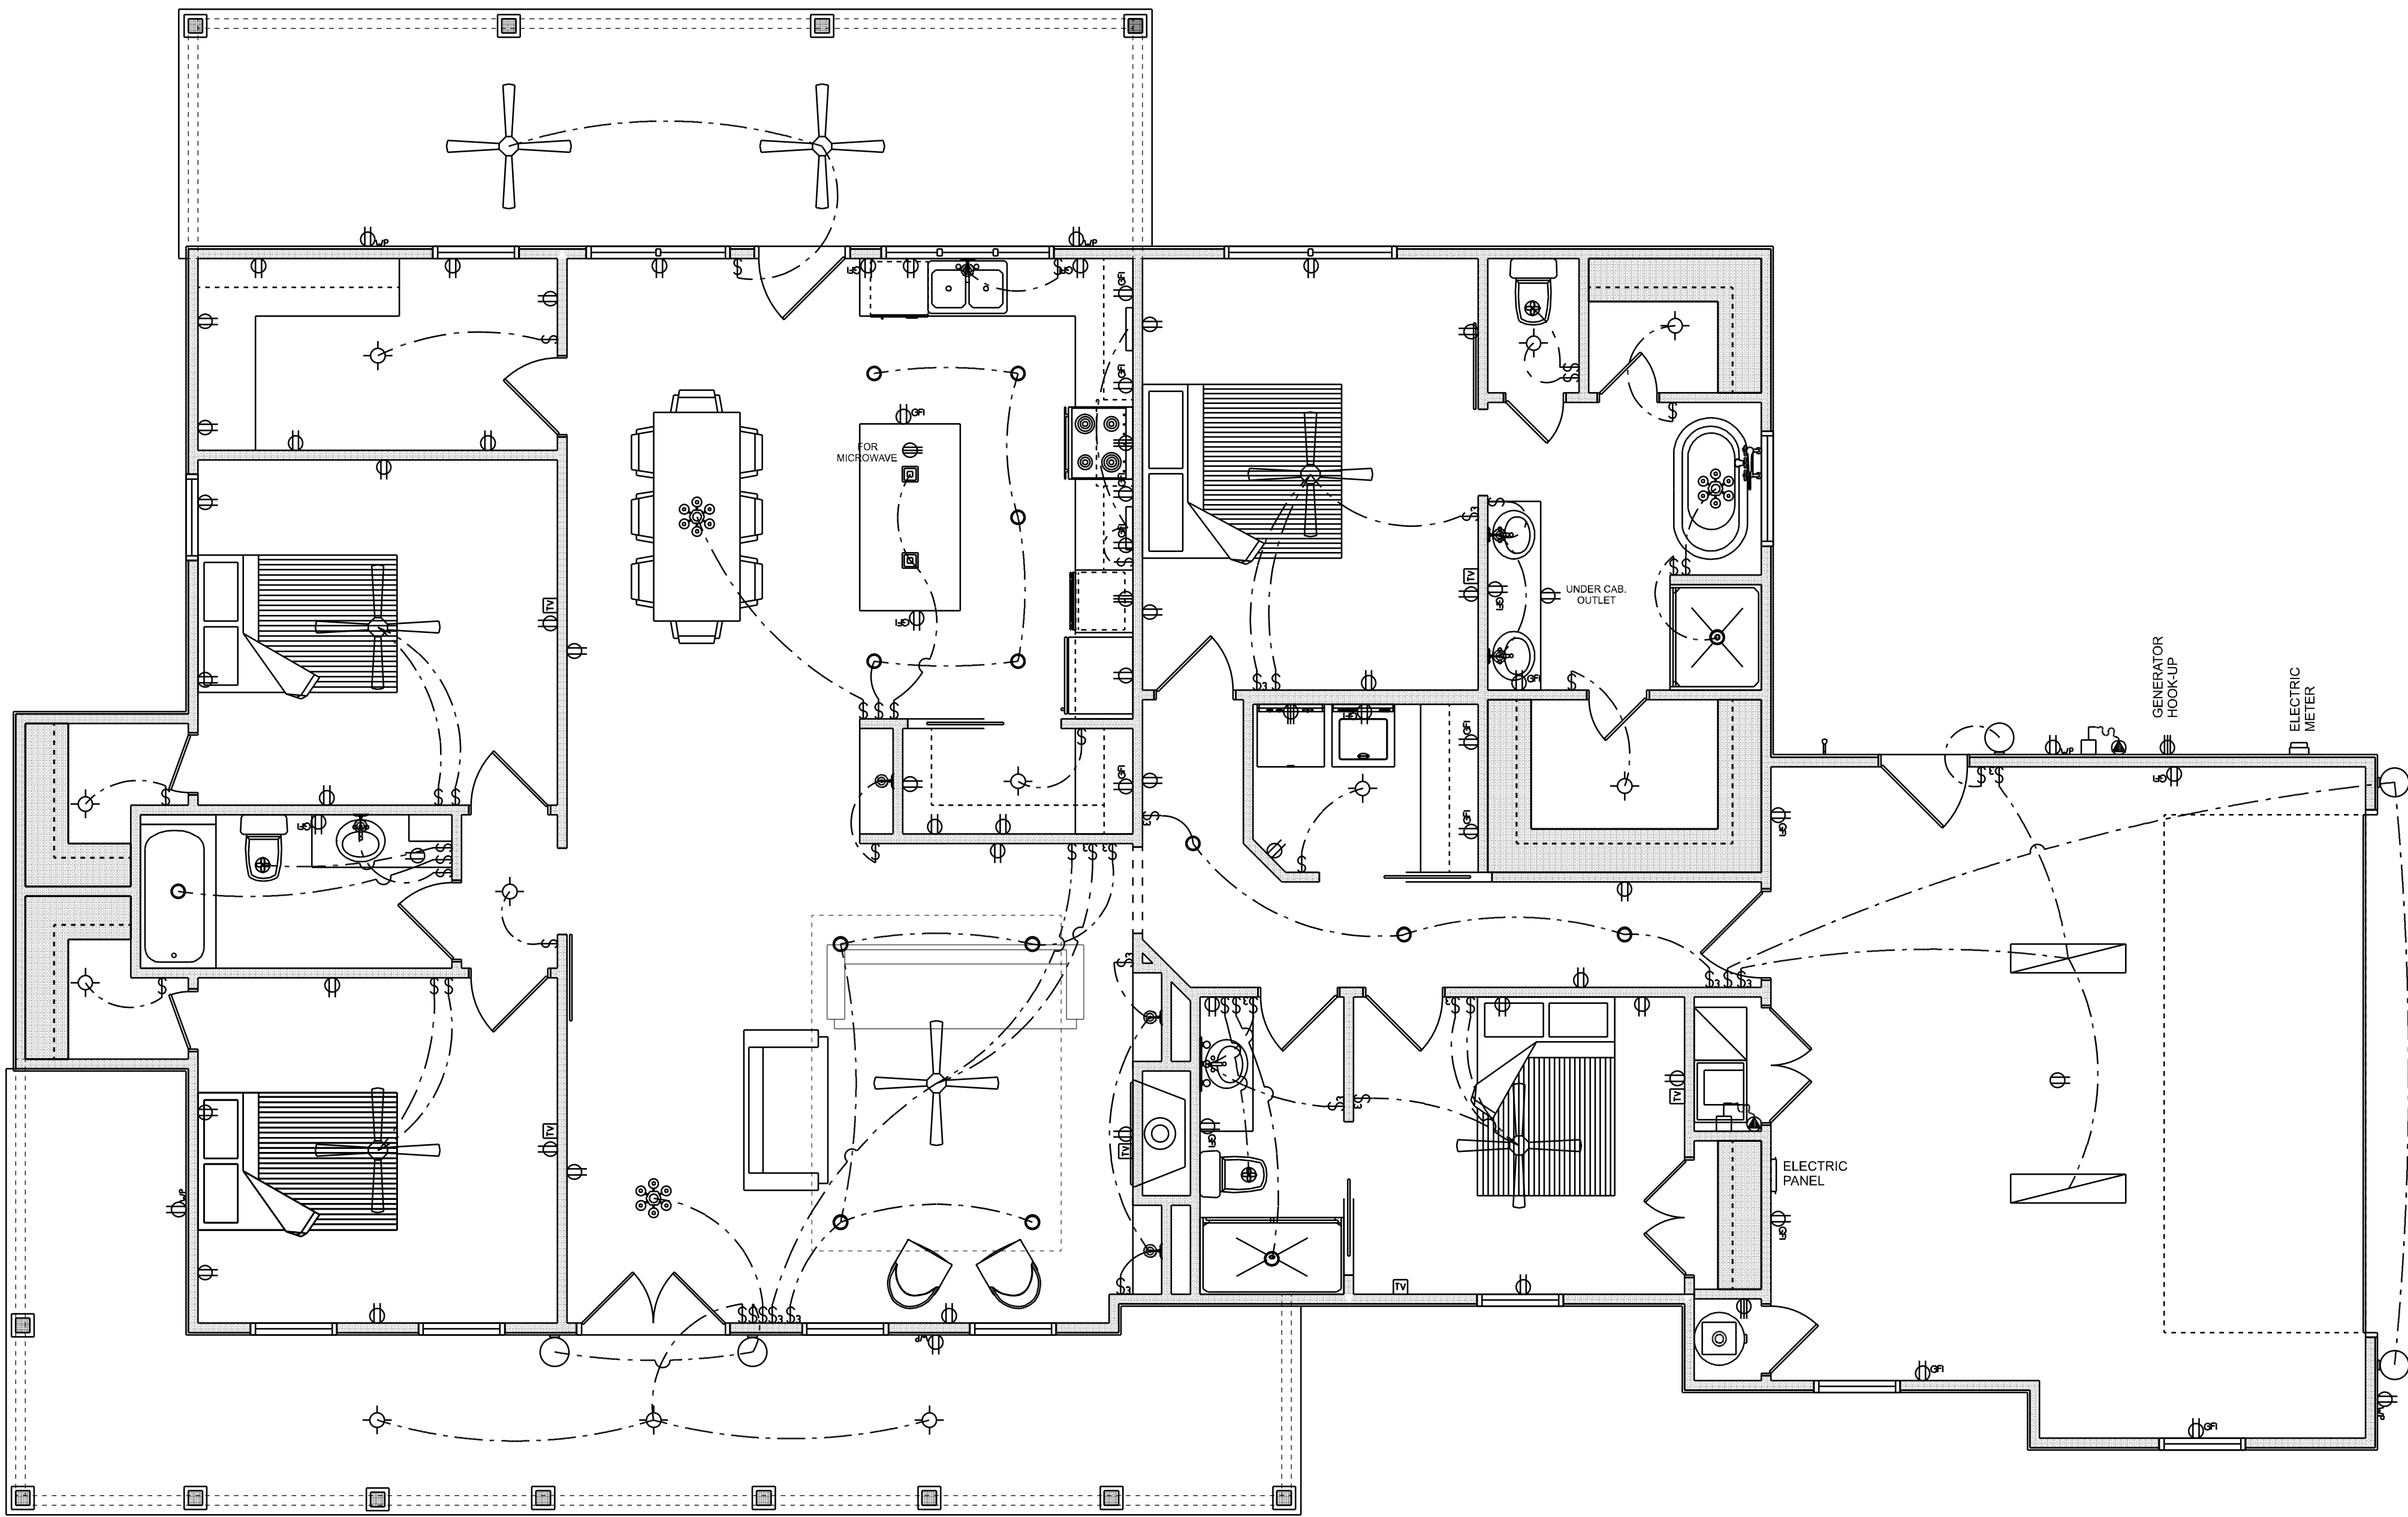

ELECTRICAL PLAN
SCALE: 1/4" = 1'-0"

REVISIONS SCHEDULE	
PROPOSAL	Feb. 16th, 2022
REVISIONS	Apr. 12th, 2022
REVISIONS	July 15th, 2022

CUSTOM HOME FOR:
WALDEN RESIDENCE

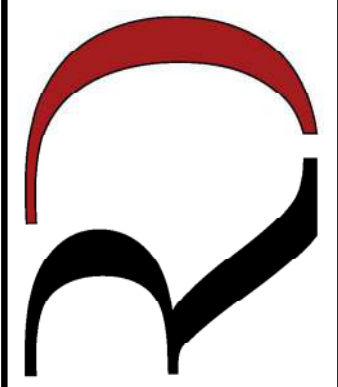**RIDGEPOINT
DESIGN**
566 SW ARLINGTON BLVD. STE 101, LAKE CITY, FL 32025
P: 386-288-1188
E: RIDGEPOINTDESIGN@GMAIL.COM

SHEET NUMBER
A.3
OF 8 SHEETS